

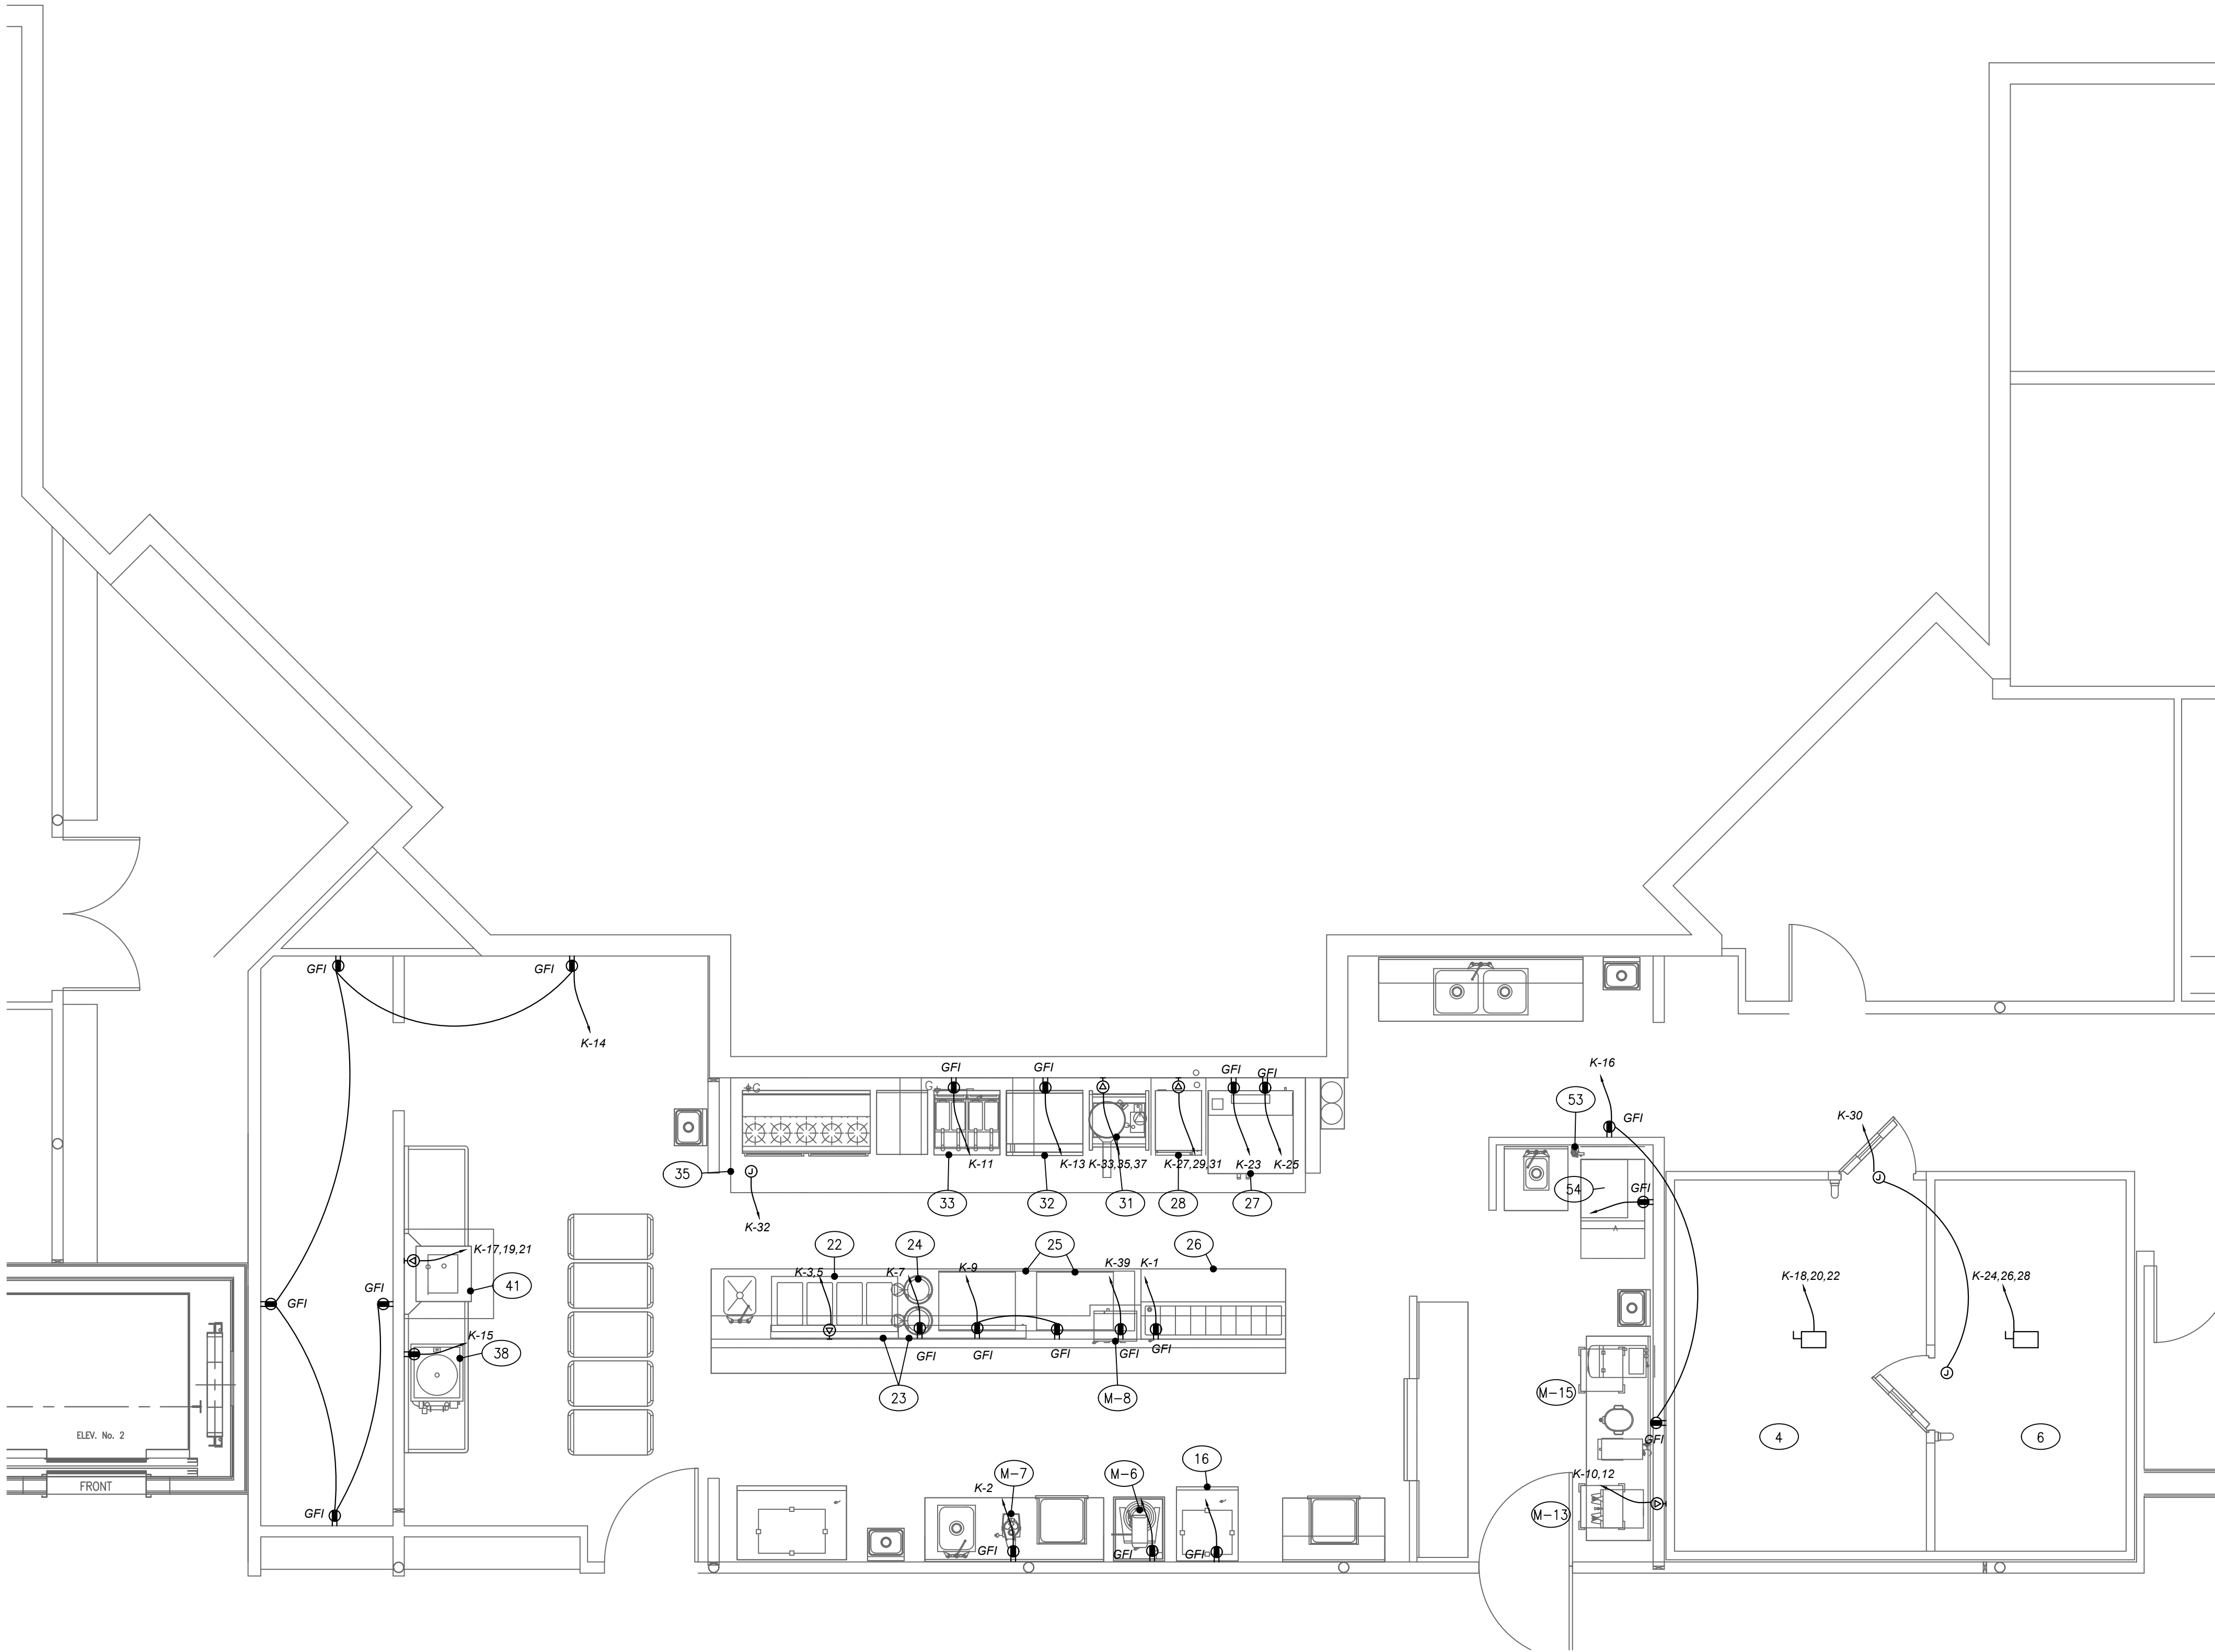


KITCHEN PANEL K												
MAIN MB			LOCATION:						FAULT:			
AMPS: 800A			VOLTAGE:			208/120V, 3ø			AIC RATING: 22K			
CIR	DESCRIPTION	BRKR	PHASE A		PHASE B		PHASE C		BRKR	DESCRIPTION	CIR	
1	REFRIG, PIZZA PREP	20/1	1.1	0.8					20/1	VEGETABLE CUTTER	2	
3	DRIP-IN WELL	25/2			1.0	1.2			20/1	MIXER	4	
5							1.0	1.0	20/1	REFRIGERATOR	6	
7	DISH DISPENSER	20/1	0.8	1.1					20/1	ICEMAKER	8	
9	REFRIGERATED DRAWERS	20/1			1.5	3.0			35/2	COFFEE MAKER	10	
11	FRYER	20/1					0.3	3.0			12	
13	GRIDDLE	20/1	0.2	1.2					20/1	RECEPTACLES	14	
15	FOOD COLLECTOR	20/1				0.8	1.2		20/1	RECEPTACLES	16	
17	DISHWASHER	45/3						4.6	1.0	15/3	WALK-IN COOLER	18
19			4.6	1.0								
21					4.6	1.0						22
23	CONVECTION OVEN	20/1						0.9	2.0	30/3	WALK-IN FREEZER	24
25	CONVECTION OVEN	20/1	0.9	2.0								
27	STEAMER	30/3			3.0	2.0						28
29									3.0	0.5	20/1	WALK-IN LTS/CONTROLS
31			3.0						20/1	HOOD LTS, CONTROLS	32	
33	KETTLE	25/3			2.1							34
35								2.1				
37			2.1									38
39	MICROWAVE	20/1			1.5							40
41	ICE MAKER	20/1					1.5					42
			TOTALS:		18.8	22.9		20.9				
			CONNECTED LOAD: 62.6 KVA			DEMAND LOAD: 62.6 KVA			173.9 AMPS			

FIXED EQUIPMENT SCHEDULE				
ITEM NO	QTY	EQUIPMENT CATEGORY	MANUFACTURER	MODEL NUMBER
1	1	AIR CURTAIN, UNHEATED	BERNER	ASF1042A-SS
2	1	WALK-IN COOLER/FREEZER	THERMOKOOL	CUSTOM
3	1	CONDENSING UNIT	THERMOKOOL	TBD
4	1	COOLER EVAPORATOR COIL	THERMOKOOL	TBD
5	1	CONDENSING UNIT	THERMOKOOL	TBD
6	1	FREEZER EVAPORATOR COIL	THERMOKOOL	TBD
7	-	SARE NUMBER		
8-A	1	SINK, WELDED INTO TABLE	ADVANCE TABCO	KSS-308
9	-	SARE NUMBER		
10	-	SARE NUMBER		
12	1	SINK, HAND, WALL MOUNT	ADVANCE TABCO	TA-11D-2
				7-PS-62
				WS-12-60
14B	1	SINK, WELDED INTO TABLE	ADVANCE TABCO	TA-11B
17	1	SINK, HAND, WALL MOUNT	ADVANCE TABCO	7-PS-62
18	1	REFRIGERATOR, REACH-IN	TRUE FOOD SERVICE	TR2R-4HS
19	-	SARE NUMBER		
20	-	SARE NUMBER		
21	1	CHEF'S COUNTER	RANDELL	CUSTOM
22	1	DROP-IN, HOT WELLS	RANDELL	95604-208DM2
24	2	DROP-IN, DISH DISPENSERS, HEATED	APW WY011	HL-10
5				
26				
27	1	OVEN, CONVECTION, GAS	VULCAN-HART	SG44C
28	1	STEAMER, BOILERLESS, ELECTRIC	GROEN	2-55B-3EF
29	-	SARE NUMBER		
30	-	SARE NUMBER		
31	1	KETTLE, COUNTER, ELEC, TILT	GROEN	TDB-40
31A	1	STAND, KETTLE, ELECTRIC	GROEN	TS-9-124700
32	1	GRIDDLE, GAS	VULCAN-HART	938A
33	1	FRYER BATTERY, GAS W/FILTER	VULCAN-HART	22P45DF
34	1	RANGE, RESTAURANT, GAS	VULCAN-HART	60L
35	1	EXHAUST HOOD	CAPTIVE-AIRE	
37	1	DISHTABLE, STRAIGHT	ADVANCE TABCO	DTS-S60-72L
38	1	COLLECTOR, FOOD WASTE	SALVADOR	SP14
39	-	SARE NUMBER		
40	-	SARE NUMBER		
41	1	WAREWASHER, DOOR TYPE, HIGH TEMP	CHAMPION	D-HB
42	1	HOOD, CONDENSATE	ADVANCE TABCO	CH-4242
44	1	SINK, HAND, WALL MOUNT	ADVANCE TABCO	7-PS-62
45	1	SINK, SCULLERY, 3 COMPARTMENTS	ADVANCE TABCO	93-63-54-24RL
46	1	RACK, POT & PAN	ADVANCE TABCO	SW-108
48	1	TABLE, WORK	ADVANCE TABCO	KSS-2410
49	-	SARE NUMBER		
50	-	SARE NUMBER		
51	1	SINK, HAND, WALL MOUNT	ADVANCE TABCO	7-PS-62
52A	1	SINK, WELDED INTO TABLE	ADVANCE TABCO	TA-11F
53	1	FILTER SYSTEM, ICEMAKER	EVERPURE	EV9324-01 (INSURICE SINGLE - 12000)
54	1	ICE MAKER	HOSHIZAKI AMERICA	KM-320MAH
MOVABLE EQUIPMENT SCHEDULE				
M-1	LOT	COOLER SHELVING, FOUR TIER	CAMBRO	CSU SERIES
M-2	-	SARE NUMBER		
M-3	LOT	DRY STORAGE SHELVING, FOUR TIER	CAMBRO	CSU SFRIFS
M-5	1	STAND, MIXER	ADVANCE TABCO	MX-SS-302
M-6	1	MIXER, COUNTER	GLOBE	SP20
M-8	1	OVEN, MICROWAVE	PANASONIC	NC 1054
M-9	1	CART, BUSSING	CAMBRO	BC340KD-110
M-10	1	TABLE, WORK	ADVANCE TABCO	KSS-302
M-11	1	CART, BUSSING	CAMBRO	BC340KD-110
M-13	1	COFFEE MAKER, SATELLITE SYSTEM	BUNN-O-MATIC	27800.0001
M-14	1	ICED TEA BREWER	BUNN-O-MATIC	24400.0000
M-15	2	DISPENSER, ICE TEA/ICE COFFEE	BUNN-O-MATIC	34100.0001
M-16	1	DISPENSER, JUICE, CONCENTRATE	BUNN-O-MATIC	32900.0000

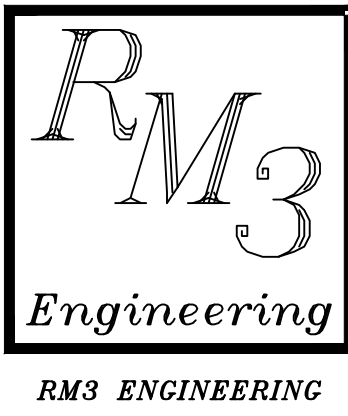

1
E12 KITCHEN POWER PLAN
1/4"=1'

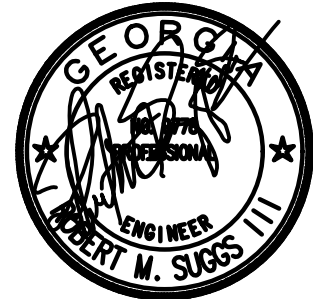

2302 Brockett Road
Tucker, Georgia
30084
770 934 0944
770 934 0945

POWER PLAN

ASSITED LIVING FACILITY
ROSSELL
ROSELL RD
SANDY SPRINGS, GEORGIA

NO.	REVISIONS

DATE: 10/4/2021
PROJECT No. 3E20-044

SHEET NO.
E12