
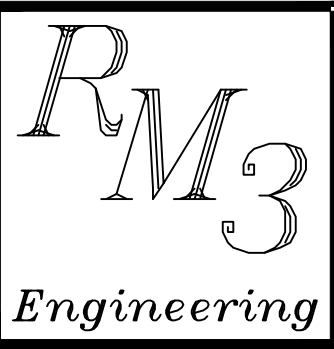


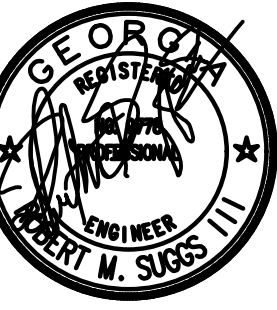

RM3 ENGINEERING

2302 Brockett Road
Tucker, Georgia
30084

770 934 0944
770 934 0945

POWER PLAN

ASSITED LIVING FACILITY
ROSSELL
ROSSELL RD
SANDY SPRINGS, GEORGIA


NO.	REVISIONS

DATE: 10/4/2021

PROJECT No. 3E20-044

SHEET NO.

E3

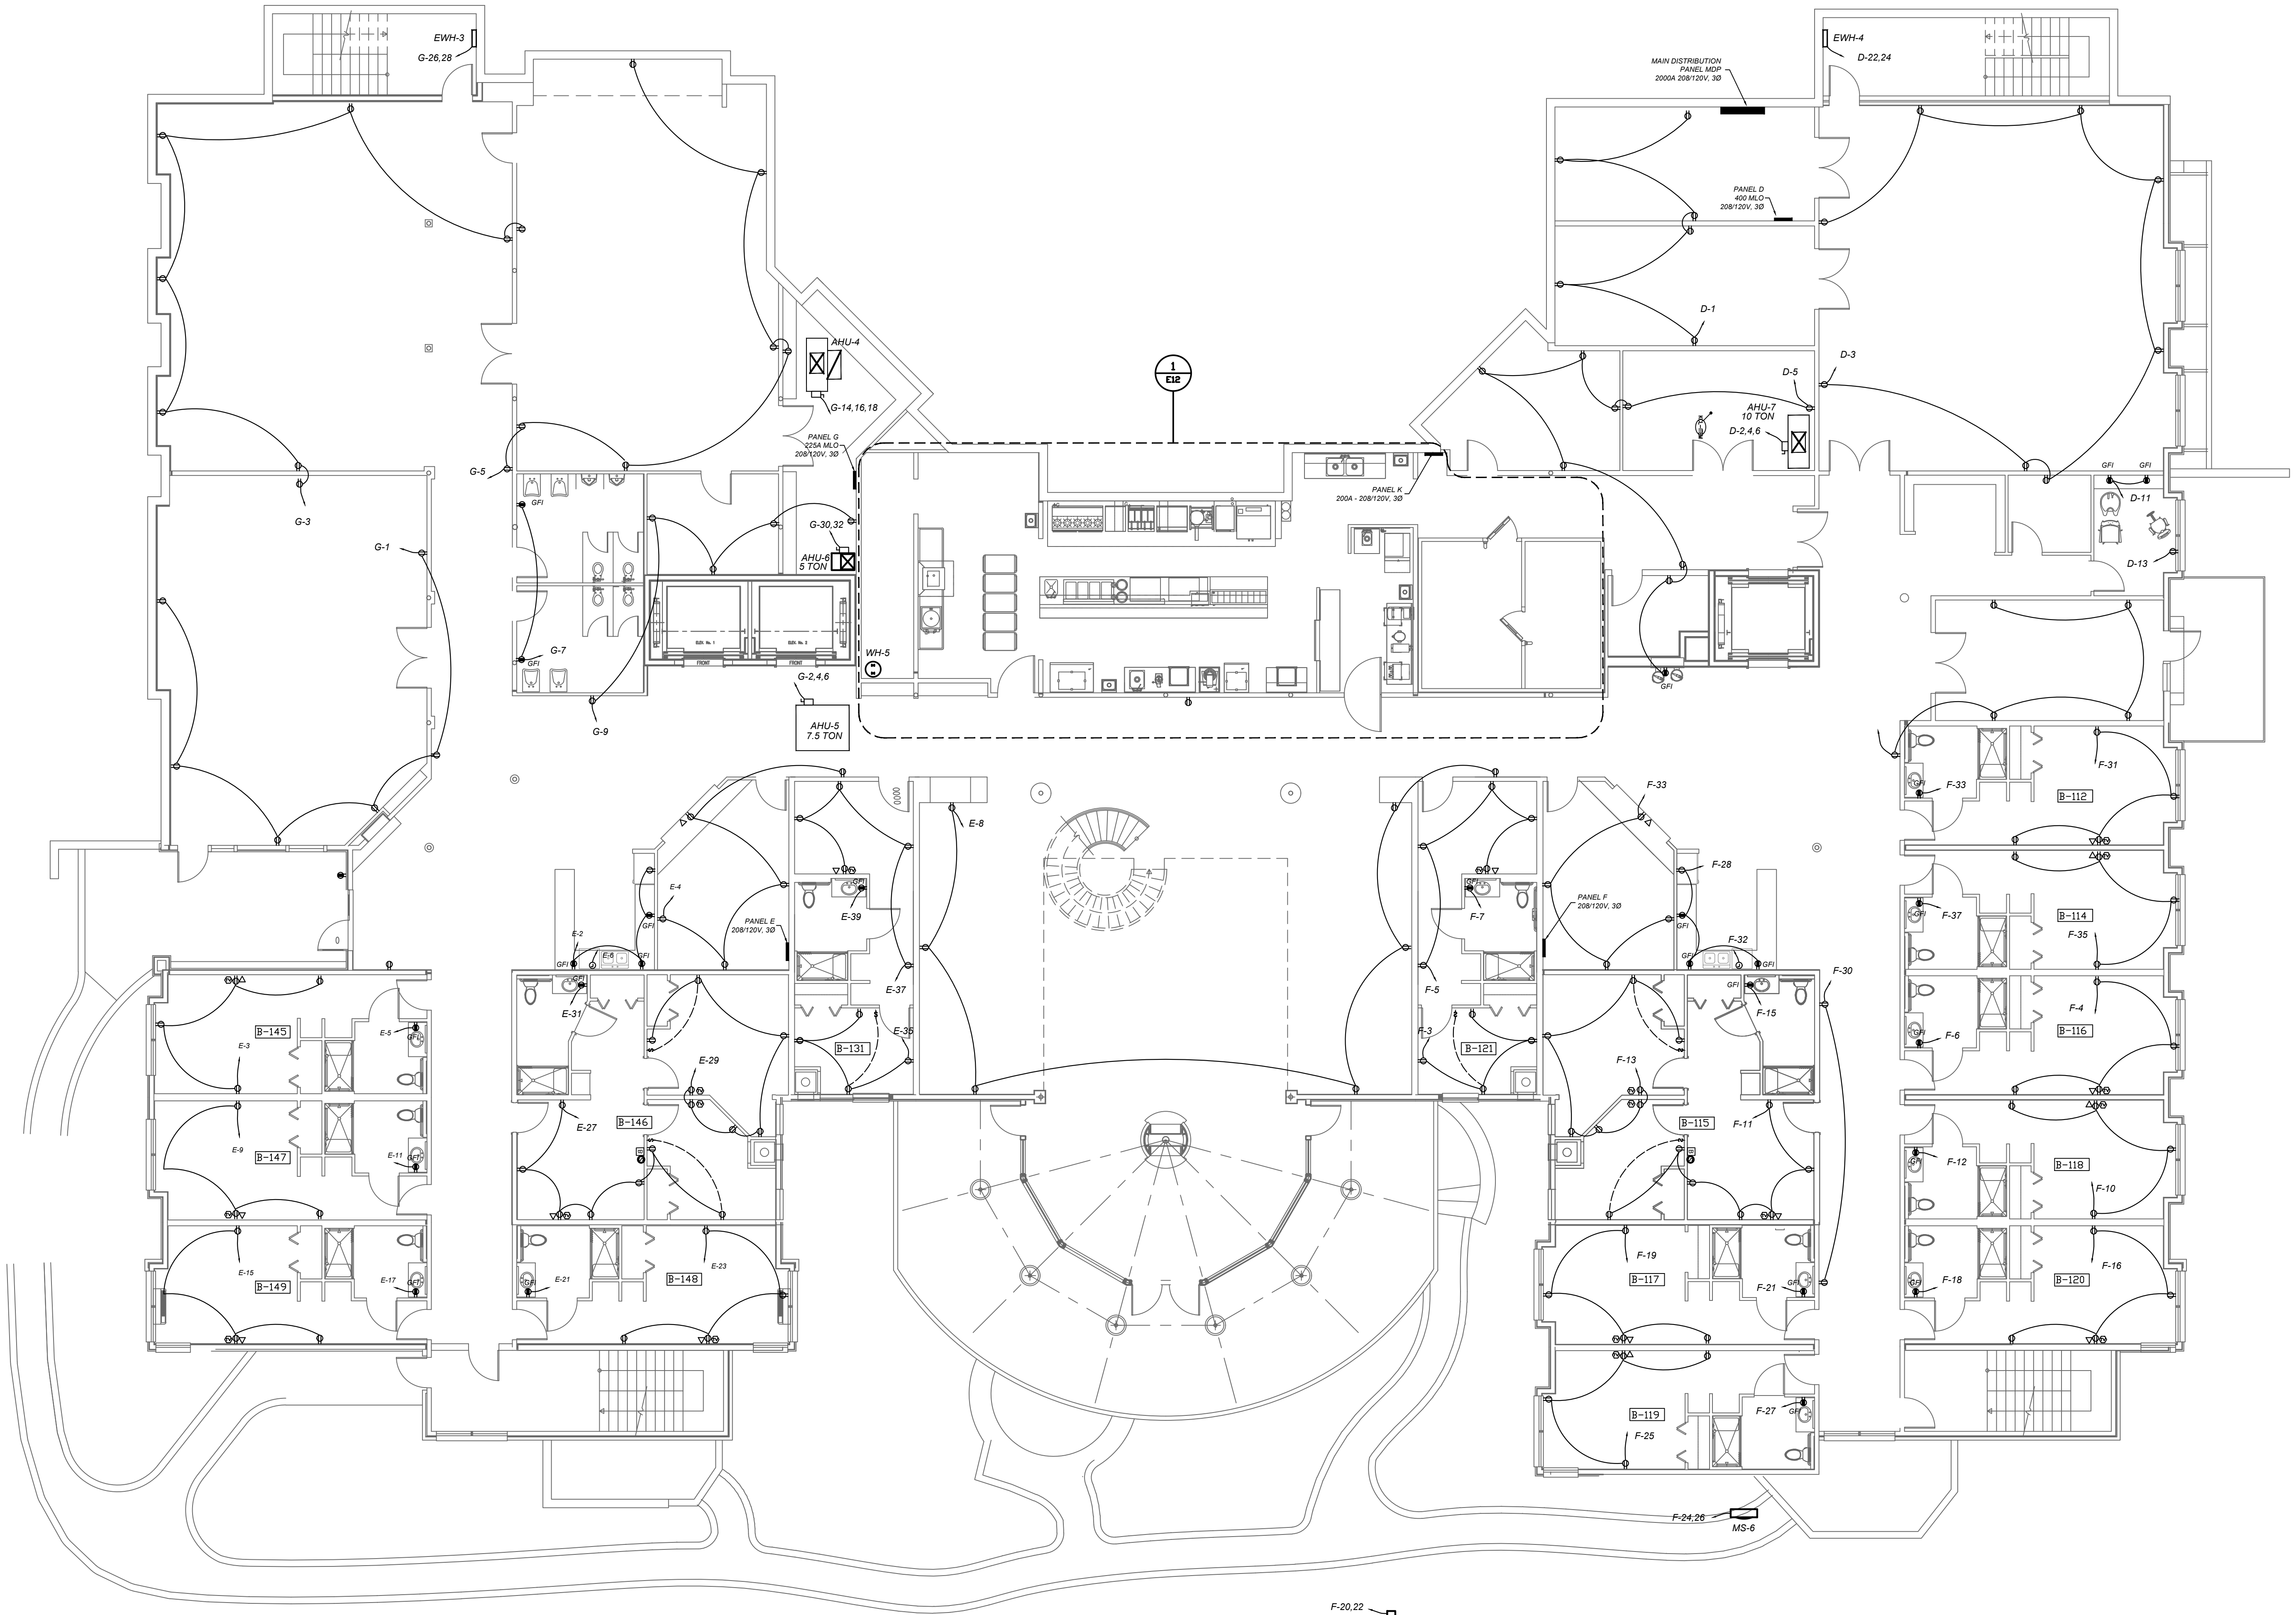

1 PATIO LEVEL PLAN
E3 1/8"=1'