
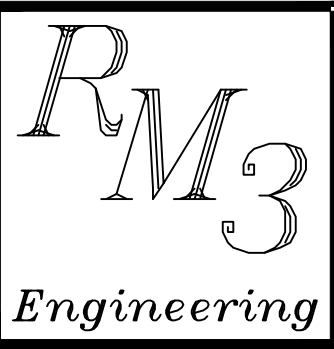


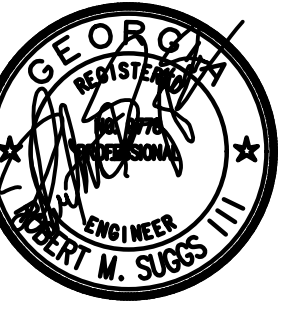

2302 Brockett Road
Tucker, Georgia
30084
770 934 0944
770 934 0945

POWER PLAN


ASSITED LIVING FACILITY
ROSSELL
ROSSELL RD
SANDY SPRINGS, GEORGIA

NO.	REVISIONS

DATE: 10/4/2021
PROJECT No. 3E20-044

SHEET NO.

E4

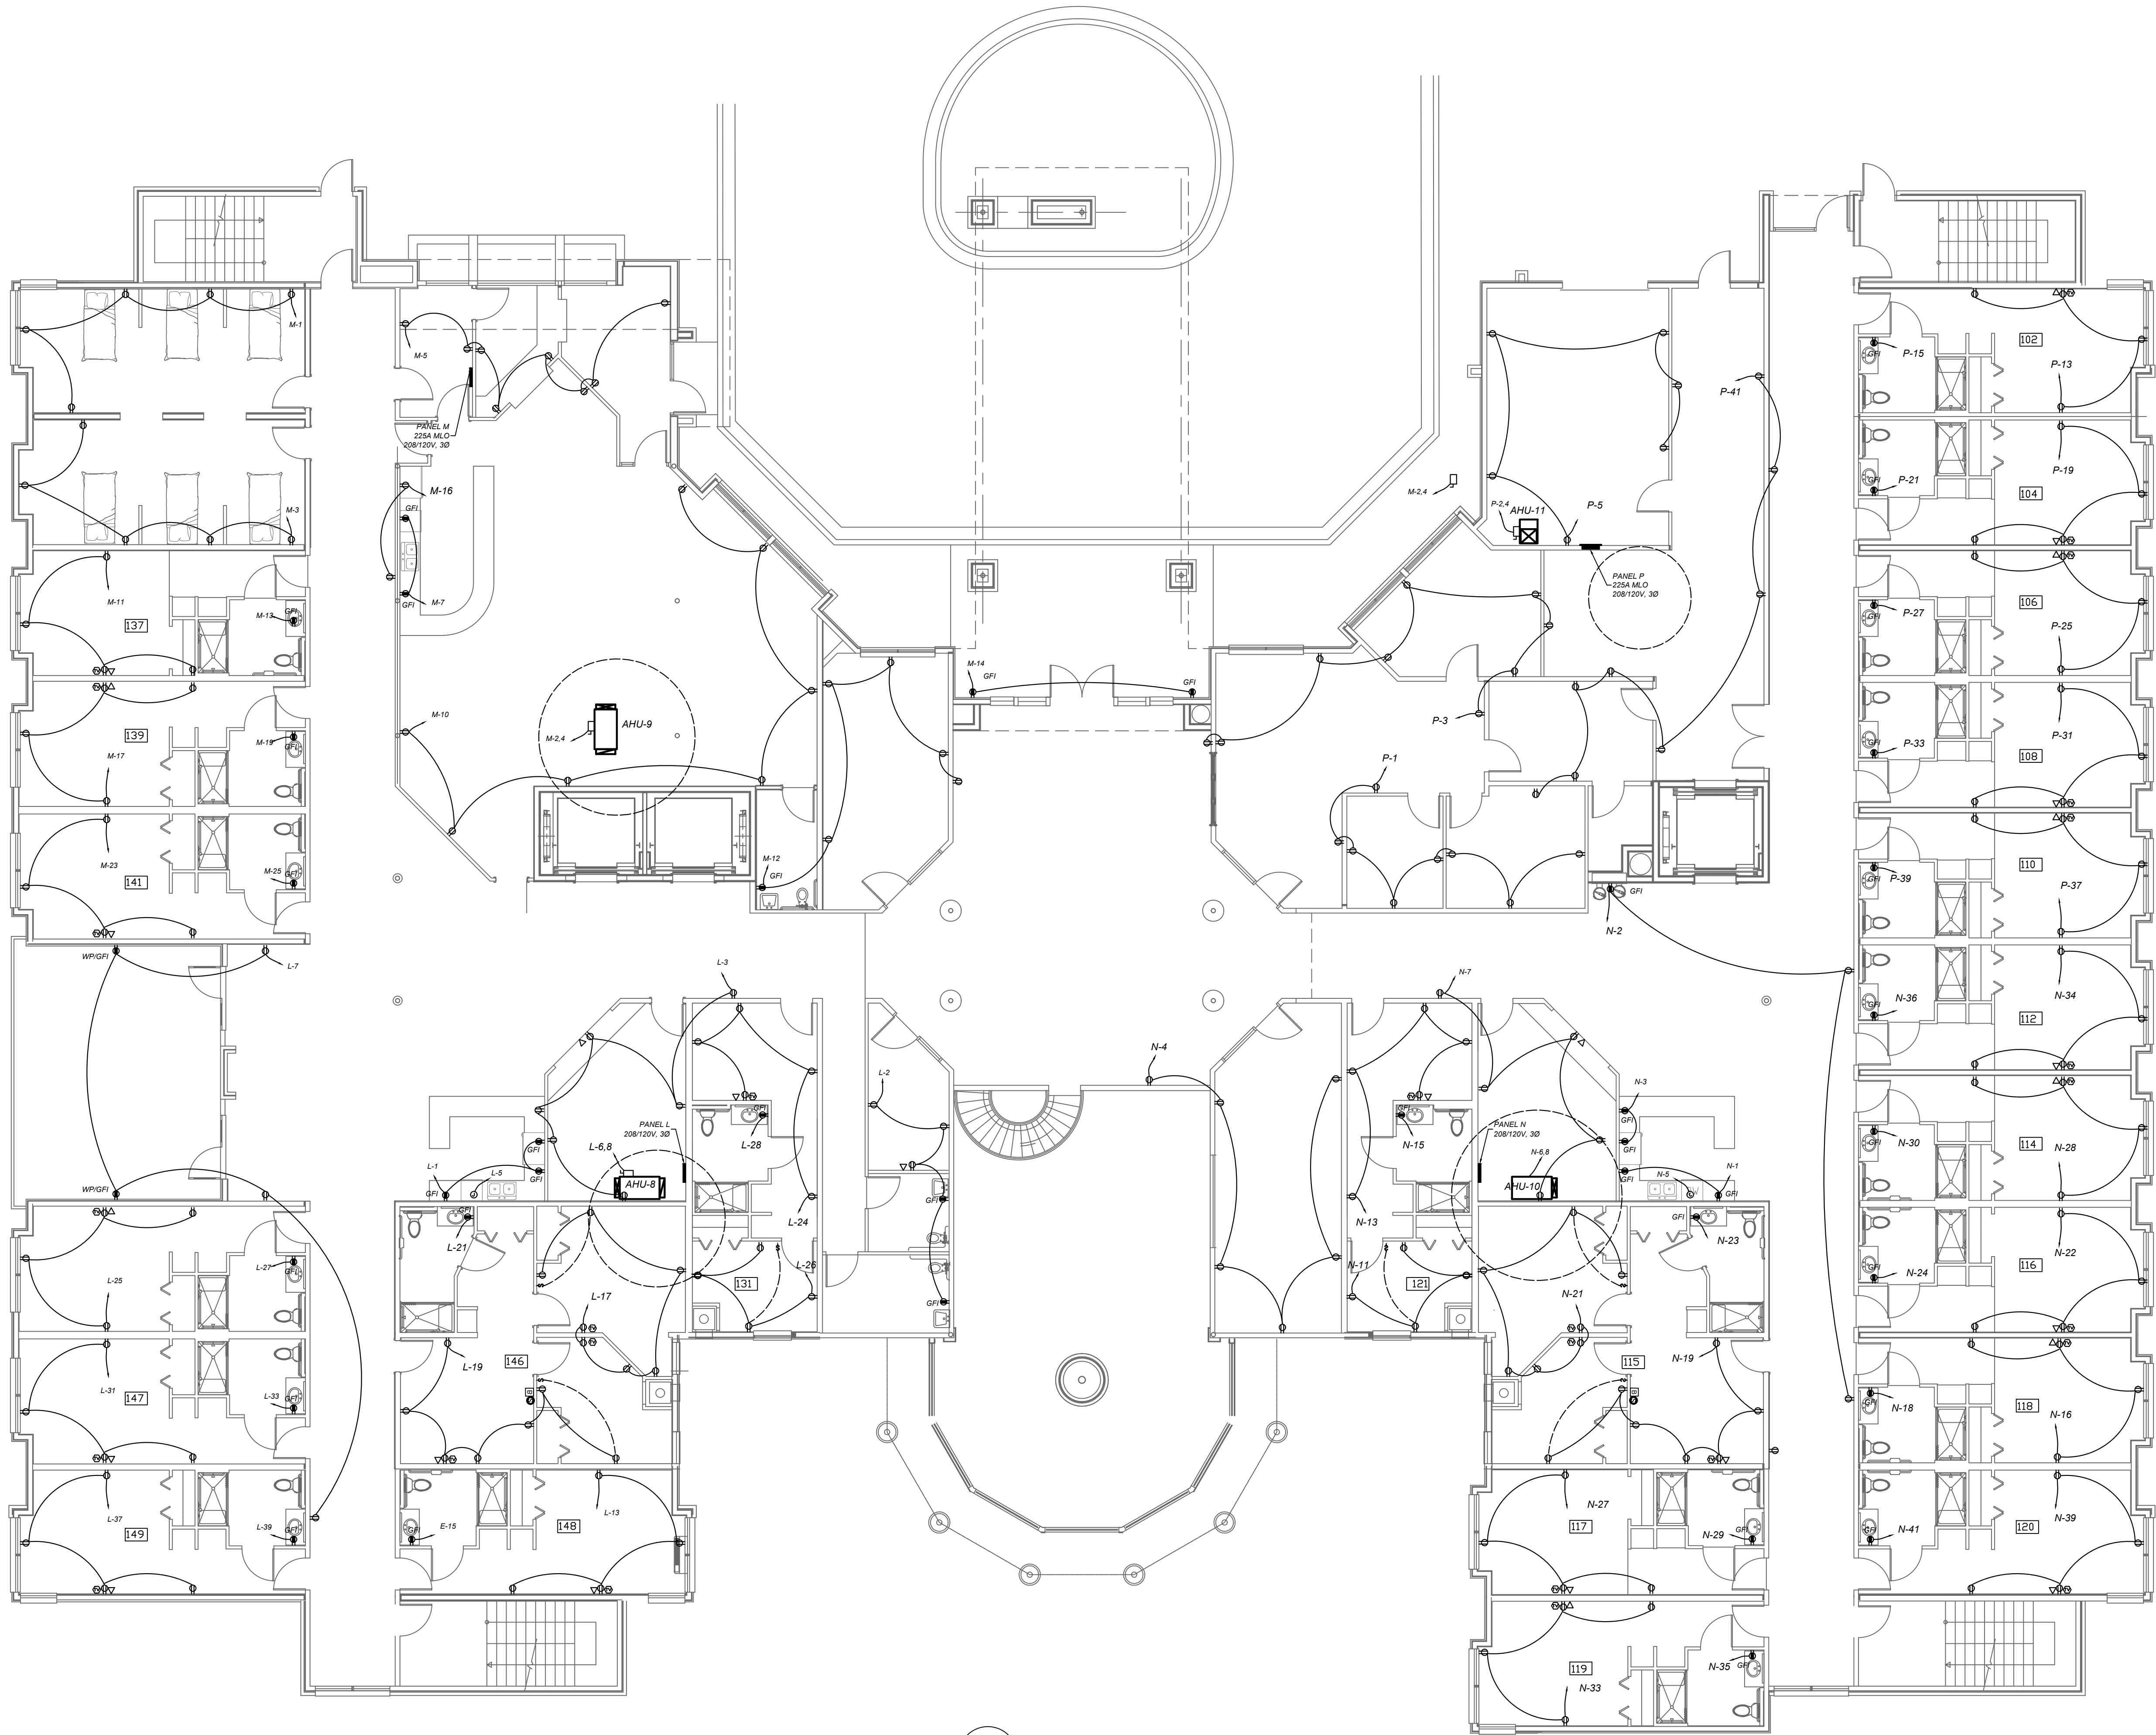

1 1ST LEVEL POWER PLAN
E4 1/8"=1'