



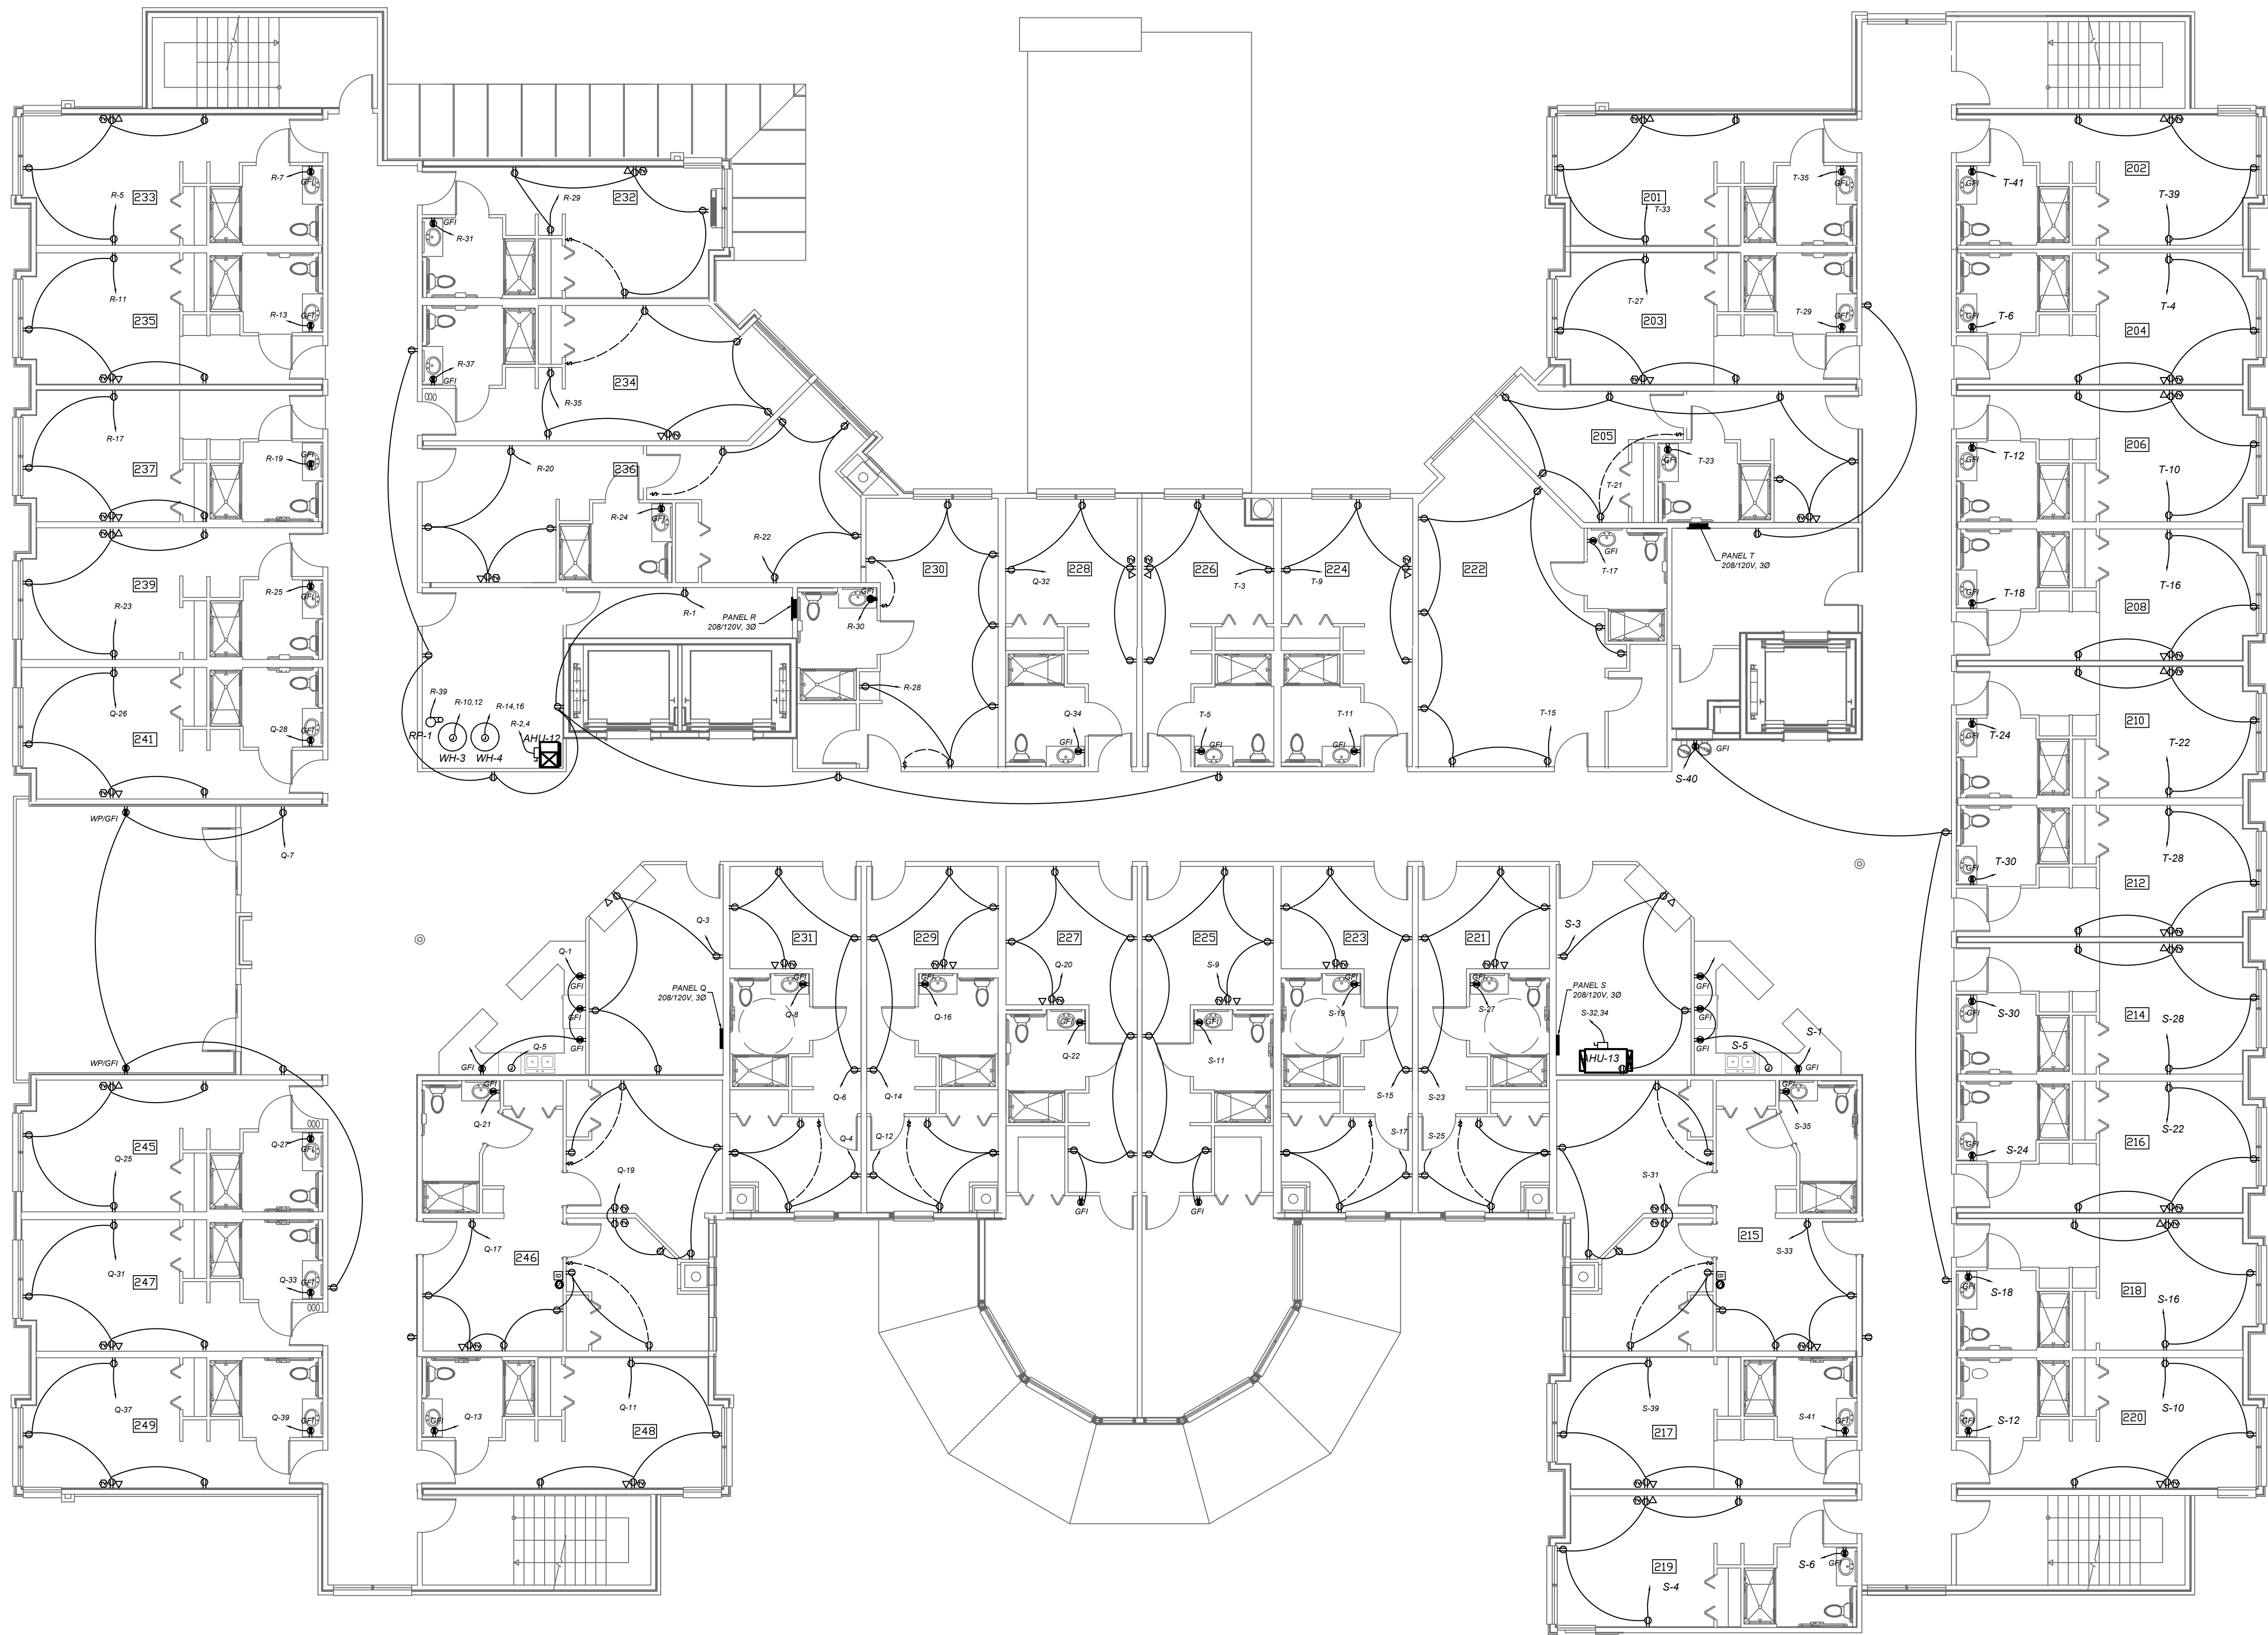

1
E5 2ND LEVEL POWER PLAN
1/8"=1'

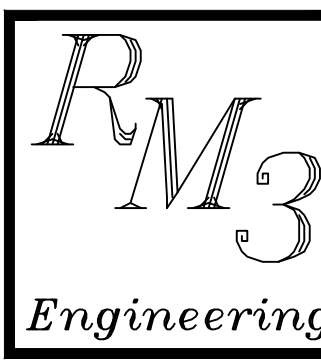

2302 Brockett Road
Tucker, Georgia
30084
770 934 0944
770 934 0945

POWER PLAN

ASSITED LIVING FACILITY
ROSSELL
ROSSELL RD
SANDY SPRINGS, GEORGIA

NO.	REVISIONS

DATE: 10/4/2021
PROJECT No. 3E20-044

SHEET NO.

E5