


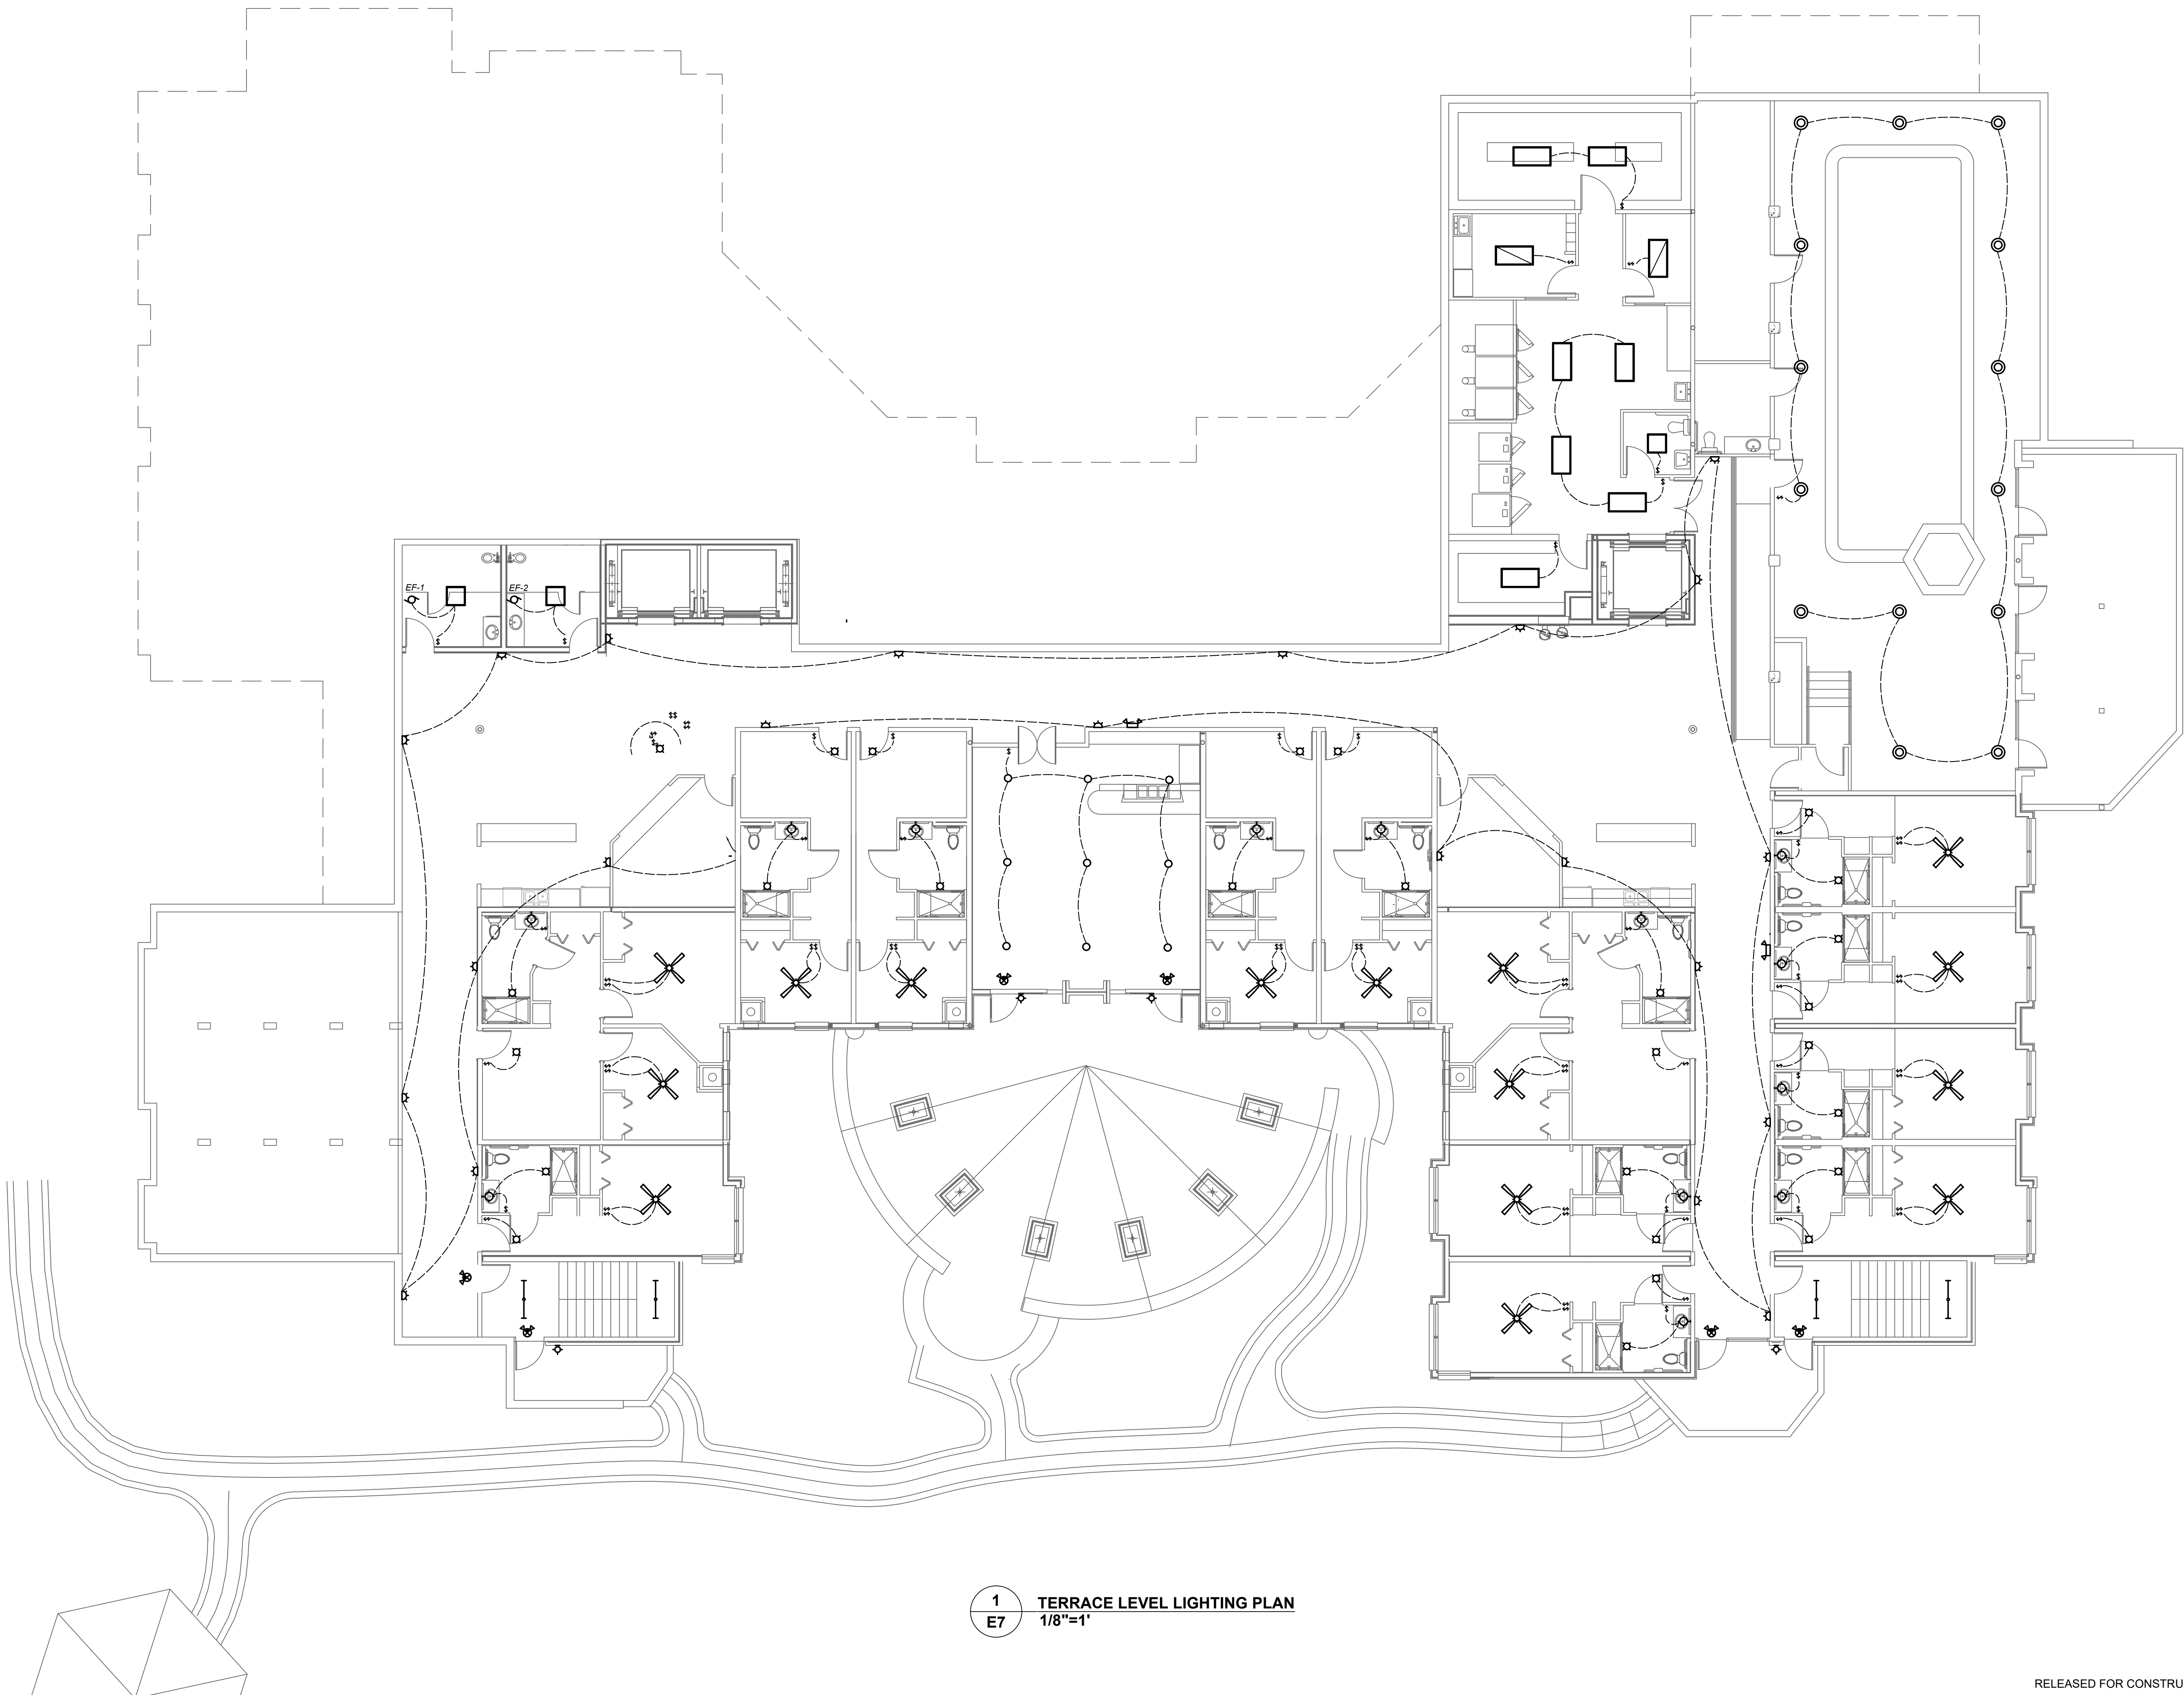

1 TERRACE LEVEL LIGHTING PLAN
E7 1/8"=1'



RM3
Engineering
RM3 ENGINEERING

2302 Brockett Road
Tucker, Georgia
30084

770 934 0944
770 934 0945

LIGHTING PLAN

ASSITED LIVING FACILITY
ROSSELL
ROSSELL RD
SANDY SPRINGS, GEORGIA

NO.	REVISIONS

DATE: 10/4/2021
PROJECT No. 3E20-044
SHEET NO.

E7

RELEASED FOR CONSTRUCTION