



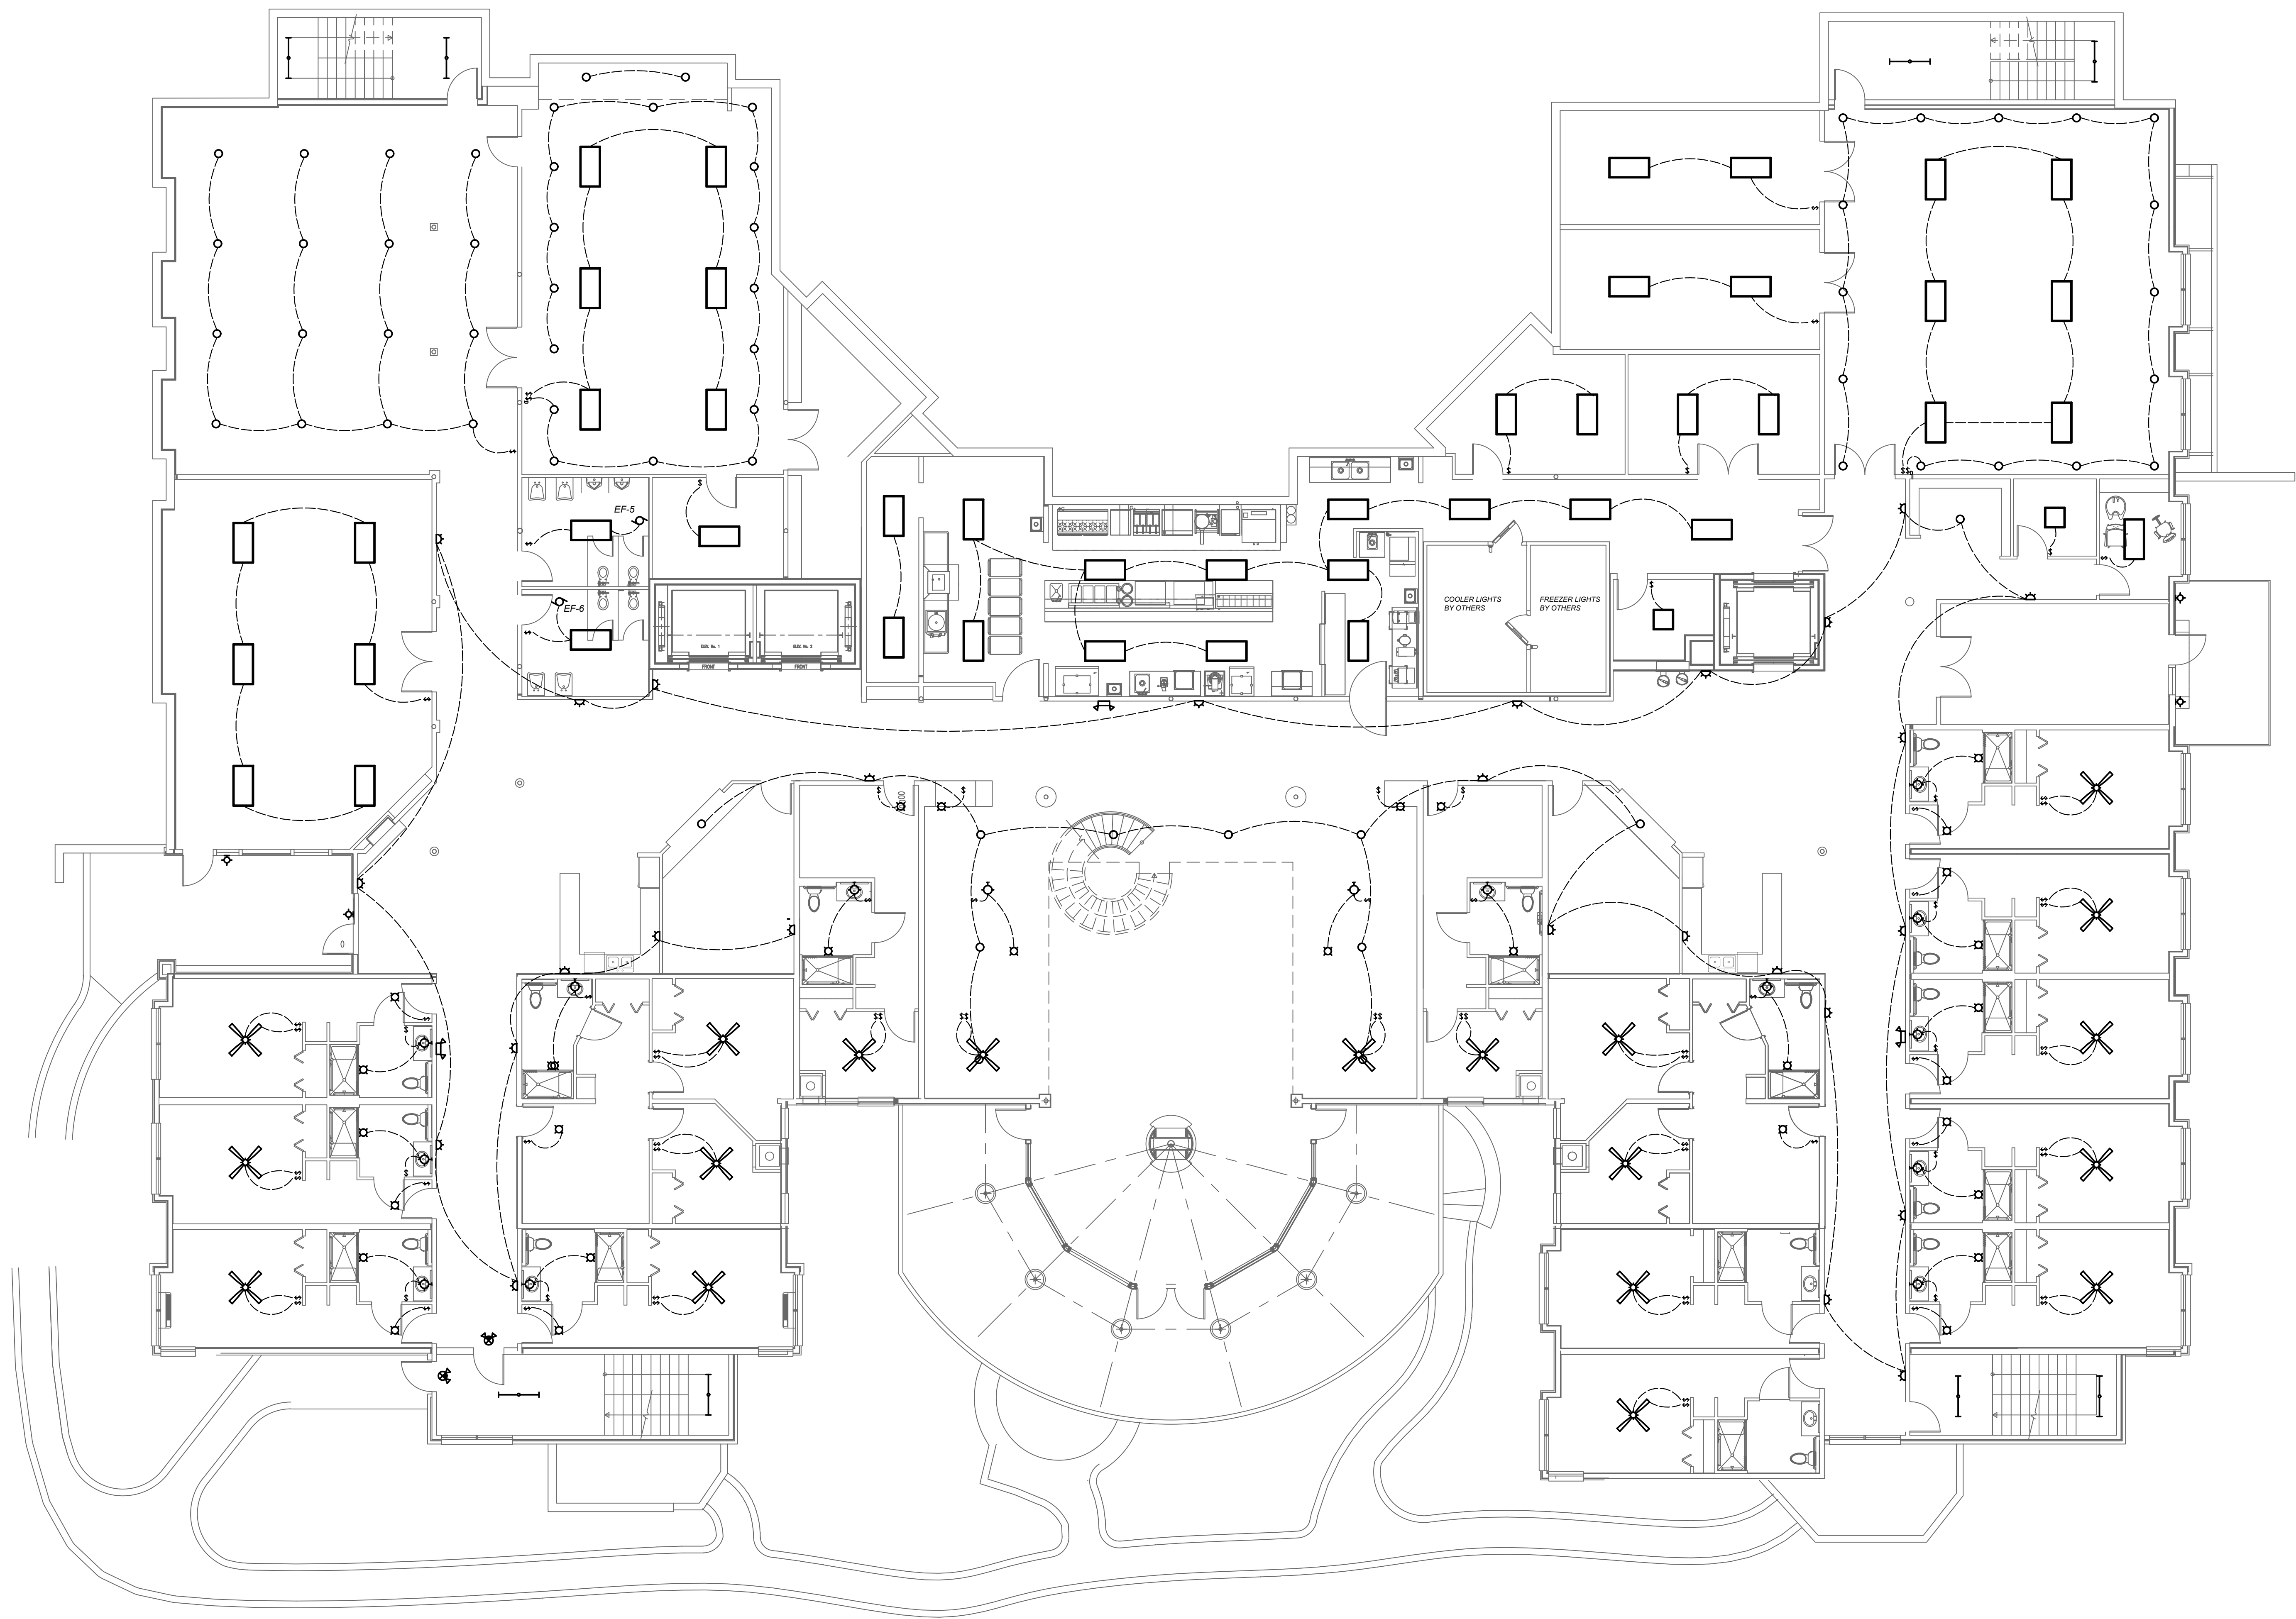

1 PATIO LEVEL LIGHTING PLAN
E8 1/8"=1'

RELEASED FOR CONSTRUCTION

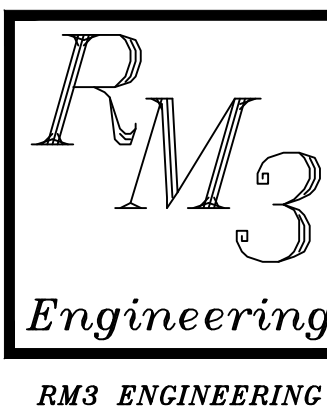

2302 Brockett Road
Tucker, Georgia
30084
770 934 0944
770 934 0945

LIGHTING PLAN

ASSISTED LIVING FACILITY
ROSWELL
ROSELL RD
SANDY SPRINGS, GEORGIA

NO.	REVISIONS

DATE: 10/4/2021
PROJECT No. 3E20-044

SHEET NO.

E8