



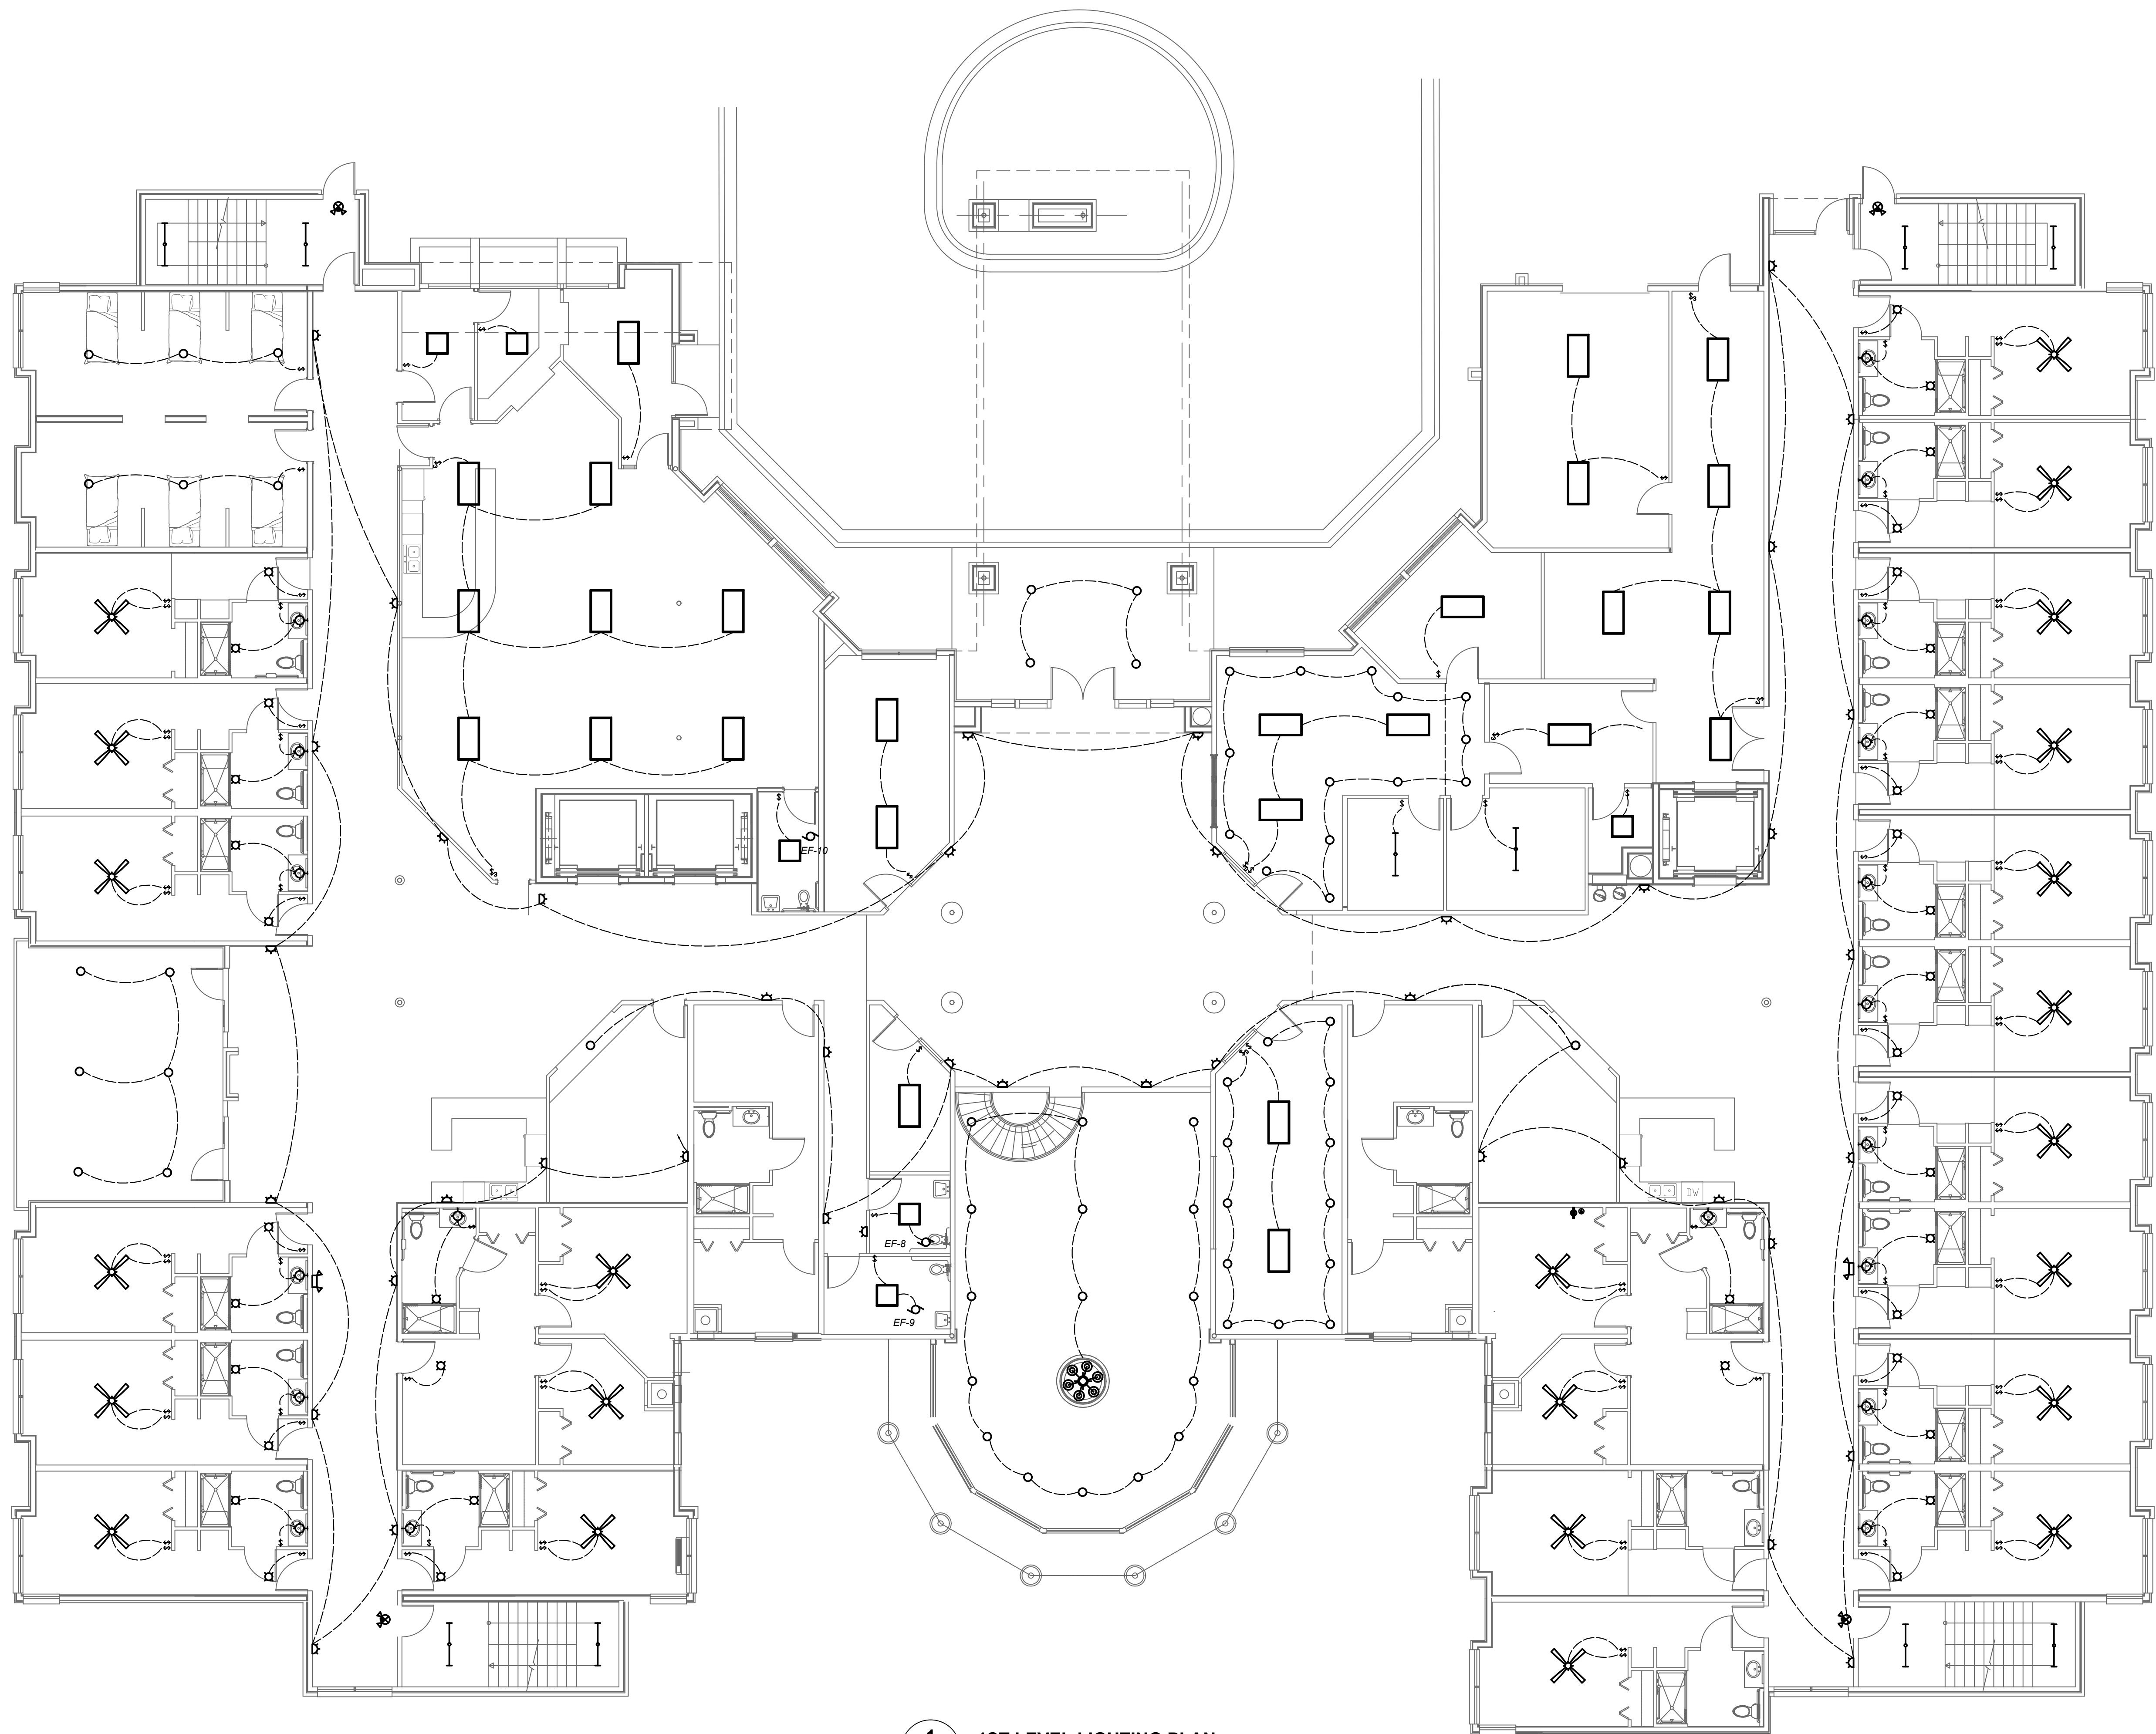

1  
E9 1ST LEVEL LIGHTING PLAN  
1/8"=1'

RELEASED FOR CONSTRUCTION

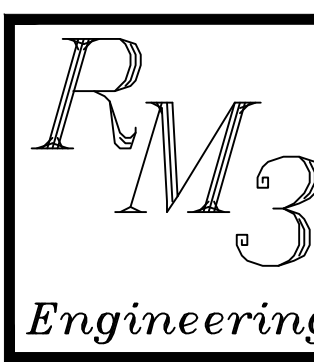

2302 Brockett Road  
Tucker, Georgia  
30084  
770 934 0944  
770 934 0945

LIGHTING PLAN

ASSISTED LIVING FACILITY  
ROSWELL  
ROSELL RD  
SANDY SPRINGS, GEORGIA

| NO. | REVISIONS |
|-----|-----------|
|     |           |
|     |           |
DATE: 10/4/2021  
PROJECT No. 3E20-044

SHEET NO.

E9