

RM3 ENGINEERING

2302 Brockett Road
Tucker, Georgia
30084

770 934 0944
770 934 0945

PLUMBING PLAN


ASSITED LIVING FACILITY
ROSSELL
ROSELL RD
SANDY SPRINGS, GEORGIA

NO.	REVISIONS

DATE: 10/4/2021
PROJECT No. 3E20-044

SHEET NO.

P6

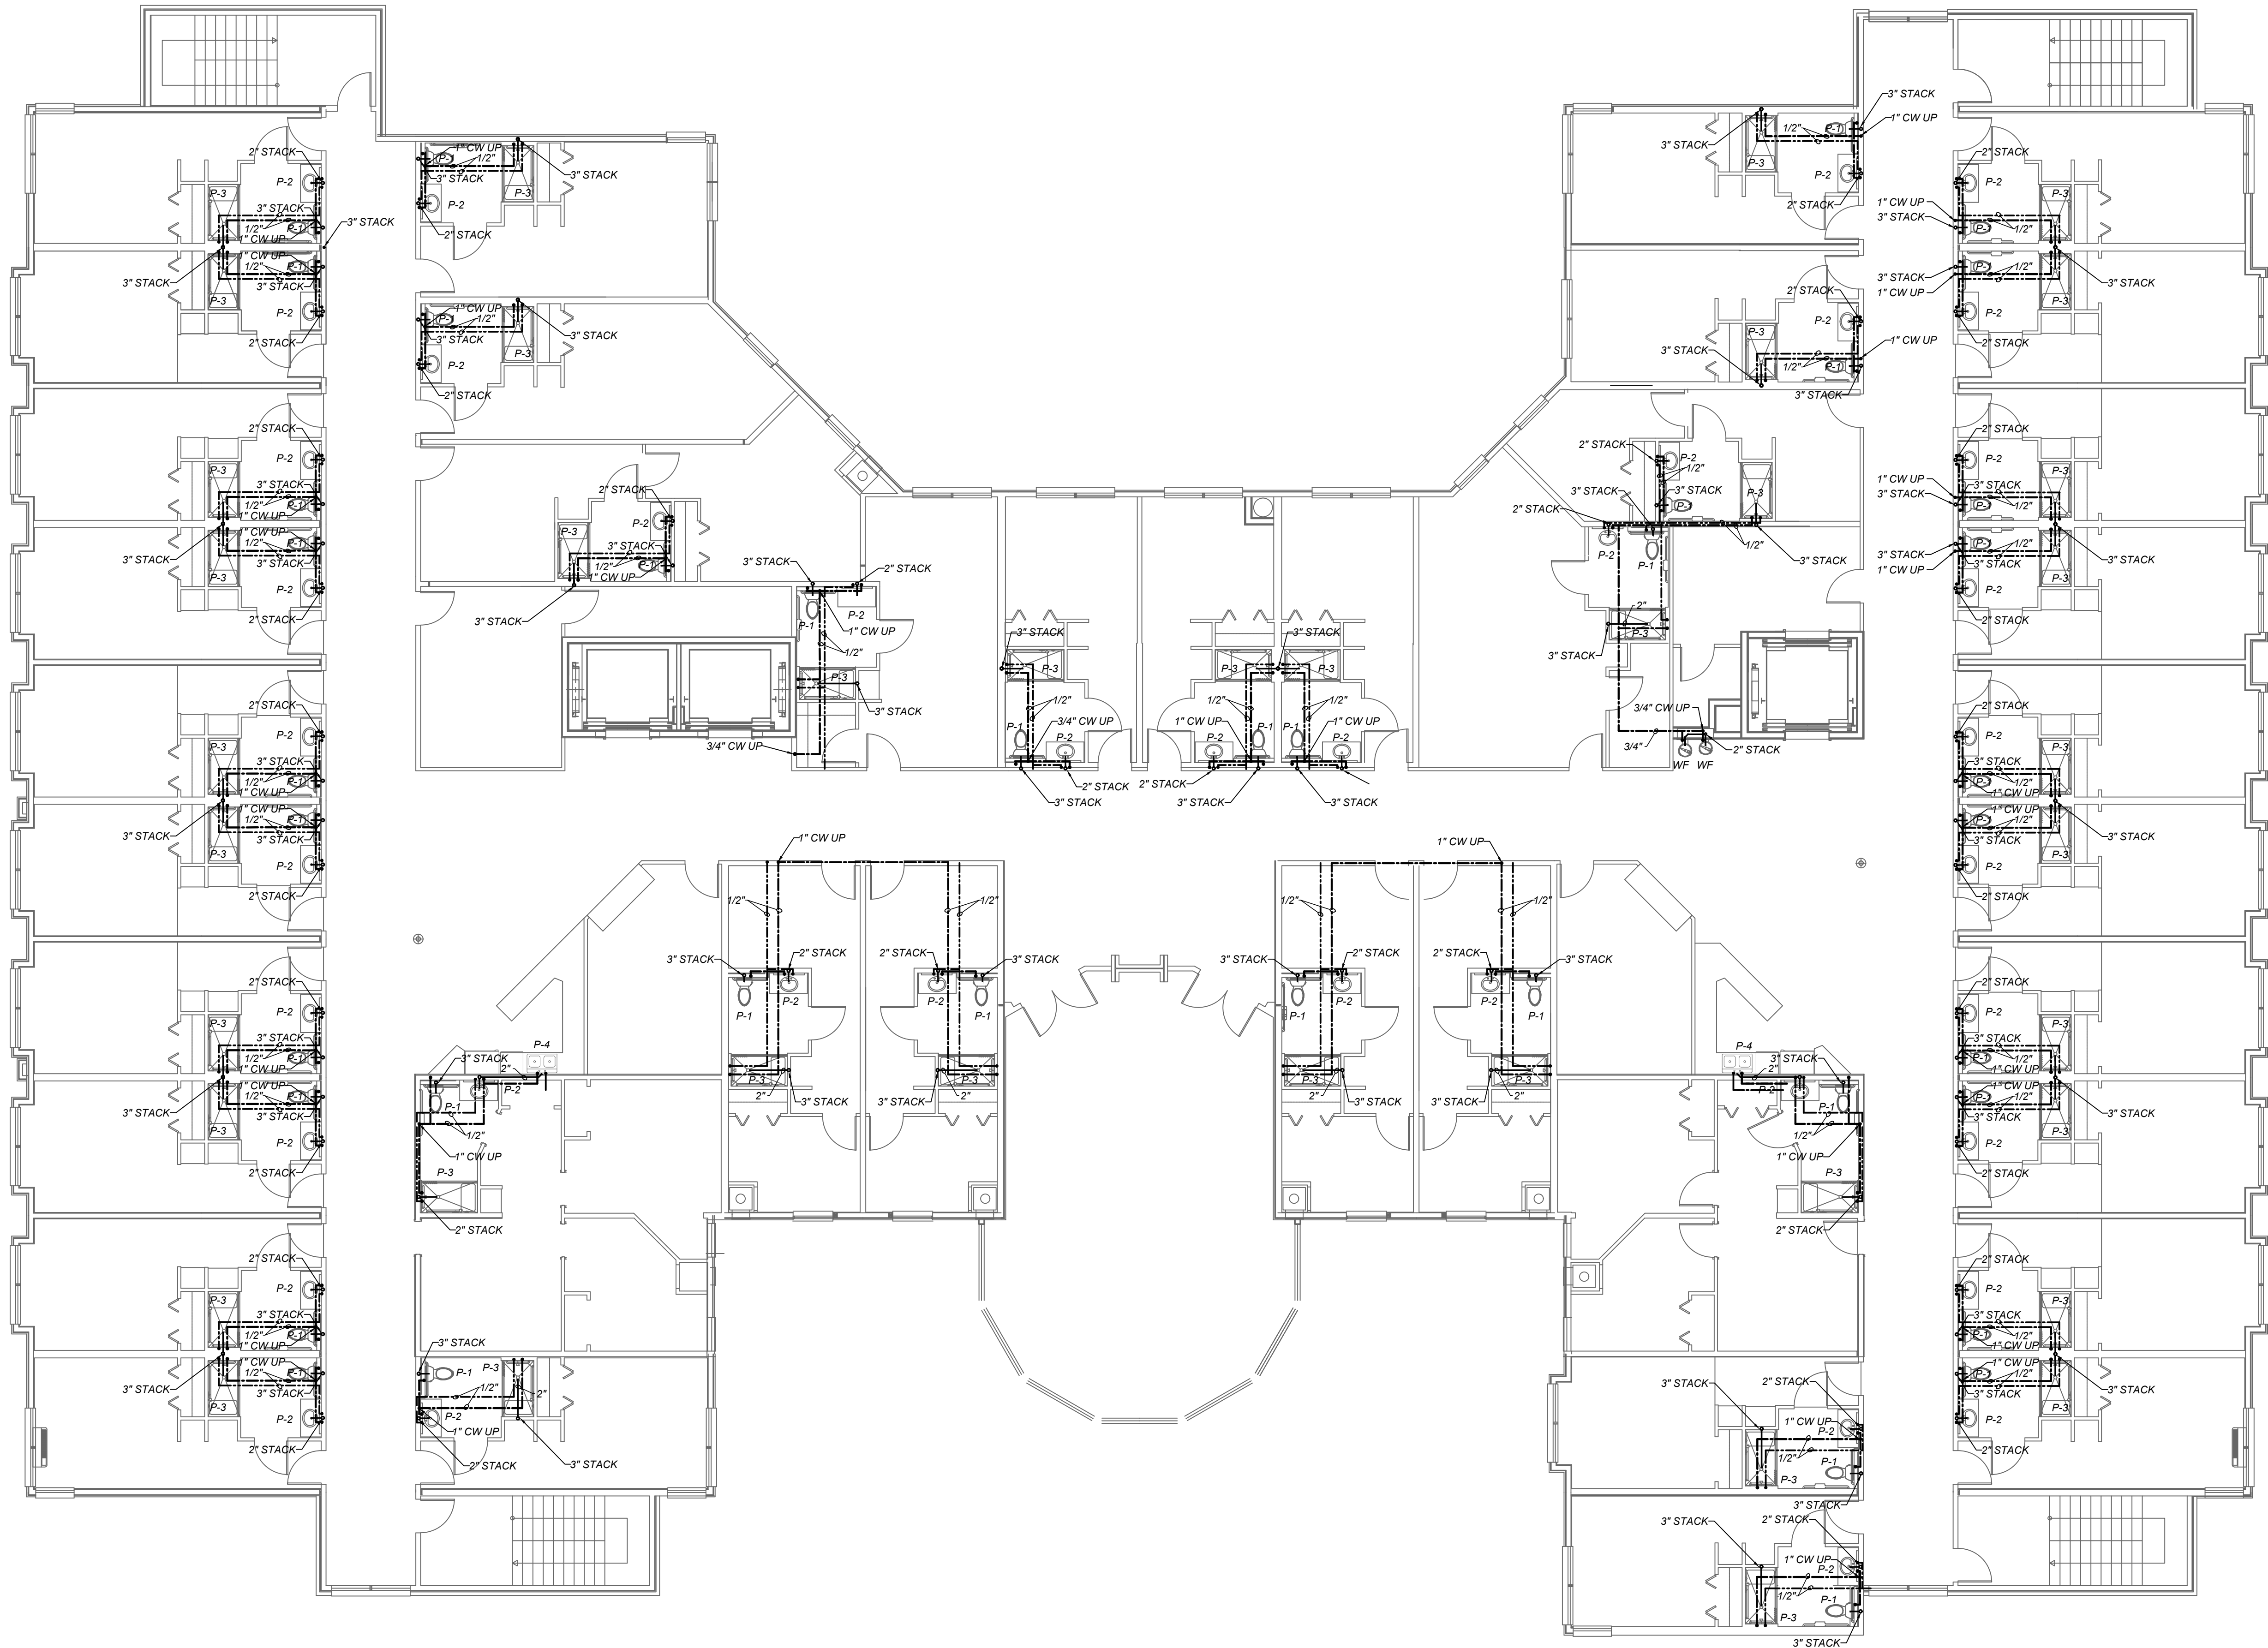

1
P6 3RD FLOOR PLUMBING PLAN
1/8"=1'