


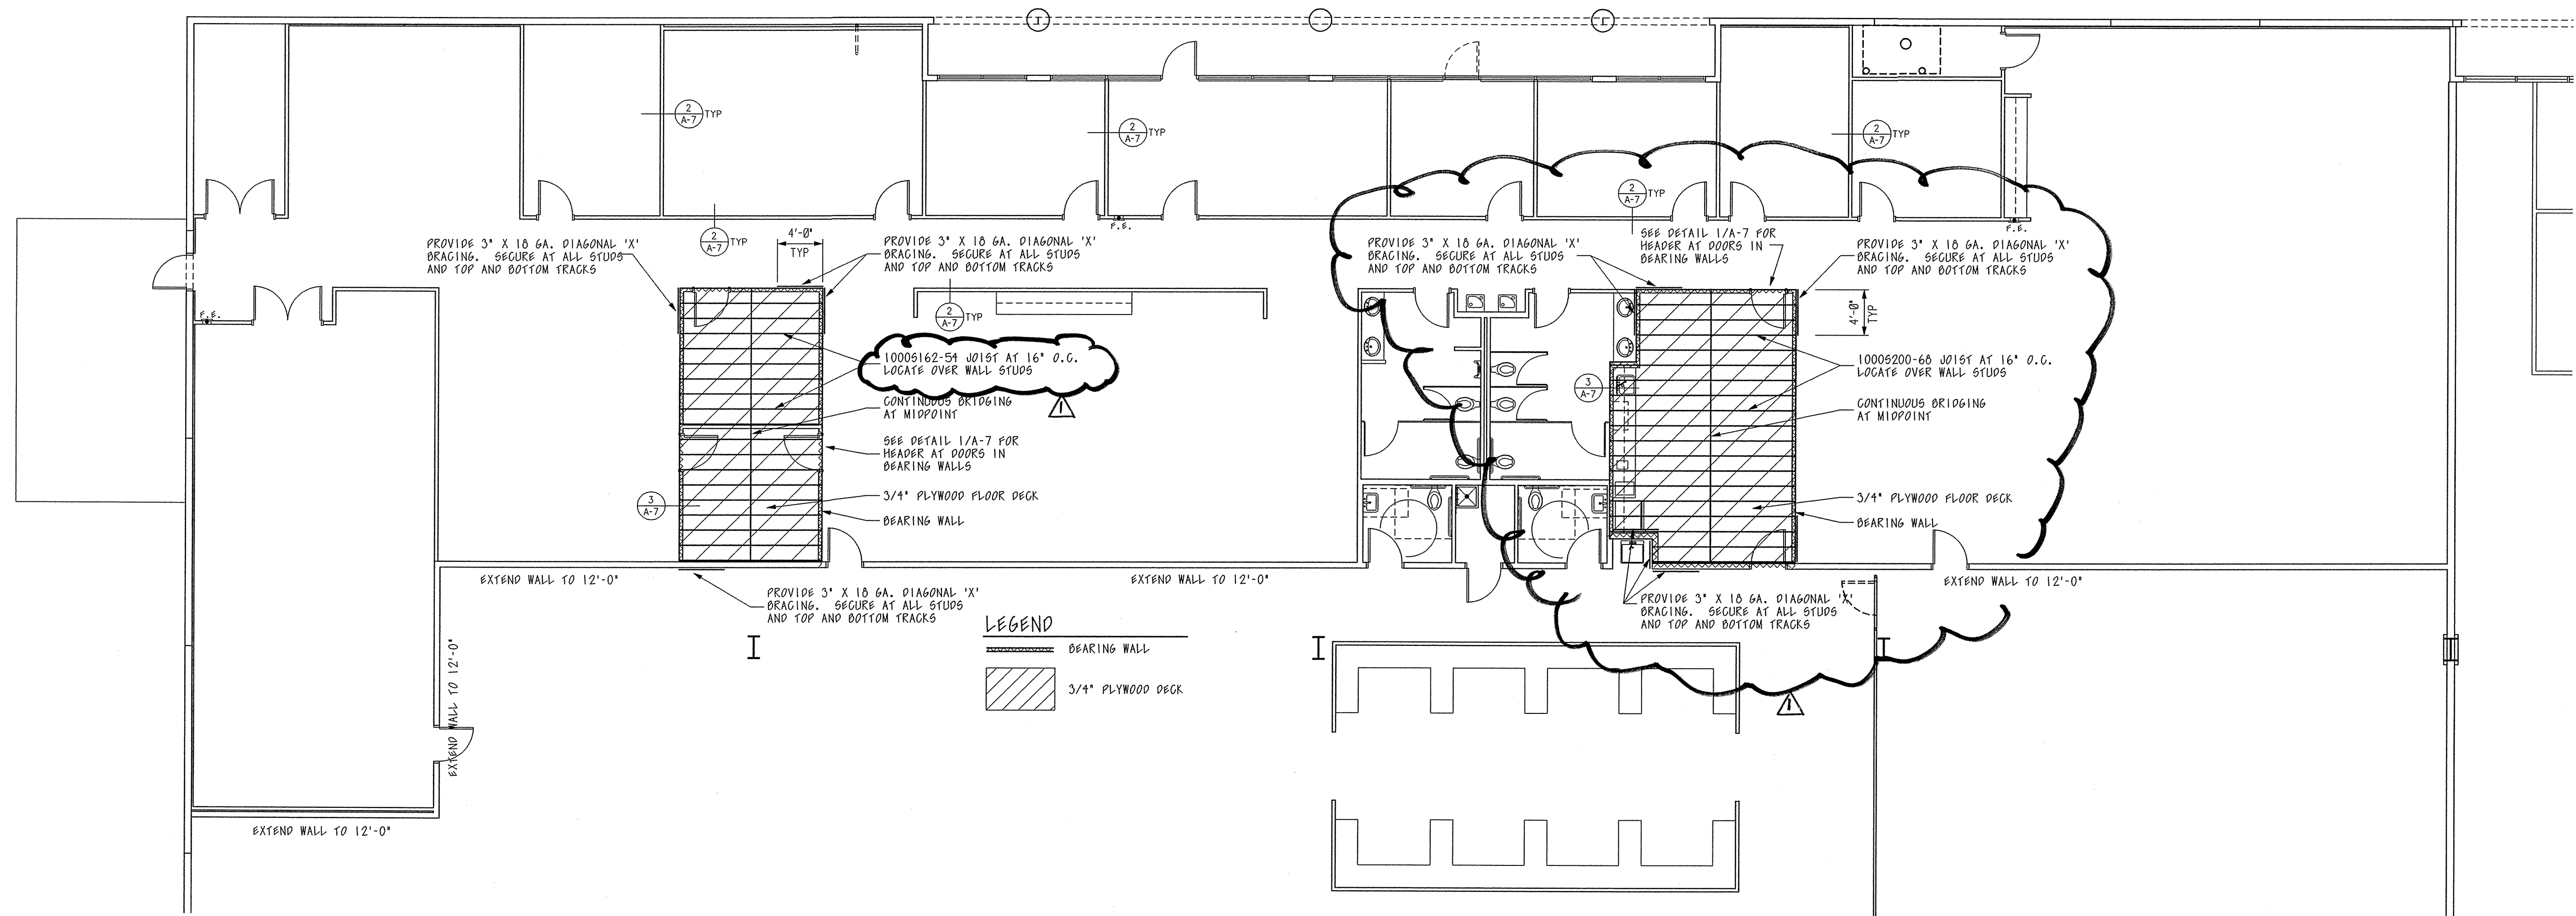

HVAC PLATFORM PLAN


SCALE: 1/8" = 1'-0"

X BRACING

- 3" X 10 GA STRAPS FROM TOP TRACK TO BOTTOM TRACK.
- SPAN ACROSS 4'-0" AT LOCATIONS SHOWN.
- PROVIDE 2-3625162-43 STUDS AT EACH END OF X-BRACING.
- PROVIDE 0-10 S.D. SCREWS AT EACH END OF EACH STRAP TO POST.

NON-LOAD BEARING WALLS

- WALLS SHALL BE BRACED TO STRUCTURE AT 4'-0" AND/OR
- EXTEND WALLS TO THE STRUCTURE AND/OR
- BRACE WALLS AT CORNERS ACROSS TOP OF WALL, 4'-0" EACH WAY AND/OR
- WALLS MAY BE BRACED TO EACH OTHER, SUCH AS ACROSS THE CORRIDOR AT 4'-0" O.C. OR TO OTHER BRACED WALLS SUCH AS THE MEZZANINES.
- PROVIDE A STRUCTURAL STEEL POST AT A SPECIFIED SPACING OF 10'-0" O.C. MAX WITH A METAL "HEADER" ACROSS THE TOP, INFILLED WITH METAL STUDS. THE POSTS WOULD INVOLVE CUTTING AWAY SOME OF THE EXISTING FLOOR SLAB TO INSTALL A NEW FOOTING AND BASE PLATE. DETAIL AVAILABLE UPON REQUEST.

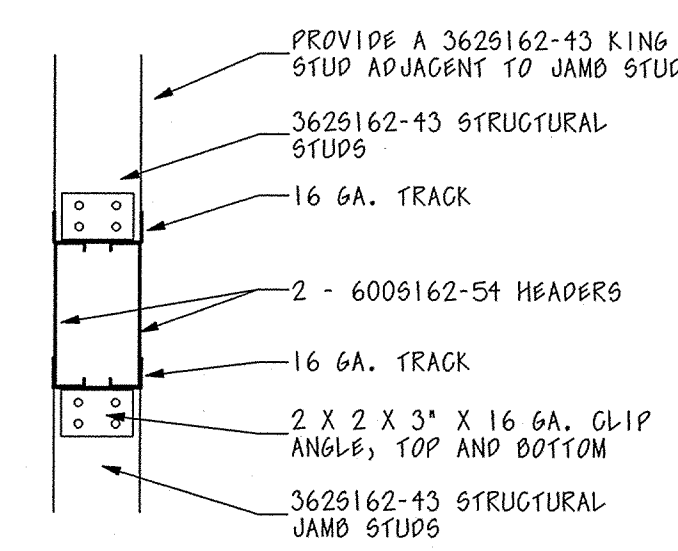


DETAIL 1

A-7

SCALE: 3/4" = 1'-0"

DOOR HEADER AT BEARING WALLS

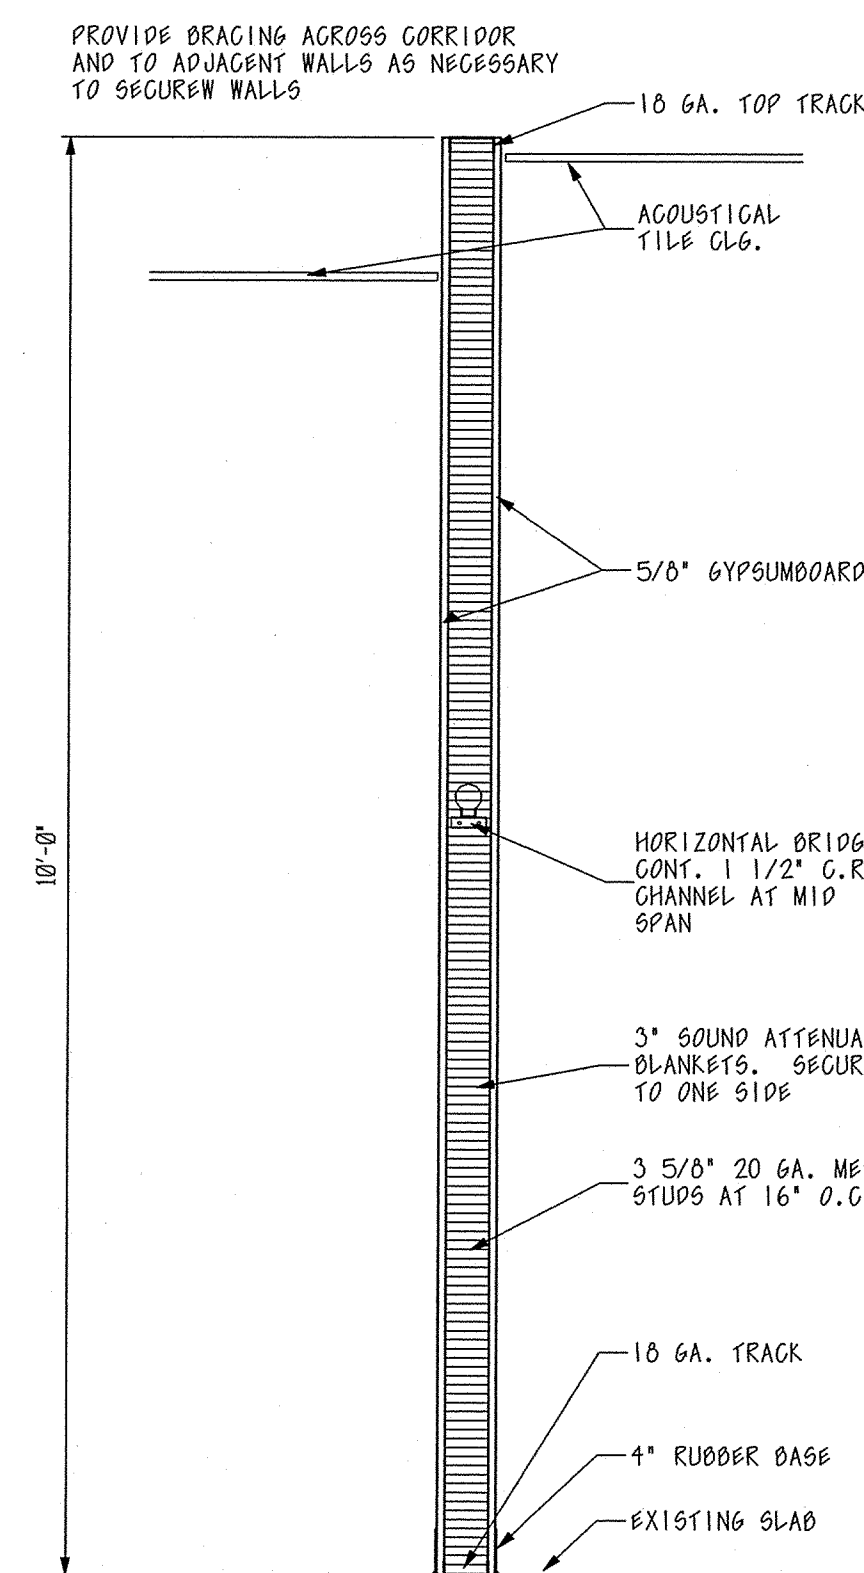


DETAIL 2

A-7

SCALE: 3/4" = 1'-0"

TYPICAL WALL SECTION

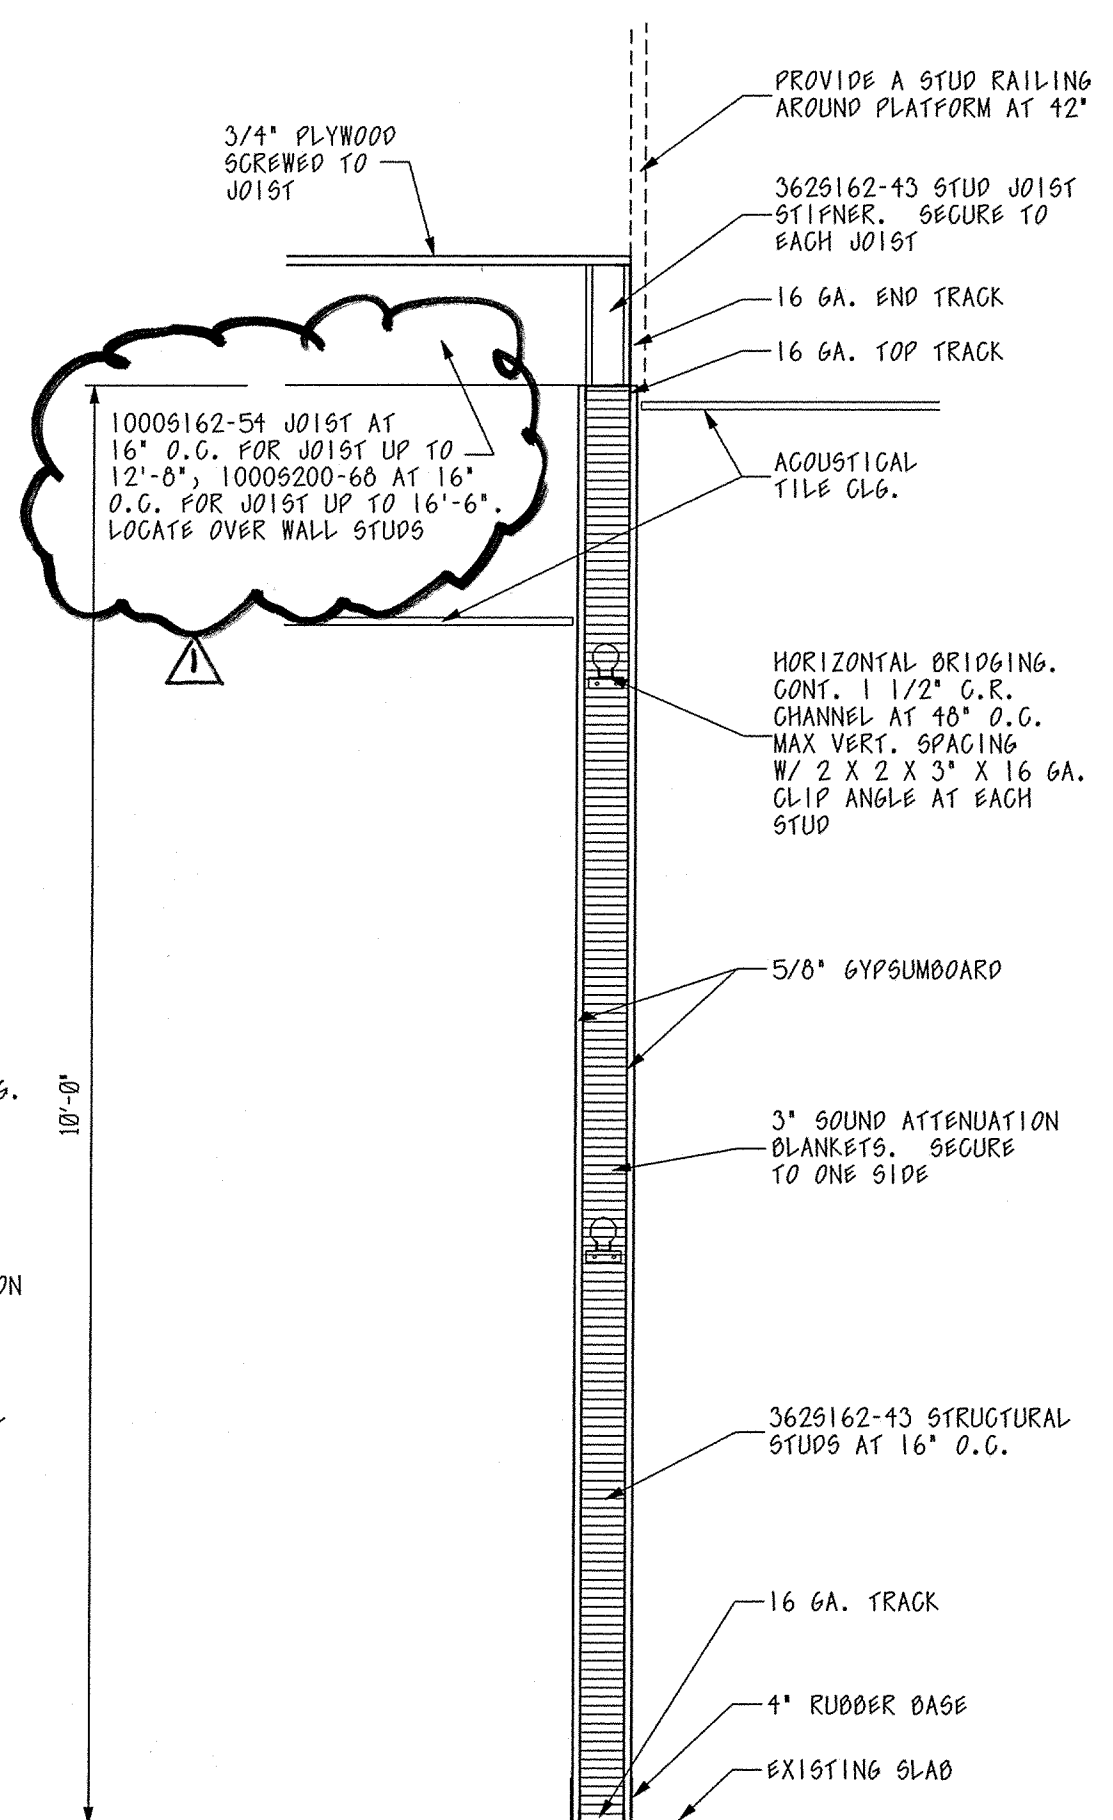

DETAIL 3

A-7


SCALE: 3/4" = 1'-0"

WALL SECTION AT HVAC PLATFORM



NEW FACILITY BUILDOUT FOR
CHEM-AQUA
ENGINEERED EQUIPMENT SOLUTIONS
580 JOE TAMPLIN INDUSTRIAL BLVD.
MACON, GEORGIA

DRAWN BY: R.A.D.
CHECKED BY: R.A.D.
DATE: JUNE 1, 2015

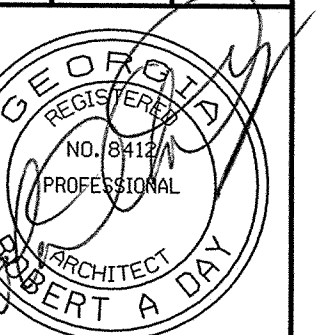

ADAMS and DAY
ARCHITECTS, AIA, P.C.
2906 VINEVILLE AVENUE - MACON, GEORGIA 31204
PHONE (478) 745-1167

REVISIONS
1 7-31-15

DRAWING NO.

A-7