

RESPONSIBILITY SCHEDULE

		FURNISH			INSTALL				
	OWNER	RSCS	GC	NOTES	OWNER	RSCS	GC	NOTES	N/A
OWNER SUPPLIED									
CCTV (includes 7 cameras)	●							2	
Mood Media - Speaker System - supply of team (Base CAPEX set-up. See RSCS section for Subscription to set up).	●							3	
Alarms (from 4 door alarms to 2 x 360 motion dete (GC to allow conduit and J boxes)	●							2	
"Hold Up" Security Button by Security System Supplier	●							2	
Safe - option to own or Safepoint subscription service as OPEX.	●							2,4	
Consulting Services - Commissioning Equipment	●							5	
Work Zone Camera - site build security (if wanted)	●							6	
IDC (International Development Charge) or PM	●								●
Grease system (new and disposal oil)								●	
UTILITIES									
Site Utilities		●						●	
Telephone line		●						●	
Cables & Misc.		●						●	
MISC.									
Post Control/eradication (termites etc)		●						●	
Hazardous Materials (Asbestos, old trash site, oil clean up)		●						●	
Indigenous Artefact/Historical Artefact discovery								●	
Misc.		●						●	
BUILDING WORK									
Concrete		●						●	
Steel - Stainless Steel Caps/Corner Guards and Panels		●						●	
Rough Carpentry (Woods, Ply, Plastics, Nails) - Includes Framing & Truss Packages		●						●	
Openings (Doors, Windows, Glass)		●						●	
Finishes - Gypsum (Drywall)		●						●	
Finishes - Tiles - Floor		●						●	
Finishes - Tiles - Wall		●						●	
Finishes - Walls - FRP		●						●	
Finishes - Silikal Floors (BOH mono floor)		●						●	
Finishes - Ceiling (acoustical)		●						●	
Specialites (Fire extinguishers etc)		●						●	
Equipment - Install Only (product provided by RSCS - see that section) GC shall provide all rough-ins.	●							●	
Furnishings & Décor (Install) - & Millwork, Finish Carpentry. See Interior Decor & Seating Sections		●						●	
Countertop Support Leg W/ Adjustable Base		●						●	
Telecommunications install & All Low-Voltage, including all back boxes, stubs, and conduit to 6' above ceiling for all Data.		●						●	
Fire Suppression (Ansul or similar approved System) - GC shall Furnish & Install in its entirety		●						●	
Refrigeration Connection		●						●	
Plumbing		●						●	
Grease Trap & Piping		●						●	
Sewer and Piping		●						●	
HVAC Units/Mechanical including all related Thermostats		●						●	
Grease Exhaust Fan, Hood Canopy					1			●	
Electrical (Light Fixture installs, BOH equip connections etc) (light fixtures & site lighting by owner)		●						●	
Storefront Windows, Doors & Glazing		●						●	
CONTRACTORS PACKAGE									
Make up air, curbs, grease ducts, exhaust fans, commissioning	●							●	9
Exhaust Hood	●							●	9
Walk-In Cooler / Freezer (including lights)	●							●	9
DT Loops (in DT concrete)	●							●	9
Switchgear - Main (By RSCS)ete	●							●	9
Switchgear - Automation Component (Lutron) now to simple version stores still requires	●							●	9
Water Heater. See sheet A2.1 for spec.								●	
DT Window. See sheet A2.1 for spec.								●	
Air Doors/ Curtains (Optional)			●					●	
Mop Sink + Lavatory faucets only			●					●	
Water softener			●					●	
Security Door	●				18			●	
Thermostats								●	
Locks (permanent cores)	●				17			●	
POS EQUIPMENT									
POS + PC + Accessories + Printer + Merit + Wifi + Install + Server (OWNER IT confirm order & then processed by RSCS)					7			●	8
Kiosks x 2 - Android terminals					7			●	9
Kiosks x 2 - Wall Mount Brackets					7			●	9
Kiosks - Install					7			●	9
Kiosks - Cables, Braille Plate, Warranty, Staging					7			●	9
White Board Backer For Network Equipment					7			●	9
Exterior Posters by OnDisplay (corner timer feature)	●							●	
POS shroud					15			●	
INTERIOR DECOR, ARTWORK & SIGNAGE - SEE SHEET A7.3									
Red Wallpaper (lobby of bathrooms)	●							●	10
EQUIPMENT - SEE SHEET A2.1									
D/T Communication (Loops etc)	●							●	14
Stainless Steel Chase Along Wall For Ice Machine	●							●	12
Bulk Oil System & Installation (OPEX cost i.e. RT1 monthly fee)	●							●	13
Bulk CO2 Tank - (i.e. Newco) - See sheet A2.1 for Spec.	●							●	19
Water Filtration	●							●	13
Miscellaneous (step ladder)	●							●	
Smallwares	●							●	
Smallwares - Office	●							●	

SUBMITTAL MATRIX

SUBMITTAL MATRIX	OWNER	ARCHITECT	A-U	GC	NOTES
ROOF LADDER (IF USED)					
DOORS, FRAMES & HARDWARE					
STONE FRONT AND GLAZING					
DRIVE THRU WINDOW					
APPROVED EQUIPMENT LIST AND SHOP DRAWINGS					
ROOF TRUSSES					
ROOFING MEMBRANE SYSTEM					
ELECTRICAL SWITCHGEAR					
HVAC UNITS					
PLUMBING FIXTURES					
LIGHTING FIXTURES					
MILLWORK SHOP DRAWINGS					
INTERIOR FINISH MATERIALS?					
WALK-IN COOLER / FREEZER					

SCHEDULE NOTES

SCHEDULE NOTES:

1. KFC
2. KFC SECURITY TEAM TO QUOTE
3. MOOD MEDIA TO QUOTE - THROUGH RSCS PROGRAMS MANAGEMENT ARM
4. MAY PURCHASE OUTRIGHT OF SUBSCRIPTION OPTION
5. GC PLACE + DIRECT SUPPLIERS
6. KFCFC FRANCHISEE TO INITIATE WITH GC AND DIRECT WITH SUPPLIER
7. RSCS [OWNER IT]
8. OWNER / PAR
9. GC OR SUPPLIER - GC MUST VERIFY
10. GC OR SUB/CONTRACT DECOR INSTALLER
11. REFER TO DETAIL 15/A6.0 FOR MORE DETAILS
12. GC SHALL PLACE + SUPPLIER / OPERATIONS TEAM SERVICEMAN SHALL BE COORDINATED BY GC TO COMMISSION IT.
13. SUPPLIER SHALL BRING TO SITE - LOCATION SHALL BE READY TO TAKE THE TANKS INTO STORE
14. GC SHALL PLACE + SUPPLIER / OPERATIONS TEAM SERVICEMAN SHALL BE COORDINATED BY GC TO COMMISSION IT.
15. BY FCI.
16. BY EMS.
17. BY INSTAKEY
18. BY LOCKNET
19. SUPPLIER BRINGS C02 PANEL, C02 MONITORING SYSTEM (INCLUDING MONITOR, HORN STRUBE, CENTRAL CONTROL PANEL, AND POWER MONITORING DEVICE TO SITE, SUPPLIER INSTALLS SYSTEM, GC TO PROVIDE 2" MINIMUM PVC CONDUIT WITH SWEEP CONNECTIONS FROM OUTDOOR TANK LOCATION TO BNB AREA.

CONTACT INFORMATION

ARMSTRONG
CONTACT: LISA CAVATAIO
CELL PH: 733.882.0299
EMAIL: LYCAVATAIO@ARMSRONGCEILINGS.COM

BENJAMIN MOORE
CONTACT: MATT EKINCI
OFFICE: 877.623.8484
CELL PH: 201.788.3282
EMAIL: MATT.EKINCI@BENJAMINMOORE.COM

JAMES HARDIE
CONTACT: MIKE MAZURK
CELL PH: 470.589.0548
EMAIL: MICHAEL.MAZURK@JAMESHARDIE.COM

CORIAN
CONTACT: DAVID GREENING
CELL PH: 614.975.6700
EMAIL: DAVID.P.GREENING@DUPONT.COM

DALTILE
CONTACT: NATIONAL ACCOUNTS
OFFICE: 877.556.5728
EMAIL: NATIONAL.ACCOUNTS@DAL TILE.COM

CUMMINGS RESOURCES
CONTACT: JOEL HALL
OFFICE: 615.921.5816
EMAIL: JOEL.HALL@CUMMINGSSIGNS.COM

FORMICA:
CONTACT: JENNIFER HORNER
CELL PH: 614.264.7768
EMAIL: JENNIFER.HORNER@FORMICA.COM

MARLITE
CONTACT: DAN EGBERS
PHONE: 330.343.6621
CELL PH: 330.260.7633
EMAIL: DEGBERS@MARLITE.COM

RAMPART for WOLF GORDON
CONTACT: NATALIE KNEZEVIC
PHONE: 800.347.0550
CELL PH: 502.200.3762
EMAIL: NATALIE.KNEZEVIC@WOLFGORDON.COM

SILIKAL
CONTACT: MARK FELDMAN
CELL PH: 775.772.2797
EMAIL: MFELDMAN@SILIKALAMERICA.COM

STO CORP:
CONTACT: CLARK LARSON
CELL PH: 407-718-4449
EMAIL: CLARSON@STOCORP.COM

ALPOLIC:
CONTACT: OCTAVIO DIAZ
CELL PH: 281.541.4258
EMAIL: OCTAVIO.DIAZ@MCGC.COM
CONTACT: STEVE MARTIN
CELL PH: 612.290.8723
EMAIL: STEVE@FOURCORNERMETAL.COM

ARCHITECT OF RECORD

THOMAS E. MORGAN, JR.
ARCHITECT

423 FISCHER TRAIL
ELLIJAY, GEORGIA 30540

SEAL:



3450 Acworth Due West Road
Building 100, Suite 120
Kennesaw, Georgia 30144
P. 770-917-9172
F. 770-917-9470
www.mrpdesign.com

RELEASED FOR
CONSTRUCTION

ISSUES / REVISIONS:

[illegible]

DRAWN BY

CHK'D BY:

PROJECT DESCRIPTION:

DEVELOPMENT OF INTERIORS CONDITIONS FOR A C-STORE IN CORDELE, GA.

PROJECT TITLE:

CONVENIENCE STORE
379 ROCKHOUSE RD E,
CORDELE GA 31015

SHEET TITLE:

KFC
RESPONSIBILITY
SCHEDULE /
CONTACT LIST

PROJECT NO: 25049

T1.1

THESE PLANS ARE THE PROPERTY OF MRP DESIGN GROUP, INC. AND ARE SUBJECT TO FEDERAL COPYRIGHT LAWS. ANY USE OF SAME WITHOUT THE EXPRESS WRITTEN PERMISSION OF MRP DESIGN GROUP, INC. IS STRICTLY PROHIBITED

SBARRO RESPONSIBILITY SCHEDULE									
	LANDLORD GENERAL CONTRACTOR OWNER NOT APPLICABLE/EXISTING		LANDLORD GENERAL CONTRACTOR OWNER NOT APPLICABLE/EXISTING						
DESCRIPTION	FURNISHED BY		INSTALLED BY					REMARKS	
PROJECT PROCEDURES									
FIELD ENGINEERING	•	•		•					
INSPECTIONS, CERTIFICATIONS & CERTIFICATE OF OCCUPANCY	•			•					
PUNCH LIST PRIOR TO CONSTRUCTION TURNOVER	•			•					
DUMPSTERS / WASTE REMOVAL	•			•					
DAILY CLEANING OF SITE & ADJACENT AREAS	•			•					
REQUIRED LANDLORD SUBCONTRACTORS									
BUILDING & HEALTH PERMITS	•	•			•				
ALL OTHER GC SUBCONTRACTOR PERMITS	•				•				
SIGNAGE PERMITS		•			•				
DEFERRED SUBMITTAL VENDOR PERMITS		•			•				
UNLOADING & STORAGE OF MATERIALS PURCHASED BY OWNER	•				•				
UNLOADING OF KITCHEN EQUIPMENT & SUPPLIES		•			•			KEC	
SECURE STORAGE OF ALL MATERIALS & EQUIPMENT DELIVERED TO SITE	•				•				
COMING SOON BANNER / GRAPHICS		•			•				
GENERAL CONSTRUCTION									
DEMISING WALLS FRAMING PER CODE			•					EXISTING; GC TO REPAIR AS REQ'D. WHERE DAMAGED OR MISSING.	
DEMISING WALLS GYP. BD./FINISHES PER CODE, READY TO RECEIVE FINISHES	•				•			EXISTING; GC TO REPAIR AS REQ'D. WHERE DAMAGED OR MISSING.	
INTERIOR PARTITIONS; FRAMING, BLOCKING & SHEATHING.	•				•			INCLUDES WOOD BLOCKING & STEEL BACKING	
FRONT COUNTER KNEE-WALL; FRAMING, BLOCKING & SHEATHING	•				•			MILLWORK BY OWNER	
SOFFIT FRAMING & GYP. BD.	•	•			•				
PAINTING	•				•			GC TO PROVIDE OWNER WITH 1 EXTRA GALLON PER PAINT COLOR FOR TOUCH-UPS & REPAIR	
WALL TILE/VINYL FINISHES & TRIM	•				•				
WALL FILM TILE COVERALL			•						•
FRP PANELS, SPLICERS, DIVIDERS, INTERIOR CORNER GUARDS & ASSOCIATED TRIM.	•				•				
SILICONE SEALANT AT ALL THRU-WALL PENETRATIONS	•				•				
CONTINUOUS WHITE SILICONE SEALANT AT ENTIRE PERIMETER OF CEILING/WALL JUNCTURE	•				•				
CONTINUOUS CLEAR SILICONE SEALANT AT ENTIRE PERIMETER OF WALL/TILE BASE JUNCTURE	•				•				
STAINLESS STEEL CORNER GUARDS	•				•			PROVIDE 2"x2"x48" 16 ga STAINLESS STEEL CORNER GUARDS AT ALL NEW WALL CORNERS.	
STAINLESS STEEL WALL PANELING		•							•
FLOOR TILE & BASE	•				•				
FLOORING TRANSITION STRIPS & CONTROL JOINTS	•				•				
LIGHTING	•				•				
LAY-IN CEILING GRID & TILES	•				•				
SERVICE DOOR FRAME & HARDWARE	•				•			EXISTING DOORS & HARDWARE TO BE RELOCATED	
SWINGING DOOR & HARWARE	•				•				
SOLID SURFACE COUNTERTOPS		•			•			PROVIDED & INSTALLED MY MILLWORK VENDOR	
FIRE EXTINGUISHERS	•				•			QTY. & LOCATION PER FIRE INSPECTORS DIRECTION	
DOOR BELL			•						•
CHEMICAL DISPENSERS		•				•		BY ECOLAB	
SOAP & PAPER TOWEL DISPENSERS			•			•		BY ECOLAB	
SBARRO SLICE LOGO WALL GRAPHIC		•			•			PROVIDED BY GTC, INSTALLED BY GC	
PUNCH WALK CLEANING	•				•				
TURNOVER/FINAL CLEANING	•	•			•				
WALL TILE FINISHES & TRIM	•				•				
SIGNAGE WALL TILE FINISHES & TRIM		•				•		BY SIGNAGE CONTRACTOR UNDER SEPARATE PERMIT. GC IS RESPONSIBLE FOR COORDINATING INSTALL, PROVIDING REQUIRED BLOCKING, POWER/ACCESS PANELS & FINAL HOOK-UP GC TO REPAIR AS REQ'D., PREP SURFACES FOR NEW PAINT FINISHES.	
PAINTING	•				•				
CLOSING/SEALING OF ALL EXISTING NON-USED ROOF PENETRATIONS				•				• CAP & SEAL & COORDINATE WITH LL CONTRACTOR.	
RTU ROOF PENETRATIONS, CURB CUTS				•				• INCLUDES MODIFICATIONS TO EXISTING EXTERIOR DUCT WORK	
RTU'S				•				• EXISTING	
EXHAUST FAN ROOF PENETRATIONS, CURB CUTS	•				•			• INCLUDES MODIFICATIONS TO EXISTING EXTERIOR DUCT WORK	
EXHAUST FANS & MAKE-UP AIR		•				•			
ALTERATIONS TO EXISTING ROOF PENETRATIONS, CURB CUTS	•				•			RTU SUPPORT FRAME	
ROOF/WALL UTILITY PENETRATIONS	•				•				
ROOF DECK, INSULATION & ROOFING			•					• EXISTING. GC TO REPAIR AS REQ'D. WHERE DAMAGED BY TENANT WORK.	
STRUCTURAL STEEL FRAMING & REINFORCING	•				•				

	LANDLORD GENERAL CONTRACTOR OWNER NOT APPLICABLE/EXISTING		LANDLORD GENERAL CONTRACTOR OWNER NOT APPLICABLE/EXISTING						
DESCRIPTION	FURNISHED BY		INSTALLED BY					REMARKS	
RECEIVING, UNLOADING & STORAGE OF EQUIPMENT									
STORAGE SHELVEING/DUNNAGE RACKS		•			•			PROVIDED & INSTALLED BY KEC	
DIRECT MOUNT WALL SHELVEING		•			•				
MOBILE RACKS & CARTS		•			•			PROVIDED & INSTALLED BY KEC	
DECA DESK		•			•				
SNEEZE GUARD	•				•			PROVIDED & INSTALLED BY QUALSERVE, INCLUDES SUPPORT POSTS & GLASS	
HAND SINKS		•			•				
KITCHEN SINKS						•			
MOP BASIN	•				•				
MOP HOLDERS, HOSE RACK	•				•				
PREP TABLES		•			•				
SPEED RAILS		•			•			PROVIDED & INSTALLED BY KEC	
S/S COUNTERTOPS - FRONT COUNTER		•			•			PROVIDED & INSTALLED BY QUALSERVE	
COUNTERTOP SUPPORTS / CABINETS		•			•			PROVIDED & INSTALLED BY QUALSERVE	
STAINLESS STEEL BACK COUNTERS		•			•				
WALK-IN COOLER					•	•			
COOLER EVAPORATOR/CONDENSOR		•			•				
COOLER EVAPORATOR/CONDENSOR ELECTRICAL SUPPLY & FINAL CONNECTIONS, CONDENSATE DRAINS	•				•				
GALVALUME INSIDE CORNER CLOSURES		•			•				
ICE MACHINE		•			•				
ICE MACHINE ELECTRICAL SUPPLY & FINAL CONNECTIONS, CONDENSATE DRAINS	•				•				
REFRIGERATION SYSTEMS START-UP	•				•				
REFREIGERATED EQUIPMENT		•			•				
PIZZA OVEN		•			•				
KITCHEN EQUIPMENT		•			•				
CONTINUOUS SILICONE SEAL AT PERMITER OF ALL FIXED EQUIPMENT	•				•				
EXHAUST HOODS		•			•				
POST-MIX SYSTEM		•			•				
SODA BUNDLE LINES INSTALL		•			•				
CO2 TANKS		•			•				
COUNTERTOP DISPLAY CASE		•			•				
ICE TEA BREWER		•			•				
LEMONADE BUBBLER		•			•			PROVIDED & INSTALLED BY KEC	
WATER FILTERS	•				•				
SMALL WARES ITEMS		•			•			PROVIDED & INSTALLED BY KEC	
P.O.S. TERMINALS & CABLING		•			•				
CASH DRAWERS		•			•				
OFFICE SAFE		•			•				
OFFICE FURNITURE		•			•				
MENU BOARDS		•			•			GC IS RESPONSIBLE FOR COORDINATING INSTALL, PROVIDING REQUIRED BLOCKING, POWER/ACCESS PANELS & FINAL HOOK-UP.	
EQUIPMENT STARTUP	•				•				

	LANDLORD GENERAL CONTRACTOR OWNER NOT APPLICABLE/EXISTING		LANDLORD GENERAL CONTRACTOR OWNER NOT APPLICABLE/EXISTING						
DESCRIPTION	FURNISHED BY		INSTALLED BY					REMARKS	
ROOFTOP UNITS & CURBS	•	•			•				
THERMOSTATS & TEMPERATURE SENSORS	•				•				
DUCT SMOKE DETECTORS	•	•			•				
DUCTWORK FOR AIR DISTRIBUTION & DIFFUSERS	•	•			•				
EXHAUST HOODS		•			•				
EXHAUST HOOD DUCTWORK	•				•				
EXHAUST HOOD DUCTWORK CLEAN-OUTS & FIREWRAP	•				•				
CLEAN-OUT OF EXISTING GREASE DUCTS & FANS	•				•				
EXHAUST FANS & CURBS		•			•				
EXHAUST FAN HINGE KIT & GREASE CATCHER		•			•				
EXHAUST HOOD ANSUL SYSTEM		•			•				
EXHAUST HOOD STRUCTURAL SUPPORTS	•				•				
MAKE-UP AIR & CURBS	•				•				
UTILITIES TO ROOF TOP EQUIPMENT	•				•				
TEST & BALANCE	•				•				
KITCHEN EQUIPMENT UTILITY CONNECTIONS	•				•				
ELECTRICAL SERVICE	•	•			•				
ELECTRICAL METER	•				•				
ELECTRICAL SWITCHGEAR	•				•				
ELECTRICAL CONDUIT & WIRING TO TENANT SPACE	•				•				
STEP-DOWN TRANSFORMER	•				•			AS REQUIRED	
DISTRIBUTION CONDUIT & WIRING	•				•				
ELECTRICAL PANELS	•				•				
CIRCUIT BREAKERS	•				•				
SYSTEM CONDUIT, J-BOXES & WIRING & ALL DEVICES: SWITCHES, RECEPTACLES, TIMERS & CONTACTORS	•				•				
TELEPHONE DEMARK PANEL w/3/4" CONDUIT CHASE WITH PULL STRING TO TENANT SPACE	•				•				
TELEPHONE / DATA CONDUITS, J-BOXES & COVERPLATES IN TENANT SPACE	•				•				
TELEPHONE / DATA WIRING IN TENANT SPACE		•			•			BY OWNERS DATA VENDOR	
INTERNET LINES TO TENANT SPACE		•	•		•	•		GC PROVIDES FINAL HOOK-UP	
SECURITY / DATA CONDUITS, J-BOXES & COVERPLATES IN TENANT SPACE	•				•				
SECURITY / DATA WIRING IN TENANT SPACE		•			•			BY OWNERS SECURITY VENDOR	
FIRE ALARM SYSTEM (NEW/MODIFICATIONS TO EXISTING)	•				•			ALL MODIFICATIONS BY GC	
KITCHEN EQUIPMENT UTILITY CONNECTIONS	•	•			•			INCLUDES TIE-IN TO LANDLORD SYSTEM	
WATER SERVICE TO SPACE	•	•			•			VERIFY IN FIELD EXISTING SIZE & LOCATION	
GAS SERVICE TO SPACE	•				•			VERIFY IN FIELD EXISTING SIZE & LOCATION	
SANITARY SERVICE TO SPACE	•				•			VERIFY IN FIELD EXISTING SIZE & LOCATION	
GREASE WASTE LINE TO SPACE	•				•			VERIFY IN FIELD EXISTING SIZE & LOCATION	
SCOPING/JETTING OF EXISTING SANITARY & GREASE LINES	•				•				
GREASE INTERCEPTOR	•				•				
CLEANING OF EXISTING GREASE TRAP			•				•		
PLUMBING VENT TO SPACE	•				•			VERIFY IN FIELD EXISTING SIZE & LOCATION	
WATER HEATER, INTAKE, EXHAUST & FLUE	•				•				
ALL NEW GAS DISTRIBUTION LINES	•				•				
ALL NEW WATER SUPPLY & WASTE DISTRIBUTION LINES	•				•				
SPRINKLER SYSTEM	•				•			SEE DRAWING P-101.00	
SINK FAUCETS & DRAINS	•				•			PROVIDED BY KEC, INSTALLED BY GC	
FLOOR SINKS, DRAINS & HUB DRAINS	•				•			PROVIDE ALTERNATE QUOTE TO ADD ADDITIONAL DRAIN (S) IN BOH & SLOPE FLOOR TOWARDS DRAINS	
INDIRECT & DIRECT DRAIN PIPING FOR ALL EQUIPMENT	•				•				
CONDENSATE DRAINS FOR ALL EQUIPMENT	•				•				
EQUIPMENT GAS QUICK DISCONNECTS		•			•			PROVIDED BY KEC, INSTALLED BY GC. REFER TO EQUIPMENT SCHEDULE	
SODA LINE PVC CONDUIT	•				•				
KITCHEN EQUIPMENT UTILITY CONNECTIONS	•				•				

CONTACT INFORMATION	
FLOOR & DECOR CONTACT: JOE NAHAY CELL PH: 770.862.8612 EMAIL: JOSEPH.NAHAY@FLOORANDDECOR.COM	
DALTILE CONTACT: LYNDA GUNDLING CELL PH: 740.815.3693 EMAIL: LYNDA.GUNDLING@DALTILE.COM	
CORAIN CONTACT: DAVID GREENING CELL PH: 614.975.6700 EMAIL: DAVID.P.GREENING@DUPONT.COM	
MARLITE CONTACT: GREG LEARY CELL PH: 800.377.1221 EMAIL: GLEARY@MARLITE.COM	
ARMSTRONG CONTACT: LISA CAVATAIO CELL PH: 733.882.0299 EMAIL: LYCAVATAIO@ARMSRONGCEILINGS.COM	
BENJAMIN MOORE CONTACT: MATT EKINCI OFFICE: 877.623.8484 CELL PH: 201.788.3282 EMAIL: MATT.EKINCI@BENJAMINMOORE.COM	

ARCHITECT OF RECORD:

THOMAS E. MORGAN, JR.
ARCHITECT

423 FISCHER TRAIL
ELLIJAY, GEORGIA 30540

SEAL:



3450 Acworth Due West Road
Building 100, Suite 120
Kennesaw, Georgia 30144
P. 770-917-9172
F. 770-917-9470
www.mrpdesign.com

RELEASED FOR
CONSTRUCTION

ISSUES / REVISIONS:

DATE	DESCRIPTION
01.26.28	COMPILED SET RELEASED FOR CONSTRUCTION

DRAWN BY:

CHKD BY:

PROJECT DESCRIPTION:

DEVELOPMENT OF INTERIORS
CONDITIONS FOR A C-STORE IN
CORDELE, GA.

PROJECT TITLE:

CONVENIENCE STORE
379 ROCKHOUSE RD E,
CORDELE, GA 31015


SHEET TITLE:

SBARRO
RESPONSIBILITY
SCHEDULE /
CONTACT LIST

PROJECT NO: 25049

T1.2

THESE PLANS ARE THE PROPERTY OF MRP DESIGN GROUP, INC. AND ARE SUBJECT TO FEDERAL COPYRIGHT LAWS. ANY USE OF SAME WITHOUT THE EXPRESS WRITTEN PERMISSION OF MRP DESIGN GROUP, INC. IS STRICTLY PROHIBITED.

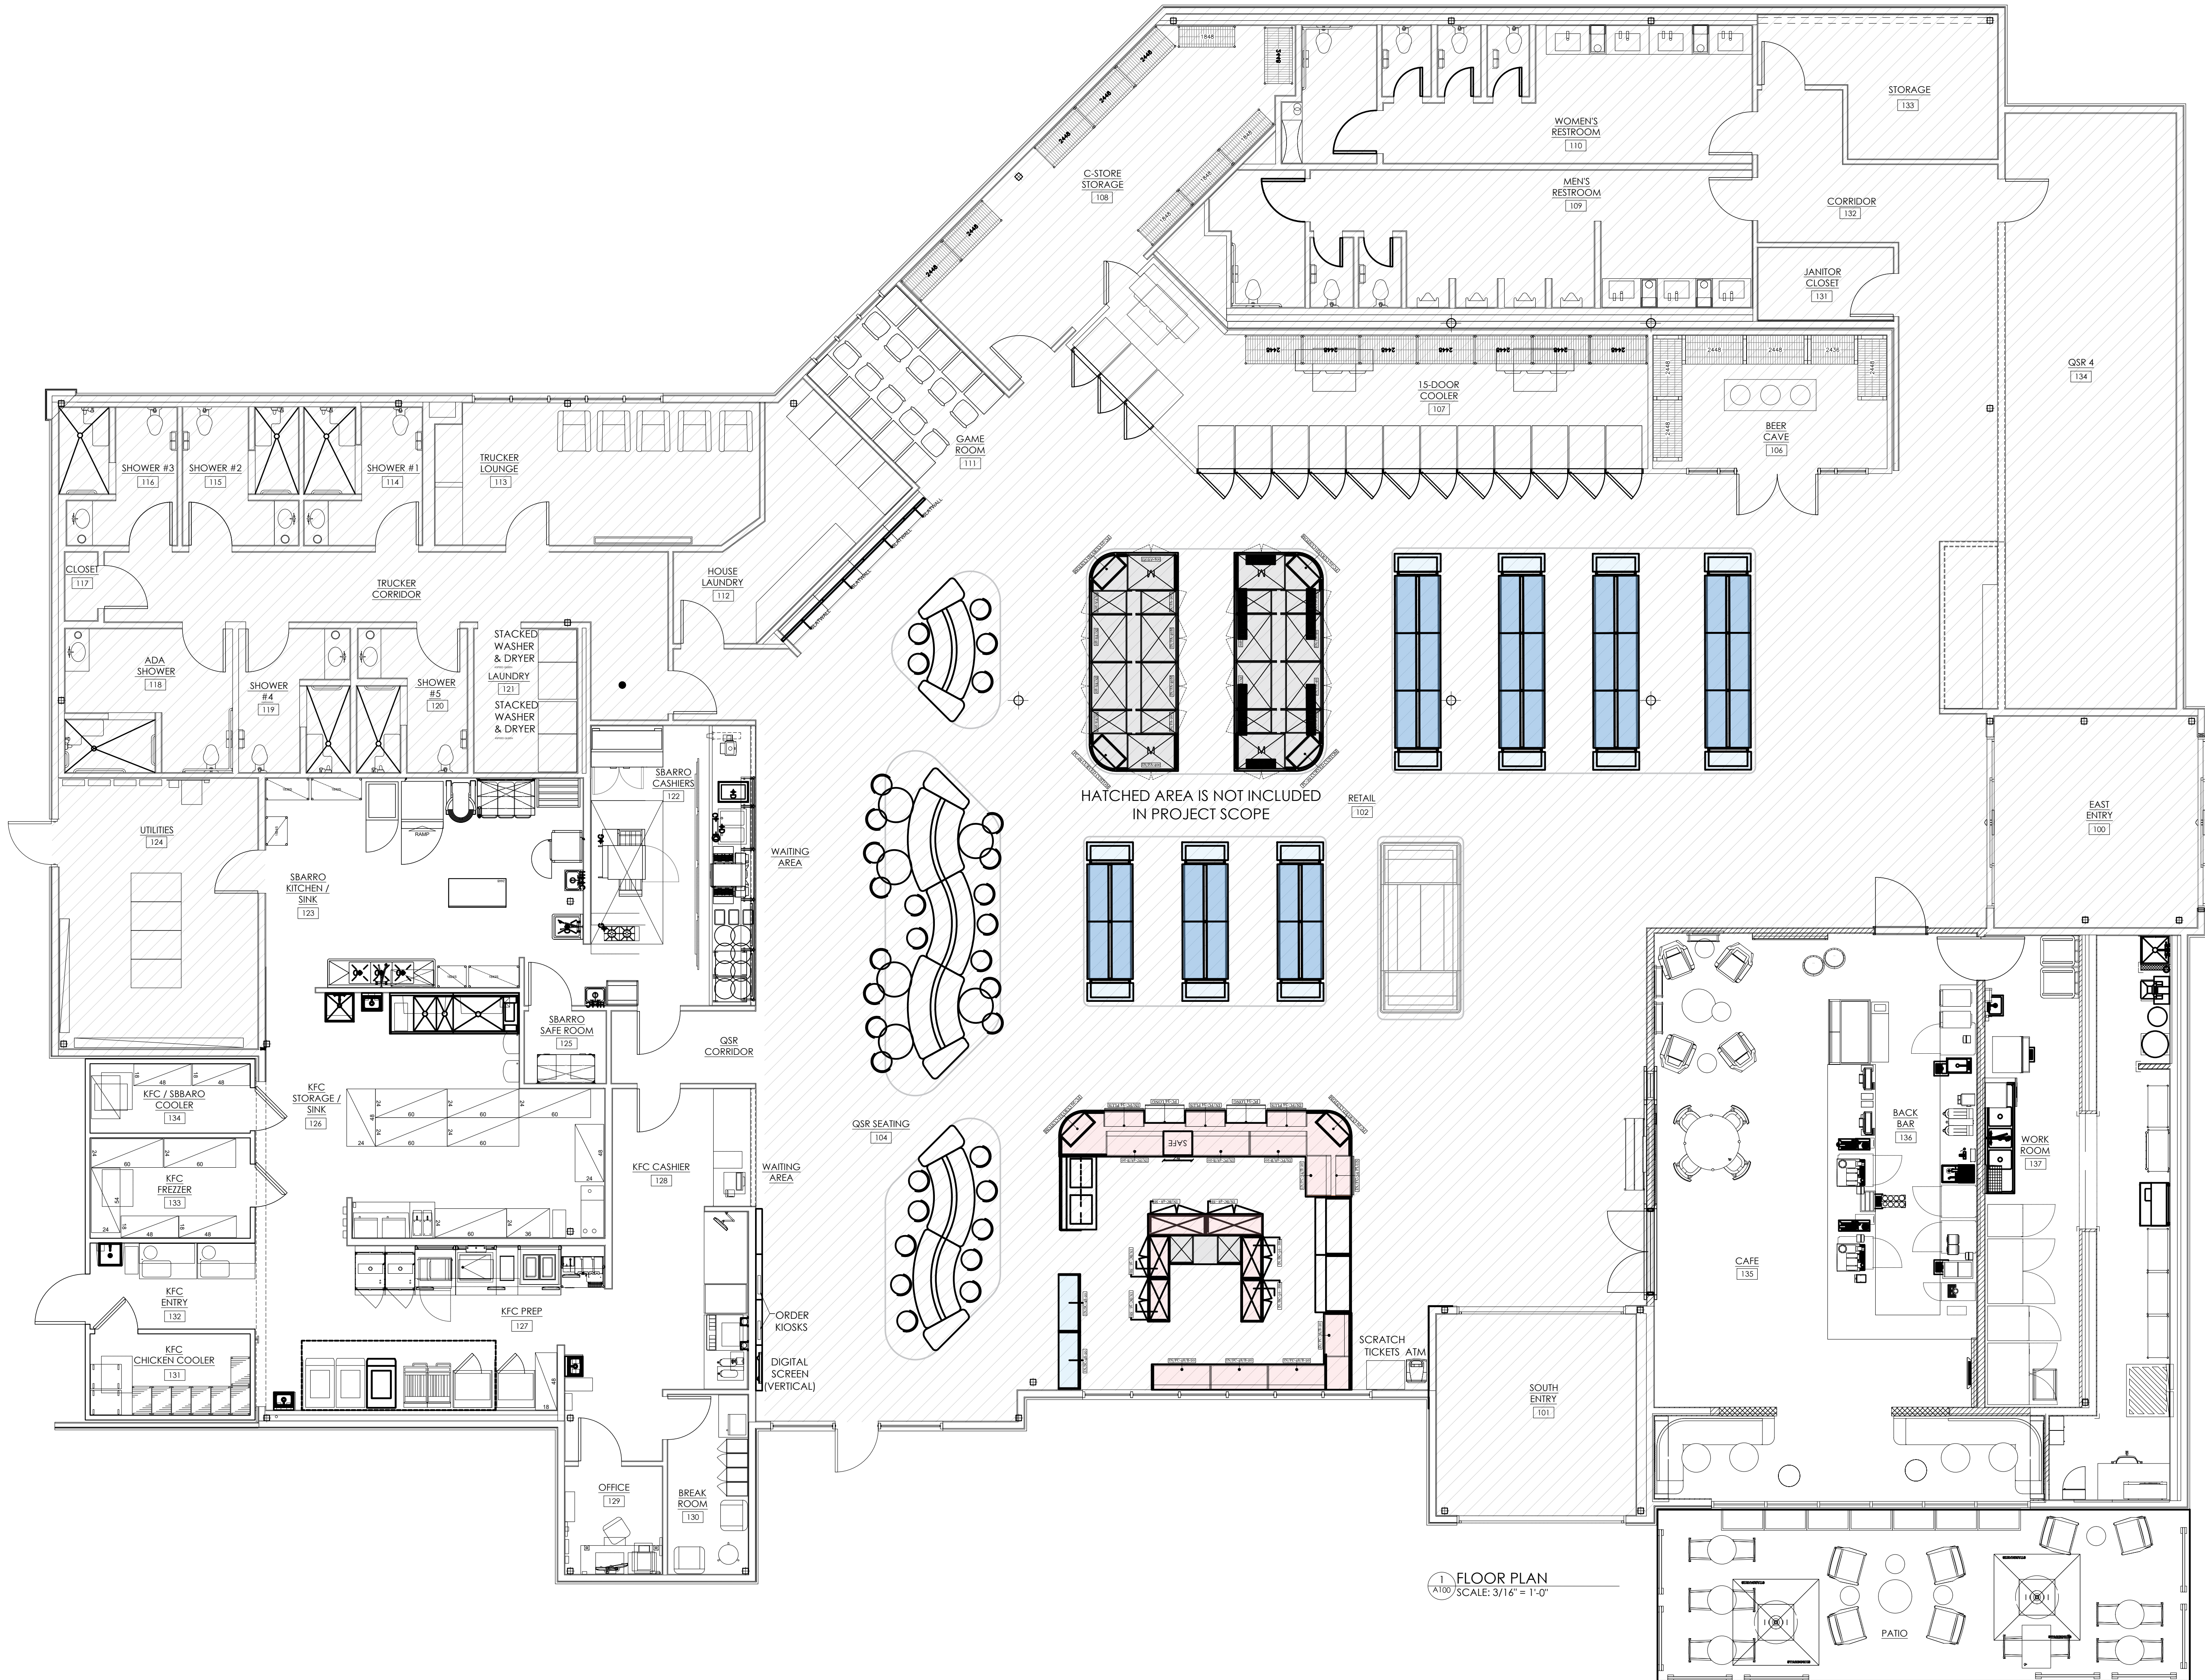

1 FLOOR PLAN
SCALE: 3/16" = 1'-0"

ARCHITECT OF RECORD:

THOMAS E. MORGAN, JR.
ARCHITECT

423 FISCHER TRAIL
ELLIJAY, GEORGIA 30540

SEAL:



3450 Acworth Due West Road
Building 100, Suite 120
Kennesaw, Georgia 30144
P. 770-917-9172
F. 770-917-9470
www.mrpdsgroup.com

RELEASED FOR
CONSTRUCTION

ISSUES / REVISIONS:

DATE	DESCRIPTION
01.26.28	COMPILED SET RELEASED FOR CONSTRUCTION

DRAWN BY:
CHKD BY:

PROJECT DESCRIPTION:
DEVELOPMENT OF INTERIORS
CONDITIONS FOR A C-STORE IN
CORDELE, GA.

PROJECT TITLE:

CONVENIENCE STORE
379 ROCKHOUSE RD E,
CORDELE, GA 31015


SHEET TITLE:

OVERALL
FLOOR PLAN



PROJECT NO: 25049

A100


THESE PLANS ARE THE PROPERTY OF MRP DESIGN GROUP, INC. AND ARE SUBJECT TO FEDERAL COPYRIGHT LAWS. ANY USE OF SAME WITHOUT THE EXPRESS WRITTEN PERMISSION OF MRP DESIGN GROUP, INC. IS STRICTLY PROHIBITED.

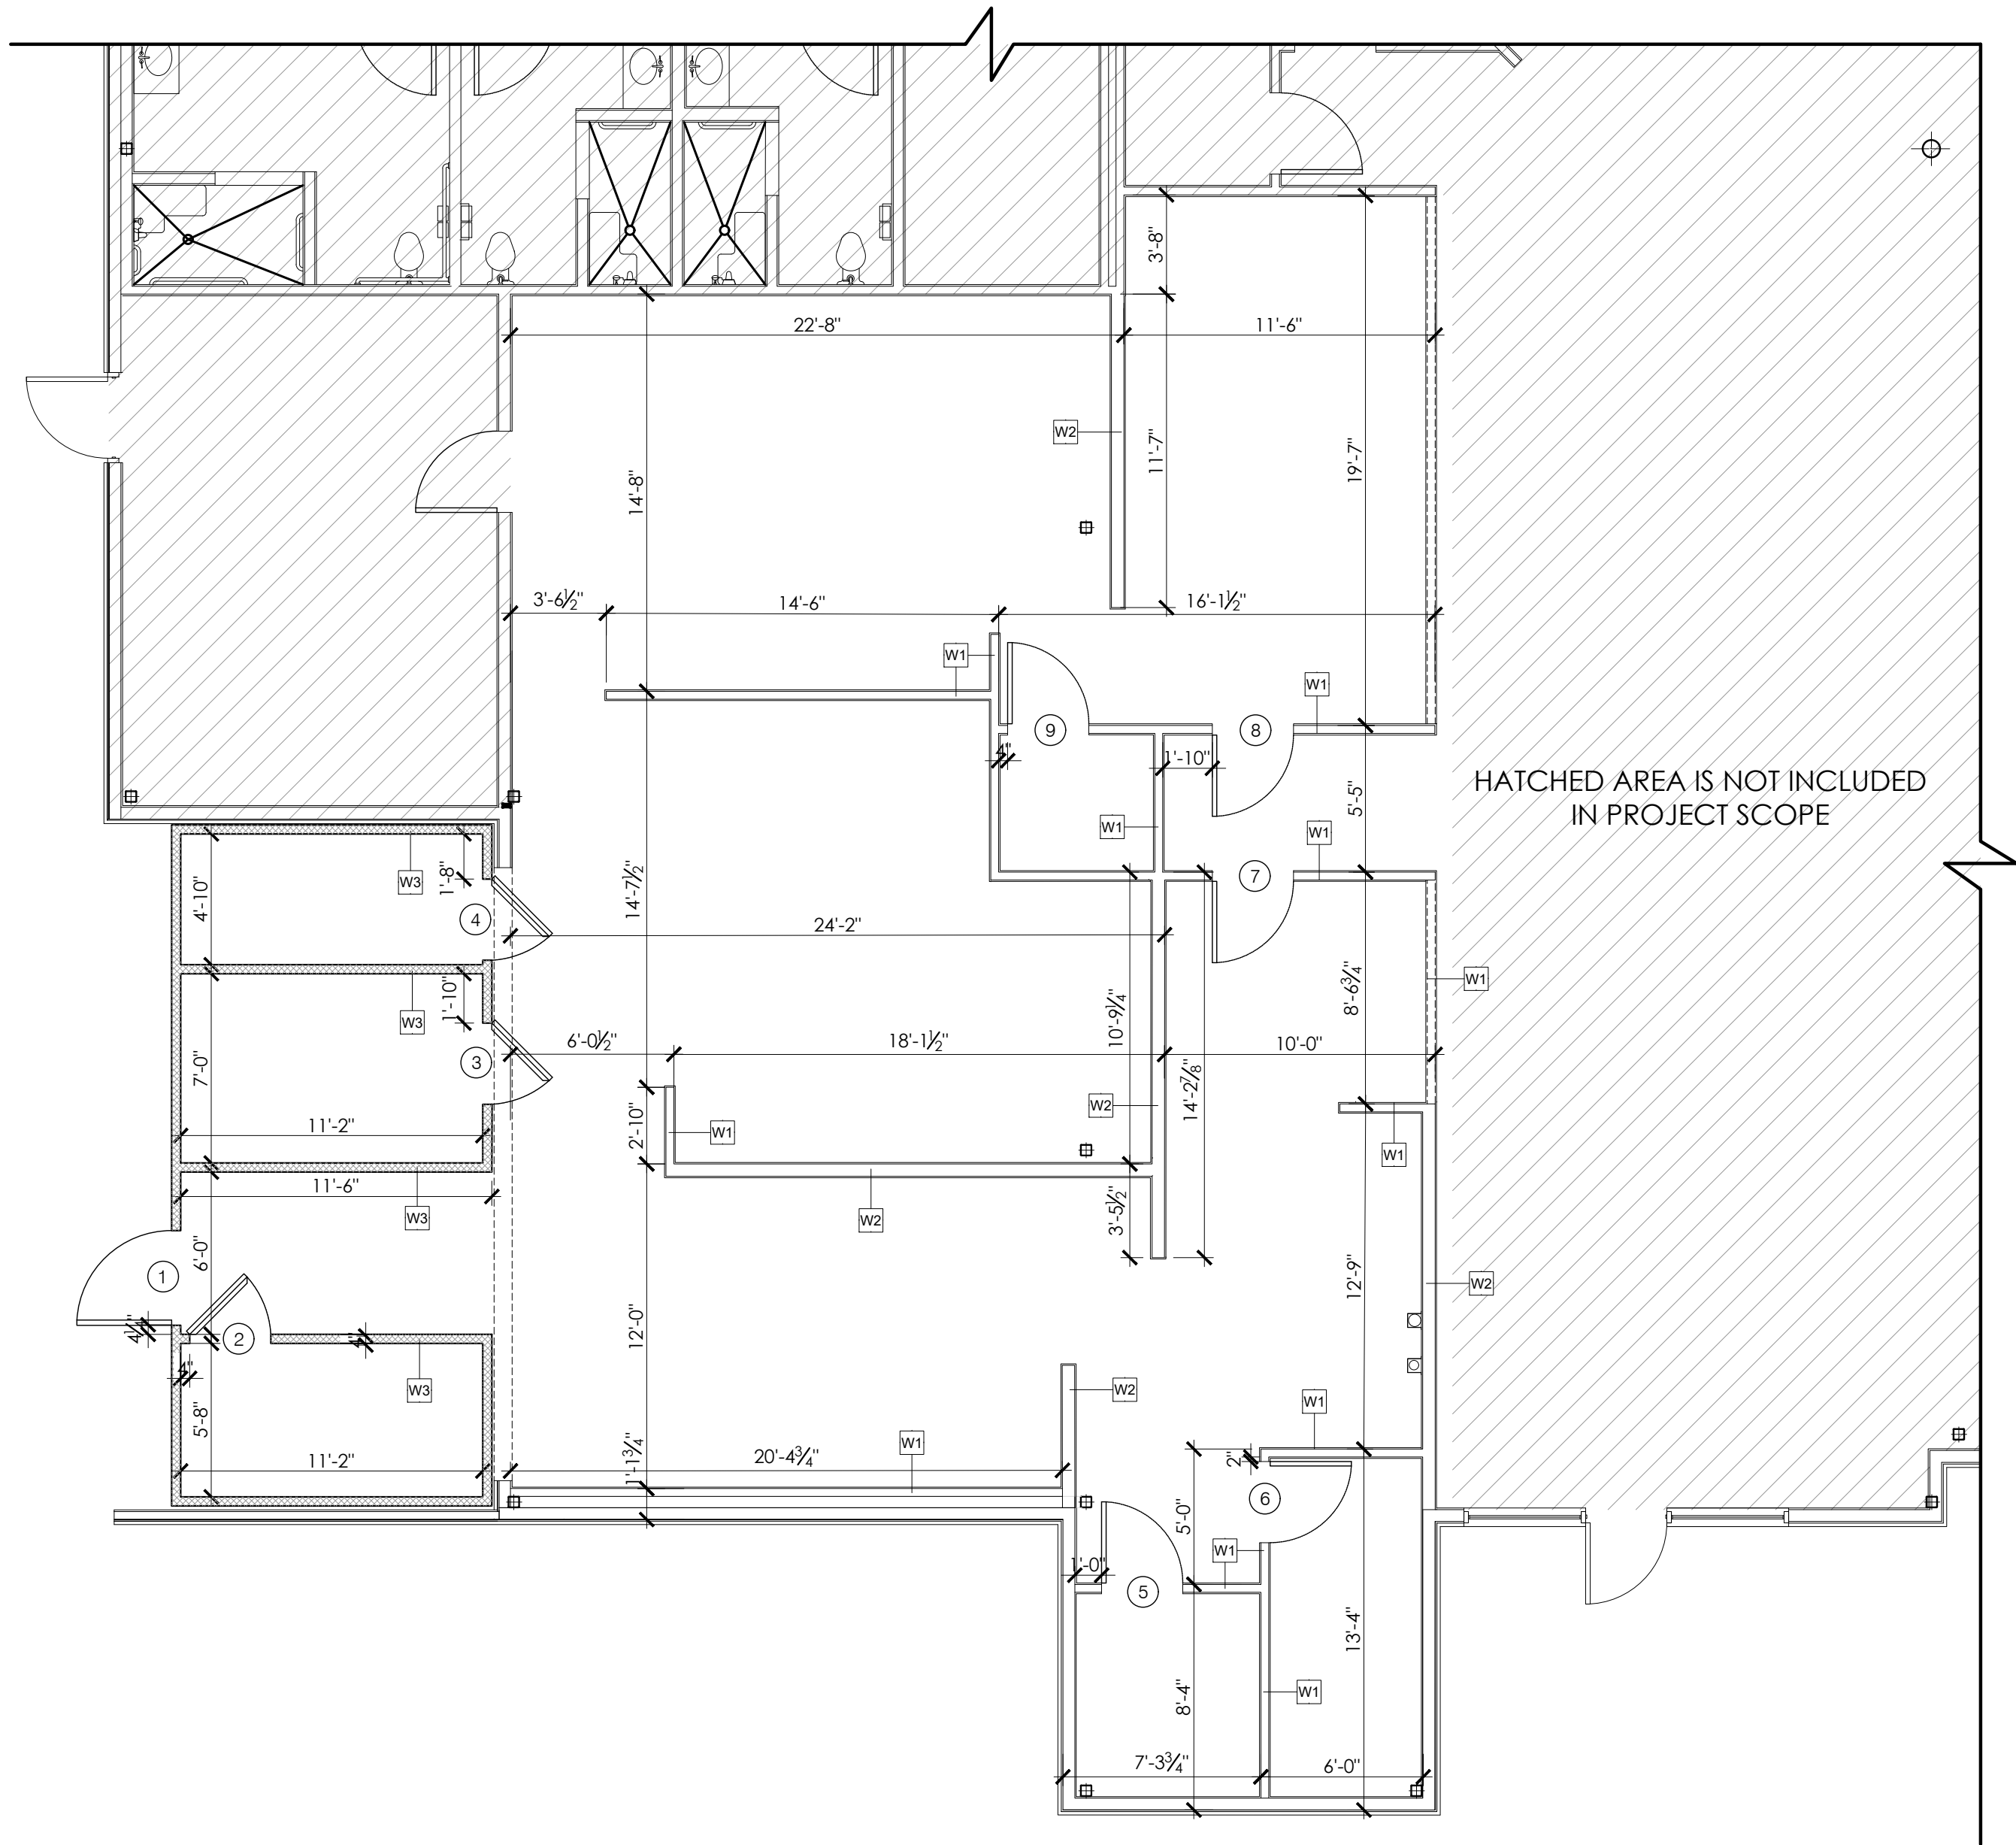


1
A401 STARBUCKS ENLARGE PLAN
SCALE: 3/8" = 1'-0"

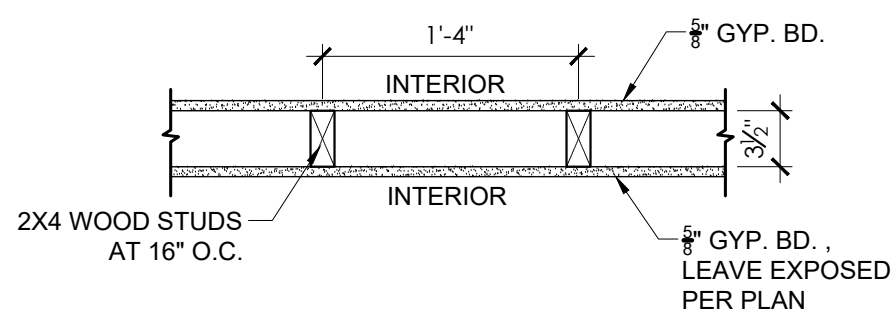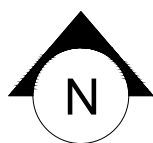


W1 2X4 WOOD STUD WALL
SCALE: 1" = 1'-0"

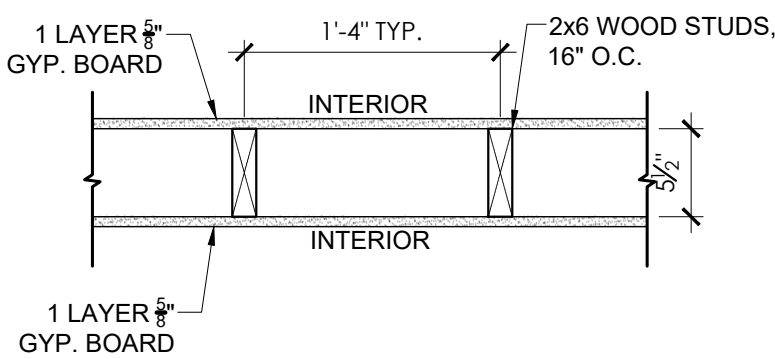


W2 2X6 METAL STUD WALL
SCALE: 1" = 1'-0"

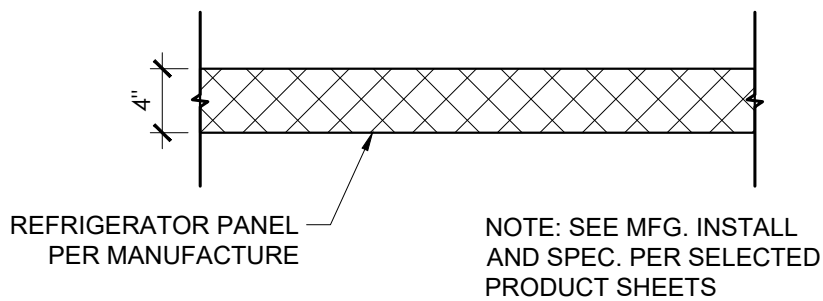

W3 REFRIGERATOR WALL PANEL
SCALE: 1" = 1'-0"

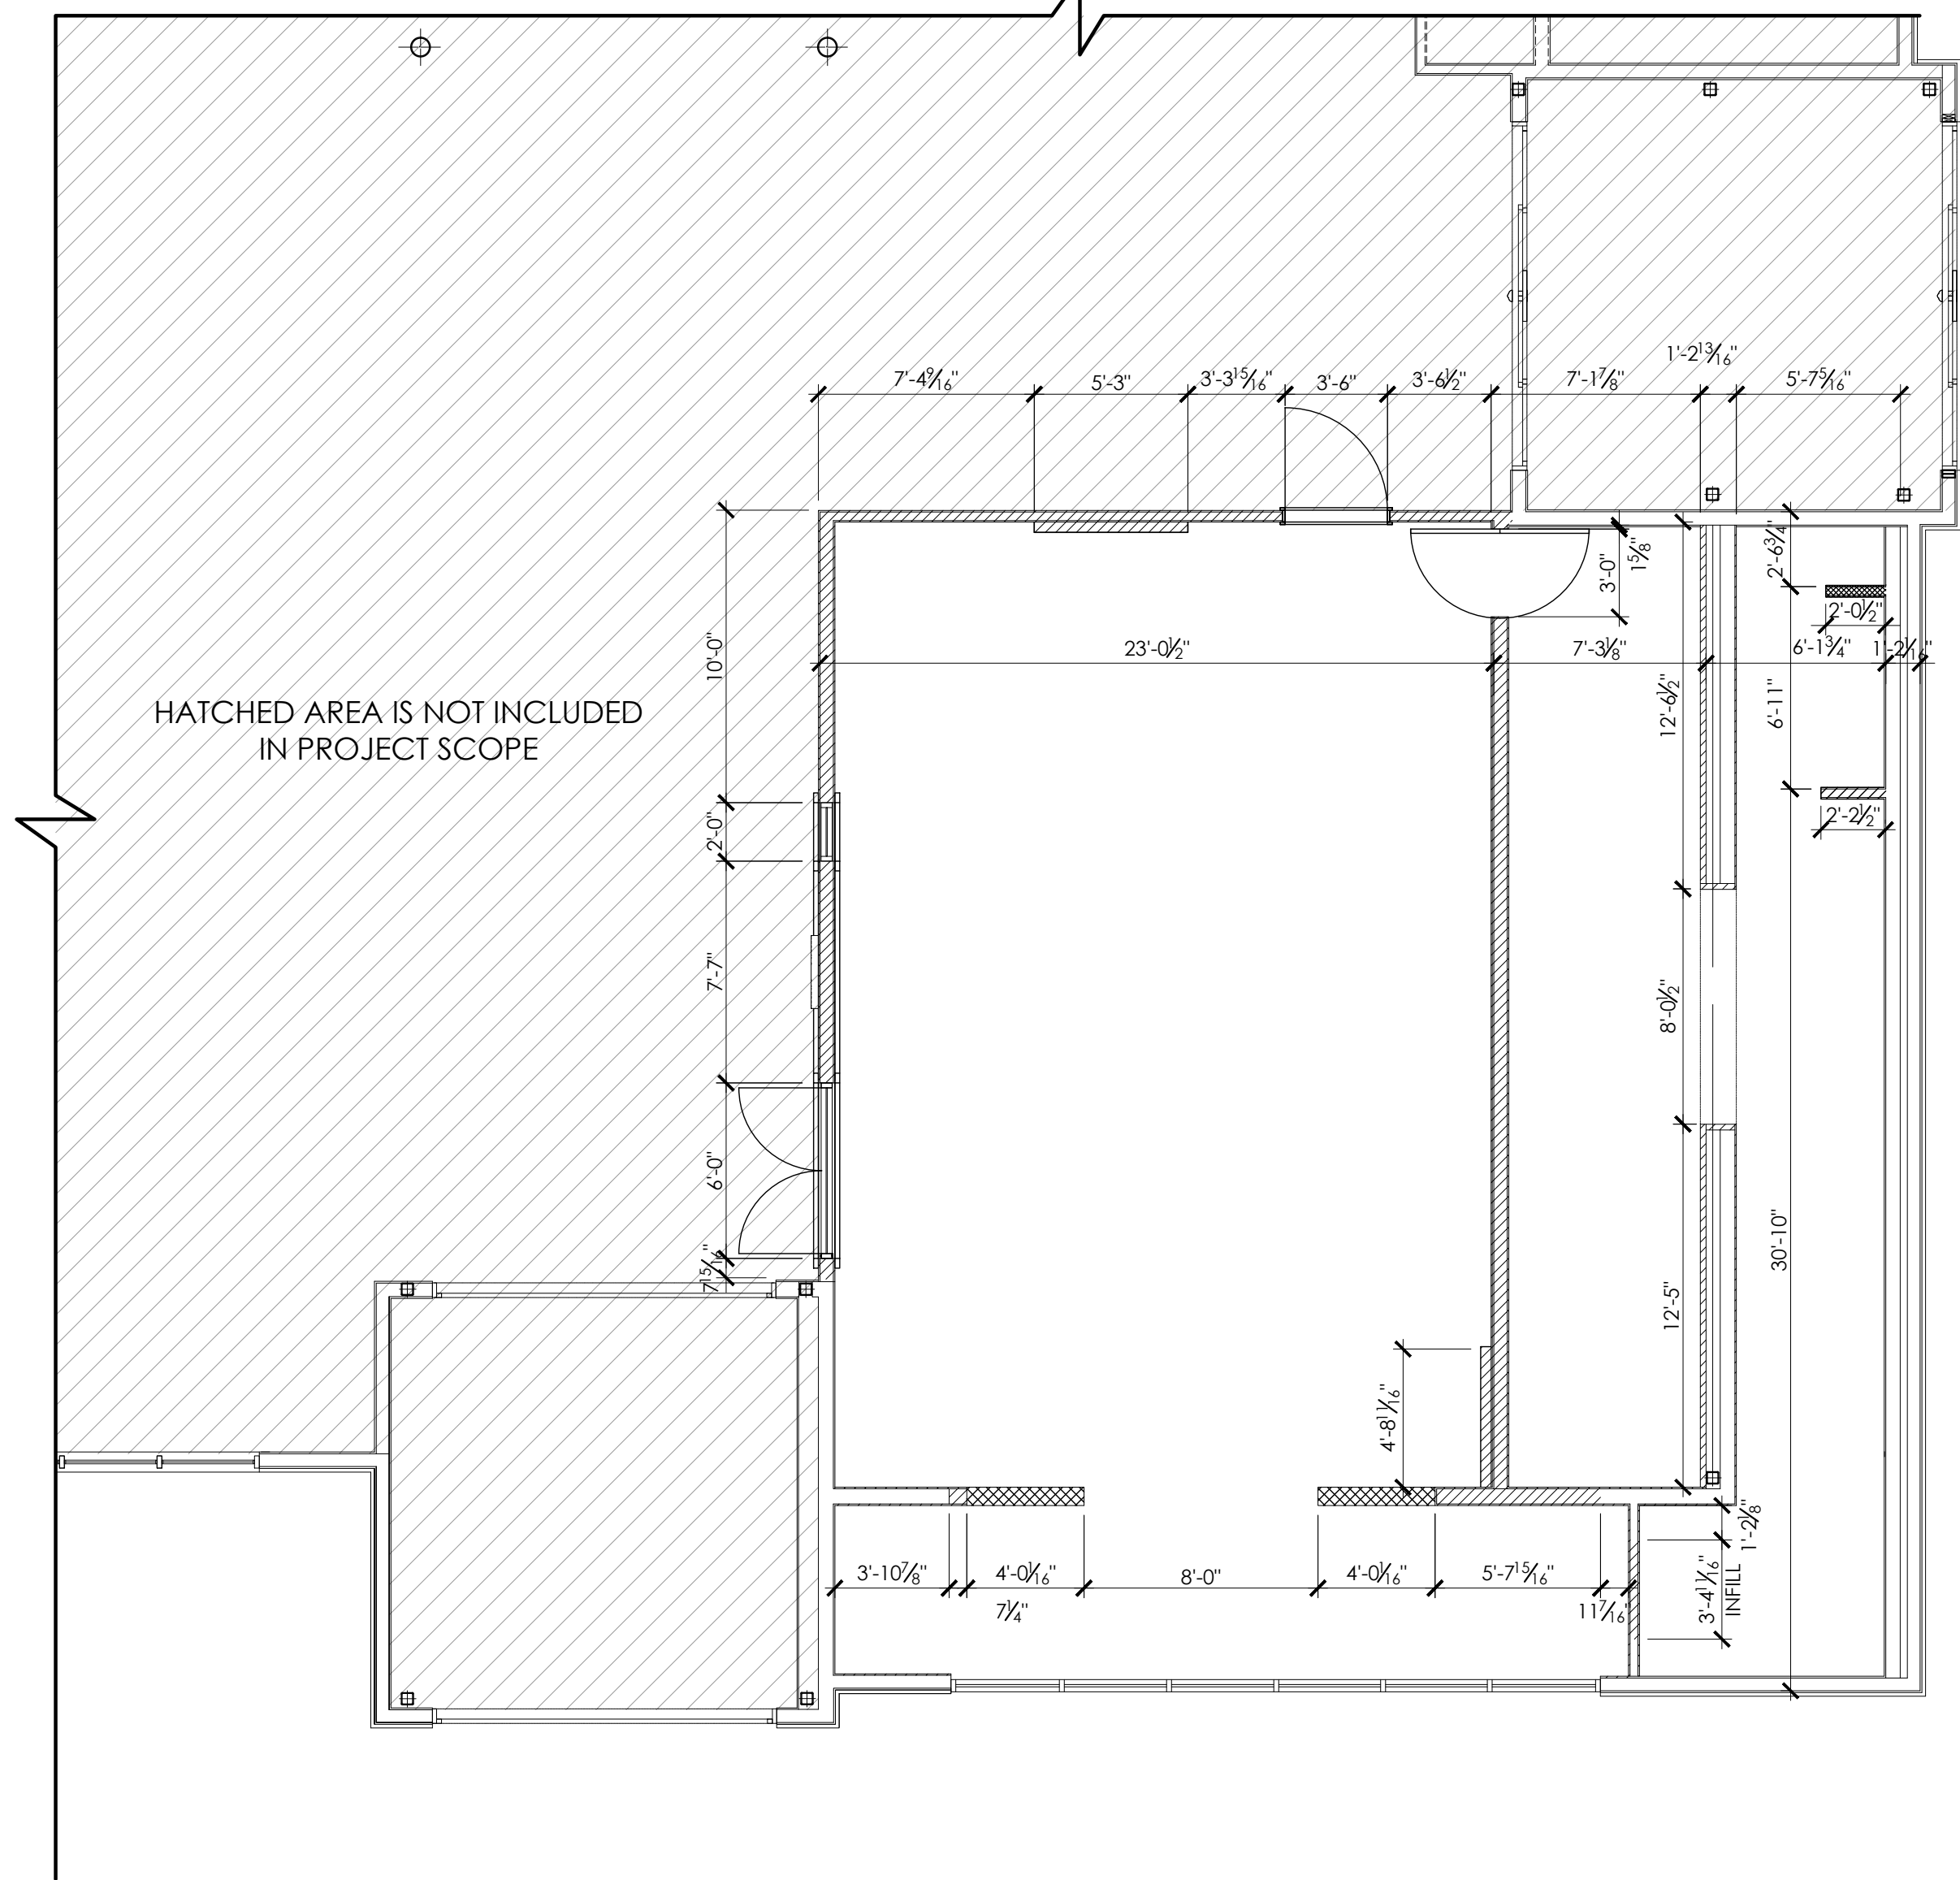

1
A401 STARBUCKS ENLARGE PLAN
SCALE: 3/16" = 1'-0"
NOTE: REFERENCE STARBUCKS ENLARGE PLAN
WALL AND DOOR TYPES

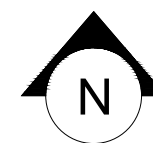

GENERAL NOTES

- INTERIOR DIMENSIONS ARE FROM STUD TO STUD (UNO).
- ALL FINISH FLOOR ELEVATIONS ARE TAKEN FROM TOP OF TILE.
- ALL GYPSUM BOARD TO BE 5/8" THICK UNLESS OTHERWISE NOTED.
- THE GENERAL CONTRACTOR SHALL PROVIDE FIRE EXTINGUISHERS PER NFPA 10 (OR LOCAL AUTHORITY). FIRE EXTINGUISHERS SHALL BE MOUNTED, TOP = 48" AFF.
- THIS STATEMENT SHALL NOT GOVERN OVER MANUFACTURERS' WARRANTIES. THE GENERAL CONTRACTOR SHALL WARRANTY HIS WORKMANSHIP FOR A MINIMUM PERIOD OF ONE YEAR FROM THE DATE OF OCCUPANCY & ACCEPTANCE OF WORK BY THE OWNER. DEFECTIVE OR INFERIOR MATERIALS OR WORKMANSHIP FOUND AT ANY TIME PRIOR TO FINAL ACCEPTANCE OF THE WORK BY THE OWNER AND ALSO DURING THE WARRANTY PERIOD MAY BE REJECTED, REGARDLESS OF PREVIOUS INSPECTION, CORRECTIVE MEASURES WHEN REQUIRED SHALL BE EXECUTED AT NO ADDITIONAL COST TO THE OWNER.
- ALL MATERIALS RELATED TO THIS WORK SHALL BE SHIPPED, STORED AND INSTALLED PER THE MANUFACTURERS' RECOMMENDATIONS.
- THE G.C. WILL LEAVE THIS SITE FREE AND CLEAR OF DEBRIS UPON COMPLETION OF THE WORK.
- WHERE THESE DOCUMENTS INDICATE TRADE OR MANUFACTURER NAMES, THE CONTRACTOR MAY SUBSTITUTE A PRODUCT OR METHOD OF BETTER OR EQUAL QUALITY UPON APPROVAL BY THE OWNER.
- TERMITE PROTECTION SHALL BE PROVIDED UNDER THE FLOOR SLAB. INSTALLATION AND WARRANTY SHALL BE PER THE INTERNATIONAL BUILDING CODE.

ARCHITECT OF RECORD:

THOMAS E. MORGAN, JR.
ARCHITECT

423 FISCHER TRAIL
ELLIJAY, GEORGIA 30540

SEAL:



3450 Acworth Due West Road
Building 100, Suite 120
Kennesaw, Georgia 30144
P. 770-917-9172
F. 770-917-9470
www.mrpdesign.com

RELEASED FOR
CONSTRUCTION

ISSUES / REVISIONS:

DATE	DESCRIPTION
01.26.28	COMPILED SET RELEASED FOR CONSTRUCTION

DRAWN BY:

CHKD BY:

PROJECT DESCRIPTION:

DEVELOPMENT OF INTERIORS
CONDITIONS FOR A C-STORE IN
CORDELE, GA.

PROJECT TITLE:

CONVENIENCE STORE
379 ROCKHOUSE RD E,
CORDELE, GA 31015

SHEET TITLE:

FLOOR
FRAMING PLAN,
WALL TYPES

PROJECT NO: 25049

A101

 
THESE PLANS ARE THE PROPERTY OF MRP DESIGN GROUP, INC. AND ARE SUBJECT TO FEDERAL COPYRIGHT LAWS. ANY USE OF SAME WITHOUT THE EXPRESS WRITTEN PERMISSION OF MRP DESIGN GROUP, INC. IS STRICTLY PROHIBITED.

WALL TYPE LEGEND

1 EXISTING WALL / CURTAIN WALL


2 NEW PARTITION WALL TO 6" (152MM) ABOVE CEILING

2 X4 WOOD STUD @ 16" O.C.
WITH 5/8" TYPE "X" GWB ON ONE OR BOTH SIDES TO MINIMUM OF 6" ABOVE CEILING GRID. DRYWALL SCREWS @ 12" WOOD STUD REINFORCEMENT @ 48" ABOVE CEILING LINE TO STRUCTURE ABOVE.




3 NEW FURRED WALL TO 6" ABOVE CEILING

2 X4 WOOD STUD @ 16" O.C.
WITH 5/8" TYPE "X" GWB TO MINIMUM OF 6" ABOVE CEILING GRID. DRYWALL SCREWS @ 12" O.C., WOOD STUD REINFORCEMENT @ 48" O.C. ABOVE CEILING LINE TO STRUCTURE ABOVE.

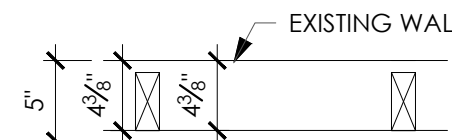


4 NEW PARTIAL HEIGHT WALL (TO 2'-0" AFF)

 2 X4 WOOD STUD @ 16" O.C.
WITH 5/8" TYPE "X" GWB ON ONE OR BOTH SIDES TO SPECIFIED HEIGHT. DRYWALL SCREWS @ 12" O.C.




5 NEW PLUMBING WALL TO 6" ABOVE CEILING

STAGGERED 2 X4 WOOD STUD @ 24" O.C.
WITH 5/8" CEMENT BOARD TO 12" AFF AND 5/8" MOISTURE RESISTANT GYP. BOARD FROM CEMENT BOARD TO TOP OF WALL WORKROOM SIDE AND 5/8" CEMENT BOARD FROM FLOOR SLAB TO TOP OF WALL ON BACKBAR SIDE. SECURE MOISTURE RESISTANT GYPSUM BOARD TO STUDS WITH DRYWALL SCREWS AT 10" O.C. AT PANEL EDGES AND 12" O.C. AT INTERMEDIATE SUPPORTS.

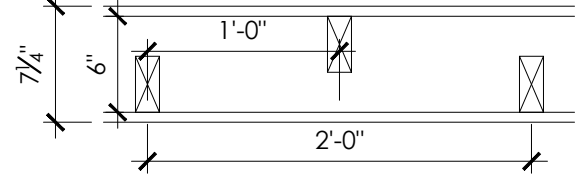


6 NEW FURRED PLUMBING WALL TO 6" ABOVE CEILING

2 X6 WOOD STUD 16" O.C.
WITH 5/8" CEMENT BOARD TO 12" AFF AND 5/8" MOISTURE RESISTANT GYP. BOARD FROM CEMENT BOARD TO TOP OF WALL WORKROOM SIDE AND 5/8" CEMENT BOARD FROM FLOOR SLAB TO TOP OF WALL ON BACKBAR SIDE. SECURE MOISTURE RESISTANT GYPSUM BOARD TO STUDS WITH DRYWALL SCREWS AT 10" O.C. AT PANEL EDGES AND 12" O.C. AT INTERMEDIATE SUPPORTS.

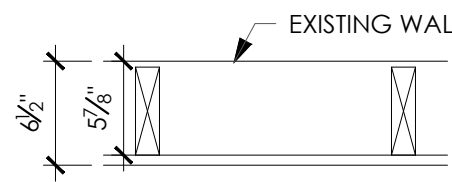

7 NEW SHALLOW FURRED WALL TO 6" (154 MM) ABOVE CEILING

 
20 GA 1-3/4" (44 MM) METAL HAT CHANNELS 16" (406 MM) O.C. WITH 5/8" TYPE "X" GWB TO MINIMUM OF 6" (152 MM) ABOVE CEILING GRID. DRYWALL SCREWS @ 12" (305 MM) O.C. 45 DEGREE METAL STUD REINFORCEMENT @ 48" (1210 MM) O.C. ABOVE CEILING LINE TO STRUCTURE ABOVE.



8 NEW CURTAIN WALL (BY AOR)


9 NEW SINGLE 5/8" GWB LAYER TO 6" ABOVE CEILING ON EXISTING STRUCTURE

 5/8" TYPE "X" GWB TO MINIMUM OF 6" ABOVE CEILING GRID




10 NEW PARTIAL HEIGHT WALL (TO 2'-10" AFF)

STAGGERED 2 X4 WOOD STUD @ 24" O.C.
WITH 5/8" TYPE "X" GWB ON BOTH SIDES TO SPECIFIED HEIGHT. DRYWALL SCREWS @ 12" O.C.

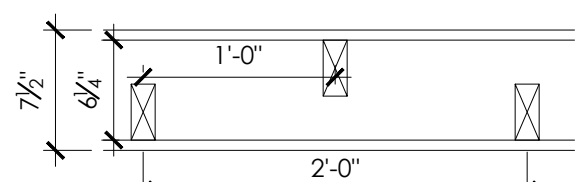



11 NEW PARTITION WALL TO 6" (152MM) ABOVE CEILING

STAGGERED 2 X4 WOOD STUD @ 24" O.C.
WITH 5/8" TYPE "X" GWB ON ONE OR BOTH SIDES TO MINIMUM OF 6" ABOVE CEILING GRID. DRYWALL SCREWS @ 12" O.C., 45 DEGREE METAL STUD REINFORCEMENT @ 48" O.C. ABOVE CEILING LINE TO STRUCTURE ABOVE.

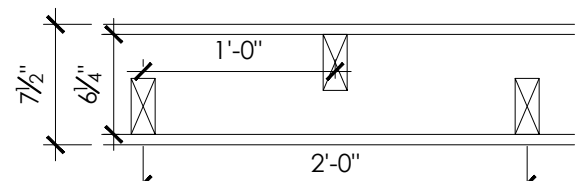

12 NEW PARTITION WALL TO 6" ABOVE CEILING

2 X6 WOOD STUD 16" O.C.
WITH 5/8" TYPE "X" GWB ON ONE OR BOTH SIDES TO MINIMUM OF 6" ABOVE CEILING GRID. DRYWALL SCREWS @ 12" O.C., WOOD STUD REINFORCEMENT @ 48" ABOVE CEILING TO STRUCTURE ABOVE.

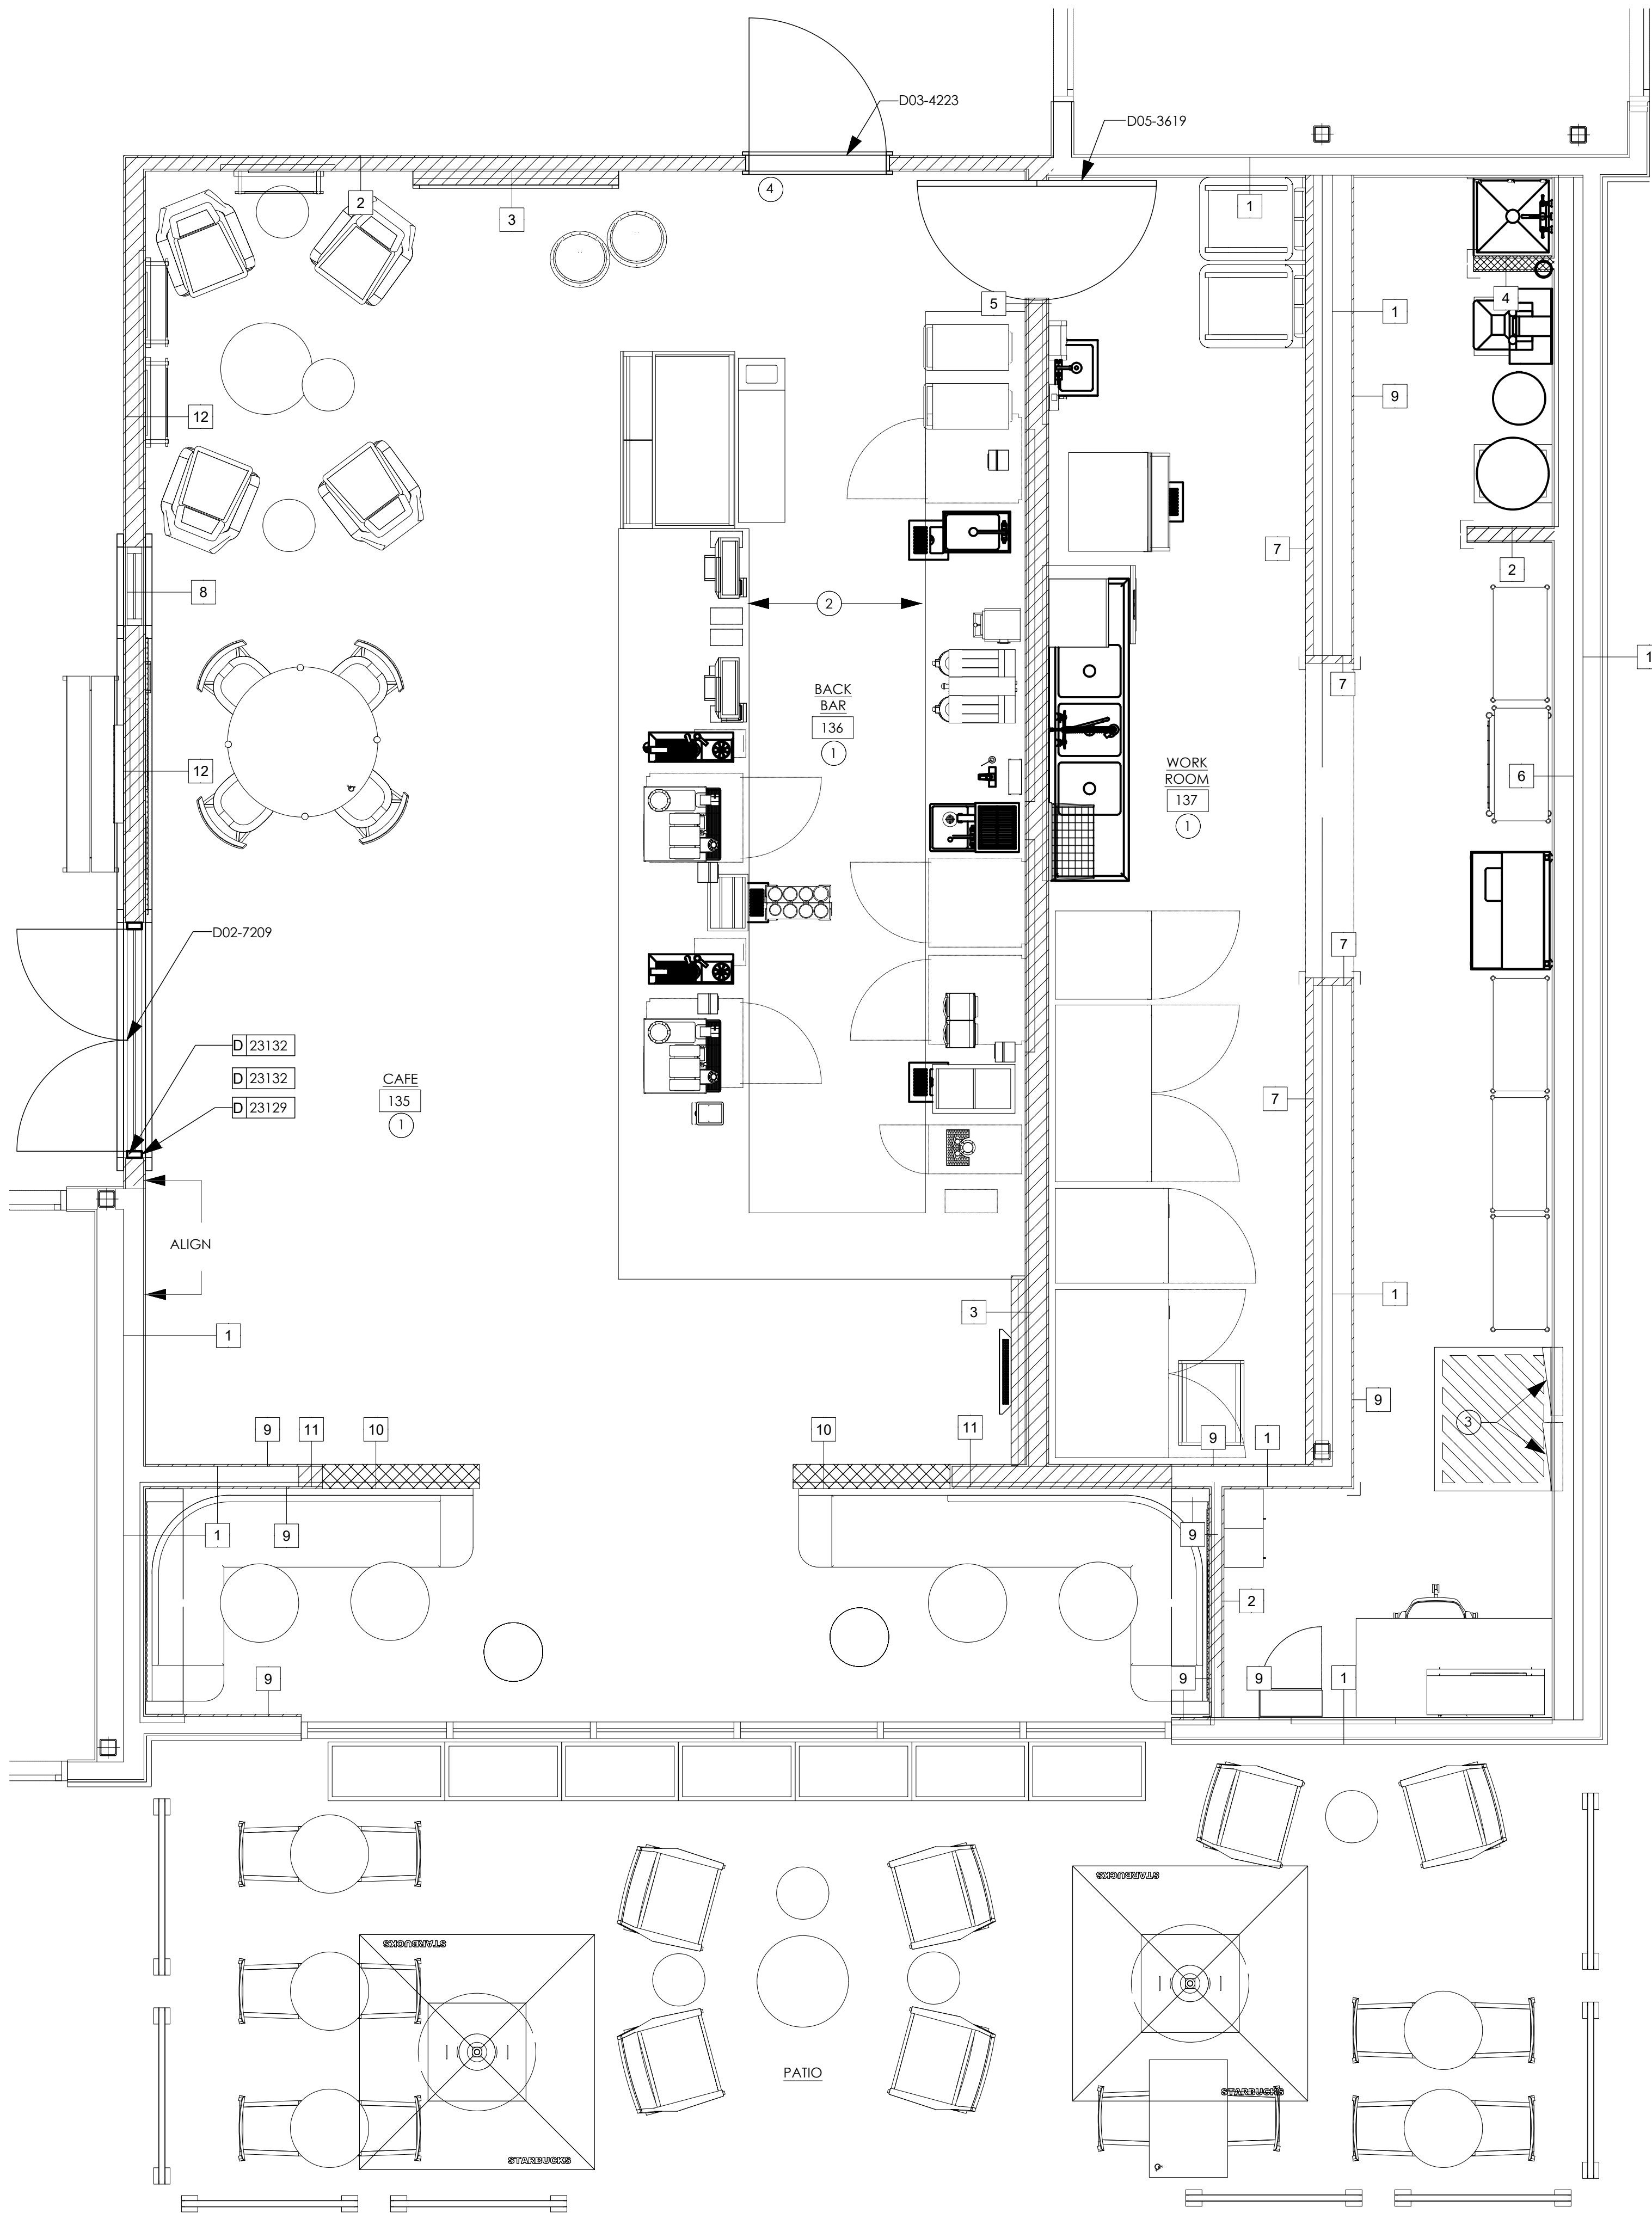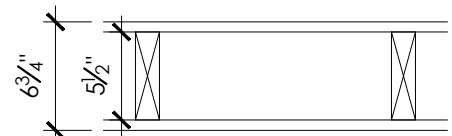

KEYED NOTES

1. INSTALL NEW WALLS AND DOORS AS INDICATED.
2. OUTLINE OF BAR PER CASEWORK MANUFACTURER.
3. PROPOSED ELECTRICAL PANEL LOCATION. MAINTAIN MINIMUM CLEARANCE AS REQUIRED BY CODE.
4. SERVICE DOOR TO BE LOCKABLE. NOT TO BE USED FOR EGRESS.

GENERAL NOTES

- A. GENERAL CONTRACTOR TO VERIFY ALL DIMENSIONS AND NOTIFY ARCHITECT OF RECORD AND STARBUCKS DEVELOPMENT MANAGER OF ANY DISCREPANCIES PRIOR TO CONSTRUCTION. ALL DIMENSIONS TO BE TAKEN FROM DESIGNATED DATUM POINT.
- B. GENERAL CONTRACTOR TO PROVIDE FIRE TREATED WOOD STUD BLOCKING, OR EQUIVALENT, TO SUPPORT ANY WALL ATTACHMENT AND/OR SIGNAGE.
- C. IF EXISTING EXTERIOR ENTRANCE THRESHOLD EXCEEDS MINIMUM BARBER FREE PROVISIONS OF THE CODE, REMOVE AND REPLACE WITH ACCESSIBLE THRESHOLD. RAISED THRESHOLDS AND FLOOR LEVEL CHANGES AT ACCESSIBLE DOORWAYS TO BE BEVELED WITH A SLOPE NO GREATER THAN 1:12.
- D. ALL DIMENSIONS ARE TO FINISHED FACE UNLESS SHOWN OR NOTED OTHERWISE.
- E. INSTALL MOISTURE RESISTANT BACKBAR WALL BOARD PER PROJECT MANUAL.
- F. ALL DOORS SHALL BE 32" (815MM) MINIMUM CLEAR OPENING WHEN OPENED TO 90 DEGREE POSITION UNLESS NOTED OTHERWISE.
- G. ARCHITECT OF RECORD TO SPECIFY ALL DOOR HARDWARE COMPONENTS, GENERAL CONTRACTOR TO FURNISH AND INSTALL.
- H. ARCHITECT OF RECORD TO VERIFY ALL EXISTING DOORS, HARDWARE, AND FRAMES MEET STARBUCKS AND/OR CODE REQUIREMENTS.
- I. GENERAL CONTRACTOR TO FURNISH AND INSTALL FIRE EXTINGUISHER(S) AS REQUIRED PER CODE.
- J. ARCHITECT OF RECORD TO VERIFY ALL WALL TYPES.
- K. GENERAL CONTRACTOR TO FURNISH AND INSTALL NEW STUD FURRING AND GWB AS REQUIRED. ARCHITECT OF RECORD TO VERIFY AND COORDINATE FOR REQUIRED FIRE RATINGS AND SOUND INSULATION CRITERIA.
- L. EGRESS SHALL NOT PASS THROUGH KITCHENS, STORAGE ROOMS, CLOSETS, OR SIMILAR SPACES.
- M. REFER TO SHEET 1105 FOR FLOOR FINISHES

LEGEND

- NEW FULL HEIGHT WALL
- NEW PARTIAL HEIGHT WALL
- EXISTING WALL
- EXISTING COLUMN
- WALL BLOCKING CALL OUT

LICENSED STORES RESPONSIBILITY LEGEND

- SB - STARBUCKS
- FC - STARBUCKS FUTURE CONTRACTOR
- LC - LICENSEE
- GC - LICENSEE'S GENERAL CONTRACTOR

ARCHITECT OF RECORD:

THOMAS E. MORGAN, JR.
ARCHITECT

423 FISCHER TRAIL
ELLIJAY, GEORGIA 30540

SEAL:



3450 Acworth Due West Road
Building 100, Suite 120
Kennesaw, Georgia 30144
P. 770-917-9172
F. 770-917-9470
www.mrpdesign.com

RELEASED FOR CONSTRUCTION

ISSUES / REVISIONS:

DATE	DESCRIPTION
01.26.28	COMPILED SET RELEASED FOR CONSTRUCTION

DRAWN BY:

CHKD BY:

PROJECT DESCRIPTION:

DEVELOPMENT OF INTERIORS
CONDITIONS FOR A C-STORE IN
CORDELE, GA.

PROJECT TITLE:

CONVENIENCE STORE
379 ROCKHOUSE RD E,
CORDELE, GA 31015

SHEET TITLE:


STARBUCKS
ENLARGE PLAN

PROJECT NO: 25049

A102

1 STARBUCKS ENLARGE PLAN
A102 SCALE: 3/8" = 1'-0"

THESE PLANS ARE THE PROPERTY OF MRP DESIGN GROUP, INC. AND ARE SUBJECT TO FEDERAL COPYRIGHT LAWS. ANY USE OF SAME WITHOUT THE EXPRESS WRITTEN PERMISSION OF MRP DESIGN GROUP, INC. IS STRICTLY PROHIBITED

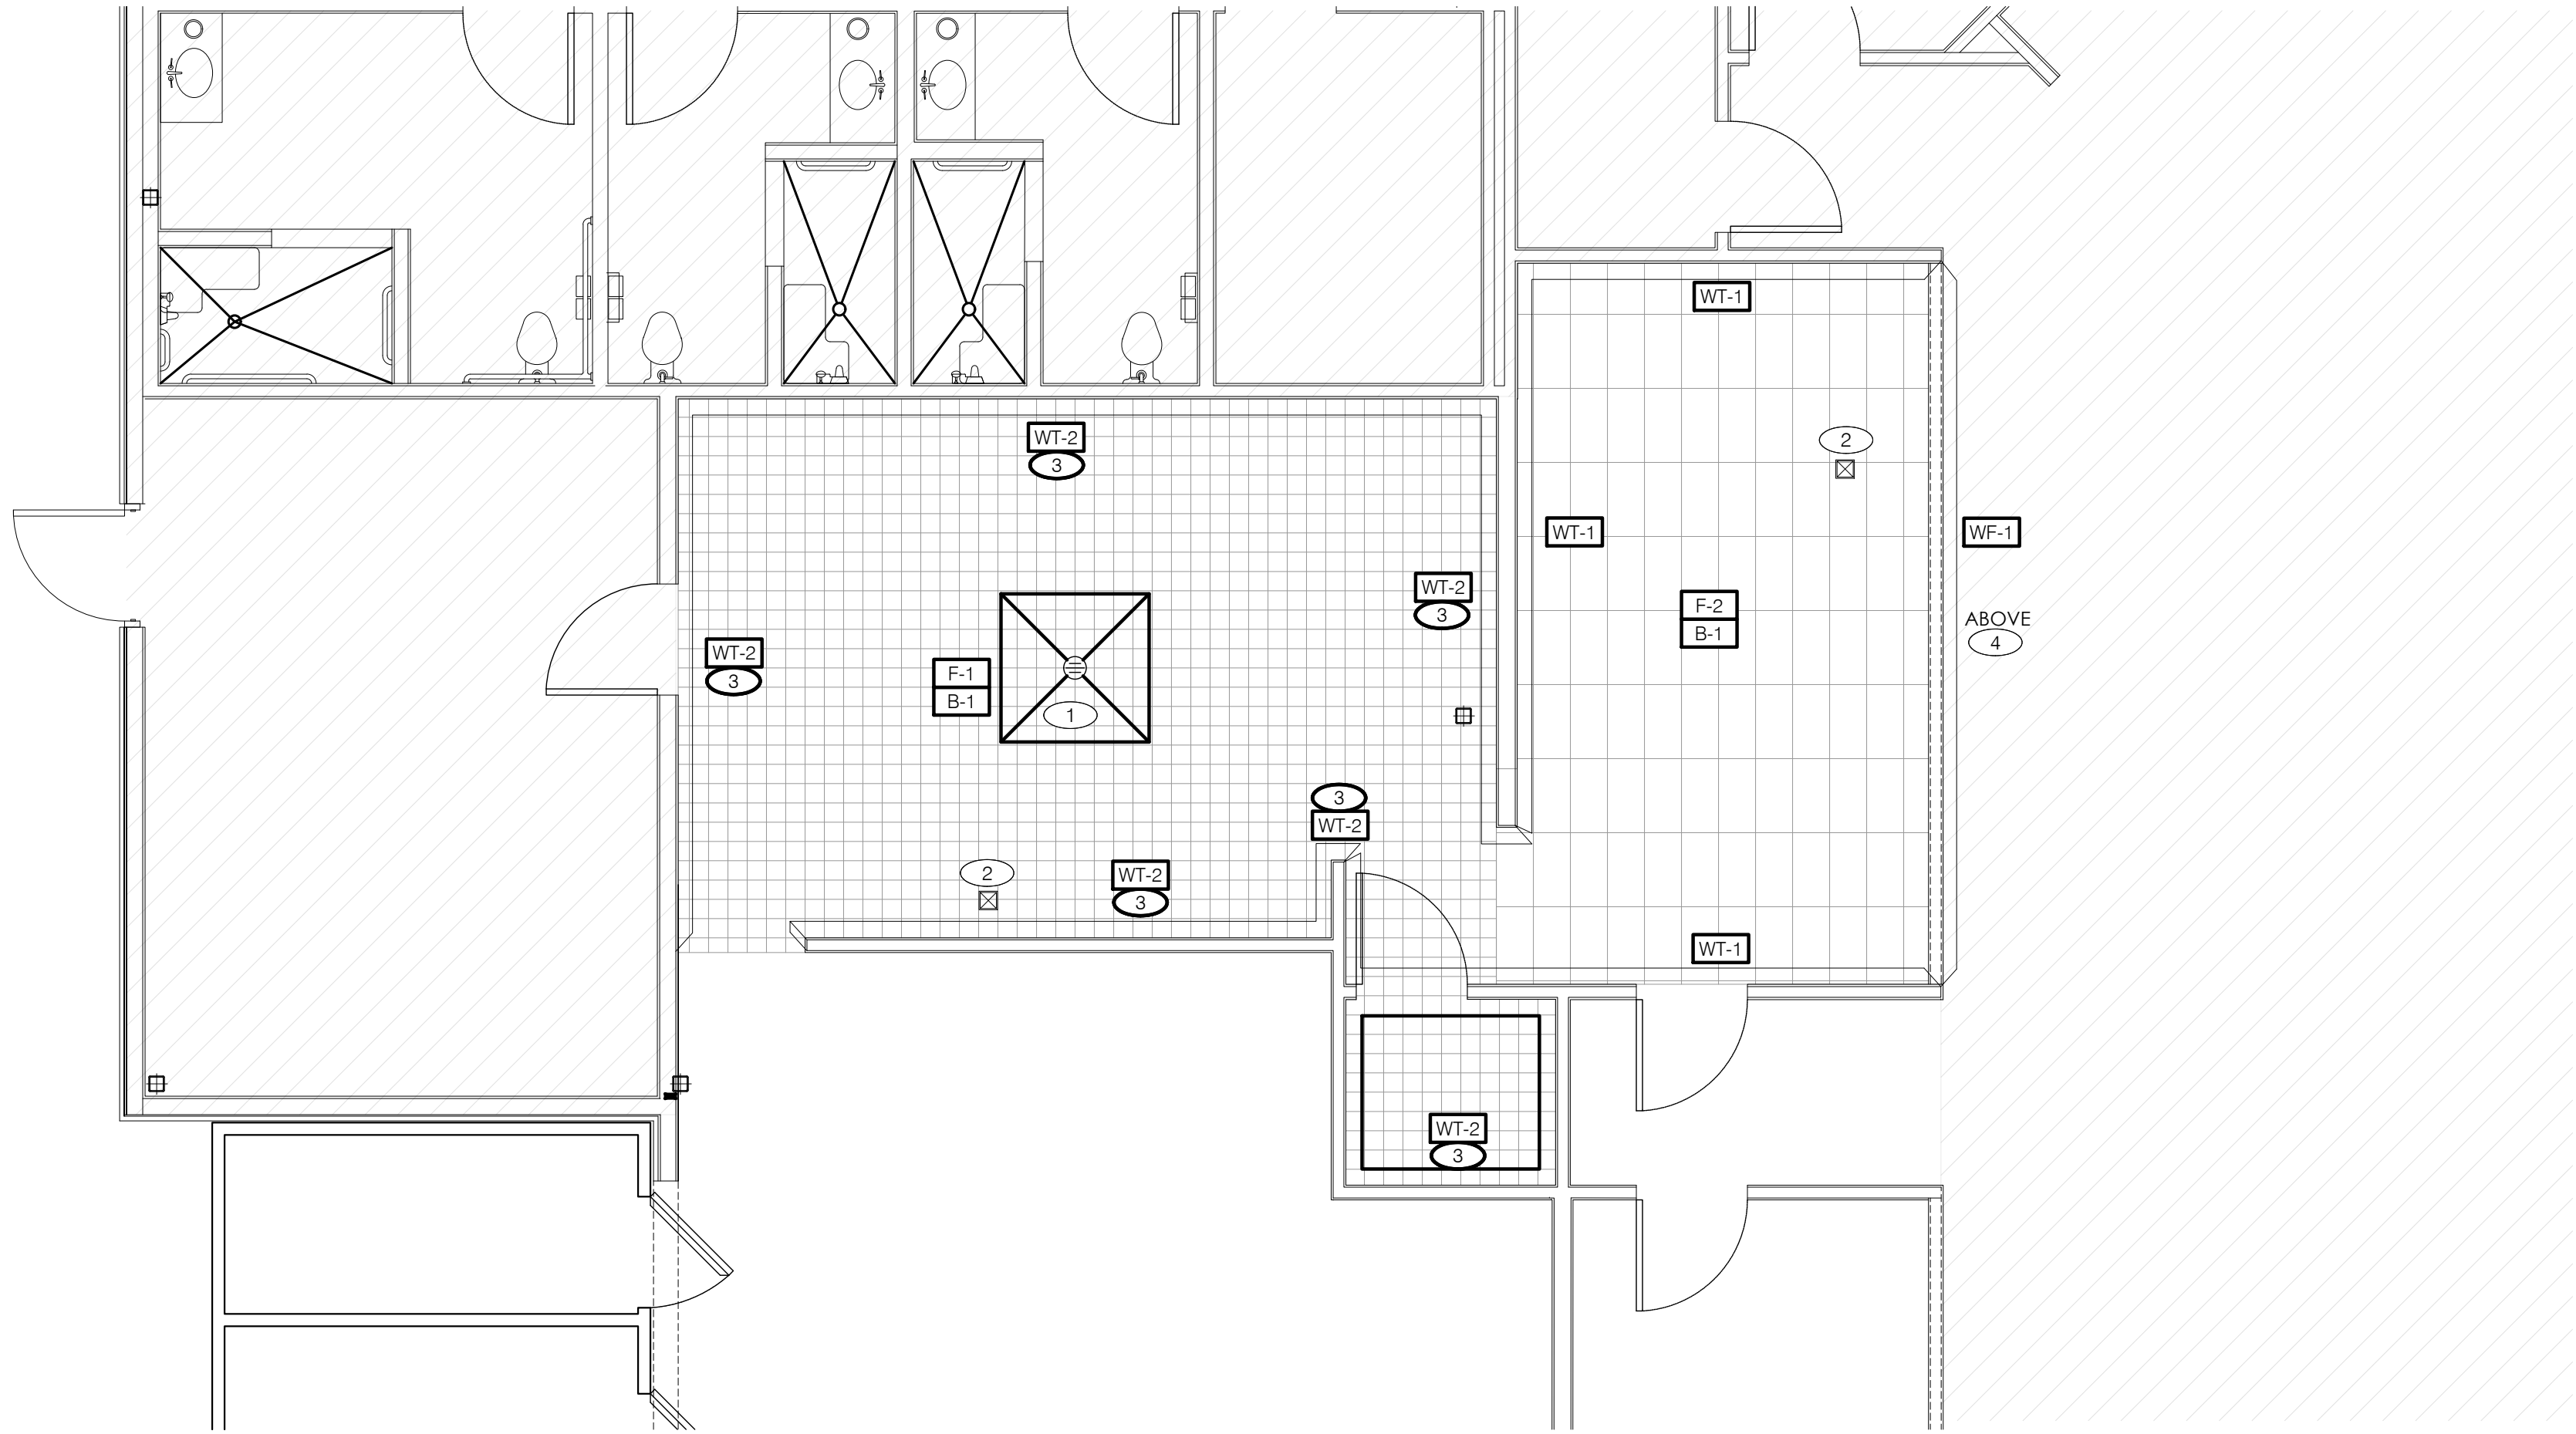

1 SBARRO FINISH FLOOR & WALL PLAN
A103 SCALE: 1/4" = 1'-0"

WALL COVERING			ANY SUBSTITUTIONS MUST BE APPROVED EQUAL		FLOOR FINISH		GENERAL NOTES		FINISH NOTES	
DESCRIPTION			ALTERNATE / NOTE		DESCRIPTION					
WT-1	MFR.: TYPE: COLOR: LOCATION:	DALTILE CURRANT 4" X 8" SH17 - GLOSSY FRONT OF HOUSE	MFR.: TYPE: COLOR: LOCATION:	MARLITE - SYMMETRIX 8" X 4" HORIZONTAL SUBWAY TILE RED (MATCH PANTONE 186C) FRONT OF HOUSE	F-1	MFR.: TYPE: COLOR:	DALTILE QUARRY TILE - ARID 6" X 6" GRAY	1. APPROVED PAINT MANUFACTURERS: BENJAMIN MOORE.	A. TILE JOINTS (U.O.N.): 1. QUARRY FLOOR TILE : 1/4" 2. GLAZED WALL TILE : 1/8" 3. BASE, TRIM AND ACCESSORIES : MATCH ADJOINING TILE UNITS	
WT-2	MFR.: TYPE: COLOR: LOCATION:	DALTILE ARTIC WHITE 4" X 8" 0190 - GLOSSY KITCHEN	MFR.: TYPE: COLOR: LOCATION:	MARLITE - SYMMETRIX 8" X 4" HORIZONTAL SUBWAY TILE WHITE HIGH GLOSS TOP COAT KITCHEN	F-2	MFR.: TYPE: COLOR:	DALTILE FLOOR TILE - INTENSITY PEBBL VL70 12" X 24" GRAY	2. ALL PAINTED SURFACES SHALL HAVE A SMOOTH TEXTURE.	B. TILE INSTALLATIONS REQUIRE MANUFACTURERS STANDARD MOLDED CORNERS	
WF-1	MFR.: TYPE: COLOR: LOCATION:	FLOOR & DECOR BURLYWOOD II LONG LEAF ACACIA 100785005 DINING SIDE - FRONT COUNTER			WALL BASE			3. ALL FINISH FLOOR ELEVATIONS ARE TAKEN FROM TOP FINISH FLOOR.	C. AT BOTH INSIDE AND OUTSIDE CORNERS, AND BULLNOSE AT TOP OF TILE WAINSCOT	
								4. TREAT ALL SLAB CRACKS, SAW CUTS AND COLD JOINTS WITH LATRICRETE CRACK SUPPRESSION KIT. FOLLOW MFG. RECOMMENDED INSTALL PROCEDURES.	D. ALL BASE TILE SHALL BE SANITARY COVE STYLE WITH 3/8" MIN RADIUS, U.O.N.	
								5. ANY DISCREPANCIES WITHIN THESE CONSTRUCTION DOCUMENTS SHALL BE BROUGHT TO THE ATTENTION OF THE ARCHITECT. THE CONTRACTOR WILL MAKE ASSUMPTIONS AT HIS OWN EXPENSE.	E. SEE RESPONSIBILITIES SCHEDULE ON SHEETS T1.1.	
								6. THIS STATEMENT SHALL NOT GOVERN OVER MANUFACTURERS' WARRANTIES. THE GENERAL CONTRACTOR SHALL WARRANTY HIS WORKMANSHIP FOR A MINIMUM PERIOD OF ONE YEAR FROM THE DATE OF OCCUPANCY & ACCEPTANCE OF WORK BY THE OWNER. DEFECTIVE OR INFERIOR MATERIALS OR WORKMANSHIP FOUND AT ANY TIME PRIOR TO FINAL ACCEPTANCE OF THE WORK BY THE OWNER AND ALSO DURING THE WARRANTY PERIOD MAY BE REJECTED, REGARDLESS OF PREVIOUS INSPECTION. CORRECTIVE MEASURES WHEN REQUIRED SHALL BE EXECUTED AT NO ADDITIONAL COST TO THE OWNER.	F. TILE CHIPPING AROUND CORE DRILL HOLES FOR SEATING WILL NOT BE ACCEPTED.	
								7. ALL MATERIALS RELATED TO THIS WORK SHALL BE: SHIPPED, STORED AND INSTALLED PER THE MANUFACTURERS RECOMMENDATIONS.	KEY NOTES	
					B-1	MFR.: TYPE: COLOR: SIZE: TYPE:	DALTILE QUARRY TILE - ARID 6" X 6" GRAY 6" HIGH INTEGRAL WALL BASE	8. THE G.C. WILL LEAVE THIS SITE FREE AND CLEAR OF DEBRIS UPON COMPLETION OF THE WORK.	① CUT / SLOPE FLOORING TO DRAIN. FOLLOW RESIN FLOORING MFR'S DETAILS AND SPECIFICATIONS. FRANCHISEE APPROVED ALTERNATE: SLOPE TO WALLS; GC TO CONFIRM ALTERNATE WITH FRANCHISEE.	
								9. WHERE THESE DOCUMENTS INDICATE TRADE OR MANUFACTURER NAMES, THE CONTRACTOR MAY SUBSTITUTE A PRODUCT OR METHOD OF BETTER OR EQUAL QUALITY UPON APPROVAL BY THE OWNER.	② FLOOR SINKS / HUB DRAINS. SEE PLUMBING DRAWINGS.	
								10. TERMITE PROTECTION SHALL BE PROVIDED UNDER THE FLOOR SLAB. INSTALLATION AND WARRANTY SHALL BE PER THE INTERNATIONAL BUILDING CODE.	③ ALL BACK-OF-HOUSE WALLS U.O.N.	
									④ WALL FINISH BY OTHER (TO MATCH T-LINES SPEC)	

ARCHITECT OF RECORD:

THOMAS E. MORGAN, JR.
ARCHITECT

423 FISCHER TRAIL
ELLIJAY, GEORGIA 30540

SEAL:



3450 Acworth Due West Road
Building 100, Suite 120
Kennesaw, Georgia 30144
P. 770-917-9172
F. 770-917-9470
www.mrpdesign.com

RELEASED FOR
CONSTRUCTION

ISSUES / REVISIONS:

DATE	DESCRIPTION
01.26.28	COMPILED SET RELEASED FOR CONSTRUCTION

DRAWN BY:

CHKD BY:

PROJECT DESCRIPTION:

DEVELOPMENT OF INTERIORS
CONDITIONS FOR A C-STORE IN
CORDELE, GA.

PROJECT TITLE:

CONVENIENCE STORE
379 ROCKHOUSE RD E,
CORDELE, GA 31015

 
SHEET TITLE:

SBARRO
FINISH FLOOR &
WALL PLAN

PROJECT NO: 25049


A103

A103.2




GENERAL NOTES	FINISH NOTES	KEY NOTES
1. INSTALL FRP ON KITCHEN SIDE OF SERVING COUNTER WALL. 2. GALV STEEL WALL AND CEILING FINISHES BY WIC / WIF BOX MFR. 3. REFER TO INTERIOR ELEVATIONS FOR LOCATIONS OF TILE AND FRP. 4. FOR FINISH LOCATIONS REFER TO: SHEETS A4.0, A4.1 - EXTERIOR ELEVATIONS SHEET A7.0 - FLOOR FINISH PLAN SHEET A7.2 - REFLECTED CEILING PLAN SHEETS A8.0, A8.1, A8.2, A8.3 - INTERIOR ELEVATIONS 5. APPROVED PAINT MANUFACTURERS: BENJAMIN MOORE. 6. ALL PAINTED SURFACES SHALL HAVE A SMOOTH TEXTURE.	A.  DENOTES FINISH MATERIAL. REFER TO SHEET A7.3 FOR FINISHES. B. TILE JOINTS (U.O.N.): 1. QUARRY FLOOR TILE : 1/4" 2. GLAZED WALL TILE : 1/8" 3. BASE, TRIM AND ACCESSORIES : MATCH ADJOINING TILE UNITS C. TILE INSTALLATIONS REQUIRE MANUFACTURERS STANDARD MOLDED CORNERS AT BOTH INSIDE AND OUTSIDE CORNERS, AND BULLNOSE AT TOP OF TILE WAINSCOT (RESTROOM WALL). D. ALL BASE TILE SHALL BE SANITARY COVE STYLE WITH 3/8" MIN RADIUS, U.O.N. E. SEE RESPONSIBILITIES SCHEDULE ON SHEETS T1-1 F. PROVIDE CLEAR SILICONE CAULK WHERE FRP STOPS AT TOP OF COVE BASE. G. TILE CHIPPING AROUND CORE DRILL HOLES FOR SEATING WILL NOT BE ACCEPTED.	 PAINT WALLS ABOVE UPPER HORIZONTAL TRIM, TRUSSES.  WALK-IN COOLER/FREEZER, FACTORY FINISH.  WALL FINISH BY OTHER (TO MATCH T-LINES SPEC)  SERVING COUNTER TOP.  FACE OF SERVING COUNTER, DINING SIDE.  FACE OF BULKHEAD, DINING SIDE.  ALL BACK-OF-HOUSE WALLS U.O.N.  ALL VERTICAL SURFACES OF SERVING COUNTER KNEEWALLS, B.O.H. SIDE.  INCLUDES FACE OF BULKHEAD, SERVING SIDE.  INCLUDES FACE OF BULKHEAD/HEADER, DRIVE-THRU SIDE.  FACE OF BULKHEAD TYP., KITCHEN SIDE.  STAINLESS STEEL WALL PANELS BEHIND HOOD. SEE SHEET A103.2

THESE PLANS ARE THE PROPERTY OF MRP DESIGN GROUP, INC. AND ARE SUBJECT TO FEDERAL COPYRIGHT LAWS. ANY USE OF SAME WITHOUT THE EXPRESS WRITTEN PERMISSION OF MRP DESIGN GROUP, INC. IS STRICTLY PROHIBITED

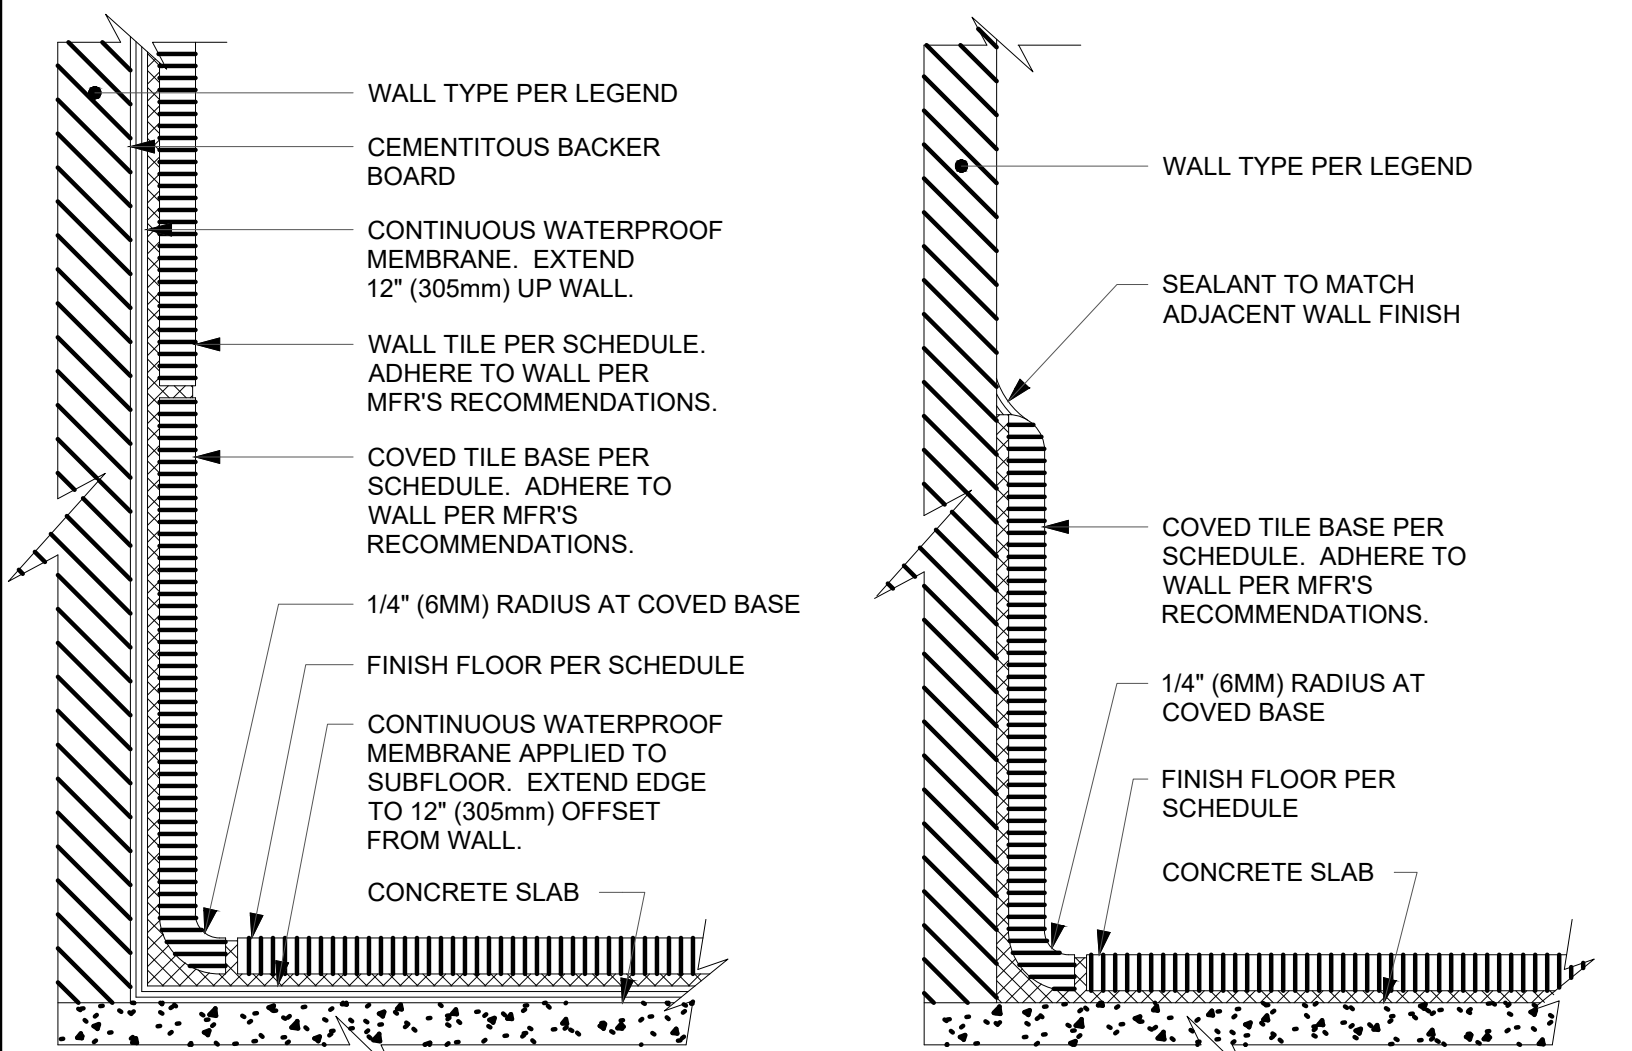


6 INTERGRAL TILE BASE @ TILED WALL SCALE: 6" = 1'-0"


2 INTERGRAL TILE BASE @ WALL SCALE: 6" = 1'-0"

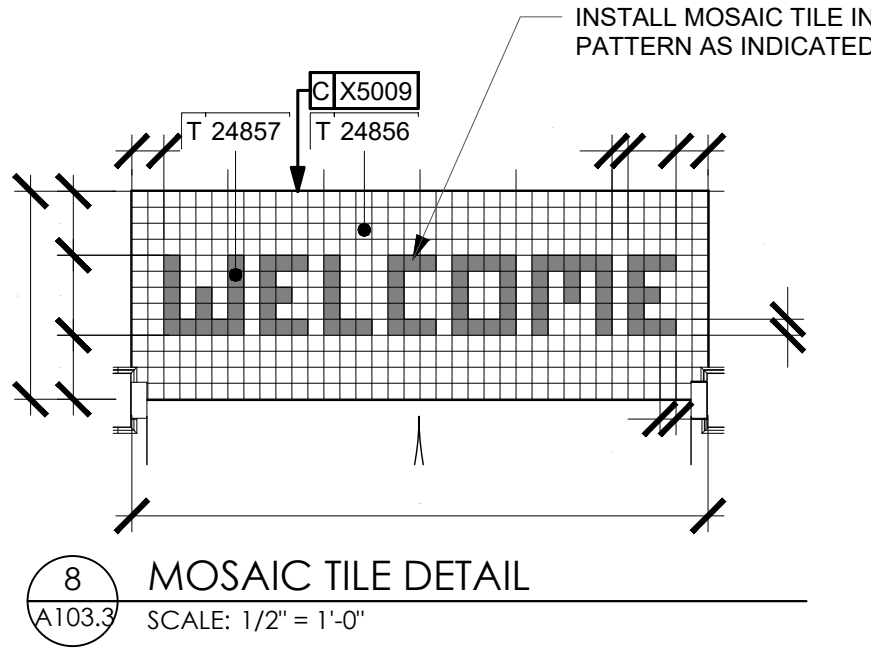


8 MOSAIC TILE DETAIL SCALE: 1/2" = 1'-0"

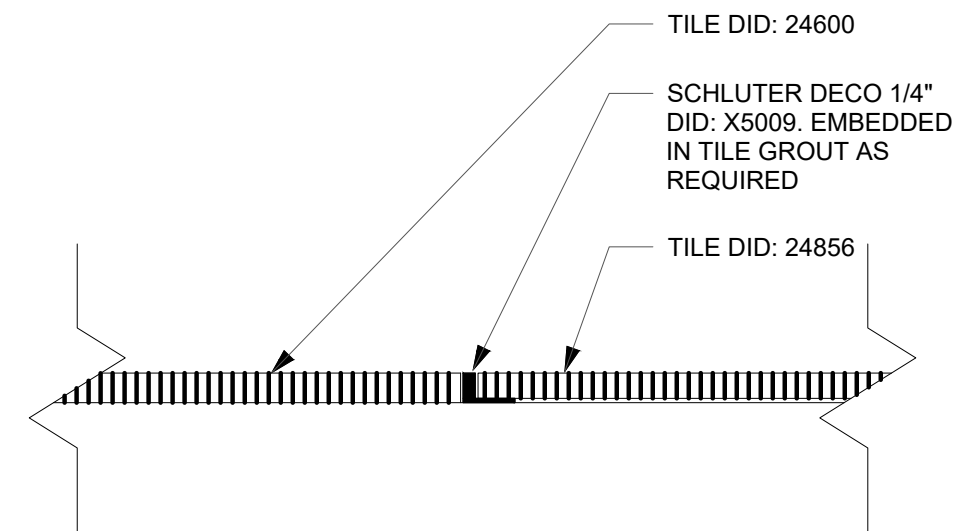


7 TRANSITION - CAFE TILE TO TILE SCALE: 3" = 1'-0"

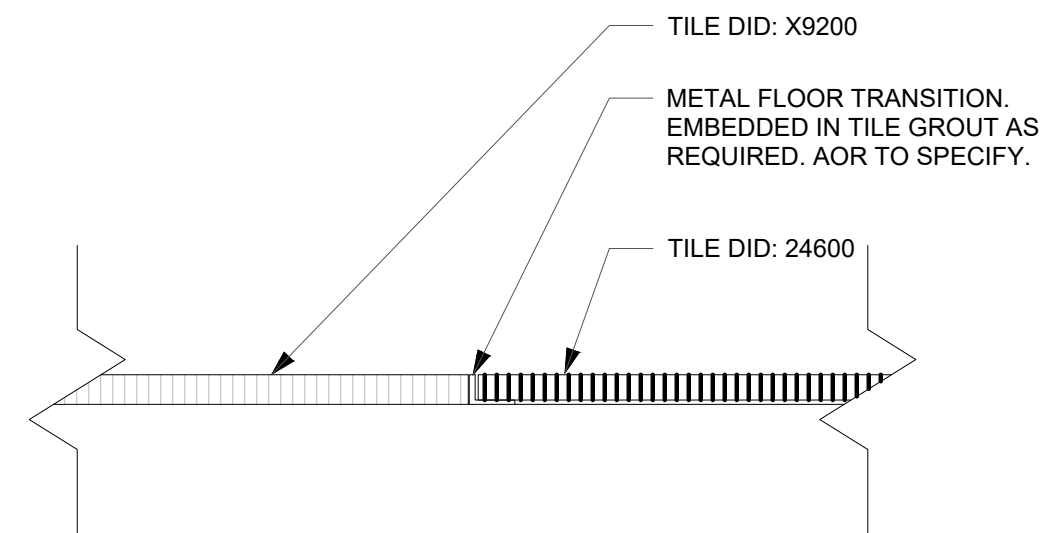


5 TRANSITION - TILE TO WORKROOM TILE SCALE: 3" = 1'-0"

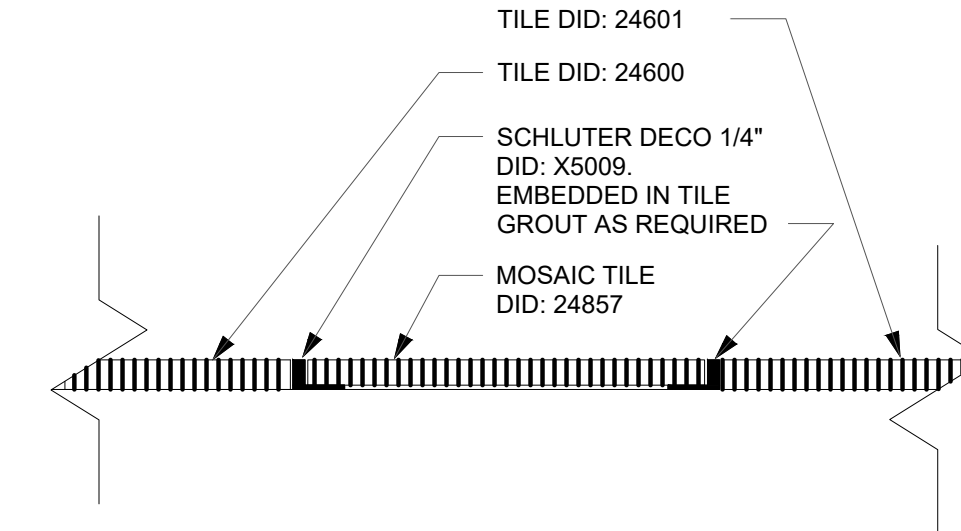

4 TRANSITION - MOSAIC TILE TO TILE SCALE: 3" = 1'-0"

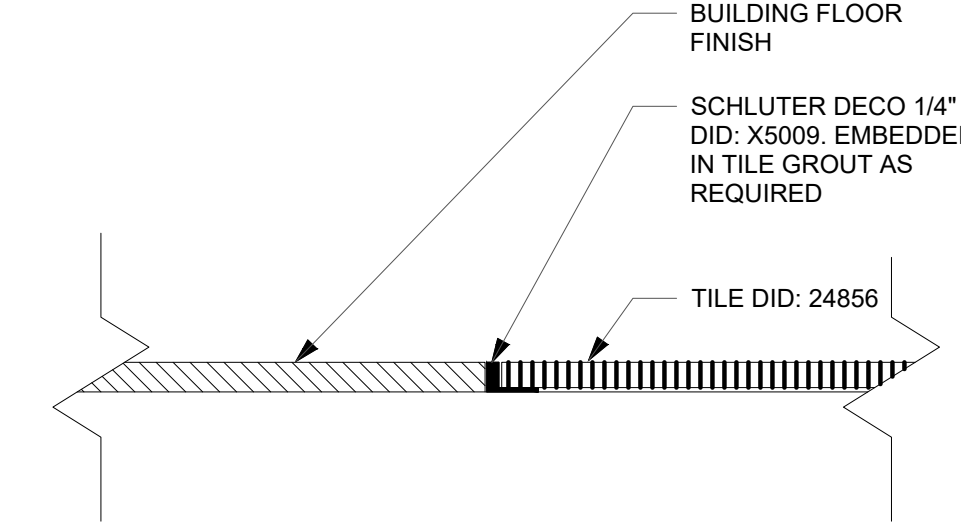

3 TRANSITION - TILE TO BUILDING FINISH SCALE: 3" = 1'-0"

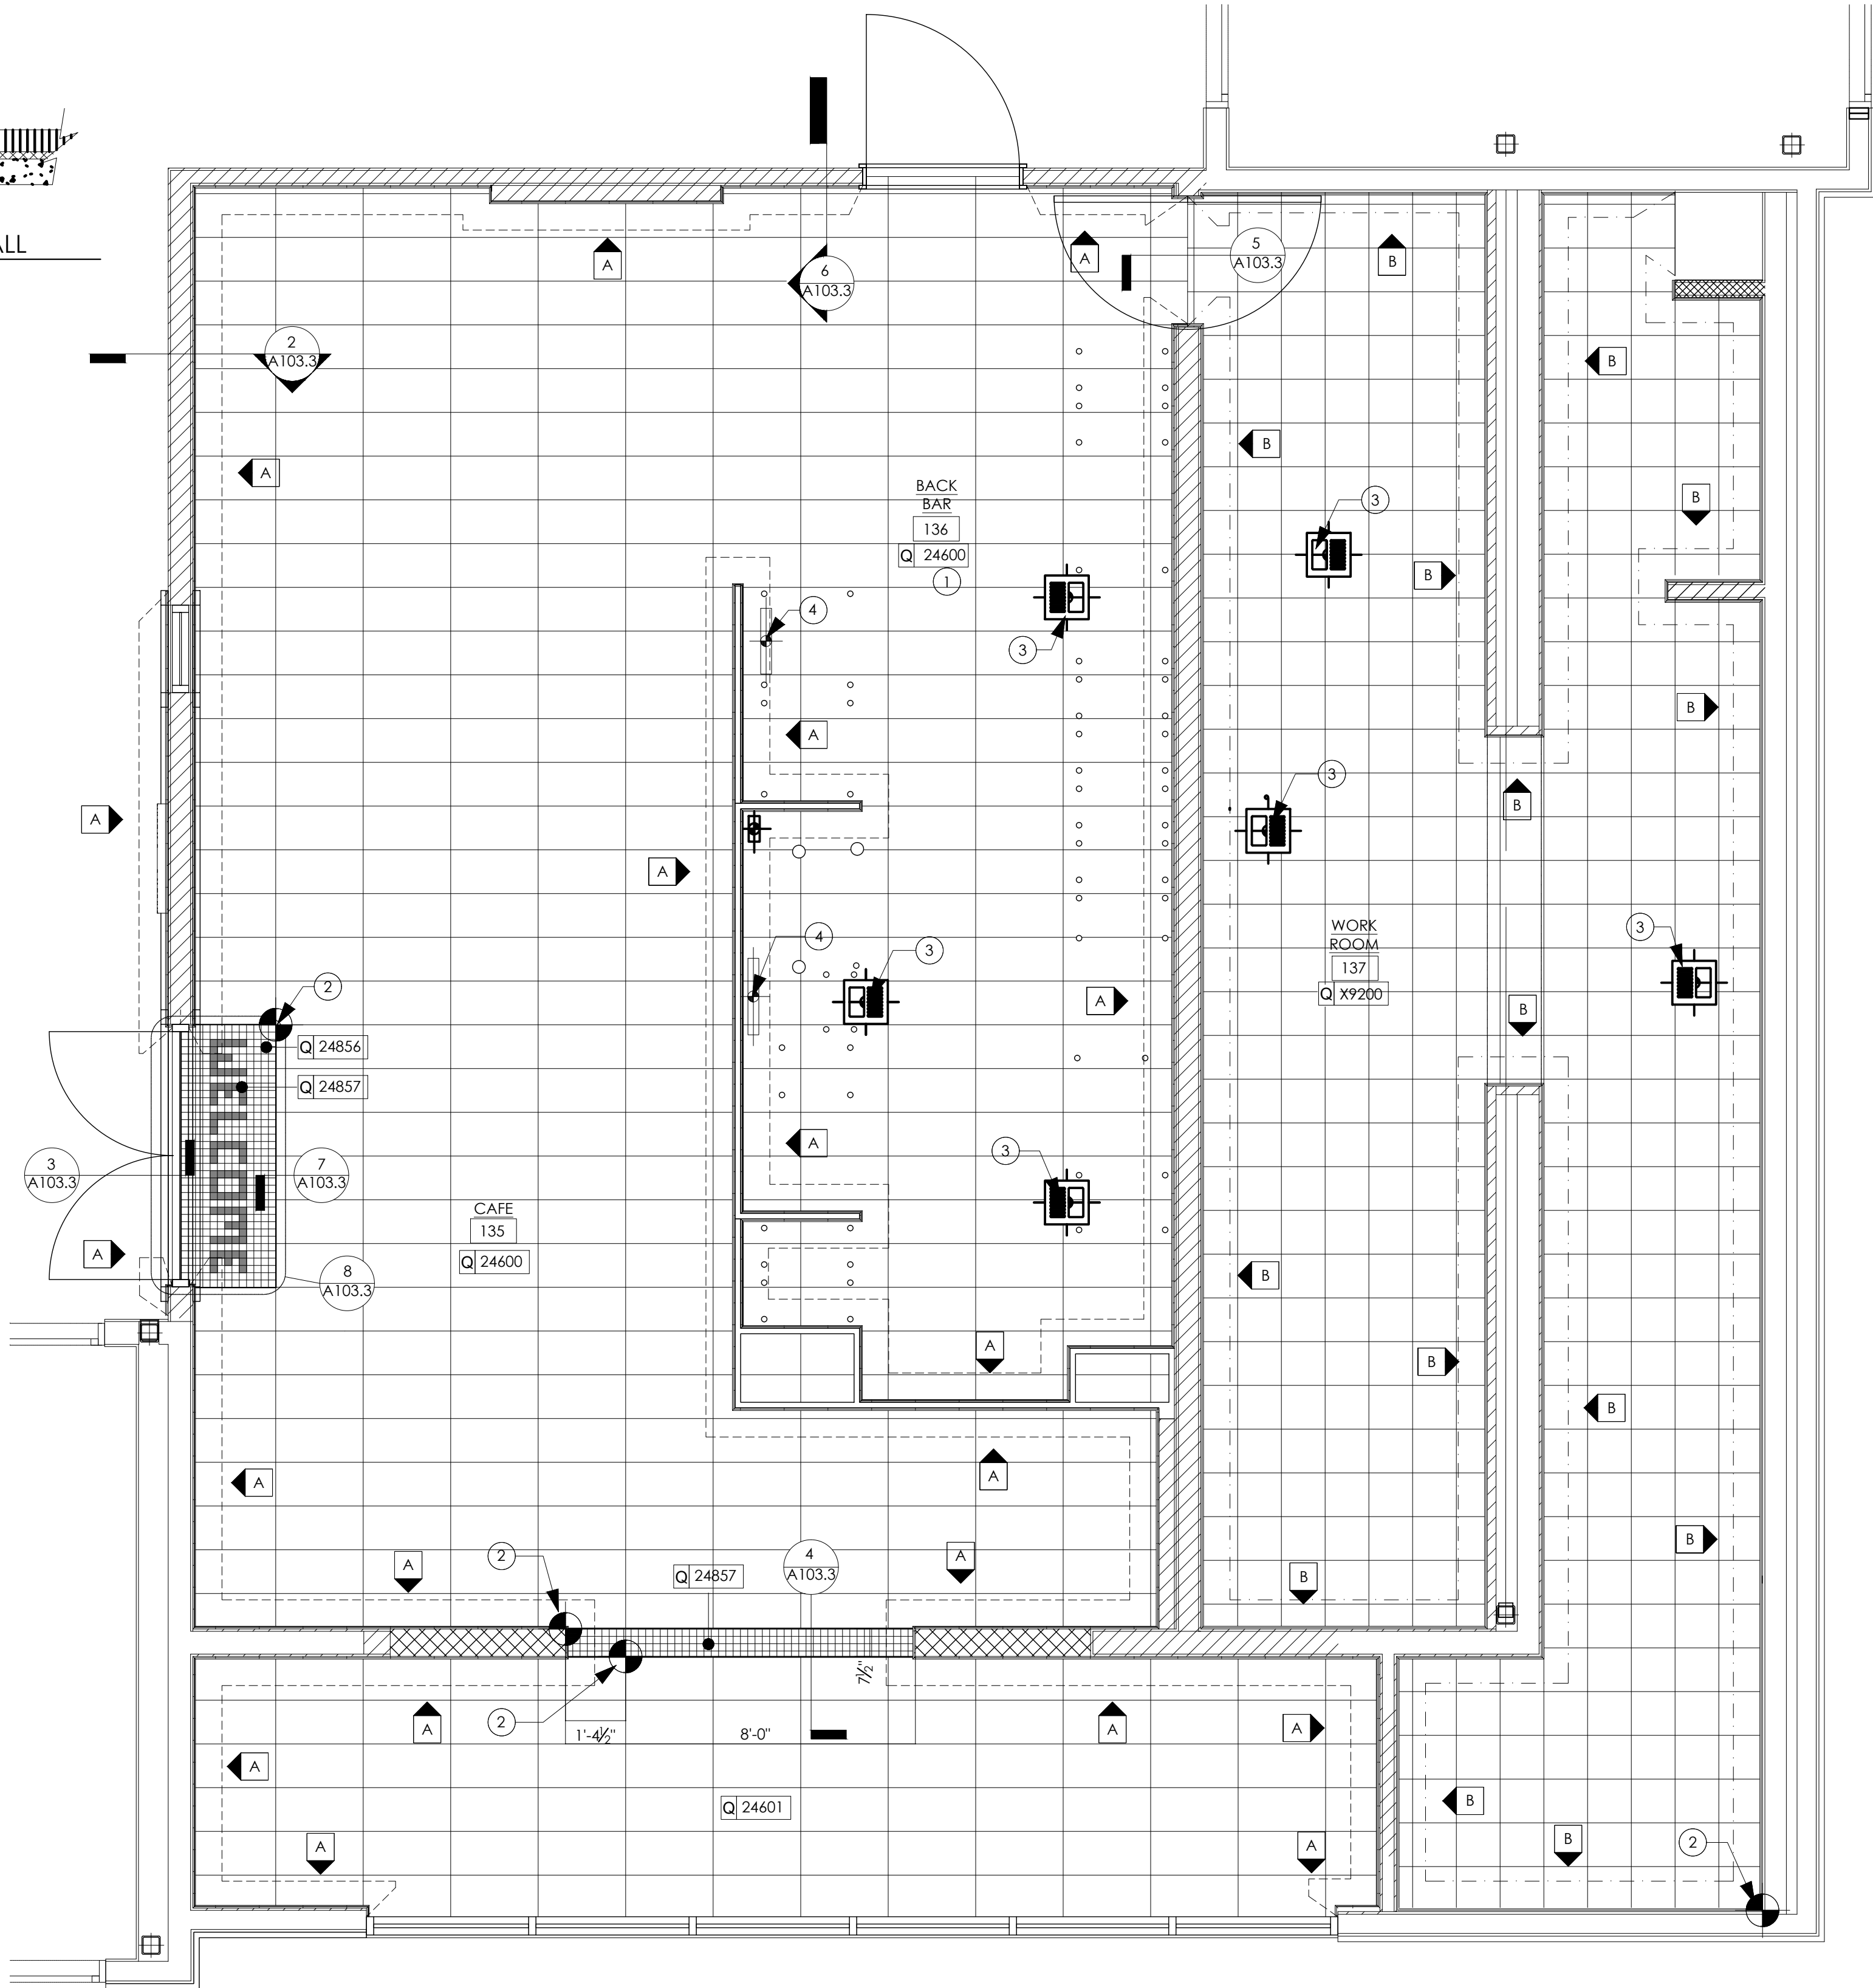

1 STARBUCKS FINISH FLOOR PLAN SCALE: 3/8" = 1'-0"

FLOOR TREATMENT SCHEDULE - "T"					
DESIGN ID	AREA	DESCRIPTION	FURN. BY	INST. BY	COMMENTS
TILE					
24600	729 SF	TILE - LAB - CLAY - NATURAL - 12X24IN	GC	GC	GROUT: MAPEI 5047-CHARCOAL. GROUT BY GC. NO SUBSTITUTIONS ALLOWED WITHOUT PRIOR SUBMITTAL APPROVAL BY STARBUCKS. SUPPLIER: STONE SOURCE - LYDIA KURTH - lkurth@ceramicttechnics.com
24601	160 SF	TILE - LAB - COAL - NATURAL - 12X24IN	GC	GC	GROUT: MAPEI 5010-BLACK. GROUT BY GC. NO SUBSTITUTIONS ALLOWED WITHOUT PRIOR SUBMITTAL APPROVAL BY STARBUCKS. SUPPLIER: STONE SOURCE - LYDIA KURTH - lkurth@ceramicttechnics.com
24856	18 SF	TILE - LAB - CLAY - MOSAIC - 12X12IN 300X300MM SHEET	GC	GC	GROUT: MAPEI 5047-CHARCOAL. GROUT BY GC. NO SUBSTITUTIONS ALLOWED WITHOUT PRIOR SUBMITTAL APPROVAL BY STARBUCKS. SUPPLIER: STONE SOURCE - LYDIA KURTH - lkurth@ceramicttechnics.com
24857	7 SF	TILE - LAB - COAL - MOSAIC - 12X12IN 300X300MM SHEET	GC	GC	GROUT: MAPEI 5010-BLACK. GROUT BY GC. NO SUBSTITUTIONS ALLOWED WITHOUT PRIOR SUBMITTAL APPROVAL BY STARBUCKS. SUPPLIER: STONE SOURCE - LYDIA KURTH - lkurth@ceramicttechnics.com
X9200	440 SF	TILE - WORKROOM	GC	GC	GROUT BY GC. LOCALLY SOURCED. AOR TO SPECIFY QUARRY TILE.

WALL BASE SCHEDULE - "B"					
DESIGN ID	LENGTH	DESCRIPTION	FURN. BY	INST. BY	COMMENTS
TILE BASE					
11434	160' - 11"	TILE BASE - WORKROOM	GC	GC	LOCALLY SOURCED. AOR TO SPECIFY QUARRY TILE.
18740	207' - 1 3/4'	TILE BASE - PLAZA NOVA - BLACK SHADOW - 6X12IN 150X300MM	GC	GC	GROUT: MAPEI - 10 BLACK. GROUT BY GC. NO SUBSTITUTIONS ALLOWED WITHOUT PRIOR SUBMITTAL APPROVAL BY STARBUCKS. SUPPLIER: DAL TILE - CARL CHITWOOD - carl.chitwood@daltile.com


KEYED NOTES

- CABINET BASES TO BE SET BEFORE FLOOR TILE INSTALLATION.
- TILE INSTALLATION START POINT(S) WHERE INDICATED.
- FLOOR SINK LOCATION. SEE BUILDING FLOOR PENETRATION PLAN ON SHEET A102 AND PLUMBING FOR ADDITIONAL INFORMATION.
- RECESSED ELECTRICAL. SEE BUILDING FLOOR PENETRATION PLAN ON SHEET A102 AND ELECTRICAL FOR ADDITIONAL INFORMATION.

GENERAL NOTES

- GENERAL CONTRACTOR TO SUPPLY RETAIL AREA AND WORKROOM FLOOR TILE AND TILE BASE, UNLESS OTHERWISE NOTED. GENERAL CONTRACTOR TO INSTALL. GENERAL CONTRACTOR TO SUPPLY AND INSTALL MORTAR, ADHESIVE, AND GROUT. GENERAL CONTRACTOR TO INSPECT ALL TILES AND REJECT DAMAGED OR SUBSTANDARD TILES PRIOR TO INSTALLATION.
- ALL FLOORING AND BASE MATERIAL TO BE INSTALLED ACCORDING TO SPECIFICATIONS AND MANUFACTURER'S INSTALLATION REQUIREMENTS.
- ALIGN TILE TRANSITIONS ON WHOLE TILES WHERE POSSIBLE.
- TILE BASE AND THRESHOLD GROUT JOINTS TO ALIGN WITH TILE FLOOR GROUT JOINTS.
- PROVIDE GROUT JOINT OF 3/16" (5MM), MAXIMUM DEVIATION OF TILE AND GROUT LINE OF 1/4" (6MM) PER 48" (1220MM).
- ALL FLOOR AND WALL JUNCTIONS IN STORAGE AND FOOD PREPARATION AREAS SHALL HAVE A 6" COVED BASE.

FLOOR FINISH LEGEND

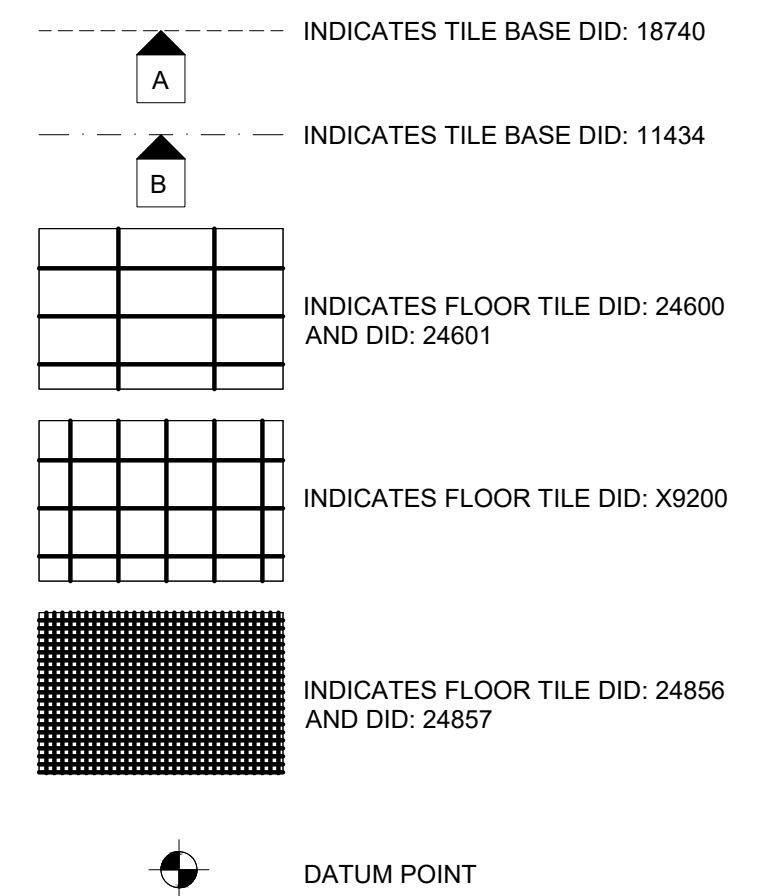

LICENSED STORES RESPONSIBILITY LEGEND

- SB - STARBUCKS
FC - STARBUCKS FIXTURE CONTRACTOR
LC - LICENSEE
GC - LICENSEE'S GENERAL CONTRACTOR

ARCHITECT OF RECORD:

THOMAS E. MORGAN, JR.
ARCHITECT

423 FISCHER TRAIL
ELLIJAY, GEORGIA 30540

SEAL:



3450 Acworth Due West Road
Building 100, Suite 120
Kennesaw, Georgia 30144
P: 770-917-9172
F: 770-917-9470
www.mrpdesign.com

RELEASED FOR CONSTRUCTION

ISSUES / REVISIONS:

DATE	DESCRIPTION
01.28.28	COMPLETED SET RELEASED FOR CONSTRUCTION

DRAWN BY:

CHKD BY:

PROJECT DESCRIPTION:

DEVELOPMENT OF INTERIORS
CONDITIONS FOR A C-STORE IN
CORDELE, GA.

PROJECT TITLE:

CONVENIENCE STORE
379 ROCKHOUSE RD E,
CORDELE, GA 31015

SHEET TITLE:

STARBUCKS
FINISH FLOOR
PLAN

PROJECT NO: 25049



A103.3

THESE PLANS ARE THE PROPERTY OF MRP DESIGN GROUP, INC. AND ARE SUBJECT TO FEDERAL COPYRIGHT LAWS. ANY USE OF SAME WITHOUT THE EXPRESS WRITTEN PERMISSION OF MRP DESIGN GROUP, INC. IS STRICTLY PROHIBITED

WALL TREATMENT (AREA) SCHEDULE - "Q"					
DESIGN ID	AREA	DESCRIPTION	FURN. BY	INST. BY	COMMENTS
PLASTIC					
11469	2255 SF	FRP - WHITE	GC	GC	VERIFY TOTAL QUANTITY WITH CEILING TREATMENT AND WALL TREATMENT SCHEDULES
TILE					
24756	148 SF	TILE - MINI FORNACE - BRUNO BISTRO - 2.4X9.4IN 60X240MM	GC	GC	GROUT: MAPEI 5004-BAHAMA BEIGE. GROUT BY GC. NO SUBSTITUTIONS ALLOWED WITHOUT PRIOR SUBMITTAL APPROVAL BY STARBUCKS. SUPPLIER: DESIGN & DIRECT SOURCE - SUZZANE SANNING -ssanning@designdirectsource.com
24757	97 SF	TILE - MINI FORNACE - FORMELLA BRUNO BISTRO - 2.4X9.4IN 60X240MM	GC	GC	GROUT: MAPEI 5004-BAHAMA BEIGE. GROUT BY GC. NO SUBSTITUTIONS ALLOWED WITHOUT PRIOR SUBMITTAL APPROVAL BY STARBUCKS. SUPPLIER: DESIGN & DIRECT SOURCE - SUZZANE SANNING -ssanning@designdirectsource.com
WALL COVERING					
24759	517 SF	WALL COVERING - CAMBRIAN - ADVENTURINE	SB	GC	PROVIDE LEVEL 5 WALL FINISH.
X9400	181 SF	WALL COVERING - MOMENTUM - WOODS - RIFTED OAK	SB	GC	SKU: SWS-75. VERTICAL GRAIN. VENDOR: MOMENTUM TEXTILES - LANETTE ALLEN -lallen@momtex.com. SEND SAMPLE TO CASEWORK VENDOR TO COLOR MATCH. STARBUCKS TO APPROVE COLOR SAMPLE.

PAINT SCHEDULE					
DESIGN ID	DESCRIPTION	LRV	FURN. BY	INST. BY	COMMENTS
20438	SW7020 BLACK FOX	8	GC	GC	
20441	SW7031 MEGA GREIGE	37	GC	GC	
X9000	BLACK TO MATCH STOREFRONT SYSTEM		GC	GC	

ACOUSTIC WALL PANEL SCHEDULE - "F"					
DESIGN ID	COUNT	DESCRIPTION	FURN. BY	INST. BY	COMMENTS
OTHER					
X6007	6	ACOUSTIC WALL PANEL - ZINTRA - EMBOSSED - CORDUROY - COLOR: ECRU	GC	GC	CONTACT: MDC - starbucks@mdcwall.com - LONG LEAD ITEM.

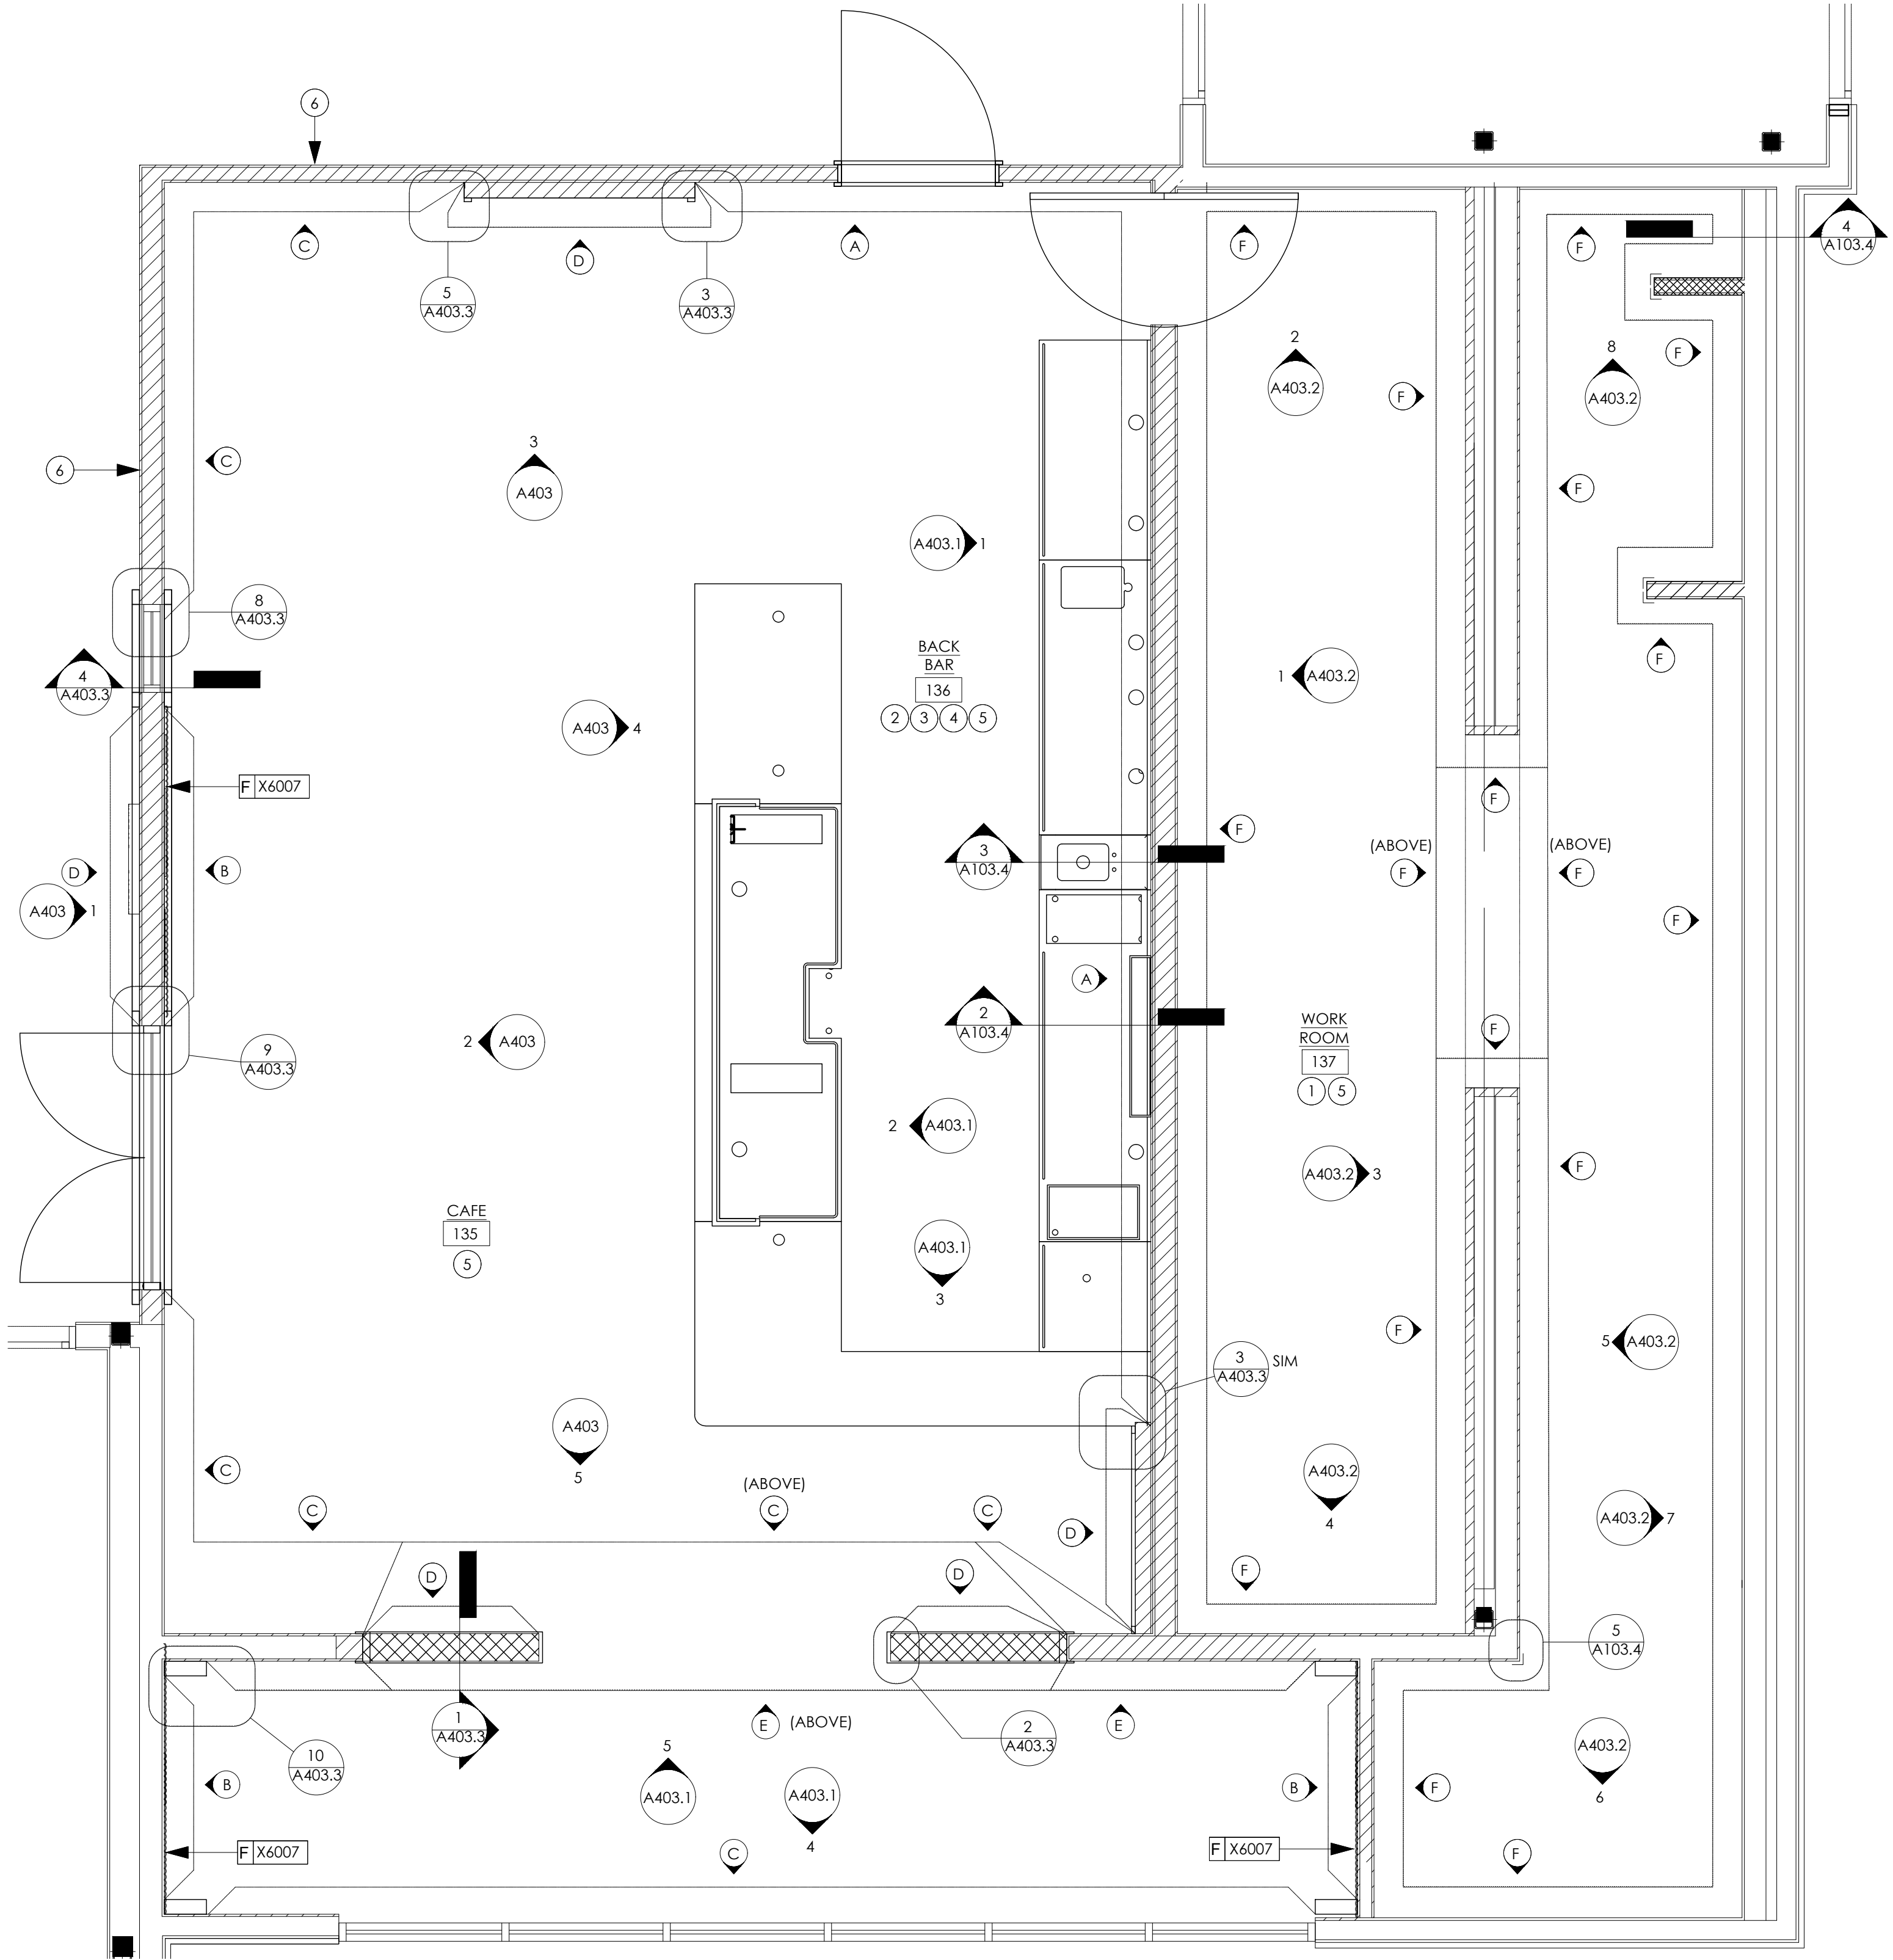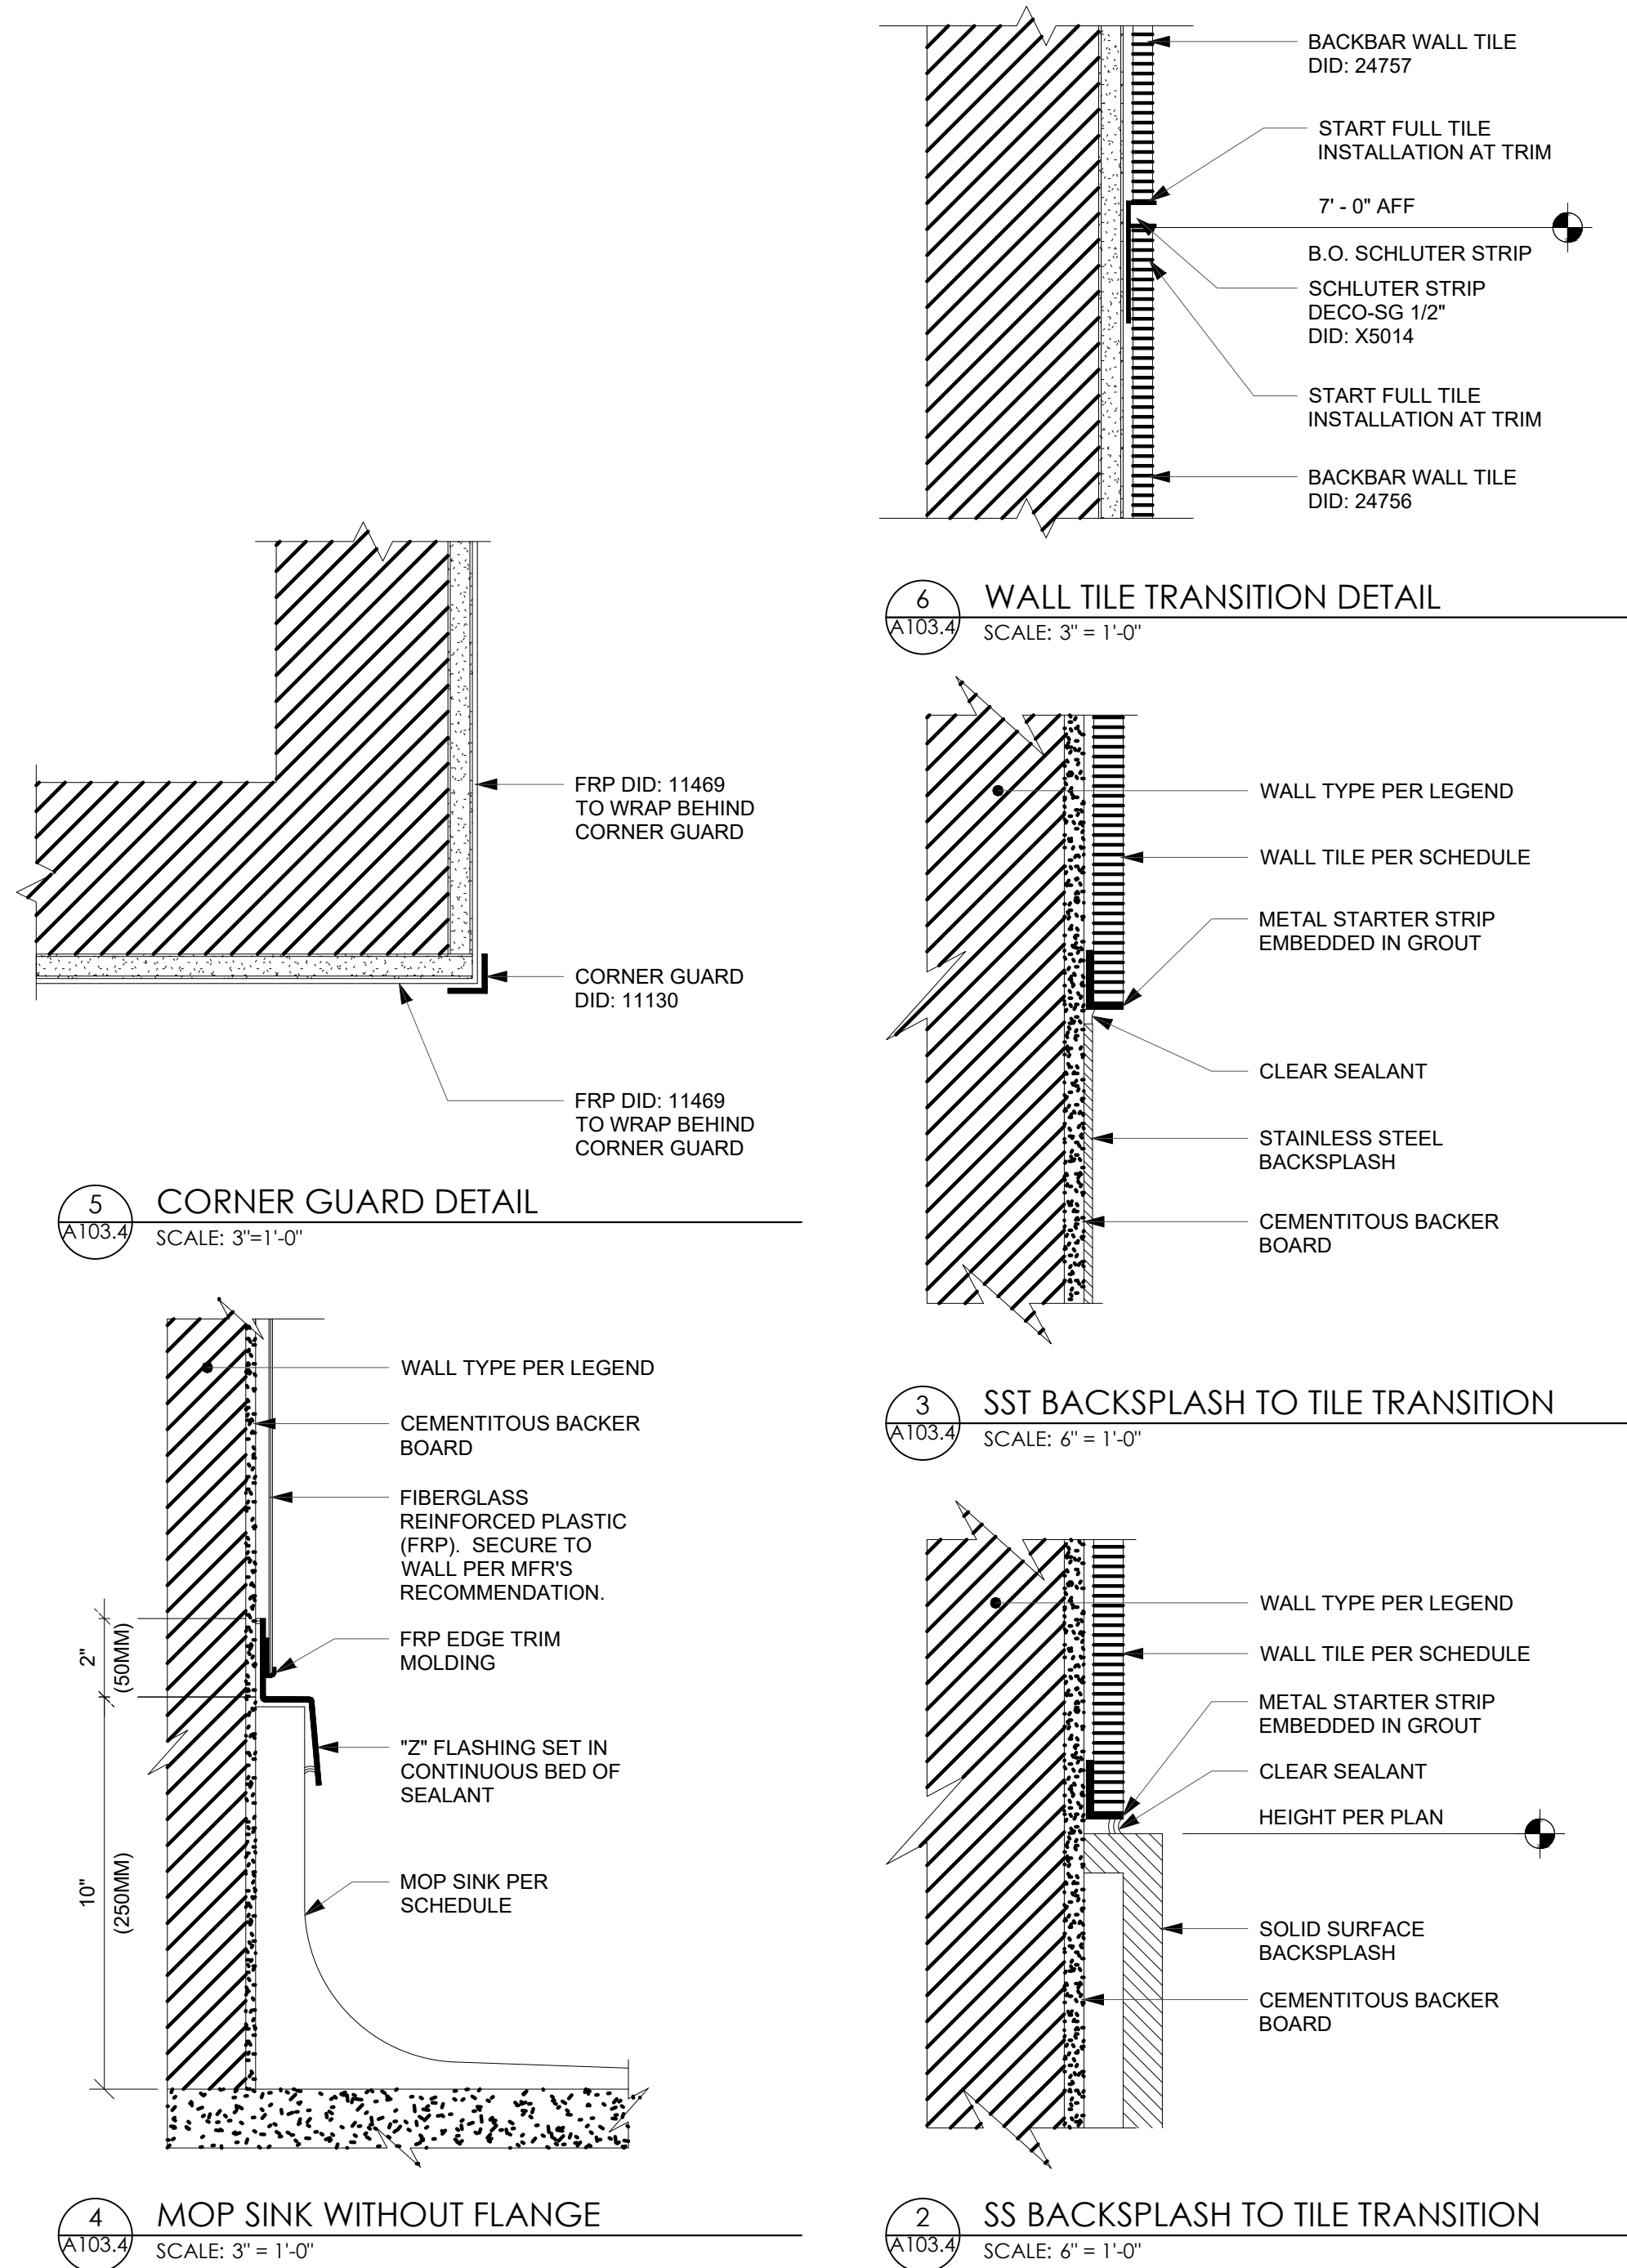

KEYED NOTES

- INSTALL METAL CORNER GUARDS WHERE INDICATED IN WORKROOM. MOUNT AT 6" (150MM) AFF. AFFIX WITH #6 STAINLESS STEEL OVAL HEAD SCREWS. 3" (75MM) FROM ENDS AND 12" (305MM) ON CENTER. OFFSET SCREWS ON EITHER SIDE BY 1/2" (10MM) VERTICALLY. SEE SPECIALTY EQUIPMENT SCHEDULE.
- GENERAL CONTRACTOR TO PROVIDE AND INSTALL FRP WALL FINISH BEHIND CASEWORK CABINETS IN AREAS BELOW COUNTERTOP HEIGHT.
- SEE INTERIOR FINISH ELEVATIONS FOR FULL EXTENT OF BACK BAR WALL TILE.
- BACK BAR WALL TILE TO BE INSTALLED IN VERTICAL STACKED PATTERN.
- GENERAL CONTRACTOR TO PROVIDE FIRE TREATED WOOD STUD BLOCKING AS REQUIRED TO SUPPORT ANY WALL ATTACHMENTS. SEE BUILDING FLOOR PLAN SHEET A101 FOR MORE INFORMATION.
- LICENSEE FINISH.

GENERAL NOTES

- GENERAL CONTRACTOR TO PATCH AND REPAIR ANY DAMAGE TO EXISTING WALLS TO A SMOOTH, PAINT READY SURFACE PRIOR TO PAINTING.
- FLOORS, WALLS, AND CEILING FINISHES IN FOOD PREPARATION AREAS SHALL BE SMOOTH, NON-TOXIC, NON-ABSORBENT, DURABLE, AND EASILY CLEANABLE. PAINT IN THESE AREAS SHALL BE WASHABLE, SEMI-GLOSS OR HIGH-GLOSS FINISH.
- CHANGE OF PAINT COLOR ONLY AT INSIDE CORNERS, UNLESS NOTED OTHERWISE.
- PAINT SUBSTITUTIONS ARE NOT ALLOWED. USE STARBUCKS NATIONAL SHERWIN WILLIAMS ACCOUNT "COLOR CODE" WHEN ORDERING PAINTS.
- PAINT FINISHES SHALL BE APPLIED AS FOLLOWS, UNLESS NOTED OTHERWISE:
 - WOOD AND METAL SURFACES SHALL BE SEMI-GLOSS OR EQUAL.
 - ACCENT AND TRIM PAINTS TO BE SEMI-GLOSS OR EQUAL.
 - WALL AND CEILING PAINTS TO BE EGGSHELL OR EQUAL.
 - PAINTS IN WORKROOM, RESTROOM(S), OR CAFE BAR SHALL BE SEMI-GLOSS EQUAL.
- WORKROOM TO BE FINISHED PER LOCAL CODE. GENERAL CONTRACTOR TO PROVIDE AND INSTALL WORKROOM WALL FINISHES.
- ALL WOOD SURFACES (DOORS, TRIM, SHELVES, CABINETS, ETC.) SHALL BE SEALED.
- REFER TO INTERIOR FINISH ELEVATIONS FOR PAINT COLOR, ARTWORK, AND GRAPHICS LOCATIONS.
- GENERAL CONTRACTOR TO INSTALL WALL BLOCKING AND HANGERS FOR WALL SHELVING BEFORE INSTALLING BACK BAR WALL TILE.

WALL TREATMENT LEGEND

- A INDICATES WALL TILE DID: 24756 TO 7'-0" AND WALL TILE DID: 24757 ABOVE (AND FRP DID: 11469 BELOW COUNTERTOPS)*
- B INDICATES ACOUSTICAL PANELS DID: X6007*
- C INDICATES WALL COVERING DID: 24759*
- D INDICATES WOOD WALL COVERING DID: X9400*
- E INDICATES PAINTED FINISH DID: 20441*
- F INDICATES FRP DID: 11469*
- INDICATES STAINLESS STEEL CORNER GUARD FOR BOH OR HOT ROLLED STEEL CORNER GUARD FOR CAFE SPACE. INSTALL 6" (150mm) TO 42" (1065mm) AFF UNLESS OTHERWISE NOTED.

- * SEE INTERIOR FINISH ELEVATIONS FOR TAGGED LOCATION OF WALL FINISH MATERIAL.

LICENSED STORES RESPONSIBILITY LEGEND

- SB - STARBUCKS
FC - STARBUCKS FIXTURE CONTRACTOR
LC - LICENSEE
GC - LICENSEE'S GENERAL CONTRACTOR

ARCHITECT OF RECORD:

THOMAS E. MORGAN, JR.
ARCHITECT

423 FISCHER TRAIL
ELLIJAY, GEORGIA 30540

SEAL:

MRP
DESIGN GROUP

3450 Acworth Due West Road
Building 100, Suite 120
Kennesaw, Georgia 30144
P. 770-917-9172
F. 770-917-9470
www.mrpdesign.com

RELEASED FOR
CONSTRUCTION

ISSUES / REVISIONS:

DATE DESCRIPTION
01.26.28 COMPILED SET RELEASED FOR CONSTRUCTION

DRAWN BY:

CHKD BY:

PROJECT DESCRIPTION:

DEVELOPMENT OF INTERIORS
CONDITIONS FOR A C-STORE IN
CORDELE, GA.

PROJECT TITLE:

CONVENIENCE STORE
379 ROCKHOUSE RD E,
CORDELE, GA 31015


SHEET TITLE:

STARBUCKS
FINISH WALL
PLAN

PROJECT NO: 25049

A103.4

THESE PLANS ARE THE PROPERTY OF MRP DESIGN GROUP, INC. AND ARE SUBJECT TO FEDERAL COPYRIGHT LAWS. ANY USE OF SAME WITHOUT THE EXPRESS WRITTEN PERMISSION OF MRP DESIGN GROUP, INC. IS STRICTLY PROHIBITED.

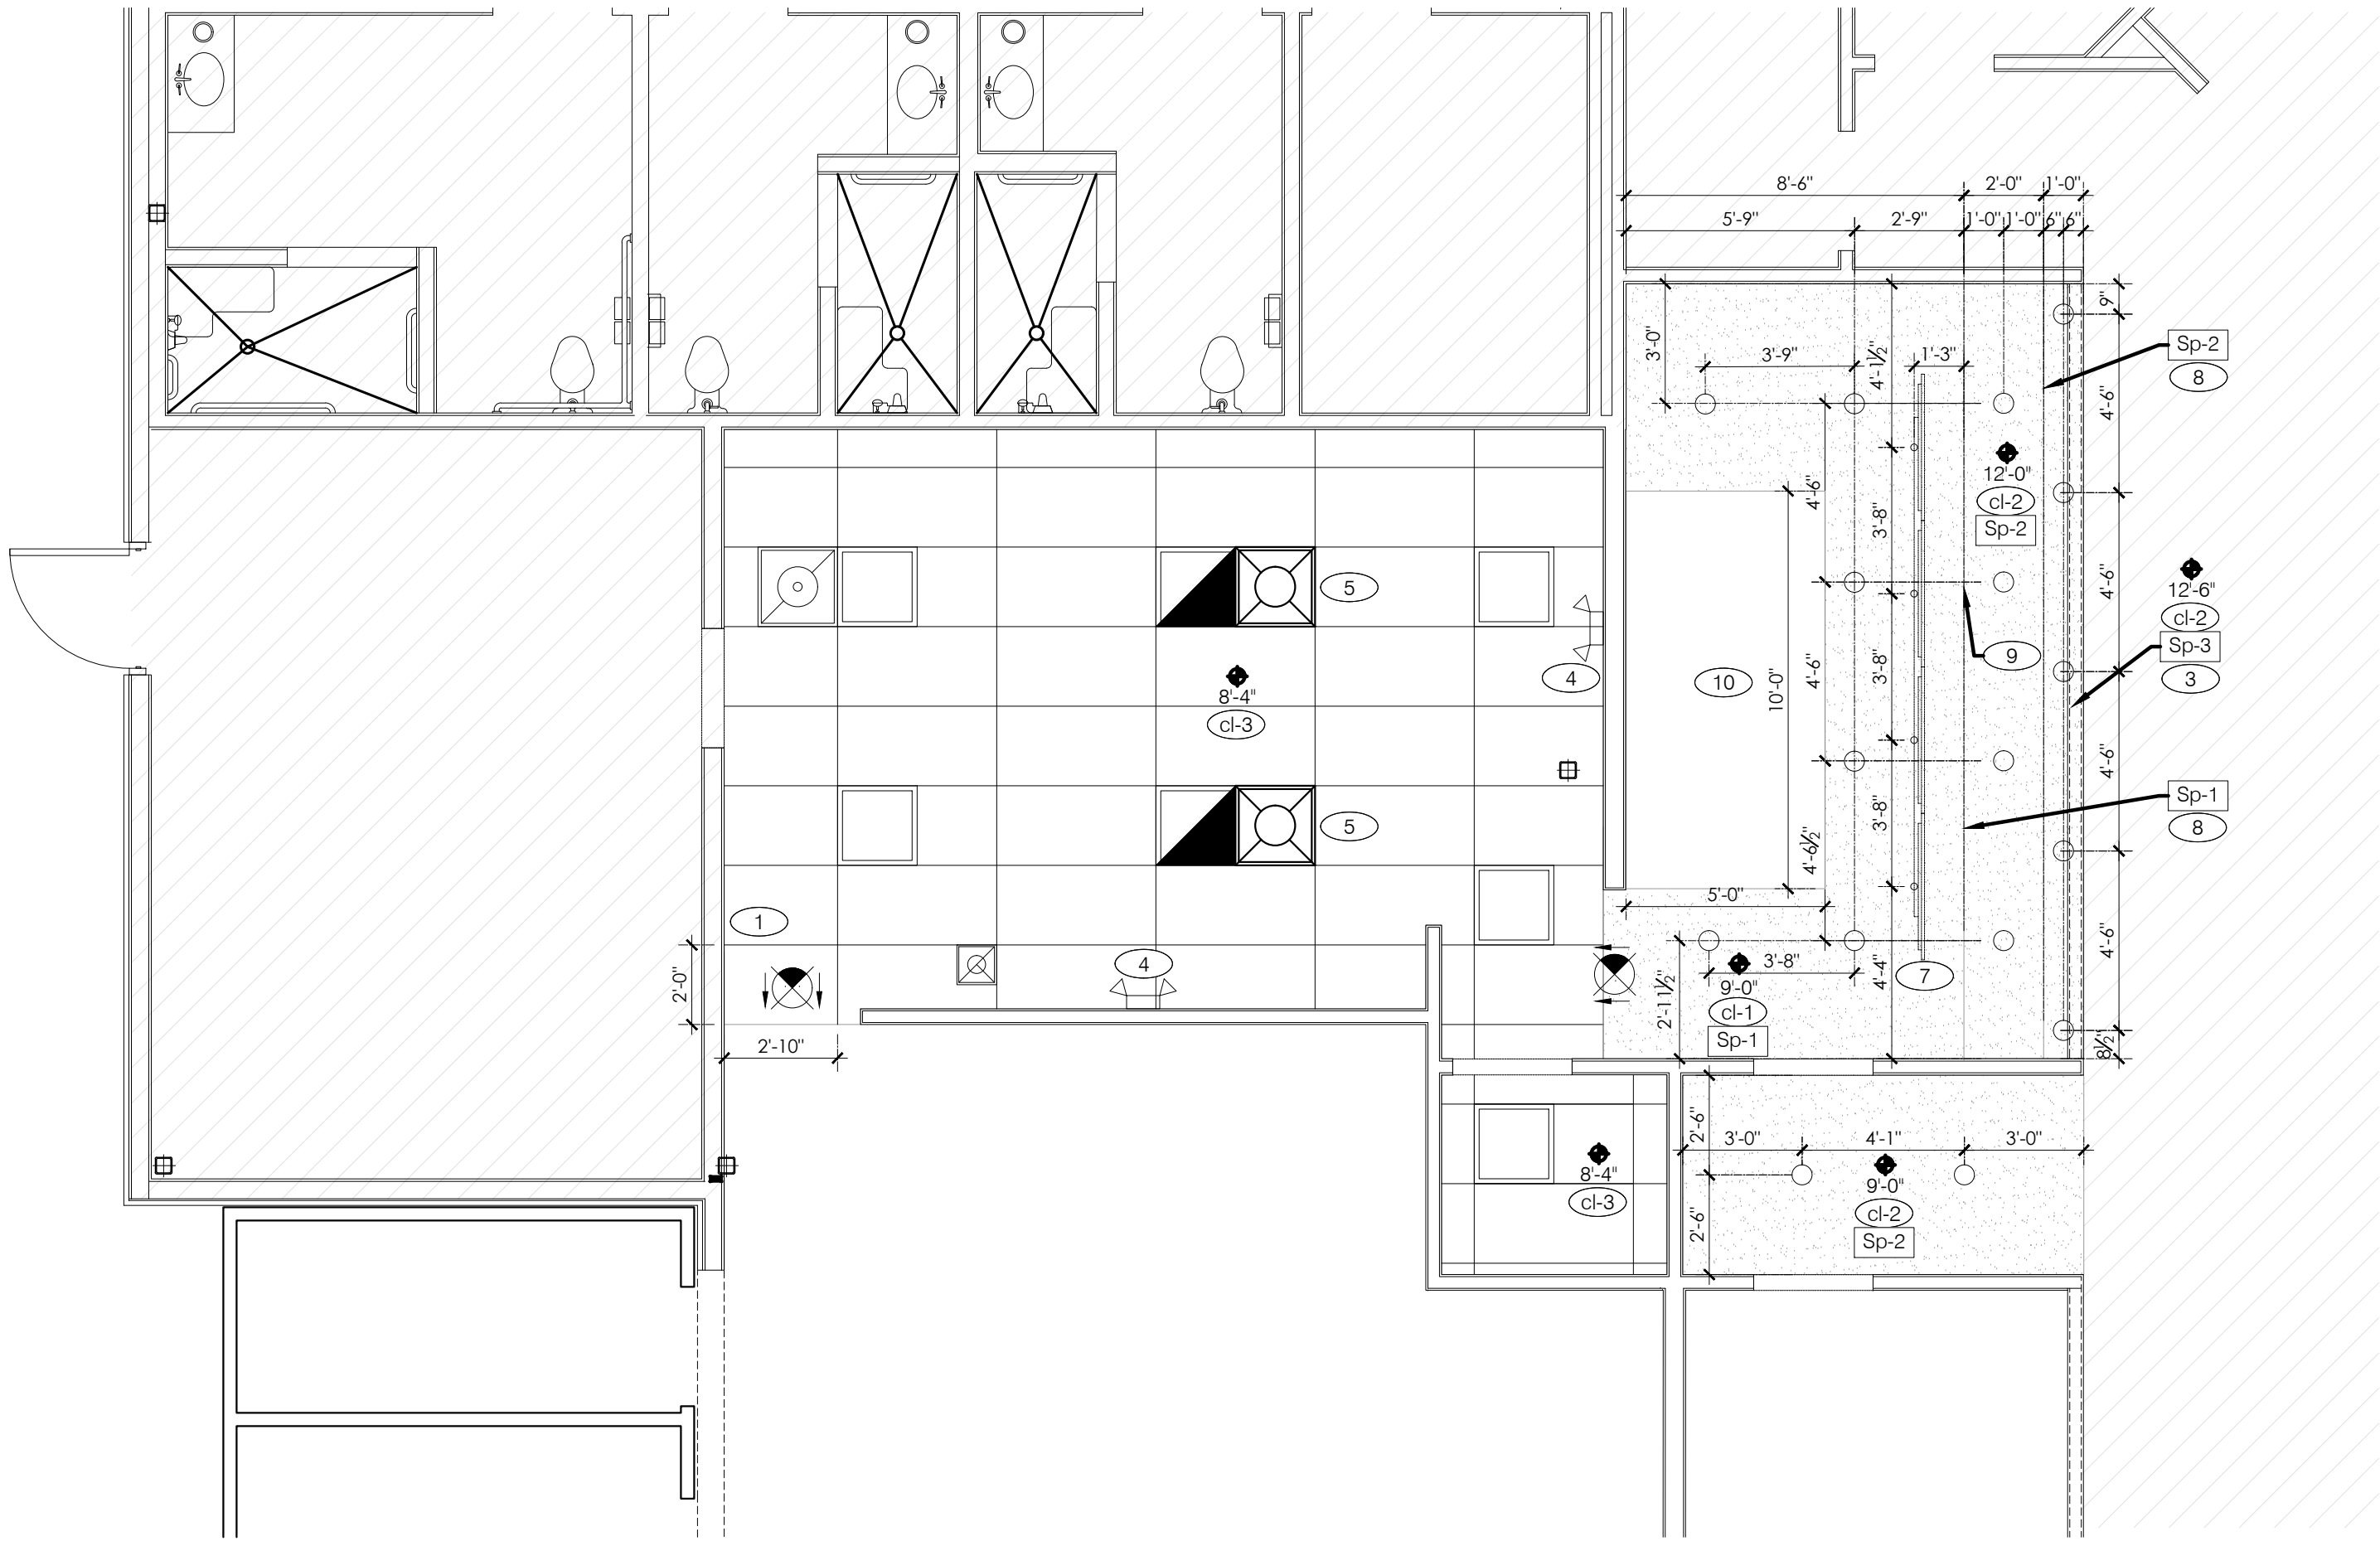

1 SBARRO REFLECTIVE CEILING PLAN
A112 SCALE: 1/4" = 1'-0"

CEILINGS			ANY SUBSTITUTIONS MUST BE APPROVED EQUAL		SYMBOL LEGEND		REFLECTED CEILING PLAN NOTES		KEY NOTES	
cl-2	MFR.: TYPE: COLOR: NOTE:	GYPSUM BOARD 1/2" THICK PER PLAN OVER 2x FRAMING AT 24" O.C. COORDINATE FRAMING WITH MECHANICAL AND ELECTRICAL FIXTURES.				2'-0" x 2'-0" LED LIGHT FIXTURE		HVAC RETURN GRILLE (SEE MECH. DRAWINGS FOR FINAL LOCATIONS)	DIMENSIONS: A. ALL DIMENSIONS ARE FROM FACE OF FINISH WALL TO C OF FIXTURES; U.O.N. SUSPENDED CEILING: A. ACOUSTICAL PANEL INSTALLATION: INSTALL ACOUSTICAL PANELS WITH EDGES IN CLOSE CONTACT WITH METAL SUPPORTS AND IN TRUE ALIGNMENT. B. ALLOWABLE VARIATIONS FROM FLAT AND LEVEL SURFACE: 1/8" IN 10'-0" MAX. C. ALLOWABLE VARIATIONS FROM PLUMB OF GRID MEMBERS: AS CAUSED BY ECCENTRIC LOADS, 2" MAX. D. INSTALL SYSTEM AFTER MAJOR ABOVE CLG. WORK IS COMPLETE. COORD LOCATIONS OF HANGERS WITH RELATED WORK. E. SEE MANUFACTURER'S SPECIFICATIONS FOR ADDITIONAL INFORMATION. GYPSUM BOARD CEILING: A. SUBSTRATE SHALL BE 1/2" THICK GYP BD. ELECTRICAL: A. SEE ELECT. DWGS. FOR FIXTURE SCHED. GENERAL NOTES: A. PROVIDE ESCUTCHEON PLATES AND SEALANT AT ALL PENETRATIONS INTO WALLS, CEILINGS, AND FLOORS. DO NOT USE CAULKS OR EXPANDING FOAM FOR SEALANT.	1 CEILING GRID STARTING POINT, TO CONTINUE FORM ADJACENT CEILING GRID. 2 SEE ELECTRICAL SHEETS 3 BOTTOM OF SOFFIT. 4 EMERGENCY LIGHT. SEE ELECTRICAL DRAWINGS. 5 REFER TO MECHANICAL PLAN FOR DIFFUSER LOCATIONS 6 DOWN LIGHT IN FRONT OUT HOUSE, TYP. CENTER FIXTURE ON GRID. SEE ELECTRICAL DRAWINGS. 7 MENUBOARD LOCATION, SOFFIT MOUNTED. 8 SIDE OF SOFFIT, SEE INT. ELEVATIONS FOR REFERENCE. 9 SIGNAGE PER ELEVATIONS. 10 REFER TO MECHANICAL PLAN FOR HOOD SPEC, SIZING AND LOCATION.
cl-3	MFR.: TYPE: COLOR: GRID: NOTE:	ARMSTRONG: ULTIMA HEALTH ZONE #1938 24" x 48" x 3/4" WHITE PRELUDE 1 STANDARD DUTY LOAD - WHITE EXPOSED TEE FLAME SPREAD RATING 0-25, CLASS A				EMERGENCY LIGHTS		HVAC SUPPLY DIFFUSER (SEE MECH. DRAWINGS FOR FINAL LOCATIONS)		
PAINT			PAINT SUBSTITUTIONS WILL NOT BE ACCEPTED.			EXIT LIGHT (WALL MOUNTED)		HVAC SUPPLY DIFFUSER (SEE MECH. DRAWINGS FOR FINAL LOCATIONS)		
Sp-1	MFR.: TYPE: COLOR: LOCATION: NOTE:	BENJAMIN MOORE PRECATALYZED EPOXY RUBY RED 2001-10 FRONT OF HOUSE SOFFIT COLOR PREVIEW COLLECTION				EXIT LIGHT (CEILING MOUNTED)		BATTERY BACKUP CEILING FIXTURE		
Sp-2	MFR.: TYPE: COLOR: LOCATION: NOTE:	BENJAMIN MOORE PRECATALYZED EPOXY SNOWFALL WHITE OC-118 FRONT OF HOUSE SOFFIT OFF WHITE COLLECTION				EXIT LIGHT/EM LIGHT (WALL MOUNTED)		DOWNLIGHT		
Sp-3	MFR.: TYPE: COLOR: LOCATION: NOTE:	BENJAMIN MOORE PRECATALYZED EPOXY MIDNIGHT DREAM FRONT OF HOUSE SOFFIT COLOR PREVIEW COLLECTION				EXTERIOR WALL FIXTURE				
						SPEAKER (COLORS: SB=BLACK, SW=WHITE)				
						12' EXHAUST FAN				

ARCHITECT OF RECORD:

THOMAS E. MORGAN, JR.
ARCHITECT

423 FISCHER TRAIL
ELLIJAY, GEORGIA 30540

SEAL:



3450 Acworth Due West Road
Building 100, Suite 120
Kennesaw, Georgia 30144
P. 770-917-9172
F. 770-917-9470
www.mrpdesign.com

RELEASED FOR
CONSTRUCTION

ISSUES / REVISIONS:

DATE	DESCRIPTION
01.26.28	COMPILED SET RELEASED FOR CONSTRUCTION

DRAWN BY:

CHKD BY:

PROJECT DESCRIPTION:

DEVELOPMENT OF INTERIORS
CONDITIONS FOR A C-STORE IN
CORDELE, GA.

PROJECT TITLE:

CONVENIENCE STORE
379 ROCKHOUSE RD E,
CORDELE, GA 31015

SHEET TITLE:

SBARRO
REFLECTIVE CEILING
PLAN

PROJECT NO: 25049



A112

A113



PAINT			PAINT SUBSTITUTIONS WILL NOT BE ACCEPTED.		SYMBOL LEGEND		REFLECTED CEILING PLAN NOTES		KEY NOTES	
DESCRIPTION			ALTERNATE / NOTE							
p-6	MFR.: TYPE: COLOR: LOCATION: NOTE:	BENJAMIN MOORE PRECATALYZED EPOXY WEDDING VEIL 2125-70 DINING ROOM HORIZ. PLANKS, CEILINGS EGGSHELL (V342)	ALTERNATE FOR P-6: SCUFF - X EGGSHELL #487				HVAC RETURN GRILLE (SEE MECH. DRAWINGS FOR FINAL LOCATIONS)		① CEILING GRID STARTING POINT.	
WALL TILE			ANY SUBSTITUTIONS MUST BE APPROVED EQUAL.				EMERGENCY LIGHTS		② NOT USED.	
wt-3	MFR.: TYPE: COLOR: SIZE: GROUT:	DALTILE COLOR WHEEL LINEAR (GLAZED) K711 MATTE BLACK 4" x 8" x 3/8" MAPEI #10 BLACK					EXIT LIGHT (WALL MOUNTED)		③ SYRUP / FILTERED WATER TUBE BUNDLES FOR DRINK SYSTEM. SEE DETAILS 1 and 6 / A6.1. SEE RESPONSIBILITIES SCHEDULE ON SHEET T1.1	
CEILINGS			ANY SUBSTITUTIONS MUST BE APPROVED EQUAL.				EXIT LIGHT (CEILING MOUNTED)		④ 6" DIA PVC STUB THROUGH CEILING. SEE DETAIL 4 / A401.1	
cl-1a	MFR.: TYPE: COLOR: GRID: NOTE:	ARMSTRONG: FINE FISSURED #1728BL 24" x 24" x 3/4" TECH BLACK PRELUDE 1 STANDARD DUTY LOAD - #6362BL BLACK EXPOSED TEE FLAME SPREAD RATING 0-25, CLASS A					EXIT LIGHT/EM LIGHT (WALL MOUNTED)		⑤ SEE ELECTRICAL SHEETS	
cl-3	MFR.: TYPE: COLOR: GRID: NOTE:	ARMSTRONG: ULTIMA HEALTH ZONE #1938 24" x 48" x 3/4" WHITE PRELUDE 1 STANDARD DUTY LOAD - WHITE EXPOSED TEE FLAME SPREAD RATING 0-25, CLASS A					EXTERIOR WALL FIXTURE		⑥ SEE AIR DEVICE SCHEDULE FOR ROUGH FRAMING OPENINGS (TYP. AT RESTROOMS).	
							SPEAKER (COLORS: SB=BLACK, SW=WHITE)		⑦ DECORATIVE PENDANT LIGHT CENTERED OVER TABLE, HT. 5'-6" A.F.F. TO BOTTOM OF FIXTURE. SEE ELECTRICAL DRAWINGS.	
							12" EXHAUST FAN		⑧ BOTTOM OF ORDER AREA BULKHEAD AT 8'-6" A.F.F. SEE DETAIL 1/A401.1	
									⑨ EXTERIOR WALL LIGHT FIXTURE. SEE ELEVATIONS AND ELECT. DWGS.	
									⑩ BOTTOM OF SOFFIT.	
									⑪ EMERGENCY LIGHT. SEE ELECTRICAL DRAWINGS.	
									⑫ REFER TO MECHANICAL PLAN FOR DIFFUSER LOCATIONS IN DINING ROOM.	
									⑬ DOWN LIGHT IN DINING ROOM, TYP. CENTER FIXTURE ON GRID. SEE ELECTRICAL DRAWINGS.	
									⑭ 6" X 6" STAINLESS STEEL CHASE ALONG WALL FOR ICE MACHINE REFRIGERANT LINES: CEILING TO TOP OF ICE MACHINE, BY GENERAL CONTRACTOR.	
									⑮ 6" X 6" STAINLESS STEEL CHASE ALONG WALL FOR SYRUP / FILTERED WATER TUBE BUNDLES.	

THESE PLANS ARE THE PROPERTY OF MRP DESIGN GROUP, INC. AND ARE SUBJECT TO FEDERAL COPYRIGHT LAWS. ANY USE OF SAME WITHOUT THE EXPRESS WRITTEN PERMISSION OF MRP DESIGN GROUP, INC. IS STRICTLY PROHIBITED.

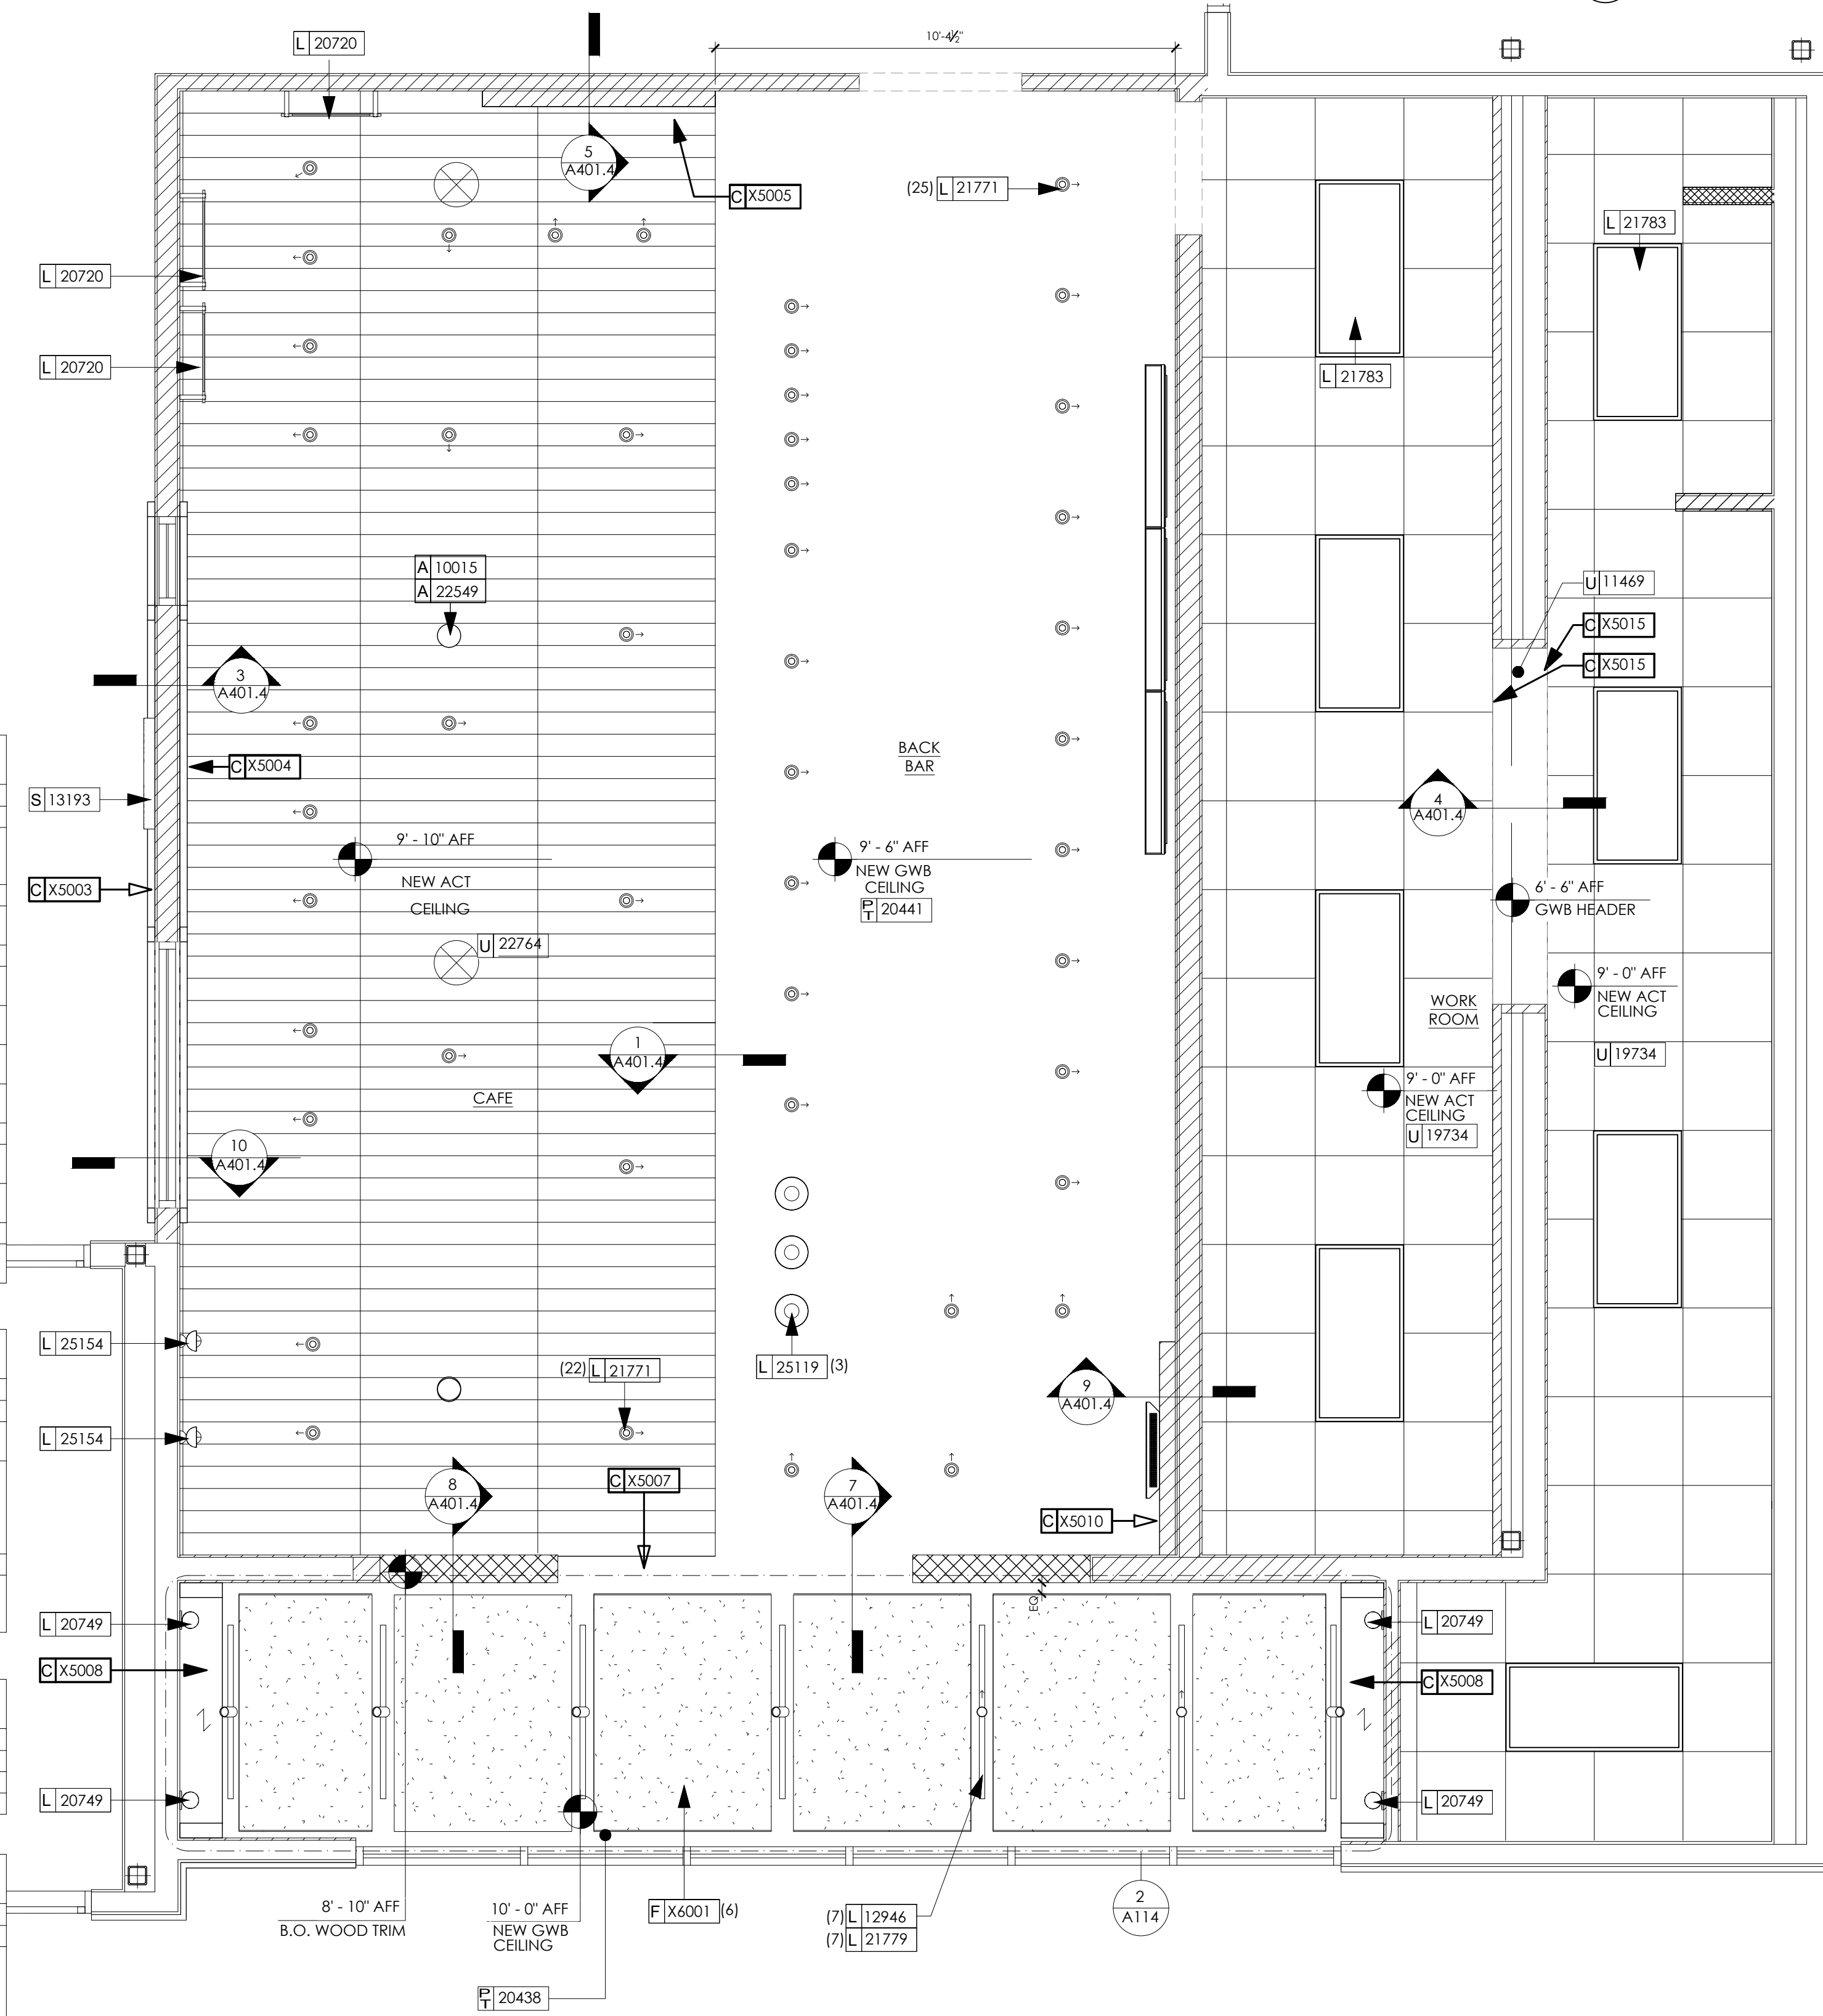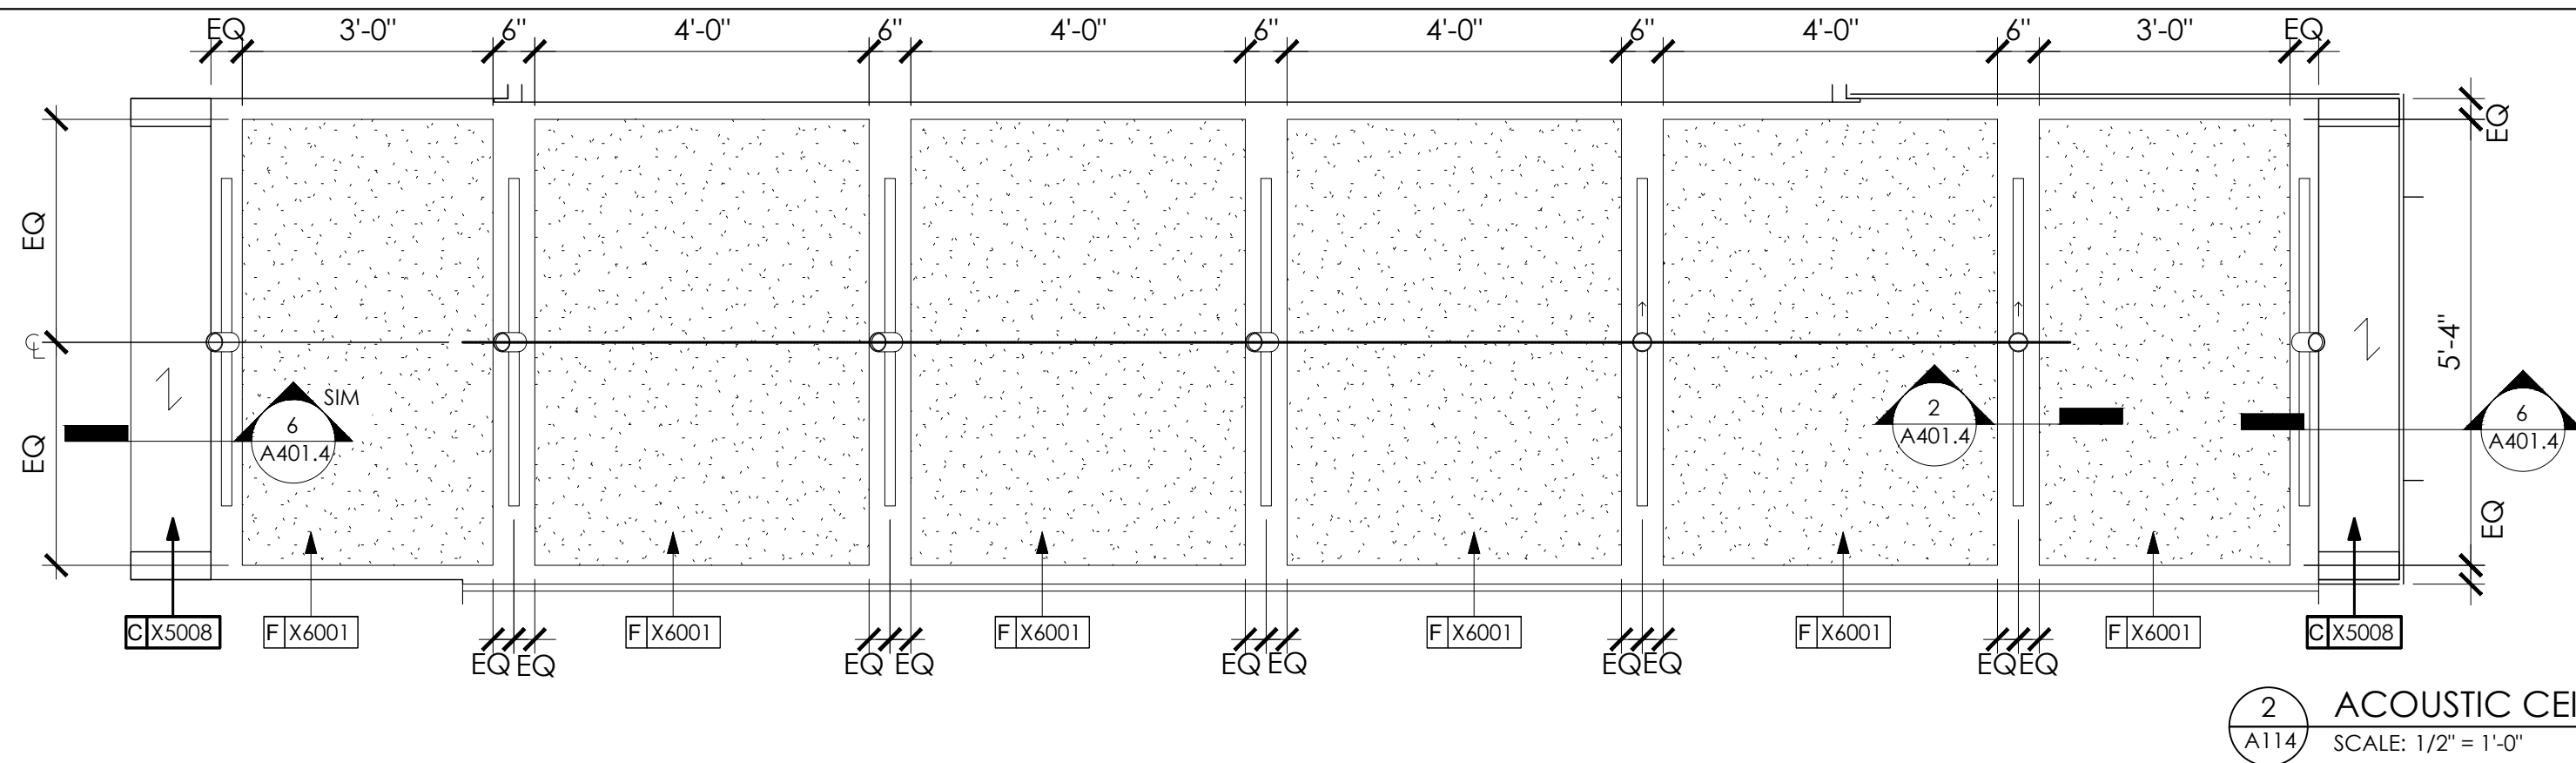

DESIGN ID	COUNT	DESCRIPTION	FURN. BY	INST. BY	BULB	COMMENTS
PENDANT						
25119	3	PENDANT - CALDERA 9IN - NATURAL BRASS	S8	GC	AS PACKAGED: 1X LED G25 6.5W (DOWN); 1X LED A15 4.5W [UF]	SUPPLIER: DOLAN HOSPITALITY. DROP LENGTH: 2'-8"
RECESSED CAN						
21771	47	CAN - LED ADJUSTABLE RECESSED - 3IN 75MM - BLACK - 800LM FLOOD	S8	GC	INTEGRATED LED	
SCONCE						
15336	3	SCONCE - MESH CYLINDER MINI - BRONZE	S8	GC	(1) LED 400LM 2700K (INCLUDED), OR EQUAL	
20720	3	SCONCE - JUNIPER THIN - 24IN 610MM - SATIN BRASS	S8	GC	INTEGRATED LED	
20749	4	SCONCE - KUZCO PLUTO SINGLE - VINTAGE BRASS	S8	GC	AS PACKAGED: 1X LED G16 5W E26 BASE	(2) FROM EXCESS INVENTORY
25154	2	SCONCE - NATHAN - AGED BRASS	S8	GC	AS PACKAGED: 1X LED A19 7W E26 BASE	SUPPLIER: DOLAN HOSPITALITY
TRACK						
12946	7	TRACK - WITH CONNECTORS - 4FT 122CM - BLACK - 1 CIRCUIT	S8	GC		
21779	7	TRACK - LED FIXTURE WITH SNOOT - 3IN 75MM - BLACK - 1100LM FLOOD	S8	GC	INTEGRATED LED	
TROFFER						
21783	8	TROFFER - LED RECESSED - 24X48IN 600X1200MM - WHITE - 4300LM	GC	GC	INTEGRATED LED	

CEILING TREATMENT SCHEDULE - "U"					
DESIGN ID	AREA	DESCRIPTION	FURN. BY	INST. BY	COMMENTS
19734	372 SF	ACT - ULTIMA - 2X2FT 61X61CM	GC	GC	STARBUCKS RECOMMENDATION. GC TO SOURCE LOCALLY.
22764	397 SF	ACT - CIRRUUS BEVELED SUPRAFINE PAINTED - 2X4FT 61X122CM	GC	GC	CUSTOM COLOR. FACTORY FINISH: SW7032 WARM STONE; FOR ORDERING CONTACT DEB PICKENS AT DLPICKENS@ARMSTRONGCEILINGS.COM, PH: 480-695-9053. LONG LEAD ITEM
PLASTIC					
11469	8 SF	FRP - WHITE	GC	GC	VERIFY TOTAL QUANTITY WITH CEILING TREATMENT AND WALL TREATMENT SCHEDULES

PAINT SCHEDULE					
DESIGN ID	DESCRIPTION	LRV	FURN. BY	INST. BY	COMMENTS
20438	SW7020 BLACK FOX	8	GC	GC	
20441	SW7031 MEGA GREIGE	37	GC	GC	
X9000	BLACK TO MATCH STOREFRONT SYSTEM		GC	GC	

ACOUSTIC CEILING PANEL SCHEDULE - "F"					
DESIGN ID	COUNT	DESCRIPTION	FURN. BY	INST. BY	COMMENTS
OTHER					
X6001	6	ACOUSTICAL CEILING PANEL - 48" X 96" X 1" - COLOR: CHESTNUT	GC	GC	SEE RCP FOR LOCATION. CUT TO FIT IN FIELD; SEE DETAILS, MFR: F-SORB. SECURE TO CEILING WITH HAT CHANNEL LONG LEAD ITEM.

- ## KEYED NOTES
1. GWB SOFFIT WITH SMOOTH FINISH (PAINT AS SCHEDULED)
 2. WASHABLE CEILING TILE LOCATED IN BACK OF HOUSE.
 3. CEILING GRID INSTALLATION START POINT WHERE INDICATED.
 4. SURFACE MOUNT LIGHT TRACK DIRECTLY TO CEILING/SOFFIT.
 5. ADJUST FOCUS OF ALL TRACK LIGHTING AND RECESSED DIRECTIONAL LIGHTING TO FULLY ILLUMINATE MENU BOARDS, MERCHANDISE BAYS, AND ARTWORK.

- A. IF PROVIDED BY LOCAL CODE, GENERAL CONTRACTOR TO REQUIRE SMO-RECESSED SPRINKLER HEADS WITH GLASS THERMOSTATIC ELEMENTS TO BE INSTALLED IN ACoustICAL CEILING TILES. IF PENDANT HEADS ARE PROVIDED IN GWS SOFFIT OVER FRONTBAR, CONCEAL, SUPPLY PIPING WITHIN SOFFIT.
- B. GENERAL CONTRACTOR TO PROVIDE AND INSTALL SPRINKLERS PER APPROVED PLAN AND LOCAL CODE. GENERAL CONTRACTOR TO ARCHITECT OF RECORD AND STAIRBUILTCS PROJECT DEVELOPMENT MANAGER IF DESIGN INTENT IS AFFECTED.
- C. LEAVE TEN (10) ADDITIONAL RETAIL CEILING TILES TO MATCH. RETAIL CEILING PANT COLOR ABOVE THE WORK AREA TO MATCH RETAIL CEILING PANT COLOR.
- D. PROVIDE GROMMET AT ACoustICAL CEILING TILE PENETRATIONS FOR FIXTURES OR SUPPORTS.
- E. HEATING, VENTILATING AND AIR CONDITIONING (HVAC) SHOWN ON THIS PLAN PROVIDED FOR REFERENCE ONLY. ACTUAL DUCTWORK AND CEILING DIFFUSER LOCATIONS TO BE DETERMINED BY ARCHITECT OF RECORD. NOTIFY NOTICED PARTY FOR PIPING, PIPING, AND CEILING LIGHT FIXTURES AS SHOWN ON THIS PLAN. NOTIFY STAIRBUILTCS DESIGN MANAGER OF ANY CONFLICTS.
- F. DIFFUSERS AND RETURNS IN ACoustICAL CEILING TO BE CENTERED IN TILE. UNLESS NOTED OTHERWISE.
- G. PAINT ALL EXPOSED HVAC DUCTS, HVAC DIFFUSERS, AND RETURNS TO MATCH EXISTING PIPING, PIPING, AND CEILING JUNCTION BOXES THE SAME COLOR AS LIGHTED SURROUNDING CEILING OR SOFFIT UNLESS NOTED OTHERWISE. THRUOUT, THRUOUT RETAIL AREA OF WORK.
- H. PAINT ALL EXPOSED WORK AREAS ARE NOT ALLOWED. USE STAIRBUILTCS NATIONAL SHERRIN WILLIAMS ACCOUNT ("COLORS" NUMBER WHEN ORDERING PAINTS).
- I. ARCHITECT OF RECORD TO SPECIFY AND LOCATE EMERGENCY LIGHTS AND EXIT SIGNS AS REQUIRED BY CODE. FIXTURES TO BE SUPPLIED AND INSTALLED BY GENERAL CONTRACTOR.
- J. ARCHITECT OF RECORD TO PROVIDE CEILING AND CEILING DETAIL SCHEDULES AS REQUIRED.
- K. BALLAST BOXES, TRANSFORMERS, JUNCTION BOXES, AND WIRING FOR ALL LIGHT FIXTURES TO BE INSTALLED SO AS TO BE HIDDEN FROM VIEW.

- ## LEGEND
- | | |
|---|-------------------------------|
|  | ELEVATION DATUM |
|  | TRACK LIGHTING |
|  | PENDANT LIGHT |
|  | ADJUSTABLE RECESSED CAN LIGHT |
|  | TROFFER |
|  | WALL SCONCE |

- ## LICENSED STORES
- ### RESPONSIBILITY LEGEND
-
- | |
|------------------------------------|
| SB - STARBUCKS |
| FC - STARBUCKS FIXTURE CONTRACTOR |
| LC - LICENSEE |
| GC - LICENSEE'S GENERAL CONTRACTOR |

1 STARBUCKS REFLECTIVE CEILING PLAN
A114 SCALE: 3/8" = 1'-0"

ARCHITECT OF RECORD:

THOMAS E. MORGAN, JR.
ARCHITECT

423 FISCHER TRAIL
ELLIJAY, GEORGIA 30540

SEAL:



450 Acworth Due West Road
Building 100, Suite 120
Kennesaw, Georgia 30144
P. 770-917-9172
F. 770-917-9470
www.mrpdesign.com

RELEASED FOR
CONSTRUCTION

ISSUES / REVISIONS:

DATE	DESCRIPTION
28.28	COMPILED SET RELEASED FOR CONSTRUCTION

RAVN BY

HK'D BY:

PROJECT DESCRIPTION:

DEVELOPMENT OF INTERIORS CONDITIONS FOR A C-STORE IN CORDELE, GA.

PROJECT TITLE:

CONVENIENCE STORE
379 ROCKHOUSE RD E,
CORDELE, GA 31015


SHEET TITLE:

STARBUCKS REFLECTIVE CEILING PLAN

PROJECT NO: 25049

A114

THESE PLANS ARE THE PROPERTY OF MRP DESIGN GROUP, INC. AND ARE SUBJECT TO FEDERAL COPYRIGHT LAWS. ANY USE OF SAME WITHOUT THE EXPRESS WRITTEN PERMISSION OF MRP DESIGN GROUP, INC. IS STRICTLY PROHIBITED.

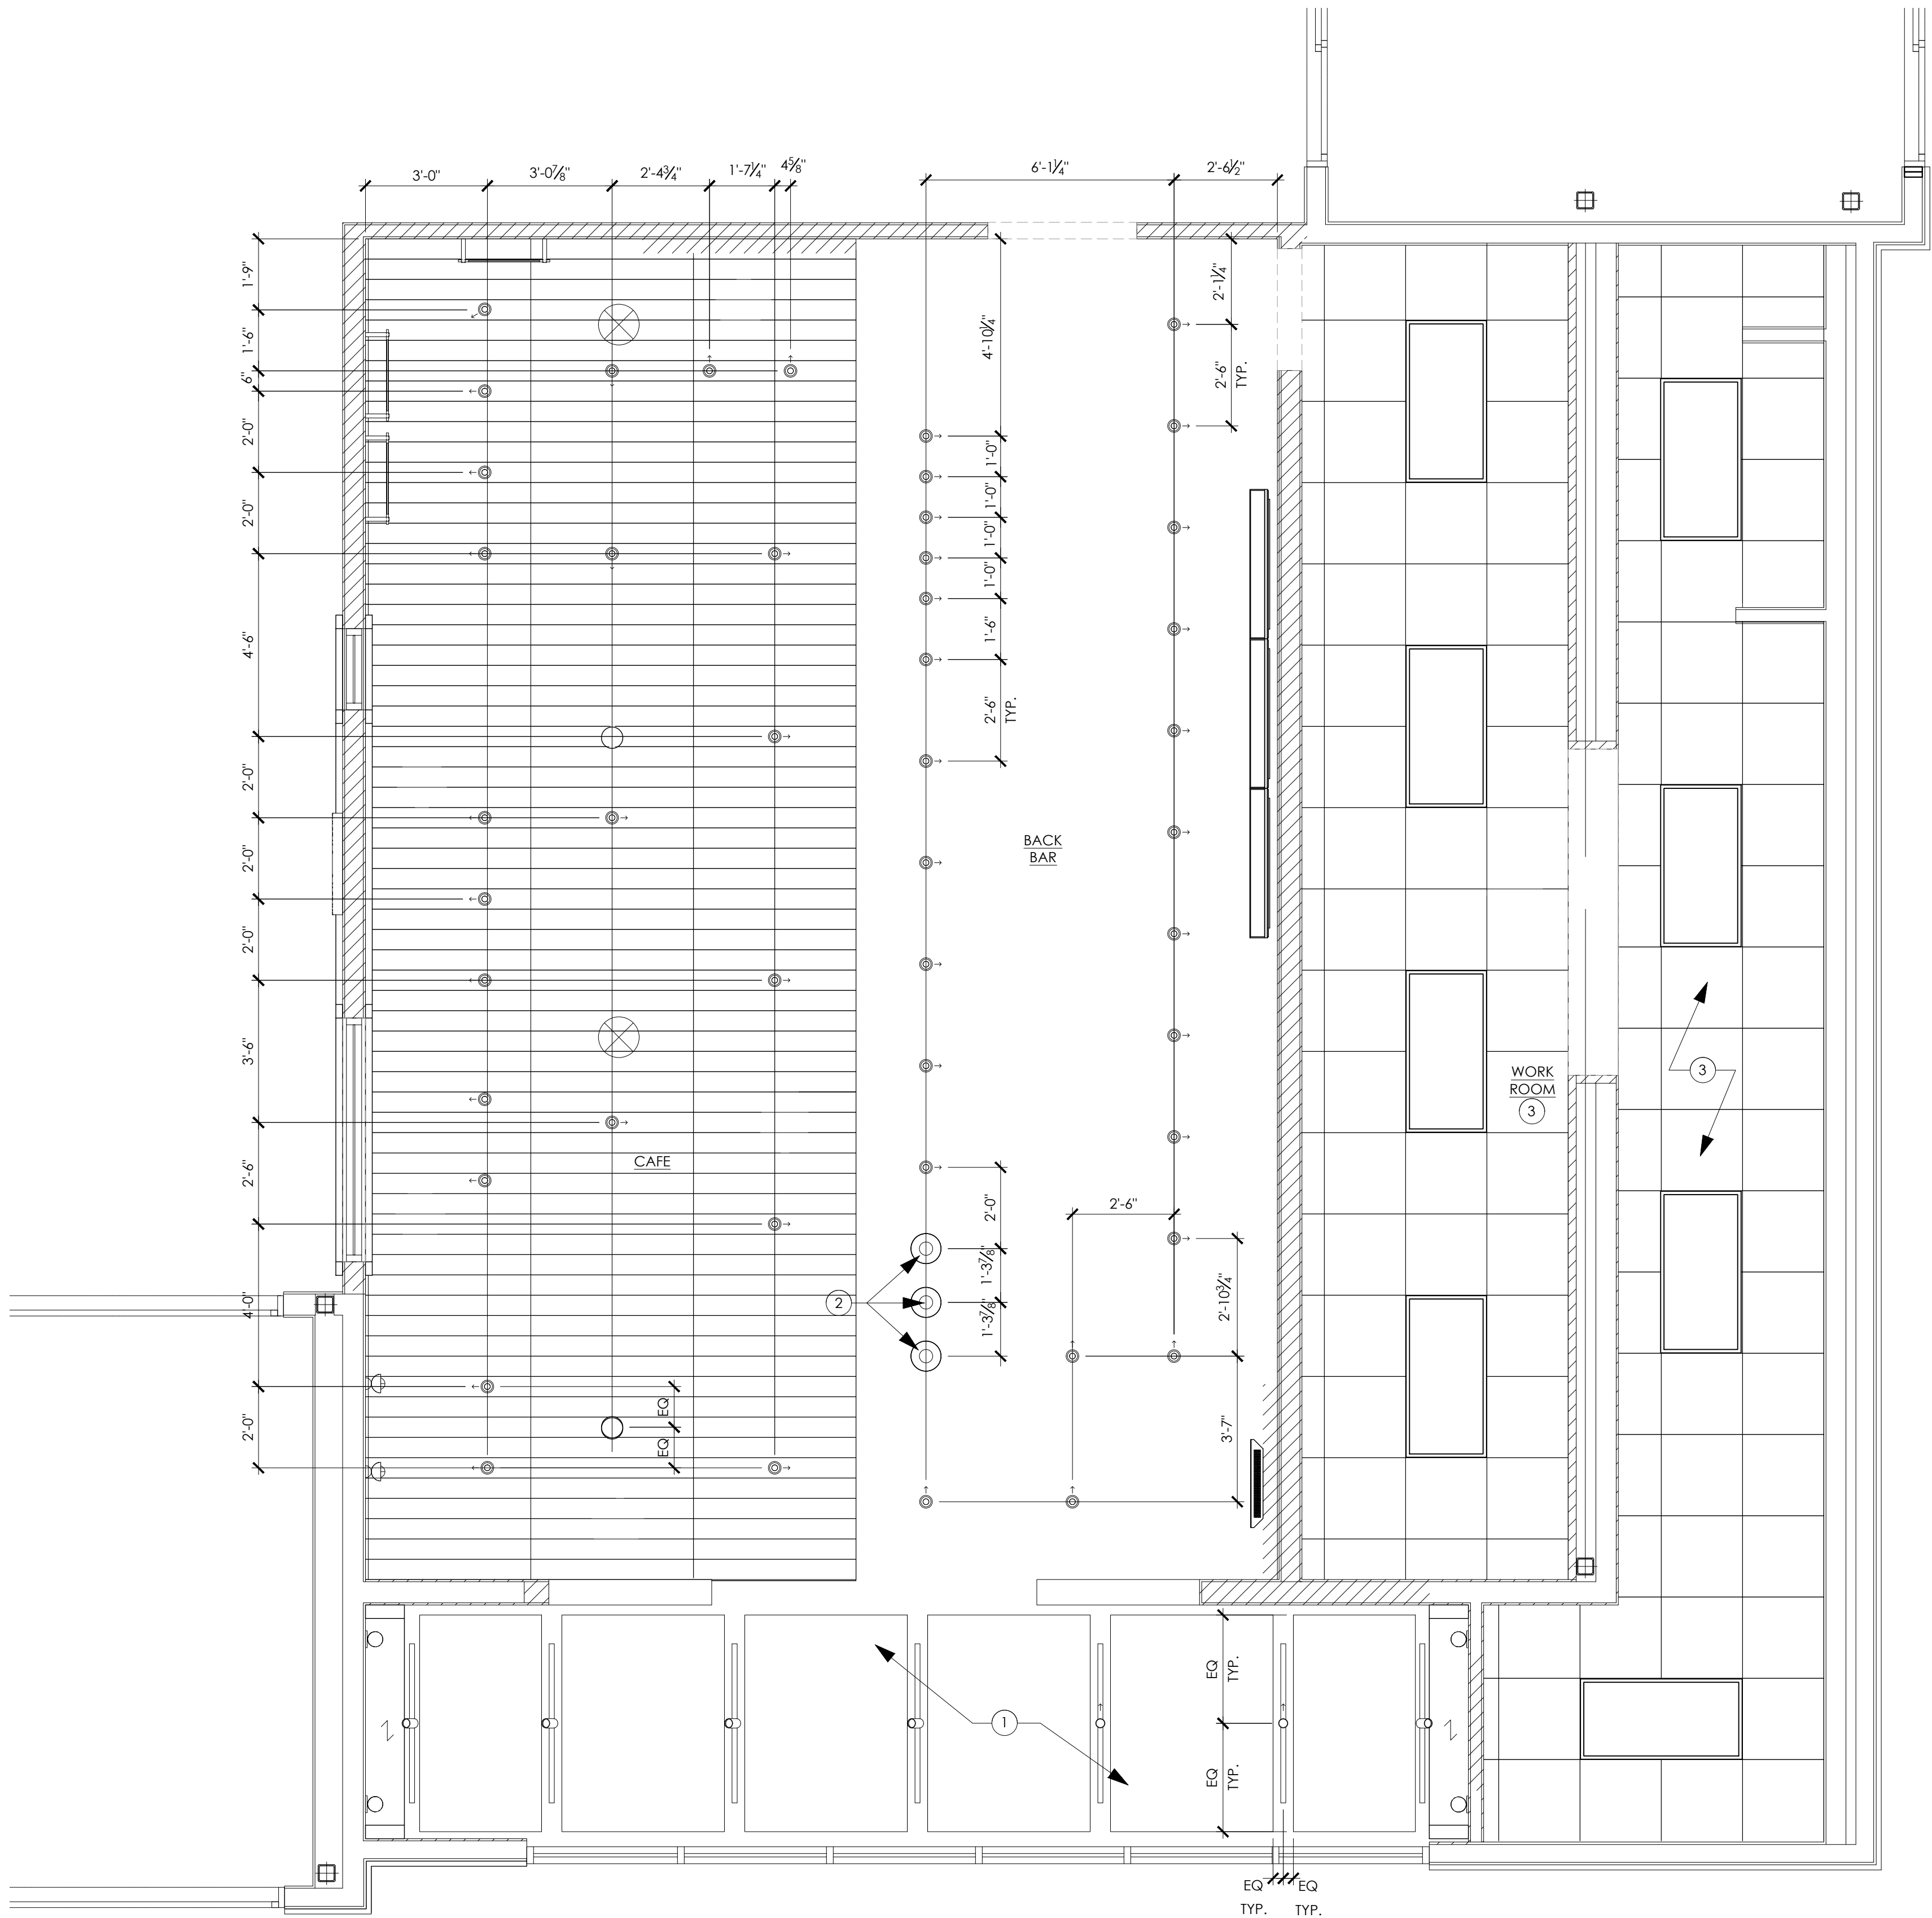

1
A115
STARBUCKS LIGHTING DIMENSION PLAN
SCALE: 3/8" = 1'-0"

KEYED NOTES

1. SURFACE MOUNT LIGHT TRACK DIRECTLY TO CEILING/SOFFIT.
2. SUSPEND BOTTOM OF PENDANT LIGHT FIXTURE AT 6'-10" AFF.
3. CENTER LIGHTS IN CEILING TILE, UNO.

GENERAL NOTES

- A. HEATING, VENTILATING AND AIR CONDITIONING (HVAC) SHOWN ON THIS PLAN PROVIDED FOR REFERENCE ONLY. ACTUAL DUCTWORK AND CEILING DIFFUSER LOCATIONS TO BE DETERMINED BY ARCHITECT OF RECORD AND ARE NOT TO INTERFERE WITH PLACEMENT OF LIGHT FIXTURES AS SHOWN ON THIS PLAN. NOTIFY STARBUCKS DESIGN MANAGER OF ANY CONFLICTS.
- B. DIFFUSERS AND RETURNS IN ACOUSTICAL CEILING TO BE CENTERED IN TILE, UNLESS OTHERWISE NOTED.
- C. ARCHITECT OF RECORD TO SPECIFY AND AND LOCATE EMERGENCY LIGHTS AND EXIT SIGNS AS REQUIRED BY CODE. FIXTURES TO BE SUPPLIED AND INSTALLED BY GENERAL CONTRACTOR.

ARCHITECT OF RECORD:

THOMAS E. MORGAN, JR.
ARCHITECT

423 FISCHER TRAIL
ELLIJAY, GEORGIA 30540

SEAL:



3450 Acworth Due West Road
Building 100, Suite 120
Kennesaw, Georgia 30144
P. 770-917-9172
F. 770-917-9470
www.mrpdesign.com

RELEASED FOR
CONSTRUCTION

ISSUES / REVISIONS:

DATE	DESCRIPTION
01.28.28	COMPILED SET RELEASED FOR CONSTRUCTION

DRAWN BY:

CHKD BY:

PROJECT DESCRIPTION:

DEVELOPMENT OF INTERIORS
CONDITIONS FOR A C-STORE IN
CORDELE, GA.

PROJECT TITLE:

CONVENIENCE STORE
379 ROCKHOUSE RD E,
CORDELE, GA 31015


SHEET TITLE:

STARBUCKS
LIGHTING
DIMENSION PLAN

PROJECT NO: 25049

A115

THESE PLANS ARE THE PROPERTY OF MRP DESIGN GROUP, INC. AND ARE SUBJECT TO FEDERAL COPYRIGHT LAWS. ANY USE OF SAME WITHOUT THE EXPRESS WRITTEN PERMISSION OF MRP DESIGN GROUP, INC. IS STRICTLY PROHIBITED

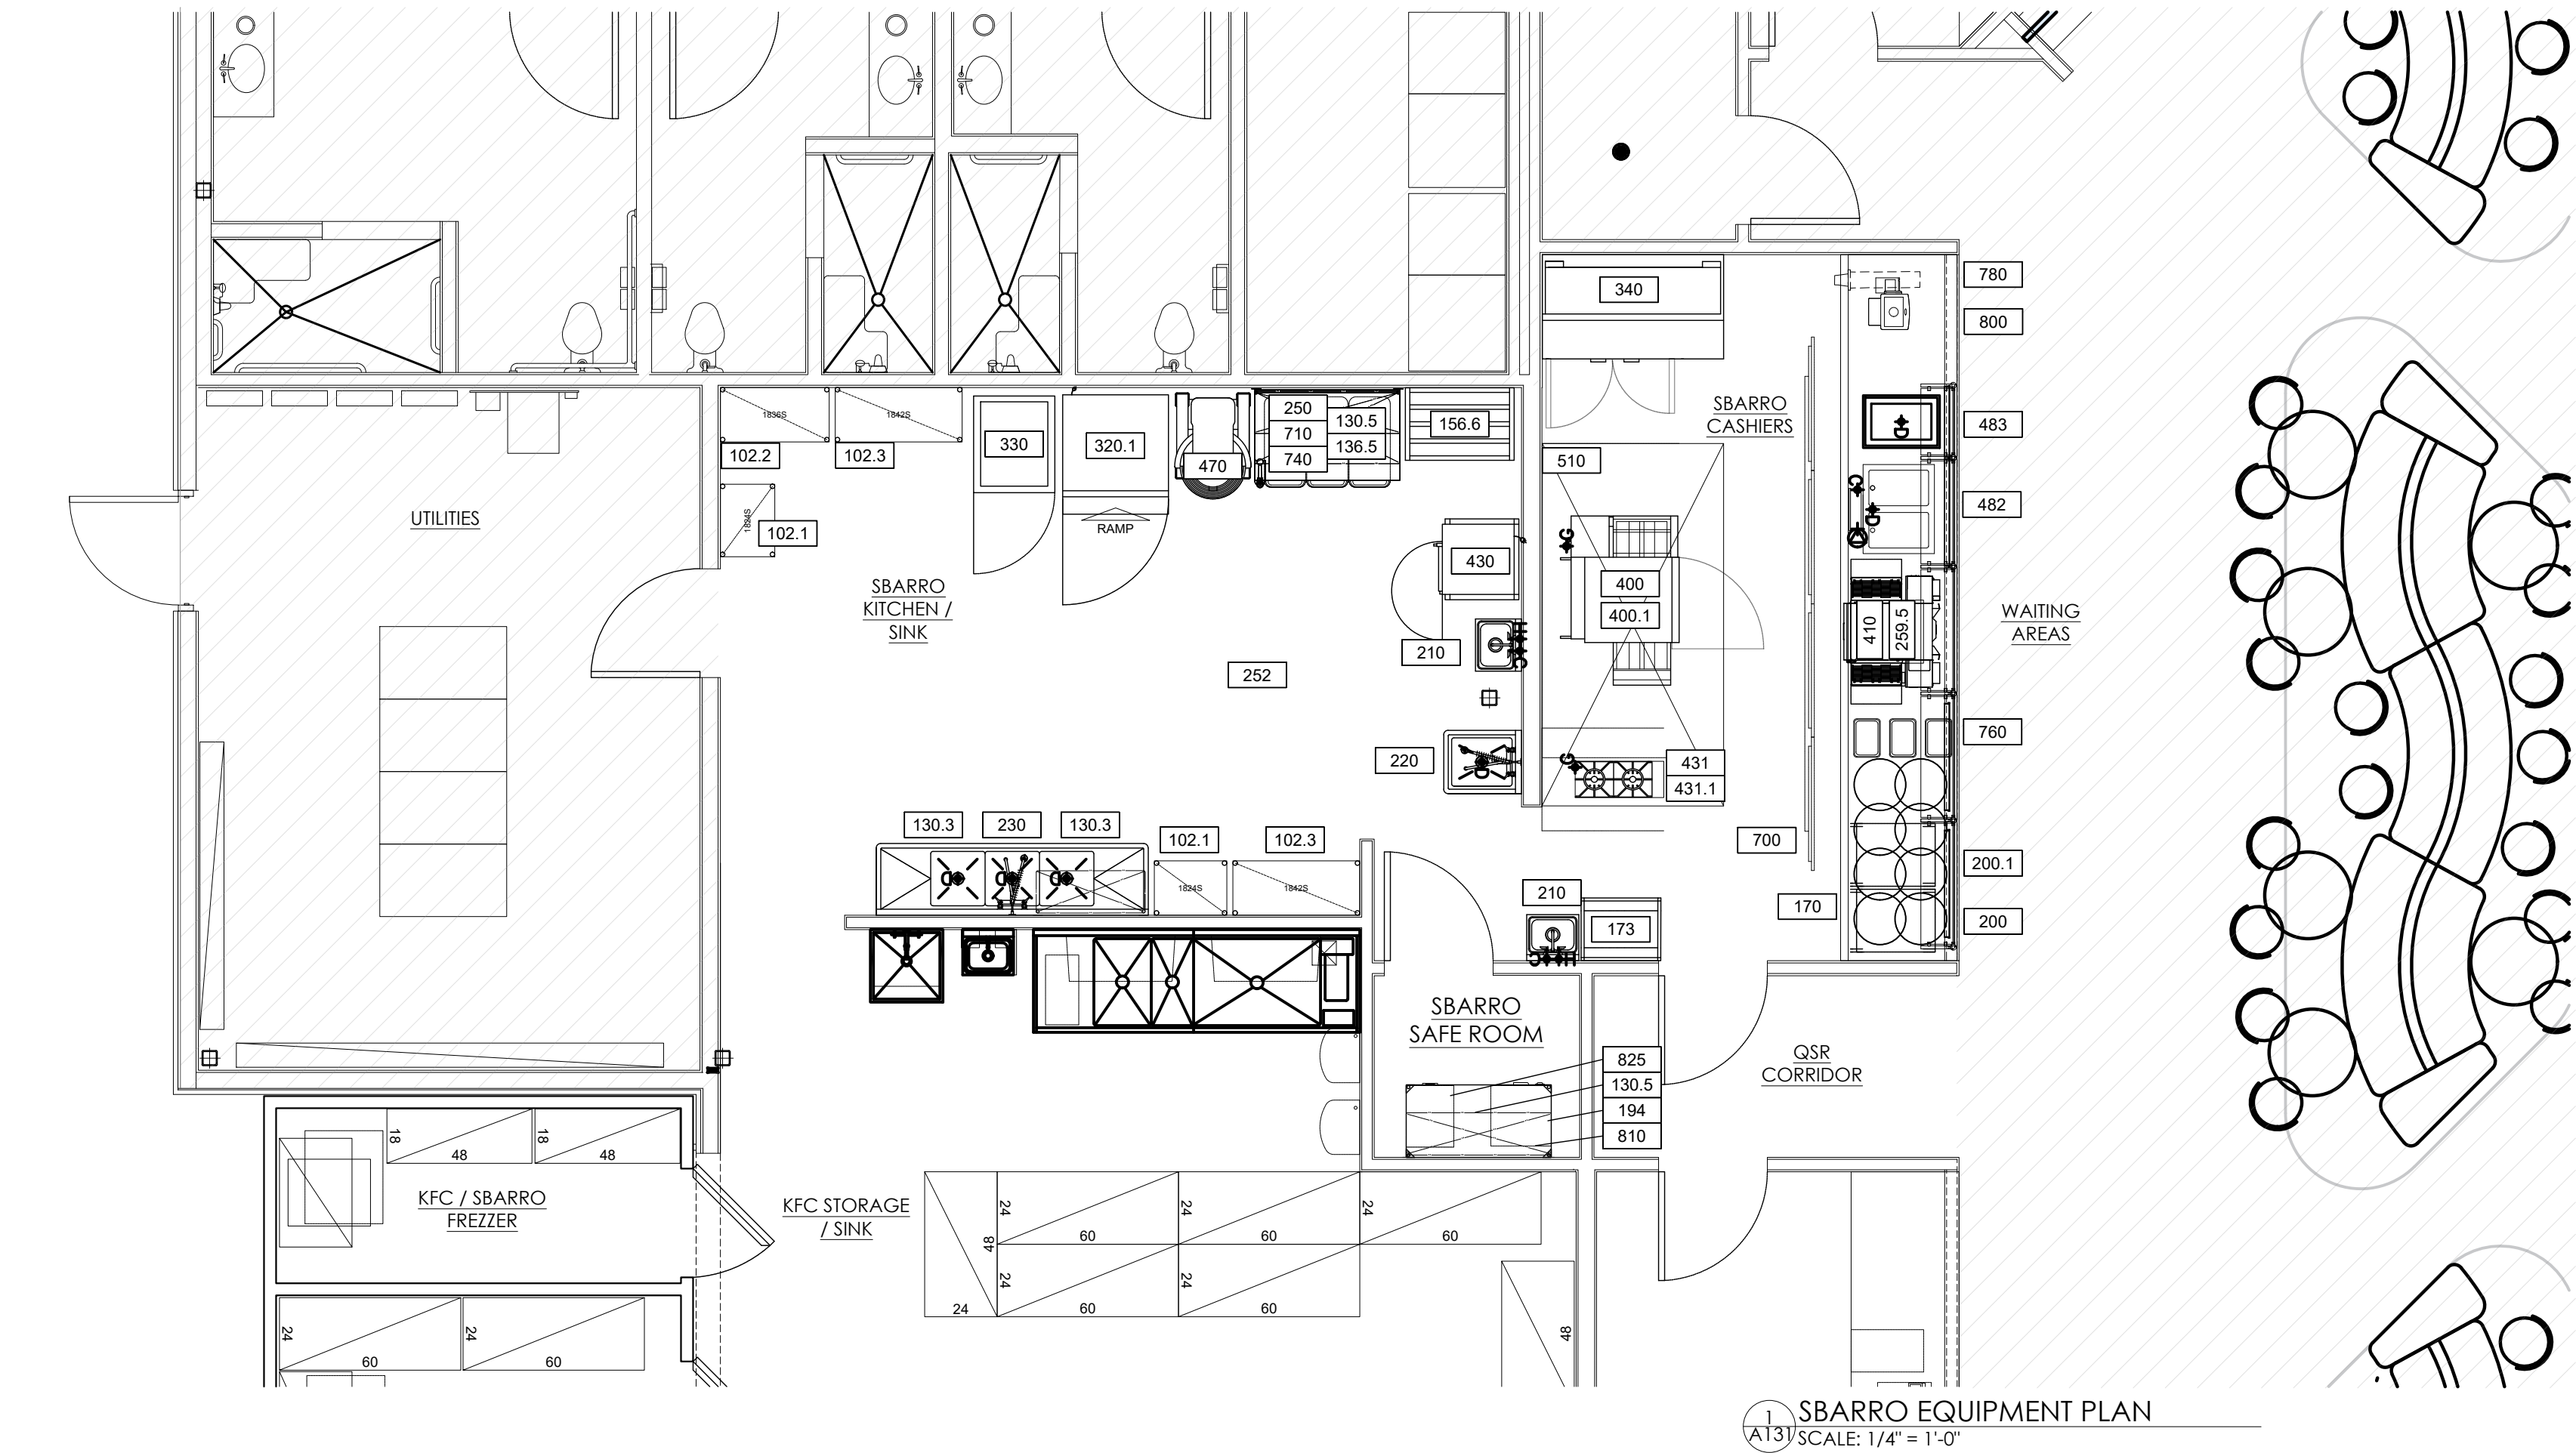

EQUIPMENT SCHEDULE										
ITEM #	QTY.	DESCRIPTION / EQUIPMENT TYPE	MANUFACTURER	MODEL NUMBER	SIZE	ELECTRICAL				REMARKS
					L X W X H	VOLT	PHASE	WATTS	AMPS	
102.1	2	DRY STORAGE WIRE SHELVING - 18"	QUANTUM FOOD SERV	(10) 1824C W/ (8) P86C	18" X 24"					
102.2	1	DRY STORAGE WIRE SHELVING - 18"	QUANTUM FOOD SERV	(5) 1836CW/ (4) P86C	18" X 36"					
102.3	2	DRY STORAGE WIRE SHELVING - 18"	QUANTUM FOOD SERV	(10) 1842PW/ (8) P86C	18" X 42"					
130.3	2	DIRECT MOUNTED WIRE SHELVING	QUANTUM FOOD SERV	1436C W/ (2) DWB14						TYPICALLY ABOVE 3 COMP SINK
130.5	2	DIRECT MOUNTED WIRE SHELVING	QUANTUM FOOD SERV	1448C W/ (2) DWB14						
136.5	1	DIRECT MOUNTED WIRE SHELVING	QUANTUM FOOD SERV	2448C W/ (2) DWB24						4' - NEAR MIXER
156.6	1	DUNNAGE RACK	CHANNEL	ADE2448	36" x 24" x 12"					
170	2	MOBILE UC BUN PAN RACK	NEW AGE INDUSTRIAL	1313						
173	1	MOBILE CUT TABLE	CHANNEL	425A/011/S	20.5" x26" x 36"					
194	1	SOLID SHELVING	METRO	(1) 2848FG W/ (4) 33P & (1) SF55A/3C	48"W x 24"D					
200	5	SNEEZE GUARD	HATCO	ED20 (42/42/42/36/24)	VARIES					
200.1	4	SNEEZE GUARD LIGHTS	HATCO	HL5 (36/36/36/24)	VARIES	120V-277V, 50/60HZ				
210	2	HAND SINK	ADVANCE TABCO	7 PS EC SP X (2)						QTY 2: 1 FOH, 1 BOH
220	1	ONE COMPARTMENT SINK	ADVANCE TABCO	(1)FC 11620 X, (1) DTA 53, (1)K 117, (1)K 5,(1)K-4	21" X 26"					DRAINBOARD: 1620-18(R OR L)
230	1	THREE (3) COMPARTMENT SINK	ADVANCE TABCO	(1)FC-31818-18RL-X, (1)DTA-53,(1)K-117,(1)K 5,(1)K-4	90" X 24"					
250	1	WORK TABLE	ADVANCE TABCO	TKMSLAG-304-X	30" X 48" W/ 5" SPLASH					FOR MIXER/DOUGH
252	1	WORK TABLE	ADVANCE TABCO	KMSLAG-244-X	24" X 48" W/ 5" SPLASH W/ SHELF					
259	1	TURBOCHEF OVEN CART	TURBOCHEF	HCT-3004-2						FOR HCS9500 AND HHC2020 (ONLY 9500 WHEN ON BACK LINE)
259.5	1	TURBOCHEF OVEN CART	TURBOCHEF	(1)NGC-1217-3, (1)TC3 0142						FOR HCS9500 WHEN ON FRONT LINE
320.1	1	SINGLE ROLL-IN REFRIGERATOR	HOSHIZAKI	RN1A-FS		115V / 60HZ	PHASE 1		6.4 AMP	ROLL-IN UNIT FOR DOUGH
330	1	SINGLE REACH-IN FREEZER	HOSHIZAKI	VF1A-FS		115V / 60HZ	PHASE 1		3.2 AMP	
340	1	REFRIGERATED PIZZA PERP	HOSHIZAKI	PR67B	67" X 33.25" X 43.25"	115V / 60HZ	PHASE 1		6 AMP	DOUBLE CHECK MODEL (PR67 TYPICAL)
400	1	CONVEYOR COOKING OVEN (GAS)	LINCOLN FOODSERVICE	1180-FB2G DOUBLE STACK GAS / KF033 SBARRO PANEL CONFIGURATION		208-240 VAC, 50/60 HZ	PHASE 3		40 AMP	1 SET, NEEDS 258 OR 259, NO HOOD
400.1	1	BLUE HOSE GAS CONNECTOR KIT	DORMONT	1675KIT48						QTY DEPENDS ON # OF UNITS
410	1	CONVEYOR RE-HEATING OVEN	TURBOCHEF	HCS-9500-23-V W/ (2)HCS 1499 JETPLATE		208-240 VAC, 50/60 HZ	PHASE 1		37 AMP	PRE-PROGRAMMED 1618, OCC. W/ 257
430	1	STEAMER, CONVECTION, BOILERLESS, COUNTERTOP	ACCUTEMP	E6 208 3D 100 00 200		208 VAC	PHASE 3		28 AMP	
430.1	1	EQUIPMENT STAND	ACCUTEMP	SNH 11 00						
431	1	HOTPLATE, COUNTERTOP, GAS	VULCAN	VCRH12-GS PLATINUM, STANDARD 24		208-240V/50-60HZ/1	PHASE 1	3500 W	17 AMP	NO HOOD REQUIRED, HIGH VOLUME STORES
431.1	1	BLUE HOSE GAS CONNECTOR KIT	DORMONT	1675KIT48						
470	1	PLANETARY MIXER	HOBART	(1)HL662-1STD,(1)V99 13,(1)TRUCK HL1484, (1)VS9HOLD SHG12,(1)VS9PL1 (1)2SH						
482	1	HOT FOOD WELL UNIT, DROP JIN, ELECTRIC	WELLS	MOD-200TDM/AF		208-240V	VARIES	1240/1650 W	VARIES	DOUBLE CHECK MODEL
483	1	COLD FOOD WELL UNIT, DROP-IN, REFRIGERATED	WELLS (MIDDLEBY)	RCP 100	25- 3⁄8" X 17- 3⁄8" X 24- 1⁄2"	115V	PHASE 1		VARIES	DOUBLE CHECK MODEL
510	1	EXHAUST HOOD SYSTEM	CAPTIVE-AIRE	CUSTOM	10'-0" X 5'-0"					OPEN GREASE PRODUCING
700	4	DIGITAL MENU BOARDS	HOWARD COMPANY INC	49UH5J H		240V, 50/60HZ				SIZE AND MOUNTS VARY BY STORE
710	1	CAN OPENER	VOLLRATH	BCO 1						
740	1	INGREDIENT BIN	WINHOLT	148PIB	31- 1⁄2" X 17" X 28- 3⁄4"					
760	1	PIZZA DISPLAY PACKAGE	WASSERSTORM	VARIES						
780	2	DISPOSABLE CUP DISPENSER	SAN JAMAR	C2410C						
800	1	POS UNIT	NCR	ALOHA CLOUD						
810	1	DROP SAFE	WILSON SAFE COMPANY	B2020S L02	20" X 20" X 20"					
820	1	OFFICE CHAIR	HON	5701						
825	1	FILING CABINET	OMCAN USA	21651	27" X 19" X 30"					

ARCHITECT OF RECORD:

THOMAS E. MORGAN, JR.
ARCHITECT

423 FISCHER TRAIL
ELLIJAY, GEORGIA 30540

SEAL:



3450 Acworth Due West Road
Building 100, Suite 120
Kennesaw, Georgia 30144
P. 770-917-9172
F. 770-917-9470
www.mrpdesign.com

RELEASED FOR
CONSTRUCTION

ISSUES / REVISIONS:

DATE	DESCRIPTION
01.26.28	COMPILED SET RELEASED FOR CONSTRUCTION

DRAWN BY:

CHKD BY:

PROJECT DESCRIPTION:

DEVELOPMENT OF INTERIORS
CONDITIONS FOR A C-STORE IN
CORDELE, GA.

PROJECT TITLE:

CONVENIENCE STORE
379 ROCKHOUSE RD E,
CORDELE, GA 31015


SHEET TITLE:

SBARRO
EQUIPMENT
PLAN

PROJECT NO: 25049

A131

THESE PLANS ARE THE PROPERTY OF MRP DESIGN GROUP, INC. AND ARE SUBJECT TO FEDERAL COPYRIGHT LAWS. ANY USE OF SAME WITHOUT THE EXPRESS WRITTEN PERMISSION OF MRP DESIGN GROUP, INC. IS STRICTLY PROHIBITED

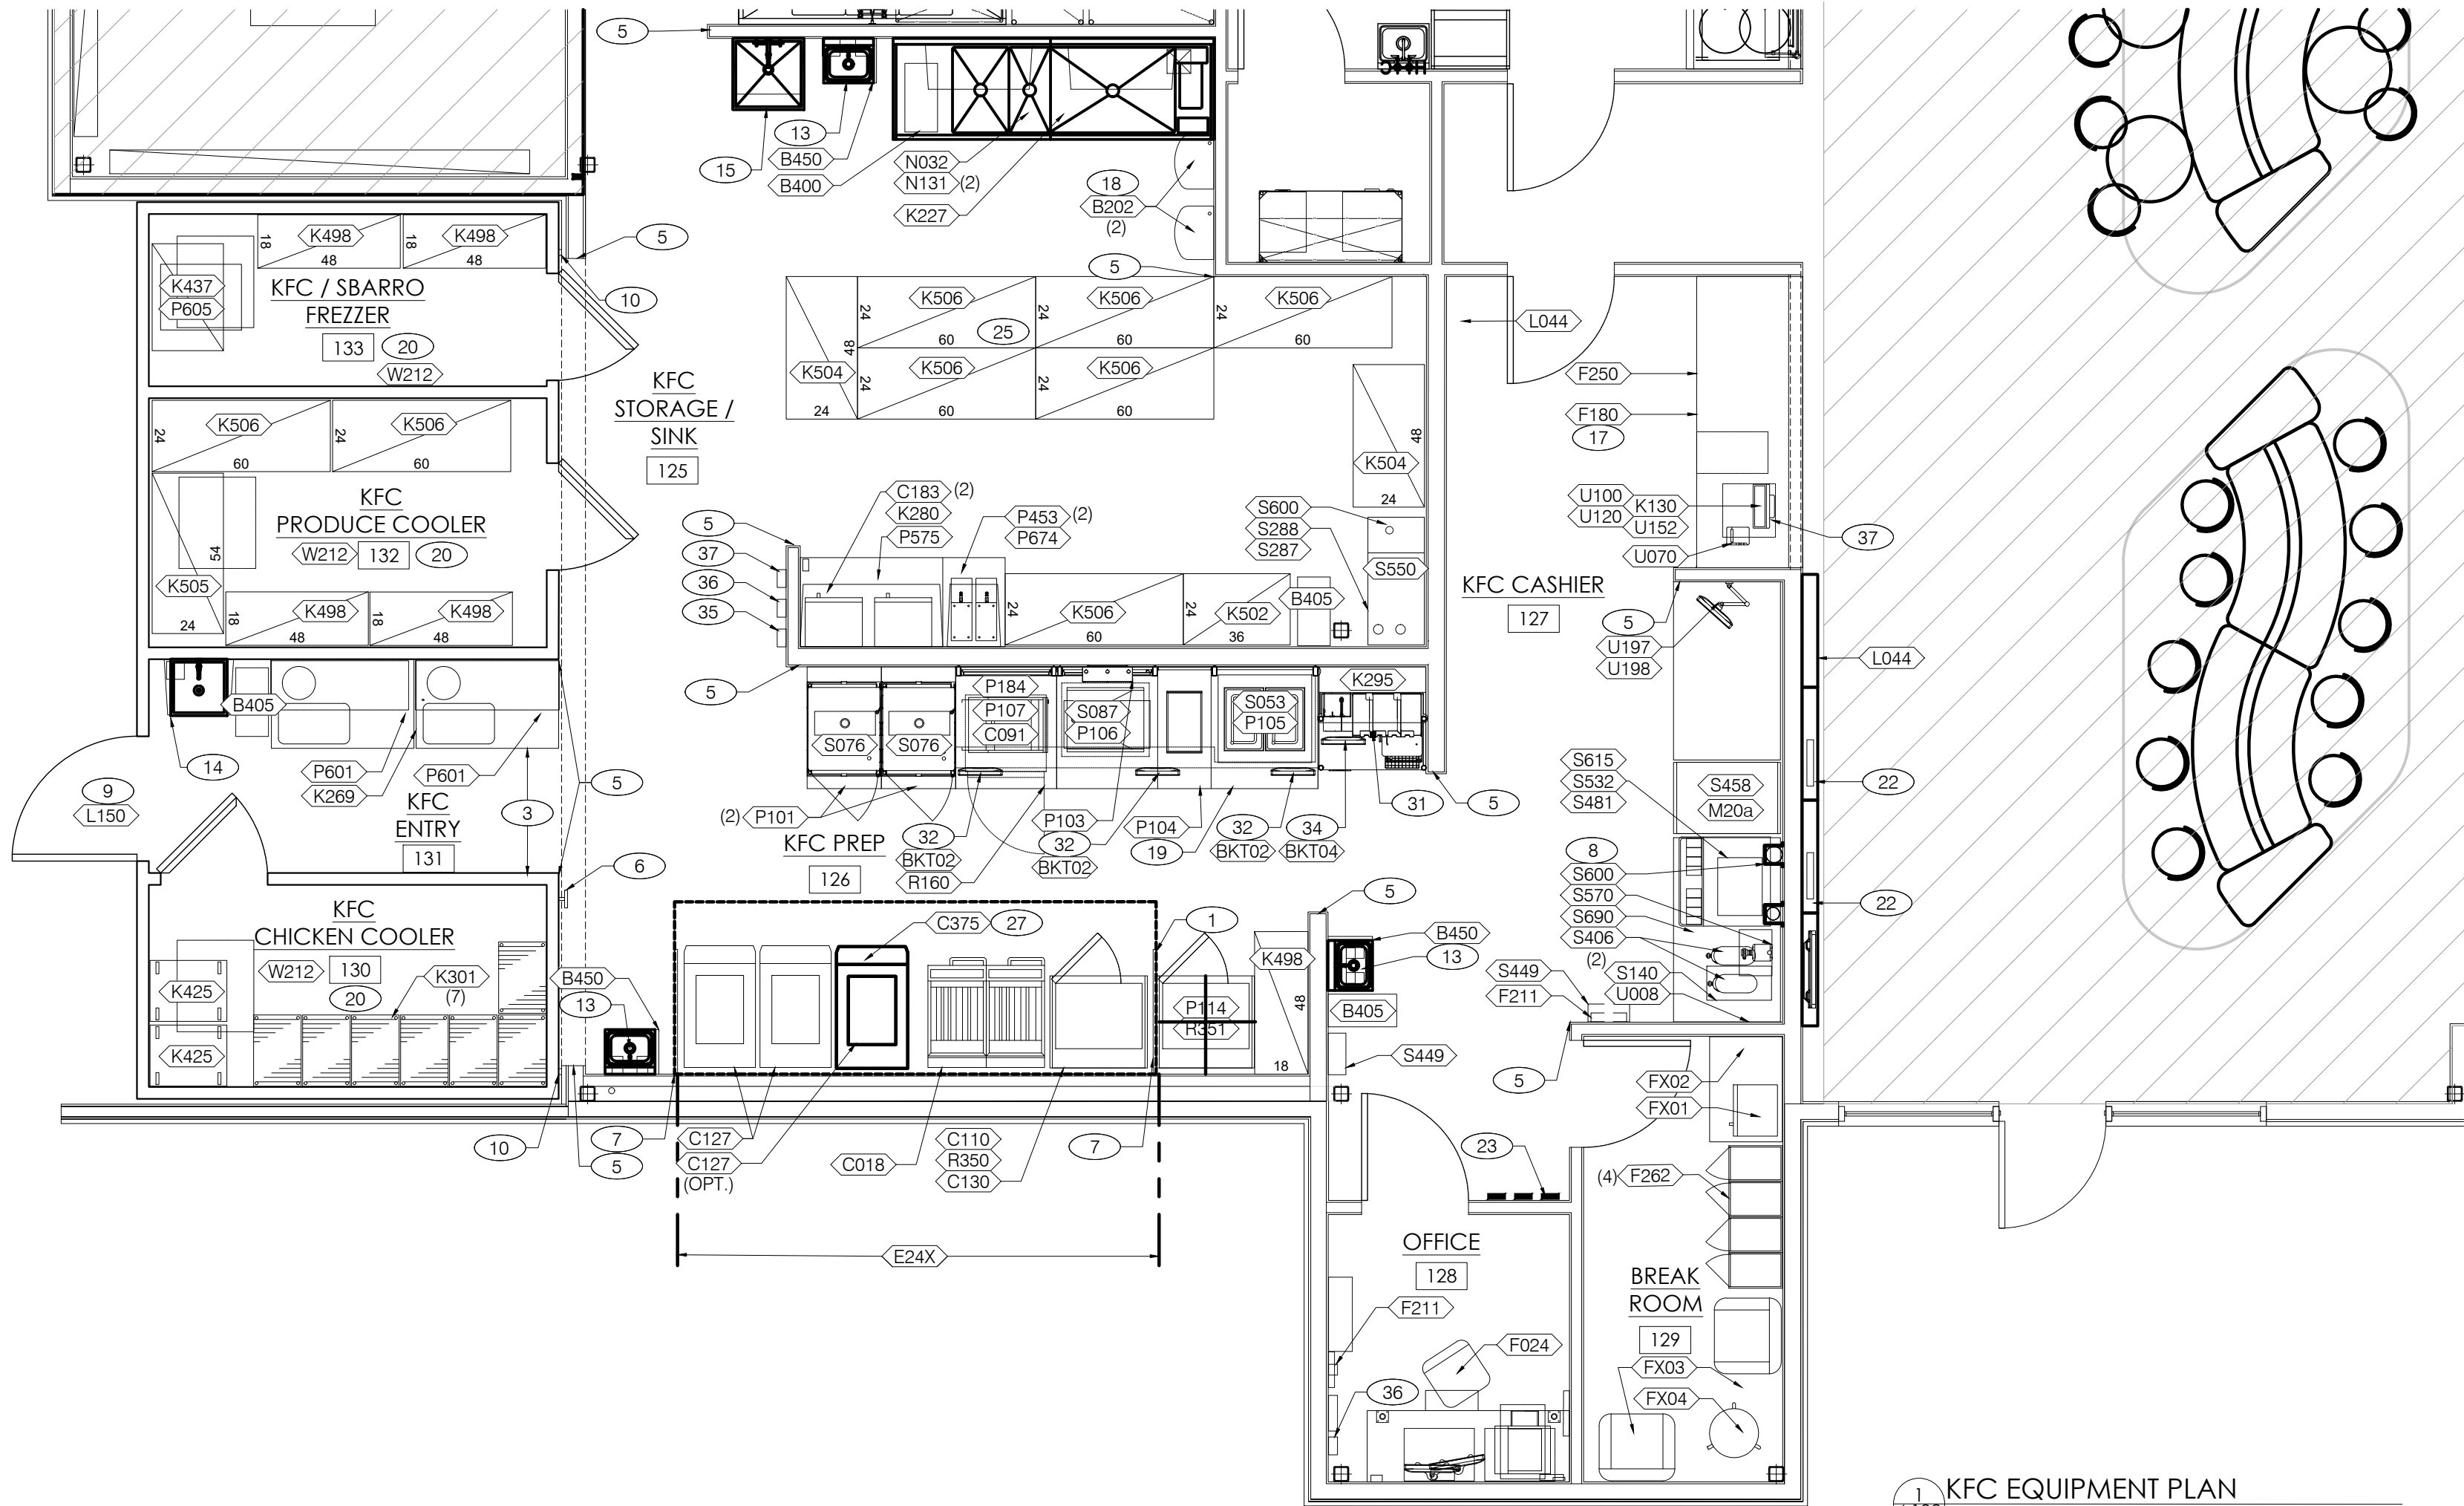

KEY NOTES

- HOOD FIRE SUPPRESSION SYSTEM; SEE MECHANICAL DRAWINGS.
- NOT USED.
- MAINTAIN 36" MIN CLEAR AISLE EGRESS PATHS TO EXIT DOORS.
- 30" x 52" CLEAR FLOOR SPACE FOR DISABLED ACCESS. BOUNDARY EXTENDS 2'-9" PAST EDGE OF TABLE.
- S.S. CORNERGUARD / WALL CAP, TYPICAL AT ALL CORNERS FROM REAR WALL TO KITCHEN SIDE OF SERVICE COUNTER. SEE DETAIL 2 / A6.1.
- PULL STATION @ 3'-8" A.F.F.
- GAS LINE DOWN TO EQUIPMENT; SEE PLUMBING DRAWINGS.
- PVC CHASE FOR INSULATED SYRUP / FILTERED WATER TUBE BUNDLE. SEE ELEVATIONS 7 / A8.0 and 6 / A8.2.
- SEE SHEET A1.1 FOR SECURITY DOOR PACKAGE.
- CLOSURES AND CORNER PROTECTION BY WALK-IN VENDOR.
- NOT USED.
- NOT USED.
- B241 X B251 X B290 X B405 X N920
- B620 X N024
- B599 X N071 X N202
- NOT USED.
- LOCATION OF SAFE.
- WATER HEATERS ABOVE CEILING ON WALL SURFACE. LOCATE BETWEEN TRUSSES. SEE PLUMBING DRAWINGS.
- SINGLE-SIDED PACK-LINE (M-LINE). COORDINATE EQUIPMENT ORDER WITH EQUIPMENT VENDOR.
- ONE REFRIGERATED UNIT, DIVIDED TO CREATE THREE UNITS- (1) CHICKEN COOLER, (1) PRODUCE COOLER & (1) FREEZER.
- NOT USED.
- ORDER KIOSK WITH WALL BRACKET. SEE RESPONSIBILITIES SCHEDULE ON SHEETS T1.1 & T1.2.
- KFC FOUNDATION ARTWORK POSTER IN FRAME.
- NOT USED
- FREESTANDING SHELVING UNIT: PROVIDE SEISMIC POSTS, FOOT PLATES & SWAY BARS IN SEISMIC ZONES
- NOT USED.
- IN THE ABSENCE OF OPTIONAL C127, LANDING TABLE C375 MAY BE USED.
- GC BUILT KNEE WALL FOR ORDER COUNTER AND PICKUP COUNTER. SEE DETAIL 11/A6.1.
- NOT USED.
- NOT USED.
- LABEL PRINTER. PROVIDE 1 QUAD OUTLET AND 2 DATA PORTS.
- KDS SCREEN. EACH SCREEN REQUIRES ONE DUPLEX OUTLET AT 40" A.F.F. AND ONE DATA PORT. ALL KDS ELECTRICAL OUTLETS TO BE WITHIN 6' OF THE SCREEN. USE BRACKET MOUNTED TO SHELF FRONT: KFC-KA-SF15V75K. SEE BRACKET SCHEDULE C/A2.0.
- NOT USED.
- KDS SCREEN WITH CLAMP MOUNT KFC-KA-PC. ADJA ADJUSTABLE 1-2" POLE CLAMP. SEE BRACKET SCHEDULE C/A2.0.
- CO2 SENSOR LOCATION.
- CO2 MONITOR CENTRAL CONTROL.
- CO2 HORN STROBE LOCATION.

GENERAL NOTES

- REFER TO RESPONSIBILITIES SCHEDULE ON SHEET T1.1.
 - REFER TO DESIGN REFERENCE MANUAL (PLANS.YUM.COM) FOR FINISHES, DIMENSIONS and DETAILS OF DECOR VENDOR SUPPLIED ITEMS. SEE SEATING PACKAGE LEGEND, THIS SHEET.
 - REFER TO SHEET A132.1 FOR EQUIPMENT TAG REFERENCES.
 - PROVIDE 2x4 WOOD BLOCKING FOR SHELVING AND HAND SINKS (TYP.)
 - REFER TO SHEET A401 FOR INTERIOR GRAPHICS; REFER TO GRAPHICS PACKAGE FOR ADDITIONAL INFORMATION.
- * THE NUTRITION MATERIALS (ACRYLIC HOLDER, NUTRITION POSTER AND BRAND NUTRITION BROCHURES) ARE PART OF A NEW RESTAURANT'S GRAND OPENING KIT AND ARE PROVIDED BY YUM FORMS.

BRACKETS SCHEDULE

TAG	ITEM DESCRIPTION	SPECIFICATION	IMAGE
BKT01	WALL MOUNTING BRACKET, USE WITH U198	KFC-KA-SSKH875C - KEYHOLE 8" KA	
BKT02	SHELF FRONT 1.5-2.5" KA MOUNTING BRACKET, USE WITH PACKLINE KDS SCREENS.	KFC-KA-SF15V75K	
BKT03	WALL MOUNTING BRACKET, USE WITH S200	MOUNT-ITI MI-4151A WITH FULL MOTION RETICULATING ARM	
BKT04	CLAMP/POLE MOUNT BRACKET FOR USE WITH POST PACK KDS SCREEN.	KFC-KA-PC. ADJA ADJUSTABLE 1-2" POLE CLAMP.	

ARCHITECT OF RECORD:

THOMAS E. MORGAN, JR.
ARCHITECT

423 FISCHER TRAIL
ELLIJAY, GEORGIA 30540

SEAL:



3450 Acworth Due West Road
Building 100, Suite 120
Kennesaw, Georgia 30144
P. 770-917-9172
F. 770-917-9470
www.mrpdesign.com

RELEASED FOR
CONSTRUCTION

ISSUES / REVISIONS:

DATE	DESCRIPTION
01.26.28	COMPILED SET RELEASED FOR CONSTRUCTION

DRAWN BY:

CHKD BY:

PROJECT DESCRIPTION:

DEVELOPMENT OF INTERIORS
CONDITIONS FOR A C-STORE IN
CORDELE, GA.

PROJECT TITLE:

CONVENIENCE STORE
379 ROCKHOUSE RD E,
CORDELE, GA 31015


SHEET TITLE:

KFC
EQUIPMENT
PLAN

PROJECT NO: 25049

A132

THESE PLANS ARE THE PROPERTY OF MRP DESIGN GROUP, INC. AND ARE SUBJECT TO FEDERAL COPYRIGHT LAWS. ANY USE OF SAME WITHOUT THE EXPRESS WRITTEN PERMISSION OF MRP DESIGN GROUP, INC. IS STRICTLY PROHIBITED

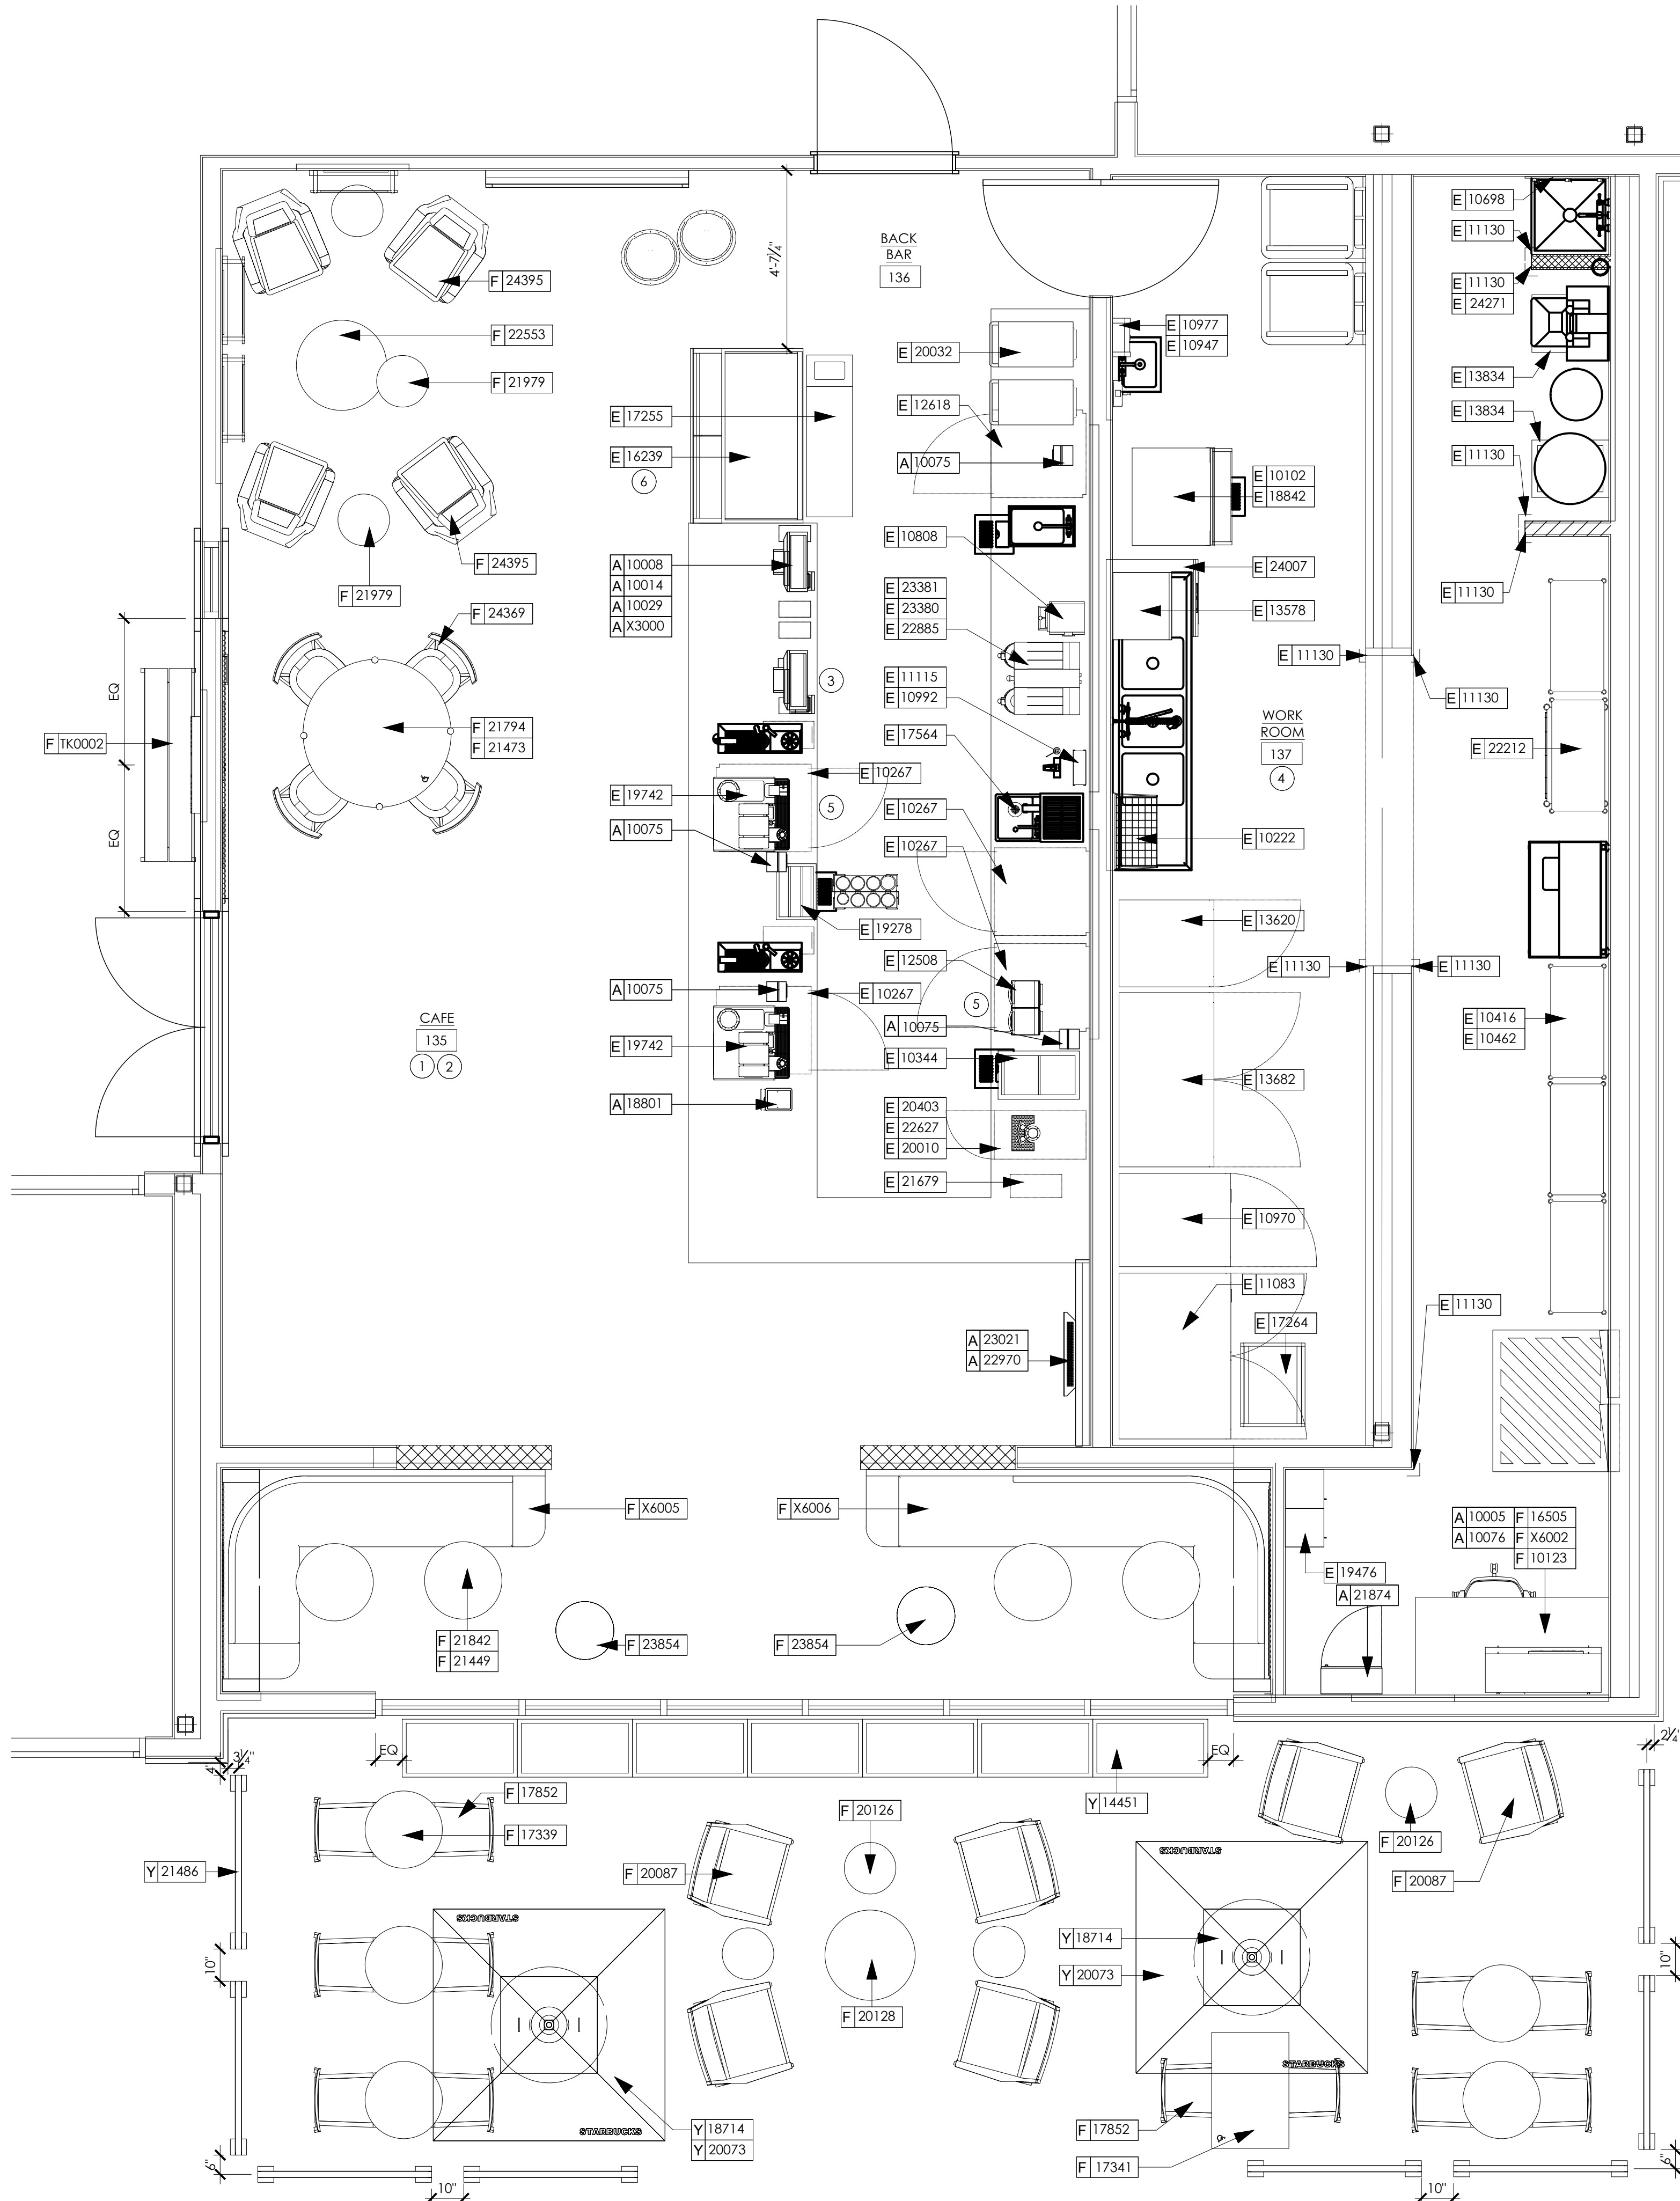


KEYED NOTES

1. INSTALL ALL FURNITURE THROUGHOUT AS SHOWN.
2. PLACE MERCHANDISE FIXTURES AND RETAIL FLOOR BASKETS PER PLAN. STORE OPERATORS TO ORDER RETAIL FLOOR BASKETS.
3. HAND SINK WITH INTEGRAL SPLASH GUARD.
4. INSTALL WALL CORNER GUARDS AS INDICATED. SEE INTERIOR FINISH ELEVATIONS.
5. GENERAL CONTRACTOR TO REVERSE HINGE ON U / C REFRIGERATOR TO LEFT HAND SWING AS SHOWN.
6. DO NOT BLOCK FOOD CASE INTAKE / EXHAUST.

GENERAL NOTES

- A. THE SITE IS SERVED BY THE MUNICIPAL WATER AND SEWER SYSTEM UNLESS OTHERWISE NOTED.
- B. ALL FLOOR AND WALL JUNCTIONS IN STORAGE AND PREP AREAS SHALL HAVE A COVED BASE.
- C. ALL FOOD STORAGE SHALL BE AT LEAST 6" (150MM) AFF.
- D. ALL WOOD SURFACES (DOORS, TRIM, SHELVES, CABINETS) SHALL BE SEALED.
- E. FLOORS, WALLS AND CEILING FINISHES IN FOOD PREP AREAS SHALL BE SMOOTH, NON-TOXIC, NON-ABSORBENT, DURABLE AND EASILY CLEANABLE. PAINT SHALL BE WASHABLE AND SEMI-GLOSS OR HIGH-GLOSS FINISH.
- F. ALL EQUIPMENT AND INSTALLATION WILL MEET NATIONAL SANITATION FOUNDATION STANDARDS OR EQUIVALENT.
- G. ALL EQUIPMENT AND CABINETRY WILL BE FLUSH MOUNTED TO COUNTERS, WALLS OR FLOORS, OR BE RAISED TO ALLOW FOR CLEANING.
- H. CONFIRM ALL NECESSARY EQUIPMENT CLEARANCES PER PRODUCT CUT SHEET (E.G. ICE MACHINE).
- I. FOR LOCATION OF COUNTERTOP EQUIPMENT, REFER TO CASEWORK ELECTRICAL DETAILS.
- J. EQUIPMENT UNITS SHALL CONTAIN NO EXPOSED THREADS, EMBELLISHMENTS OR OVERHANGING EDGES THAT SERVE AS PLACES FOR ACCUMULATION OF DUST, DIRT AND DEBRIS.
- K. EACH HAND WASHING SINK WILL HAVE A SINGLE SERVICE TOWEL AND SOAP DISPENSER, AND ALL HAND SINKS TO HAVE A COMBINATION FAUCET OR PREMIXING FAUCET.
- L. FOR PLUMBING FIXTURES, REFER TO THE PLUMBING DESIGN PLAN.

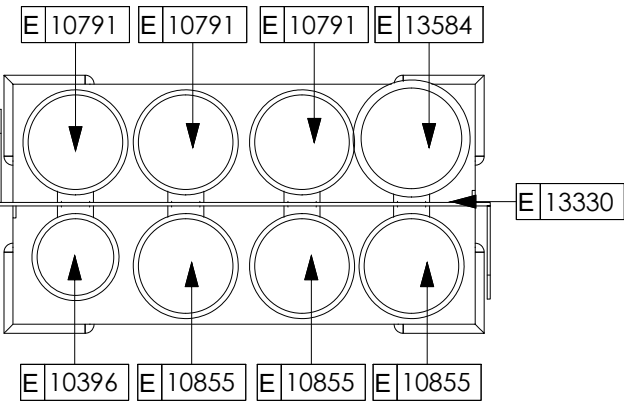

2 CUP CADDY DETAIL
SCALE: 1-1/2" = 1'-0"

1 STARBUCKS EQUIPMENT PLAN
SCALE: 3/8" = 1'-0"

ARCHITECT OF RECORD:

THOMAS E. MORGAN, JR.
ARCHITECT

423 FISCHER TRAIL
ELLIJAY, GEORGIA 30540

SEAL:



3450 Acworth Due West Road
Building 100, Suite 120
Kennesaw, Georgia 30144
P. 770-917-9172
F. 770-917-9470
www.mrpdesign.com

RELEASED FOR
CONSTRUCTION

ISSUES / REVISIONS:

DATE	DESCRIPTION
01.26.28	COMPILED SET RELEASED FOR CONSTRUCTION

DRAWN BY:

CHKD BY:

PROJECT DESCRIPTION:

DEVELOPMENT OF INTERIORS
CONDITIONS FOR A C-STORE IN
CORDELE, GA.

PROJECT TITLE:

CONVENIENCE STORE
379 ROCKHOUSE RD E,
CORDELE, GA 31015

SHEET TITLE:

STARBUCKS
EQUIPMENT
PLAN

PROJECT NO: 25049

A133

SPECIALTY EQUIPMENT SCHEDULE - "E"					
DESIGN ID	COUNT	DESCRIPTION	FURN. BY	INST. BY	COMMENTS
COOLING					
10267	4	FRIDGE UNDERCOUNTER 1 DOOR - 27IN 685MM	SB	GC	
10970	1	FRIDGE REACH IN 1 DOOR LH - 29IN 735MM	SB	GC	
11083	1	FRIDGE REACH IN 2 DOOR - 51X35IN 1295X890MM	SB	GC	
12618	1	FRIDGE UNDERCOUNTER 1 DOOR WITH SHELF - 27IN 685MM	SB	GC	
13620	1	FREEZER REACH IN 1 DOOR LH - 27IN 685MM	SB	GC	
13682	1	FREEZER REACH IN 2 DOOR - 54IN 1370MM	SB	GC	
20010	1	FRIDGE NITRO 2 TAP JT NITCOM LH	SB	GC	KIT INCLUDES UNDERCOUNTER FRIDGE, FONT, TRAY, AND TUBING
EQUIPMENT					
10808	1	GRINDER DITTING KR1203	SB	GC	
12508	2	BLENDER QUIET MODEL ON COUNTER	SB	GC	
17564	1	BLENDER PITCHER RINSER WITH SENSOR	SB	GC	
19742	2	ESPRESSO MACHINE MASTRENA II	SB	GC	50 AMPS, 2-WIRE PLUS GROUND (L1, L2, AND G), NEMA 6-50 REEPTACLE WITHIN 4.5 FEET
20032	2	OVEN EIKON E2S - BLACK	SB	GC	
21679	1	NITROGEN GENERATOR ELEMENT COMPACT	SB	GC	
22885	1	BREWER CLOVER VERTICA DOUBLE	SB	GC	50 AMPS, 2-WIRE PLUS GROUND (L1, L2, AND G), NEMA 14-50R RECEPTACLE
23380	1	BREWER CLOVER VERTICA DOUBLE INSTALL KIT	SB	GC	
23381	1	BREWER CLOVER VERTICA DOUBLE POWER CORD	SB	GC	
24007	1	DISHWASHER LXNR ADVANSYS	SB	GC	
FOOD CASE					
16239	1	FOOD CASE - ZEPHYR - 54IN 1370MM	SB	GC	
ICE					
10102	1	ICE - BIN B55	SB	GC	
10344	1	ICE - BIN DROP IN 90LB 40KG	SB	GC	
18842	1	ICE - MACHINE CIM1136HA SERIES AIR COOLED	SB	GC	
19278	1	ICE - BIN DROP IN 45LB 20KG HORIZONTAL	SB	GC	
OTHER					
10396	1	CUP DISPENSER SHORT HOT VERTICAL	SB	GC	
10791	3	CUP DISPENSER GRANDE VENTI COLD VERTICAL	SB	GC	
10855	3	CUP DISPENSER GRANDE VENTI HOT VERTICAL	SB	GC	
10947	1	SOAP DISPENSER WALL MOUNTED	LC	GC	
10977	1	PAPER TOWEL DISPENSER FULL SIZE	LC	GC	
10992	1	PAPER TOWEL DISPENSER HALF SIZE - TRANSLUCENT GRAY	LC	GC	
11115	1	SOAP DISPENSER SINK MOUNTED	SB	GC	
11130	9	CORNER GUARD - 0.375IN 10MM - ANODIZED ALUMINIUM	GC	GC	
13330	1	MOBILE CUP DISPENSER CADDY	SB	GC	
13584	1	CUP DISPENSER TRENTA COLD VERTICAL	SB	GC	
20403	6	KEG - 3GAL	SB	GC	
22627	1	NITRO 2 TAP HANDLE WITH BADGE AND MOUNT KIT	SB	GC	JOE TAP, FOR USE AT BACKBAR NITRO FONT
STORAGE					
10222	1	WIRE SHELF GRID AT SINK	SB	GC	
10416	5	WORKROOM SHELVING - 36IN 915MM	SB	GC	
10462	5	WORKROOM SHELVING POSTS	SB	GC	
10698	1	MOP RACK WITH 3 HOLDERS	SB	GC	
13578	2	DISHWARE DRYING RACK - 21IN 535MM	SB	GC	
13834	2	BASE - 24X18IN 610X455MM	SB	SB	ITEM PROVIDED BY PENTAIR FOR USE WITH WATER FILTRATON SYSTEM
17255	1	PASTRY TRAY CART - 60IN 1525MM	SB	GC	
17264	1	ROLLING PASTRY TRAY THAW RACK - 20X26IN 510X660MM	SB	GC	
19476	2	5 COMP LOCKER - 12IN 305MM	LC	GC	STARBUCKS RECOMMENDATION. LICENSEE TO PURCHASE AS NEEDED
22212	1	WORKROOM SHELVING CART KIT	SB	GC	
24271	1	FILTER - 20 GALLON RO SYSTEM STORAGE TANK SHELF	SB	SB	ITEM PROVIDED BY PENTAIR FOR USE WITH WATER FILTRATON SYSTEM
SITE SCHEDULE - "Y"					
DESIGN ID	COUNT	DESCRIPTION	FURN. BY	INST. BY	COMMENTS
FENCE AND RAILING					
21486	8	FENCE MESH - 54IN 1370MM	GC	GC	
PLANTER					
14451	7	PLANTER - BOX - 36X18X18IN 915X455X455MM - BLACK	LC	GC	
UMBRELLA					
18714	2	UMBRELLA - BASE 200LB 90KG - FLAT BLACK MT0028	SB	GC	
20073	2	UMBRELLA - WITHOUT VALANCE - 8FT 183CM - GREEN CANVAS WITH WORDMARK F0056	SB	GC	

DATA DEVICE SCHEDULE - "A"					
DESIGN ID	COUNT	DESCRIPTION	FURN. BY	INST. BY	COMMENTS
AUDIO VISUAL					
10005	1	MUSIC SYSTEM	LC	GC	LC TO REACH OUT TO InstallOrderEntry@moodmedia.com TO SET UP ACCOUNT WITH PLAYNETWORK
10015	2	SPEAKER RECESSED - WHITE	GC	GC	SEE RCP FOR LOCATION.
10076	1	AMPLIFIER - 60W	SB	GC	
18801	1	DIGITAL PRODUCTION MANAGER	SB	SB	COORDINATED BY STARBUCKS CONNECT TEAM. INCLUDES ASSOCIATED CABLES AND UPS POWER SUPPLY.
22549	2	SPEAKER GRILLE RECESSED - BLACK	GC	GC	SEE RCP FOR LOCATION.
DATA					
18744	1	EQUIPMENT RACK WITH LOCK - 24IN 610MM	LC	GC	
21874	1	PRODUCTION CONTROLLER	SB	GC	COORDINATED BY STARBUCKS CONNECT TEAM AND NCR. INCLUDES DELL WYSE 7040, SLIM LINE RETAIL CABINET RXL-4061 (AS REQUIRED FOR BOH INSTALLATION), ASSOCIATED CABLES AND UPS POWER SUPPLY
GRAPHICS - INTERIOR MENU					
22970	1	MENU BOARD - DIGITAL DISPLAY - 44X25.25IN 1121X644MM - BLACK	SB	GC	FOR ORDER STATUS BOARD. COORDINATED BY STARBUCKS CONNECT TEAM AND NCR.
23021	1	MENU BOARD - ORDER STATUS BOARD MOUNTING BRACKET - BLACK	SB	GC	COORDINATED BY STARBUCKS CONNECT TEAM AND NCR.
24899	1	MENU BOARD - DIGITAL MENU BOARD TRIPLE	LC	GC	LICENSEE TO COORDINATE WITH OSM AND NCR. SEE INTERIOR ELEVATIONS FOR LOCATION.
POINT OF SALE					
10008	2	POS - REGISTER WITH COMPACT CASH DRAWER	SB	SB	COORDINATED BY STARBUCKS CONNECT TEAM AND NCR. INCLUDES NCR POS, SCANNER, (2) NCR CASH DRAWERS FOR EACH REGISTER, CABLES, LOCK AND CYBERPOWER UPS.
10014	2	POS PRINTER	SB	SB	COORDINATED BY STARBUCKS CONNECT TEAM AND NCR. INCLUDES RECEIPT PRINTER AND CABLES.
10029	4	POS BANK	SB	SB	
10075	4	CUP LABELER	SB	SB	COORDINATED BY STARBUCKS CONNECT TEAM. INCLUDES ASSOCIATED CABLES AND UPS POWER SUPPLY.
X3000	1	PAYMENT ENTRY DEVICE (PED)	LC	LC	PAYMENT ENTRY DEVICES ARE PROVIDED BY LC THROUGH ELAVON OR FREEDOMPAY. ALL OTHER EQUIPMENT AND PERIPHERAL DEVICES ARE PROVIDED BY STARBUCKS CONNECT VIA NCR
FURNITURE SCHEDULE - "F"					
DESIGN ID	COUNT	DESCRIPTION	FURN. BY	INST. BY	COMMENTS
BANQUETTE					
X6005	1	BANQUETTE - SHORT - CUSTOM	SB	GC	WHITE OAK AND CARAMEL LEATHER - WD0073 AND F-0008
X6006	1	BANQUETTE - LONG - CUSTOM	SB	GC	WHITE OAK AND CARAMEL LEATHER - WD0073 AND F-0008
BENCH					
TK0002	1	BENCH - AMICABLE SPLIT - 60IN 1525MM - WHITE OAK	SB	GC	ORDER THROUGH GROUP O
CHAIR					
17852	12	CHAIR - CAFE PYRAMID - BLACK AND BROWN ROPE MT0028 F0194	SB	GC	
20087	6	CHAIR - LOUNGE PYRAMID - BLACK AND BROWN ROPE MT0028 F0194	SB	GC	
24369	4	CHAIR - CAFE SADOVE UPHOLSTERED - SAND AND CARAMEL	SB	GC	
24395	4	CHAIR - LOUNGE LOTTIE - NUT SADDLE	SB	GC	FROM EXCESS INVENTORY
X6002	1	CHAIR - MANAGERS WORKSTATION	LC	GC	STARBUCKS RECOMMENDATION. LICENSEE TO PURCHASE AS NEEDED.
DESK					
10123	1	DESK - MANAGERS WORKSTATION - 60X30X30IN 1525X760X760MM	LC	GC	STARBUCKS RECOMMENDATION. LICENSEE TO PURCHASE AS NEEDED.
16505	1	DESK - MANAGERS WORKSTATION SHELVES - 36IN 915MM	LC	GC	STARBUCKS RECOMMENDATION. LICENSEE TO PURCHASE AS NEEDED.
OTTOMAN					
23854	2	OTTOMAN - STOUT - BLACK AND TAN BROWN WD0035 F0245	SB	GC	
TABLE					
17339	5	TABLE - CAFE METAL PEDESTAL BASE ROUND - 24IN 610MM - BLACK MT0028	SB	GC	
17341	1	TABLE - ACCESSIBLE METAL WITH TAPERED LEGS - 36X24IN 915X610MM - BLACK MT0028	SB	GC	
20126	4	TABLE - OCCASIONAL COCKTAIL CAMERON - FLAT BLACK MT0028	SB	GC	
20128	1	TABLE - OCCASIONAL COFFEE CAMERON - FLAT BLACK MT0028	SB	GC	FROM EXCESS INVENTORY
21449	4	TABLE - BASE CAFE HEIGHT BOTTLE - FLAT BLACK MT0028	SB	GC	
21473	1	TABLE - BASE ACCESSIBLE POST LEG SQUARE - FLAT BLACK MT0028	SB	GC	
21794	1	TABLE - TOP ACCESSIBLE FOR POST LEG ROUND - 46IN 1170MM - WHITE OAK WD0073	SB	GC	FROM EXCESS INVENTORY
21842	4	TABLE - TOP ROUND EDGE ROUND - 24IN 610MM - WHITE OAK WD0073	SB	GC	(3) FROM EXCESS INVENTORY
21979	3	TABLE - OCCASIONAL SIDE WING - WHITE OAK WD0073	SB	GC	

LICENSED STORES RESPONSIBILITY LEGEND

SB - STARBUCKS

 
FC - STARBUCKS FIXTURE CONTRACTOR

LC - LICENSEE


GC - LICENSEE'S GENERAL CONTRACTOR

ARCHITECT OF RECORD:

THOMAS E. MORGAN, JR.
ARCHITECT



 423 FISCHER TRAIL
ELLIJAY, GEORGIA 30540



SEAL:



3450 Acworth Due West Road
Building 100, Suite 120
Kennesaw, Georgia 30144
P. 770-917-9172
F. 770-917-9470
www.mrpdesign.com

RELEASED FOR CONSTRUCTION

ISSUES / REVISIONS:

DATE	DESCRIPTION
01.26.28	COMPILED SET RELEASED FOR CONSTRUCTION

DRAWN BY:

CHKD BY:

PROJECT DESCRIPTION:

DEVELOPMENT OF INTERIORS
CONDITIONS FOR A C-STORE IN
CORDELE, GA.

PROJECT TITLE:

CONVENIENCE STORE
379 ROCKHOUSE RD E,
CORDELE, GA 31015

SHEET TITLE:


STARBUCKS
EQUIPMENT
PLAN

PROJECT NO: 25049

A133.1



DOOR NO.	DOOR SIZE	TYPE	DOOR FRAME	BUTTS			LOCKS			CLOSERS			KICKPLATE			THRESHOLD			DOOR STOP			PUSH		PULL		MISCELLANEOUS						DETAIL LOCATIONS			REFERENCE NOTES
				1	2	3	1	2	3	4	5	6	1	2	3	1	2	3	1	2	3	1	2	1	2	1	2	3	4	5	6				
				SEE DOOR TYPES, THIS SHEET	SEE DOOR TYPES, THIS SHEET	SEE DOOR TYPES, THIS SHEET	ONE PAIR OFFSET PIVOTS, TOP + BOTTOM, per DOOR MFR.	1 1/2 PR. BOMMER #5000-450, 4 1/2" x 4 1/2"	CONTINUOUS HINGE INCLUDED IN PACKAGE	1 1/2 PR. 180 DEGREE SWING 3" SPRING HINGES	FALCON FLA027TA (PRVACY LOCK, LEVER HANDLE STYLE)	KABA SIMPLEX 5000	FULL LENGTH LATCH PROTECTOR INCL. IN PACKAGE	PANIC HARDWARE INCLUDED IN PACKAGE	FLUSH BOLT/DEAD BOLT BY MFR AS REQUIRED	I.D.C. 8050	DORMA 7414 ARPSN689	STAINLESS STEEL 10" x .050 X 2" L.T.D.W. **	KICKPLATE INCLUDED IN PACKAGE	ACCESSIBLE ALUM. THRESHOLD BY DOOR MFR.	THRESHOLD INCLUDED IN PACKAGE	WALL STOP - ROCKWOOD RM857-RPC	WALL STOP - ROCKWOOD 409	PUSH PLATE ROCKWOOD 107x73BL	PULL PLATE ROCKWOOD 73BL -3.5" x 15"	STD. ADJUSTABLE DOOR SWEEP PER DOOR MFR.	SWEEP (VISTA 2B1 STD) NGP 101VA	PEST CONTROL DOOR SWEEP: SEALZE / #D480CLA09BL	PROVIDE A SIGN STATING "THIS DOOR TO REMAIN UNLOCKED DURING BUSINESS HOURS"	DOOR SIGN (ADA ACCESSIBLE)	DOOR SIGN (GENDER)	HEAD	JAMB	SILL	
①	3'-0" x 7'-0" x 1-3/4"	D1	HM	F1				X				X	X		X			X							X							17/A6.0	18/A6.0	16/A6.0	6, 9, 12
②	3'-0" x 7'-0" x 1-3/4"	D2															X																-	7	
③	3'-0" x 7'-0" x 1-3/4"	D2																																-	7
④	3'-0" x 7'-0" x 1-3/4"	D2																																-	7
⑤	3'-0" x 7'-0" x 1-3/4"	D4	WD	F1			X			X						X	X			X		X	X	X								7/A6.0	7/A6.0	-	1, 2, 5, 8, 9, 10, 14
⑥	3'-0" x 7'-0" x 1-3/4"	D4	WD	F1			X		X							X	X			X	X	X	X									7/A6.0	7/A6.0	-	1, 2, 5, 8, 9, 10, 14
⑦	3'-0" x 7'-0" x 1-3/4"	D3	WD	F1			X		X							X	X			X	X	X	X	X								7/A6.0	7/A6.0	-	1, 2, 5, 8, 9, 10, 14
⑧	3'-0" x 7'-0" x 1-3/4"	D3	WD	F1			X		X							X	X			X	X	X	X	X								4/A202	4/A202	-	1, 2, 5, 8, 9, 10, 14
⑨	3'-0" x 7'-0" x 1-3/4"	D3	WD	F1			X		X							X	X			X		X	X	X								4/A202	4/A202	-	1, 2, 5, 8, 9, 10, 14

 

(T) INDICATES TEMPERED GLAZING
 QTY. QUANTITY

- PROVIDE ADA AND EGRESS DOOR HARDWARE AS REQUIRED BY CODE. ALL DOOR HARDWARE TO COMPLY WITH 2018 IBC / 2010 ADA.
- DOOR SUPPLIER TO PROVIDE FINAL HARDWARE AND KEYING SCHEDULE TO OWNER FOR APPROVAL, WITH COPIES OF ALL KEYS PROVIDED TO OWNER.
- ALL HARDWARE TO BE SELECTED BY OWNER UNLESS NOTED OTHERWISE
- PROVIDE METAL THRESHOLD AND WEATHER STRIPPING AT ALL EXTERIOR DOORS.
- CAULK ENTIRE PERIMETER OF ALL EXTERIOR OPENINGS - BOTH SIDES
- ALL EXTERIOR EGRESS DOORS SHALL BE PROVIDED WITH CLOSER, TYP.
- ALL BUILDING ENVELOPE FIXTURES SUCH AS WINDOWS, DOORS AND SKYLIGHT SHALL MEET COMPLIANCE PER IECC-18 CHAPTER 402. GC TO VERIFY THAT PRODUCT MEETS COMPLIANCE BEFORE INSTALL.

1. LAMINATE ON DOORS AND PAINT FRAMES PER TO FINISH SCHEDULE.
2. ALL HM FRAMES SHALL BE 16 GA STEEL U.O.N.
3. UTILIZATION OF ALTERNATE TRAFFIC DOOR SHALL BE DETERMINED BY SITE-ADAPT CONSULTANT BASED ON LOCAL EGRESS REQUIREMENTS.
4. MOUNT DOOR STOP TO SLAB FLUSH WITH END OF WING WALL, 1/2" SPACING FROM WALL SURFACE.
5. MOUNT DOOR CLOSERS ON KITCHEN SIDE ONLY.
6. COMPLETE DOOR, FRAME AND HARDWARE PACKAGE SHALL BE ORDERED THRU LOCKNET SECURITY DOORS, PART #DU3670LS2YED: VISION PANEL (WITH 18 GA. HOLLOW METAL FRAME), CONTINUOUS HINGE, HEAVY DUTY CLOSER, RAIN DRIP, DOOR SWEEP / BOTTOM, BRUSH-TYPE DOOR SWEEP / BOTTOM (EXTERIOR SIDE), WEATHER-STRIP, KICK PLATE and PANIC HARDWARE.
7. REFERENCE AND REVIEW MANUFACTURE SPECIFICATIONS FOR DOOR INSTALL REQUIREMENTS, HARDWARE AND FINISHES.
8. MOUNT KICK PLATE ON PUSH SIDE ONLY.
9. MAXIMUM DOOR OPERATING PRESSURE: 5 Lbs INTERIOR / 8.5 Lbs EXTERIOR; MEASURED at 90 DEGREES TO THE DOOR AT THE STRIKE EDGE.
10. ADA COMPLIANT ACCESSIBILITY SIGNAGE, INCLUDE BRAILLE AS REQUIRED BY LOCAL JURISDICTION: (1) MEN, (1) WOMEN.
11. NOT USED
12. NOT USED
13. ALUMINUM DOORS, HARDWARE, HINGES, SWEEPS, PUSH / PULL PLATES (VERIFY WITH LOCAL CODE), SHALL BE PROVIDED BY STOREFRONT SYSTEM SUPPLIER / INSTALLER.
14. UNDERCUT DOOR $\frac{3}{4}$ " (TO ALLOW FOR RETURN AIR PASSAGE).
15. NOT USED
16. BOTTOM RAIL OF STOREFRONT DOORS SHALL BY 10" HIGH / MINIMUM per ADA.
17. DOORPOST AS REQUIRED FOR FINISH OPENING.
18. DOOR PROVIDED AND INSTALLED BY GC. LAMINATE: pl-6 FORMICA 8844-WR AGED ASH, VERTICAL GRAIN. BUTTS: 1-1/2" PR, BOMMER #3029-6 x 4-1/2".

SECURITY DOOR + FRAMES & HARDWARE INTERIOR DOORS + FRAMES & HARDWARE	INTERIOR DOORS + FRAMES & HARDWARE
LOCKNET GERRI LYNNE DAY 800 JOHN C WATTS DRIVE NICHOLASVILLE, KY 40356 800-887-4307 EXT.203 GERRILYNN@LOCKNET.COM	HAMILTON PARKER THOMAS LEE 1865 LEONARD AVE. COLUMBUS, OH 43219 614-935-1465 O:614.358.7887 TLEE@HAMILTONPARKER.COM

pl-6 MFR.: FORMICA
TYPE: LAMINATE
COLOR: 8844-WR AGED ASH
DOORS. INSTALL GRAIN VERTICALLY



NUMBER	QTY	DESCRIPTION	W	H	D	AUTO OPERATE	EGREES	FIRE RATING	FINISH	FURN BY	INST BY	COMMENT	HW SET	HW PACKAGE
D02-7209	1	(ENTRY/EXIT) (DOUBLE) (NEW) (ACTUATOR)	5' - 8"	7' - 0"		Yes	Yes	(none)	ALUM	GC	GC	LL PROVIDES TEMP. HARDWARE GC SHALL PROVIDE PERMANENT HARDWARE PER HARDWARE TYPE NOTED	09	(1)CONTINUOUS HINGE — PEMKO CFM83-HD1 Cw(1)FLUSH BOLT — ADAMS RITE MS1880-01-84" 682z(1)DEAD LOCK — ADAMS RITE MS1805-110-628 LH 628z(1)CYLINDER — FALCON C607 A 626 OPEN 7-PIN CORE COMBINATION "A" KEYWAY 626z(1)CYLINDER — FALCON C987 626 7 PIN MORTISE CYLINDER HOUSING W/AR CAM CAM 626z(1)KEYING — FALCON KB609-2CCA CUT CONTROL KEY "A" KEYWAYz(1)KEYING — FALCON KB632-2CCA CUT USER KEY "A" KEYWAYz(1)PUSH BAR — ROCKWOOD BF15747-33" T1HD MOUNTING US28 US28z(1)SURFACE CLOSER — DORMAKABA DOOR CLOSER 8916 AF89P B5889 CL LH CLW(1)FLOOR DOOR HOLDER — ROCKWOOD DOOR STOP W/HOOK US26Dz(1)THRESHOLD NGP325-72"z(1)WEATHERSTRIPPING — NGP137NA Wz(1)WEATHERSTRIP 72"x4"(20" Aw(1)WEATHERSTRIPPING — PEMKO DOOR SWEEP 18062CNB36" Cw(1)MISCELLANEOUS ITEM — SCHLAGE GS314-LB NS DOOR KEY SWITCHz(1)MISCELLANEOUS ITEM — REFER TO THE BARRIER FREE EXTERIOR DOOR SCHEDULE ON THIS SHEET THAT WILL INCLUDE ADDITIONAL DOOR CONTENT FOR THIS SETz(1)ROOM NAME PLATE SIGN — VINYL SIGN; THIS DOOR MUST REMAIN UNLOCKED WHEN BUILDING IS OCCUPIEDz(1)MISCELLANEOUS HARDWARE — FALCON A08794-003 ADJUSTABLE RING, MORTISE CYL15-16-13/32 626
D05-3619	1	(WORKROOM/ELIASON) (SINGLE)	3' - 0"	7' - 0"	3/4"	No	No	(none)	HPL	GC	GC		19	(1)TRAFFIC DOOR — ELIASON TRAFFIC DOOR SCP8 36" X 84"; FINISH: BLACK
D03-4223	1	(SERVICE/EXTERIOR) (SINGLE) (KEYED LOCK)	3' - 6"	7' - 0"	1 3/4"	No	No	(none)	STL	GC	GC	LL PROVIDES TEMP. HARDWARE GC SHALL PROVIDE PERMANENT HARDWARE PER HARDWARE TYPE NOTED	23	(1)CONTINUOUS HINGE — PEMKO CFM83-HD1 Cw(1)EXIT DEVICE — ACCENTRA 7100 626P-PB X 630 PANIC BAR/W/ EXTERIOR KEVED LEVER TRIM - LH 630/630z(1)CYLINDER — FALCON C607 A 626 OPEN 7-PIN CORE COMBINATION "A" KEYWAY 626z(1)CYLINDER — FALCON C953 626z(1)KEYING — FALCON KB609-2CCA CUT CONTROL KEY "A" KEYWAYz(1)KEYING — FALCON KB632-2CCA CUT USER KEY "A" KEYWAYz(1)SURFACE CLOSER — DORMAKABA DOOR CLOSER 8916 AF89P 689z(1)KICK PLATE — ROCKWOOD K1050 B4E KICKPLATE 8" X 1" LDW PULL SIDE US32D US32Dz(1)KICK PLATE — ROCKWOOD K1050 B4E KICKPLATE 8" X 2" LDW PUSH SIDE US32D US32Dz(1)WEATHERSTRIPPING — NGP 137NA WEATHERSTRIP 36" X 84" Aw(1)WEATHERSTRIPPING — PEMKO DOOR SWEEP 18062CNB36" Cw(1)DOOR KNOCKER — NEWHOUSE MCV309NWHGL DOORBELLz(1)MISCELLANEOUS HARDWARE — DU SEUNG DU SEUNG DS/1000 DOOR SCOPE SILVER

DOOR ACTUATOR SCHEDULE - "D"					
DESIGN ID	COUNT	DESCRIPTION	FURN BY	INST BY	COMMENTS
DOOR HARDWARE					
23132	2	DOOR - BARRIER FREE HARDWARE ACTUATOR MULLION MOUNT	GC	GC	FINISH: BLACK
23139	1	DOOR - BARRIER FREE HARDWARE KEY SWITCH	GC	GC	FINISH: BLACK
23135	1	DOOR - BARRIER FREE HARDWARE OPERATOR - BLACK	GC	GC	

THOMAS E. MORGAN, JR.
ARCHITECT

ELLIJAY, GEORGIA 30540

SEAL:

M R P
DESIGN GROUP

3450 Acworth Due West Road
Building 100, Suite 120
Kennesaw, Georgia 30144
P. 770-917-9172
F. 770-917-9470
www.mrpdesign.com

RELEASED FOR
CONSTRUCTION

ISSUES / REVISIONS:	
DATE	DESCRIPTION
1.28.26	COMPILED SET RELEASED FOR CONSTRUCTION

DRAWN BY

CHK'D BY:

PROJECT DESCRIPTION:

DEVELOPMENT OF INTERIORS CONDITIONS FOR A C-STORE IN CORDELE, GA.

PROJECT TITLE:

CONVENIENCE STORE

379 ROCKHOUSE RD E,
CORDELE, GA 31015

SHEET TITLE:


DOOR SCHEDULES

PROJECT NO

25049

A202

THESE PLANS ARE THE PROPERTY OF MRP DESIGN GROUP, INC. AND ARE SUBJECT TO FEDERAL COPYRIGHT LAWS. ANY USE OF SAME WITHOUT THE EXPRESS WRITTEN PERMISSION OF MRP DESIGN GROUP, INC. IS STRICTLY PROHIBITED.

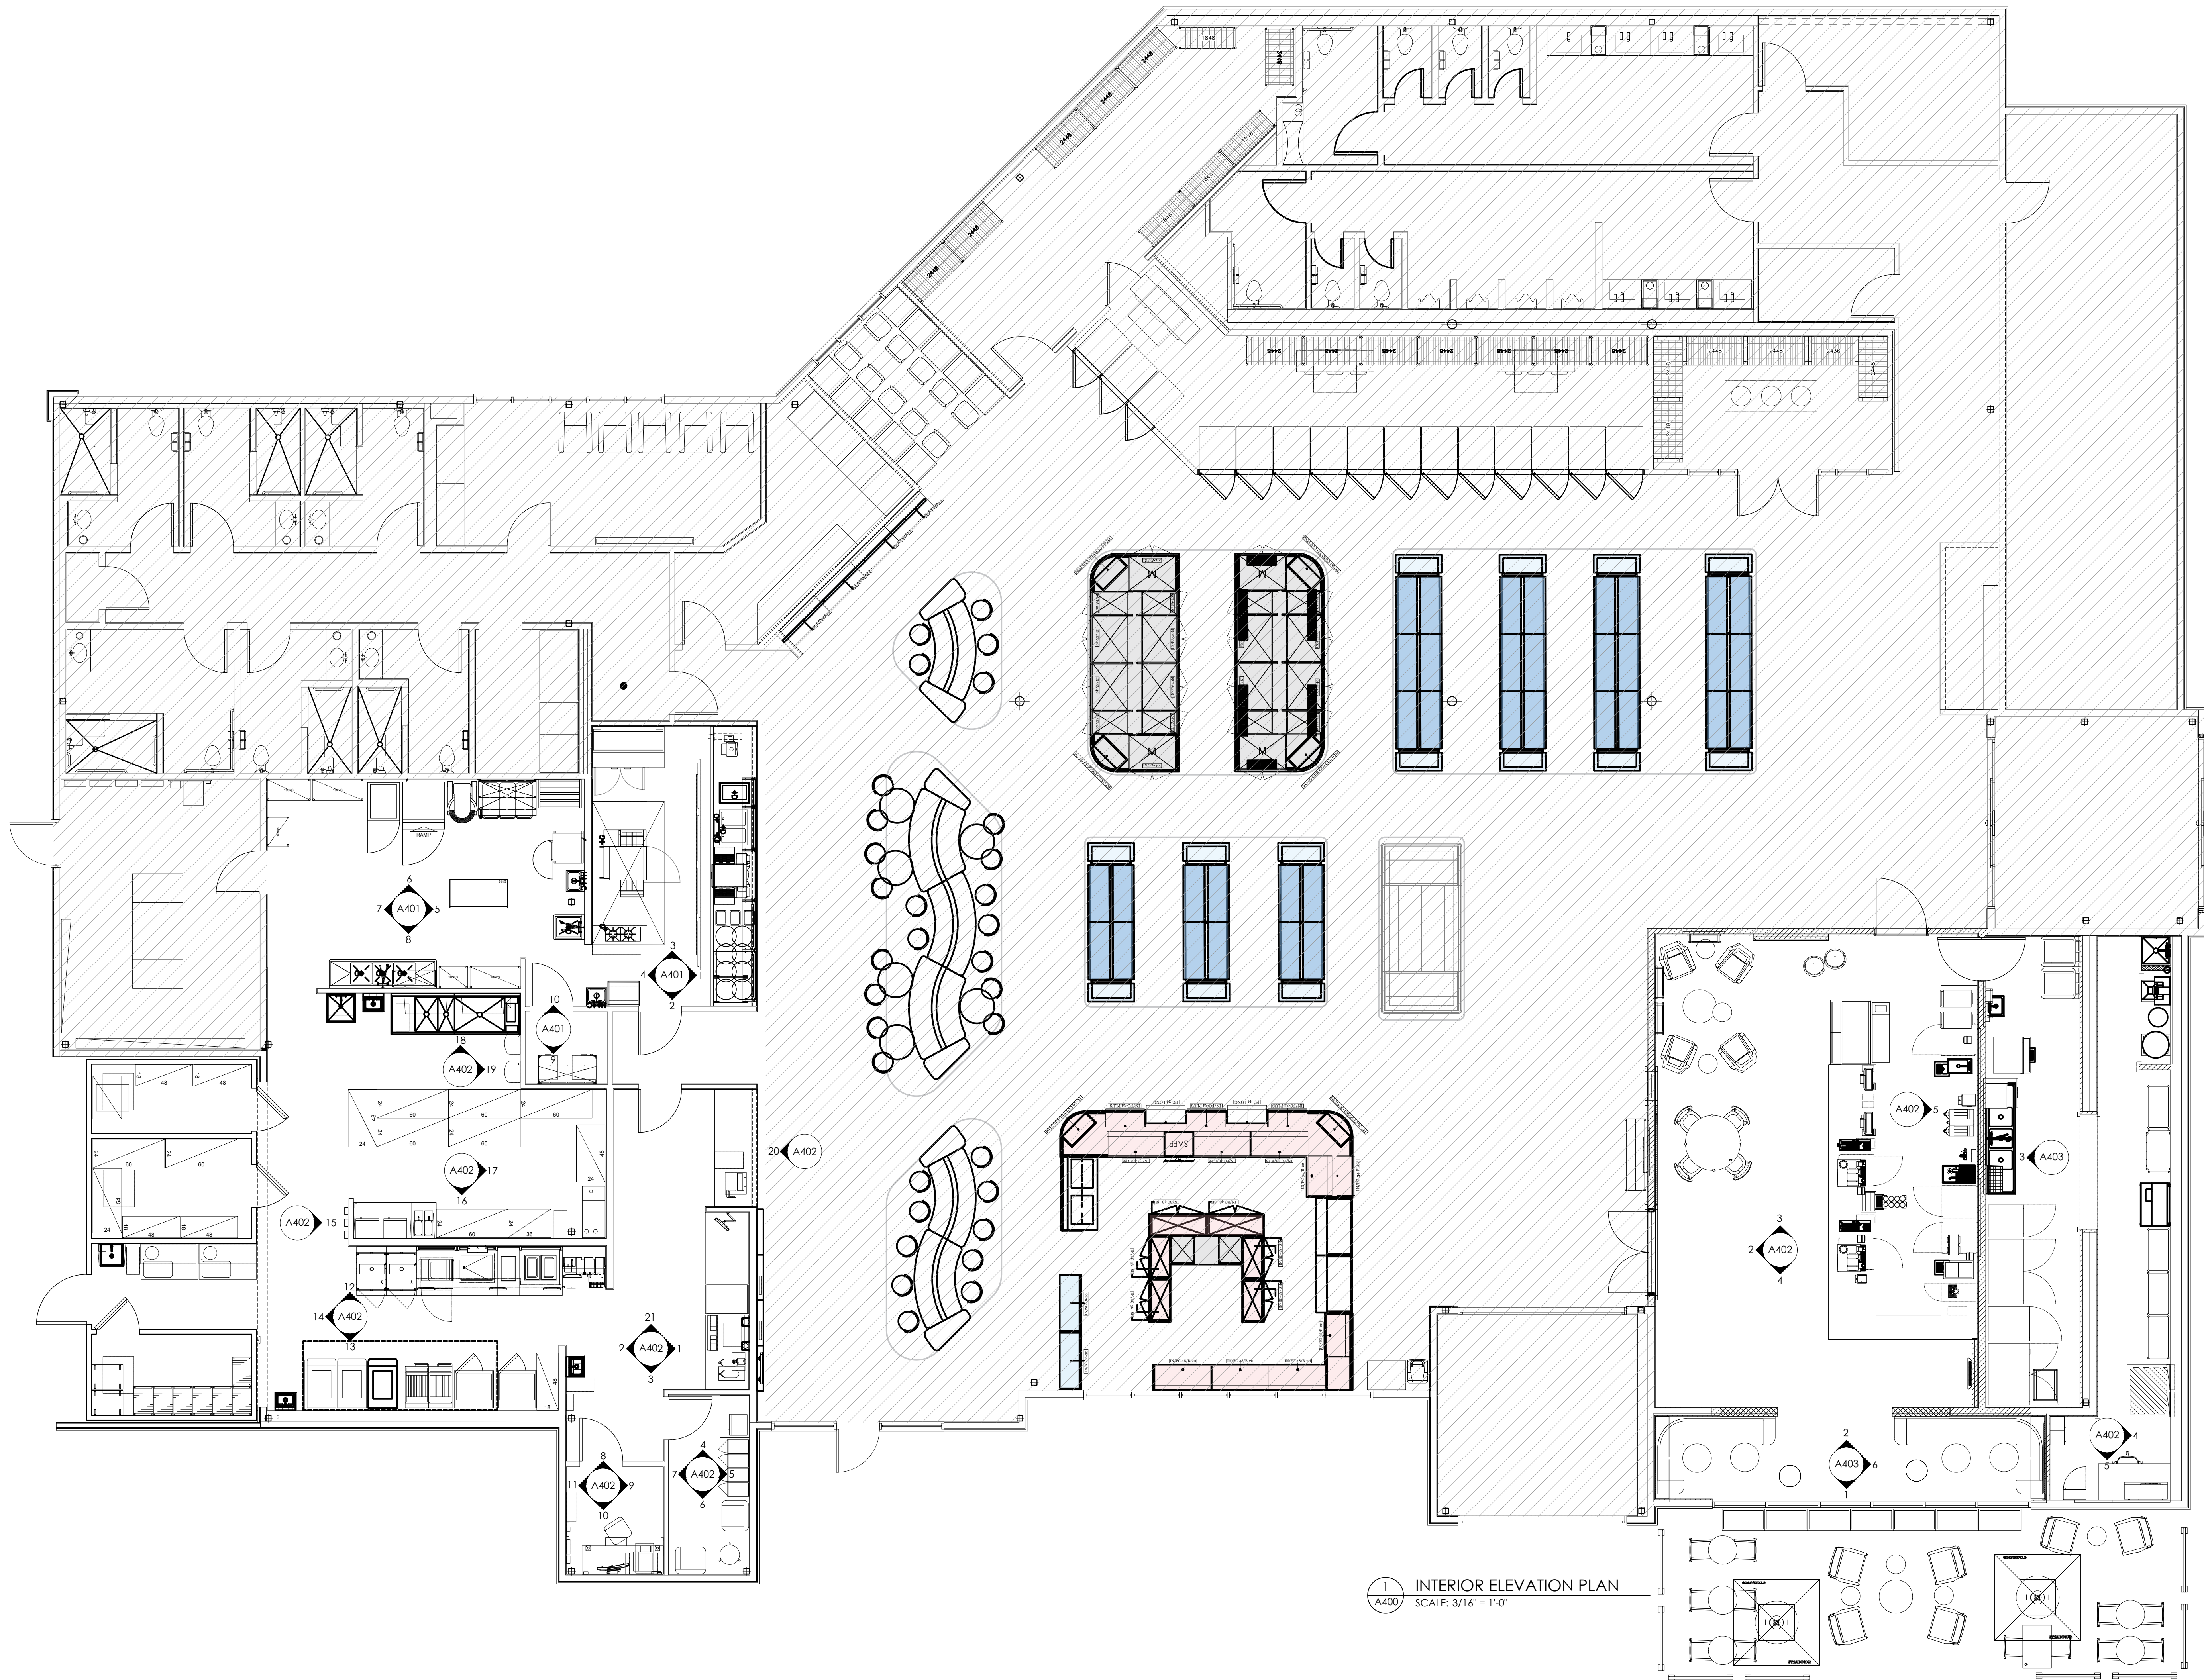

1 INTERIOR ELEVATION PLAN
SCALE: 3/16" = 1'-0"

ARCHITECT OF RECORD:

THOMAS E. MORGAN, JR.
ARCHITECT

423 FISCHER TRAIL
ELLIJAY, GEORGIA 30540

SEAL:



3450 Acworth Due West Road
Building 100, Suite 120
Kennesaw, Georgia 30144
P. 770-917-9172
F. 770-917-9470
www.mrpdesign.com

RELEASED FOR
CONSTRUCTION

ISSUES / REVISIONS:

DATE	DESCRIPTION
01.28.28	COMPILED SET RELEASED FOR CONSTRUCTION

DRAWN BY:

CHKD BY:

PROJECT DESCRIPTION:

DEVELOPMENT OF INTERIORS
CONDITIONS FOR A C-STORE IN
CORDELE, GA.

PROJECT TITLE:

CONVENIENCE STORE
379 ROCKHOUSE RD E,
CORDELE, GA 31015


SHEET TITLE:

INTERIOR
ELEVATIONS
KEY PLAN

PROJECT NO: 25049

A400
























A401

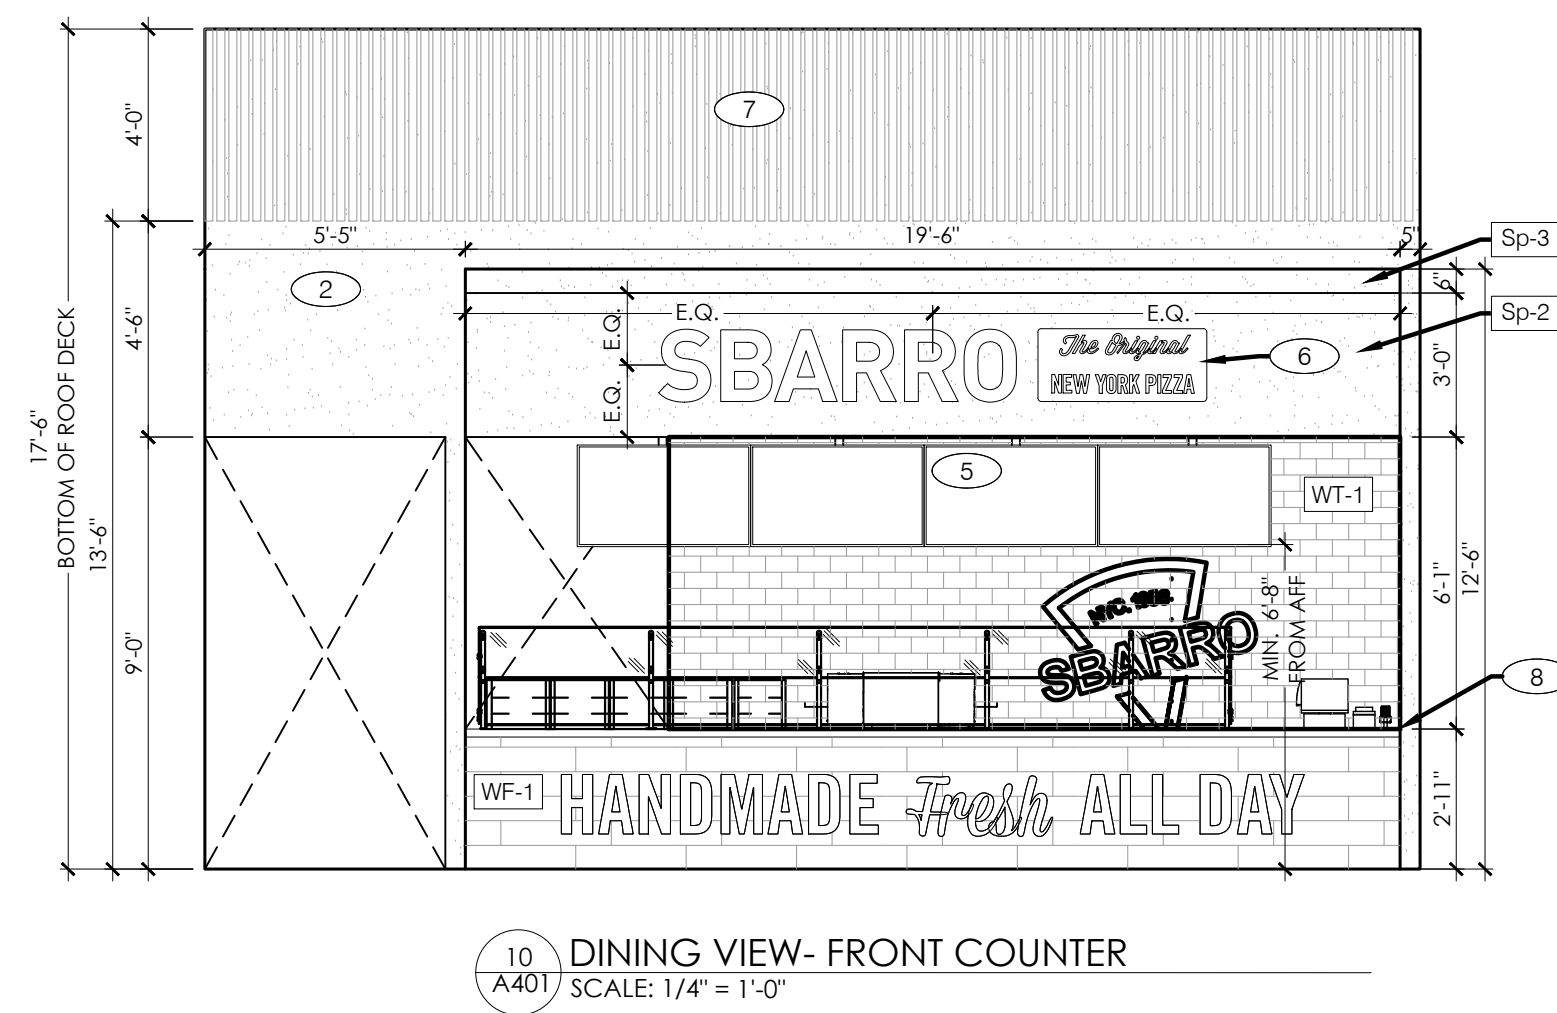

KEY NOTES

1	ALL BACK-OF-HOUSE WALLS U.O.N.
2	WALL FINISH BY OTHER (TO MATCH T-LINES SPEC)
3	SEE ELECTRICAL SHEETS
4	BOTTOM OF SOFFIT.
5	MENUBOARD LOCATION, SOFFIT MOUNTED.
6	SIGNAGE PER BY OTHER.
7	SLATS BY T-LINES
8	CORIAN - DEEP BLACK QUARTZ COUNTERTOP, REF. CONTACT LIST FOR MORE INFO.

THESE PLANS ARE THE PROPERTY OF MRP DESIGN GROUP, INC. AND ARE SUBJECT TO FEDERAL COPYRIGHT LAWS. ANY USE OF SAME WITHOUT THE EXPRESS WRITTEN PERMISSION OF MRP DESIGN GROUP, INC. IS STRICTLY PROHIBITED.

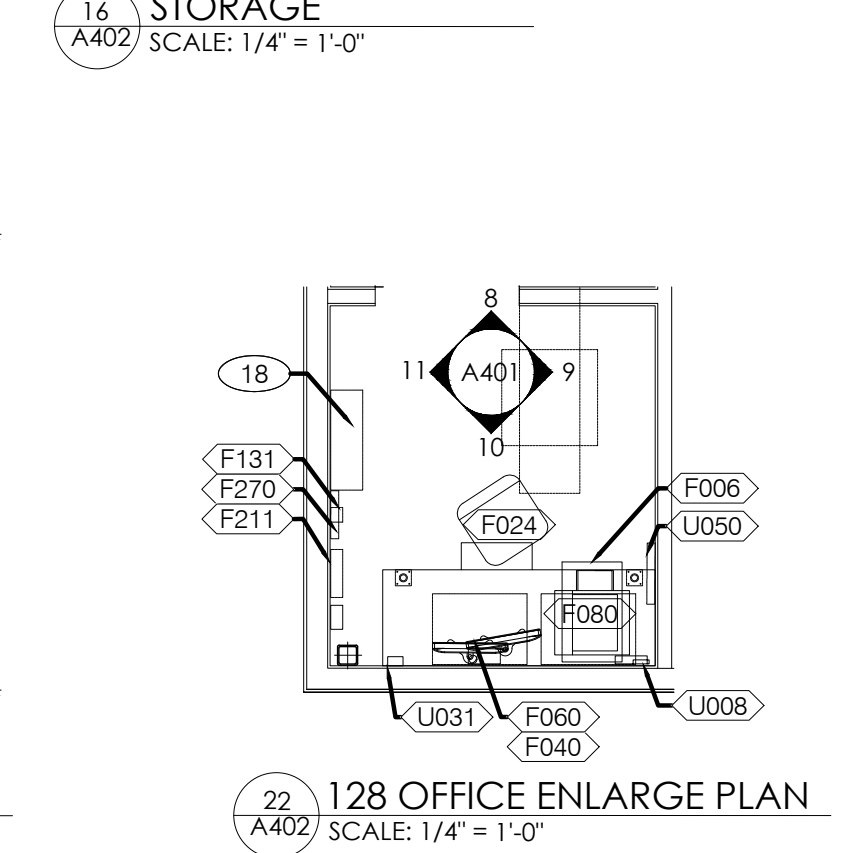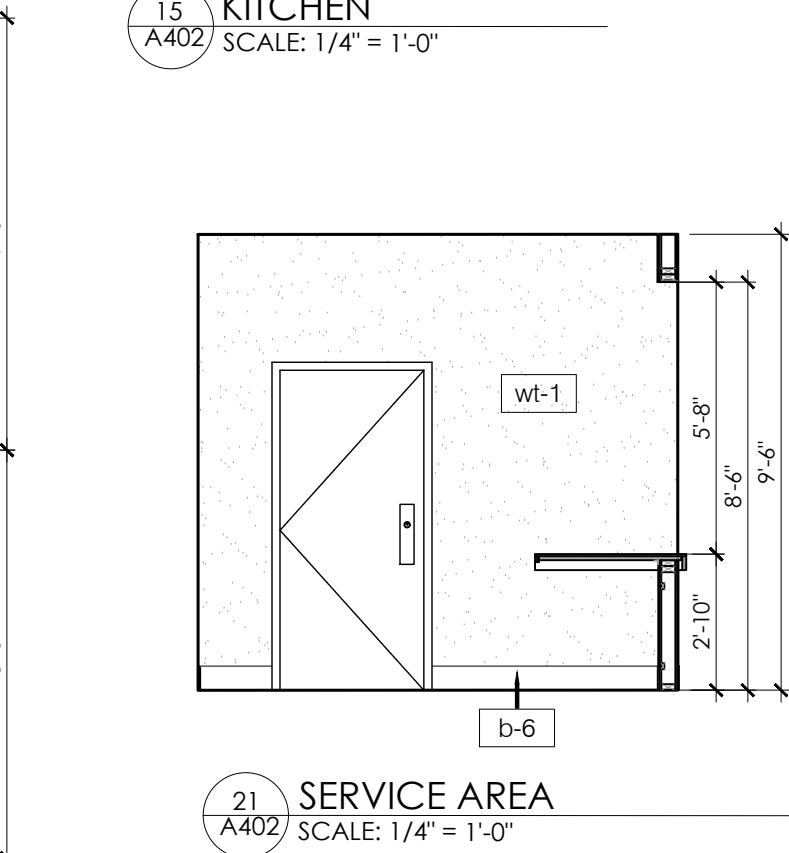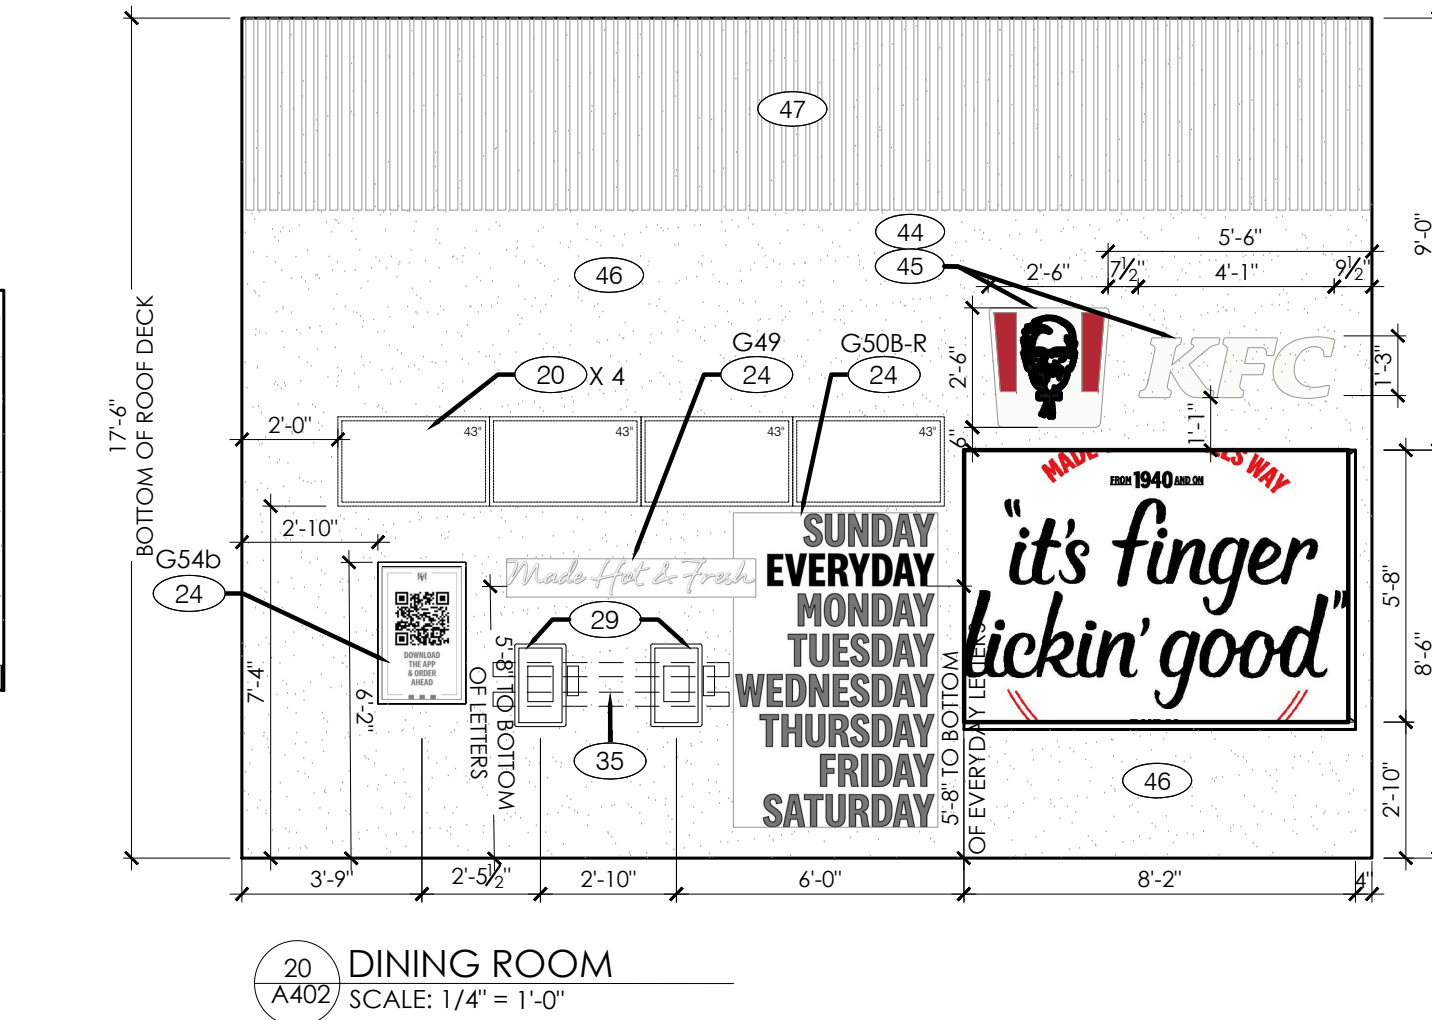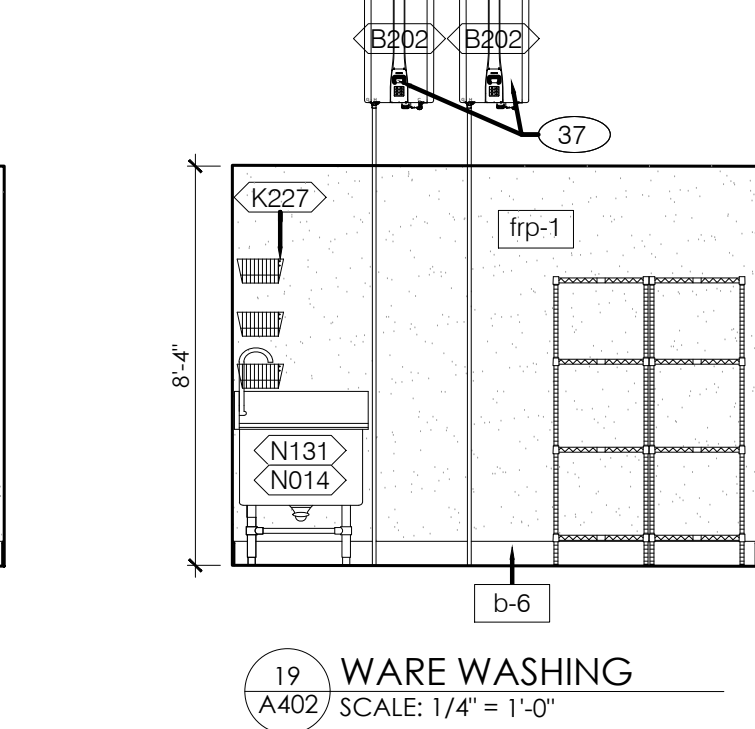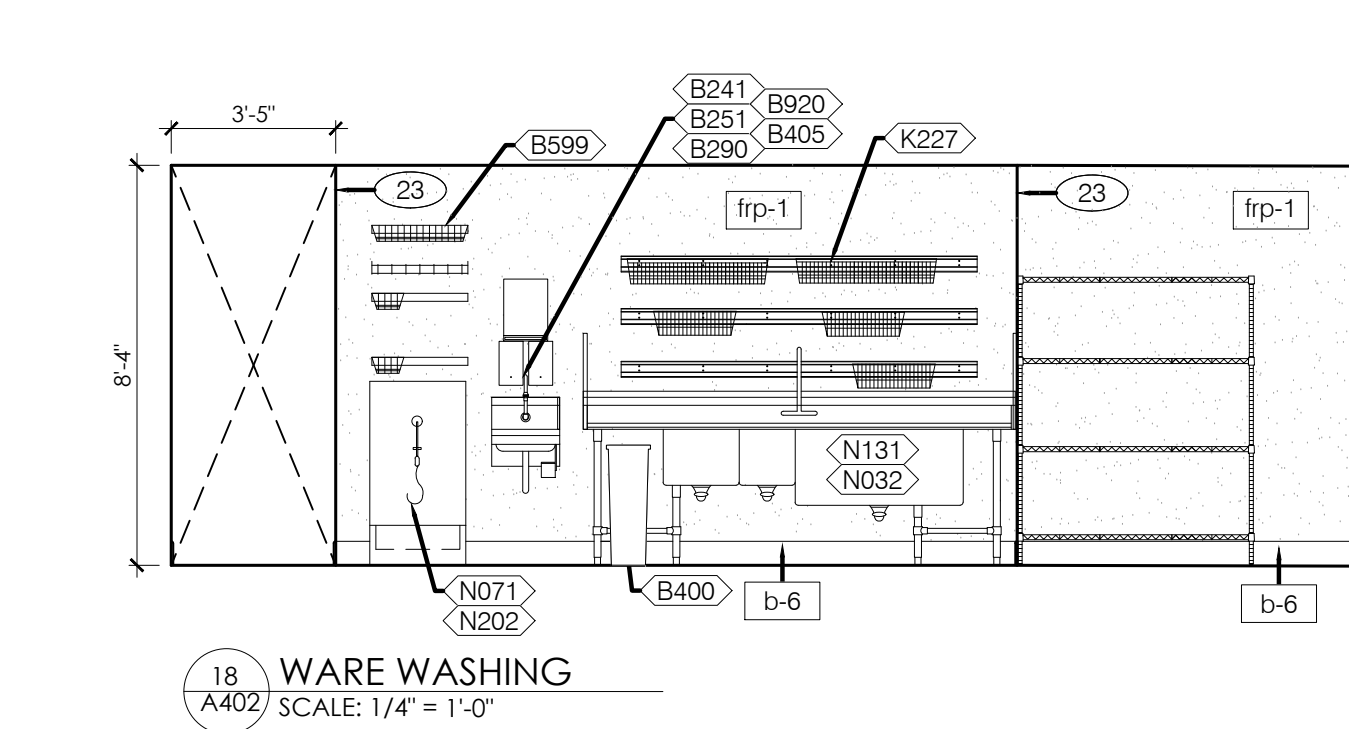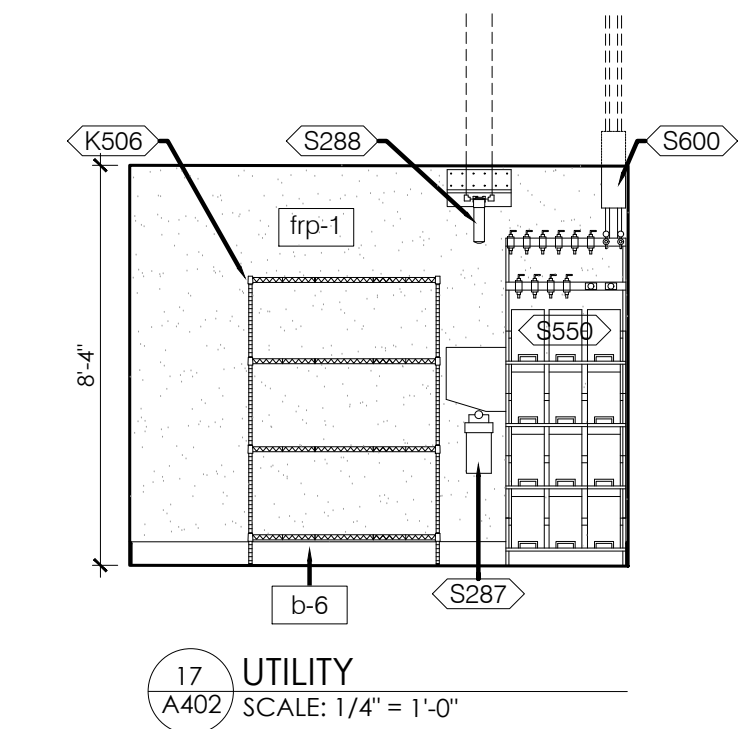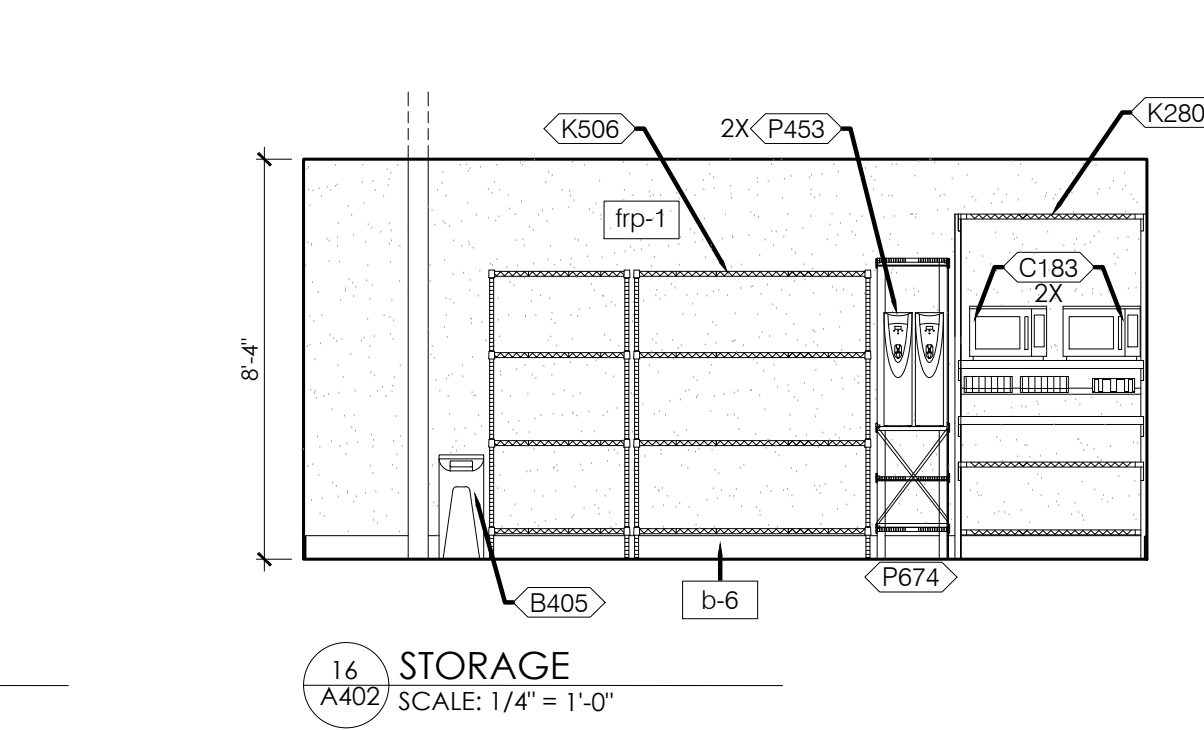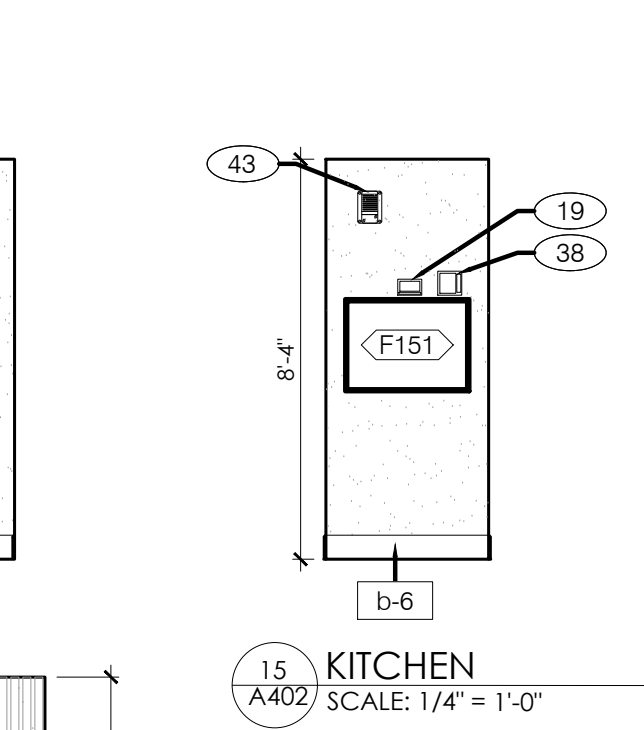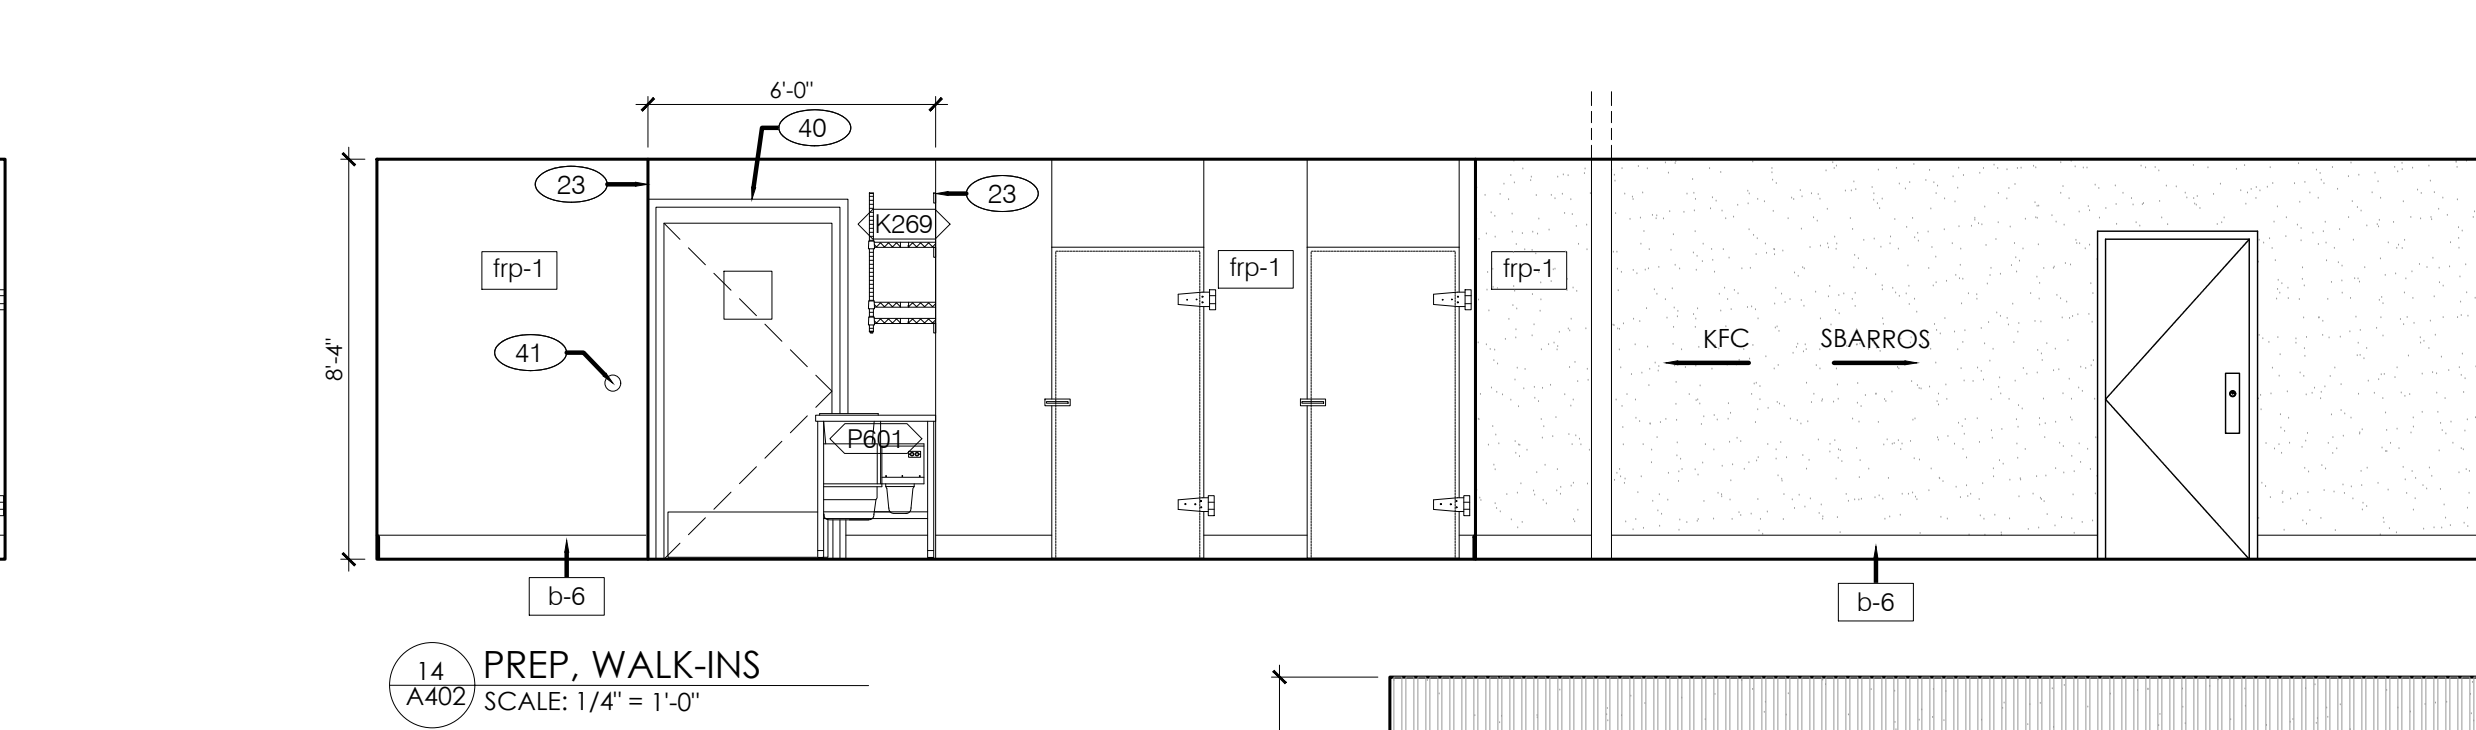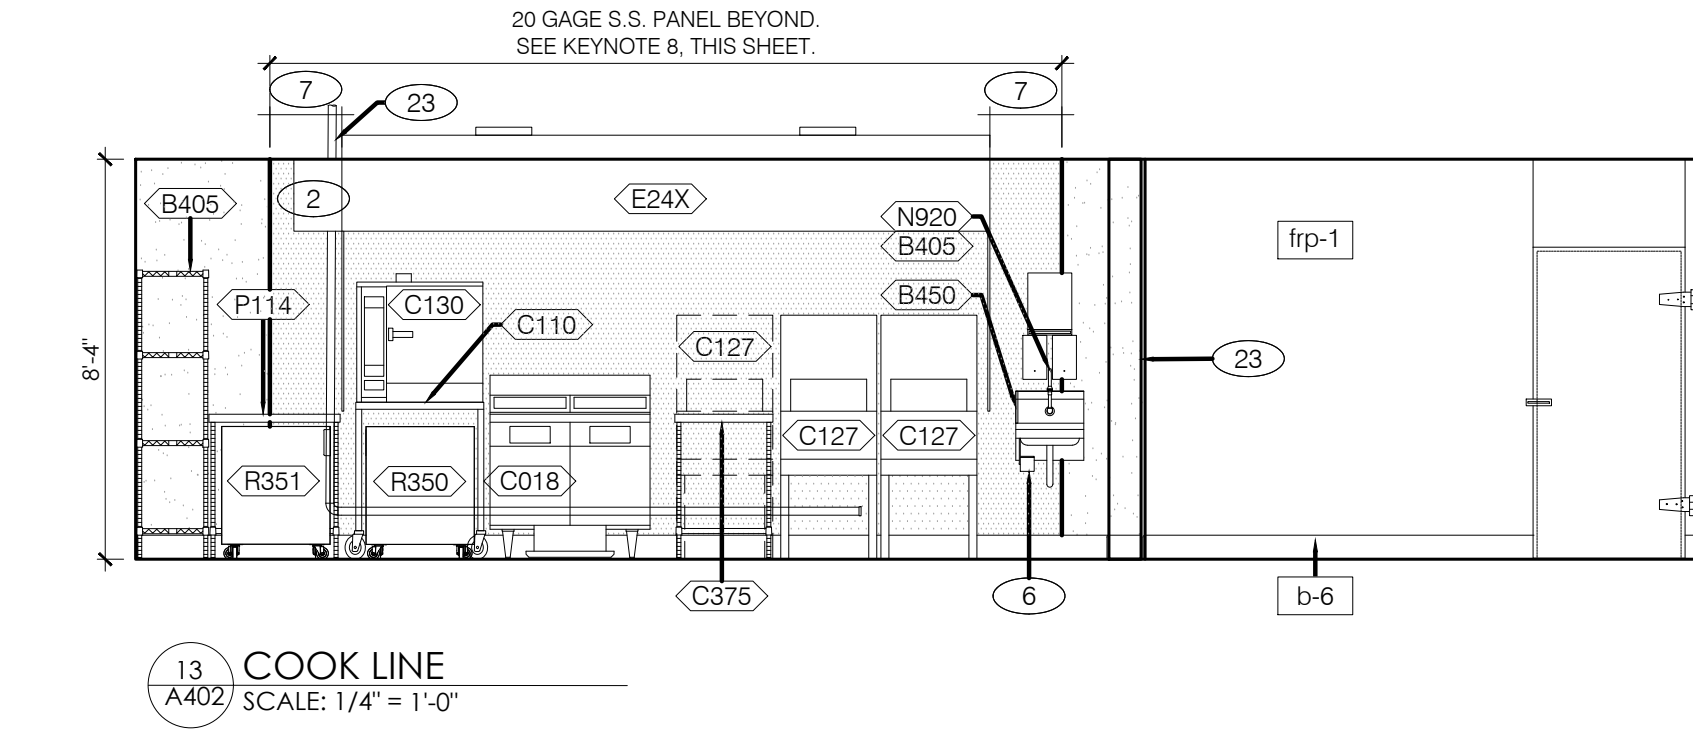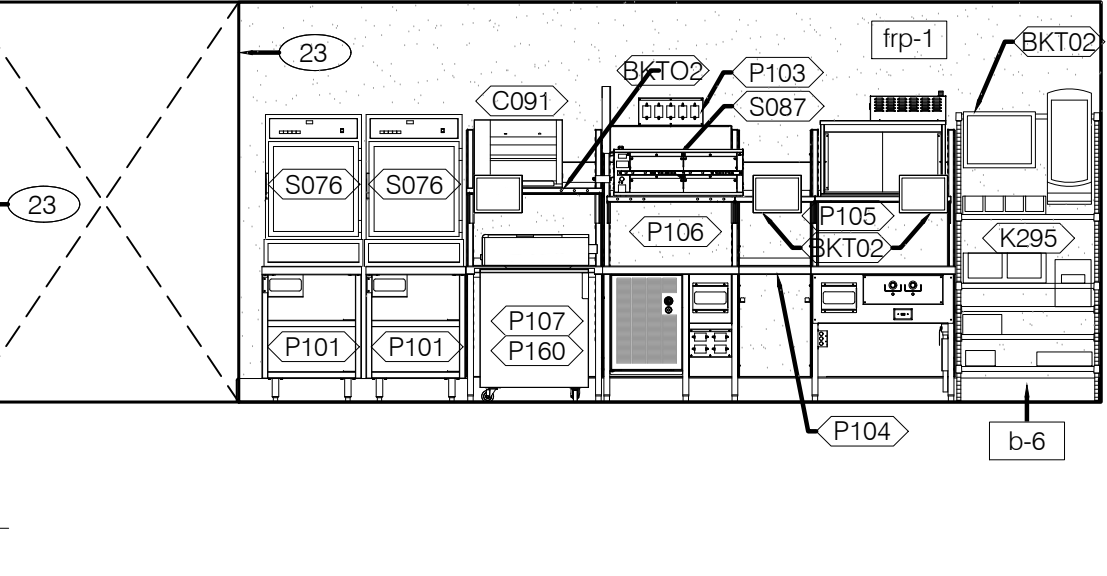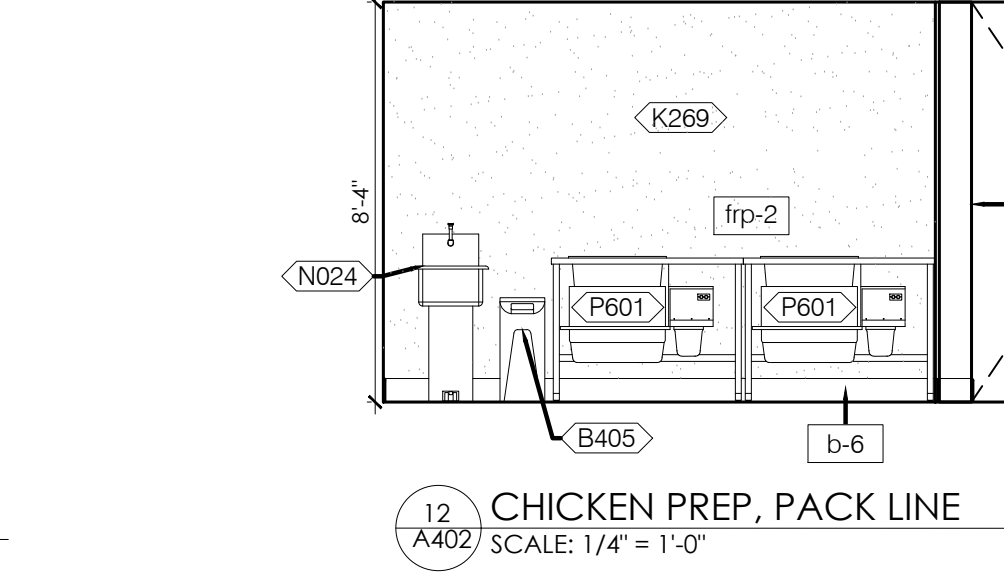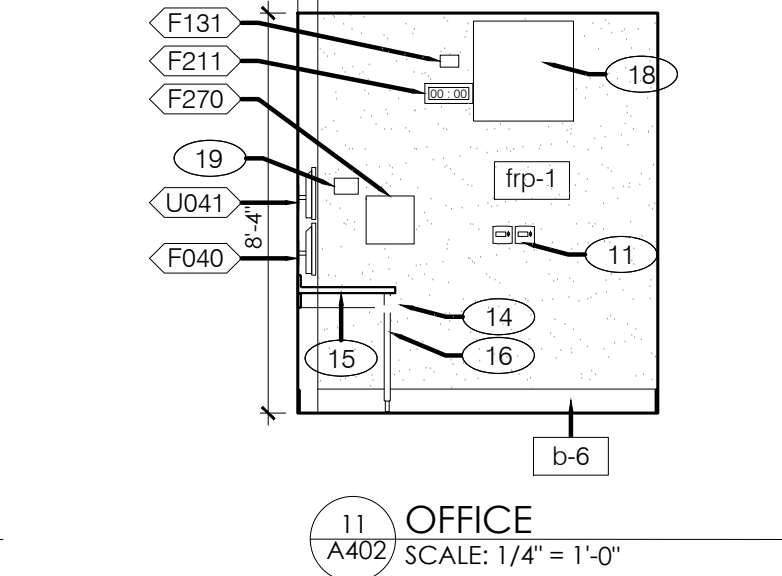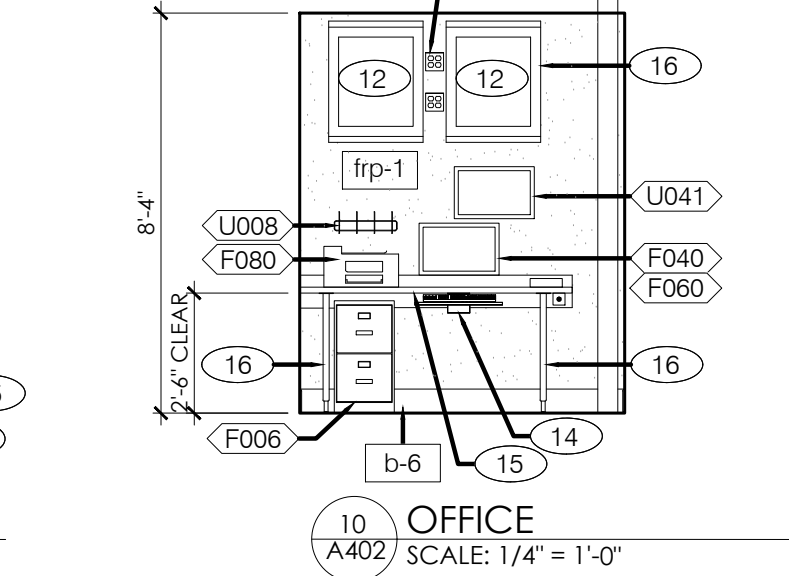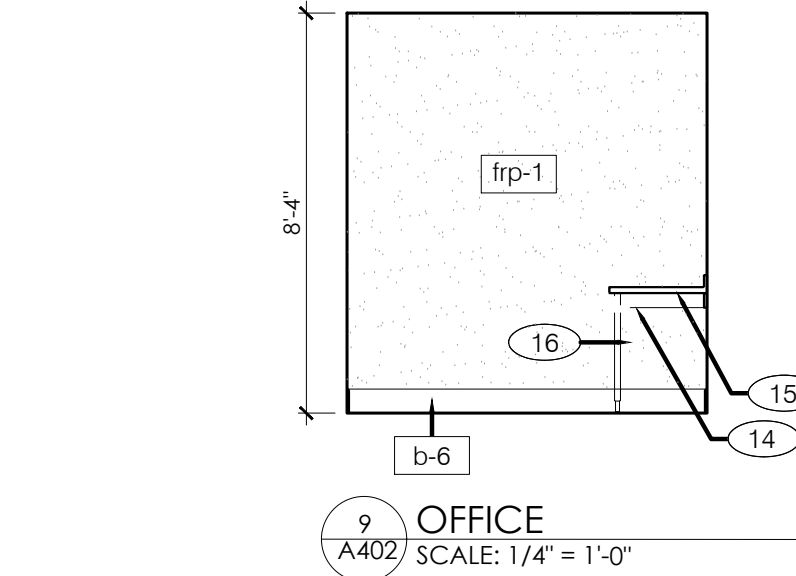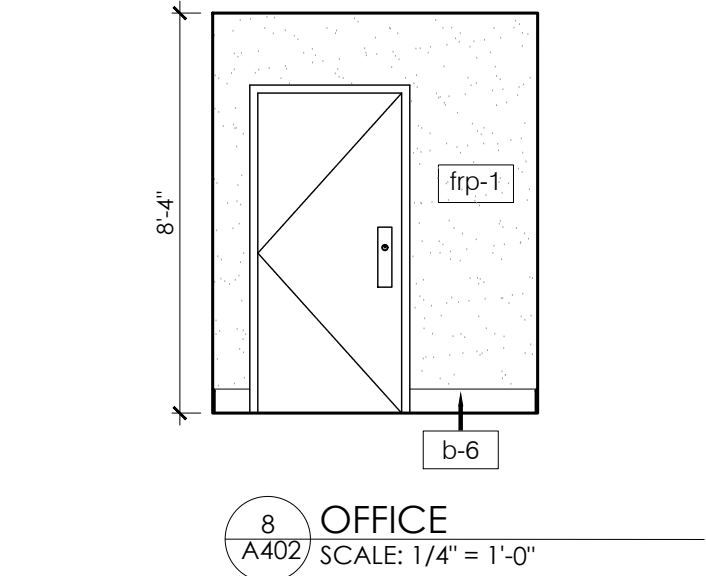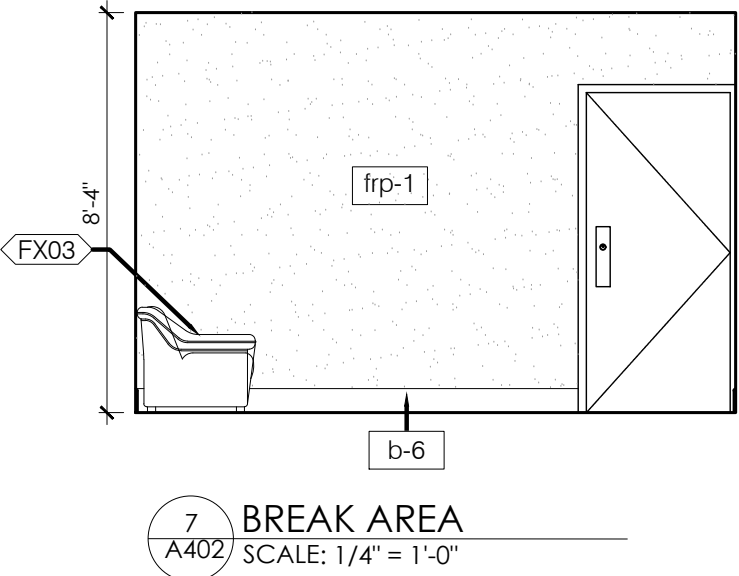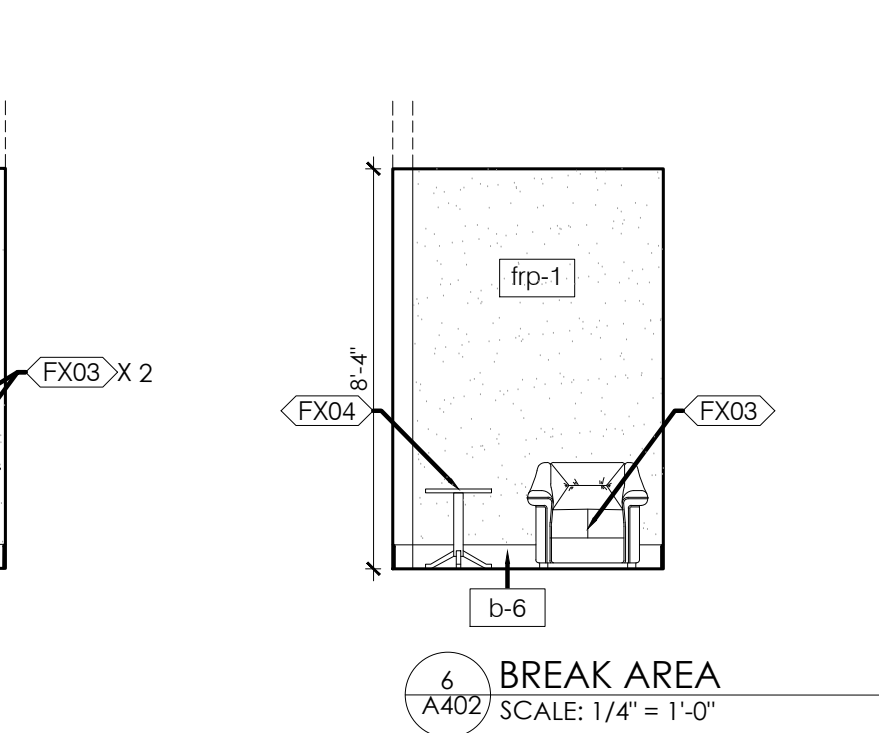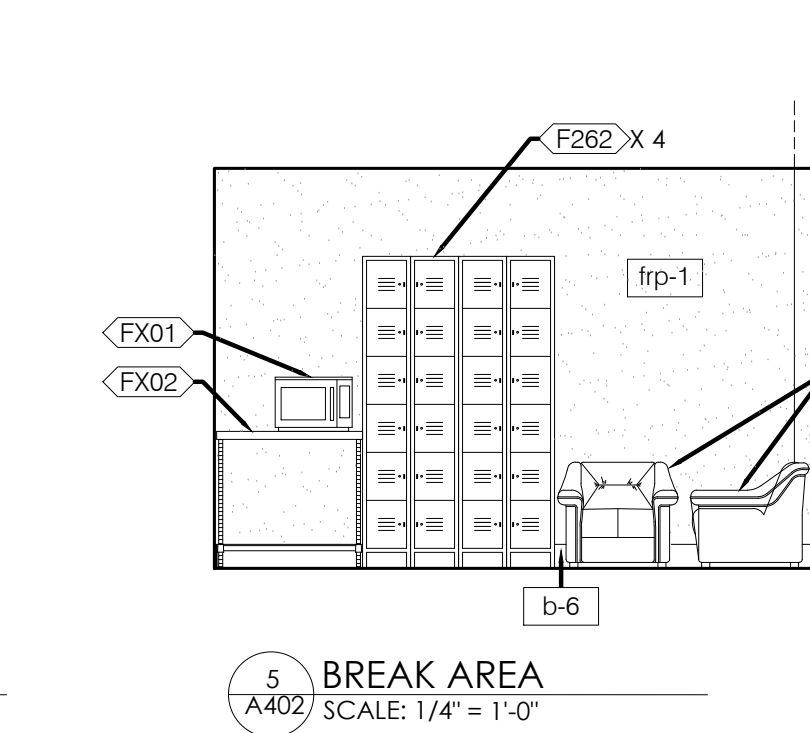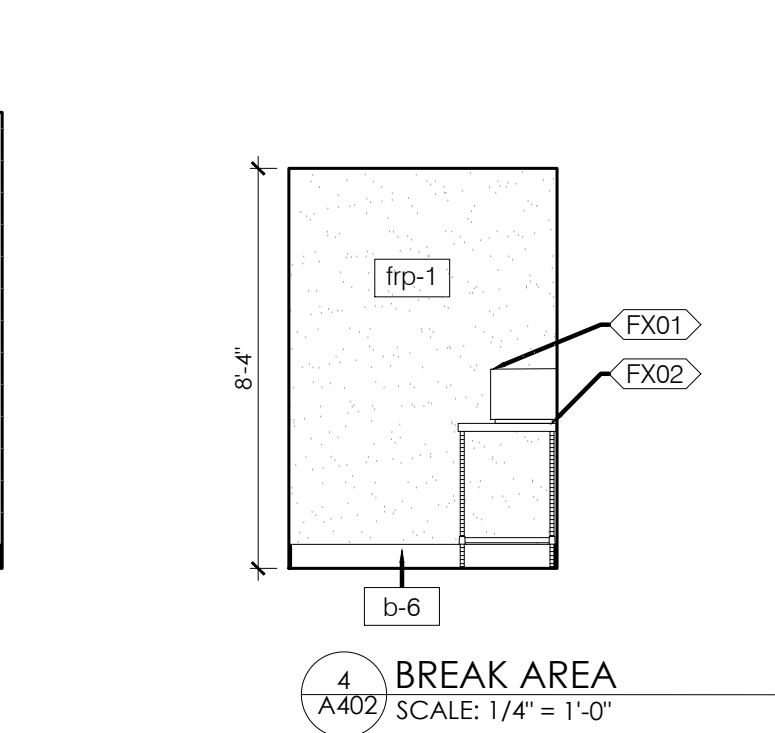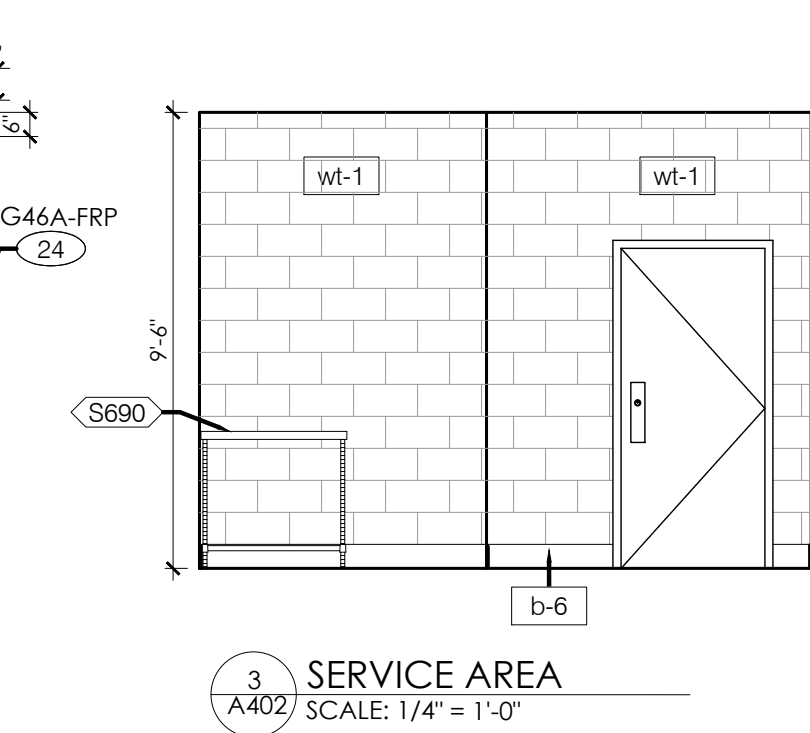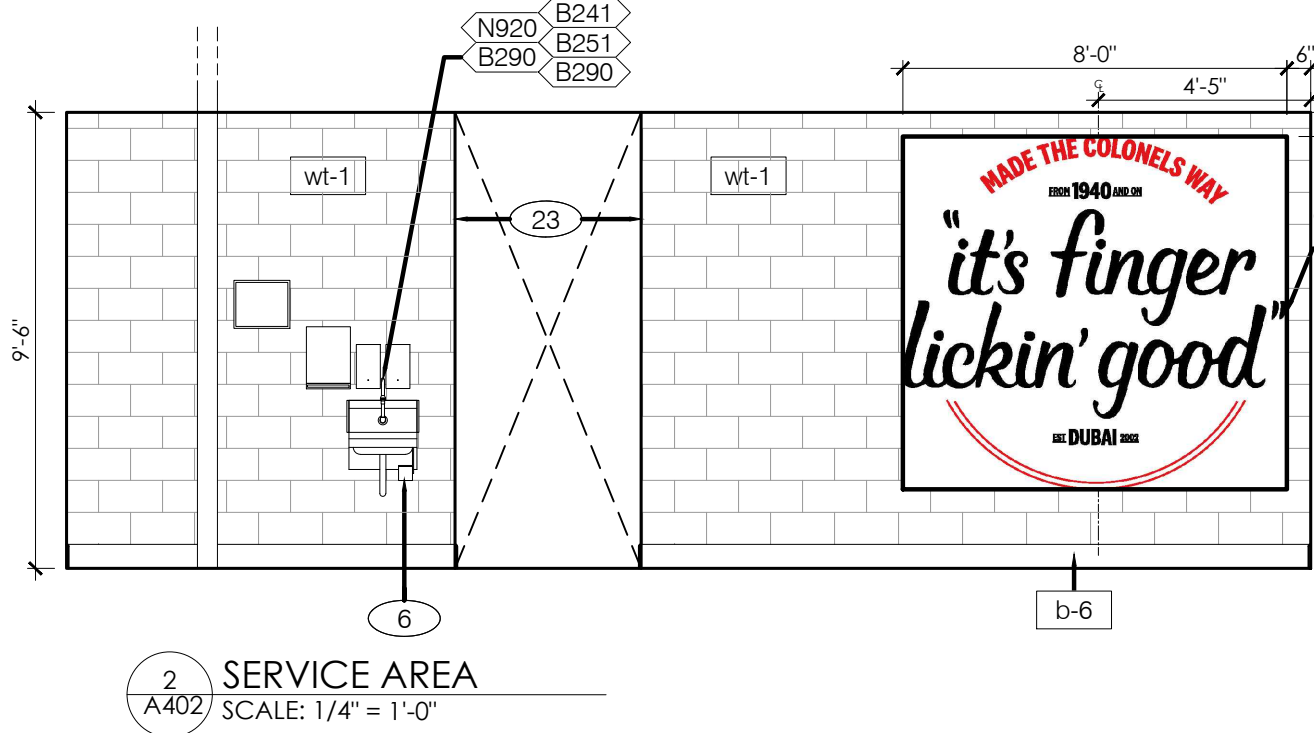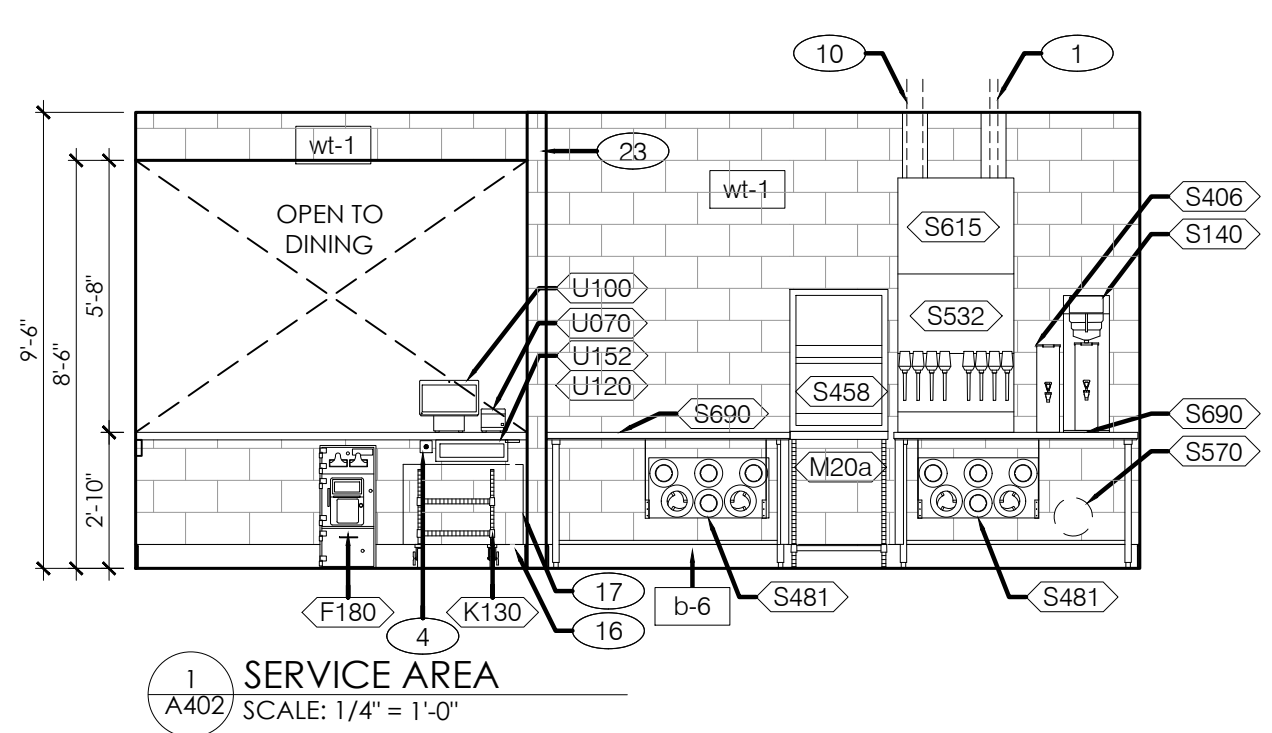

KEY NOTES

- 6" X 6" STAINLESS STEEL CHASE ALONG WALL FOR ICE MACHINE REFRIGERANT LINES. CEILING TO TOP OF ICE MACHINE; BY GENERAL CONTRACTOR.
- ANSUL CABINET.
- LOCATION OF KFC FOUNDATION ARTWORK POSTER IN FRAME.
- HOLD UP BUTTON (SECURITY SYSTEM SUPPLIER).
- S.S. END SKIRT.
- HAND SINK KNEE PEDAL.
- EDGE OF 20 GAGE STAINLESS STEEL PANEL BEHIND HOOD. COORDINATE EXTENTS OF PANEL BEYOND HOOD WITH LOCAL CODE REQUIREMENTS.
- RED VINYL DECALS ADHERED TO TILES AS INDICATED.
- GAS RISER. SEE PLUMBING DRAWINGS.
- 6" X 6" STAINLESS STEEL CHASE ALONG WALL FOR SYRUP / FILTERED WATER TUBE BUNDLES FOR DRINK SYSTEM.
- THERMOSTAT BY (EMS) SUPPLIER. SEE T1.1.
- DATA (LAN) RACK MOUNTED TO WALL. PROVIDE BLOCKING PER MFRS. REQUIREMENTS.
- TWO (2) QUAD OUTLETS BETWEEN DATA RACKS.
- UNDER COUNTER KEYBOARD TRAY.

- UNDER COUNTER KEYBOARD TRAY.
- 1-1/2" LAMINATE COUNTERTOP W/ INTEGRAL SPLASH. SEE DETAIL 9 / A-6.0 FOR SUPPORT SYSTEM, SEE SHEET A-7.2 FOR FINISHES.
- COUNTERTOP SUPPORT LEG W/ ADJUSTABLE BASE (BY G.C.). QTY. 3. SEE T1.1.
- ACCESS PANEL IN SERVING COUNTER KNEE WALL. SEE DETAIL 11A/A6.1.
- EDGE SOLUTIONS SYSTEM ELEMENTS. PROVIDE STANDARD DUPLEX OUTLET.
- CO2 MONITOR CENTRAL CONTROL.
- MENU BOARD; SEE RESPONSIBILITIES SCHEDULE ON SHEET T1.1.
- VERTICAL MONITOR.
- 3" X 3" ALUMINUM CORNER GUARDS MOUNTED TO EXPOSED SURFACES WITH SILICONE ADHESIVE. PAINT TO MATCH ADJACENT FINISH. SEE DETAIL 3 / A6.1.
- S.S. CORNER / END WALL CHANNEL GUARD, FULL HEIGHT. SEE 2 / A6.1.
- VENDOR PROVIDED ARTWORK, USE VENDOR TEMPLATE TO INSTALL AND MOUNT AT CORRECT ANGLE.
- BULKHEAD. SEE REFLECTED CEILING PLAN.
- DIMENSION IS TO BOTTOM OF LINE OF GLASS SAFETY DECALS.
- LINE OF MATERIALS TRANSITION.

- LINE OF MATERIALS TRANSITION.
- PRINTED ACM WALL PANEL W/ J-TRIM @ PERIMETER. SEE DETAILS 5 & 13/A6.2.
- CUSTOMER ORDER KIOSKS WITH ADJUSTABLE SCREEN HEIGHT. ADA ACCESS ON SCREEN AND PAYMENT DEVICE CONTROLS SHALL NOT EXCEED A HEIGHT OF 48".
- LINE OF DROPPED CEILING.
- DOUBLE-SWINGING GATE, MIN. 36" OPENING. SEE SHEETS A2.0 AND A1.1.
- LINE OF TILE COLOR CHANGE.
- GYPSON BOARD WITHIN EXTERIOR DOOR & WINDOW OPENINGS SHALL BE PAINTED P-4.
- MARLITE WALL COVERING SHALL BE INSTALLED BEHIND TILE WALL BASE.
- PROVIDE SOLID 2x BLOCKING BEHIND KIOSKS.
- HAND SINK KNEE PEDAL.
- TANKLESS WATER HEATER MOUNTED TO WALL ABOVE CEILING. COORDINATE WITH TRUSS LOCATIONS.
- CO2 SENSOR LOCATION.

- ELECTRICAL PANELS.
- SS CORNER GUARD AT SERVICE DOOR HEAD AND JAMB, SEE 17 & 18 / A6.0.
- PULL STATION.
- WALK-IN COOLER / FREEZER BOX.
- CO2 HORN STROBE LOCATION.
- PROVIDE SEALANT PER MFRS SPECIFICATIONS AT ALL WALL PENETRATIONS.
- CG TO COORDINATE WITH VENDOR PROVIDED / VENDOR INSTALLED SIGNAGE AND BUILDING ELEMENTS.
- FINISH BY T-LINES, SEE SPEC SHEETS
- SLATS BY T-LINES, SEE SPEC SHEETS

ARTWORK SCHEDULE: INTERIOR GRAPHICS

TAG	ITEM DESCRIPTION *	FURNISH/INST.	ELEC
G46-FRP	IT'S FINGER LICKIN' GOOD ROUND VINYL STAMP (8" TALL) (PRINTED FRP)	GC / **	NO
G49	MADE HOT AND FRESH - WHITE DIMENSIONAL LETTERS	GC / **	NO
G50b-R	EVERYDAY DAYS OF THE WEEK VINYL	GC / **	NO
G54b	QR CODE ART IN FRAME	GC / **	NO

* REFER TO SIGNAGE PACKAGE FOR DETAILS AND MOUNTING HEIGHTS
** GC INSTALL OR SUBCONTRACT DECOR INSTALLER

ARCHITECT OF RECORD:

THOMAS E. MORGAN, JR.
ARCHITECT

423 FISCHER TRAIL
ELLIJAY, GEORGIA 30540

SEAL:

MRP
DESIGN GROUP

3450 Acworth Due West Road
Building 100, Suite 120
Kennesaw, Georgia 30144
P. 770-917-9172
F. 770-917-9470
www.mrpdesign.com

RELEASED FOR
CONSTRUCTION

ISSUES / REVISIONS:

DATE	DESCRIPTION
01.26.28	COMPILED SET RELEASED FOR CONSTRUCTION

DRAWN BY:

CHKD BY:

PROJECT DESCRIPTION:

DEVELOPMENT OF INTERIORS
CONDITIONS FOR A C-STORE IN
CORDELE, GA.

PROJECT TITLE:

CONVENIENCE STORE
379 ROCKHOUSE RD E,
CORDELE, GA 31015


SHEET TITLE:

INTERIOR
ELEVATIONS, OFFICE
ENLARGE PLAN


PROJECT NO: 25049

A402

THESE PLANS ARE THE PROPERTY OF MRP DESIGN GROUP, INC. AND ARE SUBJECT TO FEDERAL COPYRIGHT LAWS. ANY USE OF SAME WITHOUT THE EXPRESS WRITTEN PERMISSION OF MRP DESIGN GROUP, INC. IS STRICTLY PROHIBITED

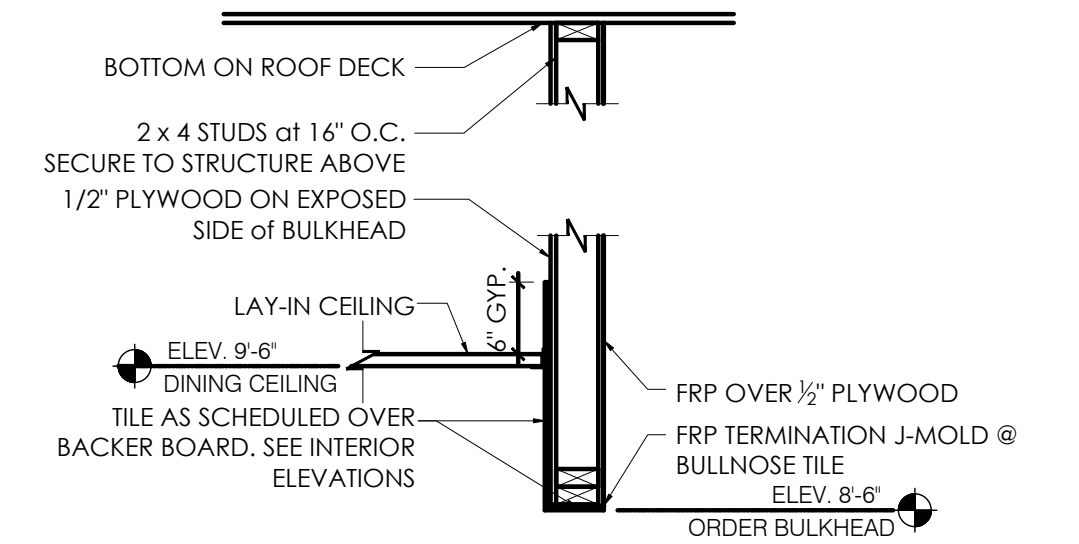


1 SECTION AT ORDER AREA BULKHEAD
SCALE: 3/4" = 1'-0"

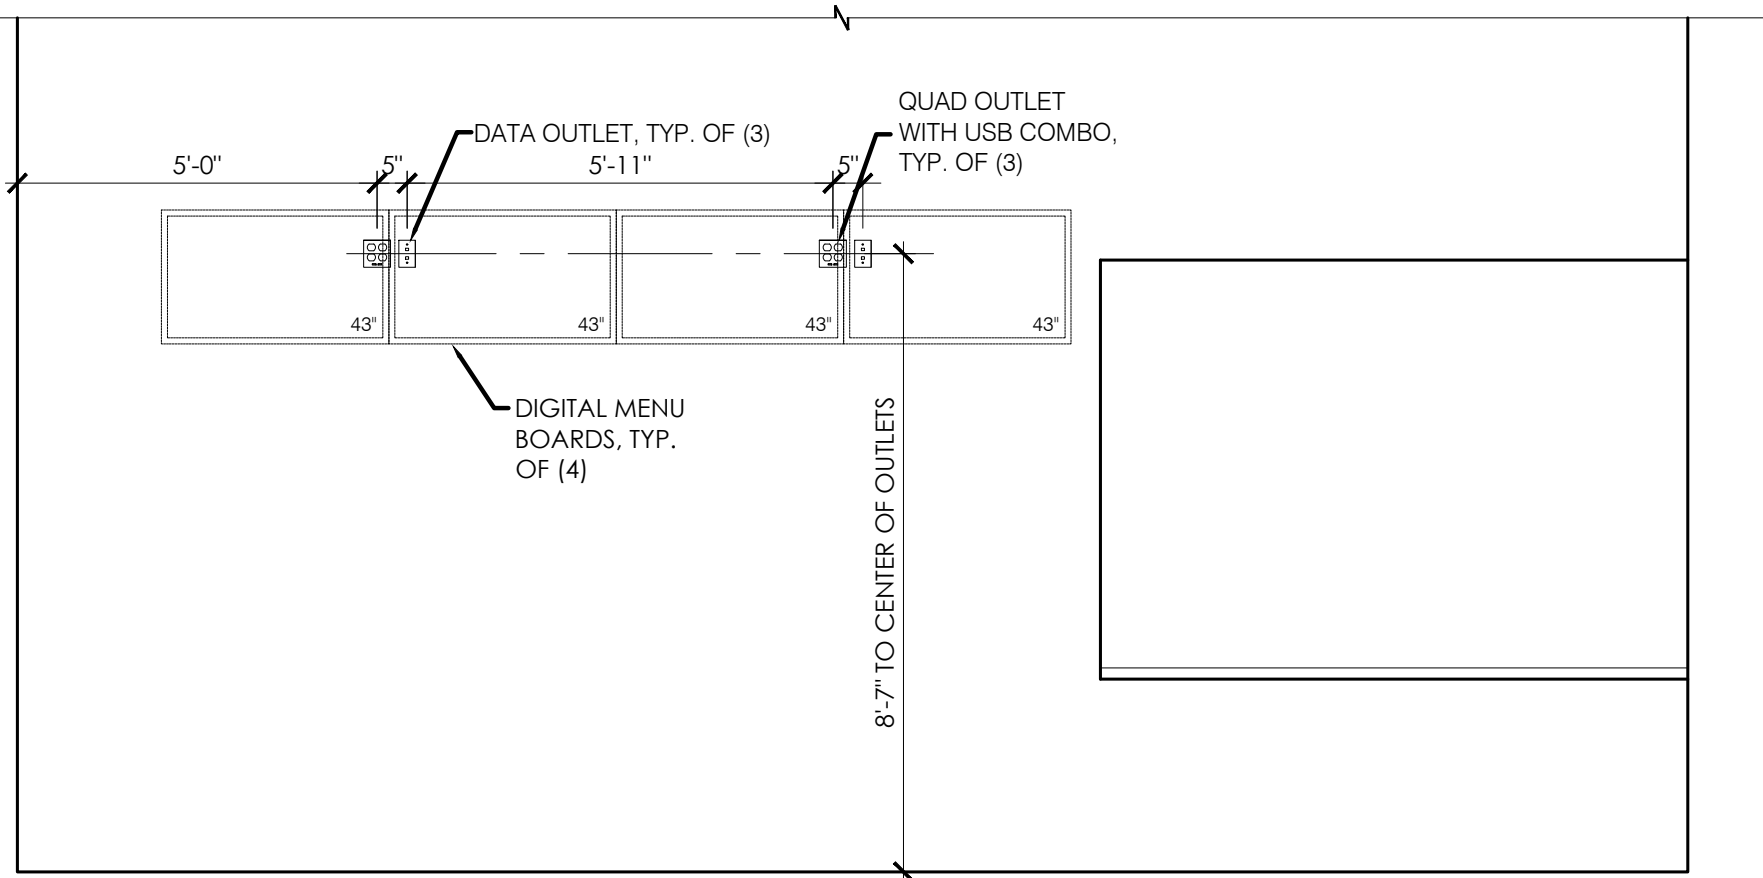


- NOTES:
- GC SHALL VERIFY CEILING HEIGHT AND WALL DIMENSIONS PRIOR TO MENUBOARD INSTALLATION.
 - MONITORS SHALL BE 43".
 - GC SHALL CONFIRM GROUNDING REQUIREMENTS. REFER TO INSTALLATION INSTRUCTIONS FOR FULL REQUIREMENTS AND PLACEMENT OF EQUIPMENT.
 - IF MENUBOARDS ARE NOT DIGITAL, PROVIDE CONDUIT AND PULL STRINGS FOR FUTURE DIGITAL MENUBOARDS POWER, COORDINATE WITH VENDOR FOR EXACT REQUIREMENTS FOR MENUBOARDS.


2 DIGITAL MENUBOARD OUTLETS
SCALE: 3/8" = 1'-0"

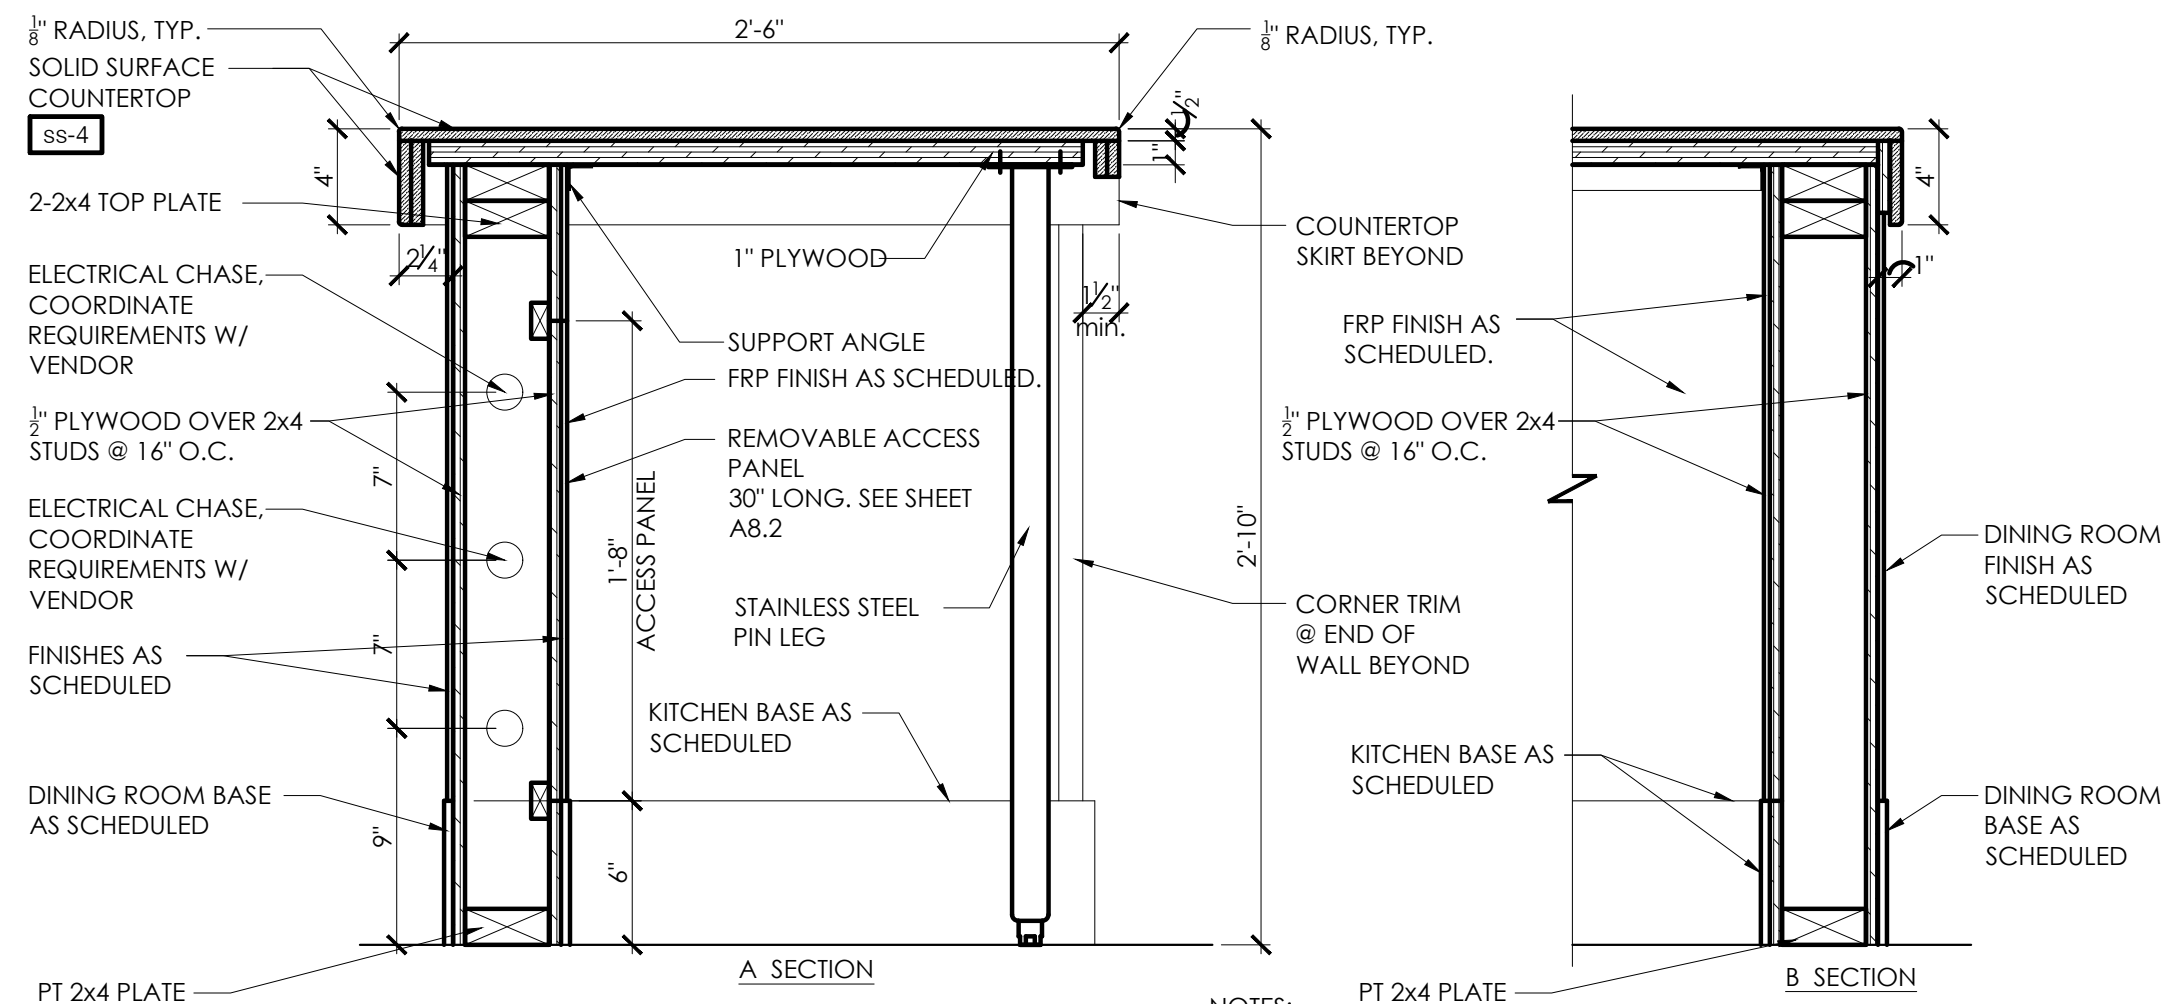


3 SERVICE COUNTER
SCALE: 1 1/2" = 1'-0"

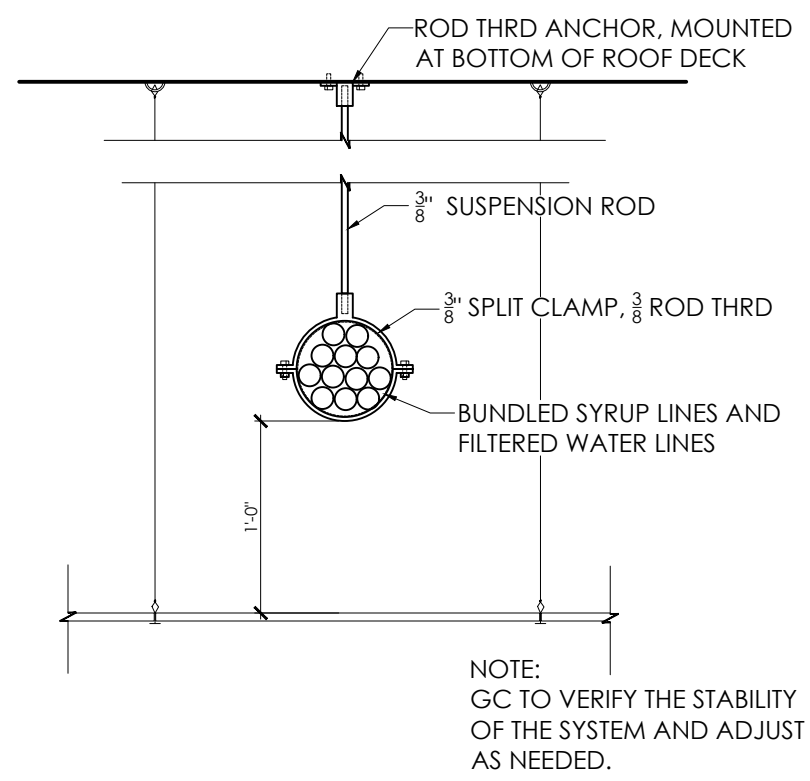


4 SYRUP LIN IN CEILING
SCALE: 1" = 1'-0"

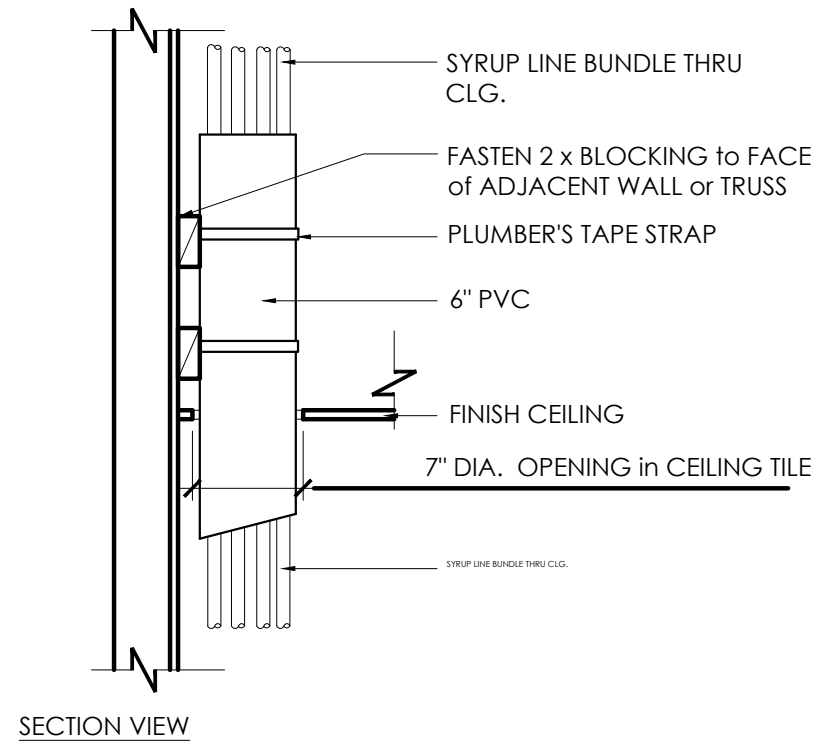


5 SYRUP BUNDLE CLG. PENETRATION
SCALE: 1" = 1'-0"

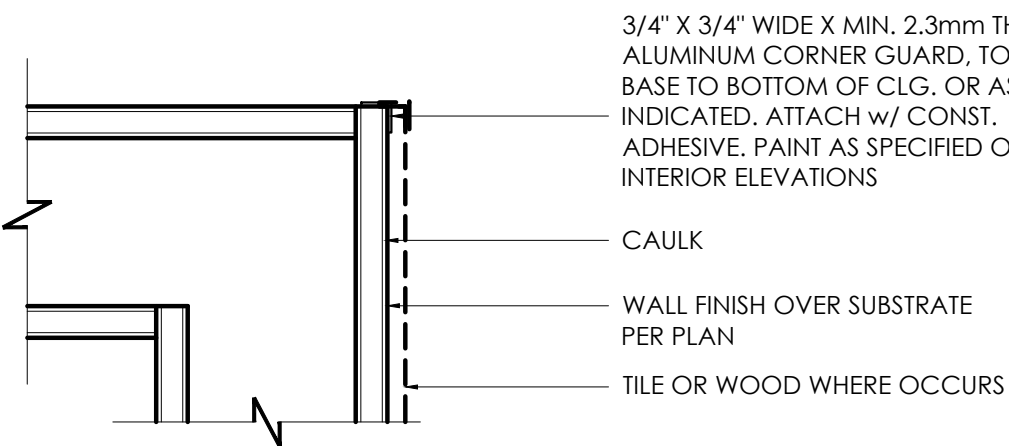


6 CORNER GUARD @ CUSTOMER AREA
SCALE: 3" = 1'-0"

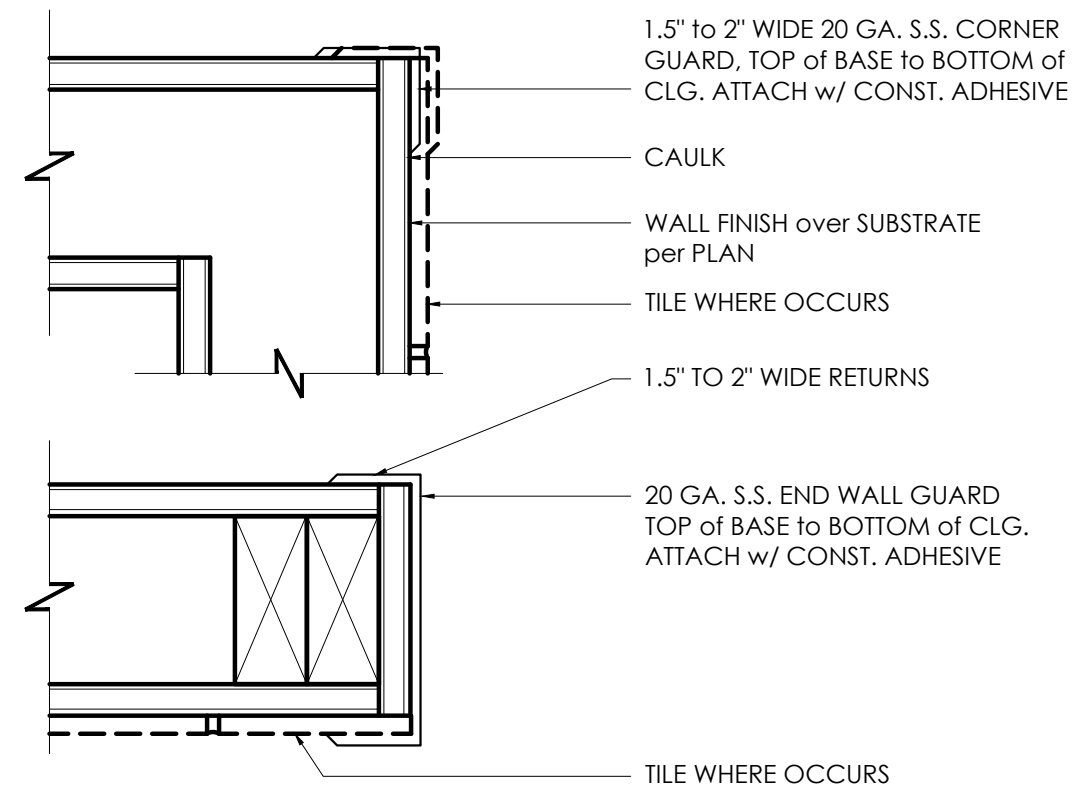


7 CORNER GUARD
SCALE: 3" = 1'-0"

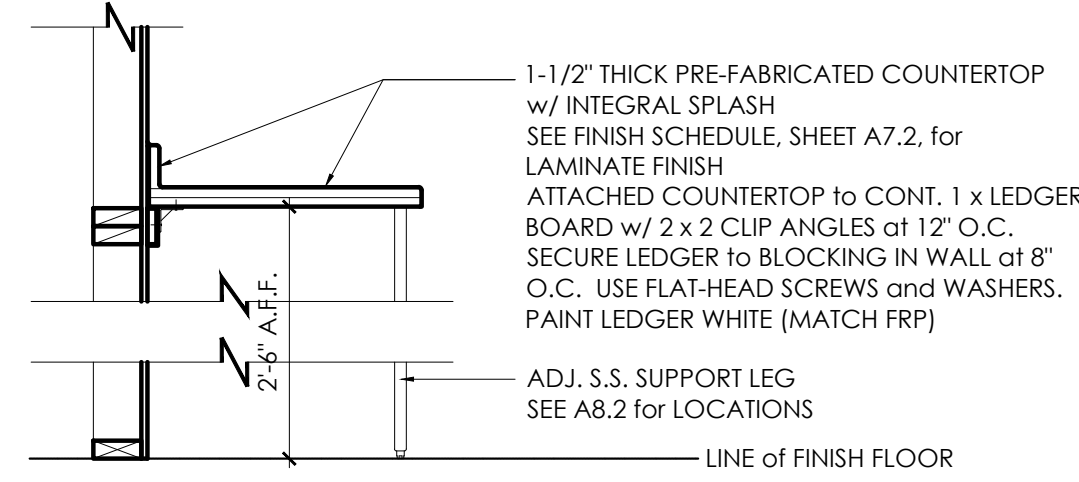


8 OFFICE COUNTER
SCALE: 3/4" = 1'-0"

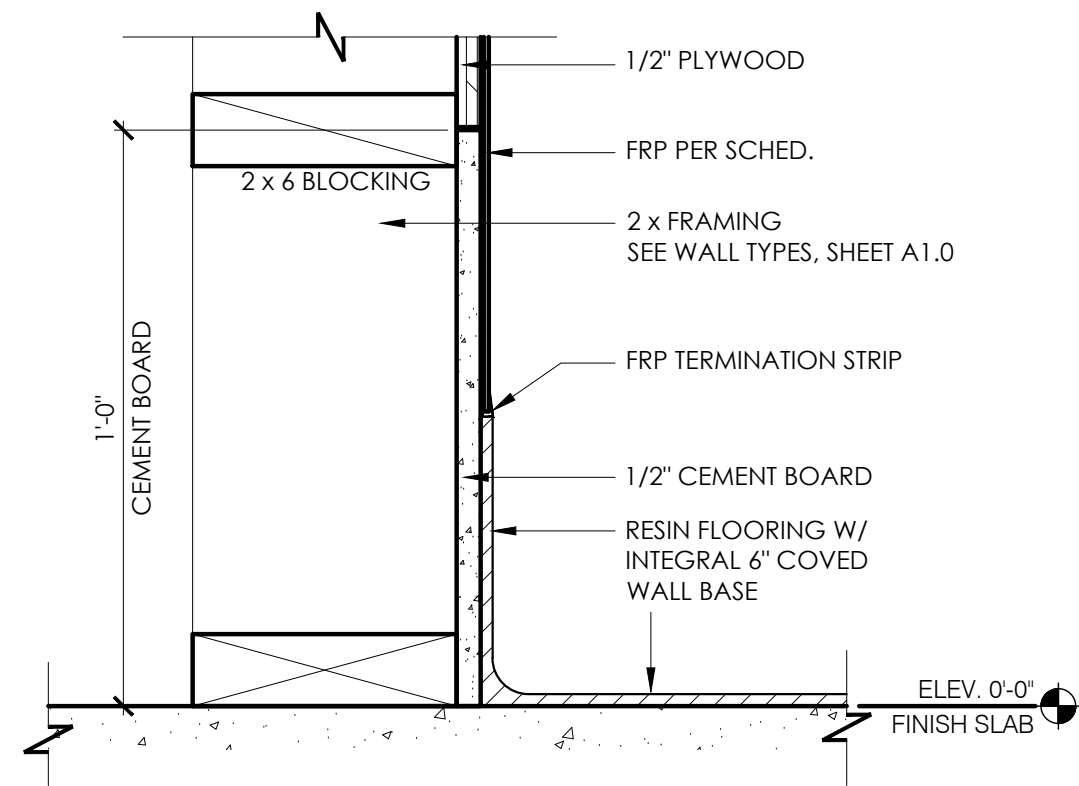


9 BASE @ INT PARTITION (KITCHEN)
SCALE: 3" = 1'-0"

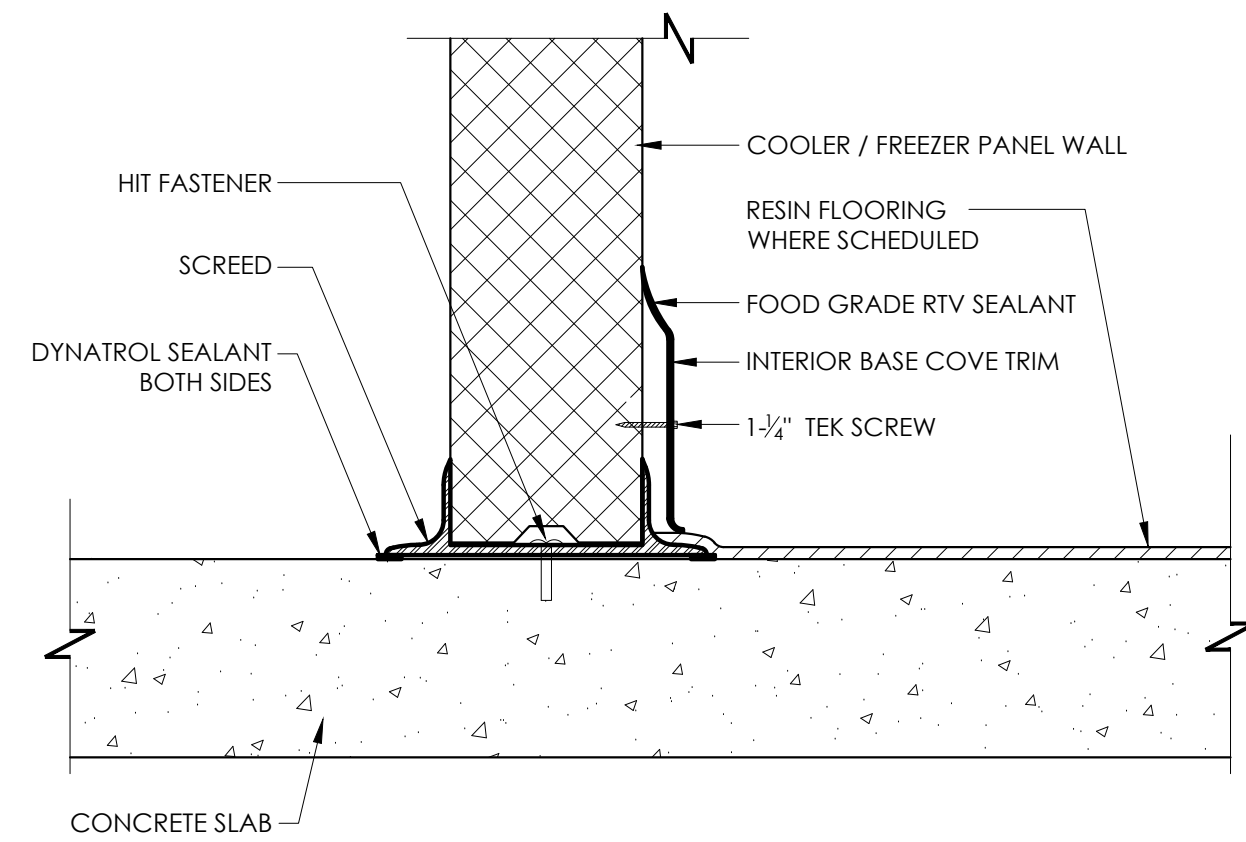

10 BASE @ WALK-IN COOLER/FREEZER
SCALE: 3" = 1'-0"

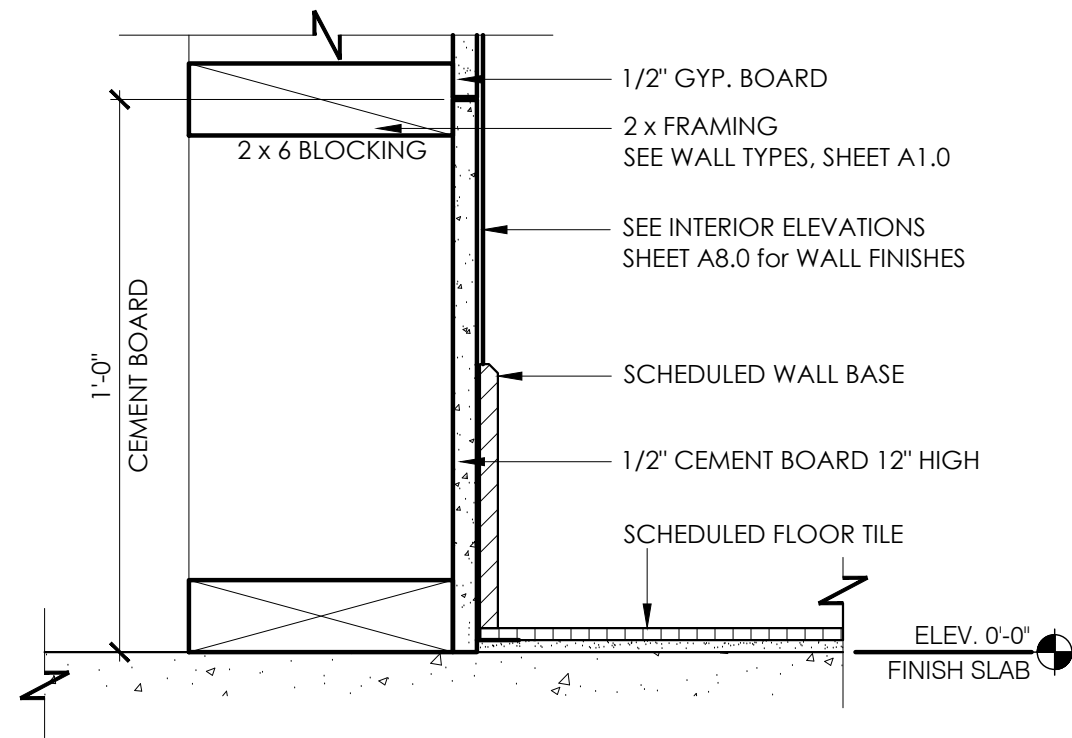

11 BASE @ INT. PARTITION (DINING)
SCALE: 3" = 1'-0"

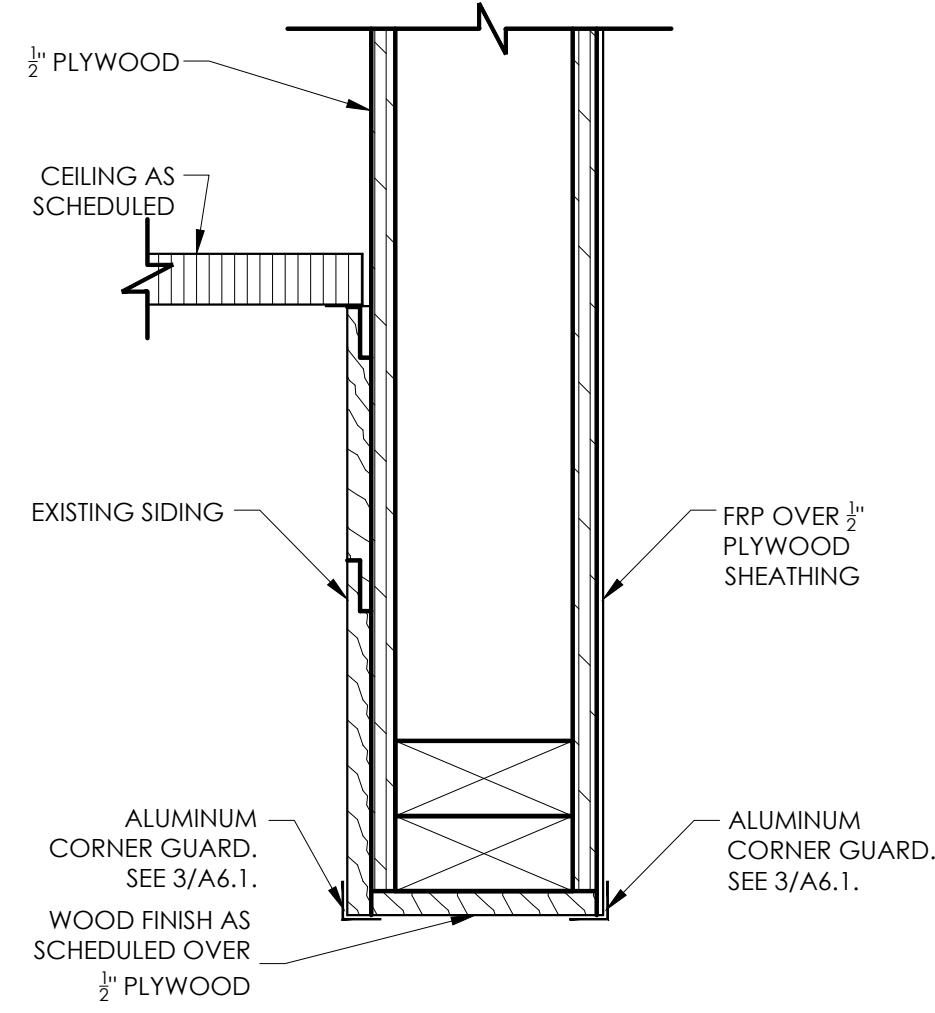

12 BASE @ WALK-IN COOLER / FREEZER
SCALE: 3" = 1'-0"

ARCHITECT OF RECORD:

THOMAS E. MORGAN, JR.
ARCHITECT

423 FISCHER TRAIL
ELLIJAY, GEORGIA 30540

SEAL:

MRP
DESIGN GROUP

3450 Acworth Due West Road
Building 100, Suite 120
Kennesaw, Georgia 30144
P: 770-917-9172
F: 770-917-9470
www.mrpdesign.com

RELEASED FOR
CONSTRUCTION

ISSUES / REVISIONS:

DATE	DESCRIPTION
01.26.28	COMPILED SET RELEASED FOR CONSTRUCTION

DRAWN BY:

CHKD BY:

PROJECT DESCRIPTION:

DEVELOPMENT OF INTERIORS
CONDITIONS FOR A C-STORE IN
CORDELE, GA.

PROJECT TITLE:

CONVENIENCE STORE
379 ROCKHOUSE RD E,
CORDELE, GA 31015

SHEET TITLE:

KFC
INTERIOR
DETAILS

PROJECT NO: 25049


A401.1

THESE PLANS ARE THE PROPERTY OF MRP DESIGN GROUP, INC. AND ARE SUBJECT TO FEDERAL COPYRIGHT LAWS. ANY USE OF SAME WITHOUT THE EXPRESS WRITTEN PERMISSION OF MRP DESIGN GROUP, INC. IS STRICTLY PROHIBITED.


GRAPHICS AND ARTWORK SCHEDULE - "G"					
DESIGN ID	COUNT	DESCRIPTION	FURN. BY	INST. BY	COMMENTS
17216	1	ART - UNKNOWN ARTIST - GREEN BEAN CLOSEUP	SB	GC	FRAME WITHOUT MAT - ART SIZE 10.75"W X 16"H - OVERALL SIZE 12.25"W X 17.5"H - PAPER 1 - FRAME 1C 613677 NATURAL MAPLE - 1/4" SPACER
19148	1	ART - CREATIVE STUDIO - COSTA RICA 6 - BW	SB	GC	FRAME WITHOUT MAT - ART SIZE 21.5"W X 21.5"H - OVERALL SIZE 23"W X 23"H - PAPER 1 - FRAME 1C 613677 NATURAL MAPLE - 1/4" SPACER. CROP AS INDICATED.
19181	1	ART - CREATIVE STUDIO - HACIENDA ALSACIA 6 - COLOR	SB	GC	FRAME WITHOUT MAT - ART SIZE 24"W X 16"H - OVERALL SIZE 25.5"W X 17.5"H - PAPER 1 - FRAME 1C 613677 NATURAL MAPLE - 1/4" SPACER
22080	1	ART - JOSHUA TRUJILLO - COSTA RICA 6 - COLOR	SB	GC	FRAME WITHOUT MAT - ART SIZE 22"W X 14.5"H - OVERALL SIZE 23.5"W X 16"H - PAPER 1 - FRAME 1C 613677 NATURAL MAPLE - 1/4" SPACER
24443	1	ART - LILY CHOU - SEATTLE ROASTERY - 7 - BW	SB	GC	FRAMED WITH MAT - ART SIZE 20"W X 30" H - MAT BORDER 3" - OVERALL SIZE 27.5" W X 37.5" H - PAPER 1 - MAT 1 - FRAME 1C 613677 NATURAL MAPLE
24448	1	ART - LILY CHOU - SEATTLE ROASTERY - 4 - BW	SB	GC	FRAMED WITH MAT - ART SIZE 20"W X 30" H - MAT BORDER 3" - OVERALL SIZE 27.5" W X 37.5" H - PAPER 1 - MAT 1 - FRAME 1C 613677 NATURAL MAPLE
24452	1	ART - LILY CHOU - SEATTLE ROASTERY - 2 - BW	SB	GC	FRAMED WITH MAT - ART SIZE 20"W X 30" H - MAT BORDER 3" - OVERALL SIZE 27.5" W X 37.5" H - PAPER 1 - MAT 1 - FRAME 1C 613677 NATURAL MAPLE
24641	1	ART - KIMBERLY TROWBRIDGE - PERU FROM MACHU PICCHU	SB	GC	WRAPPED CANVAS IN FLOAT FRAME - ART SIZE 29"W X 29"H - REVEAL .25" - PRINT TO EDGES - PRINT EDGES BLACK - OVERALL SIZE 30"W X 30"H - CANVAS 1 - FRAME 3C 623677 NATURAL MAPLE
24642	1	ART - KIMBERLY TROWBRIDGE - PERU FROM MACHU PICCHU SKETCH	SB	GC	FRAME WITHOUT MAT - ART SIZE 8"W X 12"H - OVERALL SIZE 9.5"W X 13.5"H - PAPER 1 - FRAME 1C 613677 NATURAL MAPLE - 1/4" SPACER
24644	1	ART - KIMBERLY TROWBRIDGE - COFFEE WITH PERUVIAN LLAMAS SKETCH	SB	GC	FRAME WITHOUT MAT - ART SIZE 8"W X 12"H - OVERALL SIZE 9.5"W X 13.5"H - PAPER 1 - FRAME 1C 613677 NATURAL MAPLE - 1/4" SPACER. THIS IMAGE CANNOT BE CROPPED
24690	1	ART - REBECCA ZWANZIG - YOUNG COFFEE CHERRY FRACTAL	SB	GC	FRAMED WITH MAT - ART SIZE 24" W X 30" H - MAT BORDER 3" - OVERALL SIZE 31.5" W X 36.5" H - PAPER 1 - MAT 1 - FRAME 1C 613677 NATURAL MAPLE. THIS IMAGE CANNOT BE CROPPED

GRAPHICS AND ARTWORK SCHEDULE - "G"					
DESIGN ID	COUNT	DESCRIPTION	FURN. BY	INST. BY	COMMENTS
24691	1	ART - REBECCA ZWANZIG - COFFEE FLOWER FRACTAL	SB	GC	FRAMED WITH MAT - ART SIZE 24" W X 30" H - MAT BORDER 3" - OVERALL SIZE 31.5" W X 36.5" H - PAPER 1 - MAT 1 - FRAME 1C 613677 NATURAL MAPLE. THIS IMAGE CANNOT BE CROPPED
GRAPHICS - OTHER					
23136	1	AUTOMATIC DOOR CAUTION SIGNAGE	GC	GC	


SIGNAGE SCHEDULE - "S"					
DESIGN ID	COUNT	DESCRIPTION	FURN. BY	INST. BY	COMMENTS
SIGNAGE - DISK					
13164	2	SIGN - DISK SF ILLUMINATED FLUSH MOUNTED EVOLVED - 60IN 1525MM	SB	SB	
13193	1	SIGN - DISK SF ILLUMINATED FLUSH MOUNTED EVOLVED - 30IN 760MM	SB	SB	

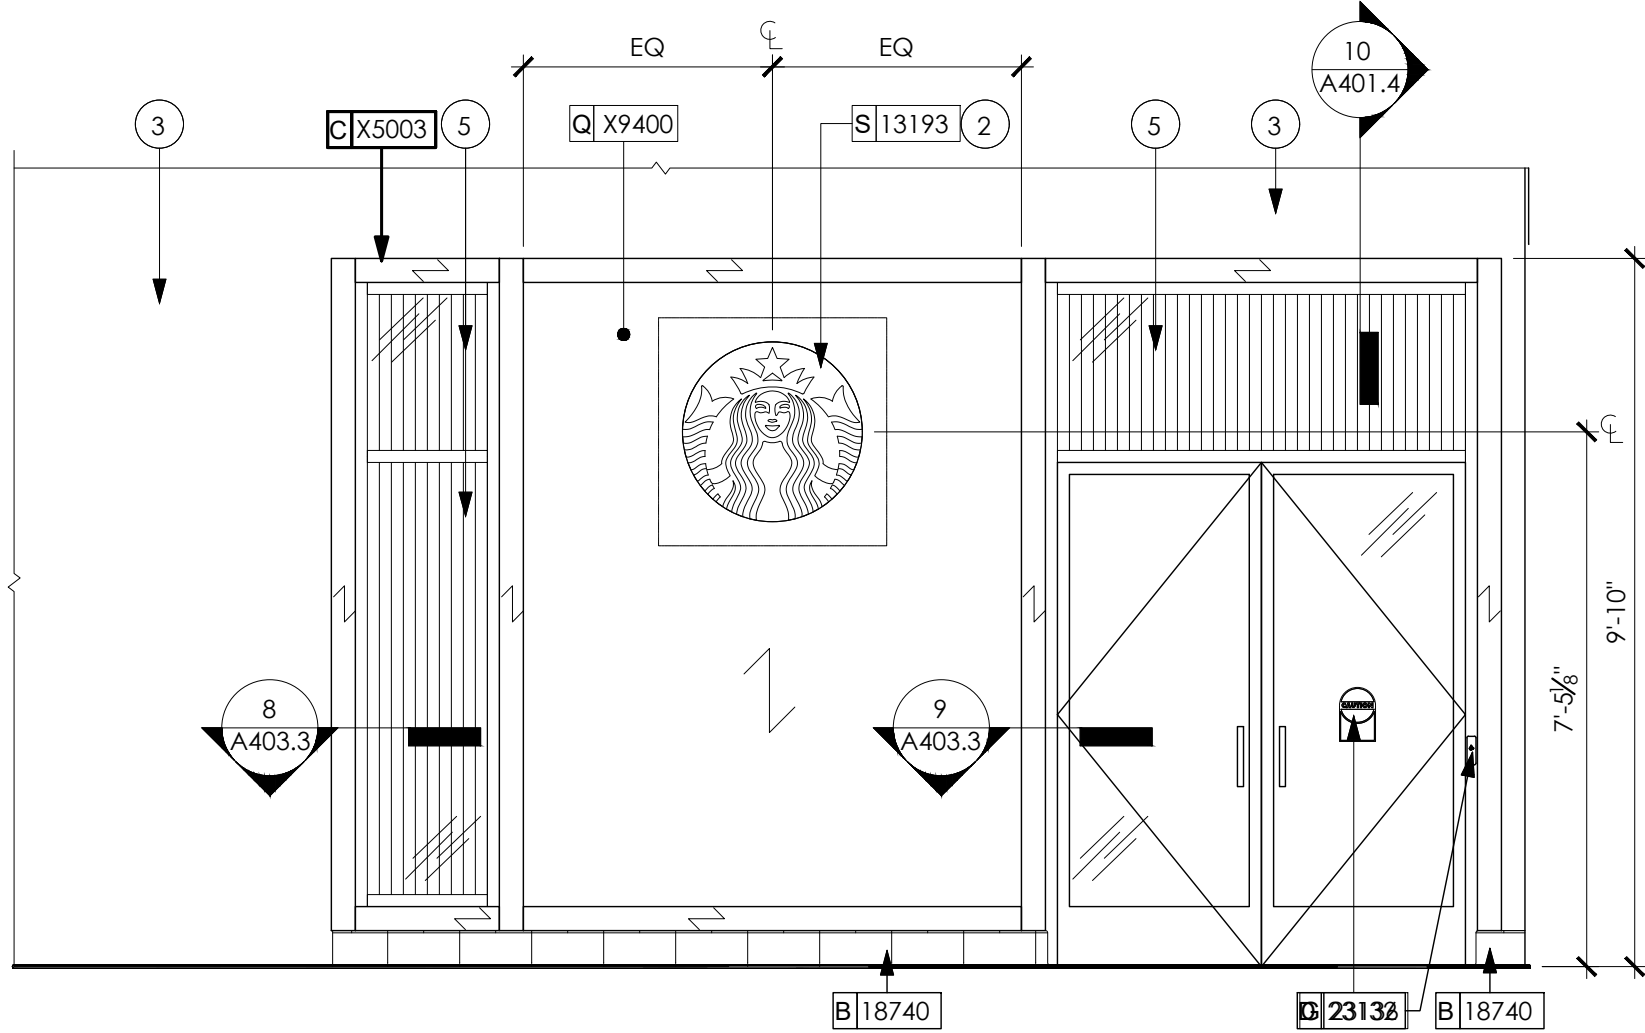

1 CAFE ENTRY ELEVATION
SCALE: 3/8" = 1'-0"

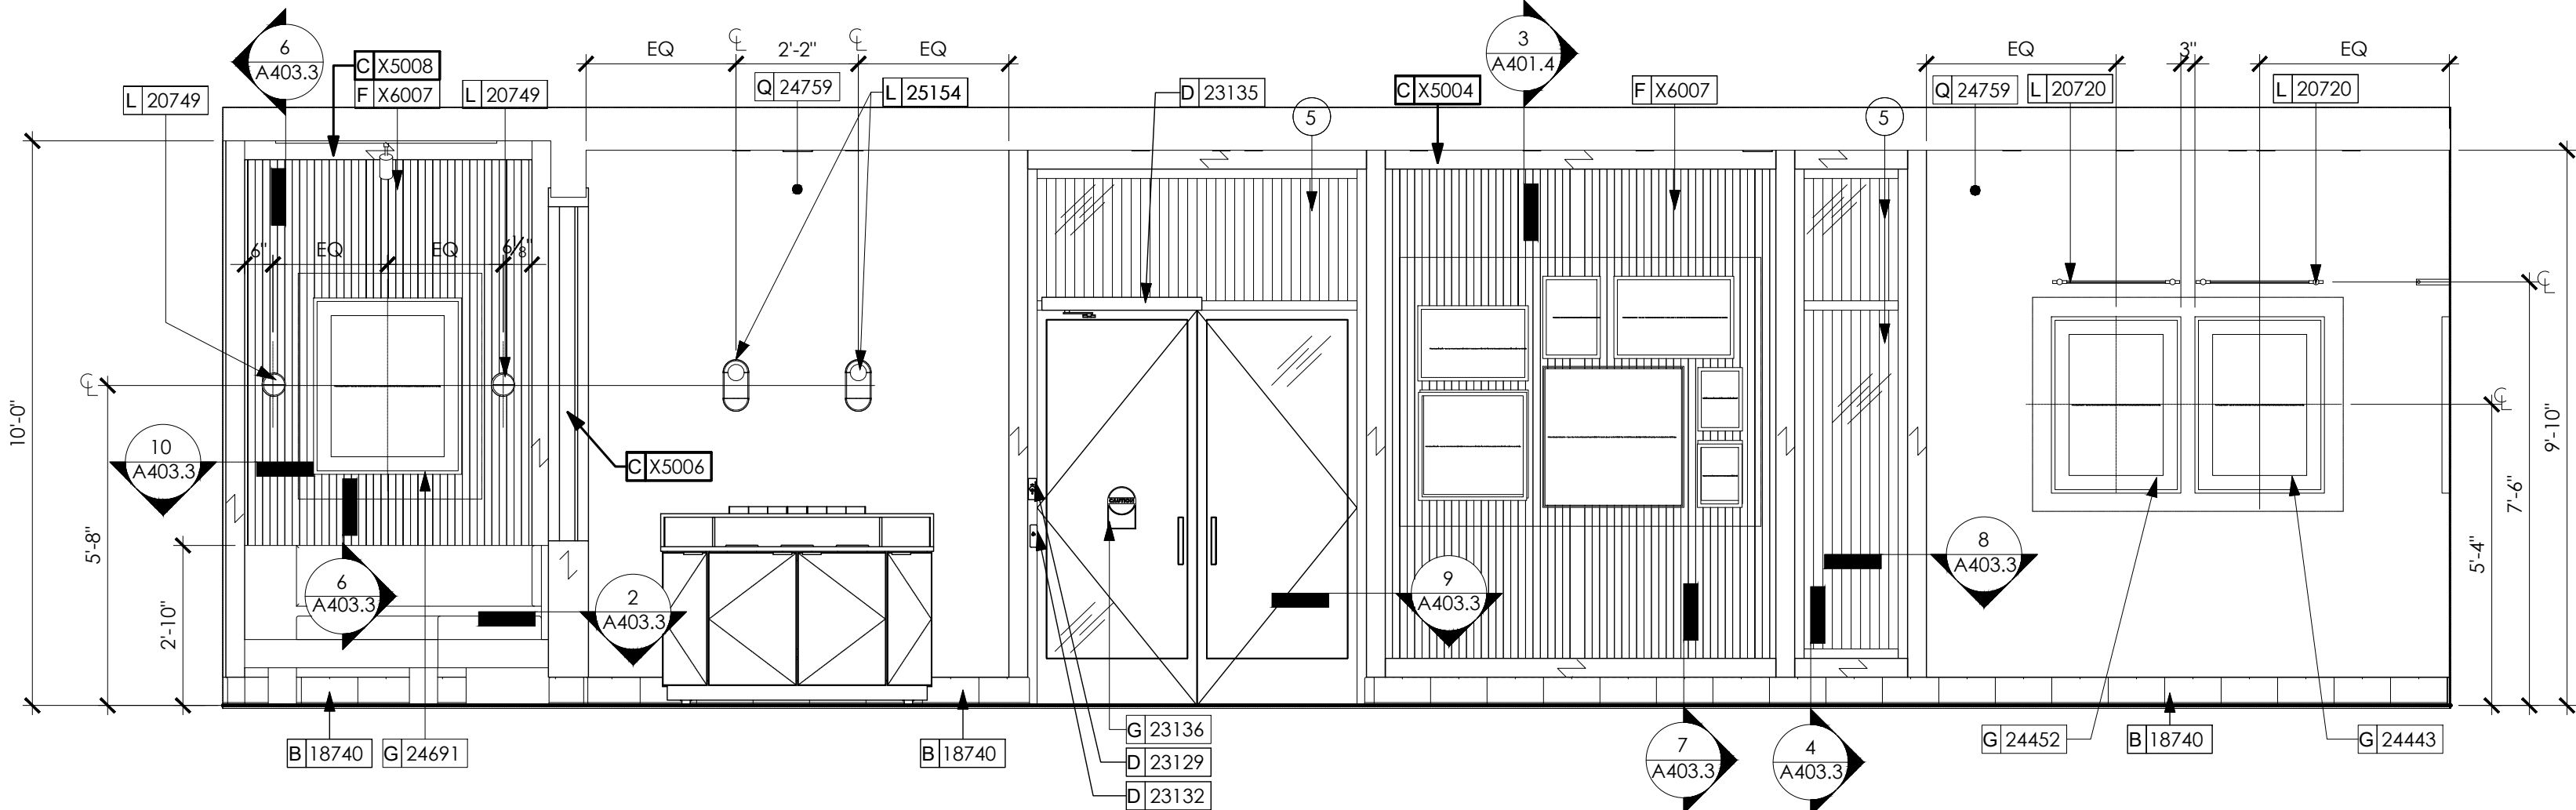

2 CAFE WEST ELEVATION
SCALE: 3/8" = 1'-0"

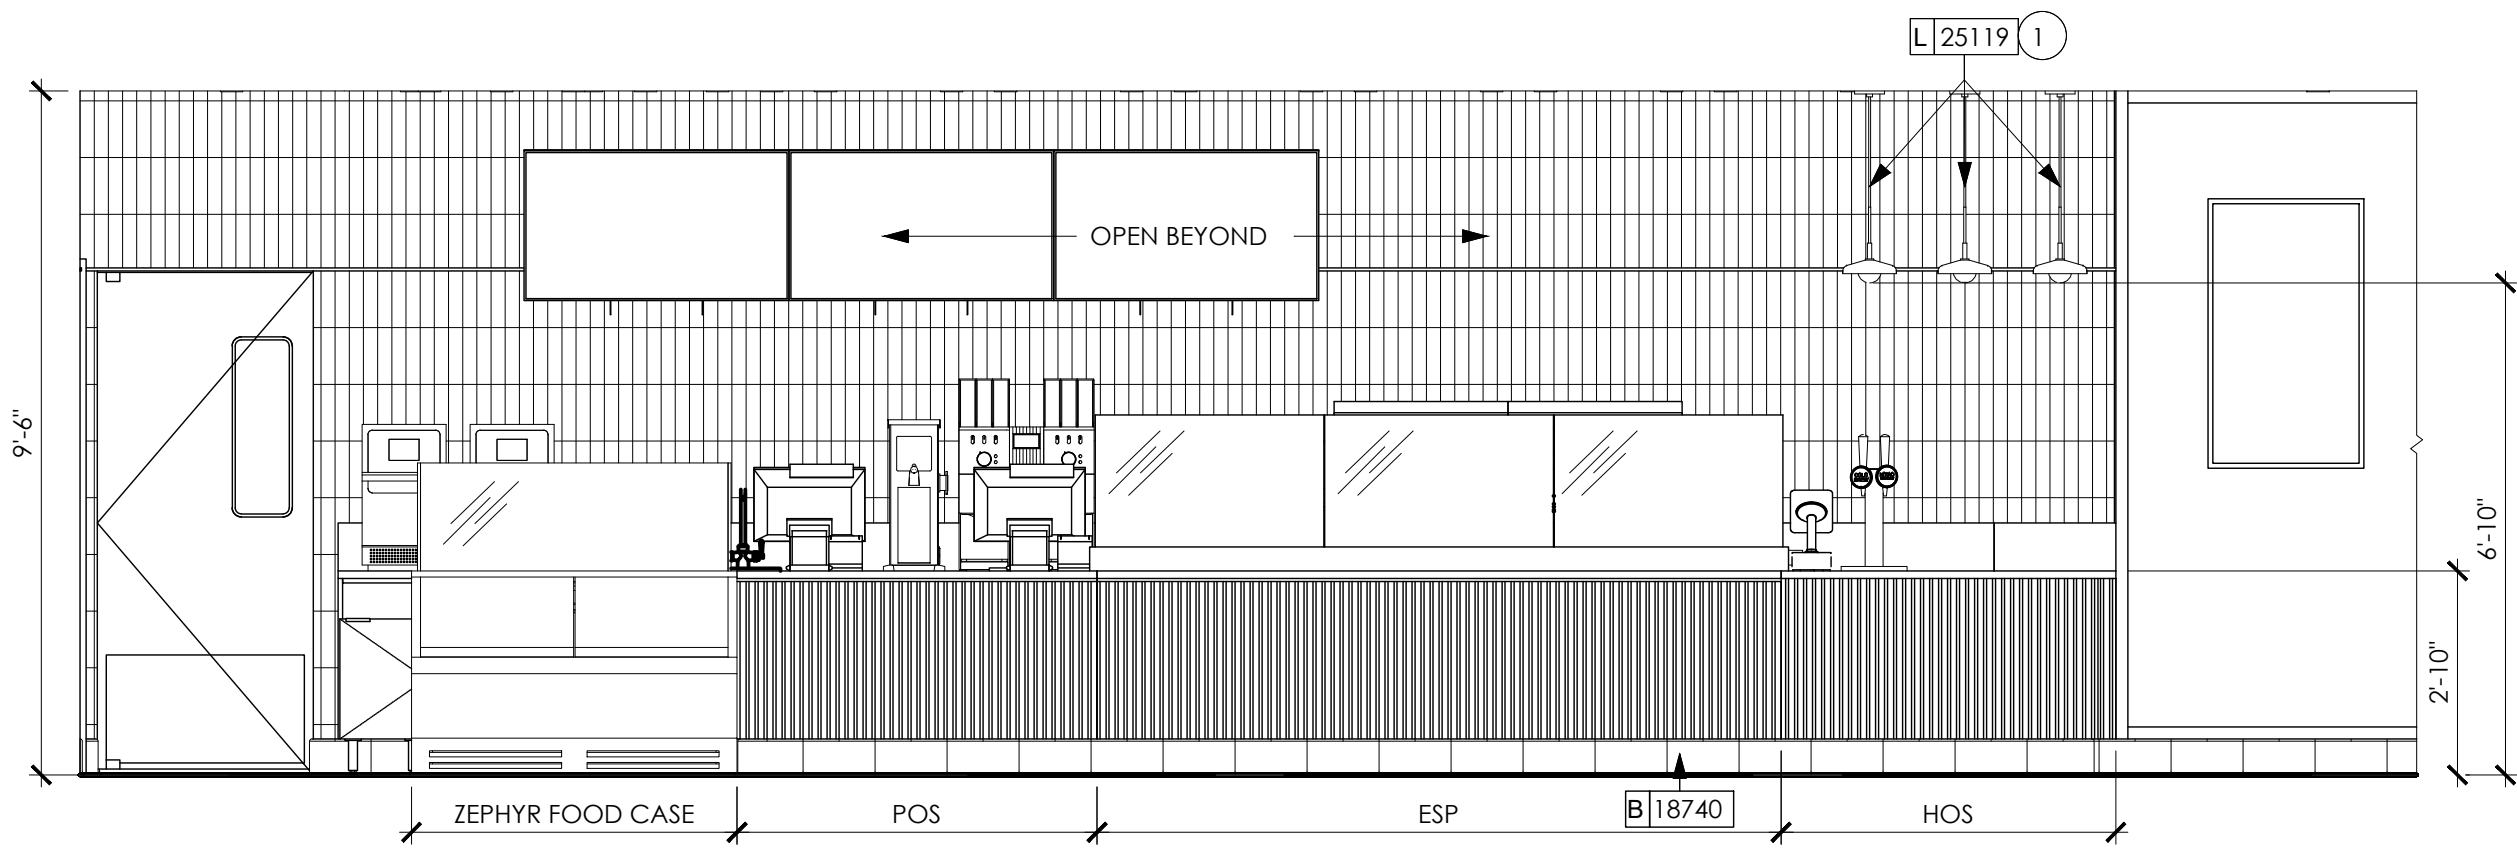

4 FRONT BAR ELEVATIONS
SCALE: 3/8" = 1'-0"

KEYED NOTES

- PENDANT LIGHT FIXTURE. SEE REFLECTED CEILING PLAN ON SHEET 1103 AND LIGHTING PLAN ON SHEET E102 FOR ADDITIONAL INFORMATION.
- STARBUCKS DESIGN MANAGER TO COORDINATE SIGNAGE PROPOSAL WITH VENDOR.
- FINISH BY LICENSEE.
- INSTALL FULL TILE ABOVE AND BELOW METAL TRIM; SEE DETAIL FOR ADDITIONAL INFORMATION.
- AOR TO SPECIFY FLUTED GLASS WHERE INDICATED. TORSTENSON GLASS - SKYTUX OR SIMILAR. STARBUCKS DESIGN TO APPROVE FINAL SPEC.

LEGEND


INDICATES WALL BLOCKING. FIRE TREATED WALL BLOCKING TO BE PROVIDED AS REQUIRED TO SUPPORT WALL ATTACHMENTS. EXTEND BLOCKING 4" (100mm) BEYOND EDGE OF ATTACHMENTS.

GENERAL NOTES


- FLOORS, WALL, AND CEILING FINISHES IN FOOD PREPARATION AREAS SHALL BE SMOOTH, NON-TOXIC, NON-ABSORBENT, DURABLE, AND EASILY CLEANABLE. PAINT IN THESE AREAS SHALL BE WASHABLE; SEMI-GLOSS OR HIGH GLOSS FINISH.
- CHANGE OF PAINT COLOR ONLY AT INSIDE CORNERS, UNLESS NOTED OTHERWISE.
- PAINT SUBSTITUTIONS ARE NOT ALLOWED. USE STARBUCKS NATIONAL SHERWIN WILLIAMS ACCOUNT "COLOR CODE" WHEN ORDERING PAINTS.
- PAINT FINISHES SHALL BE APPLIED AS FOLLOWS, UNLESS NOTED OTHERWISE:
 - WOODS AND METAL SURFACES SHALL BE SEMI-GLOSS OR EQUAL.
 - ACCENT AND TRIM PAINTS SHALL BE SEMI-GLOSS OR EQUAL.
 - WALL AND CEILING PAINTS SHALL BE EGGSHELL OR EQUAL.
 - PAINTS IN WORKROOM RESTROOM(S) OR CAFE BAR SHALL BE SEMI-GLOSS OR EQUAL.
- REFER TO INTERIOR WALL FINISH PLAN SHEET 1106 FOR PAINT SCHEDULES AND WALL FINISH SCHEDULE.
- WORKROOM TO BE FINISHED PER LOCAL CODE. GENERAL CONTRACTOR TO PROVIDE AND INSTALL WORKROOM WALL FINISHES.
- ALL WOOD SURFACES (DOORS, TRIM, SHELVES, CABINTRY) SHALL BE SEALED.
- ALL FLOOR AND WALL JUNCTIONS IN STORAGE AND FOOD PREPARATION AREAS SHALL HAVE A 6" COVED BASE.
- GENERAL CONTRACTOR TO INSTALL WALL BLOCKING AND HANGERS FOR WALL SHELVING BEFORE INSTALLING BACK BAR WALL TILE.
- REFER TO MANUFACTURER'S INSTRUCTIONS INCLUDED WITH ARTWORK / GRAPHICS FOR PROPER INSTALLATION.

LICENSED STORES RESPONSIBILITY LEGEND

SB - STARBUCKS
FC - STARBUCKS FIXTURE CONTRACTOR
LC - LICENSEE
GC - LICENSEE'S GENERAL CONTRACTOR

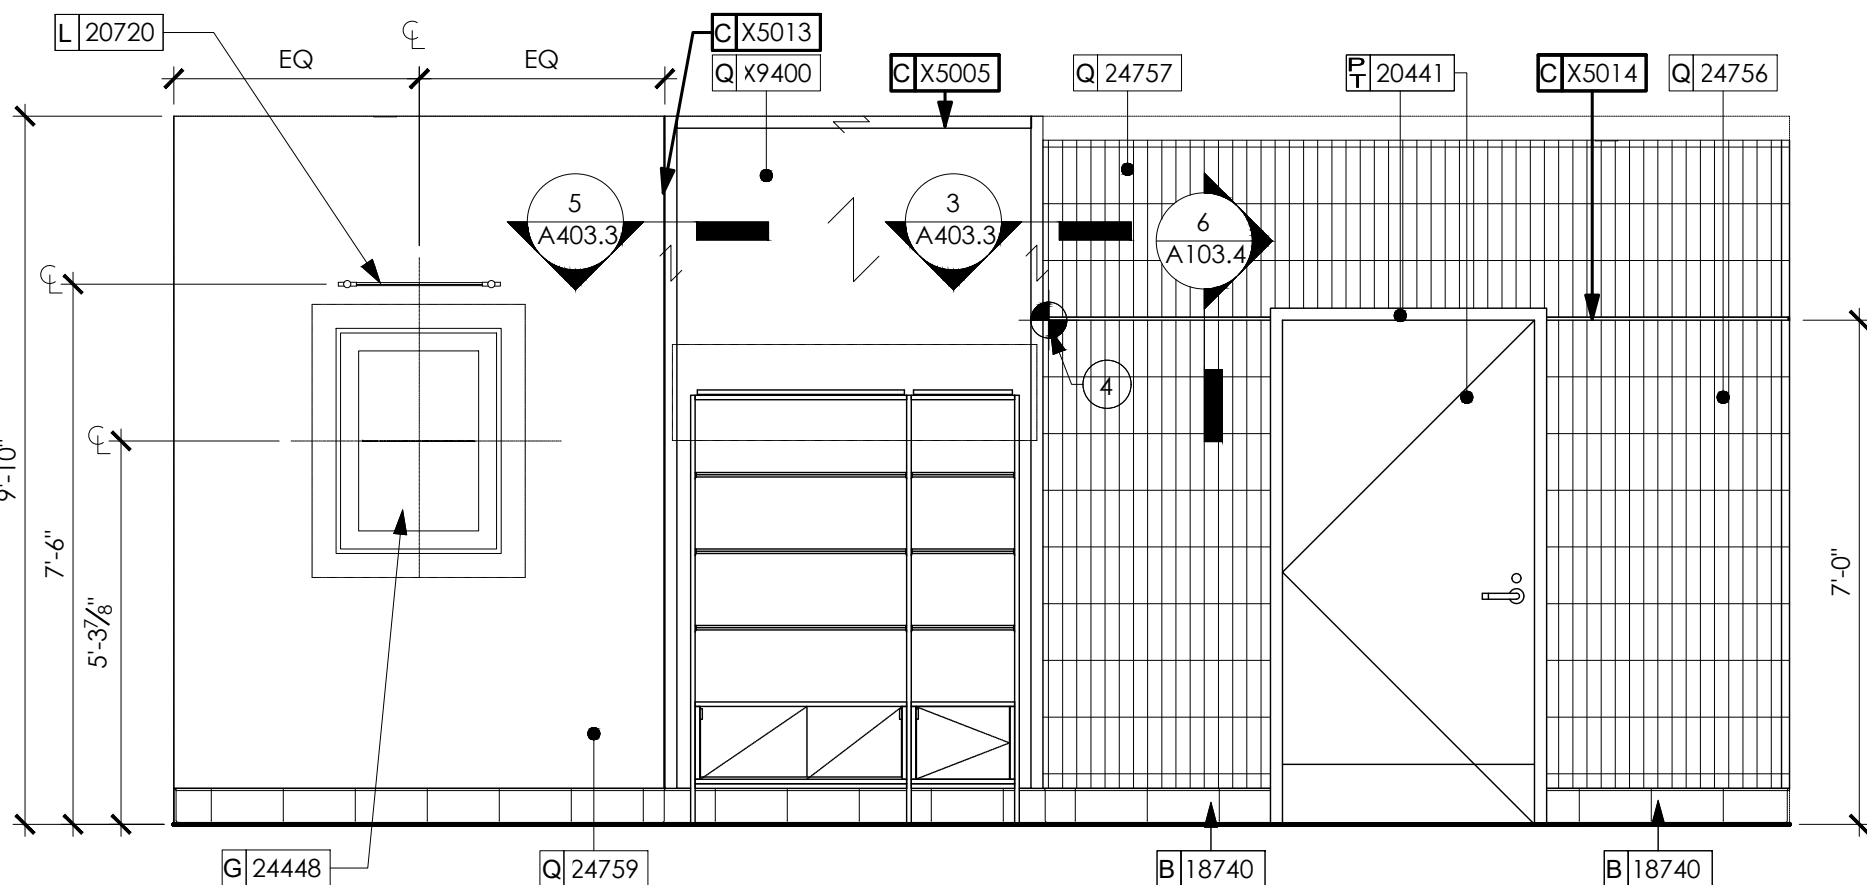

3 CAFE NORTH ELEVATIONS
SCALE: 3/8" = 1'-0"

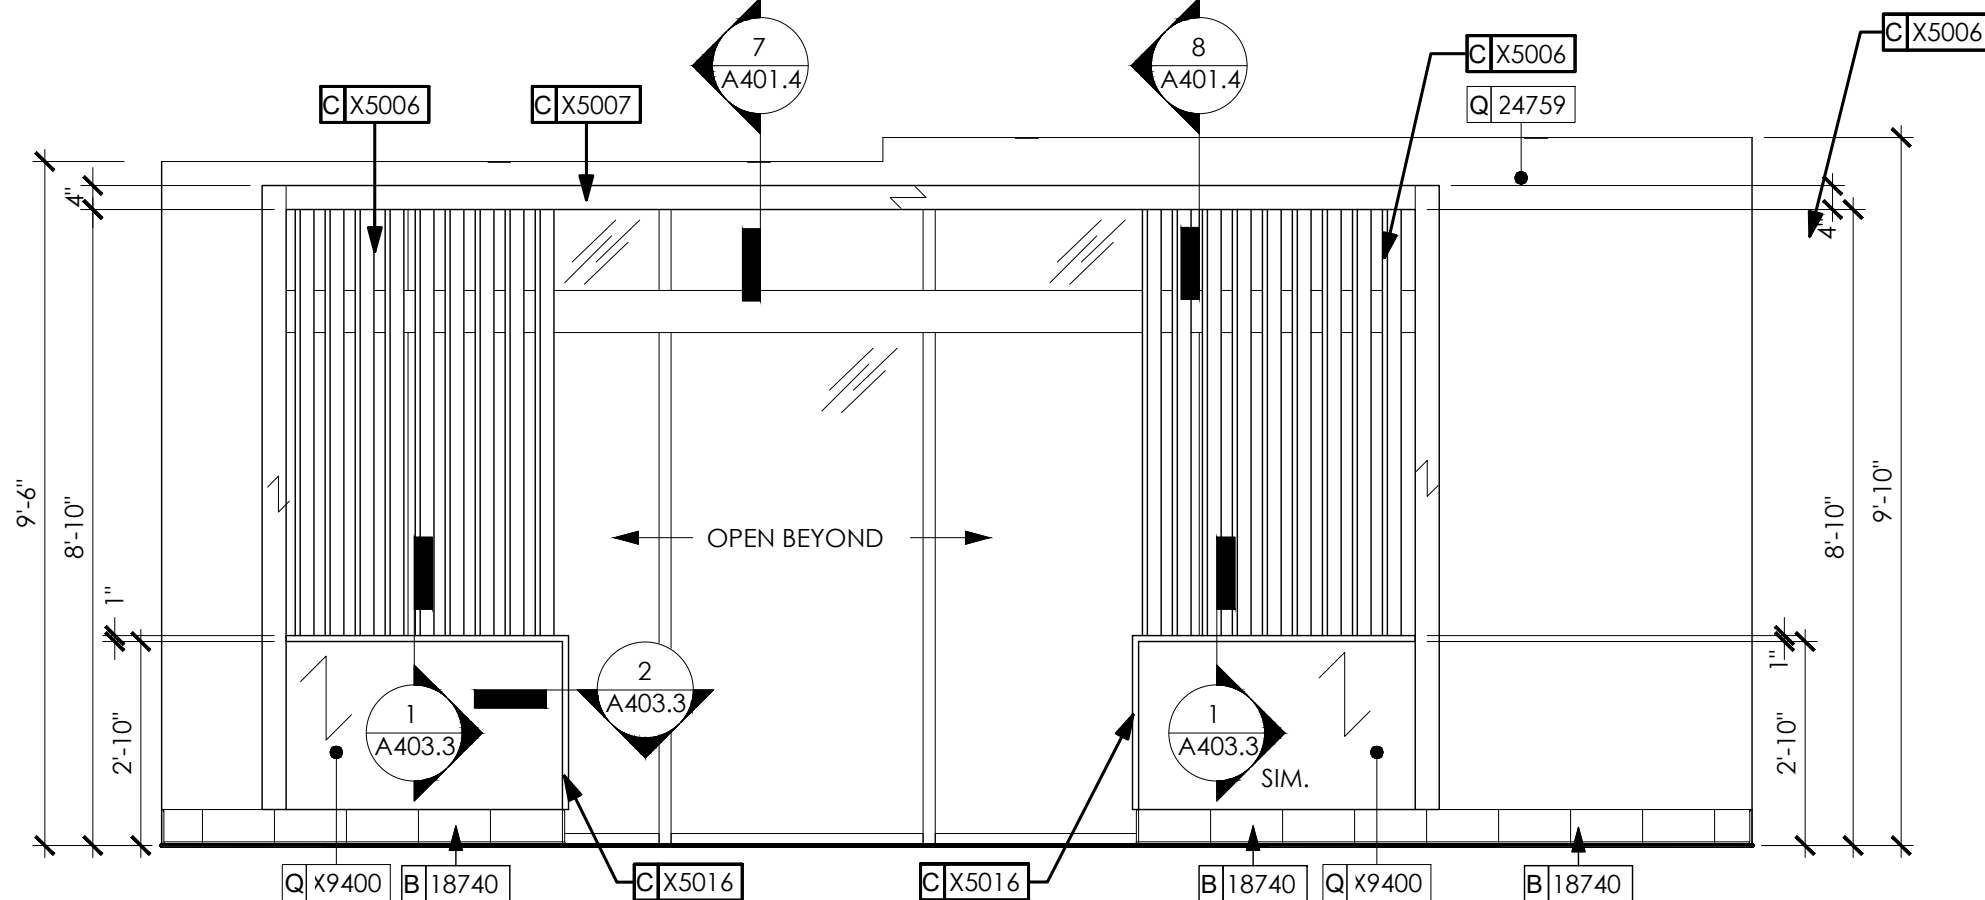

5 CAFE SOUTH ELEVATIONS
SCALE: 3/8" = 1'-0"

ARCHITECT OF RECORD:

THOMAS E. MORGAN, JR.
ARCHITECT

423 FISCHER TRAIL
ELLIJAY, GEORGIA 30540

SEAL:

MRP
DESIGN GROUP

3450 Acworth Due West Road
Building 100, Suite 120
Kennesaw, Georgia 30144
P. 770-917-9172
F. 770-917-9470
www.mrpdesign.com

RELEASED FOR CONSTRUCTION

ISSUES / REVISIONS:

DATE	DESCRIPTION
01.26.28	COMPILED SET RELEASED FOR CONSTRUCTION

DRAWN BY:

CHKD BY:

PROJECT DESCRIPTION:

DEVELOPMENT OF INTERIORS
CONDITIONS FOR A C-STORE IN
CORDELE, GA.

PROJECT TITLE:

CONVENIENCE STORE
379 ROCKHOUSE RD E,
CORDELE, GA 31015


SHEET TITLE:

STARBUCKS
INTERIOR
DETAILS


PROJECT NO: 25049

A403


THESE PLANS ARE THE PROPERTY OF MRP DESIGN GROUP, INC. AND ARE SUBJECT TO FEDERAL COPYRIGHT LAWS. ANY USE OF SAME WITHOUT THE EXPRESS WRITTEN PERMISSION OF MRP DESIGN GROUP, INC. IS STRICTLY PROHIBITED.

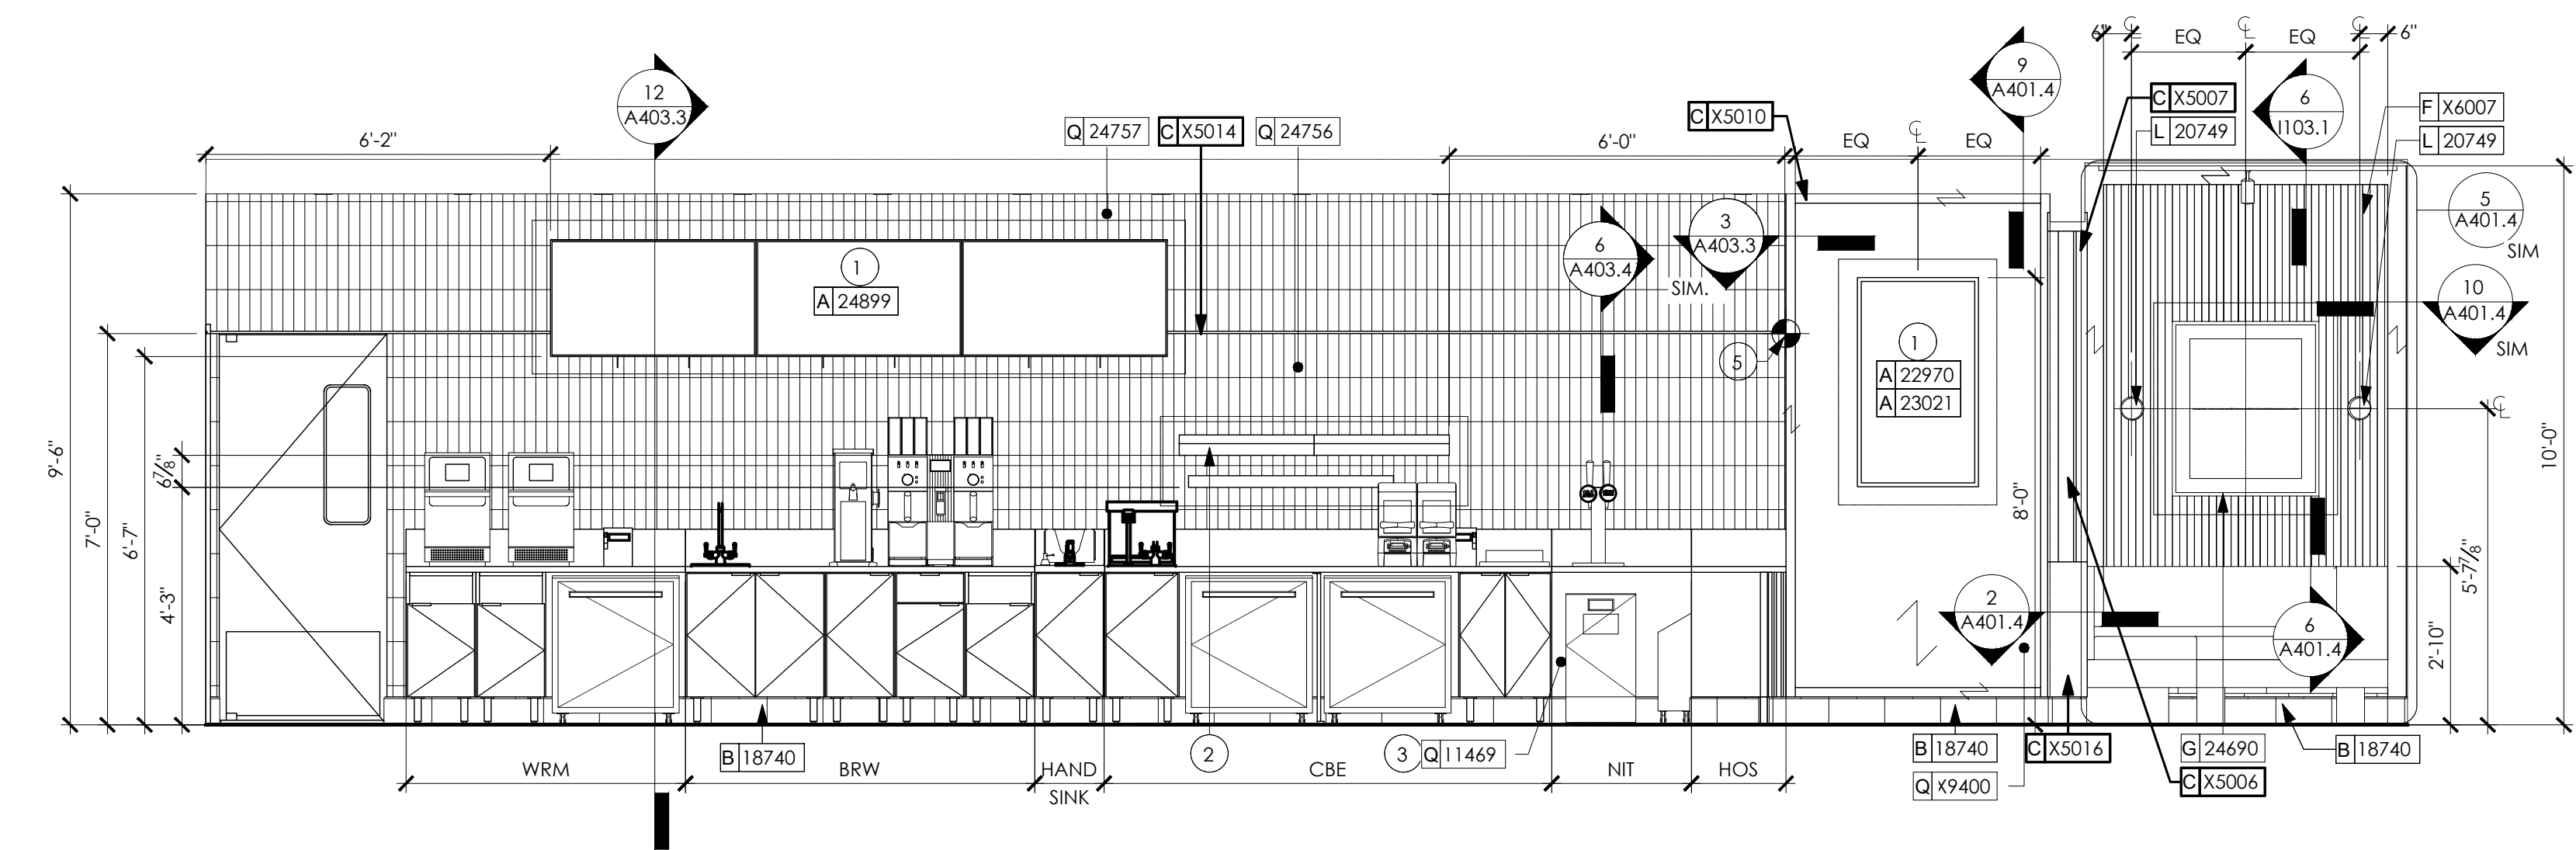


1 CAFE ENTRY ELEVATION
SCALE: 3/8" = 1'-0"

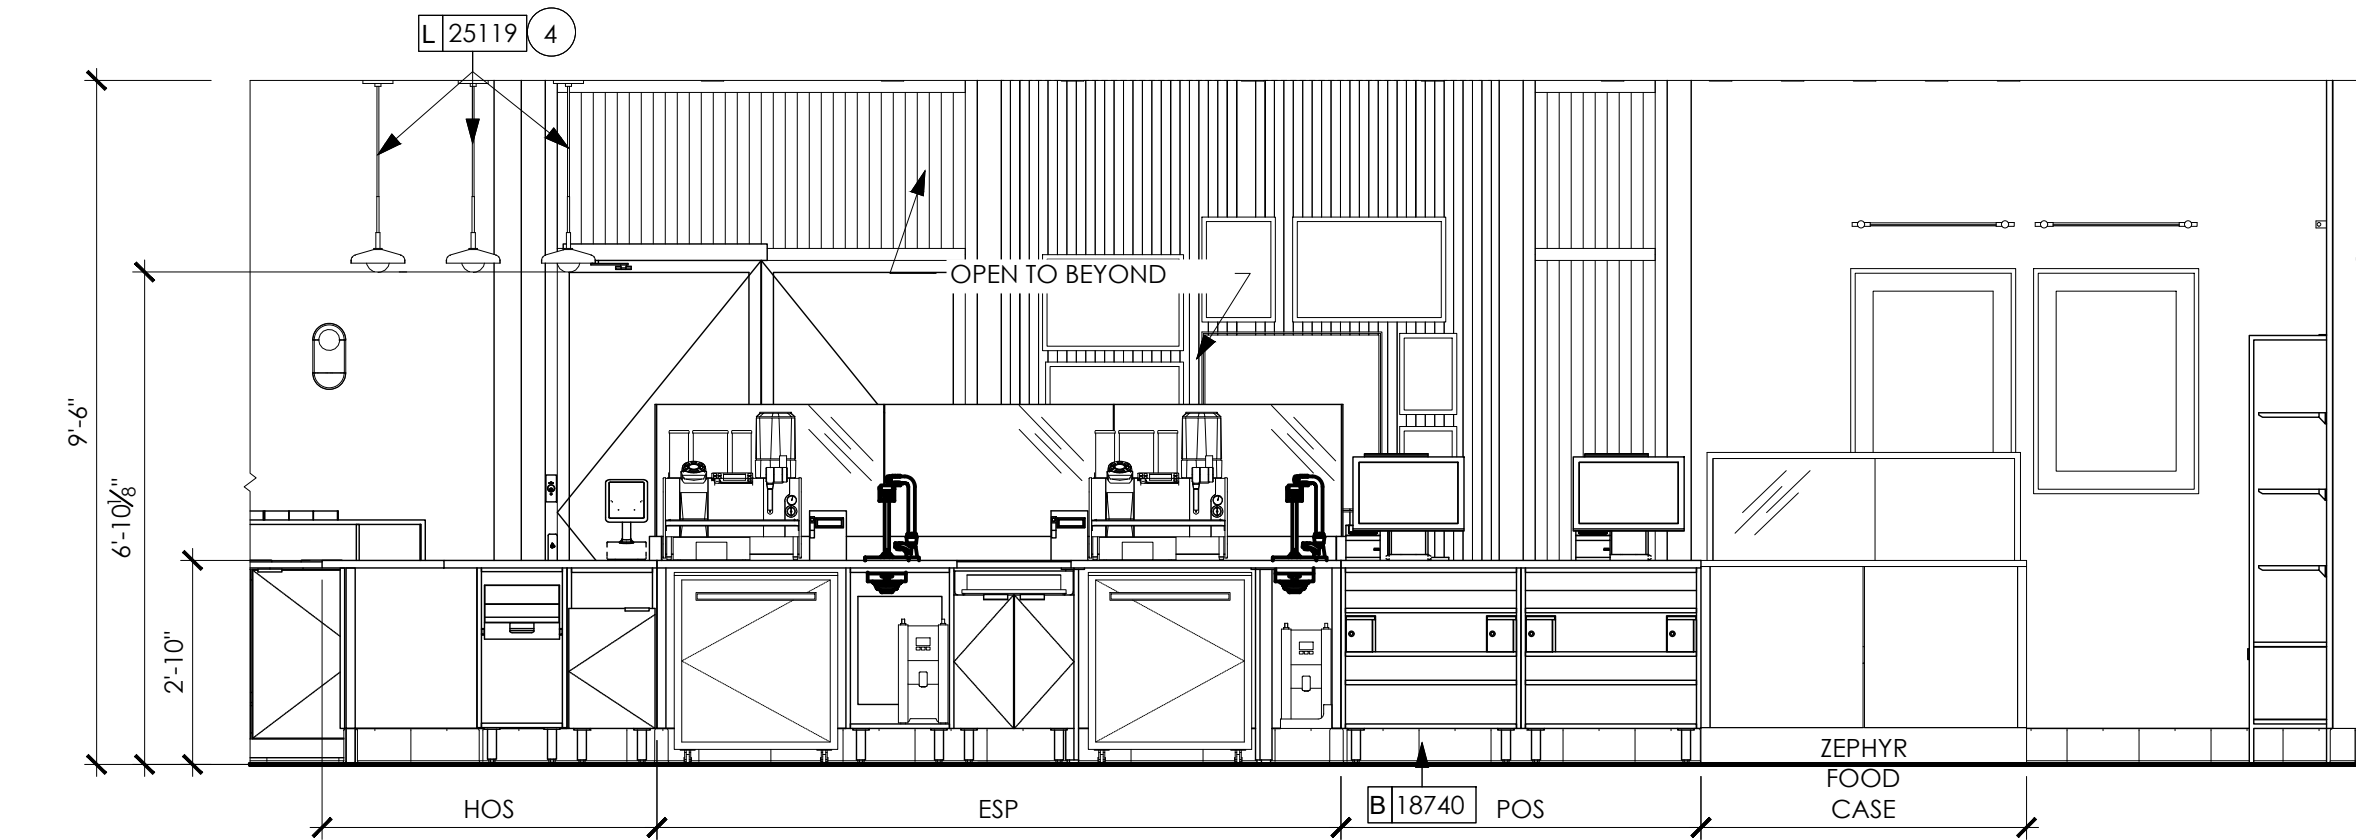


2 FRONT BAR ELEVATION (PARTNER SIDE)
SCALE: 3/8" = 1'-0"

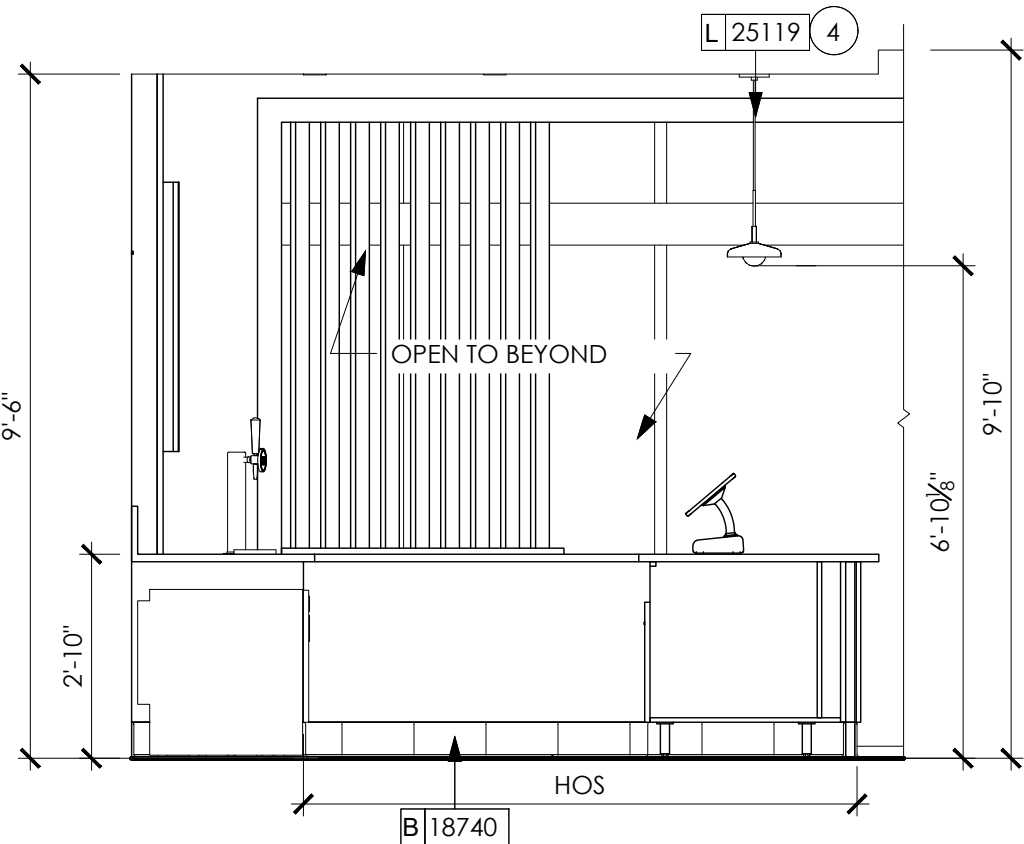

3 HOS ELEVATION (PARTNER SIDE)
SCALE: 3/8" = 1'-0"

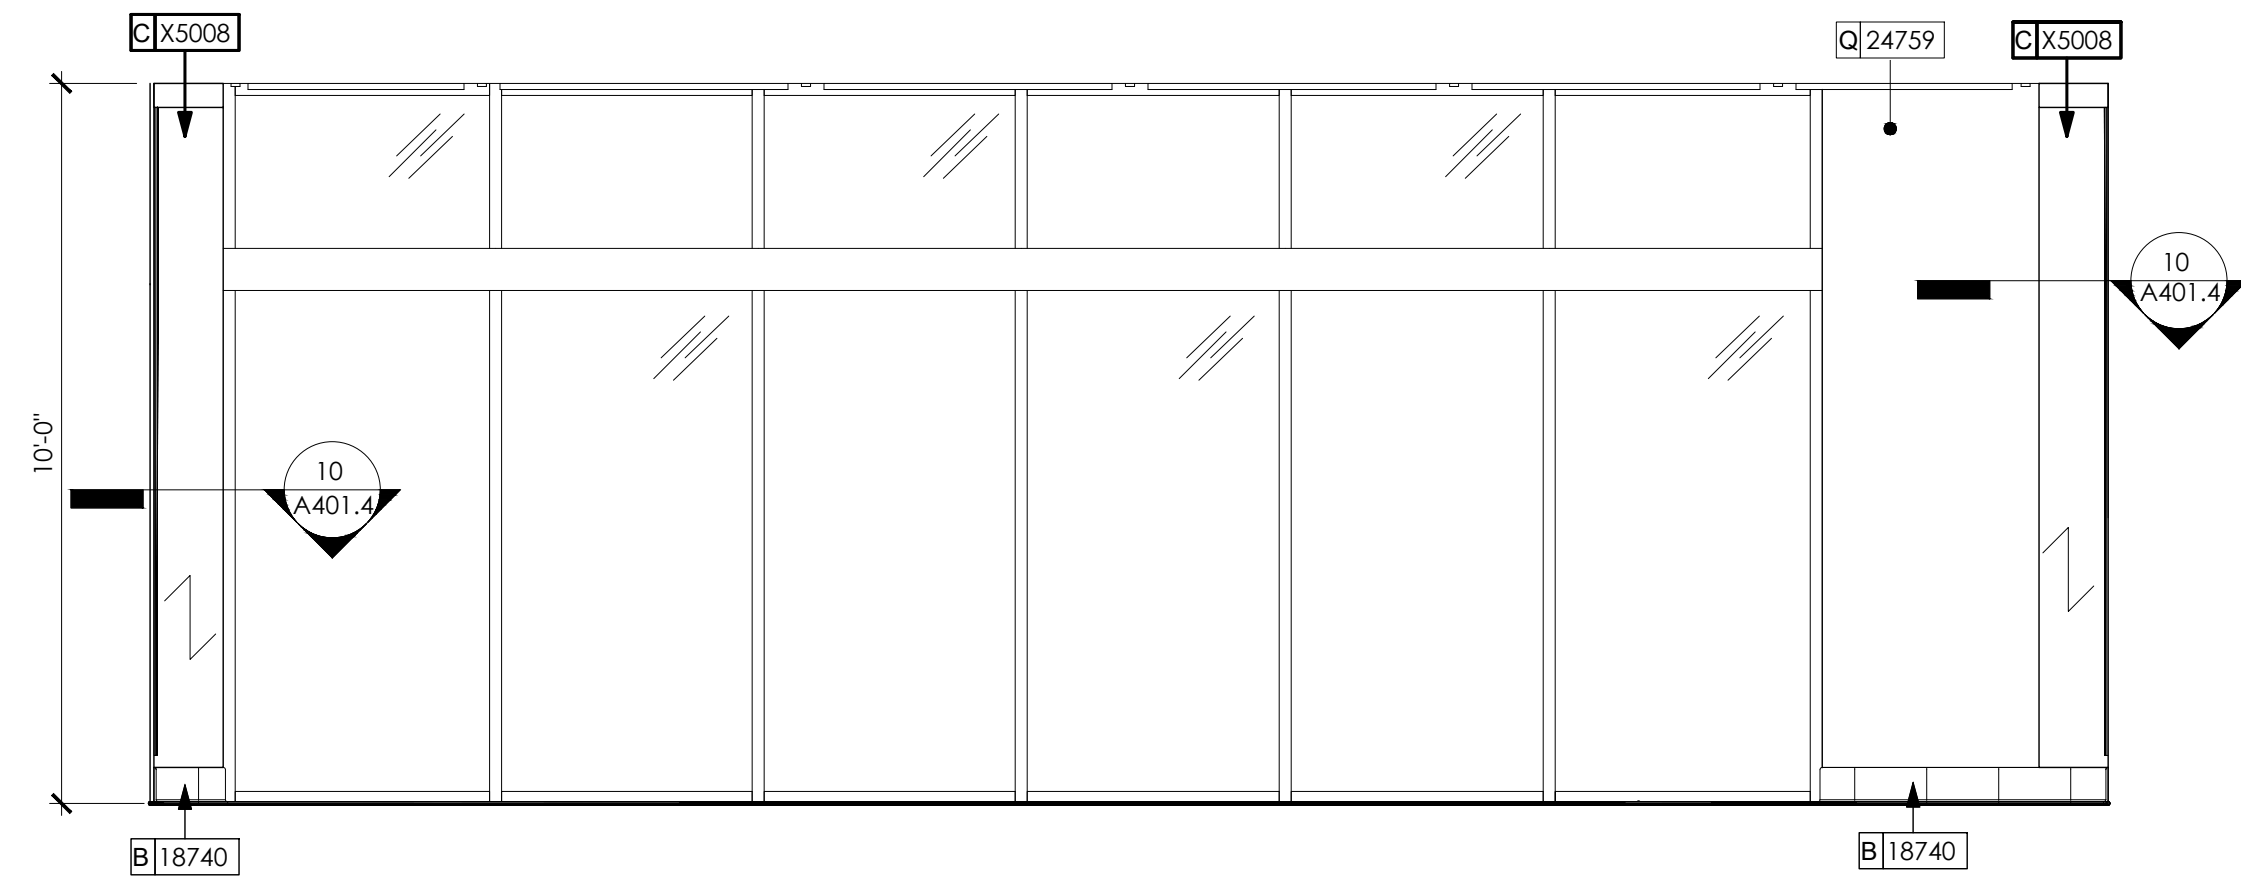

4 SEATING AREA SOUTH ELEVATION
SCALE: 3/8" = 1'-0"

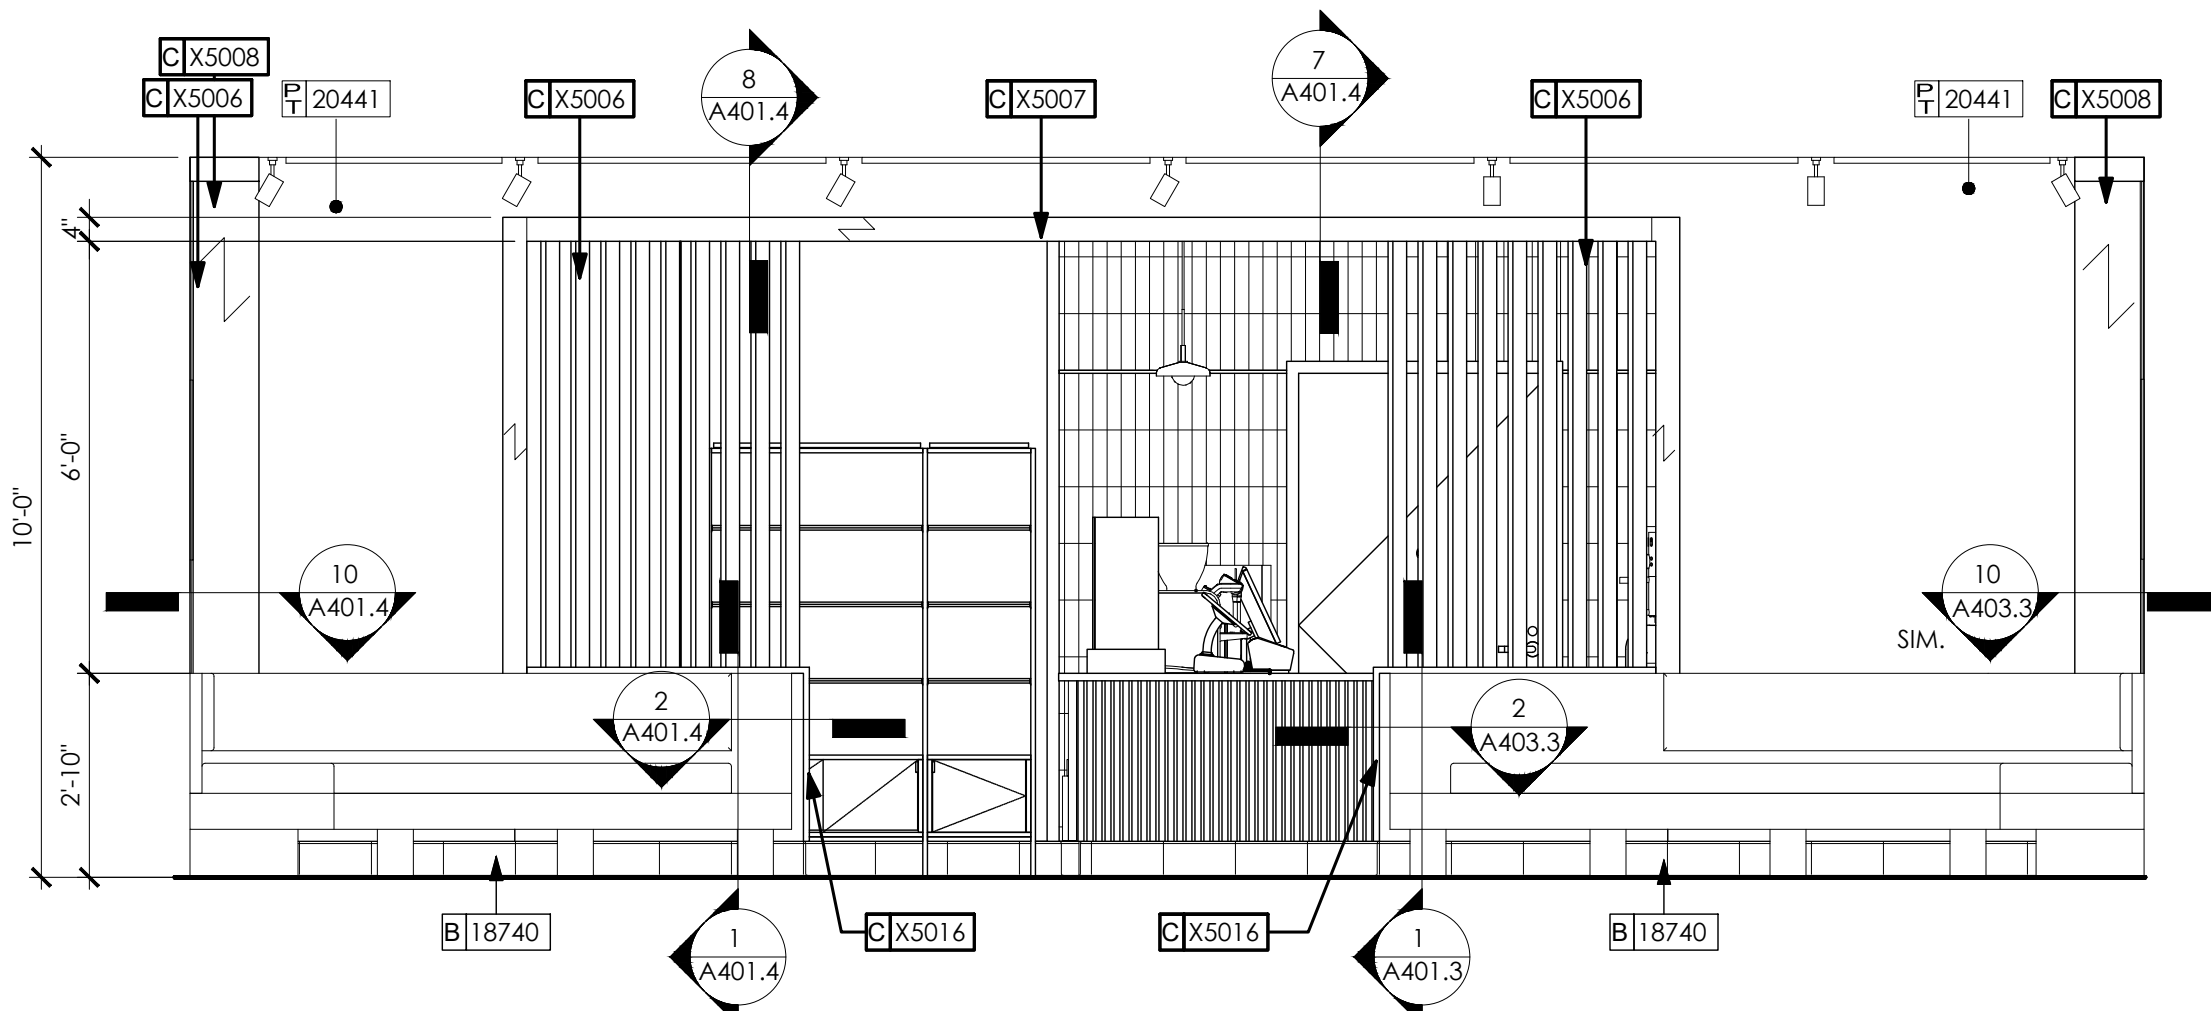

5 SEATING AREA NORTH ELEVATION
SCALE: 3/8" = 1'-0"

KEYED NOTES

- ATTACH MENU BOARDS PER INSTALLATION DETAILS.
- SHELVING FOR CBE STATION AS SHOWN. GENERAL CONTRACTOR TO PROVIDE WALL BLOCKING FOR FASTENERS.
- GENERAL CONTRACTOR TO PROVIDE AND INSTALL FRP WALL FINISH BEHIND CASEWORK CABINETS IN AREAS BELOW COUNTERTOP HEIGHT.
- PENDANT LIGHT FIXTURE. SEE REFLECTED CEILING PLAN ON SHEET I103 AND LIGHTING PLAN ON SHEET E102 FOR ADDITIONAL INFORMATION.
- INSTALL FULL TILE ABOVE AND BELOW METAL TRIM; SEE DETAIL FOR ADDITIONAL INFORMATION.

GENERAL NOTES

- FLOORS, WALL, AND CEILING FINISHES IN FOOD PREPARATION AREAS SHALL BE SMOOTH, NON-TOXIC, NON-ABSORBENT, DURABLE, AND EASILY CLEANABLE. PAINT IN THESE AREAS SHALL BE WASHABLE; SEMI-GLOSS OR HIGH GLOSS FINISH.
- CHANGE OF PAINT COLOR ONLY AT INSIDE CORNERS, UNLESS NOTED OTHERWISE.
- PAINT SUBSTITUTIONS ARE NOT ALLOWED. USE STARBUCKS NATIONAL SHERWIN WILLIAMS ACCOUNT "COLOR CODE" WHEN ORDERING PAINTS.
- PAINT FINISHES SHALL BE APPLIED AS FOLLOWS, UNLESS NOTED OTHERWISE:
 - WOODS AND METAL SURFACES SHALL BE SEMI-GLOSS OR EQUAL.
 - ACCENT AND TRIM PAINTS SHALL BE SEMI-GLOSS OR EQUAL.
 - WALL AND CEILING PAINTS SHALL BE EGGSHELL OR EQUAL.
 - PAINTS IN WORKROOM RESTROOM(S) OR CAFE BAR SHALL BE SEMI-GLOSS OR EQUAL.
- REFER TO INTERIOR WALL FINISH PLAN SHEET I106 FOR PAINT SCHEDULE AND WALL FINISH SCHEDULE.
- WORKROOM TO BE FINISHED PER LOCAL CODE. GENERAL CONTRACTOR TO PROVIDE AND INSTALL WORKROOM WALL FINISHES.
- ALL WOOD SURFACES (DOORS, TRIM, SHELVES, CABINETRY) SHALL BE SEALED.
- ALL FLOOR AND WALL JUNCTIONS IN STORAGE AND FOOD PREPARATION AREAS SHALL HAVE A 6" COVED BASE.
- GENERAL CONTRACTOR TO INSTALL WALL BLOCKING AND HANGERS FOR WALL SHELVING BEFORE INSTALLING BACK BAR WALL TILE.
- REFER TO MANUFACTURER'S INSTRUCTIONS INCLUDED WITH ARTWORK / GRAPHICS FOR PROPER INSTALLATION.

LEGEND

- INDICATES WALL BLOCKING.
FIRE TREATED WALL BLOCKING TO BE PROVIDED AS REQUIRED TO SUPPORT WALL ATTACHMENTS. EXTEND BLOCKING 4" (100mm) BEYOND EDGE OF ATTACHMENTS.

ARCHITECT OF RECORD:

THOMAS E. MORGAN, JR.
ARCHITECT

423 FISCHER TRAIL
ELLIJAY, GEORGIA 30540

SEAL:

MRP
DESIGN GROUP

3450 Acworth Due West Road
Building 100, Suite 120
Kennesaw, Georgia 30144
P. 770-917-9172
F. 770-917-9470
www.mrpdesign.com

RELEASED FOR CONSTRUCTION

ISSUES / REVISIONS:

DATE	DESCRIPTION
01.26.28	COMPILED SET RELEASED FOR CONSTRUCTION

DRAWN BY:

CHKD BY:

PROJECT DESCRIPTION:

DEVELOPMENT OF INTERIORS
CONDITIONS FOR A C-STORE IN
CORDELE, GA.

PROJECT TITLE:

CONVENIENCE STORE
379 ROCKHOUSE RD E,
CORDELE, GA 31015


SHEET TITLE:

STARBUCKS
INTERIOR
DETAILS


PROJECT NO: 25049

A403.1


THESE PLANS ARE THE PROPERTY OF MRP DESIGN GROUP, INC. AND ARE SUBJECT TO FEDERAL COPYRIGHT LAWS. ANY USE OF SAME WITHOUT THE EXPRESS WRITTEN PERMISSION OF MRP DESIGN GROUP, INC. IS STRICTLY PROHIBITED.

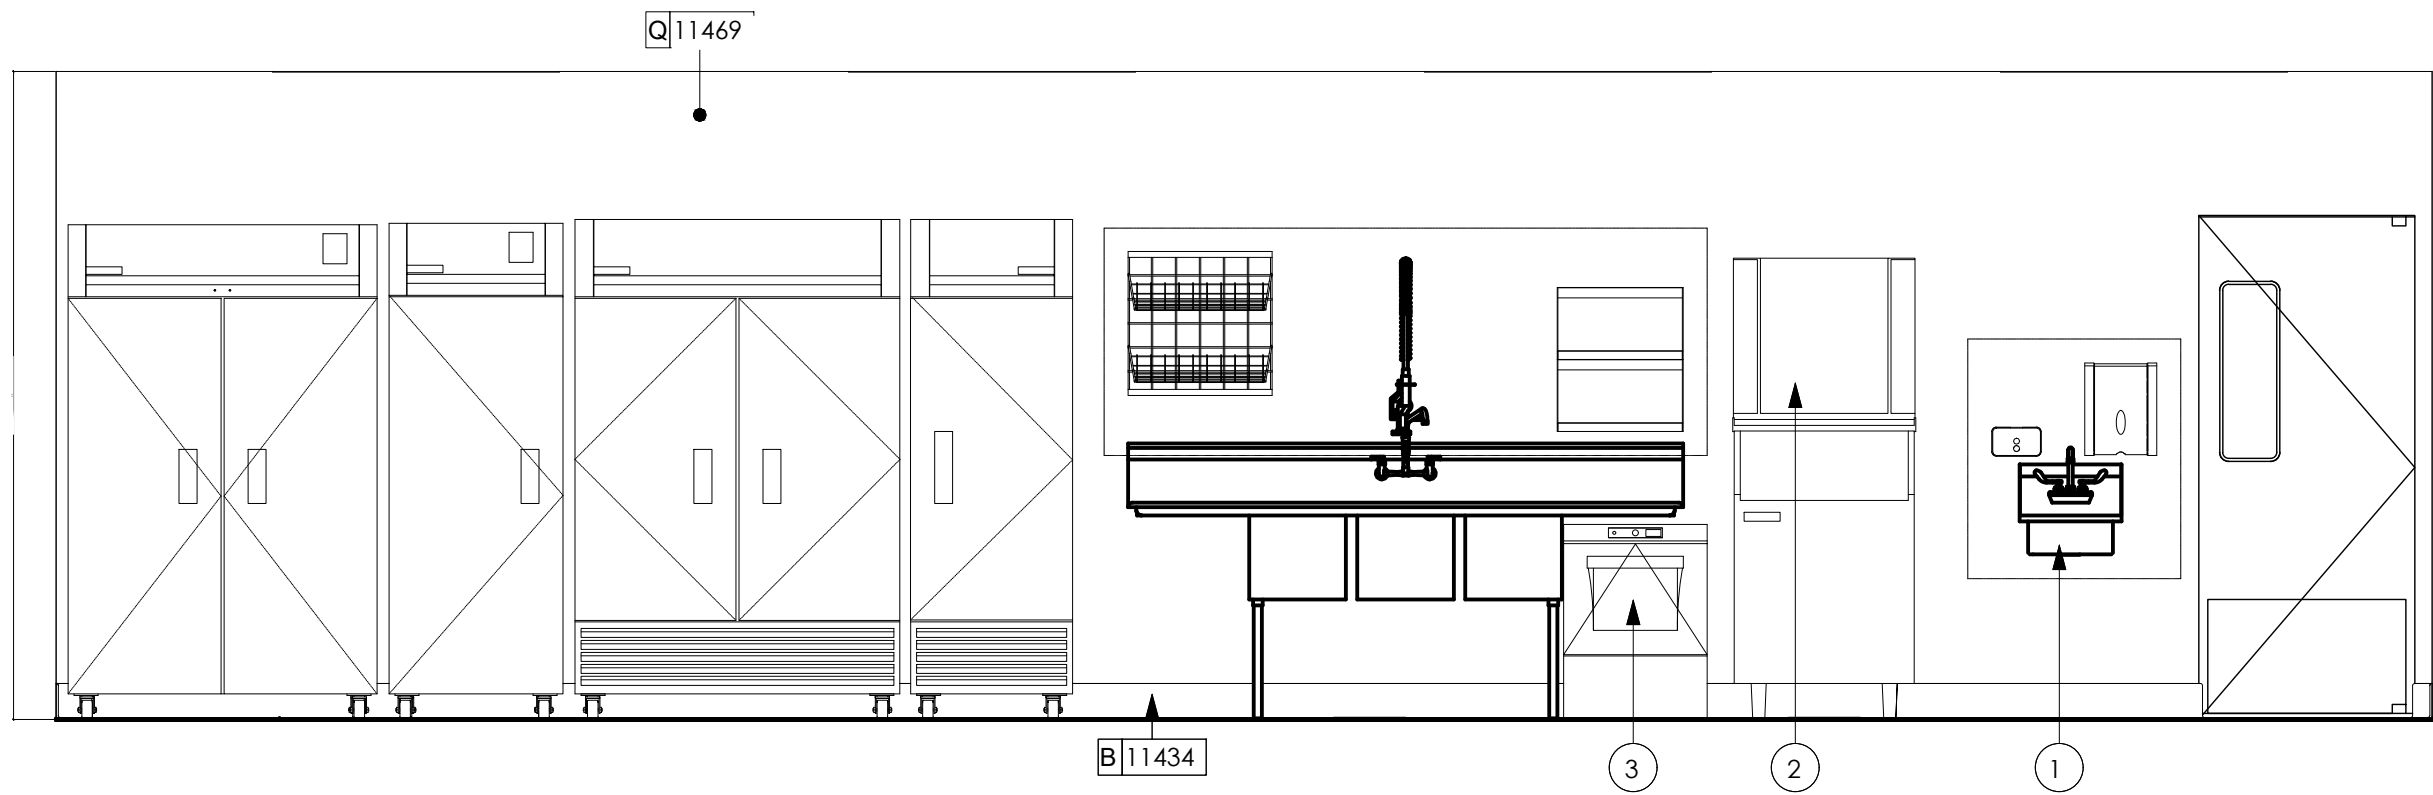


1 WORKROOM WEST ELEVATION A
A403.2 SCALE: 3/8" = 1'-0"

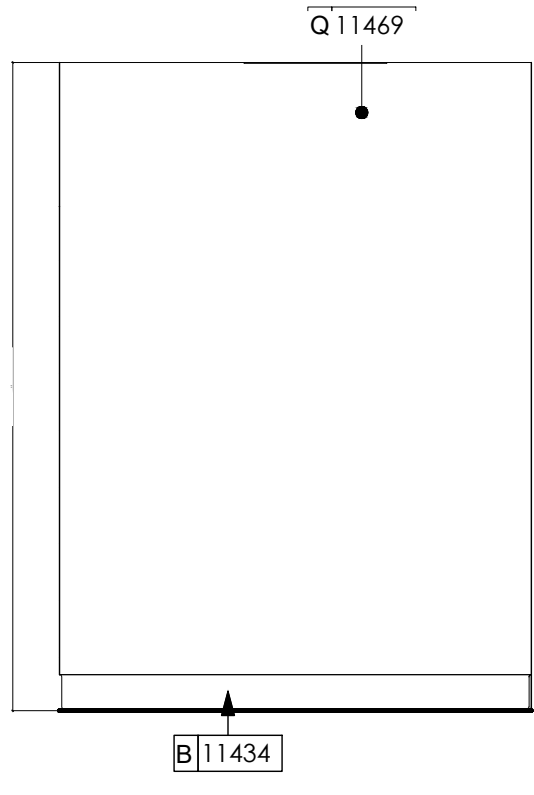


2 WORKROOM NORTH ELEVATION A
A403.1 SCALE: 3/8" = 1'-0"

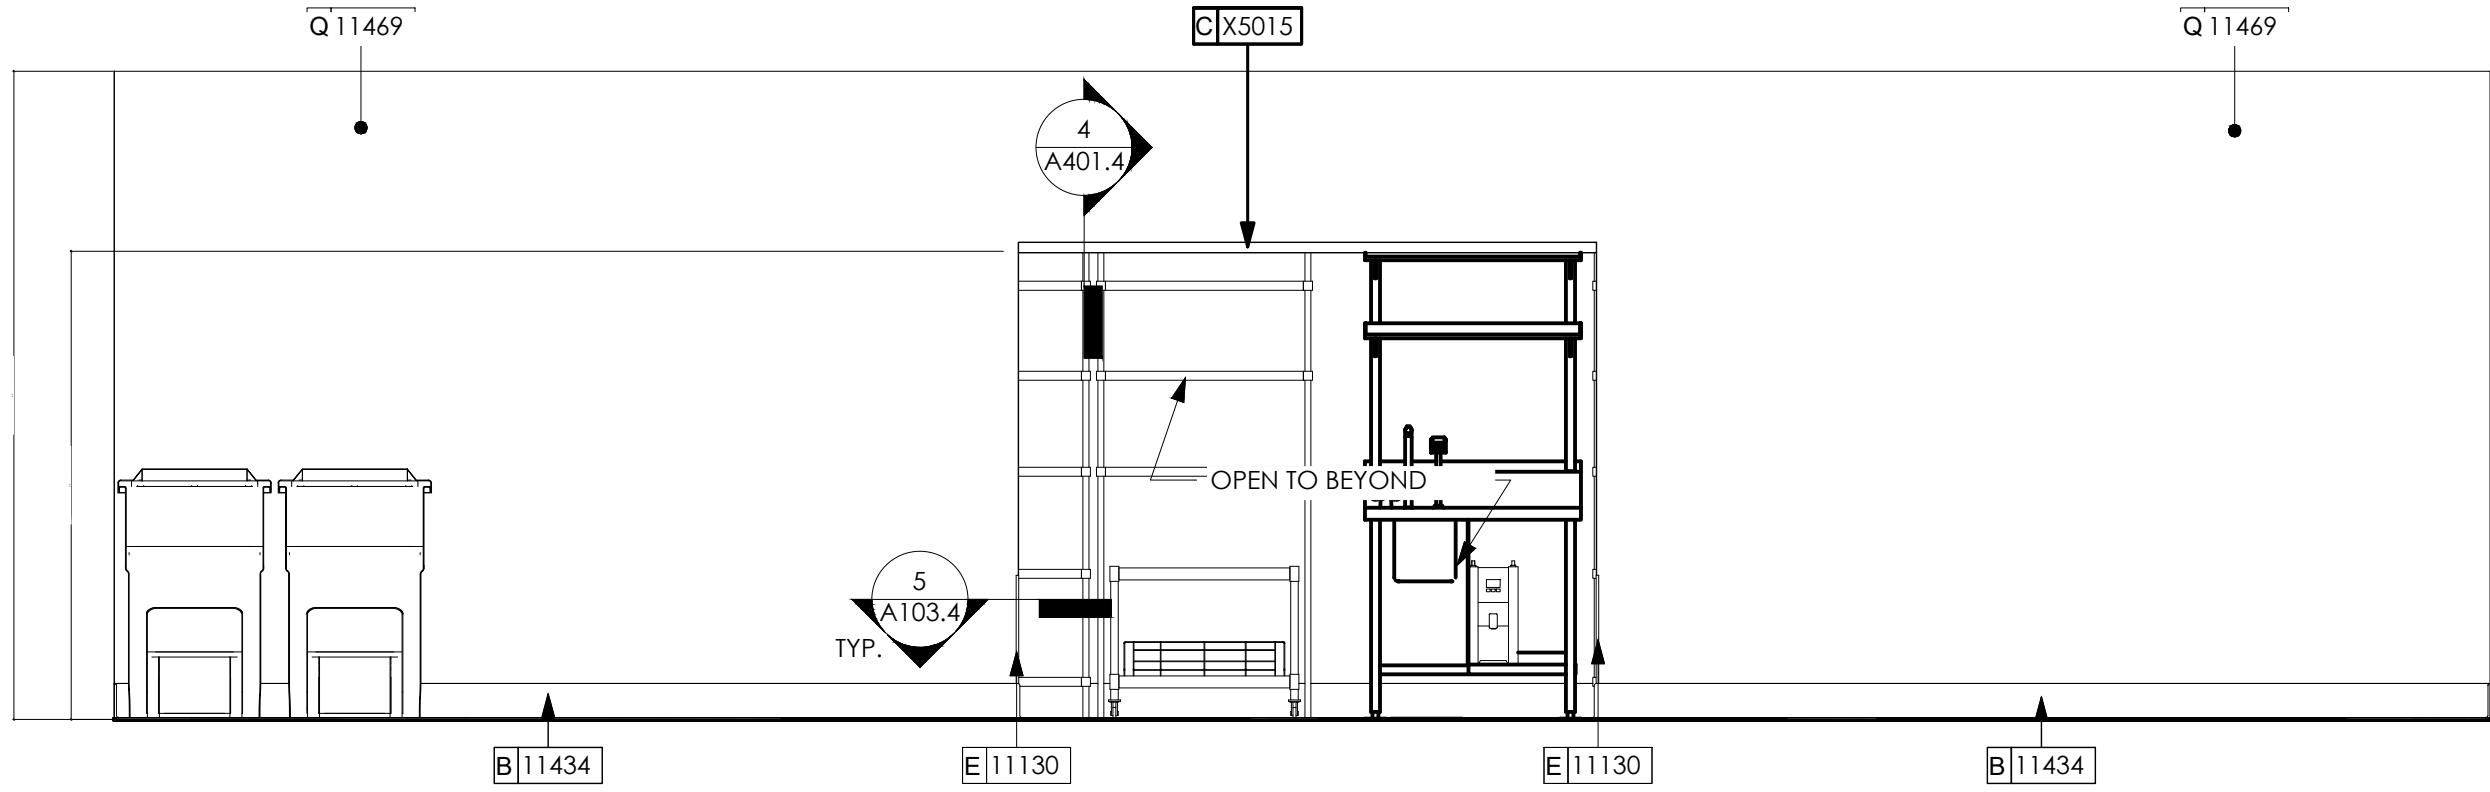


3 WORKROOM EAST ELEVATION A
A403.1 SCALE: 3/8" = 1'-0"

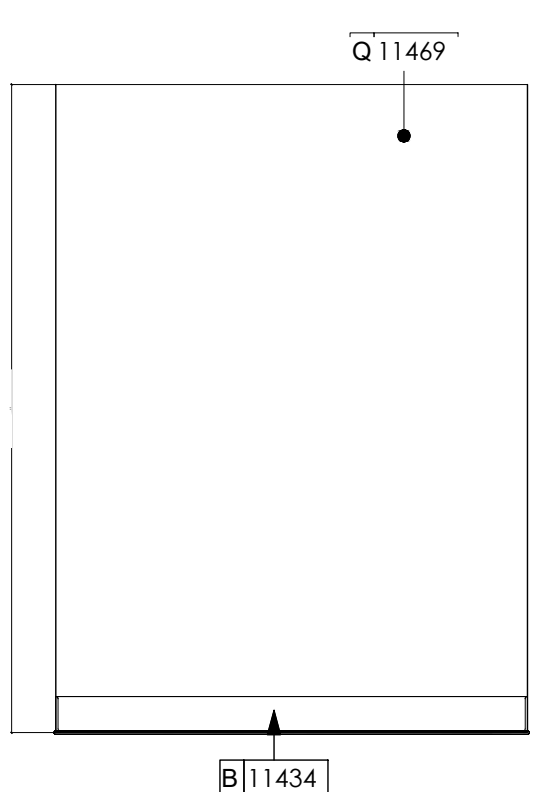


4 WORKROOM SOUTH ELEVATION A
A403.1 SCALE: 3/8" = 1'-0"

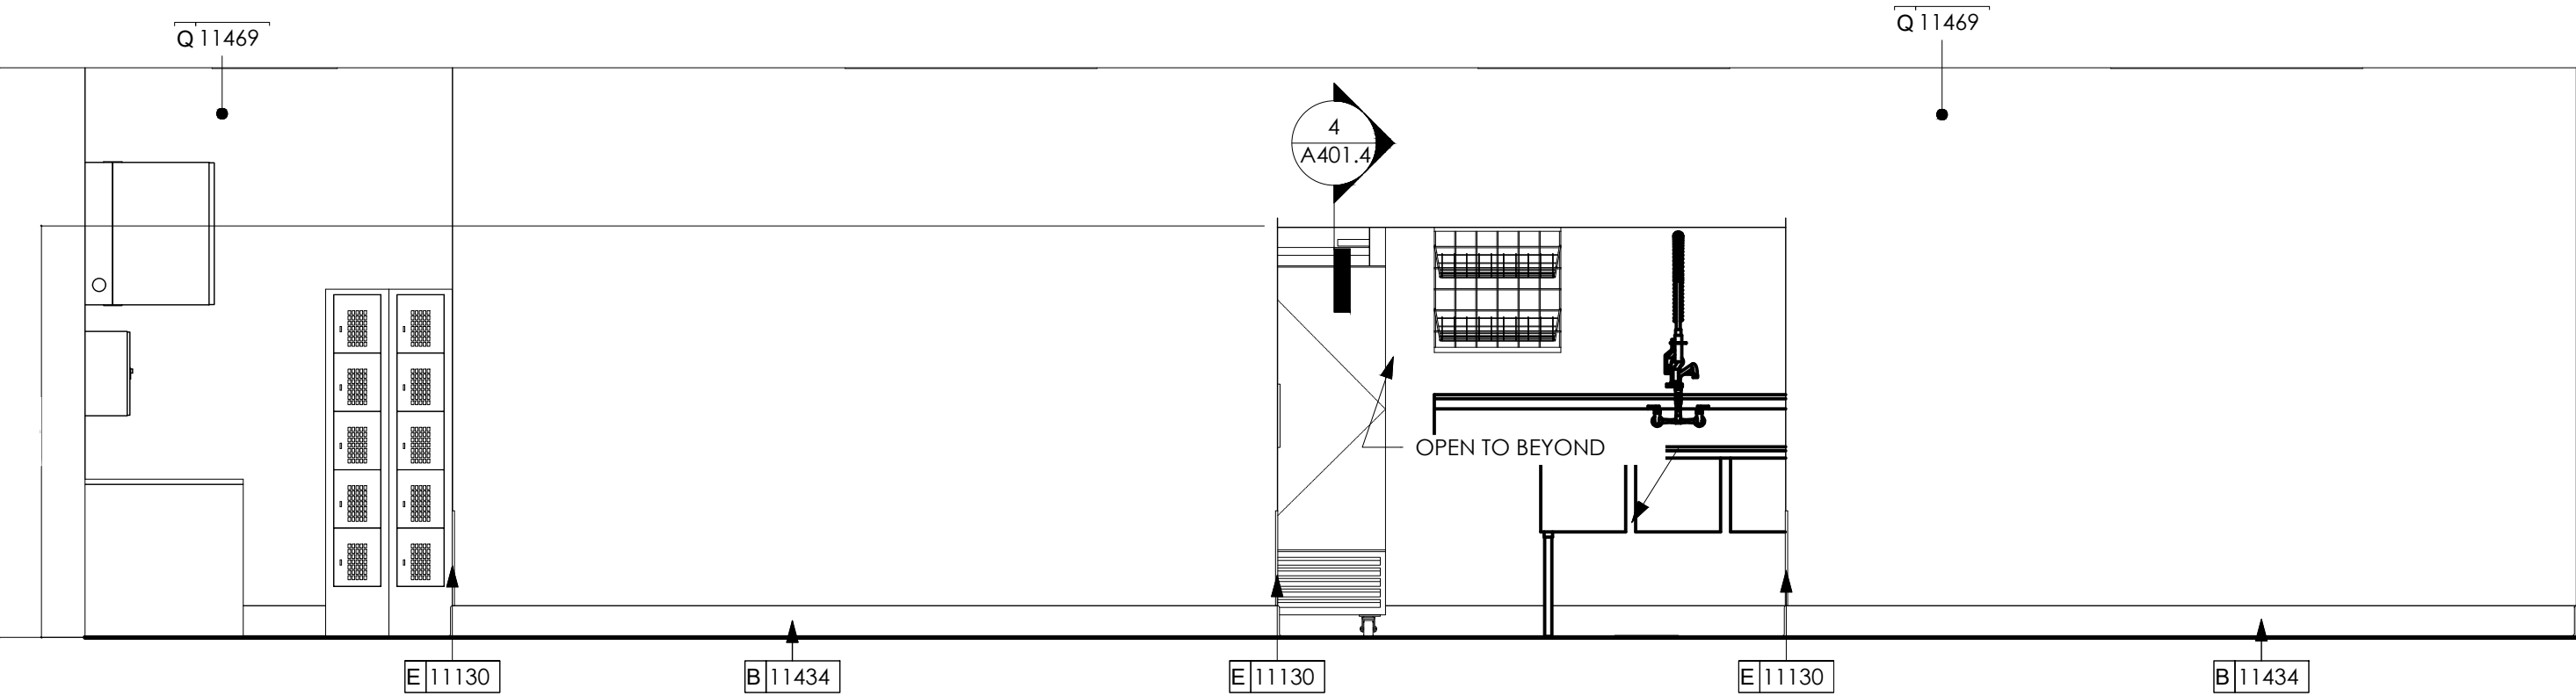


5 WORKROOM WEST ELEVATION B
A403.2 SCALE: 3/8" = 1'-0"

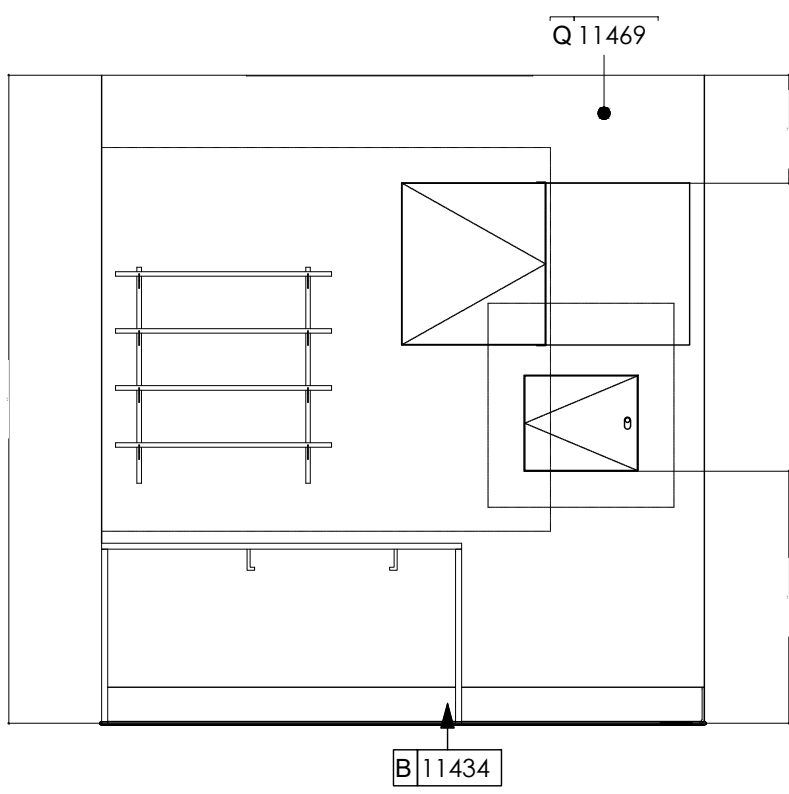

6 WORKROOM MANAGER'S DESK ELEVATION
A403.2 SCALE: 3/8" = 1'-0"

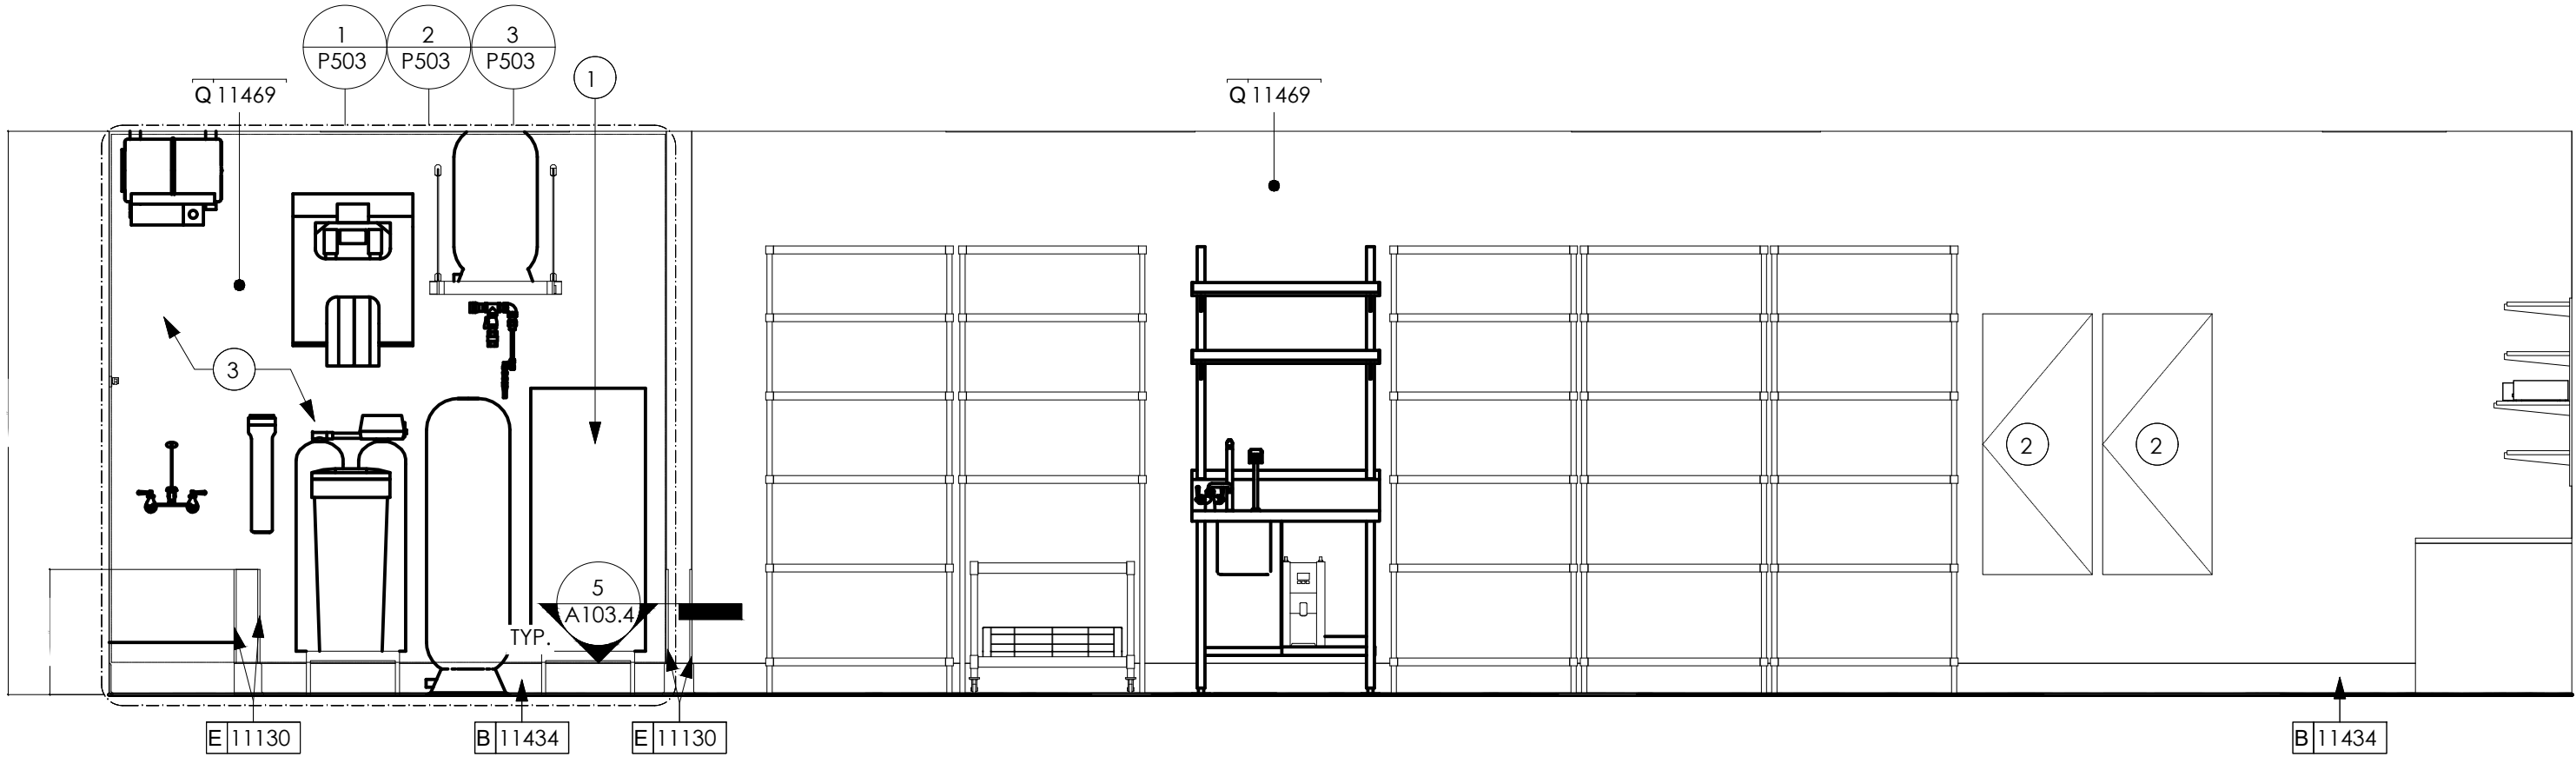

7 WORKROOM EAST ELEVATIONS B
A403.2 SCALE: 3/8" = 1'-0"

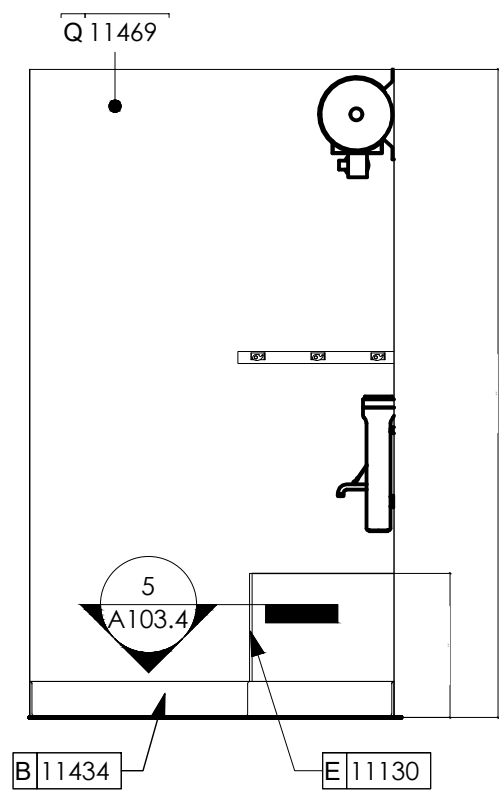

8 WORKROOM NORTH ELEVATION B
A403.1 SCALE: 3/8" = 1'-0"

KEYED NOTES

1. WALL MOUNT HAND SINK WITH SOAP AND PAPER TOWEL DISPENSER. ENSURE MOUNTING HEIGHTS CONFORM TO ACCESSIBILITY CODES. GENERAL CONTRACTOR TO PROVIDE BLOCKING FOR FASTENERS.
2. ICE MACHINE. SEE PLUMBING AND ELECTRICAL DRAWINGS FOR ADDITIONAL INFORMATION.
3. WAREWASHER/SANITIZER SET ON CASTERS FOR CLEANING ACCESS.

GENERAL NOTES

- A. FLOORS, WALL, AND CEILING FINISHES IN FOOD PREPARATION AREAS SHALL BE SMOOTH, NON-TOXIC, NON-ABSORBENT, DURABLE, AND EASILY CLEANABLE. PAINT IN THESE AREAS SHALL BE WASHABLE; SEMI-GLOSS OR HIGH GLOSS FINISH.
- B. CHANGE OF PAINT COLOR ONLY AT INSIDE CORNERS, UNLESS NOTED OTHERWISE.
- C. PAINT SUBSTITUTIONS ARE NOT ALLOWED. USE STARBUCKS NATIONAL SHERWIN WILLIAMS ACCOUNT "COLOR CODE" WHEN ORDERING PAINTS.
- D. PAINT FINISHES SHALL BE APPLIED AS FOLLOWS, UNLESS NOTED OTHERWISE:
 - 1) WOODS AND METAL SURFACES SHALL BE SEMI-GLOSS OR EQUAL.
 - 2) ACCENT AND TRIM PAINTS SHALL BE SEMI-GLOSS OR EQUAL.
 - 3) WALL AND CEILING PAINTS SHALL BE EGGSHELL OR EQUAL.
 - 4) PAINTS IN WORKROOM RESTROOM(S) OR CAFE BAR SHALL BE SEMI-GLOSS OR EQUAL.
- E. REFER TO INTERIOR WALL FINISH PLAN SHEET I106 FOR PAINT SCHEDULE AND WALL FINISH SCHEDULE.
- F. WORKROOM TO BE FINISHED PER LOCAL CODE. GENERAL CONTRACTOR TO PROVIDE AND INSTALL WORKROOM WALL FINISHES.
- G. ALL WOOD SURFACES (DOORS, TRIM, SHELVES, CABINETRY) SHALL BE SEALED.
- H. ALL FLOOR AND WALL JUNCTIONS IN STORAGE AND FOOD PREPARATION AREAS SHALL HAVE A 6" COVED BASE.
- I. GENERAL CONTRACTOR TO INSTALL WALL BLOCKING AND HANGERS FOR WALL SHELVING BEFORE INSTALLING BACK BAR WALL TILE.
- J. REFER TO MANUFACTURER'S INSTRUCTIONS INCLUDED WITH ARTWORK / GRAPHICS FOR PROPER INSTALLATION.

LEGEND

- INDICATES WALL BLOCKING. FIRE TREATED WALL BLOCKING TO BE PROVIDED AS REQUIRED TO SUPPORT WALL ATTACHMENTS. EXTEND BLOCKING 4" BEYOND EDGE OF ATTACHMENTS.

ARCHITECT OF RECORD:

THOMAS E. MORGAN, JR.
ARCHITECT

423 FISCHER TRAIL
ELLIJAY, GEORGIA 30540

SEAL:

MRP
DESIGN GROUP

3450 Acworth Due West Road
Building 100, Suite 120
Kennesaw, Georgia 30144
P. 770-917-9172
F. 770-917-9470
www.mrpdesign.com

RELEASED FOR
CONSTRUCTION

ISSUES / REVISIONS:

DATE	DESCRIPTION
01.28.28	COMPILED SET RELEASED FOR CONSTRUCTION

DRAWN BY:

CHKD BY:

PROJECT DESCRIPTION:

DEVELOPMENT OF INTERIORS
CONDITIONS FOR A C-STORE IN
CORDELE, GA.

PROJECT TITLE:

CONVENIENCE STORE
379 ROCKHOUSE RD E,
CORDELE, GA 31015

 















SHEET TITLE:

STARBUCKS
INTERIOR
DETAILS

PROJECT NO: 25049

A403.2

THESE PLANS ARE THE PROPERTY OF MRP DESIGN GROUP, INC. AND ARE SUBJECT TO FEDERAL COPYRIGHT LAWS. ANY USE OF SAME WITHOUT THE EXPRESS WRITTEN PERMISSION OF MRP DESIGN GROUP, INC. IS STRICTLY PROHIBITED.

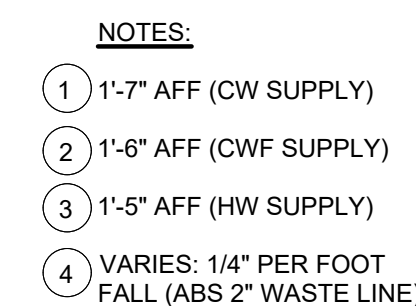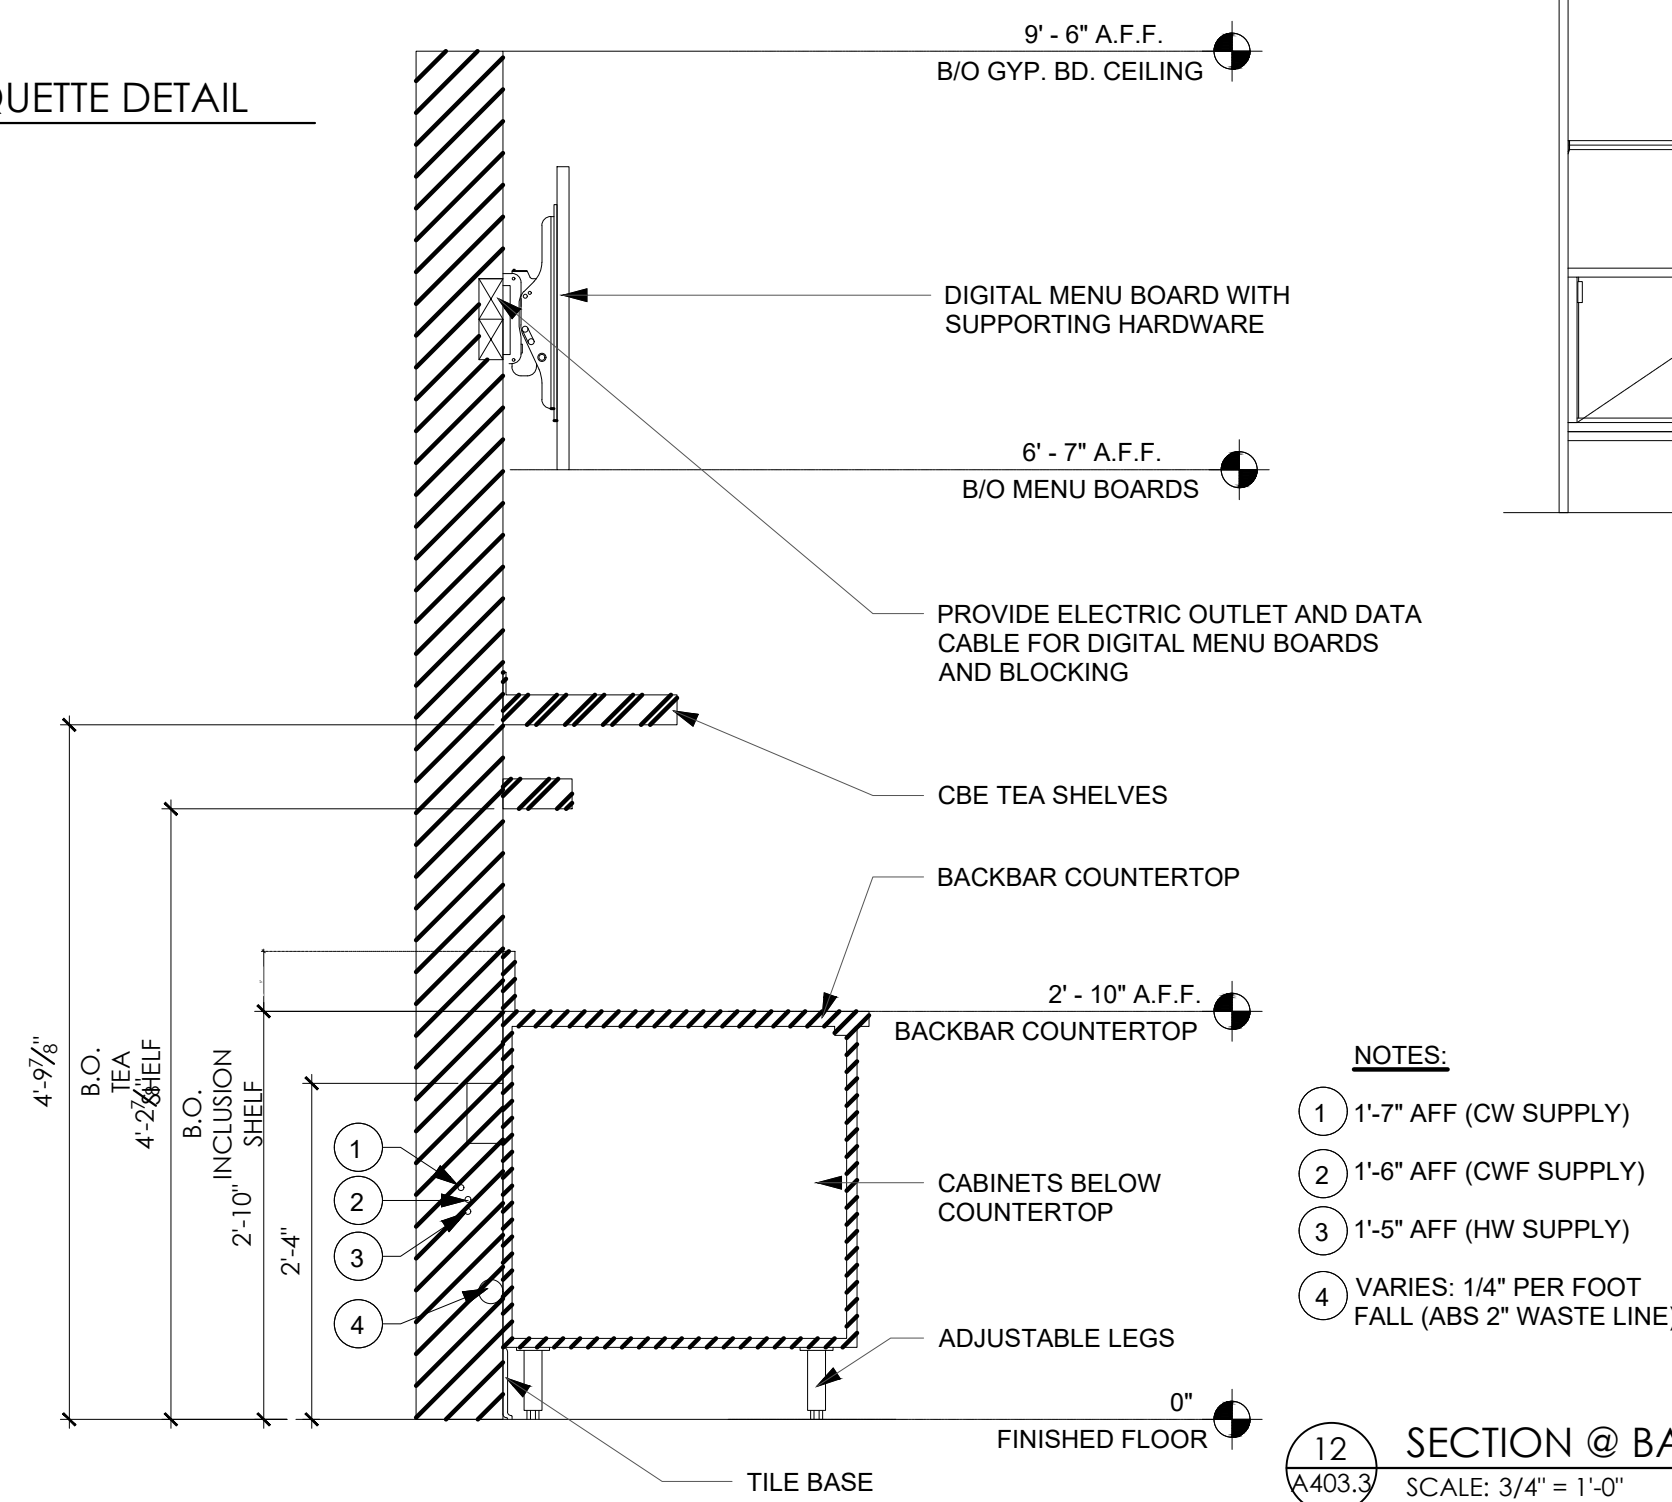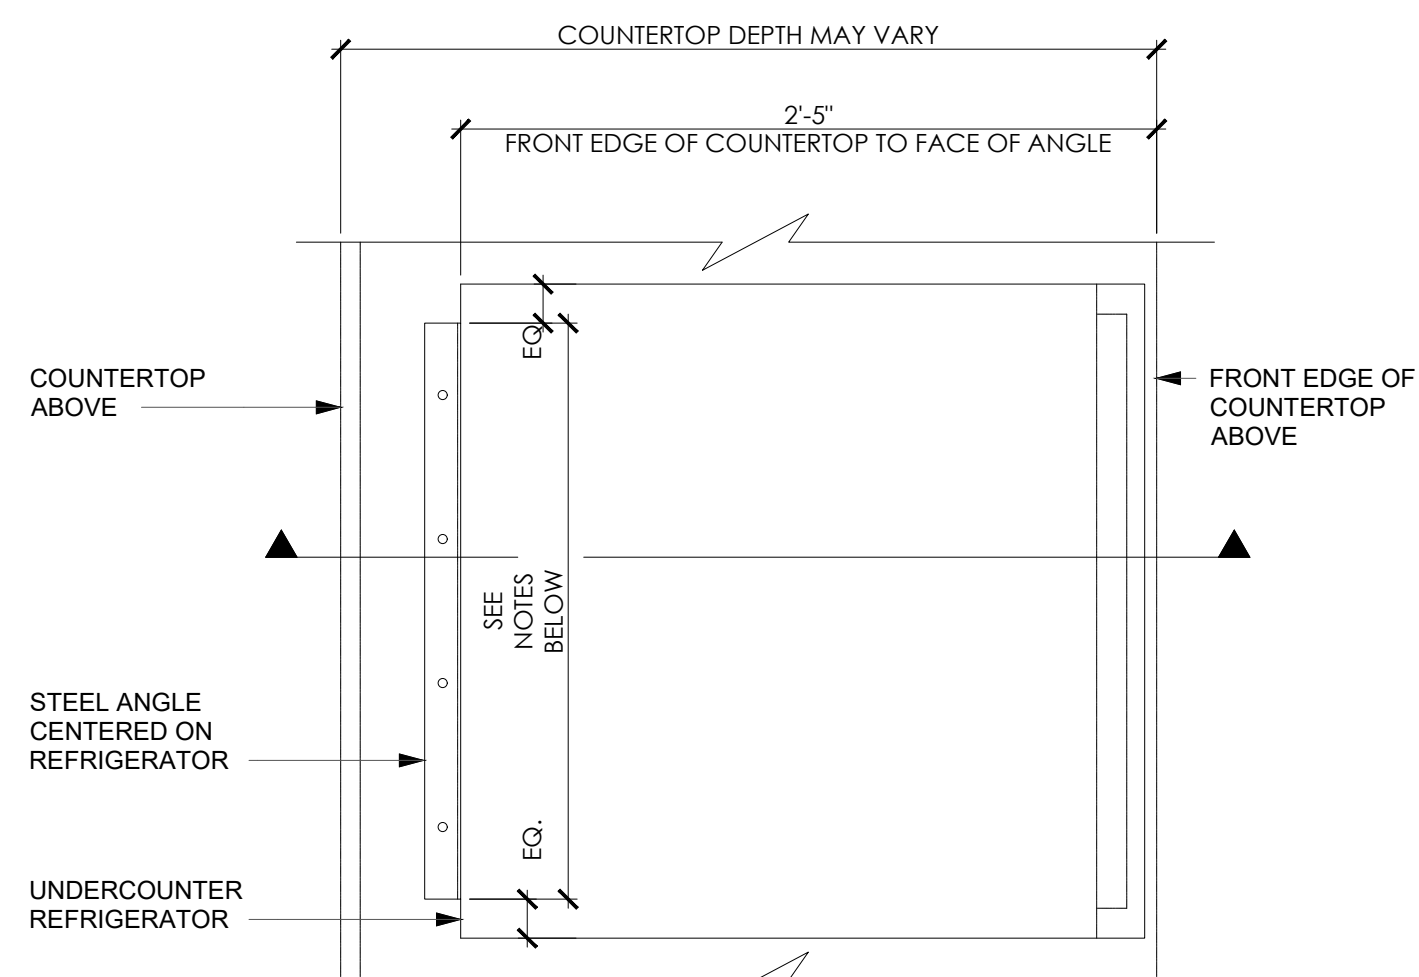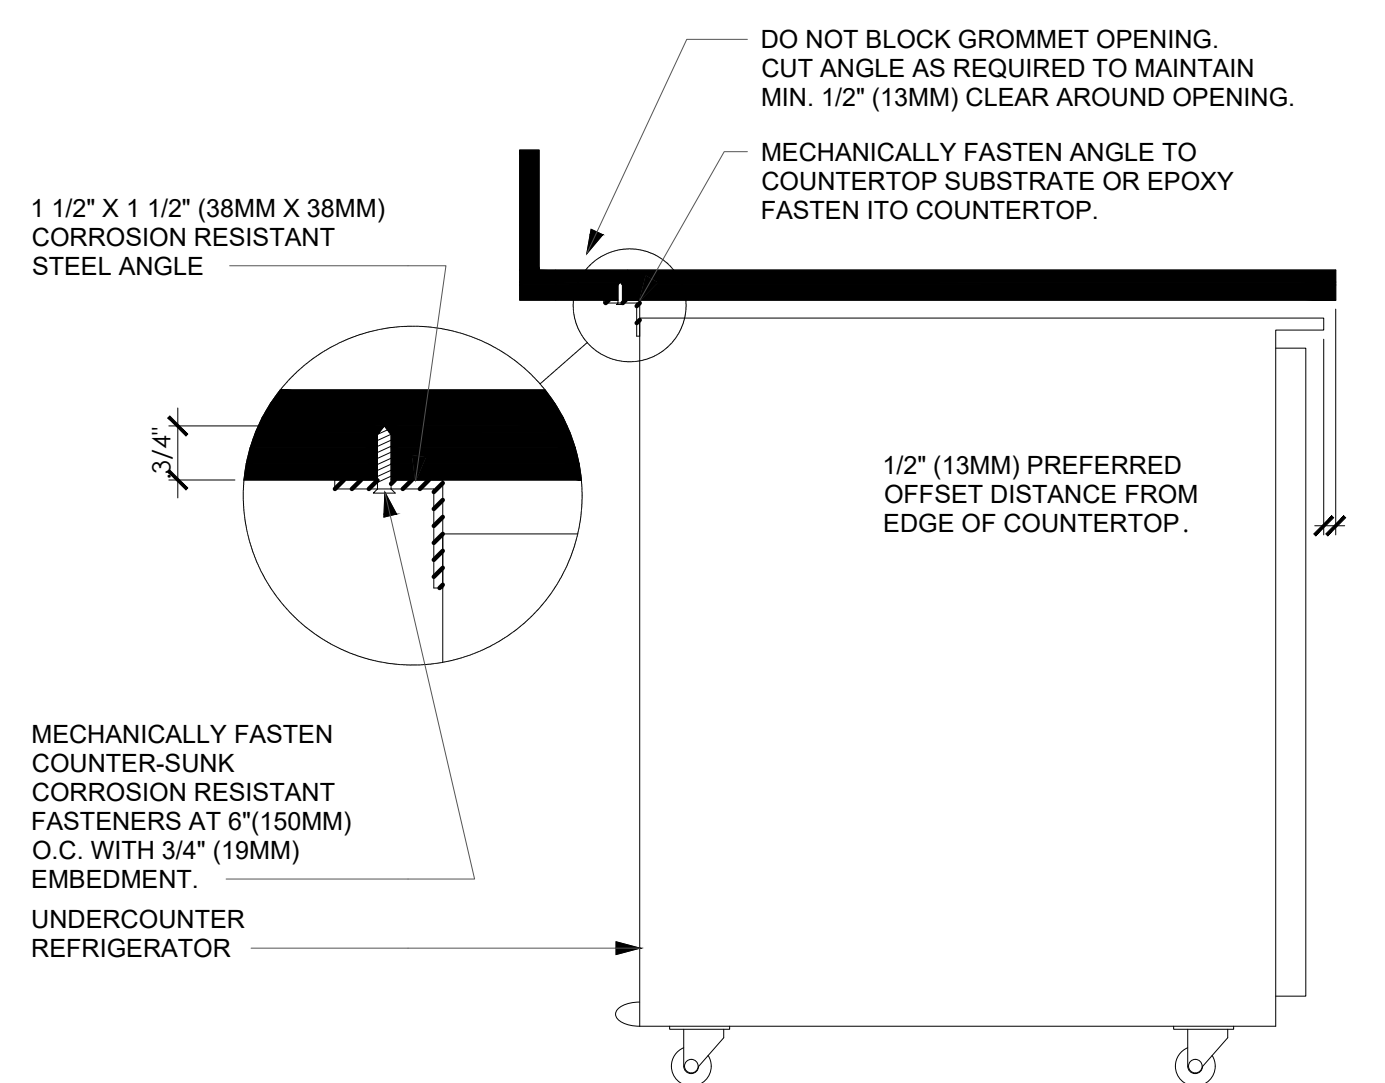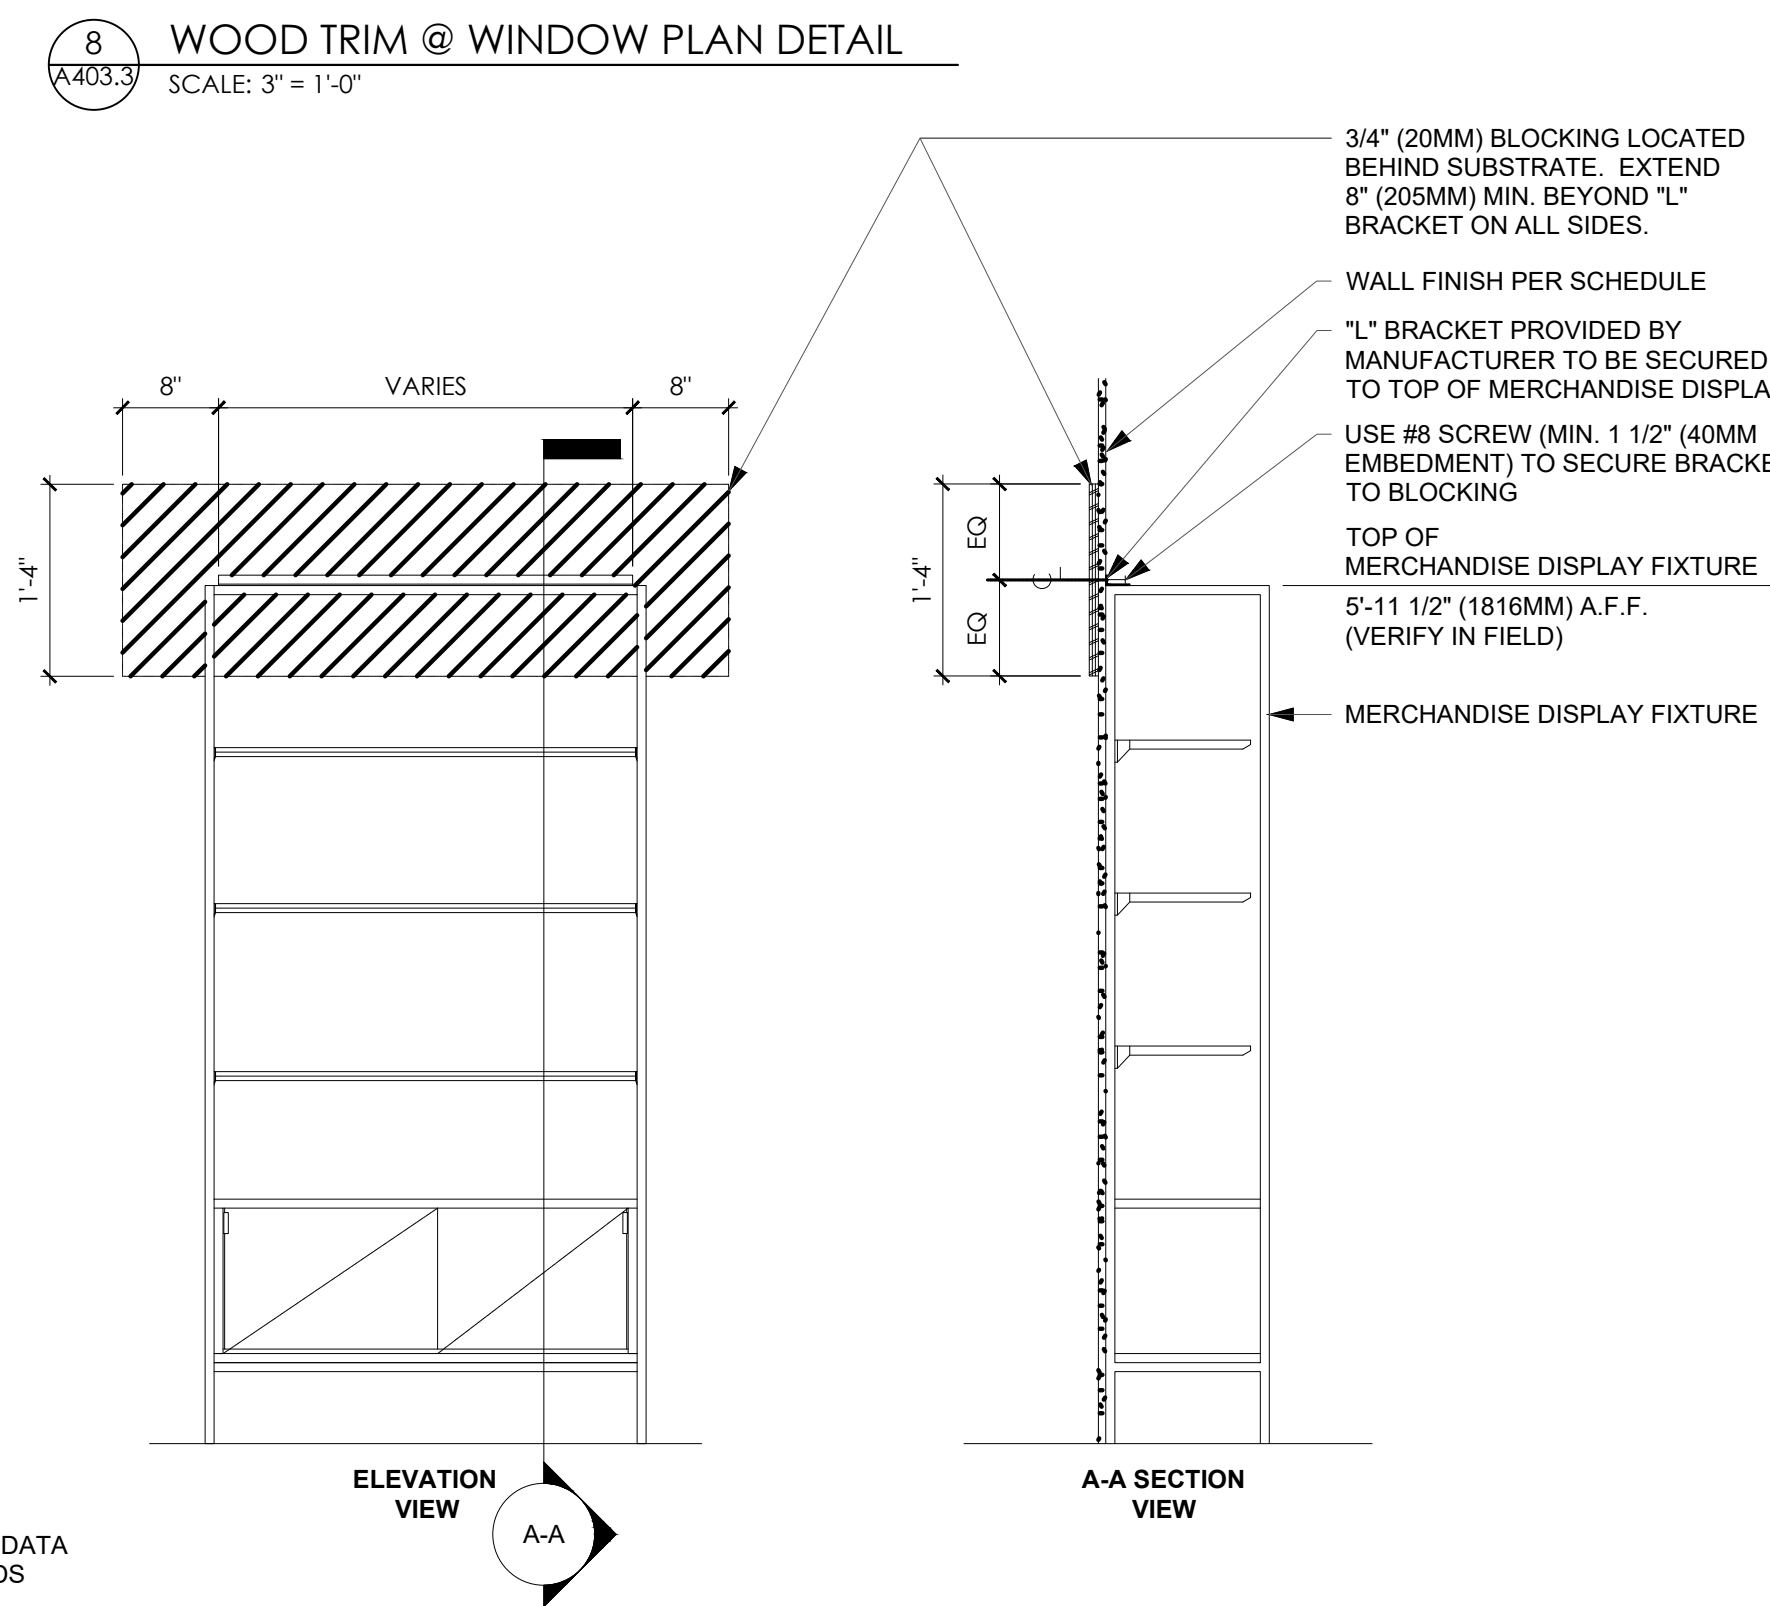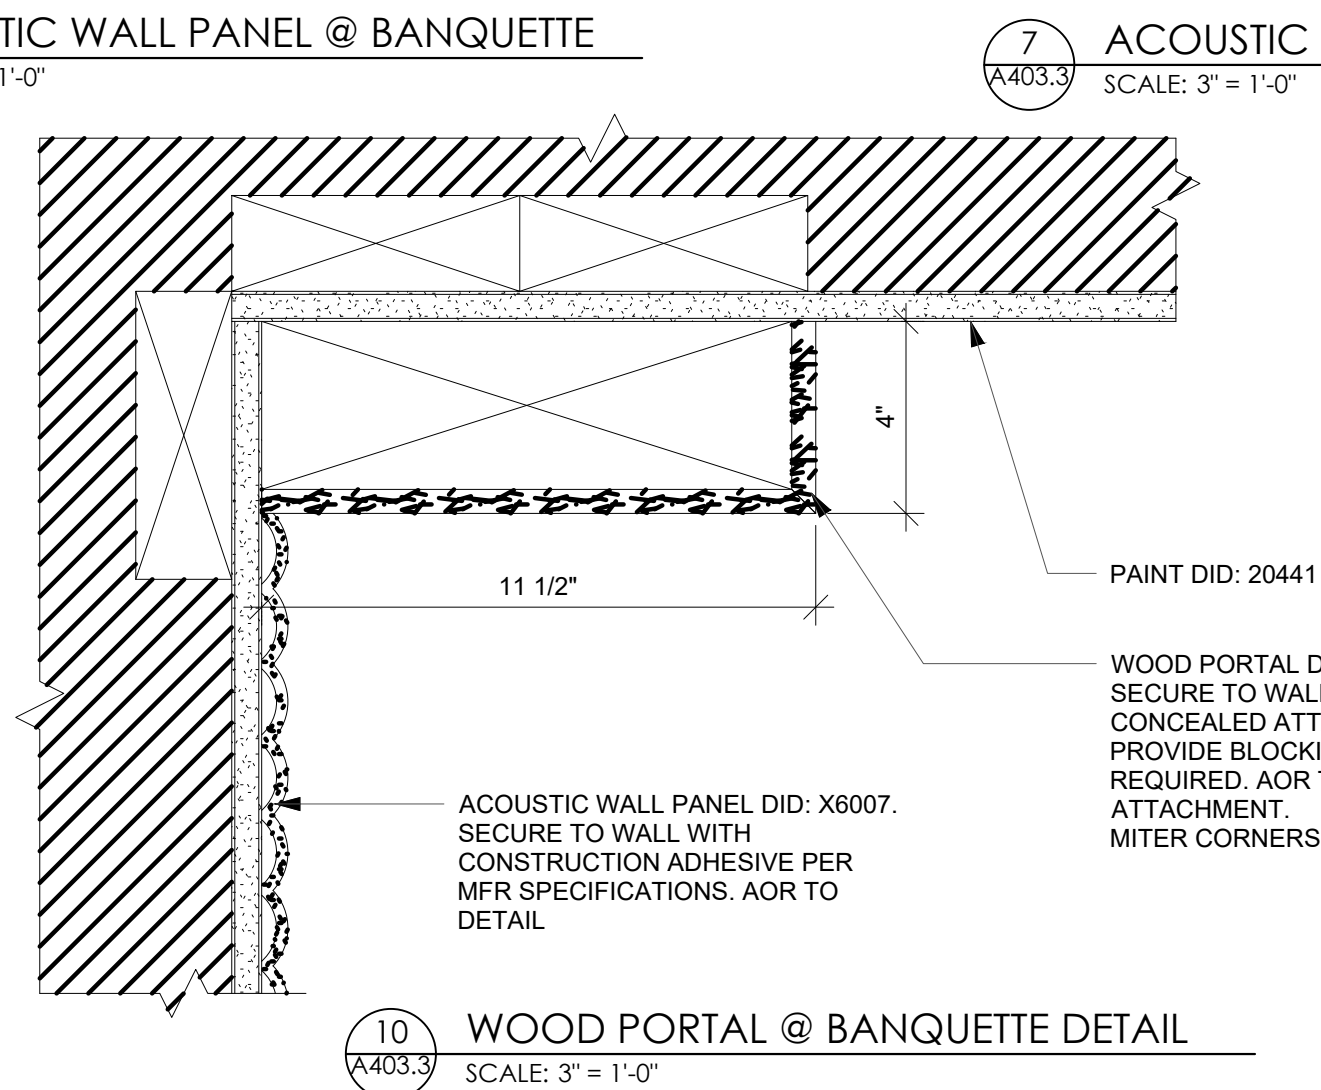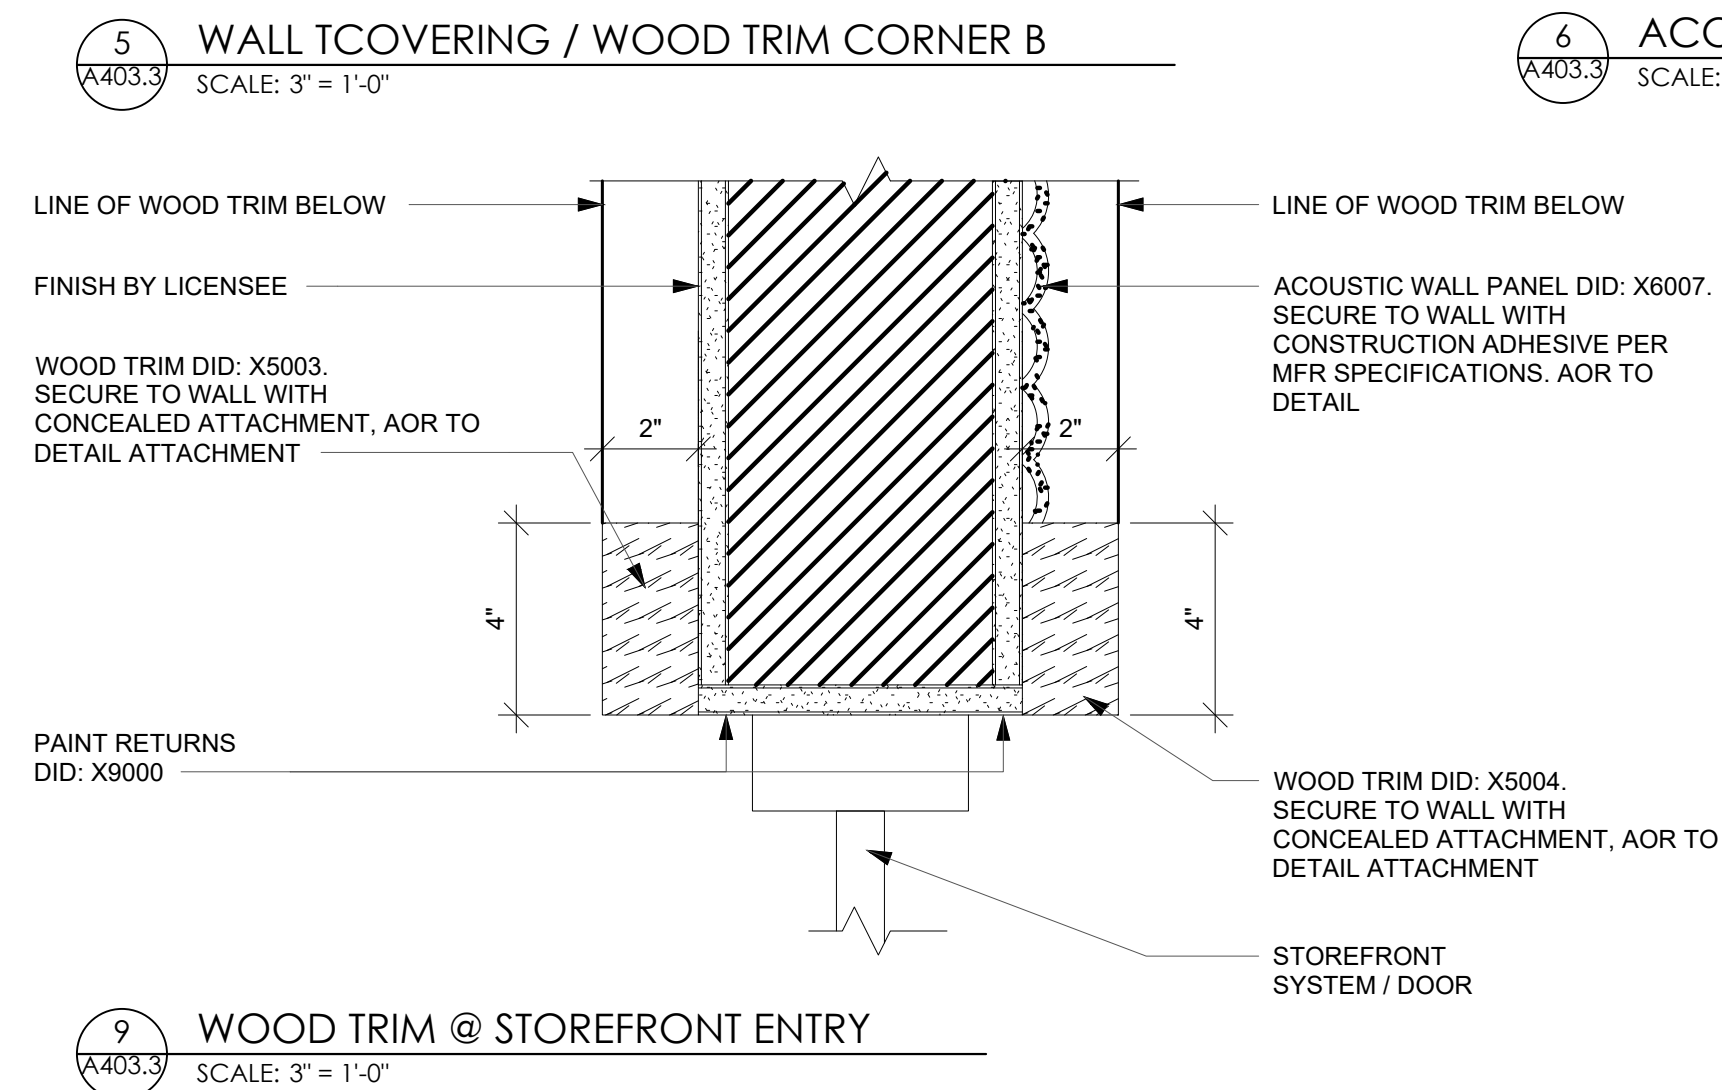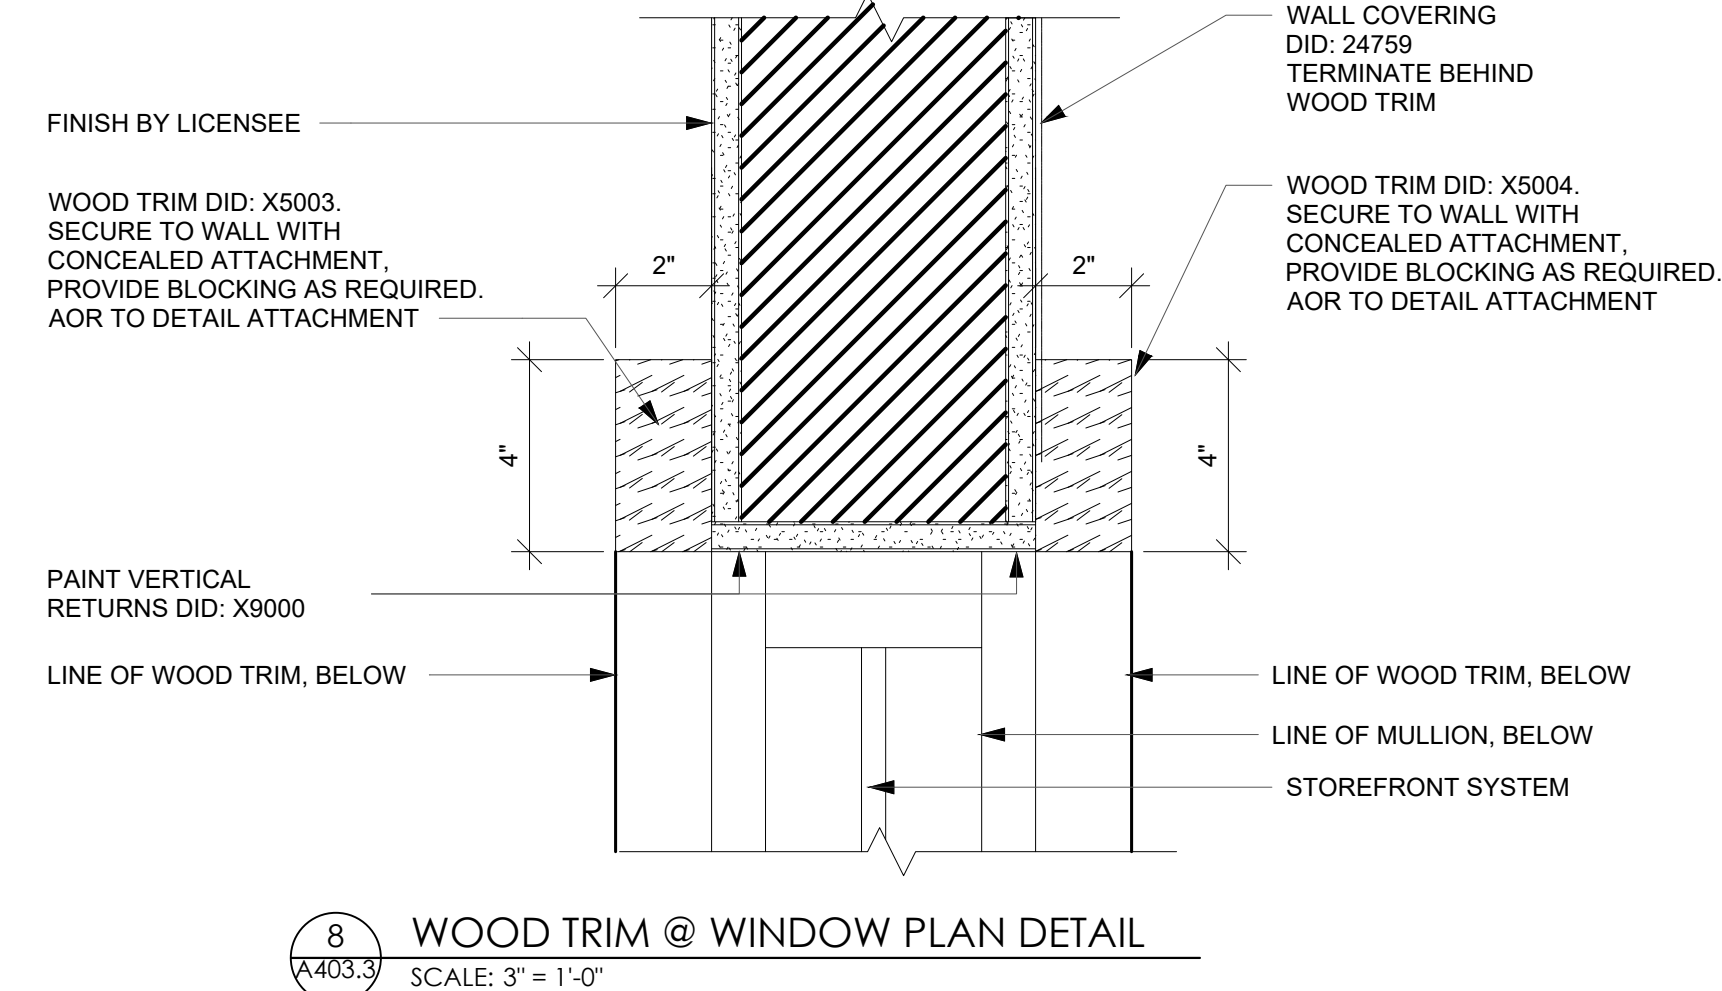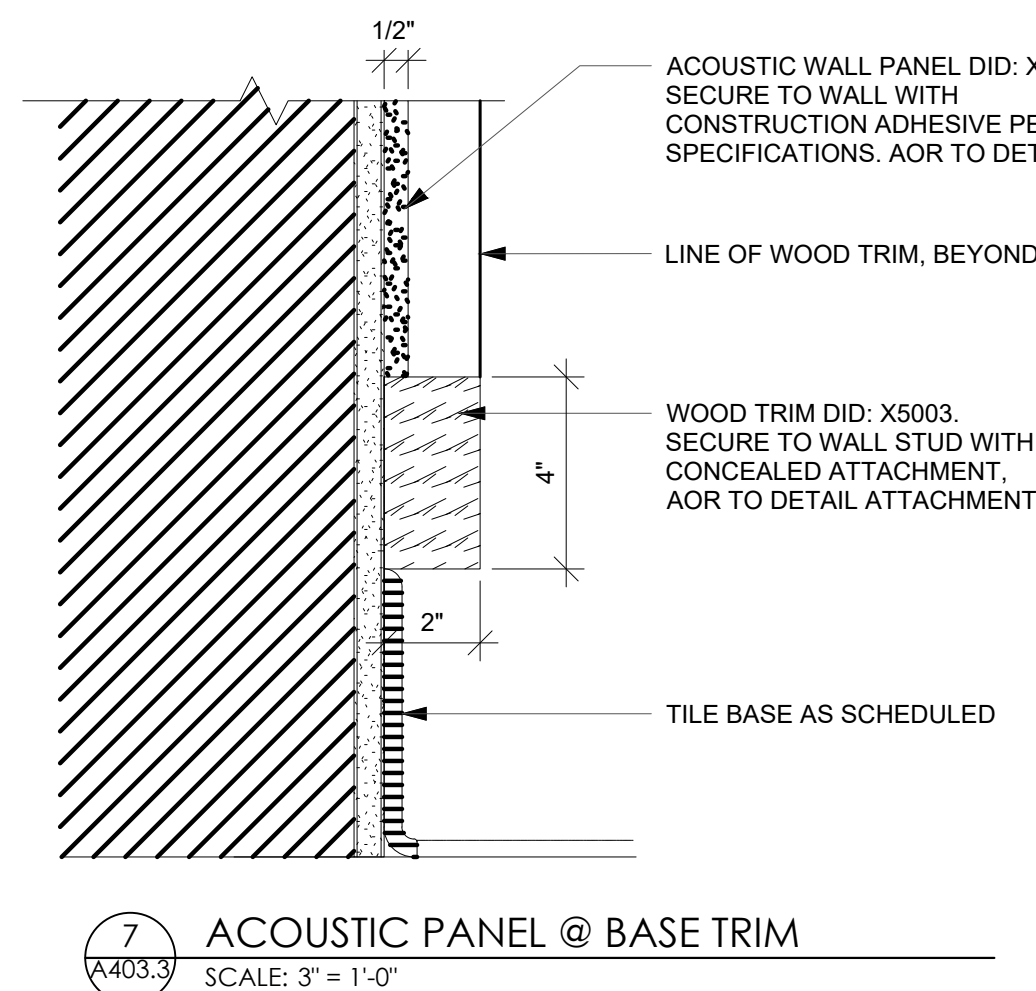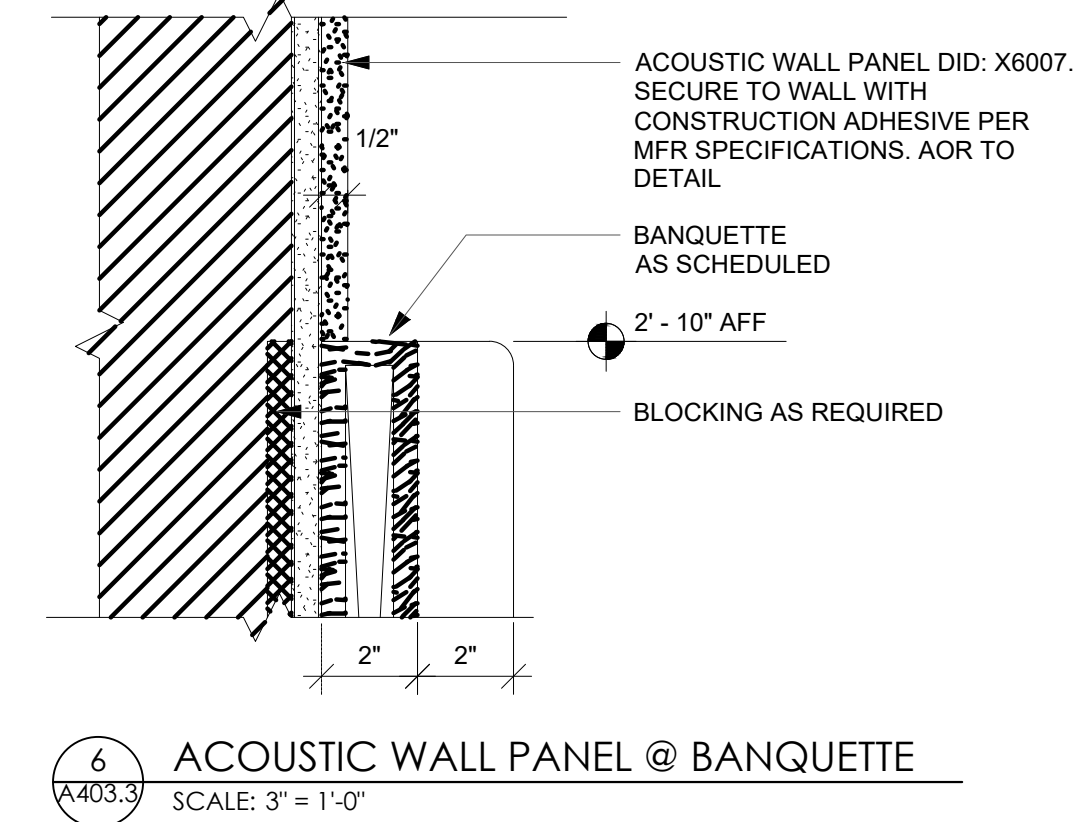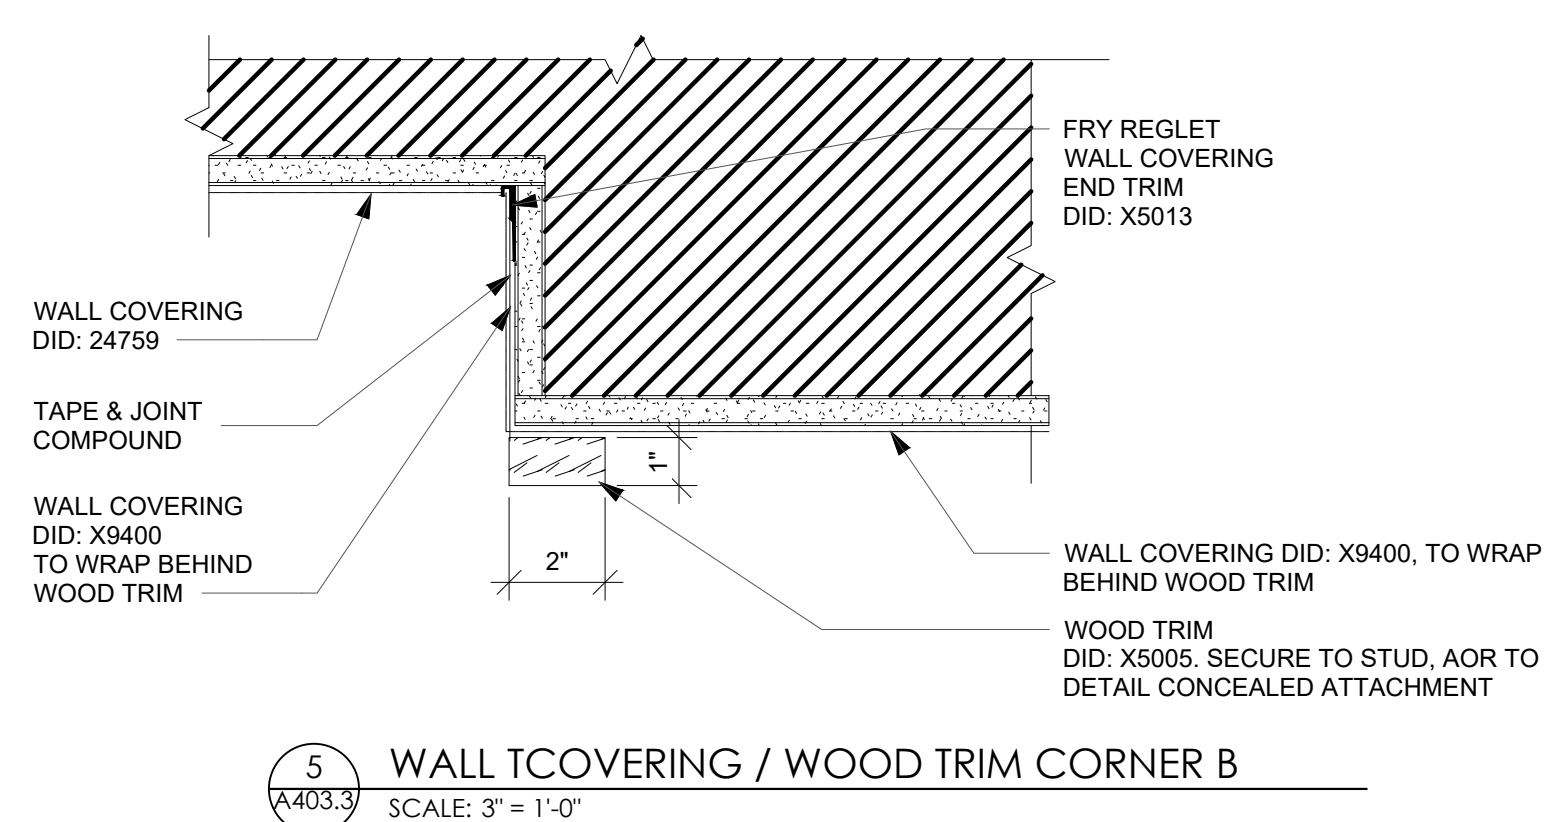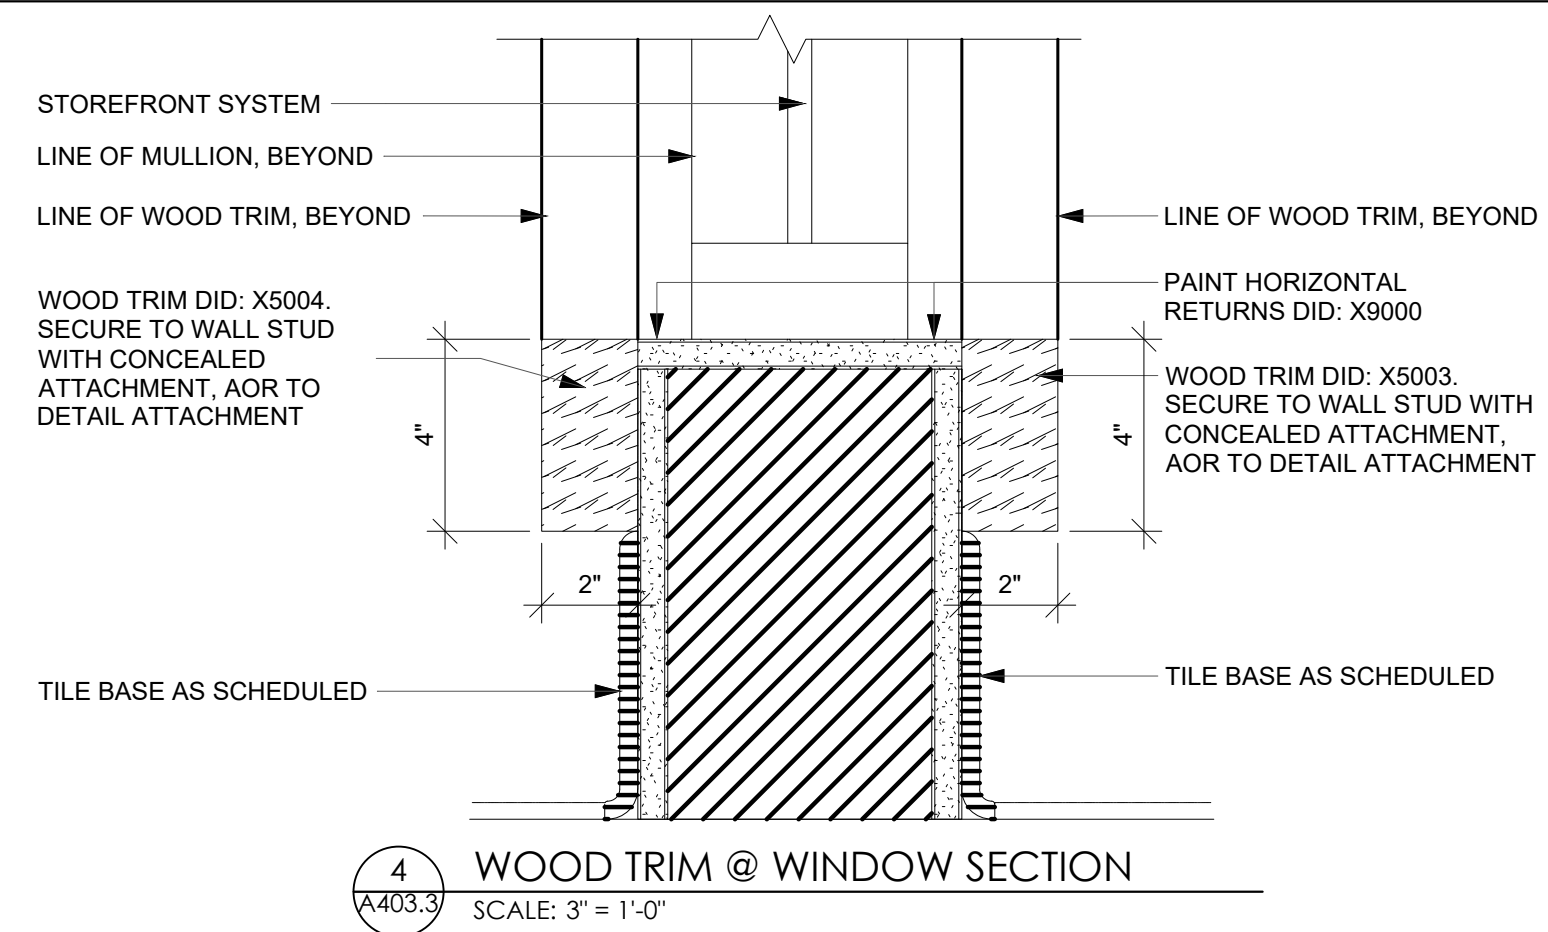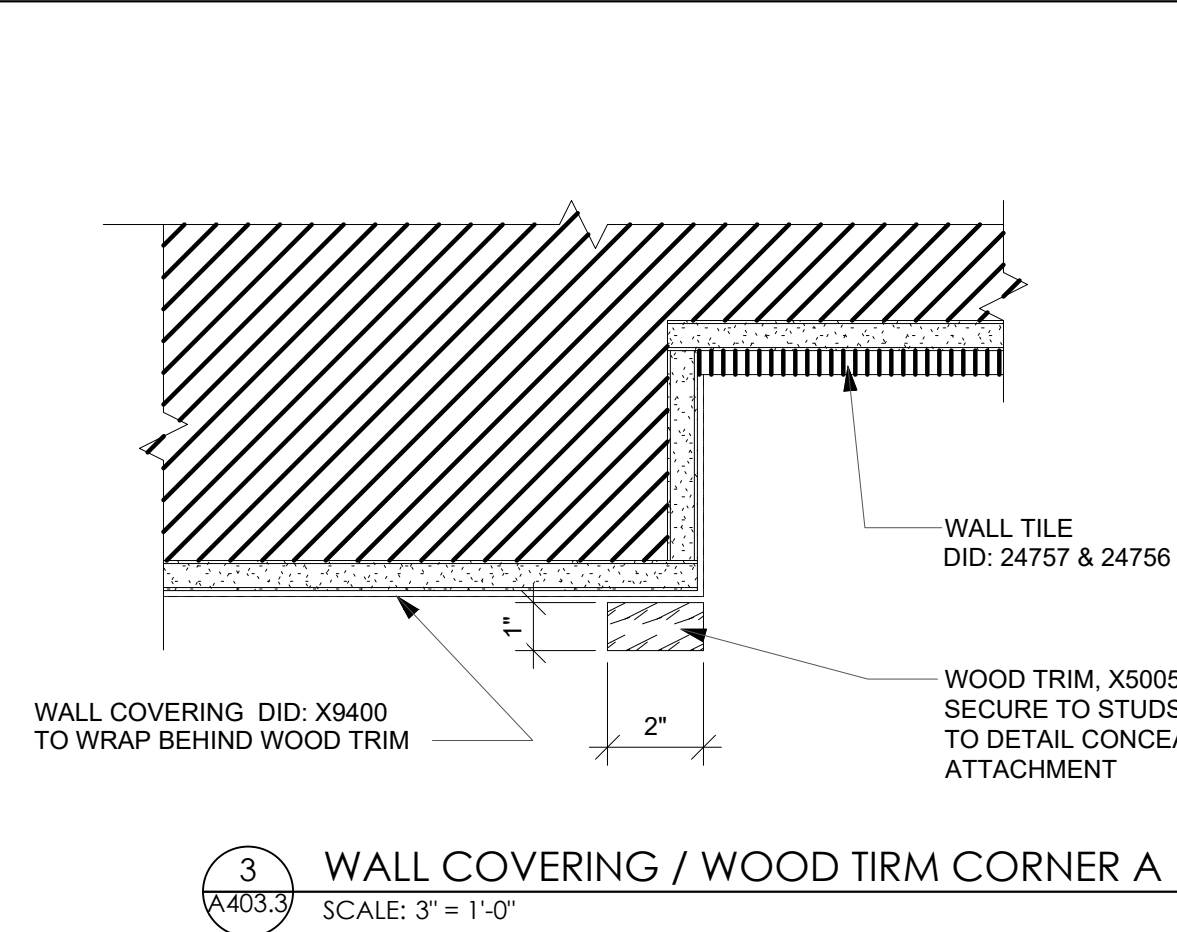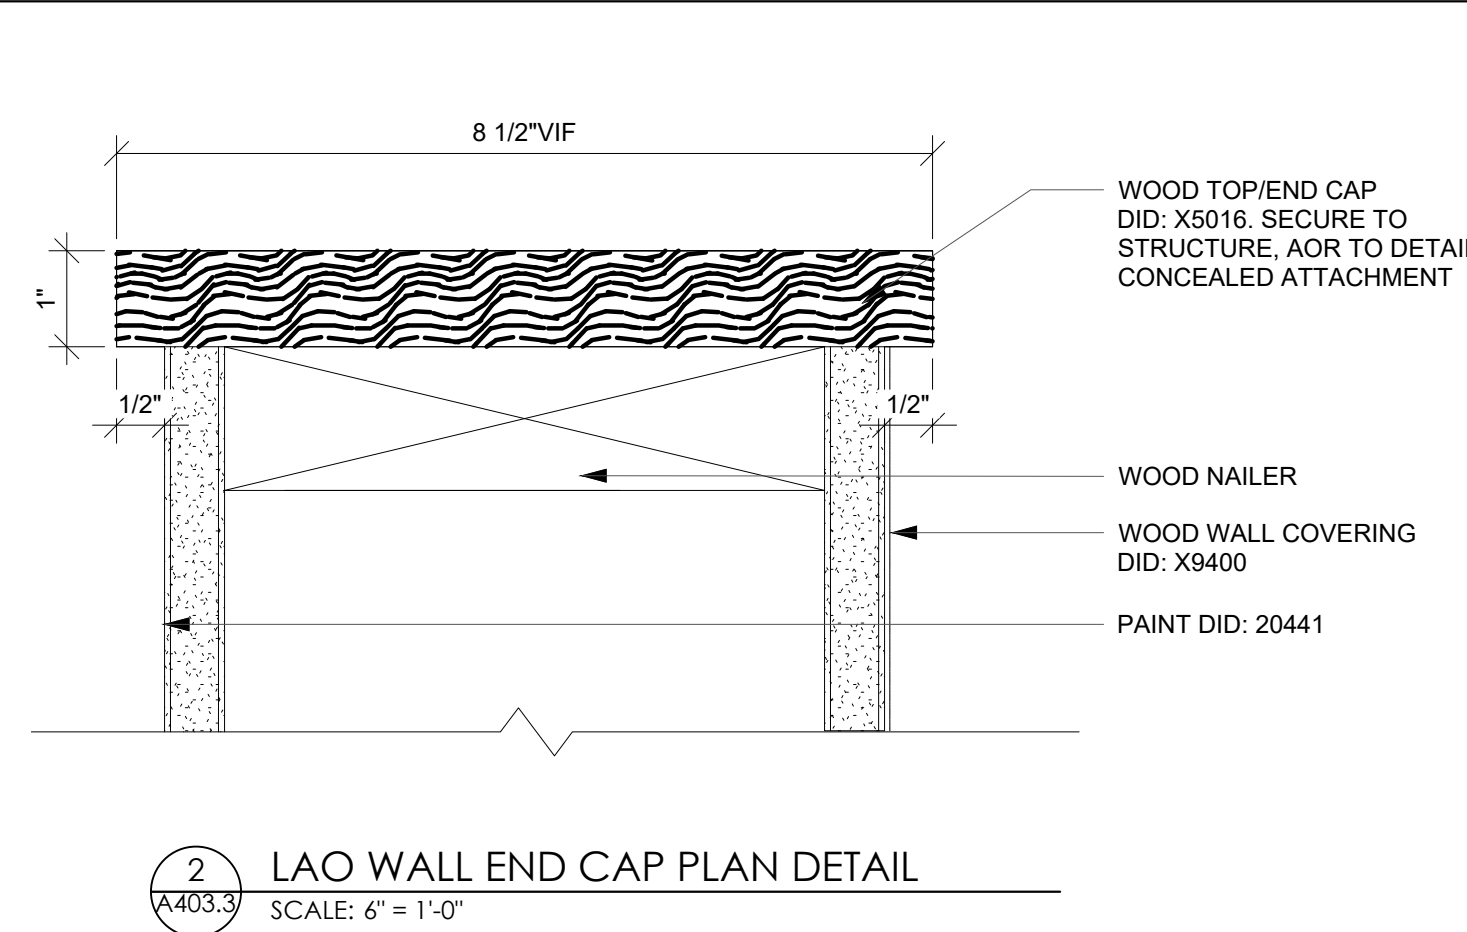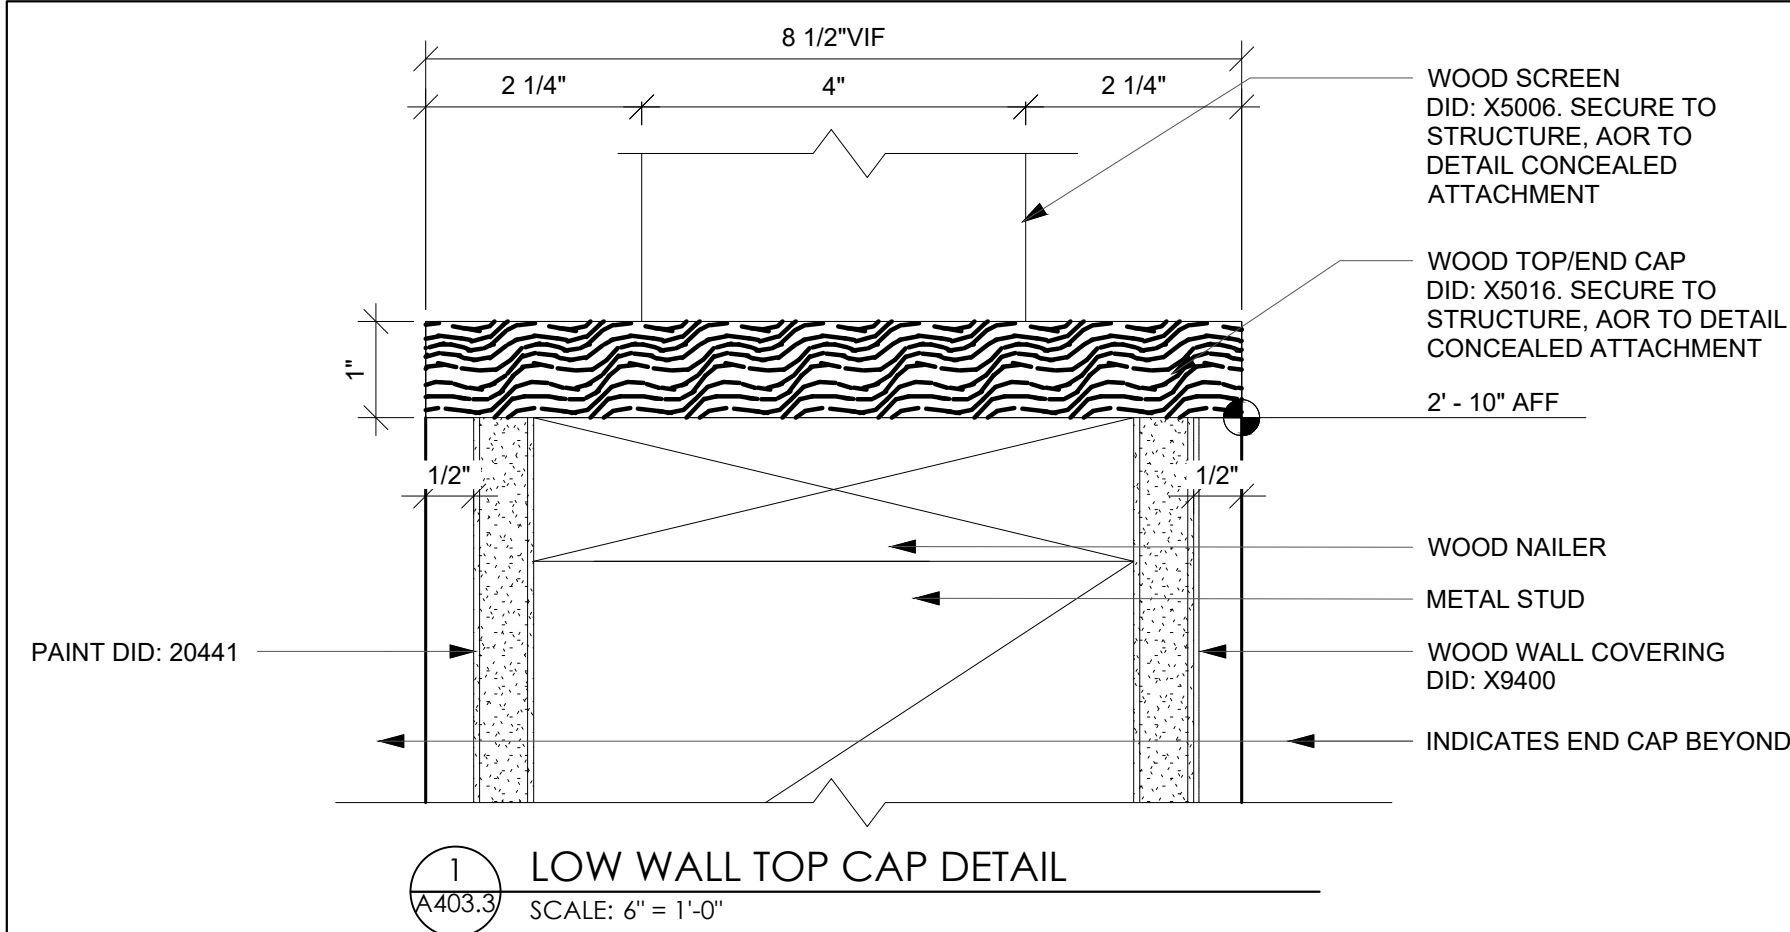

SECTION VIEW

NOTES

1. 24" (610MM) 1 1/2" X 1 1/2" (38MM X 38MM) STEEL ANGLE TO BE USED WITH SINGLE DOOR REFRIGERATORS.
2. 48" (1220MM) 1 1/2" X 1 1/2" (38MM X 38MM) STEEL ANGLE TO BE USED WITH DOUBLE DOOR REFRIGERATORS.

PLAN VIEW

11 UNDERCOUNTER REFRIGERATOR STOP INSTALLATION
A403.3 SCALE: 1-1/2" = 1'-0"

ARCHITECT OF RECORD

THOMAS E. MORGAN, JR.
ARCHITECT

423 FISCHER TRAIL
ELLIJAY, GEORGIA 30540

SEAL:



3450 Acworth Due West Road
Building 100, Suite 120
Kennesaw, Georgia 30144
P. 770-917-9172
F. 770-917-9470
www.mrpdesign.com

RELEASED FOR
CONSTRUCTION

ISSUES / REVISIONS:

[illegible]

DRAWN BY

CHK'D BY:

PROJECT DESCRIPTION:DEVELOPMENT OF INTERIORS
CONDITIONS FOR A C-STORE IN
CORDELE, GA.

PROJECT TITLE:

CONVENIENCE STORE
379 ROCKHOUSE RD E,
CORDELE, GA 31015


SHEET TITLE:

STARBUCKS INTERIOR DETAILS


PROJECT NO: 2504

A403.3


THESE PLANS ARE THE PROPERTY OF MRP DESIGN GROUP, INC. AND ARE SUBJECT TO FEDERAL COPYRIGHT LAWS. ANY USE OF SAME WITHOUT THE EXPRESS WRITTEN PERMISSION OF MRP DESIGN GROUP, INC. IS STRICTLY PROHIBITED.

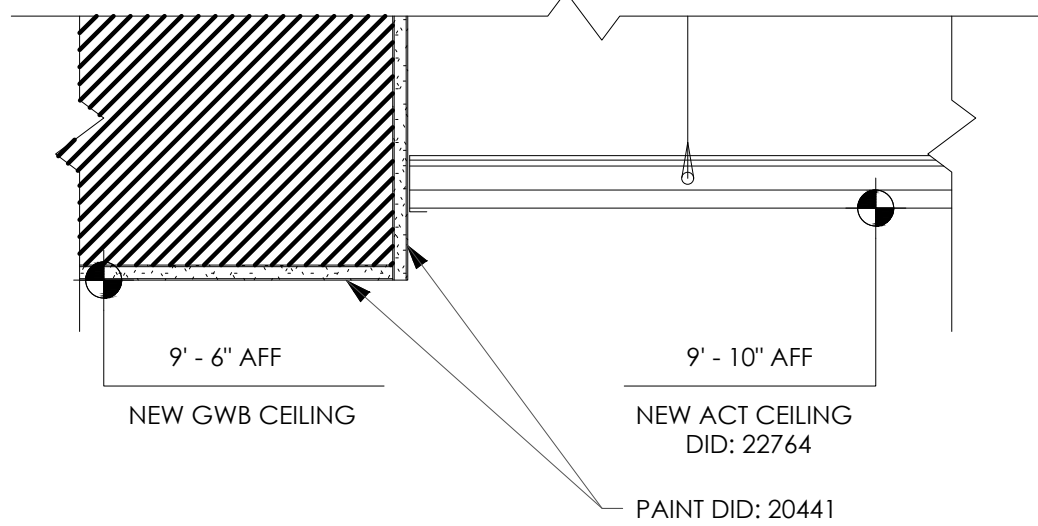


1 CAFE CEILING TRANSITION DETAIL
A401.4 SCALE: 1-1/2" = 1'-0"

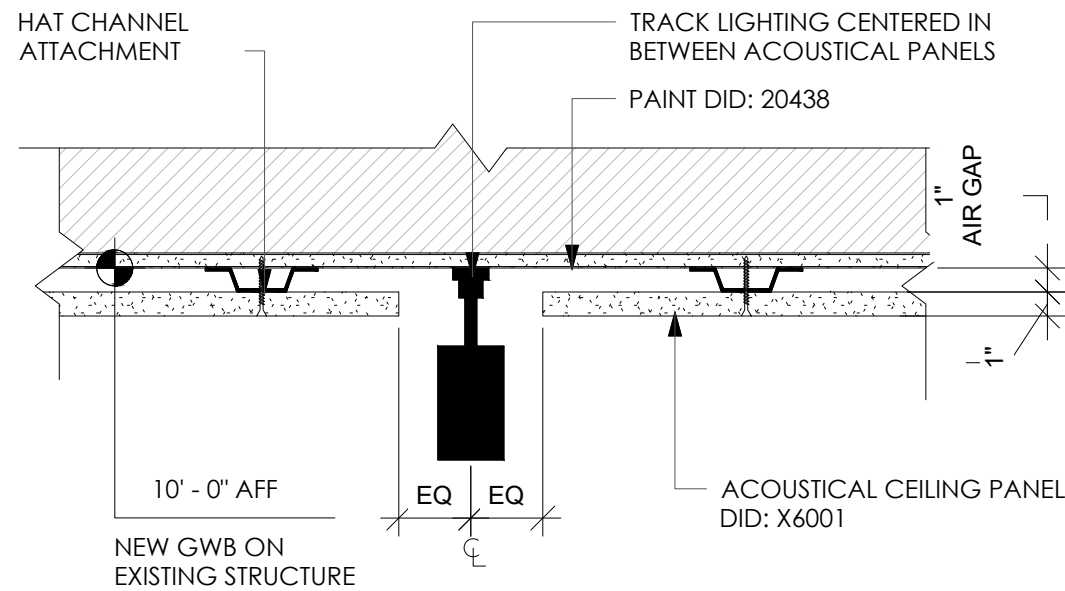


2 TRACK LIGHTING DETAIL
A401.4 SCALE: 1-1/2" = 1'-0"

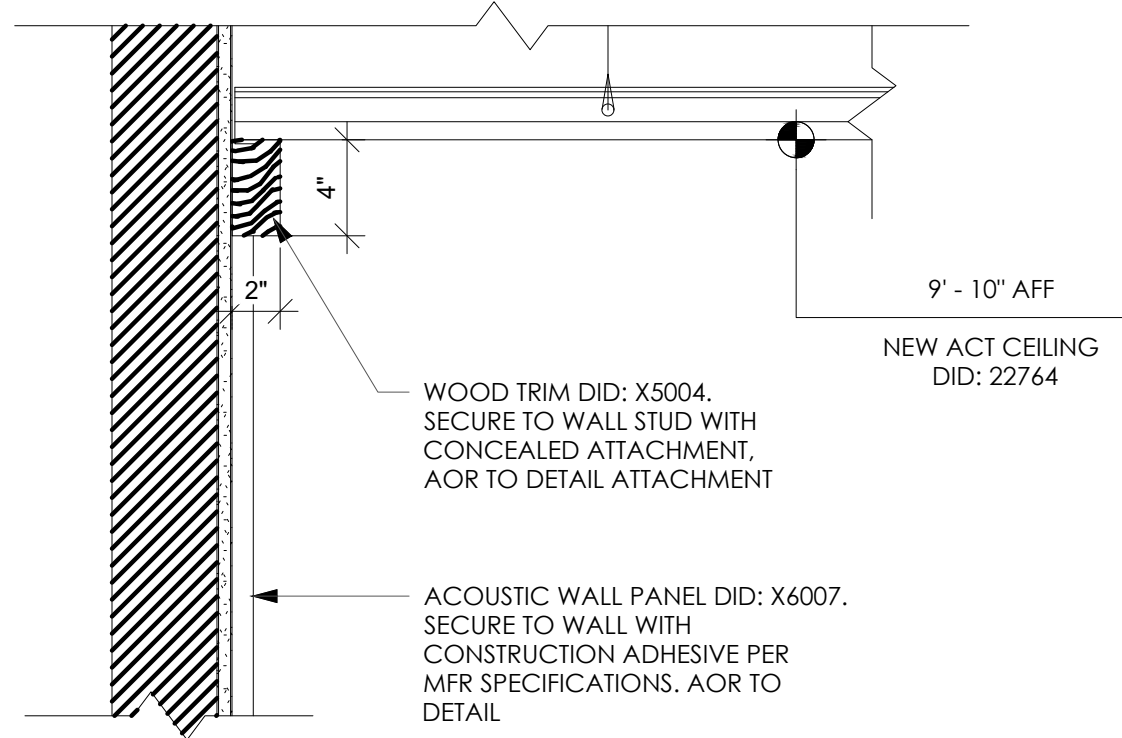


3 CEILING TRANSITION @ GALLERY WALL
A401.4 SCALE: 1-1/2" = 1'-0"

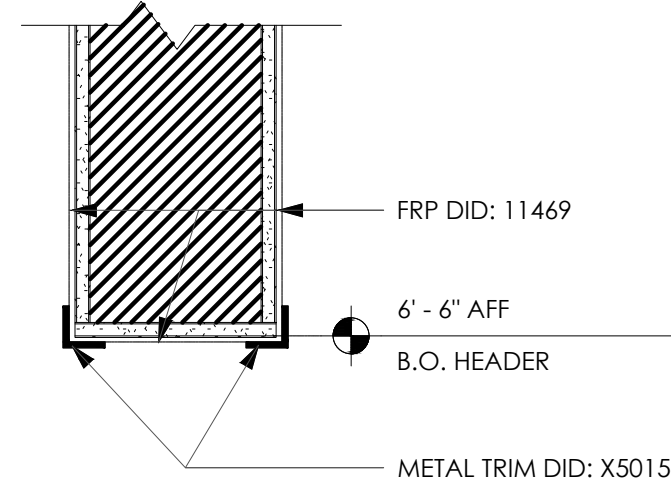


4 HEADER DETAIL @ WORKROOM
A401.4 SCALE: 1-1/2" = 1'-0"

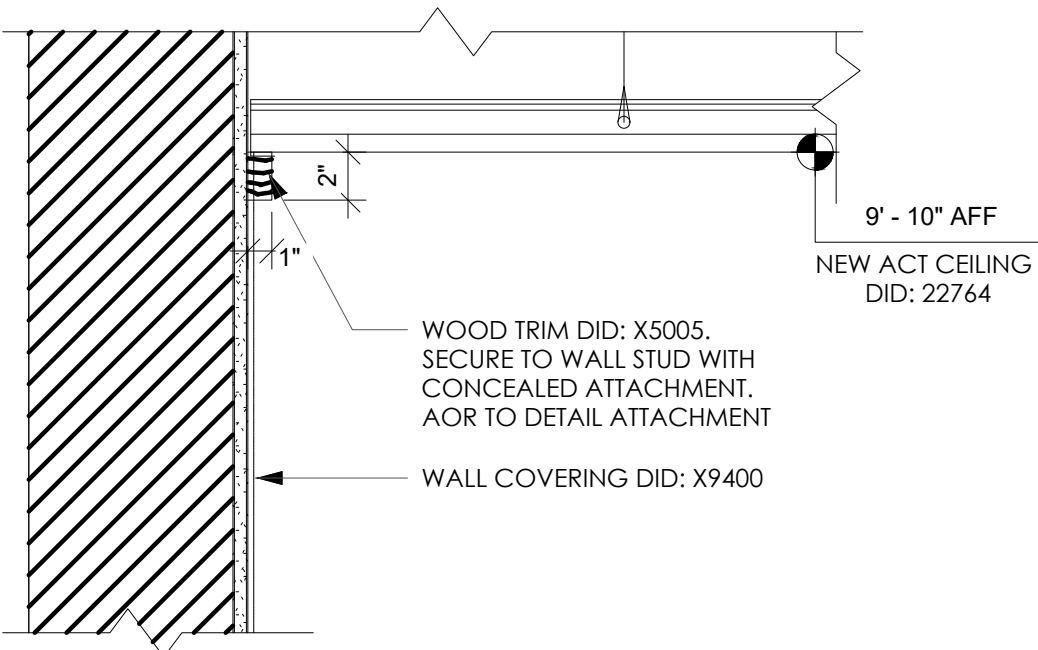


5 CEILING TRANSITION @ MERCH
A401.4 SCALE: 1-1/2" = 1'-0"

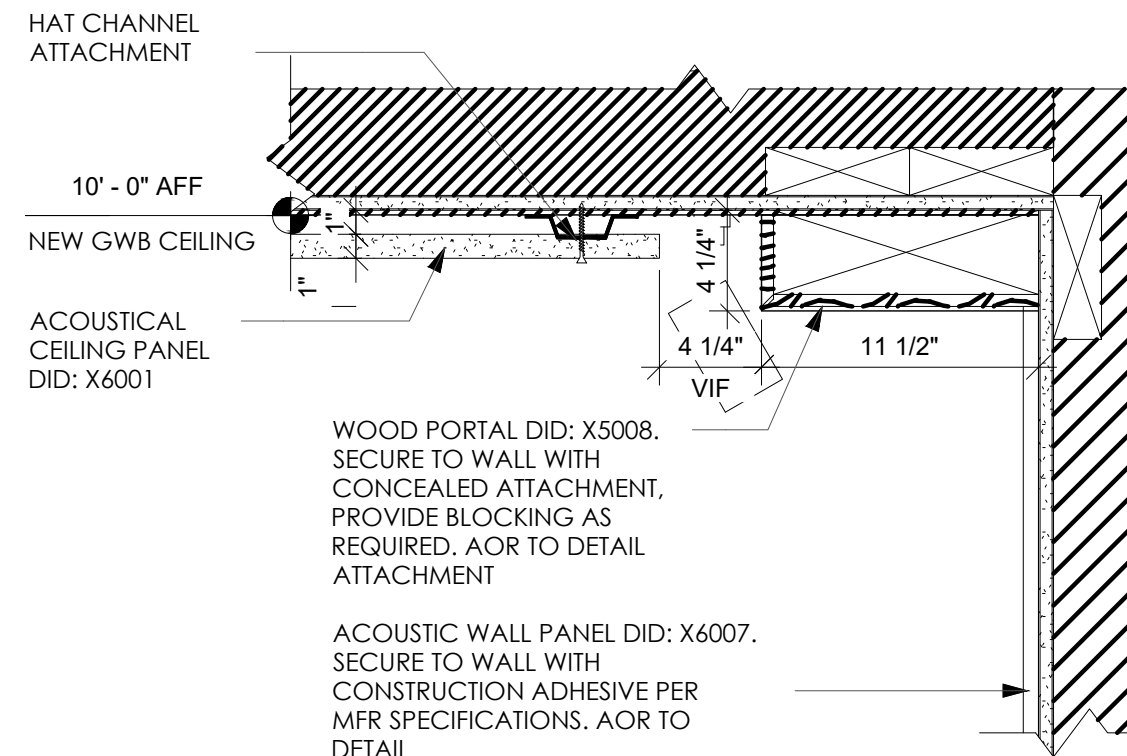


6 CEILING TRANSITION @ BANQ. WOOD PORTAL
A401.4 SCALE: 1-1/2" = 1'-0"

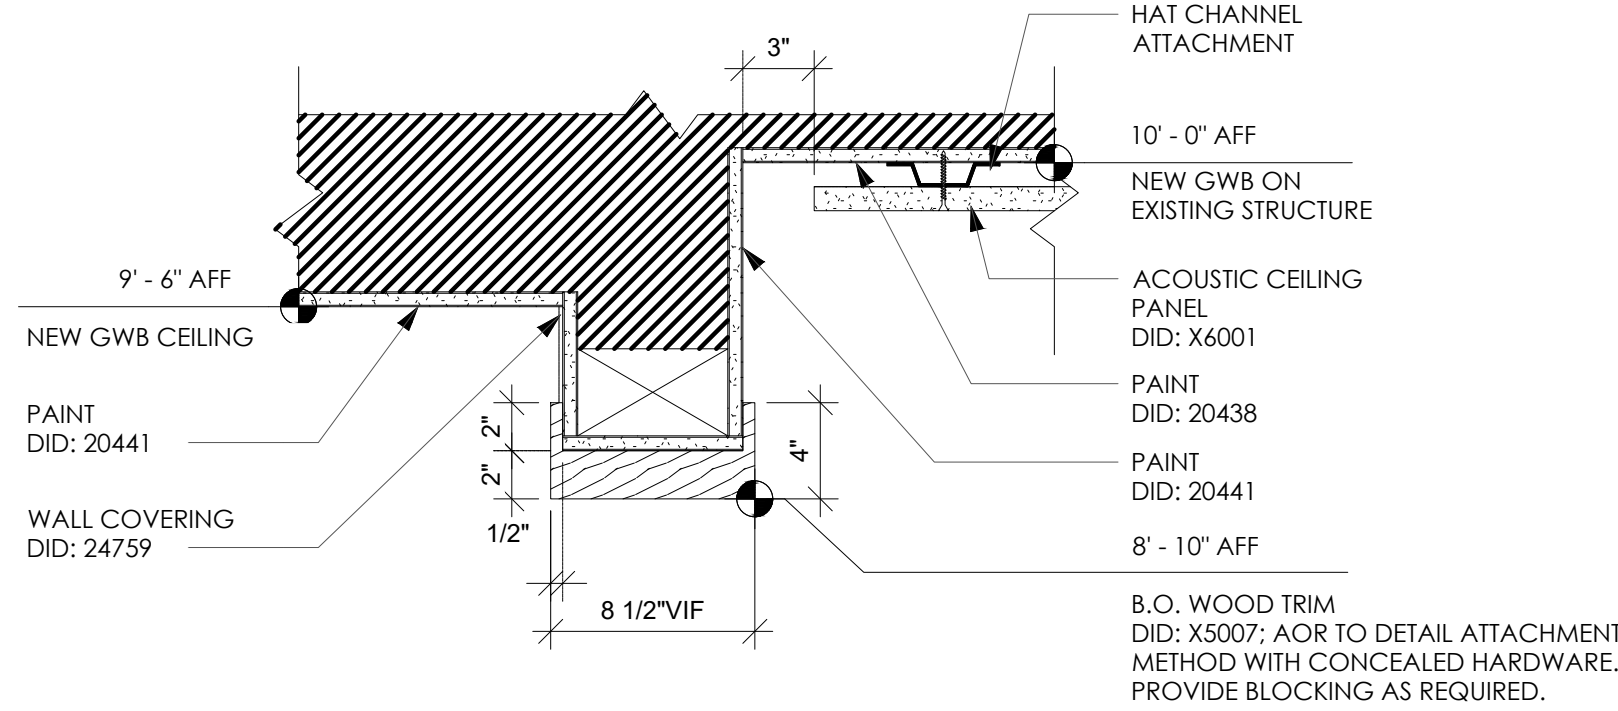


7 HEADER DETAIL @ CAFE PORTAL
A401.4 SCALE: 1-1/2" = 1'-0"

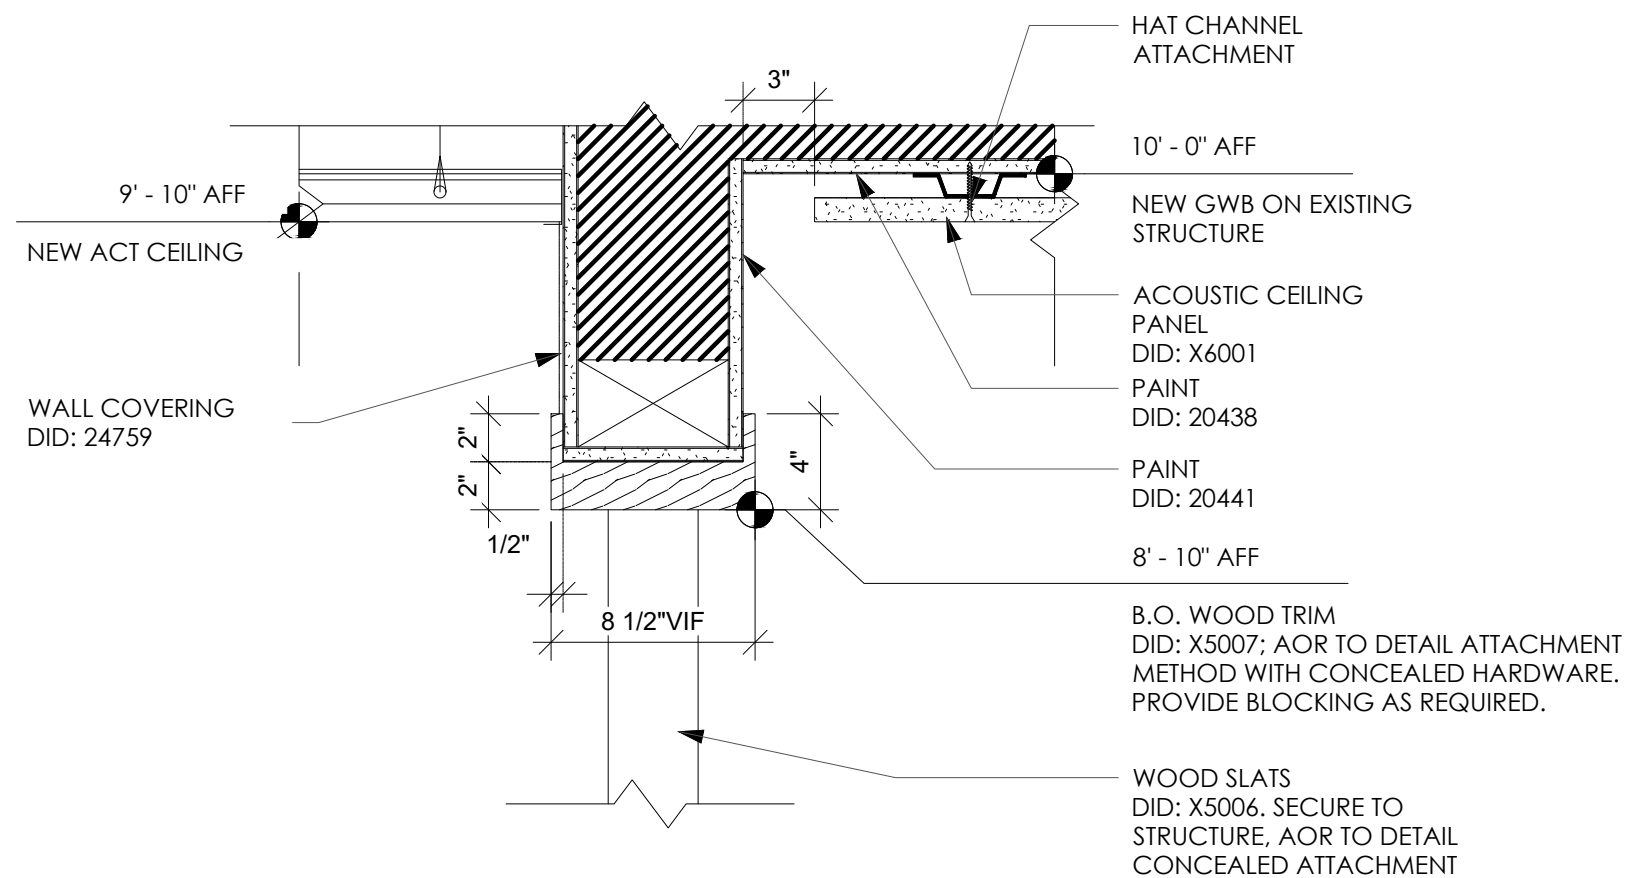

8 HEADER DETAIL @ SLATS
A401.4 SCALE: 1-1/2" = 1'-0"

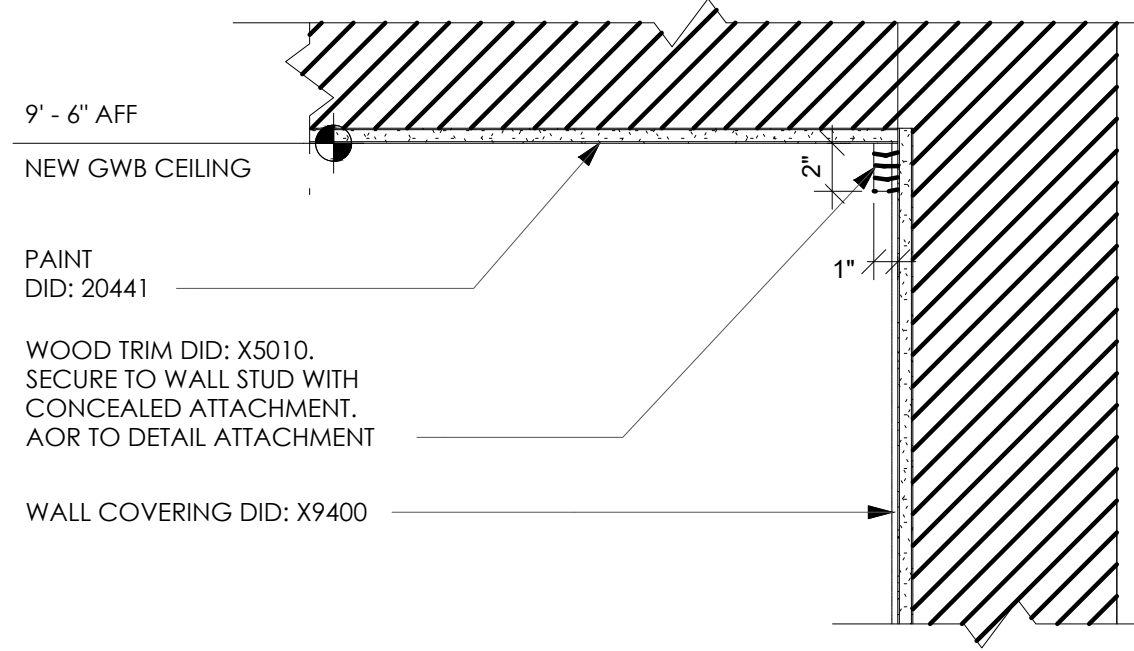

9 CEILING TRANSITION @ OSB
A401.4 SCALE: 1-1/2" = 1'-0"

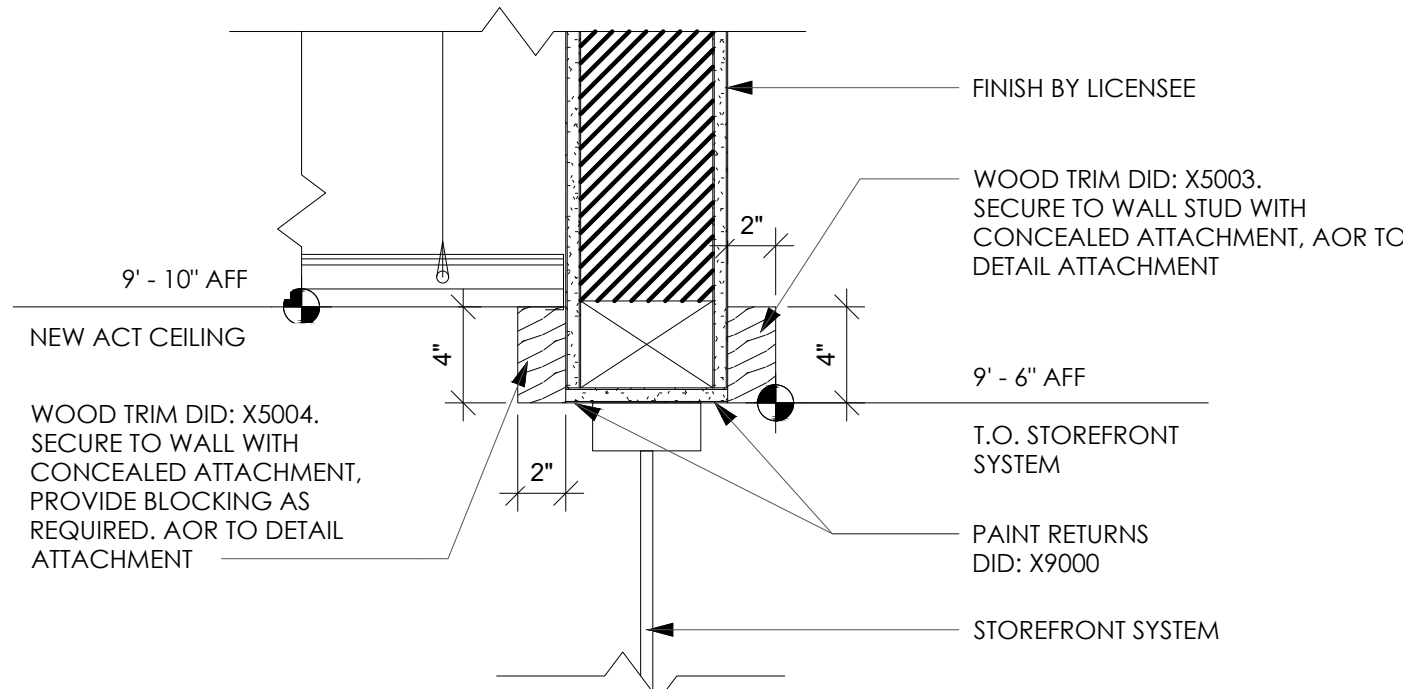

10 HEADER DETAIL @ STOREFRONT ENTRY
A401.4 SCALE: 1-1/2" = 1'-0"

ARCHITECT OF RECORD:

THOMAS E. MORGAN, JR.
ARCHITECT

423 FISCHER TRAIL
ELLIJAY, GEORGIA 30540

SEAL:

MRP
DESIGN GROUP

3450 Acworth Due West Road
Building 100, Suite 120
Kennesaw, Georgia 30144
P: 770-917-9172
F: 770-917-9470
www.mrpdesign.com

RELEASED FOR
CONSTRUCTION

ISSUES / REVISIONS:

DATE	DESCRIPTION
01.26.28	COMPILED SET RELEASED FOR CONSTRUCTION

DRAWN BY:

CHKD BY:

PROJECT DESCRIPTION:

DEVELOPMENT OF INTERIORS
CONDITIONS FOR A C-STORE IN
CORDELE, GA.

PROJECT TITLE:

CONVENIENCE STORE
379 ROCKHOUSE RD E,
CORDELE, GA 31015

SHEET TITLE:

STARBUCKS
INTERIOR DETAILS

PROJECT NO: 25049

A401.4

TAG	SERIES	CFM	DUTY	NECK	SIZE	DAMPER	MATERIAL	DESCRIPTION
A	TMS-AA	SEE DWGS	SUPPLY	SEE DWGS	24x24	YES	ALUMINUM	1
B	PAS-AA	SEE DWGS	SUPPLY	SEE DWGS	24x24	YES	ALUMINUM	2
C	50F	SEE DWGS	RETURN	22x22	24x24	NO	ALUMINUM	3
D	CT-700L	100	XFER	8x8	10x10	NO	ALUMINUM	4

NOTES:


- REFER TO ARCHITECTURAL DRAWINGS FOR TYPE OF CEILING AND/OR SUSPENSION SYSTEM.
- FINISH SHALL BE OF THE TYPE AND COLOR SELECTED BY ARCHITECT. SUBMIT FINISH CHART WITH SHOP DRAWINGS.

DESCRIPTION:

- LOUVER FACE, HIGH PERFORMANCE, ROUND NECK, SQUARE DIFFUSER.
- PERFORATED FACE, 3-WAY BLOW, ROUND NECK, SQUARE DIFFUSER.
- 1/2" X 1/2" X 1/2" EGGRATE RETURN / EXHAUST GRILLE.
- V-BLADE DOOR GRILLE. PROVIDE ADDITIONAL TRIM ON INSIDE OF DOOR OPENING.

SELECTIONS ARE BASED ON PRODUCTS BY TITUS.
EQUAL PRODUCTS: KRUEGER, CARNES, METALFAIRE & PRICE.

- ① EXISTING 7.5 TON ROOFTOP UNIT. ENSURE OUTSIDE AIR INTAKE IS A MINIMUM OF 10" AWAY FROM HOOD EXHAUST FAN AND ANY PLUMBING VENTS.
- ② UTILITY SUPPLY / RETURN CEILING GRILLES. COORDINATE LOCATION WITH CEILING GRID, LIGHTS, ETC.
- ③ APPROXIMATE LOCATION OF RETURN GRILLE FOR CONTRACTOR PROVIDED DEHUMIDIFIER. COORDINATE ACTUAL LOCATION WITH CEILING GRID, OTHER GRILLES, LIGHTS, ETC.
- ④ APPROXIMATE LOCATION OF SUPPLY GRILLE FOR CONTRACTOR PROVIDED DEHUMIDIFIER. COORDINATE ACTUAL LOCATION WITH CEILING GRID, OTHER GRILLES, LIGHTS, ETC.

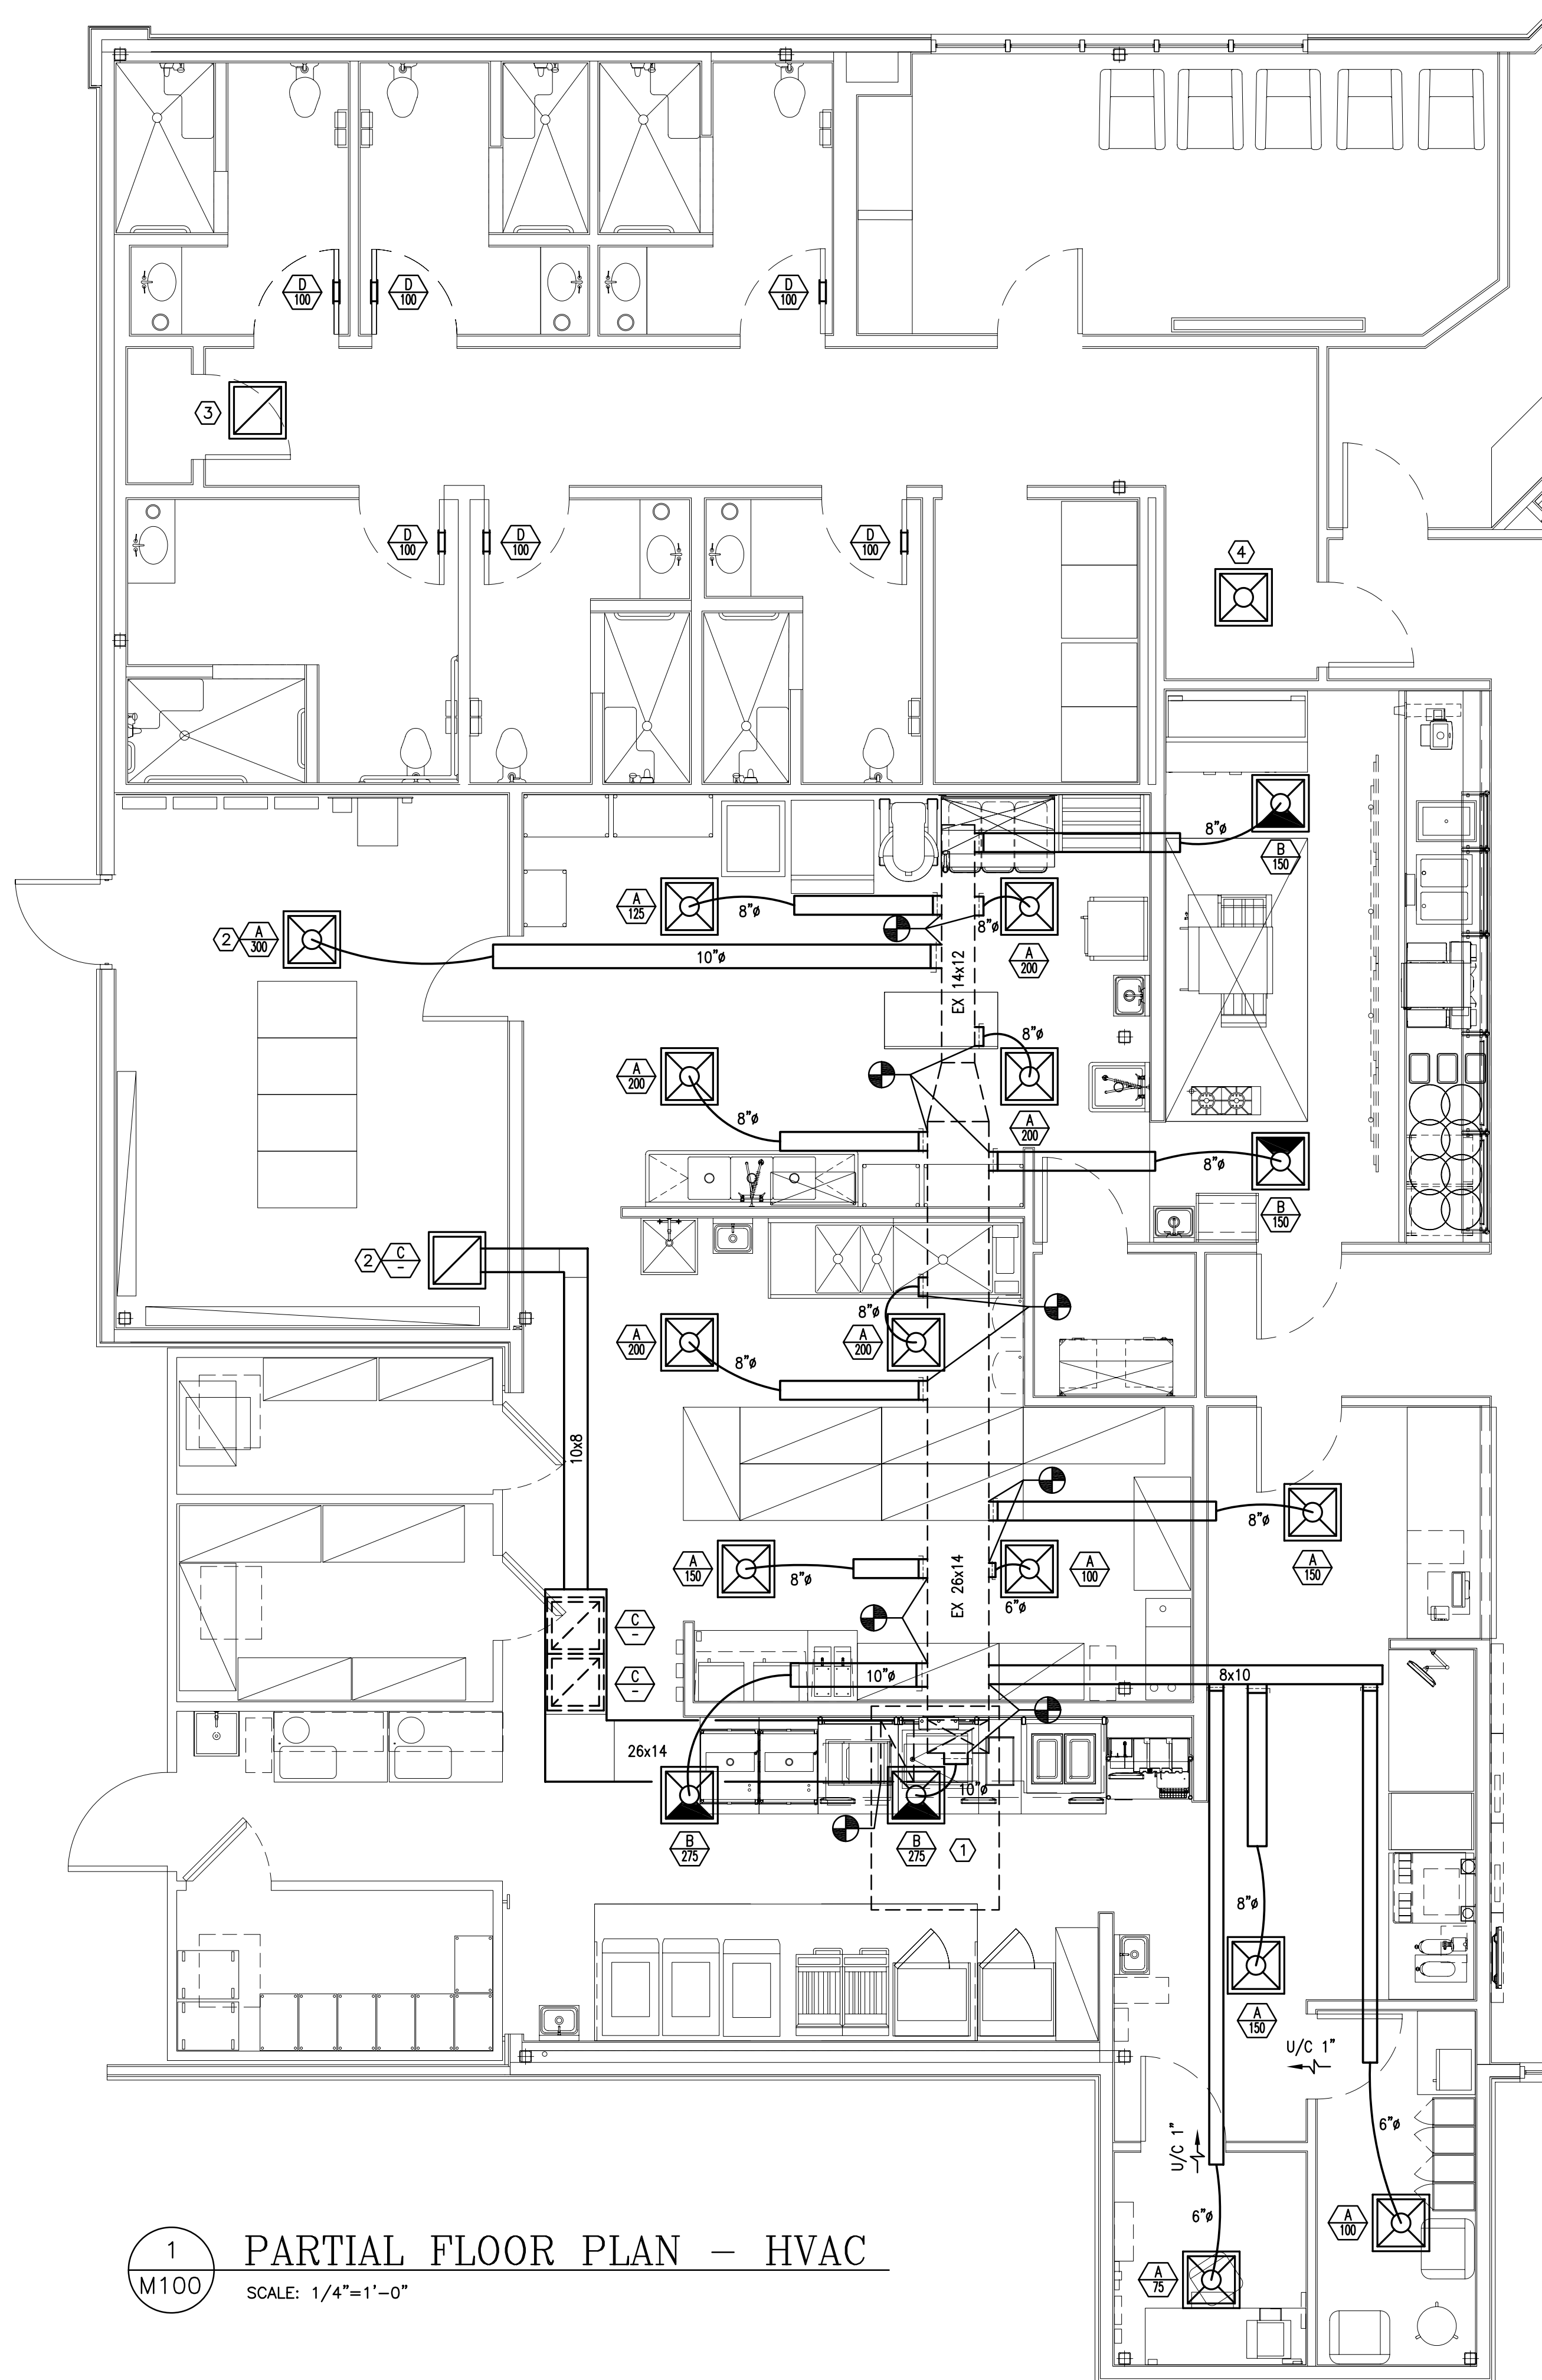

M100

ARCHITECT OF RECORD:

THOMAS E. MORGAN, JR.
ARCHITECT

423 FISCHER TRAIL
LIJAY, GEORGIA 30540



Acworth Due West Road
ing 100, Suite 120
esaw, Georgia 30144
0-917-9172
0-917-9470
mrpdesign.com

PROGRESS SET

S / REVISIONS:

[illegible]

BY: BAM

BY: JFM

ECT DESCRIPTION:

DEVELOPMENT OF INTERIORS CONDITIONS FOR A C-STORE IN ELE. GA.

ECT TITLE:

379 ROCKHOUSE RD E,
CORDELE, GA 31015

ET TITLE:

ARROS ELECTRICAL LIGHTING PLAN

JECT NO: 25049


E101

GENERAL NOTES:

- A. CONNECT ALL EMERGENCY AND EXIT LIGHTING W/UNSWITCHED HOT LEG AHEAD OF LOCAL SWITCHES.
- B. INTERIOR SIGN CONTROL SHALL BE PROVIDED AND WIRED THRU TIME CLOCK, ALL INTERIOR LIGHTING SHALL BE CONTROLLED BY LOCAL SWITCHES, EXCLUDING EMERGENCY AND NIGHT LIGHTING.
- C. SEE ARCHITECTURAL REFLECTED CEILING PLAN FOR LIGHT FIXTURE LOCATION AND ARCHITECTURAL EXTERIOR ELEVATIONS FOR MOUNTING HEIGHTS AND LOCATION OF EXTERIOR LIGHT FIXTURES.

KEY NOTES:

- 1 ALL FIXTURES IN KITCHEN/SERVING AREAS SHALL BE PROVIDED WITH GASKETED LENS.
- 2 ROUTE CIRCUIT FROM SBARRO PANEL THRU TC-1.
- 3 PROVIDE J-BOX ABOVE CEILING FOR SBARROS SIGN.
COORDINATE LOCATION W/SIGN INSTALLER AND ARCHITECTURAL ELEVATIONS. PROVIDE FINAL CONNECTION FROM J-BOX TO SIGN.
- 4 PROVIDE TIME CLOCK, TC-1 FOR SBARROS INTERIOR SIGN.
- 5 HOOD LIGHT FIXTURES AND SWITCH, SUPPLIED W/HOOD, ARE PREWIRED TO HOOD J-BOX. PROVIDE CONNECTION TO J-BOX FROM HOOD UTILITY CABINET PER HOOD DRAWINGS. PROVIDE CIRCUIT FROM SBARROS PANEL TO HOOD UTILITY CABINET.

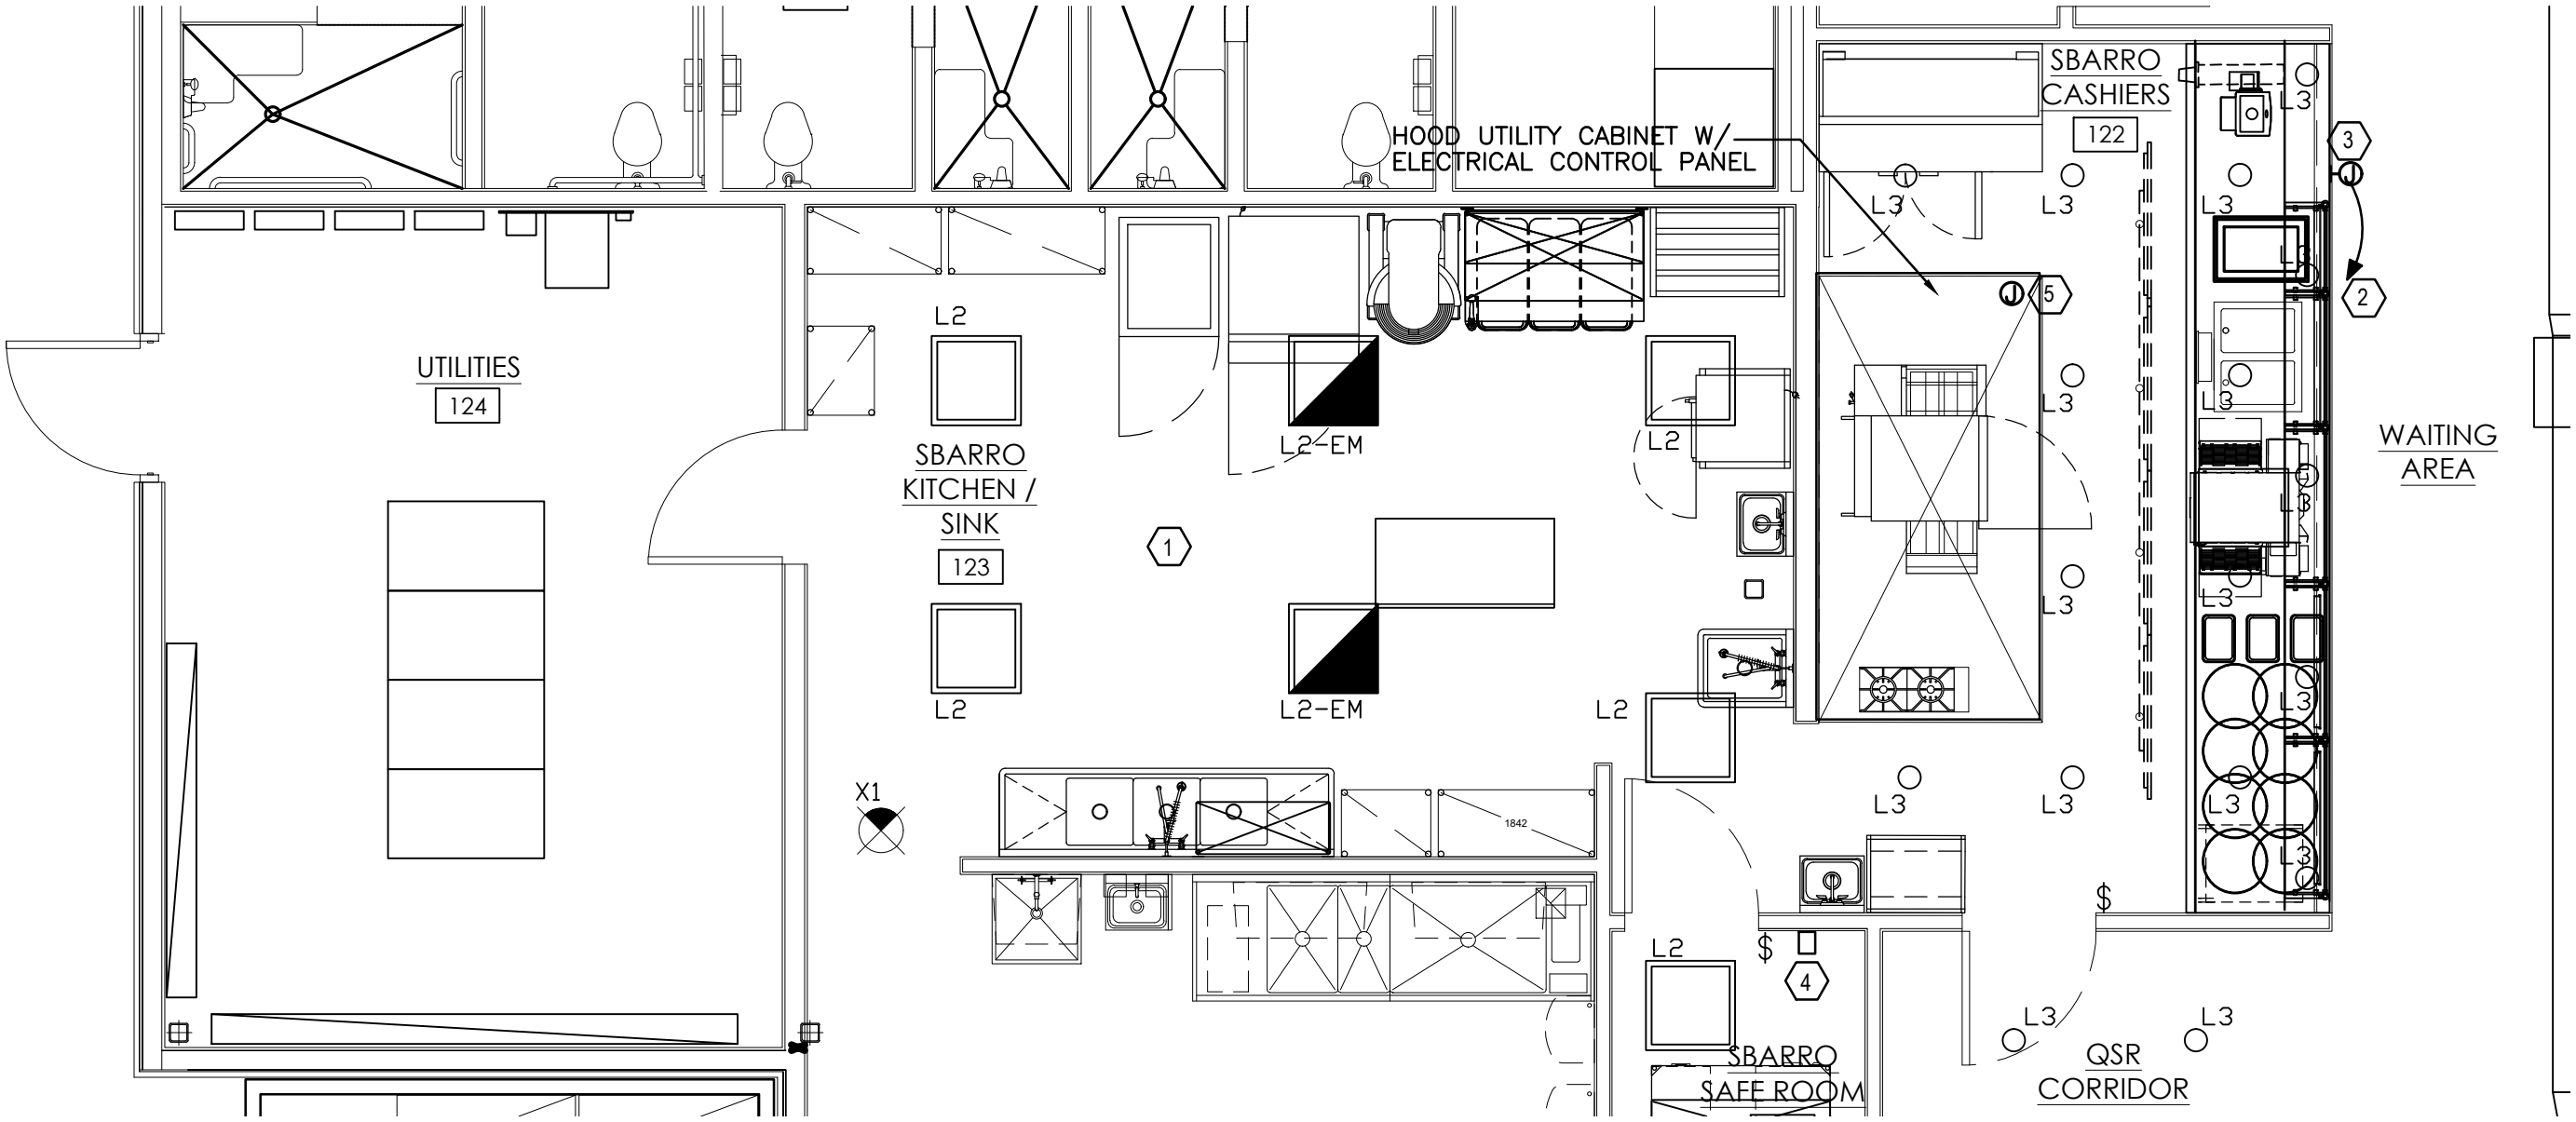

1 SBARROS ELECTRICAL LIGHTING PLAN
E101 SCALE: 1/4" = 1'-0"

LIGHT FIXTURE SCHEDULE				
TYPE	WATTS	MFG	CATALOG NUMBER	DESCRIPTION
X1	1.5	LITHONIA	LQM-S-W-R-MVOLT	EXIT - WHITE
L2	39	COOPER	22CGTS-L3C3	2X2 LED FLAT PANEL
L2-EM	39	COOPER	22CGTS-L3C3-EM	2X2 LED FLAT PANEL W/EMERGENCY BATTERY PACK
L3	18	HALO	LCR615RD9FSE020	6" LED RECESSED FIXTURE

LIGHT FIXTURE SCHEDULE NOTES:

1. ALL BATTERY BACKED FIXTURES SHALL BE RATED FOR MINIMUM 1100 LUMENS.
2. ALL FIXTURES TO BE LISTED AND CERTIFIED WITH THE CEC DIRECTORY.
3. COORDINATE FIXTURE MOUNTING HEIGHT AND LOCATION REQUIREMENTS W/ARCHITECTURAL DRAWINGS/ DETAILS/ELEVATIONS PRIOR TO ROUGH-IN. SUPPORT FIXTURES TO STRUCTURE, NOT CEILING GRID.
4. SEE NOTES ON THE ARCHITECTURAL REFLECTED CEILING PLAN.



- ① ALL FIXTURES IN KITCHEN/SERVING AREAS SHALL BE PROVIDED WITH GASKETED LENS.
- ② LIGHT FIXTURE(S) ARE PROVIDED W/COOLER/FREEZER AND CONNECTED TO SWITCH AND TO PREWIRED COOLER/FREEZER J-BOX.
- ③ PROVIDE J-BOX ABOVE CEILING FOR KFC SIGN. COORDINATE LOCATION W/SIGN INSTALLER AND ARCHITECTURAL ELEVATIONS. PROVIDE FINAL CONNECTIONS FROM J-BOX TO SIGN.
- ④ PROVIDE TIME CLOCK, TC-1, FOR KFC SIGN,
- ⑤ HOOD LIGHT FIXTURES AND SWITCH, SUPPLIED W/HOOD, ARE PREWIRED TO HOOD J-BOX. PROVIDE CONNECTION TO J-BOX FROM HOOD UTILITY CABINET PER HOOD DRAWINGS. PROVIDE CIRCUIT FROM KFC PANEL TO HOOD UTILITY CABINET.
- ⑥ ROUTE CIRCUIT FROM KFC PANEL THRU TC-1.

1. ALL BATTERY BACKED FIXTURES SHALL BE RATED FOR MINIMUM 1100 LUMENS.
2. ALL FIXTURES TO BE LISTED AND CERTIFIED WITH THE CEC DIRECTORY.
3. COORDINATE FIXTURE MOUNTING HEIGHT AND LOCATION REQUIREMENTS W/ARCHITECTURAL DRAWINGS/DETAILS/ELEVATIONS PRIOR TO ROUGH-IN. SUPPORT FIXTURES TO STRUCTURE, NOT CEILING GRID.
4. SEE NOTES ON THE ARCHITECTURAL REFLECTED CEILING PLAN.

A. ANY KITCHEN EQUIPMENT NOT IDENTIFIED IN THE KITCHEN SCHEDULE TO THE LEFT IS EXPECTED TO NOT HAVE ANY DIV. 16 INSTALLATION REQUIREMENTS. CONTRACTOR SHALL VERIFY ALL REQUIREMENTS FOR ALL KITCHEN EQUIPMENT WITH KITCHEN EQUIPMENT CONTRACTOR PRIOR TO ROUGH-IN. IF THERE ARE ANY DIFFERENCES FROM THESE DRAWINGS, CONTRACTOR SHALL MAKE ALL NECESSARY ADJUSTMENTS TO VOLTAGE, PHASE, CIRCUIT BREAKERS, DISCONNECT SWITCHES, RECEPTACLES, WIRING AND CONDUIT, ETC., FOR ACTUAL EQUIPMENT PURCHASED AND INSTALLED.

B. PROVIDE OVERCURRENT PROTECTION AND BRANCH CIRCUITS PER UL LISTED REQUIREMENTS FOR ALL EQUIPMENT SERVED. REFER TO MANUFACTURER DATA AND EQUIPMENT CUT-SHEETS FOR ROUGH-IN LOCATIONS OF ELECTRICAL CONNECTIONS AND INTERCONNECTING TO EQUIPMENT. COORDINATE EXACT NAMEPLATE DATA OF EQUIPMENT BEING INSTALLED WITH DIV. 15.

C. COORDINATE EXACT LOCATIONS OF EQUIPMENT, RECEPTACLES, AND DEVICE CONNECTIONS WITH ARCHITECTURAL PLANS AND ELEVATIONS PRIOR TO ROUGH-IN.


- ① PROVIDE RECEPTACLE AND DATA OUTLET FOR MENUBOARD, COORDINATE LOCATION AND MOUNTING HEIGHT W/OWNER PRIOR TO ROUGH-IN.
- ② ALL 125-VOLT THROUGH 250-VOLT RECEPTACLES SUPPLIED BY SINGLE-PHASE BRANCH CIRCUITS RATED 150 VOLTS OR LESS TO GROUND, 50 AMPERES OR LESS, AND ALL RECEPTACLES SUPPLIED BY THREE-PHASE BRANCH CIRCUITS RATED 150 VOLTS OR LESS TO GROUND, 100 AMPERES OR LESS, INSTALLED IN THE LOCATIONS SPECIFIED IN 210.8 (B) (1) THROUGH (B) (12) SHALL HAVE GFCI PROTECTION FOR PERSONNEL PER 2020 NEC. MOUNT AT 30" UNO.
- ③ CONNECT TO HOOD ELECTRICAL PANEL FOR HOOD LIGHTS, FIRE SUPPRESSION SYSTEM (FSS) AND CONTROLS, AND PROVIDE ALL INTERCONNECTING WIRING AND CONDUIT, AS SHOWN ON CAPTIVE AIRE DRAWINGS.
- ④ PROVIDE DEEP 4"x4" JUNCTION BOX FOR ANSUL PULL STATION WITH 3/4". STUBBED TO ACCESSIBLE CEILING. COORDINATE EXACT LOCATION AND MOUNTING HEIGHT WITH FIRE SUPPRESSION SYSTEM INSTALLED.

[illegible]

1. COORDINATE EXACT LOCATION AND MOUNTING HEIGHT WITH KITCHEN EQUIPMENT SUPPLIER PRIOR TO INSTALLATION.
2. PROVIDE POWER CORD AND RECEPTACLE PER EQUIPMENT ELECTRICAL REQUIREMENTS.
3. PROVIDE ALL CONDUIT AND WIRING REQUIRED AND CONNECT TO HOOD UTILITY CABINET FOR ALL THE POWER AND CONTROL AND FROM HOOD UTILITY CABINET FOR ALL POWER AND CONTROL AS SHOWN ON THE ECON. PLAN DWGS.
4. VERIFY RECEPTACLE WITH PLUG ON EQUIPMENT PRIOR TO ORDERING OR INSTALLING.
5. PROVIDE CIRCUIT BREAKER IN SBARO PANEL W/SHUNT TRIP AND CONNECT TO FIRE SUPPRESSION SYSTEM (FSS) TO TRIP UPON FSS ACTIVATION.

1 SBARROS ELECTRICAL POWER PLAN
E201 SCALE: 1/4" = 1'-0"

SBARROS LOAD SUMMARY					
	<u>CONN VA</u>				<u>DEMAND VA</u>
LIGHTING:	579	x	125%	=	724
RECEPTACLE:	900	x	100%	=	900
FOOD SERV:	30904	x	65%	=	20088
	32383/360=				21712/360=
	90A				60A

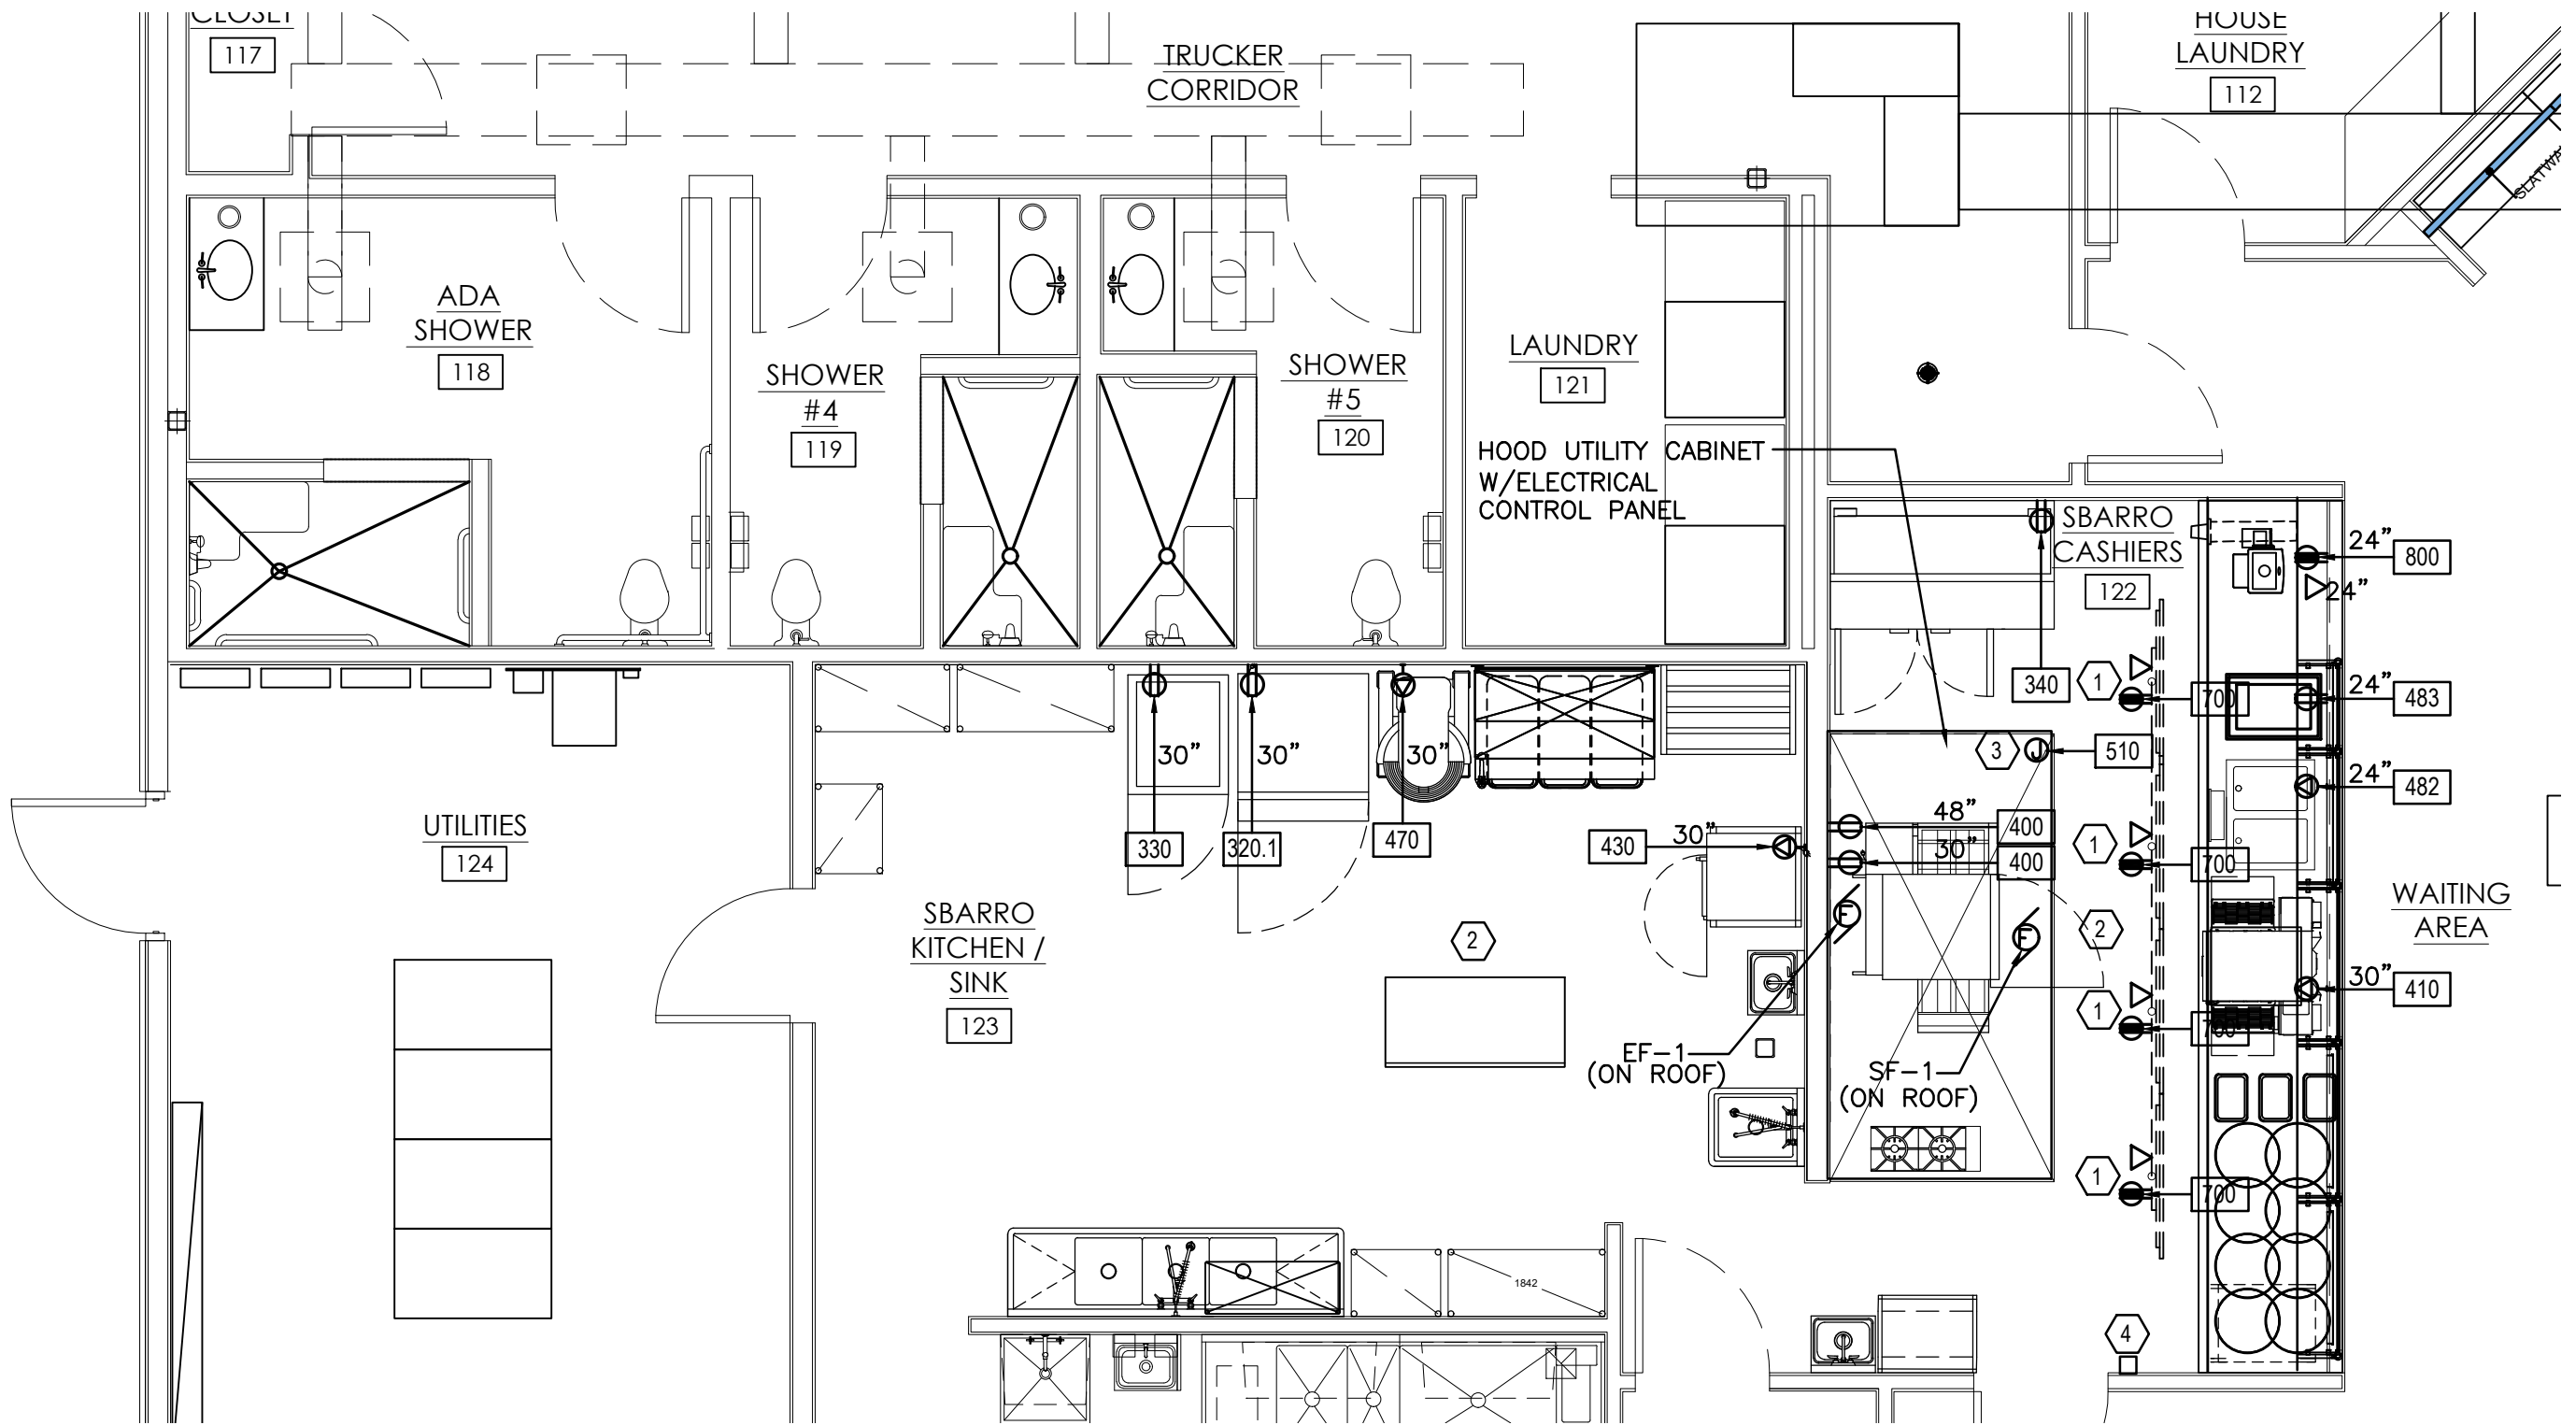

A. ANY KITCHEN EQUIPMENT NOT IDENTIFIED IN THE KITCHEN SCHEDULE TO THE LEFT IS EXPECTED TO NOT HAVE ANY DIV. 16 INSTALLATION REQUIREMENTS. CONTRACTOR SHALL VERIFY ALL REQUIREMENTS FOR ALL KITCHEN EQUIPMENT WITH KITCHEN EQUIPMENT CONTRACTOR PRIOR TO ROUGH-IN. IF THERE ARE ANY DIFFERENCES FROM THESE DRAWINGS, THE CONTRACTOR SHALL MAKE ALL NECESSARY ADJUSTMENTS TO VOLTAGE, PHASE, CIRCUIT BREAKERS, DISCONNECT SWITCHES, RECEPTACLES, WIRING AND CONDUIT, ETC., FOR ACTUAL EQUIPMENT PURCHASED AND INSTALLED.

B. PROVIDE OVERCURRENT PROTECTION AND BRANCH CIRCUITS PER UL LISTED REQUIREMENTS FOR ALL EQUIPMENT SERVED. REFER TO MANUFACTURER DATA AND EQUIPMENT CUT-SHEETS FOR ROUGH-IN LOCATIONS OF ELECTRICAL CONNECTIONS AND INTERCONNECTIONS FOR ALL EQUIPMENT. COORDINATE EXACT NAMEPLATE DATA OF EQUIPMENT BEING INSTALLED WITH DIV. 15.

C. COORDINATE EXACT LOCATIONS OF EQUIPMENT, RECEPTACLES, AND DEVICE CONNECTIONS WITH ARCHITECTURAL PLANS AND ELEVATIONS PRIOR TO ROUGH-IN.

- ① PROVIDE RECEPTACLE AND DATA OUTLET FOR MENUBOARD. COORDINATE LOCATION AND MOUNTING HEIGHT W/OWNER PRIOR TO ROUGH-IN.
- ② ALL 125-VOLT THROUGH 250-VOLT RECEPTACLES SUPPLIED BY SINGLE-PHASE BRANCH CIRCUITS RATED 150 VOLTS OR LESS TO GROUND, 50 AMPERES OR LESS, AND ALL RECEPTACLES SUPPLIED BY THREE-PHASE BRANCH CIRCUITS RATED 150 VOLTS OR LESS TO GROUND, 100 AMPERES OR LESS, SHALL BE INSTALLED IN THE LOCATIONS SPECIFIED IN 210.8 (B) (1) THROUGH (B) (12) SHALL HAVE GFCI PROTECTION FOR PERSONNEL PER 2020 NEC. MOUNT AT 30" UNO.
- ③ CONNECT TO HOOD ELECTRICAL PANEL FOR HOOD LIGHTS, FIRE SUPPRESSION SYSTEM (FSS) AND CONTROLS, AND PROVIDE INTERCONNECTING WIRING AND CONDUIT, AS SHOWN ON CAPTIVE AREA DRAWINGS.
- ④ PROVIDE DEEP 4"x4" JUNCTION BOX FOR ANSUL PULL STATION WITH 3/4"C. STUBBED TO ACCESSIBLE CEILING. COORDINATE EXACT LOCATION AND MOUNTING HEIGHT WITH FIRE SUPPRESSION SYSTEM INSTALLED.
- ⑤ PROVIDE GFI RECEPTACLE FOR CO2 MONITOR PANEL.



KFC KITCHEN EQUIPMENT CONNECTION SCHEDULE											KFC KITCHEN EQUIPMENT CONNECTION SCHEDULE CONTINUED										
MARK	QTY	EQUIPMENT	V	PH	A(Ω)	PANEL CIRCUIT	BRANCH CIR. SIZE	DISC. MEANS	TYPE OF CONNECTION	NOTES											
B302	1	TANKLESS WATER HEATERS	120	1	5.0	KFC PANEL	2#12, #12(G), 3/4"C.	PLUG	GFI QUAD NEMA 5-20R 5	S533	1	SIDES HOLDING CABINET	208	1	12.0	KFC PANEL	2#12, #12(G), 3/4"C.	PLUG	GFI NEMA 6-20R	1,2,5	
										S579	2	1/2" HT HOLDING CABINET	208	1	15.2	KFC PANEL	2#12, #12(G), 3/4"C.	PLUG	GFI NEMA 5-20R	1,2,5	
P018	1	DUAL OPEN FRYER	120	1	6.1	KFC PANEL	2#12, #12(G), 3/4"C.	PLUG	NEMA 5-20R	1,2,5		1/2" HT HOLDING CABINET	120	1	15.2	KFC PANEL	2#12, #12(G), 3/4"C.	PLUG	GFI NEMA 5-20R	1,2,5	
		DUAL OPEN FRYER	120	1	6.1	KFC PANEL	2#12, #12(G), 3/4"C.	PLUG	NEMA 5-20R	1,2,5	S149	1	INFRARED HOLDING BIN	208	1	15.5	KFC PANEL	2#12, #12(G), 3/4"C.	PLUG	GFI NEMA L6-20R	1,2,5
C091	1	BUN TOASTER	208	1	9.6	KFC PANEL	2#12, #12(G), 3/4"C.	PLUG	NEMA 6-20R	5	S570	1	TEA BREWER	120	1	14.4	KFC PANEL	2#12, #12(G), 3/4"C.	PLUG	GFI NEMA 5-20R	1,2,5
C121	3	ELECTRIC PRESSURE FRYER	120	1	10.0	KFC PANEL	2#12, #12(G), 3/4"C.	PLUG	NEMA 5-20R	5	S533	1	BEVERAGE DISPENSER	120	1	3.5	KFC PANEL	2#12, #12(G), 3/4"C.	PLUG	GFI NEMA 5-20R	1,2,5
		ELECTRIC PRESSURE FRYER	120	1	10.0	KFC PANEL	2#12, #12(G), 3/4"C.	PLUG	NEMA 5-20R	5	S550	1	BAG-N-BOX	120	1	7.0	KFC PANEL	2#12, #12(G), 3/4"C.	PLUG	GFI NEMA 5-20R	1,2,5
		ELECTRIC PRESSURE FRYER	120	1	10.0	KFC PANEL	2#12, #12(G), 3/4"C.	PLUG	NEMA 5-20R	5	S570	1	CARBONATOR	120	1	7.2	KFC PANEL	2#12, #12(G), 3/4"C.	PLUG	GFI NEMA 5-20R	1,2,5
C130	2	CONVECTION OVEN	208	3	22.2	KFC PANEL	3#10, #10(G), 3/4"C.	PLUG	NEMA 15-30R	5	S519	1	ICE CUBER MACHINE	120	1	1.1	KFC PANEL	2#12, #12(G), 3/4"C.	PLUG	GFI NEMA 5-20R	5
		CONVECTION OVEN	208	3	47.2	KFC PANEL	3#10, #10(G), 3/4"C.	PLUG	NEMA 15-30R	5			ICE CUBER COMPRESSOR	208	1	6.6	KFC PANEL	2#12, #12(G), 3/4"C.	DISCONNECT	30/2/1/15A	-
C183	2	MICROWAVE	208	1	15.4	KFC PANEL	2#12, #12(G), 3/4"C.	PLUG	NEMA 6-20R	1,2,5	A070	1	RECEIPT PRINTER	120	1	2.0	KFC PANEL	2#12, #12(G), 3/4"C.	PLUG	GFI NEMA 5-20R	5
		MICROWAVE	208	1	15.4	KFC PANEL	2#12, #12(G), 3/4"C.	PLUG	NEMA 6-20R	1,2,5	0100	1	POS/ORDER ENTRY TERMINAL	120	1	2.0	KFC PANEL	2#12, #12G, #12IG, 3/4"C	PLUG	IG GFI NEMA 5-20R	5
E24X	1	EXHAUST HOOD, KEF-1	120	1	8.9	KFC PANEL	2#12, #12(G), 3/4"C.	DISCONNECT	INCLUDED	3											
		EXHAUST HOOD, KEF-2	120	1	8.9	KFC PANEL	2#12, #12(G), 3/4"C.	DISCONNECT	INCLUDED	3											
		EXHAUST HOOD FSS, CTLS, LTS	120	1	5.0	KFC PANEL	2#12, #12(G), 3/4"C.	DIRECT	-	3											
		OFFICE COMPUTER	120	1	3.0	KFC PANEL	2#12, #12(G), 3/4"C.	PLUG	NEMA 5-20R	1,2,5	W212	1	KFC/SBARRO WIC (LTS)	120	1	1.0	KFC PANEL	2#12, #12(G), 3/4"C.	DISCONNECT	(2) SWITCH	-
P300	1	OFFICE PRINTER	120	1	3.0	KFC PANEL	2#12, #12(G), 3/4"C.	PLUG	NEMA 5-20R	1,2,5	W212	1	KFC/SBARRO WIC CONDENSER	208	1	7.0	KFC PANEL	1456 2#12, #12(G), 3/4"C.	DISCONNECT	30/2/3R/F15A	4
F180	1	SAFE	120	1	3.0	KFC PANEL	2#12, #12(G), 3/4"C.	PLUG	NEMA 5-20R	1,2,5	W212	1	KFC/SBARRO WIC FCU	120	1	1.6	KFC PANEL	192 2#12, #12(G), 3/4"C.	DISCONNECT	30/1/3R/NF	4
		EMPLOYEE MICROWAVE	120	1	15.0	KFC PANEL	2#12, #12(G), 3/4"C.	PLUG	NEMA 5-20R	1,2,5	W212	1	KFC CHK'N WIC (LTS)	120	1	1.0	KFC PANEL	2#12, #12(G), 3/4"C.	DISCONNECT	(2) SWITCH	-
N025	1	POWER SOAK	208	1	56.4	KFC PANEL	2#4, #8(G), 1"C.	DISCONNECT	100/2/3R/NF	1,2,5	W212	1	KFC CHK'N WIC CONDENSER	208	1	7.0	KFC PANEL	1456 2#12, #12(G), 3/4"C.	DISCONNECT	30/2/3R/F15A	4
P103	5	DUPLEX RECEPTACLE	120	1	7.5	KFC PANEL	2#12, #12(G), 3/4"C.	PLUG	NEMA 5-20R	1,2,5	W212	1	KFC CHK'N WIC FCU	120	1	1.6	KFC PANEL	192 2#12, #12(G), 3/4"C.	DISCONNECT	30/1/3R/NF	4
P105	1	HOT WELL TABLE, 36" WIDE	208	1	10.6	KFC PANEL	2#12, #12(G), 3/4"C.	PLUG	NEMA 6-20R	1,2,5	W212	1	KFC WIF WIC (LTS)	120	1	1.0	KFC PANEL	2#12, #12(G), 3/4"C.	DISCONNECT	(2) SWITCH	-
P108	1	COLD WELL TABLE, 34" WIDE	120	1	2.4	KFC PANEL	2#12, #12(G), 3/4"C.	PLUG	NEMA 5-20R	1,2,5	W212	1	KFC WIF CONDENSER	208	1	19.1	KFC PANEL	3973 2#10, #10G, 3/4"C	DISCONNECT	30/2/3R/F30A	4
P184	1	FRY WARMER	120	1	15.9	KFC PANEL	2#12, #12(G), 3/4"C.	PLUG	NEMA 5-20R	1,2,5	W212	1	KFC WIF FCU & DEF HTR	208	1	10.8	KFC PANEL	2246 2#12, #12(G), 3/4"C.	DISCONNECT	30/2/3R/NF	4
P453	2	HOT WATER MACHINE	208	1	24.0	KFC PANEL	2#10, #10(G), 3/4"C.	PLUG	NEMA 6-30R	1,2,5											
S001	2	BREADING TABLE	120	1	1.6	KFC PANEL	2#12, #12(G), 3/4"C.	PLUG	NEMA 5-20R	1,2,5											
		BREADING TABLE	120	1	1.6	KFC PANEL	2#12, #12(G), 3/4"C.	PLUG	NEMA 5-20R	1,2,5											
R163	1	1/2" HT REFRIGERATOR	120	1	2.0	KFC PANEL	2#12, #12(G), 3/4"C.	PLUG	GFI NEMA 5-20R	5											
R351	1	1/2" HT FREEZER	120	1	2.5	KFC PANEL	2#12, #12(G), 3/4"C.	PLUG	GFI NEMA 5-20R	5											
R351	1	1/2" HT FREEZER	120	1	2.5	KFC PANEL	2#12, #12(G), 3/4"C.	PLUG	GFI NEMA 5-20R	5											
NOTES:											1. COORDINATE EXACT LOCATION AND MOUNTING HEIGHT WITH KITCHEN EQUIPMENT SUPPLIER PRIOR TO INSTALLATION. 2. INSTALL POWER CORD PROVIDED WITH EQUIPMENT. 3. PROVIDE ALL CONDUIT AND WIRING REQUIRED AND CONNECT TO HOOD UTILITY CABINET FOR ALL THE POWER AND CONTROL; AND FROM HOOD UTILITY CABINET FOR ALL POWER AND CONTROL, AS SHOWN ON THE CAPTIVE AIRE DWGS. 4. PROVIDE ALL INTERCONNECTIONS AS REQUIRED FOR COOLER/FREEZER COMPRESSOR AND EVAPORATOR COIL. 5. VERIFY RECEPTACLE WITH PLUG ON EQUIPMENT PRIOR TO ORDERING OR INSTALLING.										

THESE PLANS ARE THE PROPERTY OF MRP DESIGN GROUP, INC. AND ARE SUBJECT TO FEDERAL COPYRIGHT LAWS. ANY USE OF SAME WITHOUT THE EXPRESS WRITTEN PERMISSION OF MRP DESIGN GROUP, INC. IS STRICTLY PROHIBITED.

SBARRO WATER DEMAND			
FIXTURE	QUANTITY	SFU (EACH)	SFU (TOTAL)
HAND SINK	2	2	4
ONE COMPARTMENT SINK	1	4	4
THREE COMPARTMENT SINK	1	4	4
TOTAL			12
<u>CALCULATION:</u> 12 SFU'S = 16 GPM, 16 GPM @ 5-10 FT/S VELOCITY = 1" INCOMING WATER SERVICE SIZE.			

FIXTURE	QUANTITY	SFU (EACH)	SFU (TOTAL)
HAND SINK	2	2	4
ONE COMPARTMENT SINK	1	4	4
THREE COMPARTMENT SINK	1	4	4
TOTAL			12

CALCULATION:
12 SFU'S = 16 GPM. 16 GPM @ 5-10 FT/S VELOCITY = 1"
INCOMING WATER SERVICE SIZE.

SBARRO PROPANE LOADS			
FIXTURE	QUANTITY	BTU (EACH)	BTU (TOTAL)
CONVEYOR OVEN	1	40,000	40,000
HOT PLATE	1	50,000	50,000
TOTAL			90,000

FIXTURE	QUANTITY	BTU (EACH)	BTU (TOTAL)
CONVEYOR OVEN	1	40,000	40,000
HOT PLATE	1	50,000	50,000
TOTAL			90,000


KFC WATER DEMAND			
FIXTURE	QUANTITY	SFU (EACH)	SFU (TOTAL)
HAND SINK	3	2	6
ONE COMPARTMENT SINK	1	4	4
THREE COMPARTMENT SINK	1	4	4
MOP SINK	1	3	3
TOTAL			17
<u>CALCULATION:</u> 17 SFU'S = 18.4 GPM. 18.4 GPM @ 5-10 FT/S VELOCITY = 1" INCOMING WATER SERVICE SIZE.			

FIXTURE	QUANTITY	SFU (EACH)	SFU (TOTAL)
HAND SINK	3	2	6
ONE COMPARTMENT SINK	1	4	4
THREE COMPARTMENT SINK	1	4	4
MOP SINK	1	3	3
TOTAL			17

CALCULATION:
17 SFU'S = 18.4 GPM. 18.4 GPM @ 5-10 FT/S VELOCITY = 1"
INCOMING WATER SERVICE SIZE.

KFC PROPANE LOADS			
FIXTURE	QUANTITY	BTU (EACH)	BTU (TOTAL)
WATER HEATER	2	199,900	399,800
OPEN FRYER	1	210,000	210,000
PRESSURE FRYER	2	200,000	200,000
TOTAL			809,800

FIXTURE	QUANTITY	BTU (EACH)	BTU (TOTAL)
WATER HEATER	2	199,900	399,800
OPEN FRYER	1	210,000	210,000
PRESSURE FRYER	2	200,000	200,000
TOTAL			809,800

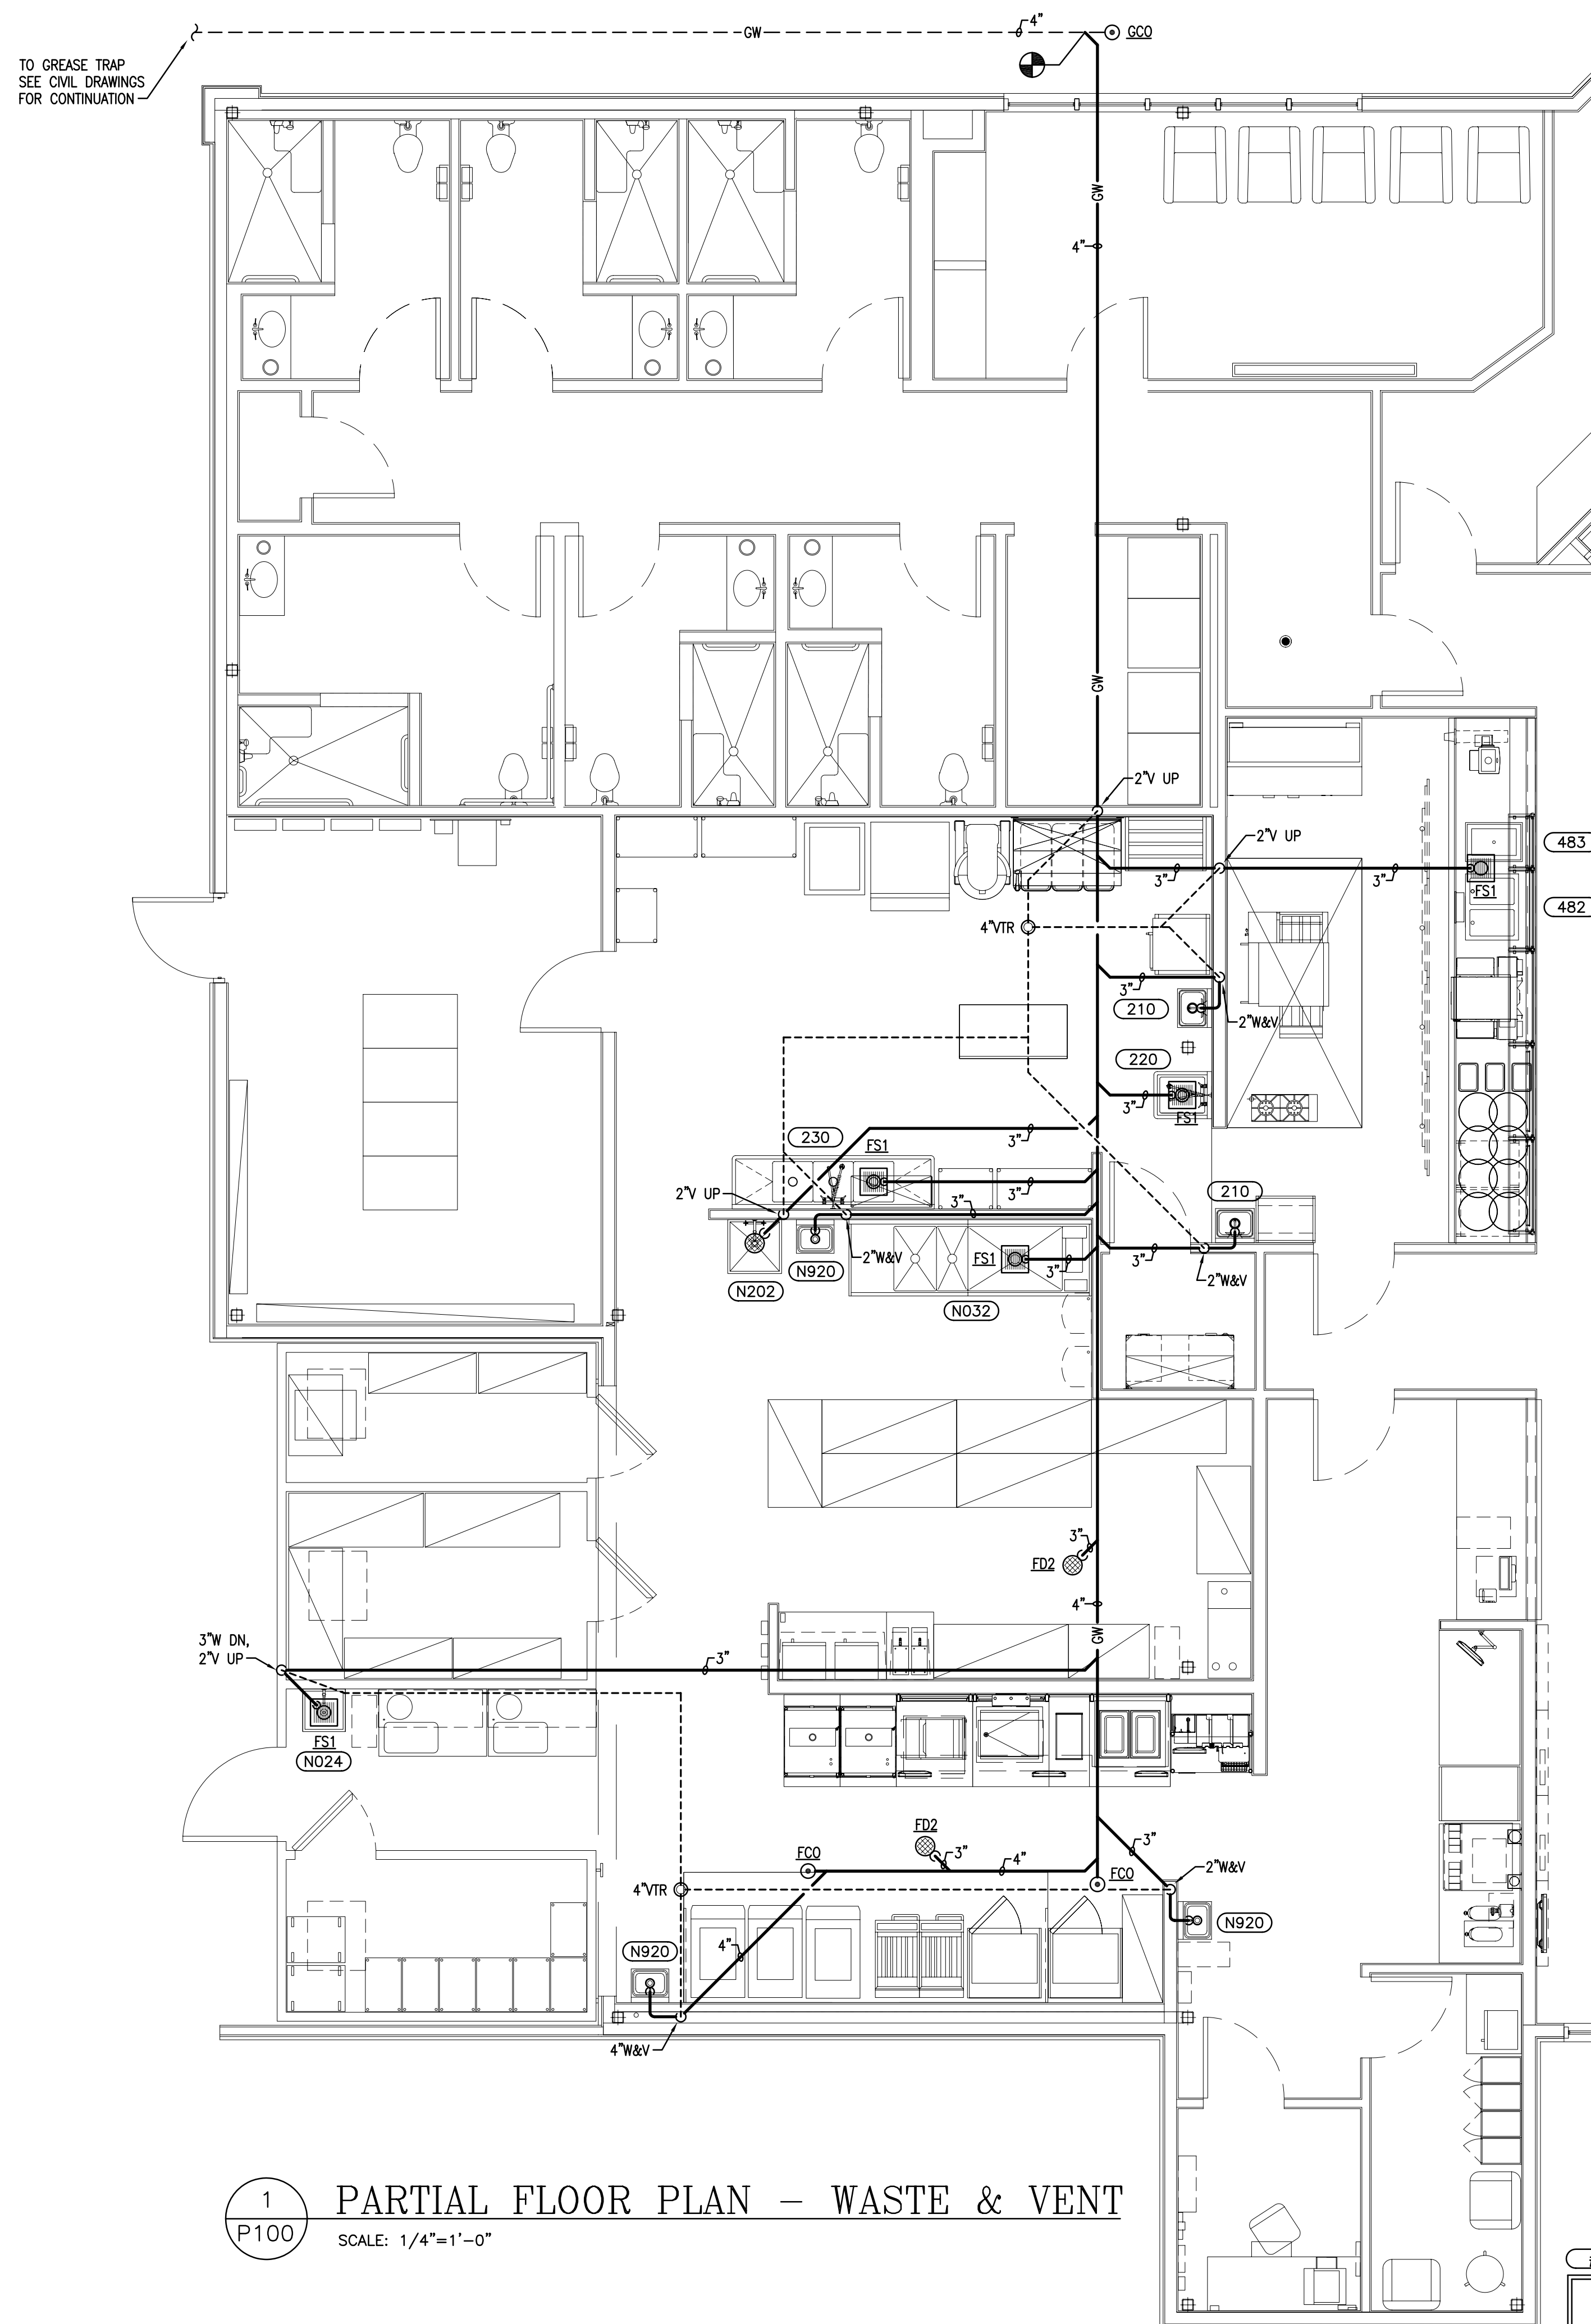

PARTIAL FLOOR PLAN – WASTE & VENT

SCALE: 1/4"=1'-0'

DENOTES KITCHEN EQUIPMENT - REFER TO FOOD SERVICE PLANS FOR ADDITIONAL INFORMATION.

GENERAL NOTE

PROVIDE FINAL PLUMBING CONNECTIONS TO ALL FOOD SERVICE EQUIPMENT INCLUDING ALL INDIRECT WASTE LINES, FITTINGS, AND APPURTENANCES FOR A COMPLETE INSTALLATION. REFER TO FOOD SERVICE EQUIPMENT DRAWINGS FOR ADDITIONAL ROUGH-IN INFORMATION AND CONNECTION DETAILS.

PROVIDE FINAL PLUMBING CONNECTIONS TO ALL FOOD SERVICE EQUIPMENT INCLUDING ALL INDIRECT WASTE LINES, FITTINGS, AND APPURTENANCES FOR A COMPLETE INSTALLATION. REFER TO FOOD SERVICE EQUIPMENT DRAWINGS FOR ADDITIONAL ROUGH-IN INFORMATION AND CONNECTION DETAILS.

100

THESE PLANS ARE THE PROPERTY OF MRP DESIGN GROUP, INC. AND ARE SUBJECT TO FEDERAL COPYRIGHT LAWS. ANY USE OF SAME WITHOUT THE EXPRESS WRITTEN PERMISSION OF MRP DESIGN GROUP, INC. IS STRICTLY PROHIBITED