


ABBREVIATIONS

3PL	THIRD PARTY LOGISTICS
A/C	AIR CONDITIONING
ACT	ACOUSTICAL CEILING TILE
ADJ	ADJUSTABLE
AFF	ABOVE FINISHED FLOOR
AMP	AMPERE
AOR	ARCHITECT OF RECORD
BLDG	BUILDING
BOH	BACK OF HOUSE
CAB	CABINET
CBS	COLD BEVERAGE STATION
CKT	CIRCUIT
CL	CENTER LINE
CLG	CEILING
CLR	CLEAR OR CLEARANCE
COL	COLUMN
COMP	COMPARTMENT
CONST	CONSTRUCTION
CONT	CONTINUOUS
CTR	CENTER
CW	COLD WATER
CX	COMMISSIONING
CXA	COMMISSIONING AGENT
DEG	DEGREE
DET	DETAIL
DIA	DIAMETER
DIM	DIMENSION
DISP	DISPENSER
DM	STARBUCKS DESIGN MANAGER
DN	DOWN
DT	DRIVE THRU
DWG	DRAWING
EA	EACH
EL	ELEVATION
ELC	ELECTRICAL
EM	EMERGENCY
EQ	EQUAL
EQUIP	EQUIPMENT
ESP	ESPRESSO
EXIST	EXISTING
EXT	EXTERIOR
FC	STARBUCKS FIXTURE CONTRACTOR
FF&E	FURNITURE, FIXTURE, AND EQUIPMENT
F&I	FURNISH AND INSTALL
FLR	FLOOR
FOH	FRONT OF HOUSE
FRP	FIBERGLAS REINFORCED PANEL
FT	FOOT/FEET
FW	FILTERED WATER
GC	GENERAL CONTRACTOR
GFCI	GROUND FAULT CIRCUIT INTERRUPTER
GND	GROUND
GWB	GYPSPUM WALLBOARD
HC	HOLLOW CORE
HDW	HARDWARE
HM	HOLLOW METAL
HORIZ	HORIZONTAL
HR	HOOR
HS	HAND SINK
HT	HEIGHT
HVAC	HEATING, VENTILATING, AND AIR CONDITIONING
HW	HOT WATER
ID	INSIDE DIAMETER
LC	LICENSEE
LEED	LEADERSHIP IN ENERGY AND ENVIRONMENTAL DESIGN
LV	LOW VOLTAGE
MAX	MAXIMUM
MECH	MECHANICAL
MEP	MECHANICAL, ELECTRICAL AND PLUMBING
MFR	MANUFACTURER
MIN	MINIMUM
MOP	MOBIL ORDER & PAY
MS	MOP SINK
NIC	NOT IN CONTRACT
NL	NIGHT LIGHT
NTS	NOT TO SCALE
OA	OVERALL
OC	ON CENTER
OD	OUTSIDE DIAMETER
PC	PLUMBING CONTRACTOR
PDM	STARBUCKS PROJECT DEVELOPMENT MANAGER
PLAM	PLASTIC LAMINATE
PLC	PLACE
POS	POINT OF SALE
R	RADIUS
REF	REFERENCE
REQD	REQUIRED
REV	REVISION
RND	ROUND
SB	STARBUCKS
SC	SOLID CORE
SF	SQUARE FEET
SHT	SHEET
SIM	SIMILAR
SPEC	SPECIFICATION
SQ	SQUARE
SS	SOLID SURFACE
SST	STAINLESS STEEL
SUSP	SUSPENDED
TEL	TELEPHONE
TEMP	TEMPORARY
TW	TEMPERED WATER
TYP	TYPICAL
UC	UNDER COUNTER
UNO	UNLESS NOTED OTHERWISE
VCT	VINYL CEILING TILE
VD	VENDOR DIRECT
VERT	VERTICAL
VIF	VERIFY IN FIELD
WH	WATER HEATER
WP	WEATHER PROOF

ARCHITECTURAL SYMBOL LEGEND

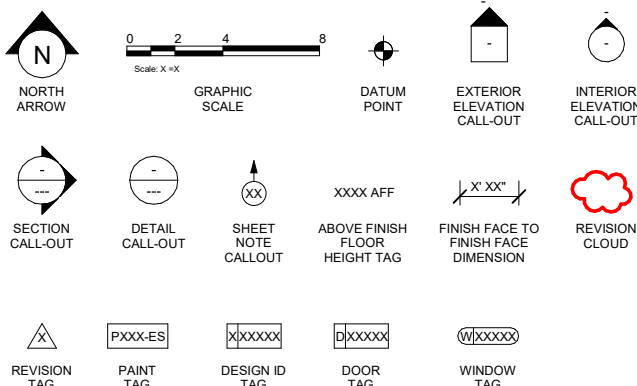


CUSTOM DESIGN ID KEY

SIGNAGE	"S"	x0000 - x0999
GRAPHICS AND ARTWORK	"G"	x1000 - x1099
SITE	"Y"	x1100 - x1199
DOORS	"D"	x2000 - x2999
DATA DEVICE	"A"	x3000 - x3999
SPECIALITY EQUIPMENT	"E"	x4000 - x4999
CASEWORK	"C"	x5000 - x5999
FURNITURE	"F"	x6000 - x6999
LIGHTING FIXTURE	"L"	x7000 - x7999
PLUMBING / MECHANICAL	"P" / "M"	x8000 - x8999
FINISHES - PAINT		x9000 - x9199
FINISHES - FLOOR TREATMENT	"T"	x9200 - x9399
FINISHES - WALL TREATMENT	"Q" / "R"	x9400 - x9799
FINISHES - CEILING TREATMENT	"U"	x9800 - x9999

SCHEDULE PREFIX

A	- DATA DEVICE SCHEDULE
B	- WALL BASE SCHEDULE
C	- CASEWORK SCHEDULE
D	- DOOR SCHEDULE
E	- SPECIALTY EQUIPMENT SCHEDULE
F	- FURNITURE SCHEDULE
G	- GRAPHICS AND ARTWORK SCHEDULE
L	- LIGHTING FIXTURE SCHEDULE
M	- MECHANICAL EQUIPMENT SCHEDULE
P	- PLUMBING FIXTURE SCHEDULE
Q	- WALL TREATMENT (AREA) SCHEDULE
R	- WALL TREATMENT (LENGTH) SCHEDULE
S	- SIGNAGE SCHEDULE
T	- FLOOR TREATMENT SCHEDULE
U	- CEILING TREATMENT SCHEDULE
W	- WINDOW SCHEDULE
Y	- SITE SCHEDULE
Z	- WINDOW FILM SCHEDULE

VICINITY PLAN

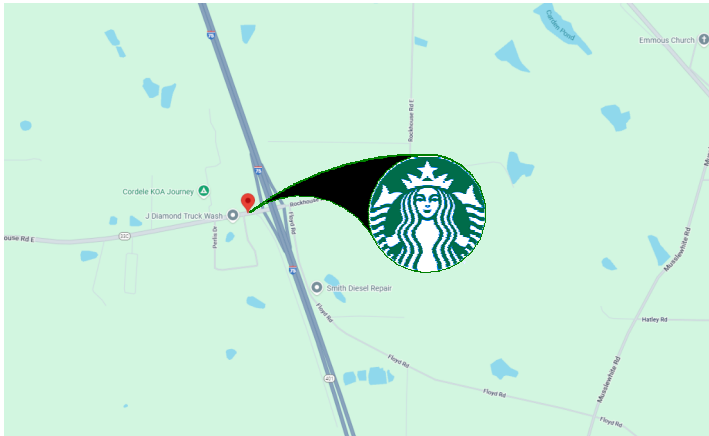

PROJECT CONTACTS

MAILING ADDRESS:	STARBUCKS COFFEE COMPANY 2401 UTAH AVENUE SOUTH MS STOP: S-SD10 SEATTLE, WASHINGTON 98134 (206) 318-1575
STORE DESIGN MANAGER:	MANDY KENT STARBUCKS COFFEE COMPANY (206) 734-6814 PHONE akent@starbucks.com
PROJECT MANAGER CONSTRUCTION:	BRIAN DELONG STARBUCKS COFFEE COMPANY (706) 851-0824 PHONE bdelong@starbucks.com
LICENSEE:	DON LEONARD SUPER PETROLEUM 20 INC. (468) 743-5097 PHONE dleonard@stroudandcompany.com
ARCHITECT OF RECORD:	KEN DALTON MRP DESIGN kdalton@victrongroup.com

FLAME SPREAD REQUIREMENTS

1. ARCHITECT OF RECORD TO VERIFY ALL REQUIRED FIRE RATINGS AND FLAME SPREADS APPLICABLE TO SPACE. ARCHITECT OF RECORD TO NOTIFY STARBUCKS TEAM IMMEDIATELY IF DISCREPANCIES ARE FOUND WITH DESIGN SCOPE.

CASEWORK	CLASS C
SUBSTRATE	CLASS C
SEALANTS	CLASS C
MURALS	CLASS C
FURNITURE	CLASS C
FABRIC	CLASS C
OTHER	CLASS C

GENERAL NOTES

- THESE DRAWINGS AND THE PROJECT MANUAL TOGETHER CONSTITUTE THE STARBUCKS DESIGN DEVELOPMENT SET. ALL GENERAL REQUIREMENTS ARE TO BE MET AND ALL MATERIALS, FINISHES, AND SYSTEMS ARE TO BE INSTALLED PER SPECIFICATIONS UNLESS NOTED OTHERWISE.
- LICENSEE SHALL HIRE ARCHITECT AND ENGINEER(S) OF RECORD TO ENGAGE IN LOCAL CODE REVIEW AND SHALL BE RESPONSIBLE FOR THE PERMITTING AND CODE COMPLIANCE, INCLUDING THE COMPLETION AND SUBMISSION OF STAMPED CONSTRUCTION PLANS ACCEPTABLE FOR PERMIT FILING. LICENSEE SHALL BE RESPONSIBLE FOR ALL COSTS AND COMPLIANCE ASSOCIATED WITH CODE, FIELD CONDITIONS, AND GOVERNING AGENCY REQUIREMENTS.
- GENERAL CONTRACTOR SHALL VISIT THE SITE, REVIEW THE BUILDING SHELL DRAWINGS AS SUBMITTED BY THE LICENSEE'S ARCHITECT OF RECORD AND BECOME THOROUGHLY FAMILIAR WITH THE SITE CONDITIONS PRIOR TO CONSTRUCTION.
- GENERAL CONTRACTOR SHALL CONSULT WITH LICENSEE'S ARCHITECT OF RECORD AND STARBUCKS PROJECT DEVELOPMENT MANAGER TO RESOLVE ANY CHANGES, OMISSIONS OR PLAN DISCREPANCIES PRIOR TO CONSTRUCTION.
- ALL WORK SHALL BE PERFORMED IN STRICT COMPLIANCE WITH LOCAL, COUNTY, STATE AND FEDERAL CODES AND ORDINANCES.
- GENERAL CONTRACTOR SHALL VERIFY THE LOCATION OF ALL UTILITIES.
- GENERAL CONTRACTOR TO VERIFY ALL DIMENSIONS, INCLUDING CLEARANCES REQUIRED BY OTHER TRADES AND NOTIFY LICENSEE'S ARCHITECT OF RECORD AND STARBUCKS PROJECT DEVELOPMENT MANAGER OF ANY DISCREPANCIES PRIOR TO PROCEEDING WITH WORK. ALL DIMENSIONS ARE TO THE FACE OF THE FINISHED SURFACE UNLESS NOTED OTHERWISE. ALL DIMENSIONS TO BE TAKEN FROM DESIGNATED DATUM POINT. DO NOT SCALE DRAWINGS.
- GENERAL CONTRACTOR SHALL PATCH AND REPAIR ALL EXISTING WALLS, FLOORS, CEILINGS, OR OTHER SURFACES IDENTIFIED TO REMAIN THAT MAY BECOME DAMAGED DURING THE COURSE OF WORK.
- GENERAL CONTRACTOR IS RESPONSIBLE FOR OBTAINING PERMITS FOR FIRE PROTECTION, PLUMBING, MECHANICAL, AND ELECTRICAL SYSTEMS PRIOR TO INSTALLATION OF SUCH SYSTEMS.
- GENERAL CONTRACTOR SHALL RETAIN ONE SET OF PERMIT PLANS ON-SITE TO DOCUMENT ALL CHANGES MADE DURING CONSTRUCTION. THE RECORD DRAWINGS SHALL BE ISSUED TO THE LICENSEE AND THE STARBUCKS PROJECT DEVELOPMENT MANAGER AT PROJECT CLOSE-OUT AS DESCRIBED IN THE GENERAL REQUIREMENTS OF THE PROJECT MANUAL.
- GENERAL CONTRACTOR IS RESPONSIBLE FOR COORDINATING DELIVERY OF MATERIALS FROM STARBUCKS CONTRACTED THIRD PARTY LOGISTICS DISTRIBUTION SERVICES AND VENDOR DIRECT SHIPMENTS. SEE PROJECT MANUAL FOR ADDITIONAL INFORMATION.
- RESPONSIBILITY FOR SUPPLY AND DELIVERY OF MATERIALS AND EQUIPMENT IS IDENTIFIED IN THE DRAWING SCHEDULE SHEETS UNDER THE COLUMN LABELED "RESPONSIBILITY".
- FOR THE PURPOSE OF THE DOCUMENTS, TO "INSTALL," SHALL MEAN TO PROVIDE ALL FASTENERS, MISCELLANEOUS HARDWARE, BLOCKING, ELECTRICAL CONNECTIONS, PLUMBING CONNECTIONS AND OTHER ITEMS REQUIRED FOR A COMPLETE AND OPERATIONAL INSTALLATION, UNLESS OTHERWISE NOTED.
- ALL ITEM SUBSTITUTIONS MUST BE APPROVED BY THE STARBUCKS DESIGN MANAGER AND/OR PROJECT DEVELOPMENT MANAGER.

PERSPECTIVE VIEW



LICENSED STORES RESPONSIBILITY LEGEND

SB	- STARBUCKS
FC	- STARBUCKS FIXTURE CONTRACTOR
LC	- LICENSEE
GC	- LICENSEE'S GENERAL CONTRACTOR

INDEX OF SHEETS

LEGEND: X - SHEET ISSUED R - SHEET ISSUED FOR REFERENCE AND COORDINATION ONLY SEE TITLEBLOCK FOR REVISION ISSUE DATE(S)							
SHEET	SHEET TITLE	REVISION 1	REVISION 2	REVISION 3	REVISION 4	REVISION 5	REVISION 6

GENERAL							
G001	GENERAL INFORMATION						
G002	DESIGN INTENT RENDERINGS						

ARCHITECTURAL							
A101	BUILDING FLOOR PLAN & DOOR SCHEDULE						
A101.1	DOOR SCHEDULE						
A102	BUILDING FLOOR PENETRATION PLAN						
A201	BUILDING EXTERIOR ELEVATIONS						
A202	BUILDING EXTERIOR ELEVATIONS						
A401	BLOCKING ELEVATIONS						
A402	BLOCKING ELEVATIONS						
A403	BLOCKING ELEVATIONS						

INTERIORS							
I101	FF & E PLAN						
I101.1	FF & E PLAN SCHEDULES						
I102	CASEWORK PLAN						
I102.1	CASEWORK SCHEDULES						
I103	REFLECTED CEILING PLAN						
I103.1	REFLECTED CEILING DETAILS						
I104	LIGHTING DIMENSION PLAN						
I104.1	LIGHTING PLACEMENT PLAN						
I105	INTERIOR FLOOR FINISH PLAN						
I106	INTERIOR WALL FINISH PLAN						
I106.1	INTERIOR WALL FINISH DETAILS						
I201	INTERIOR FINISH ELEVATIONS						
I202	INTERIOR FINISH ELEVATIONS						
I203	INTERIOR FINISH ELEVATIONS						
I501	INTERIOR DETAILS						
I502	INTERIOR DETAILS						
I503	INTERIOR DETAILS						
I504	INTERIOR DETAILS						
I505	INTERIOR DETAILS						
I506	INTERIOR DETAILS						
I507	INTERIOR DETAILS						
I508	INTERIOR DETAILS						
I509	INTERIOR DETAILS						
I510	INTERIOR DETAILS						

ELECTRICAL							
E001	ELECTRICAL NOTES						
E101	ELECTRICAL DESIGN PLAN						
E102	LIGHTING DESIGN PLAN						
E501	ELECTRICAL DETAILS						
E502	ELECTRICAL DETAILS						
E503	ELECTRICAL DETAILS						

MECHANICAL							
M001	MECHANICAL NOTES						

PLUMBING							
P001	PLUMBING NOTES						
P101	PLUMBING DESIGN PLAN						
P501	PLUMBING DETAILS						
P502	PLUMBING DETAILS						
P503	PLUMBING DETAILS						

DESIGN DEVELOPMENT ONLY - NOT INTENDED FOR CONSTRUCTION USE



STARBUCKS®
2401 UTAH AVENUE SOUTH
SEATTLE, WASHINGTON 98134
(206) 318-1575

THESE DRAWINGS AND THE PROJECT MANUAL ARE CONFIDENTIAL AND SHALL REMAIN THE SOLE PROPERTY OF STARBUCKS CORPORATION, WHICH IS THE OWNER OF THE COPYRIGHT IN THIS WORK. THEY SHALL NOT BE REPRODUCED (IN WHOLE OR IN PART), SHARED WITH THIRD PARTIES OR USED IN ANY MANNER ON OTHER PROJECTS OR EXTENSIONS TO THIS PROJECT WITHOUT THE PRIOR WRITTEN CONSENT OF STARBUCKS CORPORATION. THESE DRAWINGS AND SPECIFICATIONS ARE INTENDED TO EXPRESS DESIGN INTENT FOR A PROTOTYPICAL STARBUCKS STORE (WHICH IS SUBJECT TO CHANGE AT ANYTIME) AND DO NOT REFLECT ACTUAL SITE CONDITIONS. NEITHER PARTY SHALL HAVE ANY OBLIGATION NOR LIABILITY TO THE OTHER (EXCEPT STATED ABOVE) UNTIL A WRITTEN AGREEMENT IS FULLY EXECUTED BY BOTH PARTIES.

STARBUCKS TEMPLATE VERSION I2025.08.27

ARCHITECT OF RECORD

THIS DRAWING IS A DESIGN DEVELOPMENT DOCUMENT. SITE SPECIFIC MODIFICATIONS MADE UNDER THE RESPONSIBLE CHARGE OF THE ARCHITECT AND/OR ENGINEER-OF-RECORD WILL BE REQUIRED PRIOR TO USING THIS DOCUMENT FOR BIDDING, PERMITTING, OR CONSTRUCTION.

PROJECT NAME:

TA CORDELE

PROJECT ADDRESS:

397 ROCKHOUSE RD E
CORDELE, GA 31015

STORE #:	TBD
PROJECT #:	108648-001
ISSUE DATE:	12/03/2025
DESIGN MANAGER:	MANDY KENT
PRODUCTION DESIGNER:	MAV
CHECKED BY:	E. NORRIS

Revision Schedule			
Rev	Date	By	Description

SHEET TITLE:
GENERAL INFORMATION

SCALE: AS SHOWN

SHEET NUMBER:

G001

THIS IS A DESIGN INTENT ONLY DRAWING SET. NOT FOR CONSTRUCTION OR INSTALLATION PURPOSES. REFER TO ARCHITECT OF RECORD FINAL CONSTRUCTION DRAWINGS.

RENDERING IMAGES SHOWN ON THIS SHEET ARE FOR DESIGN INTENT ONLY AND ARE NOT INTENDED FOR CONSTRUCTION



DESIGN DEVELOPMENT ONLY - NOT INTENDED FOR CONSTRUCTION USE



© 2025 STARBUCKS COFFEE COMPANY

STARBUCKS®
2401 UTAH AVENUE SOUTH
SEATTLE, WASHINGTON 98134
(206) 318-1575

THESE DRAWINGS AND THE PROJECT MANUAL ARE CONFIDENTIAL AND SHALL REMAIN THE SOLE PROPERTY OF STARBUCKS CORPORATION, WHICH IS THE OWNER OF THE COPYRIGHT IN THIS WORK. THEY SHALL NOT BE REPRODUCED (IN WHOLE OR IN PART), SHARED WITH THIRD PARTIES OR USED IN ANY MANNER ON OTHER PROJECTS OR EXTENSIONS TO THIS PROJECT WITHOUT THE PRIOR WRITTEN CONSENT OF STARBUCKS CORPORATION. THESE DRAWINGS AND SPECIFICATIONS ARE INTENDED TO EXPRESS DESIGN INTENT FOR A PROTOTYPICAL STARBUCKS STORE (WHICH IS SUBJECT TO CHANGE AT ANYTIME) AND DO NOT REFLECT ACTUAL SITE CONDITIONS. NEITHER PARTY SHALL HAVE ANY OBLIGATION NOR LIABILITY TO THE OTHER (EXCEPT STATED ABOVE) UNTIL A WRITTEN AGREEMENT IS FULLY EXECUTED BY BOTH PARTIES.

STARBUCKS TEMPLATE VERSION I2025.08.27

ARCHITECT OF RECORD
THIS DRAWING IS A DESIGN DEVELOPMENT DOCUMENT. SITE SPECIFIC MODIFICATIONS MADE UNDER THE RESPONSIBLE CHARGE OF THE ARCHITECT AND/OR ENGINEER-OF-RECORD WILL BE REQUIRED PRIOR TO USING THIS DOCUMENT FOR BIDDING, PERMITTING, OR CONSTRUCTION.

PROJECT NAME:
TA CORDELE

PROJECT ADDRESS:
**397 ROCKHOUSE RD E
CORDELE, GA 31015**

STORE #:	TBD
PROJECT #:	108648-001
ISSUE DATE:	12/03/2025
DESIGN MANAGER:	MANDY KENT
PRODUCTION DESIGNER:	MAV
CHECKED BY:	E. NORRIS

Revision Schedule			
Rev	Date	By	Description

SHEET TITLE:
DESIGN INTENT RENDERINGS

SCALE: AS SHOWN

SHEET NUMBER:
G002


NOTES:

A. DOOR LEGEND: **DXX - XX XX**



B: REFERENCE BARRIER FREE DOOR HDW SCHEDULE FOR AUTO OPERATED & ACCESSORIES INFORMATION.

DOOR LEGEND

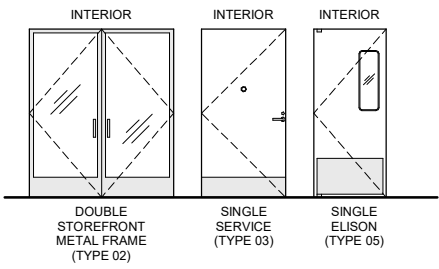

WALL TYPE LEGEND

1 EXISTING WALL / CURTAIN WALL

2 NEW PARTITION WALL TO 6" (152MM) ABOVE CEILING

20 GA 3-5/8" (96 MM) METAL STUDS 16" (406 MM) O.C. WITH 5/8" (16 MM) TYPE "X" GWB ON ONE OR BOTH SIDES TO MINIMUM OF 6" (152 MM) ABOVE CEILING GRID. DRYWALL SCREWS @ 12" (305 MM) O.C., 45 DEGREE METAL STUD REINFORCEMENT @ 48" (1210 MM) O.C. ABOVE CEILING LINE TO STRUCTURE ABOVE.

3 NEW FURRED WALL TO 6" (152MM) ABOVE CEILING

20 GA 3-5/8" (96 MM) METAL STUDS 16" (406 MM) O.C. WITH 5/8" (16 MM) TYPE "X" GWB TO MINIMUM OF 6" (152 MM) ABOVE CEILING GRID. DRYWALL SCREWS @ 12" (305 MM) O.C., 45 DEGREE METAL STUD REINFORCEMENT @ 48" (1210 MM) O.C. ABOVE CEILING LINE TO STRUCTURE ABOVE.

4 NEW PARTIAL HEIGHT WALL (TO 2'-0" AFF)

20 GA 3-5/8" (96 MM) METAL STUDS 16" (406 MM) O.C. WITH 5/8" (16 MM) TYPE "X" GWB ON ONE OR BOTH SIDES TO SPECIFIED HEIGHT. DRYWALL SCREWS @ 12" (305 MM) O.C.

5 NEW PLUMBING WALL TO 6" (152MM) ABOVE CEILING

20 GA 6" (152 MM) METAL STUDS 16" (406 MM) O.C. WITH 5/8" CEMENT BOARD TO 12" AFF AND 5/8" MOISTURE RESISTANT GYP. BOARD FROM CEMENT BOARD TO TOP OF WALL WORKROOM SIDE AND 5/8" CEMENT BOARD FROM FLOOR SLAB TO TOP OF WALL ON BACKBAR SIDE. SECURE MOISTURE RESISTANT GYPSUM BOARD TO STUDS WITH DRYWALL SCREWS AT 10" (254 MM) O.C. AT PANEL EDGES AND 12" (305 MM) O.C. AT INTERMEDIATE SUPPORTS.

6 NEW FURRED PLUMBING WALL TO 6" (152MM) ABOVE CEILING

20 GA 6" (152 MM) METAL STUDS 16" (406 MM) O.C. WITH 5/8" CEMENT BOARD TO 12" AFF AND 5/8" MOISTURE RESISTANT GYP. BOARD FROM CEMENT BOARD TO TOP OF WALL WORKROOM SIDE AND 5/8" CEMENT BOARD FROM FLOOR SLAB TO TOP OF WALL ON BACKBAR SIDE. SECURE MOISTURE RESISTANT GYPSUM BOARD TO STUDS WITH DRYWALL SCREWS AT 10" (254 MM) O.C. AT PANEL EDGES AND 12" (305 MM) O.C. AT INTERMEDIATE SUPPORTS.

7 NEW SHALLOW FURRED WALL TO 6" (154 MM) ABOVE CEILING

20 GA 1-3/4" (44 MM) METAL HAT CHANNELS 16" (406 MM) O.C. WITH 5/8" (16 MM) TYPE "X" GWB TO MINIMUM OF 6" (152 MM) ABOVE CEILING GRID. DRYWALL SCREWS @ 12" (305 MM) O.C., 45 DEGREE METAL STUD REINFORCEMENT @ 48" (1210 MM) O.C. ABOVE CEILING LINE TO STRUCTURE ABOVE.

8 NEW CURTAIN WALL (BY AOR)

9 NEW SINGLE 5/8" GWB LAYER TO 6" (154 MM) ABOVE CEILING ON EXISTING STRUCTURE

5/8" (16 MM) TYPE "X" GWB TO MINIMUM OF 6" (152 MM) ABOVE CEILING GRID

10 NEW PARTIAL HEIGHT WALL (TO 2'-10" AFF)

20 GA 5-1/4" (96 MM) METAL STUDS 16" (406 MM) O.C. WITH 5/8" (16 MM) TYPE "X" GWB ON BOTH SIDES TO SPECIFIED HEIGHT. DRYWALL SCREWS @ 12" (305 MM) O.C.

11 NEW PARTITION WALL TO 6" (152MM) ABOVE CEILING

20 GA 6-1/4" (96 MM) METAL STUDS 16" (406 MM) O.C. WITH 5/8" (16 MM) TYPE "X" GWB ON ONE OR BOTH SIDES TO MINIMUM OF 6" (152 MM) ABOVE CEILING GRID. DRYWALL SCREWS @ 12" (305 MM) O.C., 45 DEGREE METAL STUD REINFORCEMENT @ 48" (1210 MM) O.C. ABOVE CEILING LINE TO STRUCTURE ABOVE.

12 NEW PARTITION WALL TO 6" (152MM) ABOVE CEILING

20 GA 5-3/8" (96 MM) METAL STUDS 16" (406 MM) O.C. WITH 5/8" (16 MM) TYPE "X" GWB ON ONE OR BOTH SIDES TO MINIMUM OF 6" (152 MM) ABOVE CEILING GRID. DRYWALL SCREWS @ 12" (305 MM) O.C., 45 DEGREE METAL STUD REINFORCEMENT @ 48" (1210 MM) O.C. ABOVE CEILING LINE TO STRUCTURE ABOVE.

KEYED NOTES

- INSTALL NEW WALLS AND DOORS AS INDICATED.
- OUTLINE OF BAR PER CASEWORK MANUFACTURER.
- PROPOSED ELECTRICAL PANEL LOCATION. MAINTAIN MINIMUM CLEARANCE AS REQUIRED BY CODE.
- SERVICE DOOR TO BE LOCKABLE. NOT TO BE USED FOR EGRESS.

GENERAL NOTES

- GENERAL CONTRACTOR TO VERIFY ALL DIMENSIONS AND NOTIFY ARCHITECT OF RECORD AND STARBUCKS DEVELOPMENT MANAGER OF ANY DISCREPANCIES PRIOR TO CONSTRUCTION. ALL DIMENSIONS TO BE TAKEN FROM DESIGNATED DATUM POINT.
- GENERAL CONTRACTOR TO PROVIDE FIRE TREATED WOOD STUD BLOCKING, OR EQUIVALENT, TO SUPPORT ANY WALL ATTACHMENT AND/OR SIGNAGE.
- IF EXISTING EXTERIOR ENTRANCE THRESHOLD EXCEEDS MINIMUM BARRIER FREE PROVISIONS OF THE CODE, REMOVE AND REPLACE WITH ACCESSIBLE THRESHOLD. RAISED THRESHOLDS AND FLOOR LEVEL CHANGES AT ACCESSIBLE DOORWAYS TO BE BEVELED WITH A SLOPE NO GREATER THAN 1:12.
- ALL DIMENSIONS ARE TO FINISHED FACE UNLESS SHOWN OR NOTED OTHERWISE.
- INSTALL MOISTURE RESISTANT BACKBAR WALL BOARD PER PROJECT MANUAL.
- ALL DOORS SHALL BE 32" (815MM) MINIMUM CLEAR OPENING WHEN OPENED TO 90 DEGREE POSITION UNLESS NOTED OTHERWISE.
- ARCHITECT OF RECORD TO SPECIFY ALL DOOR HARDWARE COMPONENTS. GENERAL CONTRACTOR TO FURNISH AND INSTALL.
- ARCHITECT OF RECORD TO VERIFY ALL EXISTING DOORS, HARDWARE, AND FRAMES MEET STARBUCKS AND/OR CODE REQUIREMENTS.
- GENERAL CONTRACTOR TO FURNISH AND INSTALL FIRE EXTINGUISHER(S) AS REQUIRED PER CODE.
- ARCHITECT OF RECORD TO VERIFY ALL WALL TYPES.
- GENERAL CONTRACTOR TO FURNISH AND INSTALL NEW STUD FURRING AND GWB AS REQUIRED. ARCHITECT OF RECORD TO VERIFY AND COORDINATE FOR REQUIRED FIRE RATINGS AND SOUND INSULATION CRITERIA.
- EGRESS SHALL NOT PASS THROUGH KITCHENS, STORAGE ROOMS, CLOSETS, OR SIMILAR SPACES.
- REFER TO SHEET 1105 FOR FLOOR FINISHES

LEGEND

- NEW FULL HEIGHT WALL
- NEW PARTIAL HEIGHT WALL
- EXISTING WALL
- EXISTING COLUMN
- WALL BLOCKING CALL OUT

GENERAL CONTRACTOR TO FIELD VERIFY ALL DIMENSIONS AND COORDINATE AS NECESSARY WITH ARCHITECT OF RECORD


LICENSED STORES RESPONSIBILITY LEGEND

- SB - STARBUCKS
- FC - STARBUCKS FIXTURE CONTRACTOR
- LC - LICENSEE
- GC - LICENSEE'S GENERAL CONTRACTOR



1 BUILDING FLOOR PLAN

Scale: 1/4" = 1'-0"

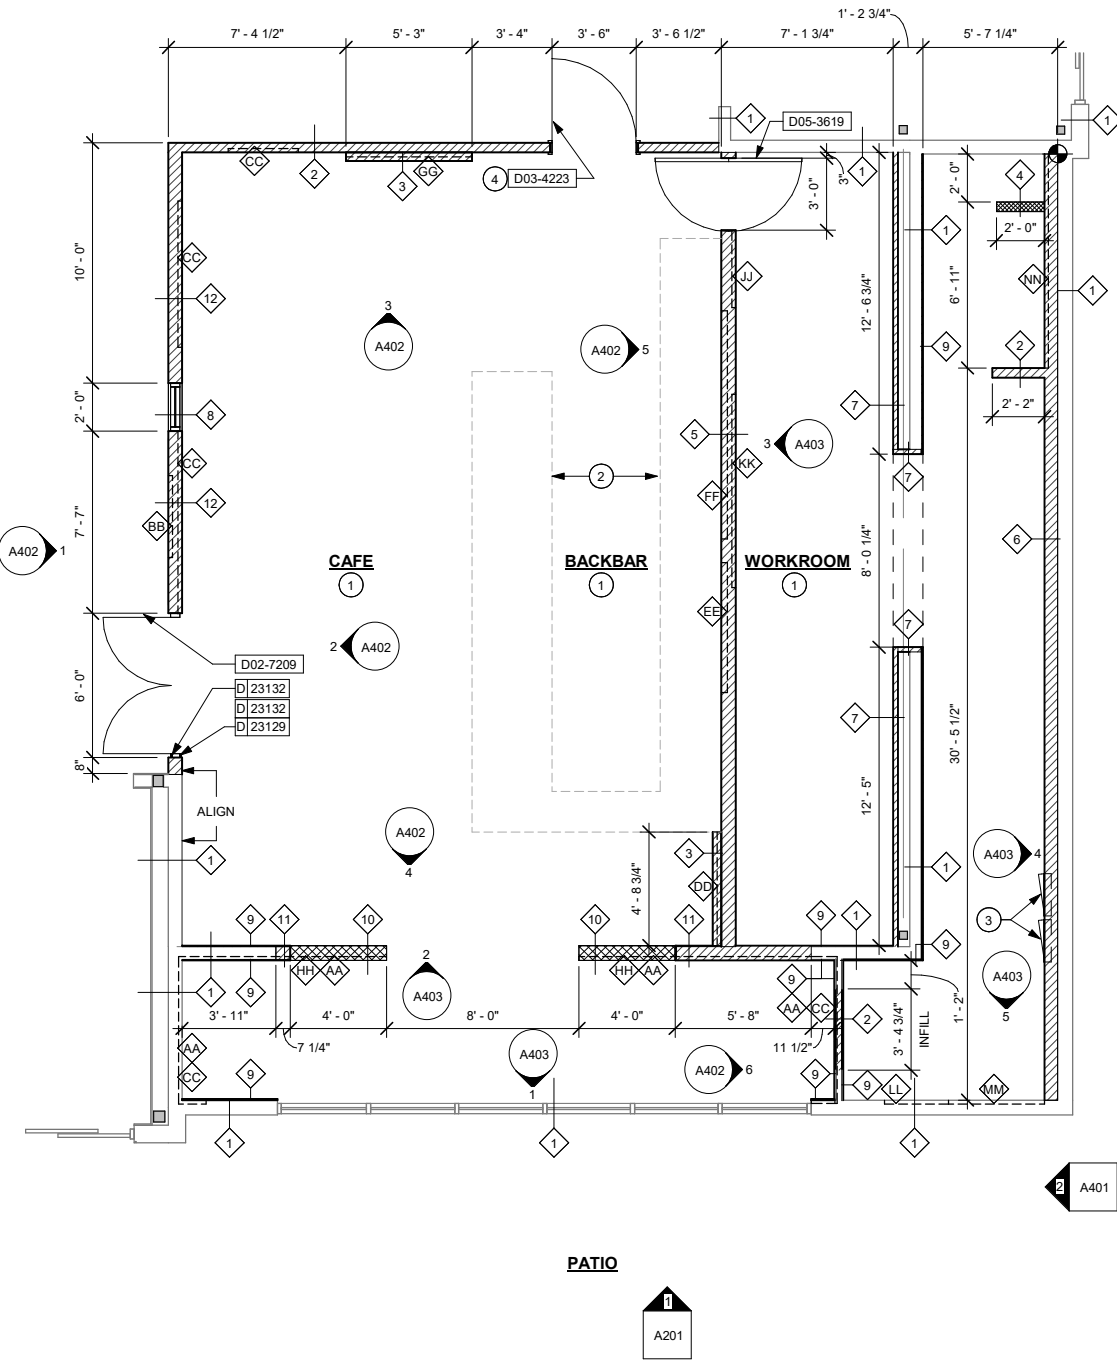

DESIGN DEVELOPMENT ONLY - NOT INTENDED FOR CONSTRUCTION USE



STARBUCKS®
2401 UTAH AVENUE SOUTH
SEATTLE, WASHINGTON 98134
(206) 318-1575

THESE DRAWINGS AND THE PROJECT MANUAL ARE CONFIDENTIAL AND SHALL REMAIN THE SOLE PROPERTY OF STARBUCKS CORPORATION, WHICH IS THE OWNER OF THE COPYRIGHT IN THIS WORK. THEY SHALL NOT BE REPRODUCED (IN WHOLE OR IN PART), SHARED WITH THIRD PARTIES OR USED IN ANY MANNER ON OTHER PROJECTS OR EXTENSIONS TO THIS PROJECT WITHOUT THE PRIOR WRITTEN CONSENT OF STARBUCKS CORPORATION. THESE DRAWINGS AND SPECIFICATIONS ARE INTENDED TO EXPRESS DESIGN INTENT FOR A PROTOTYPICAL STARBUCKS STORE (WHICH IS SUBJECT TO CHANGE AT ANYTIME) AND DO NOT REFLECT ACTUAL SITE CONDITIONS. NEITHER PARTY SHALL HAVE ANY OBLIGATION NOR LIABILITY TO THE OTHER (EXCEPT STATED ABOVE) UNTIL A WRITTEN AGREEMENT IS FULLY EXECUTED BY BOTH PARTIES.

STARBUCKS TEMPLATE VERSION I2025.08.27

ARCHITECT OF RECORD

THIS DRAWING IS A DESIGN DEVELOPMENT DOCUMENT. SITE SPECIFIC MODIFICATIONS MADE UNDER THE RESPONSIBLE CHARGE OF THE ARCHITECT AND/OR ENGINEER-OF-RECORD WILL BE REQUIRED PRIOR TO USING THIS DOCUMENT FOR BIDDING, PERMITTING, OR CONSTRUCTION.

PROJECT NAME:
TA CORDELE

PROJECT ADDRESS:
397 ROCKHOUSE RDE
CORDELE, GA 31015

STORE #: TBD
PROJECT #: 108648-001
ISSUE DATE: 12/03/2025
DESIGN MANAGER: MANDY KENT
PRODUCTION DESIGNER: MAV
CHECKED BY: E. NORRIS



Revision Schedule			
Rev	Date	By	Description

SHEET TITLE:
**BUILDING FLOOR PLAN
& DOOR SCHEDULE**
SCALE: AS SHOWN

SHEET NUMBER:
A101

DOOR SCHEDULE - "D"												
NUMBER	QTY	DESCRIPTION	W	H	D	AUTO OPERATE	EGREES	FIRE RATING	FINISH	FURN BY	INST BY	COMMENT
D02-7209	1	(ENTRY/EXIT) (DOUBLE) (NEW) (ACTUATOR)	5' - 8"	7' - 0"		Yes	Yes	(none)	ALUM	GC	GC	LL PROVIDES TEMP. HARDWARE GC SHALL PROVIDE PERMENANT HARDWARE PER HARDWARE TYPE NOTED
D05-3619	1	(WORKROOM/ELIASON) (SINGLE)	3' - 0"	7' - 0"	3/4"	No	No	(none)	HPL	GC	GC	
D03-4223	1	(SERVICE/EXTERIOR) (SINGLE) (KEYED LOCK)	3' - 6"	7' - 0"	1 3/4"	No	No	(none)	STL	GC	GC	LL PROVIDES TEMP. HARDWARE GC SHALL PROVIDE PERMENANT HARDWARE PER HARDWARE TYPE NOTED
(1)CONTINUOUS HINGE — PEMKO CFM83-HD1 C■(1)FLUSH BOLT — ADAMS RITE MS1880-01-84" 682■(1)DEAD LOCK — ADAMS RITE MS18505-110-628 LH 628■(1)CYLINDER — FALCON C607 A 626 OPEN 7-PIN CORE COMBINATED "A" KEYWAY 626■(1)CYLINDER — FALCON C987 626 7 PIN MORTISE CYLINDER HOUSING W/AR CAM 626■(1)KEYING — FALCON KB609-2CCA CUT CONTROL KEY "A" KEYWAY■(1)KEYING — FALCON KB632-2CCA CUT USER KEY "A" KEYWAY■(1)PUSH BAR — ROCKWOOD BF15747-33" T1HD MOUNTING US28 US28■(1)SURFACE CLOSER — DORMAKABA DOOR CLOSER 8916 AF89P BS889 CL LH CL■(1)FLOOR DOOR HOLDER — ROCKWOOD DOOR STOP W/ HOOK US26D■(1)THRESHOLD — NGP325-72"■(1)WEATHERSTRIPPING — NGP137NA WEATHERSTRIP 72"x84"(20") A■(1)WEATHERSTRIPPING — PEMKO DOOR SWEEP 18062CNB36" C■(1)MISCELLANEOUS ITEM — SCHLAGE GS314-LB NS DOOR KEY SWITCH■(1)MISCELLANEOUS ITEM — REFER TO THE BARRIER FREE EXTERIOR DOOR SCHEDULE ON THIS SHEET THAT WILL INCLUDE ADDITIONAL DOOR CONTENT FOR THIS SET■(1)ROOM NAME PLATE SIGN — VINYL SIGN: THIS DOOR MUST REMAIN UNLOCKED WHEN BUILDING IS OCCUPIED"■(1)MISCELLANEOUS HARDWARE — FALCON A08794-003 ADJUSTABLE RING, MORTISE CYL5/16-13/32 626 (1)TRAFFIC DOOR — ELIASON TRAFFIC DOOR SCP8 36" X 84". FINISH: BLACK (1)CONTINUOUS HINGE — PEMKO CFM83-HD1 C■(1)EXIT DEVICE — ACCENTRA 7100 626F-PB X 630 PANIC BAR W/ EXTERIOR KEYED LEVER TRIM - LH 630/630■(1)CYLINDER — FALCON C607 A 626 OPEN 7-PIN CORE COMBINATED "A" KEYWAY 626■(1)CYLINDER — FALCON C953 626■(9)KEYING — FALCON KB609-2CCA CUT CONTROL KEY "A" KEYWAY■(9)KEYING — FALCON KB632-2CCA CUT USER KEY "A" KEYWAY■(1)SURFACE CLOSER — DORMAKABA DOOR CLOSER 8916 AF89P 889■(1)KICK PLATE — ROCKWOOD K1050 B4E KICKPLATE 8" X 11" LDW PULL SIDE US32D US32D■(1)KICK PLATE — ROCKWOOD K1050 B4E KICKPLATE 8" X 2" LDW PUSH SIDE US32D US32D■(17)WEATHERSTRIPPING — NGP 137NA WEATHERSTRIP 36" X 84" A■(17)WEATHERSTRIPPING — PEMKO DOOR SWEEP 18062CNB 36" C■(17)DOOR KNOCKER — NEWHOUSE MCV309NWHGL DOORBELL■(17)MISCELLANEOUS HARDWARE — DU SEUNG DU SEUNG DS/1000 DOOR SCOPE SILVER												

DOOR ACTUATOR SCHEDULE - "D"					
DESIGN ID	COUNT	DESCRIPTION	FURN BY	INST BY	COMMENTS
DOOR HARDWARE					
23132	2	DOOR - BARRIER FREE HARDWARE ACTUATOR MULLION MOUNT	GC	GC	FINISH: BLACK
23129	1	DOOR - BARRIER FREE HARDWARE KEY SWITCH	GC	GC	FINISH: BLACK
23135	1	DOOR - BARRIER FREE HARDWARE OPERATOR - BLACK	GC	GC	

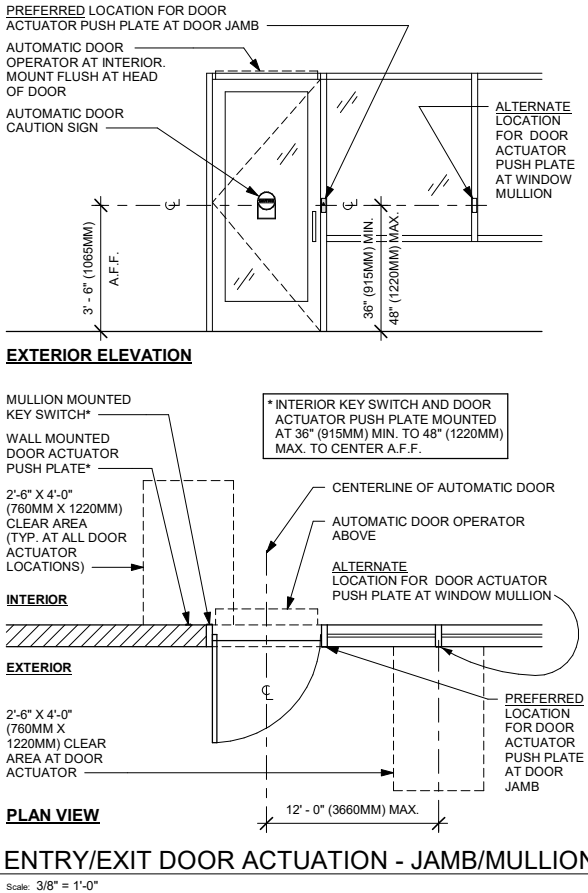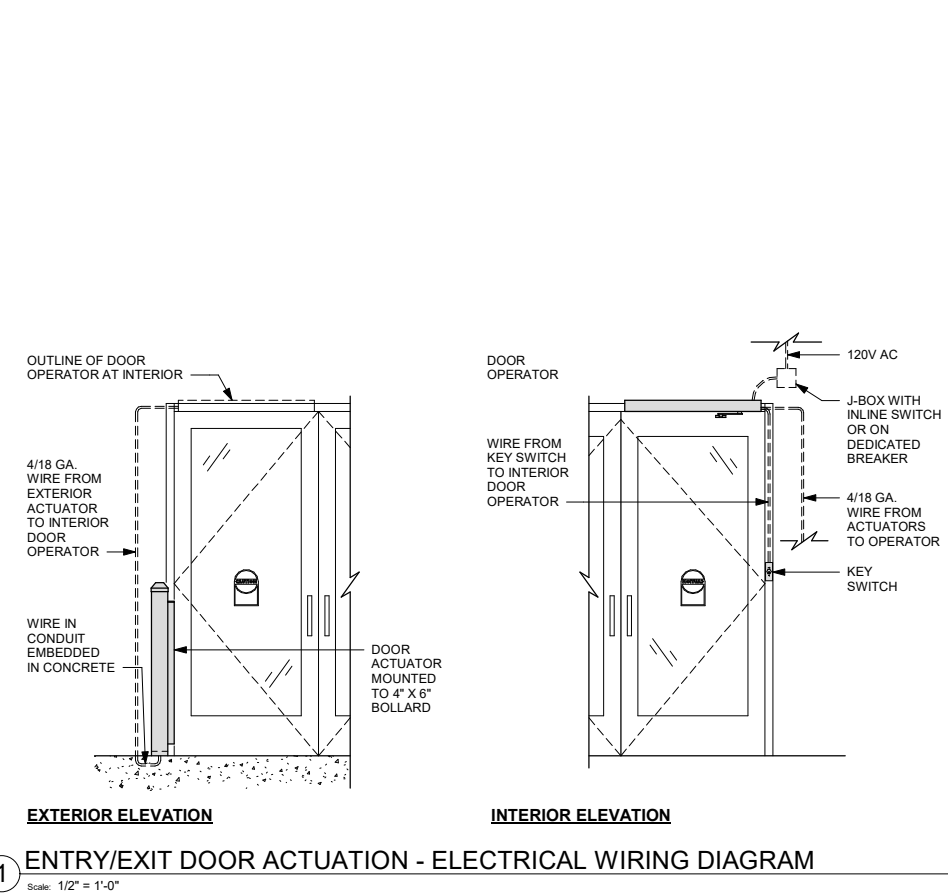


WALL BLOCKING LEGEND

SYMBOL	ITEM	WEIGHT	HEIGHT AFF	APPROX. WIDTH
AA	WOOD PORTALS	AOR TO VERIFY	SEE BLOCKING ELEVATION	SEE BLOCKING ELEVATION
BB	LOGO SIGN	AOR TO VERIFY	SEE BLOCKING ELEVATION	SEE BLOCKING ELEVATION
CC	ARTWORK	AOR TO VERIFY	SEE BLOCKING ELEVATION	SEE BLOCKING ELEVATION
DD	ORDER STATUS BOARD	AOR TO VERIFY	3' - 9" TO 8' - 6"	3' - 2"
EE	CBE SHELVES	300 LBS	3' - 11" TO 5' - 6"	5' - 6"
FF	DIGITAL MENUS	AOR TO VERIFY	6' - 1" TO 9' - 2"	12' - 0"
GG	MERCHANDISE	AOR TO VERIFY	5' - 4" TO 6' - 8"	5' - 3"
HH	BANQUETTE	AOR TO VERIFY	SEE BLOCKING ELEVATION	SEE BLOCKING ELEVATION
JJ	WORKROOM HAND SINK, SOAP AND PAPER TOWEL DISPENSER	128 LBS (58 KG)	2' - 0" TO 5' - 4"	2' - 11"
KK	SHELVES ABOVE 3-COMP SINK	200 LBS (91 KG)	3' - 8" TO 6' - 10"	8' - 5"
LL	SPC CABINET	AOR TO VERIFY	3' - 0" TO 5' - 10"	2' - 7"
MM	MANAGER DESK	300 LBS (136 KG)	2' - 8" TO 8' - 0"	6' - 3"
NN	WATER FILTRATION SYSTEM	AOR TO VERIFY	0' - 0" TO 9' - 0"	8' - 11"

PROVIDE FIRE TREATED 2X6 OR 2X8 WOOD STUD BLOCKING AS REQUIRED TO SUPPORT ANY WALL ATTACHMENTS.

REFER TO SHEETS A401 FOR LOCATIONS OF BLOCKING, MOUNTING HEIGHTS, AND EXTEND OF BLOCKING SURFACES.

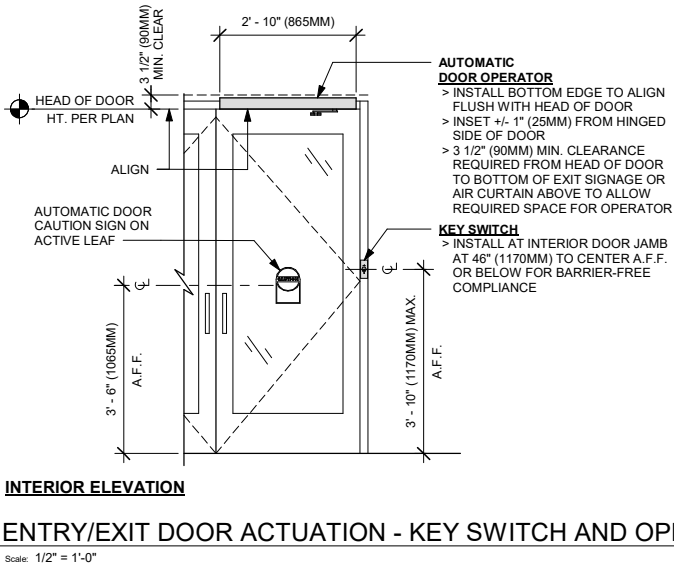

STARBUCKS®
2401 UTAH AVENUE SOUTH
SEATTLE, WASHINGTON 98134
(206) 318-1575

THESE DRAWINGS AND THE PROJECT MANUAL ARE CONFIDENTIAL AND SHALL REMAIN THE SOLE PROPERTY OF STARBUCKS CORPORATION, WHICH IS THE OWNER OF THE COPYRIGHT IN THIS WORK. THEY SHALL NOT BE REPRODUCED (IN WHOLE OR IN PART), SHARED WITH THIRD PARTIES OR USED IN ANY MANNER ON OTHER PROJECTS OR EXTENSIONS TO THIS PROJECT WITHOUT THE PRIOR WRITTEN CONSENT OF STARBUCKS CORPORATION. THESE DRAWINGS AND SPECIFICATIONS ARE INTENDED TO EXPRESS DESIGN INTENT FOR A PROTOTYPICAL STARBUCKS STORE (WHICH IS SUBJECT TO CHANGE AT ANYTIME) AND DO NOT REFLECT ACTUAL SITE CONDITIONS. NEITHER PARTY SHALL HAVE ANY OBLIGATION NOR LIABILITY TO THE OTHER (EXCEPT STATED ABOVE) UNTIL A WRITTEN AGREEMENT IS FULLY EXECUTED BY BOTH PARTIES.

STARBUCKS TEMPLATE VERSION I2025.08.27

ARCHITECT OF RECORD

THIS DRAWING IS A DESIGN DEVELOPMENT DOCUMENT. SITE SPECIFIC MODIFICATIONS MADE UNDER THE RESPONSIBLE CHARGE OF THE ARCHITECT AND/OR ENGINEER-OF-RECORD WILL BE REQUIRED PRIOR TO USING THIS DOCUMENT FOR BIDDING, PERMITTING, OR CONSTRUCTION.

PROJECT NAME:
TA CORDELE

PROJECT ADDRESS:
397 ROCKHOUSE RDE
CORDELE, GA 31015

STORE #: TBD
PROJECT #: 108648-001
ISSUE DATE: 12/03/2025
DESIGN MANAGER: MANDY KENT
PRODUCTION DESIGNER: MAV
CHECKED BY: E. NORRIS

Revision Schedule			
Rev	Date	By	Description

SHEET TITLE:
DOOR SCHEDULE


SCALE: AS SHOWN

SHEET NUMBER:

A101.1

DESIGN DEVELOPMENT ONLY - NOT INTENDED FOR CONSTRUCTION USE

1 BUILDING FLOOR PENETRATION PLAN
Scale: 1/4" = 1'-0"

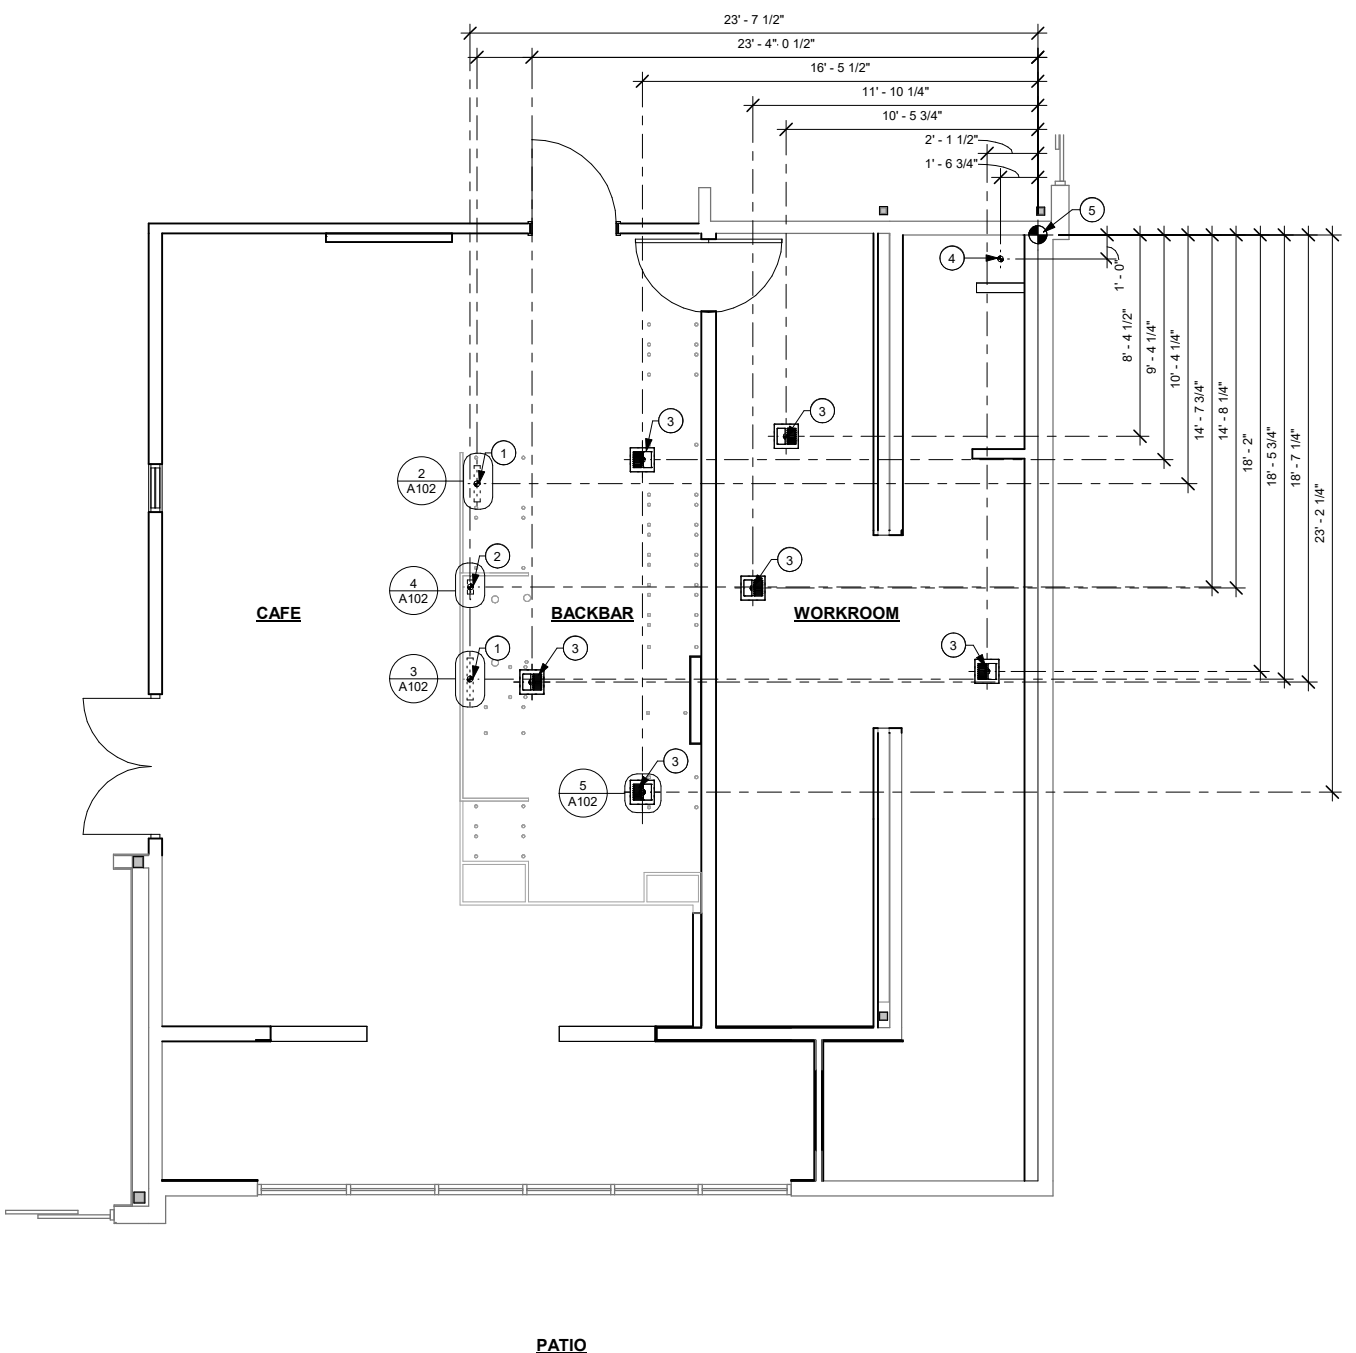

KEYED NOTES

- ELECTRICAL STUB-UP LOCATION. REFER TO ELECTRICAL PLAN AND DETAILS FOR MORE INFORMATION.
- PLUMBING STUB-UP LOCATION. REFER TO PLUMBING PLAN AND DETAILS FOR MORE INFORMATION.
- FLOOR SINK LOCATION. REFER TO PLUMBING PLAN AND DETAILS FOR MORE INFORMATION.
- MOP SINK DRAIN LOCATION. REFER TO PLUMBING PLAN AND DETAILS FOR MORE INFORMATION.
- DATUM INDICATES DIMENSION START POINT AT EXISTING WALL.

GENERAL NOTES

- GENERAL CONTRACTOR TO FIELD VERIFY ALL DIMENSIONS AND NOTIFY ARCHITECT OF RECORD AND STARBUCKS PROJECT DEVELOPMENT MANAGER OF ANY KNOWN DISCREPANCIES PRIOR TO CONSTRUCTION.
- ALL STUB-UP DIMENSIONS ARE RELATIVE TO FINISHED WALL LOCATIONS (SHOWN AS OUTLINES ON THIS PLAN). REFER TO BUILDING FLOOR PLAN FOR WALL PLACEMENT.
- GENERAL CONTRACTOR TO COORDINATE WITH SPECIFIC TRADES AND SITE CONDITIONS TO DETERMINE ACTUAL TRENCHING LAYOUT AS REQUIRED.
- REFER TO SHEET I105 FOR FLOOR FINISHES.


PENETRATION SYMBOL LEGEND

- FLOOR SINK
- FLOOR PENETRATION
- PLUMBING PENETRATION AREA
- ELECTRICAL PENETRATION AREA
- DATUM POINT


ARCHITECT AND/OR ENGINEER OF RECORD
TO VERIFY NUMBER OF FLOOR SINKS AND
STUB-UP PENETRATIONS REQUIRED BY CODE
PER JURISDICTION.

GENERAL CONTRACTOR TO FIELD VERIFY
ALL DIMENSIONS AND COORDINATE AS
NECESSARY WITH ARCHITECT OF RECORD.


2 ELECTRICAL STUB-UPS AT POS
Scale: 1 1/2" = 1'-0"

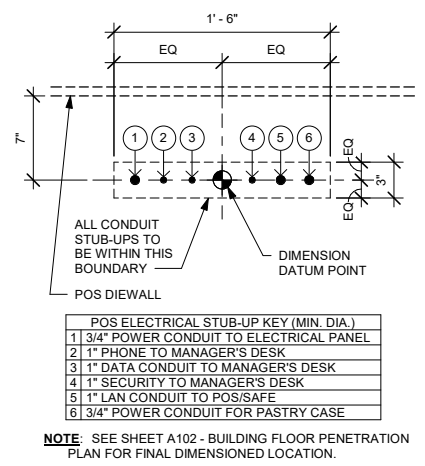



3 ELECTRICAL STUB-UPS AT ESPRESSO BAR
Scale: 1 1/2" = 1'-0"

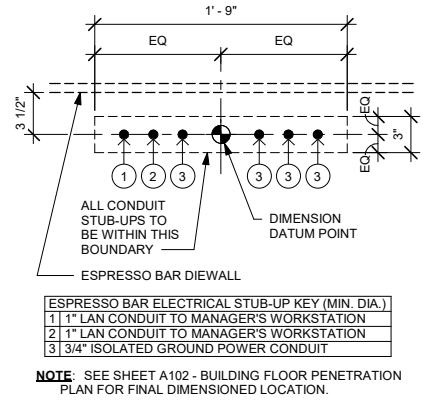

4 PLUMBING STUB-UPS AT ESPRESSO BAR
Scale: 1 1/2" = 1'-0"

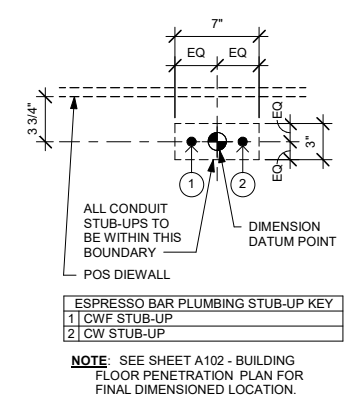

5 FLOOR SINK DETAIL
Scale: 3" = 1'-0"

 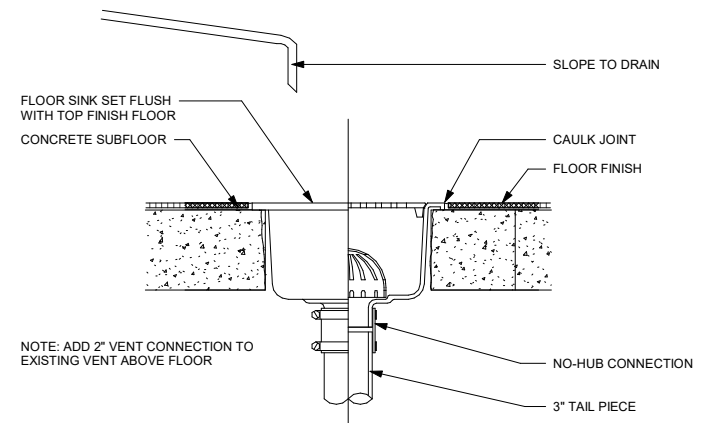

DESIGN DEVELOPMENT ONLY - NOT INTENDED FOR CONSTRUCTION USE



STARBUCKS®
2401 UTAH AVENUE SOUTH
SEATTLE, WASHINGTON 98134
(206) 318-1575

THESE DRAWINGS AND THE PROJECT MANUAL ARE CONFIDENTIAL AND SHALL REMAIN THE SOLE PROPERTY OF STARBUCKS CORPORATION, WHICH IS THE OWNER OF THE COPYRIGHT IN THIS WORK. THEY SHALL NOT BE REPRODUCED (IN WHOLE OR IN PART), SHARED WITH THIRD PARTIES OR USED IN ANY MANNER ON OTHER PROJECTS OR EXTENSIONS TO THIS PROJECT WITHOUT THE PRIOR WRITTEN CONSENT OF STARBUCKS CORPORATION. THESE DRAWINGS AND SPECIFICATIONS ARE INTENDED TO EXPRESS DESIGN INTENT FOR A PROTOTYPICAL STARBUCKS STORE (WHICH IS SUBJECT TO CHANGE AT ANYTIME) AND DO NOT REFLECT ACTUAL SITE CONDITIONS. NEITHER PARTY SHALL HAVE ANY OBLIGATION NOR LIABILITY TO THE OTHER (EXCEPT STATED ABOVE) UNTIL A WRITTEN AGREEMENT IS FULLY EXECUTED BY BOTH PARTIES.

STARBUCKS TEMPLATE VERSION I2025.08.27

ARCHITECT OF RECORD

THIS DRAWING IS A DESIGN DEVELOPMENT DOCUMENT. SITE SPECIFIC MODIFICATIONS MADE UNDER THE RESPONSIBLE CHARGE OF THE ARCHITECT AND/OR ENGINEER-OF-RECORD WILL BE REQUIRED PRIOR TO USING THIS DOCUMENT FOR BIDDING, PERMITTING, OR CONSTRUCTION.

PROJECT NAME:
TA CORDELE

PROJECT ADDRESS:
397 ROCKHOUSE RD E
CORDELE, GA 31015


STORE #: TBD
PROJECT #: 108648-001
ISSUE DATE: 12/03/2025
DESIGN MANAGER: MANDY KENT
PRODUCTION DESIGNER: MAV
CHECKED BY: E. NORRIS

Revision Schedule				
Rev	Date	By	Description	

SHEET TITLE:
**BUILDING FLOOR
PENETRATION PLAN**
SCALE: AS SHOWN

SHEET NUMBER:
A102

SIGNAGE SCHEDULE - "S"					
DESIGN ID	COUNT	DESCRIPTION	FURN. BY	INST. BY	COMMENTS
SIGNAGE - DISK					
13164	2	SIGN - DISK SF ILLUMINATED FLUSH MOUNTED EVOLVED - 60IN 1525MM	SB	SB	
13193	1	SIGN - DISK SF ILLUMINATED FLUSH MOUNTED EVOLVED - 30IN 760MM	SB	SB	

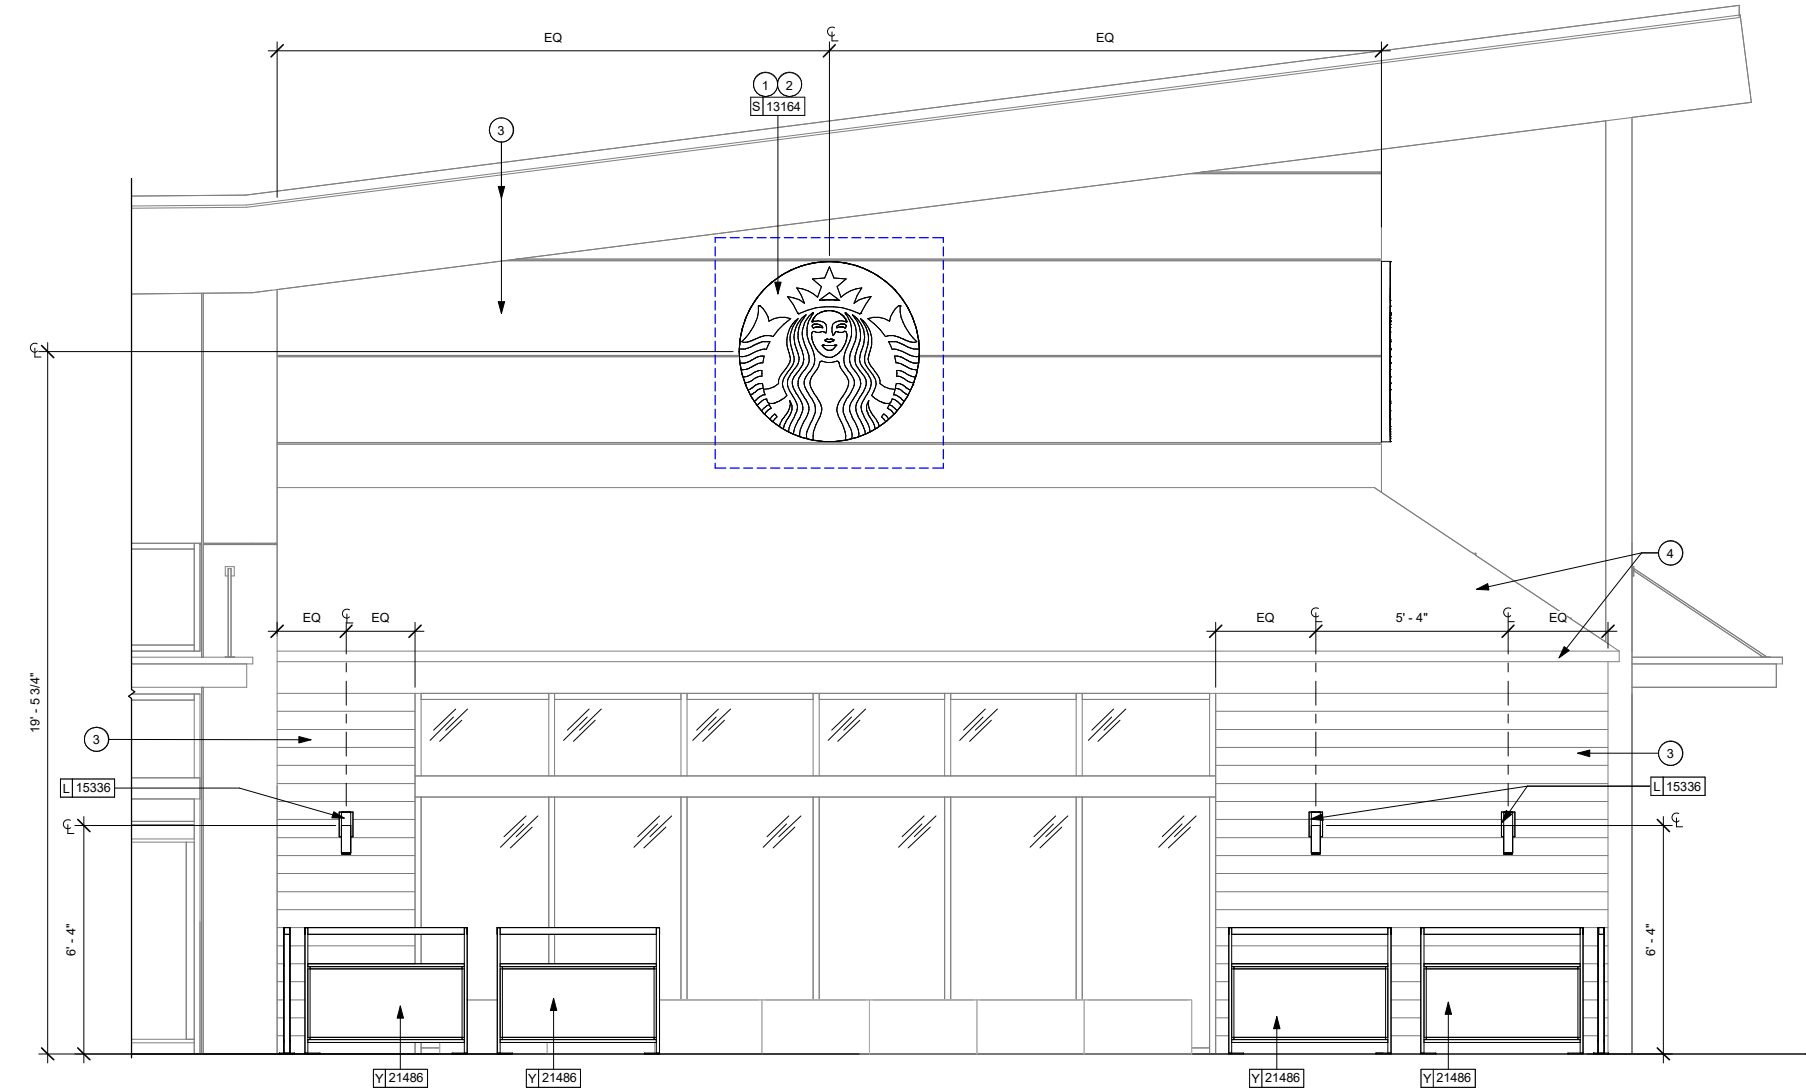

1 STOREFRONT ELEVATION A
Scale: 3/8" = 1'-0"

KEYED NOTES

- STARBUCKS DESIGN MANAGER TO COORDINATE SIGNAGE PROPOSAL WITH VENDOR.
- GENERAL CONTRACTOR TO PROVIDE 3/4" MARINE GRADE PLYWOOD BLOCKING FOR EXTERIOR SIGNAGE. EXTEND BLOCKING 8" (205MM) MIN. BEYOND EDGES OF SIGNAGE.
- EXISTING FINISH TO REMAIN.
- LICENSEE TO REFINISH ROOF AT STARBUCKS SPACE TO BE BLACK METAL FINISH.

GENERAL NOTES

- GENERAL CONTRACTOR TO COORDINATE AND SCHEDULE SIGNAGE INSTALLATION WITH THE SIGNAGE CONTRACTOR PROVIDING A MINIMUM SCHEDULING NOTICE OF 4 WEEKS AND 1 WEEK PRIOR TO SCHEDULED DATE OF INSTALLATION. STARBUCKS PROJECT DEVELOPMENT MANAGER TO PROVIDE GENERAL CONTRACTOR WITH SIGNAGE CONTRACTOR CONTACT INFORMATION.
- GENERAL CONTRACTOR SHALL COORDINATE WITH ELECTRICAL CONTRACTOR TO FURNISH AND INSTALL ELECTRICAL CIRCUITS INCLUDING ALL CONDUIT, WIRE, CONNECTIONS AND BREAKER AT PANEL BOARD NECESSARY TO SERVE SIGNAGE.
- GENERAL CONTRACTOR TO PROVIDE FIRE TREATED WOOD STUD BLOCKING OR EQUIVALENT TO SUPPORT SIGNAGE.
- SIGNAGE CONTRACTOR SHALL PROVIDE SHOP DRAWINGS TO STARBUCKS DESIGN MANAGER AND LICENSEE FOR APPROVALS PRIOR TO FABRICATION.
- SIGNAGE CONTRACTOR SHALL OBTAIN PERMIT(S) AND INSTALL SIGNAGE IN COMPLIANCE WITH LOCAL CODES.
- SIGNAGE CONTRACTOR TO PROVIDE FINAL APPROVED SHOP DRAWINGS TO THE LICENSEE. STARBUCKS DESIGN MANAGER, AND ARCHITECT OF RECORD AS NEEDED. GENERAL CONTRACTOR TO NOTIFY ARCHITECT OF RECORD AND STARBUCKS PROJECT DEVELOPMENT MANAGER IMMEDIATELY IF SHOP DRAWINGS OR INSTALLATION IS IN DISCREPANCY WITH ARCHITECTURAL DRAWINGS.
- GENERAL CONTRACTOR TO CLEAN, PATCH AND REPAIR EXISTING BUILDING EXTERIOR AS REQUIRED.

LICENSED STORES RESPONSIBILITY LEGEND

- SB - STARBUCKS
FC - STARBUCKS FIXTURE CONTRACTOR
LC - LICENSEE
GC - LICENSEE'S GENERAL CONTRACTOR

ALL SIGNAGE SUPPLIED AND INSTALLED UNDER SEPARATE PERMIT.

LEGEND

- INDICATES WALL BLOCKING. FIRE TREATED WALL BLOCKING TO BE PROVIDED AS REQUIRED TO SUPPORT WALL ATTACHMENTS. EXTEND BLOCKING 4" (100mm) BEYOND EDGE OF ATTACHMENTS.

DESIGN DEVELOPMENT ONLY - NOT INTENDED FOR CONSTRUCTION USE



STARBUCKS®
2401 UTAH AVENUE SOUTH
SEATTLE, WASHINGTON 98134
(206) 318-1575

THESE DRAWINGS AND THE PROJECT MANUAL ARE CONFIDENTIAL AND SHALL REMAIN THE SOLE PROPERTY OF STARBUCKS CORPORATION, WHICH IS THE OWNER OF THE COPYRIGHT IN THIS WORK. THEY SHALL NOT BE REPRODUCED (IN WHOLE OR IN PART), SHARED WITH THIRD PARTIES OR USED IN ANY MANNER ON OTHER PROJECTS OR EXTENSIONS TO THIS PROJECT WITHOUT THE PRIOR WRITTEN CONSENT OF STARBUCKS CORPORATION. THESE DRAWINGS AND SPECIFICATIONS ARE INTENDED TO EXPRESS DESIGN INTENT FOR A PROTOTYPICAL STARBUCKS STORE (WHICH IS SUBJECT TO CHANGE AT ANYTIME) AND DO NOT REFLECT ACTUAL SITE CONDITIONS. NEITHER PARTY SHALL HAVE ANY OBLIGATION NOR LIABILITY TO THE OTHER (EXCEPT STATED ABOVE) UNTIL A WRITTEN AGREEMENT IS FULLY EXECUTED BY BOTH PARTIES.

STARBUCKS TEMPLATE VERSION I2025.08.27

ARCHITECT OF RECORD

THIS DRAWING IS A DESIGN DEVELOPMENT DOCUMENT. SITE SPECIFIC MODIFICATIONS MADE UNDER THE RESPONSIBLE CHARGE OF THE ARCHITECT AND/OR ENGINEER-OF-RECORD WILL BE REQUIRED PRIOR TO USING THIS DOCUMENT FOR BIDDING, PERMITTING, OR CONSTRUCTION.

PROJECT NAME:
TA CORDELE

PROJECT ADDRESS:
397 ROCKHOUSE RD E
CORDELE, GA 31015

STORE #: TBD
PROJECT #: 108648-001
ISSUE DATE: 12/03/2025
DESIGN MANAGER: MANDY KENT
PRODUCTION DESIGNER: MAV
CHECKED BY: E. NORRIS

Revision Schedule

Rev	Date	By	Description

SHEET TITLE:
BUILDING EXTERIOR ELEVATIONS
SCALE: AS SHOWN

SHEET NUMBER:
A201



THESE DRAWINGS AND THE PROJECT MANUAL ARE CONFIDENTIAL AND SHALL REMAIN THE SOLE PROPERTY OF STARBUCKS CORPORATION, WHICH IS THE OWNER OF THE COPYRIGHT IN THIS WORK. THEY SHALL NOT BE REPRODUCED (IN WHOLE OR IN PART), SHARED WITH THIRD PARTIES OR USED IN ANY MANNER ON OTHER PROJECTS OR EXTENSIONS TO THIS PROJECT WITHOUT THE PRIOR WRITTEN CONSENT OF STARBUCKS CORPORATION. THESE DRAWINGS AND SPECIFICATIONS ARE INTENDED TO EXPRESS DESIGN INTENT FOR A PROTOTYPICAL STARBUCKS STORE (WHICH IS SUBJECT TO CHANGE AT ANYTIME) AND DO NOT REFLECT ACTUAL SITE CONDITIONS. NEITHER PARTY SHALL BE RESPONSIBLE FOR LIABILITY TO THE OTHER (EXCEPT STATED ABOVE) UNTIL A WRITTEN AGREEMENT IS FULLY EXECUTED BY BOTH PARTIES.

STARBUCKS TEMPLATE VERSION ||2025.08.27

ARCHITECT OF RECORD

THIS DRAWING IS A DESIGN
DEVELOPMENT DOCUMENT.
SITE SPECIFIC MODIFICATIONS
MADE UNDER THE RESPONSIBLE
CHARGE OF THE ARCHITECT
AND/OR ENGINEER-OF-RECORD
WILL BE REQUIRED PRIOR TO
USING THIS DOCUMENT FOR
BIDDING, PERMITTING, OR
CONSTRUCTION.

PROJECT NAME:
TA CORD

PROJECT ADDRESS:
397 ROCKHOUSE RD E
CORDELE, GA 31015

STORE #:	TBD
PROJECT #:	108648-001
ISSUE DATE:	12/03/2025
DESIGN MANAGER:	MANDY KENT
PRODUCTION DESIGNER:	MAV
CHECKED BY:	E. NORRIS

Revision Schedule			
Rev	Date	By	Description

SHEET TITLE:
**BUILDING EXTERIOR
ELEVATIONS**


SHEET NUMBER: A202

1. STARBUCKS DESIGN MANAGER TO COORDINATE SIGNAGE PROPOSAL WITH VENDOR.
2. GENERAL CONTRACTOR TO PROVIDE 3/4" MARINE GRADE PLYWOOD BLOCKING FOR EXTERIOR SIGNAGE. EXTEND BLOCKING 8" (205MM) MIN. BEYOND EDGES OF SIGNAGE.
3. EXISTING FINISH TO REMAIN.
4. LICENSEE TO REFINISH ROOF AT STARBUCKS SPACE TO BE BLACK METAL FINISH.

- A. GENERAL CONTRACTOR TO COORDINATE AND SCHEDULE SIGNAGE INSTALLATION WITH THE SIGNAGE CONTRACTOR PROVIDING A MINIMUM SCHEDULING NOTICE OF 4 WEEKS AND 1 WEEK PRIOR TO SCHEDULED DATE OF INSTALLATION. STARBUCKS PROJECT DEVELOPMENT MANAGER TO PROVIDE GENERAL CONTRACTOR WITH SIGNAGE CONTRACTOR CONTACT INFORMATION.
- B. GENERAL CONTRACTOR SHALL COORDINATE WITH ELECTRICAL CONTRACTOR TO FURNISH AND INSTALL ELECTRICAL CIRCUITS INCLUDING ALL CONDUIT, WIRE, CONNECTIONS AND BREAKER AT PANEL BOARD NECESSARY TO SERVE SIGNAGE.
- C. GENERAL CONTRACTOR TO PROVIDE FIRE TREATED WOOD STUD BLOCKING OR EQUIVALENT TO SUPPORT SIGNAGE.
- D. SIGNAGE CONTRACTOR SHALL PROVIDE SHOP DRAWINGS TO STARBUCKS DESIGN MANAGER AND LICENSEE FOR APPROVALS PRIOR TO FABRICATION.
- E. SIGNAGE CONTRACTOR SHALL OBTAIN PERMIT(S) AND INSTALL SIGNAGE IN COMPLIANCE WITH LOCAL CODES.
- F. SIGNAGE CONTRACTOR TO PROVIDE FINAL APPROVED SHOP DRAWINGS TO THE LICENSEE, STARBUCKS DESIGN MANAGER, AND ARCHITECT OF RECORD AS NEEDED. GENERAL CONTRACTOR TO NOTIFY ARCHITECT OF RECORD AND STARBUCKS PROJECT DEVELOPMENT MANAGER IMMEDIATELY IF SHOP DRAWINGS OR INSTALLATION IS IN DISCREPANCY WITH ARCHITECTURAL DRAWINGS.
- G. GENERAL CONTRACTOR TO CLEAN, PATCH AND REPAIR EXISTING BUILDING EXTERIOR AS REQUIRED.


INDICATES WALL BLOCKING.
FIRE TREATED WALL BLOCKING TO BE
PROVIDED AS REQUIRED TO SUPPORT WALL
ATTACHMENTS. EXTEND BLOCKING 4" (100mm)
BEYOND EDGE OF ATTACHMENTS.

ALL SIGNAGE SUPPLIED AND INSTALLED
UNDER SEPARATE PERMIT.

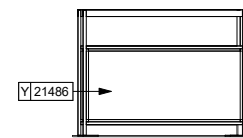


1 STOREFRONT ELEVATION B
Scale: 3/8" = 1'-0"

Scale: $\frac{3}{8}'' = 1'-0''$

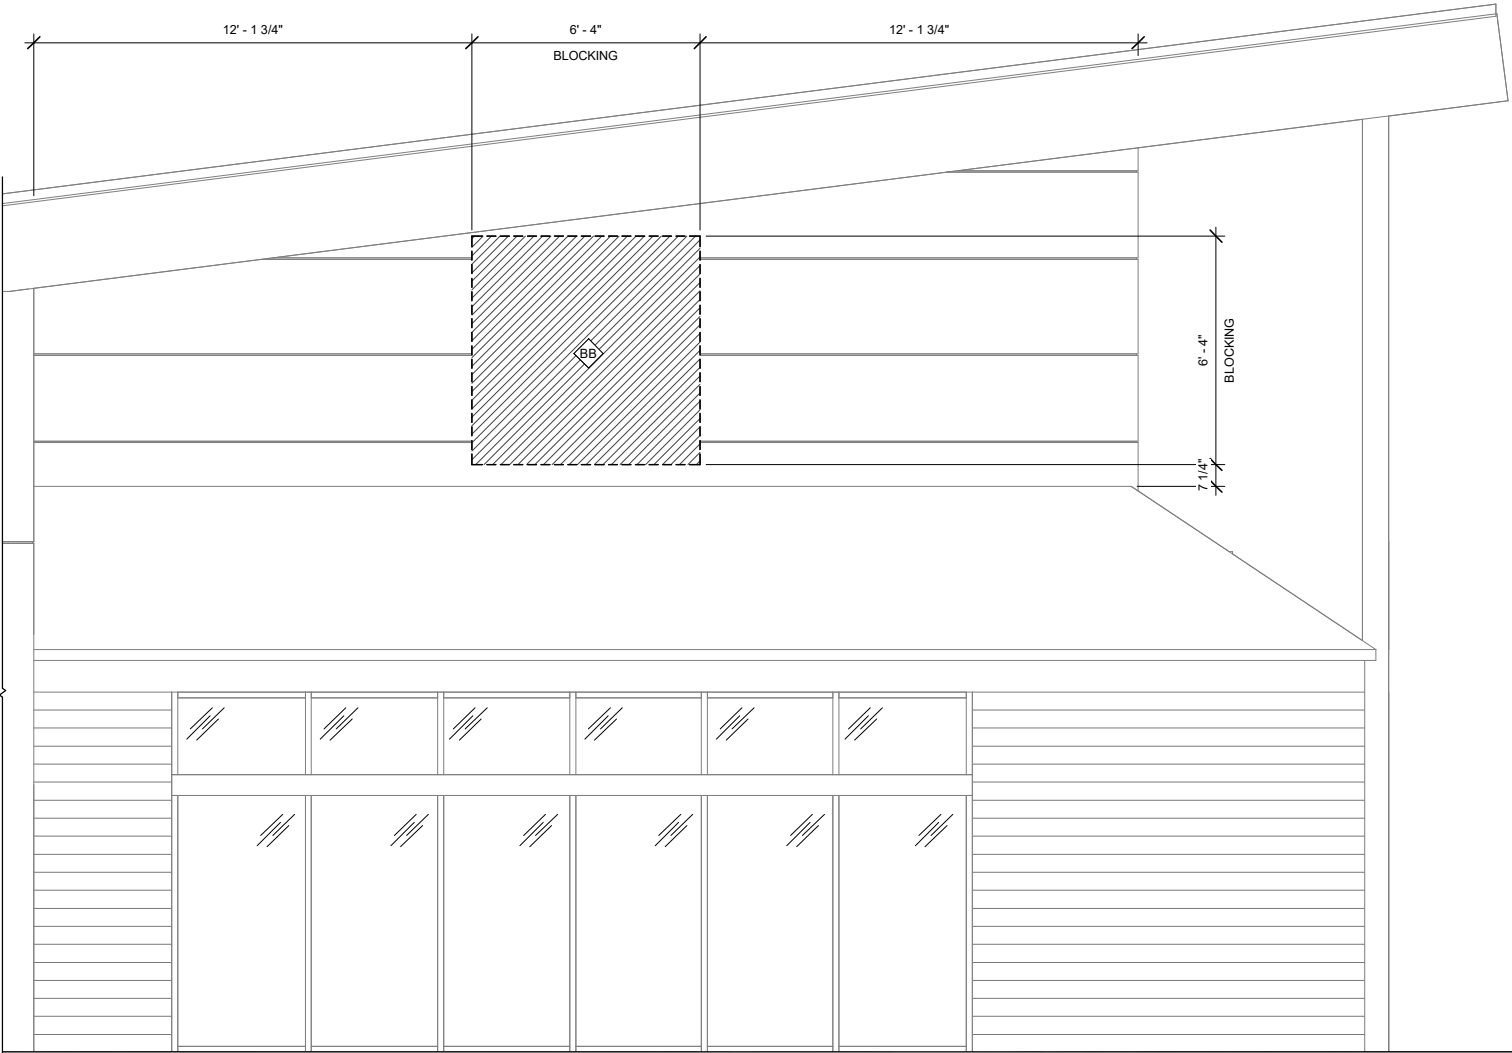

1 STOREFRONT ELEVATION A (BLOCKING)
Scale: 3/8" = 1'-0"

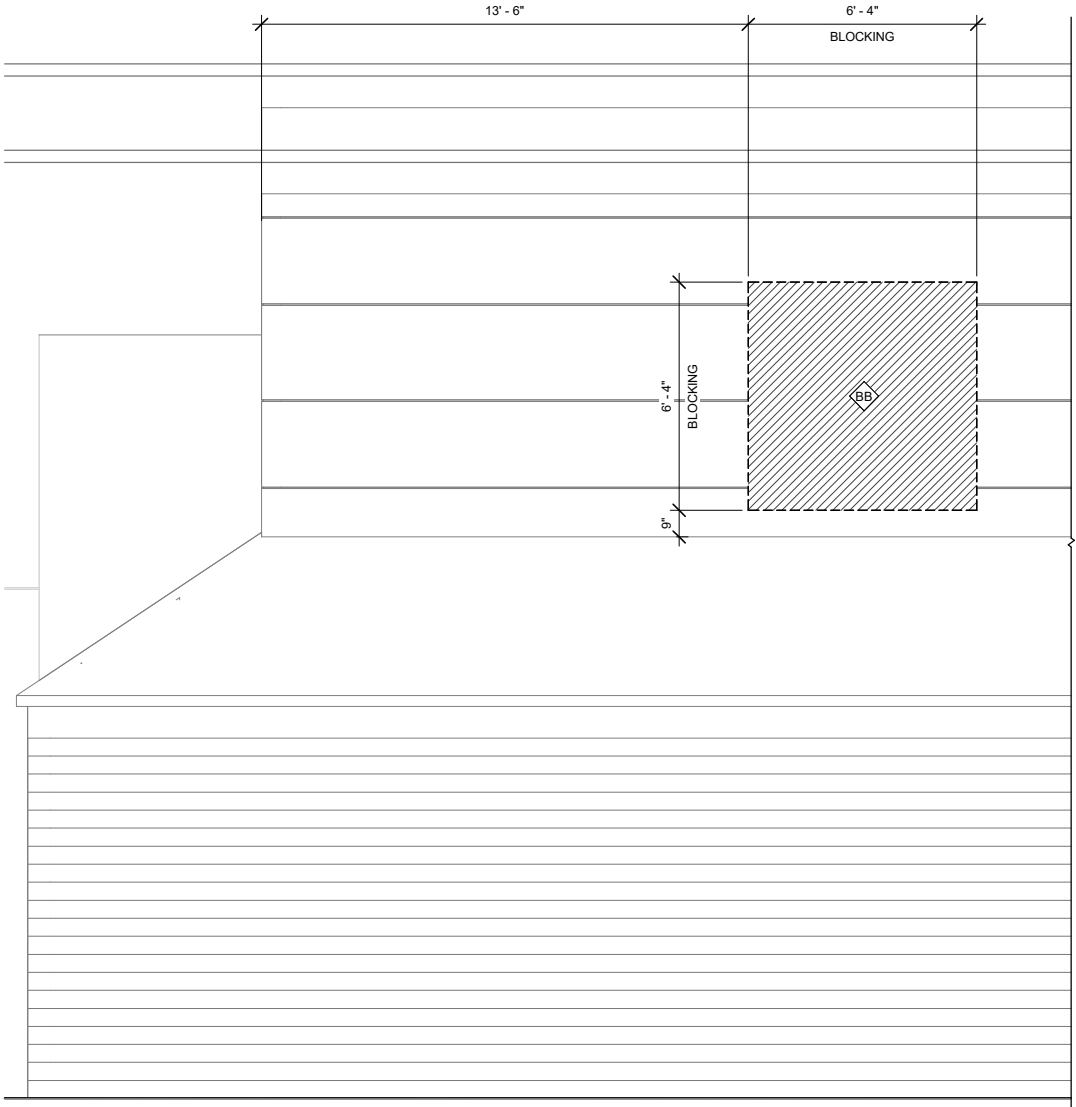

2 STOREFRONT ELEVATION B (BLOCKING)
Scale: 3/8" = 1'-0"

WALL BLOCKING LEGEND

SYMBOL	ITEM	WEIGHT	HEIGHT AFF	APPROX. WIDTH
AA	WOOD PORTALS	AOR TO VERIFY	SEE BLOCKING ELEVATION	SEE BLOCKING ELEVATION
BB	LOGO SIGN	AOR TO VERIFY	SEE BLOCKING ELEVATION	SEE BLOCKING ELEVATION
CC	ARTWORK	AOR TO VERIFY	SEE BLOCKING ELEVATION	SEE BLOCKING ELEVATION
DD	ORDER STATUS BOARD	AOR TO VERIFY	3' - 9" TO 8' - 6"	3' - 2"
EE	CBE SHELVES	300 LBS	4' - 6" TO 5' - 6"	5' - 6"
FF	DIGITAL MENUS	AOR TO VERIFY	6' - 1" TO 9' - 2"	12' - 0"
GG	MERCHANDISE	AOR TO VERIFY	5' - 4" TO 6' - 8"	5' - 3"
HH	BANQUETTE	AOR TO VERIFY	SEE BLOCKING ELEVATION	SEE BLOCKING ELEVATION

SYMBOL	ITEM	WEIGHT	HEIGHT AFF	APPROX. WIDTH
JJ	WORKROOM HAND SINK, SOAP AND PAPER TOWEL DISPENSER	128 LBS (58 KG)	2' - 0" TO 5' - 4"	2' - 11"
KK	SHELVES ABOVE 3-COMP SINK	200 LBS (91 KG)	3' - 8" TO 6' - 10"	8' - 5"
LL	SPC CABINET	AOR TO VERIFY	3' - 0" TO 5' - 10"	2' - 7"
MM	MANAGER DESK	300 LBS (136 KG)	2' - 8" TO 8' - 0"	6' - 3"
NN	WATER FILTRATION SYSTEM	AOR TO VERIFY	0' - 0" TO 9' - 0"	8' - 11"

PROVIDE FIRE TREATED 2X6 OR 2X8 WOOD STUD BLOCKING AS REQUIRED TO SUPPORT ANY WALL ATTACHMENTS.

REFER TO SHEETS A401 FOR LOCATIONS OF BLOCKING, MOUNTING HEIGHTS, AND EXTEND OF BLOCKING SURFACES.

DESIGN DEVELOPMENT ONLY - NOT INTENDED FOR CONSTRUCTION USE



© 2025 STARBUCKS COFFEE COMPANY

STARBUCKS®
2401 UTAH AVENUE SOUTH
SEATTLE, WASHINGTON 98134
(206) 318-1575

THESE DRAWINGS AND THE PROJECT MANUAL ARE CONFIDENTIAL AND SHALL REMAIN THE SOLE PROPERTY OF STARBUCKS CORPORATION, WHICH IS THE OWNER OF THE COPYRIGHT IN THIS WORK. THEY SHALL NOT BE REPRODUCED (IN WHOLE OR IN PART), SHARED WITH THIRD PARTIES OR USED IN ANY MANNER ON OTHER PROJECTS OR EXTENSIONS TO THIS PROJECT WITHOUT THE PRIOR WRITTEN CONSENT OF STARBUCKS CORPORATION. THESE DRAWINGS AND SPECIFICATIONS ARE INTENDED TO EXPRESS DESIGN INTENT FOR A PROTOTYPICAL STARBUCKS STORE (WHICH IS SUBJECT TO CHANGE AT ANYTIME) AND DO NOT REFLECT ACTUAL SITE CONDITIONS. NEITHER PARTY SHALL HAVE ANY OBLIGATION NOR LIABILITY TO THE OTHER (EXCEPT STATED ABOVE) UNTIL A WRITTEN AGREEMENT IS FULLY EXECUTED BY BOTH PARTIES.

STARBUCKS TEMPLATE VERSION I2025.08.27

ARCHITECT OF RECORD
THIS DRAWING IS A DESIGN DEVELOPMENT DOCUMENT. SITE SPECIFIC MODIFICATIONS MADE UNDER THE RESPONSIBLE CHARGE OF THE ARCHITECT AND/OR ENGINEER-OF-RECORD WILL BE REQUIRED PRIOR TO USING THIS DOCUMENT FOR BIDDING, PERMITTING, OR CONSTRUCTION.

PROJECT NAME:
TA CORDELE

PROJECT ADDRESS:
**397 ROCKHOUSE RD E
CORDELE, GA 31015**






STORE #: TBD
PROJECT #: 108648-001
ISSUE DATE: 12/03/2025
DESIGN MANAGER: MANDY KENT
PRODUCTION DESIGNER: MAV
CHECKED BY: E. NORRIS

Revision Schedule			
Rev	Date	By	Description

SHEET TITLE:
BLOCKING ELEVATIONS

SCALE: AS SHOWN

SHEET NUMBER:
A401

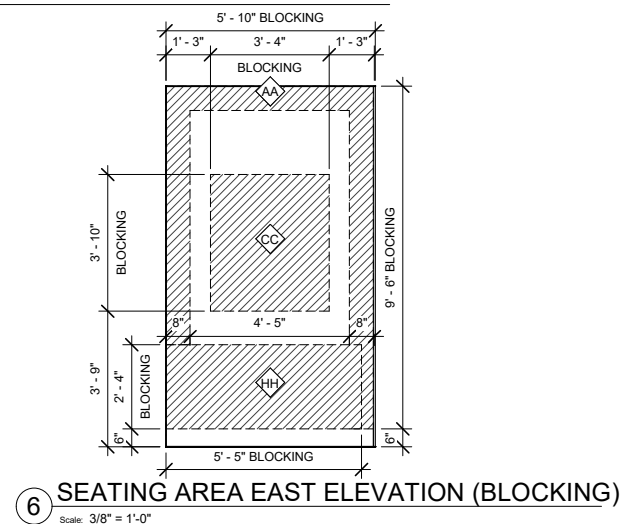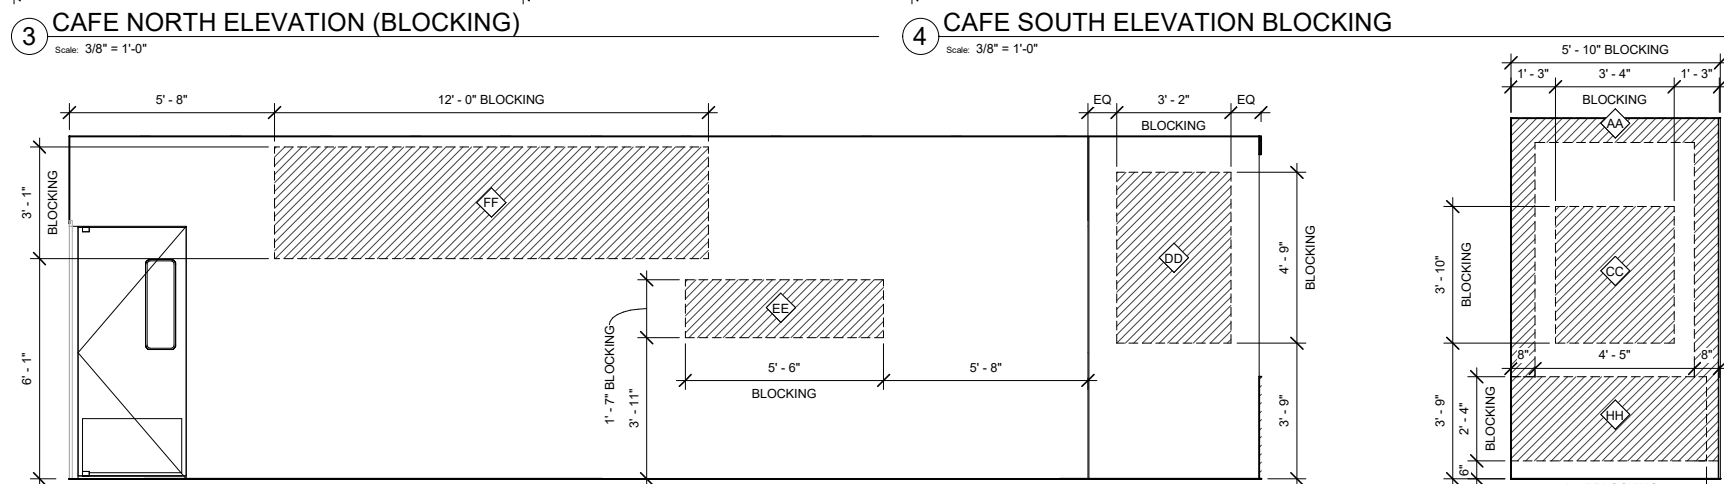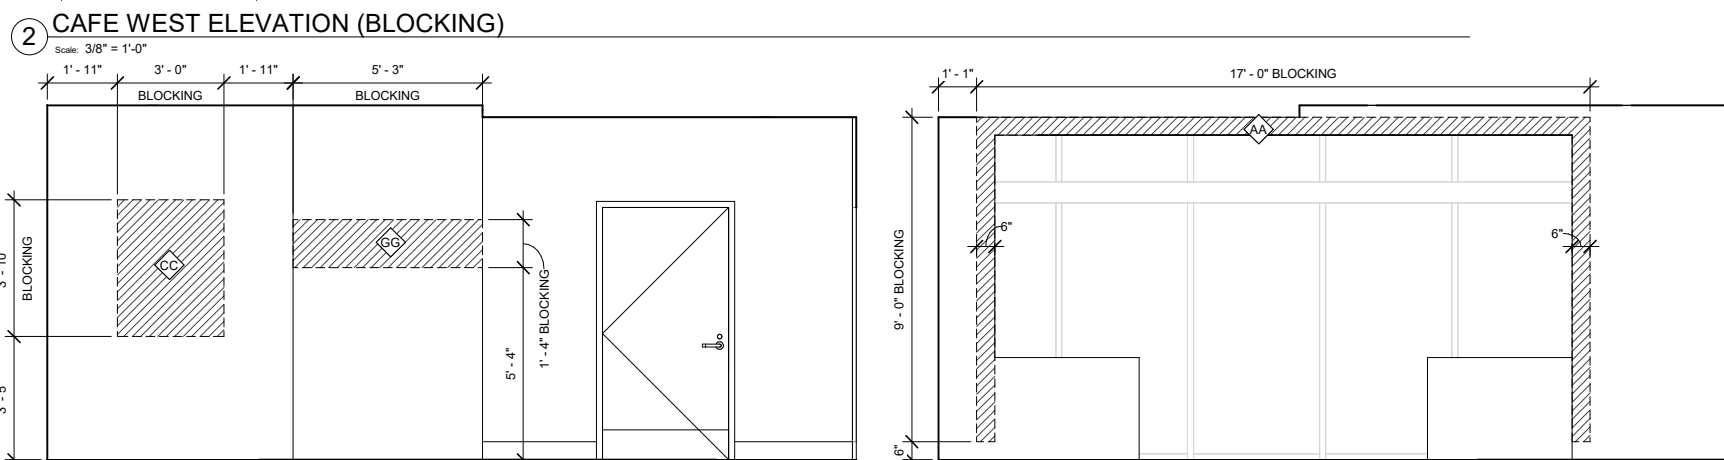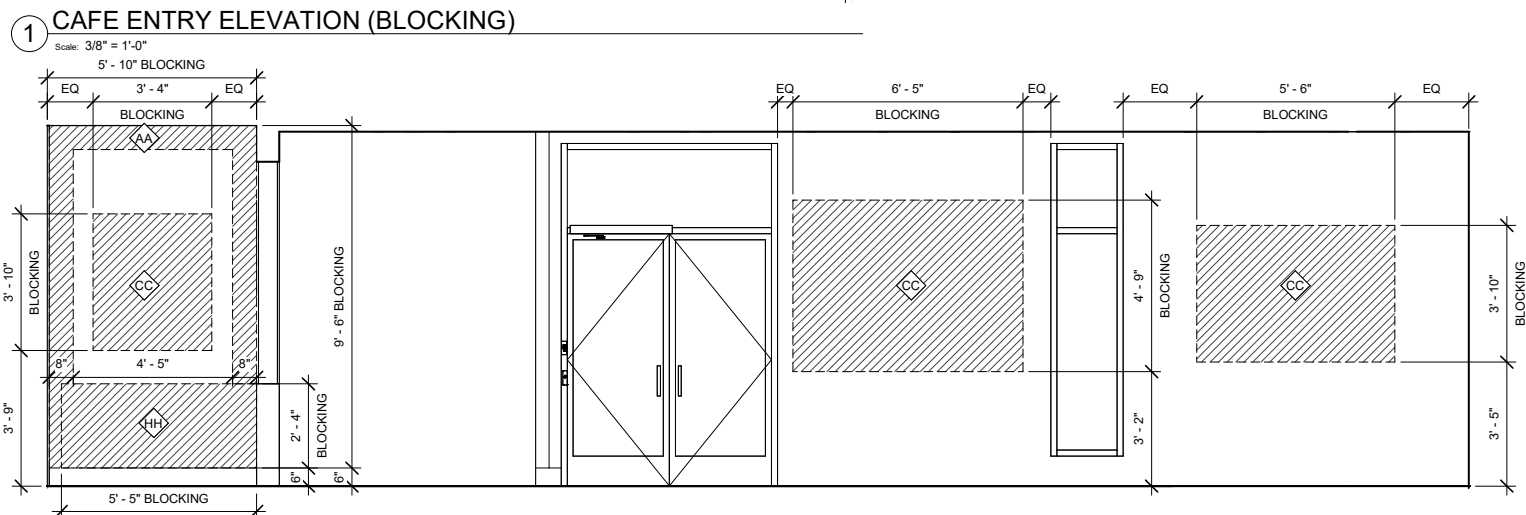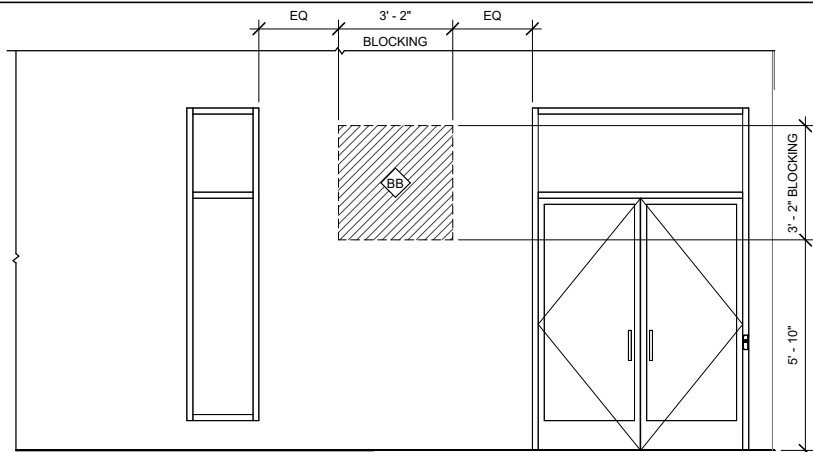

WALL BLOCKING LEGEND

SYMBOL	ITEM	WEIGHT	HEIGHT AFF	APPROX. WIDTH
AA	WOOD PORTALS	AOR TO VERIFY	SEE BLOCKING ELEVATION	SEE BLOCKING ELEVATION
BB	LOGO SIGN	AOR TO VERIFY	SEE BLOCKING ELEVATION	SEE BLOCKING ELEVATION
CC	ARTWORK	AOR TO VERIFY	SEE BLOCKING ELEVATION	SEE BLOCKING ELEVATION
DD	ORDER STATUS BOARD	AOR TO VERIFY	3' - 9" TO 8' - 6"	3' - 2"
EE	CBE SHELVES	300 LBS	3' - 11" TO 5' - 6"	5' - 6"
FF	DIGITAL MENUS	AOR TO VERIFY	6' - 1" TO 9' - 2"	12' - 0"
GG	MERCHANDISE	AOR TO VERIFY	5' - 4" TO 6' - 8"	5' - 3"
HH	BANQUETTE	AOR TO VERIFY	SEE BLOCKING ELEVATION	SEE BLOCKING ELEVATION
JJ	WORKROOM HAND SINK, SOAP AND PAPER TOWEL DISPENSER	128 LBS (58 KG)	2' - 0" TO 5' - 4"	2' - 11"
KK	SHELVES ABOVE 3-COMP SINK	200 LBS (91 KG)	3' - 8" TO 6' - 10"	8' - 5"
LL	SPC CABINET	AOR TO VERIFY	3' - 0" TO 5' - 10"	2' - 7"
MM	MANAGER DESK	300 LBS (136 KG)	2' - 8" TO 8' - 0"	6' - 3"
NN	WATER FILTRATION SYSTEM	AOR TO VERIFY	0' - 0" TO 9' - 0"	8' - 11"

PROVIDE FIRE TREATED 2X6 OR 2X8 WOOD STUD BLOCKING AS REQUIRED TO SUPPORT ANY WALL ATTACHMENTS.

REFER TO SHEETS A401 FOR LOCATIONS OF BLOCKING, MOUNTING HEIGHTS, AND
EXTEND OF BLOCKING SURFACES.



STARBUCKS®
2401 UTAH AVENUE SOUTH
SEATTLE, WASHINGTON 98134
(206) 318-1575

THESE DRAWINGS AND THE PROJECT MANUAL ARE CONFIDENTIAL AND SHALL REMAIN THE SOLE PROPERTY OF STARBUCKS CORPORATION, WHICH IS THE OWNER OF THE COPYRIGHT IN THIS WORK. THEY SHALL NOT BE REPRODUCED (IN WHOLE OR IN PART), SHARED WITH THIRD PARTIES OR USED IN ANY MANNER OTHER THAN THE PROJECTS OR EXTENSIONS TO THIS PROJECT WITHOUT THE PRIOR WRITTEN CONSENT OF STARBUCKS CORPORATION. THESE DRAWINGS AND SPECIFICATIONS ARE INTENDED TO EXPRESS DESIGN INTENT FOR A PROTOTYPICAL STARBUCKS STORE (WHICH IS SUBJECT TO CHANGE AT ANYTIME) AND DO NOT REFLECT ACTUAL SITE CONDITIONS. NEITHER PARTY SHALL BE RESPONSIBLE FOR THE ACCURACY TO THE OTHER (EXCEPT STATED ABOVE) UNTIL A WRITTEN AGREEMENT IS FULLY EXECUTED BY BOTH PARTIES.

STARBUCKS TEMPLATE VERSION li2025.08.27

ARCHITECT OF RECORD

THIS DRAWING IS A DESIGN
DEVELOPMENT DOCUMENT.
SITE SPECIFIC MODIFICATIONS
MADE UNDER THE RESPONSIBLE
CHARGE OF THE ARCHITECT
AND/OR ENGINEER-OF-RECORD
WILL BE REQUIRED PRIOR TO
USING THIS DOCUMENT FOR
BIDDING, PERMITTING, OR
CONSTRUCTION.

PROJECT NAME:
TA CORDELE

PROJECT ADDRESS:
397 ROCKHOUSE RD E
CORDELE, GA 31015

STORE #:	TBD
PROJECT #:	108648-001
ISSUE DATE:	12/03/2025
DESIGN MANAGER:	MANDY KENT
PRODUCTION DESIGNER:	MAV
CHECKED BY:	E. NORRIS


Revision Schedule			
Rev	Date	By	Description

SHEET TITLE:
BLOCKING ELEVATIONS

SCALE: AS SHOWN


SHEET NUMBER: A402

DESIGN DEVELOPMENT ONLY - NOT INTENDED FOR CONSTRUCTION USE

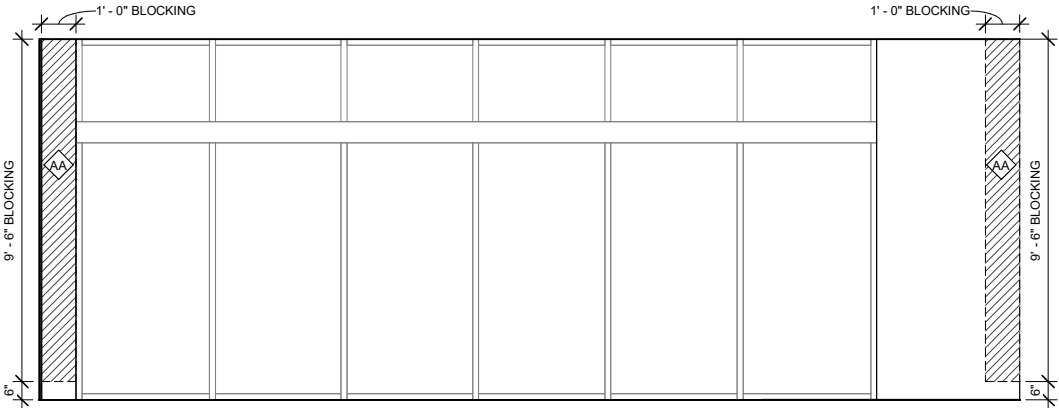


1 SEATING AREA SOUTH ELEVATION (BLOCKING)

Scale: 3/8" = 1'-0"

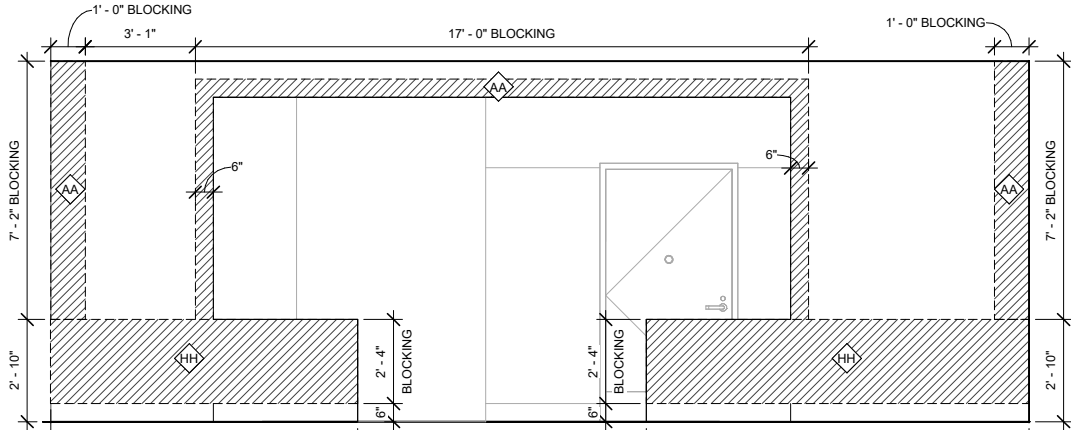


2 SEATING AREA NORTH ELEVATION (BLOCKING)

Scale: 3/8" = 1'-0"

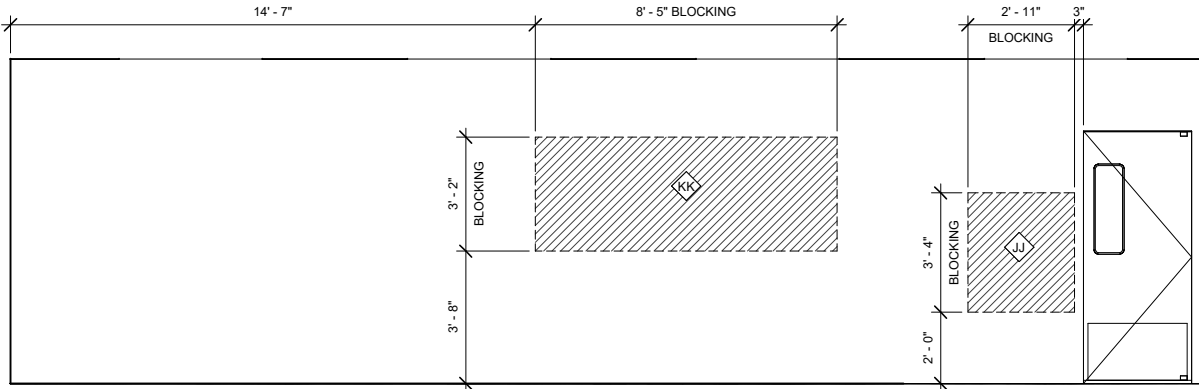


3 WORKROOM WEST ELEVATION A ((BLOCKING)

Scale: 3/8" = 1'-0"

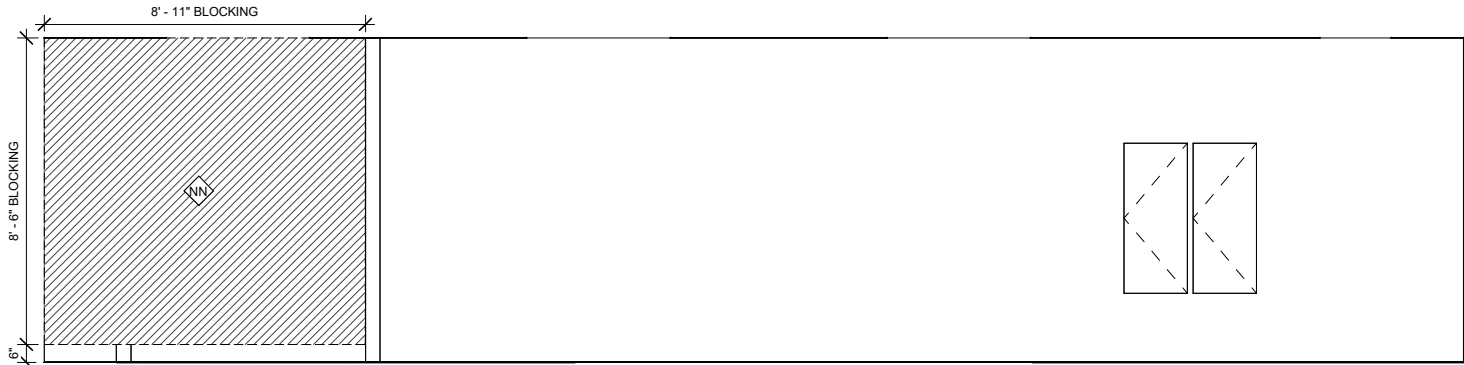

4 WORKROOM EAST ELEVATION B (BLOCKING)

Scale: 3/8" = 1'-0"

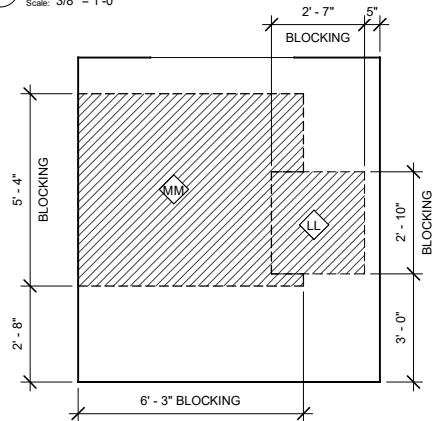

5 MGR'S DESK ELEVATION (BLOCKING)

Scale: 3/8" = 1'-0"

WALL BLOCKING LEGEND

SYMBOL	ITEM	WEIGHT	HEIGHT AFF	APPROX. WIDTH
AA	WOOD PORTALS	AOR TO VERIFY	SEE BLOCKING ELEVATION	SEE BLOCKING ELEVATION
BB	LOGO SIGN	AOR TO VERIFY	SEE BLOCKING ELEVATION	SEE BLOCKING ELEVATION
CC	ARTWORK	AOR TO VERIFY	SEE BLOCKING ELEVATION	SEE BLOCKING ELEVATION
DD	ORDER STATUS BOARD	AOR TO VERIFY	3' - 9" TO 8' - 6"	3' - 2"
EE	CBE SHELVES	300 LBS	3' - 11" TO 5' - 6"	5' - 6"
FF	DIGITAL MENUS	AOR TO VERIFY	6' - 1" TO 9' - 2"	12' - 0"
GG	MERCHANDISE	AOR TO VERIFY	5' - 4" TO 6' - 8"	5' - 3"
HH	BANQUETTE	AOR TO VERIFY	SEE BLOCKING ELEVATION	SEE BLOCKING ELEVATION
JJ	WORKROOM HAND SINK, SOAP AND PAPER TOWEL DISPENSER	128 LBS (58 KG)	2' - 0" TO 5' - 4"	2' - 11"
KK	SHELVES ABOVE 3-COMP SINK	200 LBS (91 KG)	3' - 8" TO 6' - 10"	8' - 5"
LL	SPC CABINET	AOR TO VERIFY	3' - 0" TO 5' - 10"	2' - 7"
MM	MANAGER DESK	300 LBS (136 KG)	2' - 8" TO 8' - 0"	6' - 3"
NN	WATER FILTRATION SYSTEM	AOR TO VERIFY	0' - 0" TO 9' - 0"	8' - 11"

PROVIDE FIRE TREATED 2X6 OR 2X8 WOOD STUD BLOCKING AS REQUIRED TO SUPPORT ANY WALL ATTACHMENTS.

REFER TO SHEETS A401 FOR LOCATIONS OF BLOCKING, MOUNTING HEIGHTS, AND EXTEND OF BLOCKING SURFACES.

DESIGN DEVELOPMENT ONLY - NOT INTENDED FOR CONSTRUCTION USE



STARBUCKS®
2401 UTAH AVENUE SOUTH
SEATTLE, WASHINGTON 98134
(206) 318-1575

THESE DRAWINGS AND THE PROJECT MANUAL ARE CONFIDENTIAL AND SHALL REMAIN THE SOLE PROPERTY OF STARBUCKS CORPORATION, WHICH IS THE OWNER OF THE COPYRIGHT IN THIS WORK. THEY SHALL NOT BE REPRODUCED (IN WHOLE OR IN PART), SHARED WITH THIRD PARTIES OR USED IN ANY MANNER ON OTHER PROJECTS OR EXTENSIONS TO THIS PROJECT WITHOUT THE PRIOR WRITTEN CONSENT OF STARBUCKS CORPORATION. THESE DRAWINGS AND SPECIFICATIONS ARE INTENDED TO EXPRESS DESIGN INTENT FOR A PROTOTYPICAL STARBUCKS STORE (WHICH IS SUBJECT TO CHANGE AT ANYTIME) AND DO NOT REFLECT ACTUAL SITE CONDITIONS. NEITHER PARTY SHALL HAVE ANY OBLIGATION NOR LIABILITY TO THE OTHER (EXCEPT STATED ABOVE) UNTIL A WRITTEN AGREEMENT IS FULLY EXECUTED BY BOTH PARTIES.

STARBUCKS TEMPLATE VERSION I2025.08.27

ARCHITECT OF RECORD

THIS DRAWING IS A DESIGN DEVELOPMENT DOCUMENT. SITE SPECIFIC MODIFICATIONS MADE UNDER THE RESPONSIBLE CHARGE OF THE ARCHITECT AND/OR ENGINEER-OF-RECORD WILL BE REQUIRED PRIOR TO USING THIS DOCUMENT FOR BIDDING, PERMITTING, OR CONSTRUCTION.

PROJECT NAME:

TA CORDELE

PROJECT ADDRESS:
397 ROCKHOUSE RD E
CORDELE, GA 31015

STORE #: TBD
PROJECT #: 108648-001
ISSUE DATE: 12/03/2025
DESIGN MANAGER: MANDY KENT
PRODUCTION DESIGNER: MAV
CHECKED BY: E. NORRIS

Revision Schedule

Rev	Date	By	Description



SHEET TITLE:

BLOCKING ELEVATIONS

SCALE: AS SHOWN

SHEET NUMBER:

A403

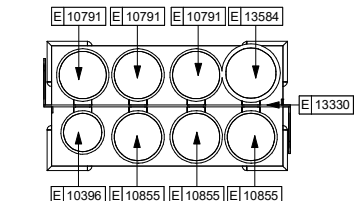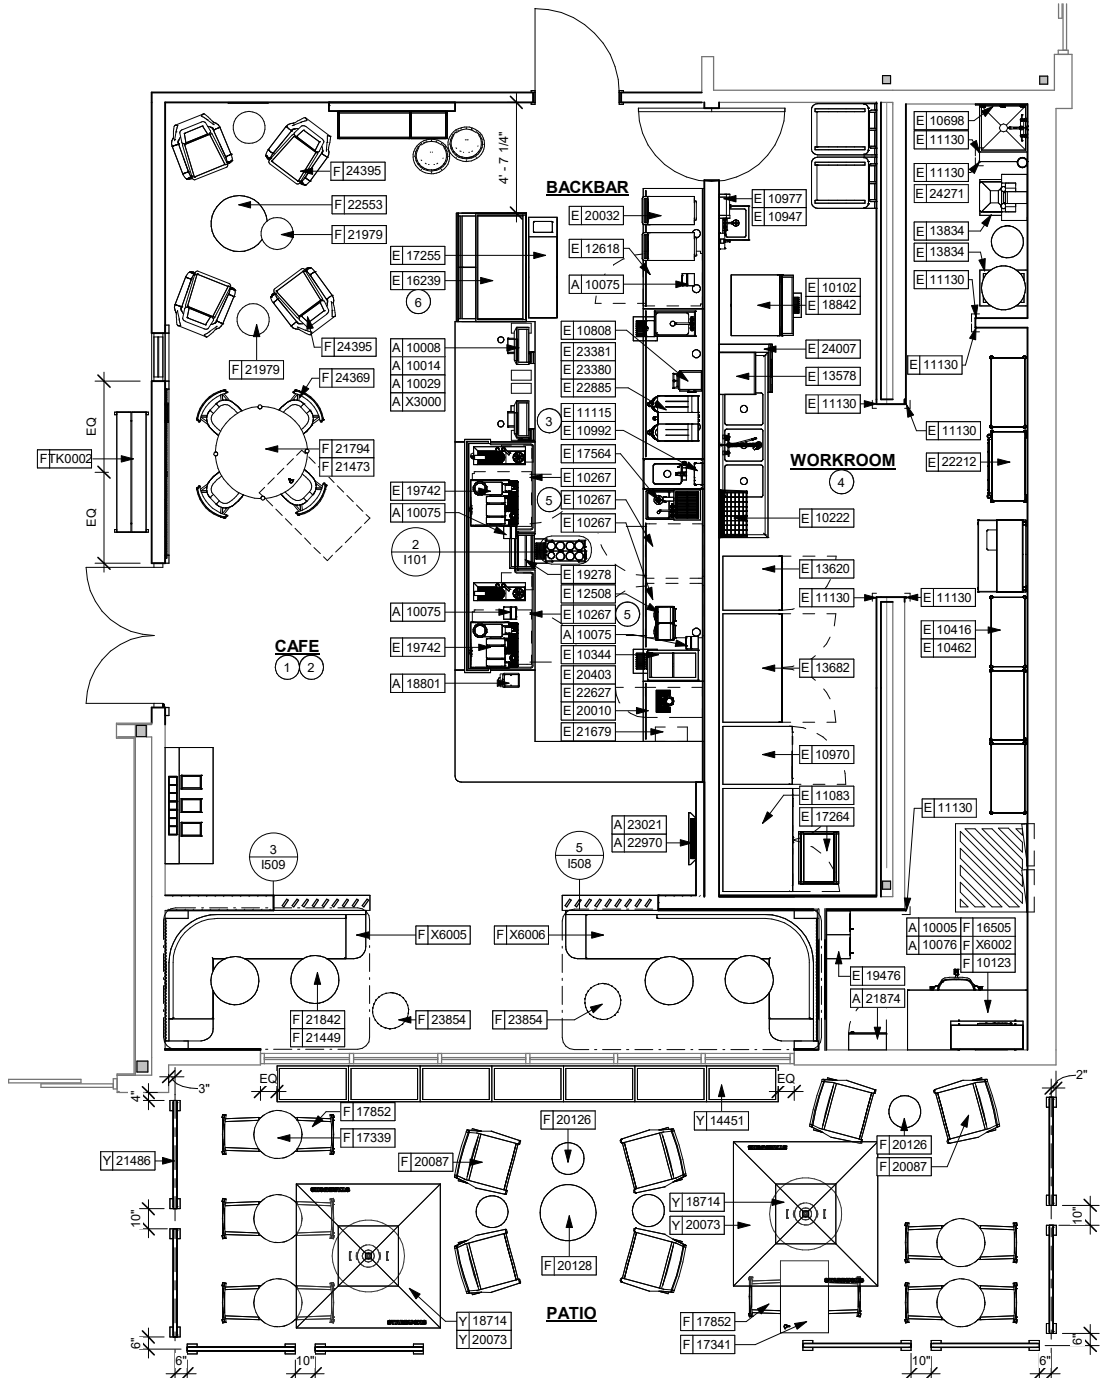

KEYED NOTES

1. INSTALL ALL FURNITURE THROUGHOUT AS SHOWN.
2. PLACE MERCHANDISE FIXTURES AND RETAIL FLOOR BASKETS PER PLAN. STORE OPERATORS TO ORDER RETAIL FLOOR BASKETS.
3. HAND SINK WITH INTEGRAL SPLASH GUARD.
4. INSTALL WALL CORNER GUARDS AS INDICATED. SEE INTERIOR FINISH ELEVATIONS.
5. GENERAL CONTRACTOR TO REVERSE HINGE ON U / C REFRIGERATOR TO LEFT HAND SWING AS SHOWN.
6. DO NOT BLOCK FOOD CASE INTAKE / EXHAUST.

GENERAL NOTES

- A. THE SITE IS SERVED BY THE MUNICIPAL WATER AND SEWER SYSTEM UNLESS OTHERWISE NOTED.
- B. ALL FLOOR AND WALL JUNCTIONS IN STORAGE AND PREP AREAS SHALL HAVE A COVED BASE.
- C. ALL FOOD STORAGE SHALL BE AT LEAST 6" (150MM) AFF.
- D. ALL WOOD SURFACES (DOORS, TRIM, SHELVES, CABINETS) SHALL BE SEALED.
- E. FLOORS, WALLS AND CEILING FINISHES IN FOOD PREP AREAS SHALL BE SMOOTH, NON-TOXIC, NON-ABSORBENT, DURABLE AND EASILY CLEANABLE. PAINT SHALL BE WASHABLE AND SEMI-GLOSS OR HIGH-GLOSS FINISH.
- F. ALL EQUIPMENT AND INSTALLATION WILL MEET NATIONAL SANITATION FOUNDATION STANDARDS OR EQUIVALENT.
- G. ALL EQUIPMENT AND CABINETRY WILL BE FLUSH MOUNTED TO COUNTERS, WALLS OR FLOORS, OR BE RAISED TO ALLOW FOR CLEANING.
- H. CONFIRM ALL NECESSARY EQUIPMENT CLEARANCES PER PRODUCT CUT SHEET (E.G. ICE MACHINE).
- I. FOR LOCATION OF COUNTERTOP EQUIPMENT, REFER TO CASEWORK ELECTRICAL DETAILS.
- J. EQUIPMENT UNITS SHALL CONTAIN NO EXPOSED THREADS, EMBELLISHMENTS OR OVERHANGING EDGES THAT SERVE AS PLACES FOR ACCUMULATION OF DUST, DIRT AND DEBRIS.
- K. EACH HAND WASHING SINK WILL HAVE A SINGLE SERVICE TOWEL AND SOAP DISPENSER, AND ALL HAND SINKS TO HAVE A COMBINATION FAUCET OR PREMIXING FAUCET.
- L. FOR PLUMBING FIXTURES, REFER TO THE PLUMBING DESIGN PLAN.



STARBUCKS®
2401 UTAH AVENUE SOUTH
SEATTLE, WASHINGTON 98134
(206) 318-1575

THESE DRAWINGS AND THE PROJECT MANUAL ARE CONFIDENTIAL AND SHALL REMAIN THE SOLE PROPERTY OF STARBUCKS CORPORATION, WHICH IS THE OWNER OF THE COPYRIGHT IN THIS WORK. THEY SHALL NOT BE REPRODUCED (IN WHOLE OR IN PART), SHARED WITH THIRD PARTIES OR USED IN ANY MANNER ON OTHER PROJECTS OR EXTENSIONS TO THIS PROJECT WITHOUT THE PRIOR WRITTEN CONSENT OF STARBUCKS CORPORATION. THESE DRAWINGS AND SPECIFICATIONS ARE INTENDED TO EXPRESS DESIGN INTENT FOR A PROTOTYPICAL STARBUCKS STORE (WHICH IS SUBJECT TO CHANGE AT ANYTIME) AND DO NOT REFLECT ACTUAL SITE CONDITIONS. NEITHER PARTY SHALL HAVE ANY OBLIGATION NOR LIABILITY TO THE OTHER (EXCEPT STATED ABOVE) UNTIL A WRITTEN AGREEMENT IS FULLY EXECUTED BY BOTH PARTIES.

STARBUCKS TEMPLATE VERSION I2025.08.27

ARCHITECT OF RECORD

THIS DRAWING IS A DESIGN DEVELOPMENT DOCUMENT. SITE SPECIFIC MODIFICATIONS MADE UNDER THE RESPONSIBLE CHARGE OF THE ARCHITECT AND/OR ENGINEER-OF-RECORD WILL BE REQUIRED PRIOR TO USING THIS DOCUMENT FOR BIDDING, PERMITTING, OR CONSTRUCTION.

PROJECT NAME:
TA CORDELE

PROJECT ADDRESS:
397 ROCKHOUSE RD E
CORDELE, GA 31015

STORE #: TBD
PROJECT #: 108648-001
ISSUE DATE: 12/03/2025
DESIGN MANAGER: MANDY KENT
PRODUCTION DESIGNER: MAV
CHECKED BY: E. NORRIS

Revision Schedule

Rev	Date	By	Description

SHEET TITLE:
FF & E PLAN

SCALE: AS SHOWN

SHEET NUMBER:

1101

DESIGN DEVELOPMENT ONLY - NOT INTENDED FOR CONSTRUCTION USE

SPECIALTY EQUIPMENT SCHEDULE - "E"					
DESIGN ID	COUNT	DESCRIPTION	FURN. BY	INST. BY	COMMENTS
COOLING					
10267	4	FRIDGE UNDERCOUNTER 1 DOOR - 27IN 685MM	SB	GC	
10970	1	FRIDGE REACH IN 1 DOOR LH - 29IN 735MM	SB	GC	
11083	1	FRIDGE REACH IN 2 DOOR - 51X35IN 1295X890MM	SB	GC	
12618	1	FRIDGE UNDERCOUNTER 1 DOOR WITH SHELF - 27IN 685MM	SB	GC	
13620	1	FREEZER REACH IN 1 DOOR LH - 27IN 685MM	SB	GC	
13682	1	FREEZER REACH IN 2 DOOR - 54IN 1370MM	SB	GC	
20010	1	FRIDGE NITRO 2 TAP JT NITCOM LH	SB	GC	KIT INCLUDES UNDERCOUNTER FRIDGE, FONT, TRAY, AND TUBING
EQUIPMENT					
10808	1	GRINDER DITTING KR1203	SB	GC	
12508	2	BLENDER QUIET MODEL ON COUNTER	SB	GC	
17564	1	BLENDER PITCHER RINSER WITH SENSOR	SB	GC	
19742	2	ESPRESSO MACHINE MASTRENA II	SB	GC	50 AMPS, 2-WIRE PLUS GROUND (L1, L2, AND G), NEMA 6-50 REEPTACLE WITHIN 4.5 FEET
20032	2	OVEN EIKON E2S - BLACK	SB	GC	
21679	1	NITROGEN GENERATOR ELEMENT COMPACT	SB	GC	
22885	1	BREWER CLOVER VERTICA DOUBLE	SB	GC	50 AMPS, 2-WIRE PLUS GROUND (L1, L2, AND G), NEMA 14-50R RECEPTACLE
23380	1	BREWER CLOVER VERTICA DOUBLE INSTALL KIT	SB	GC	
23381	1	BREWER CLOVER VERTICA DOUBLE POWER CORD	SB	GC	
24007	1	DISHWASHER LXNR ADVANSYS	SB	GC	
FOOD CASE					
16239	1	FOOD CASE - ZEPHYR - 54IN 1370MM	SB	GC	
ICE					
10102	1	ICE - BIN B55	SB	GC	
10344	1	ICE - BIN DROP IN 90LB 40KG	SB	GC	
18842	1	ICE - MACHINE CIM1136HA SERIES AIR COOLED	SB	GC	
19278	1	ICE - BIN DROP IN 45LB 20KG HORIZONTAL	SB	GC	
OTHER					
10396	1	CUP DISPENSER SHORT HOT VERTICAL	SB	GC	
10791	3	CUP DISPENSER GRANDE VENTI COLD VERTICAL	SB	GC	
10855	3	CUP DISPENSER GRANDE VENTI HOT VERTICAL	SB	GC	
10947	1	SOAP DISPENSER WALL MOUNTED	LC	GC	
10977	1	PAPER TOWEL DISPENSER FULL SIZE	LC	GC	
10992	1	PAPER TOWEL DISPENSER HALF SIZE - TRANSLUCENT GRAY	LC	GC	
11115	1	SOAP DISPENSER SINK MOUNTED	SB	GC	
11130	9	CORNER GUARD - 0.375IN 10MM - ANODIZED ALUMINUM	GC	GC	
13330	1	MOBILE CUP DISPENSER CADDY	SB	GC	
13584	1	CUP DISPENSER TRENTA COLD VERTICAL	SB	GC	
20403	6	KEG - 3GAL	SB	GC	
22627	1	NITRO 2 TAP HANDLE WITH BADGE AND MOUNT KIT	SB	GC	JOE TAP, FOR USE AT BACKBAR NITRO FONT
STORAGE					
10222	1	WIRE SHELF GRID AT SINK	SB	GC	
10416	5	WORKROOM SHELIVING - 36IN 915MM	SB	GC	
10462	5	WORKROOM SHELIVING POSTS	SB	GC	
10698	1	MOP RACK WITH 3 HOLDERS	SB	GC	
13578	2	DISHWARE DRYING RACK - 21IN 535MM	SB	GC	
13834	2	BASE - 24X18IN 610X455MM	SB	SB	ITEM PROVIDED BY PENTAIR FOR USE WITH WATER FILTRATON SYSTEM
17255	1	PASTRY TRAY CART - 60IN 1525MM	SB	GC	
17264	1	ROLLING PASTRY TRAY THAW RACK - 20X26IN 510X680MM	SB	GC	
19476	2	5 COMP LOCKER - 12IN 305MM	LC	GC	STARBUCKS RECOMMENDATION. LICENSEE TO PURCHASE AS NEEDED
22212	1	WORKROOM SHELIVING CART KIT	SB	GC	
24271	1	FILTER - 20 GALLON RO SYSTEM STORAGE TANK SHELF	SB	SB	ITEM PROVIDED BY PENTAIR FOR USE WITH WATER FILTRATON SYSTEM

SITE SCHEDULE - "Y"					
DESIGN ID	COUNT	DESCRIPTION	FURN. BY	INST. BY	COMMENTS
FENCE AND RAILING					
21486	8	FENCE MESH - 54IN 1370MM	GC	GC	
PLANTER					
14451	7	PLANTER - BOX - 36X18X18IN 915X455X455MM - BLACK	LC	GC	
UMBRELLA					
18714	2	UMBRELLA - BASE 200LB 90KG - FLAT BLACK MT0028	SB	GC	
20073	2	UMBRELLA - WITHOUT VALANCE - 6FT 183CM - GREEN CANVAS WITH WORDMARK F0056	SB	GC	

DATA DEVICE SCHEDULE - "A"					
DESIGN ID	COUNT	DESCRIPTION	FURN. BY	INST. BY	COMMENTS
AUDIO VISUAL					
10005	1	MUSIC SYSTEM	LC	GC	LC TO REACH OUT TO InstallOrderEntry@moodmedia.com TO SET UP ACCOUNT WITH PLAYNETWORK
10015	2	SPEAKER RECESSED - WHITE	GC	GC	SEE RCP FOR LOCATION.
10076	1	AMPLIFIER - 60W	SB	GC	
18801	1	DIGITAL PRODUCTION MANAGER	SB	SB	COORDINATED BY STARBUCKS CONNECT TEAM. INCLUDES ASSOCIATED CABLES AND UPS POWER SUPPLY.
22549	2	SPEAKER GRILLE RECESSED - BLACK	GC	GC	SEE RCP FOR LOCATION.
DATA					
18744	1	EQUIPMENT RACK WITH LOCK - 24IN 610MM	LC	GC	
21874	1	PRODUCTION CONTROLLER	SB	GC	COORDINATED BY STARBUCKS CONNECT TEAM AND NCR. INCLUDES DELL WYSE 7040, SLIM LINE RETAIL CABINET RXL-4061 (AS REQUIRED FOR BOH INSTALLATION), ASSOCIATED CABLES AND UPS POWER SUPPLY
GRAPHICS - INTERIOR MENU					
22970	1	MENU BOARD - DIGITAL DISPLAY - 44X25.25IN 1121X644MM - BLACK	SB	GC	FOR ORDER STATUS BOARD. COORDINATED BY STARBUCKS CONNECT TEAM AND NCR.
23021	1	MENU BOARD - ORDER STATUS BOARD MOUNTING BRACKET - BLACK	SB	GC	COORDINATED BY STARBUCKS CONNECT TEAM AND NCR.
24899	1	MENU BOARD - DIGITAL MENU BOARD TRIPLE	LC	GC	LICENSEE TO COORDINATE WITH DSM AND NCR. SEE INTERIOR ELEVATIONS FOR LOCATION.
POINT OF SALE					
10008	2	POS - REGISTER WITH COMPACT CASH DRAWER	SB	SB	COORDINATED BY STARBUCKS CONNECT TEAM AND NCR. INCLUDES NCR POS, SCANNER, (2) NCR CASH DRAWERS FOR EACH REGISTER, CABLES, LOCK AND CYBERPOWER UPS.
10014	2	POS PRINTER	SB	SB	COORDINATED BY STARBUCKS CONNECT TEAM AND NCR. INCLUDES RECEIPT PRINTER AND CABLES.
10029	4	POS BANK	SB	SB	
10075	4	CUP LABELER	SB	SB	COORDINATED BY STARBUCKS CONNECT TEAM. INCLUDES ASSOCIATED CABLES AND UPS POWER SUPPLY.
X3000	1	PAYMENT ENTRY DEVICE (PED)	LC	LC	PAYMENT ENTRY DEVICES ARE PROVIDED BY LC THROUGH ELAVON OR FREEDOMPAY. ALL OTHER EQUIPMENT AND PERIPHERAL DEVICES ARE PROVIDED BY STARBUCKS CONNECT VIA NCR

FURNITURE SCHEDULE - "F"					
DESIGN ID	COUNT	DESCRIPTION	FURN. BY	INST. BY	COMMENTS
BANQUETTE					
X6005	1	BANQUETTE - SHORT - CUSTOM	SB	GC	WHITE OAK AND CARAMEL LEATHER - WD0073 AND F-0008
X6006	1	BANQUETTE - LONG - CUSTOM	SB	GC	WHITE OAK AND CARAMEL LEATHER - WD0073 AND F-0008
BENCH					
TK0002	1	BENCH - AMICABLE SPLIT - 60IN 1525MM - WHITE OAK	SB	GC	ORDER THROUGH GROUP O
CHAIR					
17852	12	CHAIR - CAFE PYRAMID - BLACK AND BROWN ROPE MT0028 F0194	SB	GC	
20087	6	CHAIR - LOUNGE PYRAMID - BLACK AND BROWN ROPE MT0028 F0194	SB	GC	
24369	4	CHAIR - CAFE SADOVE UPHOLSTERED - SAND AND CARAMEL	SB	GC	
24395	4	CHAIR - LOUNGE LOTTIE - NUT SADDLE	SB	GC	FROM EXCESS INVENTORY
X8002	1	CHAIR - MANAGERS WORKSTATION	LC	GC	STARBUCKS RECOMMENDATION. LICENSEE TO PURCHASE AS NEEDED.
DESK					
10123	1	DESK - MANAGERS WORKSTATION - 60X30X30IN 1525X760X760MM	LC	GC	STARBUCKS RECOMMENDATION. LICENSEE TO PURCHASE AS NEEDED.
16505	1	DESK - MANAGERS WORKSTATION SHELVES - 36IN 915MM	LC	GC	STARBUCKS RECOMMENDATION. LICENSEE TO PURCHASE AS NEEDED.
OTTOMAN					
23854	2	OTTOMAN - STOUT - BLACK AND TAN BROWN WD0035 F0245	SB	GC	
TABLE					
17339	5	TABLE - CAFE METAL PEDESTAL BASE ROUND - 24IN 610MM - BLACK MT0028	SB	GC	
17341	1	TABLE - ACCESSIBLE METAL WITH TAPERED LEGS - 36X24IN 915X610MM - BLACK MT0028	SB	GC	
20126	4	TABLE - OCCASIONAL COCKTAIL CAMERON - FLAT BLACK MT0028	SB	GC	
20128	1	TABLE - OCCASIONAL COFFEE CAMERON - FLAT BLACK MT0028	SB	GC	FROM EXCESS INVENTORY
21449	4	TABLE - BASE CAFE HEIGHT BOTTLE - FLAT BLACK MT0028	SB	GC	
21473	1	TABLE - BASE ACCESSIBLE POST LEG SQUARE - FLAT BLACK MT0028	SB	GC	
21794	1	TABLE - TOP ACCESSIBLE FOR POST LEG ROUND - 46IN 1170MM - WHITE OAK WD0073	SB	GC	FROM EXCESS INVENTORY
21842	4	TABLE - TOP ROUND EDGE ROUND - 24IN 610MM - WHITE OAK WD0073	SB	GC	(3) FROM EXCESS INVENTORY
21979	3	TABLE - OCCASIONAL SIDE WING - WHITE OAK WD0073	SB	GC	

LICENSED STORES
RESPONSIBILITY LEGEND

- SB - STARBUCKS
- FC - STARBUCKS FIXTURE CONTRACTOR
- LC - LICENSEE
- GC - LICENSEE'S GENERAL CONTRACTOR

DESIGN DEVELOPMENT ONLY - NOT INTENDED FOR CONSTRUCTION USE



© 2025 STARBUCKS COFFEE COMPANY

STARBUCKS®
2401 UTAH AVENUE SOUTH
SEATTLE, WASHINGTON 98134
(206) 318-1575

THESE DRAWINGS AND THE PROJECT MANUAL ARE CONFIDENTIAL AND SHALL REMAIN THE SOLE PROPERTY OF STARBUCKS CORPORATION, WHICH IS THE OWNER OF THE COPYRIGHT IN THIS WORK. THEY SHALL NOT BE REPRODUCED (IN WHOLE OR IN PART), SHARED WITH THIRD PARTIES OR USED IN ANY MANNER ON OTHER PROJECTS OR EXTENSIONS TO THIS PROJECT WITHOUT THE PRIOR WRITTEN CONSENT OF STARBUCKS CORPORATION. THESE DRAWINGS AND SPECIFICATIONS ARE INTENDED TO EXPRESS DESIGN INTENT FOR A PROTOTYPICAL STARBUCKS STORE (WHICH IS SUBJECT TO CHANGE AT ANYTIME) AND DO NOT REFLECT ACTUAL SITE CONDITIONS. NEITHER PARTY SHALL HAVE ANY OBLIGATION NOR LIABILITY TO THE OTHER (EXCEPT STATED ABOVE) UNTIL A WRITTEN AGREEMENT IS FULLY EXECUTED BY BOTH PARTIES.

STARBUCKS TEMPLATE VERSION I|2025.08.27

ARCHITECT OF RECORD

THIS DRAWING IS A DESIGN DEVELOPMENT DOCUMENT. SITE SPECIFIC MODIFICATIONS MADE UNDER THE RESPONSIBLE CHARGE OF THE ARCHITECT AND/OR ENGINEER-OF-RECORD WILL BE REQUIRED PRIOR TO USING THIS DOCUMENT FOR BIDDING, PERMITTING, OR CONSTRUCTION.

PROJECT NAME:
TA CORDELE

PROJECT ADDRESS:
**397 ROCKHOUSE RDE
CORDELE, GA 31015**

STORE #:
PROJECT #:

TBD
108648-001

ISSUE DATE:

12/03/2025

DESIGN MANAGER:

MANDY KENT

PRODUCTION DESIGNER:

MAV


CHECKED BY:

E. NORRIS

Revision Schedule			
Rev	Date	By	Description

SHEET TITLE:
**FF & E PLAN
SCHEDULES**
SCALE: AS SHOWN

SHEET NUMBER:
I|01.1

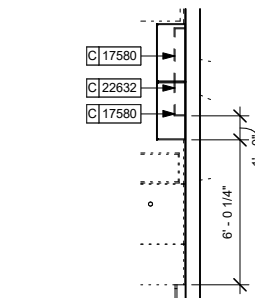

2 UPPER CASEWORK PLAN



1102

CASEWORK SCHEDULE - "C"					
DESIGN ID	COUNT	DESCRIPTION	FURN. BY	INST. BY	COMMENTS
CABINET					
17574	1	CABINET - BACKBAR SINK OR ICE - 15IN 380MM	SB	FC	
17575	1	CABINET - BACKBAR SINK OR ICE - 20IN 510MM	SB	FC	
17580	2	CABINET - CBE TEA SHELF - 29IN 735MM - FLAT BLACK MT0028	SB	GC	NOT PROVIDED BY CASEWORK VENDOR.
17740	1	CABINET - BACKBAR - 30IN 760MM	SB	FC	
17745	1	CABINET - BACKBAR DRAWER - 15IN 380MM	SB	FC	
17747	3	CABINET - BACKBAR TRASH - 15IN 380MM	SB	FC	
18122	1	CABINET - BACKBAR SINK OR ICE - 16IN 405MM	SB	FC	
19281	1	CABINET - ESPRESSO ICE BIN STAINLESS - 20IN 510MM	SB	FC	
21190	1	CABINET - FRONTBAR TRASH - 15IN 380MM	SB	FC	
21192	2	CABINET - FRONTBAR POS - 30IN 760MM	SB	FC	
21193	1	CABINET - ESPRESSO CUBBY WITH OPEN BACK - 18IN 455MM	SB	FC	
22632	1	CABINET - CBE DRY INCLUSION SHELF - 44IN 1120MM - FLAT BLACK MT0028	SB	GC	NOT PROVIDED BY CASEWORK VENDOR.
22975	1	CABINET - FRONTBAR DEL- 15IN 380MM	SB	FC	
CAFE					
20365	1	WALL BAY 2 UNIT - LH - 54IN 1370MM - WHITE OAK WD0073	SB	GC	NOT PROVIDED BY CASEWORK VENDOR.
X20132	1	CONDIMENT WASTE AND RECYCLING CART THREE DROP - WHITE OAK VERTICAL GRAIN VENEER AND MARMO - PISA WD0073 CP0113	SB	GC	CUSTOM TOP AND FINISH PANELS PROVIDED BY CASEWORK VENDOR
COUNTERTOP					
17800	1	COUNTERTOP - FRONTBAR CAP - 114IN 2895MM	SB	FC	
17809	1	COUNTERTOP - HAND SINK WITH LOW SPLASH STAINLESS - 15IN 380MM	SB	FC	
18715	1	COUNTERTOP - POS - 60IN 1525MM	SB	FC	
19708	1	COUNTERTOP - WARMING - RF - 60IN 1525MM	SB	FC	
20050	1	COUNTERTOP - BACKBAR NITRO - LH - 30IN 760MM	SB	FC	
21194	1	COUNTERTOP - ESPRESSO METRO - 114IN 2895MM	SB	FC	
21951	1	COUNTERTOP - CBE - LF - 96IN 2440MM	SB	FC	
X5000	1	COUNTERTOP - HANDOFF - CUSTOM	SB	FC	
X5012	1	COUNTERTOP - BREW WITH TRASH DROP - CUSTOM	SB	FC	
DIEWALL					
17760	1	DIEWALL - ESPRESSO - 114IN 2895MM	SB	FC	
18716	1	DIEWALL - POS - 60IN 1525MM	SB	FC	
X5002	1	DIEWALL - HANDOFF - CUSTOM	SB	FC	
OTHER					
11155	2	ESPRESSO MACHINE PUMP MOUNT - 10X10IN 255X255MM	SB	FC	
17767	1	SNEEZE GUARD - 114IN 2895MM	SB	FC	
18145	3	COUNTERTOP SUPPORT LEG	SB	FC	
19335	1	SHROUD - 69IN 1755MM	SB	FC	
20633	3	COUNTERTOP SUPPORT LEG SLIM	SB	FC	
X5006	2	WOOD SCREEN	SB	GC	PROVIDED BY CASEWORK VENDOR
X5016	2	WOOD TOP / END CAP	SB	GC	PROVIDED BY CASEWORK VENDOR
PANEL					
17763	1	PANEL - ESP - 114IN 2895MM	SB	FC	
18717	1	PANEL - POS - 60IN 1525MM	SB	FC	
X5001	1	PANEL - HANDOFF - CUSTOM	SB	FC	
TRIM					
X5003	1	WOOD TRIM - AT STOREFRONT - 2" X 4"	SB	GC	PROVIDED BY CASEWORK VENDOR
X5004	1	WOOD TRIM - AT ENTRY - 2" X 4"	SB	GC	PROVIDED BY CASEWORK VENDOR
X5005	1	WOOD TRIM - AT MERCH - 1" X 2"	SB	GC	PROVIDED BY CASEWORK VENDOR
X5007	1	WOOD PORTAL TRIM - AT CAFE	SB	GC	PROVIDED BY CASEWORK VENDOR
X5008	2	WOOD PORTAL AT BANQUETTE	SB	GC	PROVIDED BY CASEWORK VENDOR
X5009	3	SCHLUTER STRIP - DECO - 1/4" - SOLID BRASS	GC	GC	LOCATED AT FLOOR TILE. LENGTHS: (2) 8'-0" (1) 16'-4"
X5010	1	WOOD TRIM - AT ORDER STATUS BOARD - 1" X 2"	SB	GC	PROVIDED BY CASEWORK VENDOR
X5013	1	FRY REGLET WALL COVERING END TRIM	SB	GC	LENGTH: 9'4". PROVIDED BY CASEWORK VENDOR. CASEWORK VENDOR TO ORDER UNFINISHED TRIM AND REFINISH TO MATCH MT0038. LONG LEAD ITEM. SHIP TO SITE EARLY. GC TO COORDINATE EARLY DELIVERY PRIOR TO DRYWALL INSTALLATION.
X5014	1	SCHLUTER STRIP - DECO SG - 1/2" - FINISH: SATIN ANODIZED ALUMINUM	GC	GC	LOCATED AT BACKBAR WALL TILE. OVERALL LENGTH: 38'-7 3/4"
X5015	2	METAL TRIM AT WORKROOM HEADER	GC	GC	FINISH: ANODIZED ALUMINUM. LENGTH: (2) AT 8'-0 1/4"

CASEWORK FINISH SCHEDULE			
ENGINE ZONE	MATERIAL DESCRIPTION	FINISH CODE	COMMENTS
COMPOSITE - AURORA SAN REMO			
COUNTERTOPS - BACKBAR	COMPOSITE - AURORA SAN REMO	CP0113	
COUNTERTOPS - ESPRESSO	COMPOSITE - AURORA SAN REMO	CP0113	
COUNTERTOPS - FRONTBAR	COMPOSITE - AURORA SAN REMO	CP0113	
COUNTERTOPS - SHROUD	COMPOSITE - AURORA SAN REMO	CP0113	
METAL - FLAT BLACK POWDERCOAT			
CABINETS - DOOR PULL	METAL - FLAT BLACK POWDERCOAT	MT0028	
CABINETS - UNDERCOUNTER	METAL - FLAT BLACK POWDERCOAT	MT0028	
METAL - STAINLESS STEEL - BRUSHED			
CABINETS - CABINET LEG	METAL - STAINLESS STEEL - BRUSHED	#4 BRUSHED 16GA	
CABINETS - UNDERCOUNTER ICE BIN	METAL - STAINLESS STEEL - BRUSHED	#4 BRUSHED 16GA	
COUNTERTOPS - HAND SINK	METAL - STAINLESS STEEL - BRUSHED	#4 BRUSHED 16GA	
PLAM - MOTTLED BLACK			
CABINETS - UNDERCOUNTER	PLAM - MOTTLED BLACK	PL0019	
WOOD - WHITE OAK			
WOOD PORTAL AT BANQUETTE	WOOD - WHITE OAK	WD0073	MATCH TO WALL FINISH X9400 WOOD WALL COVERING. SB DM TO APPROVE FINISH SAMPLES. COORDINATE WITH WOOD VENDOR.
WOOD TOP/END CAP	WOOD - WHITE OAK	WD0073	MATCH TO WALL FINISH X9400 WOOD WALL COVERING. SB DM TO APPROVE FINISH SAMPLES. COORDINATE WITH WOOD VENDOR.
WOOD TRIM AT CAFE	WOOD - WHITE OAK	WD0073	MATCH TO WALL FINISH X9400 WOOD WALL COVERING. SB DM TO APPROVE FINISH SAMPLES. COORDINATE WITH WOOD VENDOR.
WOOD TRIM AT ENTRY	WOOD - WHITE OAK	WD0073	MATCH TO WALL FINISH X9400 WOOD WALL COVERING. SB DM TO APPROVE FINISH SAMPLES. COORDINATE WITH WOOD VENDOR.
WOOD TRIM AT MERCH	WOOD - WHITE OAK	WD0073	MATCH TO WALL FINISH X9400 WOOD WALL COVERING. SB DM TO APPROVE FINISH SAMPLES. COORDINATE WITH WOOD VENDOR.
WOOD TRIM AT STOREFRONT	WOOD - WHITE OAK	WD0073	MATCH TO WALL FINISH X9400 WOOD WALL COVERING. SB DM TO APPROVE FINISH SAMPLES. COORDINATE WITH WOOD VENDOR.
WOOD - WHITE OAK - TAMBOUR A			
FINISH PANELS - FRONTBAR	WOOD - WHITE OAK - TAMBOUR A	WD0073 MAD600	

LICENSED STORES
RESPONSIBILITY LEGEND

SB - STARBUCKS

FC - STARBUCKS FIXTURE CONTRACTOR

LC - LICENSEE

GC - LICENSEE'S GENERAL CONTRACTOR



STARBUCKS®
2401 UTAH AVENUE SOUTH
SEATTLE, WASHINGTON 98134
(206) 318-1575

THESE DRAWINGS AND THE PROJECT MANUAL ARE CONFIDENTIAL AND SHALL REMAIN THE SOLE PROPERTY OF STARBUCKS CORPORATION, WHICH IS THE OWNER OF THE COPYRIGHT IN THIS WORK. THEY SHALL NOT BE REPRODUCED (IN WHOLE OR IN PART), SHARED WITH THIRD PARTIES OR USED IN ANY MANNER ON OTHER PROJECTS OR EXTENSIONS TO THIS PROJECT WITHOUT THE PRIOR WRITTEN CONSENT OF STARBUCKS CORPORATION. THESE DRAWINGS AND SPECIFICATIONS ARE INTENDED TO EXPRESS DESIGN INTENT FOR A PROTOTYPICAL STARBUCKS STORE (WHICH IS SUBJECT TO CHANGE AT ANYTIME) AND DO NOT REFLECT ACTUAL SITE CONDITIONS. NEITHER PARTY SHALL HAVE ANY OBLIGATION NOR LIABILITY TO THE OTHER (EXCEPT STATED ABOVE) UNTIL A WRITTEN AGREEMENT IS FULLY EXECUTED BY BOTH PARTIES.

STARBUCKS TEMPLATE VERSION I|2025.08.27

ARCHITECT OF RECORD

THIS DRAWING IS A DESIGN DEVELOPMENT DOCUMENT. SITE SPECIFIC MODIFICATIONS MADE UNDER THE RESPONSIBLE CHARGE OF THE ARCHITECT AND/OR ENGINEER-OF-RECORD WILL BE REQUIRED PRIOR TO USING THIS DOCUMENT FOR BIDDING, PERMITTING, OR CONSTRUCTION.

PROJECT NAME:

TA CORDELE

PROJECT ADDRESS:

397 ROCKHOUSE RD E
CORDELE, GA 31015

STORE #: TBD
PROJECT #: 108648-001
ISSUE DATE: 12/03/2025
DESIGN MANAGER: MANDY KENT
PRODUCTION DESIGNER: MAV
CHECKED BY: E. NORRIS

Revision Schedule

Rev	Date	By	Description

SHEET TITLE:

CASEWORK
SCHEDULES

SCALE: AS SHOWN


SHEET NUMBER:

I|02.1



DESIGN DEVELOPMENT ONLY - NOT INTENDED FOR CONSTRUCTION USE

LIGHTING FIXTURE SCHEDULE - "L"						
DESIGN ID	COUNT	DESCRIPTION	FURN. BY	INST. BY	BULB	COMMENTS
PENDANT						
25119	3	PENDANT - CALDERA 9IN - NATURAL BRASS	SB	GC	AS PACKAGED: 1X LED G25 6.5W (DOWN); 1X LED A15 4.5W (UP)	SUPPLIER: DOLAN HOSPITALITY, DROP LENGTH: 2'-8"
RECESSED CAN						
21771	47	CAN - LED ADJUSTABLE RECESSED - 3IN 75MM - BLACK - 800LM FLOOD	SB	GC	INTEGRATED LED	
SCONCE						
15336	3	SCONCE - MESH CYLINDER MINI - BRONZE	SB	GC	(1) LED 400LM 2700K (INCLUDED), OR EQUAL	
20720	3	SCONCE - JUNIPER THIN - 24IN 610MM - SATIN BRASS	SB	GC	INTEGRATED LED	
20749	4	SCONCE - KUZCO PLUTO SINGLE - VINTAGE BRASS	SB	GC	AS PACKAGED: 1X LED G16 5W E26 BASE	(2) FROM EXCESS INVENTORY
25154	2	SCONCE - NATHAN - AGED BRASS	SB	GC	AS PACKAGED: 1X LED A19 7W E26 BASE	SUPPLIER: DOLAN HOSPITALITY
TRACK						
12946	7	TRACK - WITH CONNECTORS - 4FT 122CM - BLACK - 1 CIRCUIT	SB	GC		
21779	7	TRACK - LED FIXTURE WITH SNOOT - 3IN 75MM - BLACK - 1100LM FLOOD	SB	GC	INTEGRATED LED	
TROFFER						
21783	8	TROFFER - LED RECESSED - 24X48IN 600X1200MM - WHITE - 4300LM	GC	GC	INTEGRATED LED	

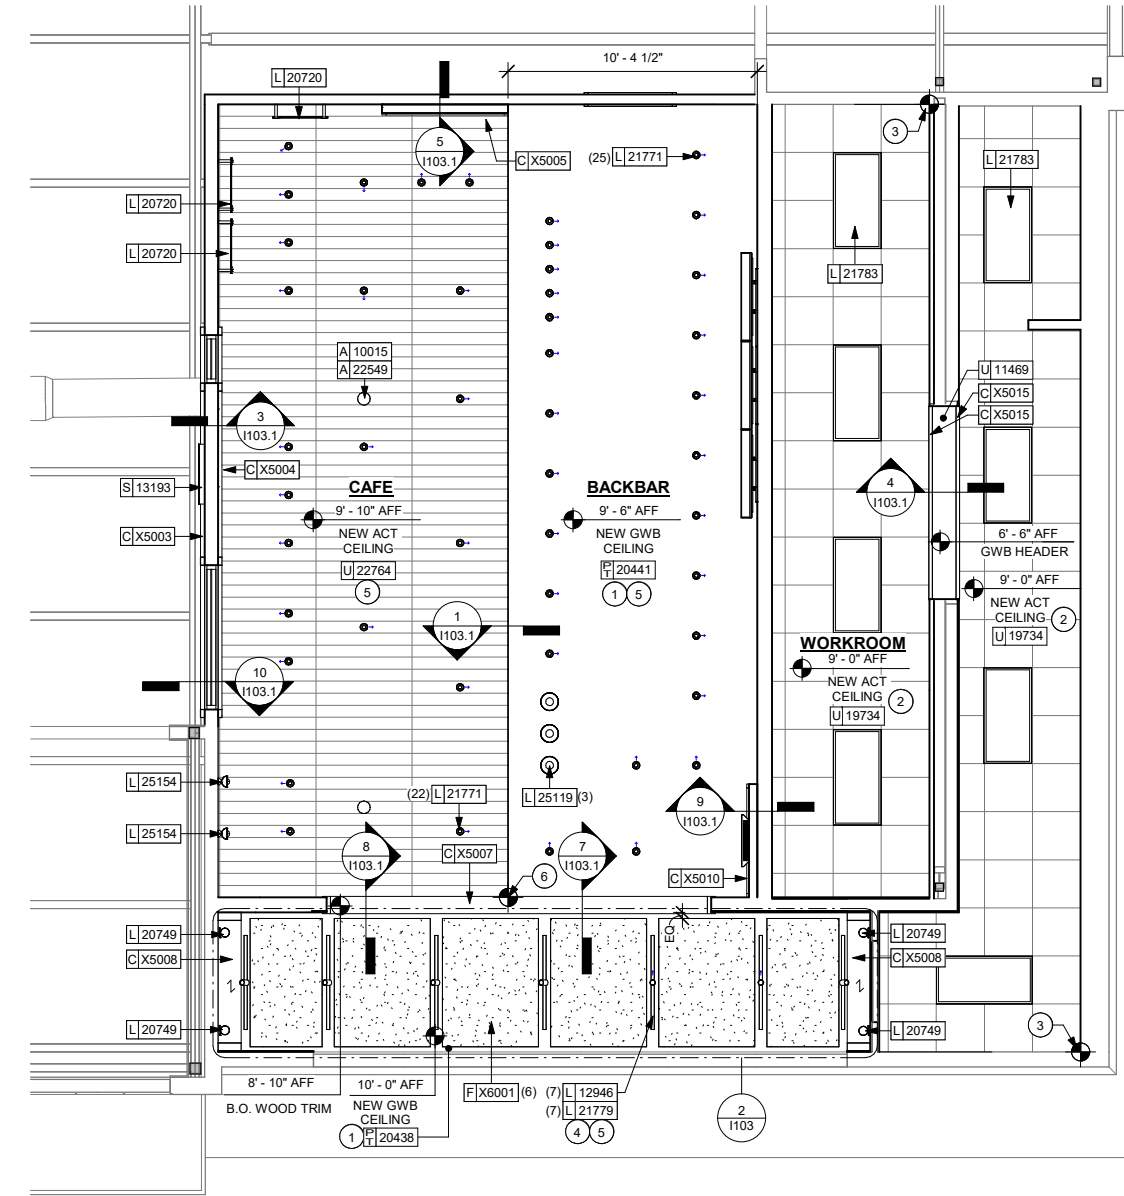


1 REFLECTED CEILING PLAN
Scale: 1/4" = 1'-0"

CEILING TREATMENT SCHEDULE - "U"						
DESIGN ID	AREA	DESCRIPTION	FURN. BY	INST. BY	COMMENTS	
OTHER						
19734	372 SF	ACT - ULTIMA - 2X2FT 61X61CM	GC	GC	STARBUCKS RECOMMENDATION. GC TO SOURCE LOCALLY.	
22764	397 SF	ACT - CIRRUS BEVELED SUPRAFINE PAINTED - 2X4FT 61X122CM	GC	GC	CUSTOM COLOR, FACTORY FINISH: SW7032 WARM STONE; FOR ORDERING CONTACT DEB PICKENS AT DLPICKENS@ARMSTRONGCEILINGS.COM, PH: 480-695-9053. LONG LEAD ITEM	
PLASTIC						
11469	8 SF	FRP - WHITE	GC	GC	VERIFY TOTAL QUANTITY WITH CEILING TREATMENT AND WALL TREATMENT SCHEDULES	

PAINT SCHEDULE					
DESIGN ID	DESCRIPTION	LRV	FURN. BY	INST. BY	COMMENTS
20438	SW7020 BLACK FOX	8	GC	GC	
20441	SW7031 MEGA GREIGE	37	GC	GC	
X9000	BLACK TO MATCH STOREFRONT SYSTEM		GC	GC	

ACOUSTIC CEILING PANEL SCHEDULE - "F"					
DESIGN ID	COUNT	DESCRIPTION	FURN. BY	INST. BY	COMMENTS
OTHER					
X6001	6	ACOUSTICAL CEILING PANEL - 48" X 96" X 1" - COLOR: CHESTNUT	GC	GC	SEE RCP FOR LOCATION. CUT TO FIT IN FIELD. SEE DETAILS. MFR: F-SORB. SECURE TO CEILING WITH HAT CHANNEL. LONG LEAD ITEM.

ARCHITECT AND/OR ENGINEER OF RECORD TO VERIFY THAT HVAC DOES NOT INTERFERE WITH LIGHTING PLACEMENT. NOTIFY STARBUCKS DESIGN MANAGER OF ANY CONFLICTS.

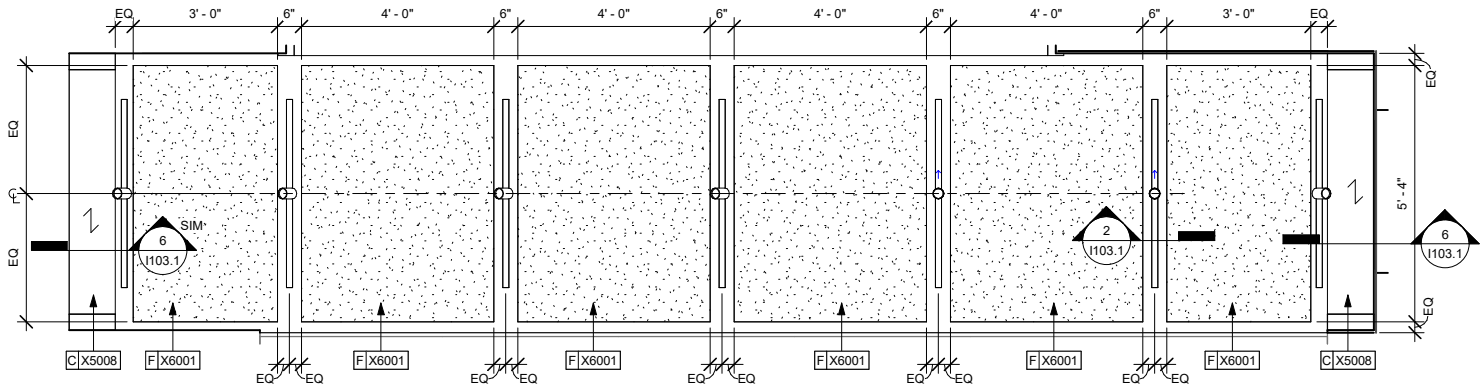

2 ACOUSTIC CEILING PANEL ENLARGED PLAN
Scale: 1/2" = 1'-0"

KEYED NOTES

- GWB SOFFIT WITH SMOOTH FINISH (PAINT AS SCHEDULED).
- WASHABLE CEILING TILE LOCATED IN BACK OF HOUSE.
- CEILING GRID INSTALLATION START POINT WHERE INDICATED.
- SURFACE MOUNT LIGHT TRACK DIRECTLY TO CEILING/SOFFIT.
- ADJUST FOCUS OF ALL TRACK LIGHTING AND RECESSED DIRECTIONAL LIGHTING TO FULLY ILLUMINATE MENU BOARDS, MERCHANDISE BAYS, AND ARTWORK.

GENERAL NOTES

- IF REQUIRED BY LOCAL CODE, GENERAL CONTRACTOR TO PROVIDE SEMI-RECESSED SPRINKLER HEADS WITH POLISHED CHROME ESOUTOCHONS CENTERED IN ACOUSTICAL CEILING TILE. IF PENDANT HEADS ARE REQUIRED IN GWB SOFFIT OVER FRONTBAR, CONCEAL SUPPLY PIPING WITHIN SOFFIT.
- GENERAL CONTRACTOR TO PROVIDE AND INSTALL SPRINKLERS PER APPROVED AOR LAYOUT AND LOCAL CODE. CONTACT ARCHITECT OF RECORD AND STARBUCKS PROJECT DEVELOPMENT MANAGER IF DESIGN INTENT IS AFFECTED.
- LEAVE TEN (10) ADDITIONAL RETAIL CEILING TILES TO MATCH RETAIL CEILING PAINT COLOR ABOVE THE WORKROOM CEILING FOR FUTURE USE.
- PROVIDE GROMMET AT ACOUSTIC CEILING TILE PENETRATIONS FOR FIXTURES OR SUPPORTS.
- HEATING, VENTILATING AND AIR CONDITIONING (HVAC) SHOWN ON THIS PLAN PROVIDED FOR REFERENCE ONLY. ACTUAL DUCTWORK AND CEILING DIFFUSER LOCATIONS TO BE DETERMINED BY ARCHITECT OF RECORD AND ARE NOT TO INTERFERE WITH PLACEMENT OF LIGHT FIXTURES AS SHOWN ON THIS PLAN. NOTIFY STARBUCKS DESIGN MANAGER OF ANY CONFLICTS.
- DIFFUSERS AND RETURNS IN ACOUSTICAL CEILING TO BE CENTERED IN TILE, UNLESS NOTED OTHERWISE.
- PAINT ALL EXPOSED HVAC DUCTS, HVAC DIFFUSERS, RECESSED SPEAKERS, LIGHT TRIM RINGS, PIPING CONDUIT AND JUNCTION BOXES THE SAME COLOR AS SPECIFIED ON SURROUNDING CEILING OR SOFFIT UNLESS NOTED OTHERWISE, TYPICAL THROUGHOUT RETAIL AREA OF STORE.
- PAINT SUBSTITUTIONS ARE NOT ALLOWED. USE STARBUCKS NATIONAL SHERWIN WILLIAMS ACCOUNT "COLOR CODE" WHEN ORDERING PAINTS.
- ARCHITECT OF RECORD TO SPECIFY AND AND LOCATE EMERGENCY LIGHTS AND EXIT SIGNS AS REQUIRED BY CODE. FIXTURES TO BE SUPPLIED AND INSTALLED BY GENERAL CONTRACTOR.
- ARCHITECT OF RECORD TO PROVIDE CEILING AND SOFFIT STRUCTURAL DETAILS AS REQUIRED.
- BALLAST BOXES, TRANSFORMERS, JUNCTION BOXES, AND WIRING FOR ALL LIGHT FIXTURES TO BE INSTALLED SO AS TO BE HIDDEN FROM VIEW.

LEGEND

- ELEVATION DATUM
- TRACK LIGHTING
- PENDANT LIGHT
- ADJUSTABLE RECESSED CAN LIGHT
- TROFFER
- WALL SCONCE

LICENSED STORES RESPONSIBILITY LEGEND

- SB - STARBUCKS
- FC - STARBUCKS FIXTURE CONTRACTOR
- LC - LICENSEE
- GC - LICENSEE'S GENERAL CONTRACTOR



STARBUCKS®
2401 UTAH AVENUE SOUTH
SEATTLE, WASHINGTON 98134
(206) 318-1575

THESE DRAWINGS AND THE PROJECT MANUAL ARE CONFIDENTIAL AND SHALL REMAIN THE SOLE PROPERTY OF STARBUCKS CORPORATION, WHICH IS THE OWNER OF THE COPYRIGHT IN THIS WORK. THEY SHALL NOT BE REPRODUCED (IN WHOLE OR IN PART), SHARED WITH THIRD PARTIES OR USED IN ANY MANNER ON OTHER PROJECTS OR EXTENSIONS TO THIS PROJECT WITHOUT THE PRIOR WRITTEN CONSENT OF STARBUCKS CORPORATION. THESE DRAWINGS AND SPECIFICATIONS ARE INTENDED TO EXPRESS DESIGN INTENT FOR A PROTOTYPICAL STARBUCKS STORE (WHICH IS SUBJECT TO CHANGE AT ANYTIME) AND DO NOT REFLECT ACTUAL SITE CONDITIONS. NEITHER PARTY SHALL HAVE ANY OBLIGATION NOR LIABILITY TO THE OTHER (EXCEPT STATED ABOVE) UNTIL A WRITTEN AGREEMENT IS FULLY EXECUTED BY BOTH PARTIES.

STARBUCKS TEMPLATE VERSION I2025.08.27

ARCHITECT OF RECORD

THIS DRAWING IS A DESIGN DEVELOPMENT DOCUMENT. SITE SPECIFIC MODIFICATIONS MADE UNDER THE RESPONSIBLE CHARGE OF THE ARCHITECT AND/OR ENGINEER-OF-RECORD WILL BE REQUIRED PRIOR TO USING THIS DOCUMENT FOR BIDDING, PERMITTING, OR CONSTRUCTION.

PROJECT NAME:
TA CORDELE

PROJECT ADDRESS:
397 ROCKHOUSE RD E
CORDELE, GA 31015

STORE #: TBD
PROJECT #: 108648-001
ISSUE DATE: 12/03/2025
DESIGN MANAGER: MANDY KENT
PRODUCTION DESIGNER: MAV
CHECKED BY: E. NORRIS

Revision Schedule

Rev	Date	By	Description


SHEET TITLE:
REFLECTED CEILING PLAN

SCALE: AS SHOWN


SHEET NUMBER:

1103


DESIGN DEVELOPMENT ONLY - NOT INTENDED FOR CONSTRUCTION USE

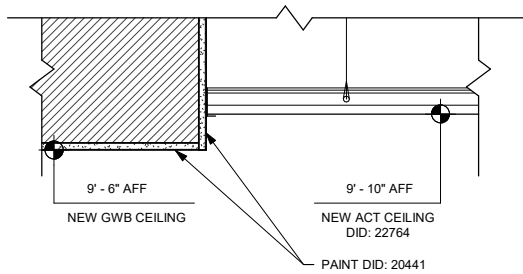


1 CAFE CEILING TRANSITION DETAIL
Scale: 1 1/2" = 1'-0"

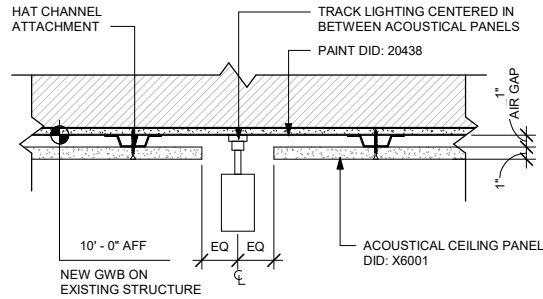


2 TRACK LIGHTING DETAIL
Scale: 1 1/2" = 1'-0"

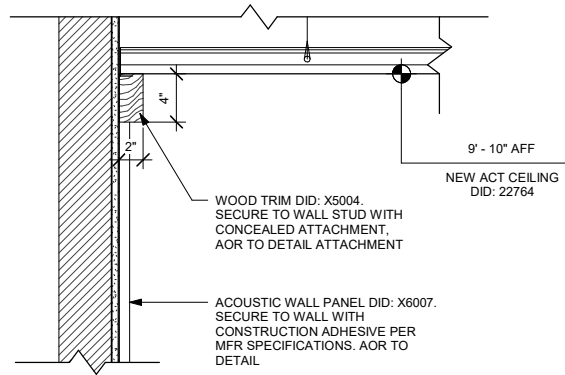


3 CEILING TRANSITION AT GALLERY WALL
Scale: 1 1/2" = 1'-0"

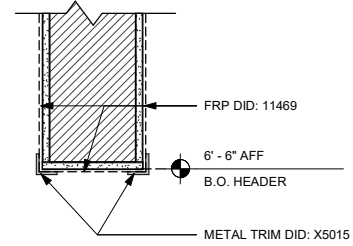


4 HEADER DETAIL @ WORKROOM
Scale: 1 1/2" = 1'-0"

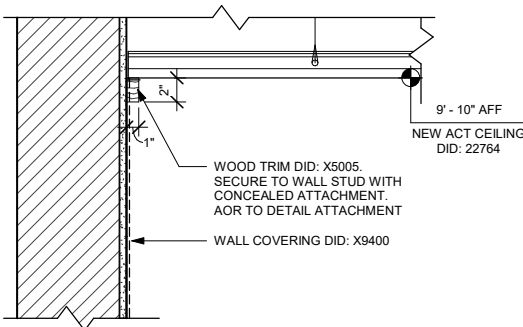


5 CEILING TRANSITION AT MERCH
Scale: 1 1/2" = 1'-0"

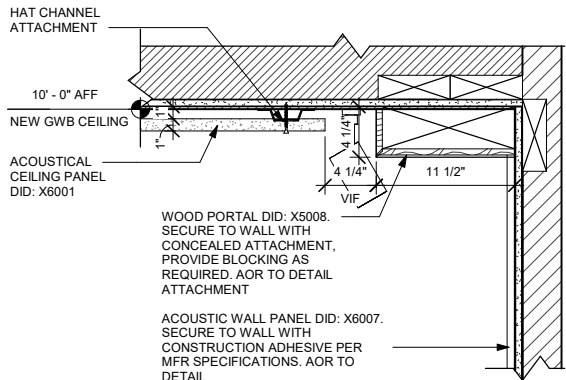


6 CEILING TRANSITION AT BANQ. WOOD PORTAL
Scale: 1 1/2" = 1'-0"

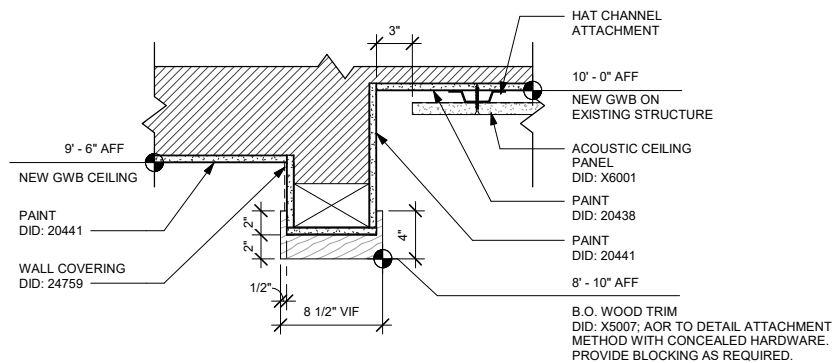


7 HEADER DETAIL @ CAFE PORTAL
Scale: 1 1/2" = 1'-0"

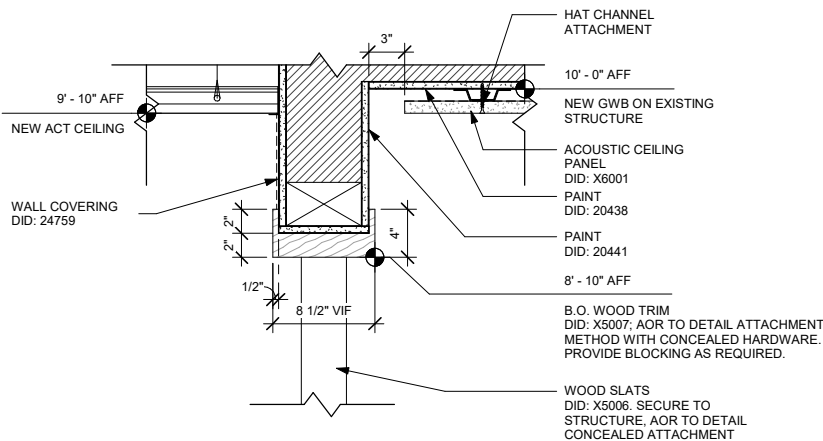

8 HEADER DETAIL @ SLATS
Scale: 1 1/2" = 1'-0"

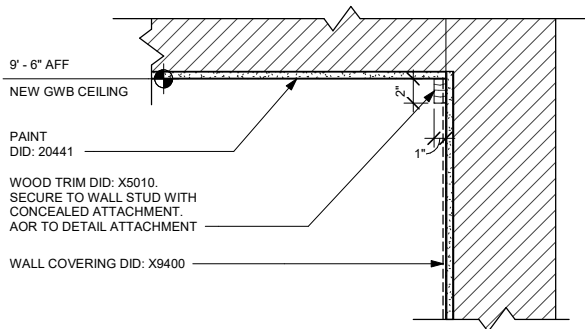

9 CEILING TRANSITION AT OSB
Scale: 1 1/2" = 1'-0"

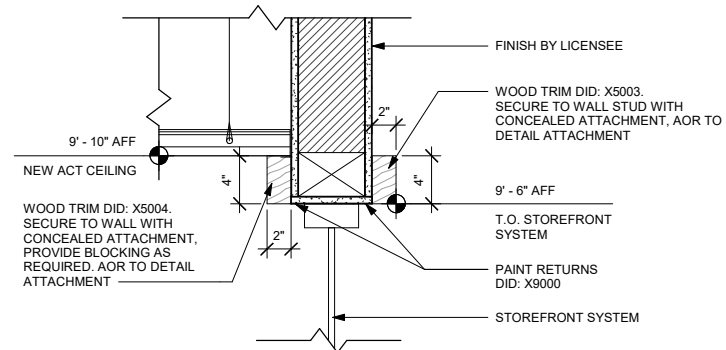

10 HEADER DETAIL @ STOREFRONT ENTRY
Scale: 1 1/2" = 1'-0"



STARBUCKS®
2401 UTAH AVENUE SOUTH
SEATTLE, WASHINGTON 98134
(206) 318-1575

THESE DRAWINGS AND THE PROJECT MANUAL ARE CONFIDENTIAL AND SHALL REMAIN THE SOLE PROPERTY OF STARBUCKS CORPORATION, WHICH IS THE OWNER OF THE COPYRIGHT IN THIS WORK. THEY SHALL NOT BE REPRODUCED (IN WHOLE OR IN PART), SHARED WITH THIRD PARTIES OR USED IN ANY MANNER ON OTHER PROJECTS OR EXTENSIONS TO THIS PROJECT WITHOUT THE PRIOR WRITTEN CONSENT OF STARBUCKS CORPORATION. THESE DRAWINGS AND SPECIFICATIONS ARE INTENDED TO EXPRESS DESIGN INTENT FOR A PROTOTYPICAL STARBUCKS STORE (WHICH IS SUBJECT TO CHANGE AT ANYTIME) AND DO NOT REFLECT ACTUAL SITE CONDITIONS. NEITHER PARTY SHALL HAVE ANY OBLIGATION NOR LIABILITY TO THE OTHER (EXCEPT STATED ABOVE) UNTIL A WRITTEN AGREEMENT IS FULLY EXECUTED BY BOTH PARTIES.

STARBUCKS TEMPLATE VERSION I2025.08.27

ARCHITECT OF RECORD

THIS DRAWING IS A DESIGN DEVELOPMENT DOCUMENT. SITE SPECIFIC MODIFICATIONS MADE UNDER THE RESPONSIBLE CHARGE OF THE ARCHITECT AND/OR ENGINEER-OF-RECORD WILL BE REQUIRED PRIOR TO USING THIS DOCUMENT FOR BIDDING, PERMITTING, OR CONSTRUCTION.

PROJECT NAME:
TA CORDELE

PROJECT ADDRESS:
397 ROCKHOUSE RD E
CORDELE, GA 31015


STORE #: TBD
PROJECT #: 108648-001
ISSUE DATE: 12/03/2025
DESIGN MANAGER: MANDY KENT
PRODUCTION DESIGNER: MAV
CHECKED BY: E. NORRIS

Revision Schedule			
Rev	Date	By	Description

SHEET TITLE:
**REFLECTED CEILING
DETAILS**
SCALE: AS SHOWN

SHEET NUMBER:
I103.1

DESIGN DEVELOPMENT ONLY - NOT INTENDED FOR CONSTRUCTION USE

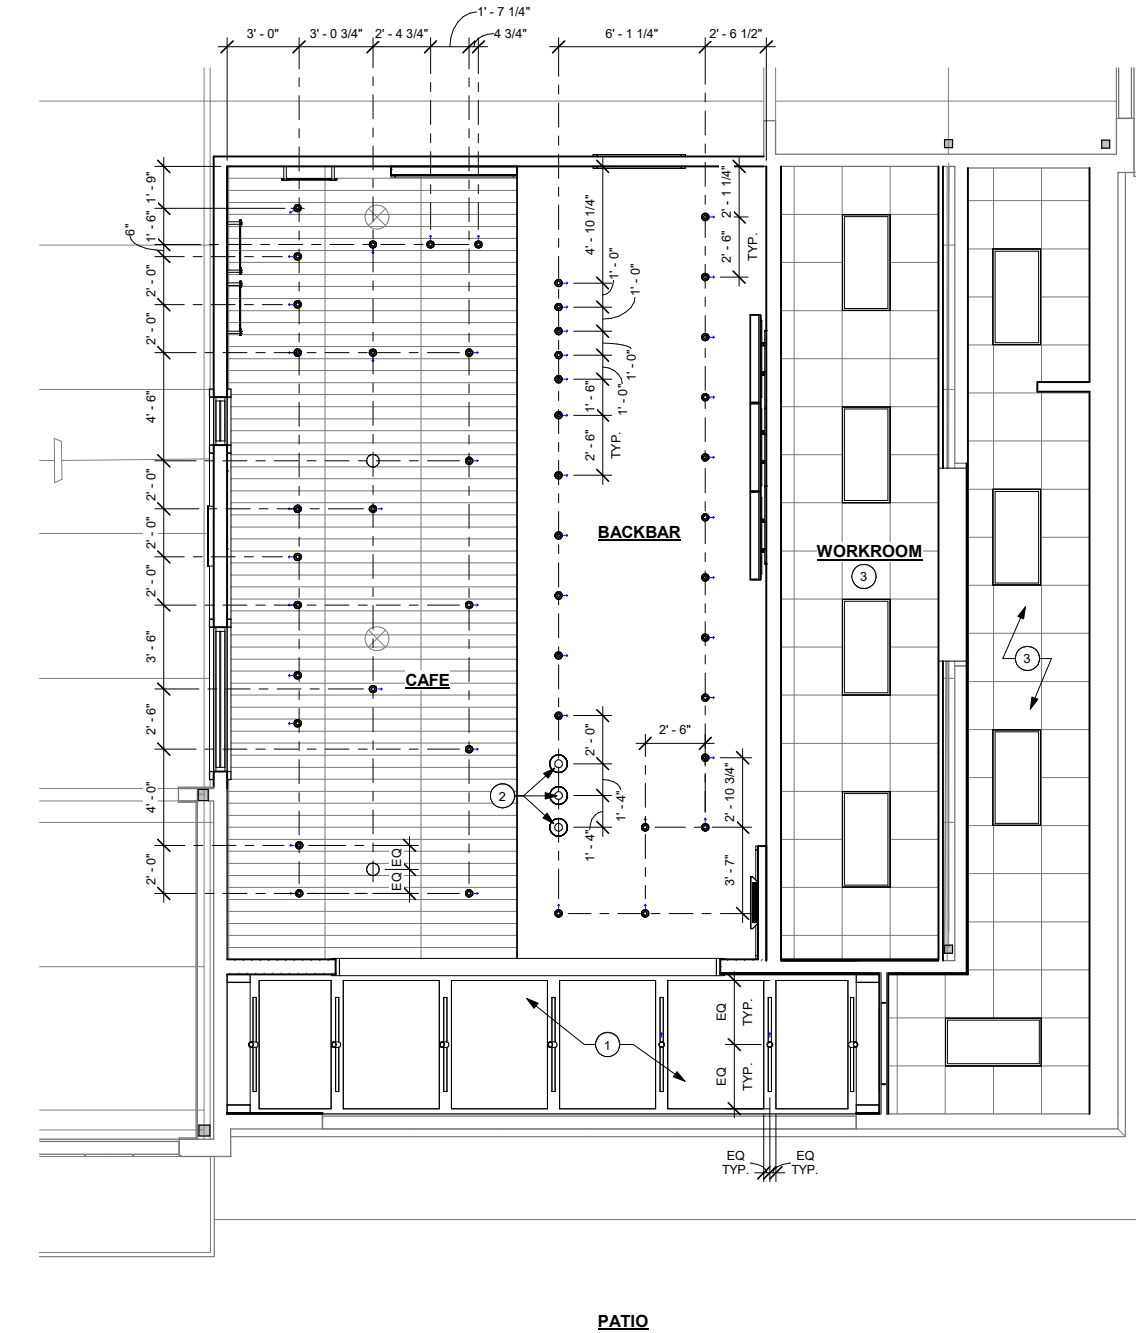

1 LIGHTING DIMENSION PLAN
Scale: 1/4" = 1'-0"

KEYED NOTES

1. SURFACE MOUNT LIGHT TRACK DIRECTLY TO CEILING/SOFFIT.
2. SUSPEND BOTTOM OF PENDANT LIGHT FIXTURE AT 6'-10" AFF.
3. CENTER LIGHTS IN CEILING TILE, UNO.

GENERAL NOTES

- A. HEATING, VENTILATING AND AIR CONDITIONING (HVAC) SHOWN ON THIS PLAN PROVIDED FOR REFERENCE ONLY. ACTUAL DUCTWORK AND CEILING DIFFUSER LOCATIONS TO BE DETERMINED BY ARCHITECT OF RECORD AND ARE NOT TO INTERFERE WITH PLACEMENT OF LIGHT FIXTURES AS SHOWN ON THIS PLAN. NOTIFY STARBUCKS DESIGN MANAGER OF ANY CONFLICTS.
- B. DIFFUSERS AND RETURNS IN ACOUSTICAL CEILING TO BE CENTERED IN TILE, UNLESS OTHERWISE NOTED.
- C. ARCHITECT OF RECORD TO SPECIFY AND AND LOCATE EMERGENCY LIGHTS AND EXIT SIGNS AS REQUIRED BY CODE. FIXTURES TO BE SUPPLIED AND INSTALLED BY GENERAL CONTRACTOR.

ARCHITECT AND/OR ENGINEER OF RECORD TO VERIFY THAT HVAC DOES NOT INTERFERE WITH LIGHTING PLACEMENT. NOTIFY STARBUCKS DESIGN MANAGER OF ANY CONFLICTS.



STARBUCKS®
2401 UTAH AVENUE SOUTH
SEATTLE, WASHINGTON 98134
(206) 318-1575

THESE DRAWINGS AND THE PROJECT MANUAL ARE CONFIDENTIAL AND SHALL REMAIN THE SOLE PROPERTY OF STARBUCKS CORPORATION, WHICH IS THE OWNER OF THE COPYRIGHT IN THIS WORK. THEY SHALL NOT BE REPRODUCED (IN WHOLE OR IN PART), SHARED WITH THIRD PARTIES OR USED IN ANY MANNER ON OTHER PROJECTS OR EXTENSIONS TO THIS PROJECT WITHOUT THE PRIOR WRITTEN CONSENT OF STARBUCKS CORPORATION. THESE DRAWINGS AND SPECIFICATIONS ARE INTENDED TO EXPRESS DESIGN INTENT FOR A PROTOTYPICAL STARBUCKS STORE (WHICH IS SUBJECT TO CHANGE AT ANYTIME) AND DO NOT REFLECT ACTUAL SITE CONDITIONS. NEITHER PARTY SHALL HAVE ANY OBLIGATION NOR LIABILITY TO THE OTHER (EXCEPT STATED ABOVE) UNTIL A WRITTEN AGREEMENT IS FULLY EXECUTED BY BOTH PARTIES.

STARBUCKS TEMPLATE VERSION I2025.08.27

ARCHITECT OF RECORD

THIS DRAWING IS A DESIGN DEVELOPMENT DOCUMENT. SITE SPECIFIC MODIFICATIONS MADE UNDER THE RESPONSIBLE CHARGE OF THE ARCHITECT AND/OR ENGINEER-OF-RECORD WILL BE REQUIRED PRIOR TO USING THIS DOCUMENT FOR BIDDING, PERMITTING, OR CONSTRUCTION.

PROJECT NAME:
TA CORDELE

PROJECT ADDRESS:
397 ROCKHOUSE RD E
CORDELE, GA 31015

STORE #: TBD
PROJECT #: 108648-001
ISSUE DATE: 12/03/2025
DESIGN MANAGER: MANDY KENT
PRODUCTION DESIGNER: MAV
CHECKED BY: E. NORRIS

Revision Schedule

Rev	Date	By	Description


SHEET TITLE:
LIGHTING DIMENSION
PLAN

SCALE: AS SHOWN

SHEET NUMBER:

1104

DESIGN DEVELOPMENT ONLY - NOT INTENDED FOR CONSTRUCTION USE

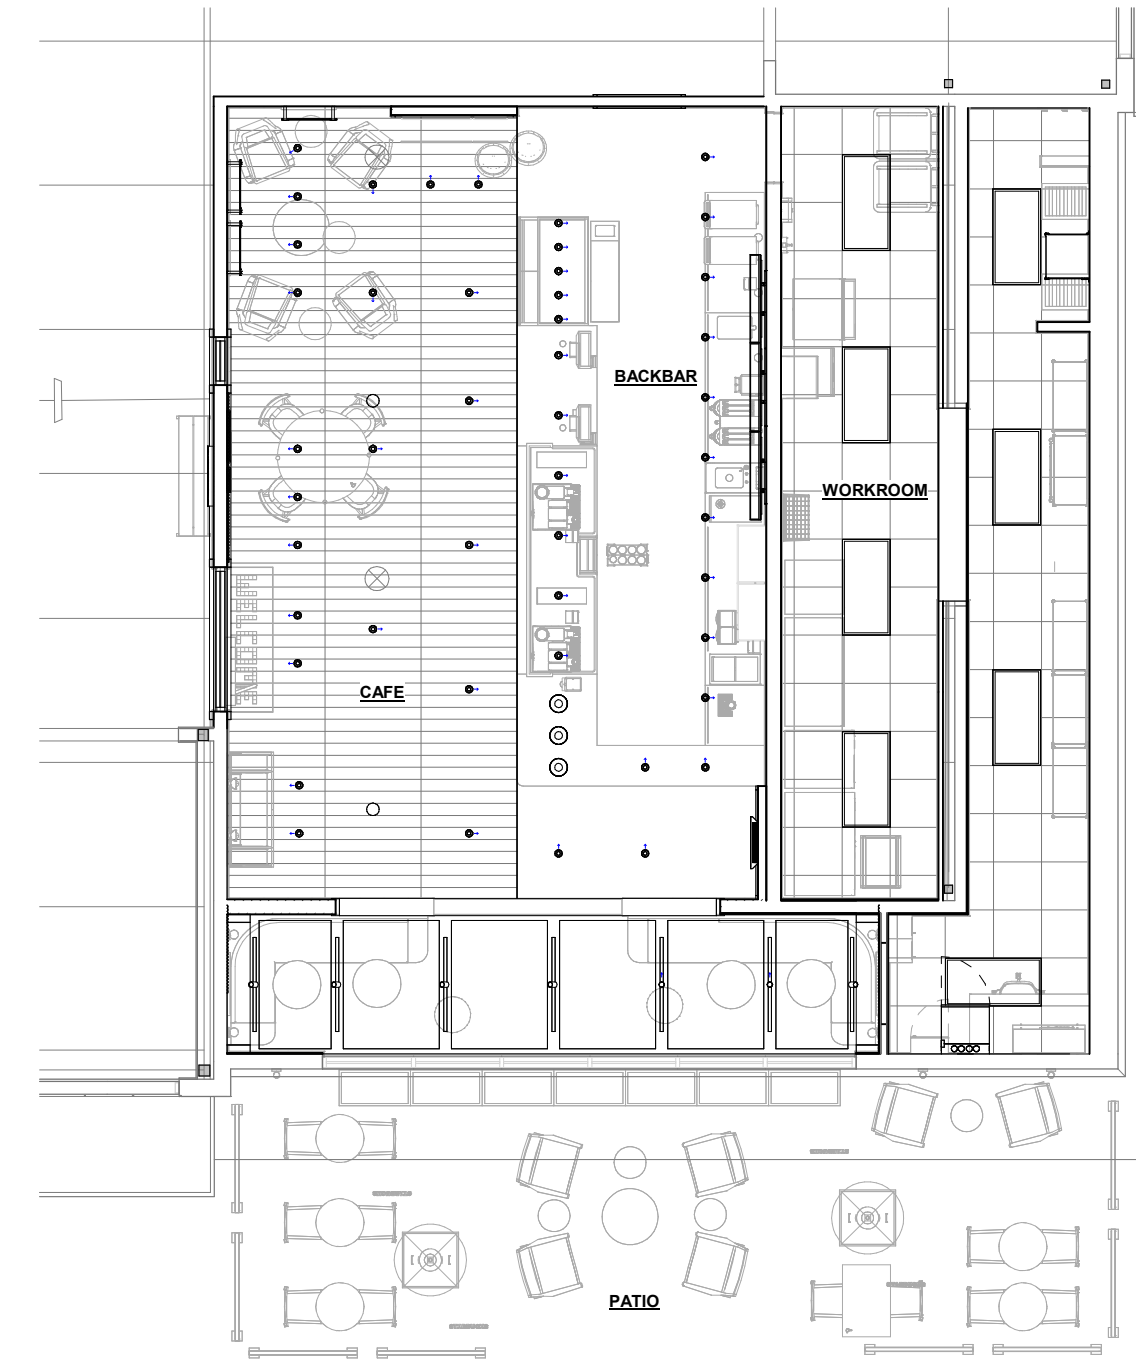

1 LIGHTING PLACEMENT PLAN
Scale: 1/4" = 1'-0"



DESIGN DEVELOPMENT ONLY - NOT INTENDED FOR CONSTRUCTION USE



STARBUCKS®
2401 UTAH AVENUE SOUTH
SEATTLE, WASHINGTON 98134
(206) 318-1575

THESE DRAWINGS AND THE PROJECT MANUAL ARE CONFIDENTIAL AND SHALL REMAIN THE SOLE PROPERTY OF STARBUCKS CORPORATION, WHICH IS THE OWNER OF THE COPYRIGHT IN THIS WORK. THEY SHALL NOT BE REPRODUCED (IN WHOLE OR IN PART), SHARED WITH THIRD PARTIES OR USED IN ANY MANNER ON OTHER PROJECTS OR EXTENSIONS TO THIS PROJECT WITHOUT THE PRIOR WRITTEN CONSENT OF STARBUCKS CORPORATION. THESE DRAWINGS AND SPECIFICATIONS ARE INTENDED TO EXPRESS DESIGN INTENT FOR A PROTOTYPICAL STARBUCKS STORE (WHICH IS SUBJECT TO CHANGE AT ANYTIME) AND DO NOT REFLECT ACTUAL SITE CONDITIONS. NEITHER PARTY SHALL HAVE ANY OBLIGATION NOR LIABILITY TO THE OTHER (EXCEPT STATED ABOVE) UNTIL A WRITTEN AGREEMENT IS FULLY EXECUTED BY BOTH PARTIES.

STARBUCKS TEMPLATE VERSION I2025.08.27

ARCHITECT OF RECORD

THIS DRAWING IS A DESIGN DEVELOPMENT DOCUMENT. SITE SPECIFIC MODIFICATIONS MADE UNDER THE RESPONSIBLE CHARGE OF THE ARCHITECT AND/OR ENGINEER-OF-RECORD WILL BE REQUIRED PRIOR TO USING THIS DOCUMENT FOR BIDDING, PERMITTING, OR CONSTRUCTION.

PROJECT NAME:
TA CORDELE

PROJECT ADDRESS:
**397 ROCKHOUSE RD E
CORDELE, GA 31015**

STORE #: TBD
PROJECT #: 108648-001
ISSUE DATE: 12/03/2025
DESIGN MANAGER: MANDY KENT
PRODUCTION DESIGNER: MAV
CHECKED BY: E. NORRIS

Revision Schedule			
Rev	Date	By	Description

SHEET TITLE:
**LIGHTING PLACEMENT
PLAN**

SCALE: AS SHOWN

SHEET NUMBER:
I104.1

FLOOR TREATMENT SCHEDULE - "T"					
DESIGN ID	AREA	DESCRIPTION	FURN. BY	INST. BY	COMMENTS
TILE					
24600	729 SF	TILE - LAB - CLAY - NATURAL - 12X24IN	GC	GC	GROUT: MAPEI 5047-CHARCOAL. GROUT BY GC. NO SUBSTITUTIONS ALLOWED WITHOUT PRIOR SUBMITTAL APPROVAL BY STARBUCKS. SUPPLIER: STONE SOURCE - LYDIA KURTH -lkurth@ceramictchnics.com
24601	160 SF	TILE - LAB - COAL - NATURAL - 12X24IN	GC	GC	GROUT: MAPEI 5010-BLACK. GROUT BY GC. NO SUBSTITUTIONS ALLOWED WITHOUT PRIOR SUBMITTAL APPROVAL BY STARBUCKS. SUPPLIER: STONE SOURCE - LYDIA KURTH -lkurth@ceramictchnics.com
24856	18 SF	TILE - LAB - CLAY - MOSAIC - 12X12IN 300X300MM SHEET	GC	GC	GROUT: MAPEI 5047-CHARCOAL. GROUT BY GC. NO SUBSTITUTIONS ALLOWED WITHOUT PRIOR SUBMITTAL APPROVAL BY STARBUCKS. SUPPLIER: STONE SOURCE - LYDIA KURTH -lkurth@ceramictchnics.com
24857	7 SF	TILE - LAB - COAL - MOSAIC - 12X12IN 300X300MM SHEET	GC	GC	GROUT: MAPEI 5010-BLACK. GROUT BY GC. NO SUBSTITUTIONS ALLOWED WITHOUT PRIOR SUBMITTAL APPROVAL BY STARBUCKS. SUPPLIER: STONE SOURCE - LYDIA KURTH -lkurth@ceramictchnics.com
X9200	440 SF	TILE - WORKROOM	GC	GC	GROUT BY GC. LOCALLY SOURCED. AOR TO SPECIFY QUARRY TILE.

WALL BASE SCHEDULE - "B"					
DESIGN ID	LENGTH	DESCRIPTION	FURN. BY	INST. BY	COMMENTS
TILE BASE					
11434	160' - 11"	TILE BASE - WORKROOM	GC	GC	LOCALLY SOURCED. AOR TO SPECIFY QUARRY TILE.
18740	207' - 1 3/4"	TILE BASE - PLAZA NOVA - BLACK SHADOW - 6X12IN 150X300MM	GC	GC	GROUT: MAPEI - 10 BLACK. GROUT BY GC. NO SUBSTITUTIONS ALLOWED WITHOUT PRIOR SUBMITTAL APPROVAL BY STARBUCKS. SUPPLIER: DAL TILE - CARL CHITWOOD - carl.chitwood@daltile.com

KEYED NOTES

- CABINET BASES TO BE SET BEFORE FLOOR TILE INSTALLATION.
- TILE INSTALLATION START POINT(S) WHERE INDICATED.
- FLOOR SINK LOCATION. SEE BUILDING FLOOR PENETRATION PLAN ON SHEET A102 AND PLUMBING FOR ADDITIONAL INFORMATION.
- RECESSED ELECTRICAL. SEE BUILDING FLOOR PENETRATION PLAN ON SHEET A102 AND ELECTRICAL FOR ADDITIONAL INFORMATION.

GENERAL NOTES


- GENERAL CONTRACTOR TO SUPPLY RETAIL AREA AND WORKROOM FLOOR TILE AND TILE BASE, UNLESS OTHERWISE NOTED. GENERAL CONTRACTOR TO INSTALL. GENERAL CONTRACTOR TO SUPPLY AND INSTALL MORTAR, ADHESIVE, AND GROUT. GENERAL CONTRACTOR TO INSPECT ALL TILES AND REJECT DAMAGED OR SUBSTANDARD TILES PRIOR TO INSTALLATION.
- ALL FLOORING AND BASE MATERIAL TO BE INSTALLED ACCORDING TO SPECIFICATIONS AND MANUFACTURER'S INSTALLATION REQUIREMENTS.
- ALIGN TILE TRANSITIONS ON WHOLE TILES WHERE POSSIBLE.
- TILE BASE AND THRESHOLD GROUT JOINTS TO ALIGN WITH TILE FLOOR GROUT JOINTS.
- PROVIDE GROUT JOINT OF 3/16" (5MM), MAXIMUM DEVIATION OF TILE AND GROUT LINE OF 1/4" (6MM) PER 48" (1220MM).
- ALL FLOOR AND WALL JUNCTIONS IN STORAGE AND FOOD PREPARATION AREAS SHALL HAVE A 6" COVED BASE.

LICENSED STORES RESPONSIBILITY LEGEND


- SB - STARBUCKS
FC - STARBUCKS FIXTURE CONTRACTOR
LC - LICENSEE
GC - LICENSEE'S GENERAL CONTRACTOR

FLOOR FINISH LEGEND


- INDICATES TILE BASE DID: 18740
INDICATES TILE BASE DID: 11434
INDICATES FLOOR TILE DID: 24600 AND DID: 24601
INDICATES FLOOR TILE DID: X9200
INDICATES FLOOR TILE DID: 24856 AND DID: 24857
DATUM POINT

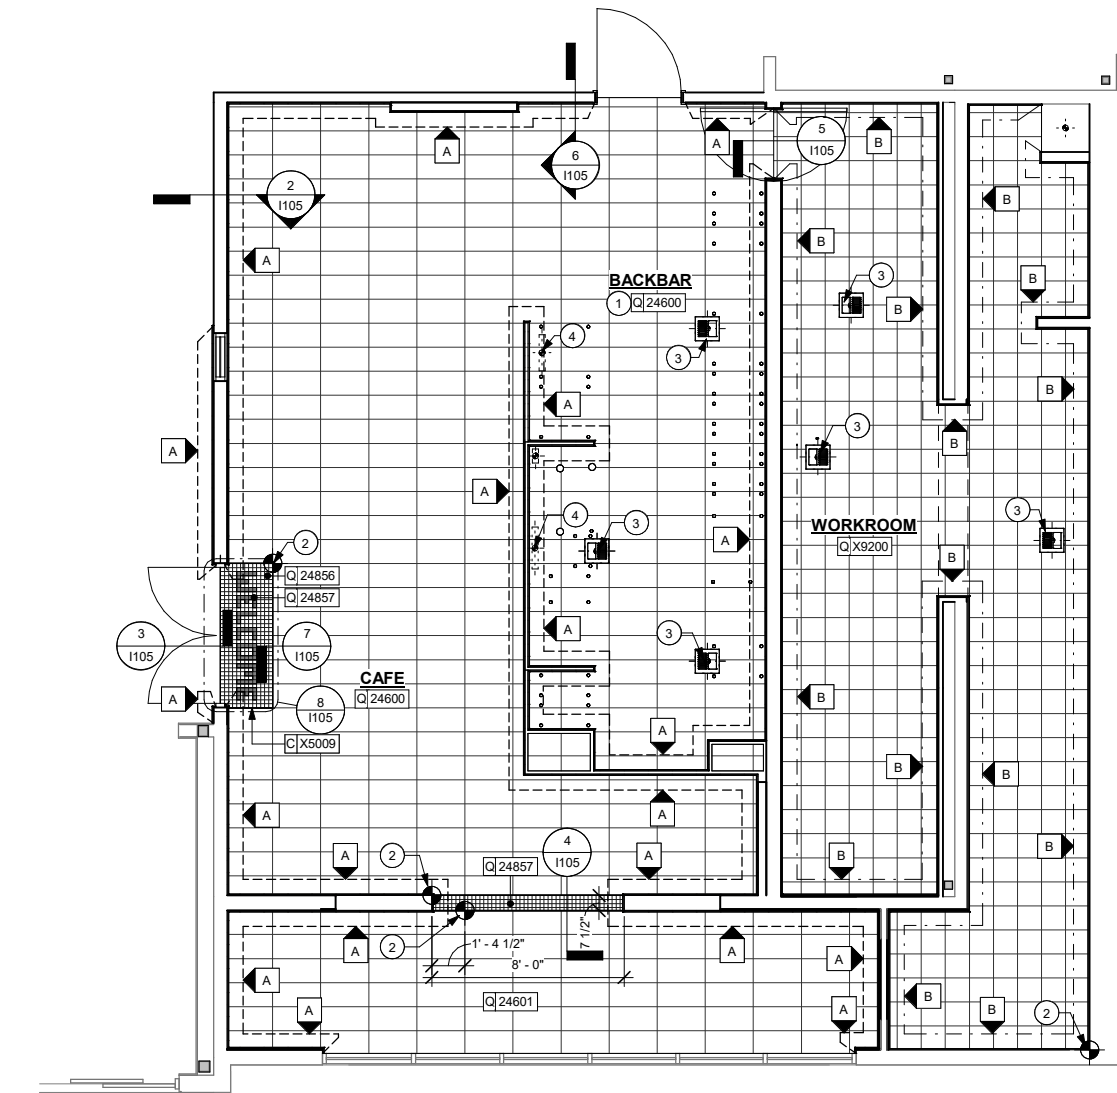


1 INTERIOR FLOOR FINISH PLAN
Scale: 1/4" = 1'-0"

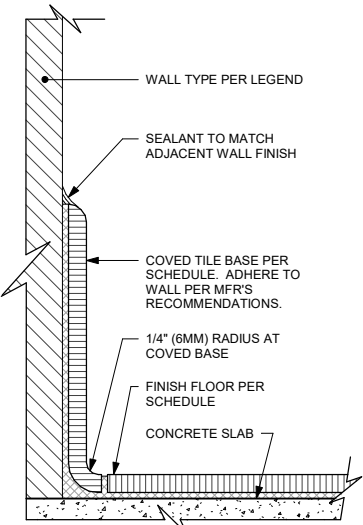


2 INTEGRAL TILE BASE AT WALL
Scale: 6\"/>

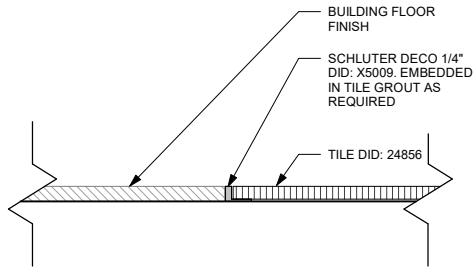


3 TRANSITION - TILE TO BUILDING FINISH
Scale: 3\"/>

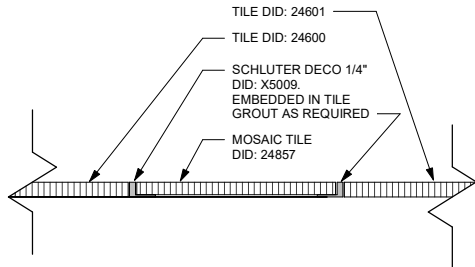


4 TRANSITION - MOSAIC TILE TO TILE
Scale: 3\"/>

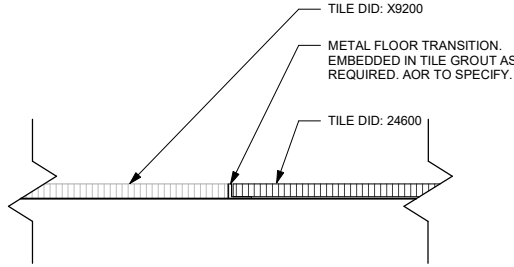


5 TRANSITION - TILE TO WORKROOM TILE
Scale: 3\"/>

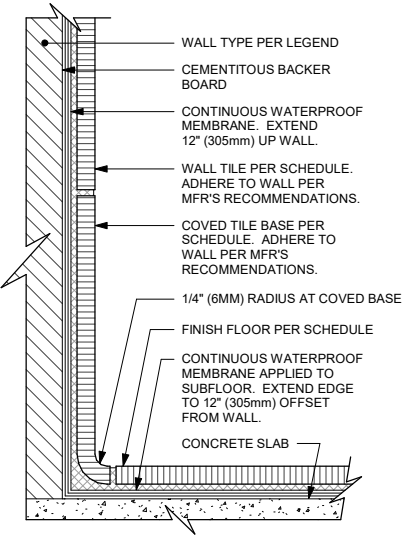

6 INTEGRAL TILE BASE AT TILED WALL
Scale: 6\"/>

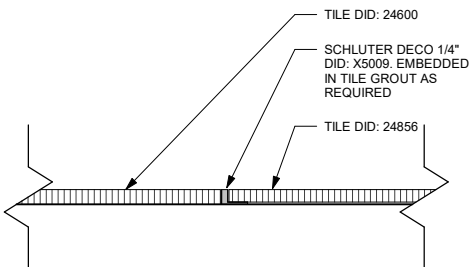

7 TRANSITION - CAFE TILE TO TILE
Scale: 3\"/>

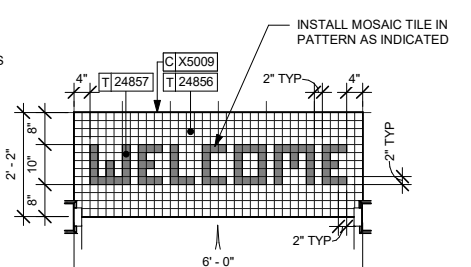

8 MOSAIC TILE DETAIL
Scale: 1/2\"/>



DESIGN DEVELOPMENT ONLY - NOT INTENDED FOR CONSTRUCTION USE



STARBUCKS®
2401 UTAH AVENUE SOUTH
SEATTLE, WASHINGTON 98134
(206) 318-1575

THESE DRAWINGS AND THE PROJECT MANUAL ARE CONFIDENTIAL AND SHALL REMAIN THE SOLE PROPERTY OF STARBUCKS CORPORATION, WHICH IS THE OWNER OF THE COPYRIGHT IN THIS WORK. THEY SHALL NOT BE REPRODUCED (IN WHOLE OR IN PART), SHARED WITH THIRD PARTIES OR USED IN ANY MANNER ON OTHER PROJECTS OR EXTENSIONS TO THIS PROJECT WITHOUT THE PRIOR WRITTEN CONSENT OF STARBUCKS CORPORATION. THESE DRAWINGS AND SPECIFICATIONS ARE INTENDED TO EXPRESS DESIGN INTENT FOR A PROTOTYPICAL STARBUCKS STORE (WHICH IS SUBJECT TO CHANGE AT ANYTIME) AND DO NOT REFLECT ACTUAL SITE CONDITIONS. NEITHER PARTY SHALL HAVE ANY OBLIGATION NOR LIABILITY TO THE OTHER (EXCEPT STATED ABOVE) UNTIL A WRITTEN AGREEMENT IS FULLY EXECUTED BY BOTH PARTIES.

STARBUCKS TEMPLATE VERSION I2025.08.27

ARCHITECT OF RECORD

THIS DRAWING IS A DESIGN DEVELOPMENT DOCUMENT. SITE SPECIFIC MODIFICATIONS MADE UNDER THE RESPONSIBLE CHARGE OF THE ARCHITECT AND/OR ENGINEER-OF-RECORD WILL BE REQUIRED PRIOR TO USING THIS DOCUMENT FOR BIDDING, PERMITTING, OR CONSTRUCTION.

PROJECT NAME:
TA CORDELE

PROJECT ADDRESS:
397 ROCKHOUSE RD E
CORDELE, GA 31015

STORE #: TBD
PROJECT #: 108648-001
ISSUE DATE: 12/03/2025
DESIGN MANAGER: MANDY KENT
PRODUCTION DESIGNER: MAV
CHECKED BY: E. NORRIS

Revision Schedule			
Rev	Date	By	Description

SHEET TITLE:
INTERIOR FLOOR FINISH PLAN
SCALE: AS SHOWN

SHEET NUMBER:
1105

WALL TREATMENT (AREA) SCHEDULE - "Q"					
DESIGN ID	AREA	DESCRIPTION	FURN. BY	INST. BY	COMMENTS
PLASTIC					
11469	2255 SF	FRP - WHITE	GC	GC	VERIFY TOTAL QUANTITY WITH CEILING TREATMENT AND WALL TREATMENT SCHEDULES
TILE					
24756	148 SF	TILE - MINI FORNACE - BRUNO BISTRO - 2.4X9.4IN 60X240MM	GC	GC	GROUT: MAPEI 5004-BAHAMA BEIGE. GROUT BY GC. NO SUBSTITUTIONS ALLOWED WITHOUT PRIOR SUBMITTAL APPROVAL BY STARBUCKS. SUPPLIER: DESIGN & DIRECT SOURCE - SUZZANE SANNING -ssanning@designdirectsource.com
24757	97 SF	TILE - MINI FORNACE - FORMELLA BRUNO BISTRO - 2.4X9.4IN 60X240MM	GC	GC	GROUT: MAPEI 5004-BAHAMA BEIGE. GROUT BY GC. NO SUBSTITUTIONS ALLOWED WITHOUT PRIOR SUBMITTAL APPROVAL BY STARBUCKS. SUPPLIER: DESIGN & DIRECT SOURCE - SUZZANE SANNING -ssanning@designdirectsource.com
WALL COVERING					
24759	517 SF	WALL COVERING - CAMBRIAN - ADVENTURINE	SB	GC	PROVIDE LEVEL 5 WALL FINISH.
X9400	181 SF	WALL COVERING - MOMENTUM - WOODS - RIFTED OAK	SB	GC	SKU: SWS-75. VERTICAL GRAIN. VENDOR: MOMENTUM TEXTILES - LANETTE ALLEN -lallen@momtex.com. SEND SAMPLE TO CASEWORK VENDOR TO COLOR MATCH. STARBUCKS TO APPROVE COLOR SAMPLE.

PAINT SCHEDULE					
DESIGN ID	DESCRIPTION	LRV	FURN. BY	INST. BY	COMMENTS
20438	SW7020 BLACK FOX	8	GC	GC	
20441	SW7031 MEGA GREIGE	37	GC	GC	
X9000	BLACK TO MATCH STOREFRONT SYSTEM		GC	GC	

ACOUSTIC WALL PANEL SCHEDULE - "F"					
DESIGN ID	COUNT	DESCRIPTION	FURN. BY	INST. BY	COMMENTS
OTHER					
X6007	6	ACOUSTIC WALL PANEL - ZINTRA - EMBOSSED - CORDUROY - COLOR: ECRU	GC	GC	CONTACT: MDC - starbucks@mdowall.com - LONG LEAD ITEM.

KEYED NOTES

- INSTALL METAL CORNER GUARDS WHERE INDICATED IN WORKROOM. MOUNT AT 6" (1500MM) AFF. AFFIX WITH #6 STAINLESS STEEL OVAL HEAD SCREWS, 3" (75MM) FROM ENDS AND 12" (305MM) ON CENTER. OFFSET SCREWS ON EITHER SIDE BY 1/2" (10MM) VERTICALLY. SEE SPECIALTY EQUIPMENT SCHEDULE.
- GENERAL CONTRACTOR TO PROVIDE AND INSTALL FRP WALL FINISH BEHIND CASEWORK CABINETRY IN AREAS BELOW COUNTERTOP HEIGHT.
- SEE INTERIOR FINISH ELEVATIONS FOR FULL EXTENT OF BACK BAR WALL TILE.
- BACK BAR WALL TILE TO BE INSTALLED IN VERTICAL STACKED PATTERN.
- GENERAL CONTRACTOR TO PROVIDE FIRE TREATED WOOD STUD BLOCKING AS REQUIRED TO SUPPORT ANY WALL ATTACHMENTS. SEE BUILDING FLOOR PLAN SHEET A101 FOR MORE INFORMATION.
- LICENSEE FINISH.

GENERAL NOTES



- GENERAL CONTRACTOR TO PATCH AND REPAIR ANY DAMAGE TO EXISTING WALLS TO A SMOOTH, PAINT READY SURFACE PRIOR TO PAINTING.
- FLOORS, WALLS, AND CEILING FINISHES IN FOOD PREPARATION AREAS SHALL BE SMOOTH, NON-TOXIC, NON-ABSORBENT, DURABLE, AND EASILY CLEANABLE. PAINT IN THESE AREAS SHALL BE WASHABLE, SEMI-GLOSS OR HIGH-GLOSS FINISH.
- CHANGE OF PAINT COLOR ONLY AT INSIDE CORNERS, UNLESS NOTED OTHERWISE.
- PAINT SUBSTITUTIONS ARE NOT ALLOWED. USE STARBUCKS NATIONAL SHERWIN WILLIAMS ACCOUNT "COLOR CODE" WHEN ORDERING PAINTS.
- PAINT FINISHES SHALL BE APPLIED AS FOLLOWS, UNLESS NOTED OTHERWISE:
 - WOOD AND METAL SURFACES SHALL BE SEMI-GLOSS OR EQUAL.
 - ACCENT AND TRIM PAINTS TO BE SEMI-GLOSS OR EQUAL.
 - WALL AND CEILING PAINTS TO BE EGGSHELL OR EQUAL.
 - PAINTS IN WORKROOM, RESTROOM(S), OR CAFE BAR SHALL BE SEMI-GLOSS EQUAL.
- WORKROOM TO BE FINISHED PER LOCAL CODE. GENERAL CONTRACTOR TO PROVIDE AND INSTALL WORKROOM WALL FINISHES.
- ALL WOOD SURFACES (DOORS, TRIM, SHELVES, CABINETRY, ETC.) SHALL BE SEALED.
- REFER TO INTERIOR FINISH ELEVATIONS FOR PAINT COLOR, ARTWORK, AND GRAPHICS LOCATIONS.
- GENERAL CONTRACTOR TO INSTALL WALL BLOCKING AND HANGERS FOR WALL SHELVING BEFORE INSTALLING BACK BAR WALL TILE.

WALL TREATMENT LEGEND


- A --- INDICATES WALL TILE DID: 24756 TO 7'-0" AND WALL TILE DID: 24757 ABOVE (AND FRP DID: 11469 BELOW COUNTERTOPS)*
- B --- INDICATES ACOUSTICAL PANELS DID: X6007*
- C --- INDICATES WALL COVERING DID: 24759*
- D --- INDICATES WOOD WALL COVERING DID: X9400*
- E --- INDICATES PAINTED FINISH DID: 20441*
- F --- INDICATES FRP DID: 11469*
- INDICATES STAINLESS STEEL CORNER GUARD FOR BOH OR HOT ROLLED STEEL CORNER GUARD FOR CAFE SPACE. INSTALL 6" (150mm) TO 42" (1065mm) AFF UNLESS OTHERWISE NOTED.
- * SEE INTERIOR FINISH ELEVATIONS FOR TAGGED LOCATION OF WALL FINISH MATERIAL.

LICENSED STORES RESPONSIBILITY LEGEND


- SB - STARBUCKS
- FC - STARBUCKS FIXTURE CONTRACTOR
- LC - LICENSEE
- GC - LICENSEE'S GENERAL CONTRACTOR

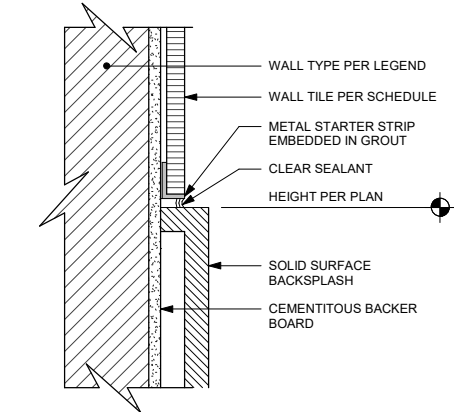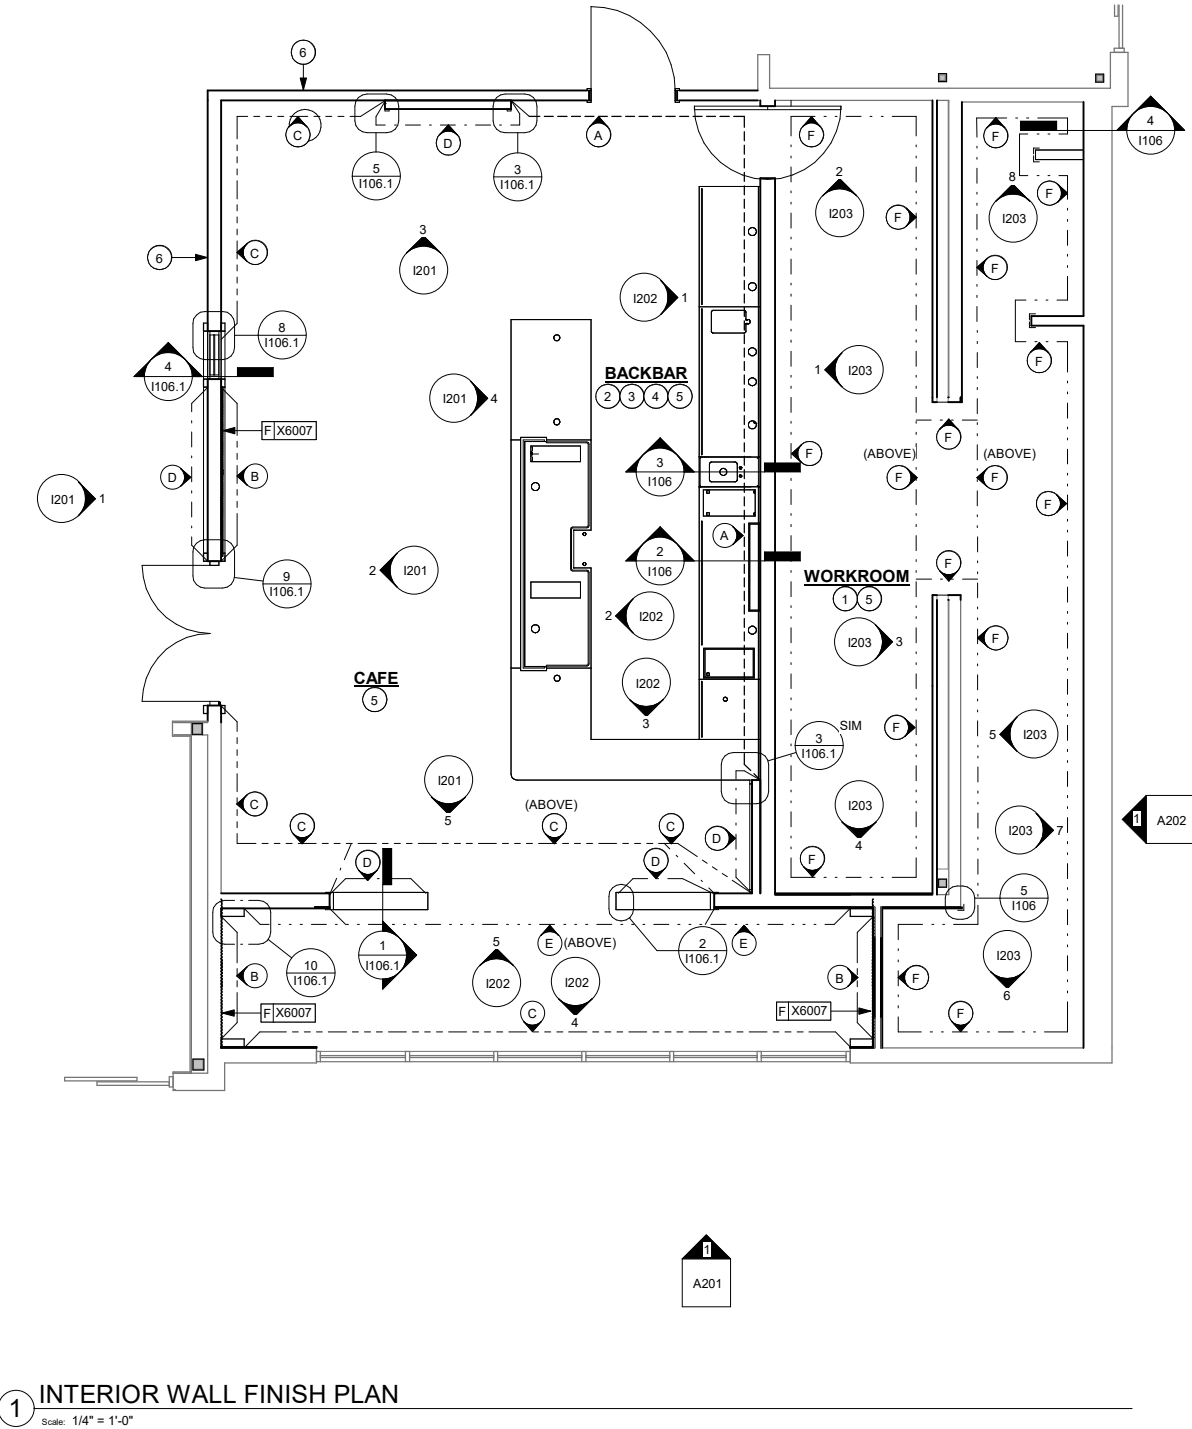


2 SS BACKSPASH TO TILE TRANSITION
Scale: 6" = 1'-0"

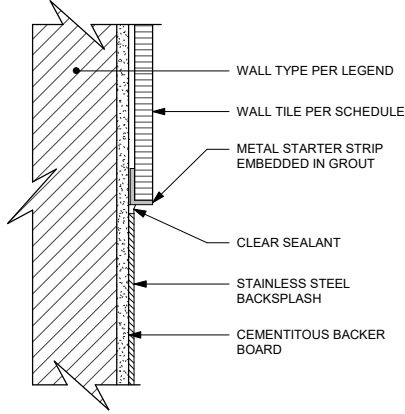


3 SST BACKSPASH TO TILE TRANSITION
Scale: 6" = 1'-0"

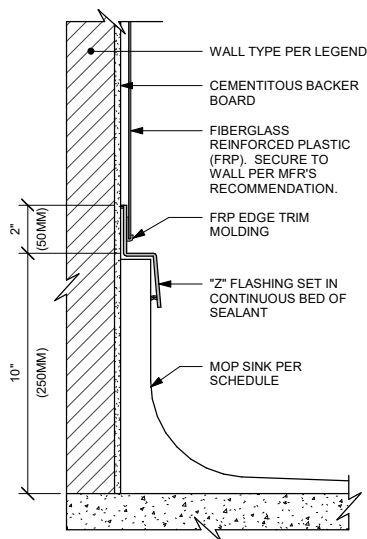

4 MOP SINK WITHOUT FLANGE
Scale: 3" = 1'-0"

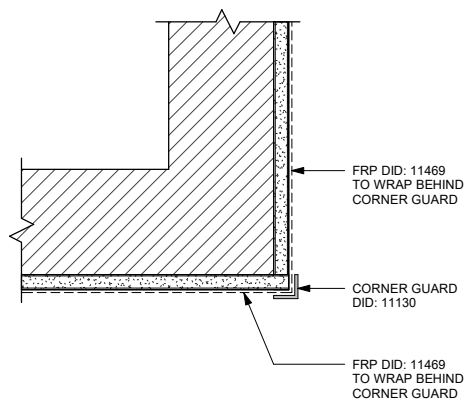

5 CORNER GUARD DETAIL
Scale: 3" = 1'-0"

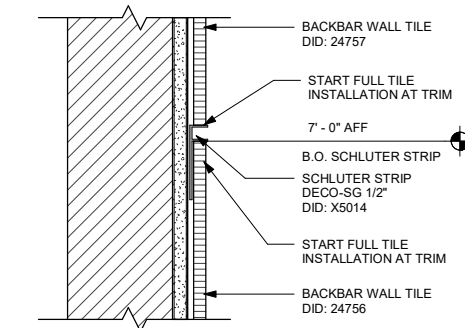

6 WALL TILE TRANSITION DETAIL
Scale: 3" = 1'-0"



DESIGN DEVELOPMENT ONLY - NOT INTENDED FOR CONSTRUCTION USE



STARBUCKS®
2401 UTAH AVENUE SOUTH
SEATTLE, WASHINGTON 98134
(206) 318-1575

THESE DRAWINGS AND THE PROJECT MANUAL ARE CONFIDENTIAL AND SHALL REMAIN THE SOLE PROPERTY OF STARBUCKS CORPORATION, WHICH IS THE OWNER OF THE COPYRIGHT IN THIS WORK. THEY SHALL NOT BE REPRODUCED (IN WHOLE OR IN PART), SHARED WITH THIRD PARTIES OR USED IN ANY MANNER ON OTHER PROJECTS OR EXTENSIONS TO THIS PROJECT WITHOUT THE PRIOR WRITTEN CONSENT OF STARBUCKS CORPORATION. THESE DRAWINGS AND SPECIFICATIONS ARE INTENDED TO EXPRESS DESIGN INTENT FOR A PROTOTYPICAL STARBUCKS STORE (WHICH IS SUBJECT TO CHANGE AT ANYTIME) AND DO NOT REFLECT ACTUAL SITE CONDITIONS. NEITHER PARTY SHALL HAVE ANY OBLIGATION NOR LIABILITY TO THE OTHER (EXCEPT STATED ABOVE) UNTIL A WRITTEN AGREEMENT IS FULLY EXECUTED BY BOTH PARTIES.

STARBUCKS TEMPLATE VERSION I02025.08.27

ARCHITECT OF RECORD

THIS DRAWING IS A DESIGN DEVELOPMENT DOCUMENT. SITE SPECIFIC MODIFICATIONS MADE UNDER THE RESPONSIBLE CHARGE OF THE ARCHITECT AND/OR ENGINEER-OF-RECORD WILL BE REQUIRED PRIOR TO USING THIS DOCUMENT FOR BIDDING, PERMITTING, OR CONSTRUCTION.

PROJECT NAME:
TA CORDELE

PROJECT ADDRESS:
397 ROCKHOUSE RD E
CORDELE, GA 31015

STORE #: TBD
PROJECT #: 108648-001
ISSUE DATE: 12/03/2025
DESIGN MANAGER: MANDY KENT
PRODUCTION DESIGNER: MAV
CHECKED BY: E. NORRIS


Revision Schedule			
Rev	Date	By	Description

SHEET TITLE:
INTERIOR WALL FINISH PLAN

SCALE: AS SHOWN

SHEET NUMBER:

 1106




DESIGN DEVELOPMENT ONLY - NOT INTENDED FOR CONSTRUCTION USE

GRAPHICS AND ARTWORK SCHEDULE - "G"					
DESIGN ID	COUNT	DESCRIPTION	FURN. BY	INST. BY	COMMENTS
GRAPHICS - ARTWORK					
17216	1	ART - UNKNOWN ARTIST - GREEN BEAN CLOSEUP	SB	GC	FRAME WITHOUT MAT - ART SIZE 10.75"W X 16"H - OVERALL SIZE 12.25"W X 17.5"H - PAPER 1 - FRAME 1C 613677 NATURAL MAPLE - 1/4" SPACER
19148	1	ART - CREATIVE STUDIO - COSTA RICA 6 - BW	SB	GC	FRAME WITHOUT MAT - ART SIZE 21.5"W X 21.5"H - OVERALL SIZE 23"W X 23"H - PAPER 1 - FRAME 1C 613677 NATURAL MAPLE - 1/4" SPACER. CROP AS INDICATED.
19181	1	ART - CREATIVE STUDIO - HACIENDA ALSACIA 6 - COLOR	SB	GC	FRAME WITHOUT MAT - ART SIZE 24"W X 16"H - OVERALL SIZE 25.5"W X 17.5"H - PAPER 1 - FRAME 1C 613677 NATURAL MAPLE - 1/4" SPACER
22080	1	ART - JOSHUA TRUJILLO - COSTA RICA 6 - COLOR	SB	GC	FRAME WITHOUT MAT - ART SIZE 22"W X 14.5"H - OVERALL SIZE 23.5"W X 16"H - PAPER 1 - FRAME 1C 613677 NATURAL MAPLE - 1/4" SPACER
24443	1	ART - LILY CHOU - SEATTLE ROASTERY - 7 - BW	SB	GC	FRAMED WITH MAT - ART SIZE 20"W X 30"H - MAT BORDER 3" - OVERALL SIZE 27.5" W X 37.5" H - PAPER 1 - MAT 1 - FRAME 1C 613677 NATURAL MAPLE
24448	1	ART - LILY CHOU - SEATTLE ROASTERY - 4 - BW	SB	GC	FRAMED WITH MAT - ART SIZE 20"W X 30"H - MAT BORDER 3" - OVERALL SIZE 27.5" W X 37.5" H - PAPER 1 - MAT 1 - FRAME 1C 613677 NATURAL MAPLE
24452	1	ART - LILY CHOU - SEATTLE ROASTERY - 2 - BW	SB	GC	FRAMED WITH MAT - ART SIZE 20"W X 30"H - MAT BORDER 3" - OVERALL SIZE 27.5" W X 37.5" H - PAPER 1 - MAT 1 - FRAME 1C 613677 NATURAL MAPLE
24641	1	ART - KIMBERLY TROWBRIDGE - PERU FROM MACHU PICCHU	SB	GC	WRAPPED CANVAS IN FLOAT FRAME - ART SIZE 29"W X 29"H - REVEAL .25" - PRINT TO EDGES - PRINT EDGES BLACK - OVERALL SIZE 30"W X 30"H - CANVAS 1 - FRAME 3C 623677 NATURAL MAPLE
24642	1	ART - KIMBERLY TROWBRIDGE - PERU FROM MACHU PICCHU SKETCH	SB	GC	FRAME WITHOUT MAT - ART SIZE 8"W X 12"H - OVERALL SIZE 9.5"W X 13.5"H - PAPER 1 - FRAME 1C 613677 NATURAL MAPLE - 1/4" SPACER
24644	1	ART - KIMBERLY TROWBRIDGE - COFFEE WITH PERUVIAN LLAMAS SKETCH	SB	GC	FRAME WITHOUT MAT - ART SIZE 8"W X 12"H - OVERALL SIZE 9.5"W X 13.5"H - PAPER 1 - FRAME 1C 613677 NATURAL MAPLE - 1/4" SPACER. THIS IMAGE CANNOT BE CROPPED
24690	1	ART - REBECCA ZWANZIG - YOUNG COFFEE CHERRY FRACTAL	SB	GC	FRAMED WITH MAT - ART SIZE 24"W X 30"H - MAT BORDER 3" - OVERALL SIZE 31.5" W X 36.5" H - PAPER 1 - MAT 1 - FRAME 1C 613677 NATURAL MAPLE. THIS IMAGE CANNOT BE CROPPED


GRAPHICS AND ARTWORK SCHEDULE - "G"					
DESIGN ID	COUNT	DESCRIPTION	FURN. BY	INST. BY	COMMENTS
24691	1	ART - REBECCA ZWANZIG - COFFEE FLOWER FRACTAL	SB	GC	FRAMED WITH MAT - ART SIZE 24" W X 30" H - MAT BORDER 3" - OVERALL SIZE 31.5" W X 36.5" H - PAPER 1 - MAT 1 - FRAME 1C 613677 NATURAL MAPLE. THIS IMAGE CANNOT BE CROPPED
GRAPHICS - OTHER					
23136	1	AUTOMATIC DOOR CAUTION SIGNAGE	GC	GC	

SIGNAGE SCHEDULE - "S"					
DESIGN ID	COUNT	DESCRIPTION	FURN. BY	INST. BY	COMMENTS
SIGNAGE - DISK					
13164	2	SIGN - DISK SF ILLUMINATED FLUSH MOUNTED EVOLVED - 60IN 1525MM	SB	SB	
13193	1	SIGN - DISK SF ILLUMINATED FLUSH MOUNTED EVOLVED - 30IN 760MM	SB	SB	

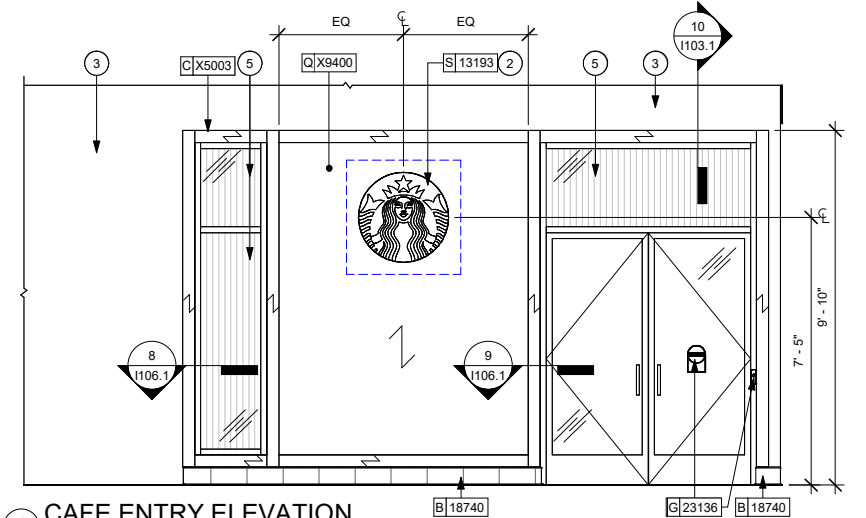


1 CAFE ENTRY ELEVATION

Scale: 3/8" = 1'-0"

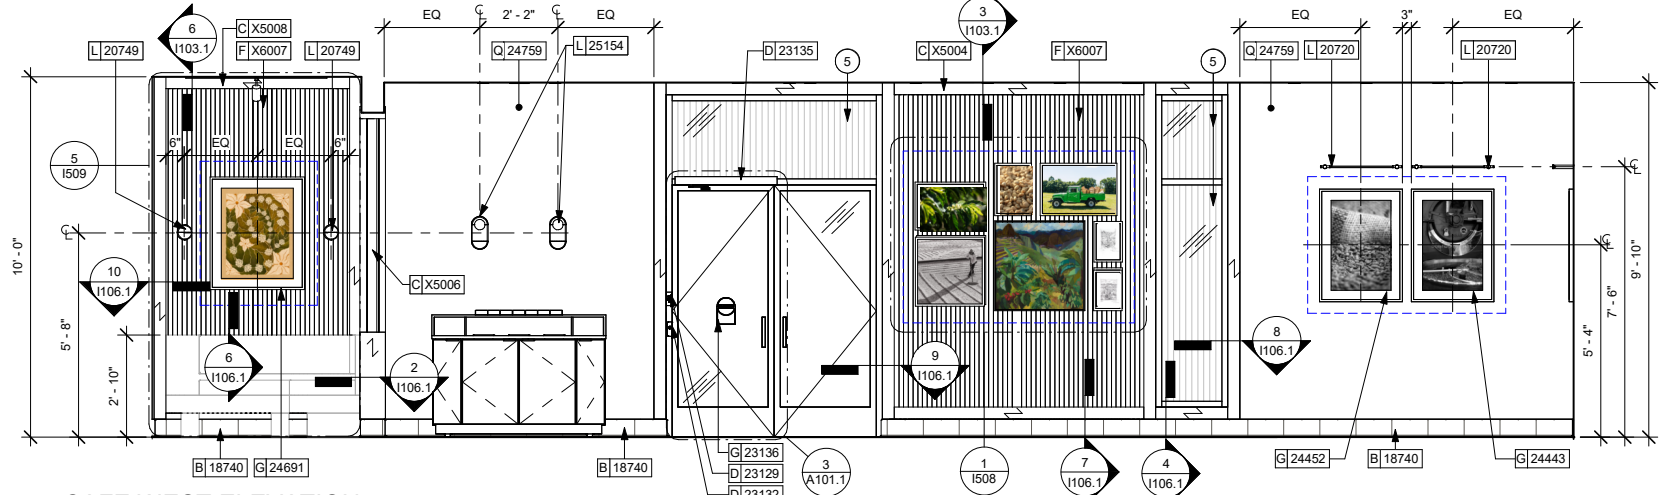


2 CAFE WEST ELEVATION

Scale: 3/8" = 1'-0"

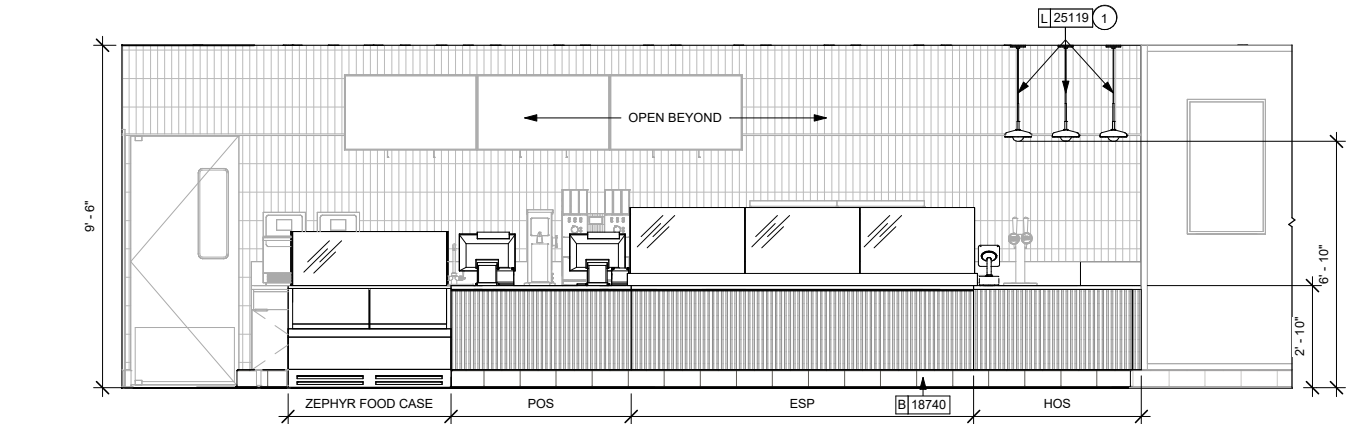


4 FRONTBAR ELEVATION

Scale: 3/8" = 1'-0"

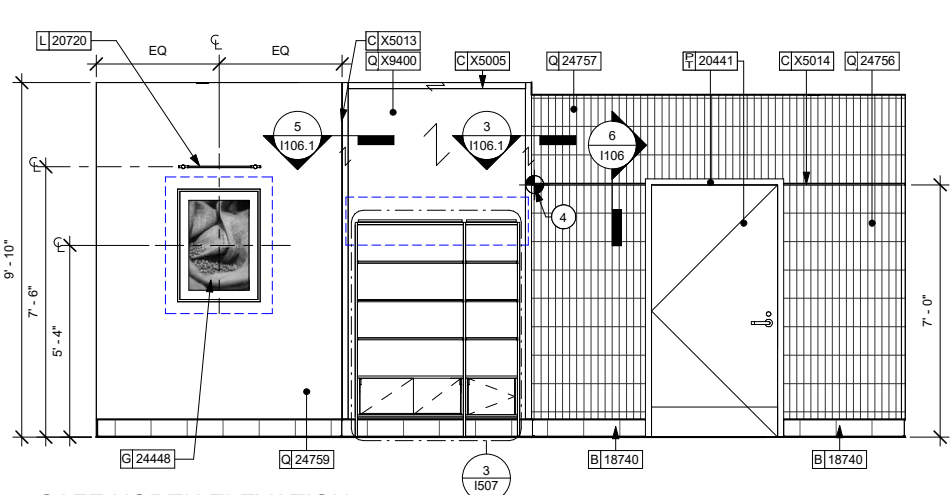

3 CAFE NORTH ELEVATION

Scale: 3/8" = 1'-0"

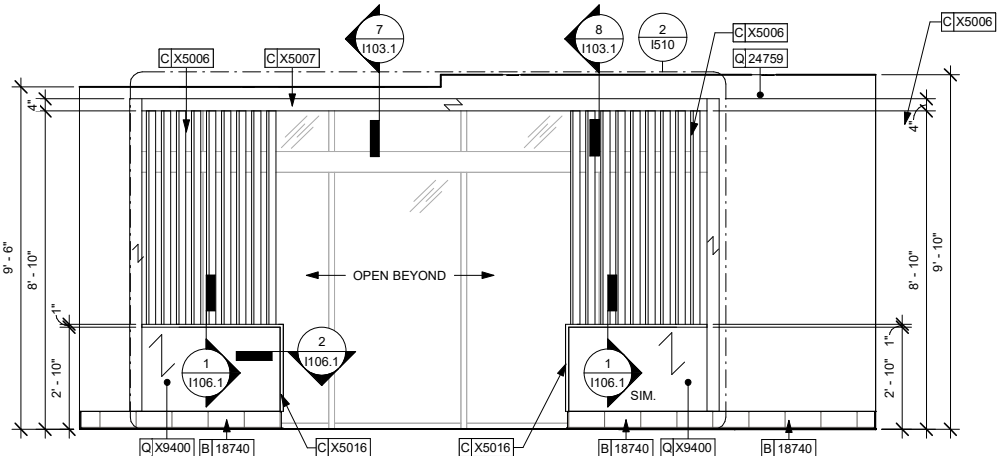

5 CAFE SOUTH ELEVATION

Scale: 3/8" = 1'-0"

KEYED NOTES

- PENDANT LIGHT FIXTURE. SEE REFLECTED CEILING PLAN ON SHEET I103 AND LIGHTING PLAN ON SHEET E102 FOR ADDITIONAL INFORMATION.
- STARBUCKS DESIGN MANAGER TO COORDINATE SIGNAGE PROPOSAL WITH VENDOR.
- FINISH BY LICENSEE.
- INSTALL FULL TILE ABOVE AND BELOW METAL TRIM; SEE DETAIL FOR ADDITIONAL INFORMATION.
- AOR TO SPECIFY FLUTED GLASS WHERE INDICATED. TORSTENSON GLASS - SKYTEX OR SIMILAR. STARBUCKS DESIGN TO APPROVE FINAL SPEC.

GENERAL NOTES

- FLOORS, WALL, AND CEILING FINISHES IN FOOD PREPARATION AREAS SHALL BE SMOOTH, NON-TOXIC, NON-ABSORBENT, DURABLE, AND EASILY CLEANABLE. PAINT IN THESE AREAS SHALL BE WASHABLE; SEMI-GLOSS OR HIGH GLOSS FINISH.
- CHANGE OF PAINT COLOR ONLY AT INSIDE CORNERS, UNLESS NOTED OTHERWISE.
- PAINT SUBSTITUTIONS ARE NOT ALLOWED. USE STARBUCKS NATIONAL SHERWIN WILLIAMS ACCOUNT "COLOR CODE" WHEN ORDERING PAINTS.
- PAINT FINISHES SHALL BE APPLIED AS FOLLOWS, UNLESS NOTED OTHERWISE:
 - WOODS AND METAL SURFACES SHALL BE SEMI-GLOSS OR EQUAL.
 - ACCENT AND TRIM PAINTS SHALL BE SEMI-GLOSS OR EQUAL.
 - WALL AND CEILING PAINTS SHALL BE EGGSHELL OR EQUAL.
 - PAINTS IN WORKROOM RESTROOM(S) OR CAFE BAR SHALL BE SEMI-GLOSS OR EQUAL.
- REFER TO INTERIOR WALL FINISH PLAN SHEET I106 FOR PAINT SCHEDULES AND WALL FINISH SCHEDULE.
- WORKROOM TO BE FINISHED PER LOCAL CODE. GENERAL CONTRACTOR TO PROVIDE AND INSTALL WORKROOM WALL FINISHES.
- ALL WOOD SURFACES (DOORS, TRIM, SHELVES, CABINETRY) SHALL BE SEALED.
- ALL FLOOR AND WALL JUNCTIONS IN STORAGE AND FOOD PREPARATION AREAS SHALL HAVE A 6" COVED BASE.
- GENERAL CONTRACTOR TO INSTALL WALL BLOCKING AND HANGERS FOR WALL SHELVING BEFORE INSTALLING BACK BAR WALL TILE.
- REFER TO MANUFACTURER'S INSTRUCTIONS INCLUDED WITH ARTWORK / GRAPHICS FOR PROPER INSTALLATION.

LEGEND

- INDICATES WALL BLOCKING.
FIRE TREATED WALL BLOCKING TO BE PROVIDED AS REQUIRED TO SUPPORT WALL ATTACHMENTS. EXTEND BLOCKING 4" (100mm) BEYOND EDGE OF ATTACHMENTS.

LICENSED STORES RESPONSIBILITY LEGEND

- SB - STARBUCKS
FC - STARBUCKS FIXTURE CONTRACTOR
LC - LICENSEE
GC - LICENSEE'S GENERAL CONTRACTOR

DESIGN DEVELOPMENT ONLY - NOT INTENDED FOR CONSTRUCTION USE



STARBUCKS®
2401 UTAH AVENUE SOUTH
SEATTLE, WASHINGTON 98134
(206) 318-1575

THESE DRAWINGS AND THE PROJECT MANUAL ARE CONFIDENTIAL AND SHALL REMAIN THE SOLE PROPERTY OF STARBUCKS CORPORATION, WHICH IS THE OWNER OF THE COPYRIGHT IN THIS WORK. THEY SHALL NOT BE REPRODUCED (IN WHOLE OR IN PART), SHARED WITH THIRD PARTIES OR USED IN ANY MANNER ON OTHER PROJECTS OR EXTENSIONS TO THIS PROJECT WITHOUT THE PRIOR WRITTEN CONSENT OF STARBUCKS CORPORATION. THESE DRAWINGS AND SPECIFICATIONS ARE INTENDED TO EXPRESS DESIGN INTENT FOR A PROTOTYPICAL STARBUCKS STORE (WHICH IS SUBJECT TO CHANGE AT ANYTIME) AND DO NOT REFLECT ACTUAL SITE CONDITIONS. NEITHER PARTY SHALL HAVE ANY OBLIGATION NOR LIABILITY TO THE OTHER (EXCEPT STATED ABOVE) UNTIL A WRITTEN AGREEMENT IS FULLY EXECUTED BY BOTH PARTIES.

STARBUCKS TEMPLATE VERSION I2025.08.27

ARCHITECT OF RECORD

THIS DRAWING IS A DESIGN DEVELOPMENT DOCUMENT. SITE SPECIFIC MODIFICATIONS MADE UNDER THE RESPONSIBLE CHARGE OF THE ARCHITECT AND/OR ENGINEER-OF-RECORD WILL BE REQUIRED PRIOR TO USING THIS DOCUMENT FOR BIDDING, PERMITTING, OR CONSTRUCTION.

PROJECT NAME:
TA CORDELE

PROJECT ADDRESS:
397 ROCKHOUSE RDE
CORDELE, GA 31015

STORE #: TBD
PROJECT #: 108648-001
ISSUE DATE: 12/03/2025
DESIGN MANAGER: MANDY KENT
PRODUCTION DESIGNER: MAV
CHECKED BY: E. NORRIS

Revision Schedule

Rev	Date	By	Description

SHEET TITLE:
INTERIOR FINISH ELEVATIONS

SCALE: AS SHOWN

SHEET NUMBER:

1201



THESE DRAWINGS AND THE PROJECT MANUAL ARE CONFIDENTIAL AND SHALL REMAIN THE SOLE PROPERTY OF STARBUCKS CORPORATION, WHICH IS THE OWNER OF THE COPYRIGHT IN THIS WORK. THEY SHALL NOT BE REPRODUCED (IN WHOLE OR IN PART), SHARED WITH THIRD PARTIES OR USED IN ANY MANNER THAT COULD SUBJECT OR BE SUBJECT TO EXTENSIONS TO THIS PROJECT WITHOUT THE PRIOR WRITTEN CONSENT OF STARBUCKS CORPORATION. THESE DRAWINGS AND SPECIFICATIONS ARE INTENDED TO EXPRESS DESIGN INTENT FOR A PROTOTYPICAL STARBUCKS STORE (WHICH IS SUBJECT TO CHANGE AT ANYTIME) AND DO NOT REFLECT ACTUAL SITE CONDITIONS. NEITHER PARTY SHALL BE RESPONSIBLE TO THE OTHER (EXCEPT STATED ABOVE) UNTIL A WRITTEN AGREEMENT IS FULLY EXECUTED BY BOTH PARTIES.

ARCHITECT OF RECORD

THIS DRAWING IS A DESIGN
DEVELOPMENT DOCUMENT.
SITE SPECIFIC MODIFICATIONS
MADE UNDER THE RESPONSIBLE
CHARGE OF THE ARCHITECT
AND/OR ENGINEER-OF-RECORD
WILL BE REQUIRED PRIOR TO
USING THIS DOCUMENT FOR
BIDDING, PERMITTING, OR
CONSTRUCTION.

PROJECT ADDRESS:
3397 ROCKHOUSE RD E
CORDELE, GA 31015

Revision Schedule

SHEET TITLE:

SCALE: AS SHOWN

1202


DESIGN DEVELOPMENT ONLY - NOT INTENDED FOR CONSTRUCTION USE

1. ATTACH MENU BOARDS PER INSTALLATION DETAILS.
2. SHELVING FOR CBE STATION AS SHOWN. GENERAL CONTRACTOR TO PROVIDE WALL BLOCKING FOR FASTENERS.
3. GENERAL CONTRACTOR TO PROVIDE AND INSTALL FRP WALL FINISH BEHIND CASEWORK CABINETS IN AREAS BELOW COUNTERTOP HEIGHT.
4. PENDANT LIGHT FIXTURE. SEE REFLECTED CEILING PLAN ON SHEET I103 AND LIGHTING PLAN ON SHEET E102 FOR ADDITIONAL INFORMATION.
5. INSTALL FULL TILE ABOVE AND BELOW METAL TRIM; SEE DETAIL FOR ADDITIONAL INFORMATION.

- A. FLOORS, WALL, AND CEILING FINISHES IN FOOD PREPARATION AREAS SHALL BE SMOOTH, NON-TOXIC, NON-ABSORBENT, DURABLE, AND EASILY CLEANABLE. PAINT IN THESE AREAS SHALL BE WASHABLE; SEMI-GLOSS OR HIGH GLOSS FINISH.
- B. CHANGE OF PAINT COLOR ONLY AT INSIDE CORNERS, UNLESS NOTED OTHERWISE.
- C. PAINT SUBSTITUTIONS ARE NOT ALLOWED. USE STARBUCKS NATIONAL SHERWIN WILLIAMS ACCOUNT "COLOR CODE" WHEN ORDERING PAINTS.
- D. PAINT FINISHES SHALL BE APPLIED AS FOLLOWS, UNLESS NOTED OTHERWISE:
 - 1) WOODS AND METAL SURFACES SHALL BE SEMI-GLOSS OR EQUAL.
 - 2) ACCENT AND TRIM PAINTS SHALL BE SEMI-GLOSS OR EQUAL.
 - 3) WALL AND CEILING PAINTS SHALL BE EGGSHELL OR EQUAL.
 - 4) PAINTS IN WORKROOM RESTROOM(S) OR CAFE BAR SHALL BE SEMI-GLOSS OR EQUAL.
- E. REFER TO INTERIOR WALL FINISH PLAN SHEET I106 FOR PAINT SCHEDULE AND WALL FINISH SCHEDULE.
- F. WORKROOM TO BE FINISHED PER LOCAL CODE. GENERAL CONTRACTOR TO PROVIDE AND INSTALL WORKROOM WALL FINISHES.
- G. ALL WOOD SURFACES (DOORS, TRIM, SHELVES, CABINETRY) SHALL BE SEALED.
- H. ALL FLOOR AND WALL JUNCTIONS IN STORAGE AND FOOD PREPARATION AREAS SHALL HAVE A 6" COVED BASE.
- I. GENERAL CONTRACTOR TO INSTALL WALL BLOCKING AND HANGERS FOR WALL SHELVING BEFORE INSTALLING BACK BAR WALL TILE.
- J. REFER TO MANUFACTURER'S INSTRUCTIONS INCLUDED WITH ARTWORK / GRAPHICS FOR PROPER INSTALLATION


INDICATES WALL BLOCKING.
FIRE TREATED WALL BLOCKING TO BE
PROVIDED AS REQUIRED TO SUPPORT WALL
ATTACHMENTS. EXTEND BLOCKING 4" (100mm)
BEYOND EDGE OF ATTACHMENTS.



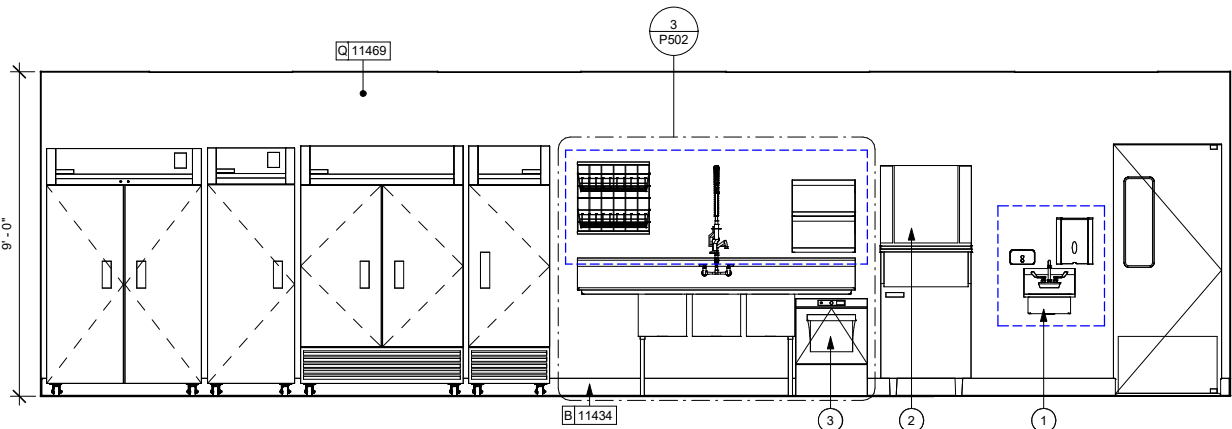


1 WORKROOM WEST ELEVATION A

Scale: 3/8" = 1'-0"

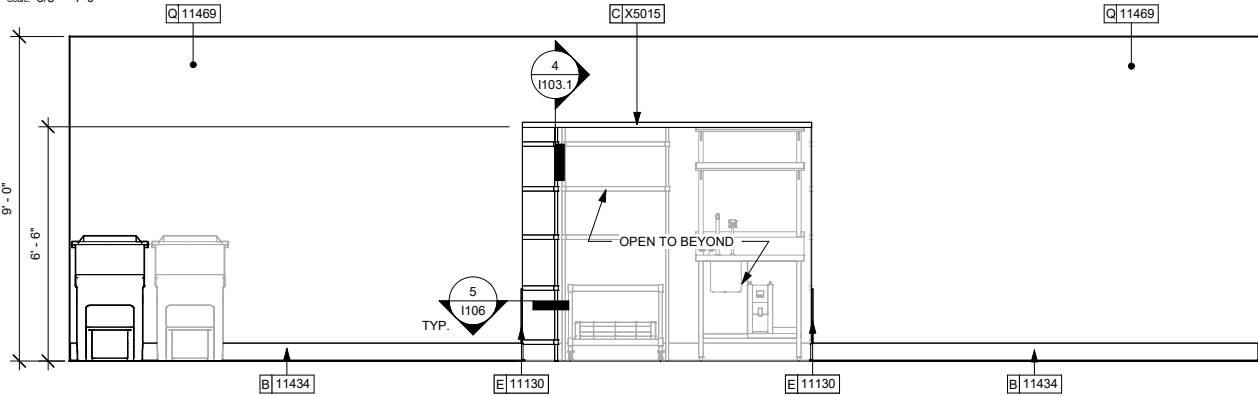


3 WORKROOM EAST ELEVATION A

Scale: 3/8" = 1'-0"

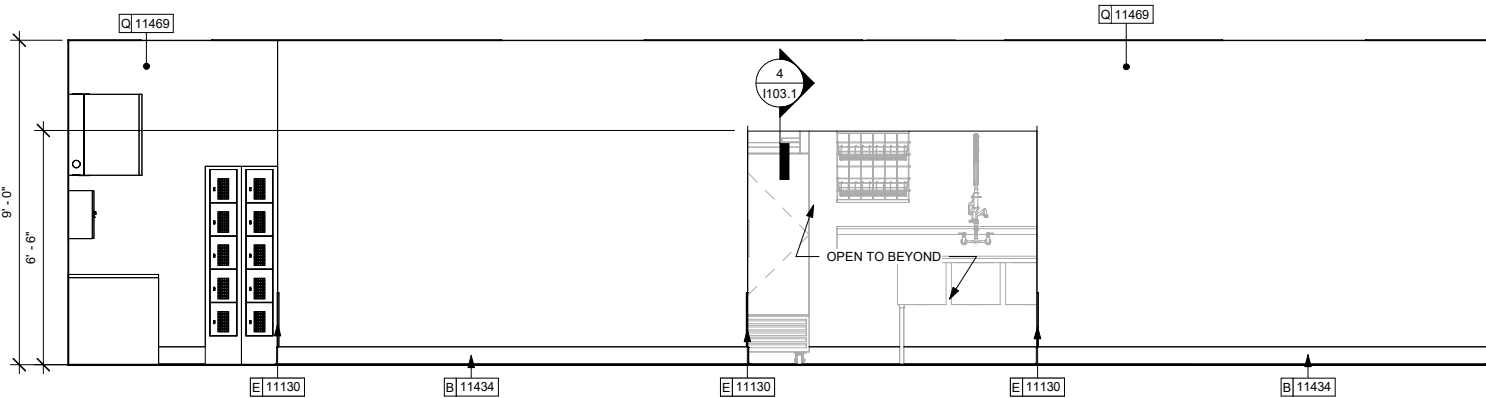


5 WORKROOM WEST ELEVATION B

Scale: 3/8" = 1'-0"

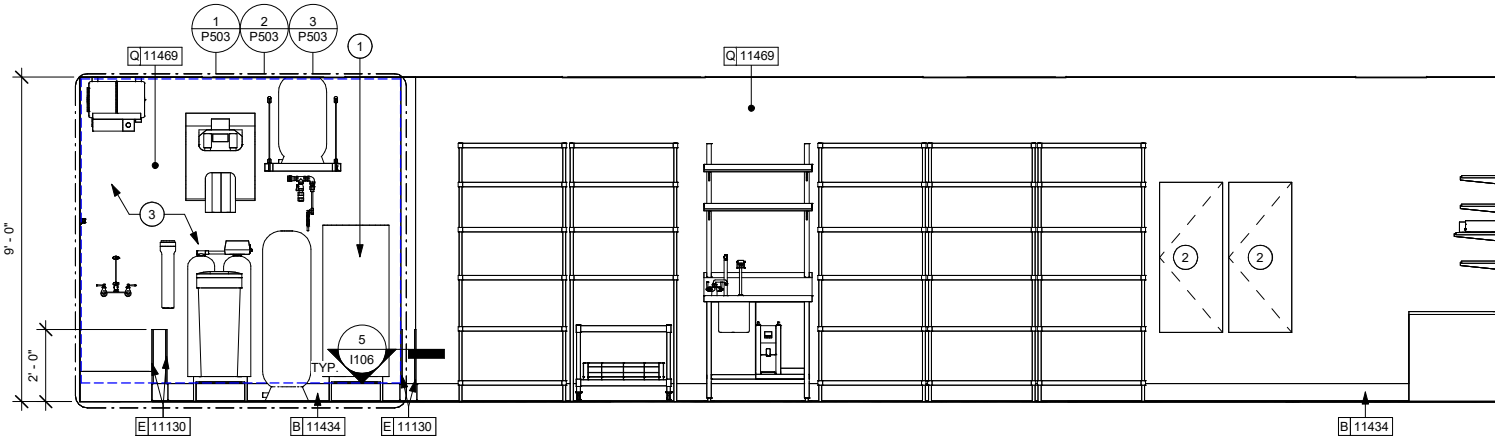


7 WORKROOM EAST ELEVATION B

Scale: 3/8" = 1'-0"

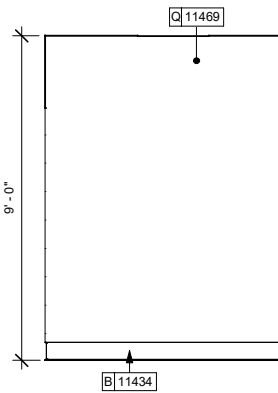


2 WORKROOM NORTH ELEVATION A

Scale: 3/8" = 1'-0"

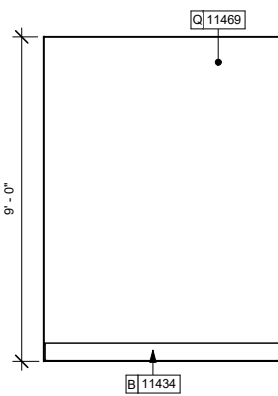


4 WORKROOM SOUTH ELEVATION A

Scale: 3/8" = 1'-0"

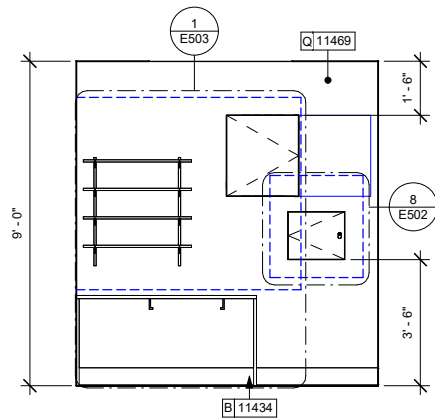

6 WORKROOM MANAGER'S DESK ELEVATION

Scale: 3/8" = 1'-0"

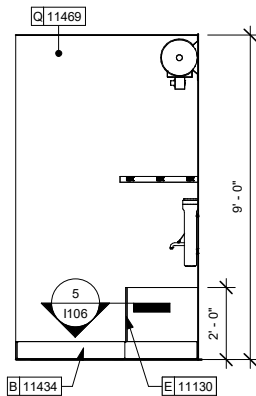

8 WORKROOM NORTH ELEVATION B

Scale: 3/8" = 1'-0"

KEYED NOTES

1. WALL MOUNT HAND SINK WITH SOAP AND PAPER TOWEL DISPENSER. ENSURE MOUNTING HEIGHTS CONFORM TO ACCESSIBILITY CODES. GENERAL CONTRACTOR TO PROVIDE BLOCKING FOR FASTENERS.
2. ICE MACHINE. SEE PLUMBING AND ELECTRICAL DRAWINGS FOR ADDITIONAL INFORMATION.
3. WAREWASHER/SANITIZER SET ON CASTERS FOR CLEANING ACCESS.

GENERAL NOTES

- A. FLOORS, WALL, AND CEILING FINISHES IN FOOD PREPARATION AREAS SHALL BE SMOOTH, NON-TOXIC, NON-ABSORBENT, DURABLE, AND EASILY CLEANABLE. PAINT IN THESE AREAS SHALL BE WASHABLE; SEMI-GLOSS OR HIGH GLOSS FINISH.
- B. CHANGE OF PAINT COLOR ONLY AT INSIDE CORNERS, UNLESS NOTED OTHERWISE.
- C. PAINT SUBSTITUTIONS ARE NOT ALLOWED. USE STARBUCKS NATIONAL SHERWIN WILLIAMS ACCOUNT "COLOR CODE" WHEN ORDERING PAINTS.
- D. PAINT FINISHES SHALL BE APPLIED AS FOLLOWS, UNLESS NOTED OTHERWISE:
 - 1) WOODS AND METAL SURFACES SHALL BE SEMI-GLOSS OR EQUAL.
 - 2) ACCENT AND TRIM PAINTS SHALL BE SEMI-GLOSS OR EQUAL.
 - 3) WALL AND CEILING PAINTS SHALL BE EGGSHELL OR EQUAL.
 - 4) PAINTS IN WORKROOM RESTROOM(S) OR CAFE BAR SHALL BE SEMI-GLOSS OR EQUAL.
- E. REFER TO INTERIOR WALL FINISH PLAN SHEET I106 FOR PAINT SCHEDULE AND WALL FINISH SCHEDULE.
- F. WORKROOM TO BE FINISHED PER LOCAL CODE. GENERAL CONTRACTOR TO PROVIDE AND INSTALL WORKROOM WALL FINISHES.
- G. ALL WOOD SURFACES (DOORS, TRIM, SHELVES, CABINETRY) SHALL BE SEALED.
- H. ALL FLOOR AND WALL JUNCTIONS IN STORAGE AND FOOD PREPARATION AREAS SHALL HAVE A 6" COVED BASE.
- I. GENERAL CONTRACTOR TO INSTALL WALL BLOCKING AND HANGERS FOR WALL SHELVING BEFORE INSTALLING BACK BAR WALL TILE.
- J. REFER TO MANUFACTURER'S INSTRUCTIONS INCLUDED WITH ARTWORK / GRAPHICS FOR PROPER INSTALLATION.

LEGEND

- INDICATES WALL BLOCKING.
FIRE TREATED WALL BLOCKING TO BE PROVIDED AS REQUIRED TO SUPPORT WALL ATTACHMENTS. EXTEND BLOCKING 4" (100mm) BEYOND EDGE OF ATTACHMENTS.



STARBUCKS®
2401 UTAH AVENUE SOUTH
SEATTLE, WASHINGTON 98134
(206) 318-1575

THESE DRAWINGS AND THE PROJECT MANUAL ARE CONFIDENTIAL AND SHALL REMAIN THE SOLE PROPERTY OF STARBUCKS CORPORATION, WHICH IS THE OWNER OF THE COPYRIGHT IN THIS WORK. THEY SHALL NOT BE REPRODUCED (IN WHOLE OR IN PART), SHARED WITH THIRD PARTIES OR USED IN ANY MANNER ON OTHER PROJECTS OR EXTENSIONS TO THIS PROJECT WITHOUT THE PRIOR WRITTEN CONSENT OF STARBUCKS CORPORATION. THESE DRAWINGS AND SPECIFICATIONS ARE INTENDED TO EXPRESS DESIGN INTENT FOR A PROTOTYPICAL STARBUCKS STORE (WHICH IS SUBJECT TO CHANGE AT ANYTIME) AND DO NOT REFLECT ACTUAL SITE CONDITIONS. NEITHER PARTY SHALL HAVE ANY OBLIGATION NOR LIABILITY TO THE OTHER (EXCEPT STATED ABOVE) UNTIL A WRITTEN AGREEMENT IS FULLY EXECUTED BY BOTH PARTIES.

STARBUCKS TEMPLATE VERSION I2025.08.27

ARCHITECT OF RECORD

THIS DRAWING IS A DESIGN DEVELOPMENT DOCUMENT. SITE SPECIFIC MODIFICATIONS MADE UNDER THE RESPONSIBLE CHARGE OF THE ARCHITECT AND/OR ENGINEER-OF-RECORD WILL BE REQUIRED PRIOR TO USING THIS DOCUMENT FOR BIDDING, PERMITTING, OR CONSTRUCTION.

PROJECT NAME:
TA CORDELE

PROJECT ADDRESS:
397 ROCKHOUSE RD E
CORDELE, GA 31015

STORE #: TBD
PROJECT #: 108648-001
ISSUE DATE: 12/03/2025
DESIGN MANAGER: MANDY KENT
PRODUCTION DESIGNER: MAV
CHECKED BY: E. NORRIS

Revision Schedule				
Rev	Date	By	Description	


SHEET TITLE:
**INTERIOR FINISH
ELEVATIONS**

SCALE: AS SHOWN


SHEET NUMBER:

1203


DESIGN DEVELOPMENT ONLY - NOT INTENDED FOR CONSTRUCTION USE

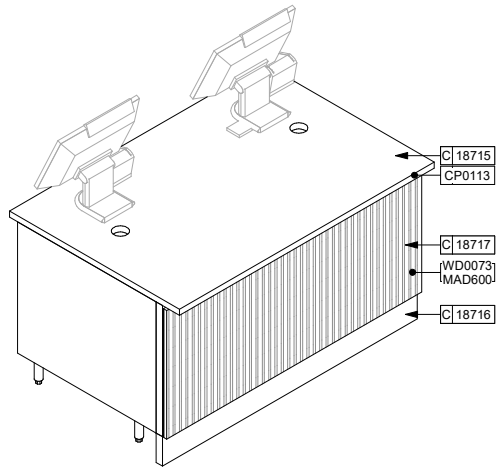


1 POS - 3D VIEW FRONT
Scale: 3/4" = 1'-0"

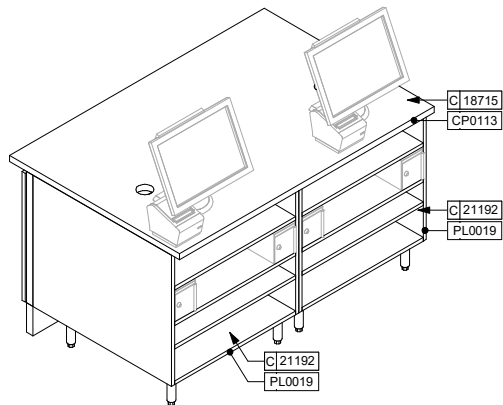


2 POS - 3D VIEW BACK
Scale: 3/4" = 1'-0"

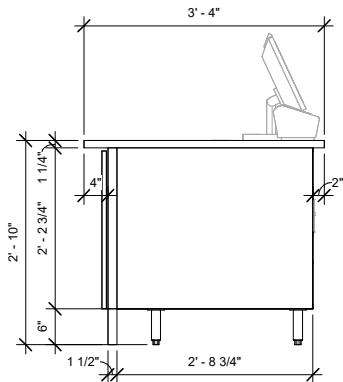


3 POS - SIDE ELEVATION
Scale: 3/4" = 1'-0"

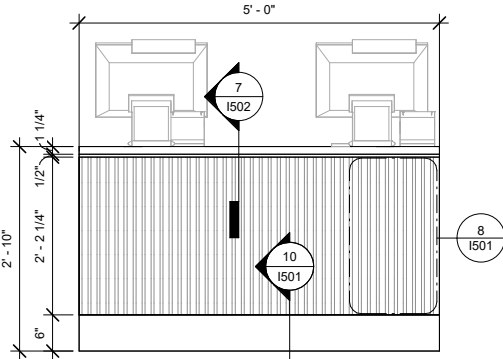


4 POS - FRONT ELEVATION
Scale: 3/4" = 1'-0"

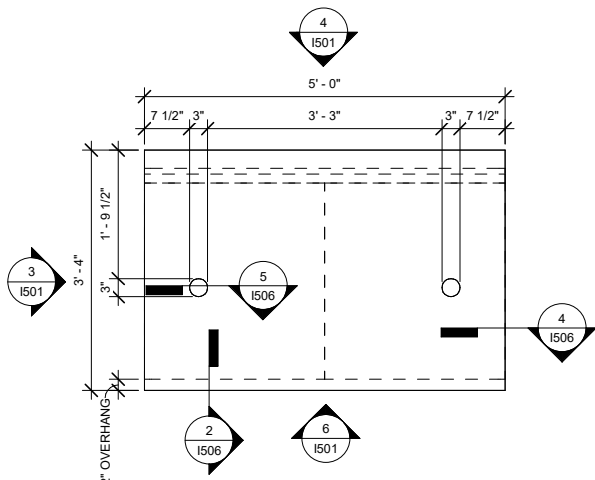


5 POS - PLAN
Scale: 3/4" = 1'-0"

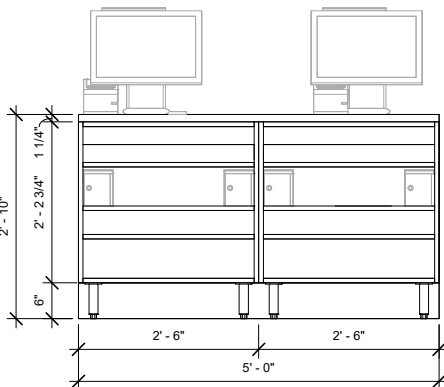


6 POS - BACK ELEVATION
Scale: 3/4" = 1'-0"

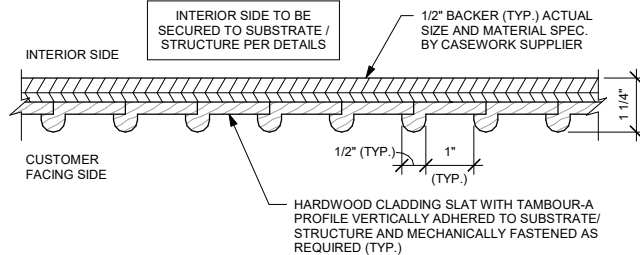


7 FINISH APPLICATION (MAD 600) TAMBOUR-A - SECTION
Scale: 6" = 1'-0"

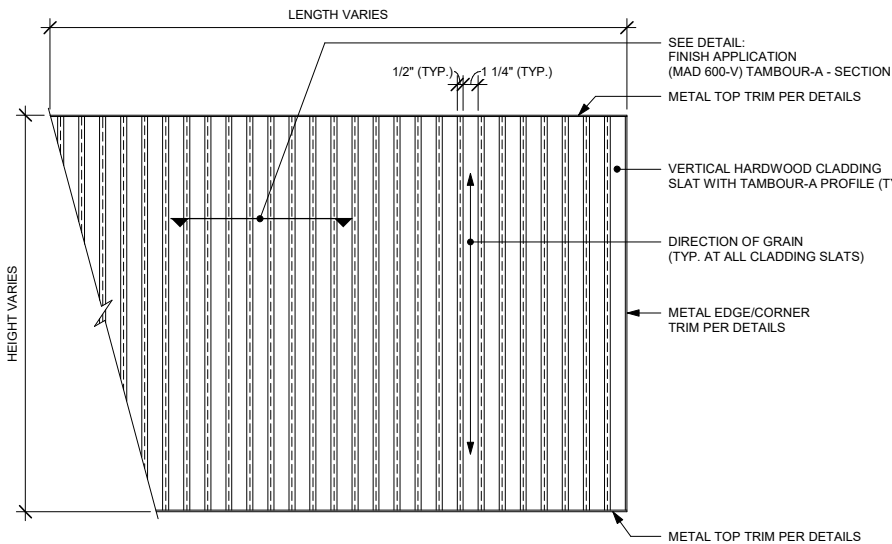

8 FINISH APPLICATION (MAD 600) TAMBOUR-A - ELEVATION
Scale: 1 1/2" = 1'-0"

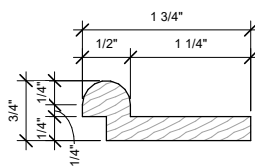

9 FINISH APPLICATION (MAD 600) PROFILE
Scale: 12" = 1'-0"

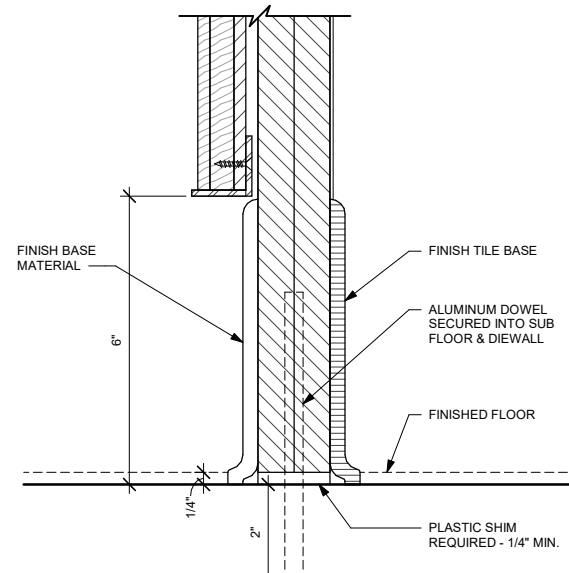

10 FINISH PANEL - 6" BASE
Scale: 6" = 1'-0"

ARCHITECT AND/OR ENGINEER OF RECORD
TO VERIFY, SPECIFY AND PLACE ALL
ELECTRICAL AND PLUMBING COMPONENTS.

ALL DETAILS ARE FOR DESIGN INTENT ONLY.
VENDOR TO FURNISH SHOP DRAWINGS TO
STARBUCKS STORE DESIGNER FOR
APPROVAL PRIOR TO FABRICATION.



STARBUCKS
2401 UTAH AVENUE SOUTH
SEATTLE, WASHINGTON 98134
(206) 318-1575

THESE DRAWINGS AND THE PROJECT MANUAL ARE CONFIDENTIAL AND SHALL REMAIN THE SOLE PROPERTY OF STARBUCKS CORPORATION, WHICH IS THE OWNER OF THE COPYRIGHT IN THIS WORK. THEY SHALL NOT BE REPRODUCED (IN WHOLE OR IN PART), SHARED WITH THIRD PARTIES OR USED IN ANY MANNER ON OTHER PROJECTS OR EXTENSIONS TO THIS PROJECT WITHOUT THE PRIOR WRITTEN CONSENT OF STARBUCKS CORPORATION. THESE DRAWINGS AND SPECIFICATIONS ARE INTENDED TO EXPRESS DESIGN INTENT FOR A PROTOTYPICAL STARBUCKS STORE (WHICH IS SUBJECT TO CHANGE AT ANYTIME) AND DO NOT REFLECT ACTUAL SITE CONDITIONS. NEITHER PARTY SHALL HAVE ANY OBLIGATION NOR LIABILITY TO THE OTHER (EXCEPT STATED ABOVE) UNTIL A WRITTEN AGREEMENT IS FULLY EXECUTED BY BOTH PARTIES.

STARBUCKS TEMPLATE VERSION I2025.08.27

ARCHITECT OF RECORD

THIS DRAWING IS A DESIGN DEVELOPMENT DOCUMENT. SITE SPECIFIC MODIFICATIONS MADE UNDER THE RESPONSIBLE CHARGE OF THE ARCHITECT AND/OR ENGINEER-OF-RECORD WILL BE REQUIRED PRIOR TO USING THIS DOCUMENT FOR BIDDING, PERMITTING, OR CONSTRUCTION.

PROJECT NAME:
TA CORDELE

PROJECT ADDRESS:
397 ROCKHOUSE RDE
CORDELE, GA 31015

STORE #: TBD
PROJECT #: 108648-001
ISSUE DATE: 12/03/2025
DESIGN MANAGER: MANDY KENT
PRODUCTION DESIGNER: MAV
CHECKED BY: E. NORRIS

Revision Schedule				
Rev	Date	By	Description	



SHEET TITLE:
INTERIOR DETAILS

SCALE: AS SHOWN

SHEET NUMBER:



1501

DESIGN DEVELOPMENT ONLY - NOT INTENDED FOR CONSTRUCTION USE

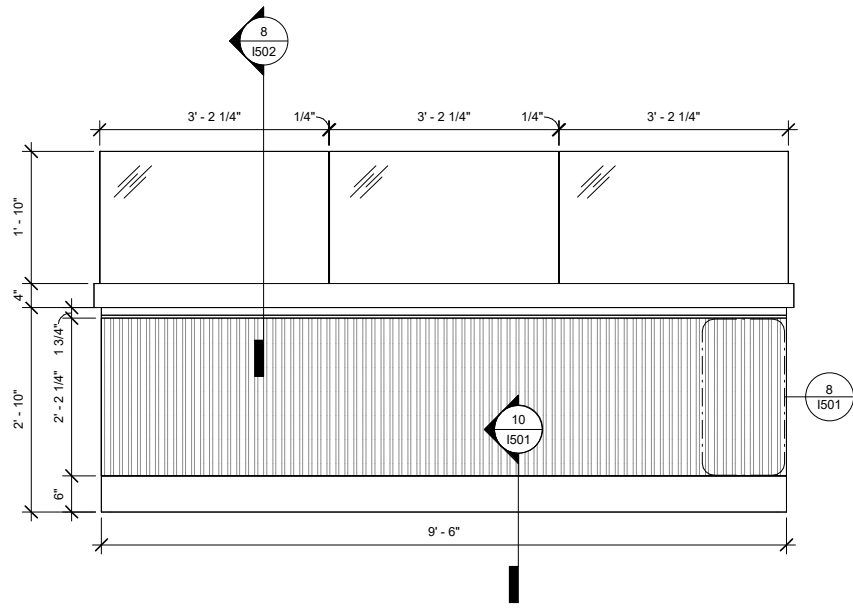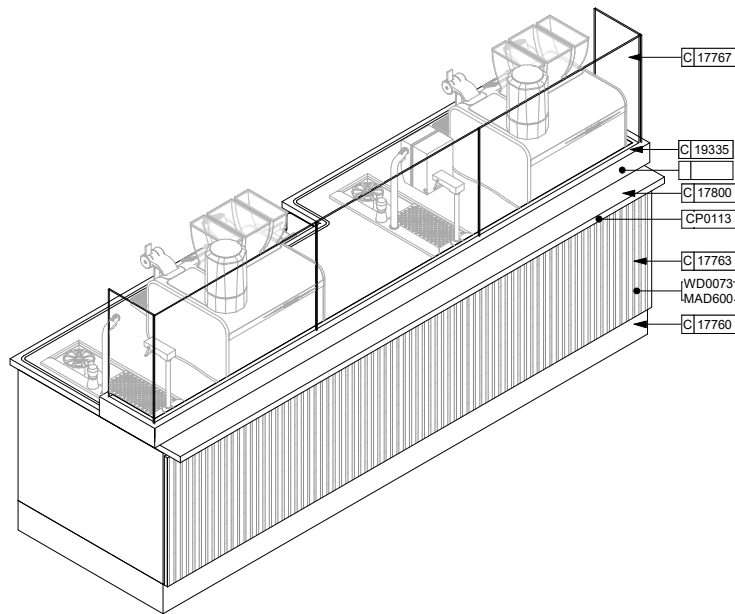



1 ESP - 3D VIEW FRONT
Scale: 3/4" = 1'-0"

4 ESP - FRONT ELEVATION
Scale: 3/4" = 1'-0"

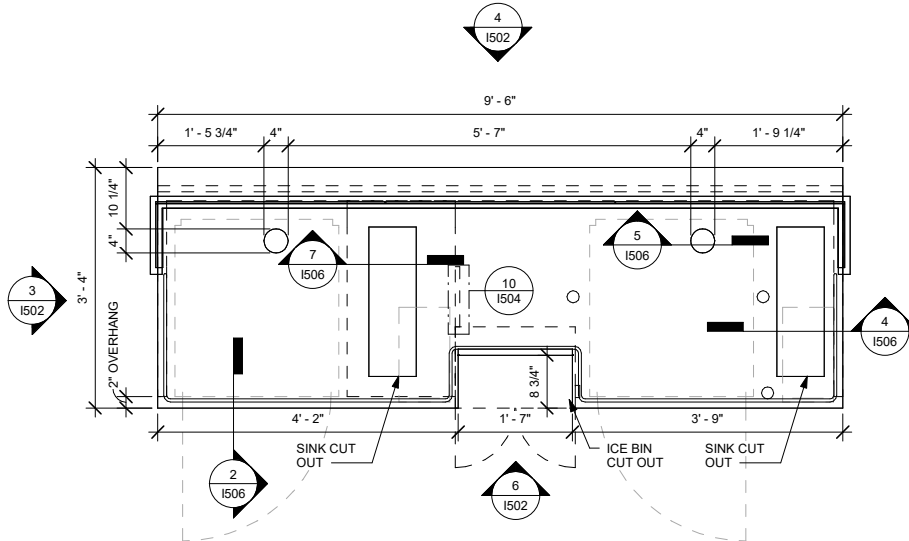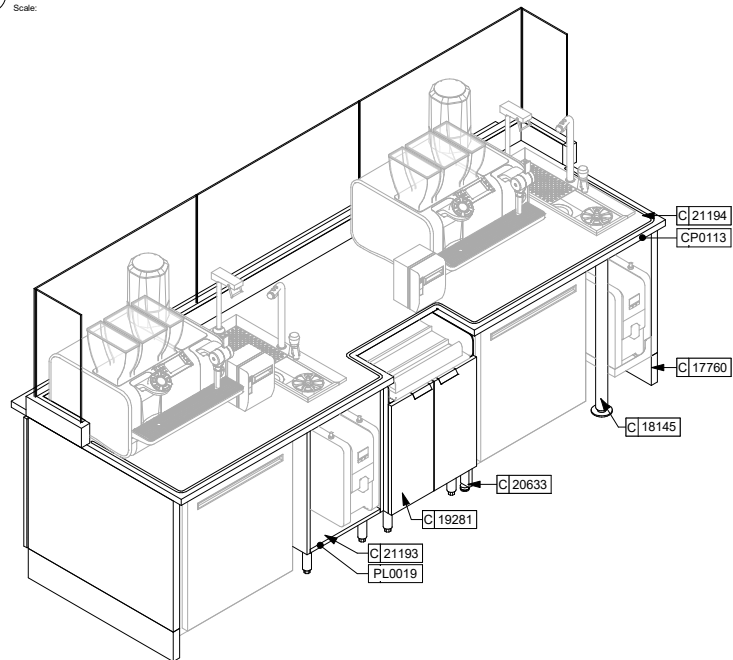

2 ESP - 3D VIEW BACK
Scale: 3/4" = 1'-0"

5 ESP - PLAN
Scale: 3/4" = 1'-0"

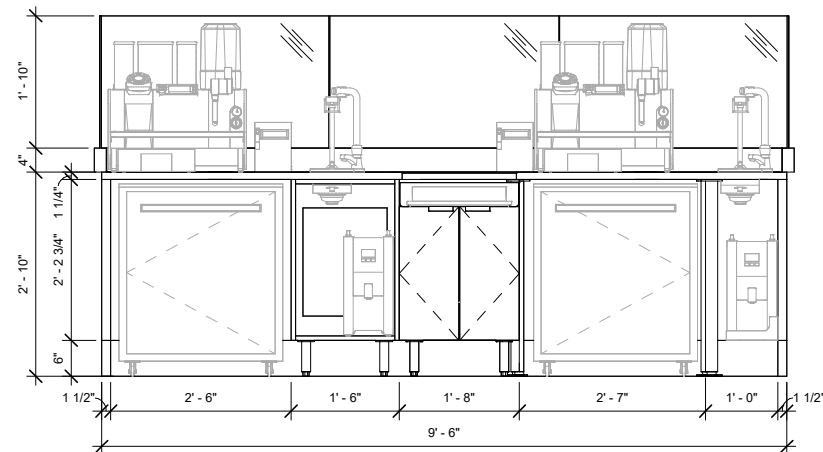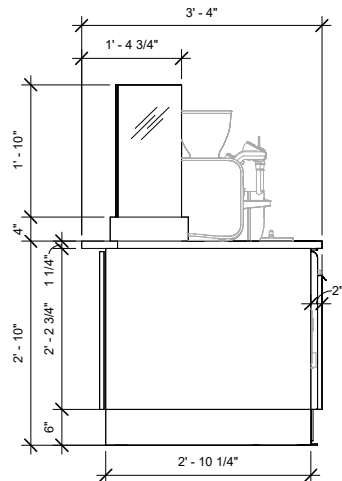


3 ESP - SIDE ELEVATION
Scale: 3/4" = 1'-0"


6 ESP - BACK ELEVATION
Scale: 3/4" = 1'-0"

ARCHITECT AND/OR ENGINEER OF RECORD
TO VERIFY, SPECIFY AND PLACE ALL
ELECTRICAL AND PLUMBING COMPONENTS.

ALL DETAILS ARE FOR DESIGN INTENT ONLY.
VENDOR TO FURNISH SHOP DRAWINGS TO
STARBUCKS STORE DESIGNER FOR
APPROVAL PRIOR TO FABRICATION.

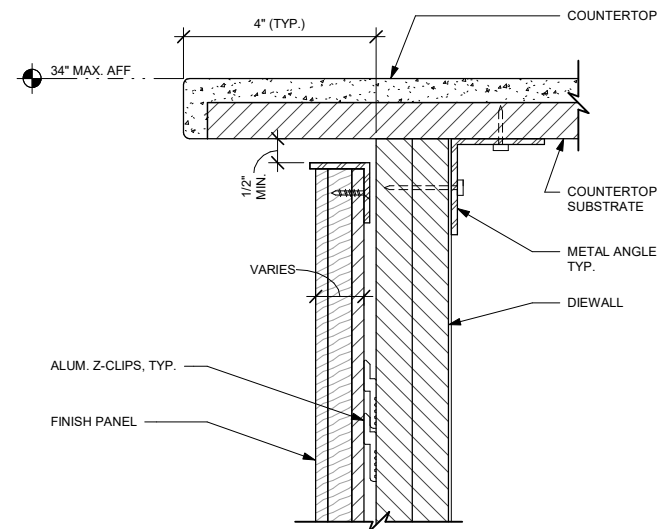

7 FINISH PANEL - COUNTERTOP OVERHANG
Scale: 6" = 1'-0"

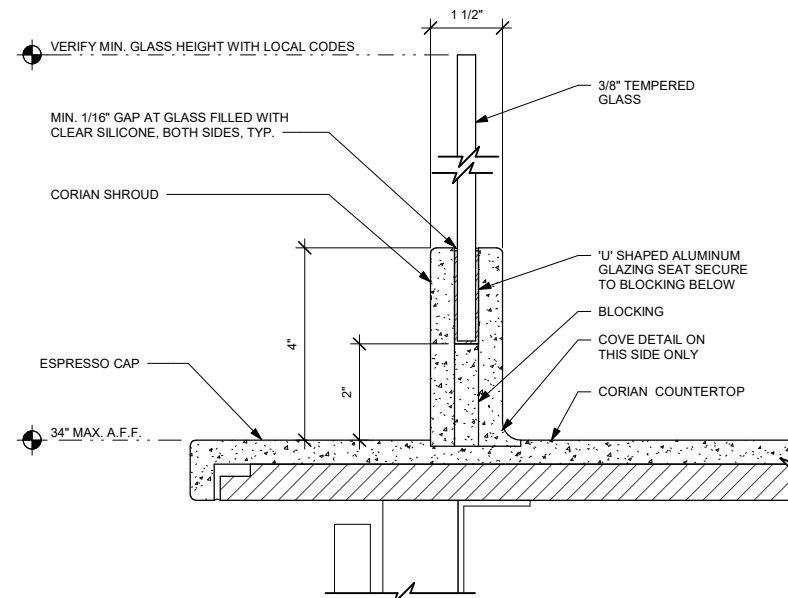

8 ESP SHROUD - CORIAN WITH SNEEZE GUARD
Scale: 6" = 1'-0"



STARBUCKS
2401 UTAH AVENUE SOUTH
SEATTLE, WASHINGTON 98134
(206) 318-1575

THESE DRAWINGS AND THE PROJECT MANUAL
ARE CONFIDENTIAL AND SHALL REMAIN THE
SOLE PROPERTY OF STARBUCKS
CORPORATION, WHICH IS THE OWNER OF THE
COPYRIGHT IN THIS WORK. THEY SHALL NOT
BE REPRODUCED (IN WHOLE OR IN PART),
SHARED WITH THIRD PARTIES OR USED IN ANY
MANNER ON OTHER PROJECTS OR
EXTENSIONS TO THIS PROJECT WITHOUT THE
PRIOR WRITTEN CONSENT OF STARBUCKS
CORPORATION. THESE DRAWINGS AND
SPECIFICATIONS ARE INTENDED TO EXPRESS
DESIGN INTENT FOR A PROTOTYPICAL
STARBUCKS STORE (WHICH IS SUBJECT TO
CHANGE AT ANYTIME) AND DO NOT REFLECT
ACTUAL SITE CONDITIONS. NEITHER PARTY
SHALL HAVE ANY OBLIGATION NOR LIABILITY TO
THE OTHER (EXCEPT STATED ABOVE) UNTIL A
WRITTEN AGREEMENT IS FULLY EXECUTED BY
BOTH PARTIES.

STARBUCKS TEMPLATE VERSION I2025.08.27

ARCHITECT OF RECORD

THIS DRAWING IS A DESIGN
DEVELOPMENT DOCUMENT.
SITE SPECIFIC MODIFICATIONS
MADE UNDER THE RESPONSIBLE
CHARGE OF THE ARCHITECT
AND/OR ENGINEER-OF-RECORD
WILL BE REQUIRED PRIOR TO
USING THIS DOCUMENT FOR
BIDDING, PERMITTING, OR
CONSTRUCTION.

PROJECT NAME:
TA CORDELE

PROJECT ADDRESS:
**397 ROCKHOUSE RD E
CORDELE, GA 31015**

STORE #: TBD
PROJECT #: 108648-001
ISSUE DATE: 12/03/2025
DESIGN MANAGER: MANDY KENT
PRODUCTION DESIGNER: MAV
CHECKED BY: E. NORRIS

Revision Schedule				
Rev	Date	By	Description	


SHEET TITLE:
INTERIOR DETAILS

SCALE: AS SHOWN

SHEET NUMBER:


1502

DESIGN DEVELOPMENT ONLY - NOT INTENDED FOR CONSTRUCTION USE

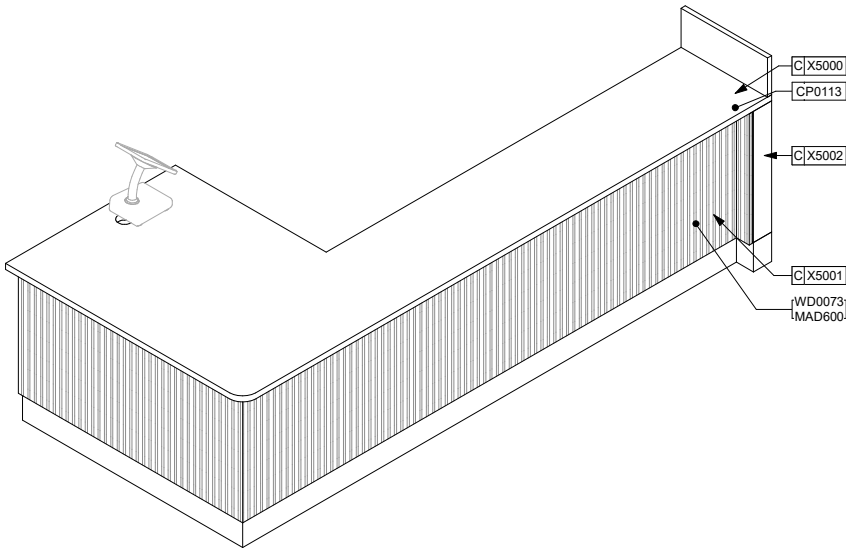


1 HOS - 3D VIEW FRONT

Scale:

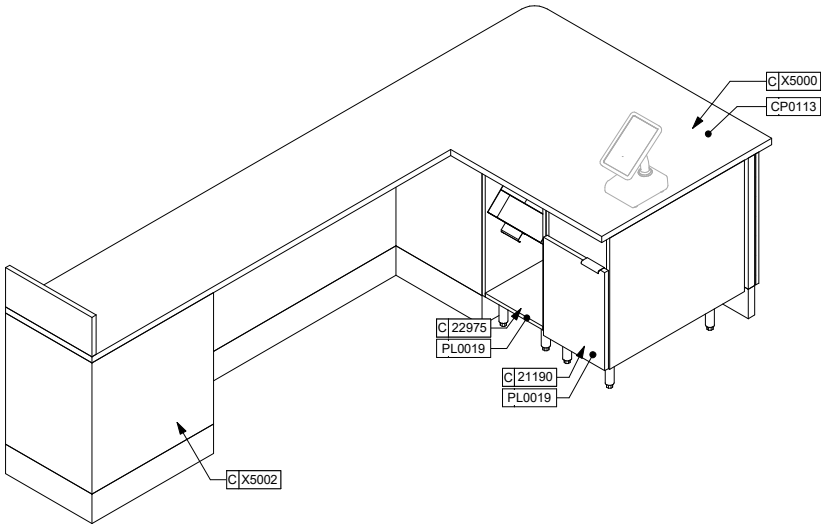


2 HOS - 3D VIEW BACK

Scale:

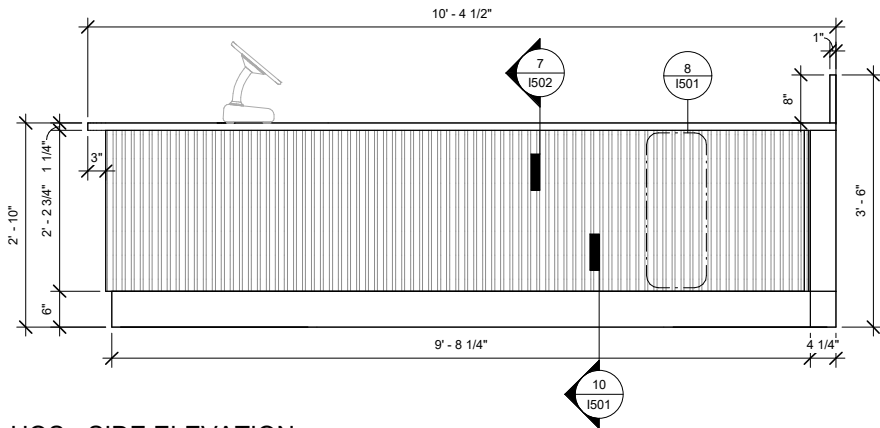


3 HOS - SIDE ELEVATION

Scale: 3/4" = 1'-0"

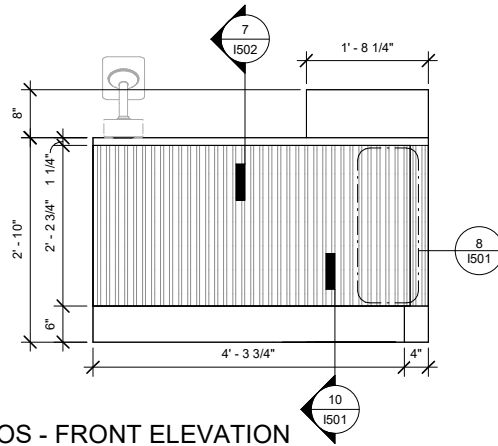


4 HOS - FRONT ELEVATION

Scale: 3/4" = 1'-0"

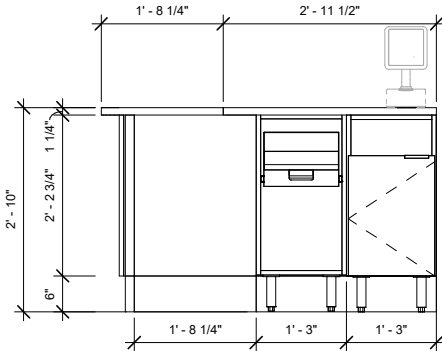

6 HOS - BACK ELEVATION

Scale: 3/4" = 1'-0"

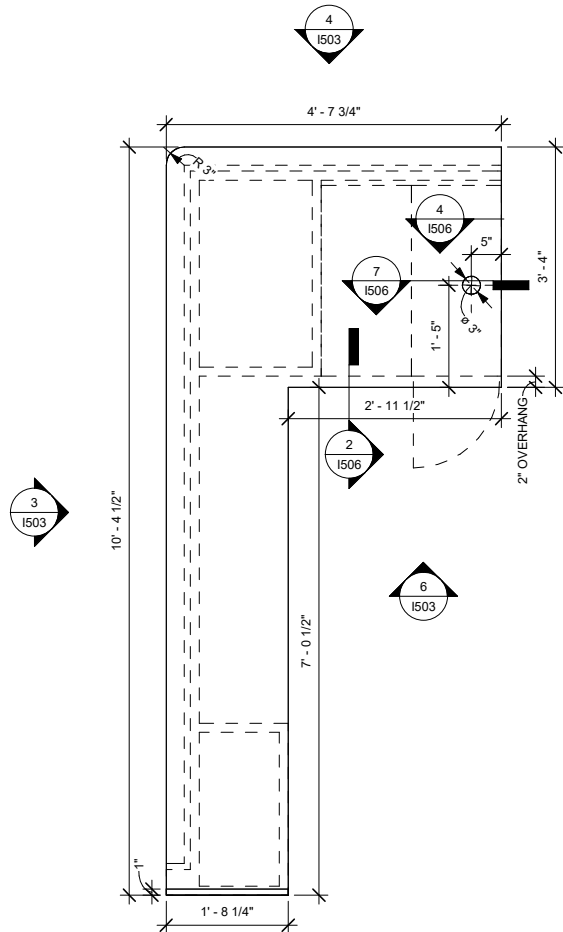

5 HOS - PLAN

Scale: 3/4" = 1'-0"

ARCHITECT AND/OR ENGINEER OF RECORD
TO VERIFY, SPECIFY AND PLACE ALL
ELECTRICAL AND PLUMBING COMPONENTS.

ALL DETAILS ARE FOR DESIGN INTENT ONLY.
VENDOR TO FURNISH SHOP DRAWINGS TO
STARBUCKS STORE DESIGNER FOR
APPROVAL PRIOR TO FABRICATION.



STARBUCKS
2401 UTAH AVENUE SOUTH
SEATTLE, WASHINGTON 98134
(206) 318-1575

THESE DRAWINGS AND THE PROJECT MANUAL
ARE CONFIDENTIAL AND SHALL REMAIN THE
SOLE PROPERTY OF STARBUCKS
CORPORATION, WHICH IS THE OWNER OF THE
COPYRIGHT IN THIS WORK. THEY SHALL NOT
BE REPRODUCED (IN WHOLE OR IN PART),
SHARED WITH THIRD PARTIES OR USED IN ANY
MANNER ON OTHER PROJECTS OR
EXTENSIONS TO THIS PROJECT WITHOUT THE
PRIOR WRITTEN CONSENT OF STARBUCKS
CORPORATION. THESE DRAWINGS AND
SPECIFICATIONS ARE INTENDED TO EXPRESS
DESIGN INTENT FOR A PROTOTYPICAL
STARBUCKS STORE (WHICH IS SUBJECT TO
CHANGE AT ANYTIME) AND DO NOT REFLECT
ACTUAL SITE CONDITIONS. NEITHER PARTY
SHALL HAVE ANY OBLIGATION NOR LIABILITY TO
THE OTHER (EXCEPT STATED ABOVE) UNTIL A
WRITTEN AGREEMENT IS FULLY EXECUTED BY
BOTH PARTIES.

STARBUCKS TEMPLATE VERSION I2025.08.27

ARCHITECT OF RECORD

THIS DRAWING IS A DESIGN
DEVELOPMENT DOCUMENT.
SITE SPECIFIC MODIFICATIONS
MADE UNDER THE RESPONSIBLE
CHARGE OF THE ARCHITECT
AND/OR ENGINEER-OF-RECORD
WILL BE REQUIRED PRIOR TO
USING THIS DOCUMENT FOR
BIDDING, PERMITTING, OR
CONSTRUCTION.

PROJECT NAME:
TA CORDELE

PROJECT ADDRESS:
397 ROCKHOUSE RD E
CORDELE, GA 31015

STORE #: TBD
PROJECT #: 108648-001
ISSUE DATE: 12/03/2025
DESIGN MANAGER: MANDY KENT
PRODUCTION DESIGNER: MAV
CHECKED BY: E. NORRIS

Revision Schedule			
Rev	Date	By	Description


SHEET TITLE:
INTERIOR DETAILS

SCALE: AS SHOWN


SHEET NUMBER:

I503


DESIGN DEVELOPMENT ONLY - NOT INTENDED FOR CONSTRUCTION USE

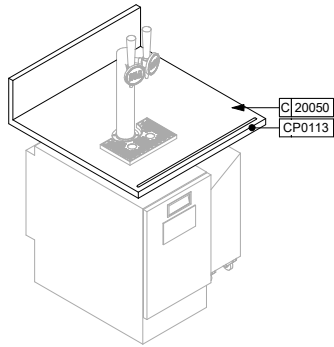


1 NIT - 3D VIEW
Scale:

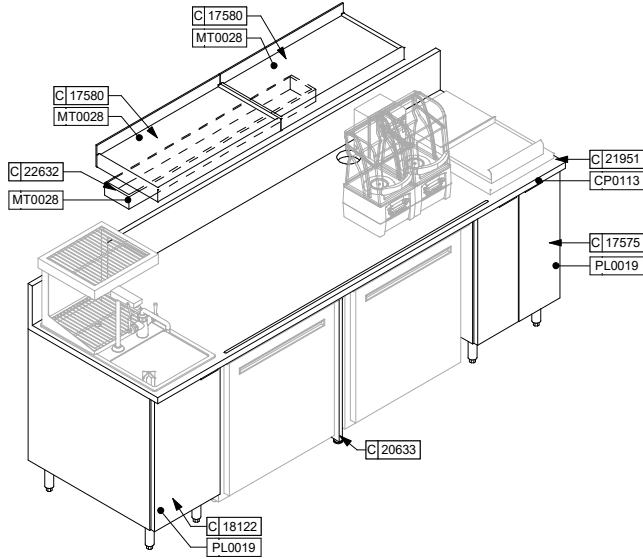


4 CBE - 3D VIEW
Scale:

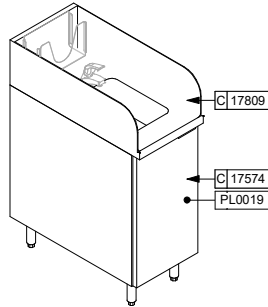


7 HAND SINK - 3D VIEW
Scale:

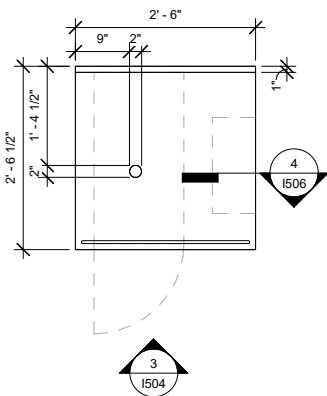


2 NIT - PLAN
Scale: 3/4" = 1'-0"

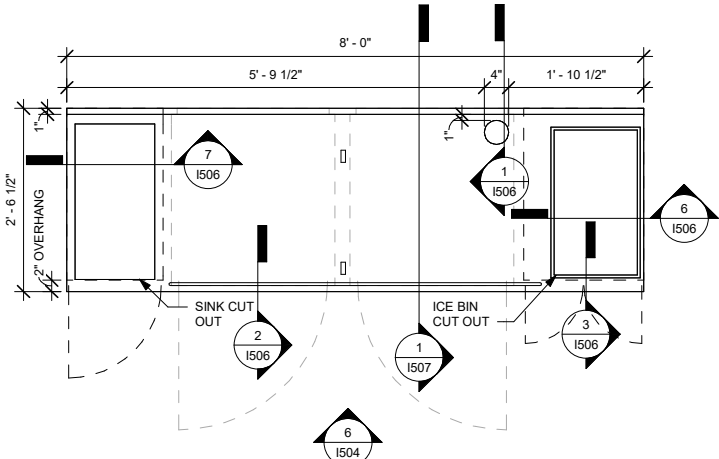


5 CBE - PLAN
Scale: 3/4" = 1'-0"

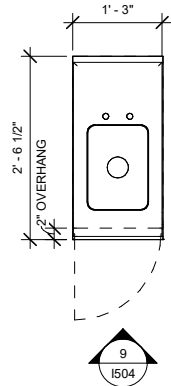


8 HAND SINK - PLAN
Scale: 3/4" = 1'-0"

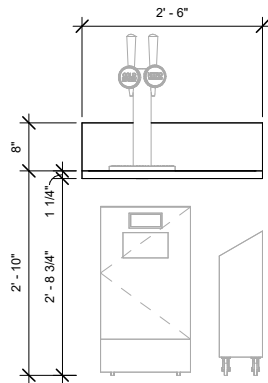

3 NIT - ELEVATION
Scale: 3/4" = 1'-0"

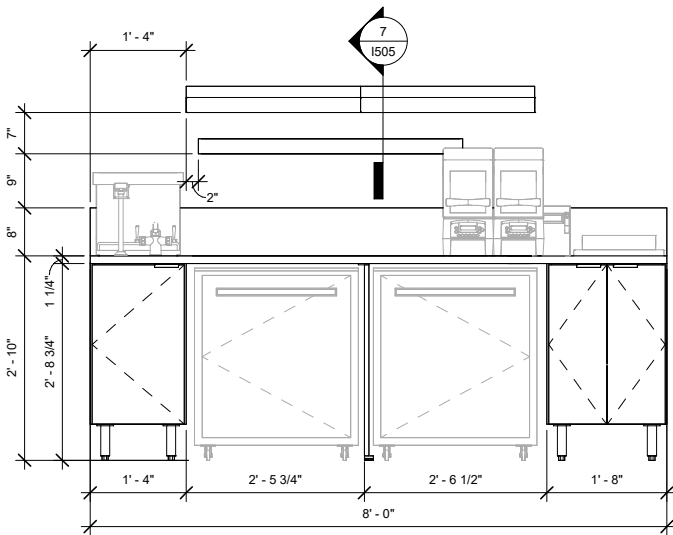

6 CBE - ELEVATION
Scale: 3/4" = 1'-0"

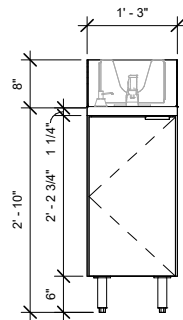

9 HAND SINK - ELEVATION
Scale: 3/4" = 1'-0"

ARCHITECT AND/OR ENGINEER OF RECORD
TO VERIFY, SPECIFY AND PLACE ALL
ELECTRICAL AND PLUMBING COMPONENTS.

ALL DETAILS ARE FOR DESIGN INTENT ONLY.
VENDOR TO FURNISH SHOP DRAWINGS TO
STARBUCKS STORE DESIGNER FOR
APPROVAL PRIOR TO FABRICATION.

NOTES:
1. LOCATE PUMP WITHIN CORD LENGTH LIMIT. ORIENT WITH PUMP HEAD LEFT, RIGHT AND AT BOTTOM. LOOSEN PUMP HEAD CLAMP, ROTATE AND RE-TIGHTEN AS REQUIRED PER ORIENTATION TO PROVIDE FRONT ACCESS TO FLOW. ADJUSTMENT WITHIN CORD LENGTH LIMIT.

2. USE LOCKTITE ON ISOLATOR THREADS. DO NOT OVER TIGHTEN.

3. LOOSEN PUMP HEAD CLAMP, ROTATE AND RE-TIGHTEN AS REQUIRED FOR PUMP ORIENTATION.

4. EACH BACKER BOARD'S ASSEMBLY COMPONENTS INCLUDE:
(1) BACKER BOARDS
(4) TENETS, 1/4-20 VENDOR MOUNTED
(8) WOOD SCREWS #8 1-1/4" (32MM)
(4) NEOPRENE ISOLATORS, KARMAN RUBBER, K84-60 NEOPRENE
(4) LOCK NUTS, 1/4-20 NYLON
(4) WASHERS, 1/4" (7MM) FLAT

EXTERIOR FACE OF CABINET
23.685" H X 12" W (602MM X 305MM),
3/4" MARINE GRADE PLYWOOD
BACKER BOARD SECURED TO
STEEL FRAME WITH THRU BOLTS
AND SILICONE ADHESIVE

OFFSET AND STACK SECOND PUMP
ABOVE UNIT BELOW TO ENSURE
THAT ANY LEAKING DOES NOT
AFFECT UNIT BELOW. ATTACH TO
BACKER BOARD WITH ASSEMBLY
COMPONENTS

SEE NOTES ABOVE
FOR ASSEMBLY ITEMS

PUMP ATTACHED TO BACKER BOARD
WITH ASSEMBLY COMPONENTS
10"x10" (250MM X 250MM) BACKER BOARD.
ATTACH TO PLYWOOD SUBSTRATE WITH
SILICONE ADHESIVE AND WOOD SCREWS.
SILICONE PERIMETER.

FINISHED FLOOR

10 ESPRESSO PUMP MOUNTED AT CABINET
Scale: 1 1/2" = 1'-0"



STARBUCKS®
2401 UTAH AVENUE SOUTH
SEATTLE, WASHINGTON 98134
(206) 318-1575

THESE DRAWINGS AND THE PROJECT MANUAL ARE CONFIDENTIAL AND SHALL REMAIN THE SOLE PROPERTY OF STARBUCKS CORPORATION, WHICH IS THE OWNER OF THE COPYRIGHT IN THIS WORK. THEY SHALL NOT BE REPRODUCED (IN WHOLE OR IN PART), SHARED WITH THIRD PARTIES OR USED IN ANY MANNER ON OTHER PROJECTS OR EXTENSIONS TO THIS PROJECT WITHOUT THE PRIOR WRITTEN CONSENT OF STARBUCKS CORPORATION. THESE DRAWINGS AND SPECIFICATIONS ARE INTENDED TO EXPRESS DESIGN INTENT FOR A PROTOTYPICAL STARBUCKS STORE (WHICH IS SUBJECT TO CHANGE AT ANYTIME) AND DO NOT REFLECT ACTUAL SITE CONDITIONS. NEITHER PARTY SHALL HAVE ANY OBLIGATION NOR LIABILITY TO THE OTHER (EXCEPT STATED ABOVE) UNTIL A WRITTEN AGREEMENT IS FULLY EXECUTED BY BOTH PARTIES.

STARBUCKS TEMPLATE VERSION I2025.08.27

ARCHITECT OF RECORD

THIS DRAWING IS A DESIGN DEVELOPMENT DOCUMENT. SITE SPECIFIC MODIFICATIONS MADE UNDER THE RESPONSIBLE CHARGE OF THE ARCHITECT AND/OR ENGINEER-OF-RECORD WILL BE REQUIRED PRIOR TO USING THIS DOCUMENT FOR BIDDING, PERMITTING, OR CONSTRUCTION.

PROJECT NAME:

TA CORDELE

PROJECT ADDRESS:
397 ROCKHOUSE RD E
CORDELE, GA 31015

STORE #: TBD
PROJECT #: 108648-001
ISSUE DATE: 12/03/2025
DESIGN MANAGER: MANDY KENT
PRODUCTION DESIGNER: MAV
CHECKED BY: E. NORRIS

Revision Schedule

Rev	Date	By	Description


SHEET TITLE:
INTERIOR DETAILS

SCALE: AS SHOWN


SHEET NUMBER:

1504


DESIGN DEVELOPMENT ONLY - NOT INTENDED FOR CONSTRUCTION USE

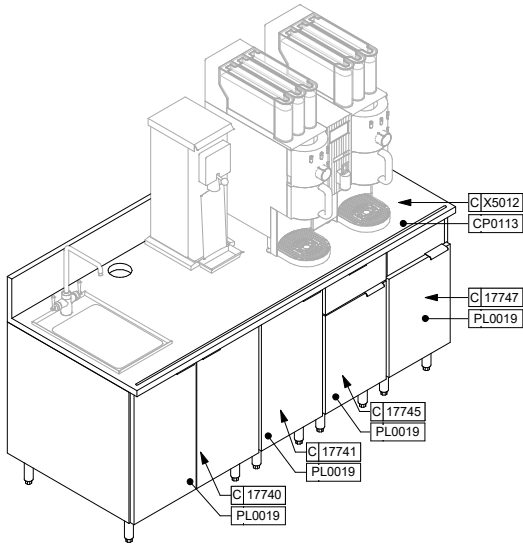


1 BRW - 3D VIEW
Scale:

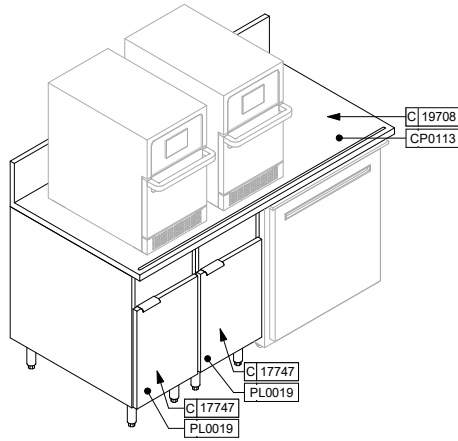


4 WRM - 3D VIEW
Scale:

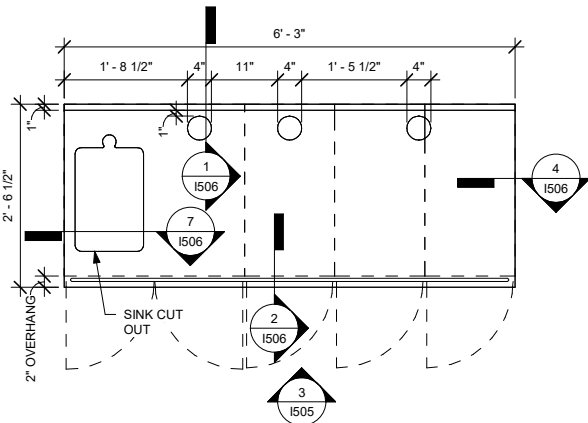


2 BRW - PLAN
Scale: 3/4" = 1'-0"

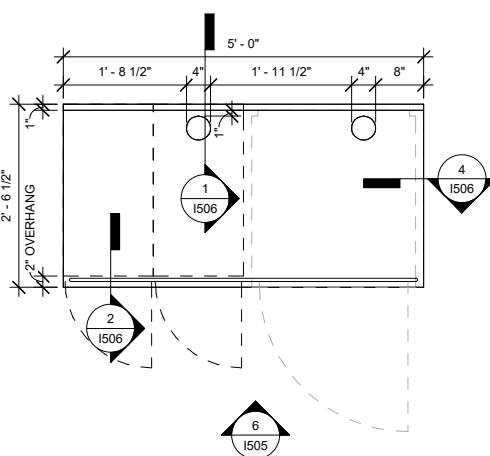


5 WRM - PLAN
Scale: 3/4" = 1'-0"

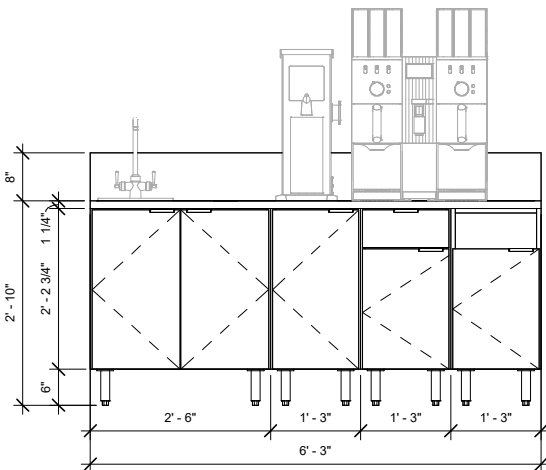

3 BRW - ELEVATION
Scale: 3/4" = 1'-0"

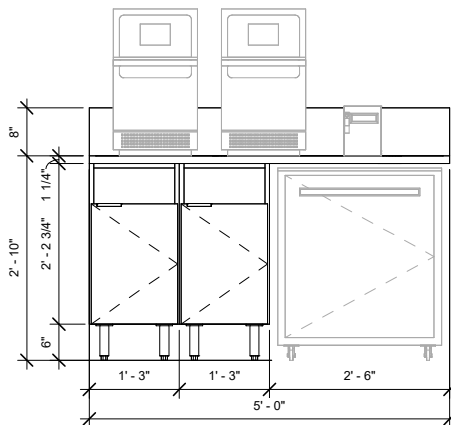

6 WRM - ELEVATION
Scale: 3/4" = 1'-0"

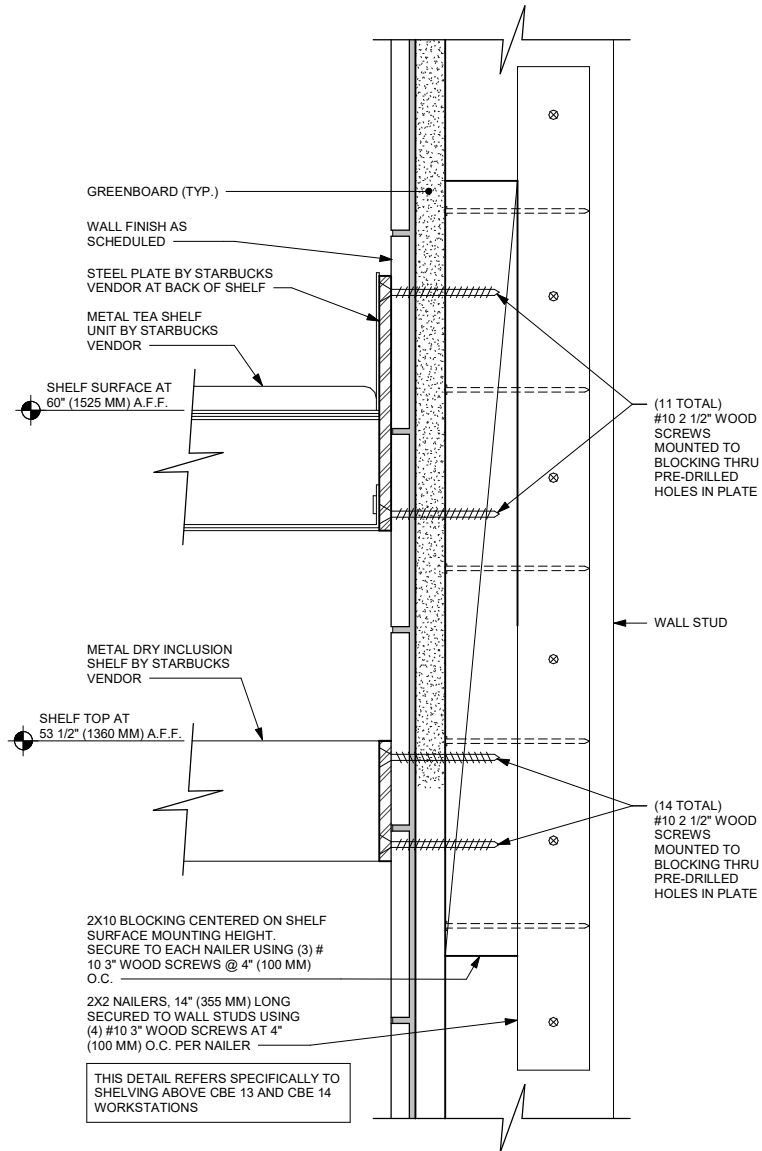

7 METAL TEA AND DRY INCLUSION SHELF WOOD WALL ATTACHMENT
Scale: 6" = 1'-0"

ARCHITECT AND/OR ENGINEER OF RECORD
TO VERIFY, SPECIFY AND PLACE ALL
ELECTRICAL AND PLUMBING COMPONENTS.

ALL DETAILS ARE FOR DESIGN INTENT ONLY.
VENDOR TO FURNISH SHOP DRAWINGS TO
STARBUCKS STORE DESIGNER FOR
APPROVAL PRIOR TO FABRICATION.



STARBUCKS®
2401 UTAH AVENUE SOUTH
SEATTLE, WASHINGTON 98134
(206) 318-1575

THESE DRAWINGS AND THE PROJECT MANUAL ARE CONFIDENTIAL AND SHALL REMAIN THE SOLE PROPERTY OF STARBUCKS CORPORATION, WHICH IS THE OWNER OF THE COPYRIGHT IN THIS WORK. THEY SHALL NOT BE REPRODUCED (IN WHOLE OR IN PART), SHARED WITH THIRD PARTIES OR USED IN ANY MANNER ON OTHER PROJECTS OR EXTENSIONS TO THIS PROJECT WITHOUT THE PRIOR WRITTEN CONSENT OF STARBUCKS CORPORATION. THESE DRAWINGS AND SPECIFICATIONS ARE INTENDED TO EXPRESS DESIGN INTENT FOR A PROTOTYPICAL STARBUCKS STORE (WHICH IS SUBJECT TO CHANGE AT ANYTIME) AND DO NOT REFLECT ACTUAL SITE CONDITIONS. NEITHER PARTY SHALL HAVE ANY OBLIGATION NOR LIABILITY TO THE OTHER (EXCEPT STATED ABOVE) UNTIL A WRITTEN AGREEMENT IS FULLY EXECUTED BY BOTH PARTIES.

STARBUCKS TEMPLATE VERSION I2025.08.27

ARCHITECT OF RECORD

THIS DRAWING IS A DESIGN DEVELOPMENT DOCUMENT. SITE SPECIFIC MODIFICATIONS MADE UNDER THE RESPONSIBLE CHARGE OF THE ARCHITECT AND/OR ENGINEER-OF-RECORD WILL BE REQUIRED PRIOR TO USING THIS DOCUMENT FOR BIDDING, PERMITTING, OR CONSTRUCTION.

PROJECT NAME:
TA CORDELE

PROJECT ADDRESS:
397 ROCKHOUSE RDE
CORDELE, GA 31015

STORE #: TBD
PROJECT #: 108648-001
ISSUE DATE: 12/03/2025
DESIGN MANAGER: MANDY KENT
PRODUCTION DESIGNER: MAV
CHECKED BY: E. NORRIS

Revision Schedule

Rev	Date	By	Description


SHEET TITLE:
INTERIOR DETAILS

SCALE: AS SHOWN


SHEET NUMBER:

1505


DESIGN DEVELOPMENT ONLY - NOT INTENDED FOR CONSTRUCTION USE

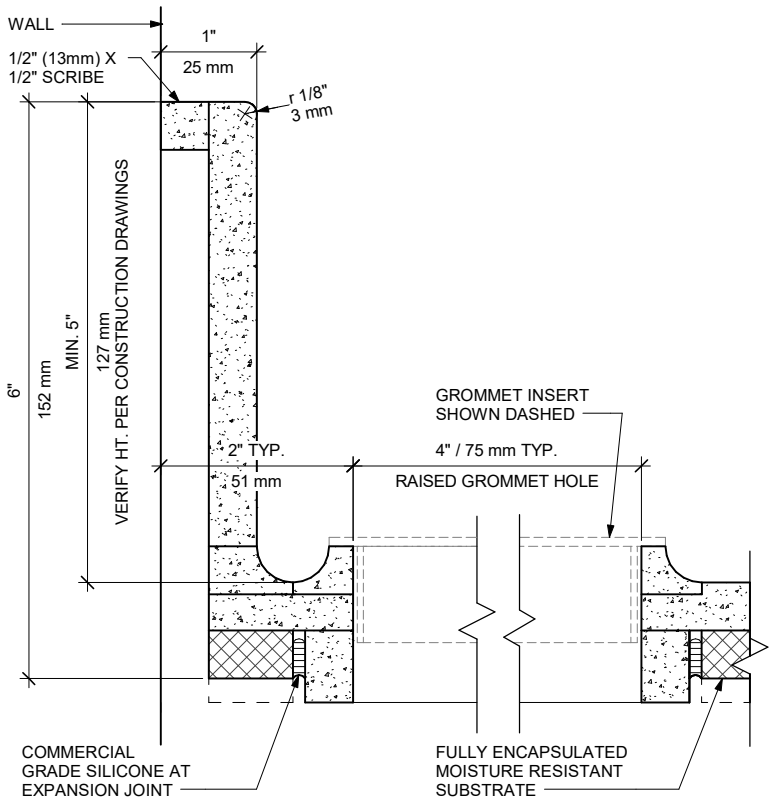


1 CORIAN COUNTERTOP BACKSPLASH AND COVED GROMMET
Scale: 12" = 1'-0"

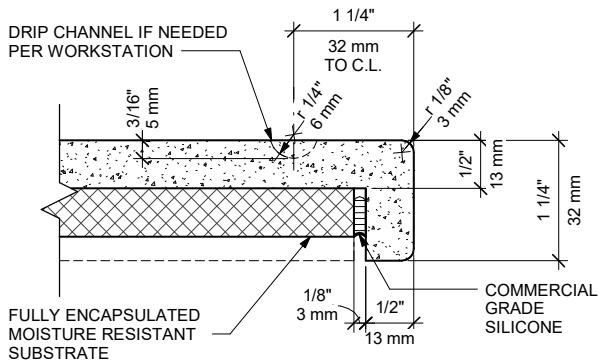


2 CORIAN COUNTERTOP FRONT EDGE
Scale: 12" = 1'-0"

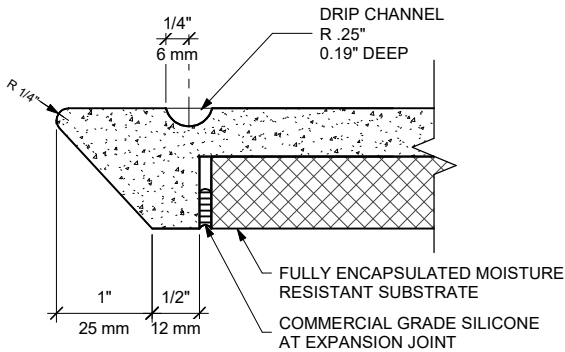


3 CORIAN COUNTERTOP FRONT EDGE AT ICE BIN
Scale: 12" = 1'-0"

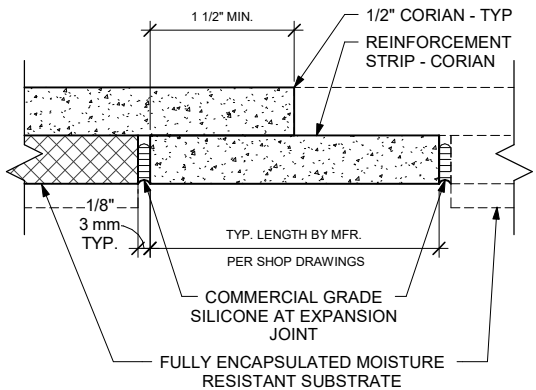


4 CORIAN COUNTERTOP REINFORCEMENT STRIP AT HARD SEAM
Scale: 12" = 1'-0"

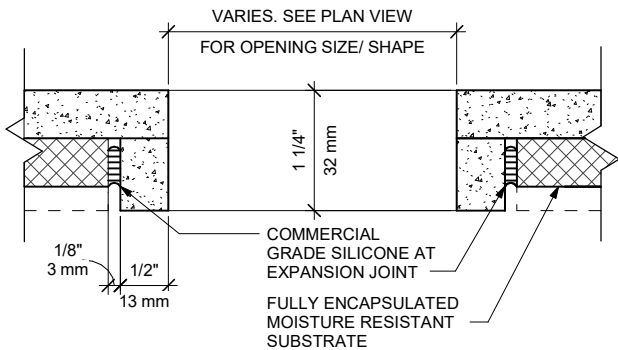

5 CORIAN COUNTERTOP TYP. CUTOUT AT TRASH AND GROMMET
Scale: 12" = 1'-0"

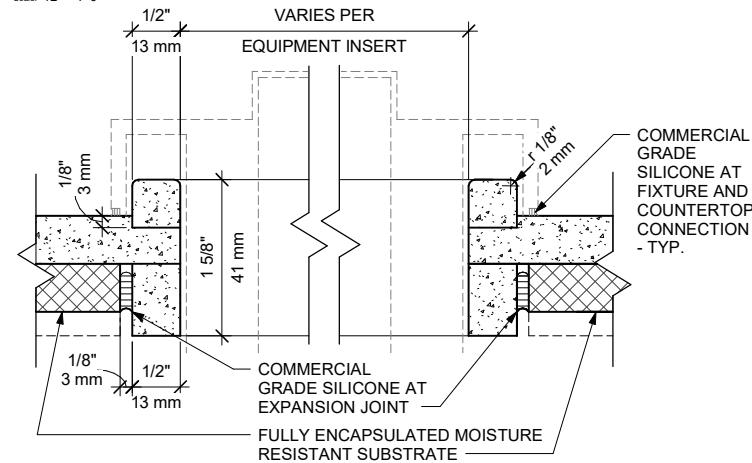

6 CORIAN COUNTERTOP TYP. ICE BIN CUTOUT WITH W/ SQUARED EDGE
Scale: 12" = 1'-0"

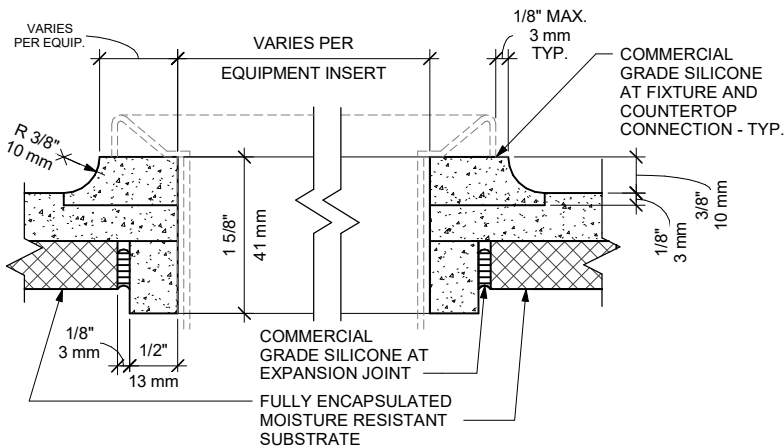

7 CORIAN COUNTERTOP TYP. SINK CUTOUT W/ COVED EDGE
Scale: 12" = 1'-0"

ARCHITECT AND/OR ENGINEER OF RECORD
TO VERIFY, SPECIFY AND PLACE ALL
ELECTRICAL AND PLUMBING COMPONENTS.

ALL DETAILS ARE FOR DESIGN INTENT ONLY.
VENDOR TO FURNISH SHOP DRAWINGS TO
STARBUCKS STORE DESIGNER FOR
APPROVAL PRIOR TO FABRICATION.



STARBUCKS®
2401 UTAH AVENUE SOUTH
SEATTLE, WASHINGTON 98134
(206) 318-1575

THESE DRAWINGS AND THE PROJECT MANUAL ARE CONFIDENTIAL AND SHALL REMAIN THE SOLE PROPERTY OF STARBUCKS CORPORATION, WHICH IS THE OWNER OF THE COPYRIGHT IN THIS WORK. THEY SHALL NOT BE REPRODUCED (IN WHOLE OR IN PART), SHARED WITH THIRD PARTIES OR USED IN ANY MANNER ON OTHER PROJECTS OR EXTENSIONS TO THIS PROJECT WITHOUT THE PRIOR WRITTEN CONSENT OF STARBUCKS CORPORATION. THESE DRAWINGS AND SPECIFICATIONS ARE INTENDED TO EXPRESS DESIGN INTENT FOR A PROTOTYPICAL STARBUCKS STORE (WHICH IS SUBJECT TO CHANGE AT ANYTIME) AND DO NOT REFLECT ACTUAL SITE CONDITIONS. NEITHER PARTY SHALL HAVE ANY OBLIGATION NOR LIABILITY TO THE OTHER (EXCEPT STATED ABOVE) UNTIL A WRITTEN AGREEMENT IS FULLY EXECUTED BY BOTH PARTIES.

STARBUCKS TEMPLATE VERSION I2025.08.27

ARCHITECT OF RECORD

THIS DRAWING IS A DESIGN DEVELOPMENT DOCUMENT. SITE SPECIFIC MODIFICATIONS MADE UNDER THE RESPONSIBLE CHARGE OF THE ARCHITECT AND/OR ENGINEER-OF-RECORD WILL BE REQUIRED PRIOR TO USING THIS DOCUMENT FOR BIDDING, PERMITTING, OR CONSTRUCTION.

PROJECT NAME:
TA CORDELE

PROJECT ADDRESS:
397 ROCKHOUSE RD E
CORDELE, GA 31015

STORE #: TBD
PROJECT #: 108648-001
ISSUE DATE: 12/03/2025
DESIGN MANAGER: MANDY KENT
PRODUCTION DESIGNER: MAV
CHECKED BY: E. NORRIS

Revision Schedule			
Rev	Date	By	Description


SHEET TITLE:
INTERIOR DETAILS

SCALE: AS SHOWN

SHEET NUMBER:

1506


DESIGN DEVELOPMENT ONLY - NOT INTENDED FOR CONSTRUCTION USE

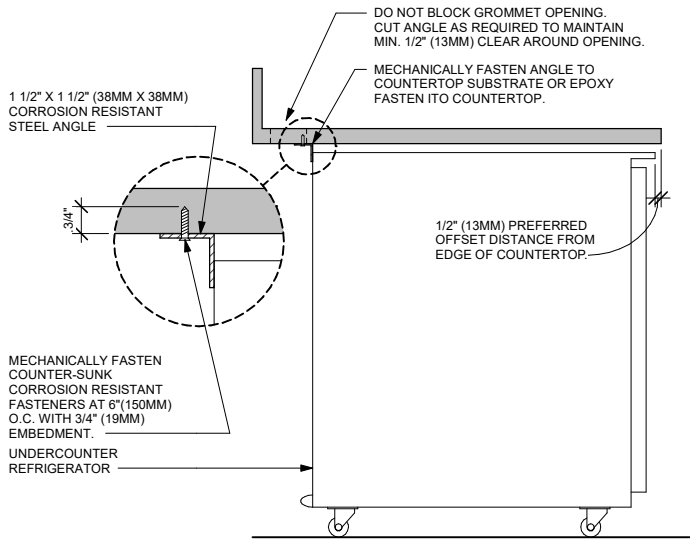

SECTION VIEW

NOTES


1. 24" (610MM) 1 1/2" X 1 1/2" (38MM X 38MM) STEEL ANGLE TO BE USED WITH SINGLE DOOR REFRIGERATORS.
2. 48" (1220MM) 1 1/2" X 1 1/2" (38MM X 38MM) STEEL ANGLE TO BE USED WITH DOUBLE DOOR REFRIGERATORS.

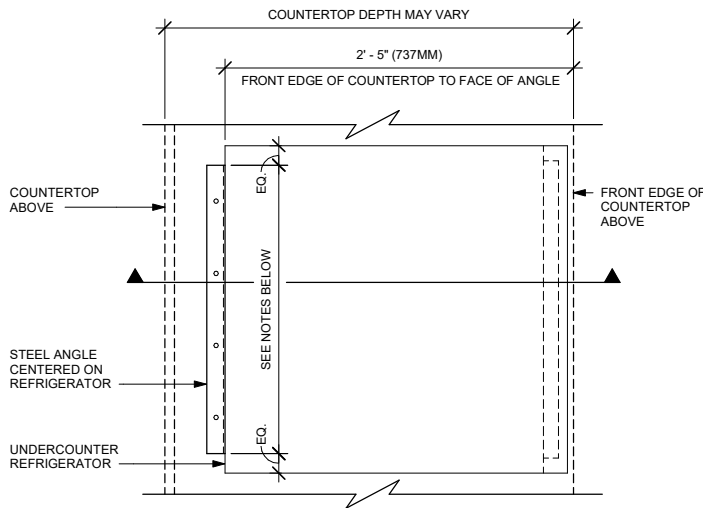

PLAN VIEW


1 UNDERCOUNTER REFRIGERATOR STOP INSTALLATION

Scale: 1 1/2" = 1'-0"

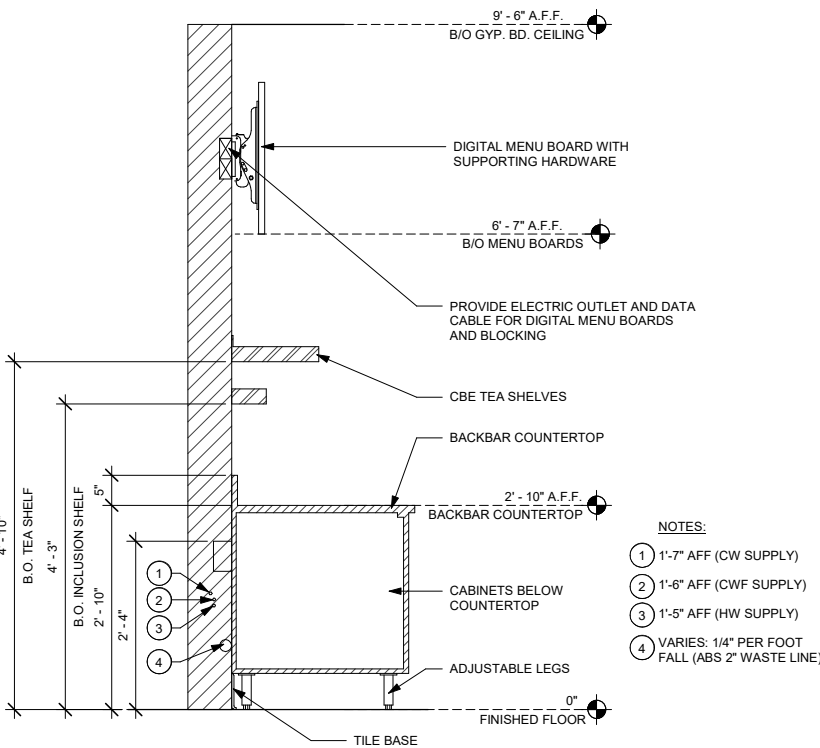

2 SECTION AT BACKBAR CB

Scale: 3/4" = 1'-0"

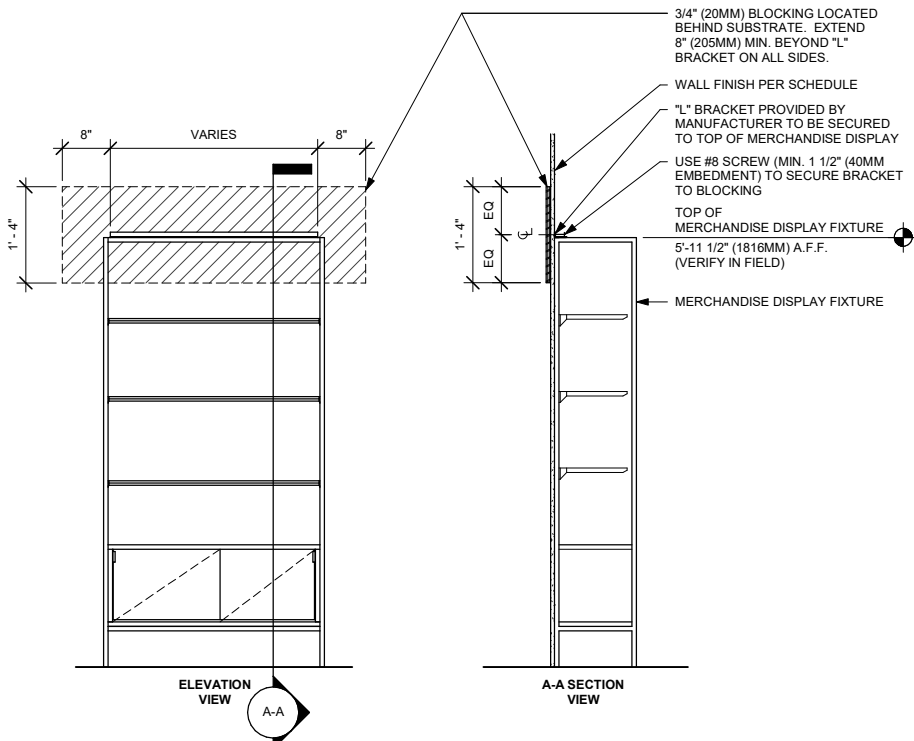

3 MERCHANDISE WALL BAY DISPLAY FIXTURE WALL ATTACHMENT

Scale: 3/4" = 1'-0"

ARCHITECT AND/OR ENGINEER OF RECORD
TO VERIFY, SPECIFY AND PLACE ALL
ELECTRICAL AND PLUMBING COMPONENTS.

ALL DETAILS ARE FOR DESIGN INTENT ONLY.
VENDOR TO FURNISH SHOP DRAWINGS TO
STARBUCKS STORE DESIGNER FOR
APPROVAL PRIOR TO FABRICATION.



STARBUCKS
2401 UTAH AVENUE SOUTH
SEATTLE, WASHINGTON 98134
(206) 318-1575

THESE DRAWINGS AND THE PROJECT MANUAL ARE CONFIDENTIAL AND SHALL REMAIN THE SOLE PROPERTY OF STARBUCKS CORPORATION, WHICH IS THE OWNER OF THE COPYRIGHT IN THIS WORK. THEY SHALL NOT BE REPRODUCED (IN WHOLE OR IN PART), SHARED WITH THIRD PARTIES OR USED IN ANY MANNER ON OTHER PROJECTS OR EXTENSIONS TO THIS PROJECT WITHOUT THE PRIOR WRITTEN CONSENT OF STARBUCKS CORPORATION. THESE DRAWINGS AND SPECIFICATIONS ARE INTENDED TO EXPRESS DESIGN INTENT FOR A PROTOTYPICAL STARBUCKS STORE (WHICH IS SUBJECT TO CHANGE AT ANYTIME) AND DO NOT REFLECT ACTUAL SITE CONDITIONS. NEITHER PARTY SHALL HAVE ANY OBLIGATION NOR LIABILITY TO THE OTHER (EXCEPT STATED ABOVE) UNTIL A WRITTEN AGREEMENT IS FULLY EXECUTED BY BOTH PARTIES.

STARBUCKS TEMPLATE VERSION I2025.08.27

ARCHITECT OF RECORD

THIS DRAWING IS A DESIGN DEVELOPMENT DOCUMENT. SITE SPECIFIC MODIFICATIONS MADE UNDER THE RESPONSIBLE CHARGE OF THE ARCHITECT AND/OR ENGINEER-OF-RECORD WILL BE REQUIRED PRIOR TO USING THIS DOCUMENT FOR BIDDING, PERMITTING, OR CONSTRUCTION.

PROJECT NAME:
TA CORDELE

PROJECT ADDRESS:
**397 ROCKHOUSE RD E
CORDELE, GA 31015**

STORE #: TBD
PROJECT #: 108648-001
ISSUE DATE: 12/03/2025
DESIGN MANAGER: MANDY KENT
PRODUCTION DESIGNER: MAV
CHECKED BY: E. NORRIS

Revision Schedule			
Rev	Date	By	Description

 
SHEET TITLE:
INTERIOR DETAILS

SCALE: AS SHOWN



SHEET NUMBER:

1507


DESIGN DEVELOPMENT ONLY - NOT INTENDED FOR CONSTRUCTION USE



  ALL DETAILS ARE FOR DESIGN INTENT ONLY.
VENDOR TO FURNISH SHOP DRAWINGS TO
STARBUCKS STORE DESIGNER FOR
APPROVAL PRIOR TO FABRICATION.




DESIGN DEVELOPMENT ONLY - NOT INTENDED FOR CONSTRUCTION USE

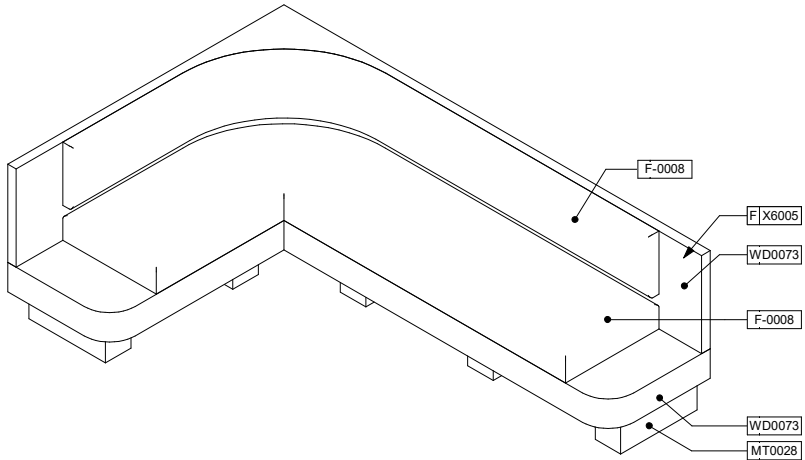


1 BANQUETTE - SHORT - 3D VIEW

Scale:

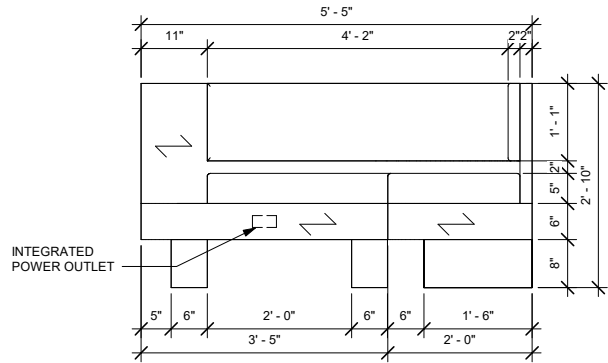


2 BANQUETTE - SHORT - SIDE ELEVATION

Scale: 3/4" = 1'-0"

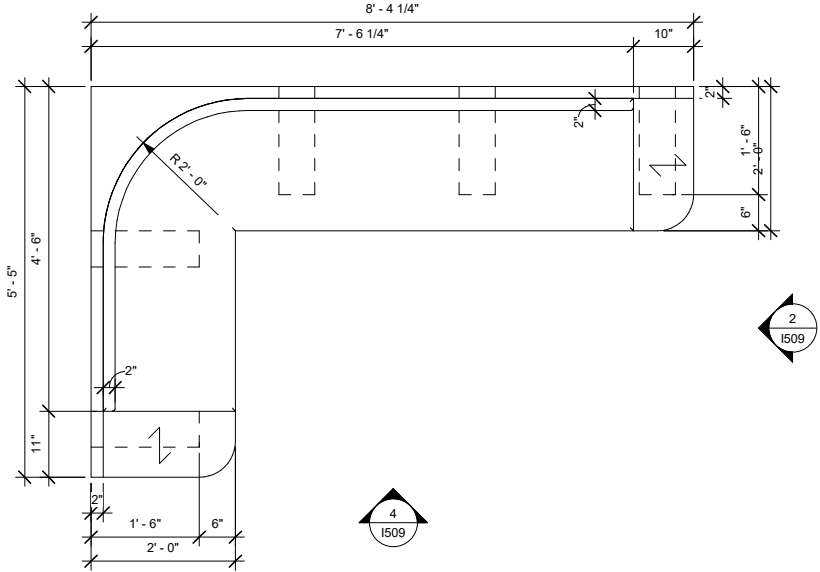

3 BANQUETTE - SHORT - PLAN

Scale: 3/4" = 1'-0"

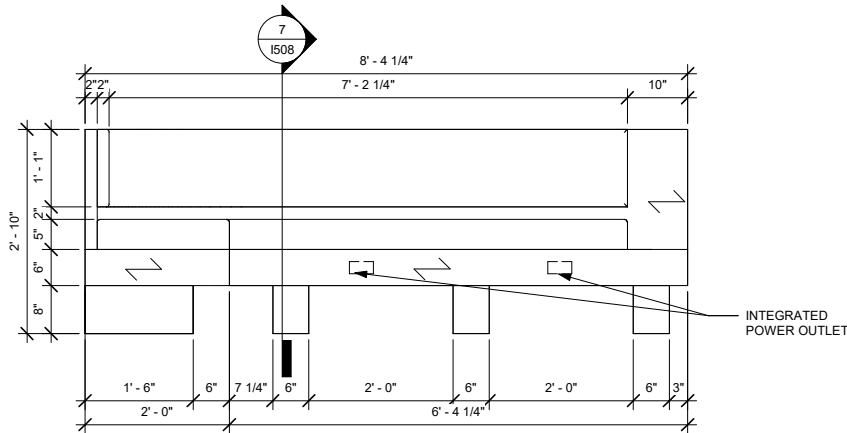


4 BANQUETTE - SHORT - FRONT ELEVATION

Scale: 3/4" = 1'-0"

ARCHITECT AND/OR ENGINEER OF RECORD
TO VERIFY, SPECIFY AND PLACE ALL
ELECTRICAL AND PLUMBING COMPONENTS.

ALL DETAILS ARE FOR DESIGN INTENT ONLY.
VENDOR TO FURNISH SHOP DRAWINGS TO
STARBUCKS STORE DESIGNER FOR
APPROVAL PRIOR TO FABRICATION.

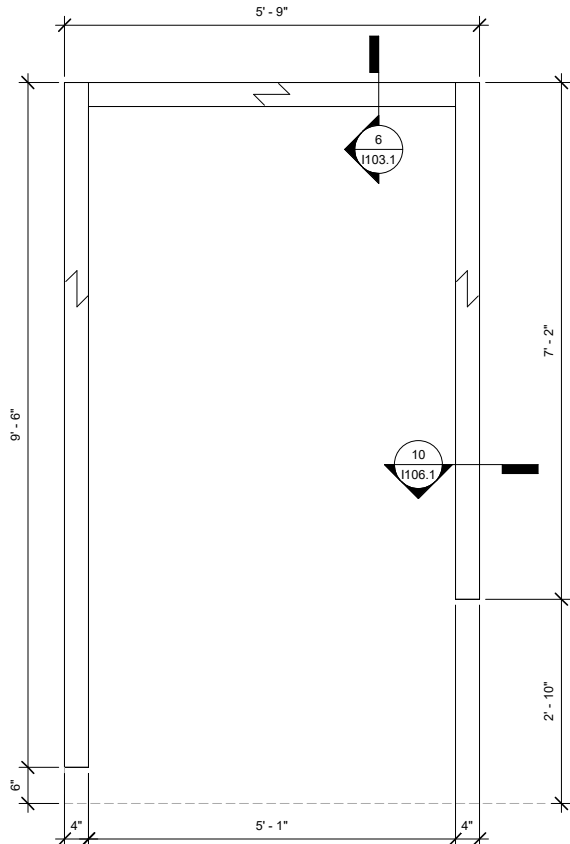

5 WOOD PORTAL AT BANQUETTE - ELEVATION

Scale: 3/4" = 1'-0"

DESIGN DEVELOPMENT ONLY - NOT INTENDED FOR CONSTRUCTION USE



STARBUCKS®
2401 UTAH AVENUE SOUTH
SEATTLE, WASHINGTON 98134
(206) 318-1575

THESE DRAWINGS AND THE PROJECT MANUAL ARE CONFIDENTIAL AND SHALL REMAIN THE SOLE PROPERTY OF STARBUCKS CORPORATION, WHICH IS THE OWNER OF THE COPYRIGHT IN THIS WORK. THEY SHALL NOT BE REPRODUCED (IN WHOLE OR IN PART), SHARED WITH THIRD PARTIES OR USED IN ANY MANNER ON OTHER PROJECTS OR EXTENSIONS TO THIS PROJECT WITHOUT THE PRIOR WRITTEN CONSENT OF STARBUCKS CORPORATION. THESE DRAWINGS AND SPECIFICATIONS ARE INTENDED TO EXPRESS DESIGN INTENT FOR A PROTOTYPICAL STARBUCKS STORE (WHICH IS SUBJECT TO CHANGE AT ANYTIME) AND DO NOT REFLECT ACTUAL SITE CONDITIONS. NEITHER PARTY SHALL HAVE ANY OBLIGATION NOR LIABILITY TO THE OTHER (EXCEPT STATED ABOVE) UNTIL A WRITTEN AGREEMENT IS FULLY EXECUTED BY BOTH PARTIES.

STARBUCKS TEMPLATE VERSION I|2025.08.27

ARCHITECT OF RECORD

THIS DRAWING IS A DESIGN DEVELOPMENT DOCUMENT. SITE SPECIFIC MODIFICATIONS MADE UNDER THE RESPONSIBLE CHARGE OF THE ARCHITECT AND/OR ENGINEER-OF-RECORD WILL BE REQUIRED PRIOR TO USING THIS DOCUMENT FOR BIDDING, PERMITTING, OR CONSTRUCTION.

PROJECT NAME:
TA CORDELE

PROJECT ADDRESS:
397 ROCKHOUSE RDE
CORDELE, GA 31015

STORE #: TBD
PROJECT #: 108648-001
ISSUE DATE: 12/03/2025
DESIGN MANAGER: MANDY KENT
PRODUCTION DESIGNER: MAV
CHECKED BY: E. NORRIS


Revision Schedule			
Rev	Date	By	Description

SHEET TITLE:
INTERIOR DETAILS

SCALE: AS SHOWN


SHEET NUMBER:
1509

ALL DETAILS ARE FOR DESIGN INTENT ONLY.
VENDOR TO FURNISH SHOP DRAWINGS TO
STARBUCKS STORE DESIGNER FOR
APPROVAL PRIOR TO FABRICATION.

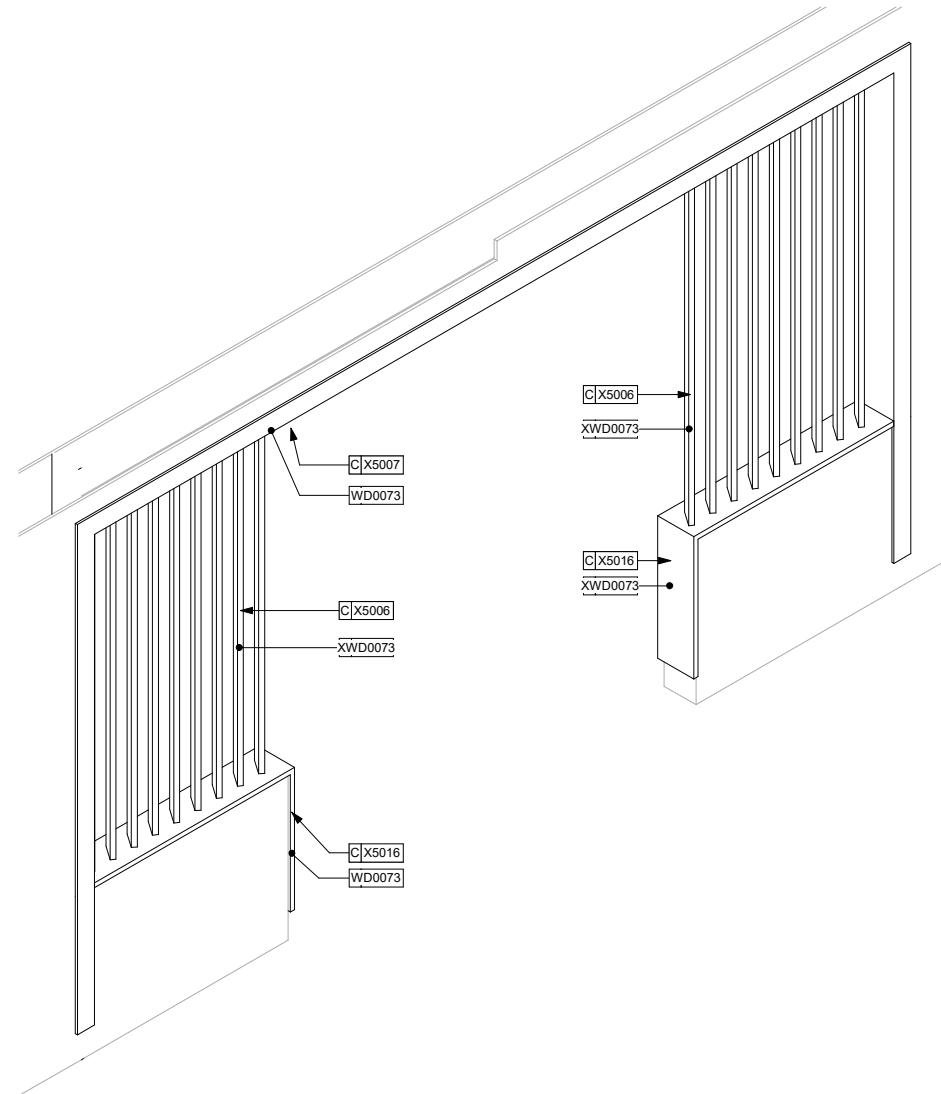


1 WOOD PORTAL AND SCREENS - 3D VIEW


CASEWORK VENDOR TO PROVIDE TEMPLATE
FOR WOOD SCREEN LAYOUT.

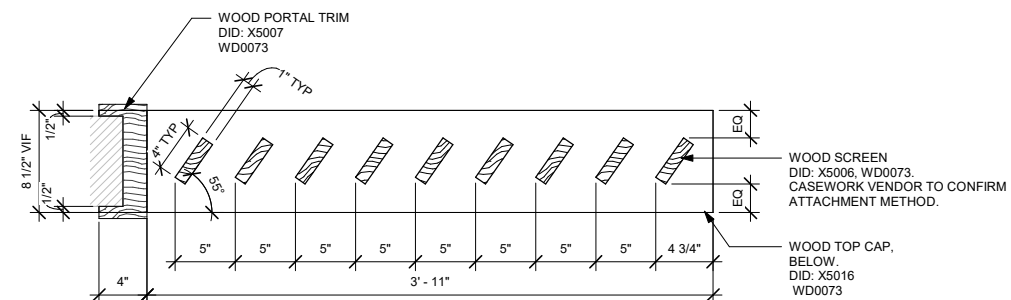


(F) WOOD SCREENS ENLARGED PLAN DETAIL

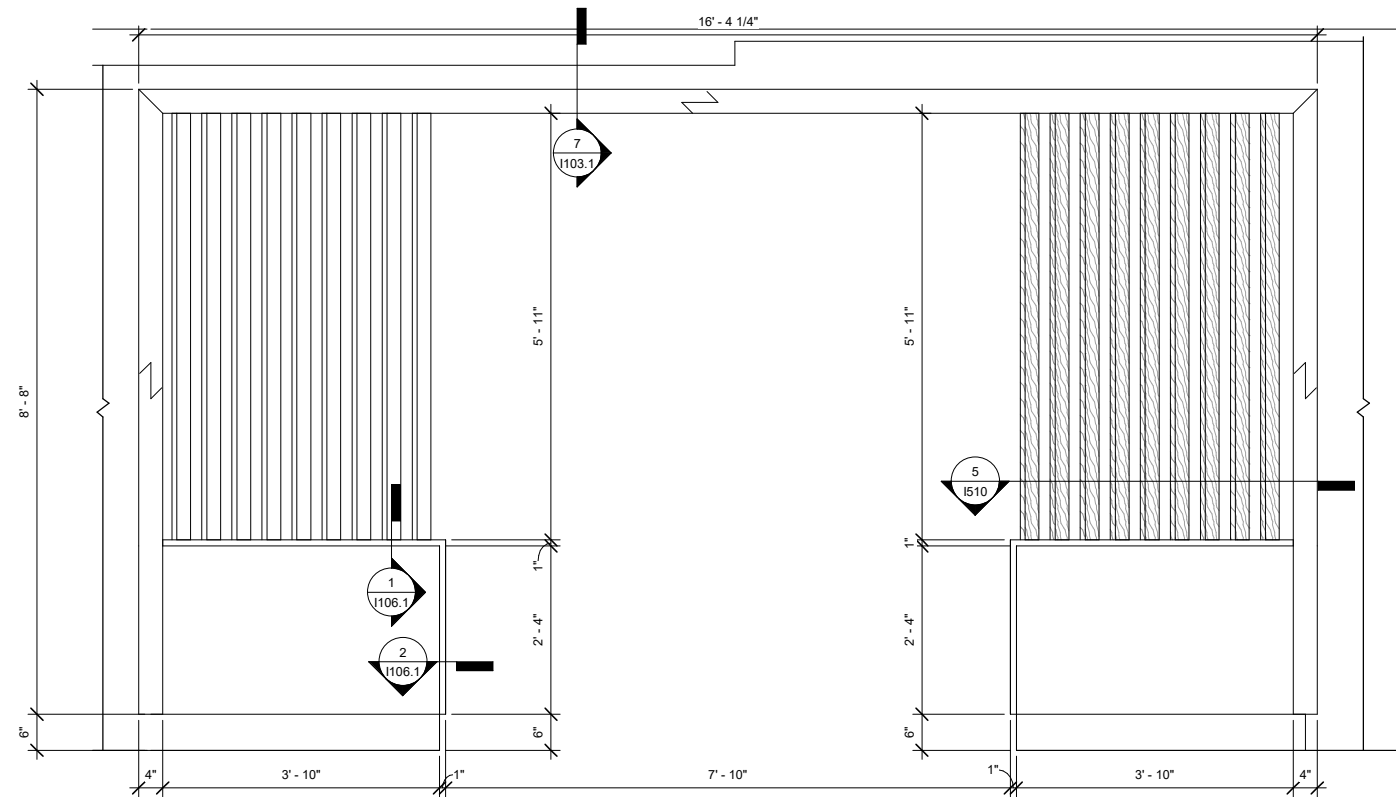

2 WOOD PORTAL AND SCREENS - FRONT ELEVATION

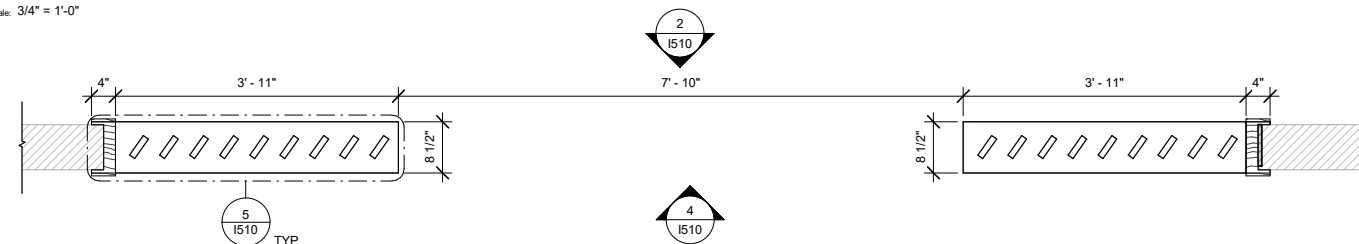

② WOOD PORTAL AND SCREENS - PLAN

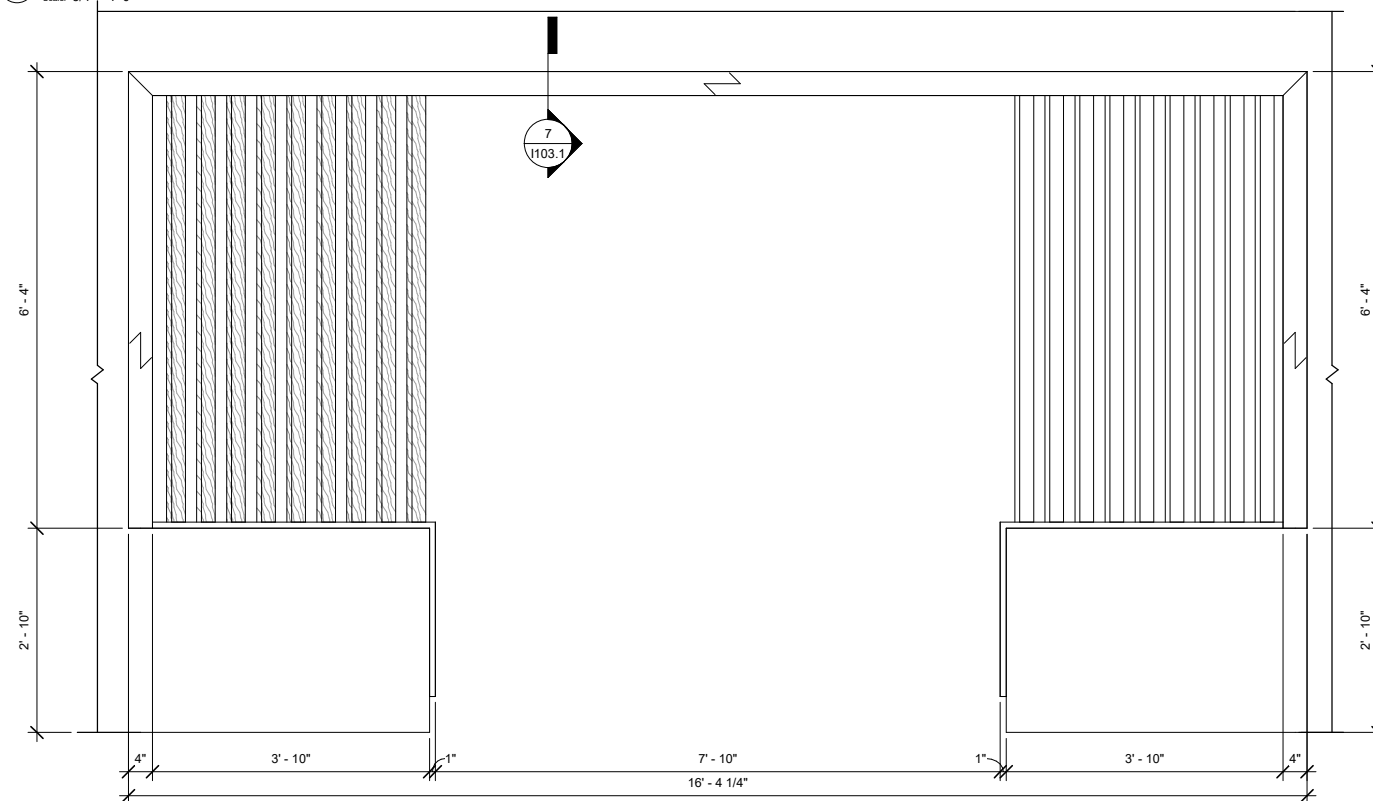

④ WOOD PORTAL AND SCREENS - BACK ELEVATION



STARBUCKS®
2401 UTAH AVENUE SOUTH
SEATTLE, WASHINGTON 98134
(206) 318-1575

THESE DRAWINGS AND THE PROJECT MANUAL ARE CONFIDENTIAL AND SHALL REMAIN THE SOLE PROPERTY OF STARBUCKS CORPORATION, WHICH IS THE OWNER OF THE COPYRIGHT IN THIS WORK. THEY SHALL NOT BE REPRODUCED (IN WHOLE OR IN PART), SHARED WITH THIRD PARTIES OR USED IN ANY MANNER ON OTHER PROJECTS OR EXTENSIONS TO THIS PROJECT WITHOUT THE PRIOR WRITTEN CONSENT OF STARBUCKS CORPORATION. THESE DRAWINGS AND SPECIFICATIONS ARE INTENDED TO EXPRESS DESIGN INTENT FOR A PROTOTYPICAL STARBUCKS STORE (WHICH IS SUBJECT TO CHANGE AT ANY TIME) AND DO NOT REFLECT ACTUAL SITE CONDITIONS. NEITHER PARTY SHALL HAVE ANY OBLIGATION NOR LIABILITY TO THE OTHER (EXCEPT STATED ABOVE) UNTIL A WRITTEN AGREEMENT IS FULLY EXECUTED BY BOTH PARTIES.

STARBUCKS TEMPLATE VERSION 11/2025.08.27

ARCHITECT OF RECORD

THIS DRAWING IS A DESIGN
DEVELOPMENT DOCUMENT.
SITE SPECIFIC MODIFICATIONS
MADE UNDER THE RESPONSIBLE
CHARGE OF THE ARCHITECT
AND/OR ENGINEER-OF-RECORD
WILL BE REQUIRED PRIOR TO
USING THIS DOCUMENT FOR
BIDDING, PERMITTING, OR
CONSTRUCTION.

PROJECT NAME:
TA CORD

PROJECT ADDRESS:
397 ROCKHOUSE RD E
CORDELE, GA 31015

STORE #:	TBD
PROJECT #:	108648-001
ISSUE DATE:	12/03/2025
DESIGN MANAGER:	MANDY KENT
PRODUCTION DESIGNER:	MAV
CHECKED BY:	E. NORRIS

Revision Schedule			
Rev	Date	By	Description

SHEET TITLE:
INTERIOR DETAILS

SCALE: AS SHOWN

1510

ABBREVIATIONS

AFF	ABOVE FINISHED FLOOR
AHJ	AUTHORITIES HAVING JURISDICTION
APPROX	APPROXIMATE
BLDG	BUILDING
CKT	CIRCUIT
CLG	CEILING
CONST	CONSTRUCTION
CW	COLD WATER
CXA	COMMISSIONING AGENT
DEG	DEGREES
DL	LIGHTS WITHIN DAYLIGHT ZONE
DM	STARBUCKS DESIGN MANAGER
DN	DOWN
DTL	DETAIL
DWG(S)	DRAWING(S)
EA	EACH
EC	ELECTRICAL CONTRACTOR
ECP	EQUIPMENT CONTROL PAC
EG	EXHAUST GRILLE
ELEC	ELECTRICAL
EM	EMERGENCY
EMS	ENERGY MANAGEMENT SYSTEM
EXIST	EXISTING
EXT	EXTERIOR
FC	STARBUCKS FIXTURE CONTRACTOR
F&I	FURNISH & INSTALL
FLR	FLOOR
FT	FOOT/FEET
GC	GENERAL CONTRACTOR
GFCI	GROUND FAULT CIRCUIT INTERRUPTER
GND	GROUND
HR	HOOR
HVAC	HEATING, VENTILATION, AIR CONDITIONING
HW	HOT WATER
LCP	LIGHTING CONTROL PANEL
LC	LICENSEE
LS	LIGHT SENSOR PHOTOCCELL
LV	LOW VOLTAGE
MAX	MAXIMUM
MC	MECHANICAL CONTRACTOR
MDP	MAIN DISTRIBUTION PANEL
MECH	MECHANICAL
MEP	MECHANICAL, ELECTRICAL, AND PLUMBING
MFG	MANUFACTURER
MIN	MINIMUM
NL	NIGHTLIGHT
NTS	NOT TO SCALE
OC	OVERCURRENT PROTECTION
PDM	STARBUCKS PROJECT DEVELOPMENT MANAGER
REF	REFERENCE
REQ(D)	REQUIRE(D)
REV	REVISION
SB	STARBUCKS
SF	SQUARE FEET
SHT	SHEET
SPECS	SPECIFICATION(S)
SST	STAINLESS STEEL
TEL	TELEPHONE
TEMP	TEMPORARY
TYP	TYPICAL
UC	UNDER COUNTER
UNO	UNLESS NOTED OTHERWISE
WH	WATER HEATER
WP	WEATHER PROOF

ELECTRICAL SYMBOL LEGEND

Ⓢ	JUNCTON BOX	Ⓢ	RECEPTACLE: DUPLEX
\$	SWITCH	Ⓢ	RECEPTACLE: DUPLEX - INDIVIDUAL BRANCH CIRCUIT
\$3	THREE-WAY SWITCH	Ⓢ	RECEPTACLE: QUAD
\$M	MOTION (OCCUPANCY) SENSOR SWITCH	Ⓢ	RECEPTACLE: QUAD - INDIVIDUAL BRANCH CIRCUIT
Ⓢ	SWITCHBACK	Ⓢ	RECEPTACLE: HIGH VOLTAGE
▼	TELEPHONE	Ⓢ	RECEPTACLE: FLOOR DUPLEX
Ⓢ	THERMOSTAT	Ⓢ	GROUNDING ELECTRODE CONNECTION
Ⓢ	THERMOSTAT SENSOR	NL	NIGHTLIGHTING 24HR/DAY
Ⓢ	DIMMER SWITCH	Ⓢ	PHOTOELECTRIC CELL
Ⓢ	RECEPTACLE: DATA	Ⓢ	SPEAKER
Ⓢ	RACEWAY CONCEALED IN CEILING OR WALL. HASH MARKS INDICATE NUMBER OF WIRES. #12 AWG WIRE UNLESS OTHERWISE NOTED. TWO WIRES PLUS GROUND IF NO HASH MARKS SHOWN. LONG HASH MARK DENOTES NEUTRAL. GROUND WIRE NOT SHOWN.	Ⓢ	WIFI ACCESS POINT
		Ⓢ	360 CAMERA
		Ⓢ	CARBON MONOXIDE SENSOR
		Ⓢ	CARBON DIOXIDE SENSOR

SECURITY SYSTEM NOTES

SECURITY WIRING AND SYSTEM PROVIDED BY LICENSEE. VERIFY SYSTEM REQUIREMENTS WITH LICENSEE PRIOR TO START OF CONSTRUCTION.

TELEPHONE SYSTEM NOTES

TELEPHONE WIRING AND SYSTEM PROVIDED BY LICENSEE. VERIFY SYSTEM REQUIREMENTS WITH LICENSEE PRIOR TO START OF CONSTRUCTION.

POS \ DATA LINE NOTES

POINT OF SALE WIRING AND SYSTEM PROVIDED BY LICENSEE. VERIFY SYSTEM REQUIREMENTS WITH LICENSEE PRIOR TO START OF CONSTRUCTION.

FIRE ALARM SYSTEM NOTES

FIRE ALARM WIRING AND SYSTEM PROVIDED BY LICENSEE. VERIFY SYSTEM REQUIREMENTS WITH LICENSEE PRIOR TO START OF CONSTRUCTION.

CARBON MONOXIDE (CO) DETECTOR NOTES

CARBON MONOXIDE (CO) DETECTOR DEVICE(S) AND LOW VOLTAGE WIRING PROVIDED BY LICENSEE. VERIFY SYSTEM REQUIREMENTS WITH LICENSEE PRIOR TO START OF CONSTRUCTION.

COMMUNICATION SYSTEM NOTES

CONFIRM PRIOR TO BEGINNING CONSTRUCTION THAT THE LICENSEE HAS FURNISHED AND INSTALLED ONE (1) ADDITIONAL 2" (51MM) (ENTRANCE) CONDUIT INCLUDING PULL STRING (FOR A TOTAL OF TWO (2)) FROM THE STREET FEED TO THE BUILDING AS IDENTIFIED BY THE INTERNET SERVICE PROVIDER.

WIRELESS NETWORK NOTES

CABLING FOR INTERNET SERVICE SHALL BE FURNISHED AND INSTALLED BY THE VENDOR FOR FIBER OR BROADBAND CONNECTIONS. T1 AND ETHERNET EXTENSION CABLING IS TO BE PROVIDED BY THE LICENSEE'S (TELEPHONE/ NETWORK) CABLING VENDOR. COORDINATE WITH THE LICENSEE.

MUSIC SYSTEM NOTES

LICENSEE TO PROVIDE AND INSTALL A COMPLETE WIRING SYSTEM FOR ALL MUSIC SPEAKERS. CONNECT SPEAKERS TO THE STARBUCKS PROVIDED MUSIC SYSTEM AND AMPLIFIER. MOUNT SPEAKERS WHERE SHOWN ON INTERIOR REFLECTED CEILING PLAN AND IN COORDINATION WITH ALL PLANS, DETAILS, AND MANUFACTURER'S INSTALLATION REQUIREMENTS. SET WATTAGE TAP ON EACH SPEAKER'S ROTARY SWITCH PER TAP SETTINGS NOTED ON PLANS.

CONTROLS AND OPERATION

THE GENERAL CONTRACTOR SHALL CONTACT <INSERT VENDOR NAME> PRIOR TO THE LAST WEEK OF CONSTRUCTION FOR COMMISSIONING AND COORDINATE REQUIREMENTS WITH STARBUCKS.

FURNISH AND INSTALL RACEWAYS WITH PULL STRINGS AND JUNCTION BOXES FOR THERMOSTAT(S) AND SENSOR(S).

SET RESTROOM OCCUPANCY SENSOR TO 5 MINUTE 'ON' DURATION IN SINGLE OCCUPANT RESTROOM AND TO 5 MINUTE 'ON' DURATION IN MULTI-OCCUPANT RESTROOM UNLESS JURISDICTION REQUIREMENTS STATE OTHERWISE.

COORDINATE WITH DRAWINGS AND LCP VENDOR FOR DEVICE LOCATIONS. VENDOR SHALL COMMISSION CONTROLS.

THE GENERAL CONTRACTOR IS TO COMPLETE FINAL CONNECTION AFTER DATA RACK AND NETWORK INSTALLATION. THE GENERAL CONTRACTOR IS TO CONTACT LCP VENDOR TO VERIFY SYSTEM OPERATION AND TROUBLESHOOT IF REQUIRED.

GENERAL ELECTRICAL NOTES

- ELECTRICAL CONTRACTOR SHALL COORDINATE ELECTRICAL WORK WITH OTHER TRADES. THE ARCHITECTURAL DRAWINGS SHALL TAKE PRECEDENCE OVER ALL OTHER DRAWINGS. DO NOT SCALE DISTANCES OFF THE ELECTRICAL DRAWINGS; USE ACTUAL BUILDING DIMENSIONS. OVERALL CASEWORK COMPONENT DIMENSIONING ON ELECTRICAL DETAILS ARE SHOWN FOR REFERENCE AND COORDINATION ONLY. SEE PROJECT MANUAL.
- DRAWINGS ARE DIAGRAMMATIC AND INDICATE GENERAL INTENT OR ARRANGEMENT OF SYSTEM(S). FURNISH AND INSTALL ALL REQUIRED COMPONENTS, WHETHER INDICATED OR NOT, TO PROVIDE A COMPLETE AND OPERATING SYSTEM.
- ELECTRICAL CONTRACTOR SHALL BE TESTED FOR PROPER OPERATION. BALANCE ALL BRANCH CIRCUIT LOADS BETWEEN THE PHASES OF THE SYSTEM WITHIN 10% OF THE HIGHEST PHASE LOAD IN EACH PANEL BOARD.
- ELECTRICAL CONTRACTOR SHALL SCHEDULE ALL ELECTRICAL SYSTEM OUTAGES WITH THE GENERAL CONTRACTOR AND LICENSEE AT LEAST 24 HOURS IN ADVANCE. UNLESS APPROVED OTHERWISE, ALL OUTAGES SHALL OCCUR BETWEEN 11:00PM AND 5:00AM.
- ELECTRICAL CONTRACTOR SHALL FURNISH AND INSTALL ALL NECESSARY CONDUIT AND J-BOXES TO SUPPORT A COMPLETE SECURITY, PHONE, POS AND DATA SYSTEMS. SEE MANAGER WORKSTAT AND BAR POINT OF SALE (POS) POWER/TELECOM/SECURITY DIAGRAM. COORDINATE ALL DEVICE LOCATIONS AND MOUNTING HEIGHTS WITH SECURITY VENDOR PRIOR TO ROUGH-IN. PROVIDE END-TO-END PULL STRINGS IN ALL CONDUITS. LABEL EACH END OF THE PULL STRING WITH CONDUIT SYSTEM ("SECURITY") AND DESTINATION ("CAFÉ", "FRONT BAR", ETC.). PROVIDE INSULATED BUSHINGS ON ALL STUBBED-UP AND EXPOSED CONDUIT ENDS.
- ELECTRICAL CONTRACTOR SHALL COORDINATE WITH THE GENERAL CONTRACTOR TO PATCH AND REPAIR ALL EXISTING WALLS, FLOORS, CEILINGS OR OTHER SURFACES IDENTIFIED TO REMAIN THAT MAY BECOME DAMAGED DURING THE COURSE OF WORK.
- EXPPOSED/SURFACE MOUNTED CONDUITS SHALL ONLY BE ALLOWED WHERE NECESSARY IN EXPOSED CEILING AREAS. IF CONDUITS NEED TO BE SURFACE MOUNTED TO WALLS, COORDINATE WITH STARBUCKS PROJECT DEVELOPMENT MANAGER FOR APPROVAL.
- VERIFY LOCATION OF ALL OUTLETS AND SWITCHES WITH ARCHITECTURAL DRAWINGS, INTERIOR DETAILS, FINISH SCHEDULES, GENERAL CONTRACTOR, EQUIPMENT VENDORS, STARBUCKS AND EXISTING SITE CONDITIONS. VERIFY FINAL DOOR HINGE LOCATION PRIOR TO SWITCH INSTALLATION AND ADJUST SWITCH LOCATION IF NEEDED. DO NOT MOUNT RECEPTACLES/SWITCHES IN LOCATIONS THAT WOULD CONFLICT WITH MIRRORS, SEAMS OF WALLS, WAINSCOTS, TILE TRANSITIONS, ETC.

GENERAL NOTES

SCOPE
THE INTENT OF THE DRAWINGS AND PROJECT MANUAL IS TO PROVIDE A COMPLETE AND FULLY OPERATIONAL ELECTRICAL SYSTEM. THE ELECTRICAL CONTRACTOR SHALL FURNISH AND INSTALL ALL LABOR, MATERIAL, AND EQUIPMENT NECESSARY TO COMPLETE THE ELECTRICAL WORK.

SITE EXAMINATION
THE ELECTRICAL CONTRACTOR SHALL THOROUGHLY EXAMINE ALL AREAS WHERE EQUIPMENT, CONDUIT, AND WIRING WILL BE INSTALLED AND WILL REPORT ANY CONDITION THAT, IN HIS OPINION, PREVENTS THE PROPER INSTALLATION OF THE ELECTRICAL WORK.

STANDARDS
EQUIPMENT AND MATERIALS SHALL CONFORM WITH APPROPRIATE PROVISIONS OF CSA, ULC, NEC, ASTM, UL, ETL, NEMA, ANSI, AS APPLICABLE TO EACH INDIVIDUAL UNIT OR ASSEMBLY.

CODES
ALL WORK SHALL BE PERFORMED IN STRICT ACCORDANCE WITH ALL APPLICABLE PROVINCIAL AND LOCAL CODES AND ORDINANCES. IN CASE OF CONFLICT BETWEEN THE DRAWINGS AND SPECIFICATIONS AND THE CODES, THE HIGHEST STANDARD SHALL APPLY. ELECTRICAL CONTRACTOR SHALL SATISFY CODE REQUIREMENTS AS A MINIMUM STANDARD WITHOUT ANY EXTRA COST TO STARBUCKS OR THE LICENSEE.

PERMITS AND FEES
THE ELECTRICAL CONTRACTOR SHALL PROCURE AND PAY FOR ALL PERMITS, FEES, AND INSPECTIONS NECESSARY TO COMPLETE THE ELECTRICAL WORK.

WARRANTY
THE ELECTRICAL CONTRACTOR SHALL UNCONDITIONALLY WARRANT ALL WORK TO BE FREE OF DEFECTS IN MATERIAL AND WORKMANSHIP FOR A PERIOD OF ONE (1) YEAR FROM THE DATE OF FINAL ACCEPTANCE BY STARBUCKS AND WILL REPAIR OR REPLACE ANY DEFECTIVE WORK PROMPTLY AND WITHOUT CHARGE AND RESTORE ANY OTHER EXISTING WORK DAMAGED IN THE COURSE OF REPAIRING DEFECTIVE MATERIALS AND WORKMANSHIP.

DESIGN DEVELOPMENT ONLY - NOT INTENDED FOR CONSTRUCTION USE



STARBUCKS®
2401 UTAH AVENUE SOUTH
SEATTLE, WASHINGTON 98134
(206) 318-1575

THESE DRAWINGS AND THE PROJECT MANUAL ARE CONFIDENTIAL AND SHALL REMAIN THE SOLE PROPERTY OF STARBUCKS CORPORATION, WHICH IS THE OWNER OF THE COPYRIGHT IN THIS WORK. THEY SHALL NOT BE REPRODUCED (IN WHOLE OR IN PART), SHARED WITH THIRD PARTIES OR USED IN ANY MANNER ON OTHER PROJECTS OR EXTENSIONS TO THIS PROJECT WITHOUT THE PRIOR WRITTEN CONSENT OF STARBUCKS CORPORATION. THESE DRAWINGS AND SPECIFICATIONS ARE INTENDED TO EXPRESS DESIGN INTENT FOR A PROTOTYPICAL STARBUCKS STORE (WHICH IS SUBJECT TO CHANGE AT ANYTIME) AND DO NOT REFLECT ACTUAL SITE CONDITIONS. NEITHER PARTY SHALL HAVE ANY OBLIGATION NOR LIABILITY TO THE OTHER (EXCEPT STATED ABOVE) UNTIL A WRITTEN AGREEMENT IS FULLY EXECUTED BY BOTH PARTIES.

STARBUCKS TEMPLATE VERSION I2025.08.27

ARCHITECT OF RECORD

THIS DRAWING IS A DESIGN DEVELOPMENT DOCUMENT. SITE SPECIFIC MODIFICATIONS MADE UNDER THE RESPONSIBLE CHARGE OF THE ARCHITECT AND/OR ENGINEER-OF-RECORD WILL BE REQUIRED PRIOR TO USING THIS DOCUMENT FOR BIDDING, PERMITTING, OR CONSTRUCTION.

PROJECT NAME:

TA CORDELE

PROJECT ADDRESS:

397 ROCKHOUSE RD E
CORDELE, GA 31015

STORE #:	TBD
PROJECT #:	108648-001
ISSUE DATE:	12/03/2025
DESIGN MANAGER:	MANDY KENT
PRODUCTION DESIGNER:	MAV
CHECKED BY:	E. NORRIS


Revision Schedule			
Rev	Date	By	Description

SHEET TITLE:
ELECTRICAL NOTES

SCALE: AS SHOWN

SHEET NUMBER:
E001

LIGHTING FIXTURE SCHEDULE - "L"						
DESIGN ID	COUNT	DESCRIPTION	FURN. BY	INST. BY	BULB	COMMENTS
PENDANT						
25119	3	PENDANT - CALDERA 9IN - NATURAL BRASS	SB	GC	AS PACKAGED: 1X LED G25 6.5W (DOWN); 1X LED A15 4.5W (UP)	SUPPLIER: DOLAN HOSPITALITY. DROP LENGTH: 2'-8"
RECESSED CAN						
21771	47	CAN - LED ADJUSTABLE RECESSED - 3IN 75MM - BLACK - 800LM FLOOD	SB	GC	INTEGRATED LED	
SCONCE						
15336	3	SCONCE - MESH CYLINDER MINI - BRONZE	SB	GC	(1) LED 400LM 2700K (INCLUDED), OR EQUAL	
20720	3	SCONCE - JUNIPER THIN - 24IN 610MM - SATIN BRASS	SB	GC	INTEGRATED LED	
20749	4	SCONCE - KUZCO PLUTO SINGLE - VINTAGE BRASS	SB	GC	AS PACKAGED: 1X LED G16 5W E26 BASE	(2) FROM EXCESS INVENTORY
25154	2	SCONCE - NATHAN - AGED BRASS	SB	GC	AS PACKAGED: 1X LED A19 7W E26 BASE	SUPPLIER: DOLAN HOSPITALITY
TRACK						
12946	7	TRACK - WITH CONNECTORS - 4FT 122CM - BLACK - 1 CIRCUIT	SB	GC		
21779	7	TRACK - LED FIXTURE WITH SNOOT - 3IN 75MM - BLACK - 1100LM FLOOD	SB	GC	INTEGRATED LED	
TROFFER						
21783	8	TROFFER - LED RECESSED - 24X48IN 600X1200MM - WHITE - 4300LM	GC	GC	INTEGRATED LED	

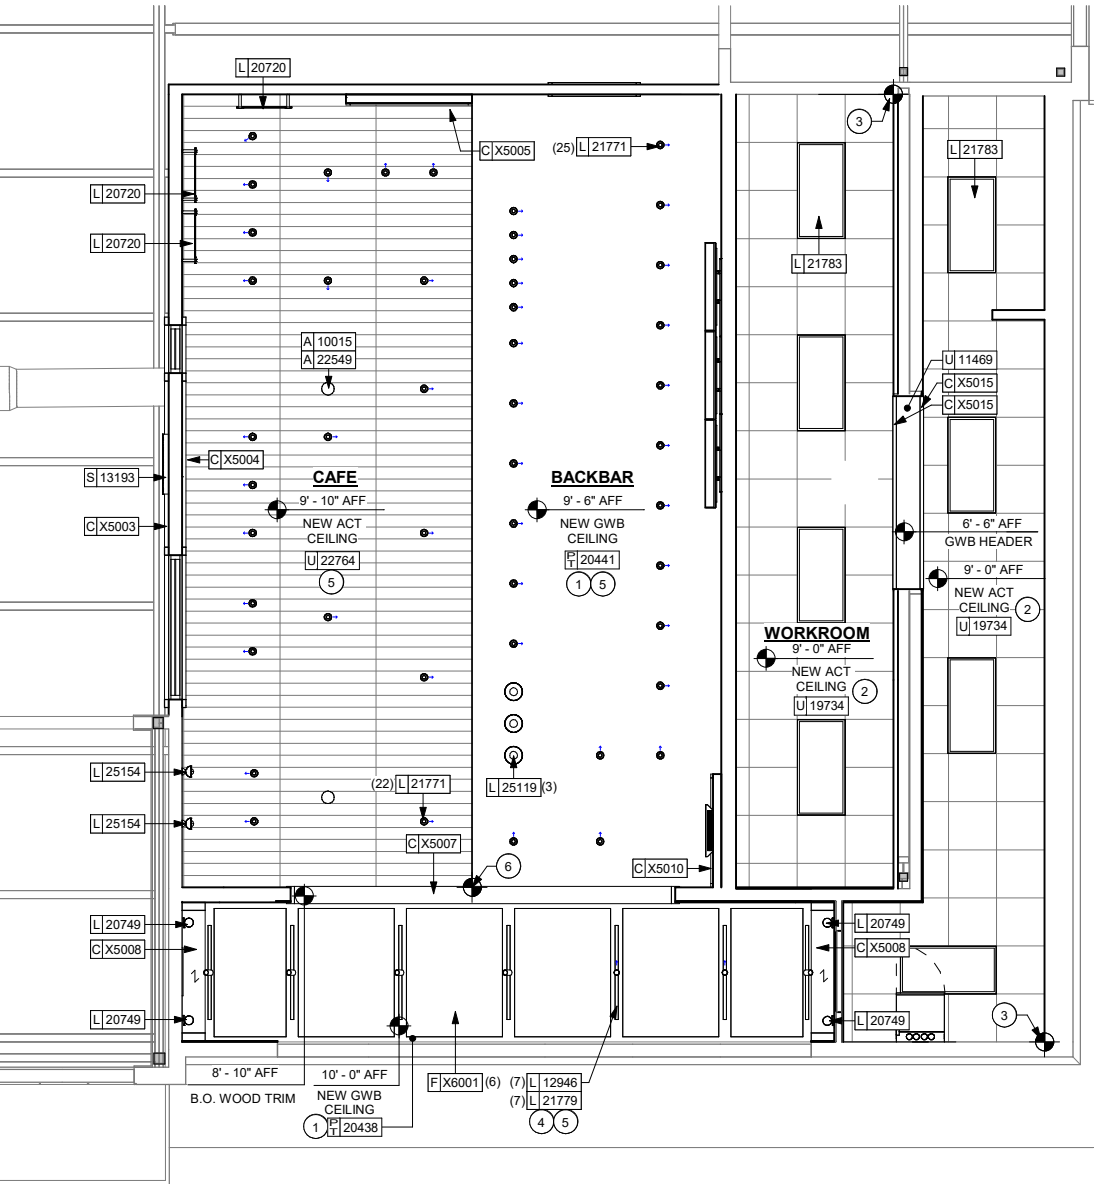

1 LIGHTING DESIGN PLAN

Scale: 1/4" = 1'-0"

KEYED NOTES

- GWB SOFFIT WITH SMOOTH FINISH (PAINT AS SCHEDULED).
- WASHABLE CEILING TILE LOCATED IN BACK OF HOUSE.
- PLATFORM FOR WATER HEATER AND WATER FILTRATION EQUIPMENT. LIFT CEILING IN THIS AREA ONLY TO ENSURE ADEQUATE CLEARANCES FOR SERVICING.
- SURFACE MOUNT LIGHT TRACK DIRECTLY TO CEILING/SOFFIT.
- ADJUST FOCUS OF ALL TRACK LIGHTING AND RECESSED DIRECTIONAL LIGHTING TO FULLY ILLUMINATE MENU BOARDS, MERCHANDISE BAYS, AND ARTWORK.
- CEILING GRID INSTALLATION START POINT WHERE INDICATED.

GENERAL NOTES

- ALL FIXTURES IN WORK ROOM, BACK AND FRONT LINE, ABOVE CONDIMENT CART, AND ANY OTHER AREAS WHERE EXPOSED FOOD, CLEAN EQUIPMENT OR UTENSILS, OR UNWRAPPED SINGLE SERVICE ITEMS WILL BE EXPOSED, SHALL HAVE SHATTERPROOF LAMPS IF THE FIXTURE IS NOT LENSED. ARCHITECT OF RECORD TO INCLUDE APPROPRIATE LAMPS / FIXTURES ON DRAWINGS AND SCHEDULES, AND COMPLY WITH ANY ADDITIONAL JURISDICTIONAL LIGHTING REQUIREMENT.
- PROVIDE GROMMET AT ALL CEILING PENETRATIONS FOR FIXTURES/SUPPORTS.
- ARCHITECT OF RECORD TO SPECIFY AND LOCATE EMERGENCY LIGHTS AND EXITS SIGNS AS REQUIRED BY CODE. FIXTURES TO BE SUPPLIED AND INSTALLED BY GENERAL CONTRACTOR.
- ADJUST FOCUS OF ALL TRACK AND RECESSED DIRECTIONAL LIGHTING TO FULLY ILLUMINATE ALL ARTWORK, MENU BOARDS, AND MERCHANDISE BAYS. COORDINATE AIMING WITH OWNER.
- IF PENDANT CYLINDERS CAN SUSPENDED LENGTH EXCEEDS 48" (1220MM) FROM CEILING, REPLACE WITH SURFACE MOUNTED CYLINDER CANS AND SUSPEND WITH GENERAL CONTRACTOR SUPPLIED CONDUIT AND J-BOX TO DIMENSIONED HEIGHT.
- BALLAST BOXES, TRANSFORMERS, JUNCTION BOXES, AND WIRING FOR ALL LIGHT FIXTURES TO BE INSTALLED HIDDEN FROM VIEW.

LICENSED STORES RESPONSIBILITY LEGEND

- SB - STARBUCKS
FC - STARBUCKS FIXTURE CONTRACTOR
LC - LICENSEE
GC - LICENSEE'S GENERAL CONTRACTOR

ARCHITECT AND/OR ENGINEER OF RECORD TO VERIFY ALL ELECTRICAL REQUIREMENTS AND REVISE AS NEEDED.

ARCHITECT AND/OR ENGINEER OF RECORD TO PROVIDE ALL ELECTRICAL DIAGRAMS, CALCULATIONS, AND DETAILS AS REQUIRED.

ARCHITECT AND/OR ENGINEER OF RECORD TO VERIFY THAT HVAC DOES NOT INTERFERE WITH LIGHTING PLACEMENT. NOTIFY STARBUCKS DESIGN MANAGER OF ANY CONFLICTS.



DESIGN DEVELOPMENT ONLY - NOT INTENDED FOR CONSTRUCTION USE



STARBUCKS®
2401 UTAH AVENUE SOUTH
SEATTLE, WASHINGTON 98134
(206) 318-1575

THESE DRAWINGS AND THE PROJECT MANUAL ARE CONFIDENTIAL AND SHALL REMAIN THE SOLE PROPERTY OF STARBUCKS CORPORATION, WHICH IS THE OWNER OF THE COPYRIGHT IN THIS WORK. THEY SHALL NOT BE REPRODUCED (IN WHOLE OR IN PART), SHARED WITH THIRD PARTIES OR USED IN ANY MANNER ON OTHER PROJECTS OR EXTENSIONS TO THIS PROJECT WITHOUT THE PRIOR WRITTEN CONSENT OF STARBUCKS CORPORATION. THESE DRAWINGS AND SPECIFICATIONS ARE INTENDED TO EXPRESS DESIGN INTENT FOR A PROTOTYPICAL STARBUCKS STORE (WHICH IS SUBJECT TO CHANGE AT ANYTIME) AND DO NOT REFLECT ACTUAL SITE CONDITIONS. NEITHER PARTY SHALL HAVE ANY OBLIGATION NOR LIABILITY TO THE OTHER (EXCEPT STATED ABOVE) UNTIL A WRITTEN AGREEMENT IS FULLY EXECUTED BY BOTH PARTIES.

STARBUCKS TEMPLATE VERSION I/2025.08.27

ARCHITECT OF RECORD

THIS DRAWING IS A DESIGN DEVELOPMENT DOCUMENT. SITE SPECIFIC MODIFICATIONS MADE UNDER THE RESPONSIBLE CHARGE OF THE ARCHITECT AND/OR ENGINEER-OF-RECORD WILL BE REQUIRED PRIOR TO USING THIS DOCUMENT FOR BIDDING, PERMITTING, OR CONSTRUCTION.

PROJECT NAME:
TA CORDELE

PROJECT ADDRESS:
397 ROCKHOUSE RD E
CORDELE, GA 31015

STORE #: TBD
PROJECT #: 108648-001
ISSUE DATE: 12/03/2025
DESIGN MANAGER: MANDY KENT
PRODUCTION DESIGNER: MAV
CHECKED BY: E. NORRIS

Revision Schedule

Rev	Date	By	Description

SHEET TITLE:
LIGHTING DESIGN PLAN


SCALE: AS SHOWN

SHEET NUMBER:

E102

POWER AND DATA RECEPTACLES AT 28" (711MM) TO TOP OF RECEPTACLE A.F.F.
•DEDICATED RECEPTACLE FOR UPS (POS AND PED)
•2-DATA PORT FOR POS, PED AND/OR CONNECT DEVICES

18" X 3" (457MM X 76MM) STUB-UP PENETRATION AREA. SUPPLY POWER, DATA AND PHONE CONDUITS FOR POS AND POWER CONDUIT FOR PASTRY CASE. SEE BUILDING FLOOR PENETRATION PLAN FOR FINAL LOCATION.

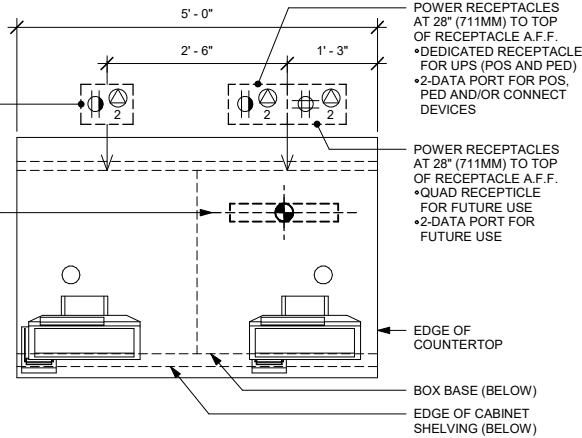


1 POS 03-01 ELECTRICAL

Scale: 3/4" = 1'-0"


POWER AND DATA RECEPTACLES AT 28" (711MM) TO TOP OF RECEPTACLE A.F.F.
•QUAD RECEPTACLE FOR LICENSED STORES DPM TABLET AND FUTURE USE
•2-DATA PORT FOR LICENSED STORES DPM TABLET AND SPARE

COUNTERTOP GROMMET FOR DPM TABLET (ONLY REQUIRED FOR LICENSED STORES PROJECTS)

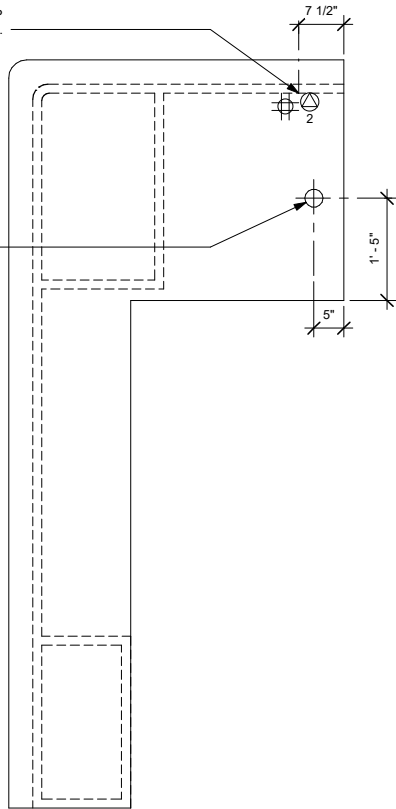


3 HOS 02-01 ELECTRICAL

Scale: 3/4" = 1'-0"

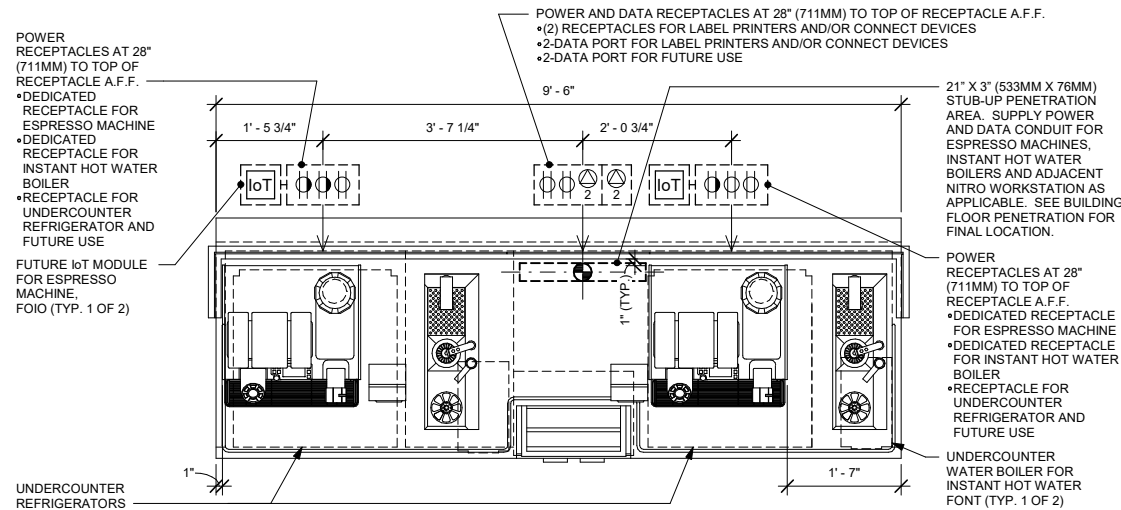


2 ESP 07-03 ELECTRICAL

Scale: 3/4" = 1'-0"

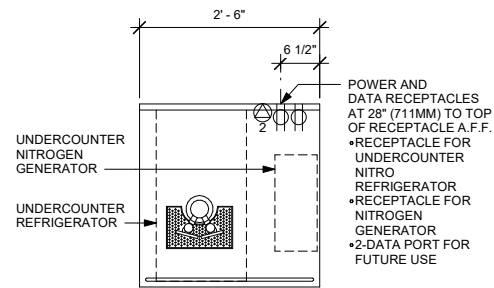


4 NIT 11-01 ELECTRICAL

Scale: 3/4" = 1'-0"

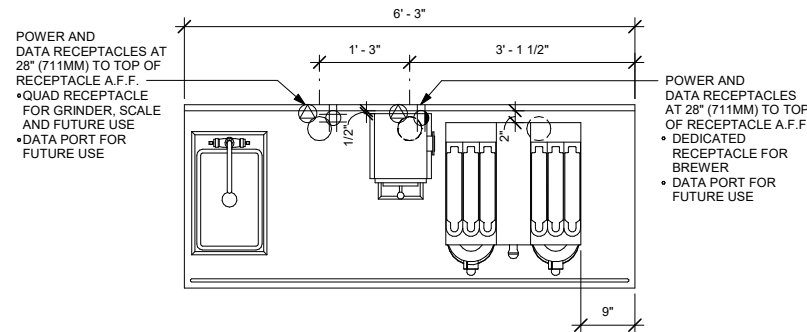

6 BRW ELECTRICAL


Scale: 3/4" = 1'-0"

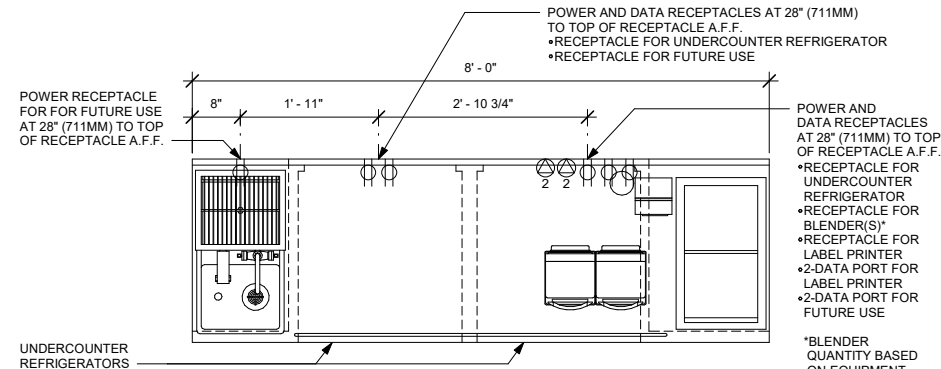

5 CBE 10-01 ELECTRICAL

Scale: 3/4" = 1'-0"

POWER AND DATA RECEPTACLES AT 28" (711MM) TO TOP OF RECEPTACLE A.F.F.
•(2) DEDICATED RECEPTACLE FOR WARMING
•2-DATA PORT FOR FUTURE USE

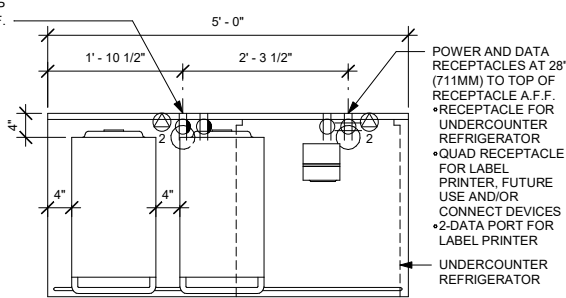

7 WRM 04-01 ELECTRICAL

Scale: 3/4" = 1'-0"

ARCHITECT AND/OR ENGINEER OF RECORD TO VERIFY ALL ELECTRICAL REQUIREMENTS AND REVISE AS NEEDED.

ARCHITECT AND/OR ENGINEER OF RECORD TO PROVIDE ALL ELECTRICAL DIAGRAMS, CALCULATIONS, AND DETAILS AS REQUIRED.



STARBUCKS®
2401 UTAH AVENUE SOUTH
SEATTLE, WASHINGTON 98134
(206) 318-1575

THESE DRAWINGS AND THE PROJECT MANUAL ARE CONFIDENTIAL AND SHALL REMAIN THE SOLE PROPERTY OF STARBUCKS CORPORATION, WHICH IS THE OWNER OF THE COPYRIGHT IN THIS WORK. THEY SHALL NOT BE REPRODUCED (IN WHOLE OR IN PART), SHARED WITH THIRD PARTIES OR USED IN ANY MANNER ON OTHER PROJECTS OR EXTENSIONS TO THIS PROJECT WITHOUT THE PRIOR WRITTEN CONSENT OF STARBUCKS CORPORATION. THESE DRAWINGS AND SPECIFICATIONS ARE INTENDED TO EXPRESS DESIGN INTENT FOR A PROTOTYPICAL STARBUCKS STORE (WHICH IS SUBJECT TO CHANGE AT ANYTIME) AND DO NOT REFLECT ACTUAL SITE CONDITIONS. NEITHER PARTY SHALL HAVE ANY OBLIGATION NOR LIABILITY TO THE OTHER (EXCEPT STATED ABOVE) UNTIL A WRITTEN AGREEMENT IS FULLY EXECUTED BY BOTH PARTIES.

STARBUCKS TEMPLATE VERSION I2025.08.27

ARCHITECT OF RECORD

THIS DRAWING IS A DESIGN DEVELOPMENT DOCUMENT. SITE SPECIFIC MODIFICATIONS MADE UNDER THE RESPONSIBLE CHARGE OF THE ARCHITECT AND/OR ENGINEER-OF-RECORD WILL BE REQUIRED PRIOR TO USING THIS DOCUMENT FOR BIDDING, PERMITTING, OR CONSTRUCTION.

PROJECT NAME:
TA CORDELE

PROJECT ADDRESS:
397 ROCKHOUSE RD E
CORDELE, GA 31015

STORE #: TBD
PROJECT #: 108648-001
ISSUE DATE: 12/03/2025
DESIGN MANAGER: MANDY KENT
PRODUCTION DESIGNER: MAV
CHECKED BY: E. NORRIS

Revision Schedule				
Rev	Date	By	Description	


SHEET TITLE:
ELECTRICAL DETAILS

SCALE: AS SHOWN


SHEET NUMBER:

E501


DESIGN DEVELOPMENT ONLY - NOT INTENDED FOR CONSTRUCTION USE

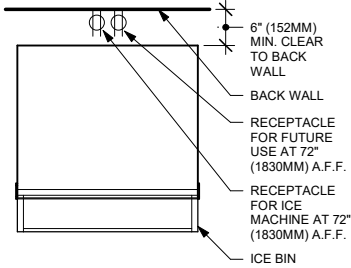


1 ICE MACHINE - ELECTRICAL
Scale: 3/4" = 1'-0"

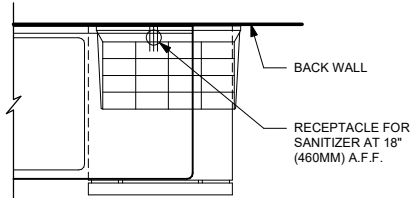


2 SANITIZING WORKSTATION - ELECTRICAL
Scale: 3/4" = 1'-0"

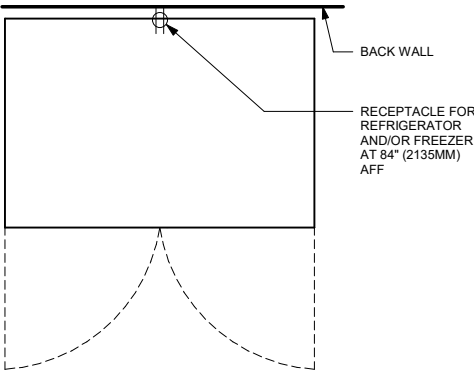


3 REFRIGERATOR/FREEZER - ELECTRICAL
Scale: 3/4" = 1'-0"

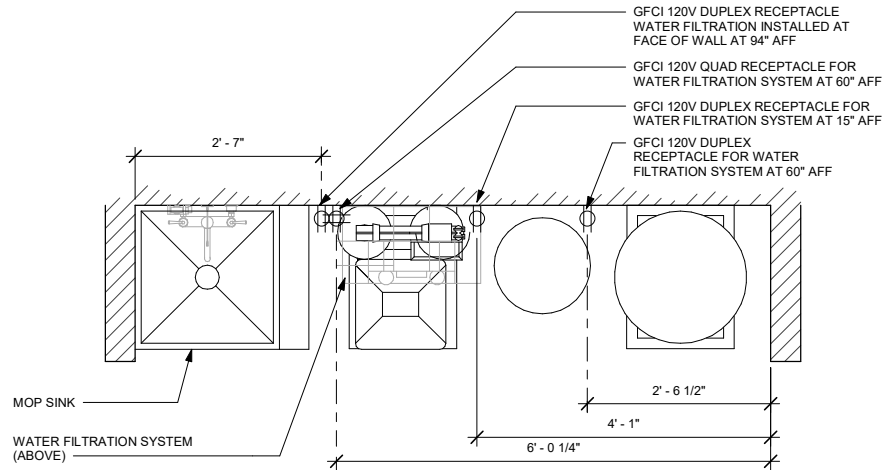


4 WATER FILTRATION - CONFIGURATION III
Scale: 3/4" = 1'-0"

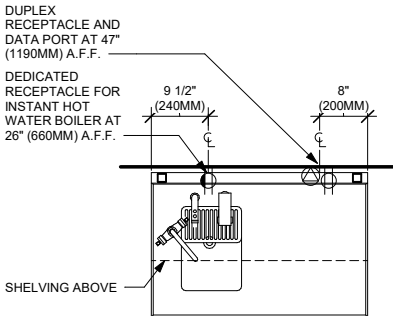


5 WATER FILLING STATION - ELECTRICAL
Scale: 3/4" = 1'-0"

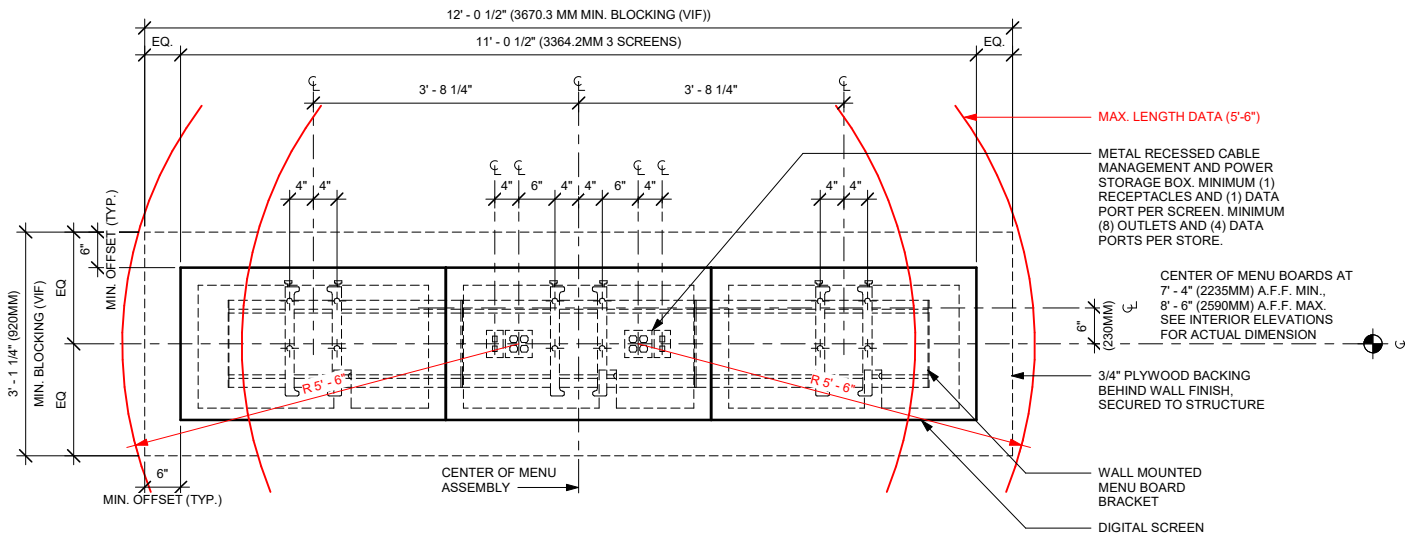

7 DIGITAL MENU BOARDS - STANDARD MOUNT
Scale: 3/4" = 1'-0"

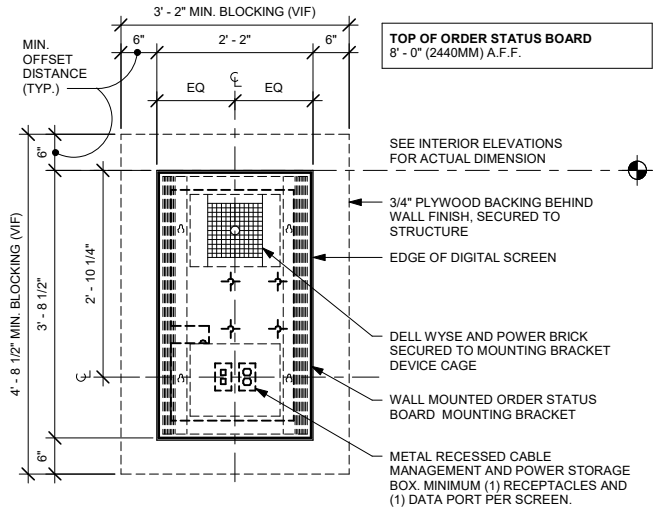

6 ORDER STATUS BOARD INFRASTRUCTURE
Scale: 3/4" = 1'-0"

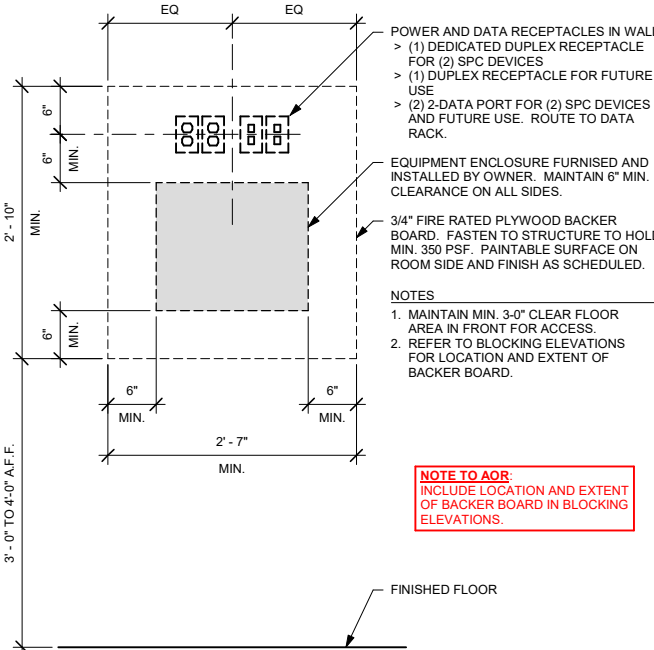

8 SPC ENCLOSURE AT WORKROOM
Scale: 1" = 1'-0"

ARCHITECT AND/OR ENGINEER OF RECORD TO VERIFY ALL ELECTRICAL REQUIREMENTS AND REVISE AS NEEDED.

ARCHITECT AND/OR ENGINEER OF RECORD TO PROVIDE ALL ELECTRICAL DIAGRAMS, CALCULATIONS, AND DETAILS AS REQUIRED.



STARBUCKS®
2401 UTAH AVENUE SOUTH
SEATTLE, WASHINGTON 98134
(206) 318-1575

THESE DRAWINGS AND THE PROJECT MANUAL ARE CONFIDENTIAL AND SHALL REMAIN THE SOLE PROPERTY OF STARBUCKS CORPORATION, WHICH IS THE OWNER OF THE COPYRIGHT IN THIS WORK. THEY SHALL NOT BE REPRODUCED (IN WHOLE OR IN PART), SHARED WITH THIRD PARTIES OR USED IN ANY MANNER ON OTHER PROJECTS OR EXTENSIONS TO THIS PROJECT WITHOUT THE PRIOR WRITTEN CONSENT OF STARBUCKS CORPORATION. THESE DRAWINGS AND SPECIFICATIONS ARE INTENDED TO EXPRESS DESIGN INTENT FOR A PROTOTYPICAL STARBUCKS STORE (WHICH IS SUBJECT TO CHANGE AT ANYTIME) AND DO NOT REFLECT ACTUAL SITE CONDITIONS. NEITHER PARTY SHALL HAVE ANY OBLIGATION NOR LIABILITY TO THE OTHER (EXCEPT STATED ABOVE) UNTIL A WRITTEN AGREEMENT IS FULLY EXECUTED BY BOTH PARTIES.

STARBUCKS TEMPLATE VERSION I2025.08.27

ARCHITECT OF RECORD

THIS DRAWING IS A DESIGN DEVELOPMENT DOCUMENT. SITE SPECIFIC MODIFICATIONS MADE UNDER THE RESPONSIBLE CHARGE OF THE ARCHITECT AND/OR ENGINEER-OF-RECORD WILL BE REQUIRED PRIOR TO USING THIS DOCUMENT FOR BIDDING, PERMITTING, OR CONSTRUCTION.

PROJECT NAME:

TA CORDELE

PROJECT ADDRESS:
397 ROCKHOUSE RD E
CORDELE, GA 31015

STORE #: TBD
PROJECT #: 108648-001
ISSUE DATE: 12/03/2025
DESIGN MANAGER: MANDY KENT
PRODUCTION DESIGNER: MAV
CHECKED BY: E. NORRIS

Revision Schedule			
Rev	Date	By	Description

SHEET TITLE:
ELECTRICAL DETAILS

SCALE: AS SHOWN


SHEET NUMBER:

E502


DESIGN DEVELOPMENT ONLY - NOT INTENDED FOR CONSTRUCTION USE

ARCHITECT AND/OR ENGINEER OF RECORD TO VERIFY ALL ELECTRICAL REQUIREMENTS AND REVISE AS NEEDED.

ARCHITECT AND/OR ENGINEER OF RECORD TO PROVIDE ALL ELECTRICAL DIAGRAMS, CALCULATIONS, AND DETAILS AS REQUIRED.

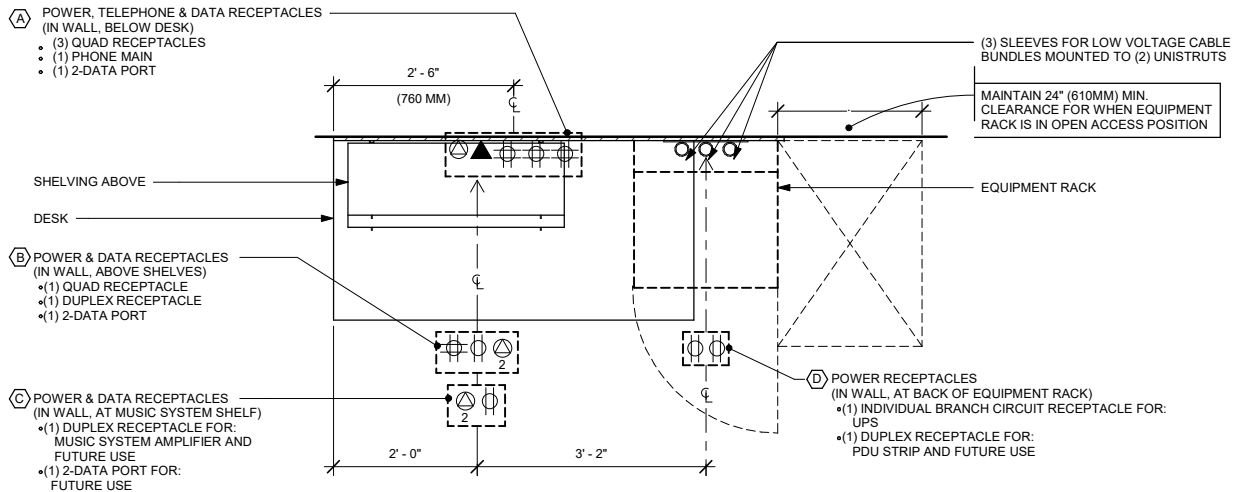

PLAN VIEW

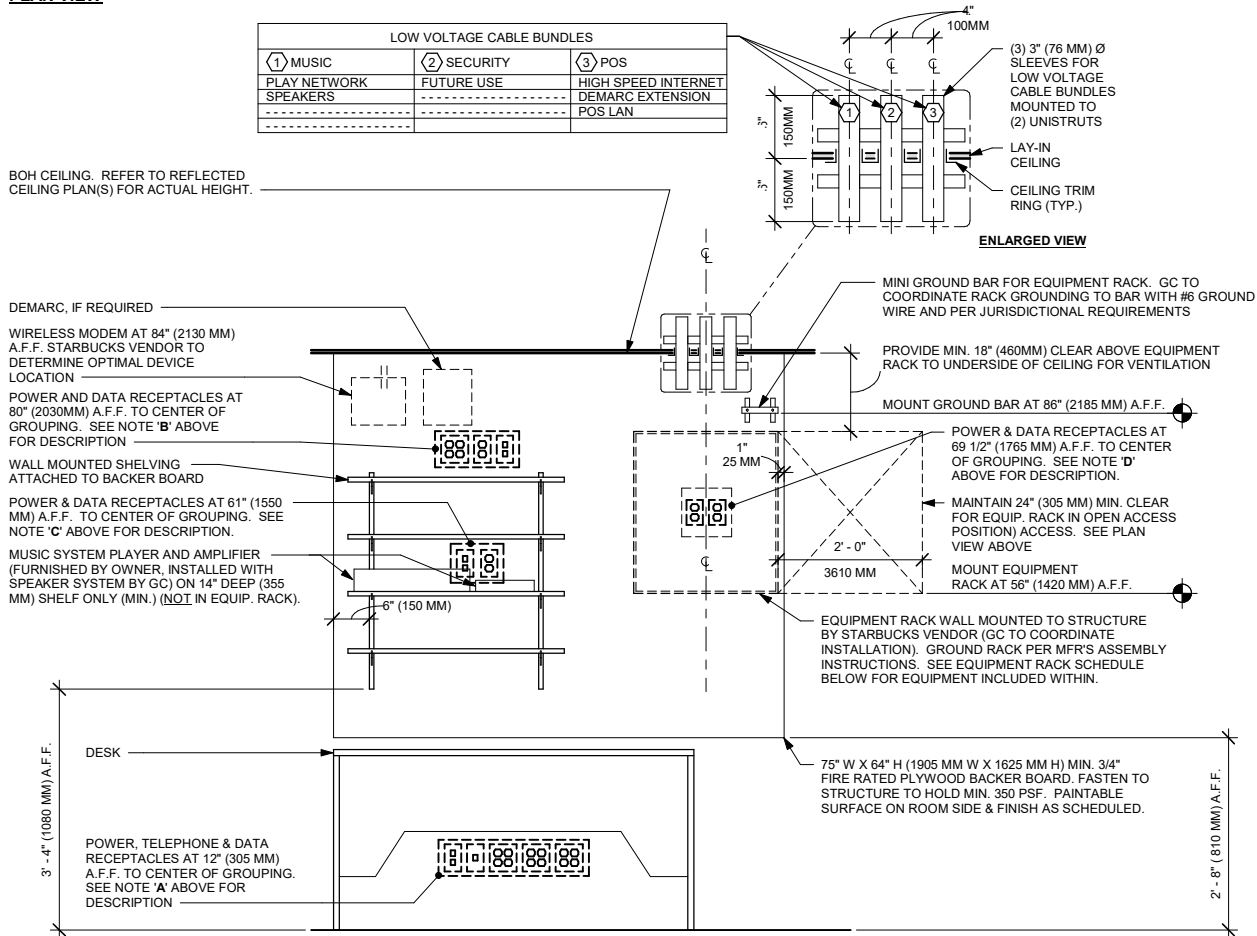

ELEVATION VIEW

NOTE: -EQUIPMENT SHOWN AS DASHED LINES IS TO BE FURNISHED AND INSTALLED BY OWNER UNLESS NOTED OTHERWISE.
-INSTALL COMMUNICATING THERMOSTAT IN AN ACCESSIBLE LOCATION IN THE VICINITY OF THE MANAGERS DESK.

EQUIPMENT RACK SCHEDULE		
UPS	NETWORK SWITCH	SECURITY RECORDER (NVR)
IPS EQUIPMENT	PATCH PANEL	SECURITY KEYBOARD
ROUTER		

1 MANAGER DESK AND EQUIPMENT RACK RIGHT - ELECTRICAL

Scale: 3/4" = 1'-0"



STARBUCKS®
2401 UTAH AVENUE SOUTH
SEATTLE, WASHINGTON 98134
(206) 318-1575

THESE DRAWINGS AND THE PROJECT MANUAL ARE CONFIDENTIAL AND SHALL REMAIN THE SOLE PROPERTY OF STARBUCKS CORPORATION, WHICH IS THE OWNER OF THE COPYRIGHT IN THIS WORK. THEY SHALL NOT BE REPRODUCED (IN WHOLE OR IN PART), SHARED WITH THIRD PARTIES OR USED IN ANY MANNER ON OTHER PROJECTS OR EXTENSIONS TO THIS PROJECT WITHOUT THE PRIOR WRITTEN CONSENT OF STARBUCKS CORPORATION. THESE DRAWINGS AND SPECIFICATIONS ARE INTENDED TO EXPRESS DESIGN INTENT FOR A PROTOTYPICAL STARBUCKS STORE (WHICH IS SUBJECT TO CHANGE AT ANYTIME) AND DO NOT REFLECT ACTUAL SITE CONDITIONS. NEITHER PARTY SHALL HAVE ANY OBLIGATION NOR LIABILITY TO THE OTHER (EXCEPT STATED ABOVE) UNTIL A WRITTEN AGREEMENT IS FULLY EXECUTED BY BOTH PARTIES.

STARBUCKS TEMPLATE VERSION I2025.08.27

ARCHITECT OF RECORD

THIS DRAWING IS A DESIGN DEVELOPMENT DOCUMENT. SITE SPECIFIC MODIFICATIONS MADE UNDER THE RESPONSIBLE CHARGE OF THE ARCHITECT AND/OR ENGINEER-OF-RECORD WILL BE REQUIRED PRIOR TO USING THIS DOCUMENT FOR BIDDING, PERMITTING, OR CONSTRUCTION.

PROJECT NAME:
TA CORDELE

PROJECT ADDRESS:
**397 ROCKHOUSE RD E
CORDELE, GA 31015**

STORE #: TBD
PROJECT #: 108648-001
ISSUE DATE: 12/03/2025
DESIGN MANAGER: MANDY KENT
PRODUCTION DESIGNER: MAV
CHECKED BY: E. NORRIS

Revision Schedule			
Rev	Date	By	Description

SHEET TITLE:
ELECTRICAL DETAILS

SCALE: AS SHOWN

SHEET NUMBER:


E503

DESIGN DEVELOPMENT ONLY - NOT INTENDED FOR CONSTRUCTION USE

ABBREVIATIONS

AFF	ABOVE FINISHED FLOOR
AHJ	AUTHORITIES HAVING JURISDICTION
APPROX	APPROXIMATE
BLDG	BUILDING
CO2	CARBON DIOXIDE
CD	CEILING DIFFUSER
CLG	CEILING
CONST	CONSTRUCTION
CXA	COMMISSIONING AGENT
DEG	DEGREES
DM	STARBUCKS DESIGN MANAGER
DN	DOWN
DTL	DETAIL
DWG(S)	DRAWING(S)
EA	EACH
EC	ELECTRICAL CONTRACTOR
ECP	EQUIPMENT CONTROL PAC
EG	EXHAUST GRILLE
ELEC	ELECTRICAL
EM	EMERGENCY
EMS	ENERGY MANAGEMENT SYSTEM
EXIST	EXISTING
EXT	EXTERIOR
F&I	FURNISH & INSTALL
FC	STARBUCKS FIXTURE CONTRACTOR
FLR	FLOOR
FT	FOOT/FEET
G	GAS PIPING
GC	GENERAL CONTRACTOR
HR	HOOR
HVAC	HEATING, VENTILATION, AIR CONDITIONING
I.D.	INSIDE DIAMETER
IAQ	INDOOR AIR QUALITY
LCP	LIGHTING CONTROL PANEL
LC	LICENSEE
LV	LOW VOLTAGE
MAX	MAXIMUM
MC	MECHANICAL CONTRACTOR
MECH	MECHANICAL
MEP	MECHANICAL, ELECTRICAL AND PLUMBING
MFG	MANUFACTURER
MIN	MINIMUM
NTS	NOT TO SCALE
O.D.	OUTSIDE DIMENSION
OSA	OUTSIDE AIR
PDM	STARBUCKS PROJECT DEVELOPMENT MANAGER
REF	REFERENCE
REQ'D	REQUIRED
REV	REVISION
RT	ROOFTOP
SB	STARBUCKS
SF	SQUARE FEET
SHT	SHEET
SPECS	SPECIFICATION(S)
SST	STAINLESS STEEL
TEMP	TEMPORARY
TYP	TYPICAL
UNO	UNLESS NOTED OTHERWISE
UC	UNDER COUNTER
WH	WATER HEATER
WSHP	WATER SOURCE HEAT PUMP

MECHANICAL SYMBOL LEGEND

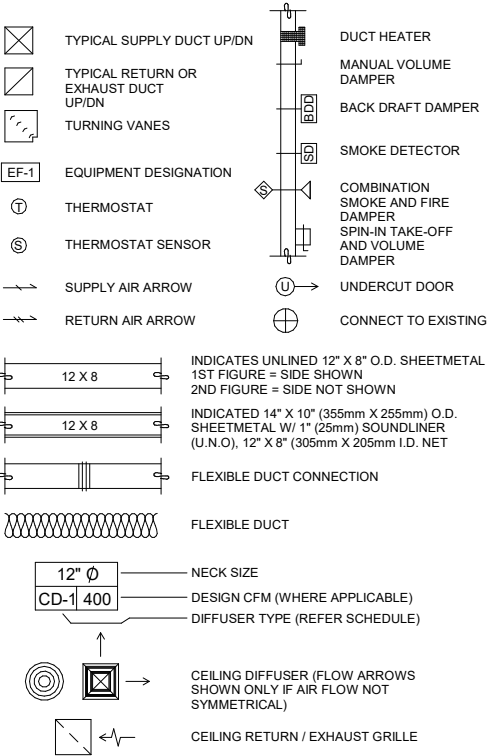

12 X 8

INDICATES UNLINED 12" X 8" O.D. SHEETMETAL

12 X 8

1ST FIGURE = SIDE SHOWN
2ND FIGURE = SIDE NOT SHOWN

14" X 10" (355mm X 255mm) O.D.
SHEETMETAL W/ 1" (25mm) SOUNDLINER
(U.N.O.), 12" X 8" (305mm X 205mm I.D. NET

FLEXIBLE DUCT CONNECTION

FLEXIBLE DUCT

12" Ø

CD-1 400

NECK SIZE

DESIGN CFM (WHERE APPLICABLE)

DIFFUSER TYPE (REFER SCHEDULE)

CEILING DIFFUSER (FLOW ARROWS SHOWN ONLY IF AIR FLOW NOT SYMMETRICAL)

CEILING RETURN / EXHAUST GRILLE

CONTROLS AND OPERATION NOTES

THE GENERAL CONTRACTOR SHALL FURNISH AND INSTALL THE FOLLOWING COMPONENTS:

CONTROL WIRING
THE MECHANICAL CONTRACTOR SHALL PROVIDE ALL CONTROL WIRING IN CONDUIT NECESSARY FOR THE COMPLETE AND PROPER OPERATING TEMPERATURE CONTROL SYSTEM INCLUDING ALL MODES OF OPERATION AND INTERLOCK.

EXHAUST FANS
RESTROOM EXHAUST FAN(S) TO BE OPERATED IN CONJUNCTION WITH STORE HOURS UNLESS OTHERWISE NOTED OR APPROVED OR AS REQUIRED BY JURISDICTION (COORDINATE WITH ELECTRICAL).

THERMOSTAT
PERMANENT THERMOSTAT(S) AND REMOTE SENSOR(S) SHALL BE FURNISHED AND INSTALLED. ONE THERMOSTAT AND SENSOR IS PROVIDED FOR EACH UNIT. MOUNT THERMOSTAT(S) AND SENSOR(S) IN LOCATION & HEIGHT AS INDICATED ON DRAWINGS. MECHANICAL CONTRACTOR TO PROVIDE THERMOSTAT IDENTIFICATION LABELS PER SPECIFICATION REQUIREMENTS. REFER TO THERMOSTAT SETUP INSTRUCTIONS BELOW FOR ADDITIONAL REQUIREMENTS.

THERMOSTAT SETUP INSTRUCTIONS
PROVIDE THE FOLLOWING SETUP AND PROGRAMMING:

- CONFIGURE AS FOLLOWS:
 - DEGREES "F" DISPLAY
 - 12 HOUR CLOCK
 - CONTINUOUS FAN OPERATION IN OCCUPIED MODE
 - DISABLE KEYBOARD PROGRAMMING
- SET TIME AND DATE.
- SET TO DISPLAY CURRENT TEMPERATURE.
- SET OCCUPIED START TIME AT 30 MIN. BEFORE OPENING. SET UNOCCUPIED START TIME AT 30 MIN. AFTER CLOSING. VERIFY HOURS WITH STORE MANAGER OR CONSTRUCTION MANAGER.
- SET POINTS SHALL BE AS FOLLOWS OR AS APPROPRIATE FOR CLIMATE:
 - OCCUPIED (5° F DEADBAND) (3° C DEADBAND)
 - HEATING: 70° F (21° C)
 - COOLING: 75° F (24° C)
 - UNOCCUPIED
 - HEATING: 60° F (15° C)
 - COOLING: 78° F (25° C)
- SET TWO (2) HOUR OCCUPIED OVERRIDE FUNCTION TO PROVIDE THE FOLLOWING SET POINT OVERRIDES:
 - HEATING: +2° F (1° C)
 - COOLING: -2° F (1° C)

DEMAND CONTROL VENTILATION (DCV)
THE CO2 SENSOR SHALL MODULATE THE AIR HANDLING UNIT OUTSIDE AIR DAMPER TO MAINTAIN 1000 PPM CO2 OR LESS

OCCUPIED MODE:

- FAN SHALL RUN CONTINUOUSLY WHILE BRINGING IN MINIMUM DCV OUTSIDE AIR AS INDICATED IN SCHEDULE.
- IF CO2 SENSOR SET POINT IS BELOW THE SETPOINT, THE AIR DAMPER SHALL BE OPEN TO THE CALCULATED DCV MINIMUM OUTSIDE AIR.
- IF CO2 SENSOR SETPOINT IS EXCEEDED, OUTSIDE AIR DAMPER SHALL MODULATE TO MAINTAIN 1000 PPM NOT TO EXCEED THE CALCULATED DESIGN MINIMUM OUTSIDE AIR.
- UPON CO2 PPM FALLING BELOW THE SETPOINT OF 1000 PPM, THE AIR DAMPER SHALL RETURN TO DCV MINIMUM OUTSIDE AIR.
- THE ECONOMIZER SHALL HAVE PRIORITY OVER THE DCV CONTROLS, OUTSIDE AIR MAY EXCEED DCV MINIMUM AND DESIGN MINIMUM WHEN AIR CONDITIONS ARE APPROPRIATE TO DO SO.

UNOCCUPIED MODE:

- FAN SHALL CYCLE WITH HEATING AND OUTSIDE AIR DAMPER CLOSED. OUTSIDE DAMPER SHALL NOT BE CYCLED WITH CO2 PPM SETPOINT.

DUCTWORK AND ACCESSORIES

SHEET METAL DUCTWORK
ASSEMBLE AND INSTALL DUCTWORK IN ACCORDANCE WITH RECOGNIZED INDUSTRY PRACTICE FOR ACHIEVING AIR TIGHT (5% LEAKAGE) AND NOISELESS (NO OBJECTIONABLE NOISE) SYSTEMS. NO VARIATION OF DUCT CONFIGURATION OR SIZES WILL BE PERMITTED EXCEPT BY PERMISSION FROM THE ENGINEER.

DAMPERS
PROVIDE CONVENIENTLY LOCATED ACCESS DOORS OF AMPLE SIZE AND QUANTITY FOR SERVICING THE DAMPERS. PROVIDE MOTORIZED DAMPERS AT ALL INTAKE & EXHAUST BUILDING OPENINGS. COORDINATE WITH OTHER TRADES FOR ACCESS PANELS, POWER AND FIRE ALARM INTERFACES. SEE PROJECT MANUAL.

ACOUSTICAL DUCT LINER
UNLESS OTHERWISE INDICATED ON THE PLANS, PROVIDE 1" (25MM) ACOUSTICAL DUCT LINER IN SUPPLY AND RETURN DUCTWORK WITHIN 10'-0" (305CM) OF THE DISCHARGE AND INTAKE OF AIR HANDLING UNITS. INCREASE DUCT SIZE INDICATED ON PLANS AS NEEDED TO ACCOMMODATE LINER. LINER TO BE PROVIDED AND FASTENED TO DUCT WITH MECHANICAL LINER FASTENERS IN ACCORDANCE WITH SMACNA AND PROJECT MANUAL.

FLEXIBLE DUCTWORK
FLEXIBLE DUCT WORK SHALL ONLY BE INSTALLED AS SHOWN IN PLAN AND NOT ABOVE HARD LID CEILINGS. FLEXIBLE DUCTWORK SHALL NOT EXCEED 5'-0" (152CM) IN LENGTH AND TWO 45° ELBOWS. IT SHALL BE PULLED TAUT AND APPROPRIATELY FASTENED TO RIGID BRANCH DUCT & DIFFUSER. BENDS SHALL BE MINIMIZED AND WHERE NEEDED BE A FULL RADIUS BEND. SUPPORT BANDS SHALL BE INSTALLED SO AS TO NOT CRIMP FLEX DUCT. FLEXIBLE DUCTWORK SHALL MEET REQUIREMENTS.

HVAC EQUIPMENT AND MATERIALS

FILTERS
IF OPERATING HVAC DURING CONSTRUCTION, PROVIDE THREE (3) SETS OF 2" (51MM) MERV6 PLEATED DISPOSABLE FILTERS (OR HIGHER RATING IF REQUIRED BY LEED). USE ONE SET UNTIL COMPLETION OF CONSTRUCTION. INSTALL ONE SET AT COMPLETION OF CONSTRUCTION (PRIOR TO TAB) AND DELIVER ONE SET OF MERV13 FILTERS TO STARBUCKS LABELED TO DENOTE THEIR RESPECTIVE AIR HANDLING UNIT.

BRACING AND ANCHORING
ALL MECHANICAL EQUIPMENT, FIXED OR FLEXIBLY MOUNTED, SHALL BE BRACED OR ANCHORED TO COMPLY WITH LOCAL CODES.

TESTING, ADJUSTING, BALANCING

INDEPENDENT AIR BALANCE CONTRACTOR OR QUALIFIED MECHANICAL CONTRACTOR SHALL BE QUALIFIED BY NEBB OR AABC STANDARDS. BALANCER SHALL ACCURATELY BALANCE THE SUPPLY, RETURN AND OUTSIDE AIR, EXHAUST FAN(S), HYDRONIC (WHERE APPLICABLE) AND EXHAUST FAN(S) SYSTEMS TO PROVIDE AIR AND WATER QUANTITIES WITHIN 10% PLUS MINUS OF THE VALUES INDICATED ON THE DRAWINGS AND IN THE SPECIFICATIONS UNLESS MANUFACTURER REQUIRES TIGHTER TOLERANCES. OPERATE AUTOMATIC CONTROLS SYSTEMS AND VERIFY SETPOINTS FOR THERMOSTATS, CO2 SENSORS, DCV, EMS AND ECONOMIZER/OUTSIDE AIR DAMPER. SEE CONTROLS AND OPERATION NOTES AND HVAC SCHEDULES AND NOTES FOR DETAILS. IF DEFICIENCIES OR SITE CONDITIONS PREVENT COMPLETE AND PROPER BALANCING, DO NOT COMPLETE WORK AND SUBMIT A REQUEST FOR INFORMATION TO GET COMPLETE INFORMATION PRIOR TO COMPLETING WORK. SUBMIT THREE (3) COPIES OF THE BALANCE REPORT TO THE ENGINEER, CONSTRUCTION MANAGER AND COMMISSIONING AGENT FOR APPROVAL. THE BALANCE REPORT SHALL INCLUDE NEBB OR AABC CREDENTIALS, EQUIPMENT/INSTRUMENT LIST WIT THE MOST RECENT CALIBRATION DATE AND BALANCE REPORTS FOR ALL HVAC AND EXHAUST SYSTEMS. TAB REPORT SHOULD MATCH NEBB OR AABC STANDARD REPORTS INCLUDING UNIT TEST DATA WITH TEMPERATURES, PRESSURES AND STATIC PRESSURE PROFILES. INCLUDE A COPY OF THE BALANCE REPORT AS APPROVED BY THE ENGINEER WITH APPLICATION FOR FINAL CONTRACT PAYMENT.

GENERAL MECHANICAL NOTES

- THE MECHANICAL CONTRACTOR SHALL COORDINATE WITH THE GENERAL CONTRACTOR TO PATCH AND REPAIR ALL EXISTING WALLS, FLOORS, CEILINGS OR OTHER SURFACES IDENTIFIED TO REMAIN THAT MAY BECOME DAMAGED DURING THE COURSE OF WORK.
- DRAWINGS ARE DIAGRAMMATIC AND INDICATE GENERAL INTENT OR ARRANGEMENT OF SYSTEM(S). FURNISH & INSTALL ALL COMPONENTS NEEDED WHETHER INDICATED OR NOT TO PROVIDE A COMPLETE AND OPERATING SYSTEM.
- CONTRACTOR TO VERIFY ALL DIMENSIONS, INCLUDING CLEARANCES REQUIRED BY OTHER TRADES, AND NOTIFY THE ARCHITECT OF RECORD OF ANY DISCREPANCIES PRIOR TO PROCEEDING WITH THE WORK. ALL DIMENSIONS ARE TO THE FACE OF THE FINISHED SURFACE UNLESS NOTED OTHERWISE. ALL DIMENSIONS TO BE TAKEN FROM ACTUAL BUILDING DIMENSIONS.
- THE MECHANICAL CONTRACTOR SHALL COORDINATE HVAC WORK WITH OTHER TRADES. THE ARCHITECTURAL DRAWINGS AND PROJECT MANUAL SHALL TAKE PRECEDENCE OVER ALL OTHER DRAWINGS. SEE ARCHITECTURAL DRAWINGS AND PROJECT MANUAL FOR DIMENSIONED DIFFUSER LOCATIONS AND MOUNTING HEIGHTS WHERE EXPOSED.
- NEW DUCTWORK AND EQUIPMENT SHALL NOT BE INSTALLED WHERE IT OBSTRUCTS ANY EXISTING OR NEW AREAS THAT REQUIRE ACCESS.

GENERAL NOTES

SCOPE
THE INTENT OF THE PROJECT MANUAL AND THE DRAWINGS IS TO PROVIDE A COMPLETE AND FULLY OPERATIONAL MECHANICAL SYSTEM. THE MECHANICAL CONTRACTOR SHALL FURNISH ALL LABOR, MATERIAL, AND EQUIPMENT NECESSARY TO COMPLETE THE MECHANICAL WORK.

SITE EXAMINATION
THE MECHANICAL CONTRACTOR SHALL THOROUGHLY EXAMINE ALL AREAS WHERE EQUIPMENT, DUCTWORK, AND PIPING WILL BE INSTALLED AND WILL REPORT ANY CONDITION THAT, IN HIS OPINION, PREVENTS THE PROPER INSTALLATION OF THE MECHANICAL WORK.

PENETRATIONS
WHERE PIPES AND DUCTS PENETRATE WALL, SEAL OPENINGS TO PREVENT AIR TRANSFER BETWEEN SPACES. USE FIRE RATED SEALANTS ON ALL FIRE SEPARATION PENETRATIONS, INCLUDING FLOORS. SEAL AROUND ALL PIPES AND DUCTS PENETRATING FIRE SEPARATIONS WITH NON-COMBUSTIBLE PACKING RETAINED BY METAL COLLARS. THE ASSEMBLY SHALL BE APPROVED BY STATE FIRE MARSHALL.

STANDARDS
EQUIPMENT AND MATERIALS SHALL CONFORM WITH THE APPROPRIATE PROVISIONS OF CSA, UL, C, ARL, ASME, ASTM, UL, NEMA, ANSI, SMACNA, ASHRAE, NFPA, AS APPLICABLE TO EACH INDIVIDUAL UNIT OR ASSEMBLY.

CODES
ALL WORK SHALL BE PERFORMED IN STRICT ACCORDANCE WITH ALL APPLICABLE PROVINCIAL AND LOCAL CODES AND ORDINANCES. IN CASE OF CONFLICT BETWEEN THE DRAWINGS AND PROJECT MANUAL AND THE CODES AND ORDINANCES, USE WHICHEVER IS MORE STRINGENT. THE MECHANICAL CONTRACTOR SHALL SATISFY CODE REQUIREMENTS AS A MINIMUM STANDARD WITHOUT ANY EXTRA COST TO STARBUCKS OR THE LICENSEE.

PERMITS AND FEES
THE MECHANICAL CONTRACTOR SHALL PROCURE AND PAY FOR ALL PERMITS, FEES, AND INSPECTIONS NECESSARY TO COMPLETE THE MECHANICAL WORK.

WARRANTY
THE MECHANICAL CONTRACTOR SHALL UNCONDITIONALLY WARRANT ALL WORK TO BE FREE OF DEFECTS IN MATERIAL AND WORKMANSHIP FOR A PERIOD OF ONE (1) YEAR FROM THE DATE OF FINAL ACCEPTANCE BY STARBUCKS AND WILL REPAIR OR REPLACE ANY DEFECTIVE WORK PROMPTLY AND WITHOUT CHARGE AND RESTORE ANY OTHER EXISTING WORK DAMAGED IN THE COURSE OF REPAIRING DEFECTIVE MATERIALS AND WORKMANSHIP.

DESIGN DEVELOPMENT ONLY - NOT INTENDED FOR CONSTRUCTION USE

STARBUCKS®
2401 UTAH AVENUE SOUTH
SEATTLE, WASHINGTON 98134
(206) 318-1575

THESE DRAWINGS AND THE PROJECT MANUAL ARE CONFIDENTIAL AND SHALL REMAIN THE SOLE PROPERTY OF STARBUCKS CORPORATION, WHICH IS THE OWNER OF THE COPYRIGHT IN THIS WORK. THEY SHALL NOT BE REPRODUCED (IN WHOLE OR IN PART), SHARED WITH THIRD PARTIES OR USED IN ANY MANNER ON OTHER PROJECTS OR EXTENSIONS TO THIS PROJECT WITHOUT THE PRIOR WRITTEN CONSENT OF STARBUCKS CORPORATION. THESE DRAWINGS AND SPECIFICATIONS ARE INTENDED TO EXPRESS DESIGN INTENT FOR A PROTOTYPICAL STARBUCKS STORE (WHICH IS SUBJECT TO CHANGE AT ANYTIME) AND DO NOT REFLECT ACTUAL SITE CONDITIONS. NEITHER PARTY SHALL HAVE ANY OBLIGATION NOR LIABILITY TO THE OTHER (EXCEPT STATED ABOVE) UNTIL A WRITTEN AGREEMENT IS FULLY EXECUTED BY BOTH PARTIES.

STARBUCKS TEMPLATE VERSION I0205.08.27

ARCHITECT OF RECORD

THIS DRAWING IS A DESIGN DEVELOPMENT DOCUMENT. SITE SPECIFIC MODIFICATIONS MADE UNDER THE RESPONSIBLE CHARGE OF THE ARCHITECT AND/OR ENGINEER-OF-RECORD WILL BE REQUIRED PRIOR TO USING THIS DOCUMENT FOR BIDDING, PERMITTING, OR CONSTRUCTION.

PROJECT NAME:
TA CORDELE

PROJECT ADDRESS:
397 ROCKHOUSE RD E
CORDELE, GA 31015

STORE #: TBD
PROJECT #: 108648-001
ISSUE DATE: 12/03/2025
DESIGN MANAGER: MANDY KENT
PRODUCTION DESIGNER: MAV
CHECKED BY: E. NORRIS

Revision Schedule				
Rev	Date	By	Description	

SHEET TITLE:
MECHANICAL NOTES

SCALE: AS SHOWN

SHEET NUMBER:
M001

ABBREVIATIONS

AFF	ABOVE FINISHED FLOOR
AHJ	AUTHORITIES HAVING JURISDICTION
APPROX	APPROXIMATE
BLDG	BUILDING
CLG	CEILING
CONST	CONSTRUCTION
CW	DOMESTIC COLD WATER
CXA	COMMISSIONING AGENT
DEG	DEGREES
DM	STARBUCKS DESIGN MANAGER
DN	DOWN
DTL	DETAIL
DWG(S)	DRAWING(S)
EA	EACH
EC	ELECTRICAL CONTRACTOR
ELEC	ELECTRICAL
EMER	EMERGENCY
EXIST	EXISTING
EXT	EXTERIOR
FC	STARBUCKS FIXTURE CONTRACTOR
FD	FLOOR DRAIN
FS	FLOOR SINK
F&I	FURNISH & INSTALL
FLR	FLOOR
FT	FOOT/FEET
FCO	FLOOR CLEANOUT
GC	GENERAL CONTRACTOR
GFCl	GROUND FAULT CIRCUIT INTERRUPTER
GW	GREASE WASTE
HR	HOOR
HVAC	HEATING, VENTILATION, AND AIR CONDITIONING
HW	HOT WATER
HS	HANDSINK
HWS	HOT WATER SUPPLY
HWR	HOT WATER RETURN
LC	LICENSEE
LV	LOW VOLTAGE
MAX	MAXIMUM
MC	MECHANICAL CONTRACTOR
MDP	MAIN DISTRIBUTION PANEL
MECH	MECHANICAL
MEP	MECHANICAL, ELECTRICAL, AND PLUMBING
MFG	MANUFACTURER
MIN	MINIMUM
MS	MOP SINK
NL	NIGHTLIGHT
NTS	NOT TO SCALE
PC	PLUMBING CONTRACTOR
PDM	STARBUCKS PROJECT DEVELOPMENT MANAGER
PS	PREP SINK
POC	POINT OF CONNECTION
REF	REFERENCE
REQ'D	REQUIRED
REV	REVISION
SB	STARBUCKS
SHT	SHEET
SF	SQUARE FEET
SPECS	SPECIFICATION(S)
SST	STAINLESS STEEL
TEL	TELEPHONE
TEMP	TEMPORARY
TMV	TEMPERATURE MIXING VALVE
TW	TEMPERED HOT WATER
TYP	TYPICAL
UC	UNDER COUNTER
UNO	UNLESS NOTED OTHERWISE
V	VENT
W	SANITARY WASTE
WCO	WALL CLEANOUT
WH	WATER HEATER
WP	WEATHER PROOF

PLUMBING SYMBOL LEGEND

	S OR W	SANITARY OR WASTE PIPING ABOVE SLAB
	S OR W	SANITARY OR WASTE PIPING BELOW SLAB
	V	VENT PIPING
	GW	GREASE WASTE
	CD	CONDENSATE DRAIN
	CW	COLD WATER PIPING
	HW	HOT WATER PIPING
	CWF	COLD WATER FILTERED
	CWN	COLD WATER NANO FILTERED
	CWS	COLD WATER SOFTENED
	TW	TEMPERED WATER
	RO	REVERSE OSMOSIS WATER
	G	GAS PIPING
	RD	REFRIGERANT DISCHARGE PIPING
	RS	REFRIGERANT SUCTION PIPING
	BV	BALL VALVE
	GV	GATE VALVE
	CH. V	CHECK VALVE
	RV	RELIEF VALVE
	HB	HOSE BIBB
		SHOCK ABSORBER
		STRAINER
	WCO	WALL CLEANOUT
	FCO	FLOOR CLEANOUT
	FS	FLOOR SINK
	WM	WATER METER
	POC	CONNECT TO EXISTING

INSULATION

WATER PIPING
PROVIDE THERMAL INSULATION PER THE SPECIFICATIONS.

SAFETY COVERS
FURNISH AND INSTALL SPECIFIED NO SCALD SAFETY COVERS WITH INSULATED FOAM LINER AND TAMPER PROOF STRAP AT ALL EXPOSED ADA SINK P-TRAPS AND WATER SUPPLIES AND AS REQUIRED BY JURISDICTION .

NITROGENATION

STARBUCKS NITROGENATION VENDOR WILL PROVIDE AND INSTALL EQUIPMENT AND FITTINGS IF APPLICABLE TO PROJECT SCOPE FOR NITRO STATION. GENERAL CONTRACTOR SHALL COORDINATE NITRO SYSTEM INSTALLATION WITH STARBUCKS VENDOR.

PLUMBING FIXTURES

WATER HEATER
SIZE WATER HEATER PER STARBUCKS STANDARD AND PER AUTHORITIES HAVING JURISDICTION (AHJ), WHICHEVER IS MORE STRINGENT. PROVIDE INSTALLATION COMPLETE WITH FITTINGS AS SHOWN IN THE DRAWINGS. SET HOT WATER TEMPERATURE AT 140° F OR ADJUST AS REQUIRED BY AHJ. PROVIDE THERMOMETER ON HOT WATER PIPE LEAVING WATER HEATER.

WATER FILTRATION
STARBUCKS WATER FILTRATION VENDOR WILL PROVIDE FILTRATION SYSTEM. CONTRACTOR SHALL CONFIRM WITH STARBUCKS CONSTRUCTION MANAGER WHETHER VENDOR OR PLUMBING CONTRACTOR IS TO INSTALL FILTRATION SYSTEM. PROVIDE AND COORDINATE INSTALLATION COMPLETE WITH ALL PIPING, FITTINGS, AND EQUIPMENT AS INDICATED ON THE DRAWINGS.

CONNECTIONS
THE PLUMBING CONTRACTOR SHALL MAKE ALL FINAL CONNECTIONS TO EQUIPMENT INCLUDING REQUIRED MATERIAL SUCH AS PIPING, VALVES, FILTERS, TRAPS, CHECKS VALVES, VACUUM BREAKERS, AND FLEXIBLE AND RIGID TUBING.

SCHEDULES
REFER TO SCHEDULES ON DRAWINGS FOR A DESCRIPTION OF LISTED ITEMS AND FURNISH ANY AND ALL PLUMBING FIXTURES LISTED AS "GC". ANY DISCREPANCIES ABOUT WHO IS TO PROVIDE PLUMBING FIXTURES IN THE SCHEDULE SHALL BE BROUGHT TO STARBUCKS ATTENTION FOR CLARIFICATION. INSTALL ALL FIXTURES LISTED REGARDLESS OF WHO SUPPLIES.

DISHWASHER
G.C. TO FURNISH AND INSTALL POWER CORD FOR DISHWASHER PER JURISDICTIONAL REQUIREMENTS. IF EQUIPMENT IS SPECIFIED AS **HOBART ADVANSYS**, THE UNIT IS TO BE PLUMBED WITH COLD, NON-FILTERED WATER. IF THE WATER FILTRATION SYSTEM IS A PENTAIR CONFIGURATION II OR III, THEN THE COLD, NON-FILTERED WATER MUST ALSO BE SOFTENED.

PIPING

CONDENSATE DRAINAGE PIPING
THE PLUMBING CONTRACTOR SHALL PROVIDE CONDENSATE DRAINS FOR AIR HANDLING UNITS AND STARBUCKS EQUIPMENT (REFER TO SCHEDULE). CONDENSATE DRAINAGE PIPING SHALL BE TYPE "M" COPPER TUBING WITH WROUGHT COPPER SWEAT FITTINGS JOINED WITH 50/50 SOLDER.

TESTING
ALL PIPES SHALL BE TESTED BY AN APPROVED METHOD BEFORE THEY ARE BACKFILLED OR CONCEALED. AFTER TESTING IS COMPLETE, THE PLUMBING CONTRACTOR SHALL DISINFECT THE POTABLE WATER SYSTEM AS REQUIRED BY LOCAL AUTHORITY. TEST WATER PURITY ACCORDING TO LOCAL REQUIREMENTS AND SUBMIT CERTIFIED TEST RESULTS TO ENGINEER FOR REVIEW AND APPROVAL.

VALVES

GENERAL
INSTALL VALVES FOR EACH FIXTURE AND ITEM OF EQUIPMENT. PROVIDE BRAIDED STAINLESS STEEL HOSE (UNLESS OTHERWISE NOTED) BETWEEN VALVE AND EQUIPMENT IN ACCORDANCE WITH MANUFACTURERS' SPECIFICATIONS. LOCATE SHUT-OFF VALVES ADJACENT TO EQUIPMENT FOR EASY ACCESS SUCH THAT VALVES CAN BE REACHED WITHOUT MOVING EQUIPMENT. SHUT OFF VALVES TO BE BALL TYPE. VALVES SHALL BE LISTED/APPROVED FOR USE PER AUTHORITIES HAVING JURISDICTION (AHJ) AND CODE REQUIREMENTS. PROVIDE VALVE IDENTIFICATION PER THE PROJECT MANUAL FOR MAIN WATER SERVICE SHUT-OFF AND ANY OTHER VALVES WHICH ARE NOT CLEARLY EVIDENT WHAT THEY SERVE.

GENERAL PLUMBING NOTES

- THE PLUMBING CONTRACTOR SHALL COORDINATE WITH THE GENERAL CONTRACTOR TO PATCH AND REPAIR ALL EXISTING WALLS, FLOORS, CEILINGS OR OTHER SURFACES IDENTIFIED TO REMAIN THAT MAY BECOME DAMAGED DURING THE COURSE OF WORK.
- EXPOSED / SURFACE MOUNTED PIPING IS ONLY ALLOWED IN THE BAR AREA UNDER COUNTERTOPS, WHERE IT DOES NOT OBSTRUCT CABINETS / DEVICES AND WHERE APPROVED BY STARBUCKS PROJECT DEVELOPMENT MANAGER. IF ROUTED THROUGH CABINETS, IT SHALL BE ROUTED TO MAXIMIZE STORAGE SPACE AND BE PROTECTED FROM DAMAGE.
- DRAWINGS ARE DIAGRAMMATIC AND INDICATE GENERAL INTENT OR ARRANGEMENT OF SYSTEM(S). FURNISH AND INSTALL ALL COMPONENTS NEEDED WHETHER INDICATED OR NOT TO PROVIDE A COMPLETE AND OPERATING SYSTEM. OVERALL CASEWORK COMPONENT DIMENSIONING ON PLUMBING DETAILS ARE SHOWN FOR REFERENCE AND COORDINATION ONLY.
- CONTRACTOR TO VERIFY ALL DIMENSIONS, INCLUDING CLEARANCES REQUIRED BY OTHER TRADES, AND NOTIFY THE LICENSEE'S ARCHITECT OF RECORD OF ANY DISCREPANCIES PRIOR TO PROCEEDING WITH THE WORK. ALL DIMENSIONS ARE TO THE FACE OF THE FINISHED SURFACE UNLESS NOTED OTHERWISE. ALL DIMENSIONS TO BE TAKEN FROM ACTUAL BUILDING DIMENSIONS.
- THE PLUMBING CONTRACTOR SHALL COORDINATE PLUMBING WORK WITH OTHER TRADES. THE ARCHITECTURAL DRAWINGS AND SPECIFICATIONS SHALL TAKE PRECEDENCE OVER ALL OTHER DRAWINGS. SEE ARCHITECTURAL DRAWINGS FOR FIXTURES IN CASEWORK AND PLUMBING DETAILS. SEE PROJECT MANUAL FOR PLUMBING SPECIFICATION SECTIONS.
- ALL PIPING AND / OR PLUMBING DEVICES SHALL BE SUPPORTED FROM STRUCTURE (NOT FROM HVAC DUCTS OR OTHER PIPES / CONDUITS).

GENERAL NOTES

SCOPE
THE INTENT OF THE PROJECT MANUAL AND THE DRAWINGS IS TO PROVIDE A COMPLETE AND FULLY OPERATIONAL PLUMBING SYSTEM. THE CONTRACTOR SHALL FURNISH ALL LABOR, MATERIAL AND EQUIPMENT RELATED TO THE INSTALLATION OF THE PLUMBING WORK.

SITE EXAMINATION
THE CONTRACTOR SHALL THOROUGHLY EXAMINE ALL AREAS WHERE FIXTURES, EQUIPMENT, AND PIPING WILL BE INSTALLED AND WILL REPORT ANY CONDITION THAT PREVENTS THE PROPER INSTALLATION OF THE PLUMBING WORK.

STANDARDS
EQUIPMENT AND MATERIALS SHALL CONFORM WITH THE APPROPRIATE PROVISIONS OF LISTING STANDARD IN EFFECT AS APPLICABLE TO EACH INDIVIDUAL UNIT OR ASSEMBLY.

CODES
ALL WORK SHALL BE PERFORMED IN STRICT ACCORDANCE WITH ALL APPLICABLE PROVINCIAL AND LOCAL CODES AND ORDINANCES. IN CASE OF CONFLICT BETWEEN THE DRAWINGS AND SPECIFICATIONS AND THE CODES AND ORDINANCES, THE HIGHEST STANDARD SHALL APPLY. THE CONTRACTOR SHALL SATISFY CODE REQUIREMENTS AS A MINIMUM STANDARD WITHOUT ANY EXTRA COST TO STARBUCKS OR THE LICENSEE.

PERMITS AND FEES
THE CONTRACTOR SHALL PROCURE AND PAY FOR ALL PERMITS, FEES, AND INSPECTIONS NECESSARY TO COMPLETE THE PLUMBING WORK.

WARRANTY
THE CONTRACTOR SHALL UNCONDITIONALLY WARRANT ALL WORK TO BE FREE OF DEFECTS IN MATERIAL AND WORKMANSHIP FOR A PERIOD OF ONE (1) YEAR FROM THE DATE OF FINAL ACCEPTANCE BY STARBUCKS AND WILL REPAIR OR REPLACE ANY DEFECTIVE WORK PROMPTLY AND WITHOUT CHARGE AND RESTORE ANY OTHER EXISTING WORK DAMAGED IN THE COURSE OF REPAIRING DEFECTIVE MATERIALS AND WORKMANSHIP.

DESIGN DEVELOPMENT ONLY - NOT INTENDED FOR CONSTRUCTION USE



STARBUCKS®
2401 UTAH AVENUE SOUTH
SEATTLE, WASHINGTON 98134
(206) 318-1575

THESE DRAWINGS AND THE PROJECT MANUAL ARE CONFIDENTIAL AND SHALL REMAIN THE SOLE PROPERTY OF STARBUCKS CORPORATION, WHICH IS THE OWNER OF THE COPYRIGHT IN THIS WORK. THEY SHALL NOT BE REPRODUCED (IN WHOLE OR IN PART), SHARED WITH THIRD PARTIES OR USED IN ANY MANNER ON OTHER PROJECTS OR EXTENSIONS TO THIS PROJECT WITHOUT THE PRIOR WRITTEN CONSENT OF STARBUCKS CORPORATION. THESE DRAWINGS AND SPECIFICATIONS ARE INTENDED TO EXPRESS DESIGN INTENT FOR A PROTOTYPICAL STARBUCKS STORE (WHICH IS SUBJECT TO CHANGE AT ANYTIME) AND DO NOT REFLECT ACTUAL SITE CONDITIONS. NEITHER PARTY SHALL HAVE ANY OBLIGATION NOR LIABILITY TO THE OTHER (EXCEPT STATED ABOVE) UNTIL A WRITTEN AGREEMENT IS FULLY EXECUTED BY BOTH PARTIES.

STARBUCKS TEMPLATE VERSION I|2025.08.27

ARCHITECT OF RECORD

THIS DRAWING IS A DESIGN DEVELOPMENT DOCUMENT. SITE SPECIFIC MODIFICATIONS MADE UNDER THE RESPONSIBLE CHARGE OF THE ARCHITECT AND/OR ENGINEER-OF-RECORD WILL BE REQUIRED PRIOR TO USING THIS DOCUMENT FOR BIDDING, PERMITTING, OR CONSTRUCTION.

PROJECT NAME:

TA CORDELE

PROJECT ADDRESS:

397 ROCKHOUSE RD E
CORDELE, GA 31015

STORE #:	TBD
PROJECT #:	108648-001
ISSUE DATE:	12/03/2025
DESIGN MANAGER:	MANDY KENT
PRODUCTION DESIGNER:	MAV
CHECKED BY:	E. NORRIS

Revision Schedule			
Rev	Date	By	Description

SHEET TITLE:
PLUMBING NOTES

SCALE: AS SHOWN

SHEET NUMBER:
P001

1. WATER FILTRATION EQUIPMENT INSTALLER TO VERIFY REQUIRED CLEARANCES AND ADJACENCIES.

- A. FURNISH AND INSTALL A COMPLETE AND OPERATING SYSTEM. ALL ITEMS ARE NOT NECESSARILY SHOWN.
- B. LICENSEE'S PLUMBING CONTRACTOR RESPONSIBLE FOR SITE INVESTIGATION PRIOR TO START OF WORK TO REVEAL FULL SCOPE OF WORK.
- C. ALL PLUMBING LINES TO BE ROUTED SUCH THAT THEY ARE NOT VISIBLE TO CUSTOMERS EXCEPT WHERE FIRST APPROVED BY STARBUCKS AT EXPOSED CEILING AREAS.
- D. REFER TO MANUFACTURER SPECIFICATIONS FOR LOCATION OF CONNECTIONS UNLESS OTHERWISE NOTED.
- E. COORDINATE WITH LICENSEE'S ELECTRICAL CONTRACTOR FOR POWER CONNECTION TO ALL PLUMBING EQUIPMENT.
- F. DIMENSIONS ARE TO FINISH FACE UNLESS OTHERWISE NOTED.
- G. REFER TO DETAIL SHEETS FOR PLUMBING FITTINGS LOCATED IN CASEWORK.
- H. COLD WATER SUPPLY LINES INSIDE CASEWORK AND BAR AREA TO BE COVERED WITH 1/2" (10MM) THICK SELF SEALING, SECTIONAL CLOSED-CELL FOAM INSULATION. REFER TO PROJECT MANUAL FOR PLUMBING WATER SUPPLY LINE INSULATION REQUIREMENTS.
- I. INSULATE ALL PIPING INCLUDING PIPES AT BAR AND IN CASEWORK PER THE REQUIREMENTS LISTED IN THE PROJECT MANUAL.
- J. INSULATE ICE BIN DRAINAGE PIPES PER REQUIREMENTS LISTED IN THE PROJECT MANUAL.
- K. WHEN BUNDLING SEVERAL INDIRECT WASTE LINES TO DRAIN INTO FLOOR SINK, A UNISTRUT IS REQUIRED FOR SECURING AND BRACING ALL LINES ABOVE THE DRAIN.
- L. FURNISH AND INSTALL WALL CLEANOUTS AT ALL SINKS AS REQUIRED AND PER CODE (NOT ALL SHOWN).
- M. GENERAL CONTRACTOR SHALL CONTACT WATER FILTRATION EQUIPMENT SUPPLIER TO COORDINATE SOW AND SCHEDULE PRIOR TO INSTALLATION OF WATER FILTRATION SYSTEM.
- N. ARCHITECT OF RECORD TO EVALUATE BUILDING HOT WATER SUPPLY AND DETERMINE IF WATER HEATER IS REQUIRED IN THIS SPACE IN ORDER TO MEET STARBUCKS REQUIREMENTS.
- O. PROVIDE FILTERED COLD WATER TO ESPRESSO MACHINE(S), BREWER(S), HOT WATER TAP(S), WATER TOWER(S), AND ICE MACHINE.

SB - STARBUCKS
FC - STARBUCKS FIXTURE CONTRACTOR
LC - LICENSEE
GC - LICENSEE'S GENERAL CONTRACTOR

PROVIDE FILTERED COLD WATER TO ESPRESSO MACHINE(S),
BREWERS(S), HOT WATER TAP(S), WATER TOWER(S), AND ICE
MACHINE.



PLUMBING FIXTURE SCHEDULE - "P"					
DESIGN ID	COUNT	DESCRIPTION	FURN. BY	INST. BY	COMMENTS
DRAIN					
10294	6	DRAIN - FLOOR SINK SQUARE - 12IN 305MM	GC	GC	
10726	6	DRAIN - GRATE HALF SQUARE - 12IN 305MM	GC	GC	
FAUCET					
10152	1	FAUCET - DOUBLE LABORATORY WITH BENT RISER SPOUT	SB	GC	
10153	4	FAUCET - WATER TOWER - 12IN 305MM	SB	GC	
10215	2	FAUCET - DOUBLE LABORATORY WITH SWING SPOUT	SB	GC	
10447	1	FAUCET - PRE RINSE SPRAYER WALL MOUNTED	SB	GC	
10597	1	FAUCET - SINGLE HANDLE	SB	GC	
10804	1	FAUCET - PRE RINSE SWING SPOUT	SB	GC	
10922	1	FAUCET - MOP SINK WALL MOUNTED	GC	GC	
11003	2	FAUCET - METERED	SB	GC	
13588	1	FAUCET - HAND SINK WALL MOUNTED	SB	GC	
22642	3	FAUCET - INSTANTHOT SYSTEM 2 BUTTON WITH BOILER AND BRACKET	SB	GC	KIT INCLUDES FONT, UNDERCOUNTER BOILER AND BOILER BRACKET FOR SIDE PANEL MOUNTING. BRACKET CAN BE FLOOR MOUNTED USING SET OF (4) STAINLESS STEEL LEGS, ORDERED SEPARATELY THROUGH VENDOR.
FILTER					
12501	1	FILTER - RO SYSTEM 600GPD	SB	SB	CONFIGURATION III. PROVIDED BY PENTAIR.
12507	1	FILTER - RO SYSTEM STORAGE TANK RO40	SB	SB	CONFIGURATION III. PROVIDED BY PENTAIR.
12896	1	FILTER - BRINE TANK	SB	SB	CONFIGURATION III. PROVIDED BY PENTAIR.
12899	2	FILTER - POLY GLASS VESSEL	SB	SB	CONFIGURATION III. PROVIDED BY PENTAIR.
13076	1	FILTER - PREFILTRATION SYSTEM	SB	SB	CONFIGURATION III. PROVIDED BY PENTAIR.
13082	1	FILTER - WATER SOFTENER TWIN	SB	SB	CONFIGURATION III. PROVIDED BY PENTAIR.
13086	1	FILTER - WATER BOOSTER 90PSI	SB	SB	CONFIGURATION III. PROVIDED BY PENTAIR.
22603	1	FILTER - RO SYSTEM STORAGE TANK RO20	SB	SB	CONFIGURATION III. PROVIDED BY PENTAIR.
24272	1	FILTER - RO SYSTEM INSTALL KIT	SB	SB	CONFIGURATION III. PROVIDED BY PENTAIR.
OTHER					
11109	1	WATER HEATER TANK ELECTRIC	GC	GC	AOR TO SPECIFY.
SINK					
10549	1	SINK - RINSE DROP IN SST - 12X20IN 305X510MM	SB	GC	
10995	1	SINK - MOP - 24X24IN 610X610MM	GC	GC	
13264	1	SINK - 3 COMP WORK SST - 93IN 2350MM	SB	GC	
14688	1	SINK - HAND WITH SIDE SPLASH WALL MOUNTED SST	SB	GC	
17565	1	SINK - RINSE WITH DRAINBOARD - 15X27IN 380X685MM	SB	GC	
17632	1	SINK - STACKED DRAINBOARD - 15IN 380MM	SB	GC	
18743	1	SINK - WATER FILLING STATION - 36X24IN 915X610MM	SB	GC	
22768	2	SINK - COUNTERTOP RINSER WITH WATER TOWER - 26X9IN 660X235MM	SB	GC	

1 PLUMBING DESIGN PLAN

Scale: 1/4" = 1'-0"



DESIGN DEVELOPMENT ONLY - NOT INTENDED FOR CONSTRUCTION USE



STARBUCKS®
2401 UTAH AVENUE SOUTH
SEATTLE, WASHINGTON 98134
(206) 318-1575

THESE DRAWINGS AND THE PROJECT MANUAL ARE CONFIDENTIAL AND SHALL REMAIN THE SOLE PROPERTY OF STARBUCKS CORPORATION, WHICH IS THE OWNER OF THE COPYRIGHT IN THIS WORK. THEY SHALL NOT BE REPRODUCED (IN WHOLE OR IN PART), SHARED WITH THIRD PARTIES, USED IN ANY MANNER ON OTHER PROJECTS OR EXTENSIONS TO THIS PROJECT WITHOUT THE PRIOR WRITTEN CONSENT OF STARBUCKS CORPORATION. THESE DRAWINGS AND SPECIFICATIONS ARE INTENDED TO EXPRESS DESIGN INTENT FOR A PROTOTYPICAL STARBUCKS STORE (WHICH IS SUBJECT TO CHANGE AT ANYTIME) AND DO NOT REFLECT ANY SITE SPECIFIC INFORMATION. PARTY SHALL HAVE ANY OBLIGATION NOR LIABILITY TO THE OTHER (EXCEPT STATED ABOVE) UNTIL A WRITTEN AGREEMENT IS FULLY EXECUTED BY BOTH PARTIES.

STARBUCKS TEMPLATE VERSION 11/2025.08.27

THIS DRAWING IS A DESIGN
DEVELOPMENT DOCUMENT.
SITE SPECIFIC MODIFICATIONS
MADE UNDER THE RESPONSIBLE
CHARGE OF THE ARCHITECT
AND/OR ENGINEER-OF-RECORD
WILL BE REQUIRED PRIOR TO
USING THIS DOCUMENT FOR
BIDDING, PERMITTING, OR
CONSTRUCTION.

PROJECT NAME:

TA CORDELE


PROJECT ADDRESS:
3397 ROCKHOUSE RD E
CORDELE, GA 31015

STORE #: TBD
PROJECT #: 108648-001
ISSUE DATE: 12/03/2025
DESIGN MANAGER: MANDY KENT
PRODUCTION DESIGNER: MAV
CHECKED BY: E. NORRIS


Revision Schedule			
Rev	Date	By	Description

SHEET TITLE:
**PLUMBING DESIGN
PLAN**


SHEET NUMBER: P101

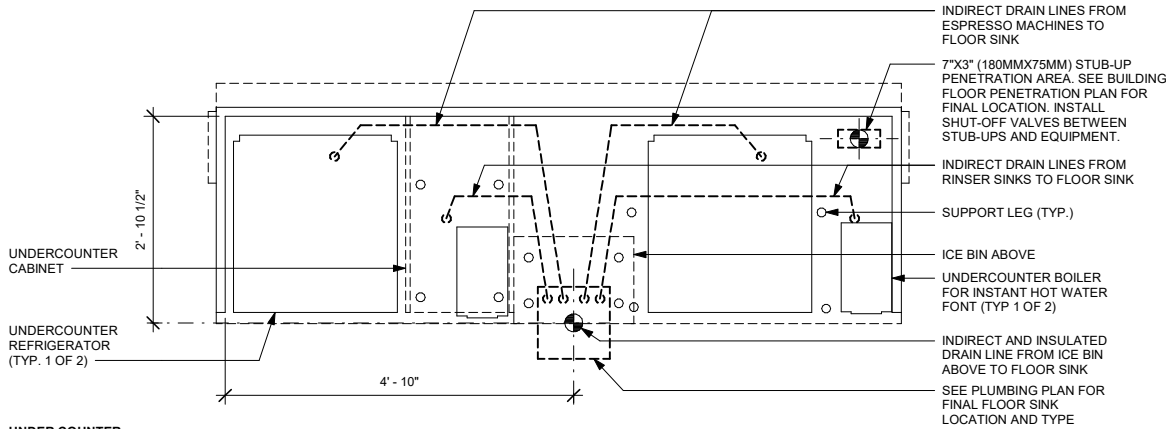

UNDER COUNTER

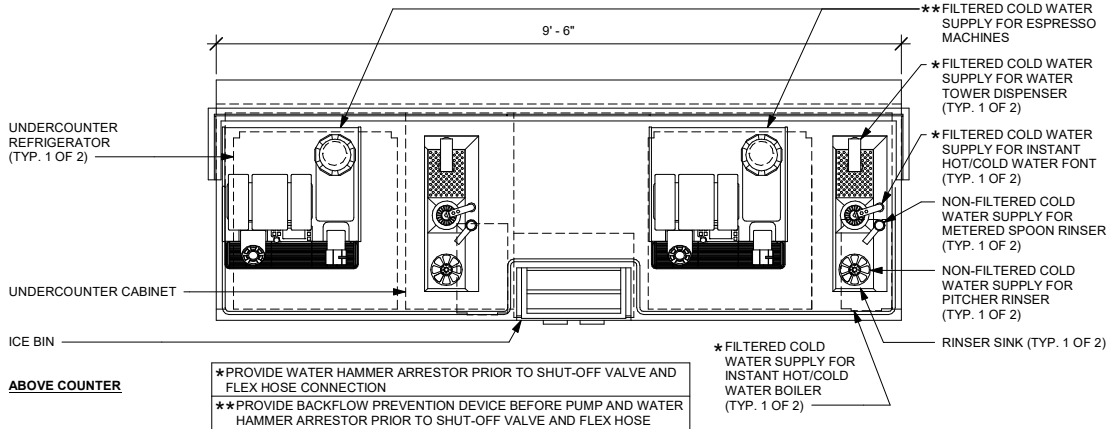

ABOVE COUNTER

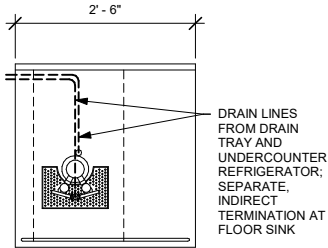


WORKSTATION TO UTILIZE SAME FLOOR SINK AS BACK BAR. SEE BUILDING FLOOR PENETRATION PLAN FOR SHARED LOCATION.

1 ESP 07-03 PLUMBING

Scale: 3/4" = 1'-0"


2 NIT 11-01 PLUMBING

Scale: 3/4" = 1'-0"

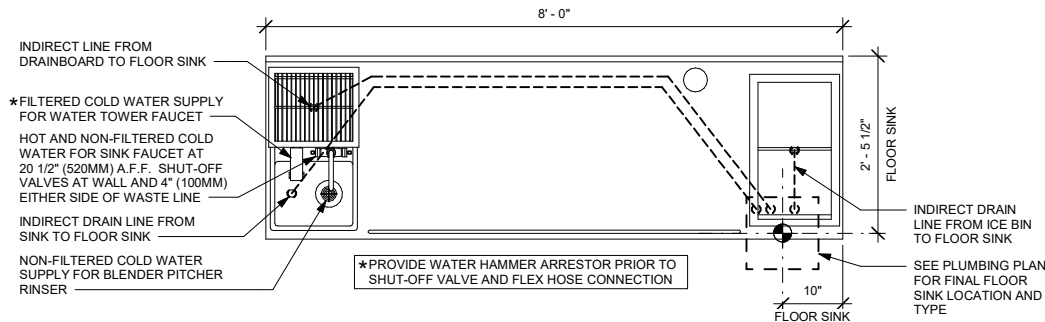


3 CBE 10-01 PLUMBING

Scale: 3/4" = 1'-0"

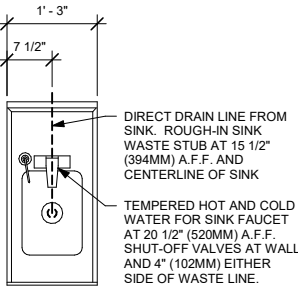

4 ADD 02-01 PLUMBING

Scale: 3/4" = 1'-0"

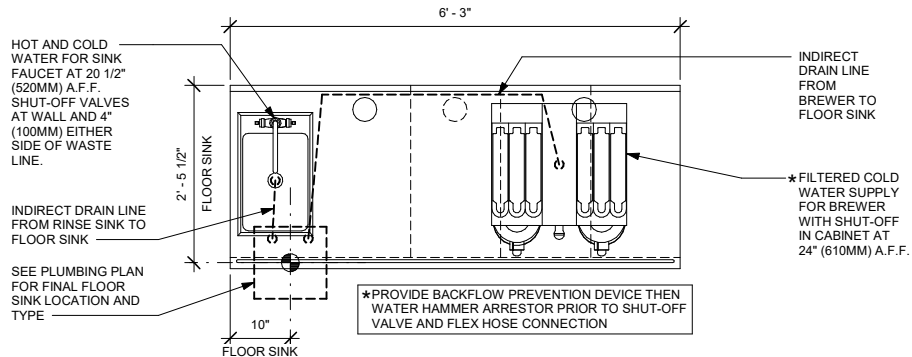

5 BRW PLUMBING

Scale: 3/4" = 1'-0"

ARCHITECT AND/OR ENGINEER OF RECORD TO VERIFY NUMBER OF FLOOR SINKS AND STUB-UP PENETRATIONS REQUIRED BY CODE PER JURISDICTION.

ARCHITECT AND/OR ENGINEER OF RECORD TO PROVIDE ALL PLUMBING DIAGRAMS, CALCULATIONS, AND DETAILS AS REQUIRED.

PROVIDE FILTERED COLD WATER TO ESPRESSO MACHINE(S), BREWER(S), HOT WATER TAP(S), WATER TOWER(S), AND ICE MACHINE.



STARBUCKS®
2401 UTAH AVENUE SOUTH
SEATTLE, WASHINGTON 98134
(206) 318-1575

THESE DRAWINGS AND THE PROJECT MANUAL ARE CONFIDENTIAL AND SHALL REMAIN THE SOLE PROPERTY OF STARBUCKS CORPORATION, WHICH IS THE OWNER OF THE COPYRIGHT IN THIS WORK. THEY SHALL NOT BE REPRODUCED (IN WHOLE OR IN PART), SHARED WITH THIRD PARTIES OR USED IN ANY MANNER ON OTHER PROJECTS OR EXTENSIONS TO THIS PROJECT WITHOUT THE PRIOR WRITTEN CONSENT OF STARBUCKS CORPORATION. THESE DRAWINGS AND SPECIFICATIONS ARE INTENDED TO EXPRESS DESIGN INTENT FOR A PROTOTYPICAL STARBUCKS STORE (WHICH IS SUBJECT TO CHANGE AT ANYTIME) AND DO NOT REFLECT ACTUAL SITE CONDITIONS. NEITHER PARTY SHALL HAVE ANY OBLIGATION NOR LIABILITY TO THE OTHER (EXCEPT STATED ABOVE) UNTIL A WRITTEN AGREEMENT IS FULLY EXECUTED BY BOTH PARTIES.

STARBUCKS TEMPLATE VERSION I2025.08.27

ARCHITECT OF RECORD

THIS DRAWING IS A DESIGN DEVELOPMENT DOCUMENT. SITE SPECIFIC MODIFICATIONS MADE UNDER THE RESPONSIBLE CHARGE OF THE ARCHITECT AND/OR ENGINEER-OF-RECORD WILL BE REQUIRED PRIOR TO USING THIS DOCUMENT FOR BIDDING, PERMITTING, OR CONSTRUCTION.

PROJECT NAME:
TA CORDELE

PROJECT ADDRESS:
397 ROCKHOUSE RD E
CORDELE, GA 31015

STORE #: TBD
PROJECT #: 108648-001
ISSUE DATE: 12/03/2025
DESIGN MANAGER: MANDY KENT
PRODUCTION DESIGNER: MAV
CHECKED BY: E. NORRIS

Revision Schedule			
Rev	Date	By	Description

SHEET TITLE:
PLUMBING DETAILS

SCALE: AS SHOWN

SHEET NUMBER:


P501

DESIGN DEVELOPMENT ONLY - NOT INTENDED FOR CONSTRUCTION USE


ARCHITECT AND/OR ENGINEER OF RECORD TO VERIFY
NUMBER OF FLOOR SINKS AND STUB-UP PENETRATIONS
REQUIRED BY CODE PER JURISDICTION.

ARCHITECT AND/OR ENGINEER OF RECORD TO PROVIDE ALL
PLUMBING DIAGRAM, CALCULATIONS, AND DETAILS
AS REQUIRED.


PROVIDE FILTERED COLD WATER TO ESPRESSO MACHINE(S),
BREWERS(S), HOT WATER TAP(S), WATER TOWER(S), AND
ICE MACHINE.

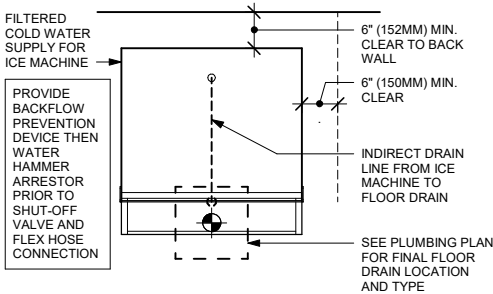

1 ICE MACHINE AND BIN - PLUMBING
Scale: 3/4" = 1'-0"

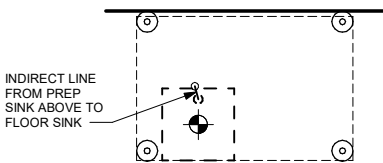


AT FLOOR LEVEL

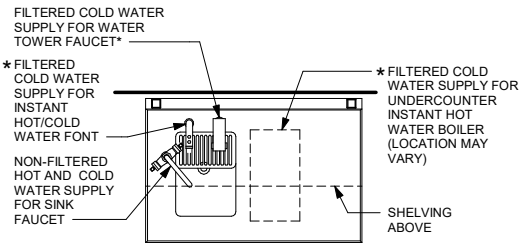


*PROVIDE WATER HAMMER ARRESTOR PRIOR TO SHUT-OFF VALVE AND FLEX HOSE CONNECTION

ABOVE COUNTERTOP

2 WATER FILLING STATION - PLUMBING
Scale: 3/4" = 1'-0"

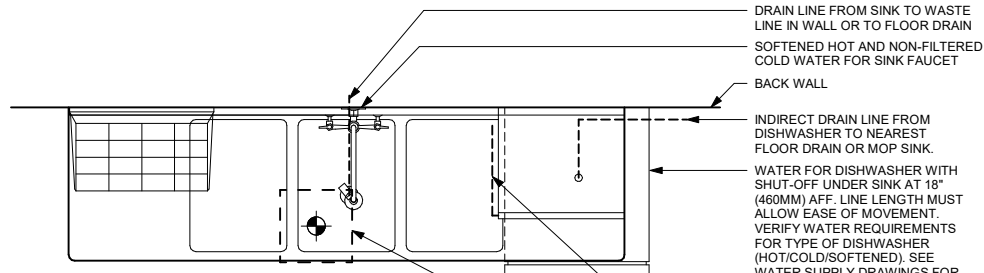

Plan View

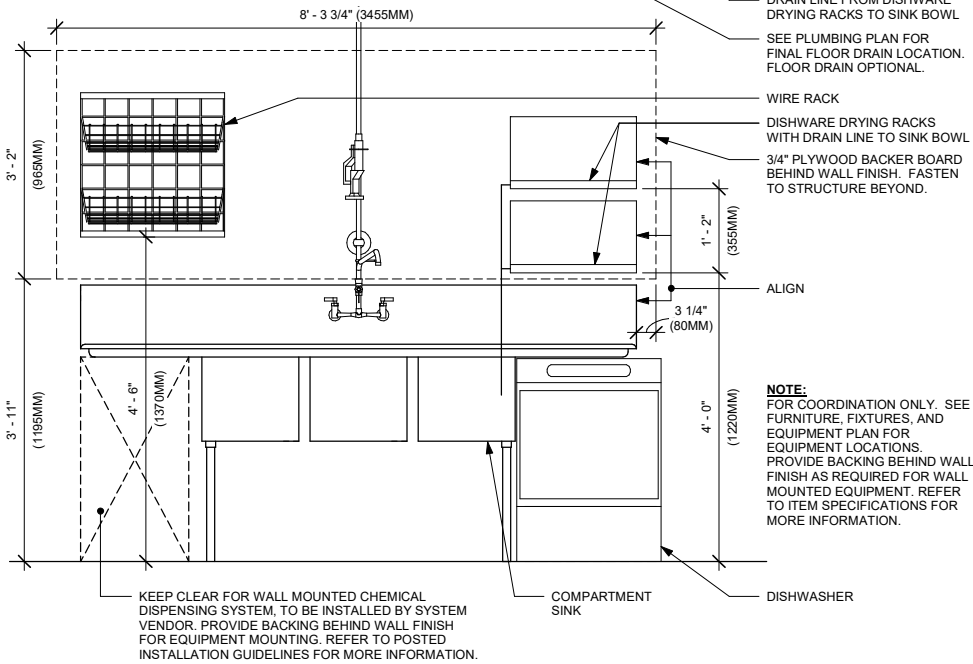

Elevation View

3 SANITIZING (GENERIC) - PLUMBING
Scale: 3/4" = 1'-0"

DESIGN DEVELOPMENT ONLY - NOT INTENDED FOR CONSTRUCTION USE



STARBUCKS®
2401 UTAH AVENUE SOUTH
SEATTLE, WASHINGTON 98134
(206) 318-1575

THESE DRAWINGS AND THE PROJECT MANUAL ARE CONFIDENTIAL AND SHALL REMAIN THE SOLE PROPERTY OF STARBUCKS CORPORATION, WHICH IS THE OWNER OF THE COPYRIGHT IN THIS WORK. THEY SHALL NOT BE REPRODUCED (IN WHOLE OR IN PART), SHARED WITH THIRD PARTIES OR USED IN ANY MANNER ON OTHER PROJECTS OR EXTENSIONS TO THIS PROJECT WITHOUT THE PRIOR WRITTEN CONSENT OF STARBUCKS CORPORATION. THESE DRAWINGS AND SPECIFICATIONS ARE INTENDED TO EXPRESS DESIGN INTENT FOR A PROTOTYPICAL STARBUCKS STORE (WHICH IS SUBJECT TO CHANGE AT ANYTIME) AND DO NOT REFLECT ACTUAL SITE CONDITIONS. NEITHER PARTY SHALL HAVE ANY OBLIGATION NOR LIABILITY TO THE OTHER (EXCEPT STATED ABOVE) UNTIL A WRITTEN AGREEMENT IS FULLY EXECUTED BY BOTH PARTIES.

STARBUCKS TEMPLATE VERSION I2025.08.27

ARCHITECT OF RECORD

THIS DRAWING IS A DESIGN DEVELOPMENT DOCUMENT. SITE SPECIFIC MODIFICATIONS MADE UNDER THE RESPONSIBLE CHARGE OF THE ARCHITECT AND/OR ENGINEER-OF-RECORD WILL BE REQUIRED PRIOR TO USING THIS DOCUMENT FOR BIDDING, PERMITTING, OR CONSTRUCTION.

PROJECT NAME:
TA CORDELE

PROJECT ADDRESS:
**397 ROCKHOUSE RDE
CORDELE, GA 31015**

STORE #: TBD
PROJECT #: 108648-001
ISSUE DATE: 12/03/2025
DESIGN MANAGER: MANDY KENT
PRODUCTION DESIGNER: MAV
CHECKED BY: E. NORRIS

Revision Schedule			
Rev	Date	By	Description

SHEET TITLE:
PLUMBING DETAILS

SCALE: AS SHOWN

SHEET NUMBER:

P502

WATER HEATER TANK.
SEE **WATER HEATER TANK** DETAIL
FOR MORE INFORMATION.

BOOSTER PUMP BY
FILTRATION VENDOR

GFCI 120V
RECEPTACLE FOR
BOOSTER PUMP
(SEE NOTE 5
BELOW)

OUT TO
WATER
FILTRATION
SYSTEM

SUPPORT
PLATFORM
PER
ENGINEER'S
DRAWINGS


CITY
WATER IN

NOTES:

1. ALL COMPONENTS DRAWN IN BOLD ARE GC RESPONSIBILITY.
2. ALL PIPING SHALL BE COPPER EXCEPT PEX TYPE PIPING WHICH IS ACCEPTABLE BETWEEN FILTER SYSTEM COMPONENTS AND ADVANSYS DISHWASHER WHERE ALLOWED BY CODE.
3. COORDINATE WITH ELECTRICAL CONTRACTOR FOR RECEPTACLES. SEE ELECTRICAL DETAILS FOR LOCATIONS.
4. ENSURE ALL PENETRATIONS THROUGH SURROUNDING WALLS AND CEILING ARE COMPLETELY SEALED.


1 BOOSTER PUMP - PLUMBING

Scale: 1" = 1'-0"

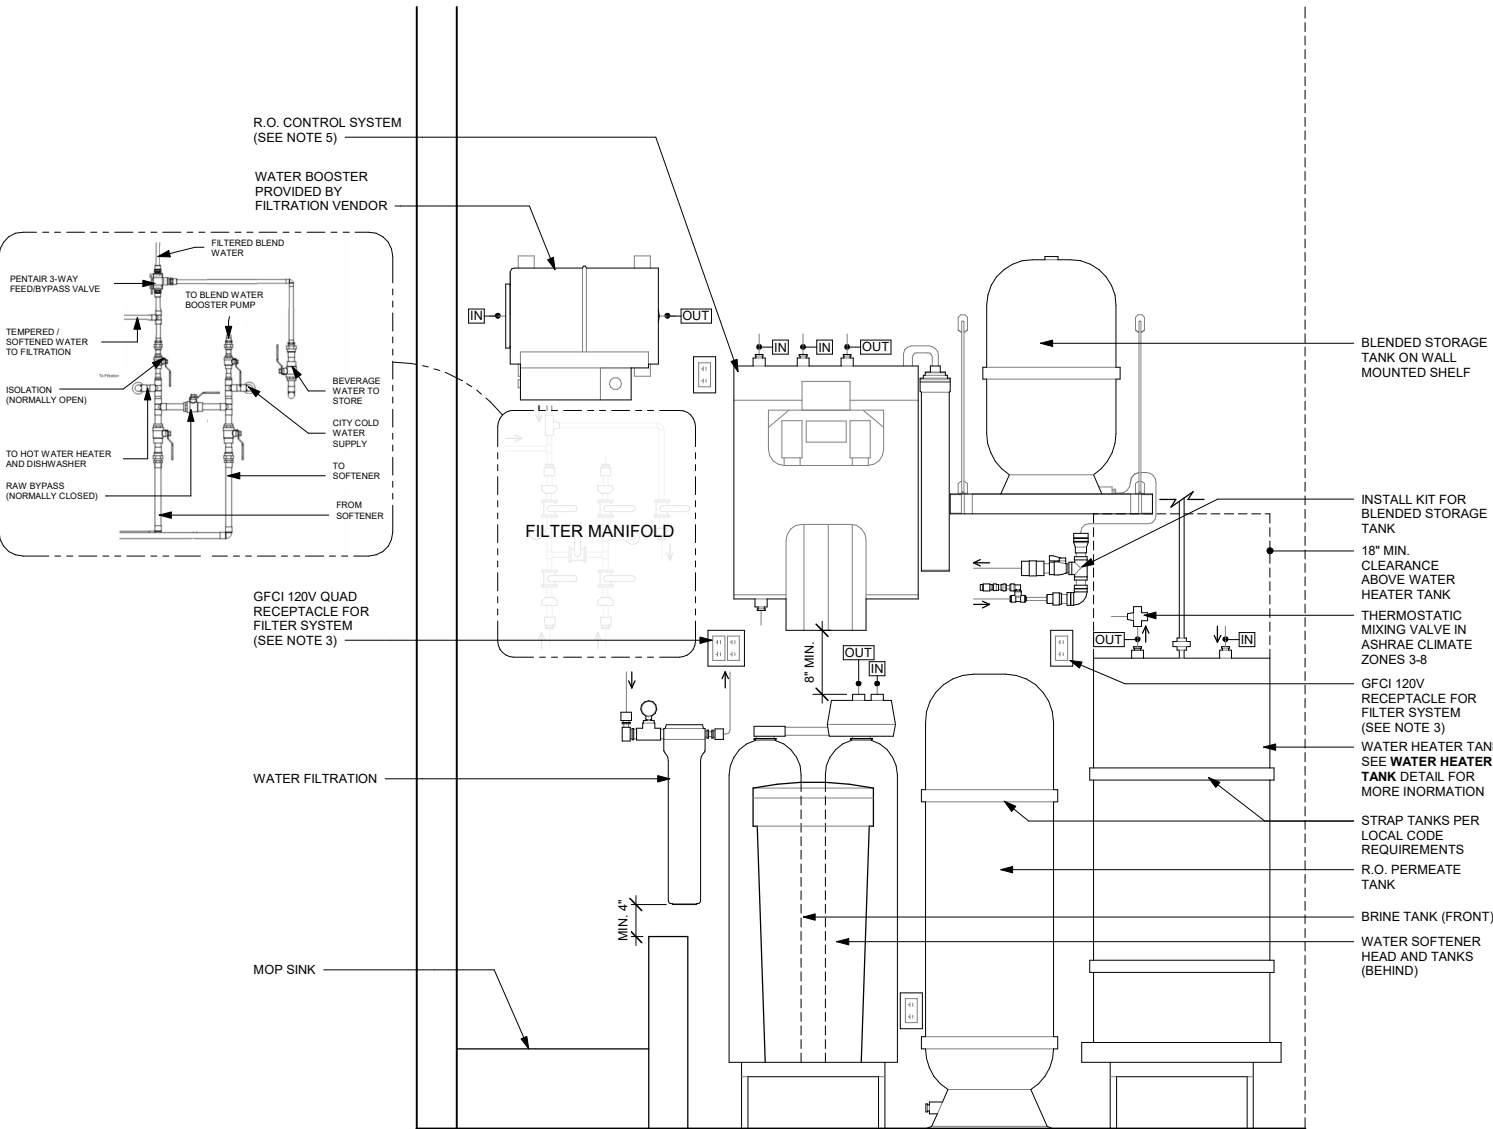

R.O. CONTROL SYSTEM
(SEE NOTE 5)

WATER BOOSTER
PROVIDED BY
FILTRATION VENDOR

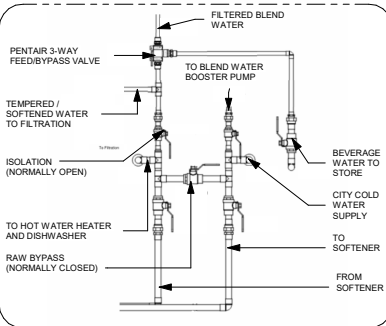

GFCI 120V QUAD
RECEPTACLE FOR
FILTER SYSTEM
(SEE NOTE 3)

WATER FILTRATION

MOP SINK

NOTES:

1. ALL COMPONENTS DRAWN IN BOLD ARE GC RESPONSIBILITY. GC TO COORDINATE INSTALLATION OF ALL OTHER COMPONENTS SHOWN WITH FILTER VENDOR.
2. ALL PIPING SHALL BE COPPER EXCEPT PEX TYPE PIPING WHICH IS ACCEPTABLE BETWEEN FILTER SYSTEM COMPONENTS AND FROM SOFTNER TO ADVANSYS DISHWASHER WHERE ALLOWED BY CODE.
3. COORDINATE WITH ELECTRICAL CONTRACTOR FOR RECEPTACLES. SEE ELECTRICAL DETAILS FOR LOCATIONS.
4. PROVIDE WATER SOFTENER INDIRECT DRAIN TO SINK, INSTALLED PER CODE. (CONFIRM REQUIREMENTS WITH SOFTENER EQUIPMENT CUTSHEETS IN ITEM SPECIFICATIONS).
5. IN MUNICIPALITIES WITH BRINE RESTRICTIONS, REFER TO THE WATER SYSTEM CONFIGURATIONS APPENDIX UNDER ITEM SPECIFICATIONS FOR WATER SOFTENER EXCHANGE TANK SCHEMATIC.
6. COMPONENTS ARE TO BE POSITIONED TO MAXIMIZE ACCESS FOR REGULAR SERVICING. PRE-FILTER, BYPASS VALVES, AND SOFTENER TANKS MUST BE INSTALLED 72" (1828MM) AFF OR LOWER.


2 CONFIGURATION III, R.O. AND SOFTENER WATER FILTRATION

Scale: 1" = 1'-0"

ARCHITECT AND/OR ENGINEER OF RECORD TO VERIFY
NUMBER OF FLOOR SINKS AND STUB-UP PENETRATIONS
REQUIRED BY CODE PER JURISDICTION.

ARCHITECT AND/OR ENGINEER OF RECORD TO PROVIDE ALL
PLUMBING DIAGRAMS, CALCULATIONS, AND DETAILS
AS REQUIRED.

PROVIDE FILTERED COLD WATER TO ESPRESSO MACHINE(S),
BREWERS(S), HOT WATER TAP(S), WATER TOWER(S), AND
ICE MACHINE.

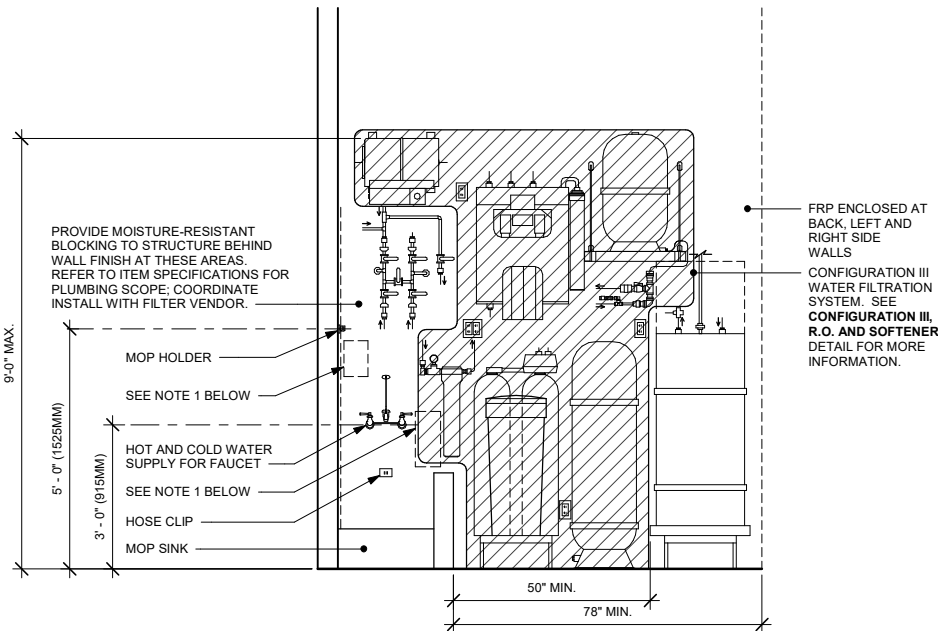

PROVIDE MOISTURE-RESISTANT
BLOCKING TO STRUCTURE BEHIND
WALL FINISH AT THESE AREAS.
REFER TO ITEM SPECIFICATIONS FOR
PLUMBING SCOPE; COORDINATE
INSTALL WITH FILTER VENDOR.

MOP HOLDER

SEE NOTE 1 BELOW

HOT AND COLD WATER
SUPPLY FOR FAUCET

SEE NOTE 1 BELOW

HOSE CLIP

MOP SINK

FRP ENCLOSED AT
BACK, LEFT AND
RIGHT SIDE
WALLS
CONFIGURATION III
WATER FILTRATION
SYSTEM. SEE
CONFIGURATION III,
R.O. AND SOFTENER
DETAIL FOR MORE
INFORMATION.

NOTE:

1. KEEP CLEAR AT BACKWALL FOR CHEMICAL DISPENSING SYSTEM COMPONENTS, TO BE INSTALLED BY SYSTEM VENDOR. REFER TO POSTED INSTALLATION GUIDELINES FOR MORE INFORMATION

3 CONFIGURATION III

Scale: 1/2" = 1'-0"



STARBUCKS[®]
2401 UTAH AVENUE SOUTH
SEATTLE, WASHINGTON 98134
(206) 318-1575

THESE DRAWINGS AND THE PROJECT MANUAL
ARE CONFIDENTIAL AND SHALL REMAIN THE
SOLE PROPERTY OF STARBUCKS
CORPORATION, WHICH IS THE OWNER OF THE
COPYRIGHT IN THIS WORK. THEY SHALL NOT
BE REPRODUCED (IN WHOLE OR IN PART),
SHARED WITH THIRD PARTIES OR USED IN ANY
MANNER ON OTHER PROJECTS OR
EXTENSIONS TO THIS PROJECT WITHOUT THE
PRIOR WRITTEN CONSENT OF STARBUCKS
CORPORATION. THESE DRAWINGS AND
SPECIFICATIONS ARE INTENDED TO EXPRESS
DESIGN INTENT FOR A PROTOTYPICAL
STARBUCKS STORE (WHICH IS SUBJECT TO
CHANGE AT ANYTIME) AND DO NOT REFLECT
ACTUAL SITE CONDITIONS. NEITHER PARTY
SHALL HAVE ANY OBLIGATION NOR LIABILITY TO
THE OTHER (EXCEPT STATED ABOVE) UNTIL A
WRITTEN AGREEMENT IS FULLY EXECUTED BY
BOTH PARTIES.

STARBUCKS TEMPLATE VERSION I2025.08.27

ARCHITECT OF RECORD

THIS DRAWING IS A DESIGN
DEVELOPMENT DOCUMENT.
SITE SPECIFIC MODIFICATIONS
MADE UNDER THE RESPONSIBLE
CHARGE OF THE ARCHITECT
AND/OR ENGINEER-OF-RECORD
WILL BE REQUIRED PRIOR TO
USING THIS DOCUMENT FOR
BIDDING, PERMITTING, OR
CONSTRUCTION.

PROJECT NAME:
TA CORDELE

PROJECT ADDRESS:
397 ROCKHOUSE RD E
CORDELE, GA 31015

STORE #: TBD
PROJECT #: 108648-001
ISSUE DATE: 12/03/2025
DESIGN MANAGER: MANDY KENT
PRODUCTION DESIGNER: MAV
CHECKED BY: E. NORRIS

Revision Schedule				
Rev	Date	By	Description	

SHEET TITLE:
PLUMBING DETAILS

SCALE: AS SHOWN

SHEET NUMBER:
P503

DESIGN DEVELOPMENT ONLY - NOT INTENDED FOR CONSTRUCTION USE