

THESE PLANS ARE THE PROPERTY OF MRP DESIGN GROUP, INC. AND ARE SUBJECT TO FEDERAL COPYRIGHT LAWS. ANY USE OF SAME WITHOUT THE EXPRESS WRITTEN PERMISSION OF MRP DESIGN GROUP, INC. IS STRICTLY PROHIBITED.

ABBREVIATIONS

3PL	THIRD PARTY LOGISTICS	HDW	HARDWARE
A/C	AIR CONDITIONING	HM	HOLLOW METAL
ACT	ACOUSTICAL CEILING TILE	HORIZ	HORIZONTAL
ADJ	ADJUSTABLE	HR	HOUR
AFF	ABOVE FINISHED FLOOR	HS	HAND SINK
AMP	AMPERE	HT	HEIGHT
AOR	ARCHITECT OF RECORD	HVAC	HEATING, VENTILATING, AND AIR CONDITIONING
BLDG	BUILDING	HW	HOT WATER
BOH	BACK OF HOUSE	ID	INSIDE DIAMETER
CAB	CABINET	LC	LICENSEE
CBS	COLD BEVERAGE STATION	LEED	LEADERSHIP IN ENERGY AND ENVIRONMENTAL DESIGN
CKT	CIRCUIT	LV	LOW VOLTAGE
CL	CENTER LINE	MAX	MAXIMUM
CLG	CEILING	MECH	MECHANICAL
CLR	CLEAR OR CLEARANCE	MEP	MECHANICAL, ELECTRICAL AND PLUMBING
COL	COLUMN	MFR	MANUFACTURER
COMP	COMPARTMENT	MIN	MINIMUM
CONST	CONSTRUCTION	MOP	MOBIL ORDER & PAY
CONT	CONTINUOUS	MS	MOP SINK
CTR	CENTER	NIC	NOT IN CONTRACT
CW	COLD WATER	NL	NIGHT LIGHT
CX	COMMISSIONING	NTS	NOT TO SCALE
CXA	COMMISSIONING AGENT	OA	OVERALL
DEG	DEGREE	OC	ON CENTER
DET	DETAIL	OD	OUTSIDE DIAMETER
DIA	DIAMETER	PC	PLUMBING CONTRACTOR
DIM	DIMENSION	PDM	STARBUCKS PROJECT DEVELOPMENT MANAGER
DISP	DISPENSER	PLAM	PLASTIC LAMINATE
DM	STARBUCKS DESIGN MANAGER	PLC	PLACE
DN	DOWN	POS	POINT OF SALE
DT	DRIVE THRU	R	RADIUS
DWG	DRAWING	REF	REFERENCE
EA	EACH	REQD	REQUIRED
EL	ELEVATION	REV	REVISION
ELEC	ELECTRICAL	RND	ROUND
EM	EMERGENCY	SB	STARBUCKS
EQ	EQUAL	SC	SOLID CORE
EQUIP	EQUIPMENT	SF	SQUARE FEET
ESP	ESPRESSO	SHT	SHEET
EXIST	EXISTING	SIM	SIMILAR
EXT	EXTERIOR	SPEC	SPECIFICATION
FC	STARBUCKS FIXTURE CONTRACTER	SQ	SQUARE
FF&E	FURNITURE, FIXTURE, AND EQUIPMENT	SS	SOLID SURFACE
F&I	FURNISH AND INSTALL	SST	STAINLESS STEEL
FLR	FLOOR	SUSP	SUSPENDED
FOH	FRONT OF HOUSE	TEL	TELEPHONE
FRP	FIBERGLAS REINFORCED PANEL	TEMP	TEMPORARY
FT	FOOT/FEET	TW	TEMPERED WATER
FW	FILTERED WATER	TYP	TYPICAL
GC	GENERAL CONTRACTOR	UC	UNDER COUNTER
GFCI	GROUND FAULT CIRCUIT INTERRUPTER	UNO	UNLESS NOTED OTHERWISE
GND	GROUND	VCT	VINYL CEILING TILE
GWB	GYPSPUM WALLBOARD	VD	VENDOR DIRECT
HC	HOLLOW CORE	VERT	VERTICAL
		VIF	VERIFY IN FIELD
		WH	WATER HEATER
		WP	WEATHER PROOF

TRAVEL CENTER-STAR BUCKS
4838 SR 96
JEFFERSONVILLE,
GEORGIA 31044



MEANS IF EGRESS (LSC CHAPTER 7 & 12)
BUSINESS, GROUP B - SEE LIFE SAFETY PLAN, SHEET LS100
OCCUPANT LOAD - (LSC TABLE 7.3.2.1.)

KITCHEN	347 SF/100	= 5
PREP STATION	110 SF/100	= 2
STANDING AREA	40 SF/5	= 8
SEATING (FIXED)		= 28
BUSINESS (STARBUCKS) TOTAL		= 43

OVERALL TOTAL = 43

NUMBER OF EXITS: 1-500:	IFC 1006.3.2 2 EXITS REQUIRED, 11 PROVIDED
MAXIMUM TRAVEL DISTANCE:	200" (NON-SPRINKLERED)

IBC-18, T-1017.2 TRAVEL DISTANCE SHOWN: COMMON PATH OF TRAVEL REQUIRED:	146'-6" 75'-0" MAXIMUM (NON-SPRINKLERED)
--	--

COMMON PATH OF TRAVEL PROVIDED: DEAD END LIMIT:	14'-0" 20'-0" MAXIMUM (NON-SPRINKLERED)
---	---

EXIT WIDTH: 0.2 x 218 = 4 x 36 RESTAURANT EGRESS DOOR = 5 x 36 B.O.H. EGRESS DOOR = 2 x 68 PUBLIC EGRESS DOOR =	IBC-18 1020.4 IFC 1005.3.2 43.6 INCHES REQUIRED 144 INCHES PROVIDED 180 INCHES PROVIDED 136 INCHES PROVIDED
---	--

TOTAL = 460 INCHES (WHOLE BUILDING)

FIRE RATINGS

	TYPE V-B	IBC TABLE 601
STRUCTURAL FRAME:	0 HRS	
INTERIOR WALLS:	0 HRS	
BEARING WALLS (EXTERIOR & INTERIOR):	0 HRS	
NON-BEARING WALLS AND PARTITIONS:	0 HRS	
FLOOR CONSTRUCTION:	0 HRS	
ROOF CONSTRUCTION:	0 HRS	

SCOPE OF WORK

NEW CONSTRUCTION OF A TA TRAVEL CENTER IN
JEFFERSONVILLE, GA, WHICH CONSISTS OF A TRUCKER LOUNGE,
SHOWERS, LAUNDRY ROOM, RETAIL AREA, RESTROOMS, GAME
AREA, SEATING AREAS, AND FOUR QUICK-SERVICE
RESTAURANTS. THE MAJORITY OF THE PROJECT HAS ALREADY
BEEN SUBMITTED. THIS ISSUE, DATED 05.04.26 HAS
MODIFICATIONS RELATED TO THE ADDITION OF THE STARBUCKS
QSR.

NOTES TO CONTRACTOR:

1. PROVIDE ADDRESS ON BUILDING IN COMPLIANCE WITH
SECTION AS PER IBC SECTION 501.2.
2. AS PER 7.2.2.3.2, LANDINGS SHALL BE LEVEL EXCEPT FOR
EXTERIOR LANDINGS, WHICH ARE PERMITTED TO HAVE A SLOPE
NOT TO EXCEED 1 IN 20, PER 7.1.6.3.1
3. GLAZING IN HAZARDOUS LOCATIONS SHALL COMPLY WITH
IBC SECTION 2406 AS IDENTIFIED IN 2406.4.
4. MAINTAIN REQUIRED SLOPE AS PER MANUFACTURER'S SPEC'S
FOR ROOFING MATERIAL.

CODE STRATEGY

THIS IS A TYPE V-B BUILDING, **NON-SPRINKLERED**. WE ARE
CONSIDERING THE WHOLE BUILDING AS USE GROUP B
(BUSINESS). PER IBC SECTION 303.1.2.1, A ROOM OR SPACE
USED FOR ASSEMBLY PURPOSES (QUICK-SERVICE RESTAURANTS,
QSRs, WHICH WOULD NORMALLY BE CLASSIFIED AS GROUP
A-2) WITH AN OCCUPANT LOAD OF LESS THAN 50 PERSONS
AND ACCESSORY TO ANOTHER OCCUPANCY MAY BE
CLASSIFIED AS A GROUP B OCCUPANCY OR AS PART OF THAT
OCCUPANCY. EACH RESTAURANT SPACE HAS AN OCCUPANT
LOAD OF LESS THAN 50 PERSONS, INCLUDING LIMITED LOBBY
SEATING FOR PATRONS. THEREFORE, WHEN CONSIDERED
INDIVIDUALLY, EACH RESTAURANT SPACE MAY BE CLASSIFIED
AS GROUP B, EVEN WHEN USING THE NON-SEPARATED USES
PROVISION. ALSO, IF THE CONVENIENCE STORE PORTION WERE
CONSIDERED AS (M) MERCANTILE IT WOULD BE LIMITED TO
12,000 SF. IN SECTION 903.2.1. WITHOUT SPRINKLER, THIS
BUSINESS IS DIRECTED TO SELLING TO TRUCKERS, PROVIDING
TRUCKER FUNCTIONS SUCH AS SHOWERS, LOUNGE, GAMES,
AND LAUNDRY. WE ARE CONSIDERING THE USE AS BUSINESS.

PLUMBING (CUSTOMER RESTROOMS & SERVICE)

TOTAL OCCUPANTS = 218	PER IPC-18, T 403.1 (MERCANTILE)	
218 / 2 = 109		
MALE: WC (109/500)	1 REQUIRED	3 PROVIDED
MALE: LAV (109/750)	1 REQUIRED	3 PROVIDED
MALE: URINALS (50 % SUBSTITUTION)	0 REQUIRED	3 PROVIDED

218 / 2 = 109		
FEMALE: WC (109/500)	1 REQUIRED	4 PROVIDED
FEMALE: LAV (109/750)	1 REQUIRED	4 PROVIDED

FAMILY WC: 2 PROVIDED


DRINKING FOUNTAIN:(218/1000) 1 REQUIRED AT BEVERAGE
FOUNTAIN &
EMPLOYEE
ATTENDED

SERVICE SINK: (SERVICES
C-STORE AREA) 1 REQUIRED 1 PROVIDED


CODE NOTES:

1. FINAL INSPECTION: ALL SYSTEMS, EQUIPMENT INSTALLED AND
OPERATING, READY FOR OCCUPANCY. THE INSPECTION
REQUEST MUST BE PHONED IN THE DAY PRIOR TO THE DATE THE
INSPECTION IS NEEDED.
2. OCCUPANCY CLASSIFICATION: M , TYPE OF CONSTRUCTION:
V-B , SPRINKLED: NO , FIRE SPRINKLER MONITORING: NO ,
T-HOUR PROTECTED: NO , BUILDING AREA IN SQUARE FEET:
15,060 , NUMBER OF STORIES: 1 , CALCULATED LOAD FOR
OCCUPANCY: 218 .
3. FIRE ALARM SYSTEM, IF REQUIRED BY CODE.
4. (DOORS) GENERAL SHALL MEET THE REQUIREMENTS OF THE NFPA
101 LIFE SAFETY CODE, CHAPTER 7, SEC. 7.2.1, 2018 EDITION. FIRE
DOOR ASSEMBLIES SHALL CONFORM TO NFPA 80.
5. **(FIRE EXTINGUISHERS)** PROVIDE PORTABLE FIRE
EXTINGUISHERS AS REQUIRED BY IBC SECTION 906
5.1. IN ACCORDANCE W/ IFC 2018. THE SIZE SHALL BE A
MINIMUM OF 2 - 2a; 10B-C, SEE A-2.0 AND 2 CLASS K 1.5
GAL., 80LB PORTABLE FIRE EXTINGUISHERS SEE A-2.0 ARE
REQUIRED AND SHALL BE INSTALLED AT A MAX. OF 48"
ABOVE THE FINISHED FLOOR TO THE TOP OF THE HANDLE.
TRAVEL DISTANCE TO A FIRE EXTINGUISHER SHALL NOT
EXCEED 75' FOR CLASS A, C & D FIRES. FIRE EXTINGUISHERS
SHALL NOT BE OBSTRUCTED OR OBSCURED FROM VIEW. FIRE
EXTINGUISHERS SHALL BE CONSPICUOUSLY LOCATED WHERE
THEY WILL BE READILY ACCESSIBLE AND IMMEDIATELY
AVAILABLE IN THE EVENT OF FIRE. PREFERABLY THEY SHALL BE
LOCATED ALONG NORMAL PATHS OF TRAVEL, INCLUDING
EXITS FROM AREA. ALL WORK AND INSPECTIONS OF
PORTABLE FIRE EXTINGUISHERS SHALL BE PERFORMED BY A
STATE CERTIFIED AGENT.
6. (SIGNAGE FOR RESTROOM): SHALL BE RAISED AND BRAILLE
CHARACTERS AND PICTORIAL SYMBOL SIGNS. SIGNS SHALL BE
INSTALLED ON THE WALL ADJACENT TO THE LATCH SIDE OF THE
DOOR. WHERE THERE IS NO WALL SPACE TO THE LATCH SIDE OF
THE DOOR, INCLUDING AT DOUBLE LEAF DOORS, SIGNS SHALL BE
PLACED ON THE NEAREST ADJACENT WALL. MOUNTING HEIGHTS
SHALL BE 60 INCHES ABOVE THE FINISH FLOOR TO THE CENTERLINE
OF THE SIGN.
7. THE (STREET NUMBER/BUILDING NUMBER) MUST BE VISIBLE FROM
THE STREET THAT PROVIDES DRIVEWAY ACCESS TO THE PROPERTY
AND PLACED ON A CONTRASTING BACKGROUND THAT
PROVIDES 24 HOUR VISIBILITY. THE STREET NUMBER MUST ALSO
MEET ONE OF THE FOLLOWING SIZE REQUIREMENTS: (1) IF THE
STREET NUMBER OR PLACED WITHIN 15 FEET OR LESS OF THE CURB
OR EDGE OF PAVEMENT OF THE STREET, THE STREET NUMBER
SHALL BE POSTED IN FIGURES AT LEAST 4 INCHES IN HEIGHT. (2) IF
THE STREET NUMBER IS PLACED MORE THAN 15 FEET FROM THE
CURB OR EDGE OF PAVEMENT OF THE STREET, THE STREET NUMBER
SHALL BE POSTED IN FIGURES AT LEAST 6 INCHES IN HEIGHT.
INTERNATIONAL FIRE CODE, CHAPTER 5, SECTION 505.1, 2018
EDITION.
8. THE DRAWINGS WERE REVIEWED UNDER THE APPLICABLE LAWS AT
THE TIME.
9. EVERY EFFORT WAS MADE TO ENSURE CODE COMPLIANCE. ANY
CODE VIOLATIONS THAT WERE MISSED DURING THE PLAN REVIEW
ARE THE OWNER'S RESPONSIBILITY AND MUST BE CORRECTED IN
ORDER TO RECEIVE APPROVAL OR A CERTIFICATE OF
OCCUPANCY.
10. THE FOLLOWING PLANS MUST BE SUBMITTED AND APPROVED
PRIOR TO THE START OF ANY CONSTRUCTION IN THEIR DISCIPLINE:
HOOD EXHAUST SYSTEM, TRUSS DESIGN PLANS AND INDIVIDUAL
TRUSS DRAWINGS.
11. KNOX BOX LOCATIONS ARE TO BE COORDINATED WITH FIRE
MARSHAL.
12. MAIN 6000 SF.
13. OCCUPANT LOAD OF ENCLOSED = 8 PERSONS MAX TRAVEL TO
EXIT. ENCLOSURE IS 68 FT, WHICH IS LESS THAN 75 FT - (COMMON
PATH - SINGLE EXIT.) NFPA 362.4.3.

LOCATION MAP NORTH
SITE LOCATION

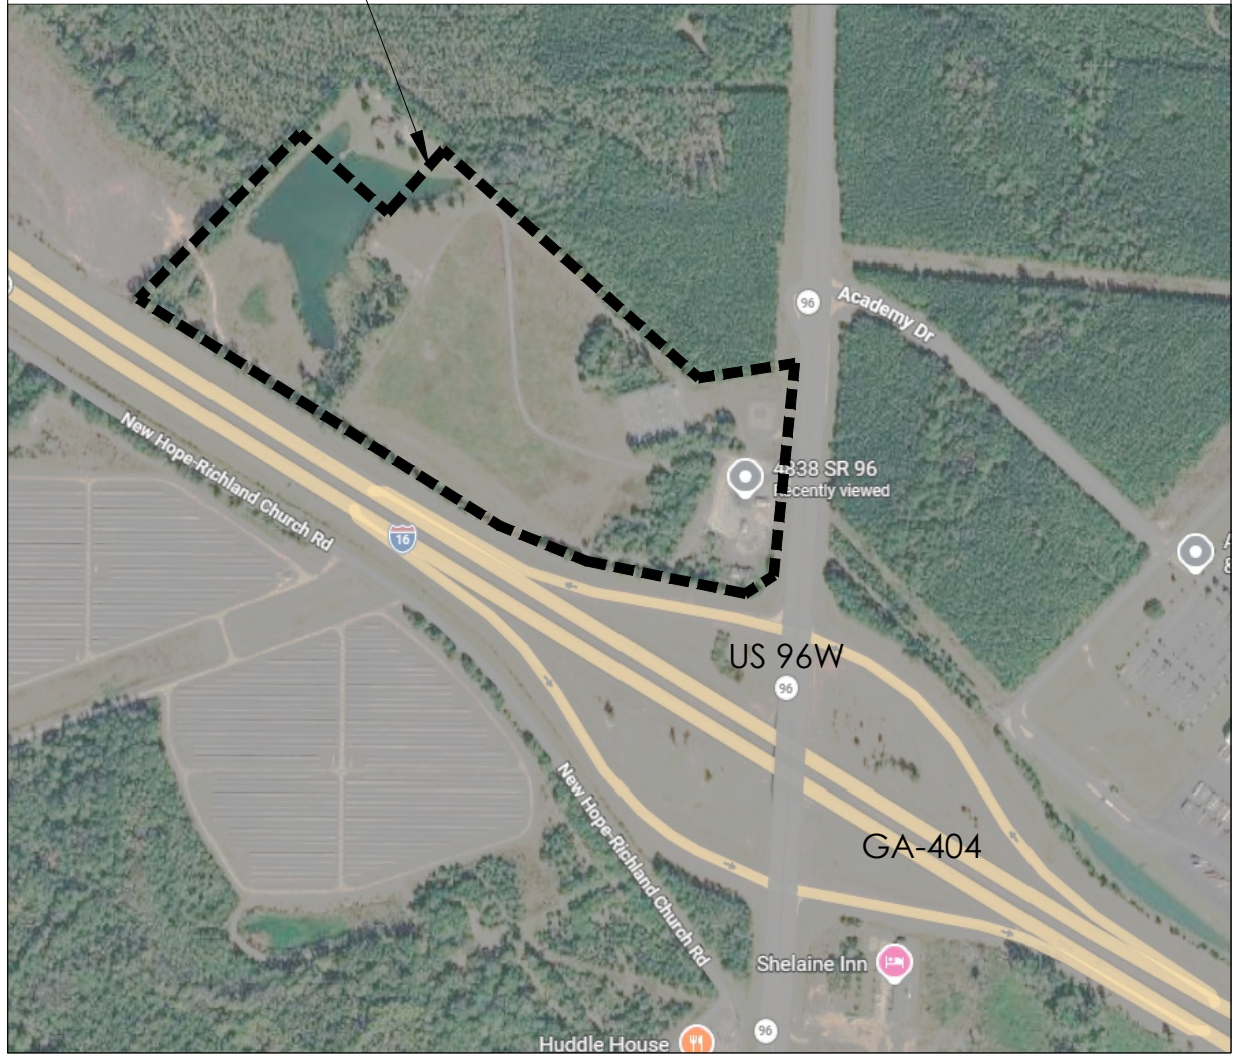

SYMBOL LEGEND

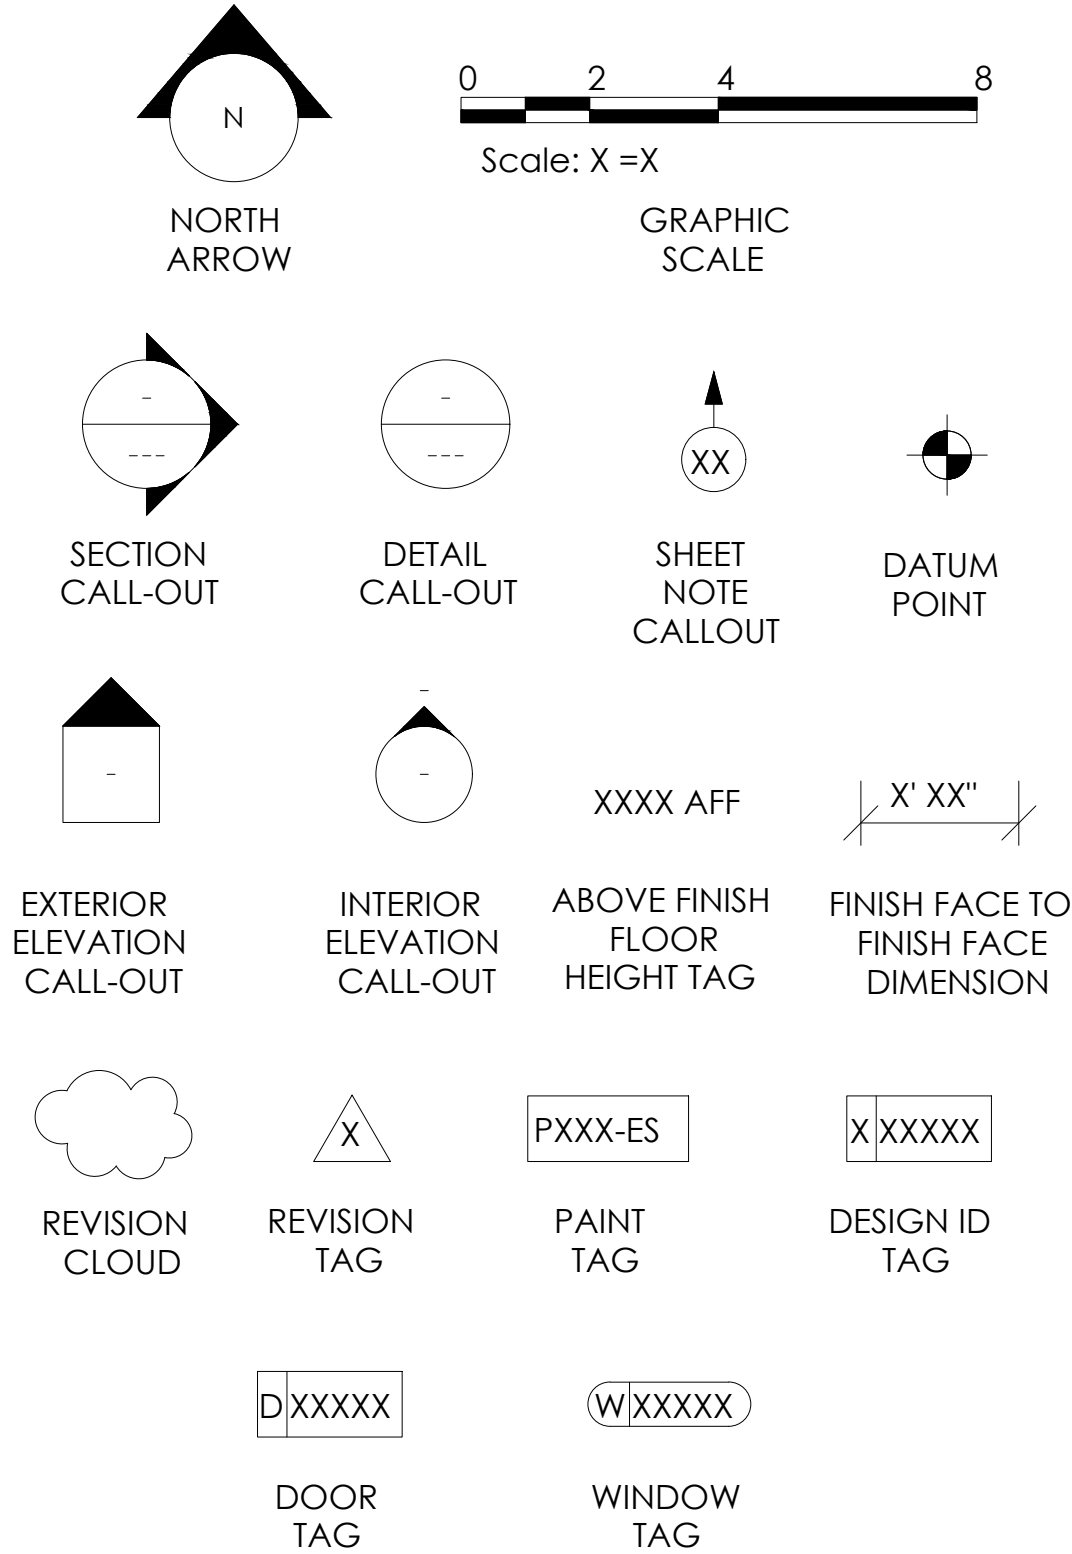

ARCHITECT'S NOTE:

THOMAS E. MORGAN, JR., THE ARCHITECT OF RECORD, HAS
NOT BEEN ENGAGED TO PERFORM CONTRACT ADMINISTRATION
WORK FOR THIS PROJECT. HE THEREFORE IS NOT RESPONSIBLE
FOR INTERPRETING THE INTENT OF THE CONSTRUCTION
DOCUMENTS DURING BIDDING AND CONSTRUCTION,
INCLUDING MAKING MODIFICATIONS AS MAY BE NECESSARY
DURING THE CONSTRUCTION PHASE; AND THE ARCHITECT OF
RECORD WILL NO LONGER BE LIABLE FOR THE WORK WHERE
CHANGES TO THESE DOCUMENTS HAVE BEEN MADE.

CONSULTANT COORDINATION

ARCHITECT
THOMAS E. MORGAN,
JR.- ARCHITECT
423 FISCHER TRAIL
ELLIJAY, GEORGIA 30540
(770) 917-9172
TMorgan@mrpdesign.com

ELECTRICAL
McCULLOUGH ENGINEERING
1820 REAVIS MOUNTAIN ROAD
BALLGROUND, GA 30107
CONTACT:JESS McCULLOUGH
TEL: 770-735-3405

MECHANICAL, PLUMBING
EDWARDS ENGINEERING
3383 HWY 5 SUITE C
DOUGLASVILLE, GA. 30135
CONTACT: JONATHAN EDWARDS
770-942-7052
edwa9281@bellsouth.net

PROJECT COORDINATOR
JOSE BECERRA
MRP DESIGN GROUP
3450 ACWORTH DUE WEST ROAD
SUITE 120
KENNESAW, GA 30144
(770) 917-9172 ext. 112
jbecerria@mrpdesign.com

STARBUCKS
(MAILING ADDRESS)
STARBUCKS COFFEE COMPANY
2401 UTAH AVENUE SOUTH
MS STOP: S-SD10
SEATTLE, WASHINGTON, 98134
(206) 318-1575

DESIGN MANAGER
STARBUCKS COFFEE COMPANY
2401 UTAH AVENUE SOUTH
SEATTLE, WASHINGTON 98134
CONTACT: MANDY KENT
(209) 434-0778
AKENT@STARBUCKS.COM

**CONSTRUCTION PROJECT
MANAGER**
STARBUCKS COFFEE COMPANY
2401 UTAH AVENUE SOUTH
SEATTLE, WASHINGTON 98134
CONTACT: BRIAN DELONG
(706) 851-0824
BDELONG@STARBUCKS.COM

ARCHITECT OF RECORD:

THOMAS E. MORGAN, JR.
ARCHITECT

423 FISCHER TRAIL
ELLIJAY, GEORGIA 30540

SEAL:



**MRP
DESIGN GROUP**

3450 Acworth Due West Road
Building 100, Suite 120
Kennesaw, Georgia 30144
P. 770-917-9172
F. 770-917-9470
www.mrpdesign.com

RELEASED FOR
CONSTRUCTION

ISSUES / REVISIONS:

DATE	DESCRIPTION
05.04.26	RELEASE FOR CONSTRUCTION

DRAWN BY: JB

CHKD BY: TM

PROJECT DESCRIPTION:

NEW CONSTRUCTION OF A TA
TRAVEL CENTER IN
JEFFERSONVILLE, GA, WHICH
CONSISTS OF A TRUCKER
LOUNGE, SHOWERS, LAUNDRY
ROOM, RETAIL AREA,
RESTROOMS, GAME AREA,
SEATING AREAS, AND FOUR
QUICK-SERVICE RESTAURANTS.
THE MAJORITY OF THE
PROJECT HAS ALREADY BEEN
SUBMITTED. THIS ISSUE, DATED
05.04.26 HAS MODIFICATIONS
RELATED TO THE ADDITION OF
THE STARBUCKS QSR.

PROJECT TITLE:

TRAVEL CENTER
4838 SR 96
JEFFERSONVILLE,
GEORGIA 31044

SHEET TITLE:

COVER SHEET

PROJECT NO: 25021

G000

THESE PLANS ARE THE PROPERTY OF MRP DESIGN GROUP, INC. AND ARE SUBJECT TO FEDERAL COPYRIGHT LAWS. ANY USE OF SAME WITHOUT THE EXPRESS WRITTEN PERMISSION OF MRP DESIGN GROUP, INC. IS STRICTLY PROHIBITED.

GENERAL NOTES:

1. THE CONTRACTOR SHALL VERIFY ALL CONDITIONS, AND DIMENSIONS PRIOR TO STARTING ANY WORK AND SHALL BE RESPONSIBLE FOR ALL WORK AND MATERIALS INCLUDING THOSE FURNISHED BY SUBCONTRACTORS AND OWNER.
2. STATED DIMENSIONS TAKE PRECEDENCE OVER GRAPHICS. DO NOT SCALE DRAWINGS TO DETERMINE LOCATIONS. THE OWNER SHALL BE NOTIFIED OF ANY DISCREPANCIES PRIOR TO CONTINUING WORK.
3. IT SHALL BE THE RESPONSIBILITY OF THE CONTRACTOR TO LOCATE ALL EXISTING UTILITIES.
4. FOR CONSTRUCTION DETAILS THAT ARE NOT SHOWN, USE THE MANUFACTURER'S APPROVED SHOP DRAWINGS / DATA SHEETS IN ACCORDANCE WITH THE DRAWINGS.
5. ALL SPECIFIED MATERIALS MUST BE INSTALLED PER MANUFACTURER'S REQUIREMENTS. ANY DISCREPANCIES OR CONFLICTS BETWEEN THE DRAWINGS AND THE MANUFACTURER'S REQUIREMENTS SHOULD BE IDENTIFIED BY THE CONTRACTOR PRIOR TO INSTALLATION.
6. CONTRACTOR TO NOTIFY THE ARCHITECT OF ANY AND ALL DISCREPANCIES FOUND ON THESE DOCUMENTS. IN THE ABSENCE OF NOTIFICATION OR RESPONSE FROM THE ARCHITECT THE CONTRACTOR WILL BID THE MOST EXPENSIVE CHOICE OF THE ITEMS IN QUESTION
7. NO EMAILS WILL SUPERSEDE THESE DRAWINGS. G.C. MUST CONTACT THE ARCHITECT BY PHONE OR SIGNED RFI'S.

STARBUCKS GENERAL NOTES

1. THESE DRAWINGS AND THE PROJECT MANUAL TOGETHER CONSTITUTE THE STARBUCKS DESIGN DEVELOPMENT SET. ALL GENERAL REQUIREMENTS ARE TO BE MET AND ALL MATERIALS, FINISHES, AND SYSTEMS ARE TO BE INSTALLED PER SPECIFICATIONS UNLESS NOTED OTHERWISE.
2. GENERAL CONTRACTOR SHALL VISIT THE SITE, REVIEW THE BUILDING SHELL DRAWINGS AS SUBMITTED BY THE LICENSEE'S ARCHITECT OF RECORD AND BECOME THOROUGHLY FAMILIAR WITH THE SITE CONDITIONS PRIOR TO CONSTRUCTION.
3. GENERAL CONTRACTOR SHALL CONSULT WITH LICENSEE'S ARCHITECT OF RECORD AND STARBUCKS PROJECT DEVELOPMENT MANAGER TO RESOLVE ANY CHANGES, OMISSIONS OR PLAN DISCREPANCIES PRIOR TO CONSTRUCTION.
4. GENERAL CONTRACTOR SHALL PATCH AND REPAIR ALL EXISTING WALLS, FLOORS, CEILINGS, OR OTHER SURFACES IDENTIFIED TO REMAIN THAT MAY BECOME DAMAGED DURING THE COURSE OF WORK.
5. GENERAL CONTRACTOR IS RESPONSIBLE FOR OBTAINING PERMITS FOR FIRE PROTECTION, PLUMBING, MECHANICAL, AND ELECTRICAL SYSTEMS PRIOR TO INSTALLATION OF SUCH SYSTEMS.
6. GENERAL CONTRACTOR SHALL RETAIN ONE SET OF PERMIT PLANS ON-SITE TO DOCUMENT ALL CHANGES MADE DURING CONSTRUCTION. THE RECORD DRAWINGS SHALL BE ISSUED TO THE LICENSEE AND THE STARBUCKS PROJECT DEVELOPMENT MANAGER AT PROJECT CLOSE-OUT AS DESCRIBED IN THE GENERAL REQUIREMENTS OF THE PROJECT MANUAL.
7. GENERAL CONTRACTOR IS RESPONSIBLE FOR COORDINATING DELIVERY OF MATERIALS FROM STARBUCKS CONTRACTED THIRD PARTY LOGISTICS DISTRIBUTION SERVICES AND VENDOR DIRECT SHIPMENTS. SEE PROJECT MANUAL FOR ADDITIONAL INFORMATION.
8. RESPONSIBILITY FOR SUPPLY AND DELIVERY OF MATERIALS AND EQUIPMENT IS IDENTIFIED IN THE DRAWING SCHEDULE SHEETS THE COLUMN LABELED "RESPONSIBILITY".
9. FOR THE PURPOSE OF THE DOCUMENTS, TO TO PROVIDE ALL FASTENERS, MISCELLANEOUS HARDWARE, BLOCKING, ELECTRICAL CONNECTIONS, PLUMBING CONNECTIONS AND OTHER ITEMS REQUIRED FOR A COMPLETE AND OPERATIONAL INSTALLATION, UNLESS OTHERWISE NOTED.
10. ALL ITEM SUBSTITUTIONS MUST BE APPROVED BY THE STARBUCKS DESIGN MANAGER AND/OR PROJECT DEVELOPMENT MANAGER.

INDEX OF SHEETS

LEGEND: X - SHEET ISSUED
R - SHEET ISSUED FOR REFERENCE AND COORDINATION ONLY
SEE TITLBLOCK FOR REVISION ISSUE DATE(S)

SCHEDULE PREFIX

- A - DATA DEVICE SCHEDULE
- B - WALL BASE SCHEDULE
- C - CASEWORK SCHEDULE
- D - DOOR SCHEDULE
- E - SPECIALTY EQUIPMENT SCHEDULE
- F - FURNITURE SCHEDULE
- G - GRAPHICS AND ARTWORK SCHEDULE
- L - LIGHTING FIXTURE SCHEDULE
- M - MECHANICAL EQUIPMENT SCHEDULE
- P - PLUMBING FIXTURE SCHEDULE
- Q - WALL TREATMENT (AREA) SCHEDULE
- R - WALL TREATMENT (LENGTH) SCHEDULE
- S - SIGNAGE SCHEDULE
- T - FLOOR TREATMENT SCHEDULE
- U - CEILING TREATMENT SCHEDULE
- W - WINDOW SCHEDULE
- Y - SITE SCHEDULE
- Z - WINDOW FILM SCHEDULE

CUSTOM DESIGN ID KEY

SIGNAGE	"S"	x0000 - x0999
GRAPHICS AND ARTWORK	"G"	x1000 - x1099
SITE	"Y"	x1100 - x1199
DOORS	"D"	x2000 - x2999
DATA DEVICE	"A"	x3000 - x3999
SPECIALITY EQUIPMENT	"E"	x4000 - x4999
CASEWORK	"C"	x5000 - x5999
FURNITURE	"F"	x6000 - x6999
LIGHTING FIXTURE	"L"	x7000 - x7999
PLUMBING / MECHANICAL	"P" / "M"	x8000 - x8999
FINISHES - PAINT		x9000 - x9199
FINISHES - FLOOR TREATMENT	"T"	x9200 - x9399
FINISHES - WALL TREATMENT	"Q" / "R"	x9400 - x9799
FINISHES - CEILING TREATMENT	"U"	x9800 - x9999

LICENSED STORES
RESPONSIBILITY LEGEND

- SB - STARBUCKS
- FC - STARBUCKS FIXTURE CONTRACTOR
- LC - LICENSEE
- GC - LICENSEE'S GENERAL CONTRACTOR
- 3PV - STARBUCKS THIRD - PARTY VENDOR

FLAME SPREAD REQUIREMENTS


CASEWORK	CLASS C
SUBSTRATE	CLASS C
SEALANTS	CLASS C
MURALS	CLASS C
FURNITURE	CLASS C
FABRIC	CLASS C
OTHER	CLASS C

SHEET INDEX


DRWG. NO.	TITLE	REVISION DATE
G 000 G 001 ADA-1 ADA-2 ADA-3 LSP	<u>GENERAL DRAWINGS</u> COVER SHEET SHEET INDEX & COM. CHECK ADA COMPLIANCE ADA COMPLIANCE ADA COMPLIANCE LIFE SAFETY PLAN	
	<u>ARCHITECURAL DRAWINGS</u> ARCHITECTURAL SITE PLAN BUILDING FLOOR PLAN & DOOR SCHEDULE BUILDING FLOOR PENETRATION PLAN BUILDING EXTERIOR ELEVATIONS BLOCKING ELEVATIONS BLOCKING ELEVATIONS BLOCKING ELEVATIONS	
A001 A101 A102 A201 A401 A402 A403	<u>STARBUCKS INTERIOR DRAWINGS</u> ARCHITECTURAL SITE PLAN BUILDING FLOOR PLAN & DOOR SCHEDULE BUILDING FLOOR PENETRATION PLAN BUILDING EXTERIOR ELEVATIONS BLOCKING ELEVATIONS BLOCKING ELEVATIONS BLOCKING ELEVATIONS REFLECTED CEILING PLAN LIGHTING DIMENSION PLAN LIGHTING PLACEMENT PLAN CASEWORK FRONTBAR DETAIL INTERIOR FLOOR FINISH DETAILS INTERIOR WALL FINISH DETAILS INTERIOR WALL FINISH DETAILS INTERIOR FINISH ELEVATIONS INTERIOR FINISH ELEVATIONS INTERIOR FINISH ELEVATIONS INTERIOR FINISH ELEVATIONS INTERIOR DETAILS INTERIOR DETAILS INTERIOR DETAILS INTERIOR DETAILS INTERIOR DETAILS CASEWORK DETAILS CASEWORK DETAILS CASEWORK DETAILS CASEWORK DETAILS CASEWORK DETAILS CASEWORK DETAILS CASEWORK DETAILS CASEWORK DETAILS DESIGN DETAIL - ARTWORK	
1101 1101.1 1102 1102.1 1102.3 1102.5 1102.5.2 1103 1104 1105 1106 1106.1 1107 1107.1 1201 1202 1203 1501 1502 1503 1504 1505 1506 1507 1507.1 1507.2 1507.3 1507.4 1507.5 1507.6 1508 1509	<u>MECHANICAL DRAWINGS</u> NOTES, SCHEDULES, LEGENDS - HVAC FLOOR PLAN- HVAC ROOF PLAN - HVAC <u>ELECTRICAL DRAWINGS</u> CALCULATIONS FOOD SERVICE EQUIPMENT SCHEDULES TRAVEL CENTER LIGHTING PLAN STARBUCKS POWER PLAN <u>PLUMBING DRAWINGS</u> PLUMBING NOTES & LEGEND FLOOR PLAN - PLUMBING PART PLANS- STARBUCKS	
M000 M100 M101		
E003 E004 E100 E201		
P000 P100 P106		

ARCHITECT OF RECORD:

 
THOMAS E. MORGAN, JR.
ARCHITECT



 423 FISCHER TRAIL
ELLIJAY, GEORGIA 30540



SEAL:

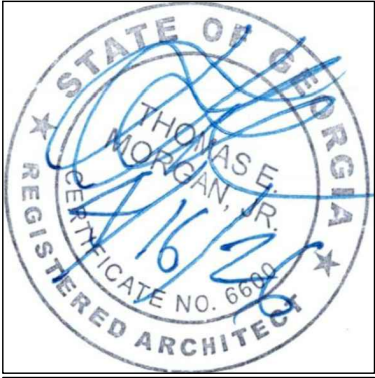

3450 Acworth Due West Road
Building 100, Suite 120
Kennesaw, Georgia 30144
P: 770-917-9172
F: 770-917-9470
www.mrpdesign.com

RELEASED FOR
CONSTRUCTION

ISSUES / REVISIONS:

DATE	DESCRIPTION
05.04.26	RELEASE FOR CONSTRUCTION

DRAWN BY: JB

CHKD BY: TM

PROJECT DESCRIPTION:

NEW CONSTRUCTION OF A TA TRAVEL CENTER IN JEFFERSONVILLE, GA. WHICH CONSISTS OF A TRUCKER LOUNGE, SHOWERS, LAUNDRY ROOM, RETAIL AREA, RESTROOMS, GAME AREA, SEATING AREAS, AND FOUR QUICK-SERVICE RESTAURANTS. THE MAJORITY OF THE PROJECT HAS ALREADY BEEN SUBMITTED. THIS ISSUE, DATED 05.04.26 HAS MODIFICATIONS RELATED TO THE ADDITION OF THE STARBUCKS QSR.

PROJECT TITLE:

TRAVEL CENTER
4838 SR 96
JEFFERSONVILLE,
GEORGIA 31044


SHEET TITLE:

SHEET INDEX
& COM. CHECK

PROJECT NO: 25021

G001

THESE PLANS ARE THE PROPERTY OF MRP DESIGN GROUP, INC. AND ARE SUBJECT TO FEDERAL COPYRIGHT LAWS. ANY USE OF SAME WITHOUT THE EXPRESS WRITTEN PERMISSION OF MRP DESIGN GROUP, INC. IS STRICTLY PROHIBITED

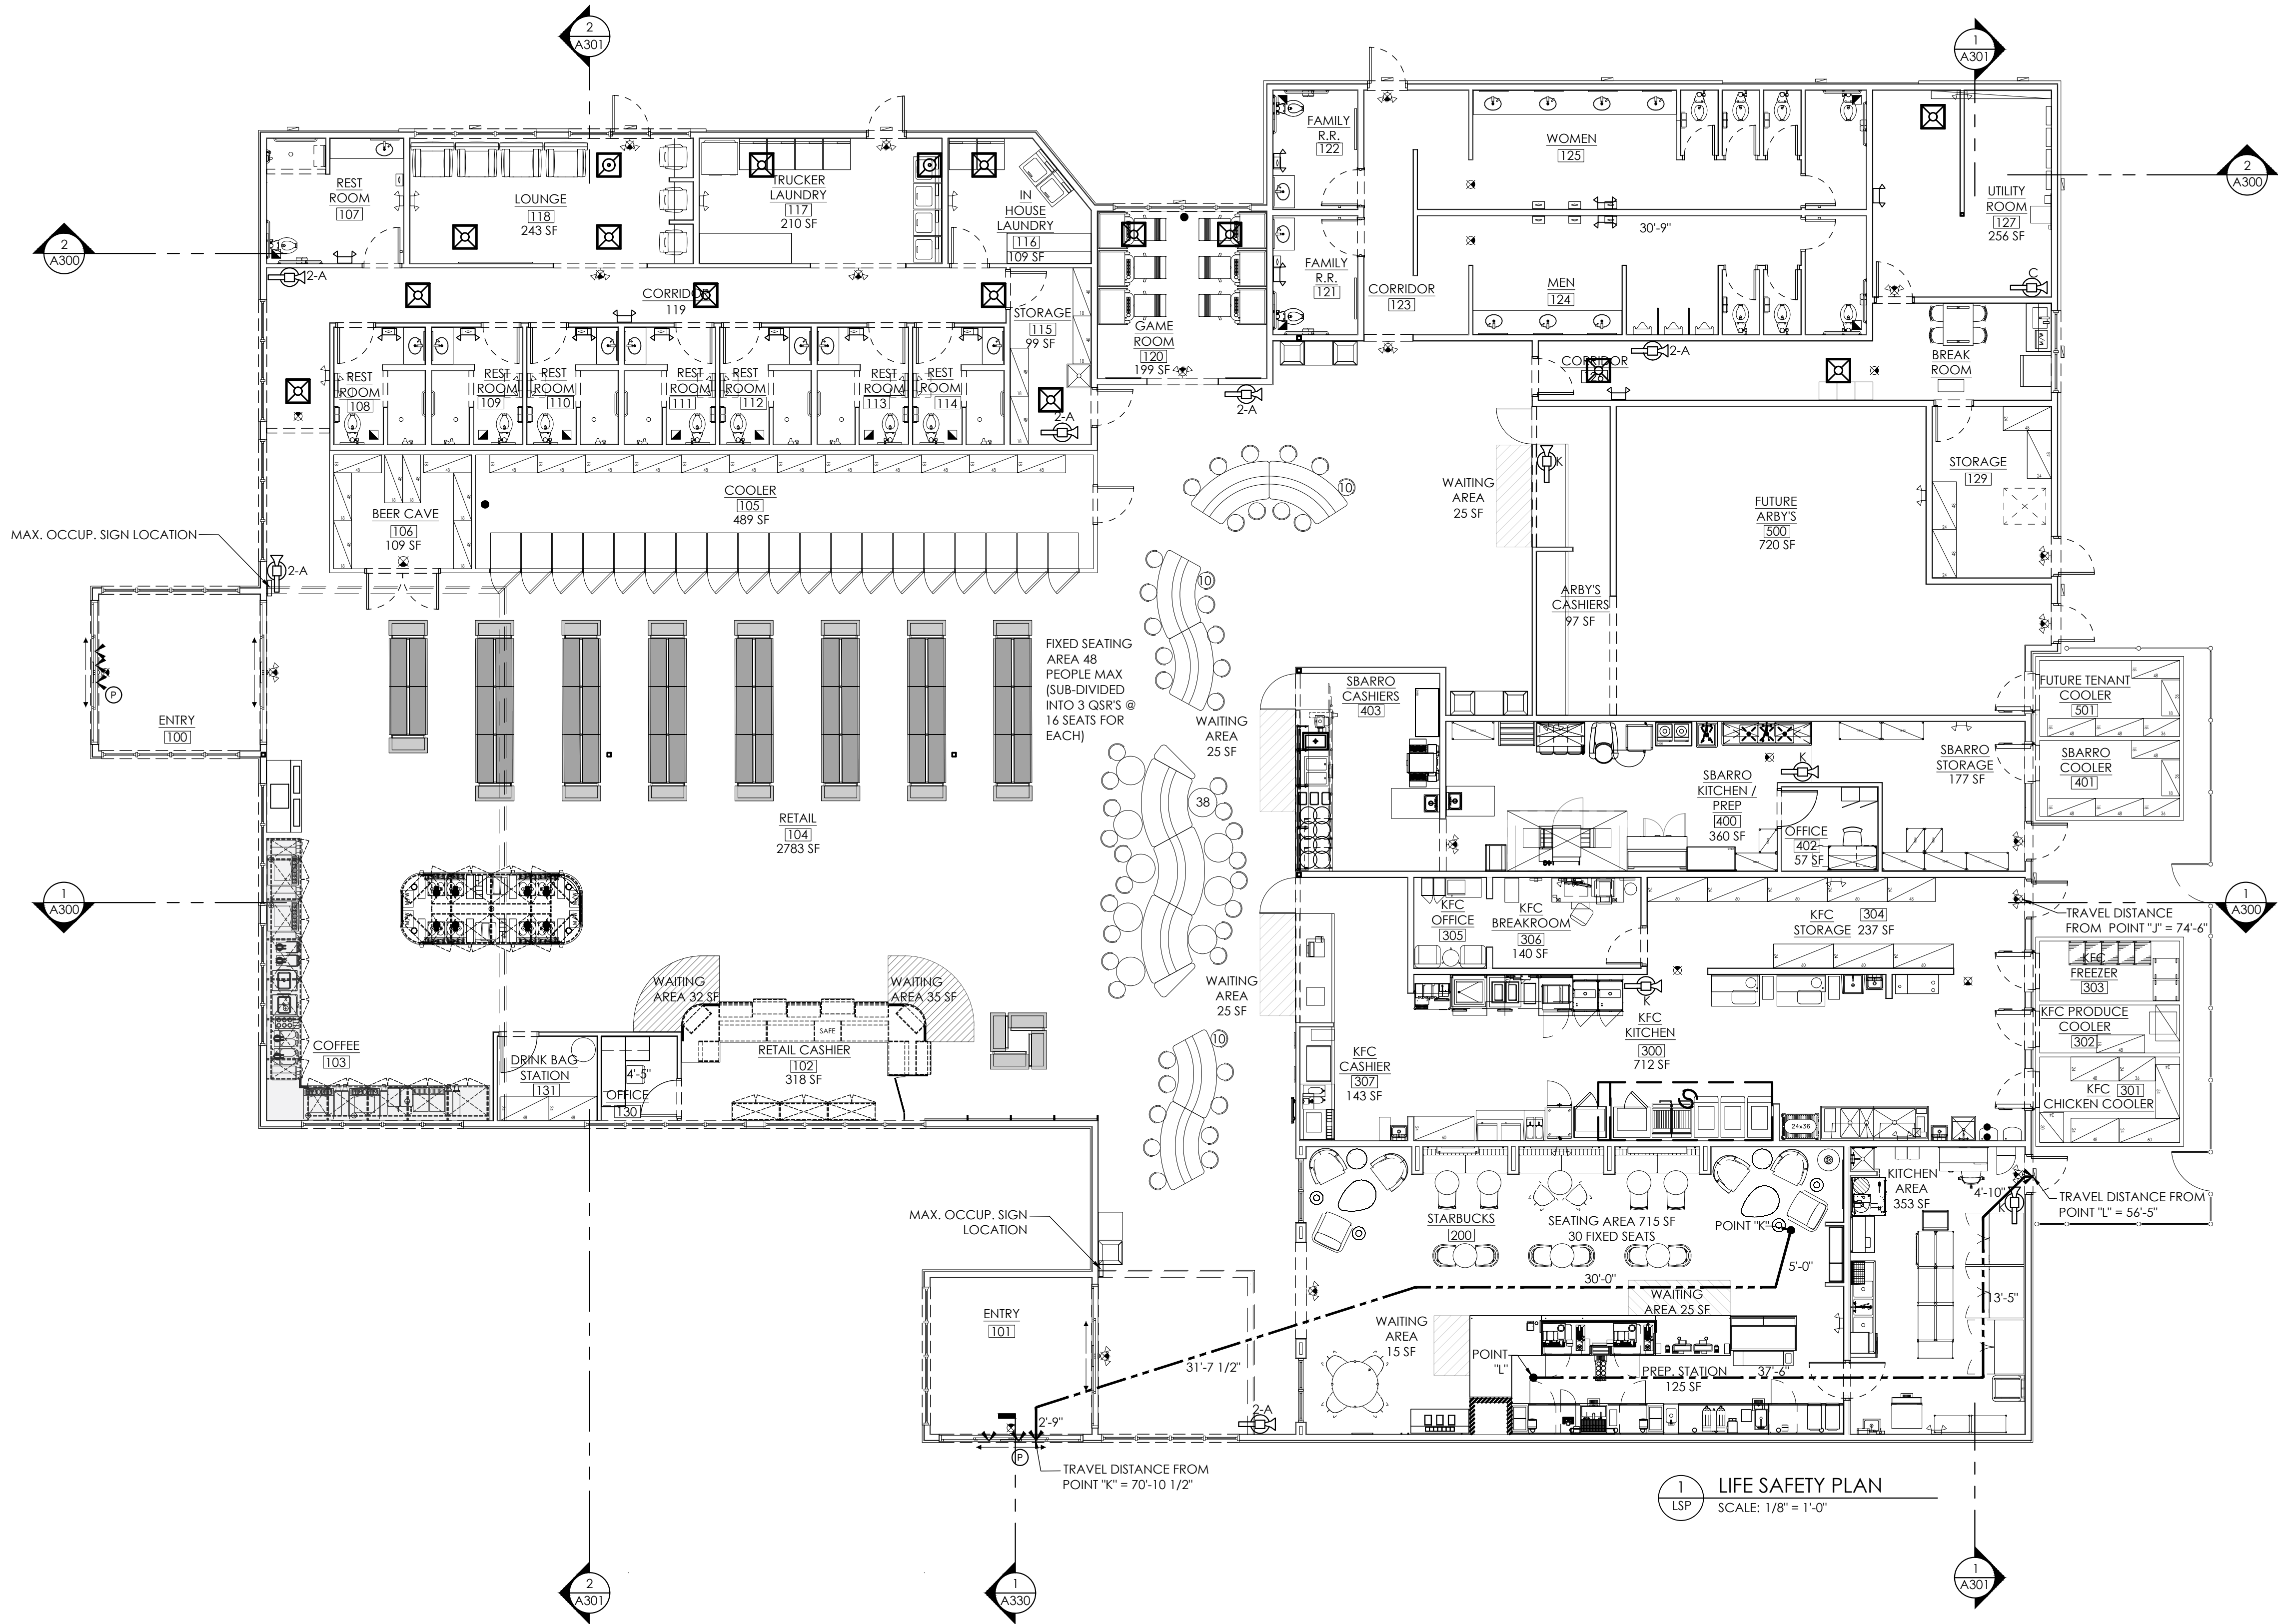

LEGEND	
	EGRESS TRAVEL
	DOORS WITH PANIC HARDWARE
	EMERGENCY LIGHTS
	EXIT LIGHT (WALL MOUNTED)
	EXIT LIGHT (CEILING MOUNTED)
	EXIT LIGHT/EM LIGHT (WALL MOUNTED)

FIRE EXTINGUISHER TYPES	
	CLASS 2-A EXTINGUISHER (PER NFPA 10): FOR CLASS A HAZARDS IN ORDINARY (MODERATE) HAZARD OCCUPANCY, (I) EXTINGUISHER PROVIDES 1,500 S.F. OF PROTECTION IN DINING AREA - DISTANCE TO EXTINGUISHER NOT TO EXCEED 75'-0"
	CLASS C EXTINGUISHER (PER NFPA 10): REQUIRED WHERE ENERGIZED ELECTRICAL EQUIPMENT CAN BE ENCOUNTERED THAT WOULD REQUIRE A NON - CONDUCTING EXTINGUISHING MEDIUM
	CLASS K EXTINGUISHER (PER NFPA 10): PROVIDED FOR HAZARDS WHERE THERE IS A POTENTIAL FOR FIRES INVOLVING COMBUSTIBLE COOKING MEDIA - DISTANCE TO EXTINGUISHER NOT TO EXCEED 30'-0" OF COOKING EQUIPMENT

EXITS	
EXITS WIDTH:	LSC 39.2.3 .2 x 189 = 37.8" REQUIRED (4 x 36") + (5 x 36") + (2 x 88") = 460" PROVIDED (O.K.)
MAXIMUM OCCUPANT LOAD SIGNAGE TO BE PROVIDE "NEAR THE MAIN EXIT OR EXIT ACCESS FROM THE ROOM OR SPACE" AS REQUIRED PER IBC 1004.9 AT ASSEMBLY OCCUPANCIES.	


CODE SUMMARY MIXED OCCUPANCY BUILDING CODE - 2018 IBC OCCUPANT LOAD - (IBC TABLE 1004.1.2)	CONSTRUCTION TYPE: V-B OCCUPANCY TYPE: B - BUSINESS 15,060 SF
OCCUPANCY BREAK DOWN BUSINESS (C-STORE) LOUNGE 243 SF/150 = 2 TRUCKER LAUNDRY 210 SF/150 = 2 GAME ROOM 199 SF/150 = 2 RETAIL 2847 SF/150 = 19 BEER CAVE 109 SF/150 = 1 RETAIL CASHIER 111 SF/150 = 1 PUBLIC TOTAL = 29 IN HOUSE LAUNDRY 109 SF/150 = 1 STORAGE (NEAR TRUCKER SHOWERS) 99 SF/300 = 1 STORAGE (NEAR BREAK ROOM) 167 SF/300 = 1 COOLER 489 SF/300 = 2 BREAK ROOM 372 SF/150 = 3 UTILITY ROOM 256 SF/300 = 1 STANDING AREA (CASHIERS) 67 SF/5 = 14 OFFICE 44 SF/300 = 1 DRINK BACK STATION 58 SF/300 = 1 BACK OF HOUSE TOTAL = 25 KITCHEN 360 SF/100 = 4 CASHIER 155 SF/100 = 2 STANDING AREA 25 SF/5 = 5 STORAGE 177 SF/300 = 1 OFFICE 57 SF/300 = 1 SEATING (FIXED) = 16 BUSINESS (SBARRO'S) TOTAL = 29 KITCHEN 712 SF/100 = 5 CASHIER 143 SF/100 = 2 STANDING AREA 25 SF/5 = 5 STORAGE 237 SF/300 = 1 OFFICE/BREAKROOM 140 SF/300 = 1 SEATING (FIXED) = 16 BUSINESS (KFC) TOTAL = 30 KITCHEN 347 SF/100 = 5 PREP STATION 110 SF/100 = 2 STANDING AREA 40 SF/5 = 8 SEATING (FIXED) = 28 BUSINESS (STARBUCKS) TOTAL = 43 KITCHEN 720 SF/100 = 5 CASHIER 97 SF/100 = 2 STANDING AREA 25 SF/5 = 5 SEATING (FIXED) = 16 BUSINESS (ARBY'S) TOTAL = 28 OVERALL TOTAL = 184	SPRINKLER REQUIREMENTS (IBC TABLE 503) NOT-REQUIRED. TRAVEL DISTANCE (IBC TABLE 1017.2) 200'-0" MAX ALLOWED 146'-6" MAX PROVIDED COMMON PATH OF EGRESS TRAVEL (IFC 1006.2.1) 75'-0" MAX ALLOWED 14'-0" MAX PROVIDED BUSINESS OCCUPANCY NOTE SQUARE FOOTAGE ALLOW 9,000SF SQUARE FOOTAGE W/ FRONTAGE INCREASES 15,750 (506.3.3 [F/P - .25] W/30 = .75 * 1 = .75) (1.75 * 9000 = 15,750) SQUARE FOOTAGE ACTUAL 15,100 (OK)

ARCHITECT OF RECORD:

THOMAS E. MORGAN, JR.
ARCHITECT

423 FISCHER TRAIL
ELLIHAY, GEORGIA 30540

SEAL:

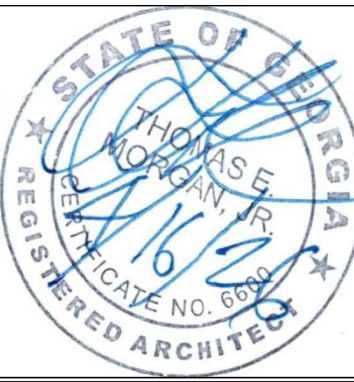

MRP
DESIGN GROUP

3450 Acworth Due West Road
Building 100, Suite 120
Kennesaw, Georgia 30144
P. 770-917-9172
F. 770-917-9470
www.mrpdesign.com

RELEASED FOR
CONSTRUCTION

ISSUES / REVISIONS:

DATE	DESCRIPTION
05.04.26	RELEASE FOR CONSTRUCTION

DRAWN BY: JB
CHKD BY: TM

PROJECT DESCRIPTION:

NEW CONSTRUCTION OF A TA TRAVEL CENTER IN JEFFERSONVILLE, GA, WHICH CONSISTS OF A TRUCKER ROOM, RETAIL AREA, RESTROOMS, GAME AREA, SEATING AREAS, AND FOUR QUICK-SERVICE RESTAURANTS. THE MAJORITY OF THE PROJECT HAS ALREADY BEEN SUBMITTED. THIS ISSUE, DATED 05.04.26 HAS MODIFICATIONS RELATED TO THE ADDITION OF THE STARBUCKS QSR.

PROJECT TITLE:

TRAVEL CENTER
4838 SR 96
JEFFERSONVILLE,
GEORGIA 31044


SHEET TITLE:

LIFE SAFETY
PLAN


PROJECT NO: 25021

LSP

THESE PLANS ARE THE PROPERTY OF MRP DESIGN GROUP, INC. AND ARE SUBJECT TO FEDERAL COPYRIGHT LAWS. ANY USE OF SAME WITHOUT THE EXPRESS WRITTEN PERMISSION OF MRP DESIGN GROUP, INC. IS STRICTLY PROHIBITED.

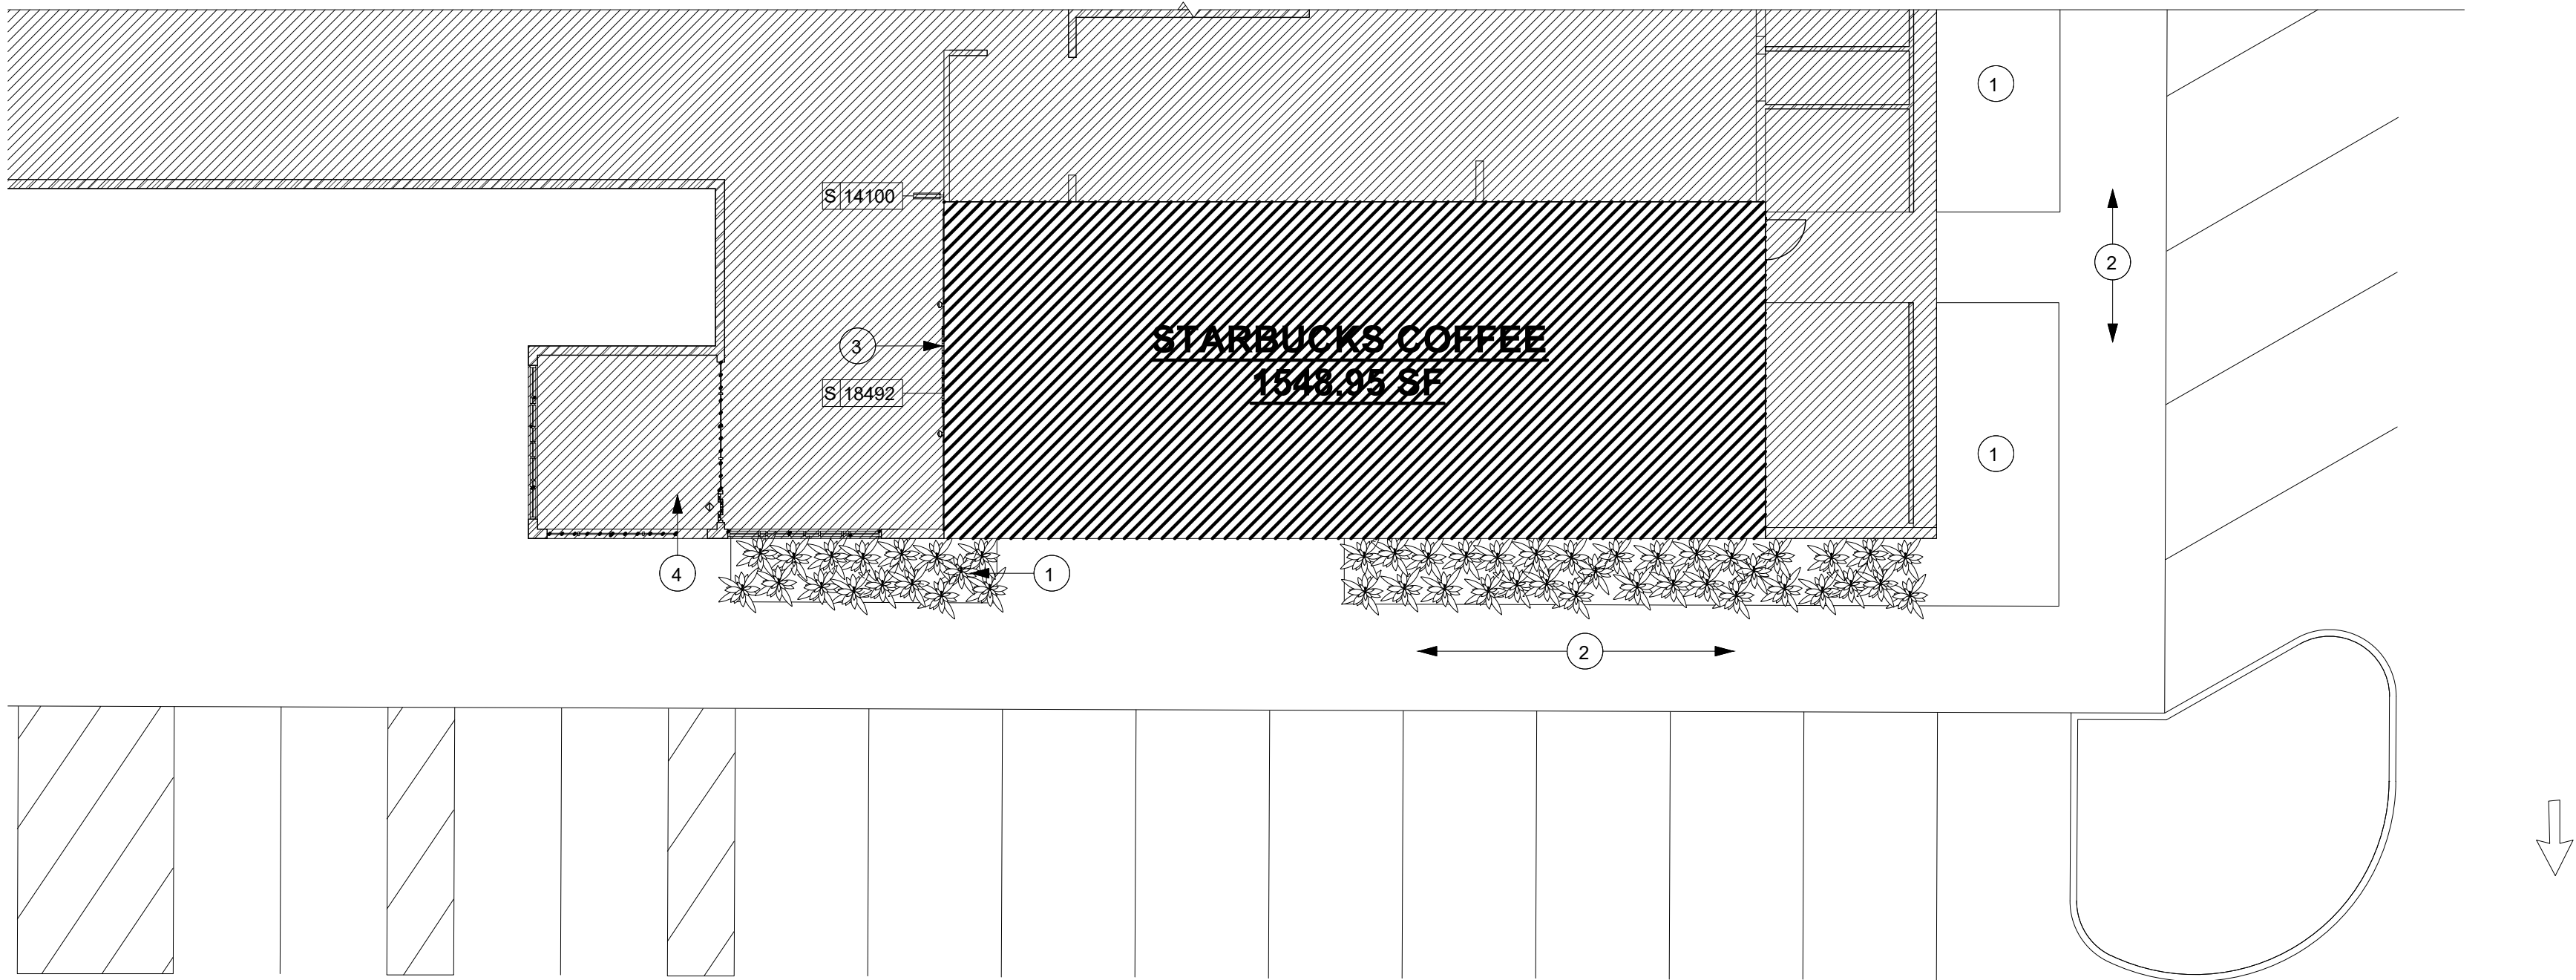

 01 ARCHITECTURAL SITE PLAN
Scale: 3/32" = 1'-0"



SIGNAGE SCHEDULE - "S"					
DESIGN ID	COUNT	DESCRIPTION	FURN. BY	INST. BY	COMMENTS
SIGNAGE - DISK					
14100	1	SIGN - DISK BLADE ILLUMINATED WALL MOUNTED EVOLVED - 24IN 610MM	SB	SB	EXTERIOR, GC TO COORDINATE WITH SB VENDOR.
SIGNAGE - WORDMARK					
18492	1	SIGN - WORDMARK STARBUCKS FLUSH MOUNTED - 8IN 205MM	SB	SB	EXTERIOR, WHITE LETTERS, GC TO COORDINATE WITH SB VENDOR.

LEGEND

- AREA OUT OF SCOPE, NIC.
- STARBUCKS AREA

LICENSED STORES RESPONSIBILITY LEGEND

- SB - STARBUCKS
- FC - STARBUCKS FIXTURE CONTRACTOR
- LC - LICENSEE
- GC - LICENSEE'S GENERAL CONTRACTOR
- 3PV - STARBUCKS THIRD - PARTY VENDOR

KEYED NOTES

- LANDSCAPE AREA.
- ACCESSIBLE PATH OF TRAVEL TO PUBLIC WAY.
- MAIN ENTRANCE OF THE STORE.
- MAIN ENTRANCE OF THE BUILDING.

GENERAL NOTES


- REFER TO EXTERIOR ELEVATIONS ON SHEET A201 FOR BUILDING SIGNAGE LOCATIONS AND DESIGN ID. REFER TO ELECTRICAL PLANS FOR ELECTRICAL REQUIREMENTS.
- GENERAL CONTRACTOR TO APPLY CONCRETE SEALER TO ALL EXTERIOR CONCRETE PATIO AND WALKWAY SURFACES.
- GENERAL CONTRACTOR TO VERIFY ALL EXISTING ELEVATIONS AND BUILDING CONDITIONS IN FIELD PRIOR TO START OF CONSTRUCTION.

ARCHITECT OF RECORD:

THOMAS E. MORGAN, JR.
ARCHITECT

423 FISCHER TRAIL
ELLIJAY, GEORGIA 30540

SEAL:

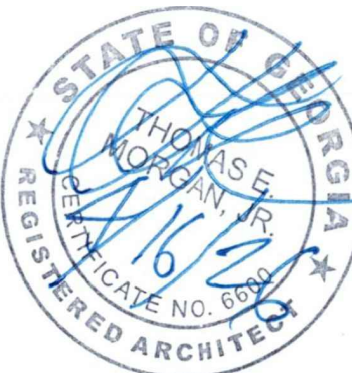

MRP
DESIGN GROUP

3450 Acworth Due West Road
Building 100, Suite 120
Kennesaw, Georgia 30144
P. 770-917-9172
F. 770-917-9470
www.mrpdesign.com

RELEASED FOR
CONSTRUCTION

ISSUES / REVISIONS:

DATE	DESCRIPTION
05.04.26	RELEASE FOR CONSTRUCTION

DRAWN BY: JB

CHKD BY: TM

PROJECT DESCRIPTION:

NEW CONSTRUCTION OF A TA TRAVEL CENTER IN JEFFERSONVILLE, GA, WHICH CONSISTS OF A TRUCKER LOUNGE, SHOWERS, LAUNDRY ROOM, RETAIL AREA, RESTROOMS, GAME AREA, SEATING AREAS, AND FOUR QUICK-SERVICE RESTAURANTS. THE MAJORITY OF THE PROJECT HAS ALREADY BEEN SUBMITTED. THIS ISSUE, DATED 05.04.26 HAS MODIFICATIONS RELATED TO THE ADDITION OF THE STARBUCKS QSR.

PROJECT TITLE:

TRAVEL CENTER
4838 SR 96
JEFFERSONVILLE,
GEORGIA 31044

SHEET TITLE:

ARCHITECTURAL
SITE PLAN

PROJECT NO: 25021

A001

THESE PLANS ARE THE PROPERTY OF MRP DESIGN GROUP, INC. AND ARE SUBJECT TO FEDERAL COPYRIGHT LAWS. ANY USE OF SAME WITHOUT THE EXPRESS WRITTEN PERMISSION OF MRP DESIGN GROUP, INC. IS STRICTLY PROHIBITED

DOOR SCHEDULE - "D"							
DESIGN ID	MARK	DESCRIPTION	WIDTH	HEIGHT	FURN BY	INST BY	COMMENTS
Exterior							
21146	1	DOOR - SINGLE SERVICE- 36IN 915MM	3' - 0"	7' - 0"	GC	GC	FINISH TO MATCH SLATE GREY LAMINATE FINISH - D91 BY WILSONART. STARBUCKS DM TO APPROVE ALL DOOR FINISHES.
1							
Interior							
10190	2	DOOR - SINGLE FLUSH DOUBLE ACTING - 36IN 915MM	3' - 0"	7' - 0"	GC	GC	FINISH TO MATCH SLATE GREY LAMINATE FINISH - D91 BY WILSONART. STARBUCKS DM TO APPROVE ALL DOOR FINISHES.
1							

1 EXISTING WALL

2 NEW PARTITION WALL TO 6" (152MM) ABOVE CEILING

20 GA 3-5/8" (86 MM) METAL STUDS 16" (406MM) O.C. WITH 5/8" (16 MM) TYPE "X" GWB ON ONE OR BOTH SIDES TO MINIMUM OF 6" (152 MM) ABOVE CEILING GRID. DRYWALL SCREWS @ 12" (305 MM) O.C., 45 DEGREES. METAL STUD REINFORCEMENT @ 48" (1219 MM) O.C. ABOVE CEILING LINE TO STRUCTURE ABOVE.

3 NEW CURTAIN WALL, MATCH EXISTING

AOR TO SPECIFY MINIMUM REQUIREMENTS AND GC TO COORDINATE WITH LICENSEE PRIOR INSTALLATION.



4 NEW PLUMBING WALL 6" (152MM) ABOVE CEILING

20 GA 6" (152 MM) METAL STUDS 16" (406 MM) O.C. WITH 5/8" (16 MM) MOISTURE RESISTANT GYPSUM BOARD ON ONE OR BOTH SIDES TO MINIMUM 6" (152 MM) ABOVE CEILING. SECURE MOISTURE RESISTANT GYPSUM BOARD TO STUDS WITH DRYWALL SCREWS AT 10" (254 MM) O.C. AT PANEL EDGES AND 12" (305 MM) O.C. AT INTERMEDIATE SUPPORTS. 45 DEGREE METAL STUD REINFORCEMENT @ 48" (1219 MM) O.C. ABOVE CEILING LINE TO STRUCTURE ABOVE.

5 NEW PARTIAL HEIGHT WALL TO 5' - 0" AFF

20 GA 3-5/8" (86 MM) METAL STUDS 16" (406 MM) O.C. WITH 5/8" (16 MM) TYPE "X" MOISTURE RESISTANT GWB ON BOTH SIDES TO SPECIFIED HEIGHT. DRYWALL SCREWS @ 12" (305 MM) O.C.

DOOR LEGEND

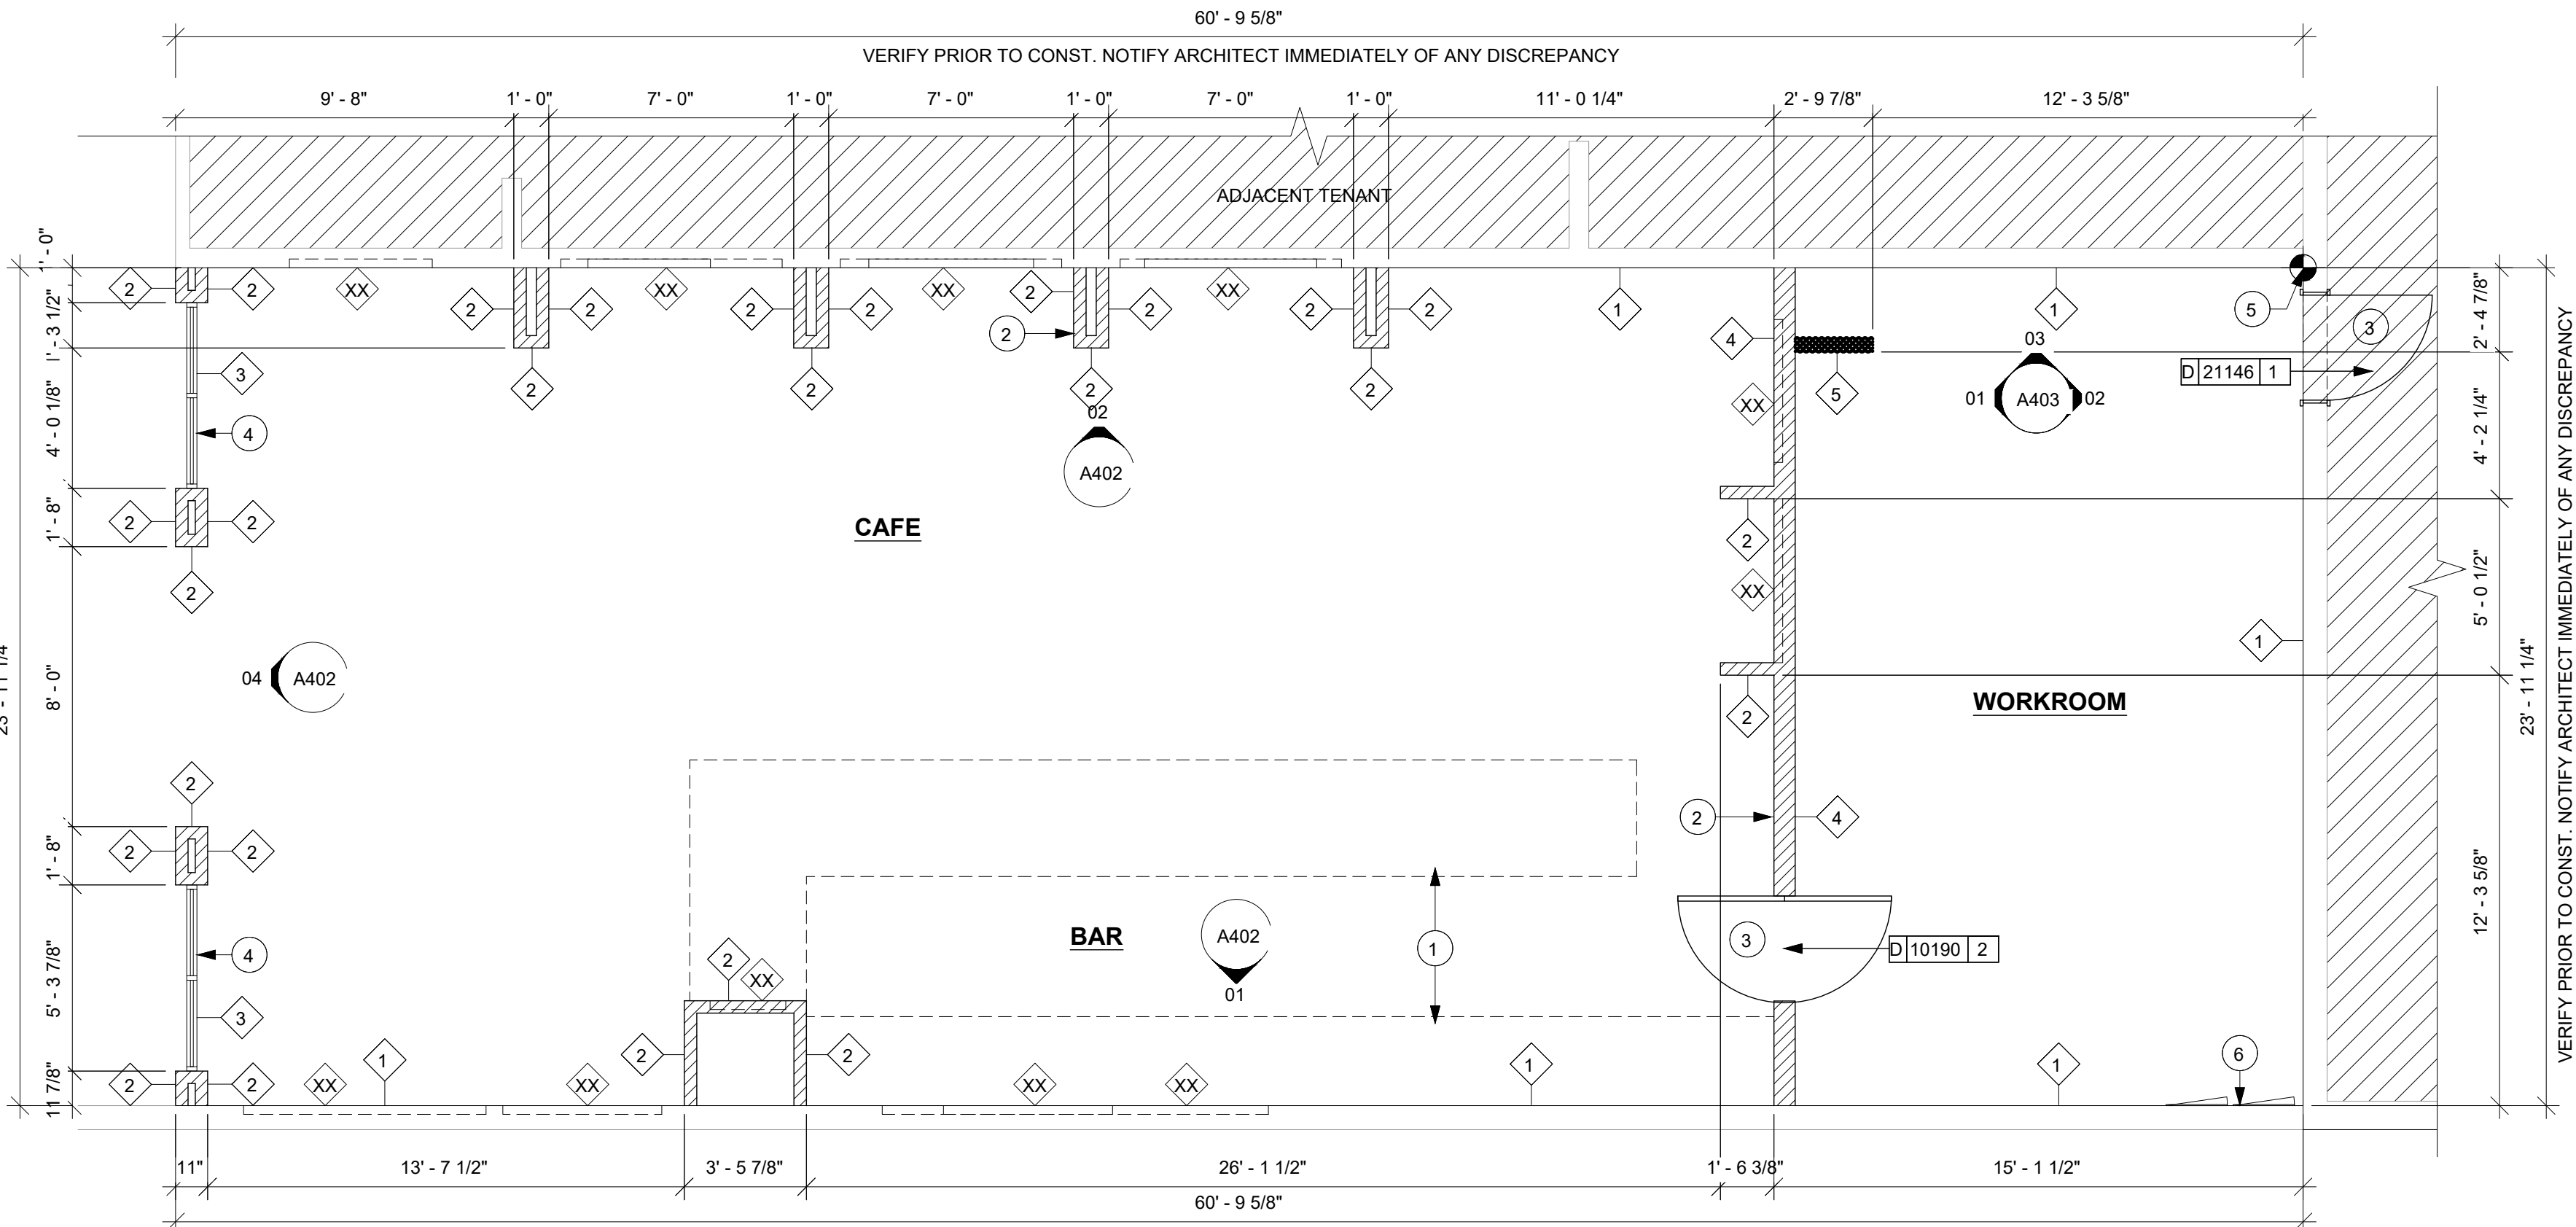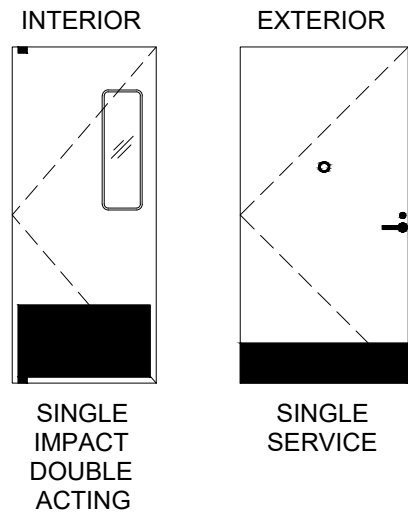

01 BUILDING FLOOR PLAN
Scale: 1/4" = 1'-0"

KEYED NOTES

- OUTLINE OF BAR PER CASEWORK MANUFACTURER.
- INSTALL NEW WALLS AS INDICATED.
- INSTALL NEW DOOR AS INDICATED. REFER TO DOOR SCHEDULE FOR ADDITIONAL INFORMATION.
- STOREFRONT, CURTAIN WALL AND DOOR FINISH BY LICENSEE.
- DATUM POINT REFERENCE FOR NEW WALL LOCATION.
- ELECTRICAL PANEL LOCATION. MAINTAIN MINIMUM CLEARANCE AS REQUIRED BY CODE.

GENERAL NOTES

- GENERAL CONTRACTOR TO VERIFY ALL DIMENSIONS AND NOTIFY ARCHITECT OF RECORD AND STARBUCKS DEVELOPMENT MANAGER OF ANY DISCREPANCIES PRIOR TO CONSTRUCTION. ALL DIMENSIONS TO BE TAKEN FROM DESIGNATED DATUM POINT.
- GENERAL CONTRACTOR TO PROVIDE FIRE TREATED WOOD STUD BLOCKING, OR EQUIVALENT, TO SUPPORT ANY WALL ATTACHMENT AND/OR SIGNAGE.
- ALL DIMENSIONS ARE TO FINISHED FACE UNLESS SHOWN OR NOTED OTHERWISE.
- INSTALL MOISTURE RESISTANT BACKBAR WALL BOARD PER PROJECT MANUAL.
- ALL DOORS SHALL BE 32" (815MM) MINIMUM CLEAR OPENING WHEN OPENED TO 90 DEGREE POSITION UNLESS NOTED OTHERWISE.
- ARCHITECT OF RECORD TO SPECIFY ALL DOOR HARDWARE COMPONENTS. GENERAL CONTRACTOR TO FURNISH AND INSTALL.
- ARCHITECT OF RECORD TO VERIFY ALL EXISTING DOORS, HARDWARE, AND FRAMES MEET STARBUCKS AND/OR CODE REQUIREMENTS.
- ARCHITECT OF RECORD TO VERIFY ALL WALL TYPES.
- GENERAL CONTRACTOR TO FURNISH AND INSTALL NEW STUD FURRING AND GWB AS REQUIRED. ARCHITECT OF RECORD TO VERIFY AND COORDINATE FOR REQUIRED FIRE RATINGS AND SOUND INSULATION CRITERIA.
- EGRESS SHALL NOT PASS THROUGH KITCHENS, STORAGE ROOMS, CLOSETS, OR SIMILAR SPACES.
- REFER TO SHEET I105 FOR FLOOR FINISHES

LEGEND

- NEW FULL HEIGHT WALL
- NEW PARTIAL HEIGHT WALL
- EXISTING WALL
- EXISTING COLUMN
- WALL BLOCKING CALL OUT
- AREA OUT OF SCOPE, NIC.
- DATUM POINT
- WALL TYPE

LICENSED STORES RESPONSIBILITY LEGEND

- SB - STARBUCKS
- FC - STARBUCKS FIXTURE CONTRACTOR
- LC - LICENSEE
- GC - LICENSEE'S GENERAL CONTRACTOR
- 3PV - STARBUCKS THIRD - PARTY VENDOR


GENERAL CONTRACTOR TO
FIELD VERIFY ALL DIMENSIONS
AND COORDINATE AS
NECESSARY WITH ARCHITECT
OF RECORD

ARCHITECT OF RECORD:

THOMAS E. MORGAN, JR.
ARCHITECT

423 FISCHER TRAIL
ELLIJAY, GEORGIA 30540

SEAL:

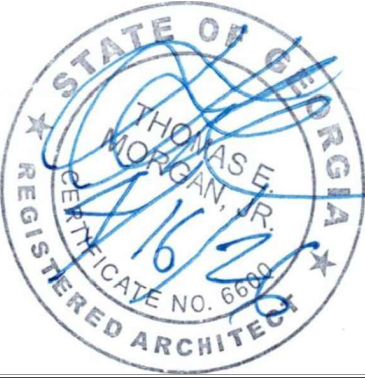

MRP
DESIGN GROUP

3450 Acworth Due West Road
Building 100, Suite 120
Kennesaw, Georgia 30144
P: 770-917-9172
F: 770-917-9470
www.mrpdesign.com

RELEASED FOR CONSTRUCTION

ISSUES / REVISIONS:

DATE	DESCRIPTION
05.04.26	RELEASE FOR CONSTRUCTION

DRAWN BY: JB

CHKD BY: TM

PROJECT DESCRIPTION:

NEW CONSTRUCTION OF A TA TRAVEL CENTER IN JEFFERSONVILLE, GA, WHICH CONSISTS OF A TRUCKER LOUNGE, SHOWERS, LAUNDRY ROOM, RETAIL AREA, RESTROOMS, GAME AREA, SEATING AREAS, AND FOUR QUICK-SERVICE RESTAURANTS. THE MAJORITY OF THE PROJECT HAS ALREADY BEEN SUBMITTED. THIS ISSUE, DATED 05.04.26 HAS MODIFICATIONS RELATED TO THE ADDITION OF THE STARBUCKS QSR.

PROJECT TITLE:

TRAVEL CENTER
4838 SR 96
JEFFERSONVILLE,
GEORGIA 31044


SHEET TITLE:

BUILDING
FLOOR PLAN
& DOOR
SCHEDULE


PROJECT NO: 25021

A101


THESE PLANS ARE THE PROPERTY OF MRP DESIGN GROUP, INC. AND ARE SUBJECT TO FEDERAL COPYRIGHT LAWS. ANY USE OF SAME WITHOUT THE EXPRESS WRITTEN PERMISSION OF MRP DESIGN GROUP, INC. IS STRICTLY PROHIBITED.

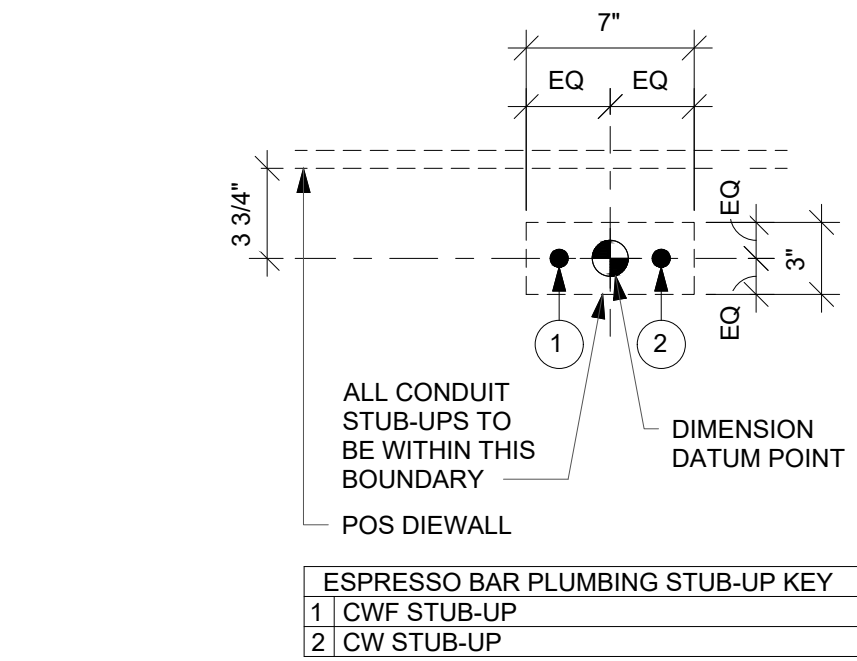


01 PLUMBING STUB-UPS AT ESPRESSO BAR
Scale: 1 1/2" = 1'-0"

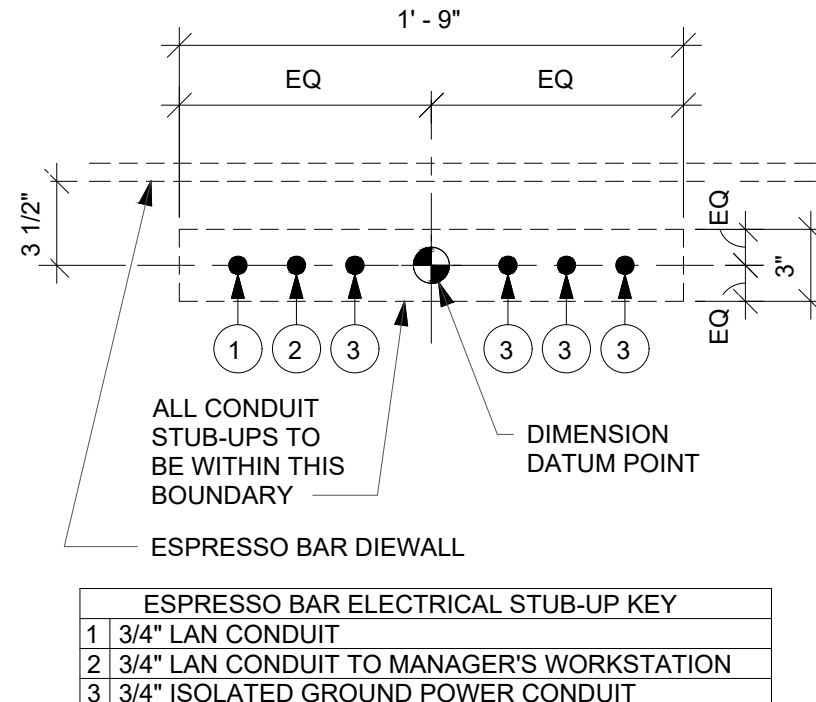


02 ELECTRICAL STUB-UPS AT ESPRESSO BAR
Scale: 1 1/2" = 1'-0"

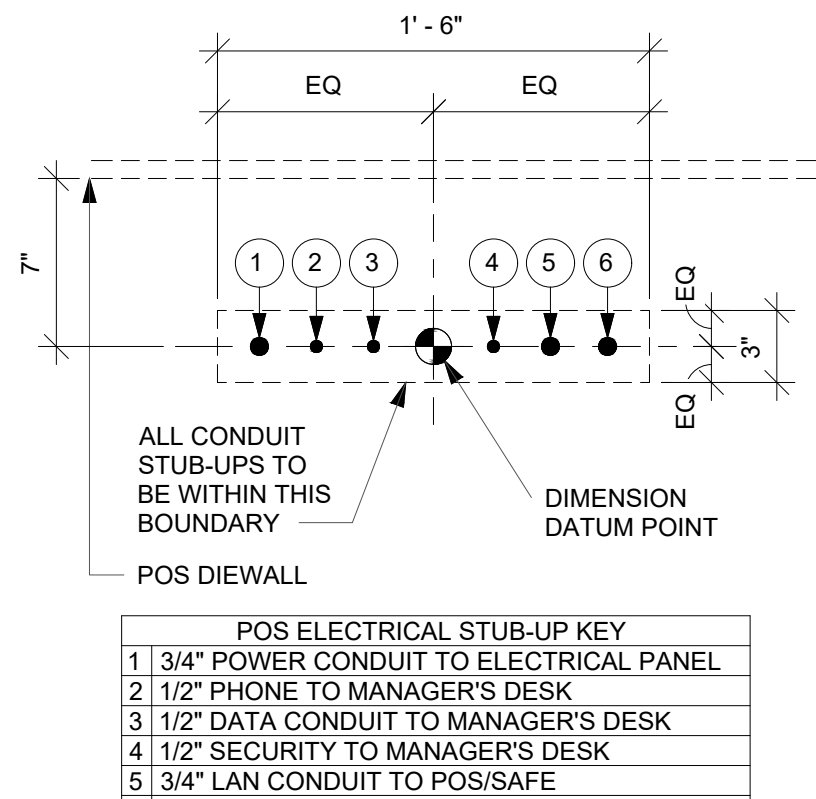



03 ELECTRICAL STUB-UPS AT POS
Scale: 1 1/2" = 1'-0"

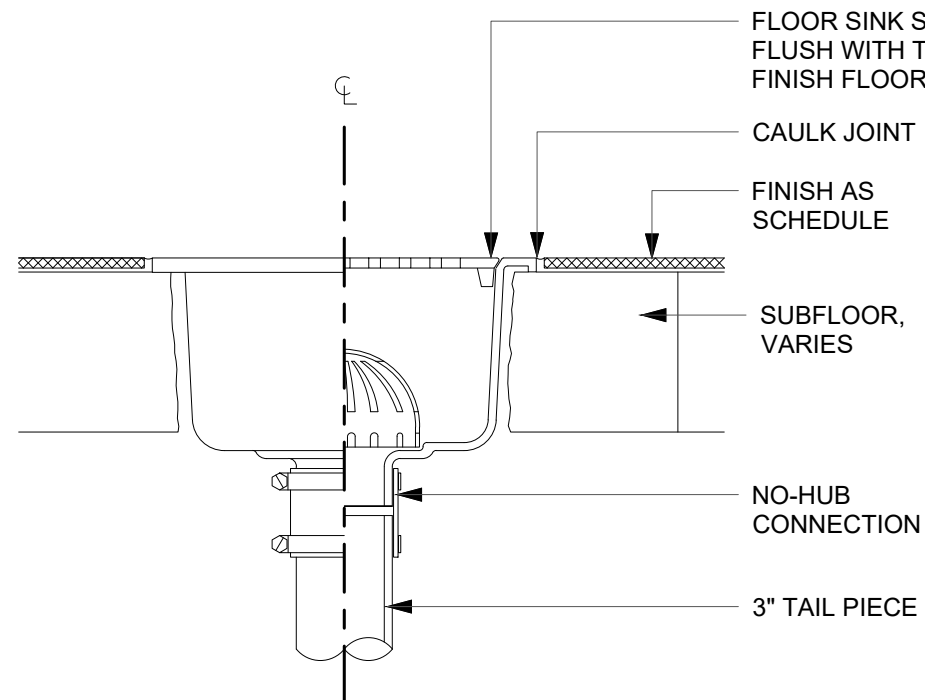

04 FLOOR SINK SECTION
Scale: 3" = 1'-0"

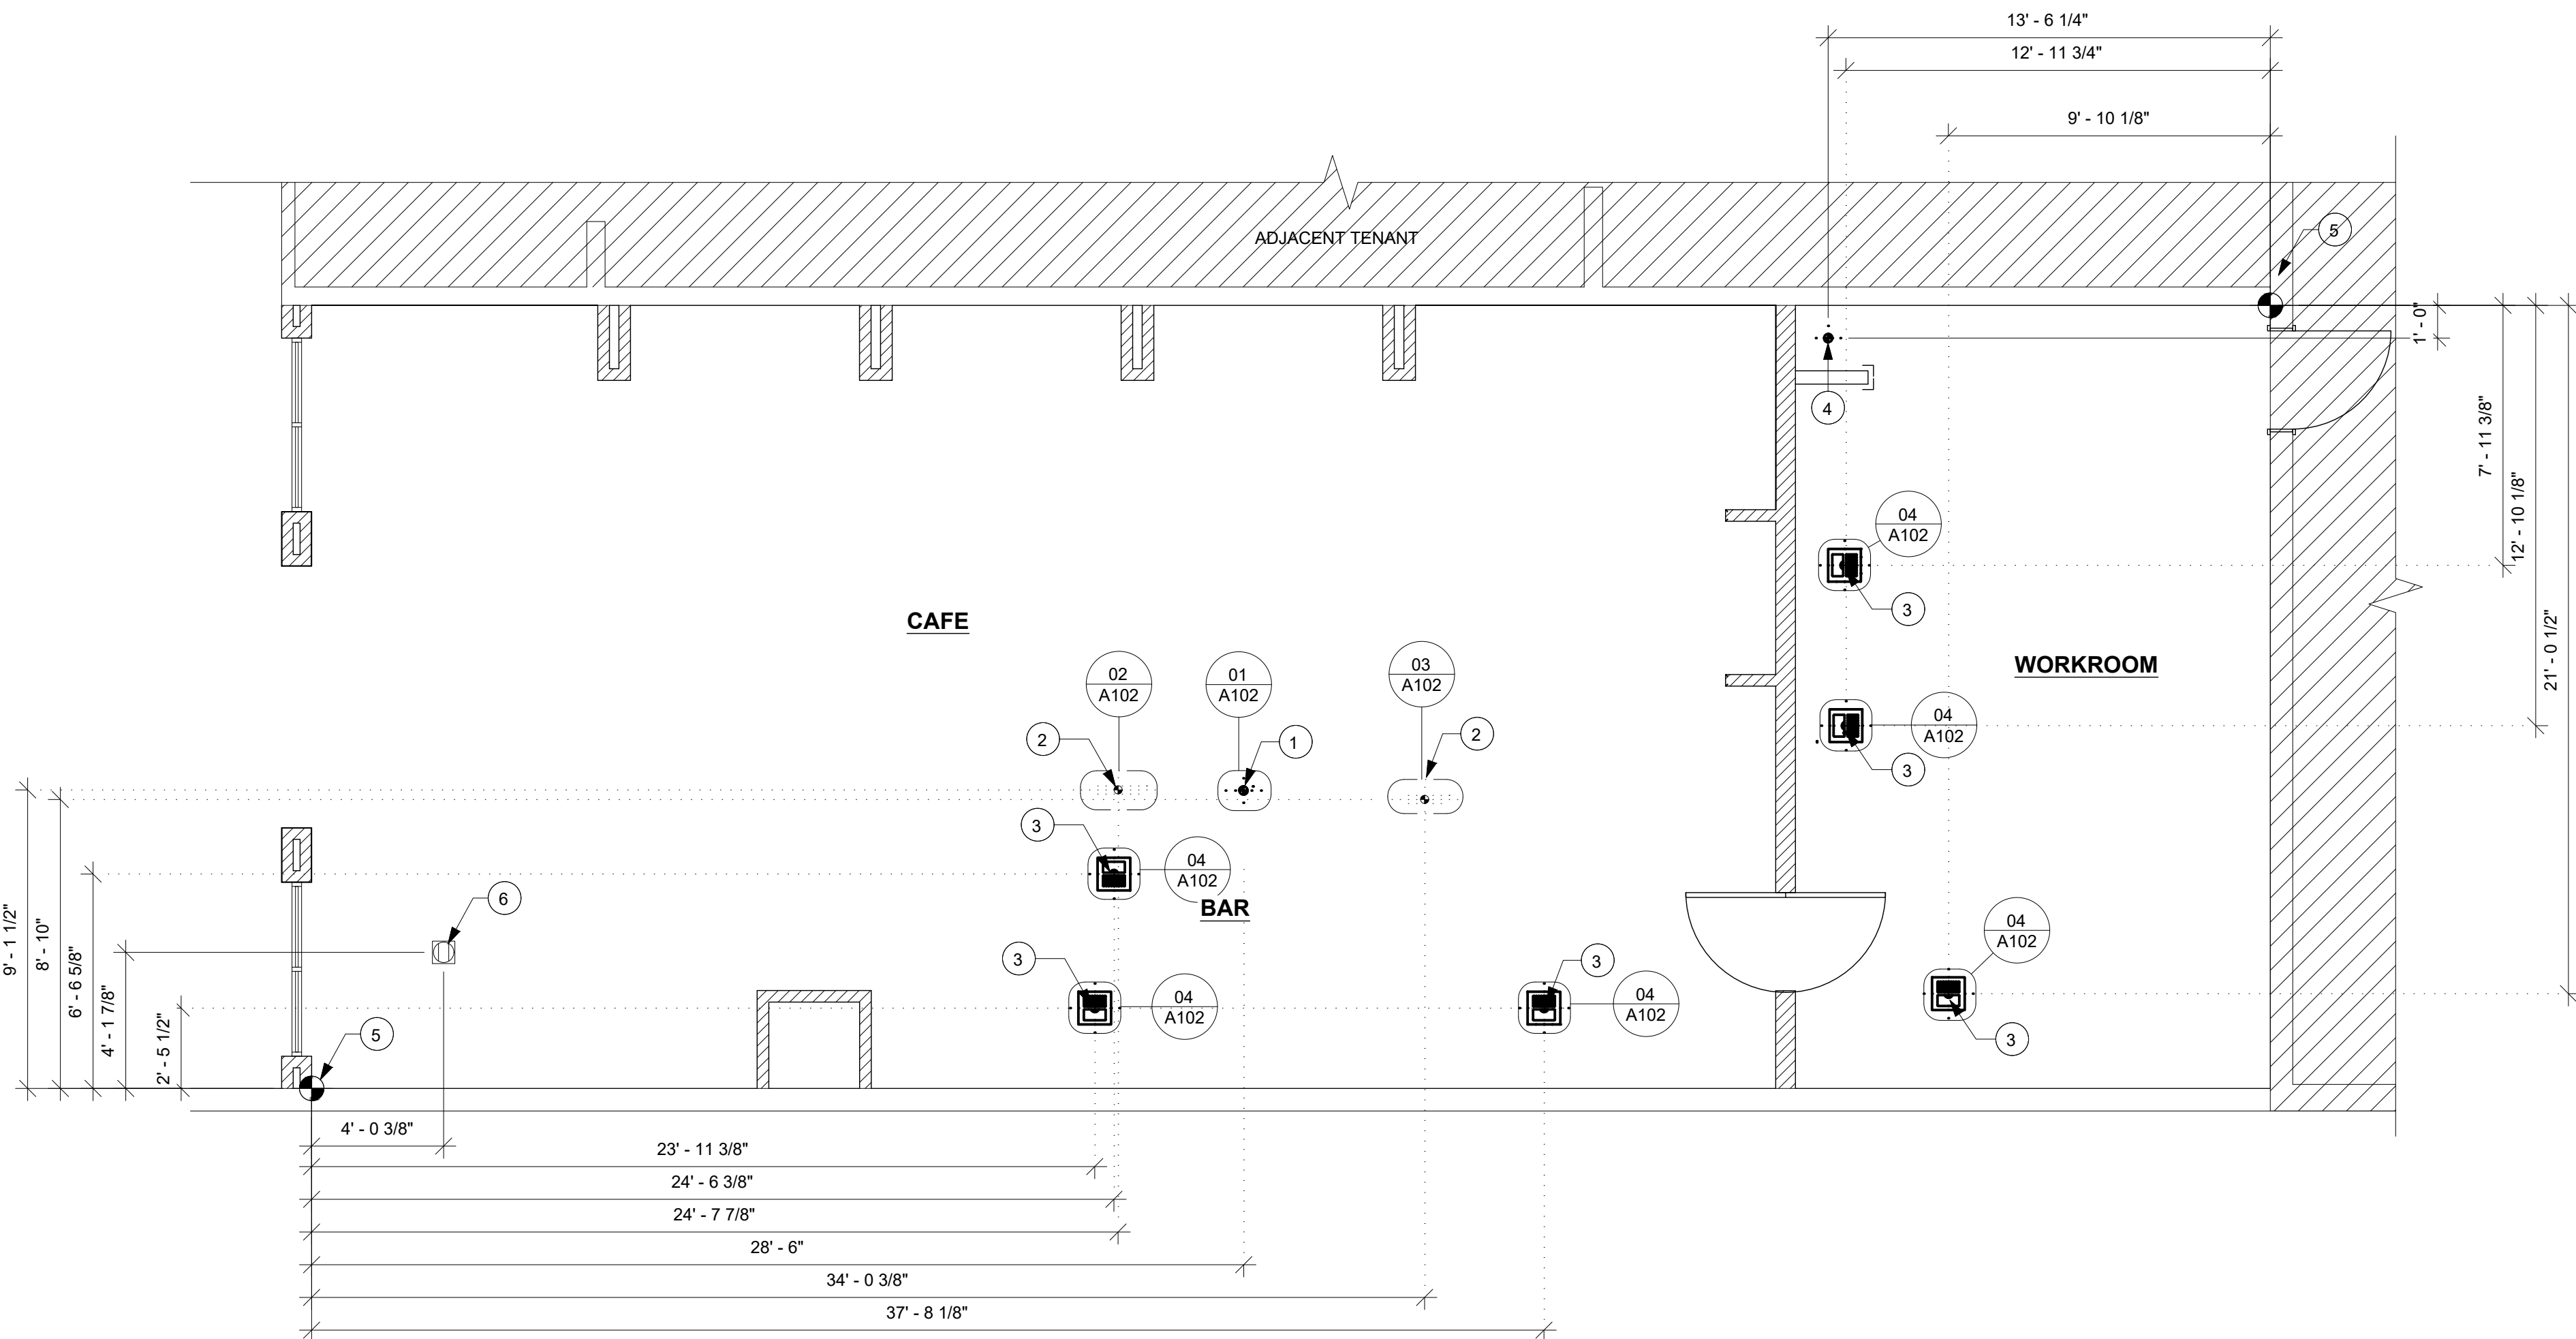

 05 BUILDING FLOOR PENETRATION PLAN
Scale: 1/4" = 1'-0"

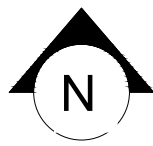

GENERAL NOTES

- GENERAL CONTRACTOR TO FIELD VERIFY ALL DIMENSIONS AND NOTIFY ARCHITECT OF RECORD AND STARBUCKS PROJECT DEVELOPMENT MANAGER OF ANY KNOWN DISCREPANCIES PRIOR TO CONSTRUCTION.
- ALL STUB-UP DIMENSIONS ARE RELATIVE TO FINISHED WALL LOCATIONS (SHOWN AS OUTLINES ON THIS PLAN). REFER TO BUILDING FLOOR PLAN FOR WALL PLACEMENT.
- GENERAL CONTRACTOR TO COORDINATE WITH SPECIFIC TRADES AND SITE CONDITIONS TO DETERMINE ACTUAL TRENCHING LAYOUT AS REQUIRED.
- REFER TO SHEET I106 FOR FLOOR FINISHES.

KEYED NOTES

- PLUMBING STUB-UP LOCATION. REFER TO PLUMBING PLAN AND DETAILS FOR MORE INFORMATION.
- ELECTRICAL STUB-UP LOCATION. REFER TO ELECTRICAL PLAN AND DETAILS FOR MORE INFORMATION.
- FLOOR SINK LOCATION. REFER TO PLUMBING PLAN AND DETAILS FOR MORE INFORMATION.
- MOP SINK DRAIN LOCATION. REFER TO PLUMBING PLAN AND DETAILS FOR MORE INFORMATION. WATER FILTRATION CABINET HOSE TO BE CONNECTED TO THIS DRAINAGE.
- DATUM INDICATES DIMENSION START POINT.
- ELECTRICAL FLOOR DUPLEX LOCATED IN RETAIL AREA. REFER TO ELECTRICAL PLAN AND DETAILS FOR MORE INFORMATION.

PENETRATION SYMBOL LEGEND


- | | |
|--|-----------------------------|
| | FLOOR SINK |
| | FLOOR PENETRATION |
| | PLUMBING PENETRATION AREA |
| | ELECTRICAL PENETRATION AREA |
| | DATUM POINT |
| | AREA OUT OF SCOPE, NIC. |

ARCHITECT OF RECORD:

THOMAS E. MORGAN, JR.
ARCHITECT

423 FISCHER TRAIL
ELLIJAY, GEORGIA 30540

SEAL:

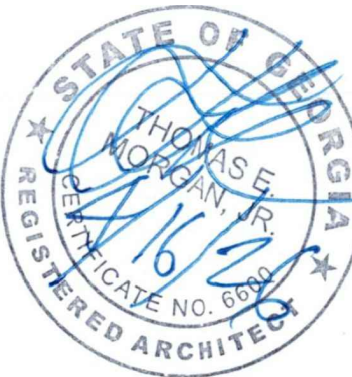

MRP
DESIGN GROUP

3450 Acworth Due West Road
Building 100, Suite 120
Kennesaw, Georgia 30144
P. 770-917-9172
F. 770-917-9470
www.mrpdesign.com

RELEASED FOR CONSTRUCTION

ISSUES / REVISIONS:

DATE	DESCRIPTION
05.04.26	RELEASE FOR CONSTRUCTION

DRAWN BY: JB

CHKD BY: TM

PROJECT DESCRIPTION:

NEW CONSTRUCTION OF A TA TRAVEL CENTER IN JEFFERSONVILLE, GA, WHICH CONSISTS OF A TRUCKER LOUNGE, SHOWERS, LAUNDRY ROOM, RETAIL AREA, RESTROOMS, GAME AREA, SEATING AREAS, AND FOUR QUICK-SERVICE RESTAURANTS. THE MAJORITY OF THE PROJECT HAS ALREADY BEEN SUBMITTED. THIS ISSUE, DATED 05.04.26 HAS MODIFICATIONS RELATED TO THE ADDITION OF THE STARBUCKS QSR.

PROJECT TITLE:

TRAVEL CENTER
4838 SR 96
JEFFERSONVILLE,
GEORGIA 31044

SHEET TITLE:


BUILDING
FLOOR
PENETRATION
PLAN

PROJECT NO: 25021


A102

THESE PLANS ARE THE PROPERTY OF MRP DESIGN GROUP, INC. AND ARE SUBJECT TO FEDERAL COPYRIGHT LAWS. ANY USE OF SAME WITHOUT THE EXPRESS WRITTEN PERMISSION OF MRP DESIGN GROUP, INC. IS STRICTLY PROHIBITED.


SIGNAGE SCHEDULE - "S"					
DESIGN ID	COUNT	DESCRIPTION	FURN. BY	INST. BY	COMMENTS
SIGNAGE - DISK					
14100	1	SIGN - DISK BLADE ILLUMINATED WALL MOUNTED EVOLVED - 24IN 610MM	SB	SB	EXTERIOR. GC TO COORDINATE WITH SB VENDOR.
SIGNAGE - WORDMARK					
18492	1	SIGN - WORDMARK STARBUCKS FLUSH MOUNTED - 8IN 205MM	SB	SB	EXTERIOR, WHITE LETTERS. GC TO COORDINATE WITH SB VENDOR.

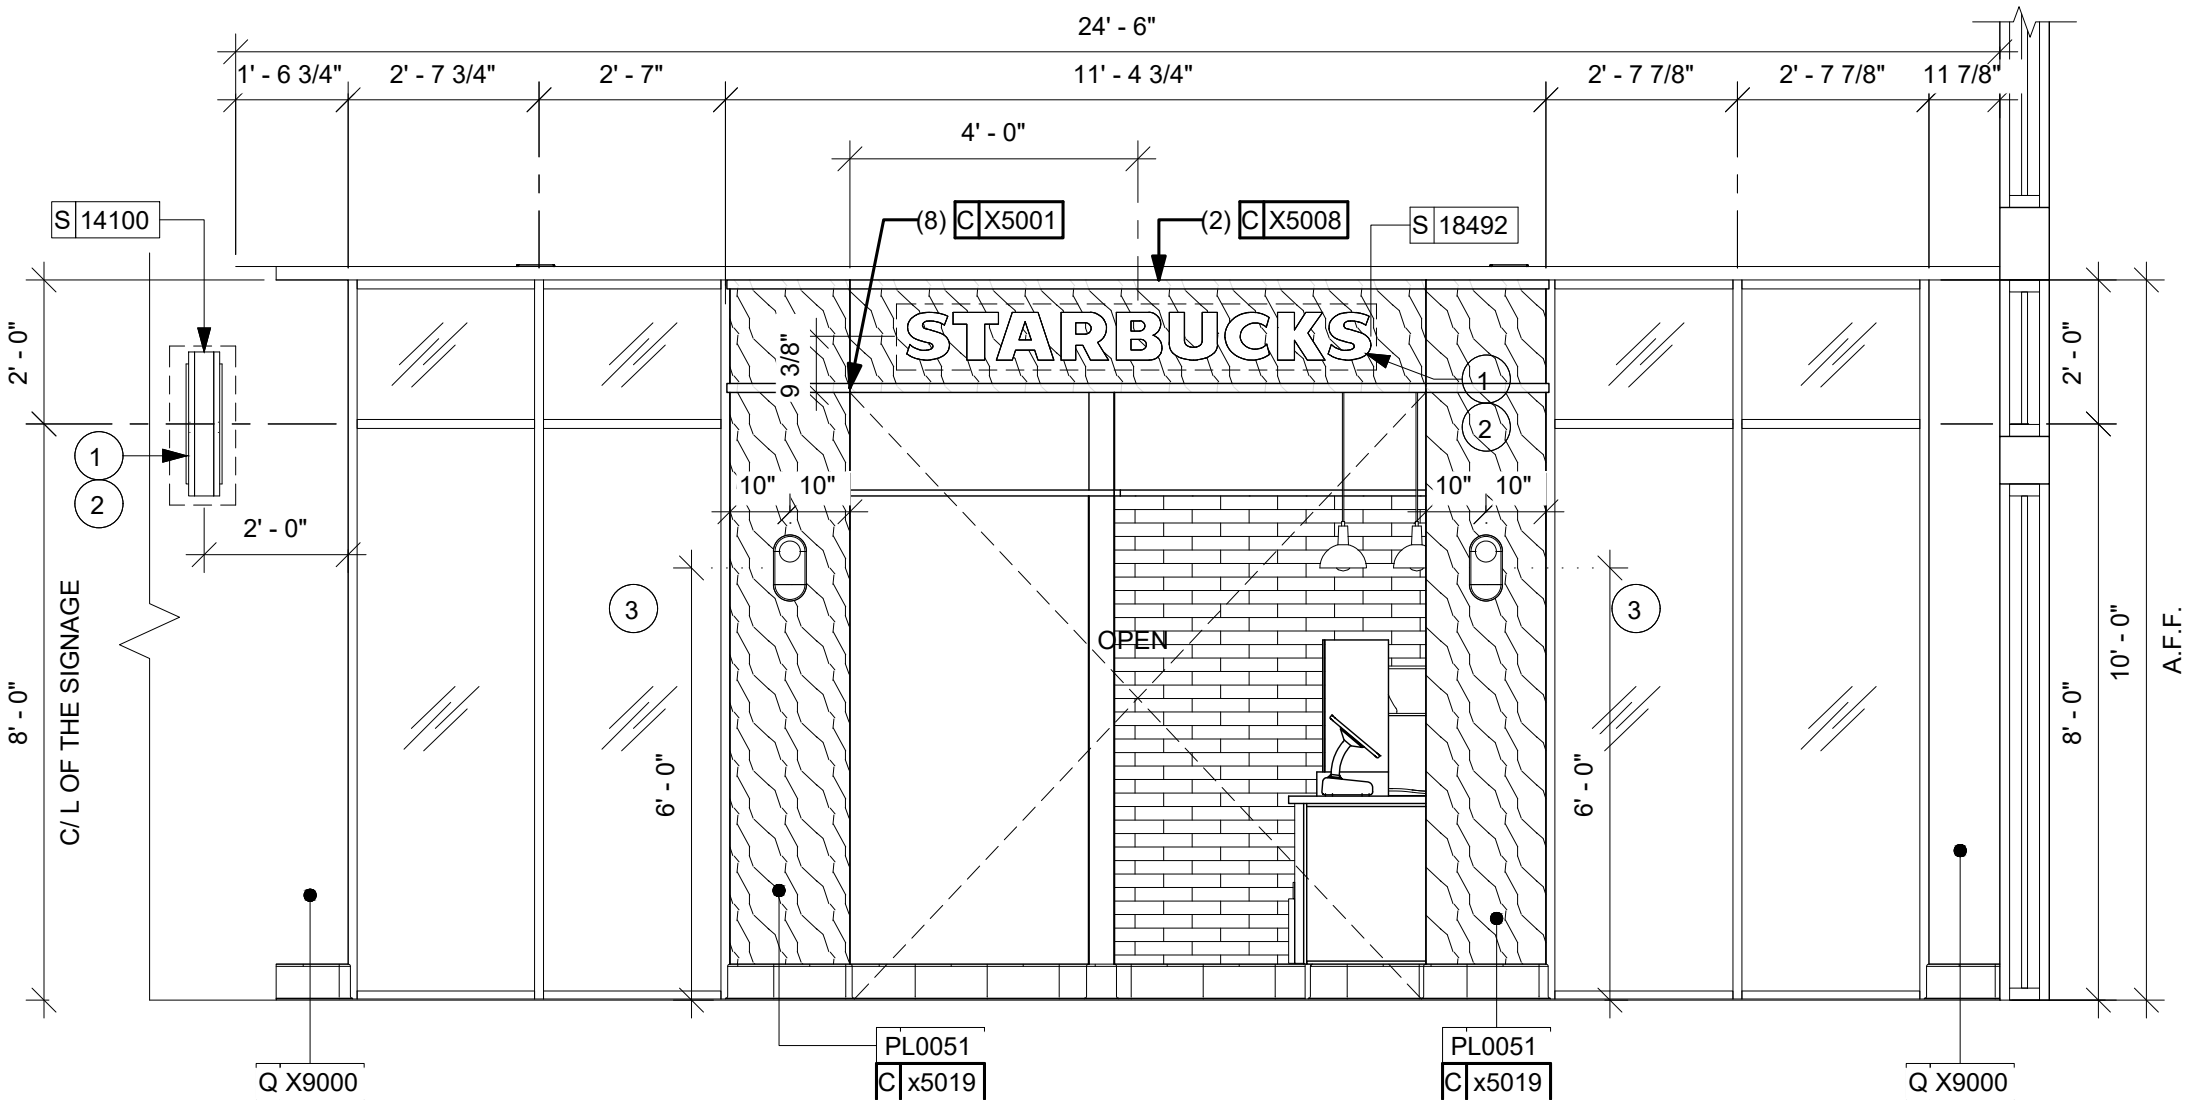


1 EXTERIOR ELEVATION_ENTRANCE
Scale: 3/8" = 1'-0"

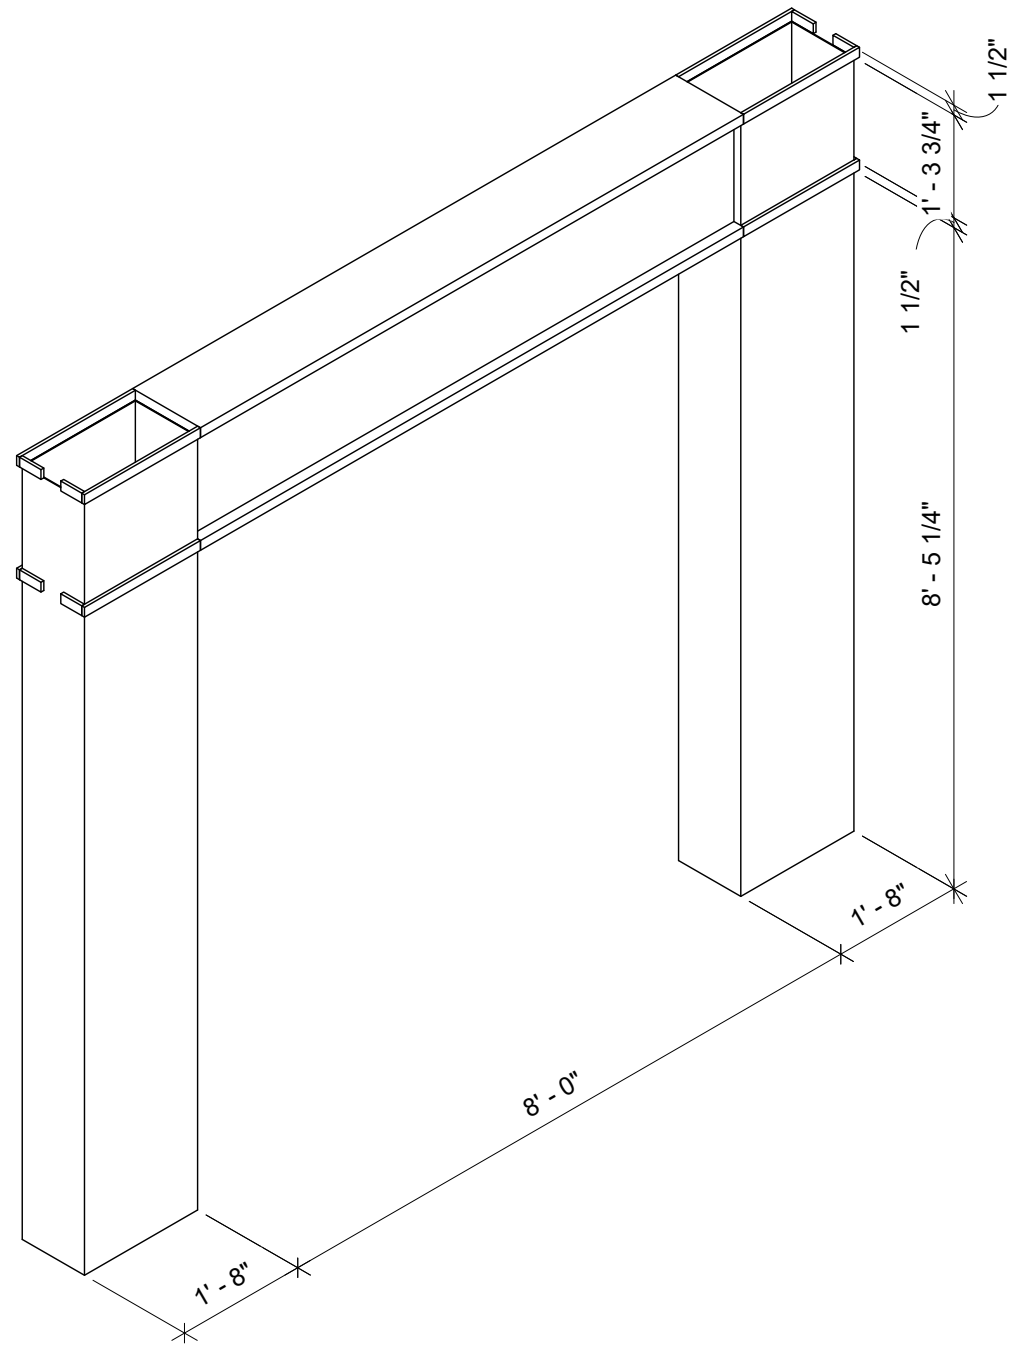

2 X5019 3D VIEW
Scale:

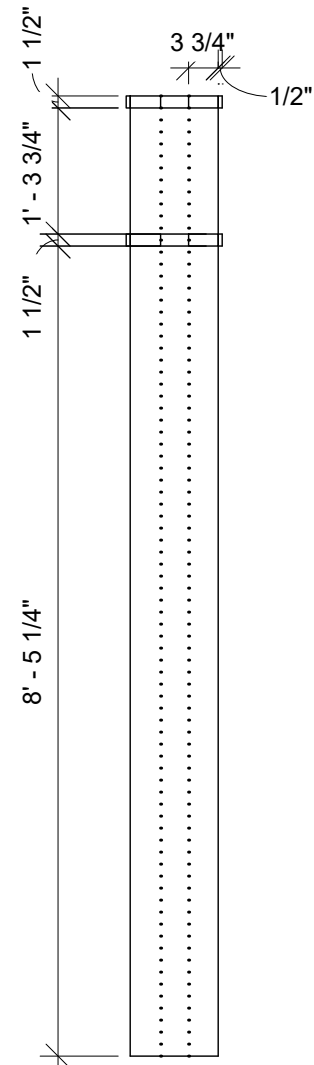

3 X5019 SIDE VIEW
Scale: 1/2" = 1'-0"

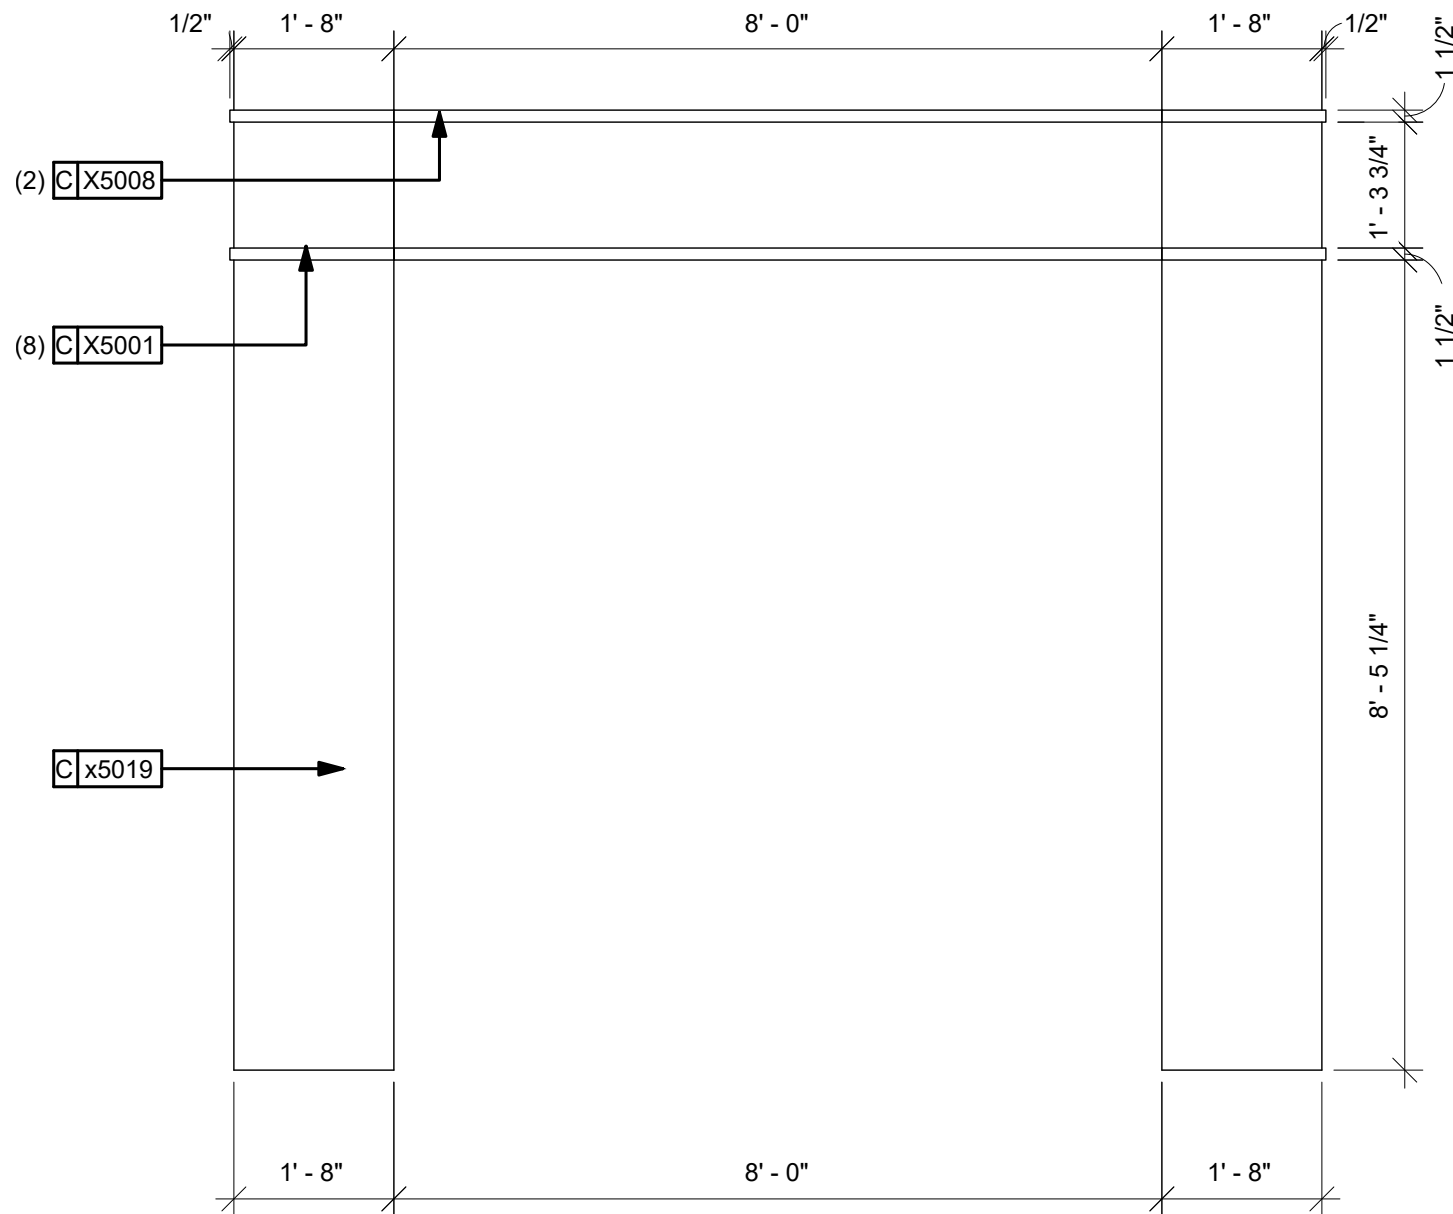

4 X5019 FRONT VIEW
Scale: 1/2" = 1'-0"

KEYED NOTES

- STARBUCKS DESIGN MANAGER TO COORDINATE SIGNAGE PROPOSAL WITH VENDOR.
- GENERAL CONTRACTOR TO PROVIDE 3/4" MARINE GRADE PLYWOOD BLOCKING FOR EXTERIOR SIGNAGE. EXTEND BLOCKING 8" (205MM) MIN. BEYOND EDGES OF SIGNAGE.
- NEW CURTAIN WALL FINISH TO MATCH EXISTING STOREFRONT. FINISH BY LICENSEE. AOR TO SPECIFY.

GENERAL NOTES

- GENERAL CONTRACTOR TO COORDINATE AND SCHEDULE SIGNAGE INSTALLATION WITH THE SIGNAGE CONTRACTOR PROVIDING A MINIMUM SCHEDULING NOTICE OF 4 WEEKS AND 1 WEEK PRIOR TO SCHEDULED DATE OF INSTALLATION. STARBUCKS PROJECT DEVELOPMENT MANAGER TO PROVIDE GENERAL CONTRACTOR WITH SIGNAGE CONTRACTOR CONTACT INFORMATION.
- GENERAL CONTRACTOR SHALL COORDINATE WITH ELECTRICAL CONTRACTOR TO FURNISH AND INSTALL ELECTRICAL CIRCUITS INCLUDING ALL CONDUIT, WIRE, CONNECTIONS AND BREAKER AT PANEL BOARD NECESSARY TO SERVE SIGNAGE.
- GENERAL CONTRACTOR TO PROVIDE FIRE TREATED WOOD STUD BLOCKING OR EQUIVALENT TO SUPPORT SIGNAGE.
- SIGNAGE CONTRACTOR SHALL PROVIDE SHOP DRAWINGS TO STARBUCKS DESIGN MANAGER AND LICENSEE FOR APPROVALS PRIOR TO FABRICATION.
- SIGNAGE CONTRACTOR SHALL OBTAIN PERMIT(S) AND INSTALL SIGNAGE IN COMPLIANCE WITH LOCAL CODES.
- SIGNAGE CONTRACTOR TO PROVIDE FINAL APPROVED SHOP DRAWINGS TO THE LICENSEE, STARBUCKS DESIGN MANAGER, AND ARCHITECT OF RECORD AS NEEDED. GENERAL CONTRACTOR TO NOTIFY ARCHITECT OF RECORD AND STARBUCKS PROJECT DEVELOPMENT MANAGER IMMEDIATELY IF SHOP DRAWINGS OR INSTALLATION IS IN DISCREPANCY WITH ARCHITECTURAL DRAWINGS.
- GENERAL CONTRACTOR TO CLEAN, PATCH AND REPAIR EXISTING BUILDING EXTERIOR AS REQUIRED.

LICENSED STORES RESPONSIBILITY LEGEND

- SB - STARBUCKS
FC - STARBUCKS FIXTURE CONTRACTOR
LC - LICENSEE
GC - LICENSEE'S GENERAL CONTRACTOR
3PV - STARBUCKS THIRD - PARTY VENDOR

ALL SIGNAGE SUPPLIED AND INSTALLED UNDER SEPARATE PERMIT.

LEGEND


- INDICATES WALL BLOCKING.
FIRE TREATED WALL BLOCKING TO BE PROVIDED AS REQUIRED TO SUPPORT WALL ATTACHMENTS. EXTEND BLOCKING 4" (100mm) BEYOND EDGE OF ATTACHMENTS.
- GRAIN DIRECTION
- AREA OUT OF SCOPE, NIC.

ARCHITECT OF RECORD:

THOMAS E. MORGAN, JR.
ARCHITECT

423 FISCHER TRAIL
ELLIJAY, GEORGIA 30540

SEAL:

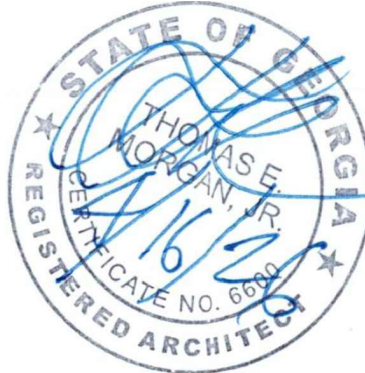

MRP
DESIGN GROUP

3450 Acworth Due West Road
Building 100, Suite 120
Kennesaw, Georgia 30144
P. 770-917-9172
F. 770-917-9470
www.mrpdesign.com

RELEASED FOR
CONSTRUCTION

ISSUES / REVISIONS:

DATE	DESCRIPTION
05.04.26	RELEASE FOR CONSTRUCTION

DRAWN BY: JB

CHKD BY: TM

PROJECT DESCRIPTION:

NEW CONSTRUCTION OF A TA TRAVEL CENTER IN JEFFERSONVILLE, GA. WHICH CONSISTS OF A TRUCKER LOUNGE, SHOWERS, LAUNDRY ROOM, RETAIL AREA, RESTROOMS, GAME AREA, SEATING AREAS, AND FOUR QUICK-SERVICE RESTAURANTS. THE MAJORITY OF THE PROJECT HAS ALREADY BEEN SUBMITTED. THIS ISSUE, DATED 05.04.26 HAS MODIFICATIONS RELATED TO THE ADDITION OF THE STARBUCKS QSR.

PROJECT TITLE:

TRAVEL CENTER
4838 SR 96
JEFFERSONVILLE,
GEORGIA 31044


SHEET TITLE:

BUILDING
EXTERIOR
ELEVATIONS

PROJECT NO: 25021

A201

THESE PLANS ARE THE PROPERTY OF MRP DESIGN GROUP, INC. AND ARE SUBJECT TO FEDERAL COPYRIGHT LAWS. ANY USE OF SAME WITHOUT THE EXPRESS WRITTEN PERMISSION OF MRP DESIGN GROUP, INC. IS STRICTLY PROHIBITED.

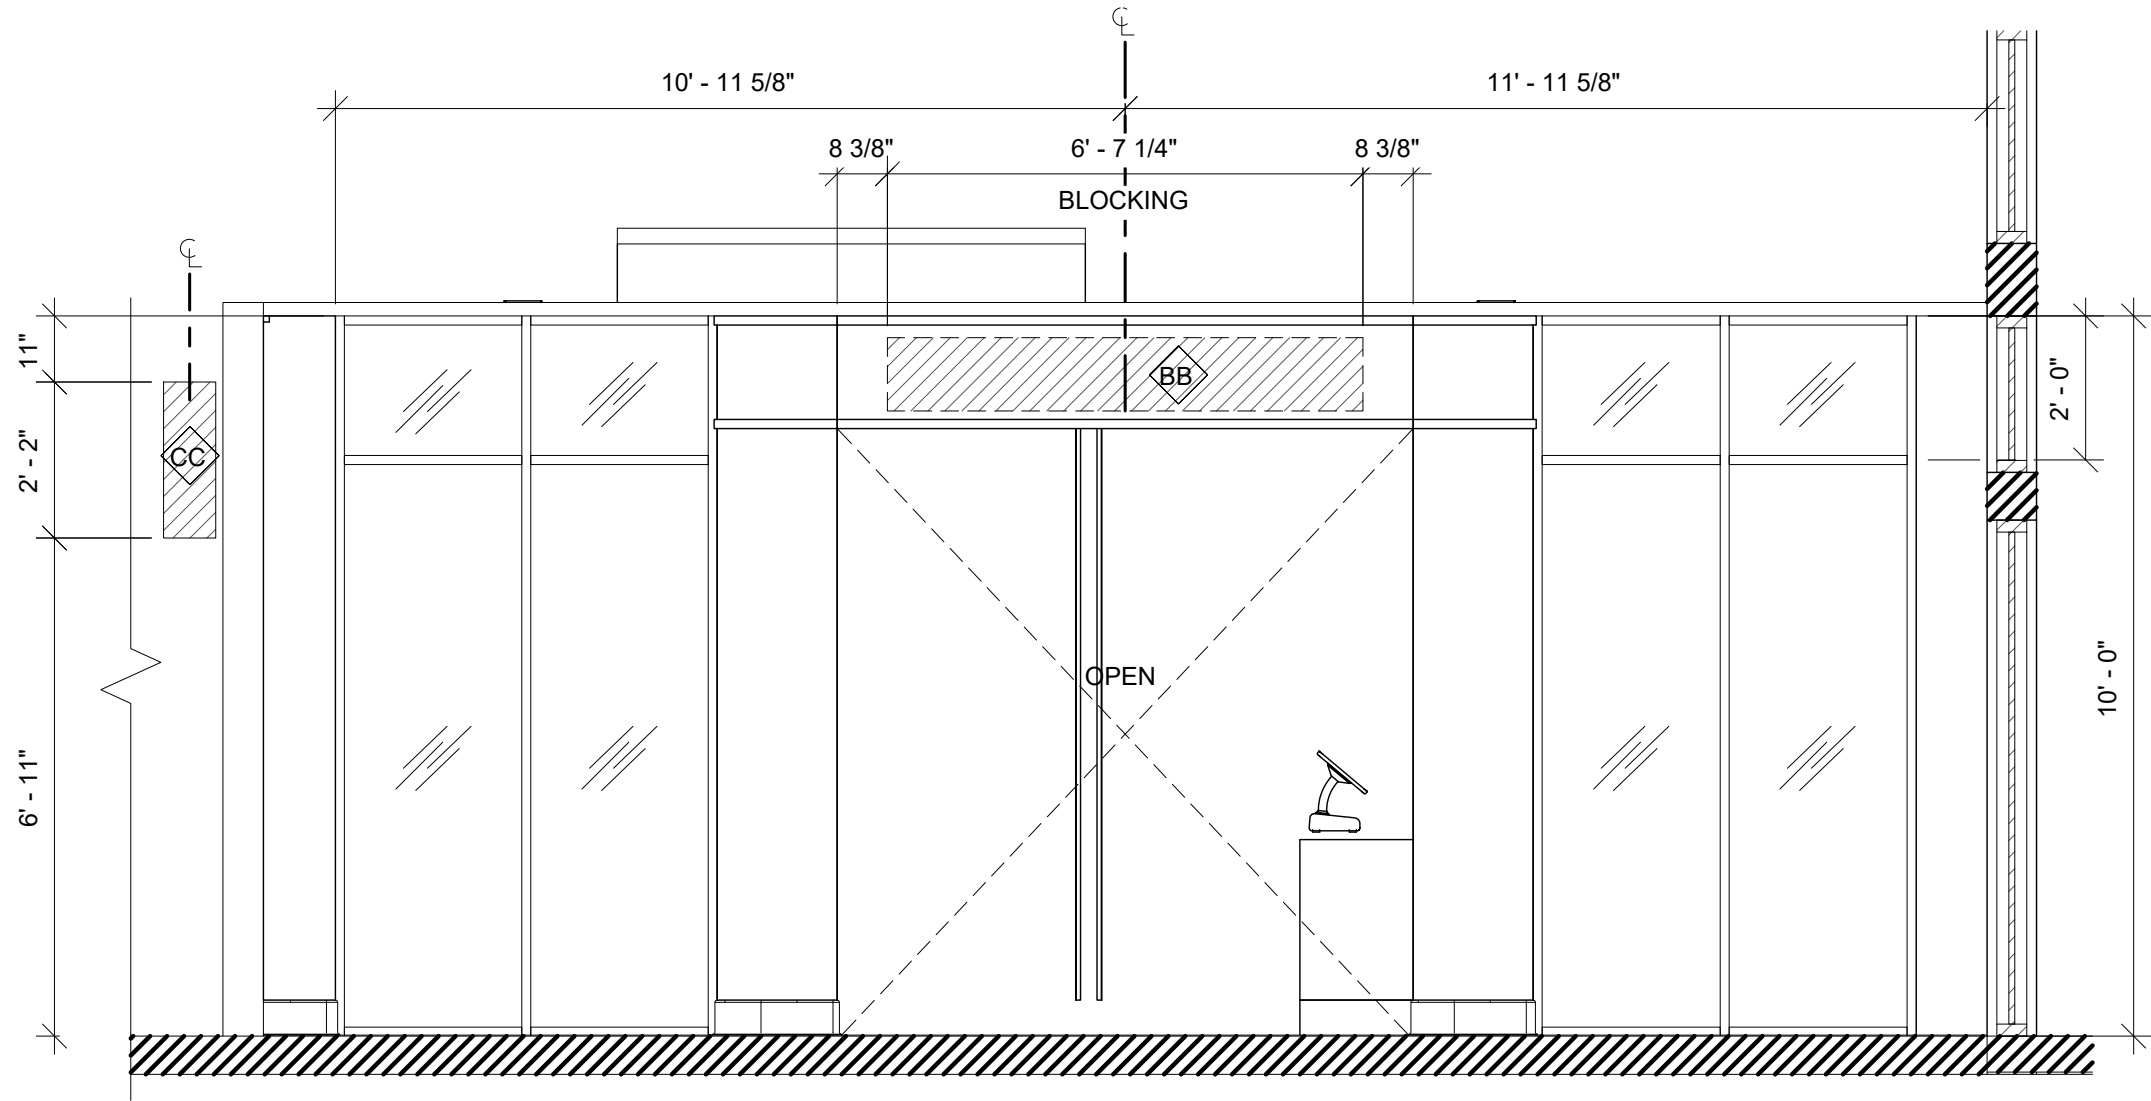

1 EXTERIOR BLOCKING ELEVATION_ENTRANCE
Scale: 3/8" = 1'-0"

WALL BLOCKING LEGEND

SYMBOL	ITEM	WEIGHT
AA	BANQUETTE	AOR TO VERIFY
BB	WORDMARK	AOR TO VERIFY
CC	LOGO SIGN	AOR TO VERIFY
DD	ARTWORK	AOR TO VERIFY
EE	CBE SHELVES	AOR TO VERIFY
FF	DIGITAL MENUS	AOR TO VERIFY
GG	WOOD SHELVES	AOR TO VERIFY
HH	ORDER STATUS BOARD	AOR TO VERIFY
JJ	PAINTED WOOD CLADDING	AOR TO VERIFY
KK	WORKROOM HAND SINK, SOAP AND PAPER TOWEL DISPENSER	128 LBS (58 KG)
LL	SHELVES ABOVE 3-COMP SINK	200 LBS (91 KG)
MM	WATER FILTRATION CABINET MANIFOLD	AOR TO VERIFY
NN	MANAGER DESK	300 LBS (136 KG)
OO	SPC CABINET	AOR TO VERIFY
PP	OFFICE COAT HOOK	AOR TO VERIFY
QQ	WATER FILLING STATION	AOR TO VERIFY
RR	ELECTRICAL PANELS	AOR TO VERIFY
SS	MERCH	AOR TO VERIFY
TT	WATER HEATING TANK PLATFORM	AOR TO VERIFY

PROVIDE FIRE TREATED 2X8 OR 2X8 WOOD STUD BLOCKING AS REQUIRED TO SUPPORT ANY WALL ATTACHMENTS.

REFER TO SHEETS A301 FOR LOCATIONS OF BLOCKING, MOUNTING HEIGHTS, AND EXTEND OF BLOCKING SURFACES.

ARCHITECT OF RECORD:

THOMAS E. MORGAN, JR.
ARCHITECT

423 FISCHER TRAIL
ELLIJAY, GEORGIA 30540

SEAL:



3450 Acworth Due West Road
Building 100, Suite 120
Kennesaw, Georgia 30144
P. 770-917-9172
F. 770-917-9470
www.mrpdesign.com

RELEASED FOR
CONSTRUCTION

ISSUES / REVISIONS:

DATE	DESCRIPTION
05.04.26	RELEASE FOR CONSTRUCTION

DRAWN BY: JB

CHKD BY: TM

PROJECT DESCRIPTION:

NEW CONSTRUCTION OF A TA TRAVEL CENTER IN JEFFERSONVILLE, GA, WHICH CONSISTS OF A TRUCKER LOUNGE, SHOWERS, LAUNDRY ROOM, RETAIL AREA, RESTROOMS, GAME AREA, SEATING AREAS, AND FOUR QUICK-SERVICE RESTAURANTS. THE MAJORITY OF THE PROJECT HAS ALREADY BEEN SUBMITTED. THIS ISSUE, DATED 05.04.26 HAS MODIFICATIONS RELATED TO THE ADDITION OF THE STARBUCKS QSR.

PROJECT TITLE:

TRAVEL CENTER
4838 SR 96
JEFFERSONVILLE,
GEORGIA 31044


SHEET TITLE:

BLOCKING
ELEVATIONS


PROJECT NO: 25021

A401


THESE PLANS ARE THE PROPERTY OF MRP DESIGN GROUP, INC. AND ARE SUBJECT TO FEDERAL COPYRIGHT LAWS. ANY USE OF SAME WITHOUT THE EXPRESS WRITTEN PERMISSION OF MRP DESIGN GROUP, INC. IS STRICTLY PROHIBITED.

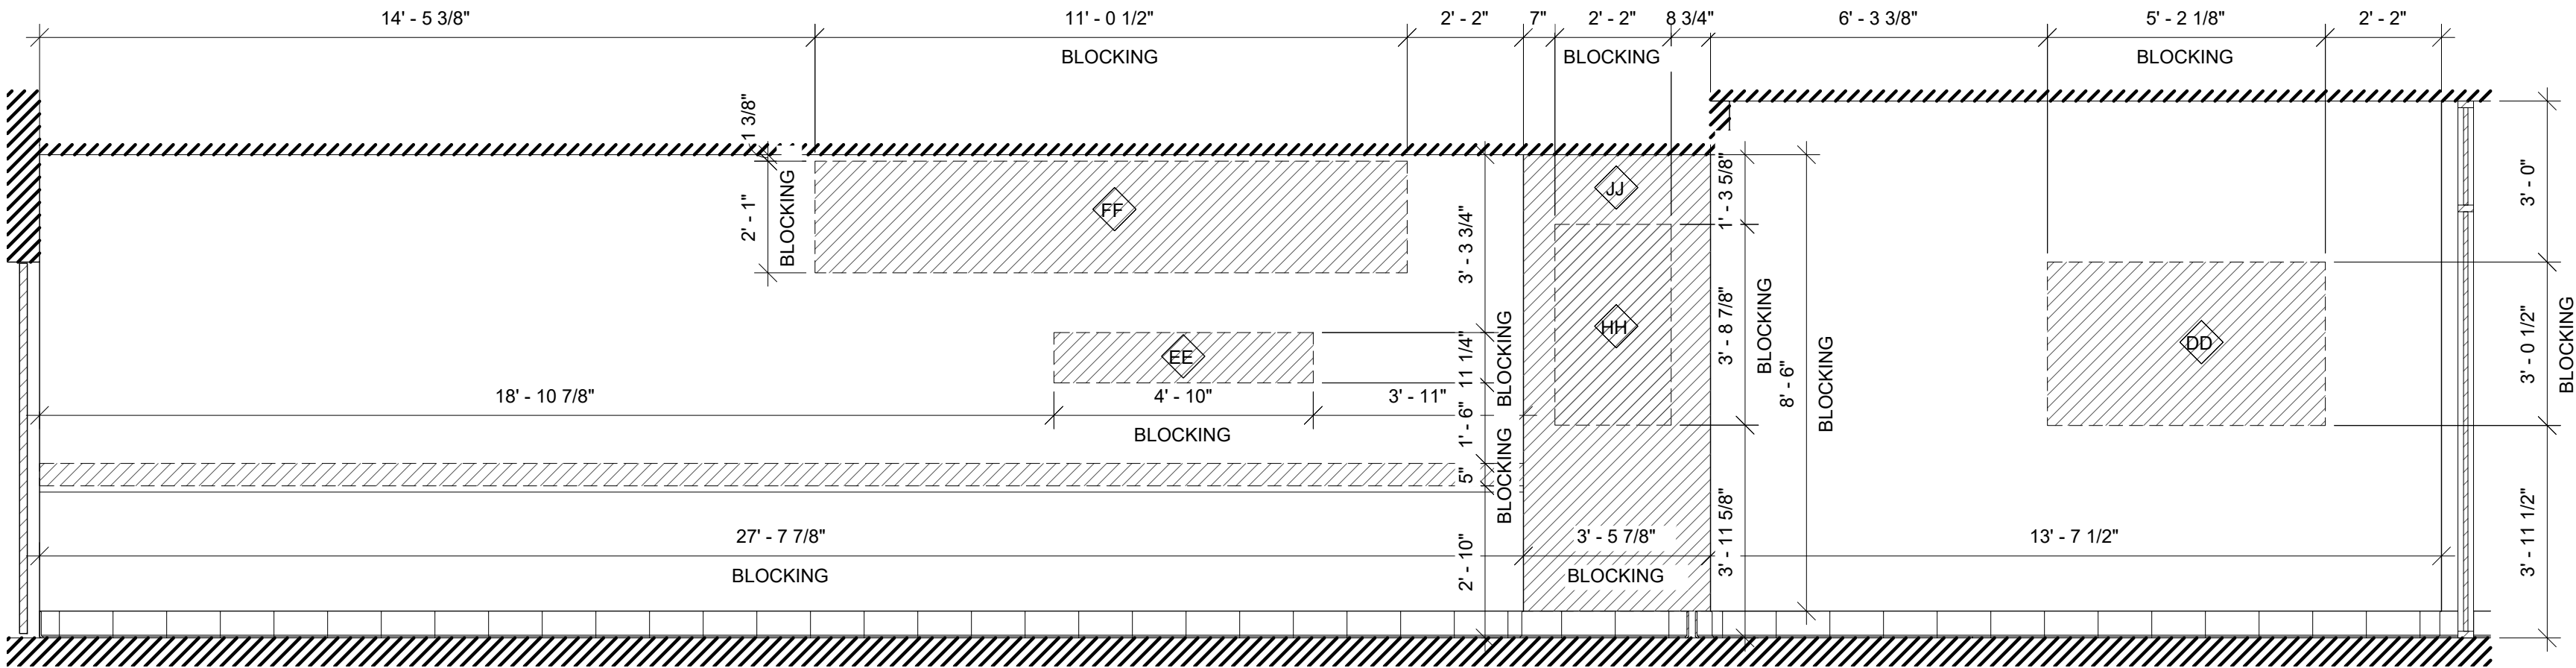


01 INTERIOR BLOCKING ELEVATION ENGINE_BACK BAR
Scale: 3/8" = 1'-0"

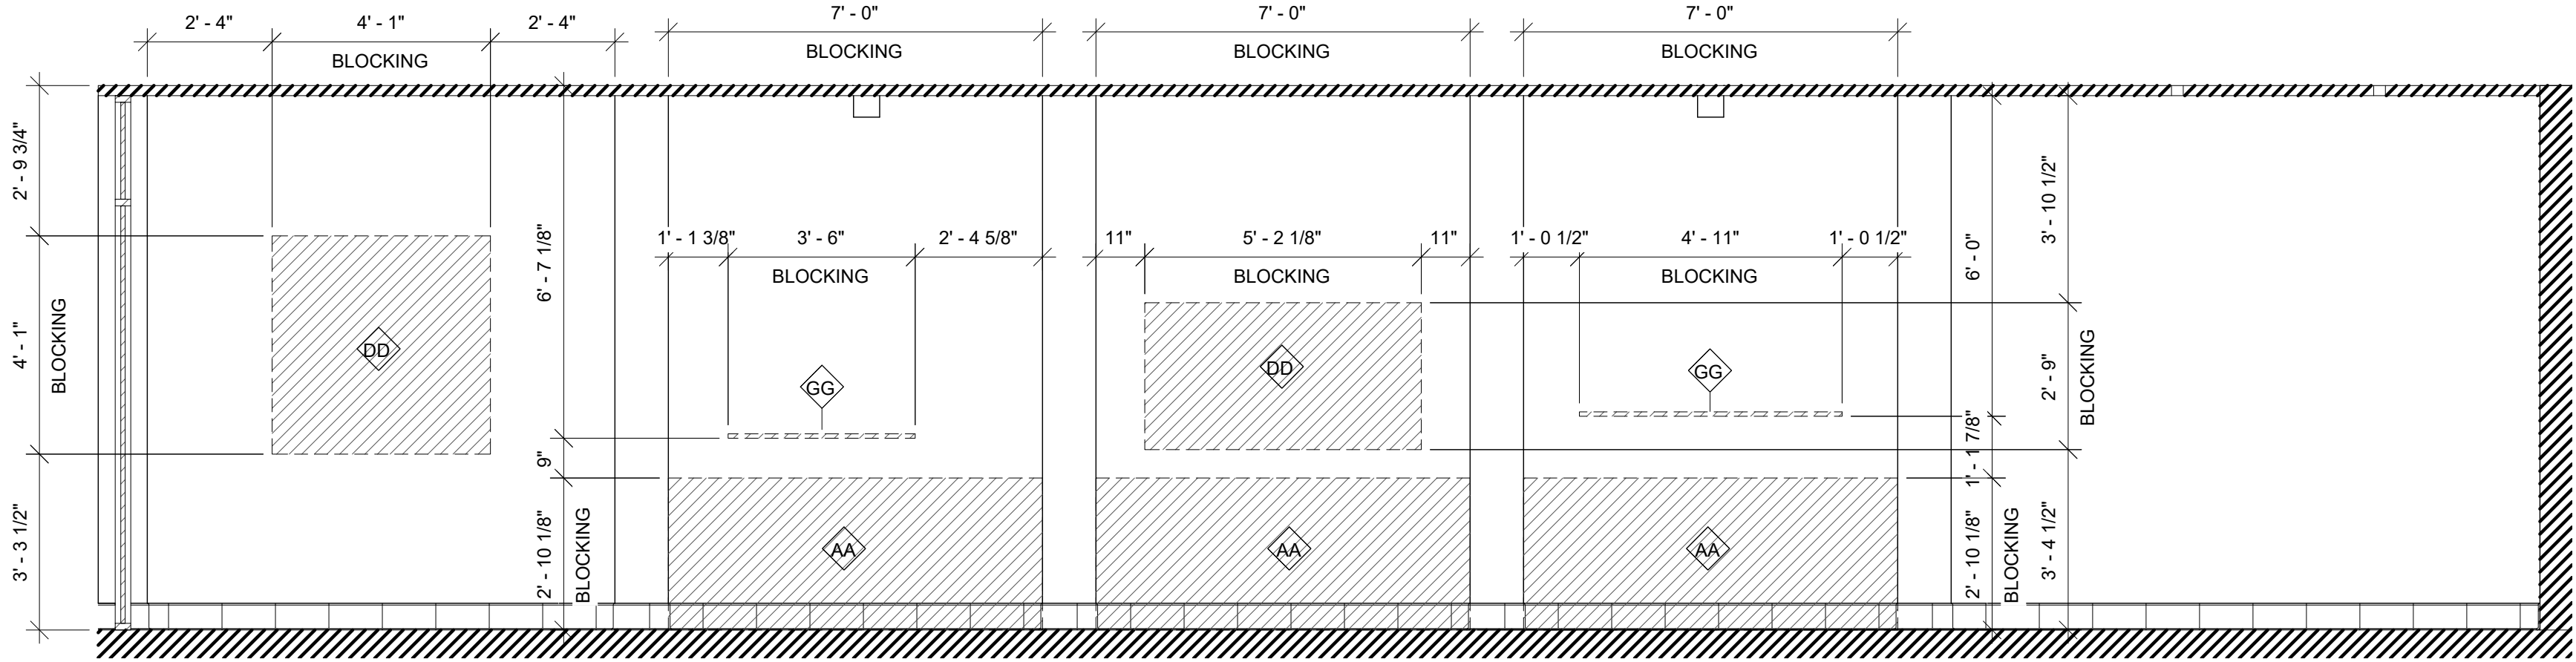

02 INTERIOR BLOCKING ELEVATION - ART WALL
Scale: 3/8" = 1'-0"

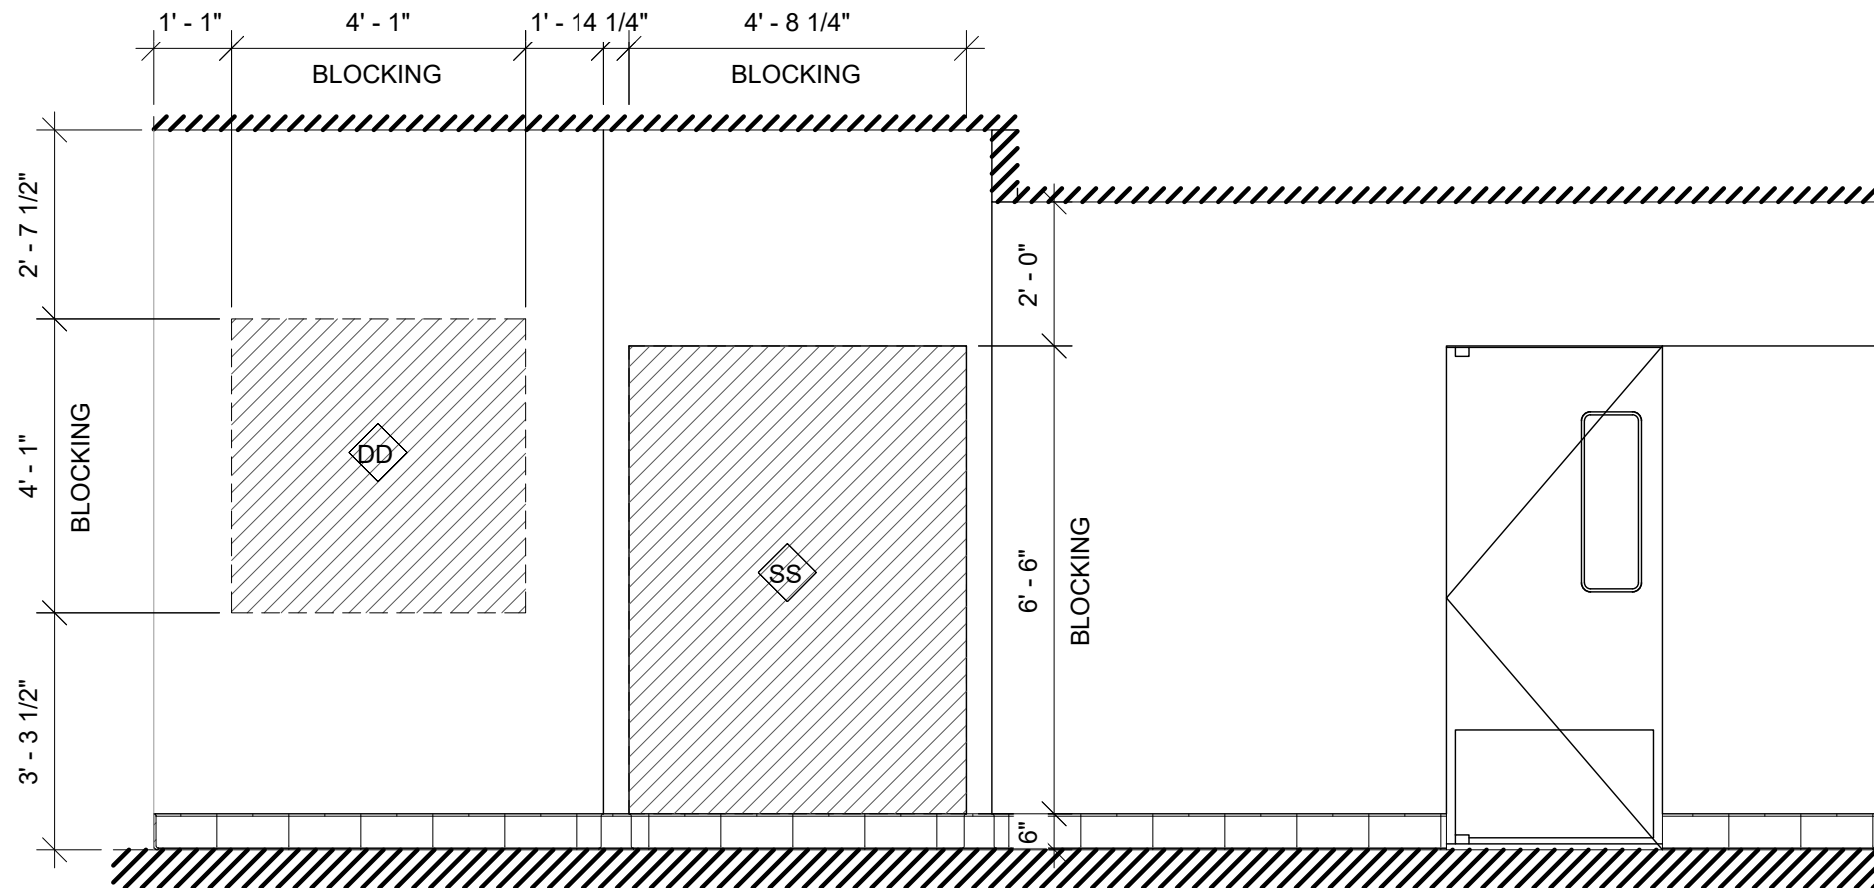

03 INTERIOR BLOCKING ELEVATION - MERCH
Scale: 3/8" = 1'-0"

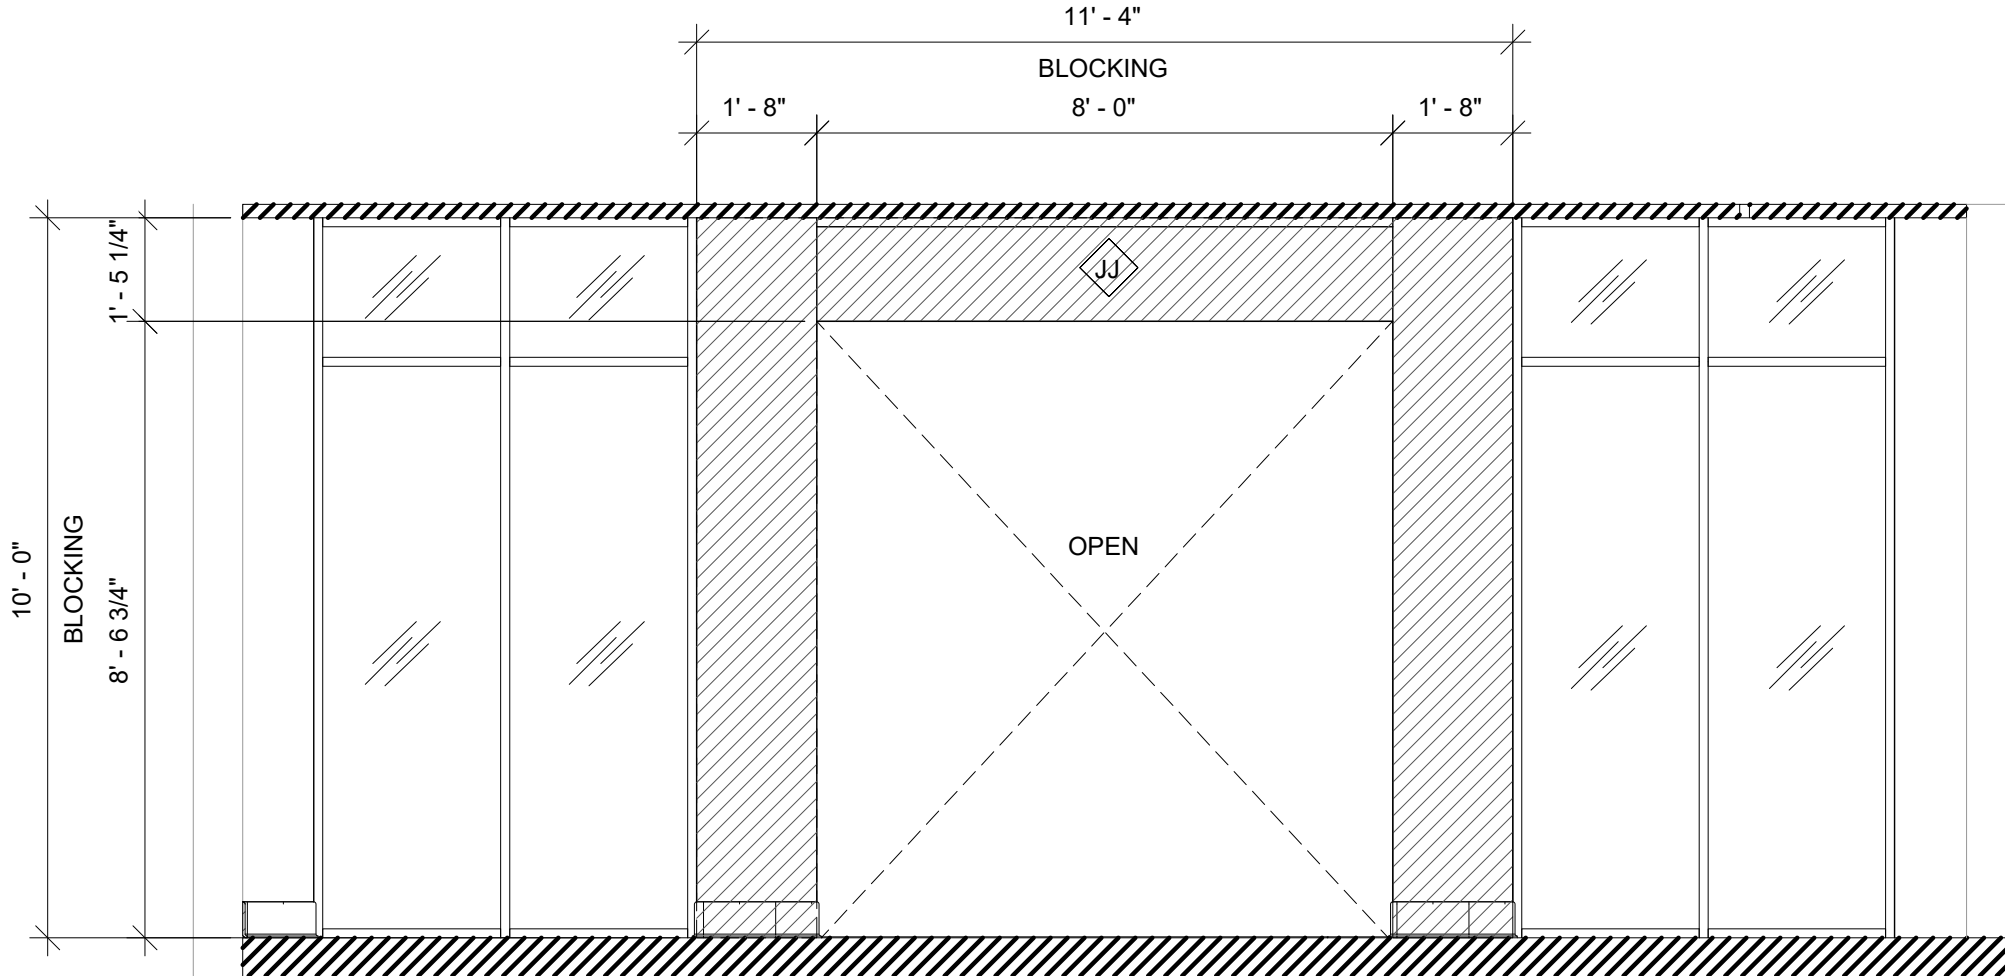

04 INTERIOR BLOCKING ELEVATION - STOREFRONT
Scale: 3/8" = 1'-0"

WALL BLOCKING LEGEND

SYMBOL	ITEM	WEIGHT
AA	BANQUETTE	AOR TO VERIFY
BB	WORDMARK	AOR TO VERIFY
CC	LOGO SIGN	AOR TO VERIFY
DD	ARTWORK	AOR TO VERIFY
EE	CBE SHELVES	AOR TO VERIFY
FF	DIGITAL MENUS	AOR TO VERIFY
GG	WOOD SHELVES	AOR TO VERIFY
HH	ORDER STATUS BOARD	AOR TO VERIFY
JJ	PAINTED WOOD CLADDING	AOR TO VERIFY
KK	WORKROOM HAND SINK, SOAP AND PAPER TOWEL DISPENSER	128 LBS (58 KG)
LL	SHELVES ABOVE 3-COMP SINK	200 LBS (91 KG)
MM	WATER FILTRATION CABINET MANIFOLD	AOR TO VERIFY
NN	MANAGER DESK	300 LBS (136 KG)
OO	SPC CABINET	AOR TO VERIFY
PP	OFFICE COAT HOOK	AOR TO VERIFY
QQ	WATER FILLING STATION	AOR TO VERIFY
RR	ELECTRICAL PANELS	AOR TO VERIFY
SS	MERCH	AOR TO VERIFY
TT	WATER HEATING TANK PLATFORM	AOR TO VERIFY

PROVIDE FIRE TREATED 2X6 OR 2X8 WOOD STUD BLOCKING AS REQUIRED TO SUPPORT ANY WALL ATTACHMENTS.


REFER TO SHEETS A301 FOR LOCATIONS OF BLOCKING, MOUNTING HEIGHTS, AND EXTEND OF BLOCKING SURFACES.

ARCHITECT OF RECORD:

THOMAS E. MORGAN, JR.
ARCHITECT

423 FISCHER TRAIL
ELLIJAY, GEORGIA 30540

SEAL:

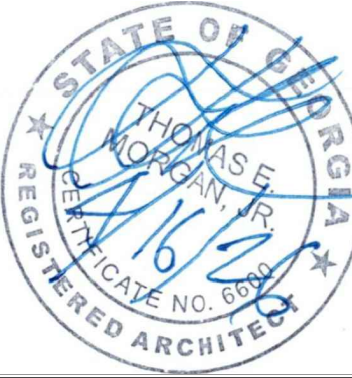

MRP
DESIGN GROUP

3450 Acworth Due West Road
Building 100, Suite 120
Kennesaw, Georgia 30144
P. 770-917-9172
F. 770-917-9470
www.mrpdesign.com

RELEASED FOR
CONSTRUCTION

ISSUES / REVISIONS:

DATE	DESCRIPTION
05.04.26	RELEASE FOR CONSTRUCTION

DRAWN BY: JB

CHKD BY: TM

PROJECT DESCRIPTION:

NEW CONSTRUCTION OF A TA TRAVEL CENTER IN JEFFERSONVILLE, GA, WHICH CONSISTS OF A TRUCKER LOUNGE, SHOWERS, LAUNDRY ROOM, RETAIL AREA, RESTROOMS, GAME AREA, SEATING AREAS, AND FOUR QUICK-SERVICE RESTAURANTS. THE MAJORITY OF THE PROJECT HAS ALREADY BEEN SUBMITTED. THIS ISSUE, DATED 05.04.26 HAS MODIFICATIONS RELATED TO THE ADDITION OF THE STARBUCKS QSR.

PROJECT TITLE:

TRAVEL CENTER
4838 SR 96
JEFFERSONVILLE,
GEORGIA 31044


SHEET TITLE:

BLOCKING
ELEVATIONS


PROJECT NO: 25021

A402


THESE PLANS ARE THE PROPERTY OF MRP DESIGN GROUP, INC. AND ARE SUBJECT TO FEDERAL COPYRIGHT LAWS. ANY USE OF SAME WITHOUT THE EXPRESS WRITTEN PERMISSION OF MRP DESIGN GROUP, INC. IS STRICTLY PROHIBITED

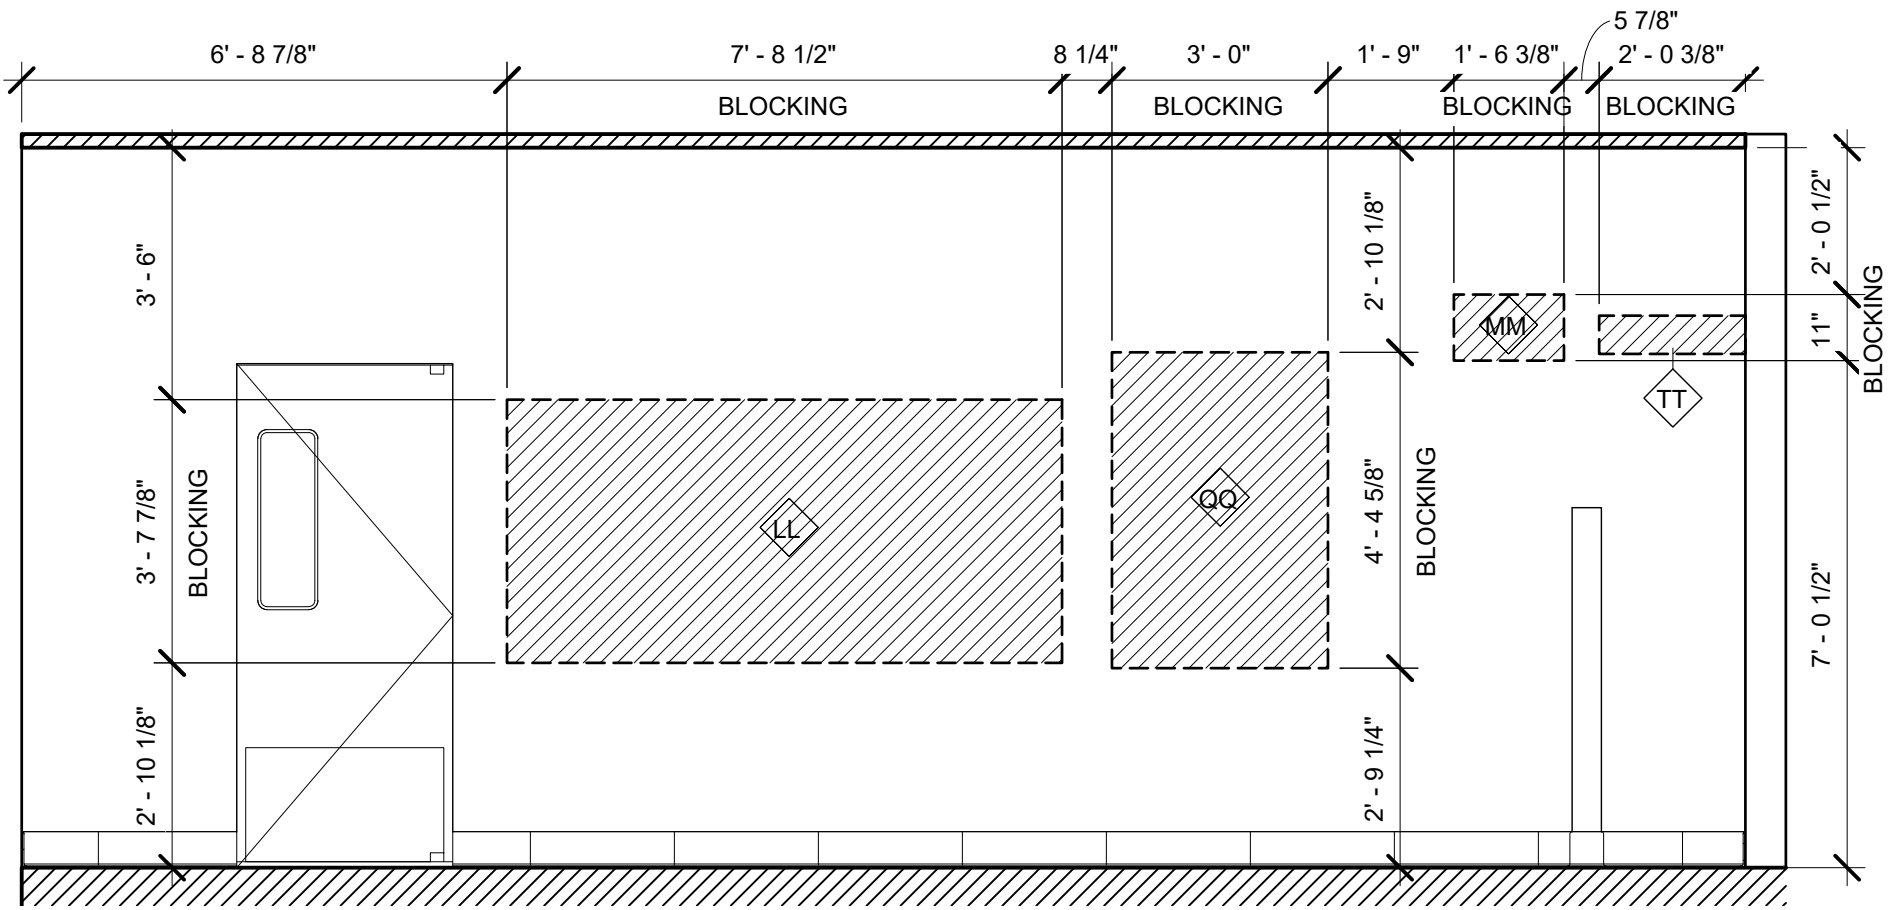


01 INTERIOR BLOCKING ELEVATION @ BOH ENTRANCE
Scale: 3/8" = 1'-0"

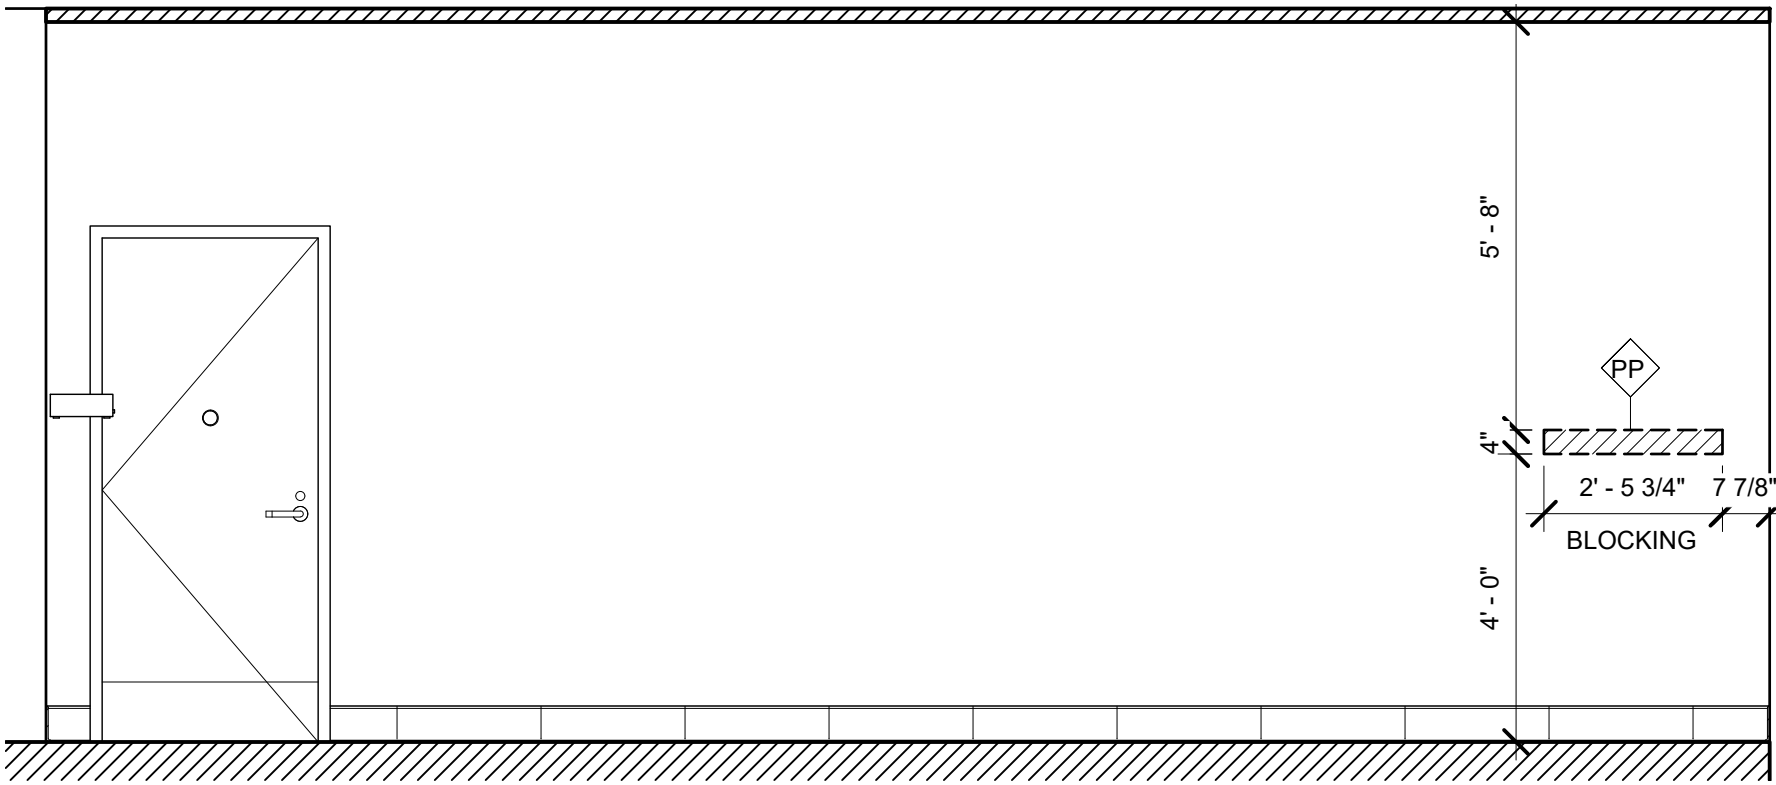

02 INTERIOR BLOCKING ELEVATION @ BOH EXIT
Scale: 3/8" = 1'-0"

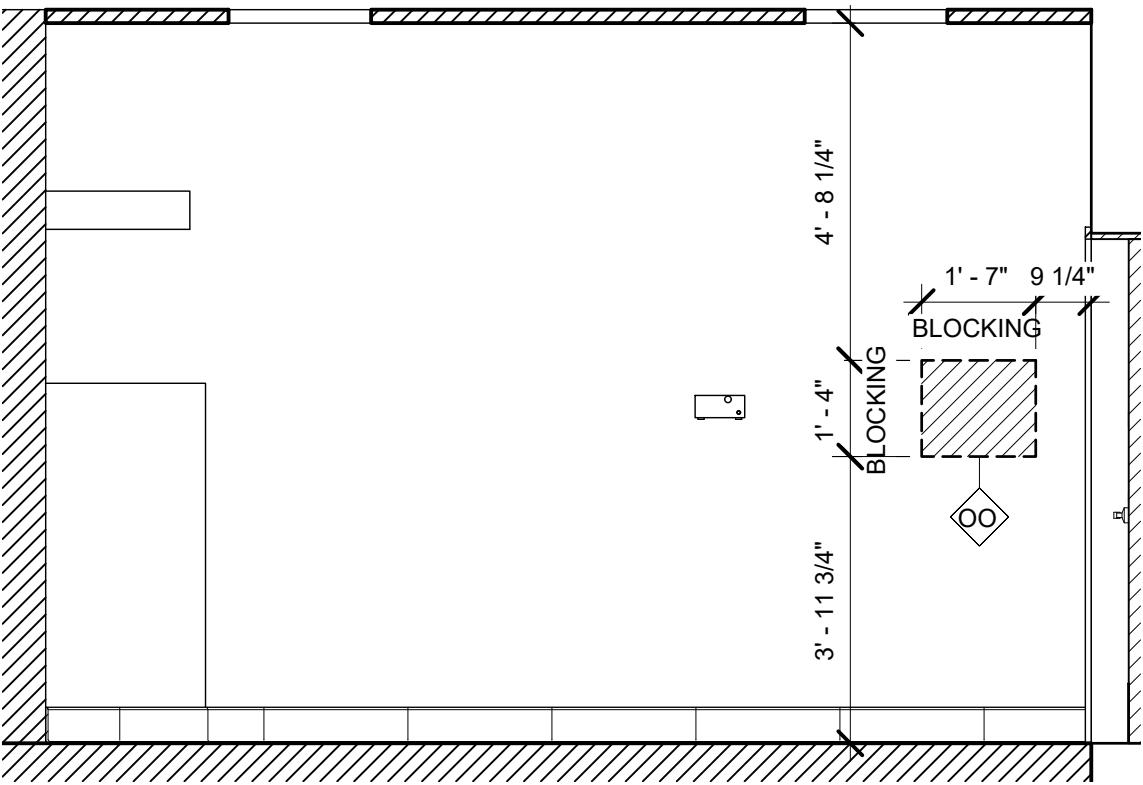

03 INTERIOR BLOCKING ELEVATION @ MGR DESK
Scale: 3/8" = 1'-0"

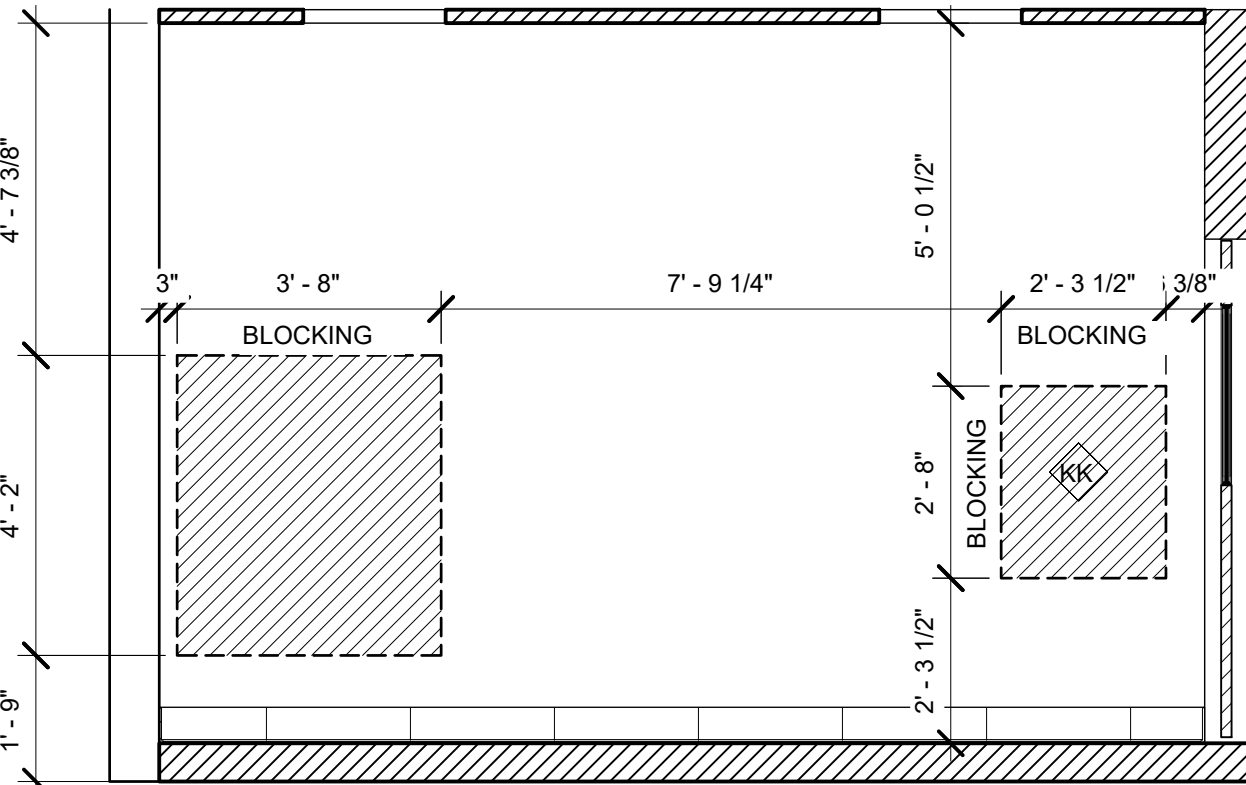

04 INTERIOR ELEVATION @ POWER PANELS
Scale: 3/8" = 1'-0"

WALL BLOCKING LEGEND

SYMBOL	ITEM	WEIGHT
AA	BANQUETTE	AOR TO VERIFY
BB	WORDMARK	AOR TO VERIFY
CC	LOGO SIGN	AOR TO VERIFY
DD	ARTWORK	AOR TO VERIFY
EE	CBE SHELVES	AOR TO VERIFY
FF	DIGITAL MENUS	AOR TO VERIFY
GG	WOOD SHELVES	AOR TO VERIFY
HH	ORDER STATUS BOARD	AOR TO VERIFY
JJ	PAINTED WOOD CLADDING	AOR TO VERIFY
KK	WORKROOM HAND SINK, SOAP AND PAPER TOWEL DISPENSER	128 LBS (58 KG)
LL	SHELVES ABOVE 3-COMP SINK	200 LBS (91 KG)
MM	WATER FILTRATION CABINET MANIFOLD	AOR TO VERIFY
NN	MANAGER DESK	300 LBS (136 KG)
OO	SPC CABINET	AOR TO VERIFY
PP	OFFICE COAT HOOK	AOR TO VERIFY
QQ	WATER FILLING STATION	AOR TO VERIFY
RR	ELECTRICAL PANELS	AOR TO VERIFY
SS	MERCH	AOR TO VERIFY
TT	WATER HEATING TANK PLATFORM	AOR TO VERIFY

PROVIDE FIRE TREATED 2X6 OR 2X8 WOOD STUD BLOCKING AS REQUIRED TO SUPPORT ANY WALL ATTACHMENTS.


REFER TO SHEETS A301 FOR LOCATIONS OF BLOCKING, MOUNTING HEIGHTS, AND EXTEND OF BLOCKING SURFACES.

ARCHITECT OF RECORD:

THOMAS E. MORGAN, JR.
ARCHITECT

423 FISCHER TRAIL
ELLIJAY, GEORGIA 30540

SEAL:

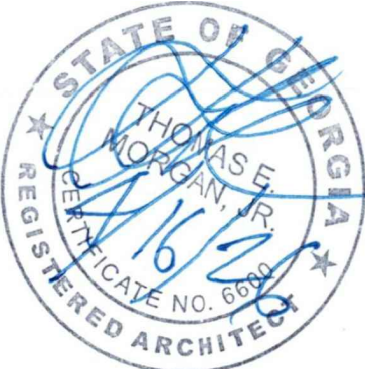

MRP
DESIGN GROUP

3450 Acworth Due West Road
Building 100, Suite 120
Kennesaw, Georgia 30144
P. 770-917-9172
F. 770-917-9470
www.mrpdesign.com

RELEASED FOR
CONSTRUCTION

ISSUES / REVISIONS:

DATE	DESCRIPTION
05.04.26	RELEASE FOR CONSTRUCTION

DRAWN BY: JB

CHKD BY: TM

PROJECT DESCRIPTION:

NEW CONSTRUCTION OF A TA TRAVEL CENTER IN JEFFERSONVILLE, GA, WHICH CONSISTS OF A TRUCKER LOUNGE, SHOWERS, LAUNDRY ROOM, RETAIL AREA, RESTROOMS, GAME AREA, SEATING AREAS, AND FOUR QUICK-SERVICE RESTAURANTS. THE MAJORITY OF THE PROJECT HAS ALREADY BEEN SUBMITTED. THIS ISSUE, DATED 05.04.26 HAS MODIFICATIONS RELATED TO THE ADDITION OF THE STARBUCKS QSR.

PROJECT TITLE:

TRAVEL CENTER
4838 SR 96
JEFFERSONVILLE,
GEORGIA 31044


SHEET TITLE:

BLOCKING
ELEVATIONS


PROJECT NO: 25021

A403


THESE PLANS ARE THE PROPERTY OF MRP DESIGN GROUP, INC. AND ARE SUBJECT TO FEDERAL COPYRIGHT LAWS. ANY USE OF SAME WITHOUT THE EXPRESS WRITTEN PERMISSION OF MRP DESIGN GROUP, INC. IS STRICTLY PROHIBITED.

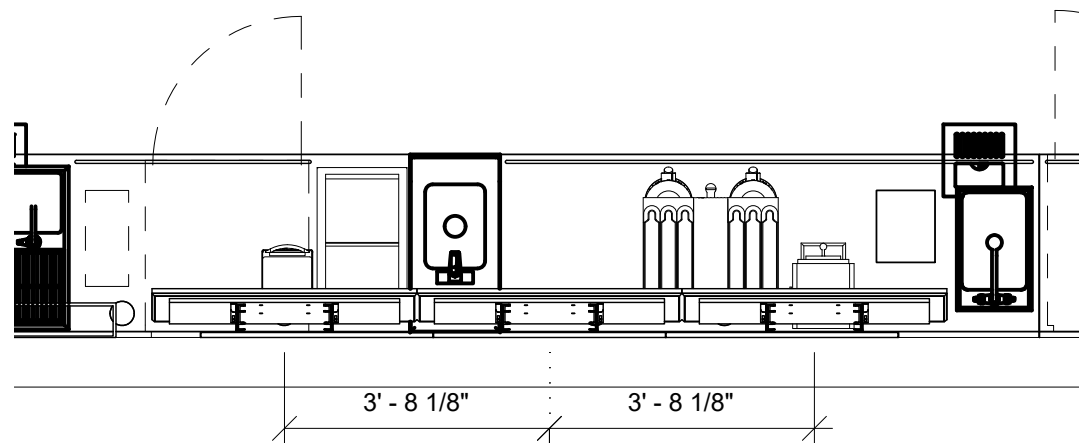

01 ENLARGED PLAN - DIGITAL MENU BOARDS
Scale: 3/8" = 1'-0"

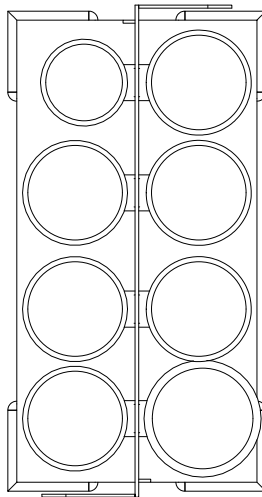

02 CUP CADDY PLAN
Scale: 1 1/2" = 1'-0"

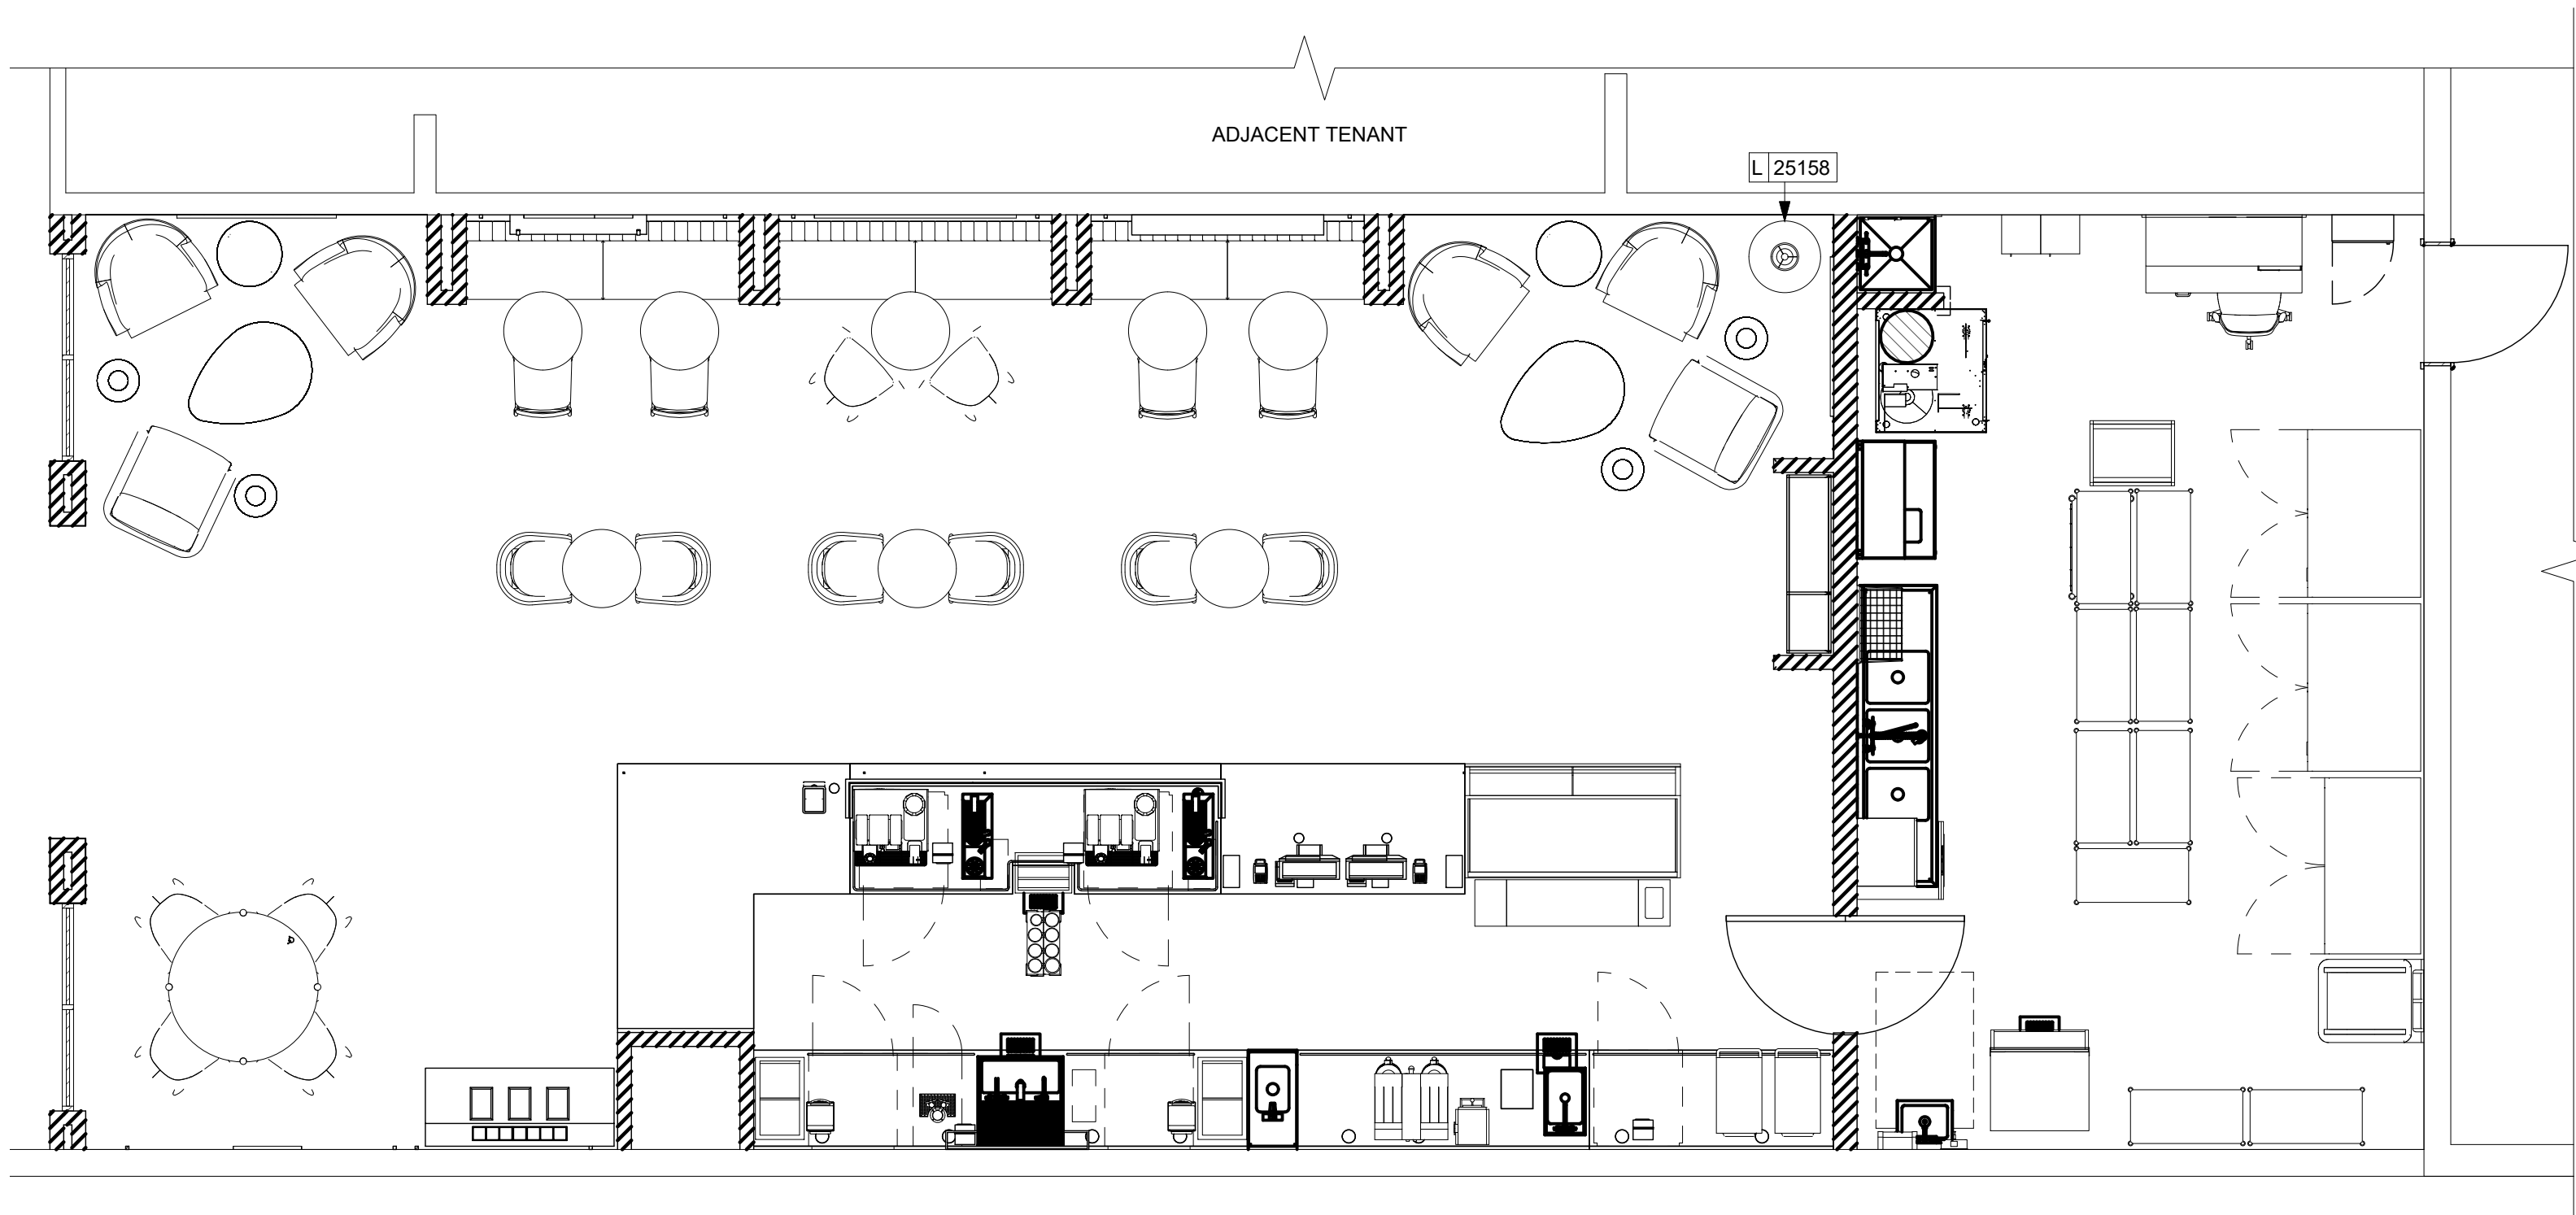

03 FURNITURE, FIXTURES, AND EQUIPMENT PLAN
Scale: 1/4" = 1'-0"

KEYED NOTES

1. INSTALL ALL FURNITURE THROUGHOUT AS SHOWN.
2. PLACE MERCHANDISE FIXTURES AND RETAIL FLOOR BASKETS PER PLAN. STORE OPERATORS TO ORDER RETAIL FLOOR BASKETS.
3. HAND SINK WITH INTEGRAL SPLASH GUARD.
4. DO NOT BLOCK FOOD CASE INTAKE / EXHAUST.
5. GENERAL CONTRACTOR TO REVERSE HINGE ON U / C REFRIGERATOR TO LEFT HAND SWING AS SHOWN.
6. INSTALL NEW WALL MOUNTED MUSIC SPEAKER WHERE INDICATED. SEE INTERIOR FINISH ELEVATIONS FOR MOUNTING HEIGHT.

GENERAL NOTES

- A. THE SITE IS SERVED BY THE MUNICIPAL WATER AND SEWER SYSTEM UNLESS OTHERWISE NOTED.
- B. ALL FLOOR AND WALL JUNCTIONS IN STORAGE AND PREP AREAS SHALL HAVE A COVED BASE.
- C. ALL FOOD STORAGE SHALL BE AT LEAST 6" (150MM) AFF.
- D. ALL WOOD SURFACES (DOORS, TRIM, SHELVES, CABINETS) SHALL BE SEALED.
- E. FLOORS, WALLS AND CEILING FINISHES IN FOOD PREP AREAS SHALL BE SMOOTH, NON-TOXIC, NON- ABSORBENT, DURABLE AND EASILY CLEANABLE. PAINT SHALL BE WASHABLE AND SEMI-GLOSS OR HIGH-GLOSS FINISH.
- F. ALL EQUIPMENT AND INSTALLATION WILL MEET NATIONAL SANITATION FOUNDATION STANDARDS OR EQUIVALENT.
- G. ALL EQUIPMENT AND CABINETRY WILL BE FLUSH MOUNTED TO COUNTERS, WALLS OR FLOORS, OR BE RAISED TO ALLOW FOR CLEANING.
- H. CONFIRM ALL NECESSARY EQUIPMENT CLEARANCES PER PRODUCT CUT SHEET (E.G. ICE MACHINE).
- I. FOR LOCATION OF COUNTERTOP EQUIPMENT, REFER TO CASEWORK ELECTRICAL DETAILS.
- J. EQUIPMENT UNITS SHALL CONTAIN NO EXPOSED THREADS, EMBELLISHMENTS OR OVERHANGING EDGES THAT SERVE AS PLACES FOR ACCUMULATION OF DUST, DIRT AND DEBRIS.
- K. EACH HAND WASHING SINK WILL HAVE A SINGLE SERVICE TOWEL AND SOAP DISPENSER, AND ALL HAND SINKS TO HAVE A COMBINATION FAUCET OR PREMIXING FAUCET.
- L. FOR PLUMBING FIXTURES, REFER TO THE PLUMBING DESIGN PLAN.

LICENSED STORES RESPONSIBILITY LEGEND

- SB - STARBUCKS
FC - STARBUCKS FIXTURE CONTRACTOR
LC - LICENSEE
GC - LICENSEE'S GENERAL CONTRACTOR
3PV - STARBUCKS THIRD - PARTY VENDOR

LEGEND


AREA OUT OF SCOPE, NIC.

ARCHITECT OF RECORD:

THOMAS E. MORGAN, JR.
ARCHITECT

423 FISCHER TRAIL
ELLIJAY, GEORGIA 30540

SEAL:

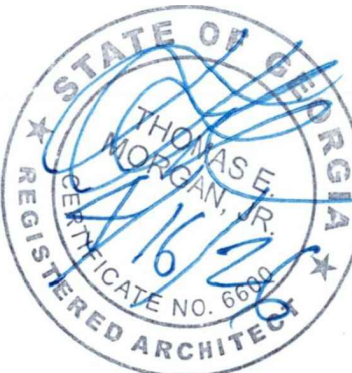

MRP
DESIGN GROUP

3450 Acworth Due West Road
Building 100, Suite 120
Kennesaw, Georgia 30144
P. 770-917-9172
F. 770-917-9470
www.mrpdesign.com

RELEASED FOR CONSTRUCTION

ISSUES / REVISIONS:

DATE	DESCRIPTION
05.04.26	RELEASE FOR CONSTRUCTION

DRAWN BY: JB

CHKD BY: TM

PROJECT DESCRIPTION:

NEW CONSTRUCTION OF A TRAVEL CENTER IN JEFFERSONVILLE, GA. WHICH CONSISTS OF A TRUCKER LOUNGE, SHOWERS, LAUNDRY ROOM, RETAIL AREA, RESTROOMS, GAME AREA, SEATING AREAS, AND FOUR QUICK-SERVICE RESTAURANTS. THE MAJORITY OF THE PROJECT HAS ALREADY BEEN SUBMITTED. THIS ISSUE, DATED 05.04.26 HAS MODIFICATIONS RELATED TO THE ADDITION OF THE STARBUCKS QSR.

PROJECT TITLE:

TRAVEL CENTER
4838 SR 96
JEFFERSONVILLE,
GEORGIA 31044

SHEET TITLE:

FF & E PLAN

PROJECT NO: 25021

1101

FOR REFERENCE ONLY

THESE PLANS ARE THE PROPERTY OF MRP DESIGN GROUP, INC. AND ARE SUBJECT TO FEDERAL COPYRIGHT LAWS. ANY USE OF SAME WITHOUT THE EXPRESS WRITTEN PERMISSION OF MRP DESIGN GROUP, INC. IS STRICTLY PROHIBITED.

SPECIALTY EQUIPMENT SCHEDULE - "E"					
DESIGN ID	COUNT	DESCRIPTION	FURN. BY	INST. BY	COMMENTS
COOLING					
10267	4	FRIDGE UNDERCOUNTER 1 DOOR - 27IN 685MM	SB	GC	
11083	2	FRIDGE REACH IN 2 DOOR - 51X35IN 1295X890MM	SB	GC	
12618	1	FRIDGE UNDERCOUNTER 1 DOOR WITH SHELF - 27IN 685MM	SB	GC	
13682	1	FREEZER REACH IN 2 DOOR - 54IN 1370MM	SB	GC	
20011	1	FRIDGE NITRO 2 TAP JT NITCOM RH	SB	GC	KIT INCLUDES UNDERCOUNTER FRIDGE, FONT, TRAY, AND TUBING
EQUIPMENT					
10808	1	GRINDER DITTING KR1203	SB	GC	
12508	2	BLENDER QUIET MODEL ON COUNTER	SB	GC	
19742	2	ESPRESSO MACHINE MASTRENA II	SB	GC	50 AMP DEDICATED BREAKER REQUIRED. OUTLETS PROVIDED BY GC. 3-WIRE PLUS GROUND (L1, L2 AND G); NEMA 6-50 RECEPTACLE WIN 4.5 FT. FIXTURE CONTRACTOR TO SCHEDULE AND COORDINATE WITH BUNN FOR EQUIPMENT INSTALL AND CALIBRATION. 30 AMP BREAKER REQUIRED.
20032	2	OVEN EIKON E2S - BLACK	SB	GC	
21679	1	NITROGEN GENERATOR ELEMENT COMPACT	SB	GC	
22885	1	BREWER CLOVER VERTICA DOUBLE	SB	GC	50 AMP DEDICATED BREAKER REQUIRED. OUTLETS PROVIDED BY GC. 3-WIRE PLUS GROUND (L1, L2 AND G); NEMA 6-50 RECEPTACLE WIN 4.5 FT. FIXTURE CONTRACTOR TO SCHEDULE AND COORDINATE WITH BUNN FOR EQUIPMENT INSTALL AND CALIBRATION. 60HZ, 50 AMP SERVICE. NEMA 14-50 REQUIRED. PROVIDED BY GC.
23380	1	BREWER CLOVER VERTICA DOUBLE INSTALL KIT	SB	GC	
23381	1	BREWER CLOVER VERTICA DOUBLE POWER CORD	SB	GC	50 AMP DEDICATED BREAKER REQUIRED. OUTLETS PROVIDED BY GC. 3-WIRE PLUS GROUND (L1, L2 AND G); NEMA 6-50 RECEPTACLE WIN 4.5 FT. FIXTURE CONTRACTOR TO SCHEDULE AND COORDINATE WITH BUNN FOR EQUIPMENT INSTALL AND CALIBRATION.
24007	1	DISHWASHER LXNR ADVANSYS	SB	GC	SUPPLIED SOFTENED WATER. CORD AND CAPS TO BE SUPPLIED BY GC.
FOOD CASE					
16238	1	FOOD CASE - ZEPHYR - 66IN 1675MM	SB	GC	
ICE					
10102	1	ICE - BIN B55	SB	GC	
10344	2	ICE - BIN DROP IN 90LB 40KG	SB	GC	
18842	1	ICE - MACHINE CIM1136HA SERIES AIR COOLED	SB	GC	
19278	1	ICE - BIN DROP IN 45LB 20KG HORIZONTAL	SB	GC	
OTHER					
10396	1	CUP DISPENSER SHORT HOT VERTICAL	SB	GC	
10791	3	CUP DISPENSER GRANDE VENTI COLD VERTICAL	SB	GC	
10855	3	CUP DISPENSER GRANDE VENTI HOT VERTICAL	SB	GC	
10947	1	SOAP DISPENSER WALL MOUNTED	LC	GC	
10977	1	PAPER TOWEL DISPENSER FULL SIZE	LC	GC	
13330	1	MOBILE CUP DISPENSER CADDY	SB	GC	
13584	1	CUP DISPENSER TRENTA COLD VERTICAL	SB	GC	
20403	6	KEG - 3GAL	SB	GC	STARBUCKS OPS TO PREPARE 1KEG COLD BREW AT LEAST 20HRS PRIOR TO NITRO CALIBRATION.
22627	1	NITRO 2 TAP HANDLE WITH BADGE AND MOUNT KIT	SB	GC	JOE TAP, FOR USE AT BACKBAR NITRO FONT
STORAGE					
10222	1	WIRE SHELF GRID AT SINK	SB	GC	
10416	9	WORKROOM SHELVEING - 36IN 915MM	SB	GC	
10462	9	WORKROOM SHELVEING POSTS	SB	GC	
10898	1	MOP RACK WITH 3 HOLDERS	SB	GC	
13578	2	DISHWARE DRYING RACK - 21IN 535MM	SB	GC	
17255	1	PASTRY TRAY CART - 60IN 1525MM	SB	GC	
17264	1	ROLLING PASTRY TRAY THAW RACK - 20X26IN 510X660MM	SB	GC	
19476	2	5 COMP LOCKER - 12IN 305MM	LC	GC	SPECIFICATIONS PROVIDED BY SB ARE SUGGESTIVE PROPOSALS, LC TO SPECFY/PROCURE PROPOSED OR SIMILAR ALTERNATE OF CHOICE.
22212	1	WORKROOM SHELVEING CART KIT	SB	GC	


FURNITURE SCHEDULE - "F"					
DESIGN ID	COUNT	DESCRIPTION	FURN. BY	INST. BY	COMMENTS
BANQUETTE					
19503	3	BANQUETTE - CLOSTER BASE - WALNUT WD0077	SB	GC	
19508	3	BANQUETTE - CLOSTER CUSHION VERTICAL STITCH - CAMEL BROWN NATURAL F0008	SB	GC	
CHAIR					
21373	4	CHAIR - CAFE PEGGY UPHOLSTERED - WALNUT AND CAMEL BROWN NATURAL WD0077 F0008	SB	GC	
21458	4	CHAIR - CAFE ASHER UPHOLSTERED - WALNUT AND CAMEL BROWN NATURAL WD0077 F0008	SB	GC	
21540	6	CHAIR - CAFE DAPHNE UPHOLSTERED - BLACK AND CAMEL BROWN NATURAL WD0035 F0008	SB	GC	
24532	2	CHAIR - CAFE ASHER UPHOLSTERED - WALNUT AND FERN GREEN WD0077 F0244	SB	GC	
TK0077	1	CHAIR - MANAGERS WORKSTATION	LC	GC	SUGGESTED ITEM ONLY. LC TO PURCHASE SPEC AS NEEDED.
X6000	4	WEST ELM - CHAIR - JODIE WING LEATHER - MACE, LUDLOW LEATHER	SB	GC	
X6002	2	WEST ELM - CHAIR - BENSON LEATHER CHAIR - BLACK, LUDLOW LEATHER	SB	GC	
DESK					
TK0053	1	DESK - MANAGERS WORKSTATION SHELVES - 48IN 1220MM	LC	GC	SUGGESTED ITEM ONLY. LC TO PURCHASE SPEC AS NEEDED.
TK0076	1	DESK - MANAGERS WORKSTATION - 48X24X27IN 1220X610X685MM	LC	GC	SUGGESTED ITEM ONLY. LC TO PURCHASE SPEC AS NEEDED.
OTHER					
TK0051	1	COAT HOOK STRIP - 30IN 760MM	LC	GC	BLACK FINISH
STORAGE					
TK0078	1	FILE MOBILE PEDESTAL WITH CUSHION AND LOCK	LC	GC	SUGGESTED ITEM ONLY. LC TO PURCHASE SPEC AS NEEDED.
TABLE					
21449	8	TABLE - BASE CAFE HEIGHT BOTTLE - FLAT BLACK MT0028	SB	GC	
21473	1	TABLE - BASE ACCESSIBLE POST LEG SQUARE - FLAT BLACK MT0028	SB	GC	
21793	1	TABLE - TOP ACCESSIBLE FOR POST LEG ROUND - 46IN 1170MM - WALNUT WD0077	SB	GC	
21841	8	TABLE - TOP ROUND EDGE ROUND - 24IN 610MM - WALNUT WD0077	SB	GC	
X6001	4	WEST ELM - SIDE TABLE - FLOATING DISK - 13"	SB	GC	
X6003	2	WEST ELM - COFFEE TABLE - ORGANIC MODULAR - 31" - WALNUT	SB	GC	
X6004	2	WEST ELM - SIDE TABLE - TANNER SOLID WOOD - 20" - BLACK	SB	GC	

DATA DEVICE SCHEDULE - "A"					
DESIGN ID	COUNT	DESCRIPTION	FURN. BY	INST. BY	COMMENTS
AUDIO VISUAL					
10005	1	MUSIC SYSTEM	LC	GC	LC TO REACH OUT TO INSTALL ORDERENTRY@MODMEDIA.COM TO SET UP ACCOUNT WITH PLAYWORK.
10015	5	SPEAKER RECESSED - WHITE	GC	GC	SEE RCP FOR LOCATION.
10076	1	AMPLIFIER - 60W	SB	GC	
18801	1	DIGITAL PRODUCTION MANAGER	SB	GC	COORDINATED BY STARBUCKS CONNECT TEAM. INCLUDES ASSOCIATED CABLES AND UPS POWER SUPPLY.
22549	5	SPEAKER GRILLE RECESSED - BLACK	GC	GC	SEE RCP FOR LOCATION.
DATA					
10002	1	COMPUTER MANAGER WORKSTATION	LC	GC	SUGGESTED ITEM ONLY. LC TO PURCHASE SPEC AS NEEDED.
21874	1	PRODUCTION CONTROLLER	SB	GC	COORDINATED BY STARBUCKS CONNECT TEAM AND NCR. INCLUDES (2) DELL CLIENT, SLIM LINE RETAIL CABINET (REQUIRED FOR BOH INSTALLATION), ASSOCIATED CABLES AND UPS POWER SUPPLY.
GRAPHICS - INTERIOR MENU					
22970	1	MENU BOARD - DIGITAL DISPLAY - 44X25.25IN 1121X644MM - BLACK	SB	SB	COORDINATED BY STARBUCKS CONNECT TEAMS AND NCR.
23021	1	MENU BOARD - ORDER STATUS BOARD MOUNTING BRACKET - BLACK	SB	GC	COORDINATED BY STARBUCKS CONNECT TEAMS AND NCR.
24899	1	MENU BOARD - DIGITAL MENU BOARD TRIPLE	LC	GC	LICENSEE TO COORDINATE WITH OSM AND NCR. SEE INTERIOR ELEVATIONS FOR LOCATION.
POINT OF SALE					
10008	2	POS - REGISTER WITH COMPACT CASH DRAWER	SB	SB	COORDINATED BY STARBUCKS CONNECT TEAM AND NCR. INCLUDES NCR POS, SCANNER, (2) NCR CASH DRAWERS FOR EACH REGISTER, CABLES, LOCK AND CYBERPOWER UPS.
10014	2	POS PRINTER	SB	SB	COORDINATED BY STARBUCKS CONNECT TEAM AND NCR. INCLUDES RECEIPT PRINTER AND CABLES.
10029	4	POS BANK	SB	SB	
10075	4	CUP LABELER	SB	SB	COORDINATED BY STARBUCKS CONNECT TEAM. INCLUDES ASSOCIATED CABLES AND UPS POWER SUPPLY.
23821	2	POS - PED DEVICE	LC	LC	PAYMENT ENTRY DEVICES ARE PROVIDED BY LC. ALL OTHER EQUIPMENT AND PERIPHERAL DEVICES ARE PROVIDED BY STARBUCKS CONNECT VIA NCR.

ARCHITECT OF RECORD:

THOMAS E. MORGAN, JR.
ARCHITECT

423 FISCHER TRAIL
ELLIJAY, GEORGIA 30540

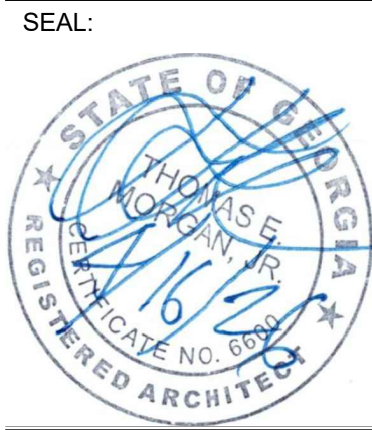

M

R

P

DESIGN GROUP

3450 Acworth Due West Road
Building 100, Suite 120
Kennesaw, Georgia 30144
P. 770-917-9172
F. 770-917-9470
www.mrpdesign.com

RELEASED FOR
CONSTRUCTION

ISSUES / REVISIONS:	
DATE	DESCRIPTION
05.04.26	RELEASE FOR CONSTRUCTION

DRAWN BY: JB
CHKD BY: TM

PROJECT DESCRIPTION:
NEW CONSTRUCTION OF A TA TRAVEL CENTER IN JEFFERSONVILLE, GA, WHICH CONSISTS OF A TRUCKER LOUNGE, SHOWERS, LAUNDRY ROOM, RETAIL AREA, RESTROOMS, GAME AREA, SEATING AREAS, AND FOUR QUICK-SERVICE RESTAURANTS. THE MAJORITY OF THE PROJECT HAS ALREADY BEEN SUBMITTED. THIS ISSUE, DATED 05.04.26 HAS MODIFICATIONS RELATED TO THE ADDITION OF THE STARBUCKS QSR.

PROJECT TITLE:

TRAVEL CENTER
4838 SR 96
JEFFERSONVILLE,
GEORGIA 31044

SHEET TITLE:

FF & E
SCHEDULES

PROJECT NO: 25021

1101.1

FOR REFERENCE ONLY

NEW CONSTRUCTION OF A TRUCK TRAVEL CENTER IN
JEFFERSONVILLE, GA, WHICH
CONSISTS OF A TRUCKER
LOUNGE, SHOWERS, LAUNDRY
ROOM, RETAIL AREA,
RESTROOMS, GAME AREA,
EATING AREAS, AND FOUR
QUICK-SERVICE RESTAURANTS.
THE MAJORITY OF THE
PROJECT HAS ALREADY BEEN
SUBMITTED. THIS ISSUE, DATED
5.04.26 HAS MODIFICATION
RELATED TO THE ADDITION OF
THE STARBUCKS QSR.

TRAVEL CENTER
4838 SR 96
JEFFERSONVILLE,
GEORGIA 31044

FF & E SCHEDULES

PROJECT NO: 25021

1102

1. COUNTERTOP DESIGN INCLUDES INTEGRATED TRASH DROPLIP.
2. INSTALL CASEWORK, COUNTERTOPS, SHELVES, CUBBIES, FINISHES, TRIM AND TABLE TOPS THROUGHOUT. REFERENCE FINISH SCHEDULE AND MANUFACTURER'S SPECIFICATIONS FOR MORE INFORMATION.
3. ALL COUNTERTOPS UTILIZED FOR CUSTOMER TRANSACTIONS, INCLUDING BAR, CONDIMENT AND SALES COUNTERTOPS SHALL BE INSTALLED AT 2'10" AFF MAXIMUM.
4. CASEWORK MANUFACTURER TO ENGINEER PROPER COUNTERTOP SUPPORT AT ESPRESSO BAR AND OTHER WORKSTATIONS FOR STARBUCKS MINIMUM PERFORMANCE CRITERIA.
5. WALL FINISH BEHIND EXPOSED CABINETRY AND BELOW UNDERSIDE OF COUNTERTOP SUBSTRATE TO BE FRP WALL COVERING AS SCHEDULED.
6. VARIABLE WIDTH FILLER CABINET / COUNTERTOP REQUIRED TO FILL GAP (FIELD VERIFY DIMENSION). FILLER PANEL AND COUNTERTOP SHALL BE SCRIBED AND FIELD CUT TO FIT.
7. FLOOR SINK BELOW. CASEWORK MANUFACTURER TO COORDINATE DESIGN TO ENSURE THIS AREA IS READILY ACCESSIBLE FOR CLEANING AND FREE OF CABINET / COUNTERTOP SUPPORT.
8. HAND SINK WITH INTEGRAL SPLASH GUARD, TOWEL SINK TO HAVE SOAP AND SINGLE SERVICE WAND DISPENSERS.
9. INSTALL TRIMS AS INDICATED. SEE INTERIOR FINISH PLAN, CASEWORK SCHEDULE AND ELEVATIONS FOR MORE INFORMATION.
10. DO NOT CAULK TRASH RINGS TO COUNTERTOPS.
11. EXTEND 1/8" WALL COVERING TO WRAP BEHIND IT.
12. ENLARGED BAR / ENGINE PLAN 1202 AND CASEWORK DETAILS 1507.1 FOR MORE INFORMATION.

- A. GENERAL CONTRACTOR TO NOTIFY CONSTRUCTION MANAGER IMMEDIATELY IF A DISCREPANCY EXISTS BETWEEN CASEWORK SHOP DRAWINGS, EXISTING SITE CONDITIONS, ARCHITECTURAL DRAWINGS OR BUILT FIXTURES. ALL DIMENSIONS SHALL BE FIELD VERIFIED BY G.C.
- B. STARBUCKS CONSTRUCTION MANAGER TO COORDINATE AND SCHEDULE CASEWORK DELIVERY DATE. GENERAL CONTRACTOR TO CONFIRM CASEWORK DELIVERY DATE WITH CASEWORK MANUFACTURER AT FOUR (4) WEEKS PRIOR AND THEN ONE (1) WEEK PRIOR TO SCHEDULED DATE OF DELIVERY.
- C. ALL CASEWORK BOX BASES SHALL BE SET AND LEVELED USING 1/4" (6 MM) NON-ABSORBENT PLASTIC SHIMS PROVIDED BY CASEWORK VENDOR.
- D. SET INTERIOR FINISH ELEVATIONS AND SCHEDULES FOR LOCATION AND TAGGING OF WALL TREATMENTS BY CV AND OTHERS.
- E. SEE REFLECTED CEILING PLAN FOR ABOVE BAR SOFFIT LOCATIONS.
- F. REFERENCE PLUMBING AND ELECTRICAL PLANS FOR PLACEMENT OF ELECTRICAL DATA AND PLUMBING ON FRONT AND BACKLINE OF BAR.

 INDICATES STAINLESS STEEL (SST) COUNTERTOP
 INDICATES SOLID SURFACE (SS) COUNTERTOP
 AREA OUT OF SCOPE, NIC.

SB - STARBUCKS
FC - STARBUCKS FIXTURE CONTRACTOR
LC - LICENSEE
GC - LICENSEE'S GENERAL CONTRACTOR
3PV- STARBUCKS THIRD - PARTY VENDOR



THESE PLANS ARE THE PROPERTY OF MRP DESIGN GROUP, INC. AND ARE SUBJECT TO FEDERAL COPYRIGHT LAWS. ANY USE OF SAME WITHOUT THE EXPRESS WRITTEN PERMISSION OF MRP DESIGN GROUP, INC. IS STRICTLY PROHIBITED.

FOR REFERENCE ONLY


THESE PLANS ARE THE PROPERTY OF MRP DESIGN GROUP, INC. AND ARE SUBJECT TO FEDERAL COPYRIGHT LAWS. ANY USE OF SAME WITHOUT THE EXPRESS WRITTEN PERMISSION OF MRP DESIGN GROUP, INC. IS STRICTLY PROHIBITED.

CASEWORK SCHEDULE - "C"					
DESIGN ID	COUNT	DESCRIPTION	FURN. BY	INST. BY	COMMENTS
CABINET					
17574	1	CABINET - BACKBAR SINK OR ICE - 15IN 380MM	SB	FC	PROVIDED BY CASEWORK VENDOR.
17580	2	CABINET - CBE TEA SHELF - 29IN 735MM - FLAT BLACK MT0028	SB	GC	NOT PROVIDED BY CASEWORK VENDOR.
17740	3	CABINET - BACKBAR - 30IN 760MM	SB	FC	PROVIDED BY CASEWORK VENDOR.
17741	1	CABINET - BACKBAR 15IN 380MM	SB	FC	PROVIDED BY CASEWORK VENDOR.
17745	1	CABINET - BACKBAR DRAWER - 15IN 380MM	SB	FC	PROVIDED BY CASEWORK VENDOR.
17747	2	CABINET - BACKBAR TRASH - 15IN 380MM	SB	FC	PROVIDED BY CASEWORK VENDOR.
17896	1	CABINET - BACKBAR CUBBY - 15IN 380MM	SB	FC	PROVIDED BY CASEWORK VENDOR.
18060	1	CABINET - FRONTBAR POS CUBBY - 15IN 380MM	SB	FC	PROVIDED BY CASEWORK VENDOR.
18122	2	CABINET - BACKBAR SINK OR ICE - 16IN 405MM	SB	FC	PROVIDED BY CASEWORK VENDOR.
19281	1	CABINET - ESPRESSO ICE BIN STAINLESS - 20IN 510MM	SB	FC	PROVIDED BY CASEWORK VENDOR.
21190	1	CABINET - FRONTBAR TRASH - 15IN 380MM	SB	FC	PROVIDED BY CASEWORK VENDOR.
21192	2	CABINET - FRONTBAR POS - 30IN 760MM	SB	FC	PROVIDED BY CASEWORK VENDOR.
21193	1	CABINET - ESPRESSO CUBBY WITH OPEN BACK - 18IN 455MM	SB	FC	PROVIDED BY CASEWORK VENDOR.
22574	1	CABINET - FRONTBAR CUBBY - 15IN 380MM	SB	FC	PROVIDED BY CASEWORK VENDOR.
22632	1	CABINET - CBE DRY INCLUSION SHELF - 44IN 1120MM - FLAT BLACK MT0028	SB	GC	NOT PROVIDED BY CASEWORK VENDOR.
22975	2	CABINET - FRONTBAR DEL- 15IN 380MM	SB	FC	PROVIDED BY CASEWORK VENDOR.
CAFE					
20334	1	WALL BAY 2 UNIT - LH - 54IN 1370MM - WALNUT WD0077	SB	GC	NOT PROVIDED BY CASEWORK VENDOR.
X20129	1	CONDIMENT CART THREE DROP - WALNUT AND WHITE WD0077 CP0002.	SB	GC	PANELS PROVIDED BY CASEWORK VENDOR. VERTICAL REVEAL SLAT. FINISH WD0077 MAD101.
COUNTERTOP					
17800	1	COUNTERTOP - FRONTBAR CAP - 114IN 2895MM	SB	FC	FINISH CP0113 - COMPOSITE - AURORA SAN REMO. PROVIDED BY CASEWORK VENDOR.
18079	1	COUNTERTOP - POS - 75IN 1905MM	SB	FC	FINISH CP0113 - COMPOSITE - AURORA SAN REMO. PROVIDED BY CASEWORK VENDOR.
18721	1	COUNTERTOP - BREW WITH TRASH DROP - RF - 90IN 2285MM	SB	FC	FINISH CP0113 - COMPOSITE - AURORA SAN REMO. PROVIDED BY CASEWORK VENDOR.
19711	1	COUNTERTOP - WARMING - RF - 75IN 1905MM	SB	FC	FINISH CP0113 - COMPOSITE - AURORA SAN REMO. PROVIDED BY CASEWORK VENDOR.
21194	1	COUNTERTOP - ESPRESSO METRO - 114IN 2895MM	SB	FC	FINISH CP0113 - COMPOSITE - AURORA SAN REMO. PROVIDED BY CASEWORK VENDOR.
23146	1	COUNTERTOP - CBE RINSE SINK 90LB ICE BINS - RF - 152IN 3880MM	SB	FC	FINISH CP0113 - COMPOSITE - AURORA SAN REMO. PROVIDED BY CASEWORK VENDOR.
X5010	1	COUNTERTOP - HAND-OFF PLAIN	SB	FC	FINISH CP0113 - COMPOSITE - AURORA SAN REMO. PROVIDED BY CASEWORK VENDOR.
X5012	1	BACKSPLASH - HAND-OFF PLAIN	SB	GC	FINISH CP0113 - COMPOSITE - AURORA SAN REMO. PROVIDED BY CASEWORK VENDOR.
DIEWALL					
17760	1	DIEWALL - ESPRESSO - 114IN 2895MM	SB	FC	PROVIDED BY CASEWORK VENDOR.
18080	1	DIEWALL - POS - 75IN 1905MM	SB	FC	PROVIDED BY CASEWORK VENDOR.
24314	3	DIEWALL - VARIABLE LENGTH	SB	FC	PROVIDED BY CASEWORK VENDOR.
FIT KIT					
X5014	1	FIT KIT - CABINET FILLER PANEL	SB	FC	PROVIDED BY CASEWORK VENDOR.
X5015	1	CABINET - CORNER FIT KIT	SB	FC	PROVIDED BY CASEWORK VENDOR.
OTHER					
11130	2	CORNER GUARD - 0.375IN 10MM - ANODIZED ALUMINUM	GC	GC	
11142	2	CORBEL SUPPORT - 24IN 610MM	SB	FC	PROVIDED BY CASEWORK VENDOR.
11155	2	ESPRESSO MACHINE PUMP MOUNT - 10X10IN 255X255MM	SB	FC	PROVIDED BY CASEWORK VENDOR.
17767	1	SNEEZE GUARD - 114IN 2895MM	SB	FC	PROVIDED BY CASEWORK VENDOR.
18126	1	SHROUD - 114IN 2895MM	SB	FC	FINISH CP0113 - COMPOSITE - AURORA SAN REMO. PROVIDED BY CASEWORK VENDOR.
18145	3	COUNTERTOP SUPPORT LEG	SB	FC	PROVIDED BY CASEWORK VENDOR.
20633	1	COUNTERTOP SUPPORT LEG SLIM	SB	FC	PROVIDED BY CASEWORK VENDOR.
X5008	2	WOOD CAP - 1'X8'X1 1/2" - WALNUT - WDOO77	SB	GC	PROVIDED BY CASEWORK VENDOR.
X5009	4	CARAMEL BROWN LEATHER - F0008 - SHELF SUPPORT STRAP - 1IN	SB	GC	PROVIDED BY CASEWORK VENDOR.
X5013	1	CUSTOM SHELF - 3'6" X 4" X 1'	SB	GC	FINISH: WD077 - WALNUT. PROVIDED BY CASEWORK VENDOR. ALL DIMENSIONS TO BE VERIFIED ON SITE.
X5016	4	WALL COVERING CORNER FRY REGLET	SB	GC	PROVIDED BY CASEWORK VENDOR. CORNER WALLCOVERING FRY REGLET FINISH: WINCHESTER BROWN
X5018	1	CUSTOM SHELF - 4'11" X 4" X 1'	SB	GC	FINISH: WD077 - WALNUT. PROVIDED BY CASEWORK VENDOR. ALL DIMENSIONS TO BE VERIFIED ON SITE.
x5019	1	PLAM PANELS AT ENTRANCE	SB	GC	
x5020	1	WALL PANELS AT CAFE			
PANEL					
17783	1	PANEL - 114IN 2895MM	SB	GC	FINISH: PLAM - PL0051 - WALNUT WOODGRAIN. PROVIDED BY CASEWORK VENDOR.
18081	1	PANEL - 75IN 1905MM	SB	GC	FINISH: PLAM - PL0051 - WALNUT WOODGRAIN. PROVIDED BY CASEWORK VENDOR.
24311	2	FINISH PANEL - HOS - VARIABLE LENGTH	SB	GC	FINISH: PLAM - PL0051 - WALNUT WOODGRAIN. PROVIDED BY CASEWORK VENDOR.
X5011	1	FINISH PANEL - HAND-OFF PLAIN	SB	GC	FINISH: PLAM - PL0051 - WALNUT WOODGRAIN. PROVIDED BY CASEWORK VENDOR.
TRIM					
X5000	24	CUSTOM WOOD TRIM - 1X1IN 25.4X25.4M	SB	GC	FINISH: WD077 - WALNUT. PROVIDED BY CASEWORK VENDOR. ALL DIMENSIONS TO BE VERIFIED ON SITE.
X5001	16	CUSTOM WOOD TRIM - 1 1/2 X1/2IN 38.1X12.7MM	SB	GC	FINISH TO MATCH X5019 PLAM AT THE ENTRANCE. PROVIDED BY CASEWORK VENDOR. ALL DIMENSIONS TO BE VERIFIED ON SITE.
X5002	4	CUSTOM WOOD TRIM - 1X1IN 25.4X25.4MM	SB	GC	FINISH: SW 7032 - WARM STONE. PROVIDED BY CASEWORK VENDOR. ALL DIMENSIONS TO BE VERIFIED ON SITE.
X5003	4	CUSTOM WOOD TRIM - 1X1IN 25.4X25.4MM	SB	GC	FINISH: SW 7032 - WARM STONE. PROVIDED BY CASEWORK VENDOR. ALL DIMENSIONS TO BE VERIFIED ON SITE.
X5004	6	CUSTOM WOOD TRIM - 1X1IN 25.4X25.4MM	SB	GC	FINISH: HC-188 - ESSEX GREEN. PROVIDED BY CASEWORK VENDOR. ALL DIMENSIONS TO BE VERIFIED ON SITE.
X5005	6	CUSTOM WOOD TRIM - 1X1IN 25.4X25.4MM	SB	GC	FINISH: HC-188 - ESSEX GREEN. PROVIDED BY CASEWORK VENDOR. ALL DIMENSIONS TO BE VERIFIED ON SITE.
X5006	20	CUSTOM WOOD TRIM - 1/2X1/2IN 12.7X12.7MM	SB	FC	FINISH: WD077 - WALNUT. PROVIDED BY CASEWORK VENDOR. ALL DIMENSIONS TO BE VERIFIED ON SITE.
X5007	19	WOOD TRIM - 1/2IN X 1/2IN 12.7X12.7MM	SB	FC	FINISH: WD077 - WALNUT. PROVIDED BY CASEWORK VENDOR. ALL DIMENSIONS TO BE VERIFIED ON SITE.


CASEWORK FINISH SCHEDULE			
ENGINE ZONE	MATERIAL DESCRIPTION	FINISH CODE	COMMENTS
COMPOSITE - TBD			
COUNTERTOPS - BACKBAR	COMPOSITE - TBD	CP0113	CORIAN FINISH TBD. SB DM TO APPROVE WITH CASEWORK VENDOR.
COUNTERTOPS - ESPRESSO	COMPOSITE - TBD	CP0113	CORIAN FINISH TBD. SB DM TO APPROVE WITH CASEWORK VENDOR.
COUNTERTOPS - FRONTBAR	COMPOSITE - TBD	CP0113	CORIAN FINISH TBD. SB DM TO APPROVE WITH CASEWORK VENDOR.
COUNTERTOPS - SHROUD	COMPOSITE - TBD	CP0113	CORIAN FINISH TBD. SB DM TO APPROVE WITH CASEWORK VENDOR.
METAL - ALUMINUM - BRUSHED			
CABINETS - UNDERCOUNTER	METAL - ALUMINUM - BRUSHED		
METAL - FLAT BLACK POWDERCOAT			
CABINETS - DOOR PULL	METAL - FLAT BLACK POWDERCOAT	MT0028	
CABINETS - UNDERCOUNTER	METAL - FLAT BLACK POWDERCOAT	MT0028	
METAL - STAINLESS STEEL - BRUSHED			
CABINETS - CABINET LEG	METAL - STAINLESS STEEL - BRUSHED	#4 BRUSHED 16GA	
CABINETS - UNDERCOUNTER ICE BIN	METAL - STAINLESS STEEL - BRUSHED	#4 BRUSHED 16GA	
PLAM - ALMOND			
CABINETS - UNDERCOUNTER	PLAM - ALMOND		
PLAM - MOTTLED BLACK			
CABINETS - UNDERCOUNTER	PLAM - MOTTLED BLACK	PL0019	
PLAM - WALNUT WOODGRAIN			
FINISH PANELS - FRONTBAR	PLAM - WALNUT WOODGRAIN	PL0051	
FINISH PANELS - HANDOFF	PLAM - WALNUT WOODGRAIN	PL0051	
PLASTIC - BLACK			
CABINETS - UNDERCOUNTER	PLASTIC - BLACK		
PLASTIC LAMINATE - LAVA			
CABINETS - UNDERCOUNTER	PLASTIC LAMINATE - LAVA	PL0053	
COUNTERTOPS - BACKBAR	PLASTIC LAMINATE - LAVA	PL0053	
WOOD - WALNUT			
SHELVING	WOOD - WALNUT	WD0077	

ARCHITECT OF RECORD:

 
THOMAS E. MORGAN, JR.
ARCHITECT



 423 FISCHER TRAIL
ELLIJAY, GEORGIA 30540



SEAL:

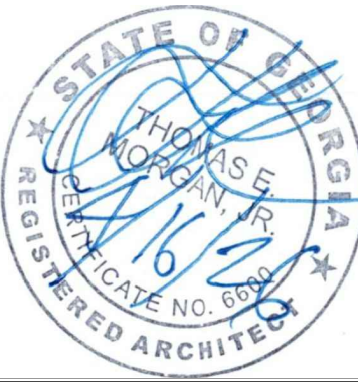

3450 Acworth Due West Road
Building 100, Suite 120
Kennesaw, Georgia 30144
P. 770-917-9172
F. 770-917-9470
www.mrpdesign.com

RELEASED FOR
CONSTRUCTION

ISSUES / REVISIONS:

DATE	DESCRIPTION
05.04.26	RELEASE FOR CONSTRUCTION

DRAWN BY: JB

CHKD BY: TM

PROJECT DESCRIPTION:

NEW CONSTRUCTION OF A TA TRAVEL CENTER IN JEFFERSONVILLE, GA, WHICH CONSISTS OF A TRUCKER LOUNGE, SHOWERS, LAUNDRY ROOM, RETAIL AREA, RESTROOMS, GAME AREA, SEATING AREAS, AND FOUR QUICK-SERVICE RESTAURANTS. THE MAJORITY OF THE PROJECT HAS ALREADY BEEN SUBMITTED. THIS ISSUE, DATED 05.04.26 HAS MODIFICATIONS RELATED TO THE ADDITION OF THE STARBUCKS QSR.

PROJECT TITLE:

TRAVEL CENTER
4838 SR 96
JEFFERSONVILLE,
GEORGIA 31044

SHEET TITLE:


CASEWORK
SCHEDULES

PROJECT NO: 25021

1102.1

FOR REFERENCE ONLY

THESE PLANS ARE THE PROPERTY OF MRP DESIGN GROUP, INC. AND ARE SUBJECT TO FEDERAL COPYRIGHT LAWS. ANY USE OF SAME WITHOUT THE EXPRESS WRITTEN PERMISSION OF MRP DESIGN GROUP, INC. IS STRICTLY PROHIBITED.

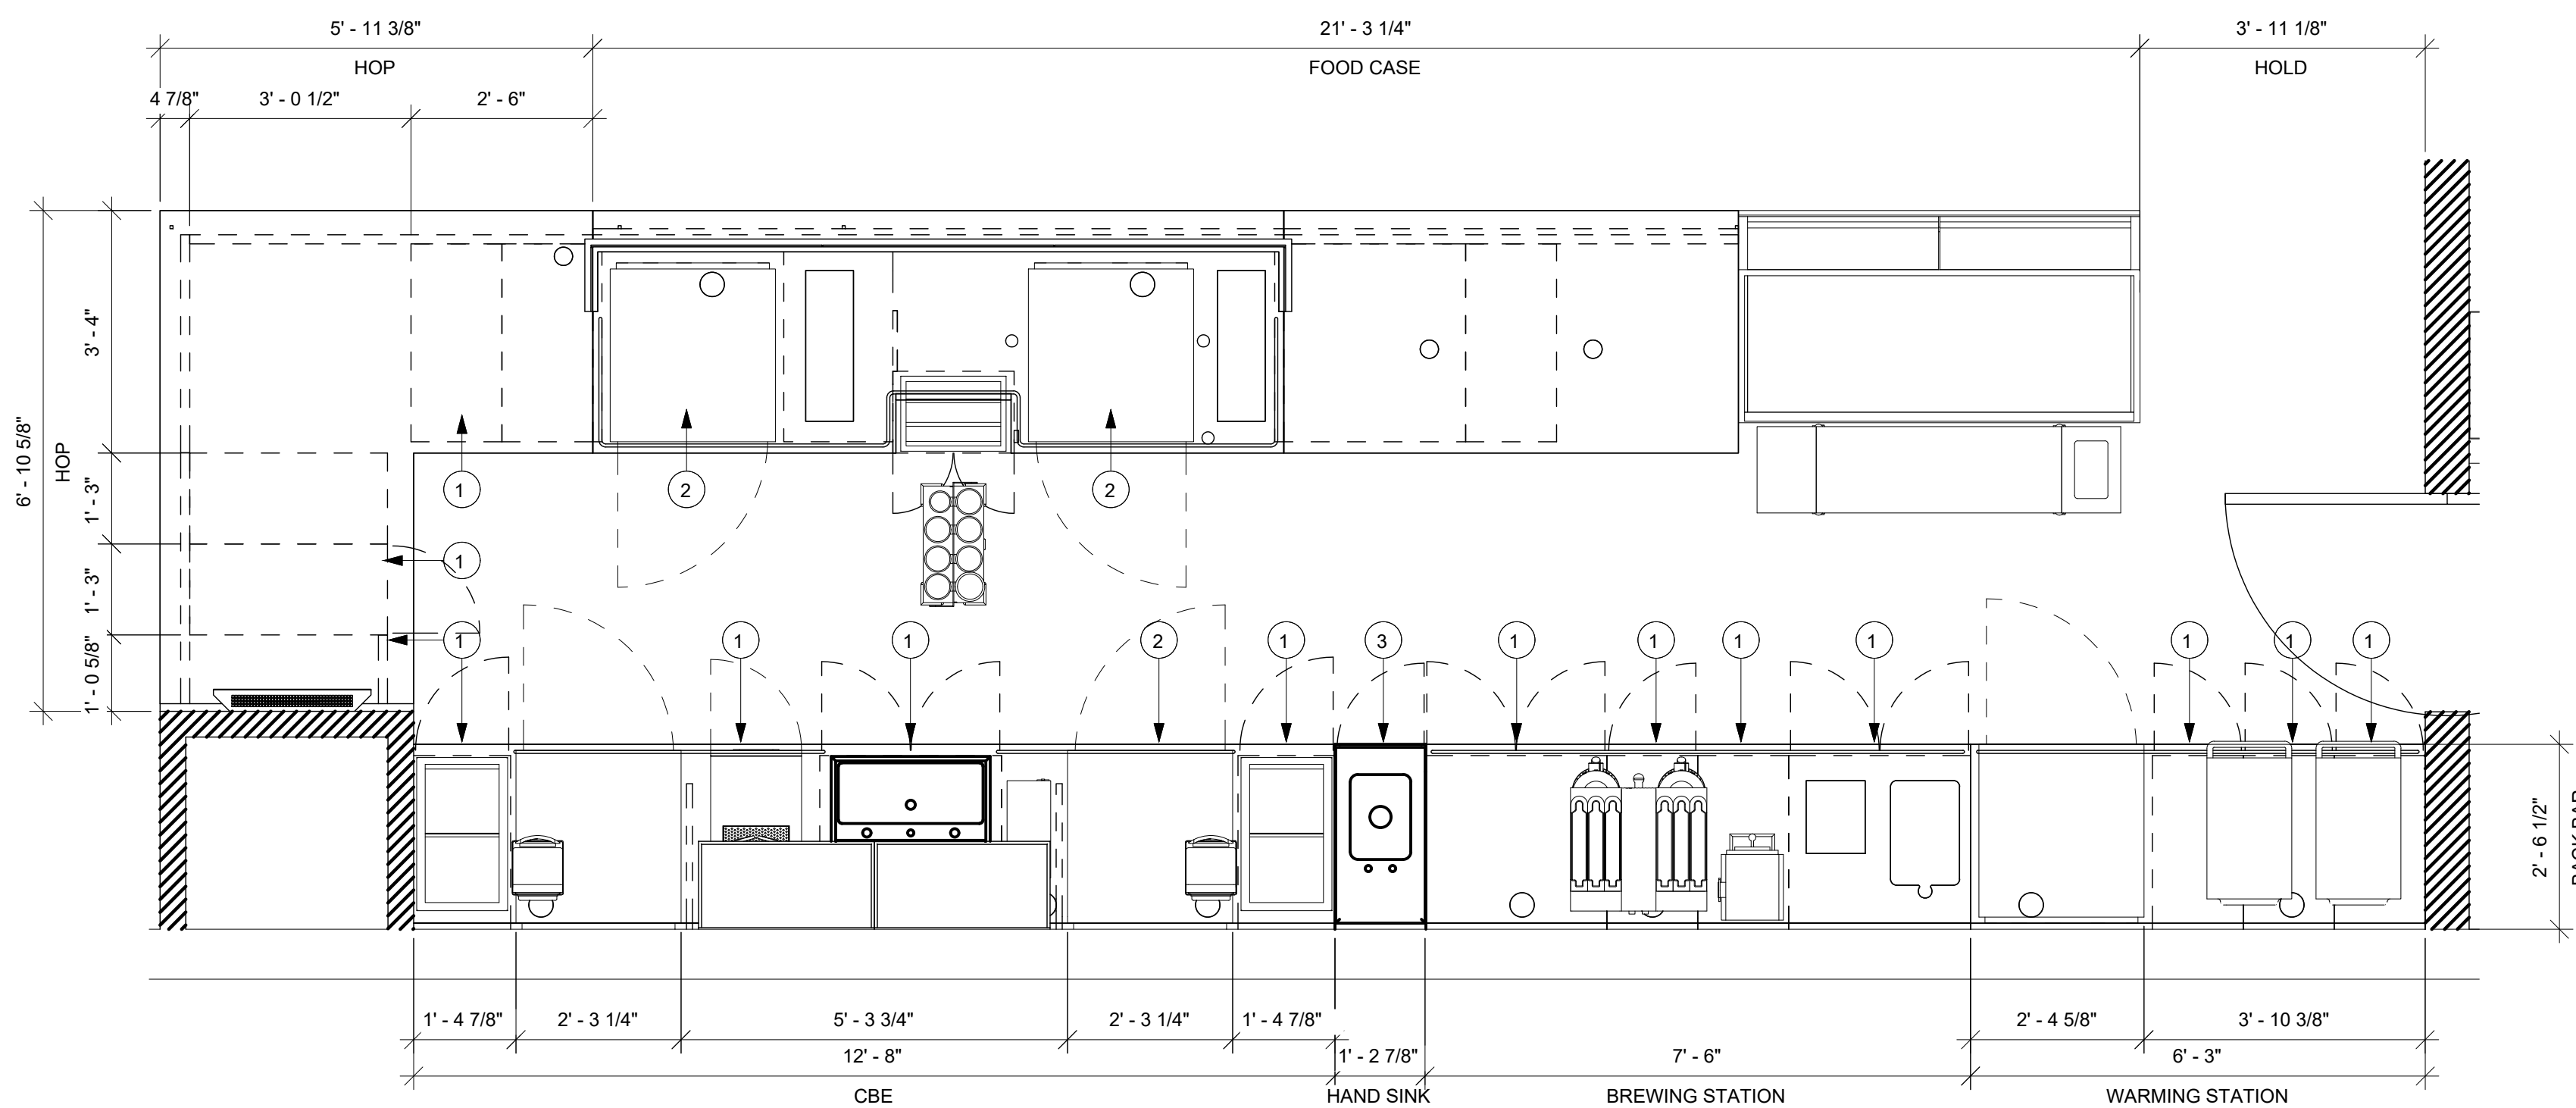

01 ENLARGED BAR / ENGINE PLAN
Scale: 1/2" = 1'-0"

KEYED NOTES

- ITEMS TO BE LOCATED BELOW COUNTER. REFERENCE INTERIOR ELEVATIONS.
- GC TO REVERSE HINGE UNDERCOUNTER REFRIGERATOR TO LEFT HAND SWING AS SHOWN.
- HAND SINK WITH INTEGRAL SPLASH GUARD. HAND SINK TO HAVE SOAP AND SINGLE SERVICE TOWEL DISPENSERS.

GENERAL NOTES


- GENERAL CONTRACTOR TO SCHEDULE WITH LOCAL REFRIGERATION CONTRACTOR TO CONDUCT INITIAL FOOD CASE STARTUP AND TESTING. FOR LIST OF APPROVED START UP CONTRACTORS, CONTACT PROJECT CONSTRUCTION REPRESENTATIVE.
- THE SITE IS SERVED BY THE MUNICIPAL WATER AND SEWER SYSTEM UNLESS OTHERWISE NOTED.
- ALL FOOD STORAGE SHALL BE 6" (150MM) A.F.F.
- ALL WOOD SURFACES (DOORS, TRIM, SHELVES, CABINETS) SHALL BE SEALED.
- ALL EQUIPMENT AND INSTALLATION WILL MEET NATIONAL SANITATION FOUNDATION STANDARDS OR EQUIVALENT.
- ALL EQUIPMENT AND CABINETRY WILL BE FLUSH MOUNTED TO COUNTERS, WALLS OR FLOORS, OR BE RAISED TO ALLOW FOR CLEANING.
- CONFIRM ALL NECESSARY EQUIPMENT CLEARANCES PER PRODUCT CUT SHEET (E.G. ICE MACHINE).
- FOR LOCATION OF COUNTERTOP EQUIPMENT, REFER TO CASEWORK ELECTRICAL DETAILS.
- EQUIPMENT UNITS SHALL CONTAIN NO EXPOSED THREADS, EMBELLISHMENTS OR OVERHANGING EDGES THAT SERVE AS PLACES FOR ACCUMULATION OF DUST, DIRT AND DEBRIS.
- WARMING OVEN(S) SHOWN FOR PERMITTING PURPOSES. INSTALLATION AT STORE OPENING TO BE VERIFIED BY STARBUCKS CONSTRUCTION REPRESENTATIVE.
- EACH HAND WASHING SINK WILL HAVE A SINGLE SERVICE TOWEL AND SOAP DISPENSER, AND ALL HAND SINKS TO HAVE A COMBINATION FAUCET OR PREMIXING FAUCET.
- FOR PLUMBING FIXTURES, REFER TO THE PLUMBING DESIGN PLAN. FOR DATA DEVICE SCHEDULE, REFER TO THE ELECTRICAL DESIGN PLAN.
- SEE ELEVATIONS FOR DISTRIBUTION OF CUP DISPENSERS.
- PROVIDE FIRE EXTINGUISHERS AS NOTED ON THE APPROVED PLANS FROM THE LOCAL JURISDICTION.

ARCHITECT OF RECORD:

THOMAS E. MORGAN, JR.
ARCHITECT

423 FISCHER TRAIL
ELLIJIAY, GEORGIA 30540

SEAL:

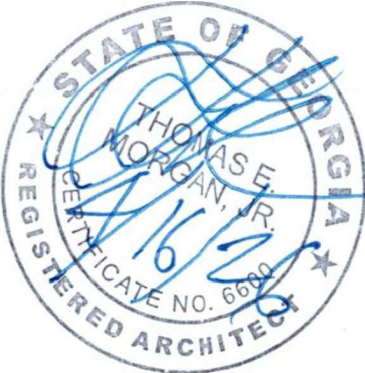

MRP
DESIGN GROUP

3450 Acworth Due West Road
Building 100, Suite 120
Kennesaw, Georgia 30144
P. 770-917-9172
F. 770-917-9470
www.mrpdesign.com

RELEASED FOR
CONSTRUCTION

ISSUES / REVISIONS:

DATE	DESCRIPTION
05.04.26	RELEASE FOR CONSTRUCTION

DRAWN BY: JB

CHKD BY: TM

PROJECT DESCRIPTION:

NEW CONSTRUCTION OF A TA TRAVEL CENTER IN JEFFERSONVILLE, GA, WHICH CONSISTS OF A TRUCKER LOUNGE, SHOWERS, LAUNDRY ROOM, RETAIL AREA, RESTROOMS, GAME AREA, SEATING AREAS, AND FOUR QUICK-SERVICE RESTAURANTS. THE MAJORITY OF THE PROJECT HAS ALREADY BEEN SUBMITTED. THIS ISSUE, DATED 05.04.26 HAS MODIFICATIONS RELATED TO THE ADDITION OF THE STARBUCKS QSR.

PROJECT TITLE:

TRAVEL CENTER
4838 SR 96
JEFFERSONVILLE,
GEORGIA 31044

SHEET TITLE:

CASEWORK
SCHEDULES

PROJECT NO: 25021

1102.3


FOR REFERENCE ONLY

THESE PLANS ARE THE PROPERTY OF MRP DESIGN GROUP, INC. AND ARE SUBJECT TO FEDERAL COPYRIGHT LAWS. ANY USE OF SAME WITHOUT THE EXPRESS WRITTEN PERMISSION OF MRP DESIGN GROUP, INC. IS STRICTLY PROHIBITED.

CASEWORK VENDOR TO PROVIDE ALL SHOP
DRAWINGS TO STARBUCKS DM AND ARCHITECT OF
RECORD FOR REVIEW PRIOR TO MANUFACTURE.


GENERAL NOTES

- A. ALL WOOD SURFACES (DOORS, TRIM, SHELVES, CABINETRY) SHALL BE SEALED.
- B. REFER TO CASEWORK FINISH SCHEDULE ON THE CASEWORK FINISH PLAN ON SHEET 1102 FOR CASEWORK FINISH MATERIAL INFORMATION.

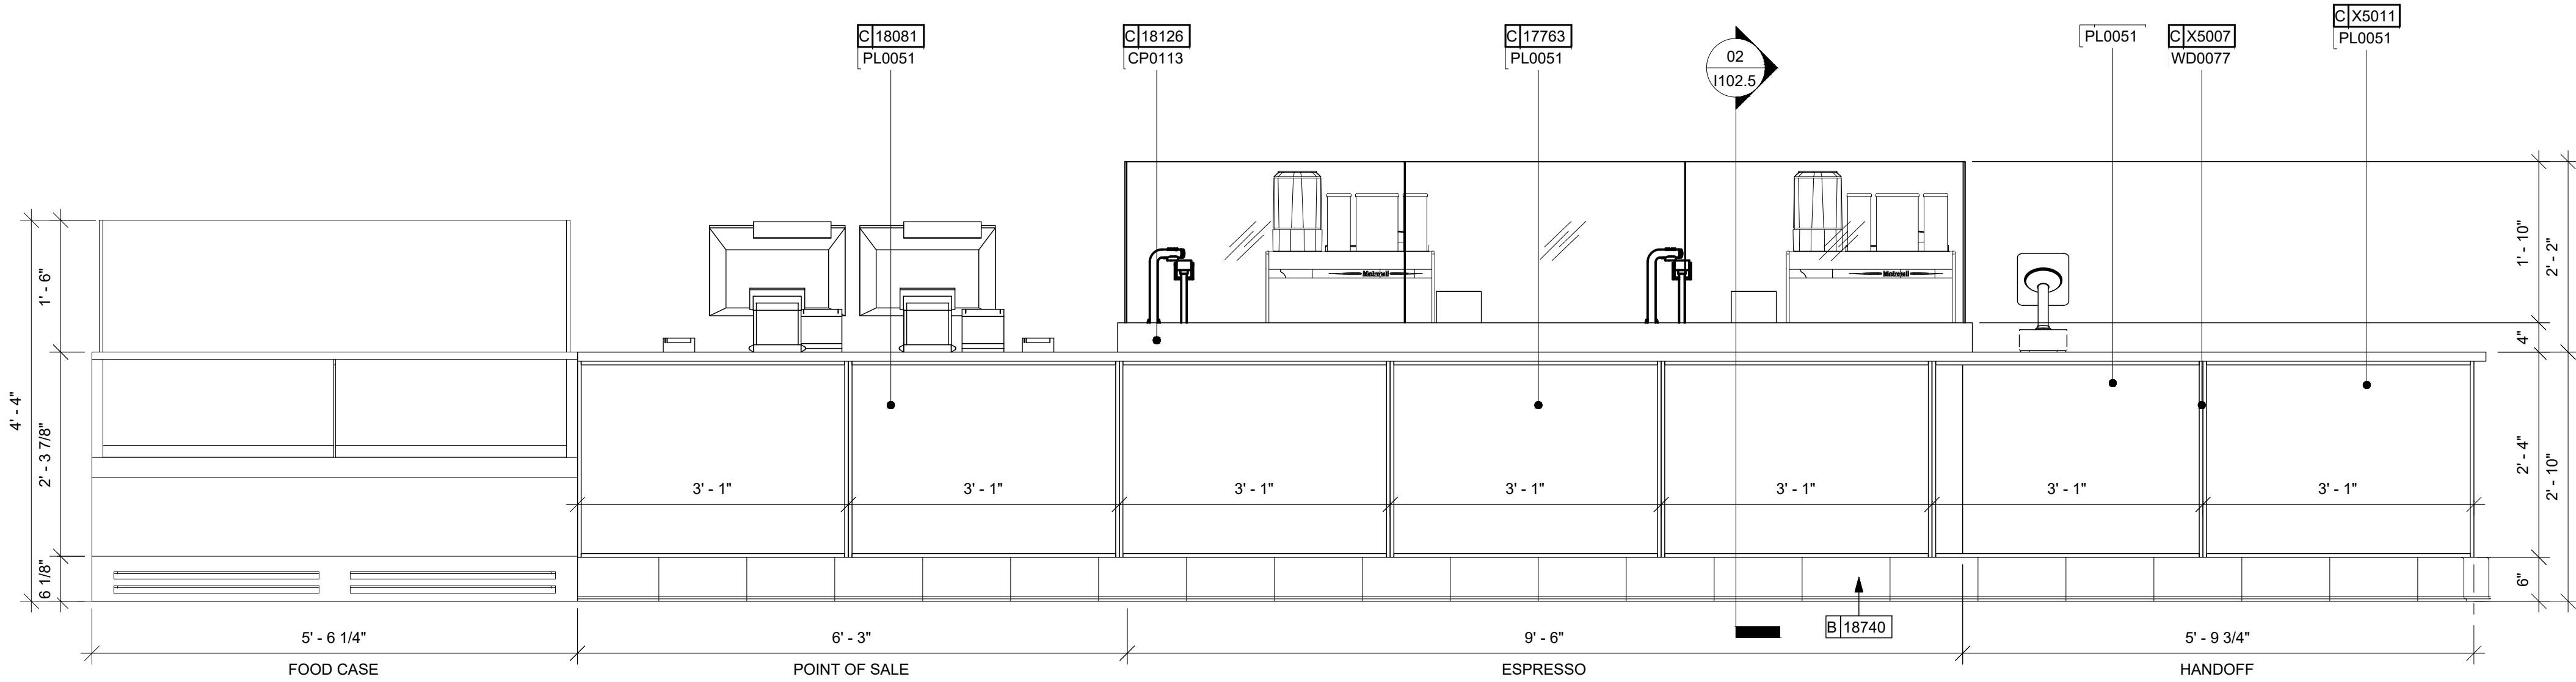



01 FRONT BAR FINISH ELEVATION

Scale: 3/4" = 1'-0"

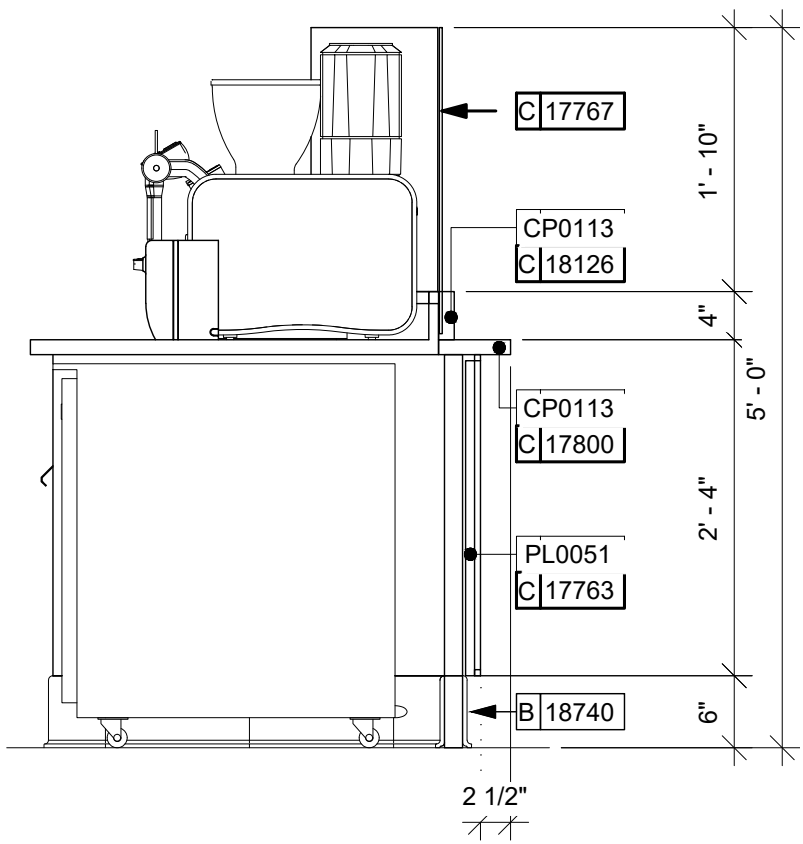


02 FRONT BAR FINISH SECTION

 Scale: 3/4" = 1'-0"

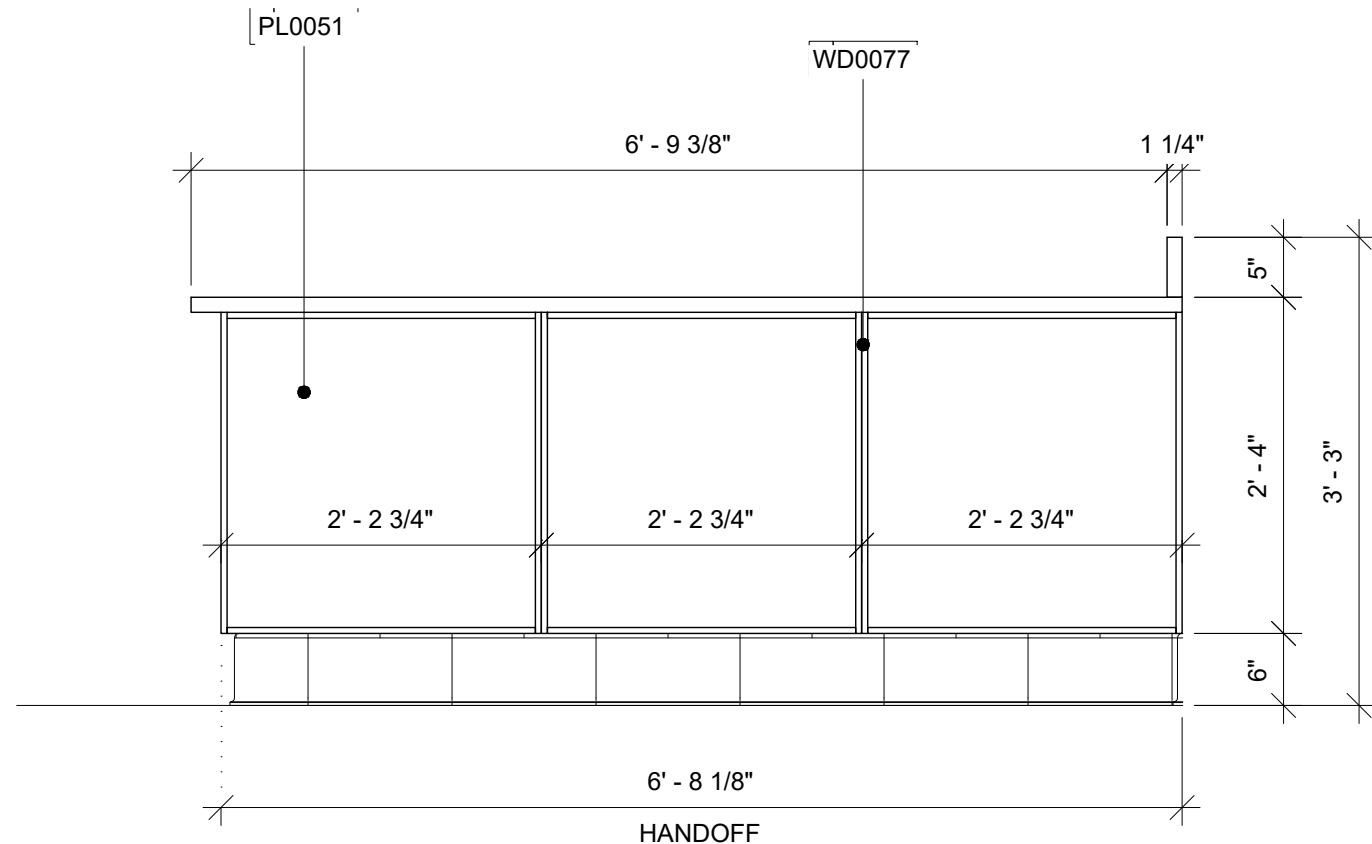

03 FRONTBAR SIDE FINISH ELEVATION

 Scale: 3/4" = 1'-0"




ARCHITECT OF RECORD:

THOMAS E. MORGAN, JR.
ARCHITECT

423 FISCHER TRAIL
ELLIJAY, GEORGIA 30540

SEAL:

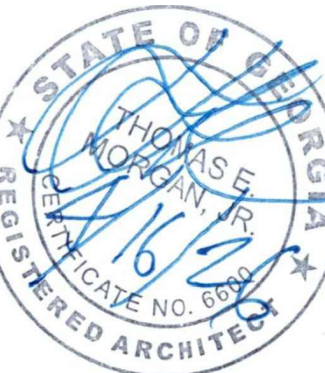

MRP
DESIGN GROUP

3450 Acworth Due West Road
Building 100, Suite 120
Kennesaw, Georgia 30144
P. 770-917-9172
F. 770-917-9470
www.mrpdesign.com

RELEASED FOR
CONSTRUCTION

ISSUES / REVISIONS:

DATE	DESCRIPTION
05.04.26	RELEASE FOR CONSTRUCTION

DRAWN BY: JB

CHKD BY: TM

PROJECT DESCRIPTION:

NEW CONSTRUCTION OF A TA TRAVEL CENTER IN JEFFERSONVILLE, GA, WHICH CONSISTS OF A TRUCKER LOUNGE, SHOWERS, LAUNDRY ROOM, RETAIL AREA, RESTROOMS, GAME AREA, SEATING AREAS, AND FOUR QUICK-SERVICE RESTAURANTS. THE MAJORITY OF THE PROJECT HAS ALREADY BEEN SUBMITTED. THIS ISSUE, DATED 05.04.26 HAS MODIFICATIONS RELATED TO THE ADDITION OF THE STARBUCKS QSR.

PROJECT TITLE:

TRAVEL CENTER
4838 SR 96
JEFFERSONVILLE,
GEORGIA 31044

SHEET TITLE:


CASEWORK
ELEVATION

PROJECT NO: 25021

1102.5


FOR REFERENCE ONLY

THESE PLANS ARE THE PROPERTY OF MRP DESIGN GROUP, INC. AND ARE SUBJECT TO FEDERAL COPYRIGHT LAWS. ANY USE OF SAME WITHOUT THE EXPRESS WRITTEN PERMISSION OF MRP DESIGN GROUP, INC. IS STRICTLY PROHIBITED.

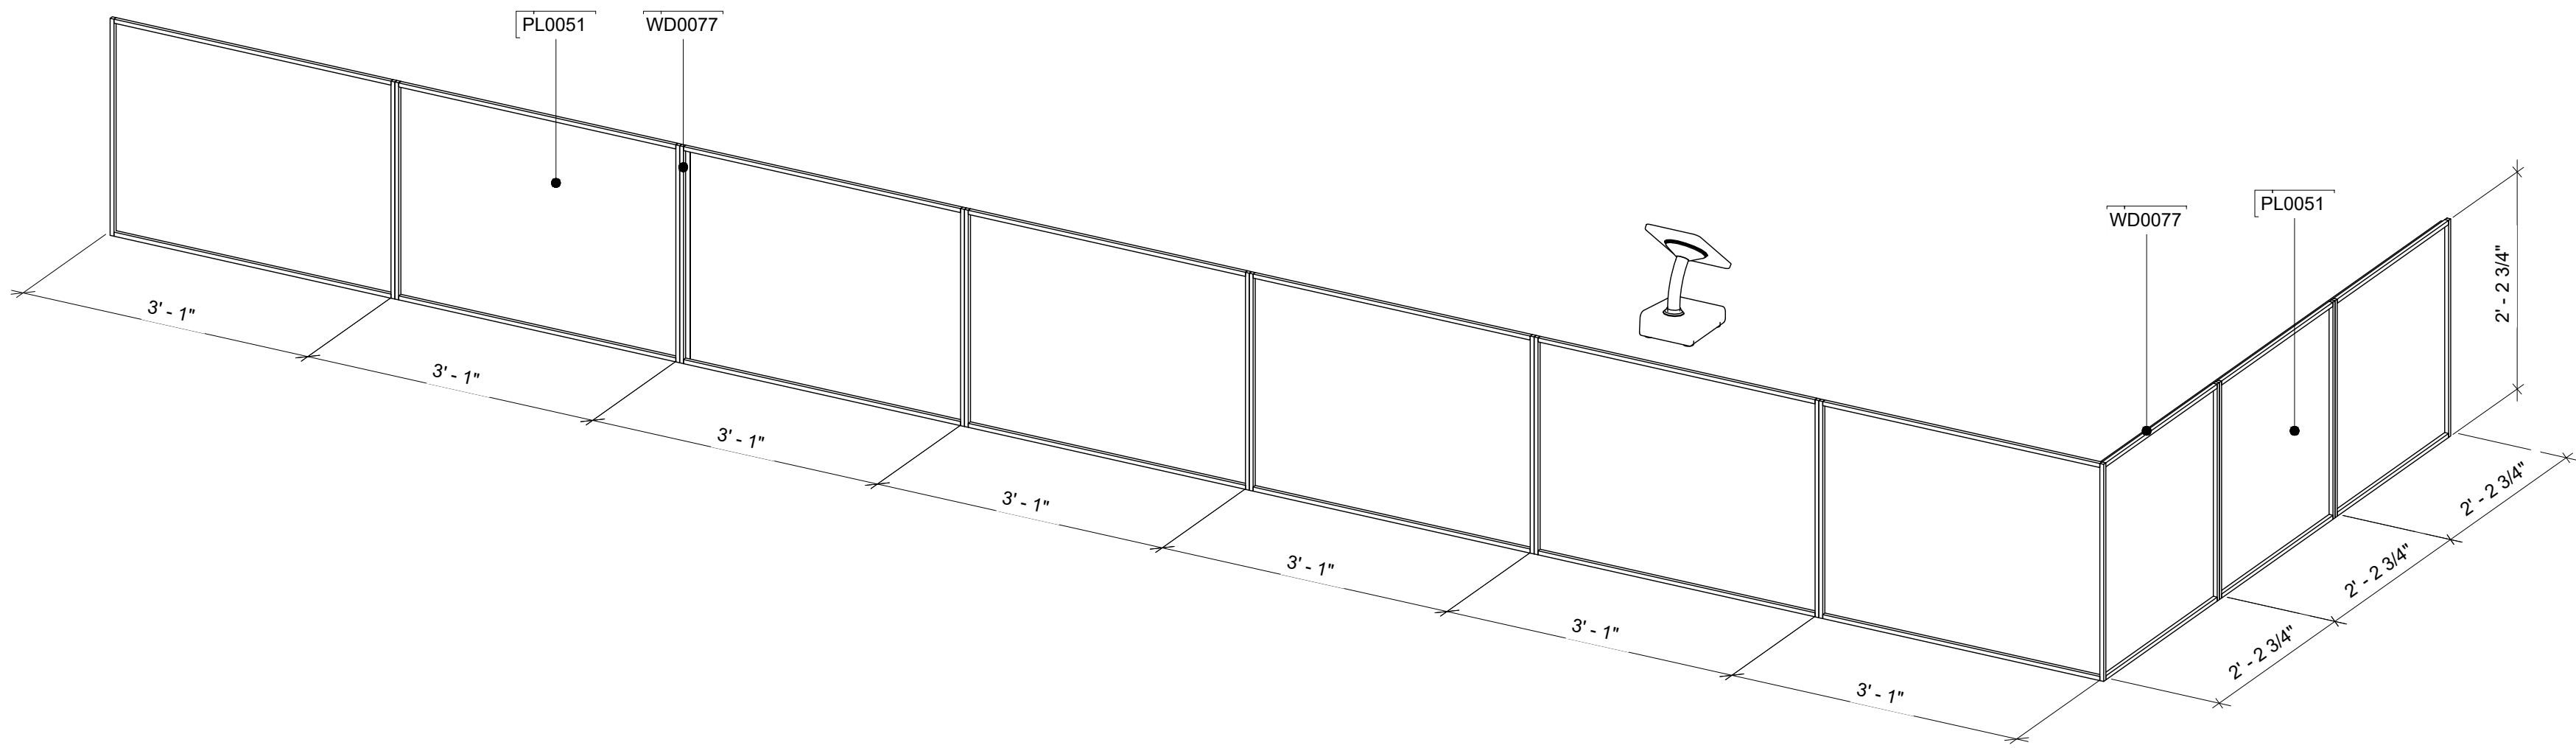


1 FRONT BAR DETAIL

Scale:

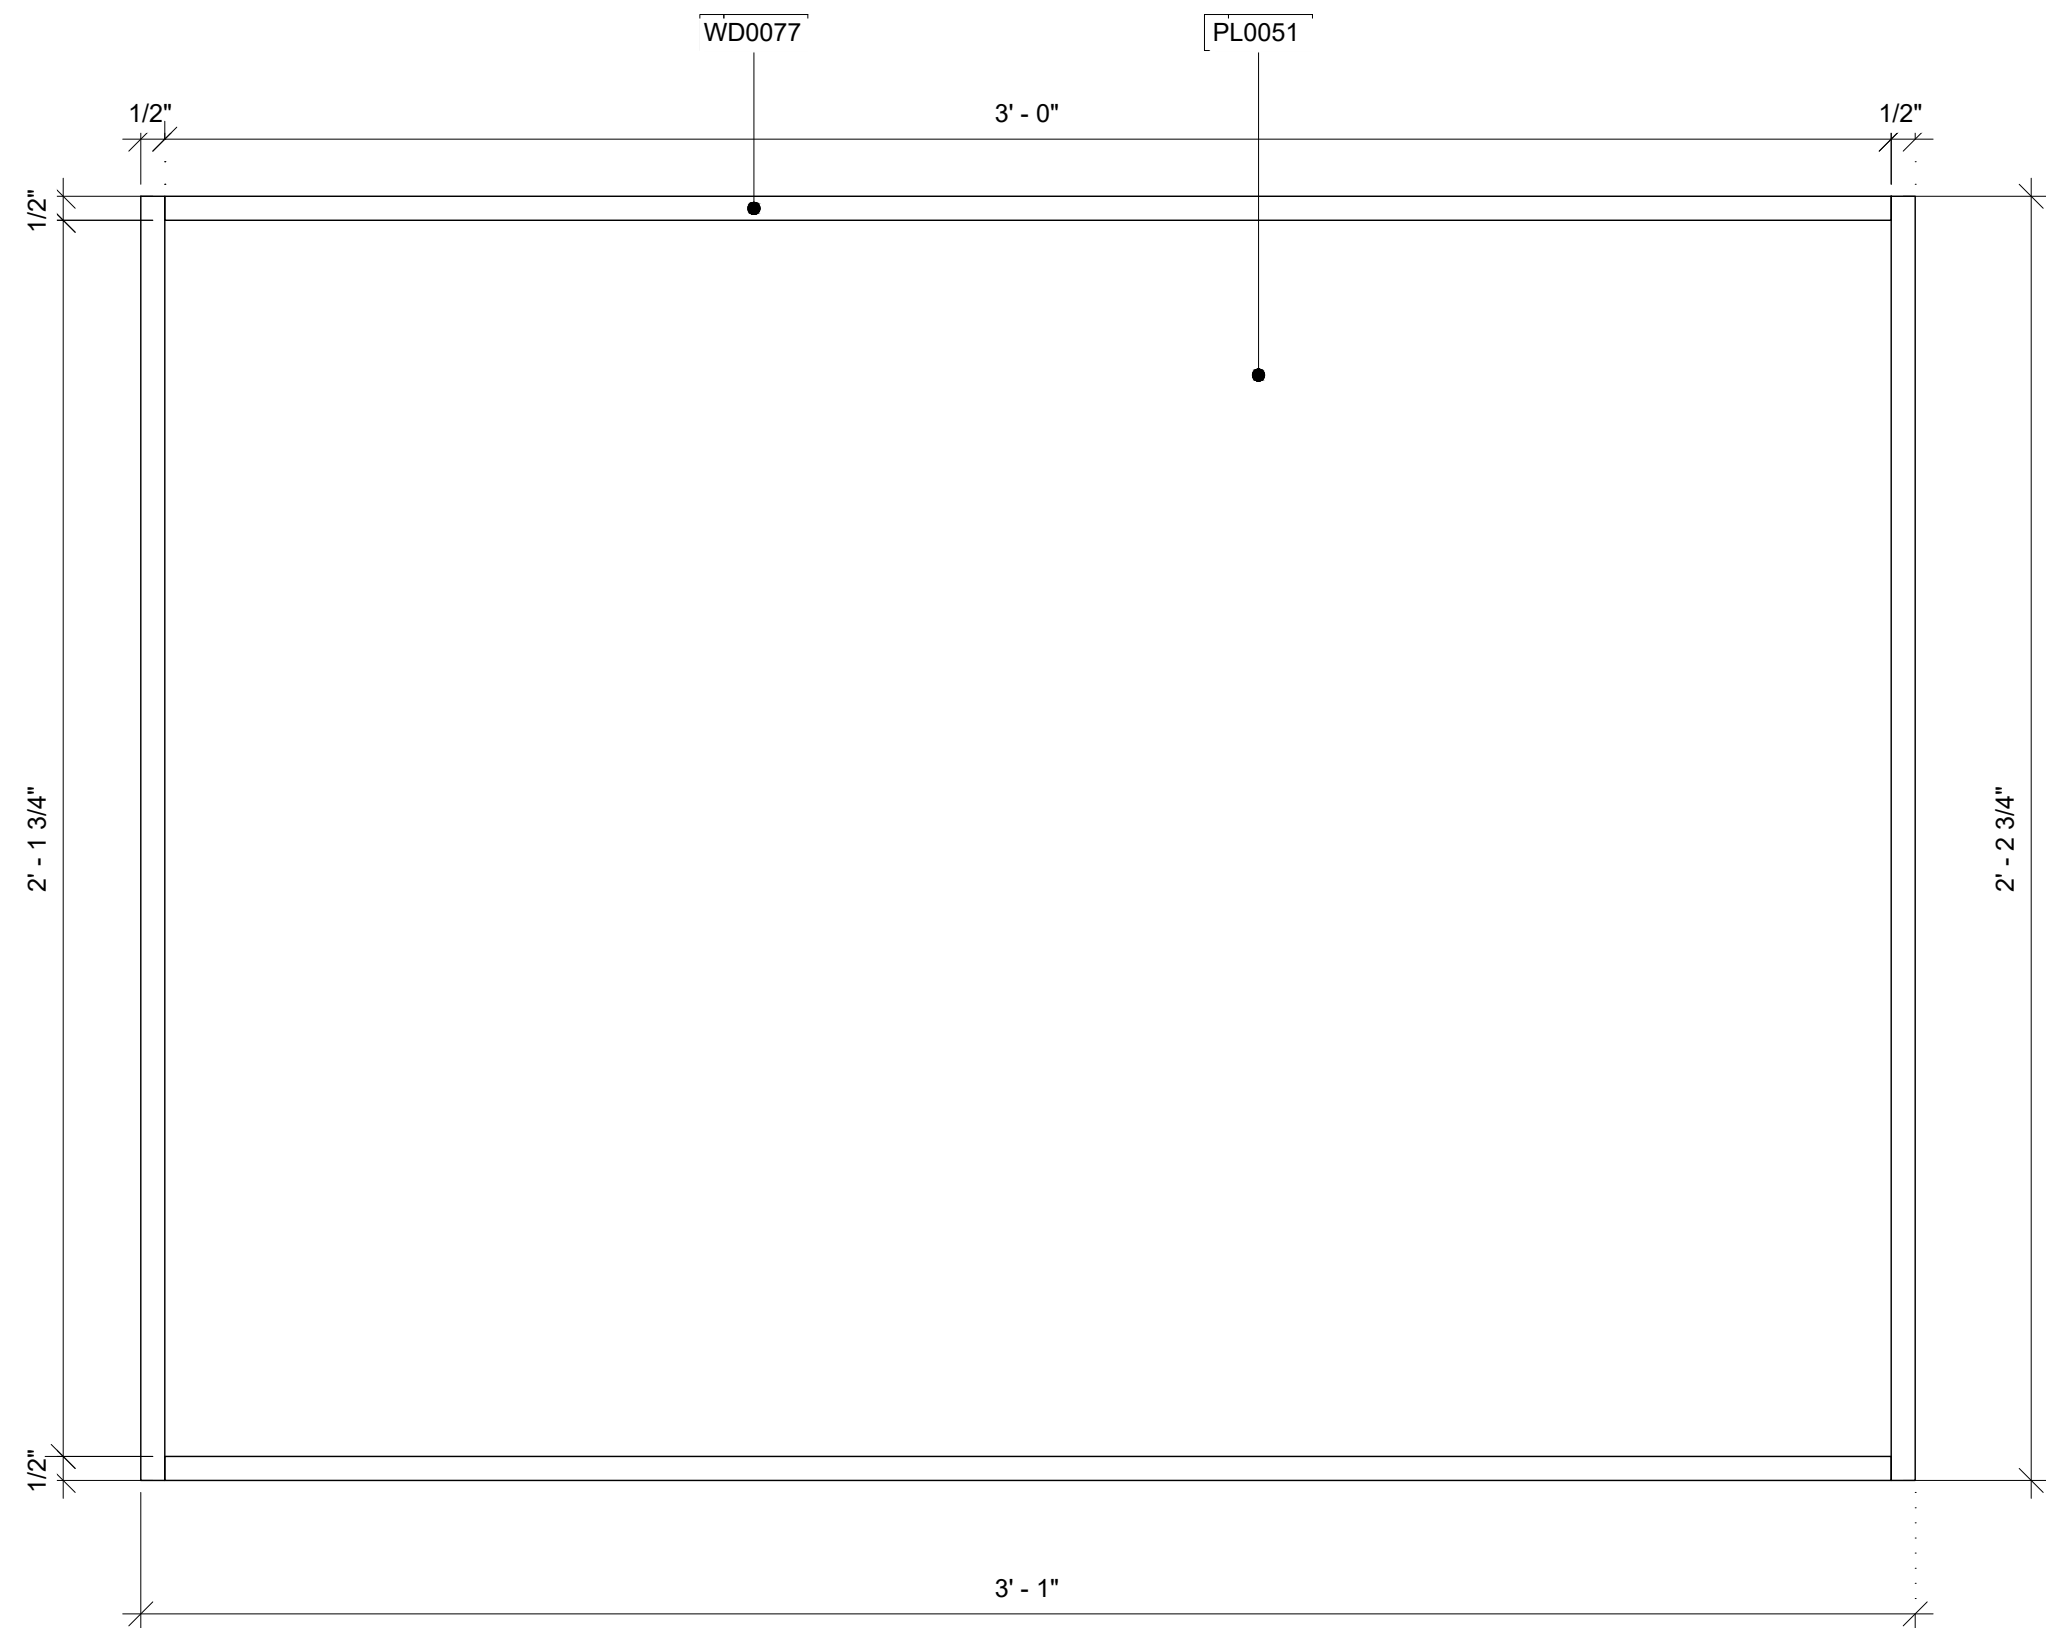

2 DETAIL PANEL AT FRONT BAR

Scale: 3" = 1'-0"

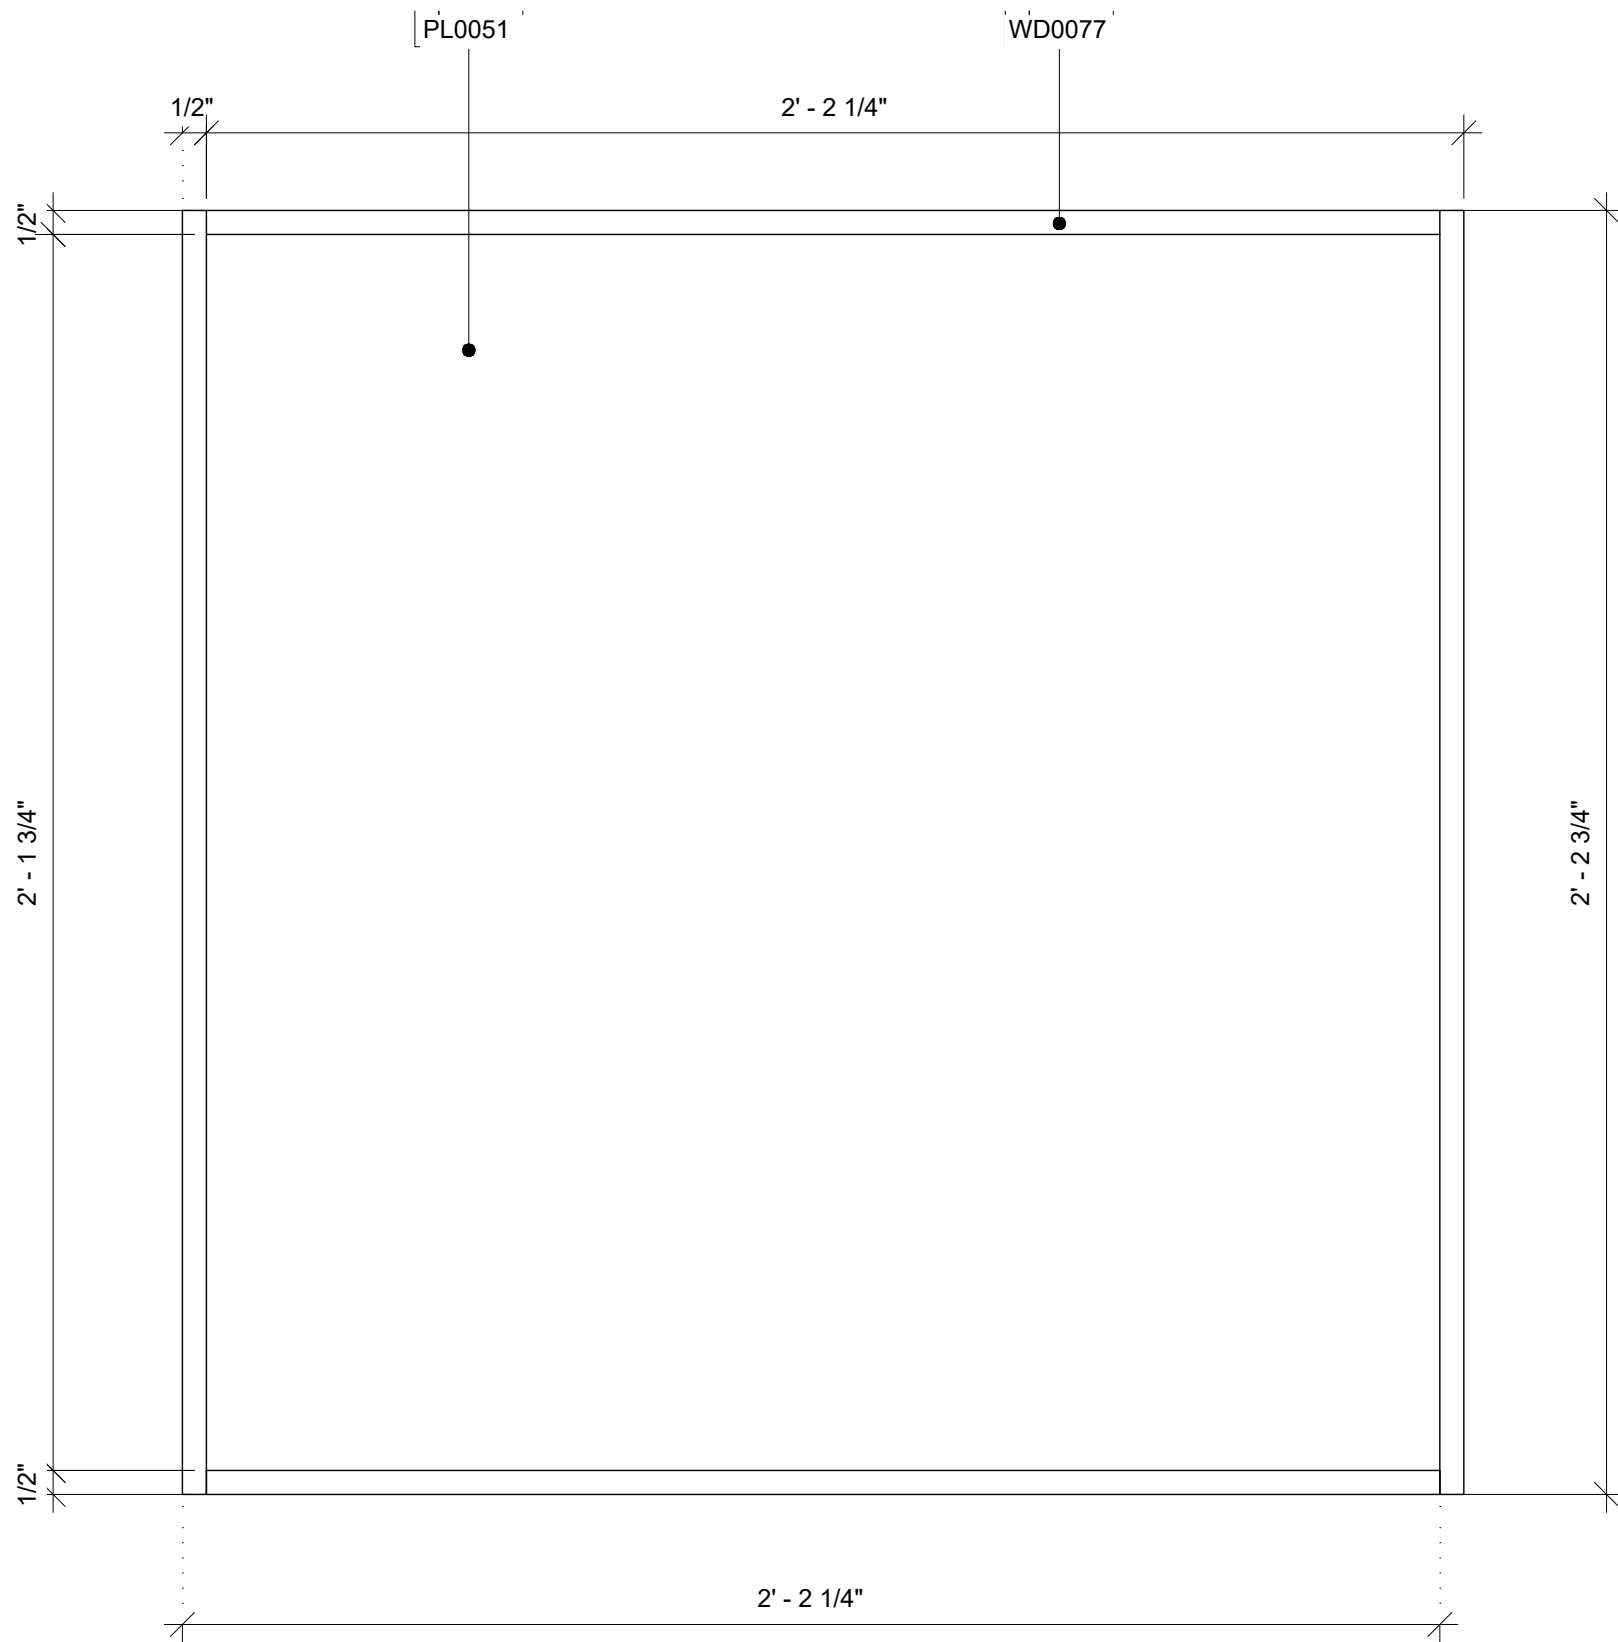

3 DETAIL PANEL AT SIDE BAR

Scale: 3" = 1'-0"

ARCHITECT OF RECORD:

THOMAS E. MORGAN, JR.
ARCHITECT

423 FISCHER TRAIL
ELLIJAY, GEORGIA 30540

SEAL:



MRP
DESIGN GROUP

3450 Acworth Due West Road
Building 100, Suite 120
Kennesaw, Georgia 30144
P. 770-917-9172
F. 770-917-9470
www.mrpdesign.com

RELEASED FOR
CONSTRUCTION

ISSUES / REVISIONS:

DATE	DESCRIPTION
05.04.26	RELEASE FOR CONSTRUCTION

DRAWN BY: JB

CHKD BY: TM

PROJECT DESCRIPTION:

NEW CONSTRUCTION OF A TA TRAVEL CENTER IN JEFFERSONVILLE, GA. WHICH CONSISTS OF A TRUCKER LOUNGE, SHOWERS, LAUNDRY ROOM, RETAIL AREA, RESTROOMS, GAME AREA, SEATING AREAS, AND FOUR QUICK-SERVICE RESTAURANTS. THE MAJORITY OF THE PROJECT HAS ALREADY BEEN SUBMITTED. THIS ISSUE, DATED 05.04.26 HAS MODIFICATIONS RELATED TO THE ADDITION OF THE STARBUCKS QSR.

PROJECT TITLE:

TRAVEL CENTER
4838 SR 96
JEFFERSONVILLE,
GEORGIA 31044

SHEET TITLE:

CASEWORK
FRONTBAR
DETAIL

PROJECT NO: 25021


1102.5.2

FOR REFERENCE ONLY

THESE PLANS ARE THE PROPERTY OF MRP DESIGN GROUP, INC. AND ARE SUBJECT TO FEDERAL COPYRIGHT LAWS. ANY USE OF SAME WITHOUT THE EXPRESS WRITTEN PERMISSION OF MRP DESIGN GROUP, INC. IS STRICTLY PROHIBITED.


3 GYP CEILING TRANSITION AT CAFE

Scale: 3" = 1'-0"

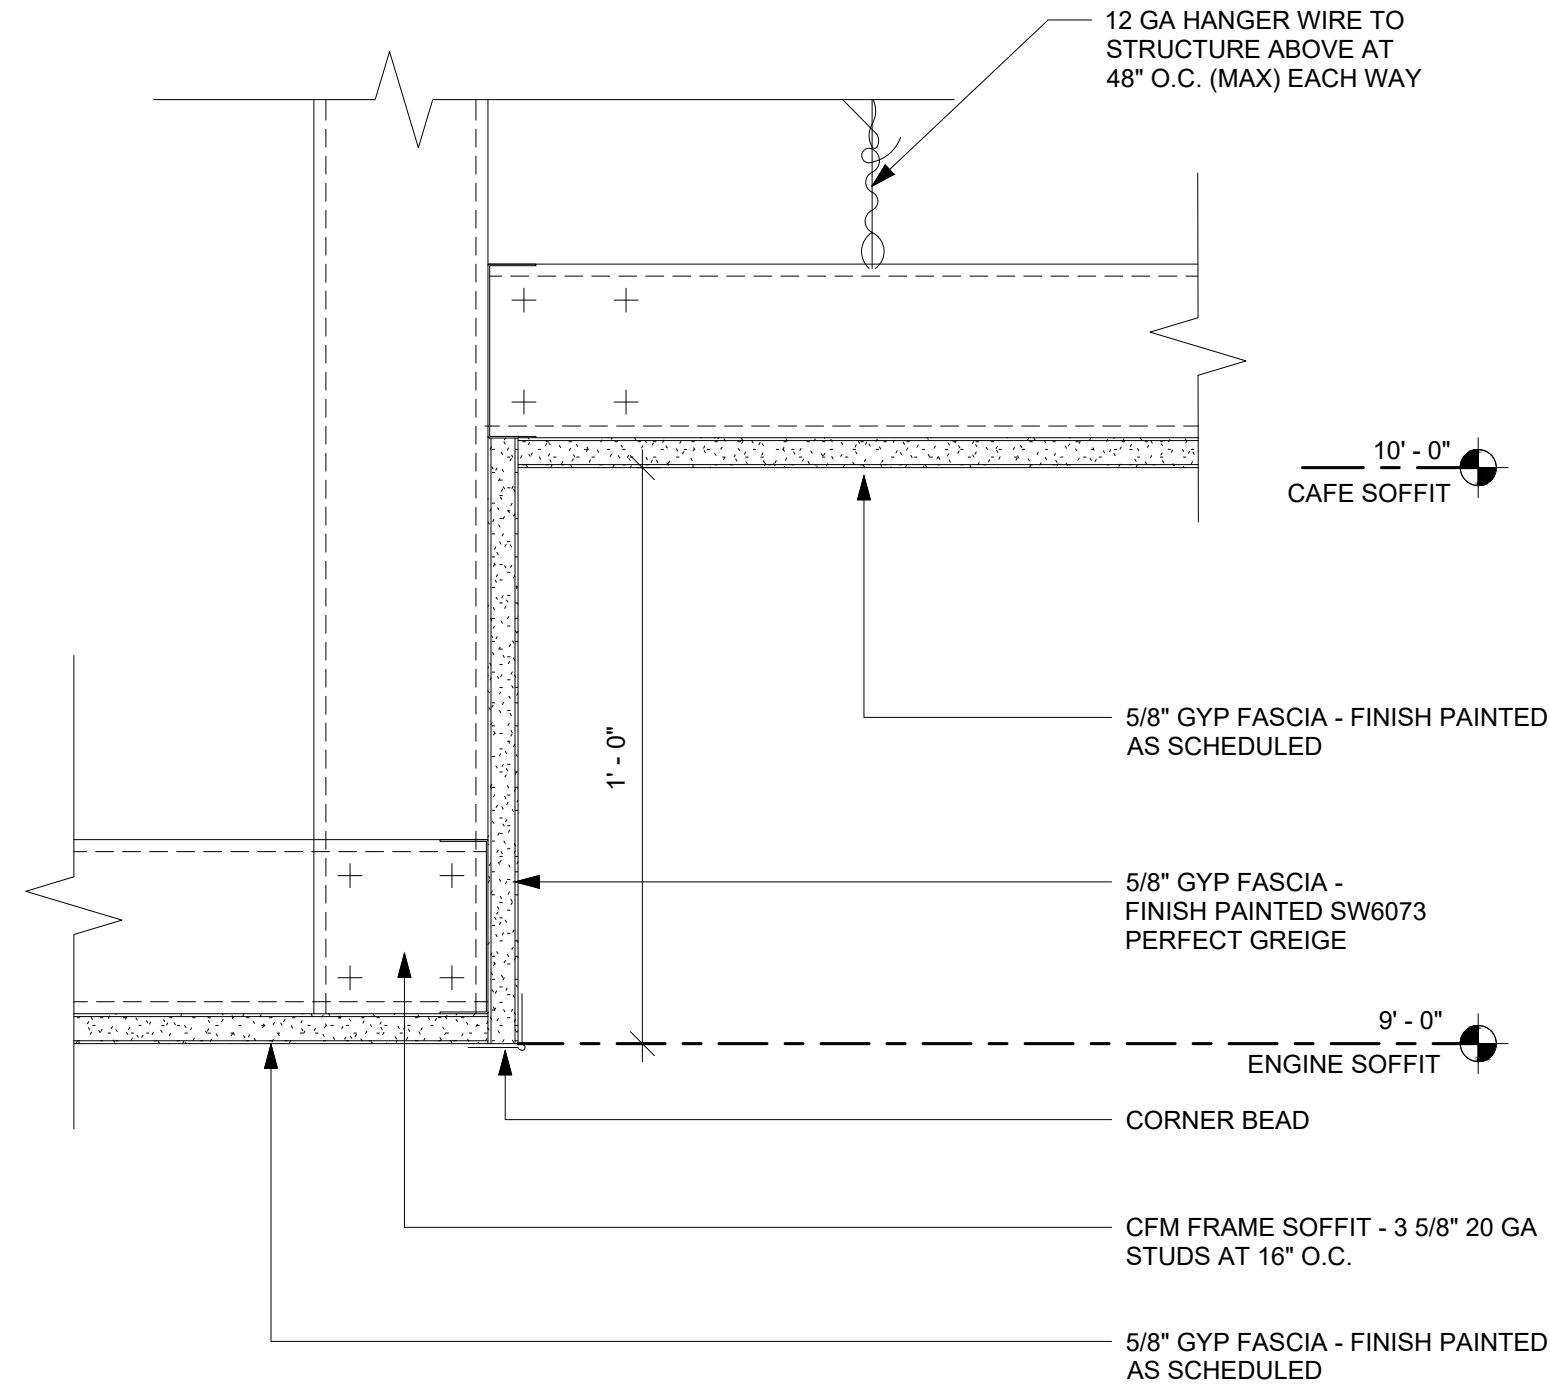


01 ACT CEILING TRANSITION AT CAFE

Scale: 3" = 1'-0"

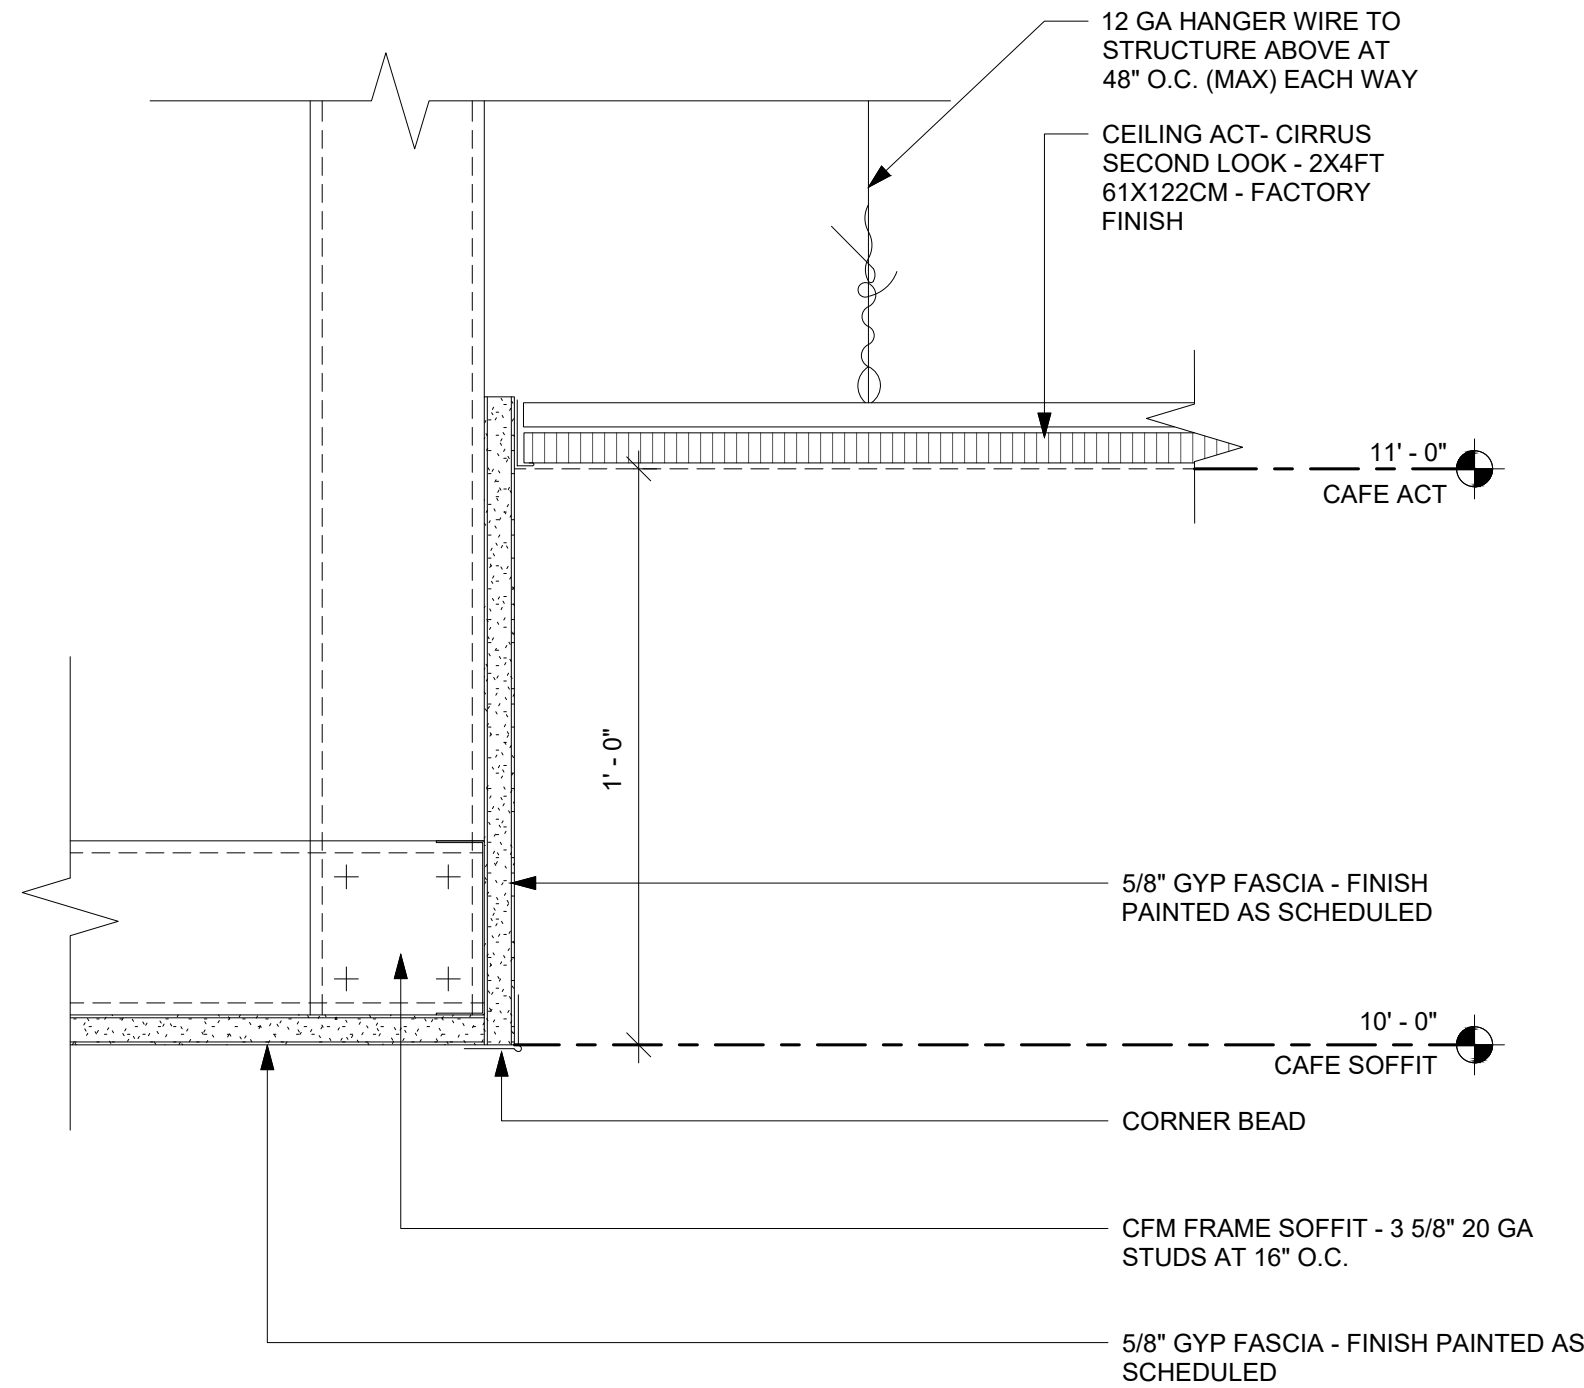

02 LIGHTING DIMENSION PLAN

Scale: 1/4" = 1'-0"

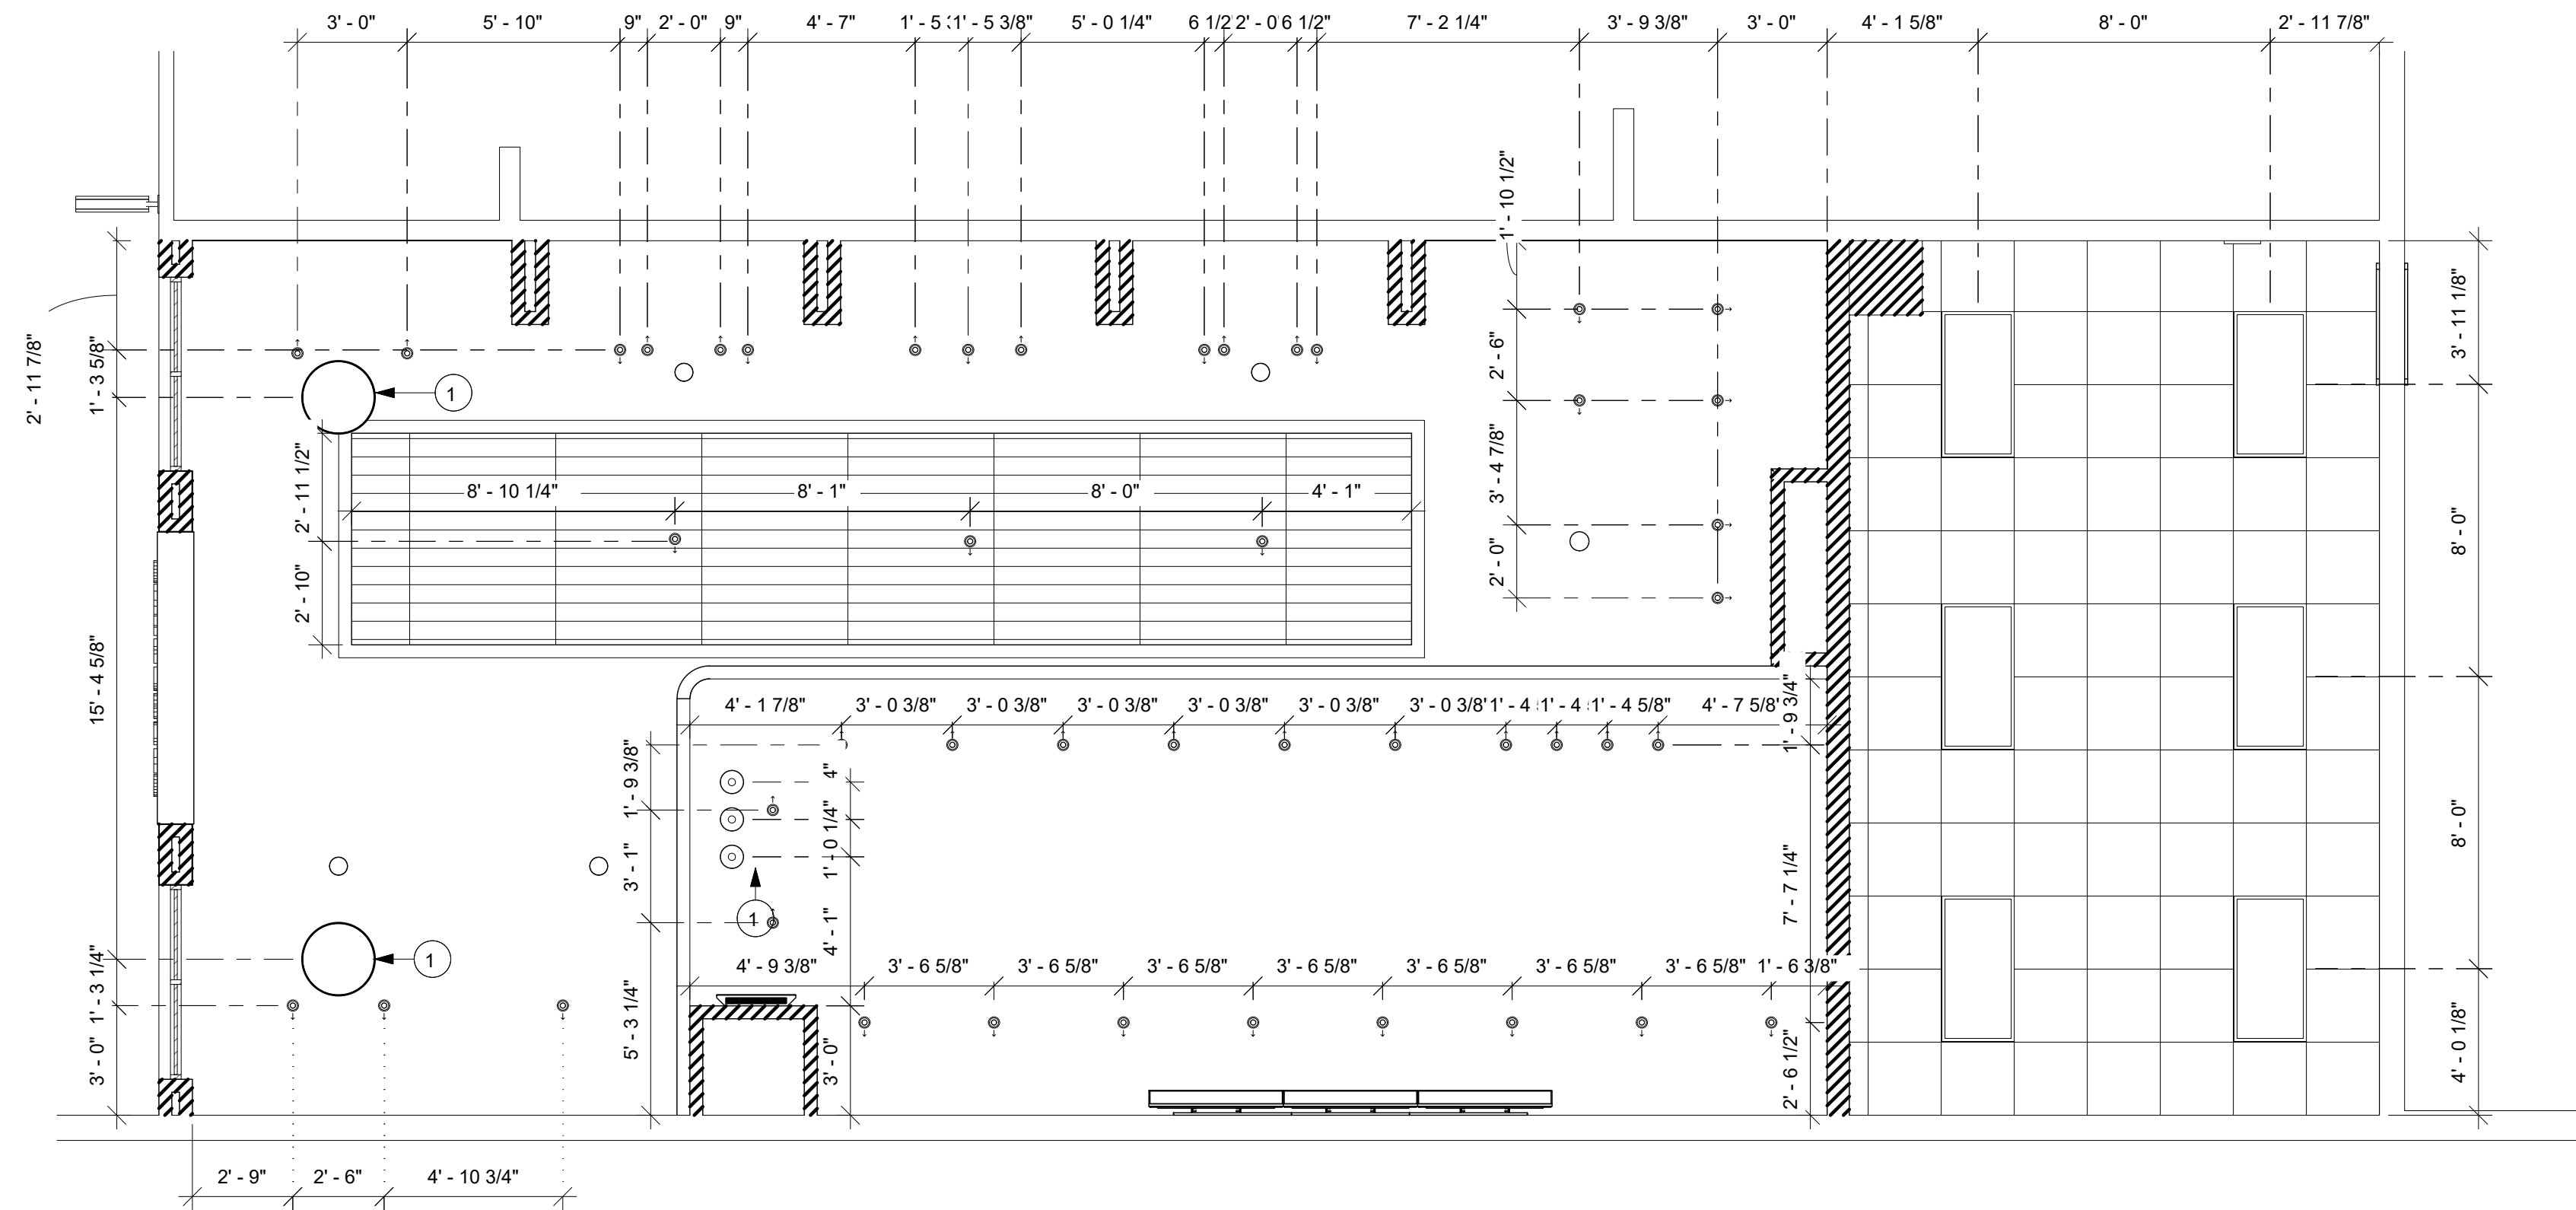

KEYED NOTES

1. FOR BO PENDANT AFF HEIGHT, SEE INTERIOR ELEVATIONS.

GENERAL NOTES

- A. HEATING, VENTILATING AND AIR CONDITIONING (HVAC) SHOWN ON THIS PLAN PROVIDED FOR REFERENCE ONLY. ACTUAL DUCTWORK AND CEILING DIFFUSER LOCATIONS TO BE DETERMINED BY ARCHITECT OF RECORD AND ARE NOT TO INTERFERE WITH PLACEMENT OF LIGHT FIXTURES AS SHOWN ON THIS PLAN. NOTIFY STARBUCKS DESIGN MANAGER OF ANY CONFLICTS.
- B. DIFFUSERS AND RETURNS IN ACOUSTICAL CEILING TO BE CENTERED IN TILE, UNLESS OTHERWISE NOTED.
- C. ARCHITECT OF RECORD TO SPECIFY AND AND LOCATE EMERGENCY LIGHTS AND EXIT SIGNS AS REQUIRED BY CODE. FIXTURES TO BE SUPPLIED AND INSTALLED BY GENERAL CONTRACTOR.

LEGEND


- ELEVATION DATUM
- PENDANT LIGHT
RODAN - HAMMERED ANTIQUE PEWTER - DID:25142
- PENDANT LIGHT
KAURI ORGANIC - BRASS AND CERAMIC - DID:25159
- ADJUSTABLE RECESSED CAN LIGHT
31IN 75MM-BLACK-1000LM WALL WASH - DID:21775
- ADJUSTABLE RECESSED CAN LIGHT
31IN 75MM-BLACK-800LM FLOOD - DID:21771
- ADJUSTABLE RECESSED CAN LIGHT
31IN 75MM - BLACK - 700LM WF - DID:21773
- TROFFER
24X48IN TROFFER LIGHT - DID: 15057
- WALL SCONCE
- EXIT SECURITY LIGHT
- MUSIC SYSTEM SPEAKER
- WIFI ACCESS POINT (WAP)
- SECURITY CAMERA
- SUPPLY AIR
- RETURN AIR
- AREA OUT OF SCOPE, NIC.

ARCHITECT OF RECORD:

THOMAS E. MORGAN, JR.
ARCHITECT

423 FISCHER TRAIL
ELLIJAY, GEORGIA 30540

SEAL:

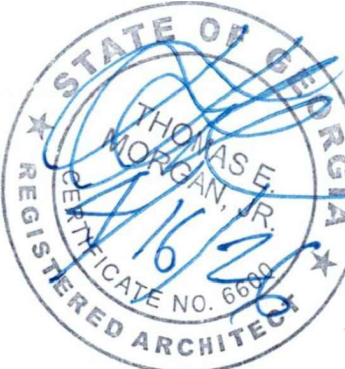

MRP
DESIGN GROUP

3450 Acworth Due West Road
Building 100, Suite 120
Kennesaw, Georgia 30144
P. 770-917-9172
F. 770-917-9470
www.mrpdesign.com

RELEASED FOR CONSTRUCTION

ISSUES / REVISIONS:

DATE	DESCRIPTION
05.04.26	RELEASE FOR CONSTRUCTION

DRAWN BY: JB

CHKD BY: TM

PROJECT DESCRIPTION:

NEW CONSTRUCTION OF A TA TRAVEL CENTER IN JEFFERSONVILLE, GA, WHICH CONSISTS OF A TRUCKER LOUNGE, SHOWERS, LAUNDRY ROOM, RETAIL AREA, RESTROOMS, GAME AREA, SEATING AREAS, AND FOUR QUICK-SERVICE RESTAURANTS. THE MAJORITY OF THE PROJECT HAS ALREADY BEEN SUBMITTED. THIS ISSUE, DATED 05.04.26 HAS MODIFICATIONS RELATED TO THE ADDITION OF THE STARBUCKS QSR.

PROJECT TITLE:

TRAVEL CENTER
4838 SR 96
JEFFERSONVILLE,
GEORGIA 31044

SHEET TITLE:


LIGHTING
DIMENSION
PLAN

PROJECT NO: 25021


1104

FOR REFERENCE ONLY

THESE PLANS ARE THE PROPERTY OF MRP DESIGN GROUP, INC. AND ARE SUBJECT TO FEDERAL COPYRIGHT LAWS. ANY USE OF SAME WITHOUT THE EXPRESS WRITTEN PERMISSION OF MRP DESIGN GROUP, INC. IS STRICTLY PROHIBITED.

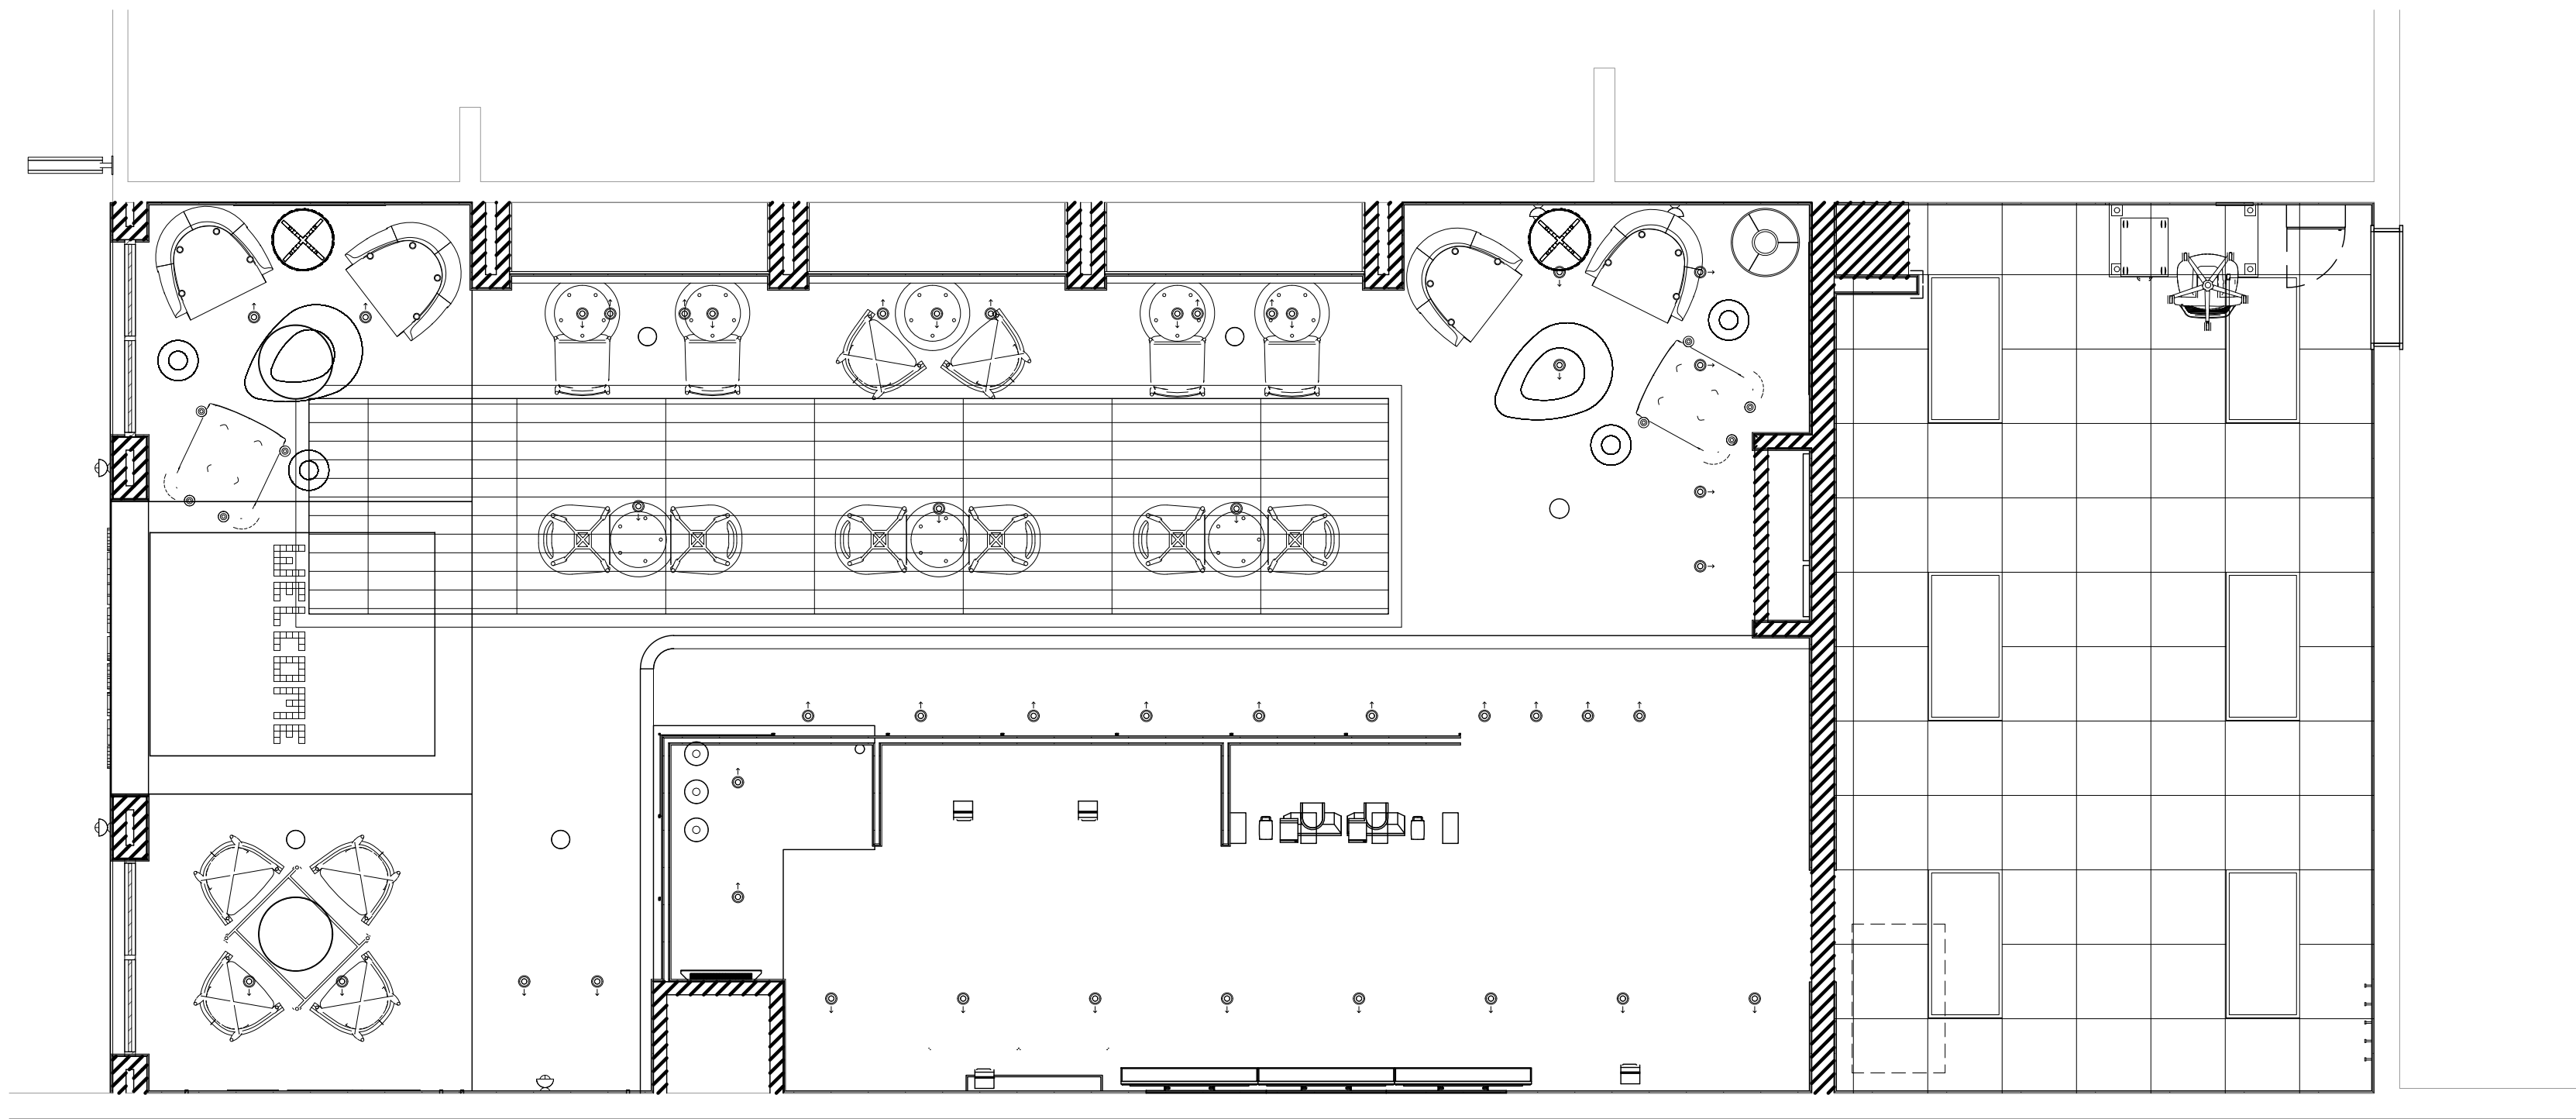

 01 LIGHTING PLACEMENT PLAN
Scale: 1/4" = 1'-0"



LEGEND

- ELEVATION DATUM
- PENDANT LIGHT
RODAN - HAMMERED ANTIQUE PEWTER - DID:25142
- PENDANT LIGHT
KAURI ORGANIC - BRASS AND CERAMIC - DID:25159
- ADJUSTABLE RECESSED CAN LIGHT
31IN 75MM - BLACK - 1000LM WALL WASH - DID:21775
- ADJUSTABLE RECESSED CAN LIGHT
31IN 75MM - BLACK - 800LM FLOOD - DID:21771
- ADJUSTABLE RECESSED CAN LIGHT
31IN 75MM - BLACK - 700LM WF - DID:21773
- TROFFER
24X48IN TROFFER LIGHT - DID: 15057
- WALL SCONCE
- EXIT SECURITY LIGHT
- MUSIC SYSTEM SPEAKER
- WIFI ACCESS POINT (WAP)
- SECURITY CAMERA
- SUPPLY AIR
- RETURN AIR
- AREA OUT OF SCOPE, NIC.

ARCHITECT OF RECORD:

THOMAS E. MORGAN, JR.
ARCHITECT

423 FISCHER TRAIL
ELLIJAY, GEORGIA 30540

SEAL:



3450 Acworth Due West Road
Building 100, Suite 120
Kennesaw, Georgia 30144
P. 770-917-9172
F. 770-917-9470
www.mrpdesign.com

RELEASED FOR
CONSTRUCTION

ISSUES / REVISIONS:

DATE	DESCRIPTION
05.04.26	RELEASE FOR CONSTRUCTION

DRAWN BY: JB

CHKD BY: TM

PROJECT DESCRIPTION:

NEW CONSTRUCTION OF A TA TRAVEL CENTER IN JEFFERSONVILLE, GA. WHICH CONSISTS OF A TRUCKER LOUNGE, SHOWERS, LAUNDRY ROOM, RETAIL AREA, RESTROOMS, GAME AREA, SEATING AREAS, AND FOUR QUICK-SERVICE RESTAURANTS. THE MAJORITY OF THE PROJECT HAS ALREADY BEEN SUBMITTED. THIS ISSUE, DATED 05.04.26 HAS MODIFICATIONS RELATED TO THE ADDITION OF THE STARBUCKS QSR.

PROJECT TITLE:

TRAVEL CENTER
4838 SR 96
JEFFERSONVILLE,
GEORGIA 31044

SHEET TITLE:

LIGHTING
PLACEMENT
PLAN

PROJECT NO: 25021

1105

FOR REFERENCE ONLY

FLOOR TREATMENT SCHEDULE - "T"					
DESIGN ID	AREA	DESCRIPTION	FURN. BY	INST. BY	COMMENTS
24733	862 SF	TILE - PALERMO METALLIC - DEEP - 12X24IN	GC	GC	GROUT: MAPEI 5010-BLACK
24856	202 SF	TILE - LAB - CLAY - MOSAIC - 12X12IN 300X300MM SHEET	GC	GC	GROUT: MAPEI 5047-CHARCOAL, OR EQUAL
24857	33 SF	TILE - LAB - COAL - MOSAIC - 12X12IN 300X300MM SHEET	GC	GC	GROUT: MAPEI 5010-BLACK, OR EQUAL
X9201	362 SF	TILE - LOCALLY SOURCED QUARRY TILE - 24X42IN 600X600MM	GC	GC	LOCALLY SOURCED QUARRY TILE. AOR TO VERIFY COMPLIANCE WITH HEALTH CODE. GROUT: MAPEI - 47 CHARCOAL, OR EQUAL

WALL BASE SCHEDULE - "B"					
DESIGN ID	LENGTH	DESCRIPTION	FURN. BY	INST. BY	COMMENTS
TILE BASE 18740	211" - 4 7/8"	TILE BASE - PLAZA NOVA - BLACK SHADOW - 6X12IN 150X300MM	GC	GC	GROUT: MAPEI - 5047 CHARCOAL, OR EQUAL. NO SUBSTITUTION ALLOWED WHITOUT PRIOR SUBMITTAL. APPROVAL BY STARBUCKS. SUPPLIER CONTACT: Ceramic Technics Ltd starbucks@ceramictechnics.com Lydia Kurth Office: (770) 740-0070 Cell: (954) 520-4283
X9200	102" - 2 1/4"	LOCALLY SOURCED 6X12IN QUARRY TILE	GC	GC	AOR TO SPECIFY TILE AND GROUT. VERIFY COMPLIANCE WITH HEALTH CODE.
X9202	0"	SCHLUTER BRASS FINISH - METAL FLOOR TRANSITION	GC	GC	GROUT TO MATCH ADJACENT TILE FINISH. DIMENSIONS TO BE V.I.F. (1) 3' - 2 1/2", (2) 4' - 0", (1) 3' - 0"


KEYED NOTES

1. CABINET BASES TO BE SET [BEFORE] [AFTER] FLOOR TILE INSTALLATION.
2. TILE INSTALLATION START POINT(S) WHERE INDICATED.
3. FLOOR SINK LOCATION. SEE BUILDING FLOOR PENETRATION PLAN ON SHEET A102 AND PLUMBING FOR ADDITIONAL INFORMATION.
4. RECESSED ELECTRICAL. SEE BUILDING FLOOR PENETRATION PLAN ON SHEET A102 AND ELECTRICAL FOR ADDITIONAL INFORMATION.
5. NEW FLOORS MUST BE LEVELLED TO MATCH EXISTING FLOORS.

GENERAL NOTES

- A. STAIRBUCKS TO SUPPLY RETAIL AREA AND WORKROOM FLOOR TILE AND TILE BASE, UNLESS OTHERWISE NOTED. GENERAL CONTRACTOR TO INSTALL. GENERAL CONTRACTOR TO SUPPLY AND INSTALL MORTAR, ADHESIVE, AND GROUT. GENERAL CONTRACTOR TO INSPECT ALL TILES AND REJECT DAMAGED OR SUBSTANDARD TILES PRIOR TO INSTALLATION.
- B. ALL FLOORING AND BASE MATERIAL TO BE INSTALLED ACCORDING TO SPECIFICATIONS AND MANUFACTURER'S INSTALLATION REQUIREMENTS.
- C. ALIGN TILE TRANSITIONS ON WHOLE TILES WHERE POSSIBLE.
- D. TILE BASE AND THRESHOLD GROUT JOINTS TO ALIGN WITH TILE FLOOR GROUT JOINTS.
- E. PROVIDE GROUT JOINT OF 3/16" (5MM), MAXIMUM DEVIATION OF TILE AND GROUT LINE OF 1/4" (6MM) PER 48" (1220MM).
- F. ALL FLOOR AND WALL JUNCTIONS IN STORAGE AND FOOD PREPARATION AREAS SHALL HAVE A 6" COVERED BASE.

FLOOR FINISH LEGEND

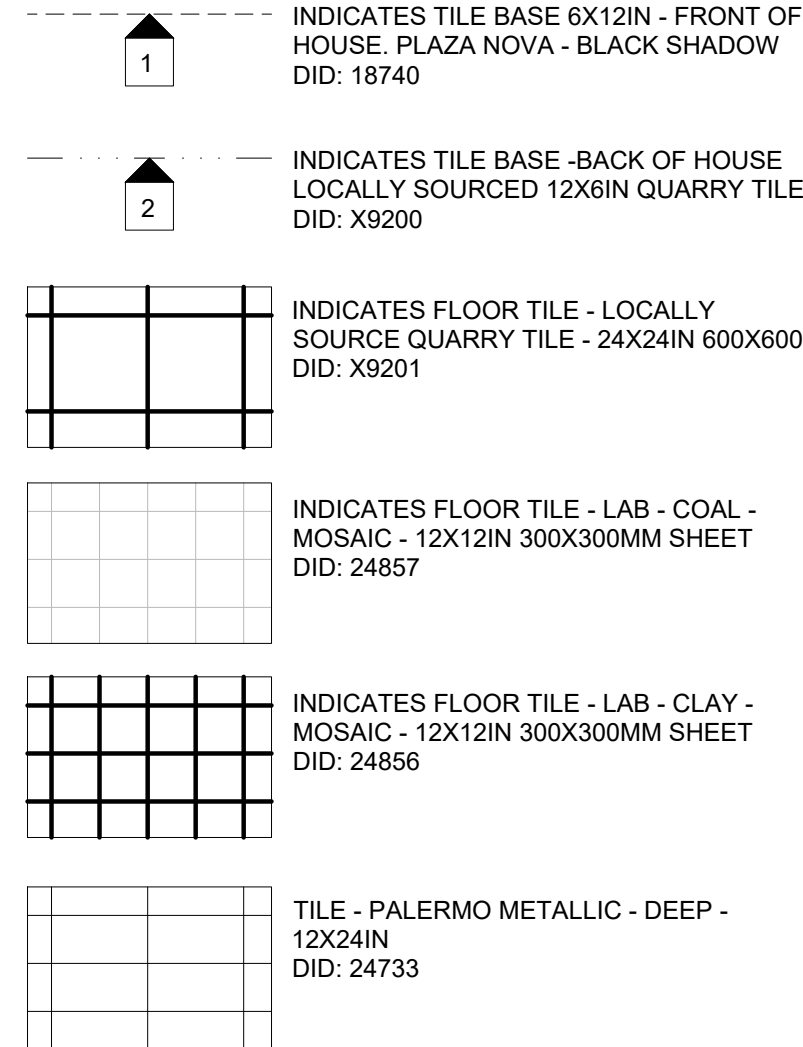 DATUM POINT

AREA OUT OF SCOPE, NIC.

LICENSED STORES RESPONSIBILITY LEGEND

- SB - STARBUCKS
FC - STARBUCKS FIXTURE CONTRACTOR
LC - LICENSEE
GC - LICENSEE'S GENERAL CONTRACTOR
3PV - STARBUCKS THIRD - PARTY VENDOR

ARCHITECT OF RECORD:

THOMAS E. MORGAN, JR.
ARCHITECT

423 FISCHER TRAIL
ELLIJAY, GEORGIA 30540

SEAL:



3450 Acworth Due West Road
Building 100, Suite 120
Kennesaw, Georgia 30144
P. 770-917-9172
F. 770-917-9470
www.mrpdesign.com

RELEASED FOR
CONSTRUCTION

ISSUES / REVISIONS:

DATE	DESCRIPTION
05/04/26	RELEASE FOR CONSTRUCTION

DRAWN BY: JB

CHK'D BY: TM

PROJECT DESCRIPTION

NEW CONSTRUCTION OF A TRAVEL CENTER IN JEFFERSONVILLE, GA, WHICH CONSISTS OF A TRUCKER LOUNGE, SHOWERS, LAUNDRY ROOM, RETAIL AREA, RESTROOMS, GAME AREA, SEATING AREAS, AND FOUR QUICK-SERVICE RESTAURANTS. THE MAJORITY OF THE PROJECT HAS ALREADY BEEN SUBMITTED. THIS ISSUE, DATED 05.04.26 HAS MODIFICATIONS RELATED TO THE ADDITION OF THE STARBUCKS QSR.

PROJECT TITLE:

TRAVEL CENTER
4838 SR 96
JEFFERSONVILLE,
GEORGIA 31044


SHEET TITLE:

CASEWORK FRONTBAR DETAIL

PROJECT NO: 25021


1106

FOR REFERENCE ONLY

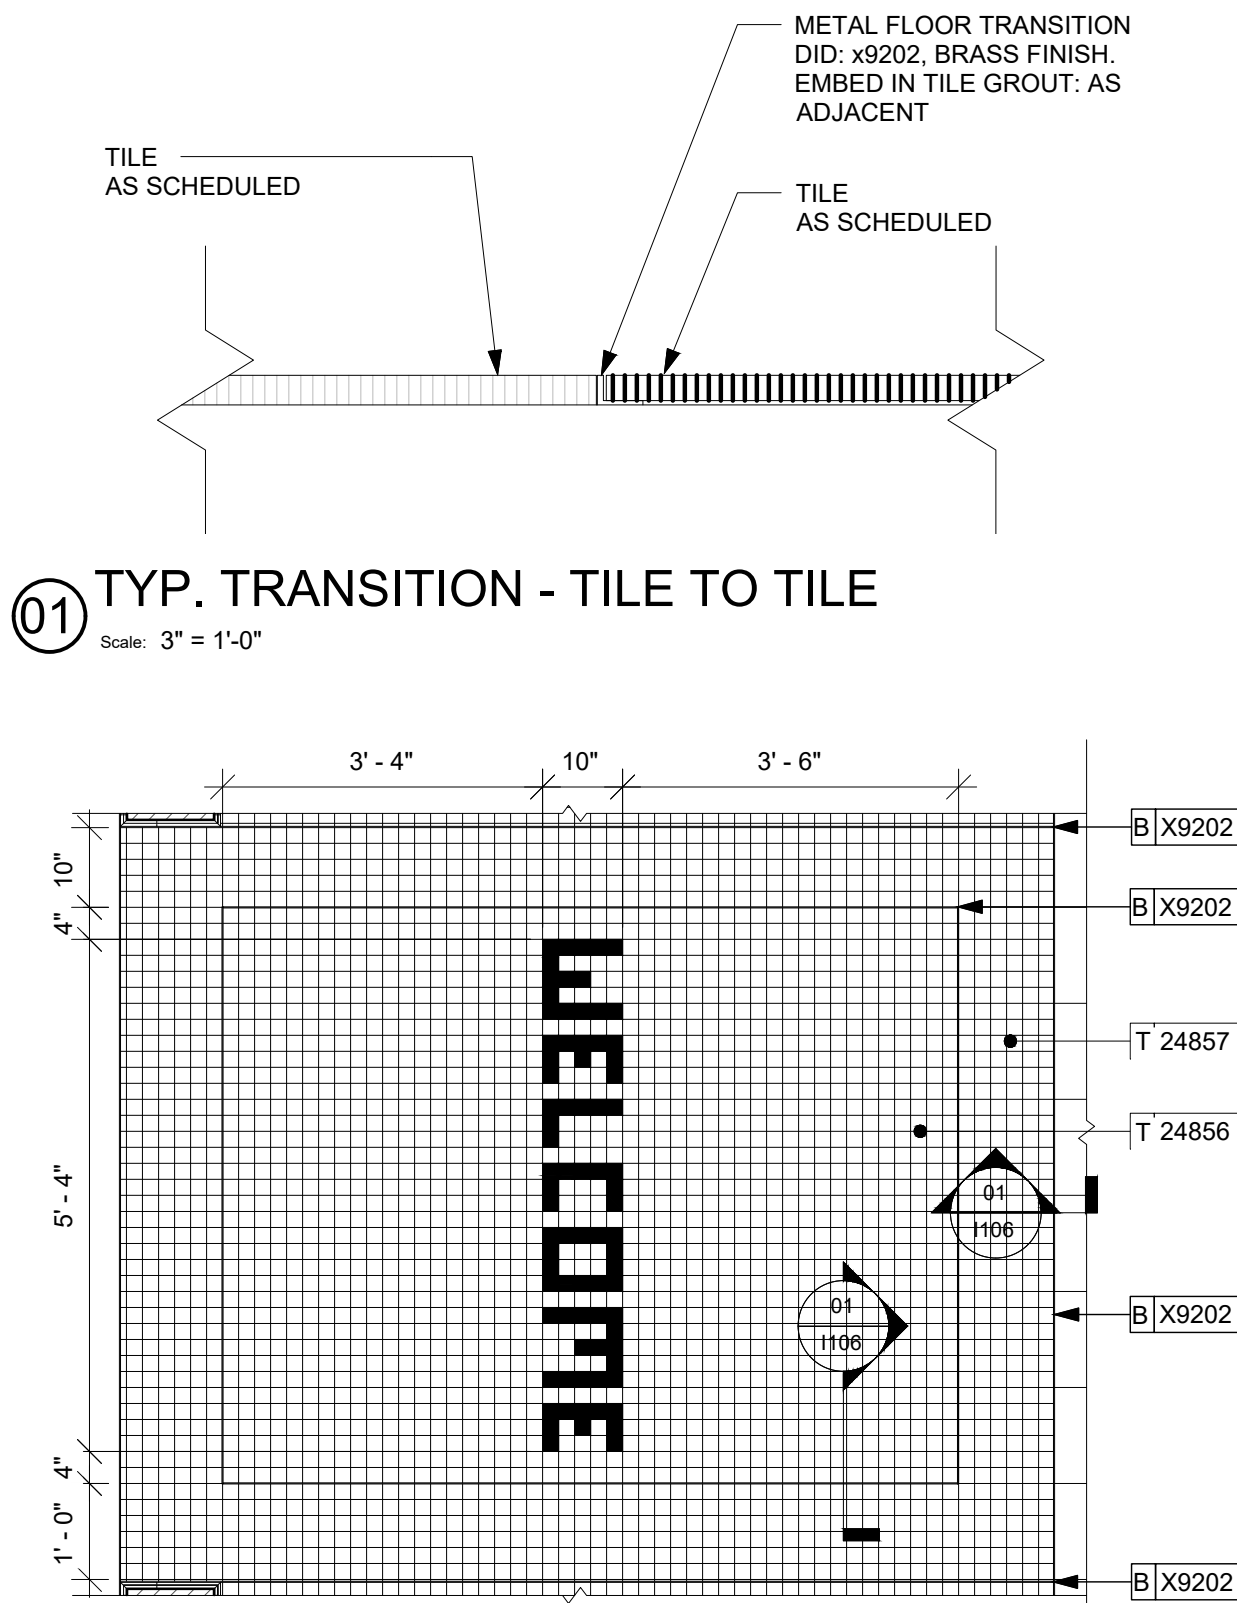


01 TYP. TRANSITION - TILE TO TILE
Scale: 3" = 1'-0"

2 INTERIOR FLOOR FINISH PLAN - Callout 1
Scale: 1/2" = 1'-0"

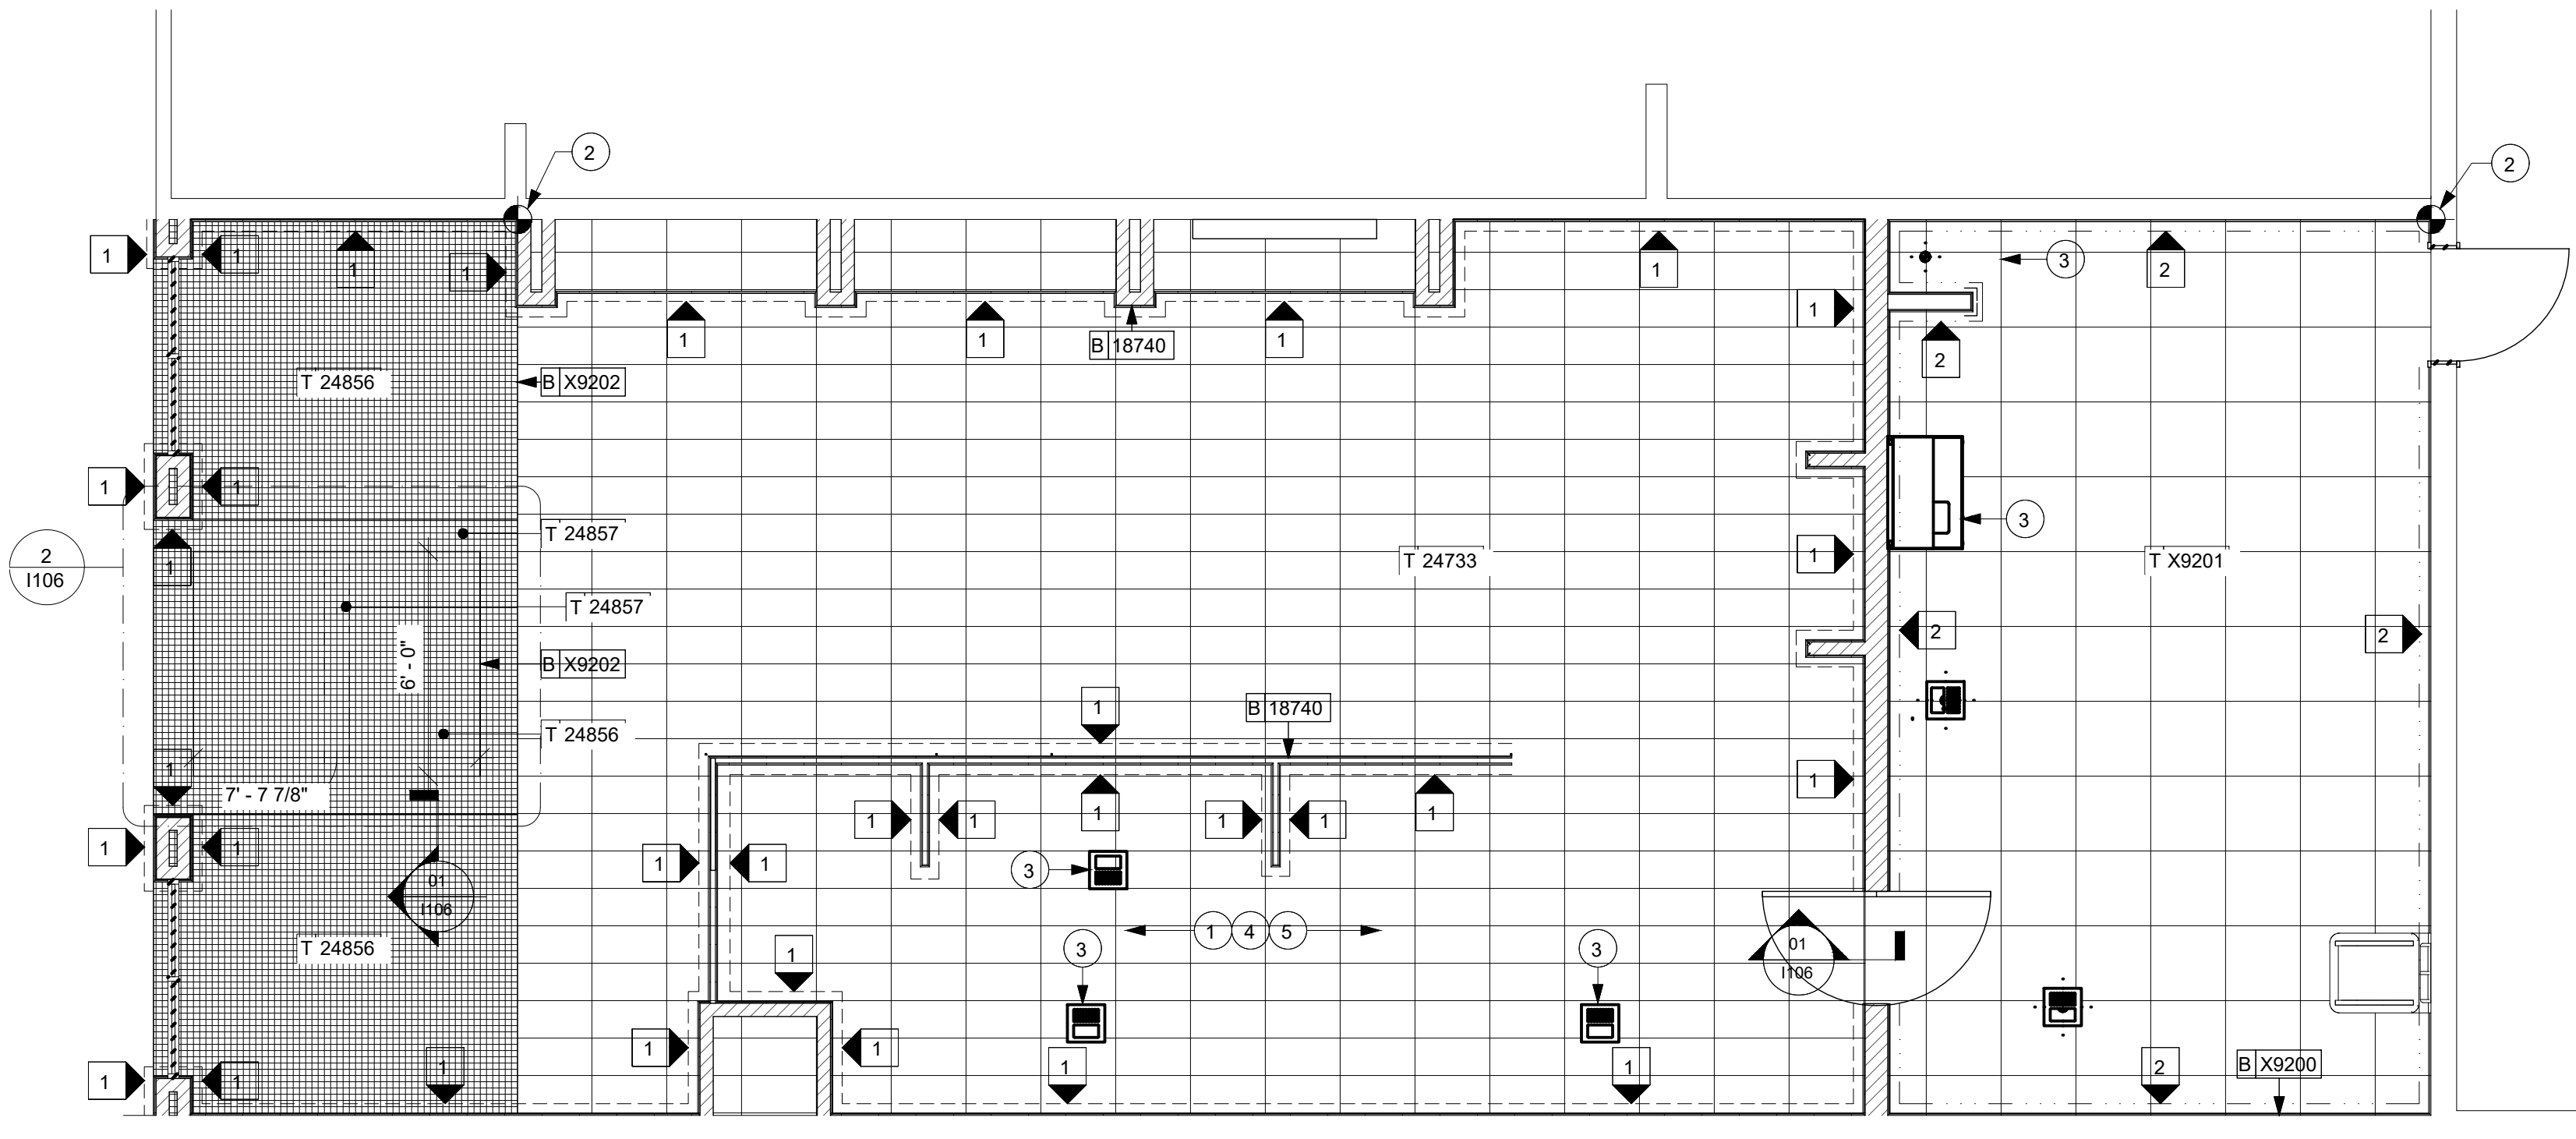


03 INTERIOR FLOOR FINISH PLAN

 
Scale: 1/4" = 1'-0"




THESE PLANS ARE THE PROPERTY OF MRP DESIGN GROUP, INC. AND ARE SUBJECT TO FEDERAL COPYRIGHT LAWS. ANY USE OF SAME WITHOUT THE EXPRESS WRITTEN PERMISSION OF MRP DESIGN GROUP, INC. IS STRICTLY PROHIBITED.

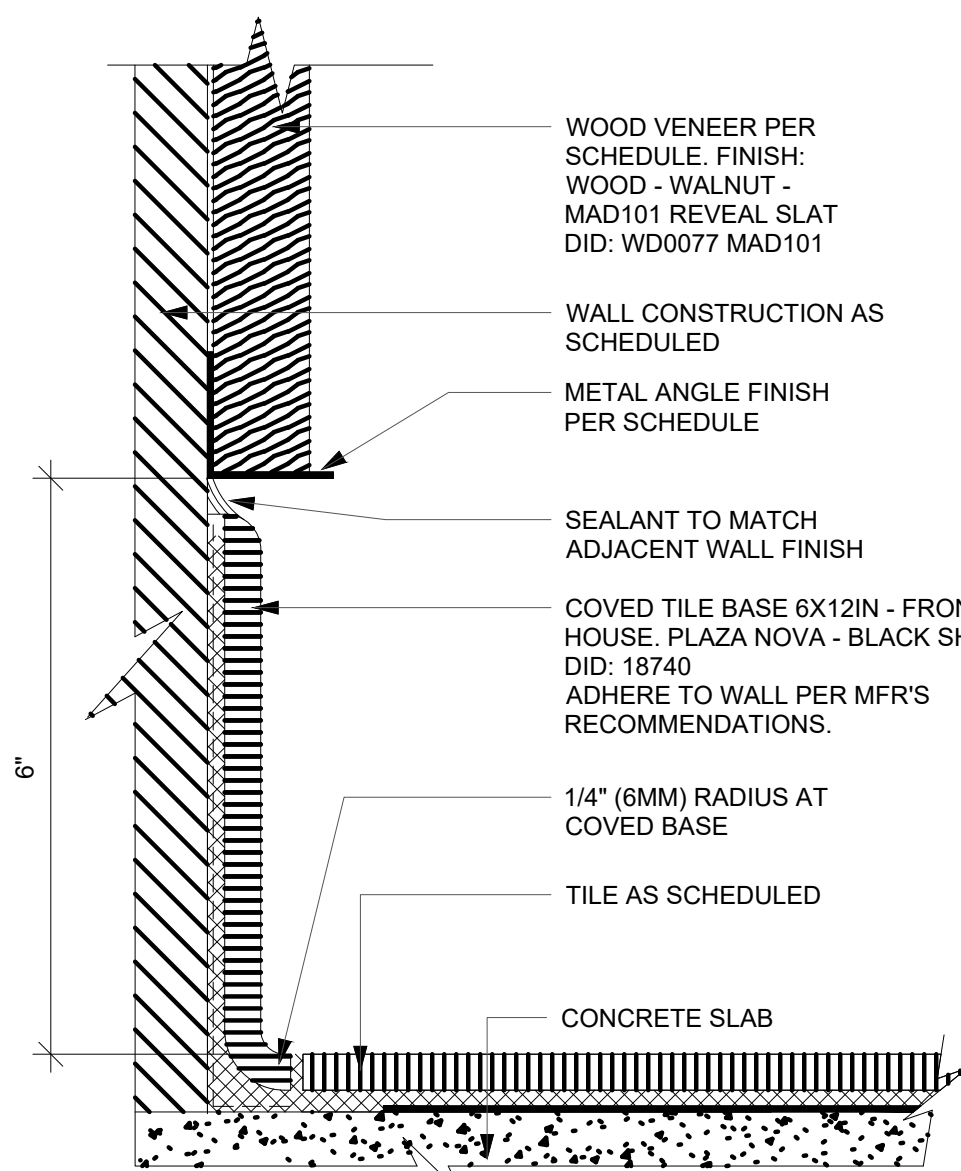


01 TILE BASE AT VENEER WALL
Scale: 6" = 1'-0"

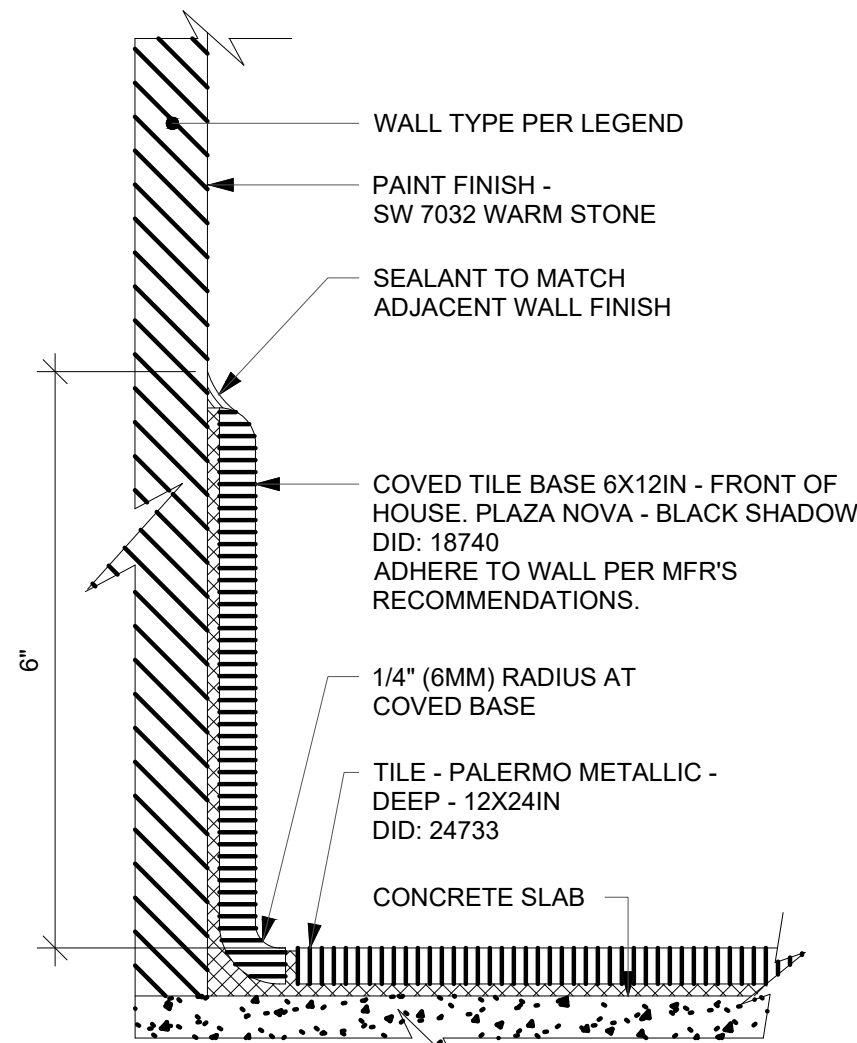


02 TILE COVE BASE AT WALL PAINT
Scale: 6" = 1'-0"

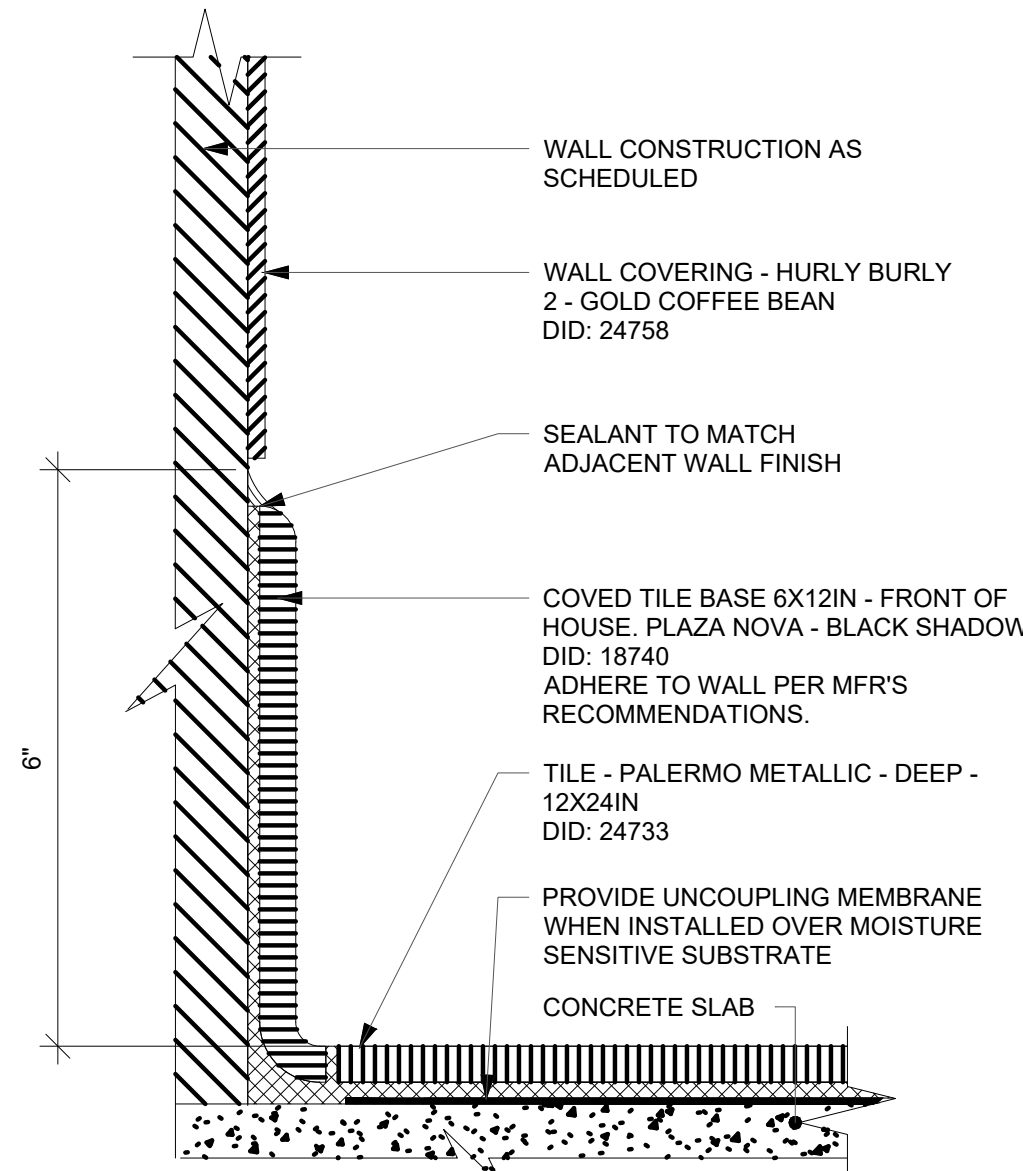


03 TILE COVE BASE AT WALL COVERING
Scale: 6" = 1'-0"

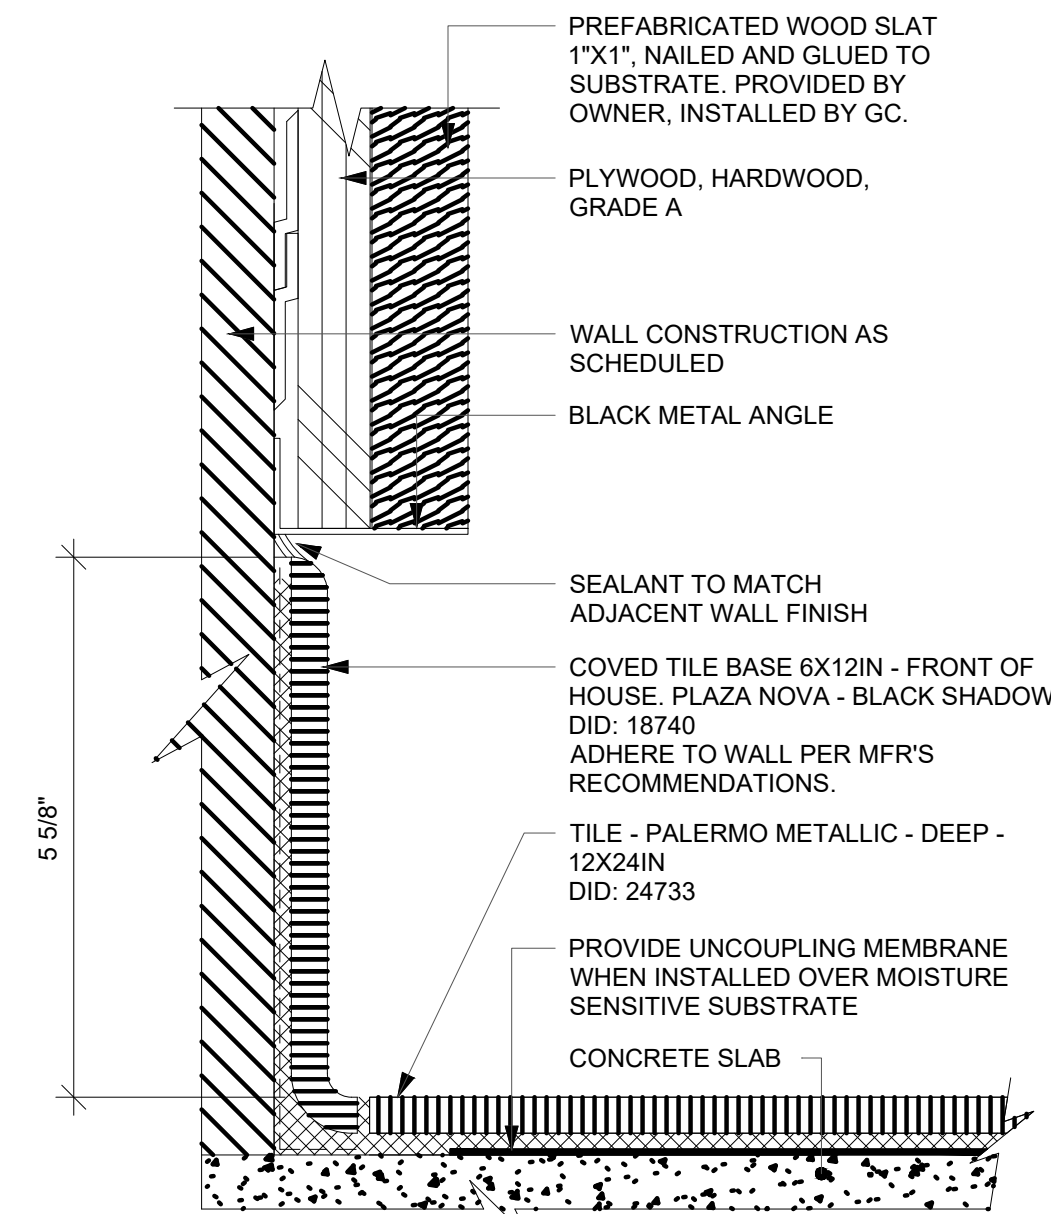


04 TILE BASE AT WOOD SLAT WALL
Scale: 6" = 1'-0"

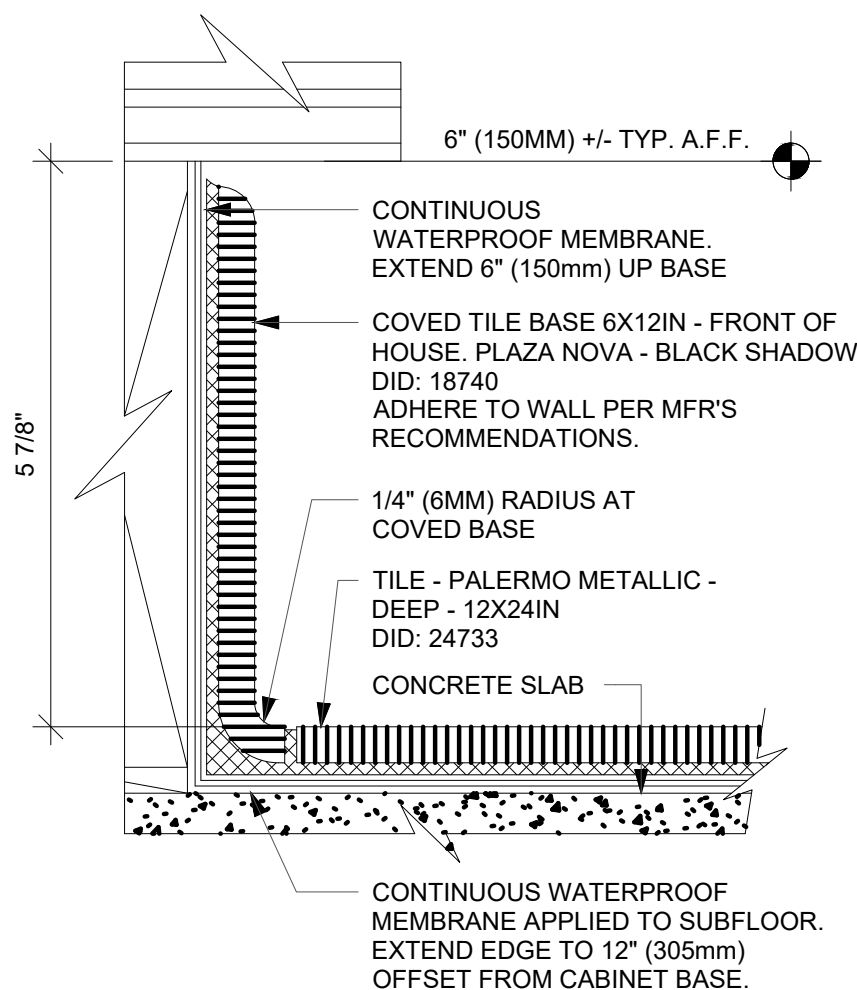


05 TILE BASE AT MERCH
Scale: 6" = 1'-0"

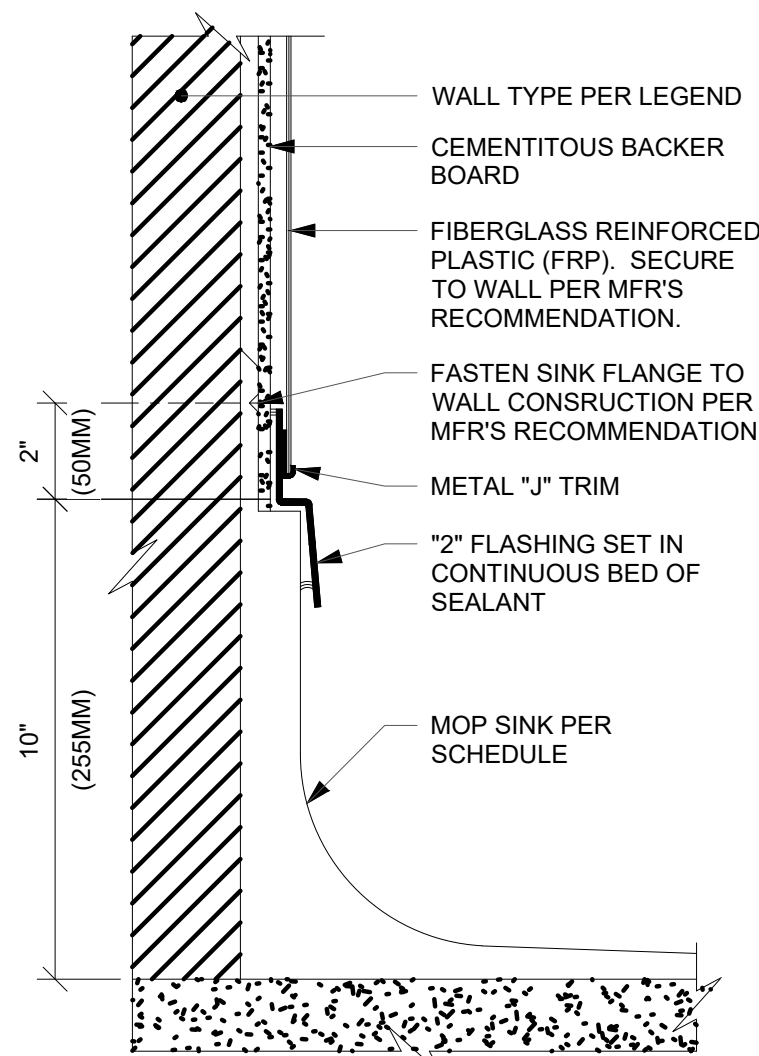

06 MOP SINK WITH FLANGE
Scale: 3" = 1'-0"

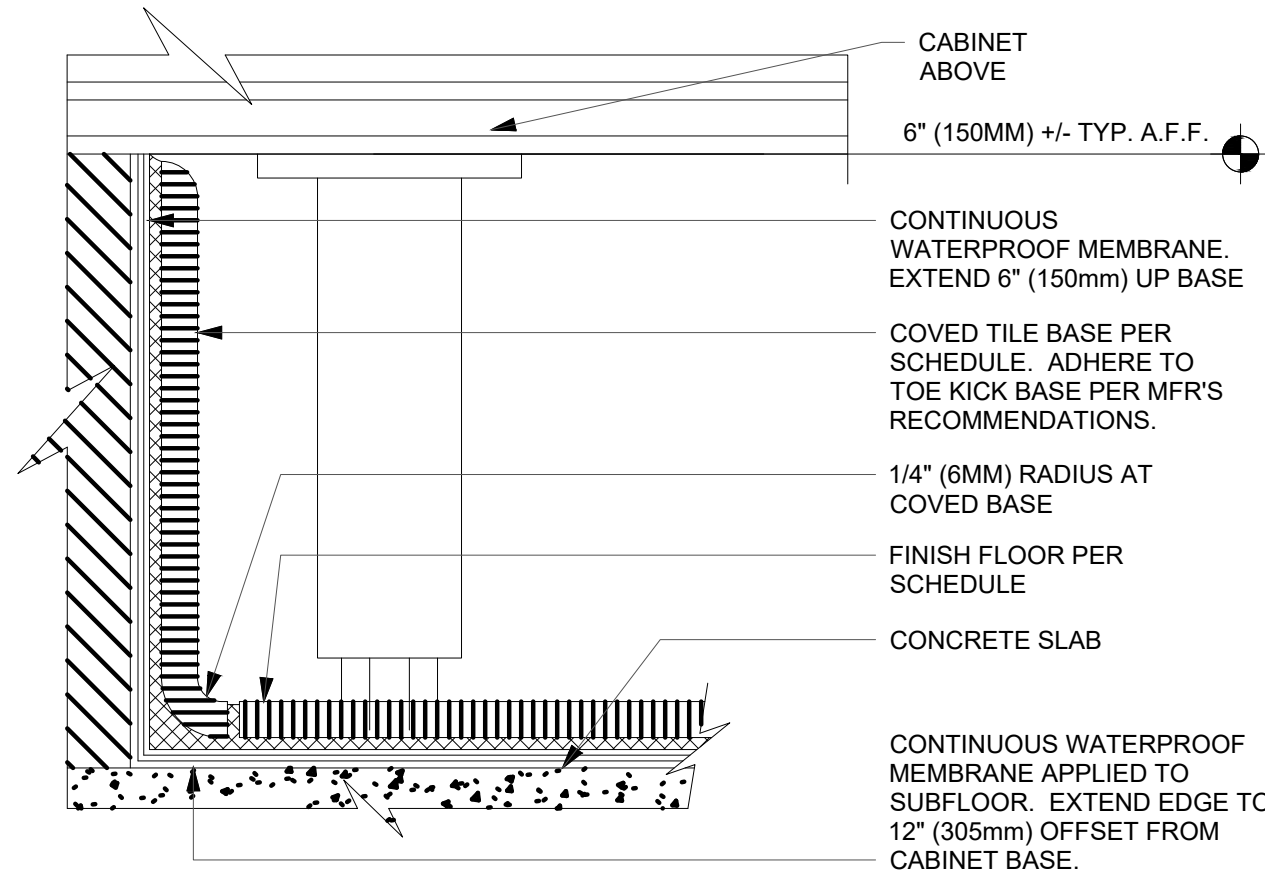

07 INTEGRAL TILE BASE AT CABINET
Scale: 6" = 1'-0"

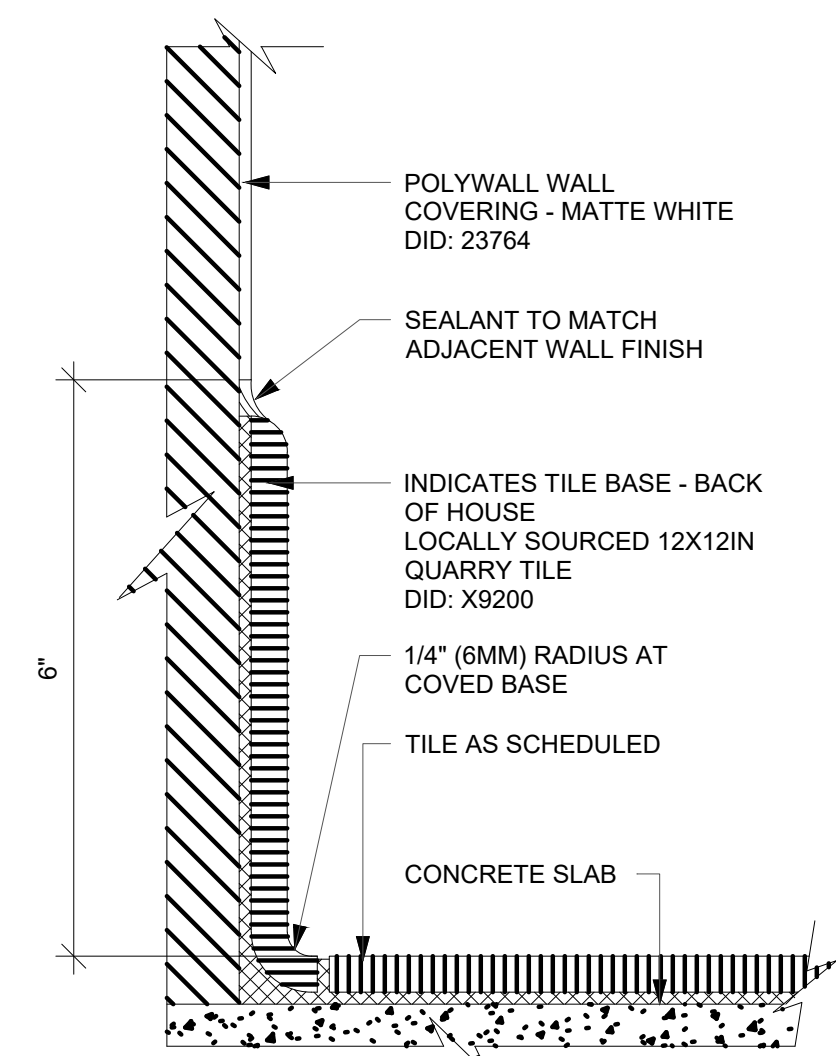

08 TILE BASE AT BOH WALL & UNDER COUNTERTOP AREA
Scale: 6" = 1'-0"

ARCHITECT OF RECORD:

THOMAS E. MORGAN, JR.
ARCHITECT

423 FISCHER TRAIL
ELLIJAY, GEORGIA 30540

SEAL:

MRP
DESIGN GROUP

3450 Acworth Due West Road
Building 100, Suite 120
Kennesaw, Georgia 30144
P. 770-917-9172
F. 770-917-9470
www.mrpdesign.com

RELEASED FOR
CONSTRUCTION

ISSUES / REVISIONS:

DATE	DESCRIPTION
05.04.26	RELEASE FOR CONSTRUCTION

DRAWN BY: JB

CHKD BY: TM

PROJECT DESCRIPTION:

NEW CONSTRUCTION OF A TA
TRAVEL CENTER IN
JEFFERSONVILLE, GA, WHICH
CONSISTS OF A TRUCKER
LOUNGE, SHOWERS, LAUNDRY
ROOM, RETAIL AREA,
RESTROOMS, GAME AREA,
SEATING AREAS, AND FOUR
QUICK-SERVICE RESTAURANTS.
THE MAJORITY OF THE
PROJECT HAS ALREADY BEEN
SUBMITTED. THIS ISSUE, DATED
05.04.26 HAS MODIFICATIONS
RELATED TO THE ADDITION OF
THE STARBUCKS QSR.

PROJECT TITLE:

TRAVEL CENTER
4838 SR 96
JEFFERSONVILLE,
GEORGIA 31044

SHEET TITLE:

INTERIOR
FLOOR
FINISH
DETAILS

PROJECT NO: 25021







1106.1

FOR REFERENCE ONLY

THESE PLANS ARE THE PROPERTY OF MRP DESIGN GROUP, INC. AND ARE SUBJECT TO FEDERAL COPYRIGHT LAWS. ANY USE OF SAME WITHOUT THE EXPRESS WRITTEN PERMISSION OF MRP DESIGN GROUP, INC. IS STRICTLY PROHIBITED.

WALL TREATMENT (AREA) SCHEDULE - "Q"					
DESIGN ID	AREA	DESCRIPTION	FURN. BY	INST. BY	COMMENTS
PLASTIC					
23764	881 SF	POLYWALL WALL COVERING - MATTE WHITE	GC	GC	FRP O EQUIVALENT ACCODING TO HEALTH REQUIREMENTS.
TILE					
24753	213 SF	TILE - INAX HIIRONE - GLAZED - 9.5X2.25IN 240X60MM	GC	GC	GROUT: MAPEI 5007-CHOCOLATE OR EQUAL. NO SUBSTITUTIONS ALLOWED WITHOUT PRIOR SUBMITAL APPROVAL BY STARBUCKS.
WALL COVERING					
24758	269 SF	WALL COVERING - CAMBRIAN - ADVENTURINE	SB	GC	
WOOD					
x9402	125 SF	PLAM - WALNUT WOODGRAIN	SB	GC	PROVIDED BY CASEWORK VENDOR.
x9403	320 SF	WOOD - WALNUT - REVEAL SLAT	SB	GC	PROVIDED BY CASEWORK VENDOR.

PAINT SCHEDULE					
DESIGN ID	DESCRIPTION	LRV	FURN. BY	INST. BY	COMMENTS
X9000	SW7030 ANEW GRAY, OR EQUIVALENT		GC	GC	
X9001	HC-188 ESSEX GREEN, OR EQUIVALENT		GC	GC	
X9002	SW7032 WARM STONE, OR EQUIVALENT		GC	GC	
X9003	SW7033 BRAINSTORM BRONZE, OR EQUIVALENT	14	GC	GC	

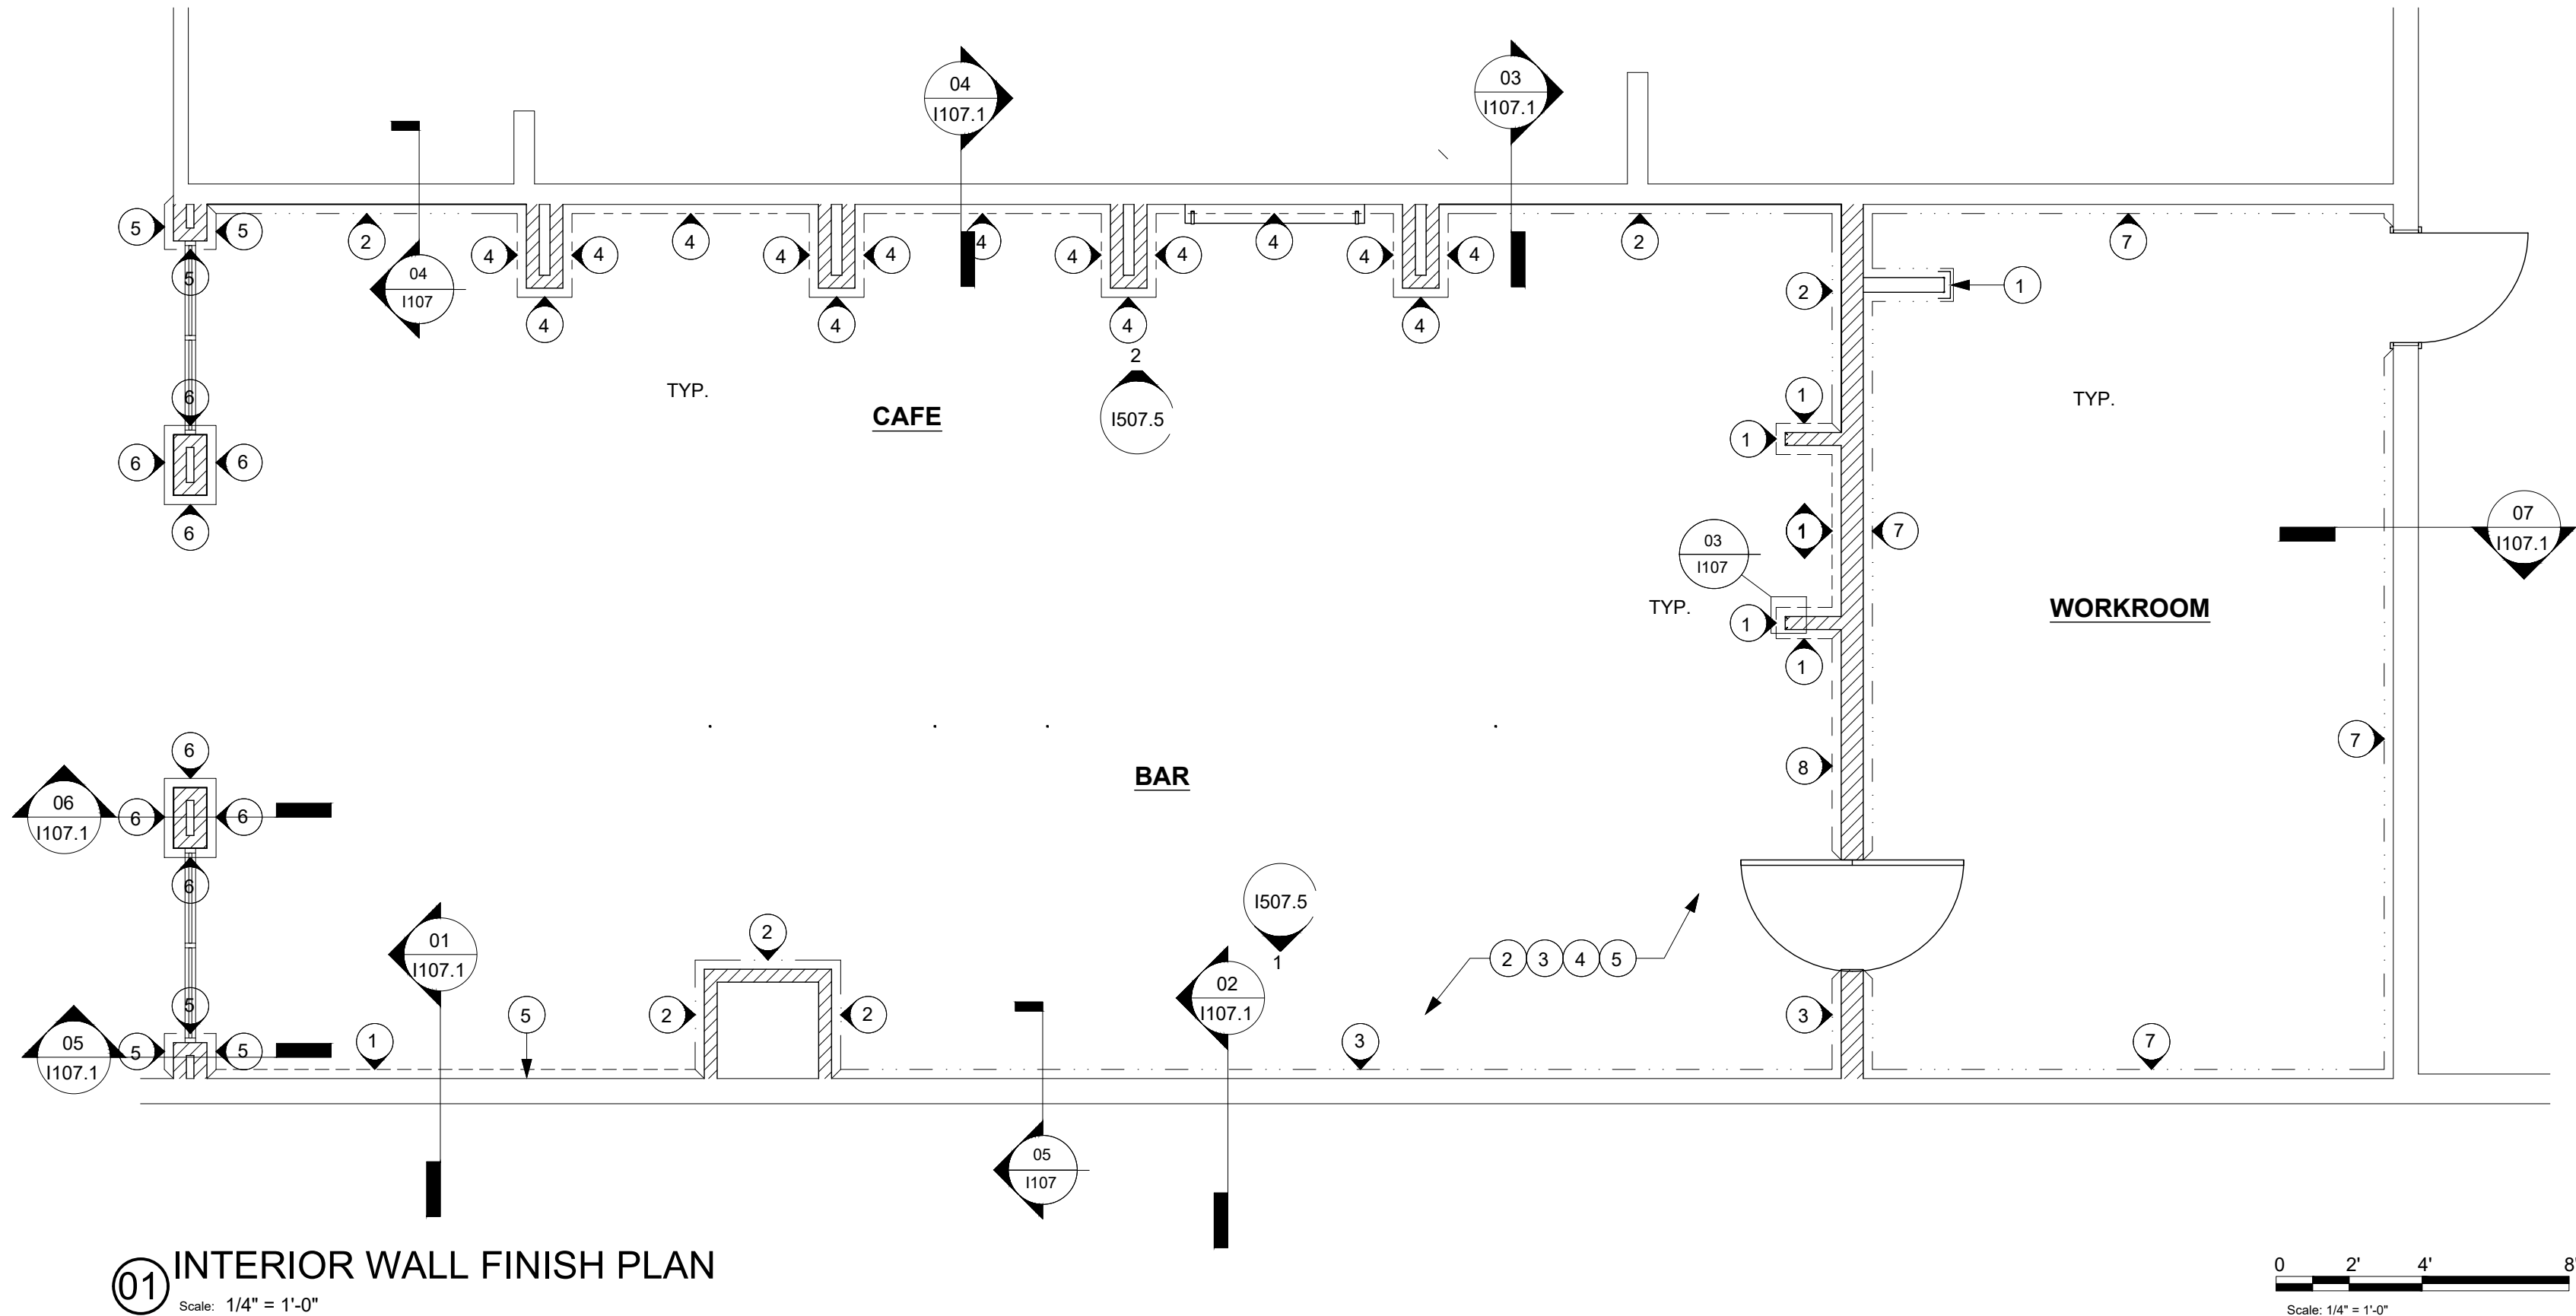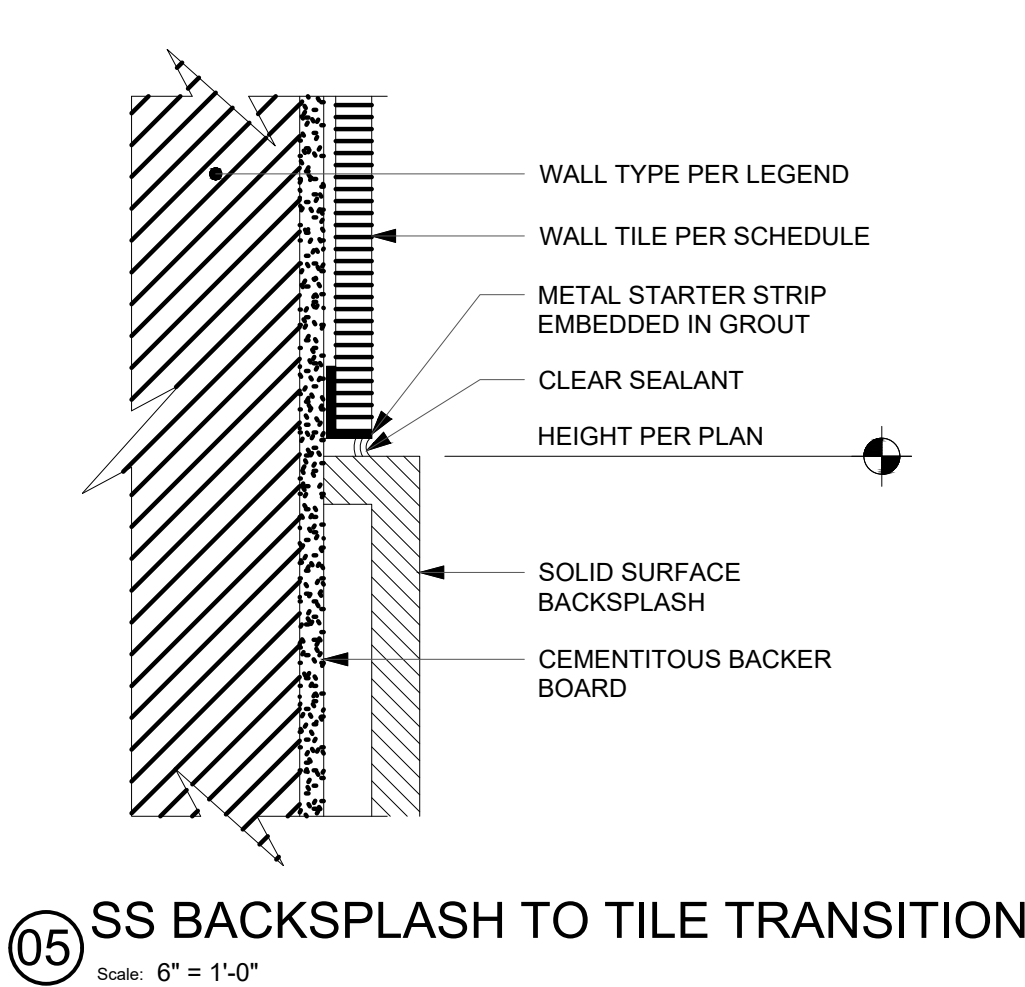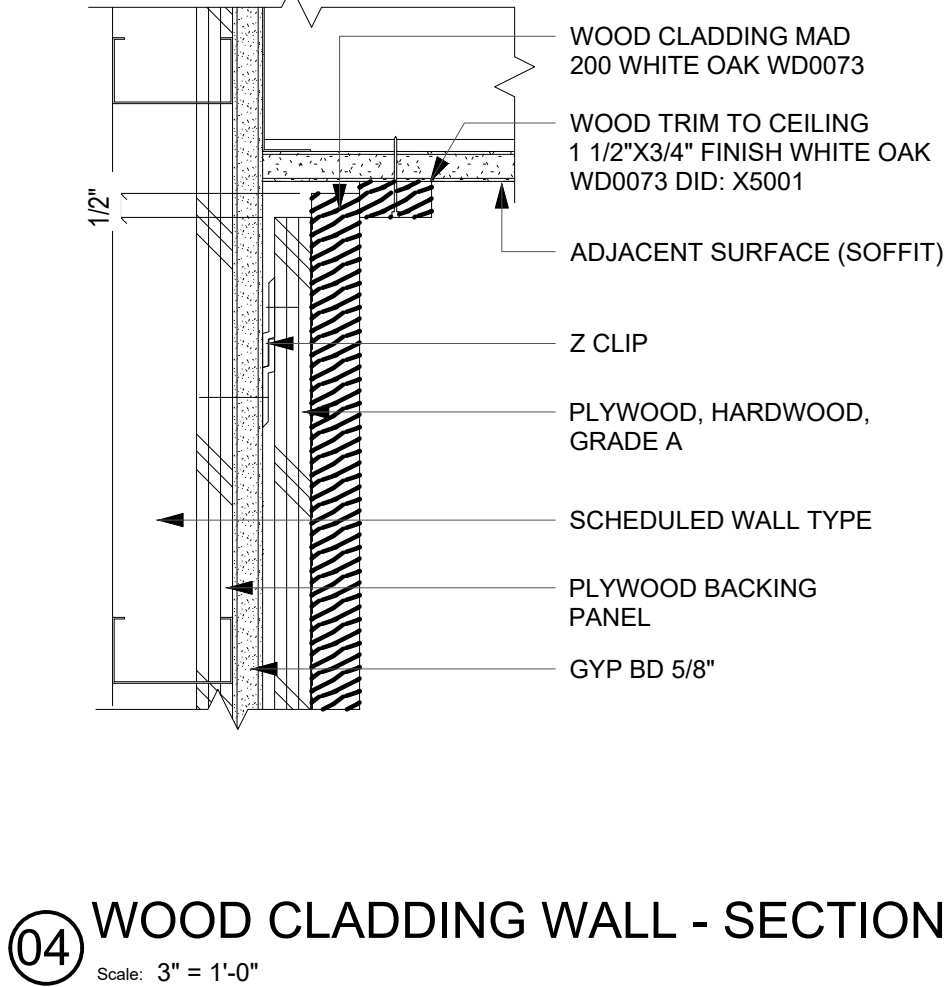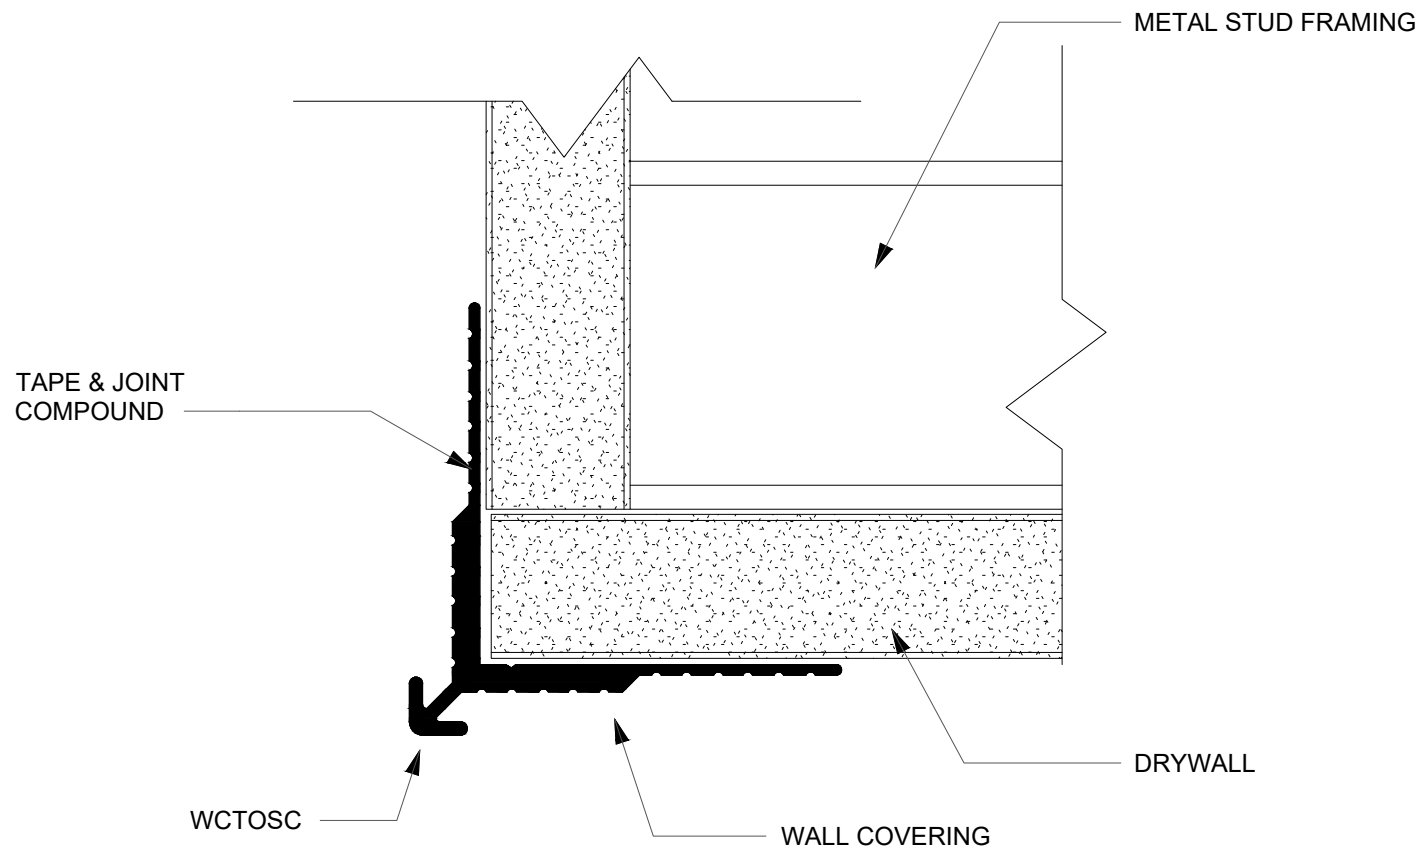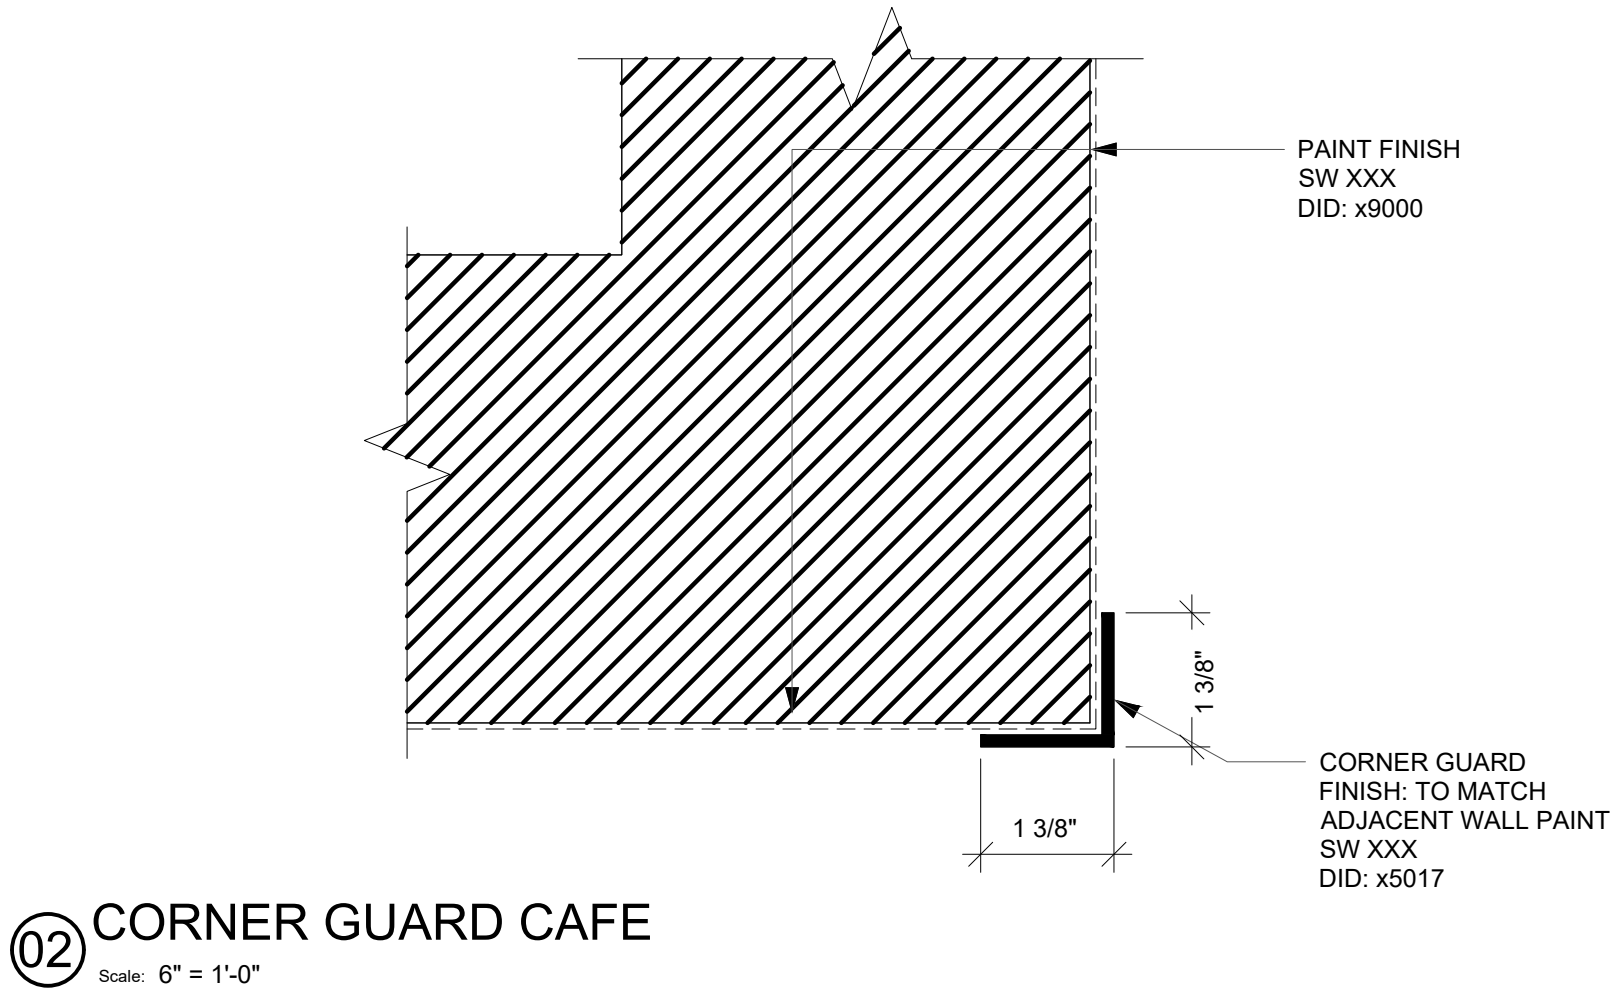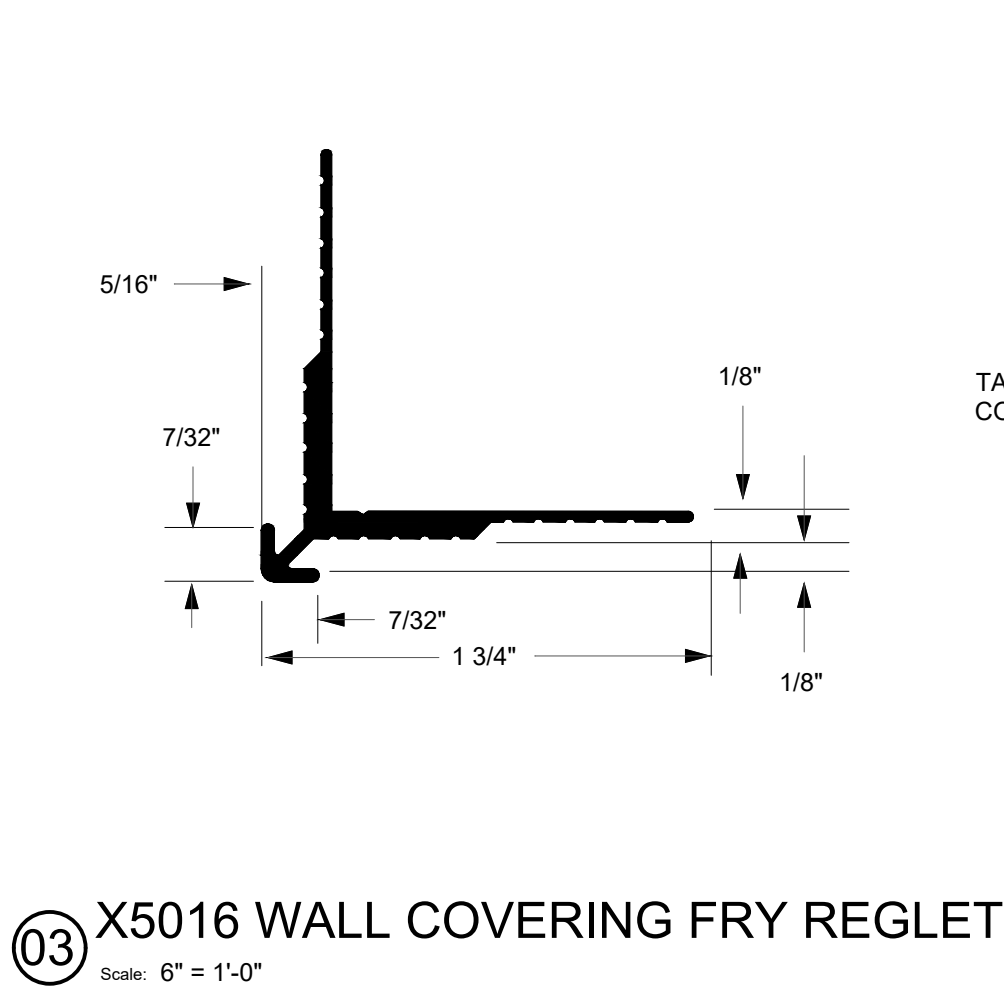

KEYED NOTES

- INSTALL METAL CORNER GUARDS WHERE INDICATED IN WORKROOM. MOUNT AT 6" (1500MM) AFF. AFFIX WITH #6 STAINLESS STEEL OVAL HEAD SCREWS, 3" (75MM) FROM ENDS AND 12" (305MM) ON CENTER. OFFSET SCREWS ON EITHER SIDE BY 1/2" (10MM) VERTICALLY. SEE SPECIALTY EQUIPMENT SCHEDULE.
- GENERAL CONTRACTOR TO PROVIDE AND INSTALL FRP WALL FINISH BEHIND CASEWORK CABINETRY IN AREAS BELOW COUNTERTOP HEIGHT.
- SEE INTERIOR FINISH ELEVATIONS FOR FULL EXTENT OF BACK BAR WALL TILE.
- BACK BAR WALL TILE TO BE INSTALLED IN "RUNNING BOND" PATTERN.
- GENERAL CONTRACTOR TO PROVIDE FIRE TREATED WOOD STUD BLOCKING AS REQUIRED TO SUPPORT ANY WALL ATTACHMENTS. SEE BUILDING FLOOR PLAN SHEET A101 FOR MORE INFORMATION.
- INSTALL METAL CORNER GUARDS WHERE INDICATED IN CAFE. MOUNT AT 6" (1500MM) AFF. AFFIX WITH #6 STAINLESS STEEL OVAL HEAD SCREWS, 3" (75MM) FROM ENDS AND 12" (305MM) ON CENTER. OFFSET SCREWS ON EITHER SIDE BY 1/2" (10MM) VERTICALLY. MATCH SW731 MEGA GREIGE.

GENERAL NOTES

- GENERAL CONTRACTOR TO PATCH AND REPAIR ANY DAMAGE TO EXISTING WALLS TO A SMOOTH, PAINT READY SURFACE PRIOR TO PAINTING.
- FLOORS, WALLS, AND CEILING FINISHES IN FOOD PREPARATION AREAS SHALL BE SMOOTH, NON-TOXIC, NON-ABSORBENT, DURABLE, AND EASILY CLEANABLE. PAINT IN THESE AREAS SHALL BE WASHABLE, SEMI-GLOSS OR HIGH-GLOSS FINISH.
- CHANGE OF PAINT COLOR ONLY AT INSIDE CORNERS, UNLESS NOTED OTHERWISE.
- PAINT SUBSTITUTIONS ARE NOT ALLOWED. USE STARBUCKS NATIONAL SHERWIN WILLIAMS ACCOUNT "COLOR CODE" WHEN ORDERING PAINTS.
- PAINT FINISHES SHALL BE APPLIED AS FOLLOWS, UNLESS NOTED OTHERWISE:
 - WOOD AND METAL SURFACES SHALL BE SEMI-GLOSS OR EQUAL.
 - ACCENT AND TRIM PAINTS TO BE SEMI-GLOSS OR EQUAL.
 - WALL AND CEILING PAINTS TO BE EGGSHELL OR EQUAL.
 - PAINTS IN WORKROOM, RESTROOM(S), OR CAFE BAR SHALL BE SEMI-GLOSS EQUAL.
- WORKROOM TO BE FINISHED PER LOCAL CODE. GENERAL CONTRACTOR TO PROVIDE AND INSTALL WORKROOM WALL FINISHES.
- ALL WOOD SURFACES (DOORS, TRIM, SHELVES, CABINETRY, ETC.) SHALL BE SEALED.
- REFER TO INTERIOR FINISH ELEVATIONS FOR PAINT COLOR, ARTWORK, AND GRAPHICS LOCATIONS.
- GENERAL CONTRACTOR TO INSTALL WALL BLOCKING AND HANGERS FOR WALL SHELVING BEFORE INSTALLING BACK BAR WALL TILE.

WALL TREATMENT LEGEND

- INDICATES WALL COVERING - HURLY BURLY 2 - GOLD COFFEE BEAN DID: 24758
- WOOD - WALNUT - MAD101 REVEAL SLAT DID: x9403
- INDICATES FRP WALL COVERING UP TO 2' - 10" DID:23764 INDICATES BACKBAR WALL TILE - INAX HIIRONE - GLAZED UP TP 7'-0" AND SW 7030 ANEW GRAY UP TO CEILING DID: 24753
- INDICATES PAINTED FINISH WITH WOOD TRIMS - HC-188 ESSEX GREEN UP TO 7'-8" AND SW 7032 WARM STONE UP TO CEILING
- INDICATES PAINTED FINISH - SW 7032 WARM STONE
- INDICATES VENEER - PLAM - WALNUT WOODGRAIN DID: x9402
- INDICATES BACK OF HOUSE - POLYWALL WALL COVERING - MATTE WHITE DID: 23764
- INDICATES BACKBAR WALL TILE - INAX HIIRONE - GLAZED UP TP 7'-0" AND SW 7030 ANEW GRAY UP TO CEILING DID: 24753

INDICATES STAINLESS STEEL CORNER GUARD FOR BOH OR HOT ROLLED STEEL CORNER GUARD FOR CAFE SPACE. INSTALL 6" (150mm) TO 42" (1065mm) AFF UNLESS OTHERWISE NOTED. PAINTED TO MATCH ADJACENT WALL.

AREA OUT OF SCOPE, NIC.

- SEE INTERIOR FINISH ELEVATIONS FOR TAGGED LOCATION OF WALL FINISH MATERIAL.
- SEE RESTROOM PLAN & ELEVATIONS FOR TAGGED LOCATION OF WALL FINISH MATERIAL

LICENSED STORES RESPONSIBILITY LEGEND

- SB - STARBUCKS
FC - STARBUCKS FIXTURE CONTRACTOR
LC - LICENSEE
GC - LICENSEE'S GENERAL CONTRACTOR
3PV - STARBUCKS THIRD - PARTY VENDOR

ARCHITECT OF RECORD:

THOMAS E. MORGAN, JR.
ARCHITECT

423 FISCHER TRAIL
ELLIJAY, GEORGIA 30540

SEAL:

MRP
DESIGN GROUP

3450 Acworth Due West Road
Building 100, Suite 120
Kennesaw, Georgia 30144
P. 770-917-9172
F. 770-917-9470
www.mrpdesign.com

RELEASED FOR CONSTRUCTION

ISSUES / REVISIONS:

DATE	DESCRIPTION
05.04.26	RELEASE FOR CONSTRUCTION

DRAWN BY: JB

CHKD BY: TM

PROJECT DESCRIPTION:

NEW CONSTRUCTION OF A TA TRAVEL CENTER IN JEFFERSONVILLE, GA, WHICH CONSISTS OF A TRUCKER LOUNGE, SHOWERS, LAUNDRY ROOM, RETAIL AREA, RESTROOMS, GAME AREA, SEATING AREAS, AND FOUR QUICK-SERVICE RESTAURANTS. THE MAJORITY OF THE PROJECT HAS ALREADY BEEN SUBMITTED. THIS ISSUE, DATED 05.04.26 HAS MODIFICATIONS RELATED TO THE ADDITION OF THE STARBUCKS QSR.

PROJECT TITLE:

TRAVEL CENTER
4838 SR 96
JEFFERSONVILLE,
GEORGIA 31044


SHEET TITLE:

INTERIOR
WALL
FINISH
PLAN


PROJECT NO: 25021

1107


THESE PLANS ARE THE PROPERTY OF MRP DESIGN GROUP, INC. AND ARE SUBJECT TO FEDERAL COPYRIGHT LAWS. ANY USE OF SAME WITHOUT THE EXPRESS WRITTEN PERMISSION OF MRP DESIGN GROUP, INC. IS STRICTLY PROHIBITED.

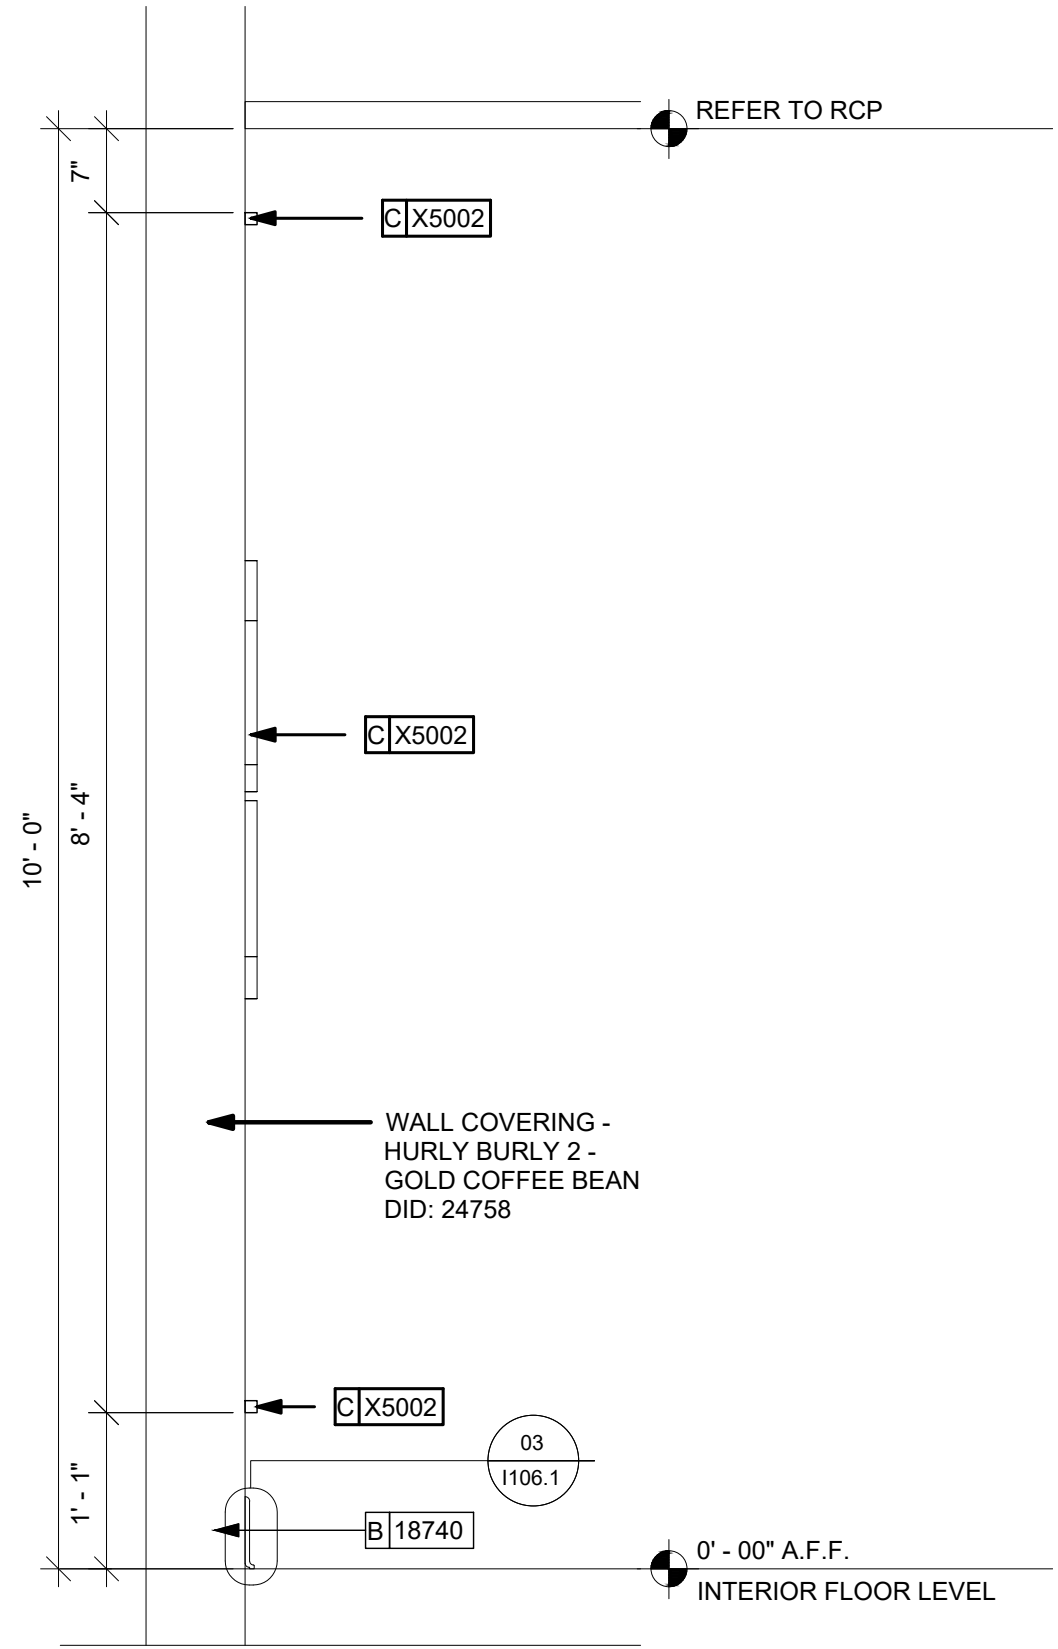


01 WALL TYPE 1 - TRANSITIONS
Scale: 3/4" = 1'-0"

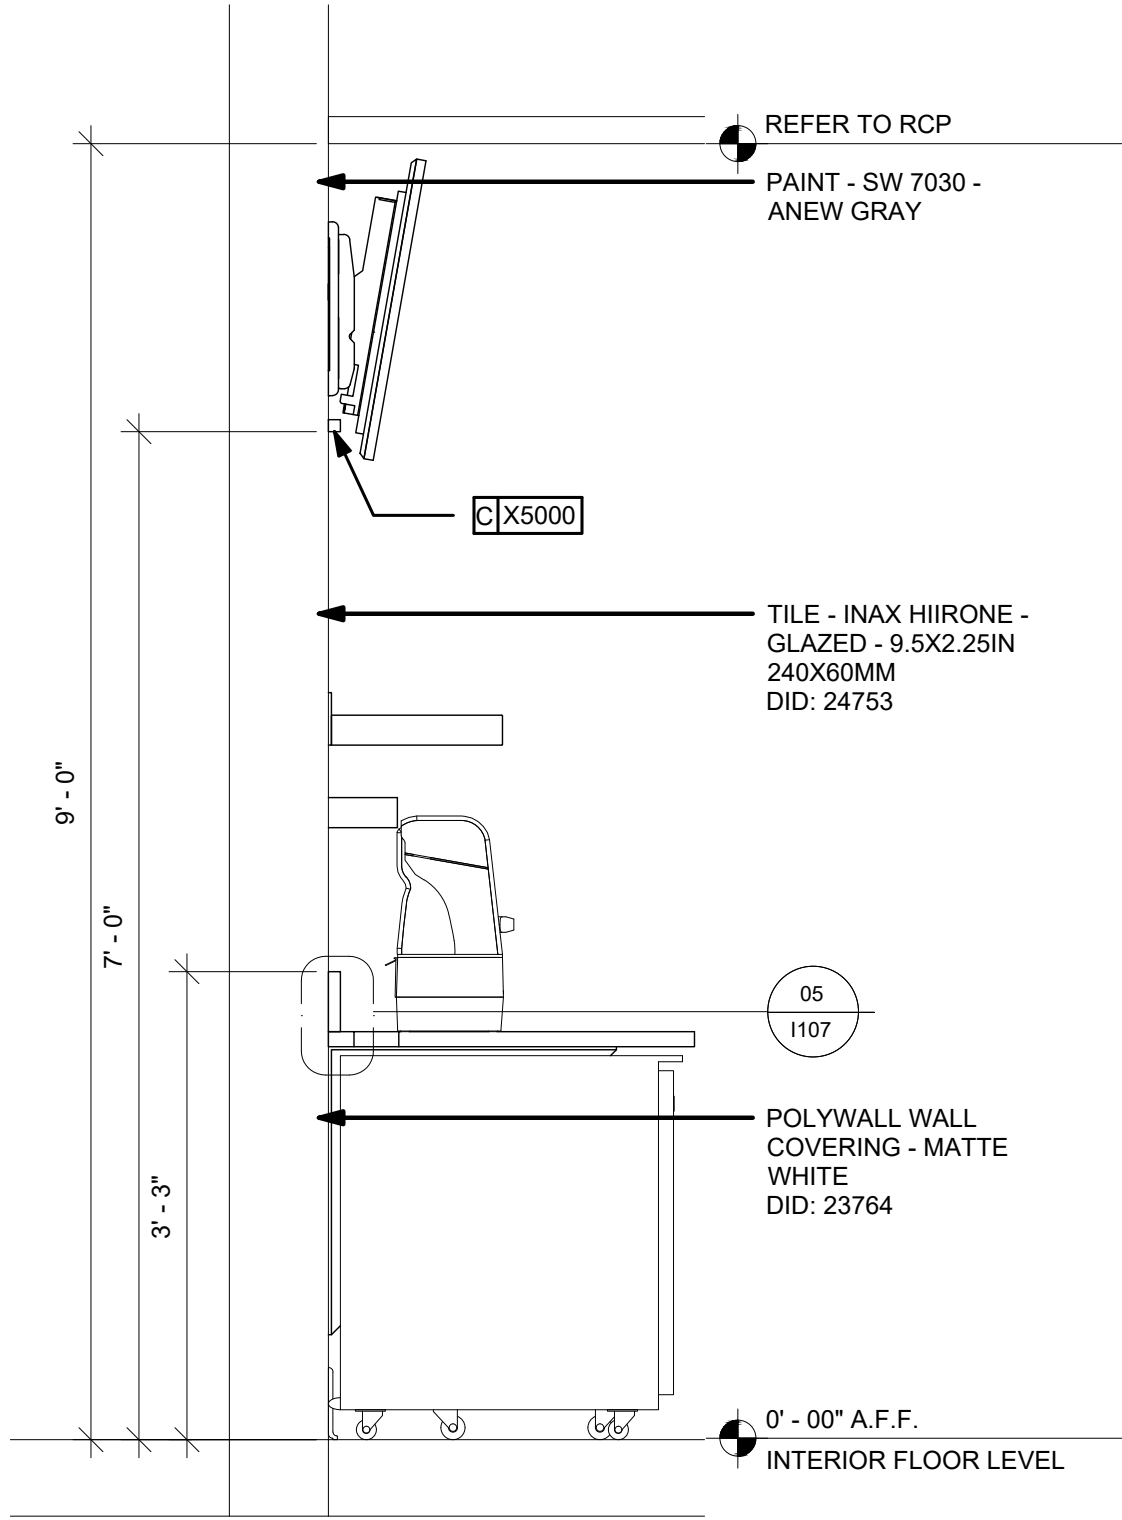


02 WALL TYPE 2 - TRANSITIONS
Scale: 3/4" = 1'-0"

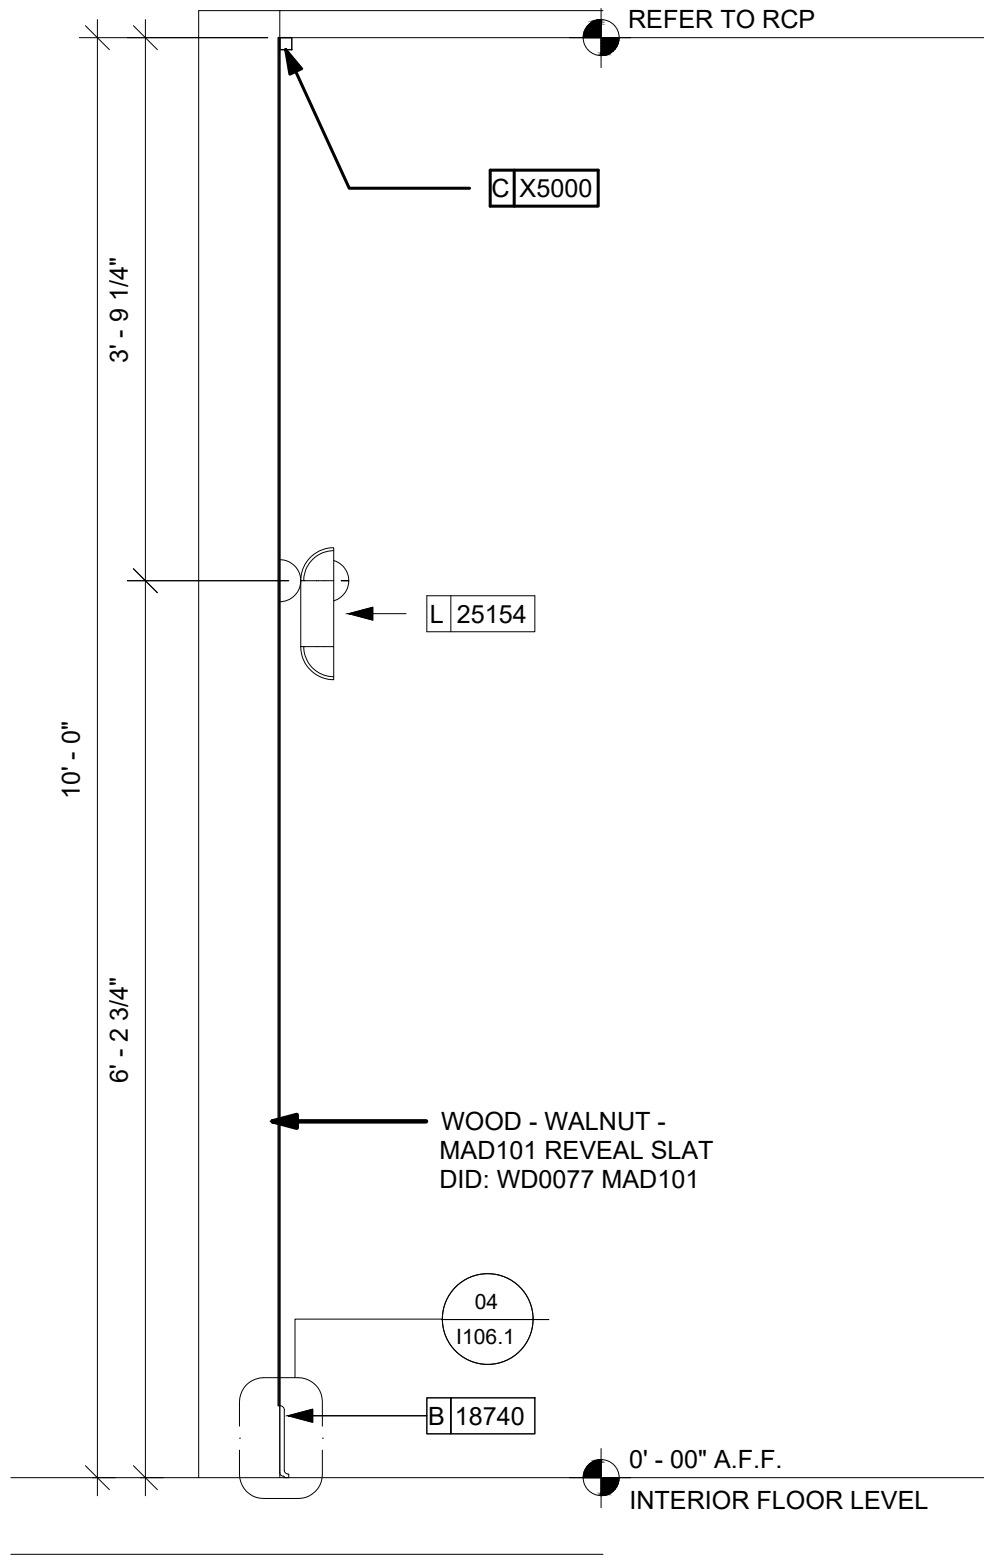


03 WALL TYPE 3 - TRANSITIONS
Scale: 3/4" = 1'-0"

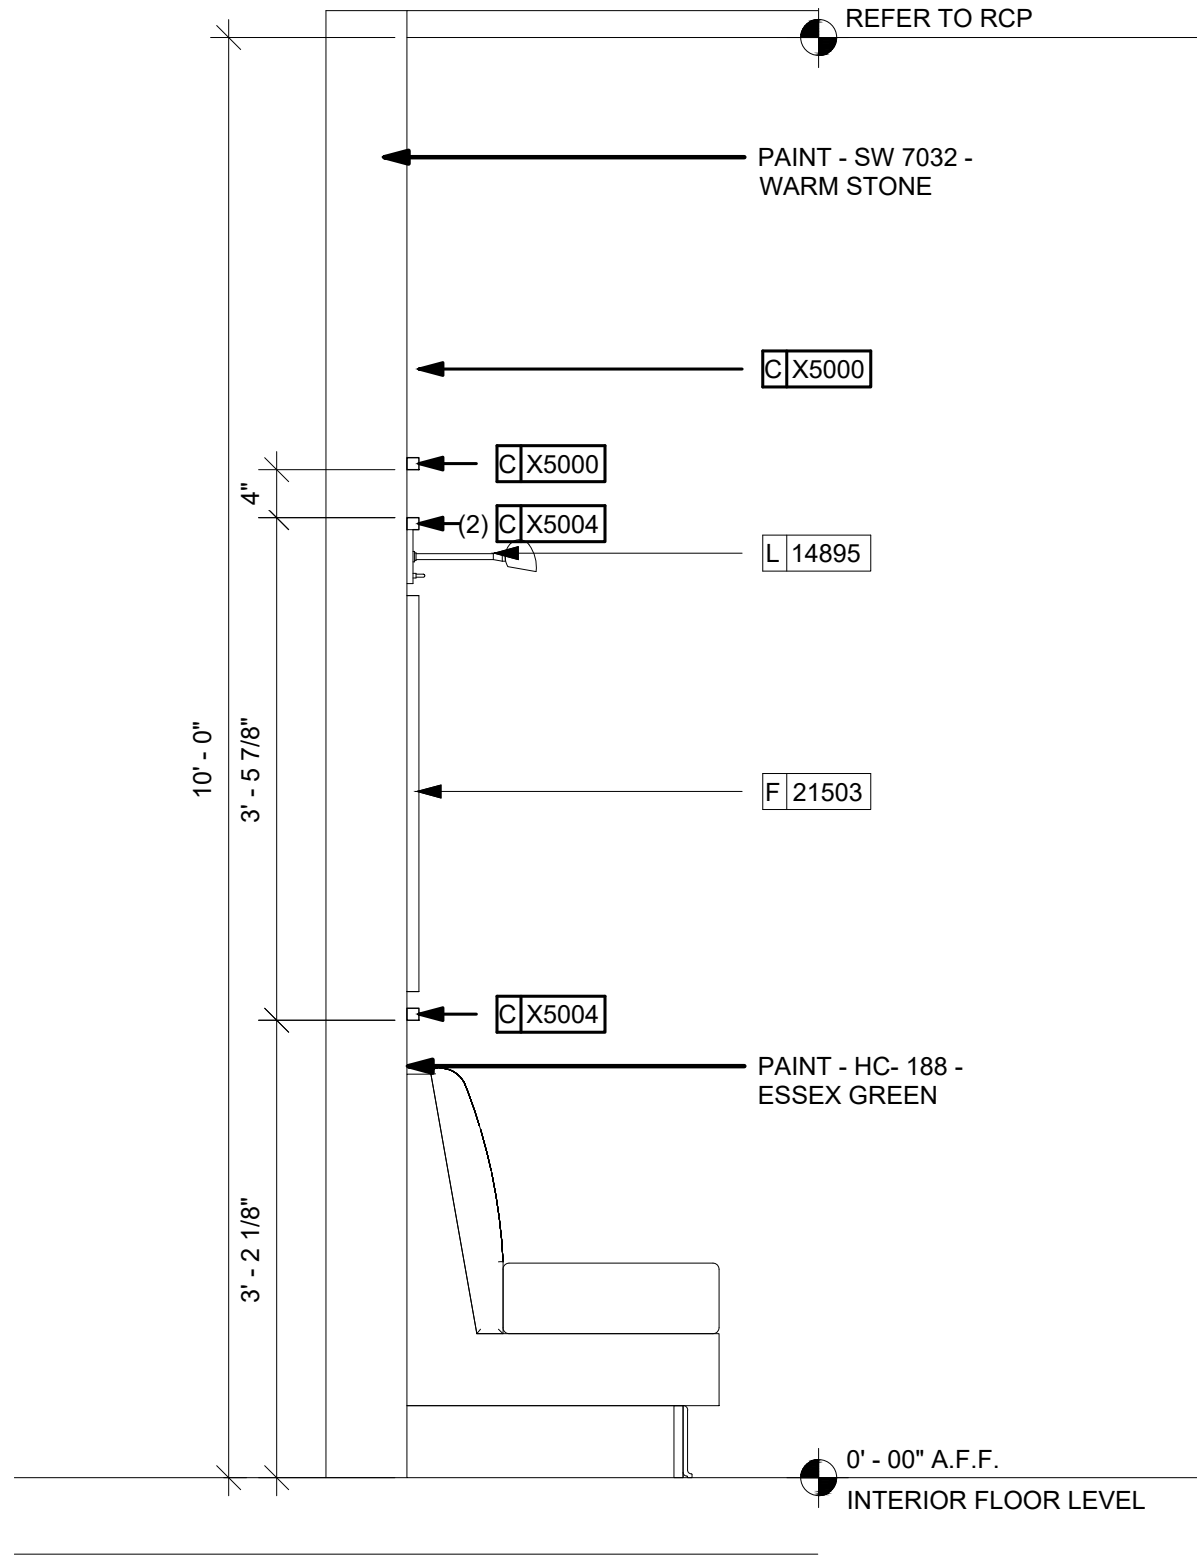


04 WALL TYPE 4 - TRANSITIONS
Scale: 3/4" = 1'-0"

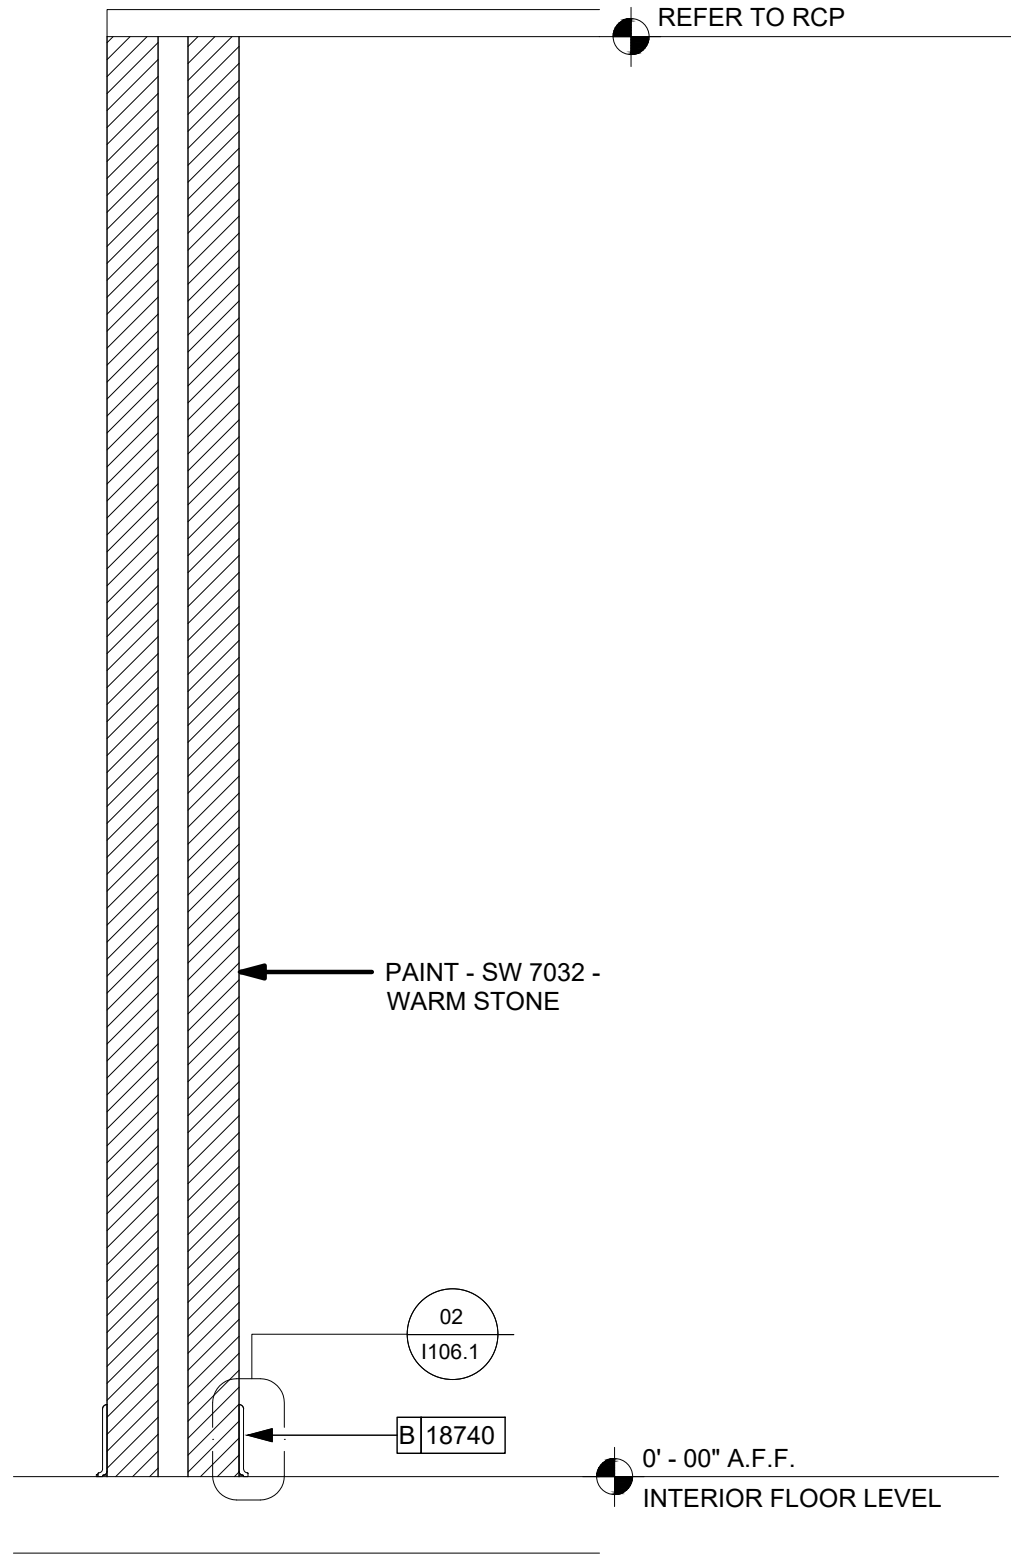

05 WALL TYPE 5 - TRANSITIONS
Scale: 3/4" = 1'-0"

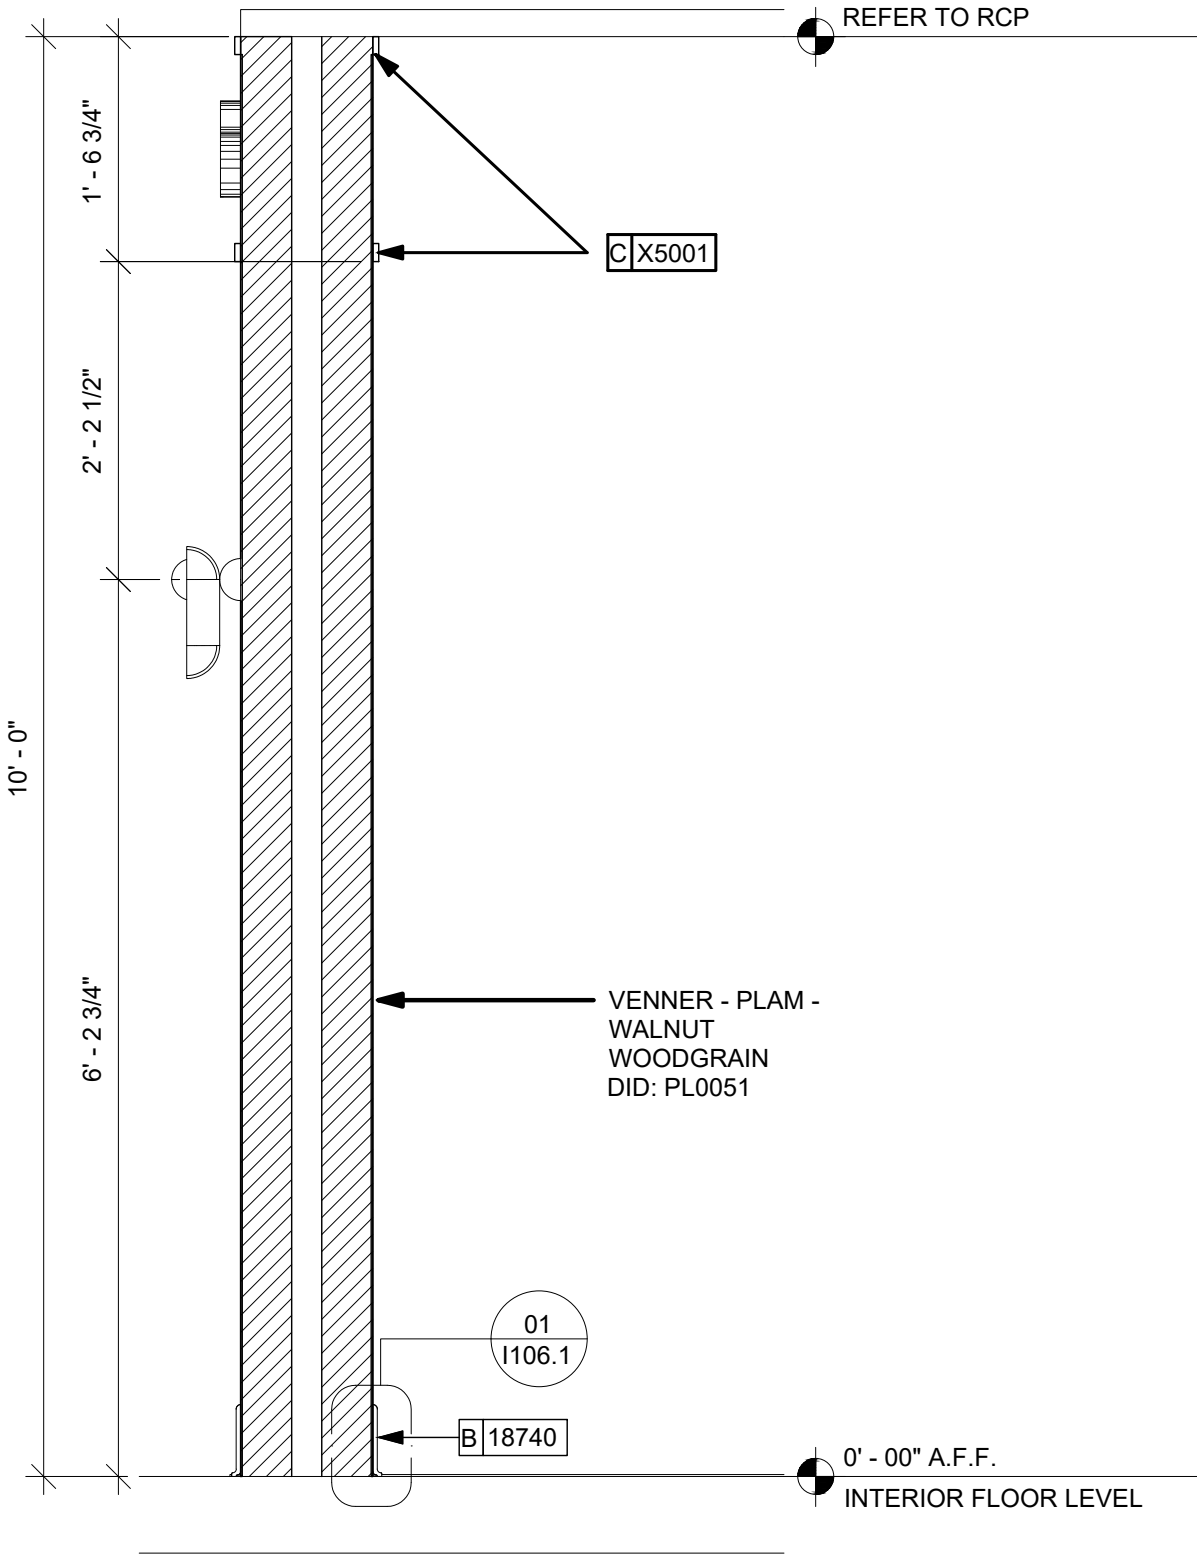

06 WALL TYPE 6 - TRANSITIONS
Scale: 3/4" = 1'-0"

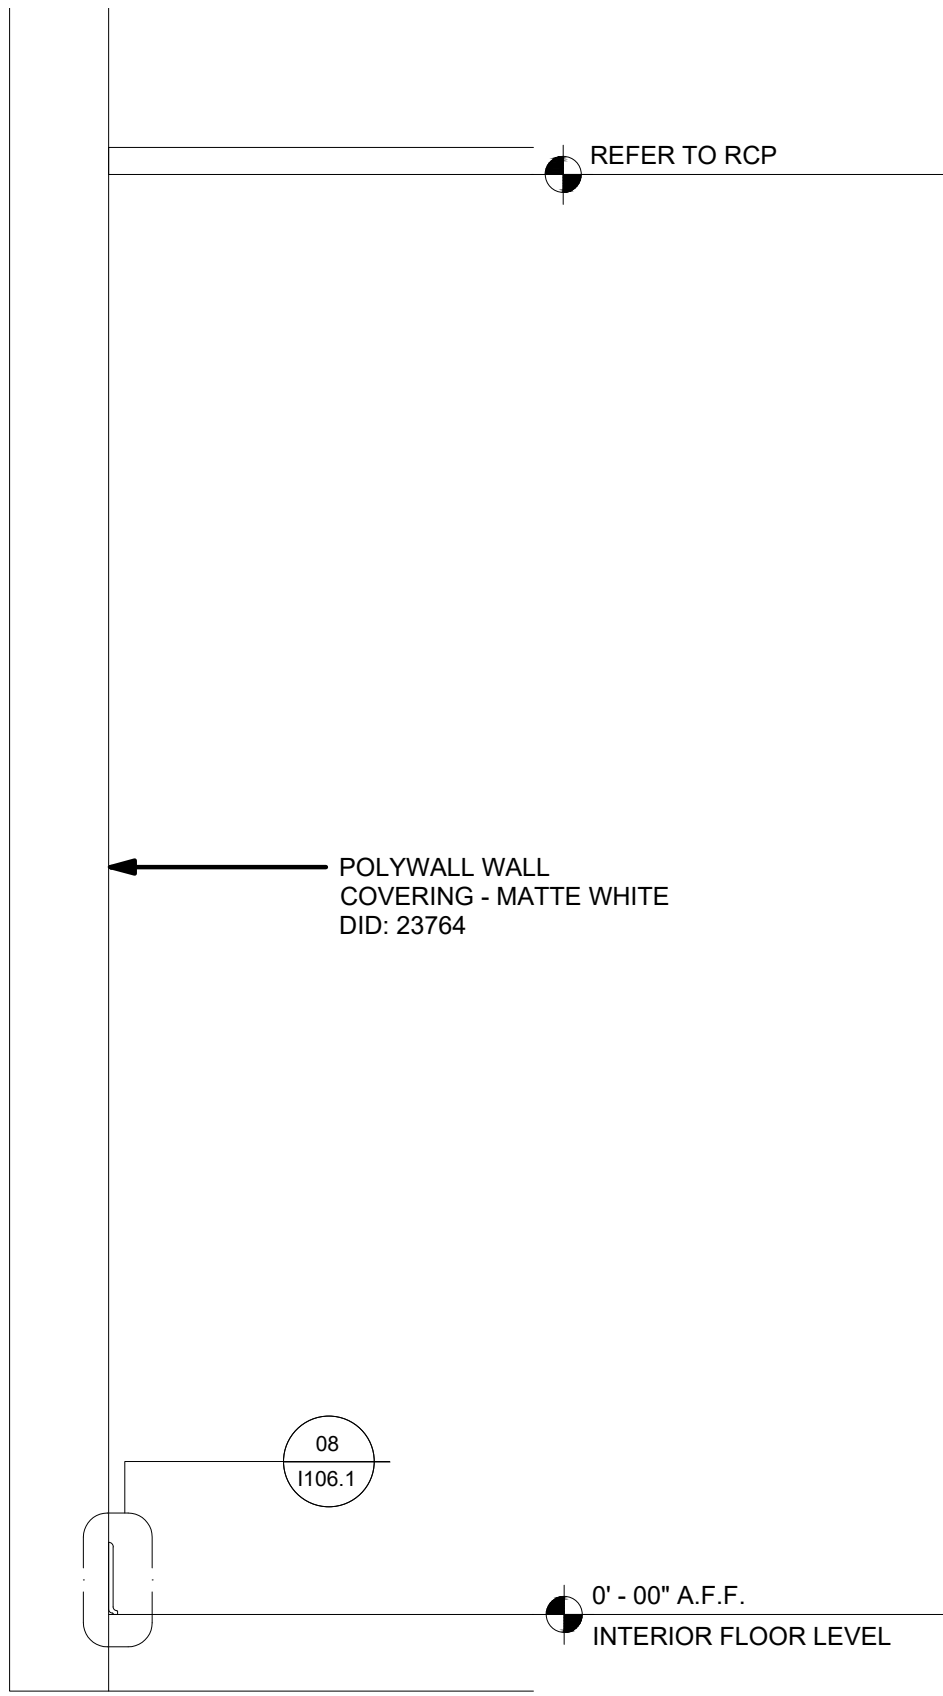


07 WALL TYPE 7 - TRANSITIONS
Scale: 3/4" = 1'-0"

ARCHITECT OF RECORD:

THOMAS E. MORGAN, JR.
ARCHITECT

423 FISCHER TRAIL
ELLIJAY, GEORGIA 30540

SEAL:

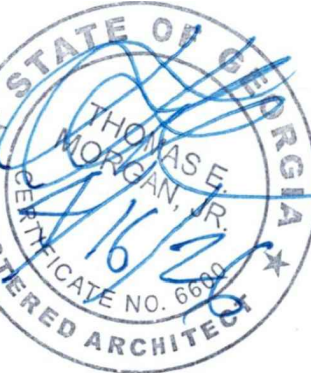

MRP
DESIGN GROUP

3450 Acworth Due West Road
Building 100, Suite 120
Kennesaw, Georgia 30144
P: 770-917-9172
F: 770-917-9470
www.mrpdesign.com

RELEASED FOR
CONSTRUCTION

ISSUES / REVISIONS:

DATE	DESCRIPTION
05.04.26	RELEASE FOR CONSTRUCTION

DRAWN BY: JB

CHKD BY: TM

PROJECT DESCRIPTION:

NEW CONSTRUCTION OF A TA TRAVEL CENTER IN JEFFERSONVILLE, GA, WHICH CONSISTS OF A TRUCKER LOUNGE, SHOWERS, LAUNDRY ROOM, RETAIL AREA, RESTROOMS, GAME AREA, SEATING AREAS, AND FOUR QUICK-SERVICE RESTAURANTS. THE MAJORITY OF THE PROJECT HAS ALREADY BEEN SUBMITTED. THIS ISSUE, DATED 05.04.26 HAS MODIFICATIONS RELATED TO THE ADDITION OF THE STARBUCKS QSR.

PROJECT TITLE:

TRAVEL CENTER
4838 SR 96
JEFFERSONVILLE,
GEORGIA 31044

SHEET TITLE:

INTERIOR
WALL
FINISH
DETAILS

PROJECT NO: 25021

1107.1

FOR REFERENCE ONLY

201

KEYED NOTES

- ATTACH MENU BOARDS PER INSTALLATION DETAILS.
1. SHELVING FOR CBE STATION AS SHOWN.
2. GENERAL CONTRACTOR TO PROVIDE WALL BLOCKING FOR FASTENERS.
3. GENERAL CONTRACTOR TO PROVIDE AND INSTALL FRP WALL FINISH BEHIND CASEWORK CABINETS IN AREAS BELOW COUNTERTOP HEIGHT.
4. START POINT OF TILE.
5. WALL MOUNT HAND SINK WITH SOAP AND PAPER TOWEL DISPENSER. ENSURE MOUNTING HEIGHTS CONFORM TO ACCESSIBILITY CODES. GENERAL CONTRACTOR TO PROVIDE BLOCKING FOR FASTENERS.
6. PENDANT LIGHT FIXTURE. SEE REFLECTED CEILING PLAN ON SHEET H103 AND LIGHTING PLAN ON SHEET E102 FOR ADDITIONAL INFORMATION.
7. ICE MACHINE. SEE PLUMBING AND ELECTRICAL DRAWINGS FOR ADDITIONAL INFORMATION.
8. WAREWASHER/SANITIZER SET ON CASTERS FOR CLEANING AREA.
9. WATER HEATER ABOVE. SEE PLUMBING DRAWINGS.
10. ELECTRICAL PANELS. SEE ELECTRICAL DRAWINGS FOR ADDITIONAL INFORMATION.
1. WATER FILTRATION EQUIPMENT NOT SHOWN IN ACTUAL LOCATIONS. REFER TO MANUFACTURER'S INSTALLATION INSTRUCTIONS FOR PROPER CONFIGURATION AND PLUMBING REQUIREMENTS.
2. WALL BLOCKING. FOR MORE INFORMATION REFER TO SHEET A402.

LEGEND

INDICATES WALL BLOCKING.
FIRE TREATED WALL BLOCKING TO BE
PROVIDED AS REQUIRED TO SUPPORT WALL
ATTACHMENTS. EXTEND BLOCKING 4" (100mm)
BEYOND EDGE OF ATTACHMENTS.

← → GRAIN DIRECTION

AREA OUT OF SCOPE, NIC.




FOR REFERENCE ONLY

202


- 04 INTERIOR ELEVATION - ART WALL
Scale: 3/8" = 1'-0"

FOR REFERENCE ONLY


THESE PLANS ARE THE PROPERTY OF MRP DESIGN GROUP, INC. AND ARE SUBJECT TO FEDERAL COPYRIGHT LAWS. ANY USE OF SAME WITHOUT THE EXPRESS WRITTEN PERMISSION OF MRP DESIGN GROUP, INC. IS STRICTLY PROHIBITED.

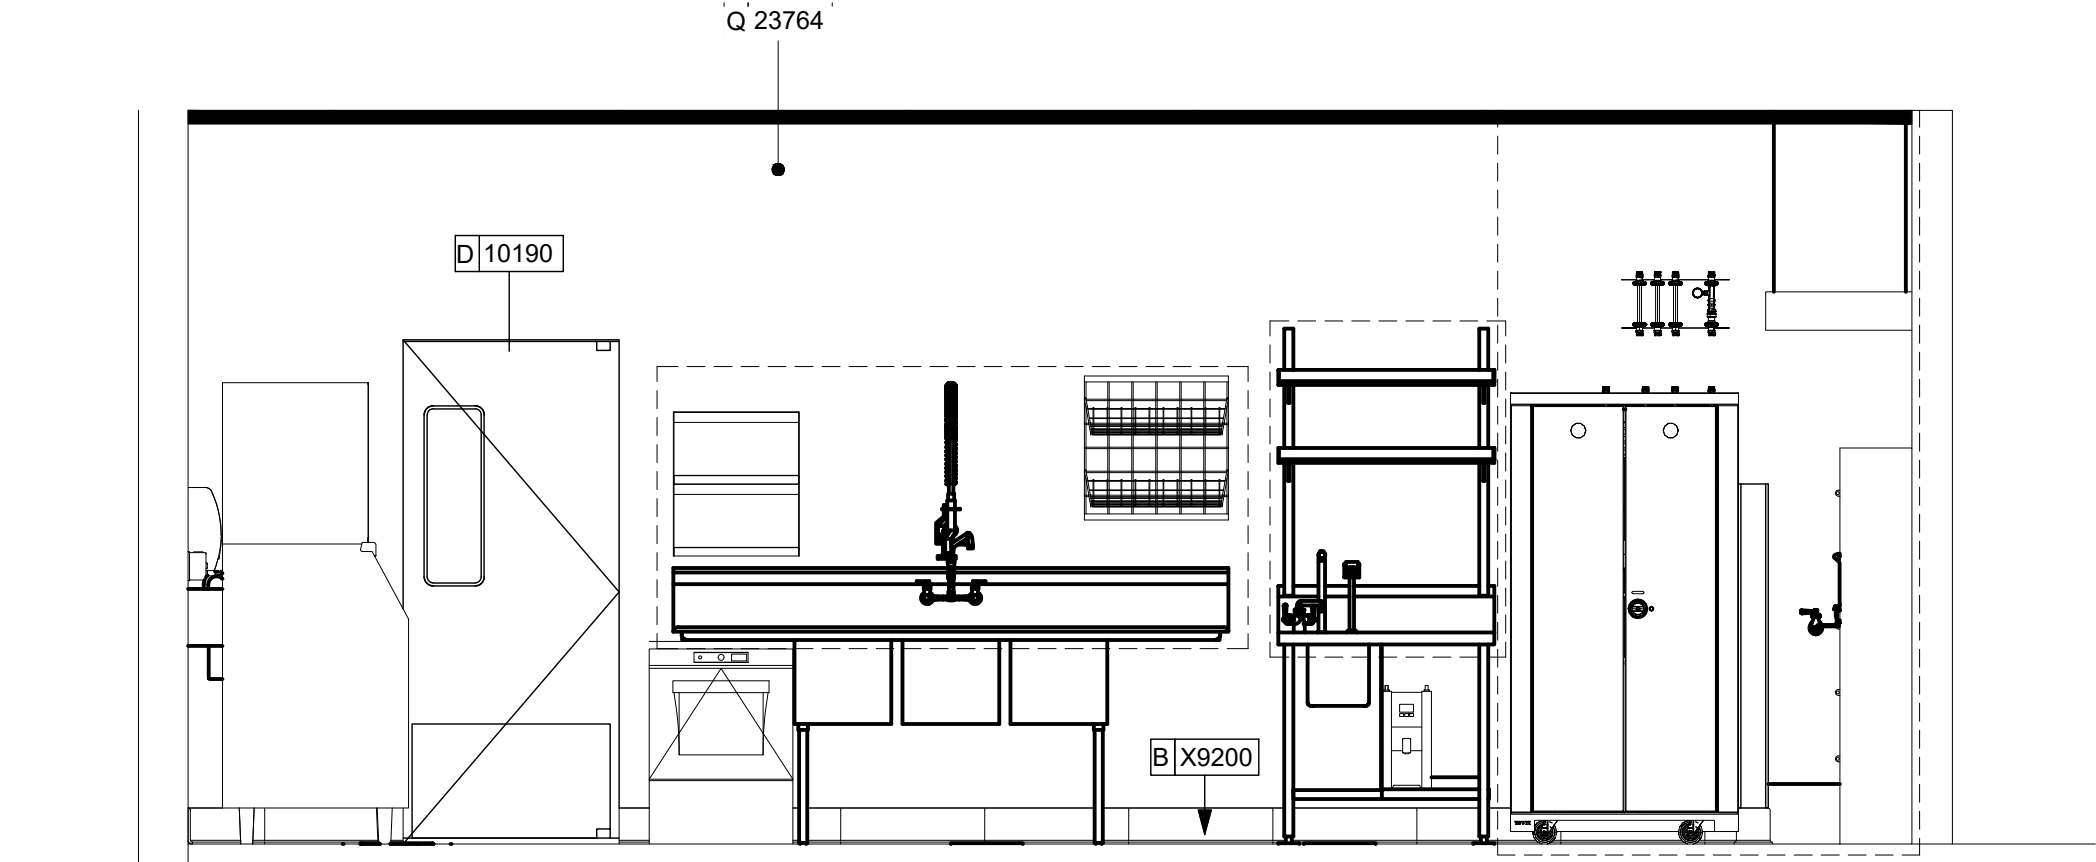


01 INTERIOR ELEVATION @ BOH ENTRANCE
Scale: 3/8" = 1'-0"

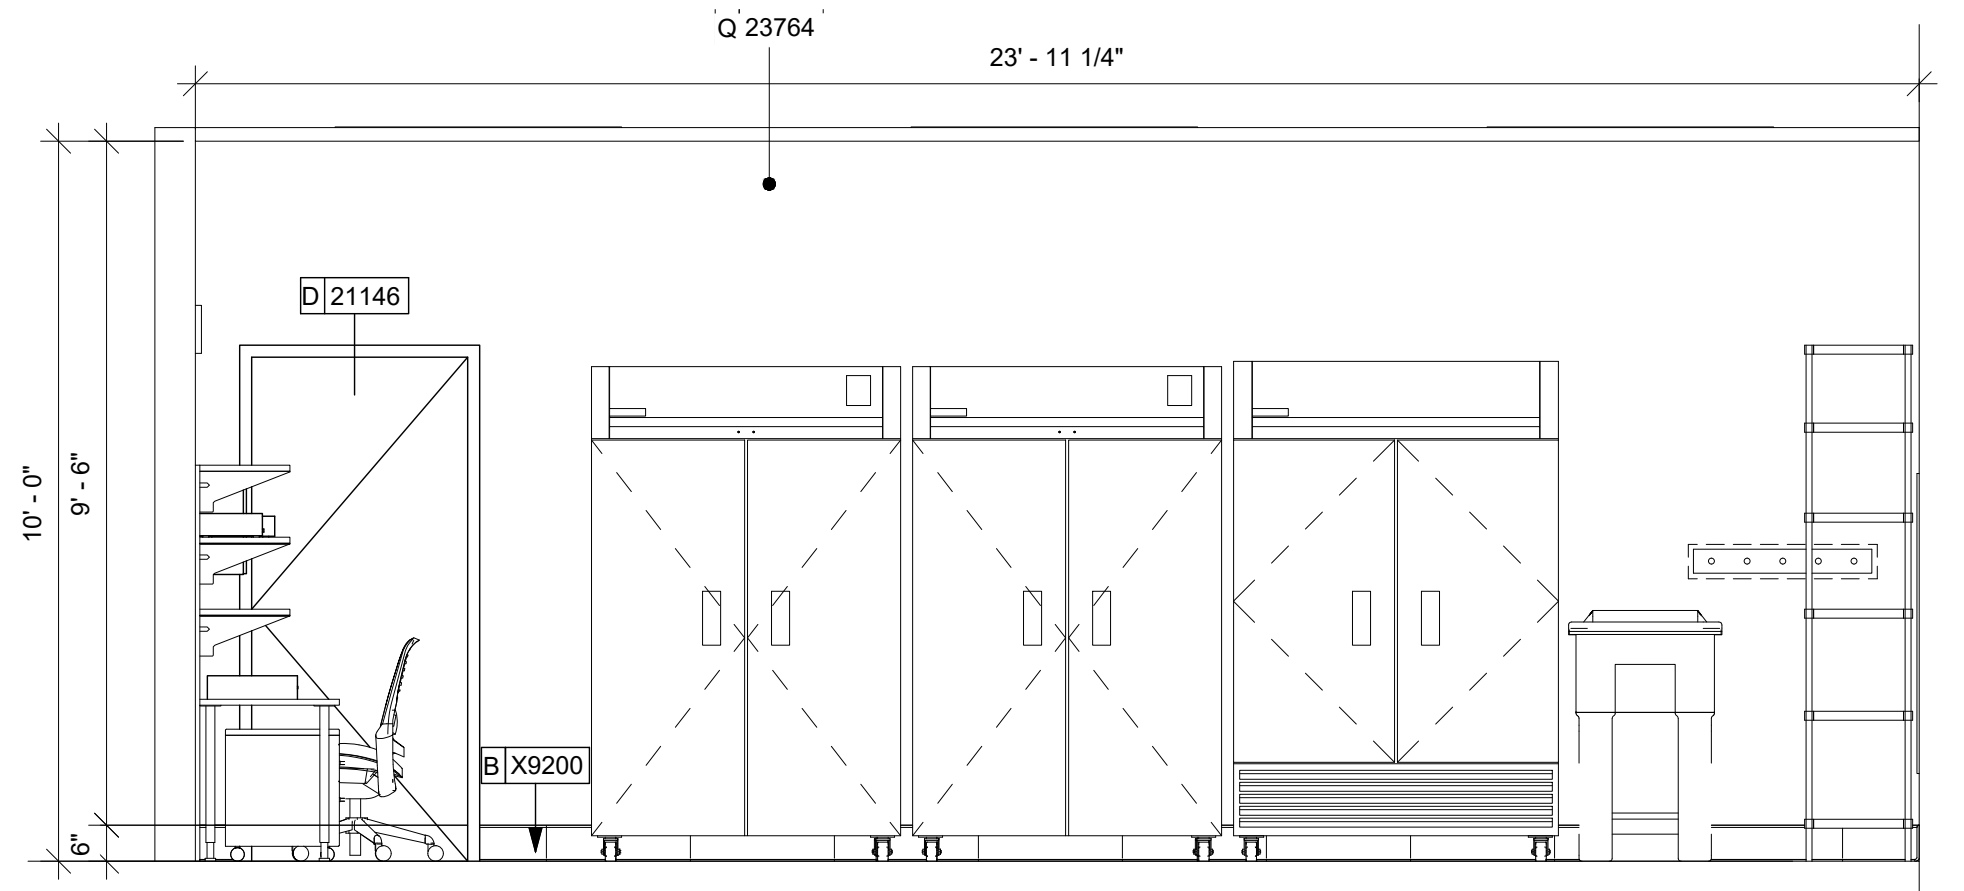

02 INTERIOR ELEVATION @ BOH EXIT
Scale: 3/8" = 1'-0"

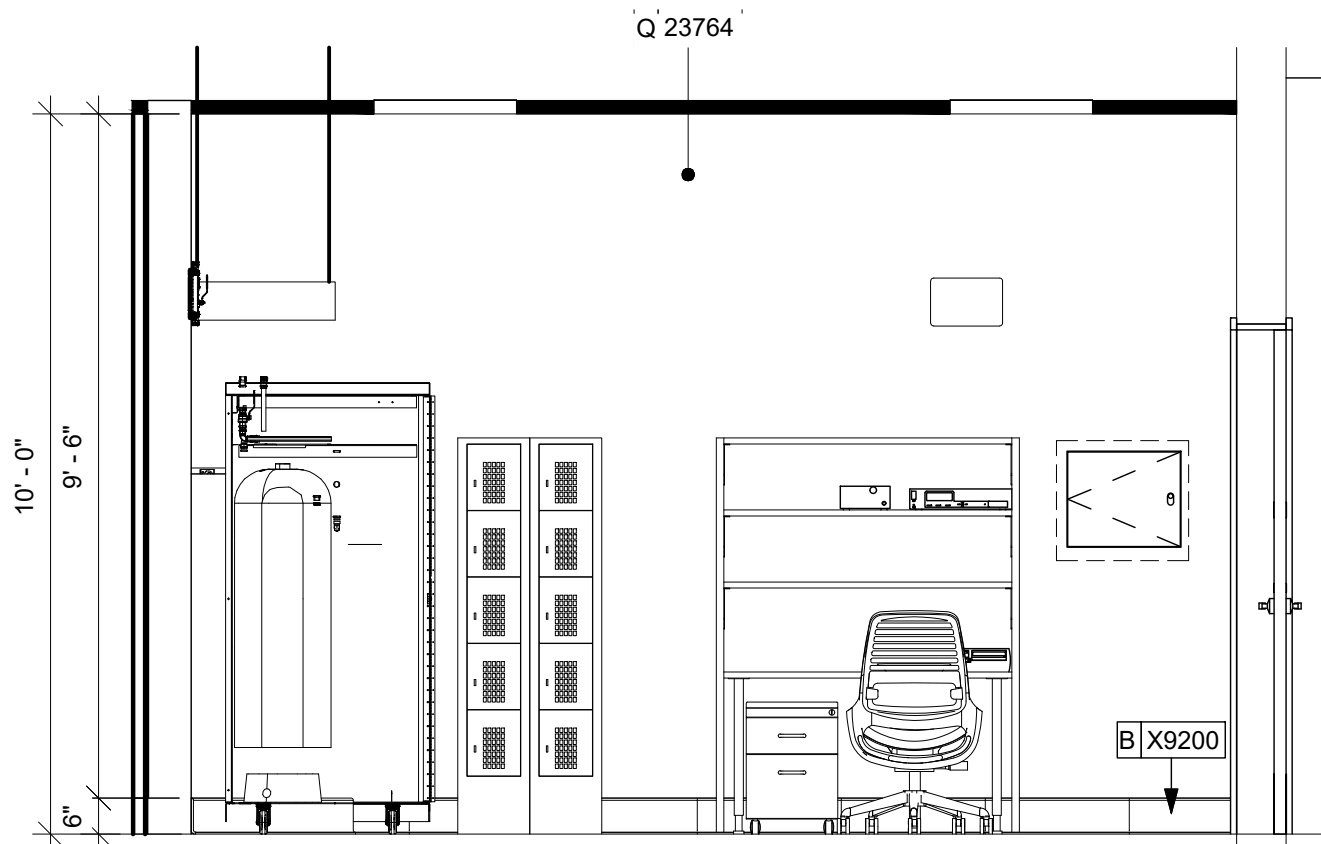

03 INTERIOR ELEVATION @ MGR DESK
Scale: 3/8" = 1'-0"

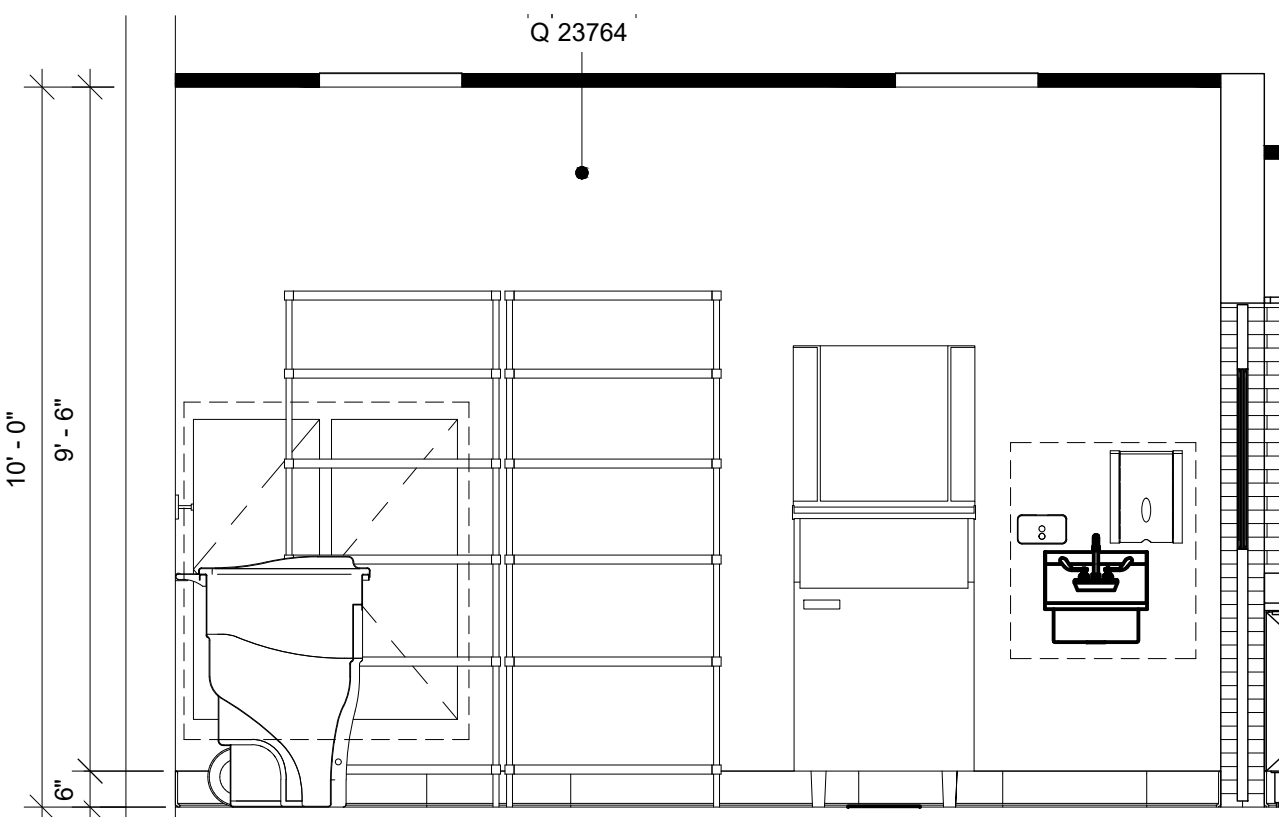

04 INTERIOR ELEVATION @ POWER PANELS
Scale: 3/8" = 1'-0"

KEYED NOTES

1. ATTACH MENU BOARDS PER INSTALLATION DETAILS.
2. SHELVING FOR CBE STATION AS SHOWN. GENERAL CONTRACTOR TO PROVIDE WALL BLOCKING FOR FASTENERS.
3. GENERAL CONTRACTOR TO PROVIDE AND INSTALL FRP WALL FINISH BEHIND CASEWORK CABINETS IN AREAS BELOW COUNTERTOP HEIGHT.
4. START POINT OF TILE.
5. WALL MOUNT HAND SINK WITH SOAP AND PAPER TOWEL DISPENSER. ENSURE MOUNTING HEIGHTS CONFORM TO ACCESSIBILITY CODES. GENERAL CONTRACTOR TO PROVIDE BLOCKING FOR FASTENERS.
6. CHAIR RAIL. SEE CASEWORK SCHEDULE ON SHEET I102 AND INTERIOR WALL FINISH PLAN SHEET I106 FOR MORE INFORMATION.
7. PENDANT LIGHT FIXTURE. SEE REFLECTED CEILING PLAN ON SHEET I103 AND LIGHTING PLAN ON SHEET E102 FOR ADDITIONAL INFORMATION.
8. ICE MACHINE. SEE PLUMBING AND ELECTRICAL DRAWINGS FOR ADDITIONAL INFORMATION.
9. WAREWASHER/SANITIZER SET ON CASTERS FOR CLEANING ACCESS.
10. WATER HEATER ABOVE. SEE PLUMBING DRAWINGS.
11. ELECTRICAL PANELS. SEE ELECTRICAL DRAWINGS FOR ADDITIONAL INFORMATION.
12. WATER FILTRATION EQUIPMENT NOT SHOWN IN ACTUAL LOCATIONS. REFER TO MANUFACTURER'S INSTALLATION INSTRUCTIONS FOR PROPER CONFIGURATION AND PLUMBING REQUIREMENTS.
13. WALL BLOCKING, FOR MORE INFORMATION REFER TO SHEET A402.

GENERAL NOTES

- A. FLOORS, WALL, AND CEILING FINISHES IN FOOD PREPARATION AREAS SHALL BE SMOOTH, NON-TOXIC, NON-ABSORBENT, DURABLE, AND EASILY CLEANABLE. PAINT IN THESE AREAS SHALL BE WASHABLE; SEMI-GLOSS OR HIGH GLOSS FINISH.
- B. CHANGE OF PAINT COLOR ONLY AT INSIDE CORNERS, UNLESS NOTED OTHERWISE.
- C. PAINT SUBSTITUTIONS ARE NOT ALLOWED. USE STARBUCKS NATIONAL SHERWIN WILLIAMS ACCOUNT "COLOR CODE" WHEN ORDERING PAINTS.
- D. PAINT FINISHES SHALL BE APPLIED AS FOLLOWS, UNLESS NOTED OTHERWISE:
 - 1) WOODS AND METAL SURFACES SHALL BE SEMI-GLOSS OR EQUAL.
 - 2) ACCENT AND TRIM PAINTS SHALL BE SEMI-GLOSS OR EQUAL.
 - 3) WALL AND CEILING PAINTS SHALL BE EGGSHELL OR EQUAL.
 - 4) PAINTS IN WORKROOM RESTROOM(S) OR CAFE BAR SHALL BE SEMI-GLOSS OR EQUAL.
- E. REFER TO INTERIOR WALL FINISH PLAN SHEET I106 FOR PAINT SCHEDULE AND WALL FINISH SCHEDULE.
- F. WORKROOM TO BE FINISHED PER LOCAL CODE. GENERAL CONTRACTOR TO PROVIDE AND INSTALL WORKROOM WALL FINISHES.
- G. ALL WOOD SURFACES (DOORS, TRIM, SHELVES, CABINETRY) SHALL BE SEALED.
- H. ALL FLOOR AND WALL JUNCTIONS IN STORAGE AND FOOD PREPARATION AREAS SHALL HAVE A 6" COVED BASE.
- I. GENERAL CONTRACTOR TO INSTALL WALL BLOCKING AND HANGERS FOR WALL SHELVING BEFORE INSTALLING BACK BAR WALL TILE.
- J. REFER TO MANUFACTURER'S INSTRUCTIONS INCLUDED WITH ARTWORK / GRAPHICS FOR PROPER INSTALLATION.

LEGEND


- INDICATES WALL BLOCKING. FIRE TREATED WALL BLOCKING TO BE PROVIDED AS REQUIRED TO SUPPORT WALL ATTACHMENTS. EXTEND BLOCKING 4" (100mm) BEYOND EDGE OF ATTACHMENTS.
- GRAIN DIRECTION
- AREA OUT OF SCOPE, NIC.

ARCHITECT OF RECORD:

THOMAS E. MORGAN, JR.
ARCHITECT

423 FISCHER TRAIL
ELLIJAY, GEORGIA 30540

SEAL:

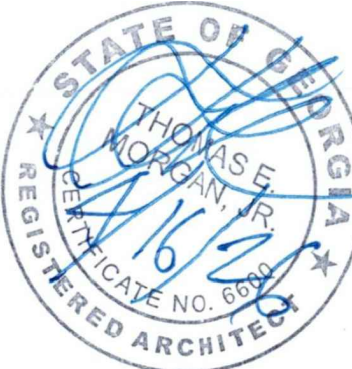

MRP
DESIGN GROUP

3450 Acworth Due West Road
Building 100, Suite 120
Kennesaw, Georgia 30144
P. 770-917-9172
F. 770-917-9470
www.mrpdesign.com

RELEASED FOR CONSTRUCTION

ISSUES / REVISIONS:

DATE	DESCRIPTION
05.04.26	RELEASE FOR CONSTRUCTION

DRAWN BY: JB

CHKD BY: TM

PROJECT DESCRIPTION:

NEW CONSTRUCTION OF A TA TRAVEL CENTER IN JEFFERSONVILLE, GA. WHICH CONSISTS OF A TRUCKER LOUNGE, SHOWERS, LAUNDRY ROOM, RETAIL AREA, RESTROOMS, GAME AREA, SEATING AREAS, AND FOUR QUICK-SERVICE RESTAURANTS. THE MAJORITY OF THE PROJECT HAS ALREADY BEEN SUBMITTED. THIS ISSUE, DATED 05.04.26 HAS MODIFICATIONS RELATED TO THE ADDITION OF THE STARBUCKS QSR.

PROJECT TITLE:

TRAVEL CENTER
4838 SR 96
JEFFERSONVILLE,
GEORGIA 31044

SHEET TITLE:


INTERIOR
FINISH
ELEVATIONS

PROJECT NO: 25021

1203


FOR REFERENCE ONLY

THESE PLANS ARE THE PROPERTY OF MRP DESIGN GROUP, INC. AND ARE SUBJECT TO FEDERAL COPYRIGHT LAWS. ANY USE OF SAME WITHOUT THE EXPRESS WRITTEN PERMISSION OF MRP DESIGN GROUP, INC. IS STRICTLY PROHIBITED

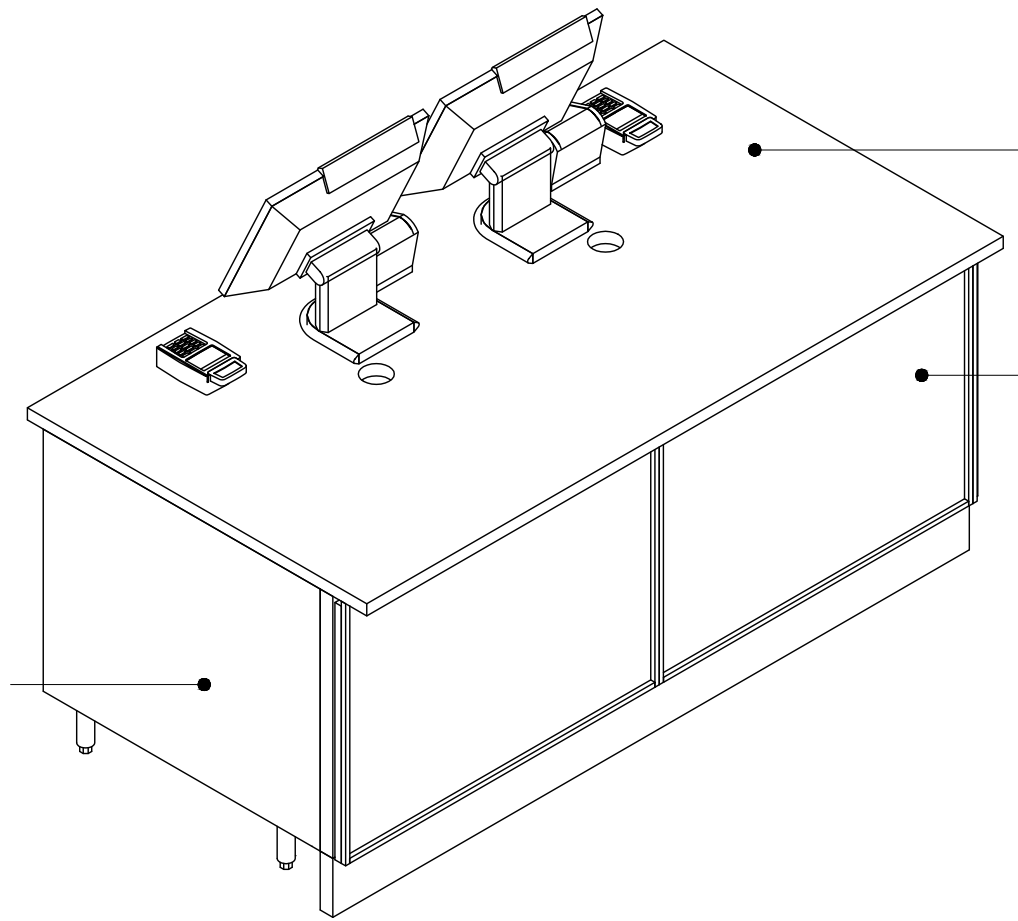


01 POS FRONT 3D VIEW

Scale:

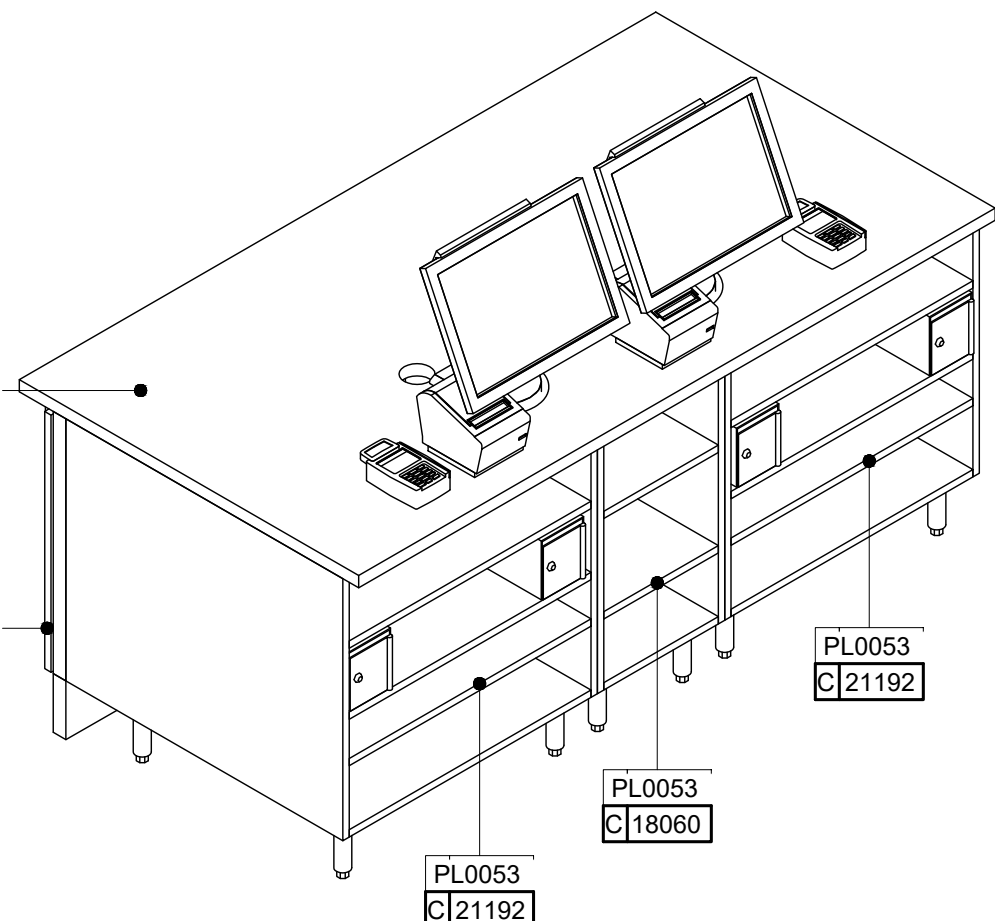


02 POS BACK 3D VIEW

Scale:

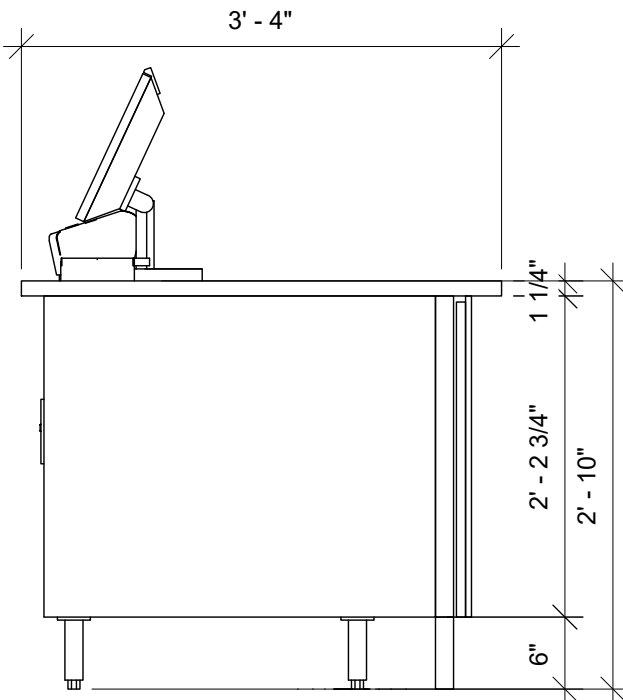


03 POS - SIDE ELEVATION

Scale: 3/4" = 1'-0"

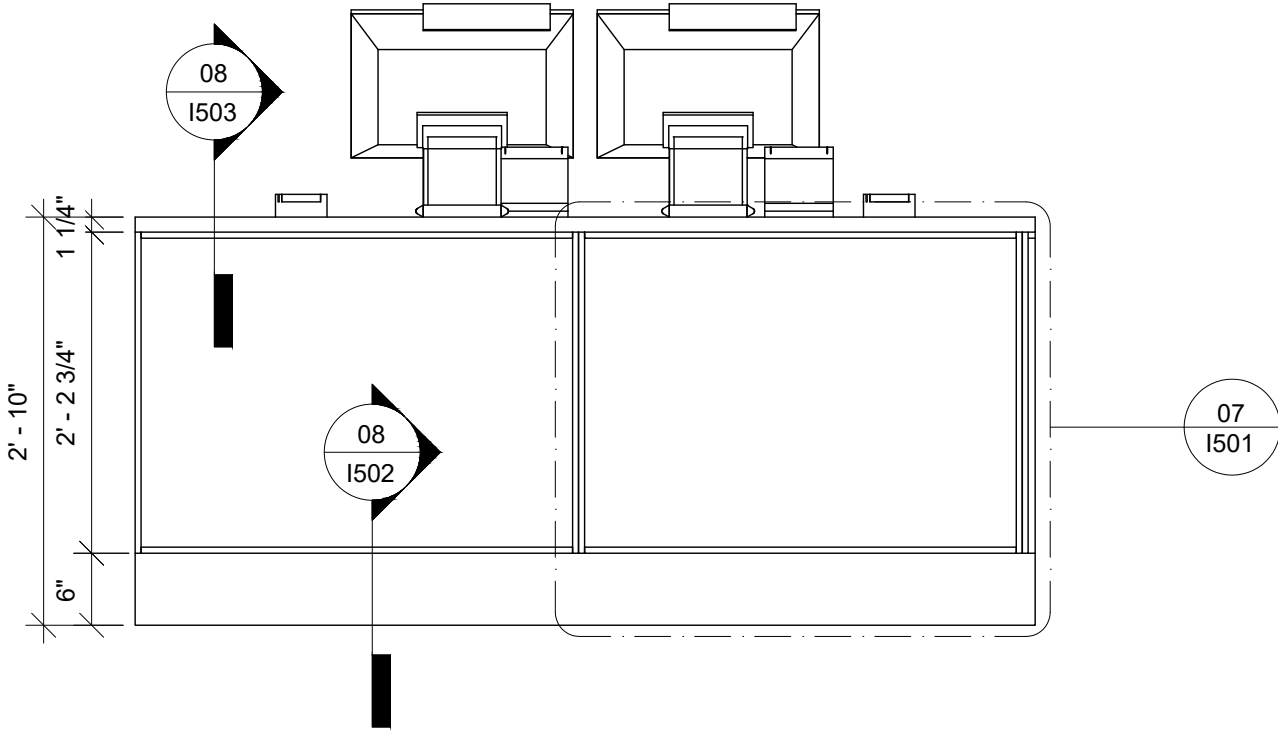


04 POS -FRONT ELEVATION

Scale: 3/4" = 1'-0"

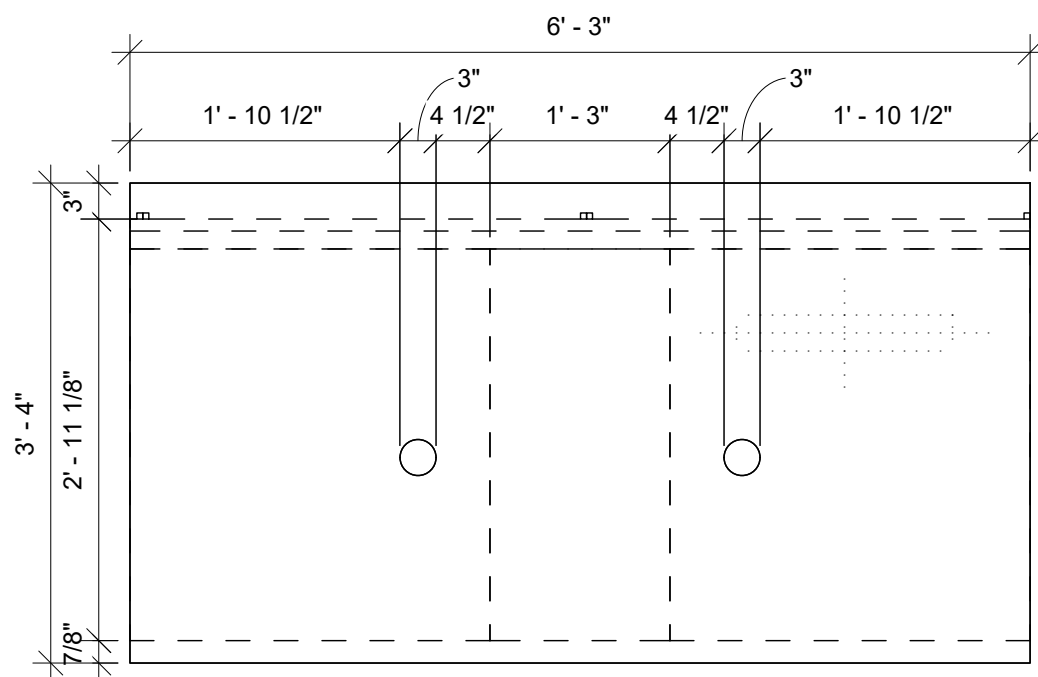


05 POS -PLAN

Scale: 3/4" = 1'-0"

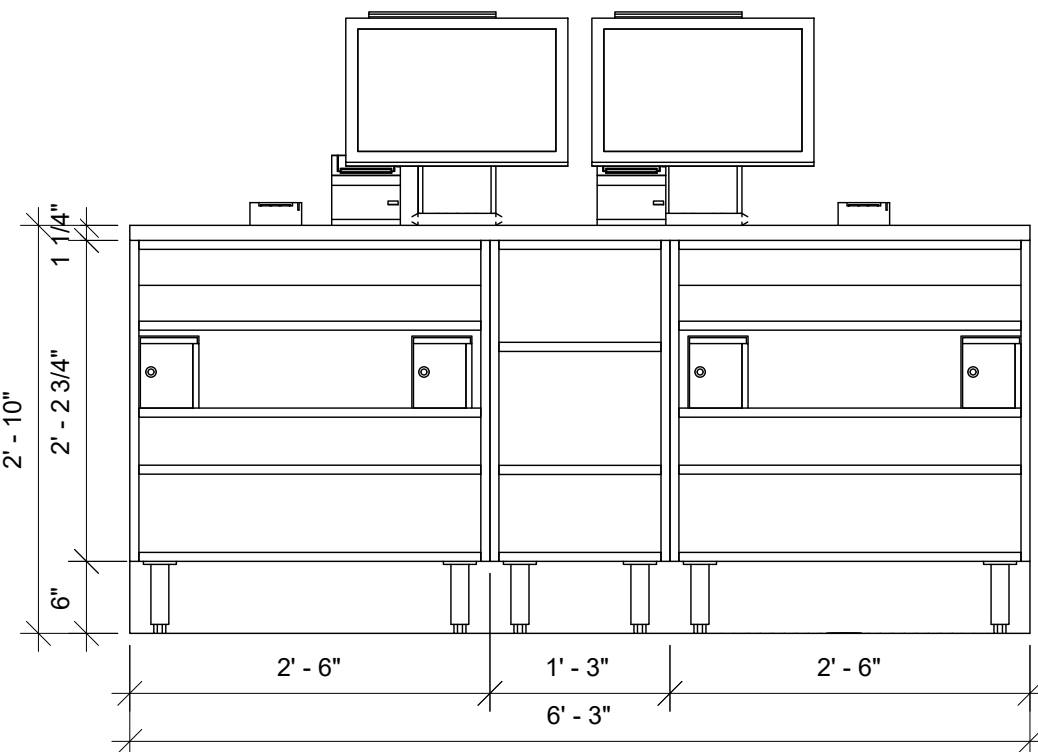


06 POS -BACK ELEVATION

Scale: 3/4" = 1'-0"

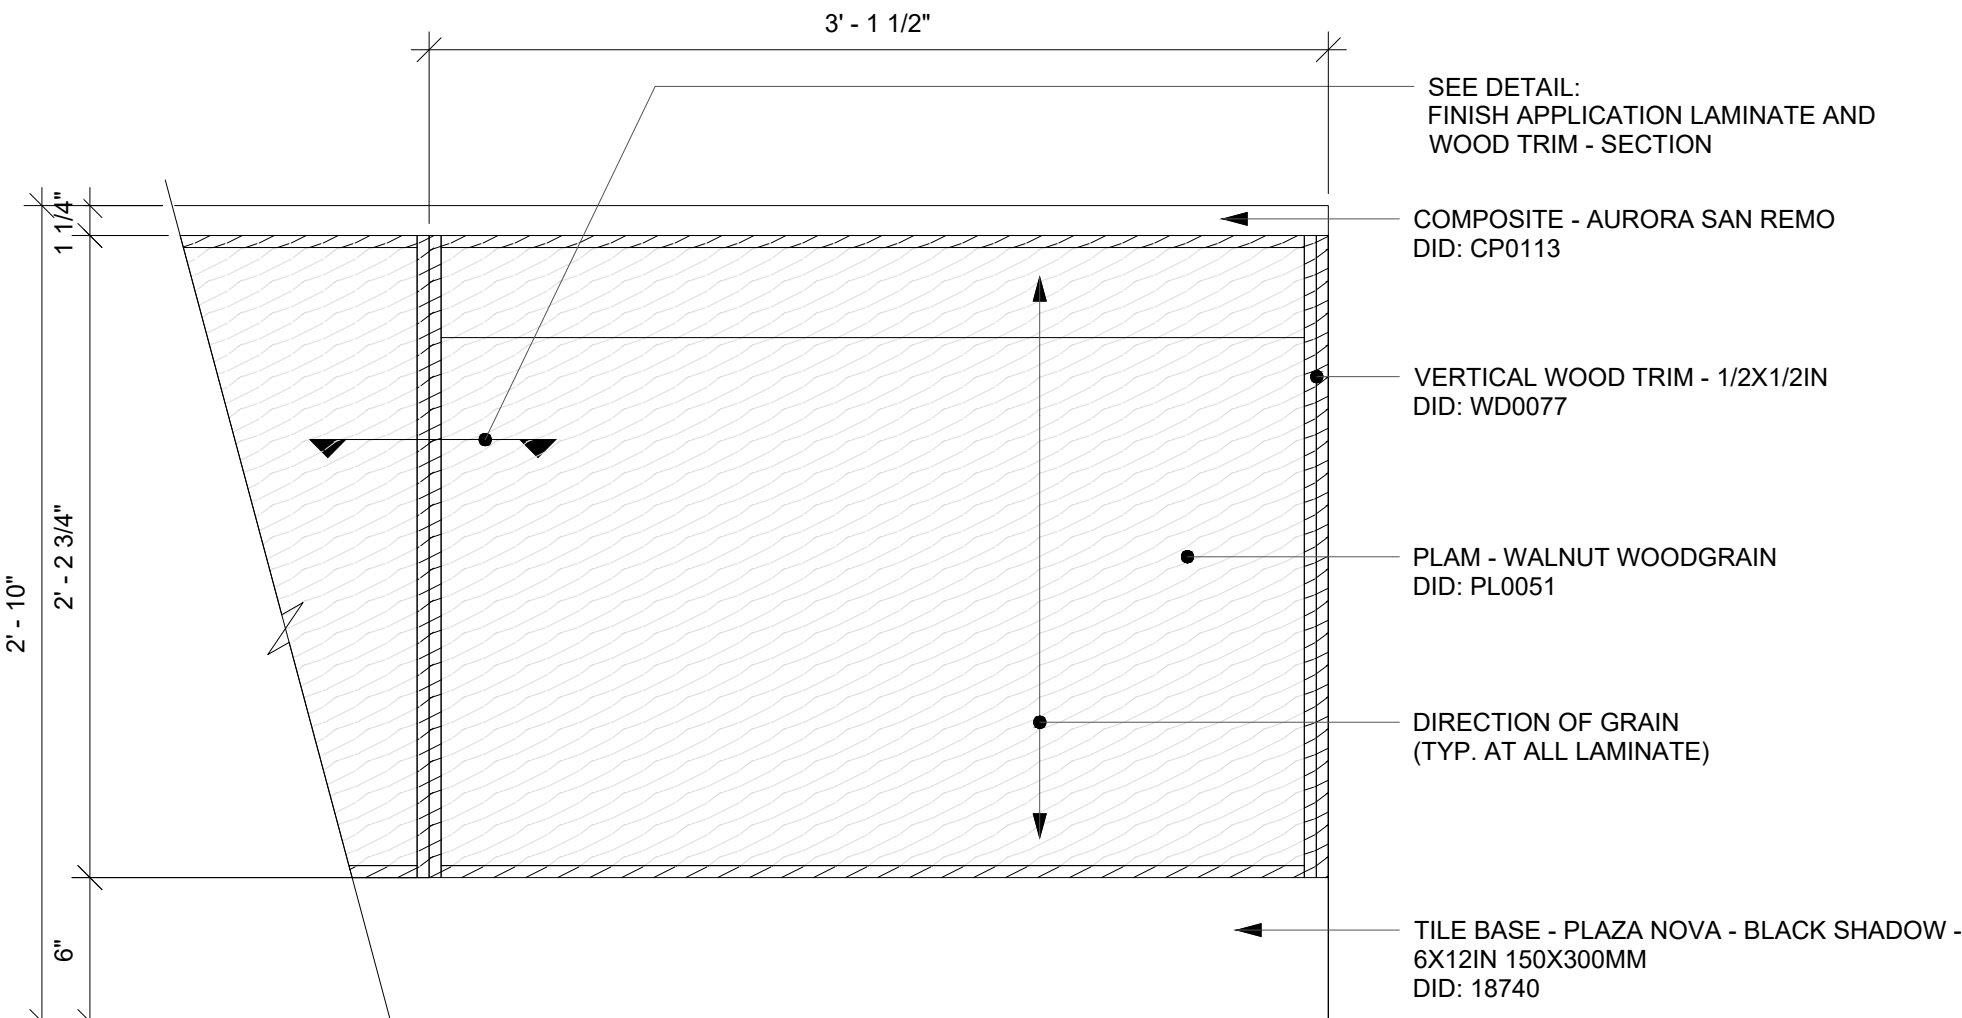

07 FINISH APPLICATION PLAM - WALNUT WOODGRAIN - ELEVATION

Scale: 1 1/2" = 1'-0"

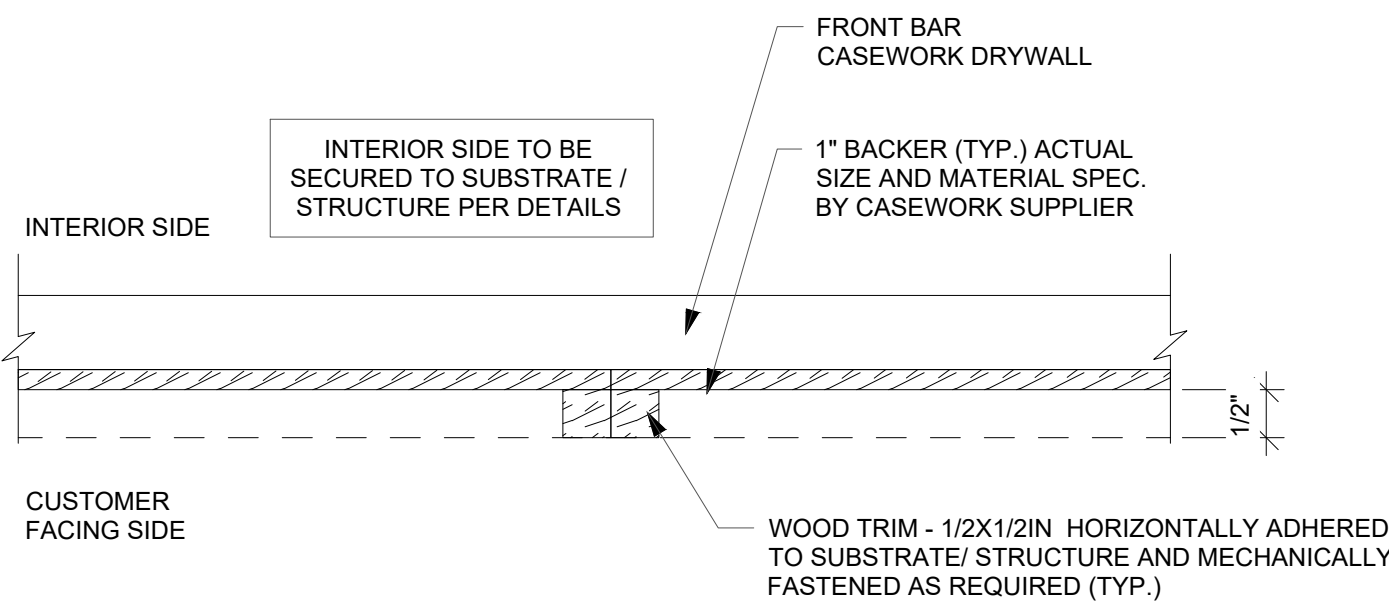

08 FINISH APPLICATION WOOD TRIM - SECTION


Scale: 6" = 1'-0"

ARCHITECT OF RECORD:

THOMAS E. MORGAN, JR.
ARCHITECT

423 FISCHER TRAIL
ELLIJAY, GEORGIA 30540

SEAL:

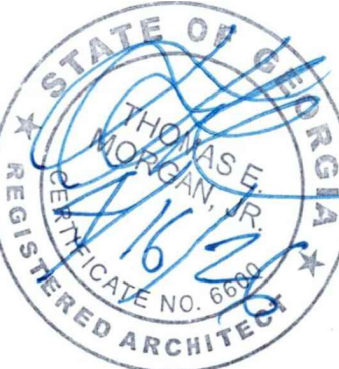

MRP
DESIGN GROUP

3450 Acworth Due West Road
Building 100, Suite 120
Kennesaw, Georgia 30144
P. 770-917-9172
F. 770-917-9470
www.mrpdesign.com

RELEASED FOR
CONSTRUCTION

ISSUES / REVISIONS:

DATE	DESCRIPTION
05.04.26	RELEASE FOR CONSTRUCTION

DRAWN BY: JB

CHKD BY: TM

PROJECT DESCRIPTION:

NEW CONSTRUCTION OF A TA
TRAVEL CENTER IN
JEFFERSONVILLE, GA. WHICH
CONSISTS OF A TRUCKER
LOUNGE, SHOWERS, LAUNDRY
ROOM, RETAIL AREA,
RESTROOMS, GAME AREA,
SEATING AREAS, AND FOUR
QUICK-SERVICE RESTAURANTS.
THE MAJORITY OF THE
PROJECT HAS ALREADY BEEN
SUBMITTED. THIS ISSUE, DATED
05.04.26 HAS MODIFICATIONS
RELATED TO THE ADDITION OF
THE STARBUCKS QSR.

PROJECT TITLE:

TRAVEL CENTER
4838 SR 96
JEFFERSONVILLE,
GEORGIA 31044









SHEET TITLE:

INTERIOR
FINISH
ELEVATIONS

PROJECT NO: 25021

1501

FOR REFERENCE ONLY

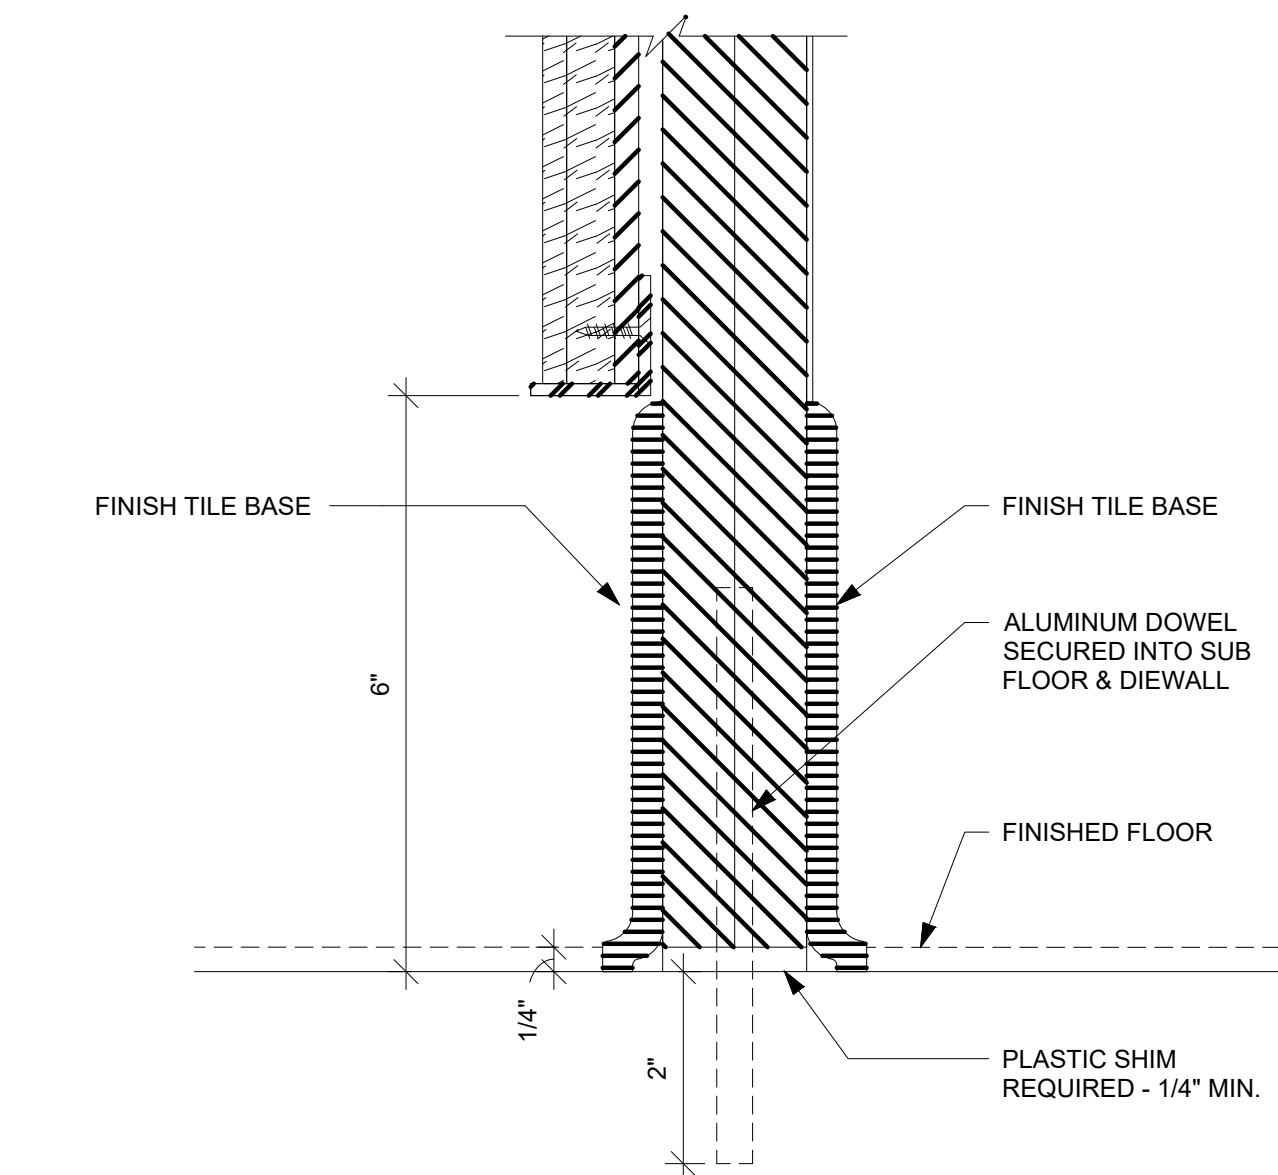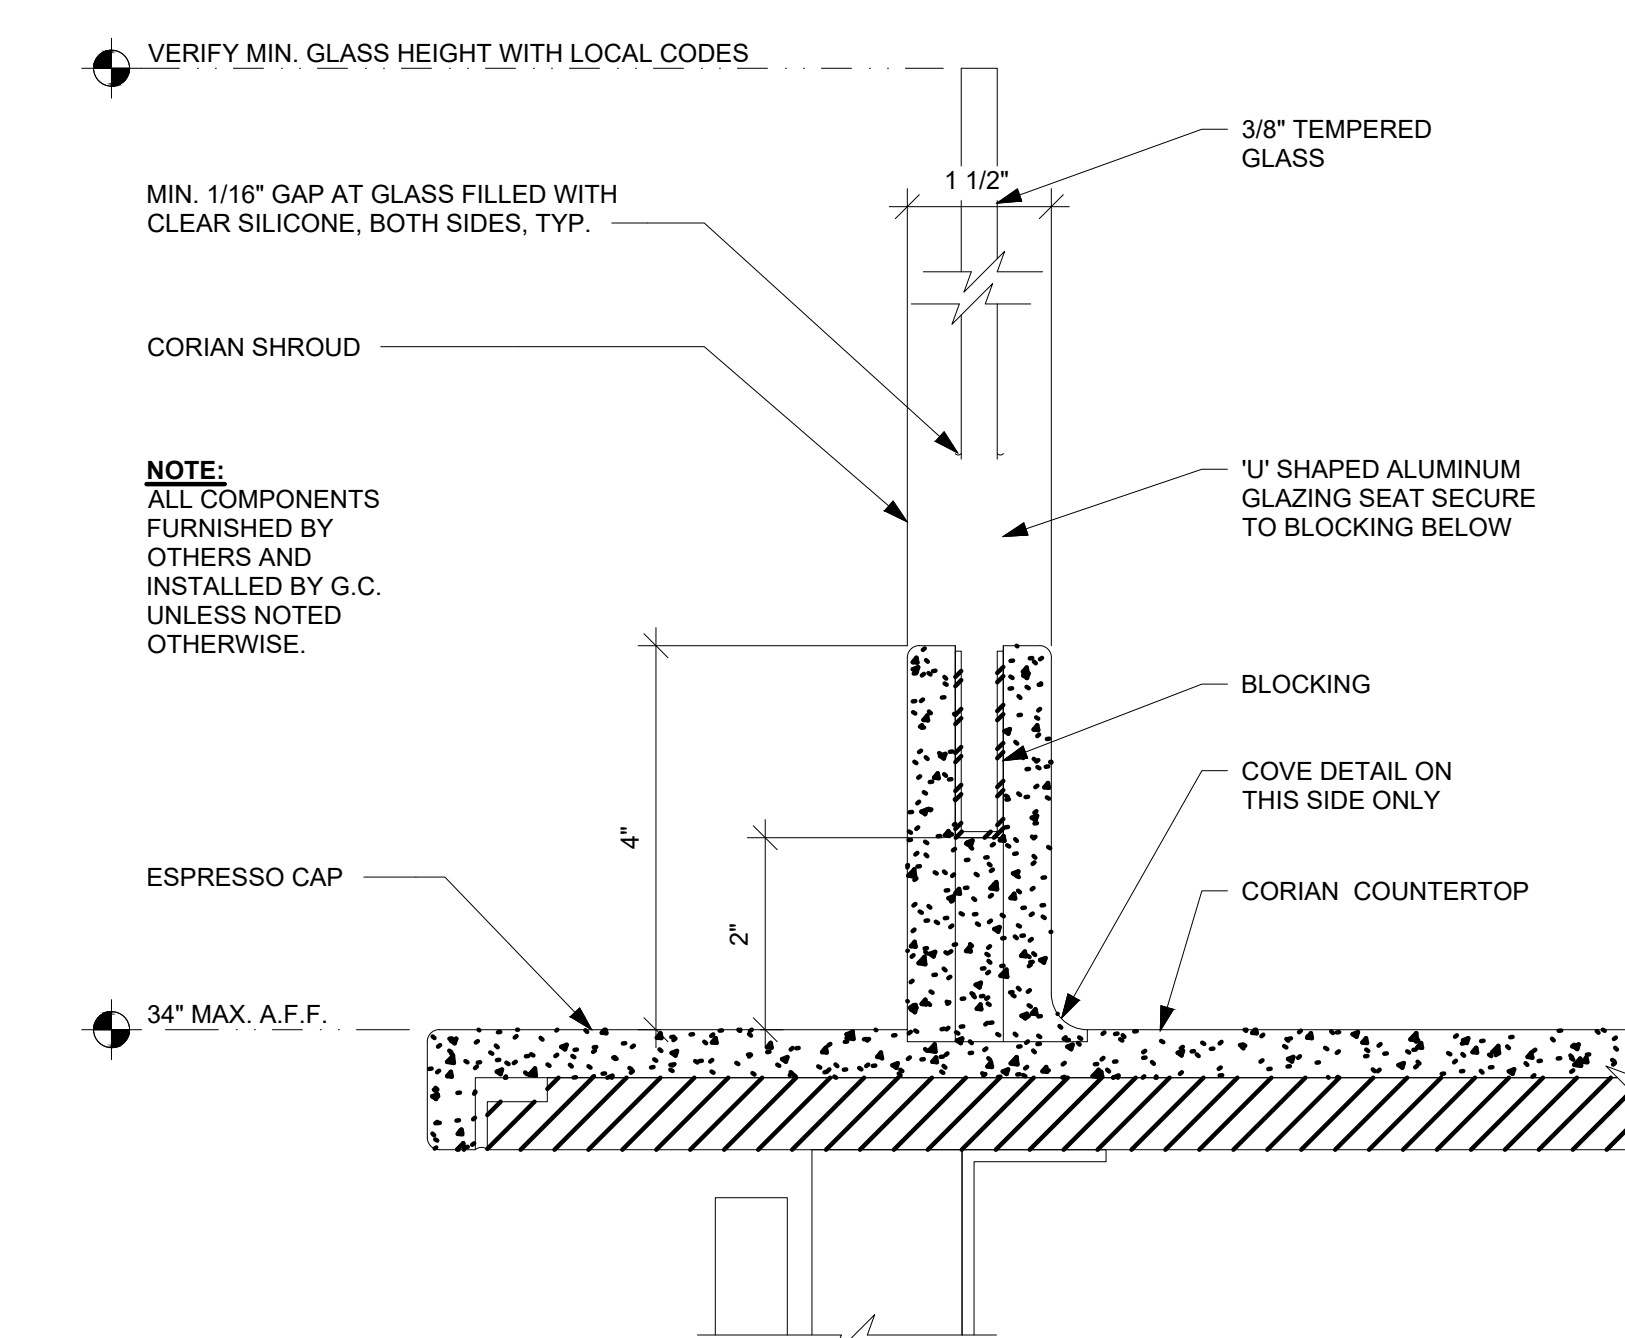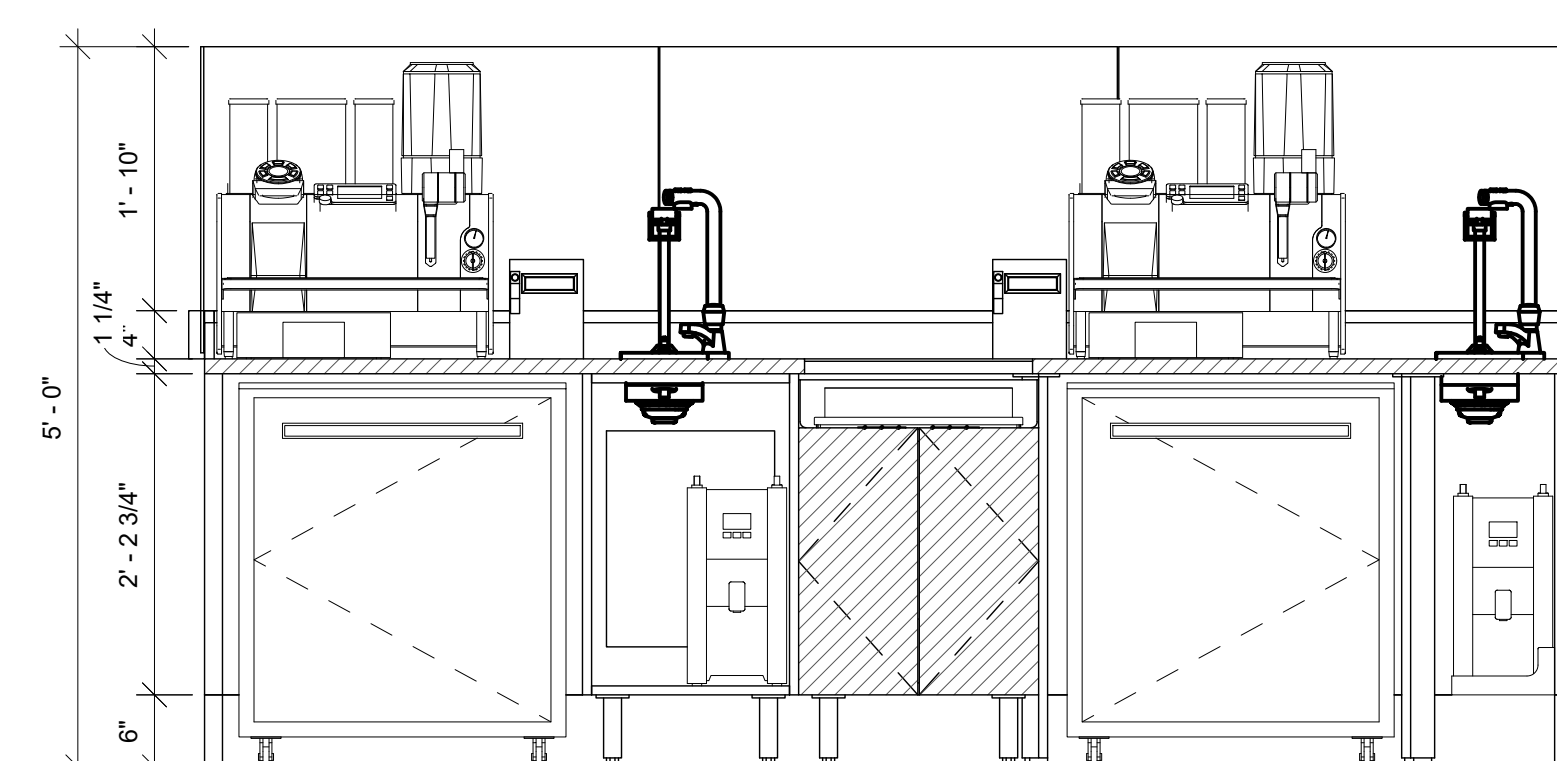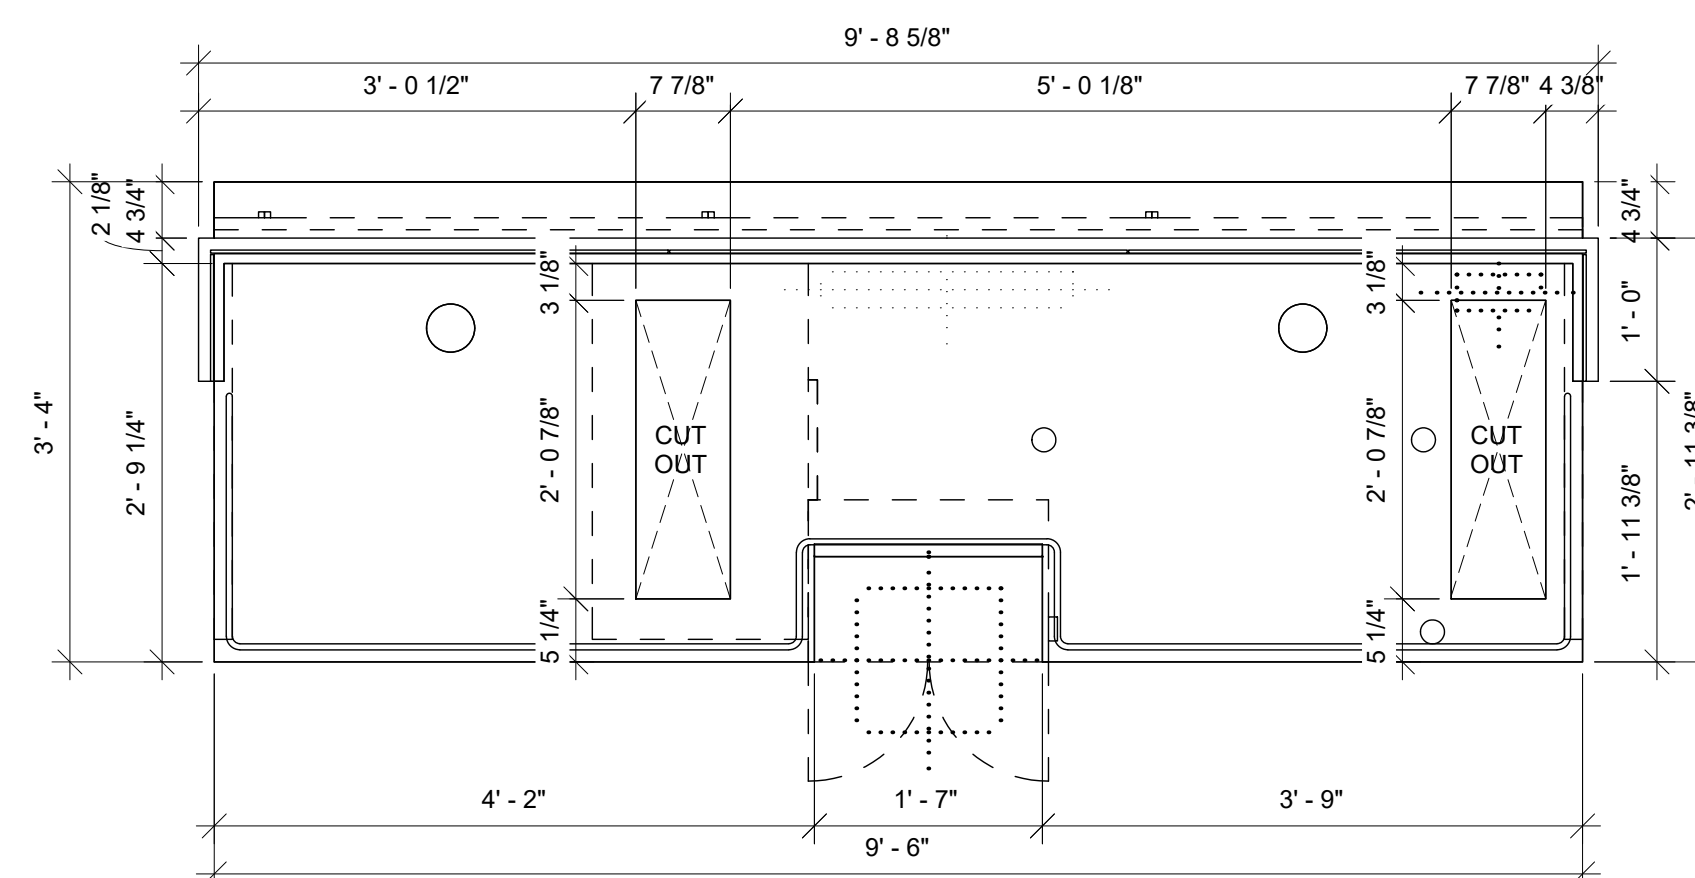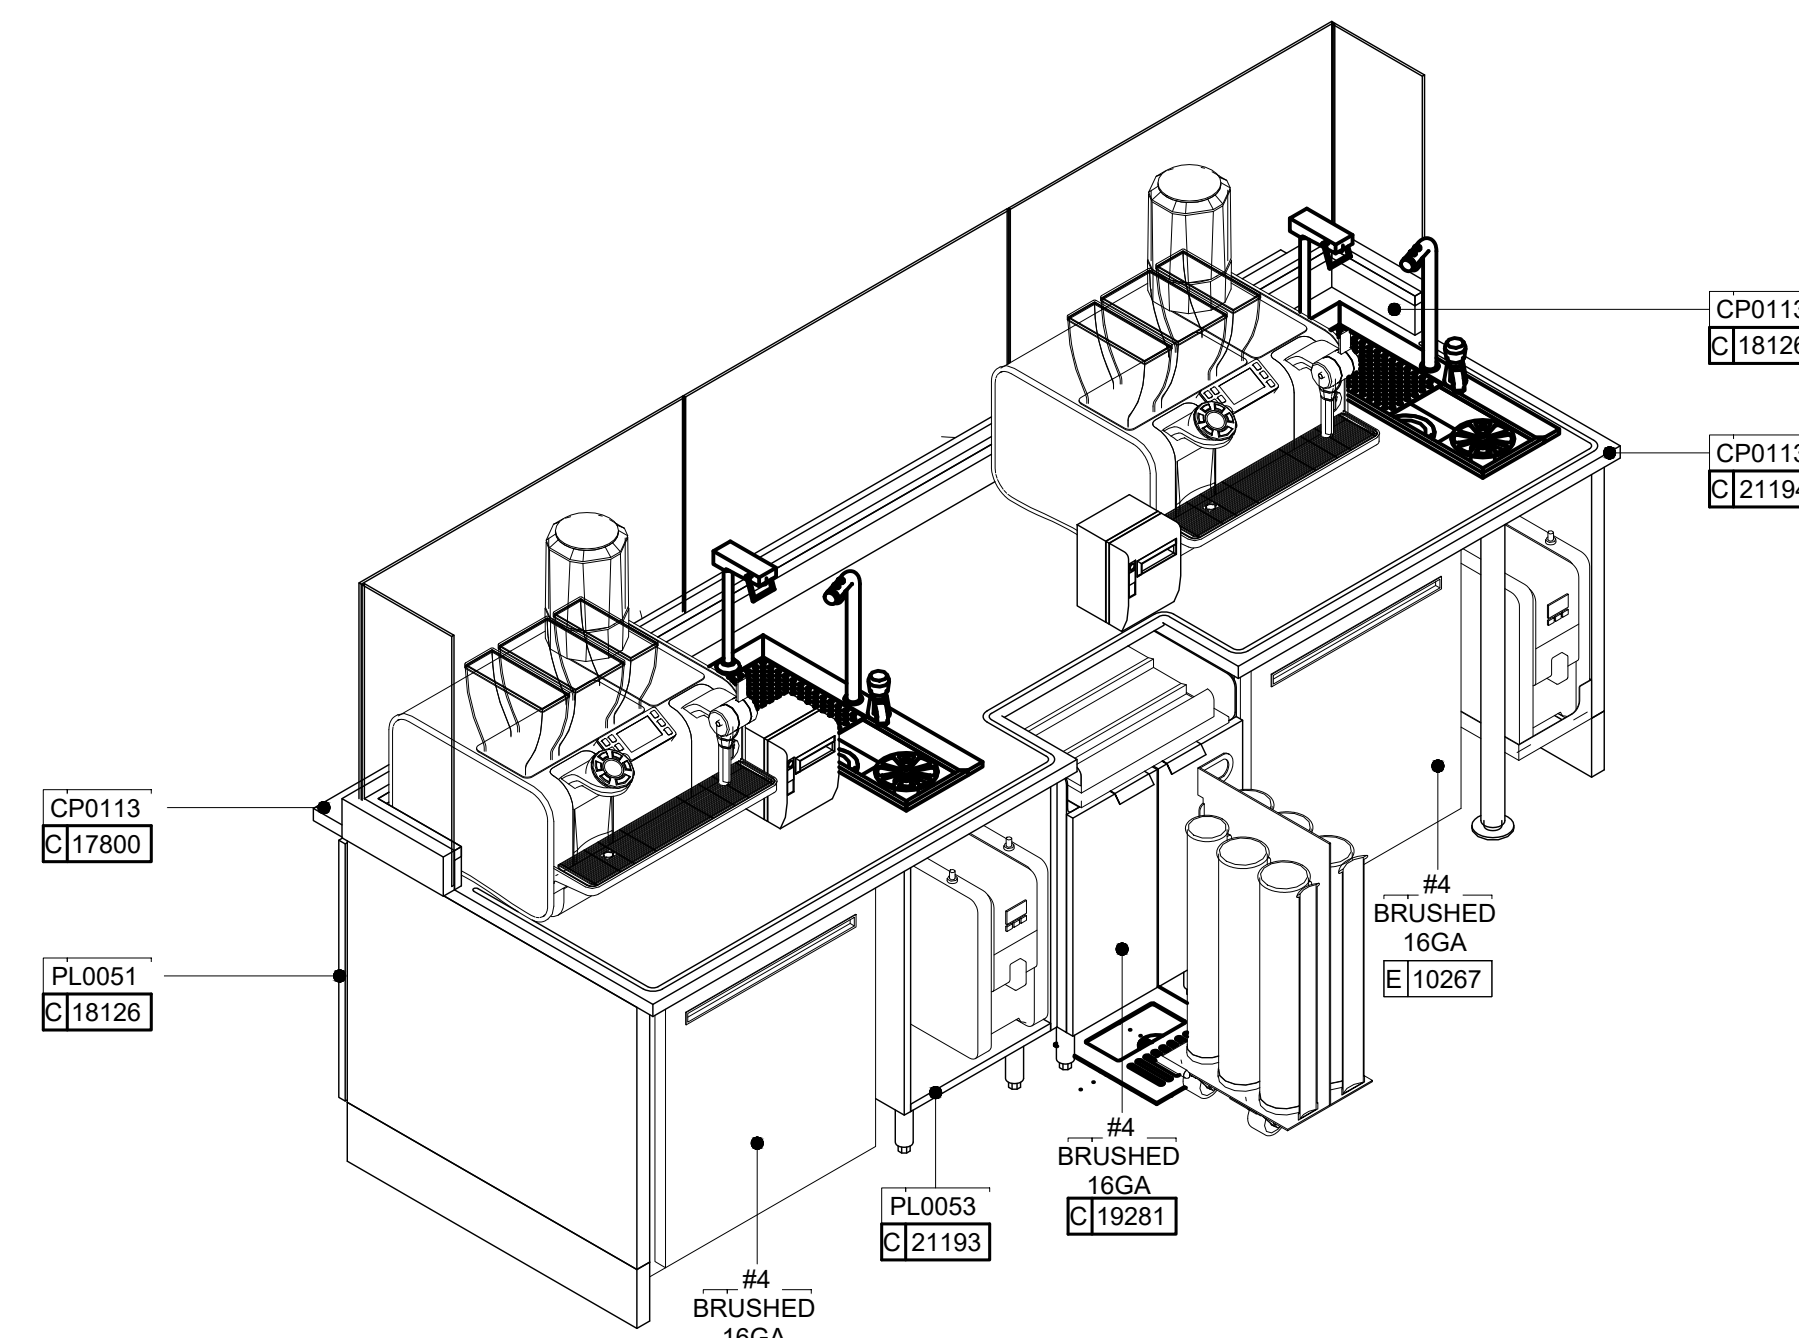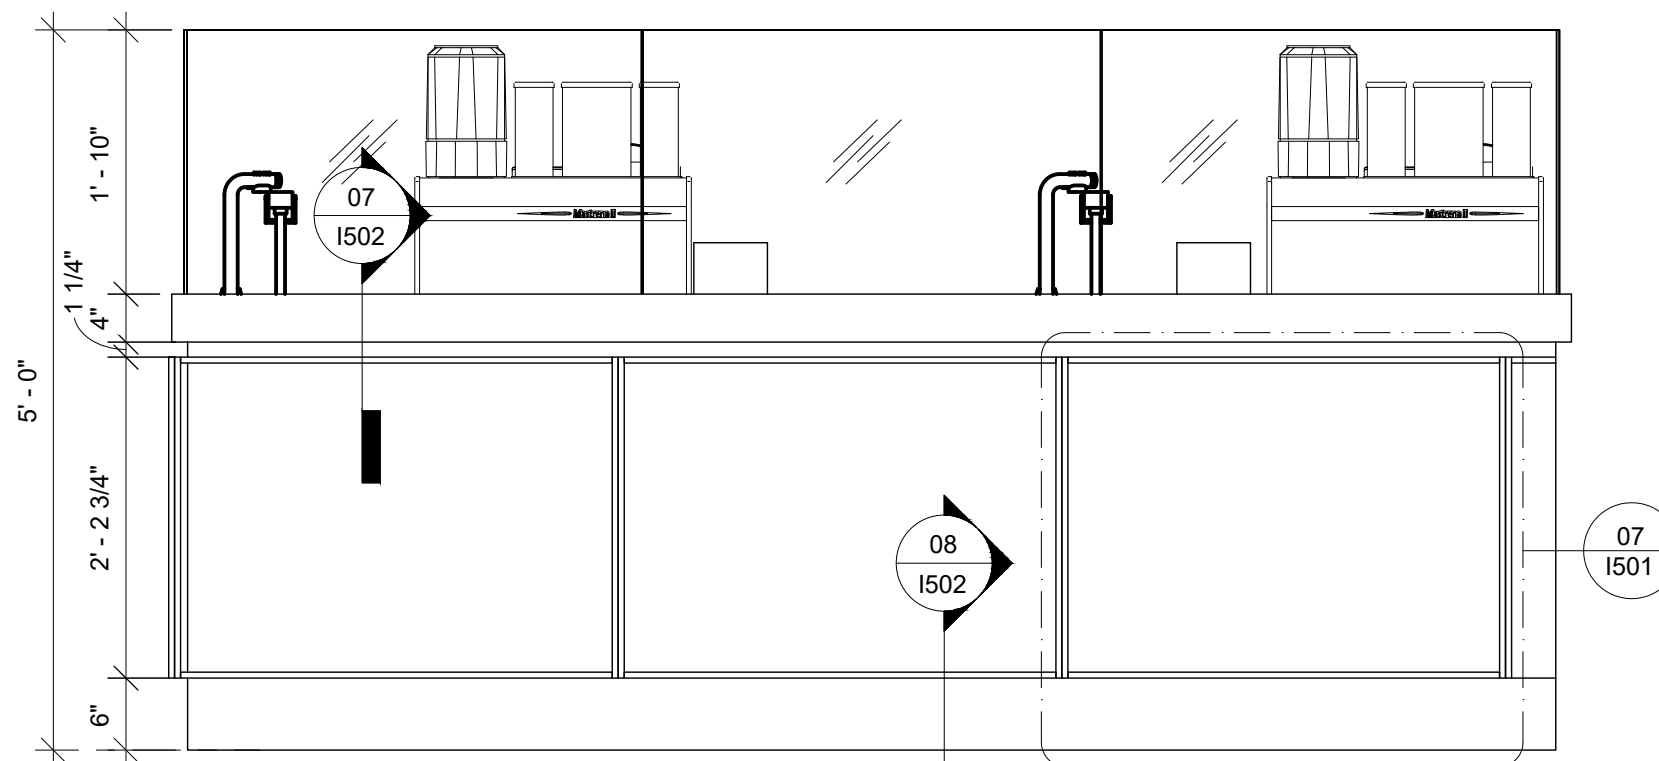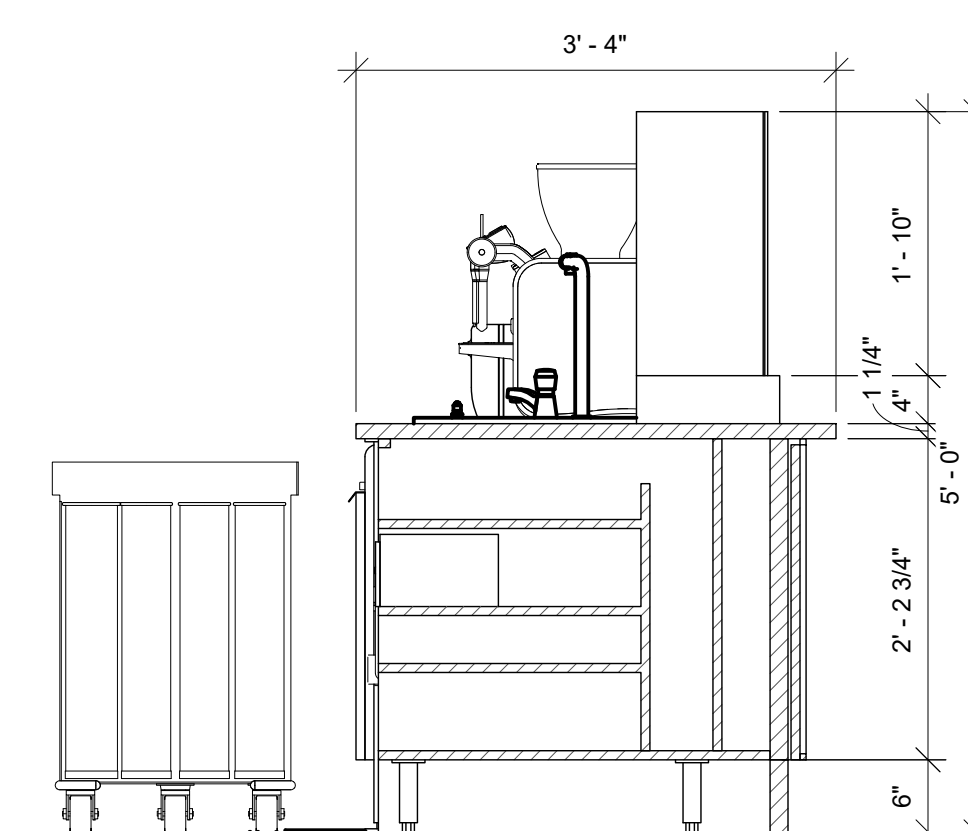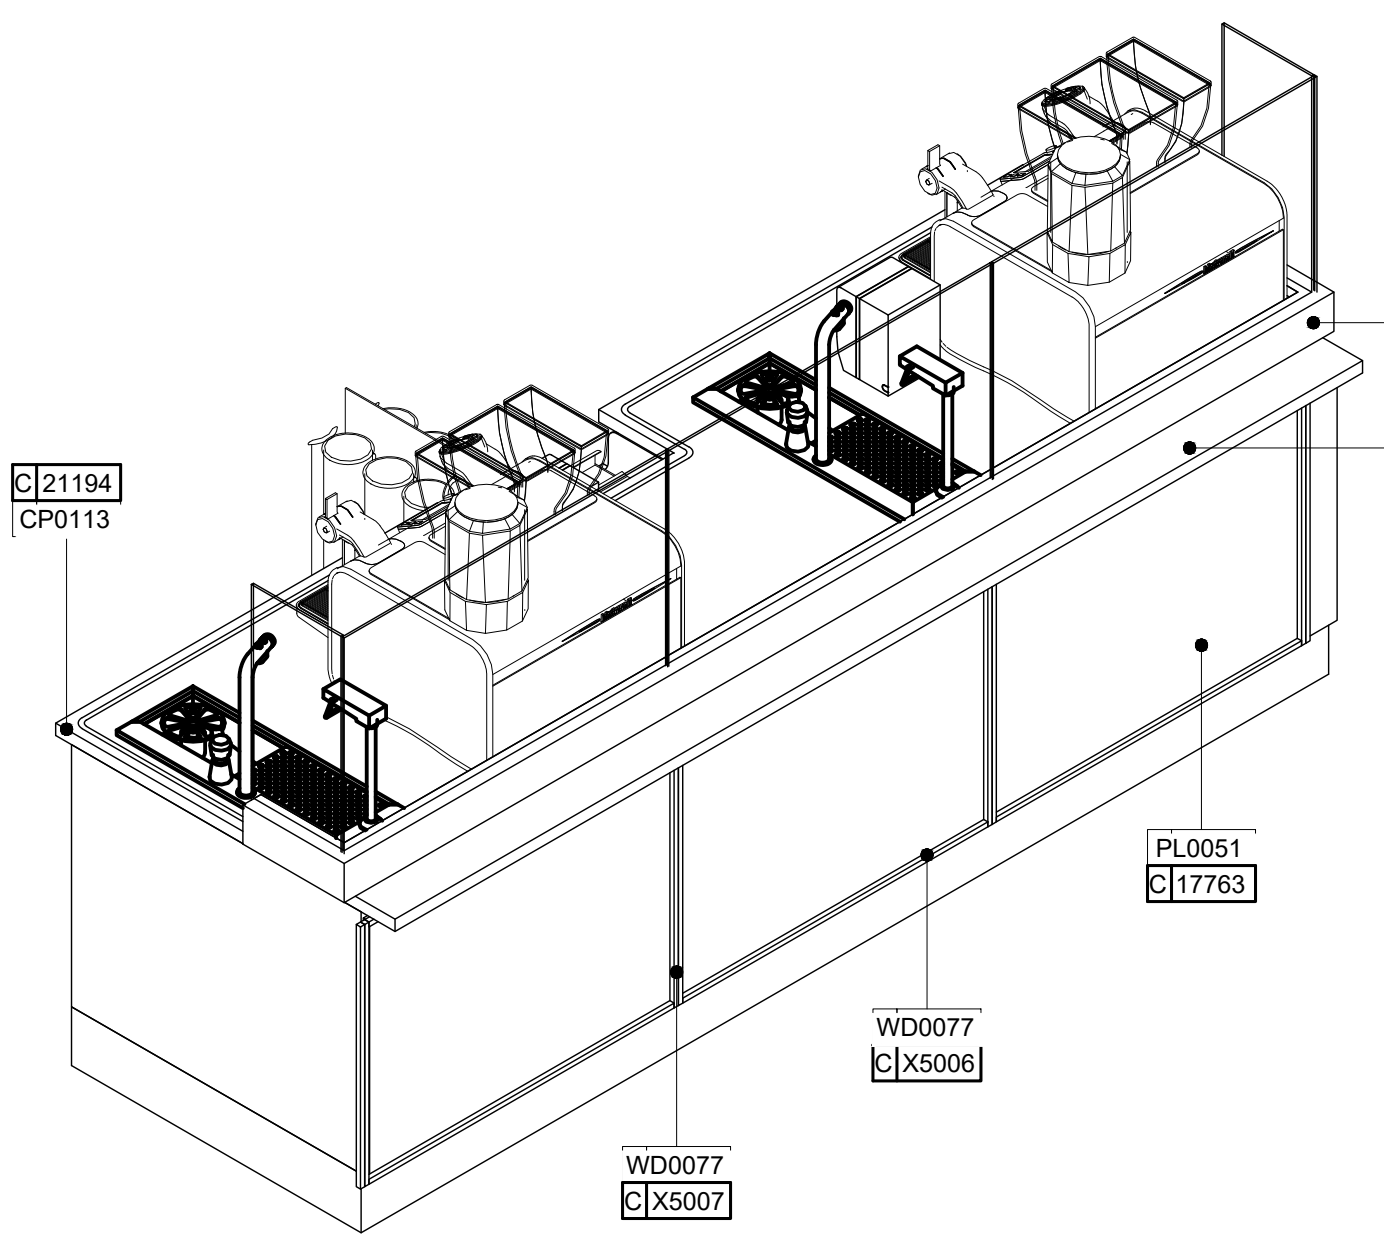

ARCHITECT OF RECORD:

THOMAS E. MORGAN, JR.
ARCHITECT

423 FISCHER TRAIL
ELLIJAY, GEORGIA 30540

SEAL:



3450 Acworth Due West Road
Building 100, Suite 120
Kennesaw, Georgia 30144
P. 770-917-9172
F. 770-917-9470
www.mrpdesign.com

RELEASED FOR
CONSTRUCTION

ISSUES / REVISIONS:

DATE	DESCRIPTION
05.04.28	RELEASE FOR CONSTRUCTION

DRAWN BY: JB

CHK'D BY: TM

PROJECT DESCRIPTION:

NEW CONSTRUCTION OF A TA TRAVEL CENTER IN JEFFERSONVILLE, GA, WHICH CONSISTS OF A TRUCKER LOUNGE, SHOWERS, LAUNDRY ROOM, RETAIL AREA, RESTROOMS, GAME AREA, SEATING AREAS, AND FOUR QUICK-SERVICE RESTAURANTS. THE MAJORITY OF THE PROJECT HAS ALREADY BEEN SUBMITTED. THIS ISSUE, DATED 05.04.26 HAS MODIFICATIONS RELATED TO THE ADDITION OF THE STARBUCKS QSR.

PROJECT TITLE:

TRAVEL CENTER
4838 SR 96
JEFFERSONVILLE,
GEORGIA 31044

SHEET TITLE:


INTERIOR DETAILS

PROJECT NO: 25021

1502


FOR REFERENCE ONLY

THESE PLANS ARE THE PROPERTY OF MRP DESIGN GROUP, INC. AND ARE SUBJECT TO FEDERAL COPYRIGHT LAWS. ANY USE OF SAME WITHOUT THE EXPRESS WRITTEN PERMISSION OF MRP DESIGN GROUP, INC. IS STRICTLY PROHIBITED.

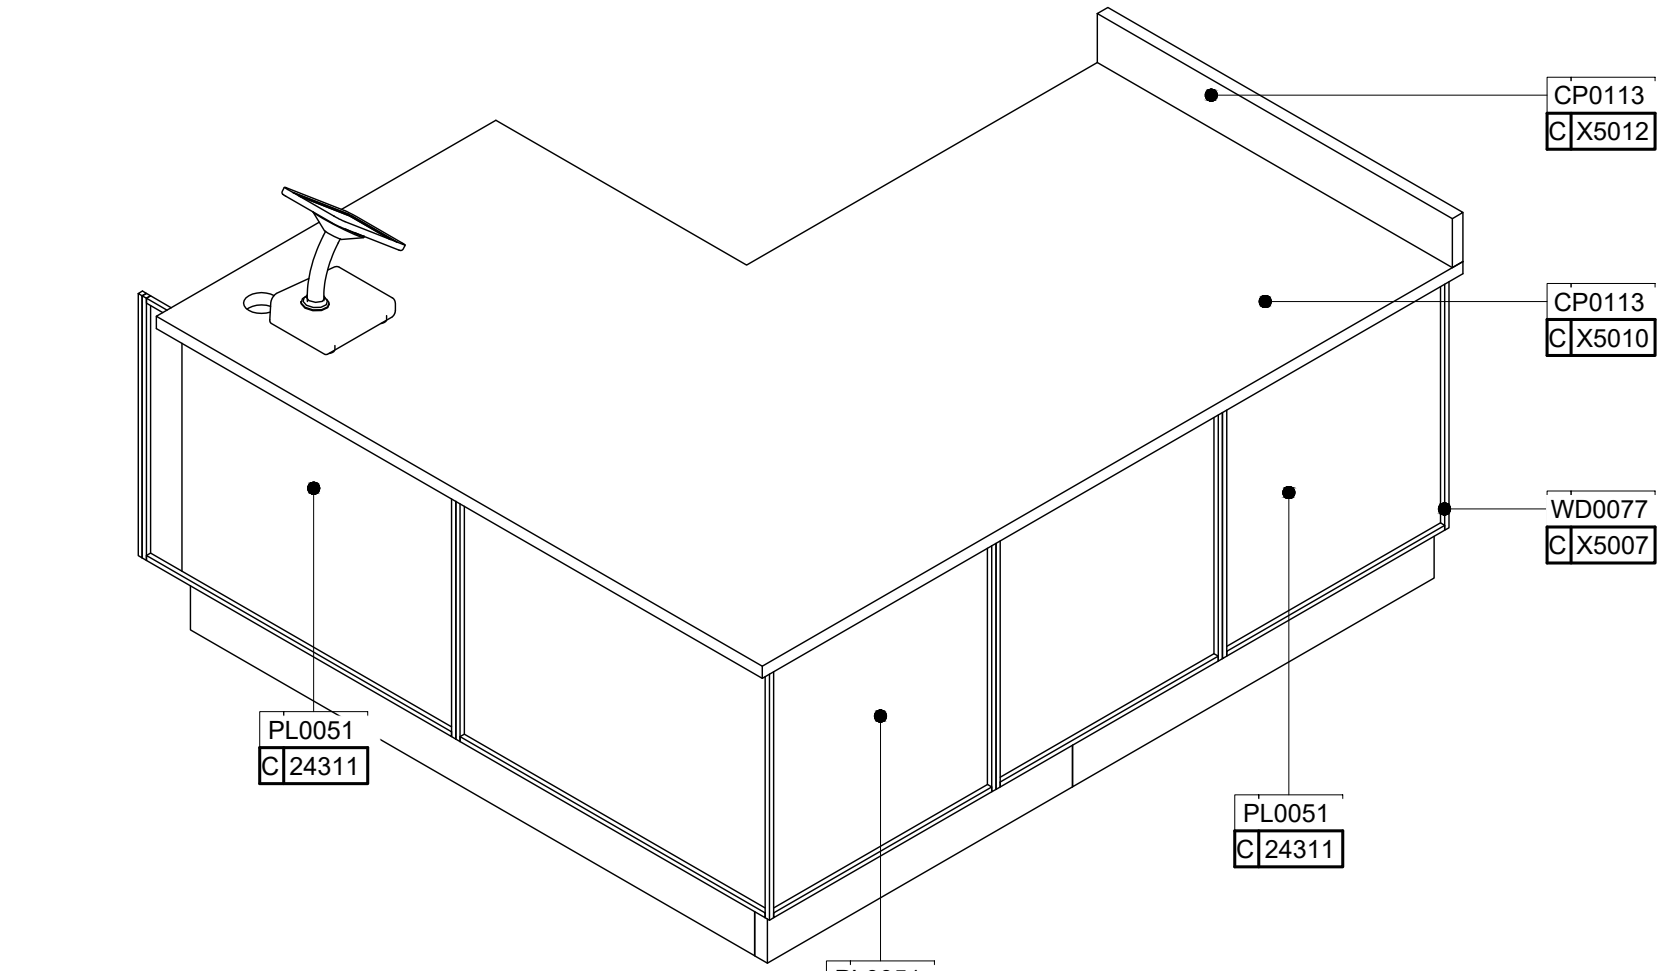


01 MOP FRONT 3D VIEW

Scale: 3/4" = 1'-0"

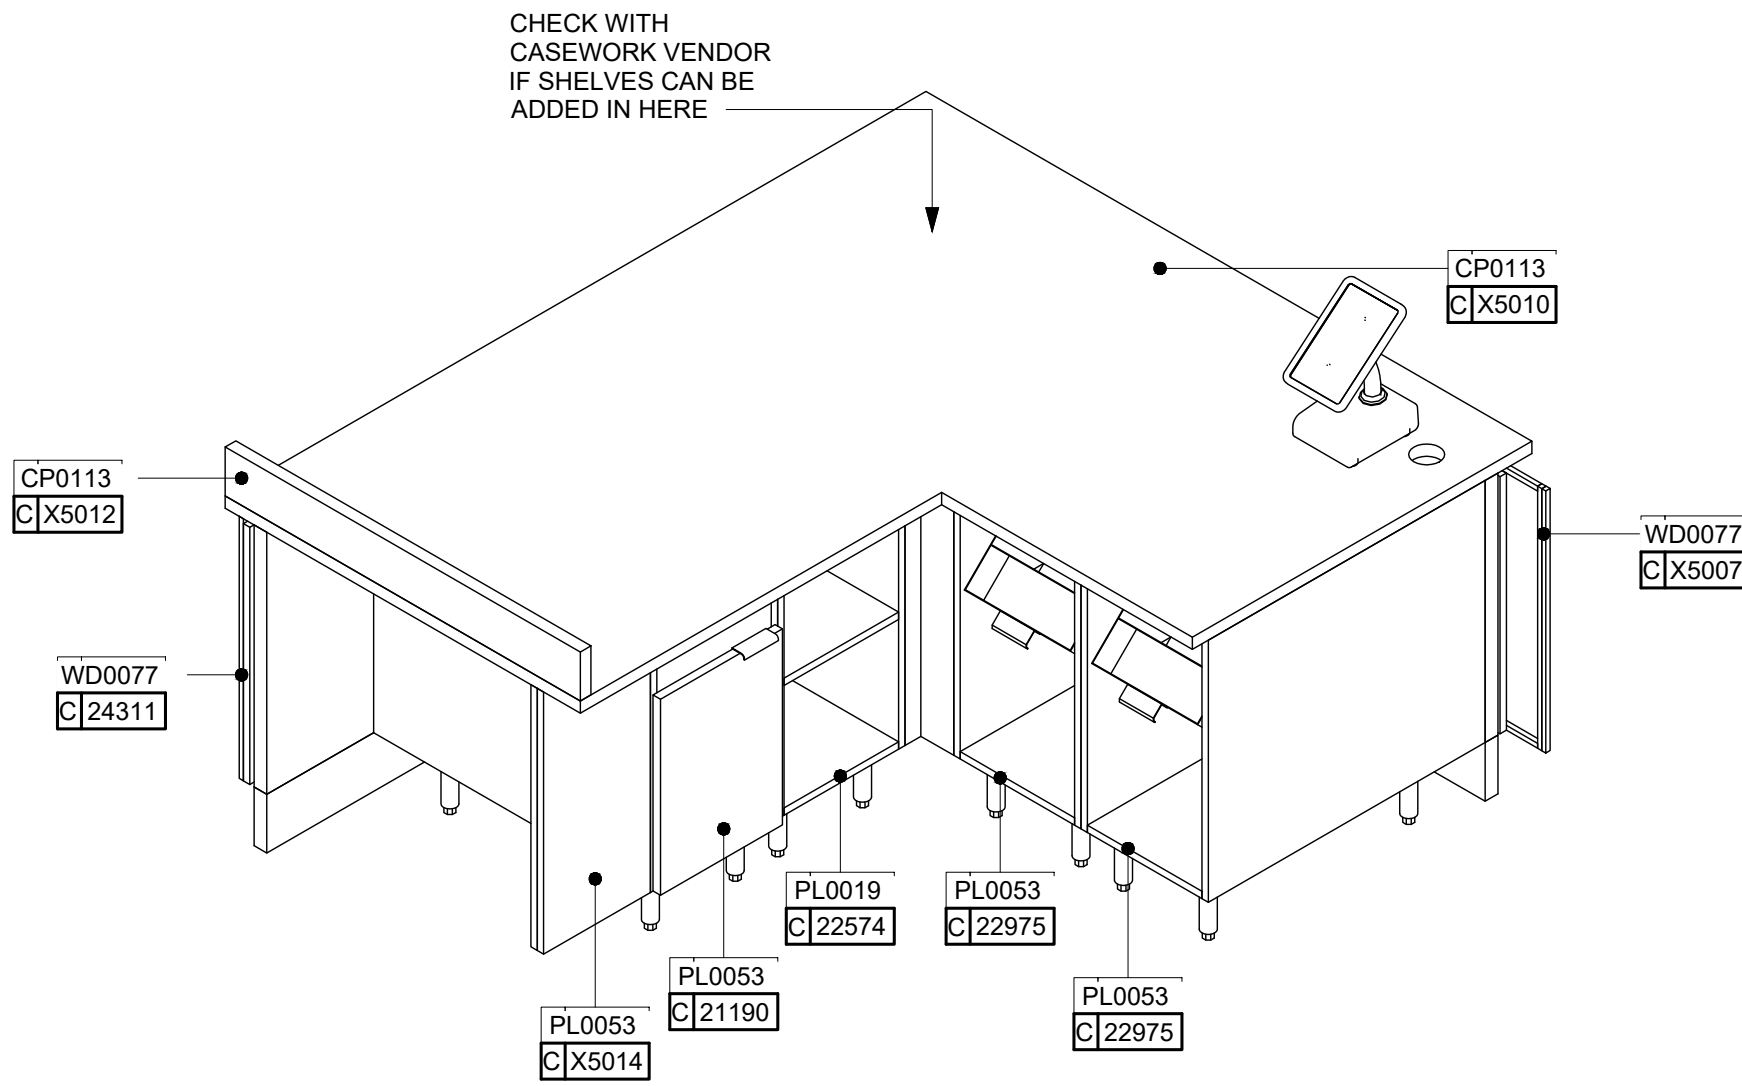


02 MOP BACK 3D VIEW

Scale: 3/4" = 1'-0"

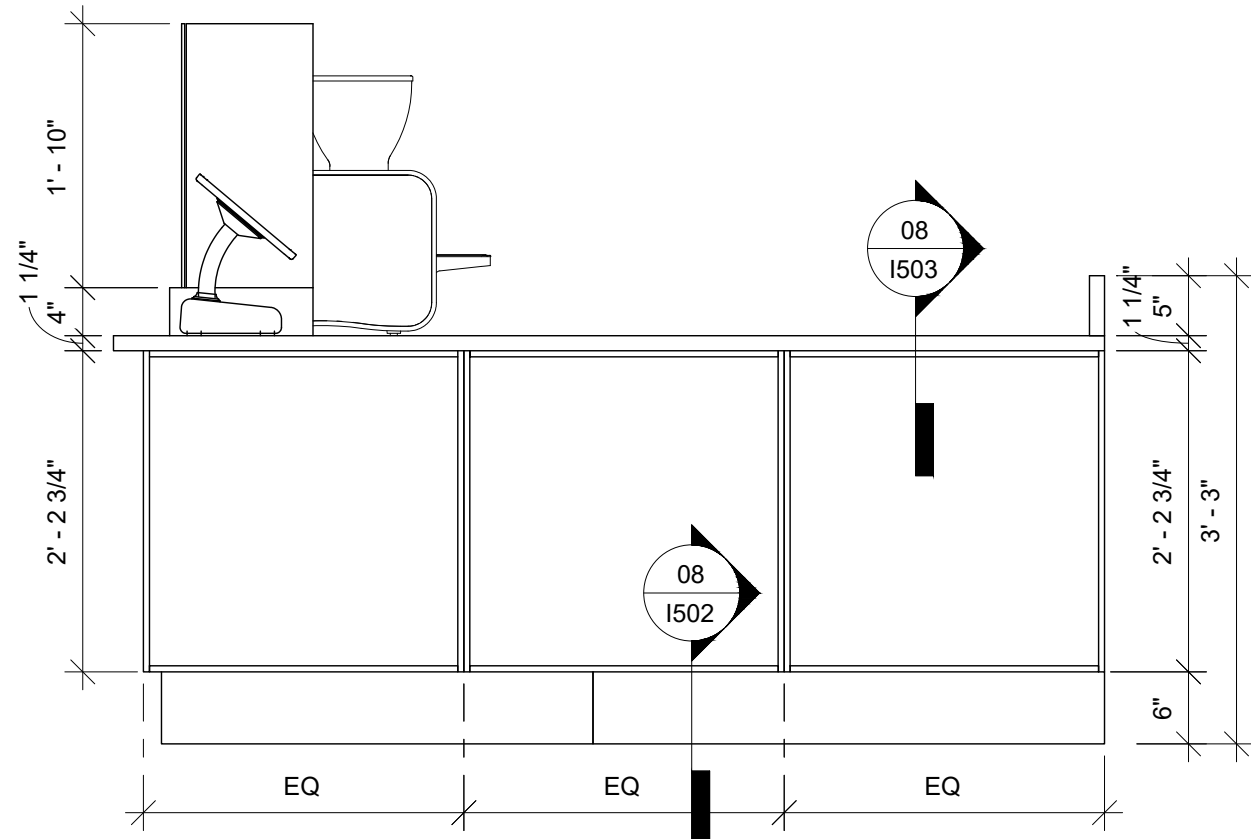


03 MOP - LEFT SIDE ELEVATION

Scale: 3/4" = 1'-0"

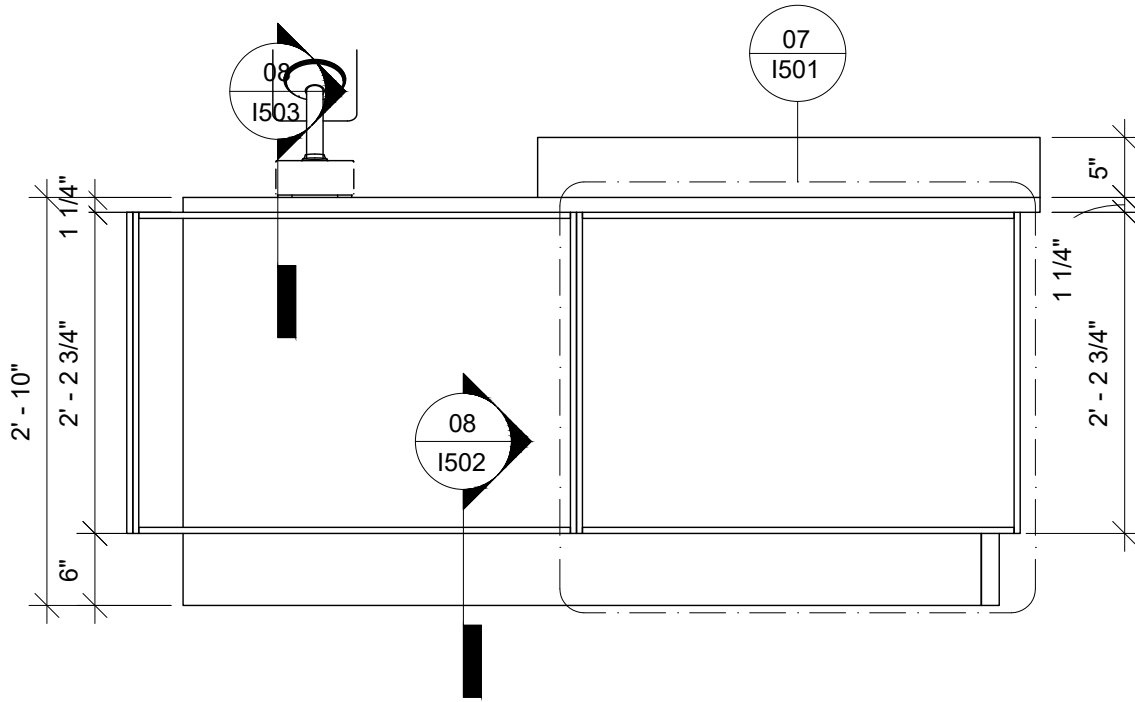


04 MOP -FRONT ELEVATION

Scale: 3/4" = 1'-0"

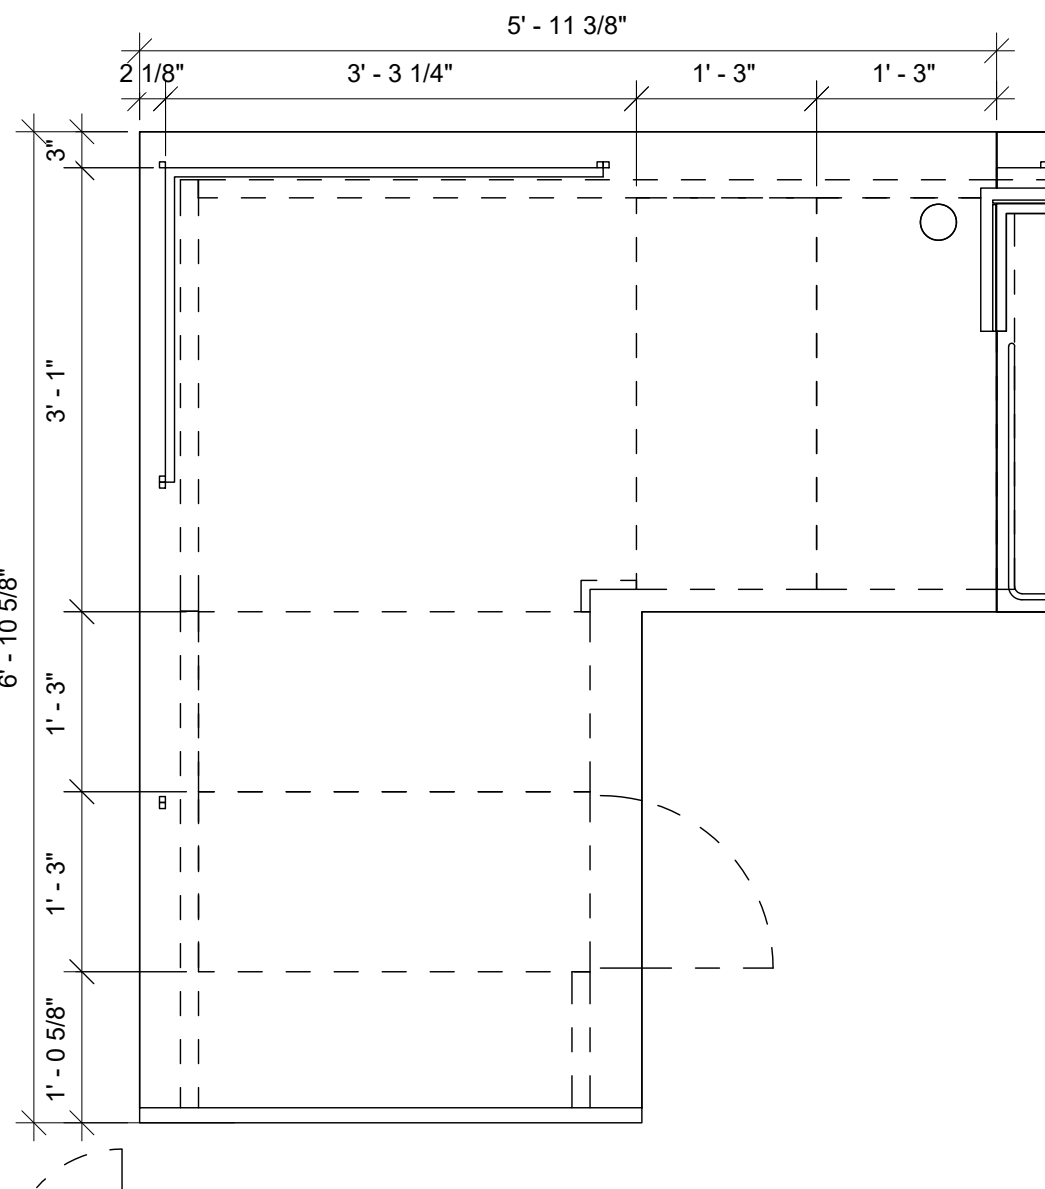


05 MOP - PLAN

Scale: 3/4" = 1'-0"

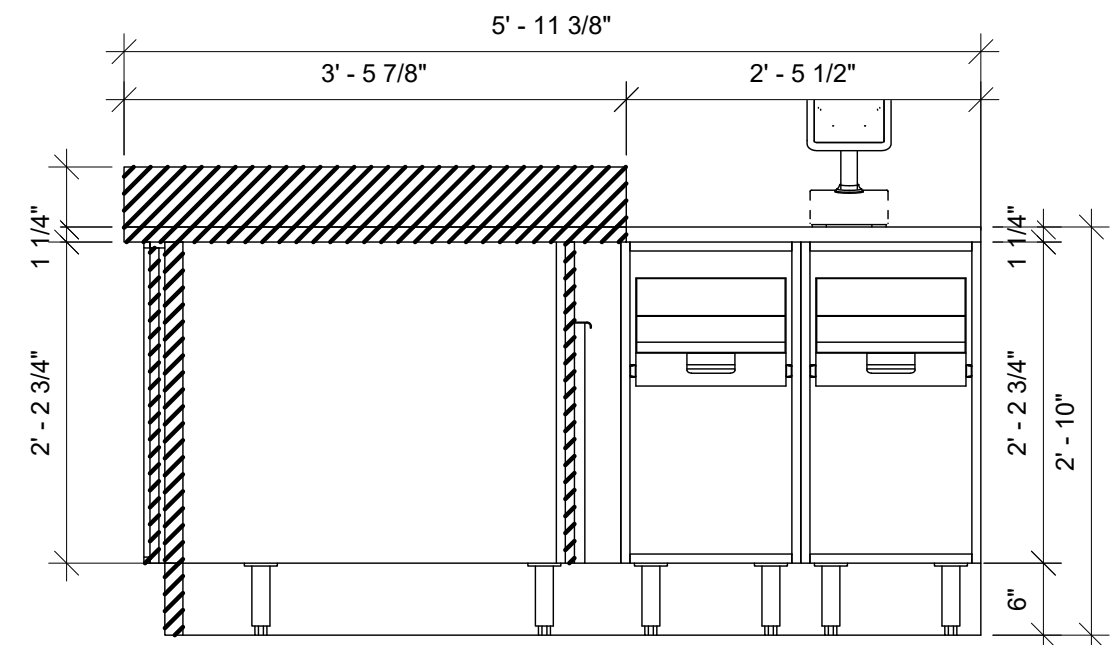


06 MOP -BACK ELEVATION

Scale: 3/4" = 1'-0"

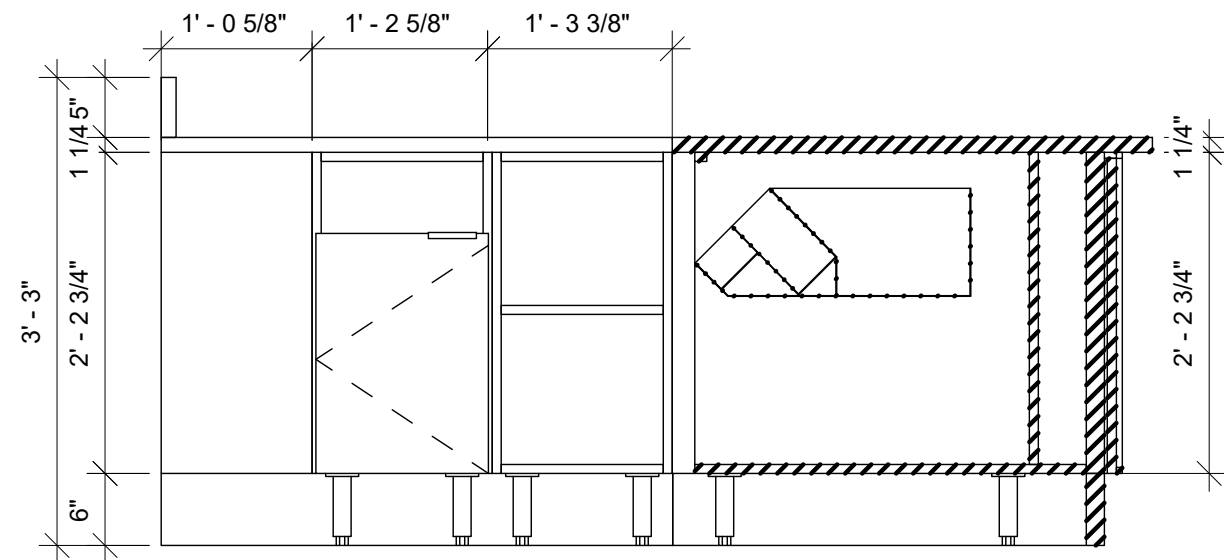

07 MOP - RIGHT SIDE ELEVATION

Scale: 3/4" = 1'-0"

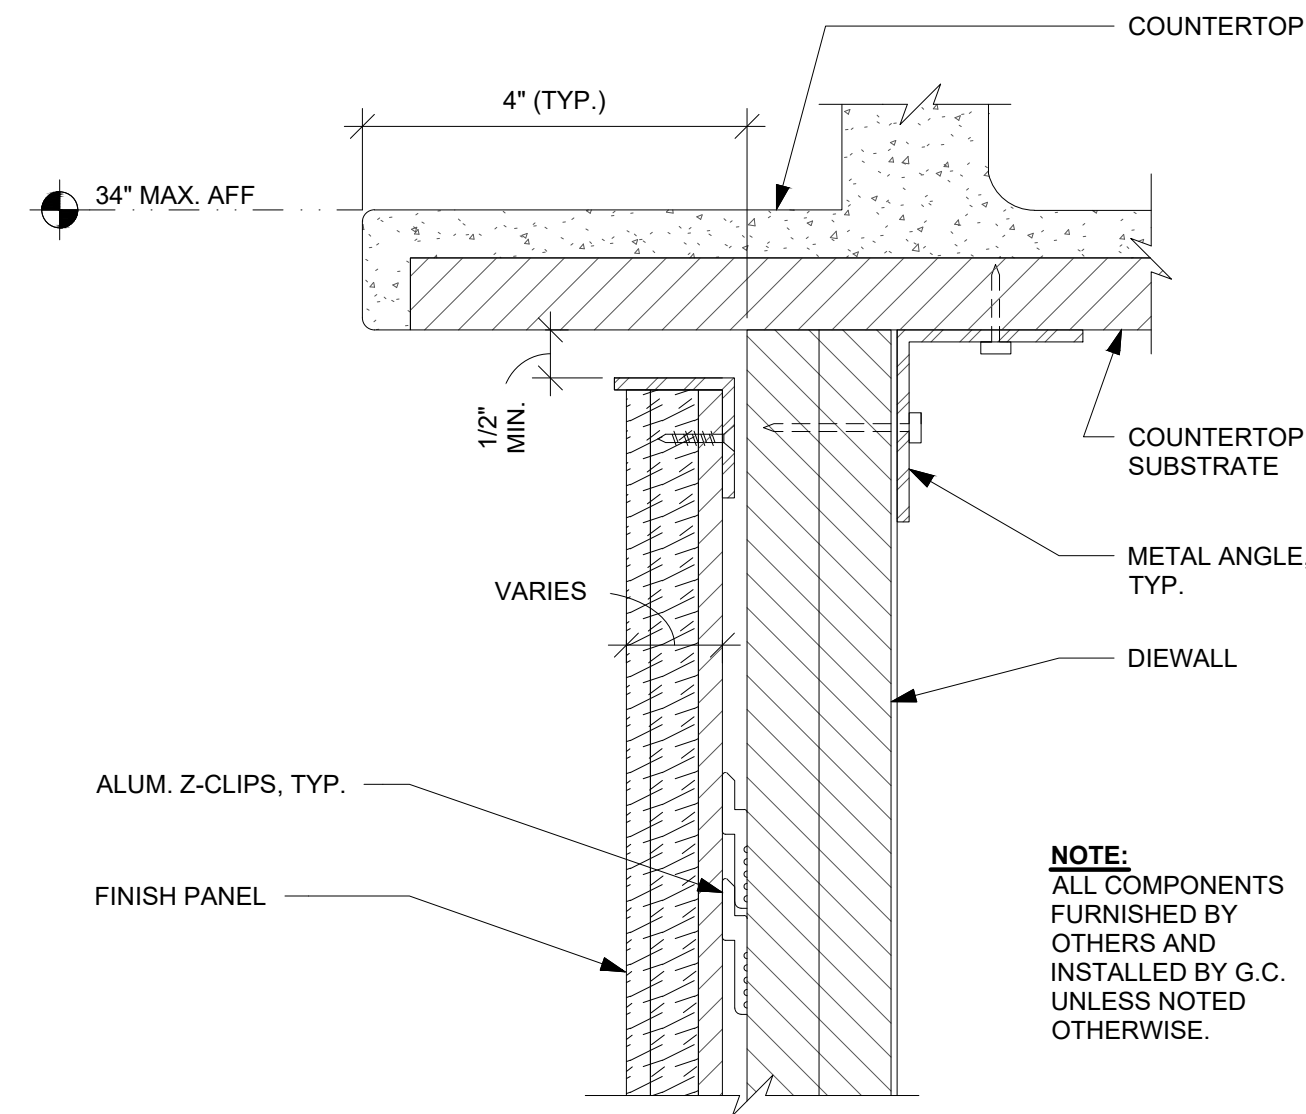

08 FINISH PANEL - COUNTERTOP OVERHANG

Scale: 6" = 1'-0"

ARCHITECT OF RECORD:

THOMAS E. MORGAN, JR.
ARCHITECT

423 FISCHER TRAIL
ELLIJAY, GEORGIA 30540

SEAL:



MRP
DESIGN GROUP

3450 Acworth Due West Road
Building 100, Suite 120
Kennesaw, Georgia 30144
P. 770-917-9172
F. 770-917-9470
www.mrpdesign.com

RELEASED FOR
CONSTRUCTION

ISSUES / REVISIONS:

DATE	DESCRIPTION
05.04.26	RELEASE FOR CONSTRUCTION

DRAWN BY: JB

CHKD BY: TM

PROJECT DESCRIPTION:

NEW CONSTRUCTION OF A TA
TRAVEL CENTER IN
JEFFERSONVILLE, GA. WHICH
CONSISTS OF A TRUCKER
LOUNGE, SHOWERS, LAUNDRY
ROOM, RETAIL AREA,
RESTROOMS, GAME AREA,
SEATING AREAS, AND FOUR
QUICK-SERVICE RESTAURANTS.
THE MAJORITY OF THE
PROJECT HAS ALREADY BEEN
SUBMITTED. THIS ISSUE, DATED
05.04.26 HAS MODIFICATIONS
RELATED TO THE ADDITION OF
THE STARBUCKS QSR.

PROJECT TITLE:

TRAVEL CENTER
4838 SR 96
JEFFERSONVILLE,
GEORGIA 31044

SHEET TITLE:


INTERIOR
DETAILS

PROJECT NO: 25021

1503


FOR REFERENCE ONLY

THESE PLANS ARE THE PROPERTY OF MRP DESIGN GROUP, INC. AND ARE SUBJECT TO FEDERAL COPYRIGHT LAWS. ANY USE OF SAME WITHOUT THE EXPRESS WRITTEN PERMISSION OF MRP DESIGN GROUP, INC. IS STRICTLY PROHIBITED.

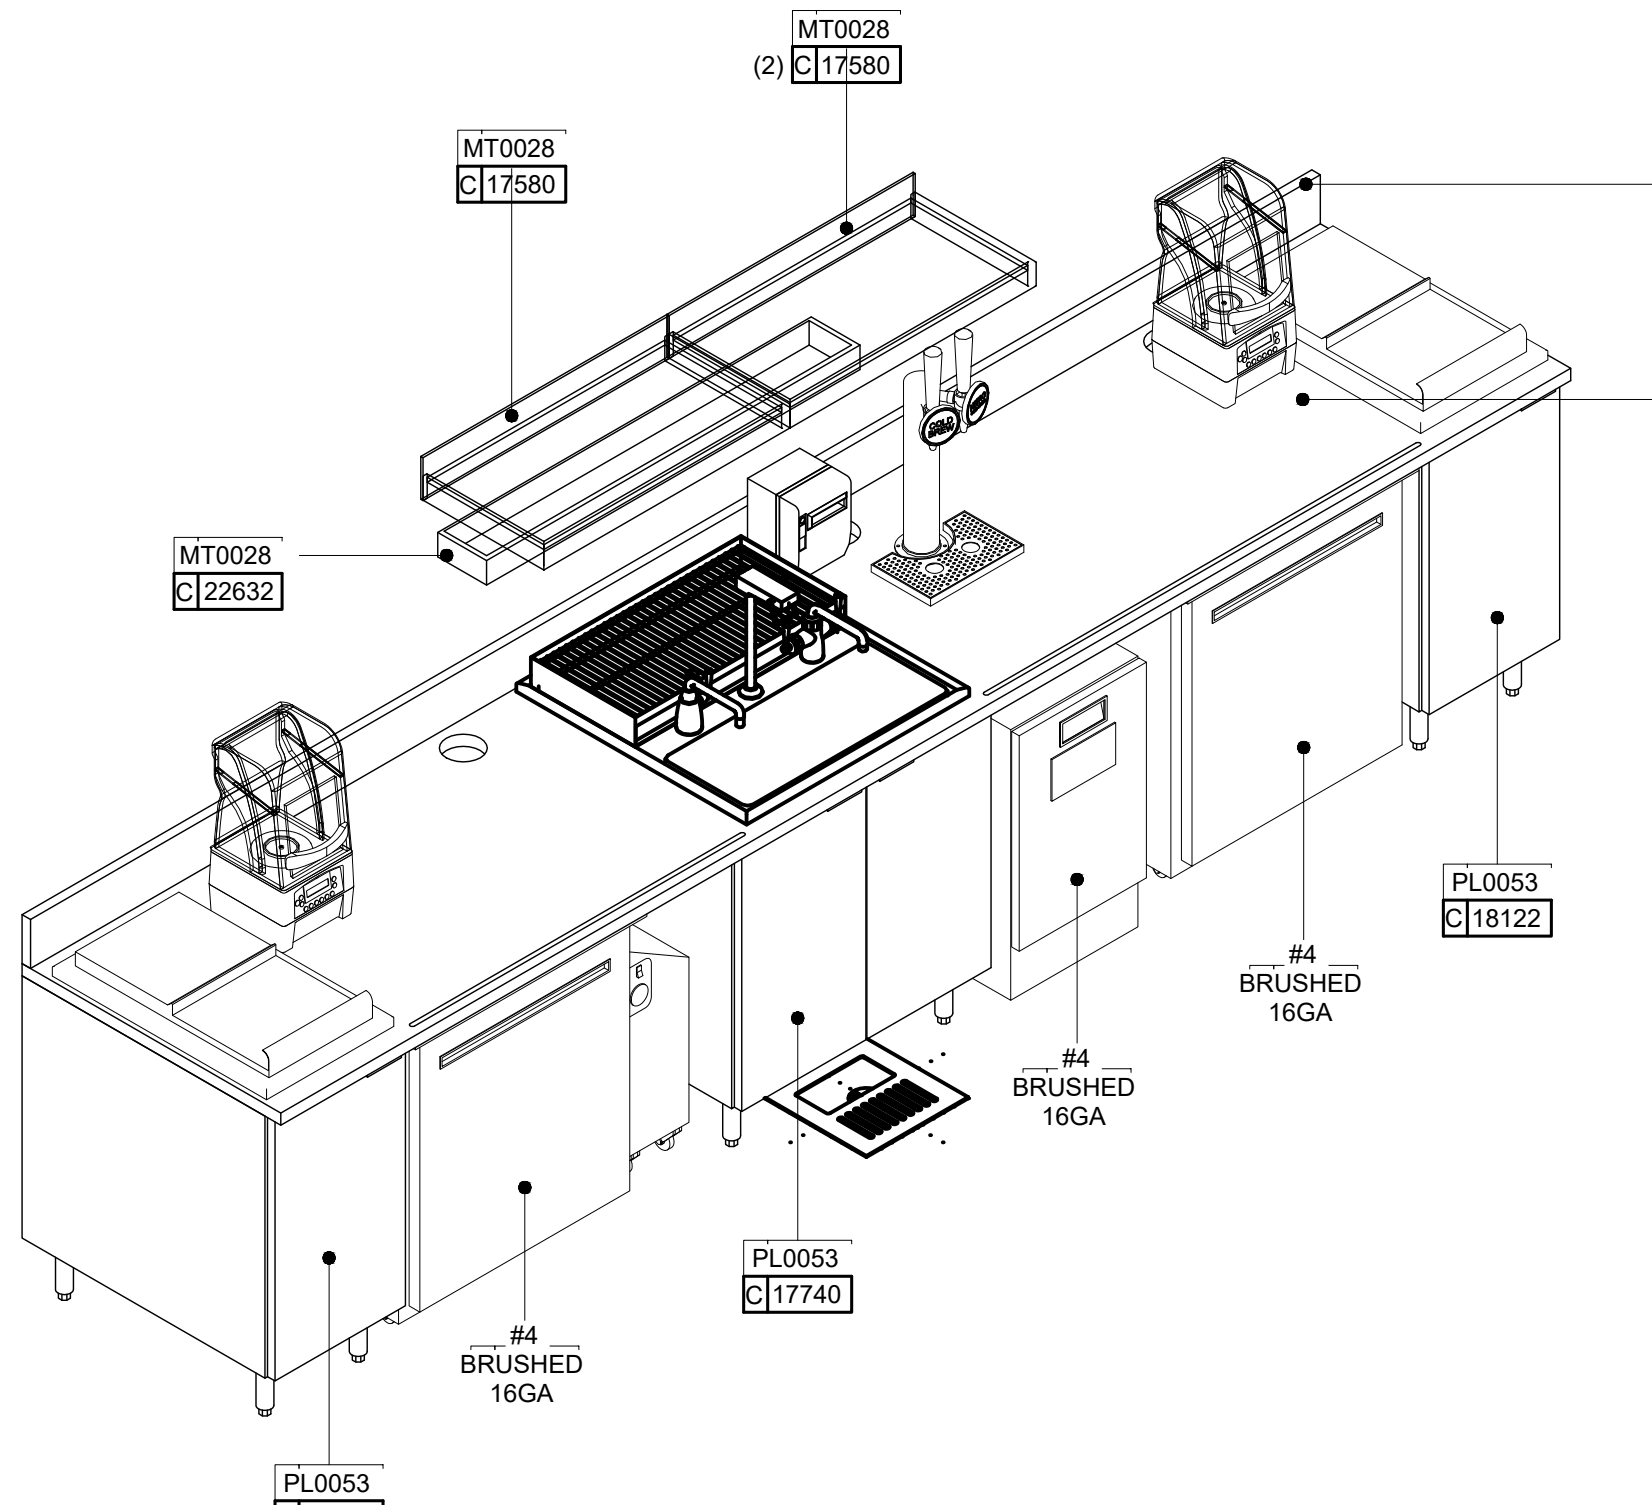


01 CBE 3D VIEW

Scale:

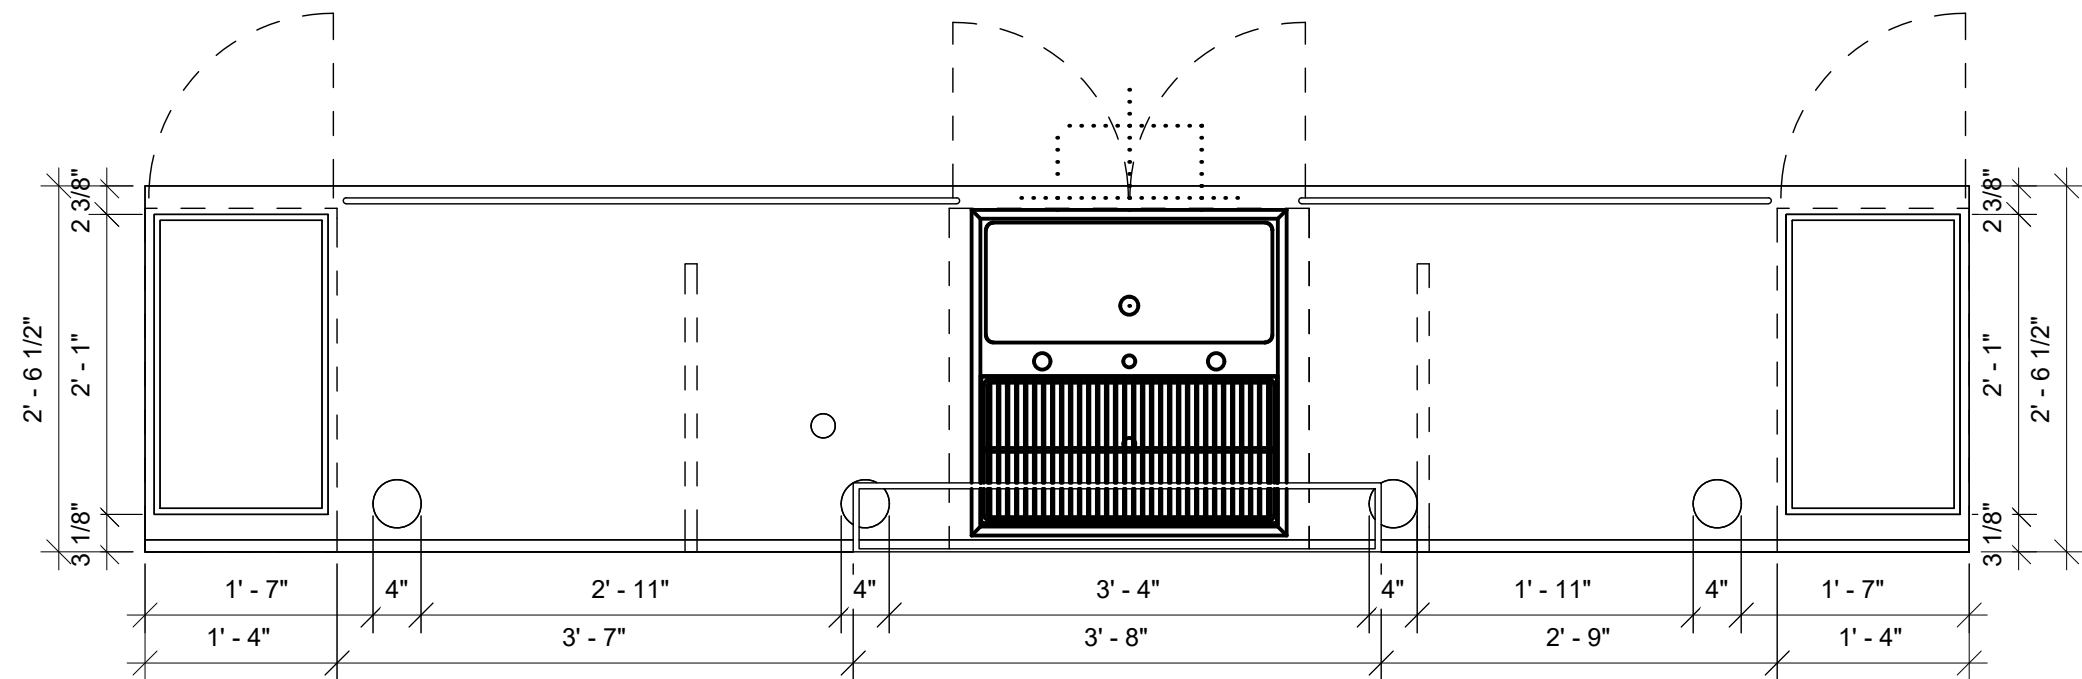


02 CBE -PLAN

Scale: 3/4" = 1'-0"

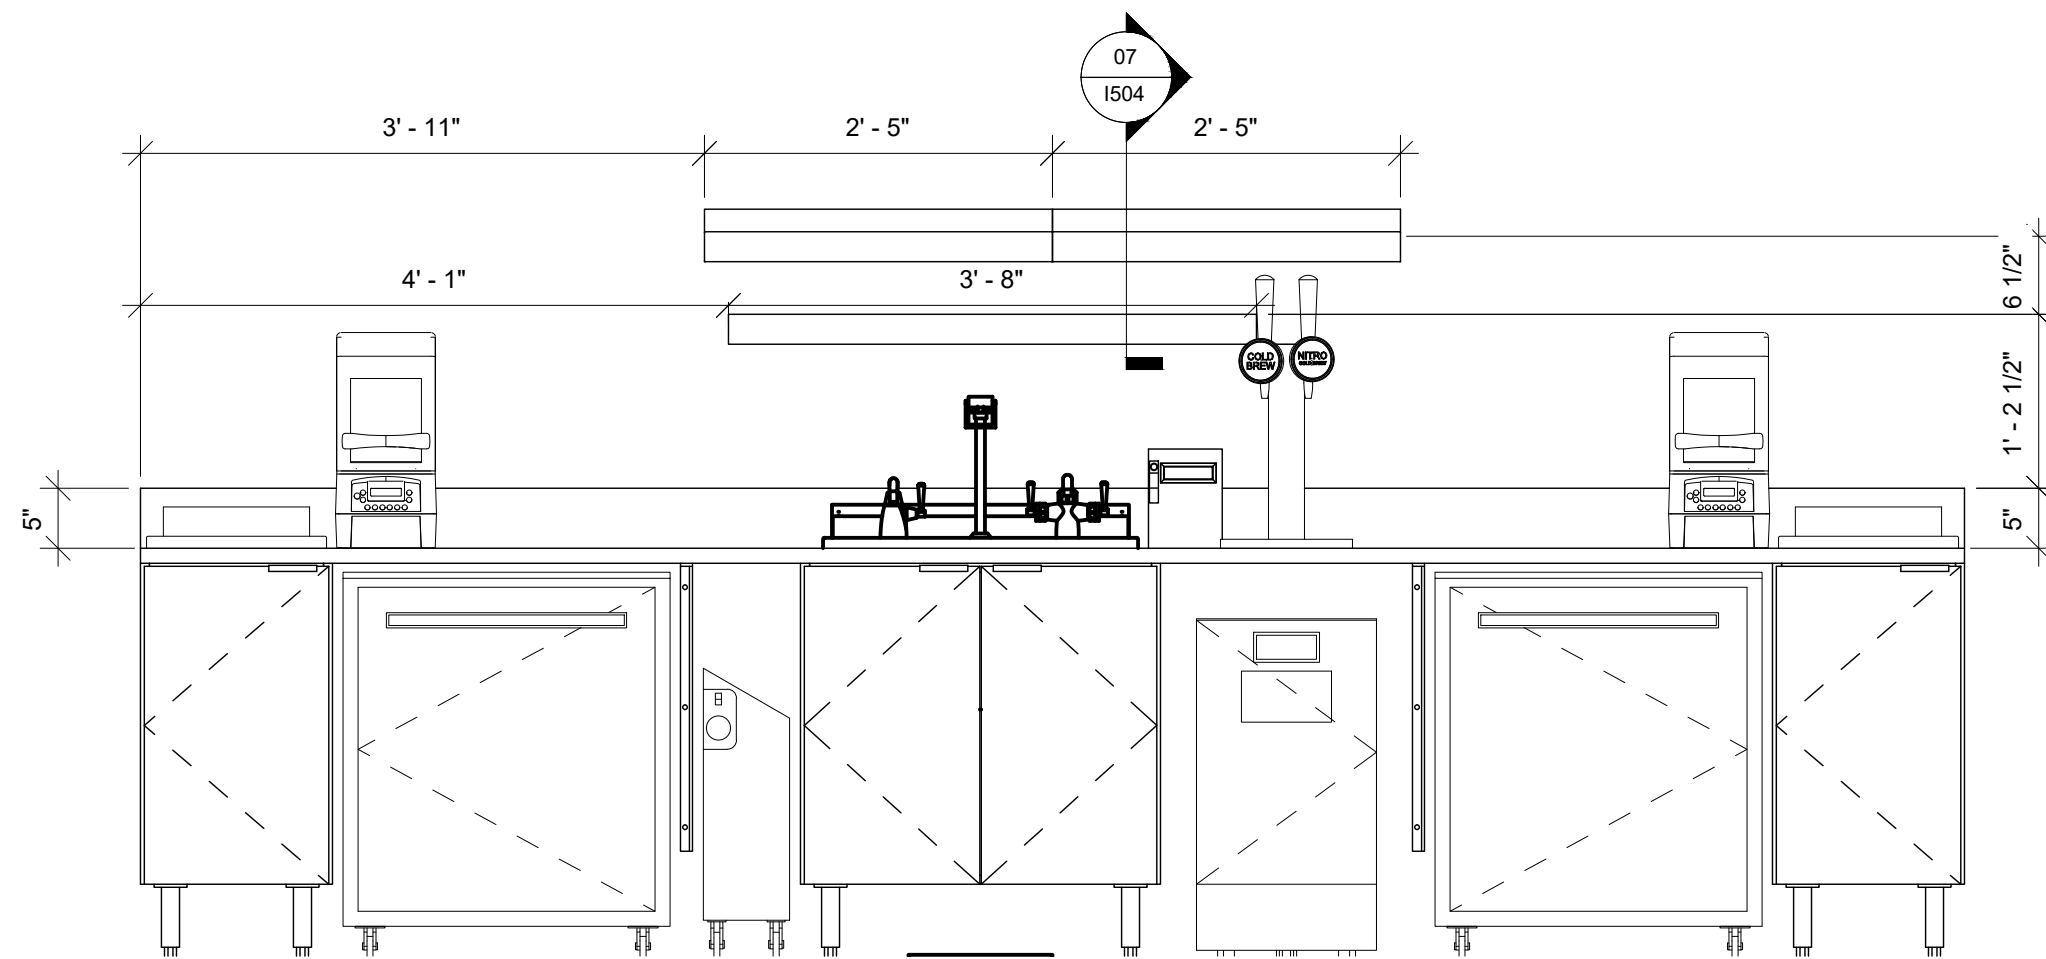


03 CBE -FRONT ELEVATION

Scale: 3/4" = 1'-0"

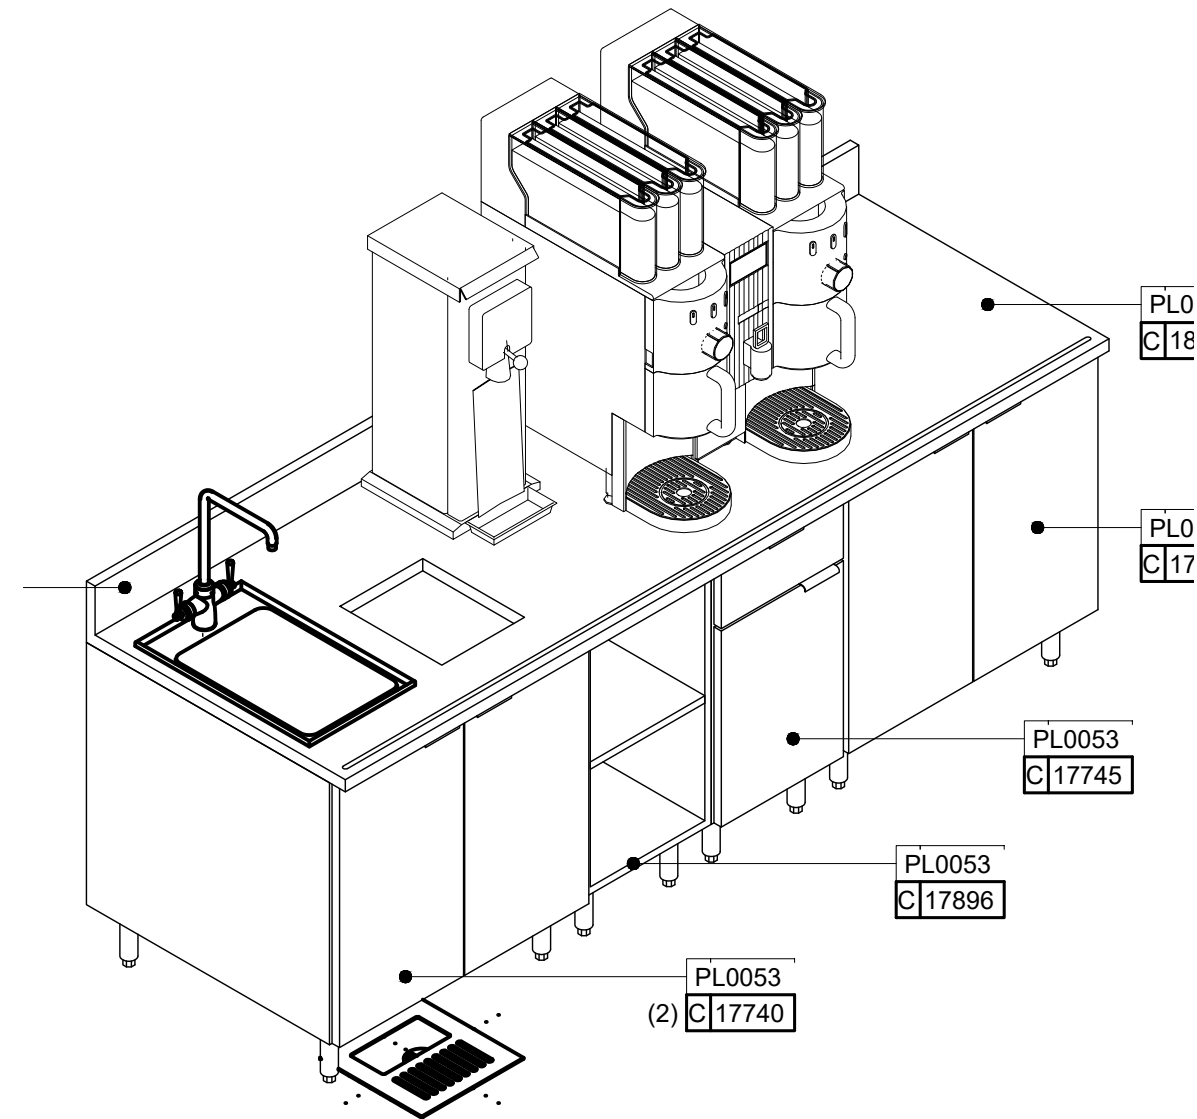


04 BRW 3D VIEW

Scale:

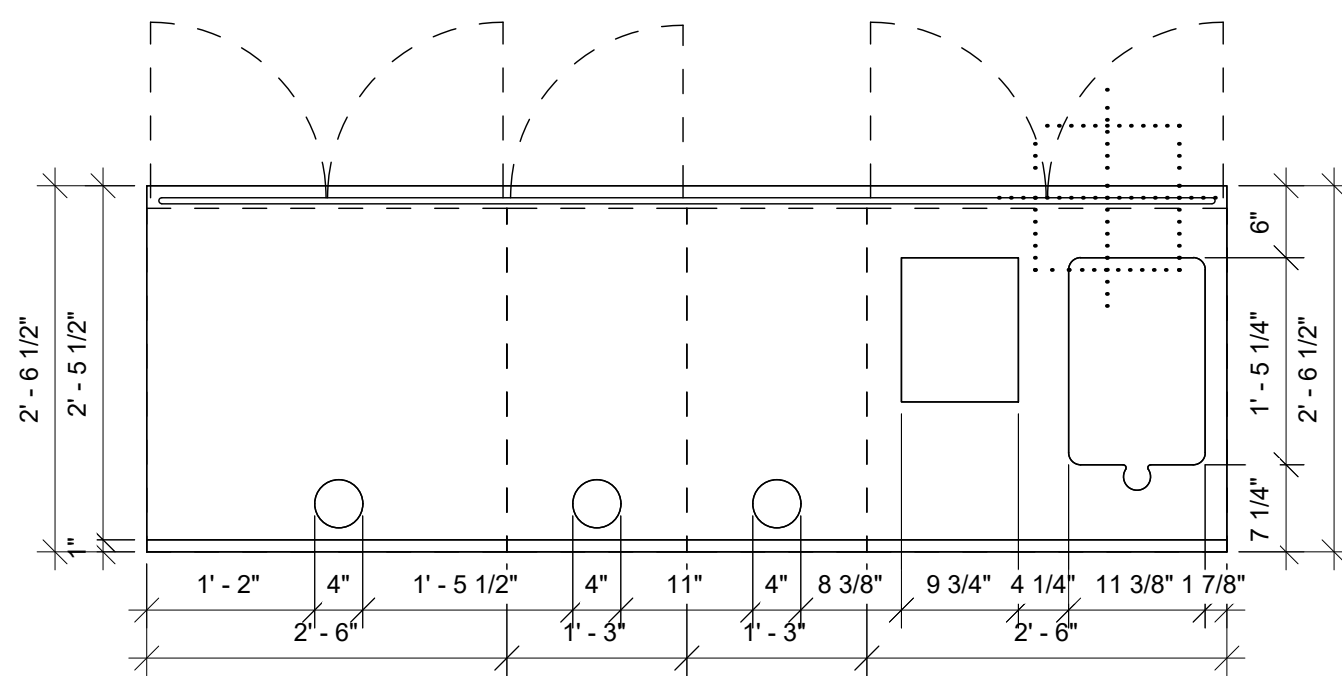


05 BRW -PLAN

Scale: 3/4" = 1'-0"

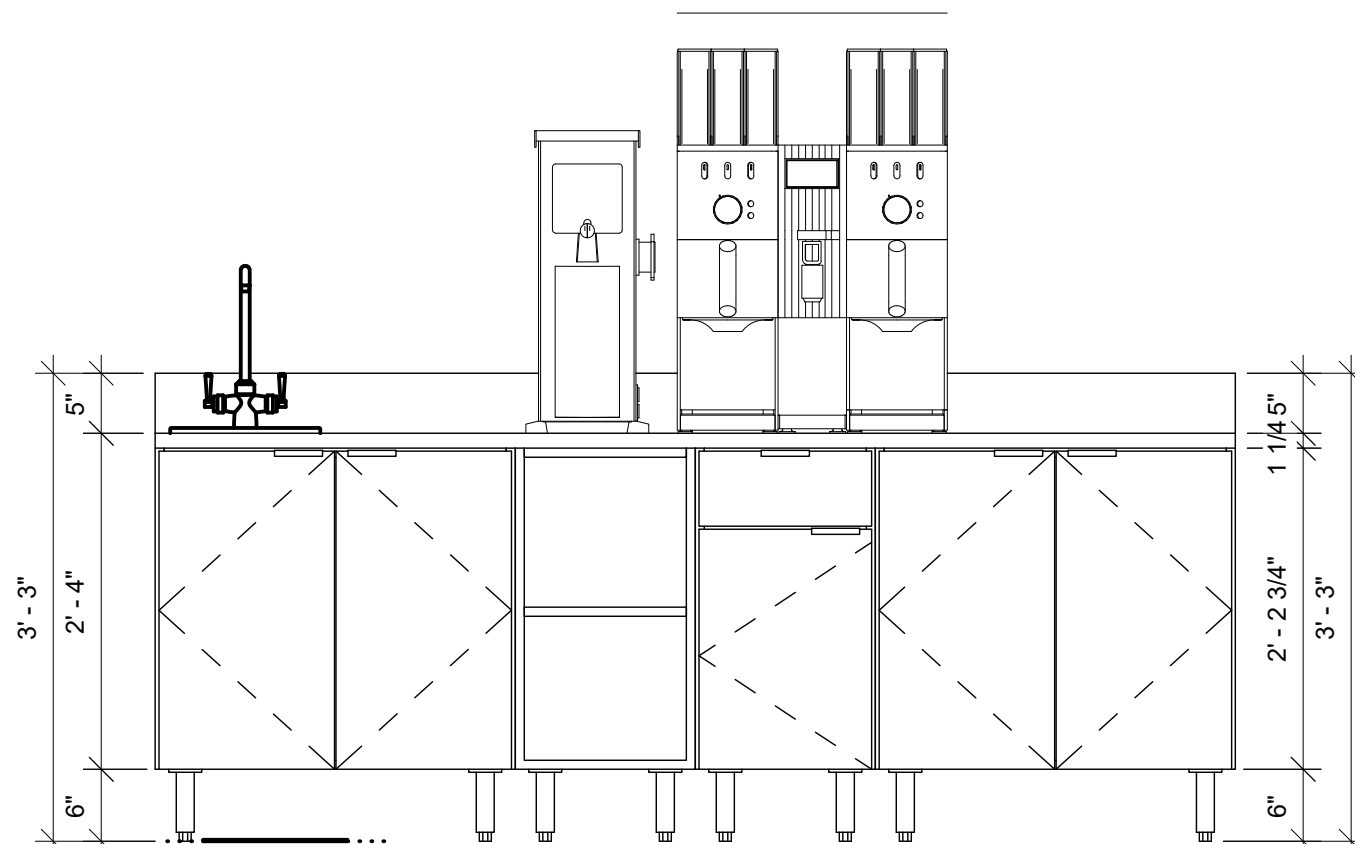

06 BRW -FRONT ELEVATION

Scale: 3/4" = 1'-0"

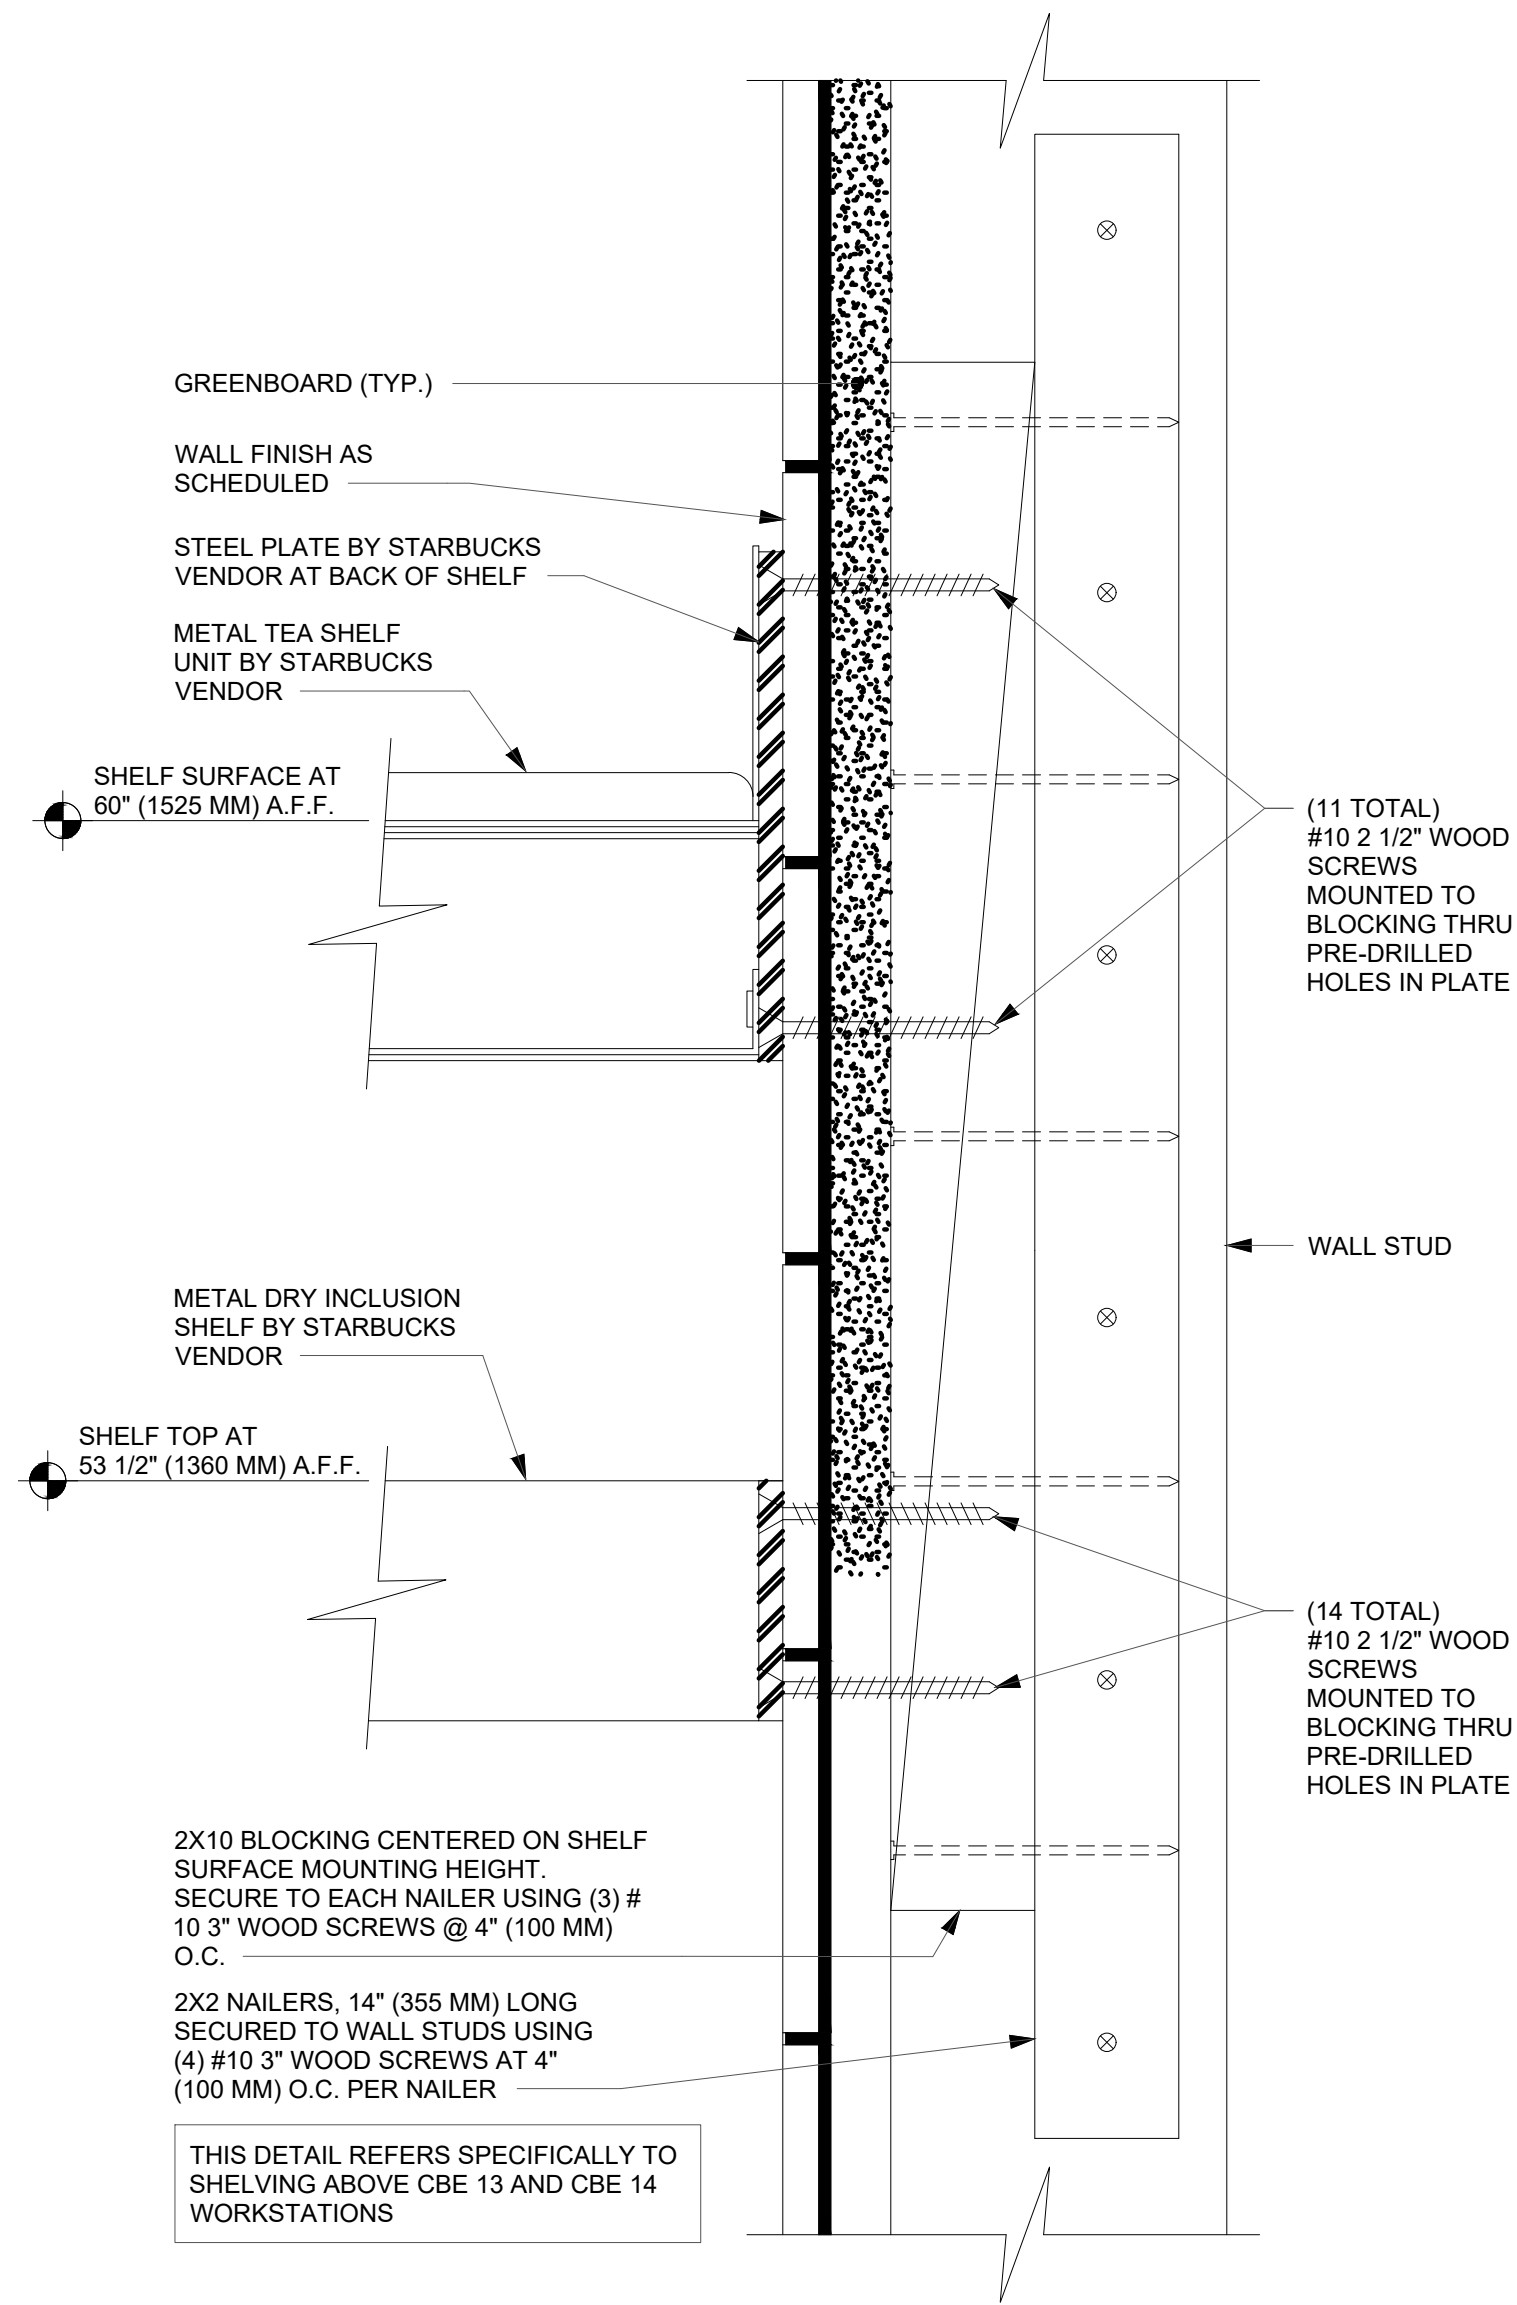

07 METAL TEA AND DRY INCLUSION SHELF WALL ATTACHMENT

Scale: 6" = 1'-0"

ARCHITECT OF RECORD:

THOMAS E. MORGAN, JR.
ARCHITECT

423 FISCHER TRAIL
ELLIJAY, GEORGIA 30540

SEAL:



MRP
DESIGN GROUP

3450 Acworth Due West Road
Building 100, Suite 120
Kennesaw, Georgia 30144
P: 770-917-9172
F: 770-917-9470
www.mrpdesign.com

RELEASED FOR
CONSTRUCTION

ISSUES / REVISIONS:

DATE	DESCRIPTION
05.04.26	RELEASE FOR CONSTRUCTION

DRAWN BY: JB

CHKD BY: TM

PROJECT DESCRIPTION:

NEW CONSTRUCTION OF A TA
TRAVEL CENTER IN
JEFFERSONVILLE, GA, WHICH
CONSISTS OF A TRUCKER
LOUNGE, SHOWERS, LAUNDRY
ROOM, RETAIL AREA,
RESTROOMS, GAME AREA,
SEATING AREAS, AND FOUR
QUICK-SERVICE RESTAURANTS.
THE MAJORITY OF THE
PROJECT HAS ALREADY BEEN
SUBMITTED. THIS ISSUE, DATED
05.04.26 HAS MODIFICATIONS
RELATED TO THE ADDITION OF
THE STARBUCKS QSR.

PROJECT TITLE:

TRAVEL CENTER
4838 SR 96
JEFFERSONVILLE,
GEORGIA 31044

SHEET TITLE:


INTERIOR
DETAILS

PROJECT NO: 25021


1504

FOR REFERENCE ONLY


THESE PLANS ARE THE PROPERTY OF MRP DESIGN GROUP, INC. AND ARE SUBJECT TO FEDERAL COPYRIGHT LAWS. ANY USE OF SAME WITHOUT THE EXPRESS WRITTEN PERMISSION OF MRP DESIGN GROUP, INC. IS STRICTLY PROHIBITED.

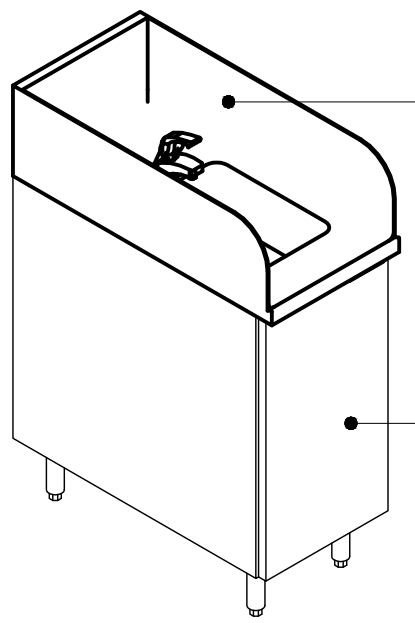


01 SINK -3D VIEW
Scale:

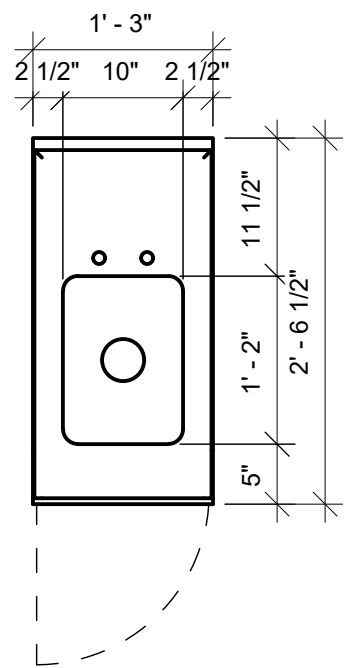


02 SINK -PLAN
Scale: 3/4" = 1'-0"

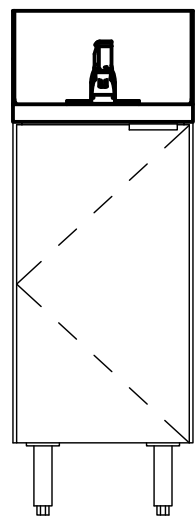


03 SINK -FRONT ELEVATION
Scale: 3/4" = 1'-0"

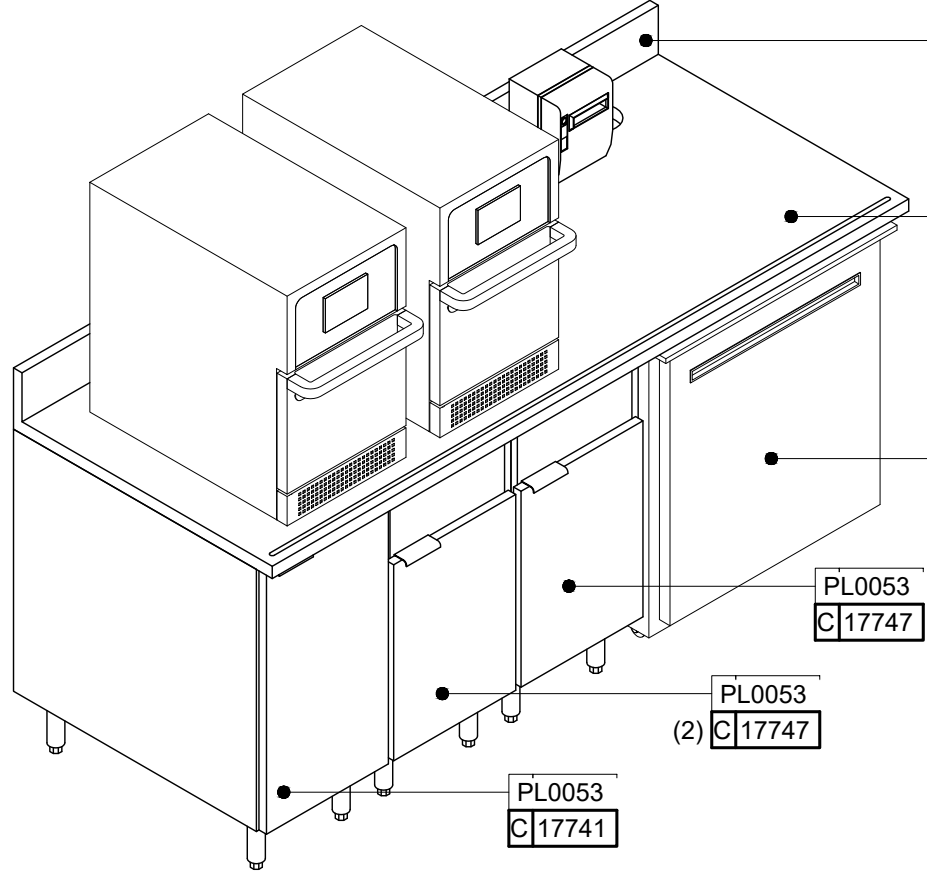


04 WRM 3D VIEW
Scale:

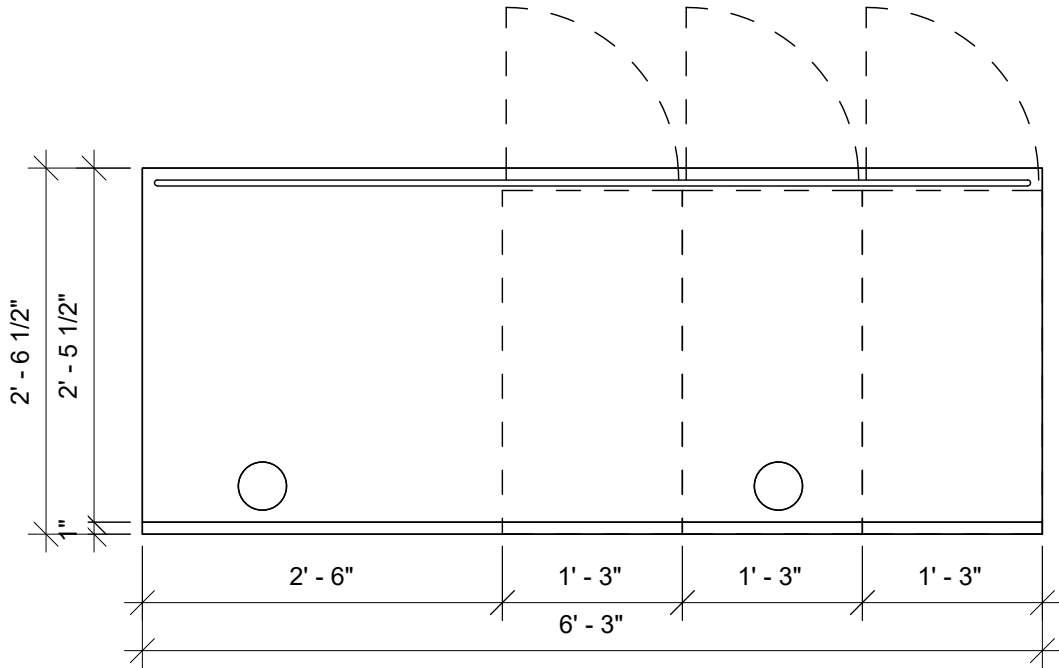


05 WRM - PLAN
Scale: 3/4" = 1'-0"

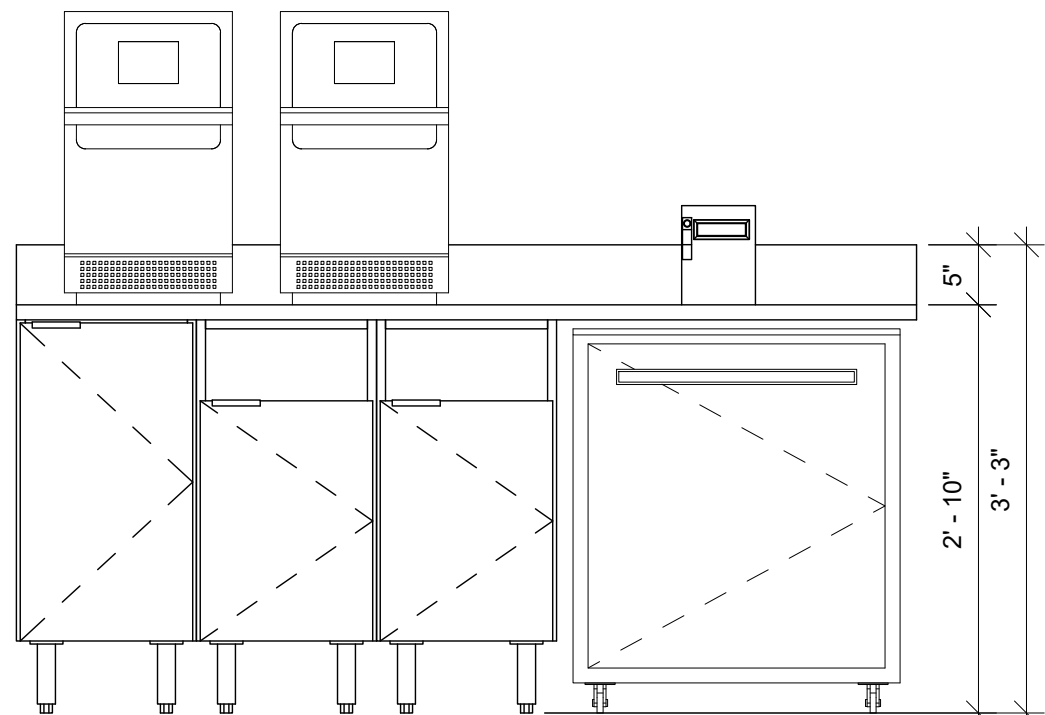


06 WRM -ELEVATION
Scale: 3/4" = 1'-0"

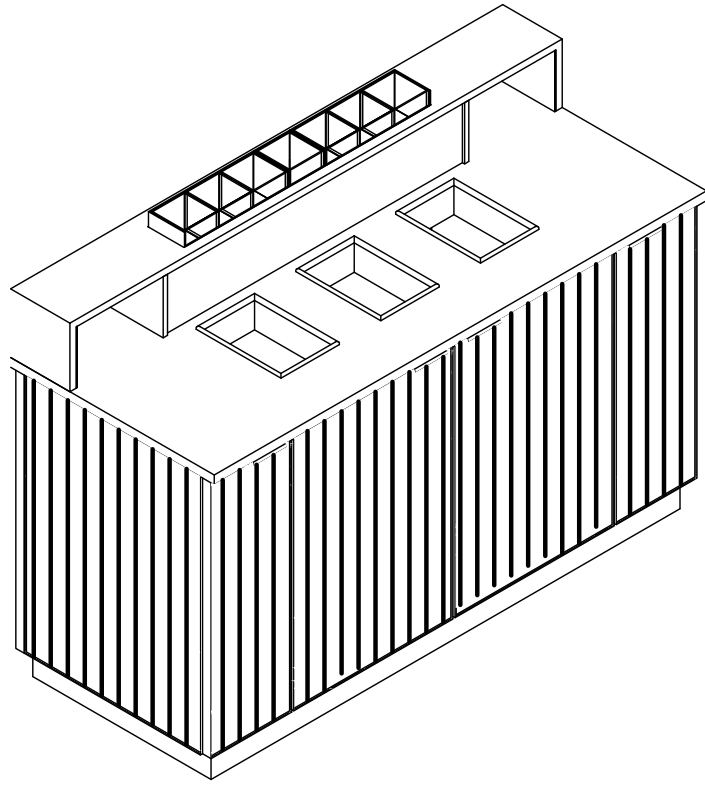

07 CONDIMENT CART FRONT 3D VIEW
Scale:

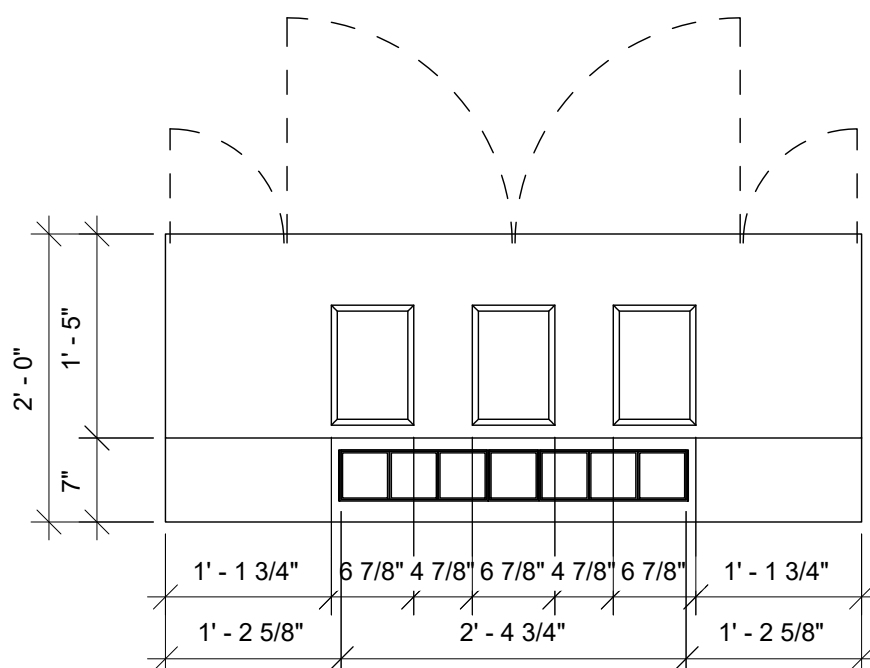

08 CONDIMENT CART - PLAN
Scale: 3/4" = 1'-0"

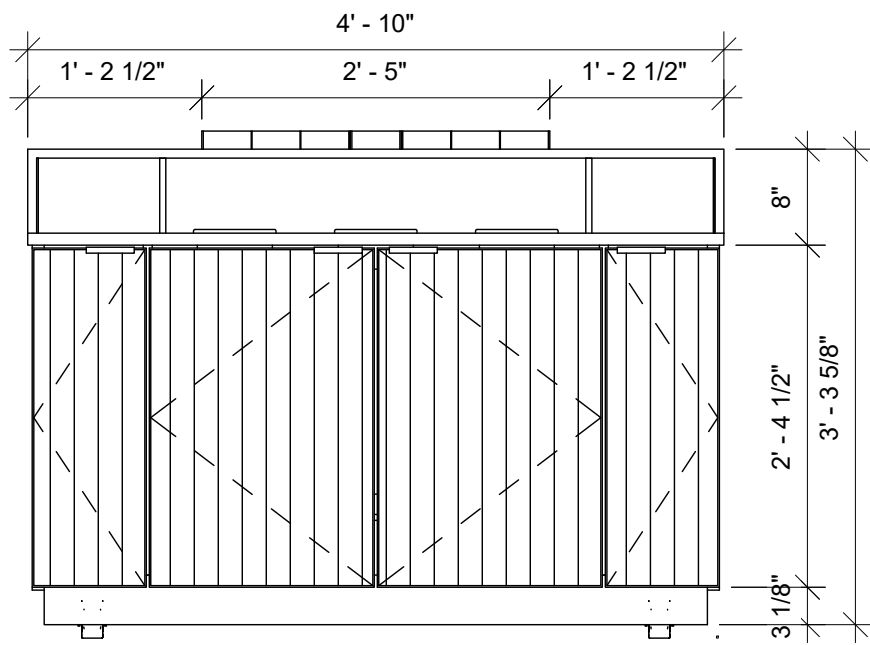

09 CONDIMENT CART - FRONT ELEVATION
Scale: 3/4" = 1'-0"

ARCHITECT OF RECORD:

THOMAS E. MORGAN, JR.
ARCHITECT

423 FISCHER TRAIL
ELLIJAY, GEORGIA 30540

SEAL:



MRP
DESIGN GROUP

3450 Acworth Due West Road
Building 100, Suite 120
Kennesaw, Georgia 30144
P: 770-917-9172
F: 770-917-9470
www.mrpdesign.com

RELEASED FOR
CONSTRUCTION

ISSUES / REVISIONS:

DATE	DESCRIPTION
05.04.26	RELEASE FOR CONSTRUCTION

DRAWN BY: JB

CHKD BY: TM

PROJECT DESCRIPTION:

NEW CONSTRUCTION OF A TA TRAVEL CENTER IN JEFFERSONVILLE, GA, WHICH CONSISTS OF A TRUCKER LOUNGE, SHOWERS, LAUNDRY ROOM, RETAIL AREA, RESTROOMS, GAME AREA, SEATING AREAS, AND FOUR QUICK-SERVICE RESTAURANTS. THE MAJORITY OF THE PROJECT HAS ALREADY BEEN SUBMITTED. THIS ISSUE, DATED 05.04.26 HAS MODIFICATIONS RELATED TO THE ADDITION OF THE STARBUCKS QSR.

PROJECT TITLE:

TRAVEL CENTER
4838 SR 96
JEFFERSONVILLE,
GEORGIA 31044

SHEET TITLE:


INTERIOR
DETAILS

PROJECT NO: 25021

1505


FOR REFERENCE ONLY

THESE PLANS ARE THE PROPERTY OF MRP DESIGN GROUP, INC. AND ARE SUBJECT TO FEDERAL COPYRIGHT LAWS. ANY USE OF SAME WITHOUT THE EXPRESS WRITTEN PERMISSION OF MRP DESIGN GROUP, INC. IS STRICTLY PROHIBITED.

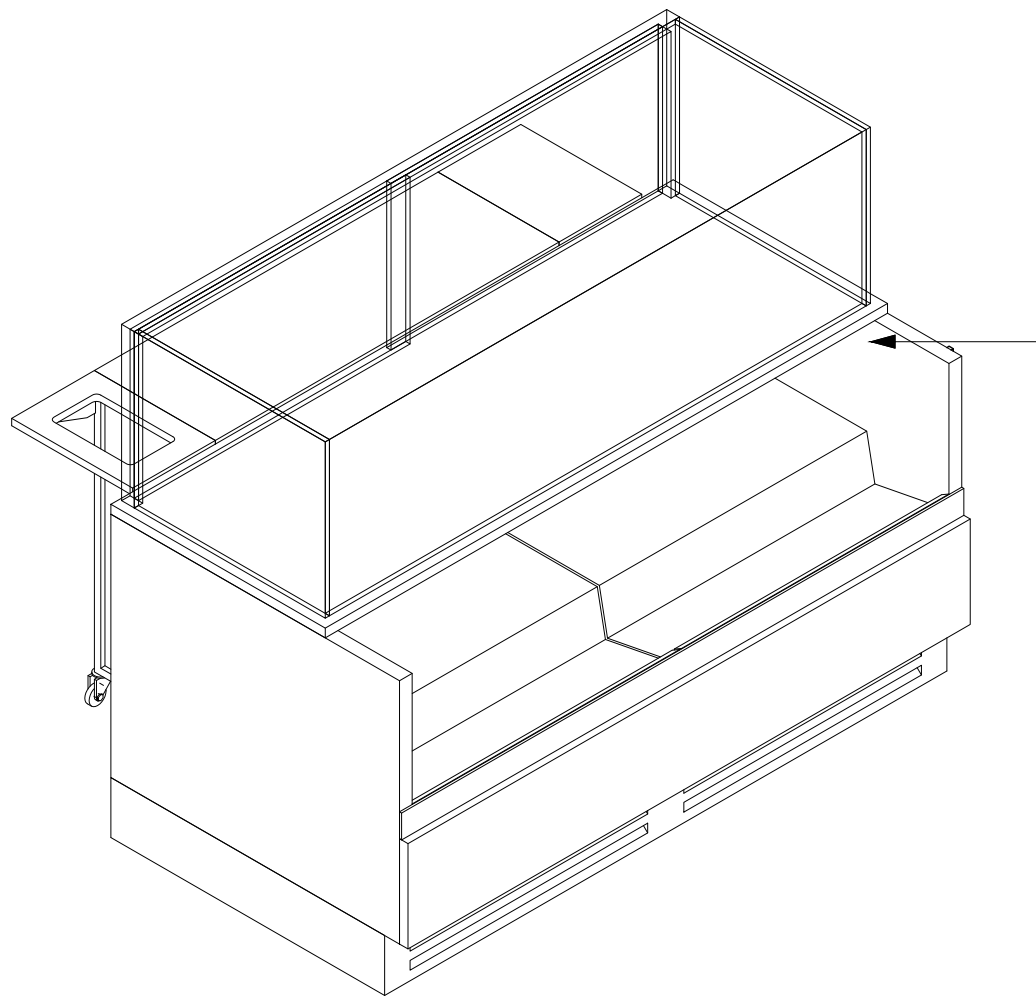


01 FOOD CASE FRONT 3D VIEW

Scale:

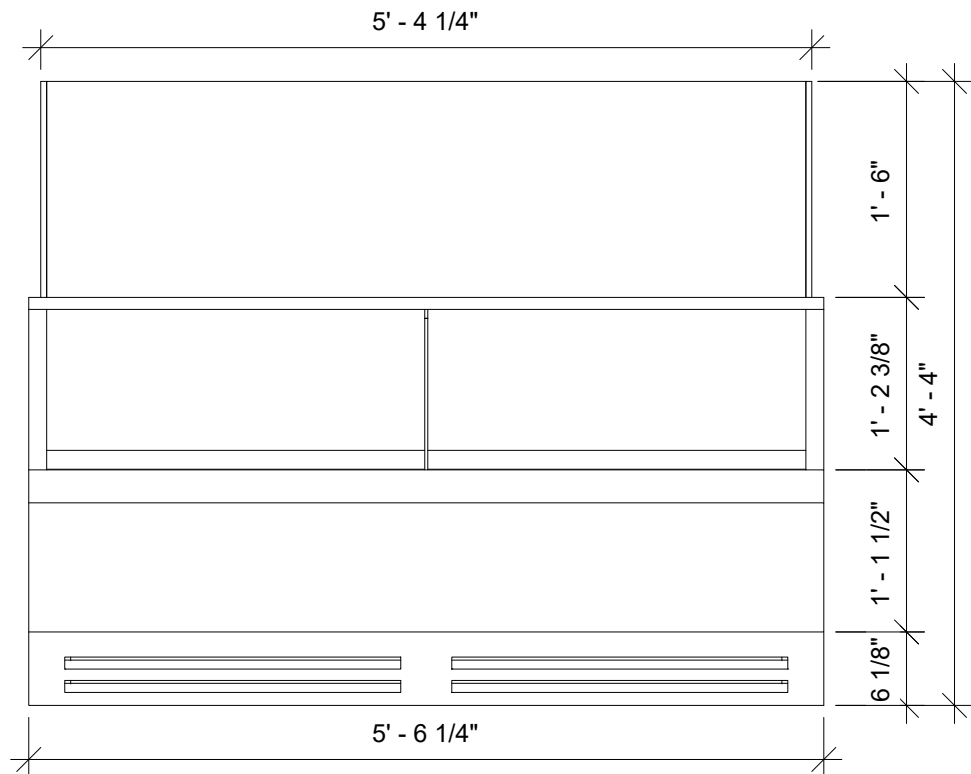


04 FOOD CASE-FRONT ELEVATION

Scale: 3/4" = 1'-0"

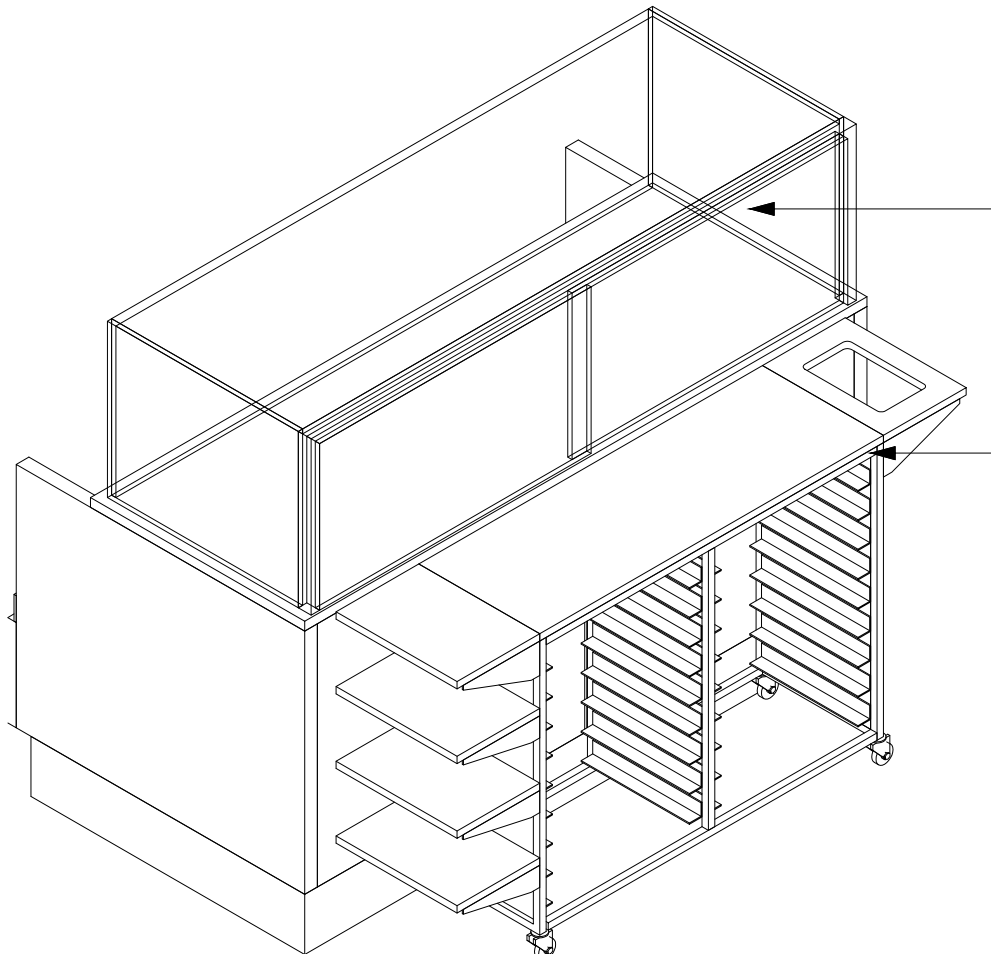


02 FOOD CASE BACK 3D VIEW

Scale:

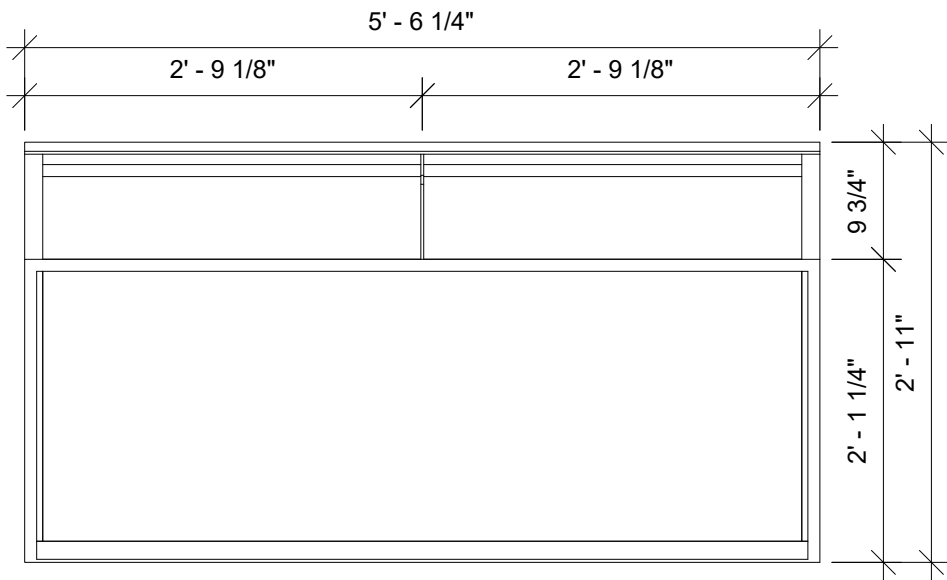


05 FOOD CASE -PLAN

Scale: 3/4" = 1'-0"

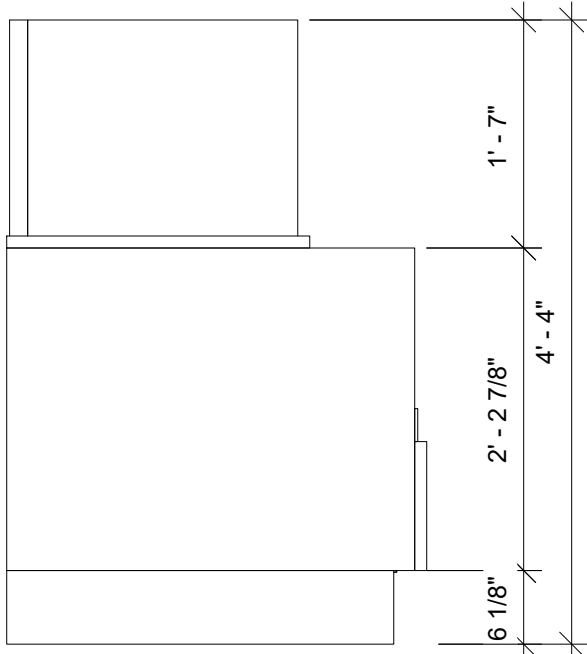

03 FOOD CASE - SIDE ELEVATION

Scale: 3/4" = 1'-0"

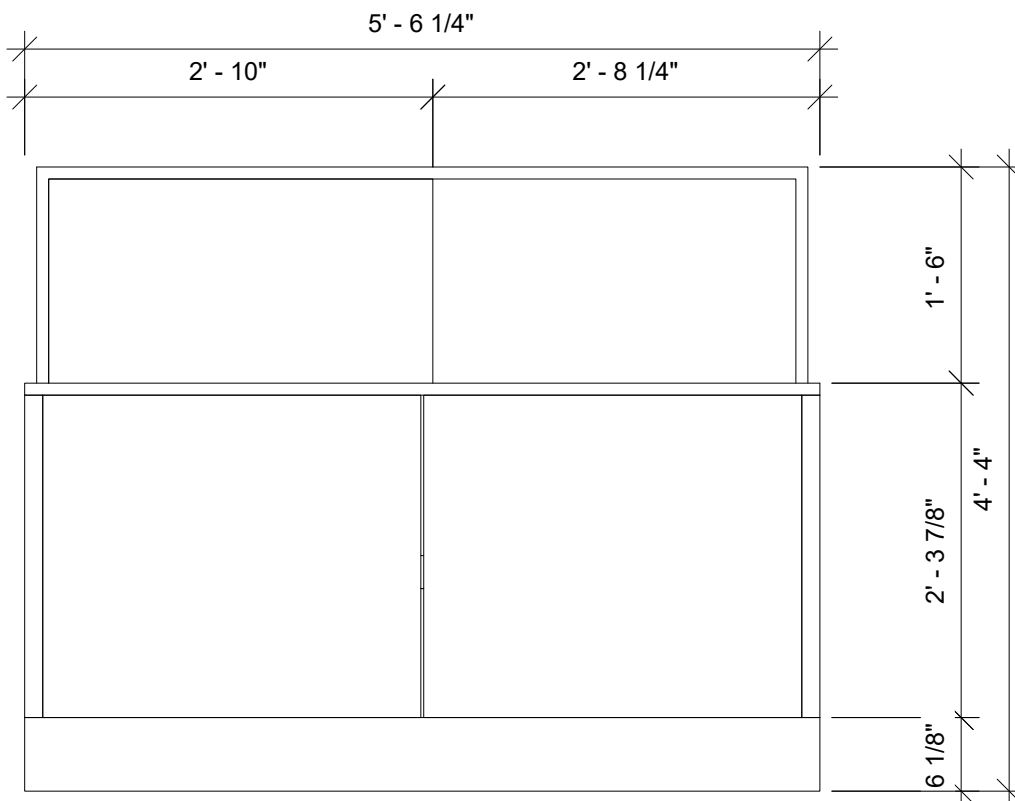

06 FOOD CASE -BACK ELEVATION


Scale: 3/4" = 1'-0"

ARCHITECT OF RECORD:

THOMAS E. MORGAN, JR.
ARCHITECT

423 FISCHER TRAIL
ELLIJAY, GEORGIA 30540

SEAL:

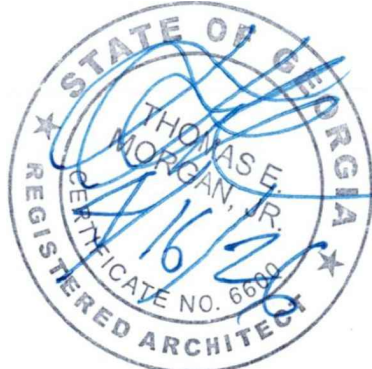

MRP
DESIGN GROUP

3450 Acworth Due West Road
Building 100, Suite 120
Kennesaw, Georgia 30144
P. 770-917-9172
F. 770-917-9470
www.mrpdesign.com

RELEASED FOR
CONSTRUCTION

ISSUES / REVISIONS:

DATE	DESCRIPTION
05.04.26	RELEASE FOR CONSTRUCTION

DRAWN BY: JB

CHKD BY: TM

PROJECT DESCRIPTION:

NEW CONSTRUCTION OF A TA TRAVEL CENTER IN JEFFERSONVILLE, GA. WHICH CONSISTS OF A TRUCKER LOUNGE, SHOWERS, LAUNDRY ROOM, RETAIL AREA, RESTROOMS, GAME AREA, SEATING AREAS, AND FOUR QUICK-SERVICE RESTAURANTS. THE MAJORITY OF THE PROJECT HAS ALREADY BEEN SUBMITTED. THIS ISSUE, DATED 05.04.26 HAS MODIFICATIONS RELATED TO THE ADDITION OF THE STARBUCKS QSR.

PROJECT TITLE:

TRAVEL CENTER
4838 SR 96
JEFFERSONVILLE,
GEORGIA 31044

SHEET TITLE:

INTERIOR
DETAILS

PROJECT NO: 25021


1506

FOR REFERENCE ONLY


THESE PLANS ARE THE PROPERTY OF MRP DESIGN GROUP, INC. AND ARE SUBJECT TO FEDERAL COPYRIGHT LAWS. ANY USE OF SAME WITHOUT THE EXPRESS WRITTEN PERMISSION OF MRP DESIGN GROUP, INC. IS STRICTLY PROHIBITED.

NOTES:

1. LOCATE PUMP WITHIN CORD LENGTH LIMIT. ORIENT WITH PUMP HEAD LEFT, RIGHT AND AT BOTTOM. LOOSEN PUMP HEAD CLAMP. ROTATE AND RE-TIGHTEN AS REQUIRED PER ORIENTATION TO PROVIDE FRONT ACCESS TO FLOW. ADJUSTMENT WITHIN CORD LENGTH LIMIT.
2. USE LOCKTITE ON ISOLATOR THREADS. DO NOT OVER TIGHTEN.
3. LOOSEN PUMP HEAD CLAMP, ROTATE AND RE-TIGHTEN AS REQUIRED FOR PUMP ORIENTATION.
4. EACH BACKER BOARD'S ASSEMBLY COMPONENTS INCLUDE:
 - (1) BACKER BOARDS
 - (4) TENETS, 1/4-20 VENDOR MOUNTED
 - (8) WOOD SCREWS #8 1-1/4" (32MM)
 - (4) NEOPRENE ISOLATORS, KARMAN RUBBER, K84-60
 - NEOPRENE
 - (4) LOCK NUTS, 1/4-20 NYLON
 - (4) WASHERS, 1/4" (7MM) FLAT

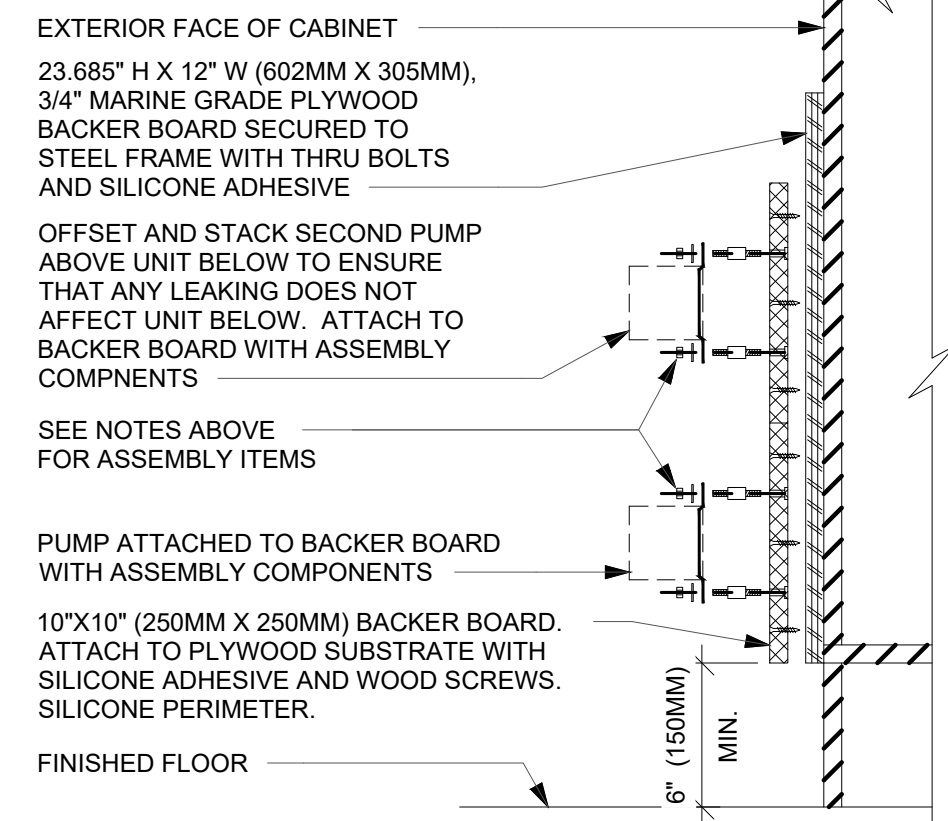

01 ESPRESSO PUMP MPUNTED AT CANINET
Scale: 1 1/2" = 1'-0"

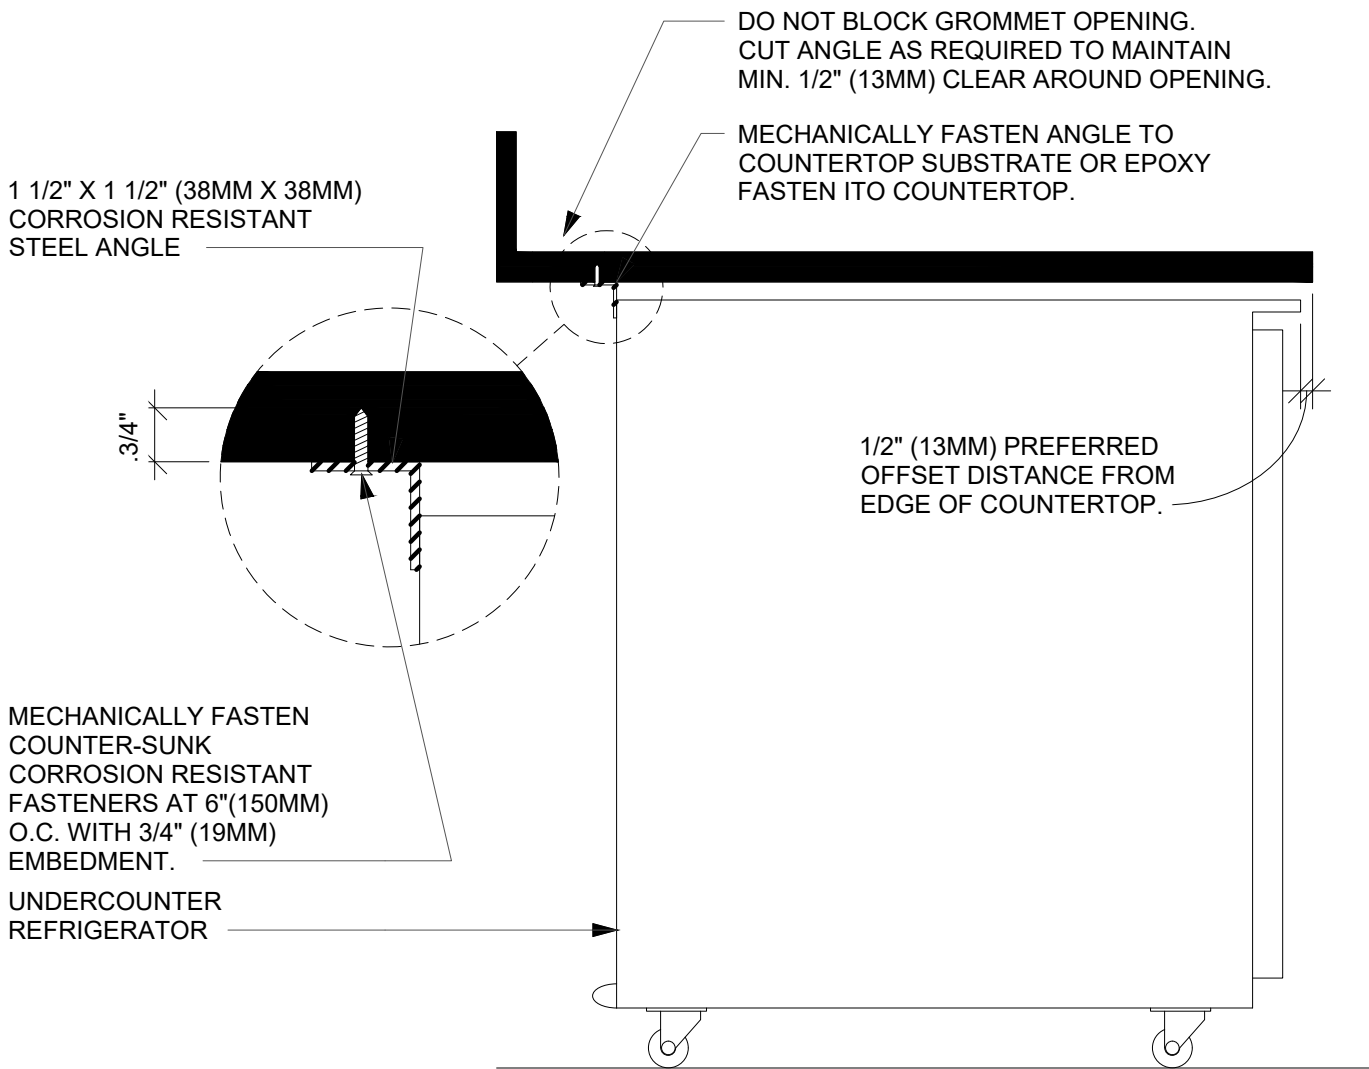

SECTION VIEW

NOTES

1. 24" (610MM) 1 1/2" X 1 1/2" (38MM X 38MM) STEEL ANGLE TO BE USED WITH SINGLE DOOR REFRIGERATORS.
2. 48" (1220MM) 1 1/2" X 1 1/2" (38MM X 38MM) STEEL ANGLE TO BE USED WITH DOUBLE DOOR REFRIGERATORS.


02 UNDERCOUNTER REFRIGERATOR STOP INSTALLATION
Scale: 1 1/2" = 1'-0"

10' - 0" A.F.F.
B/O GYP BOARD CEILING

2' - 10" A.F.F.
BACKBAR COUNTERTOP

0' - 00" A.F.F.
INTERIOR FLOOR LEVEL


03 SECTION AT BACK BAR
Scale: 3/4" = 1'-0"

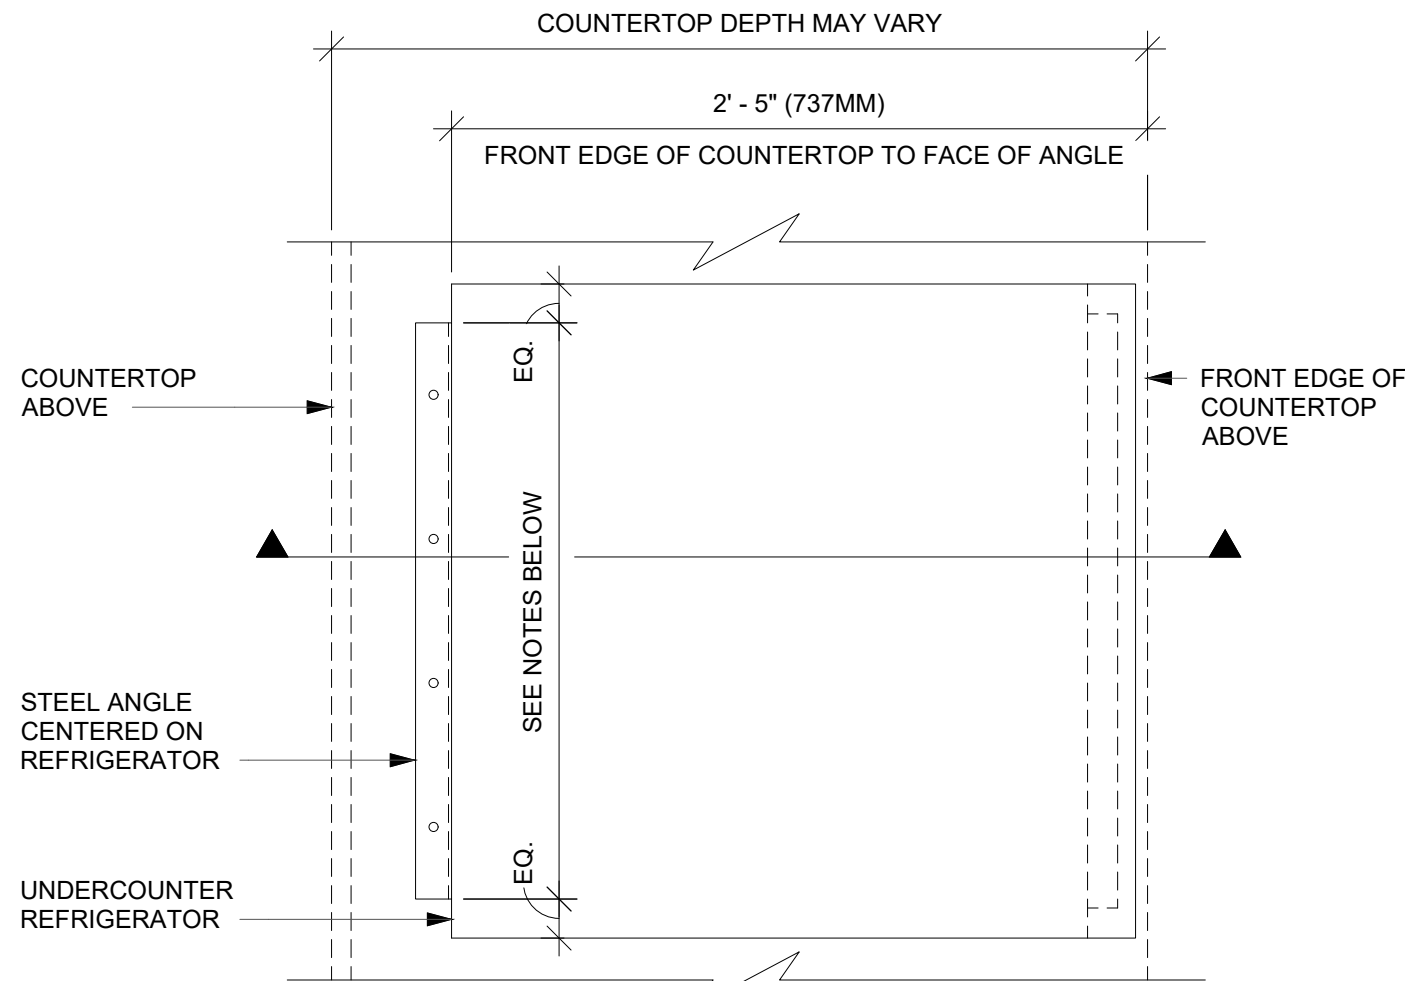

PLAN VIEW

NOTES:

- 1 1' - 7" AFF (CW SUPPLY)
- 2 1' - 6" AFF (CWF SUPPLY)
- 3 1' - 5" AFF (HW SUPPLY)
- 4 VARIES: 1/4" PER FOOT FALL (ABS 2" WASTE LINE)

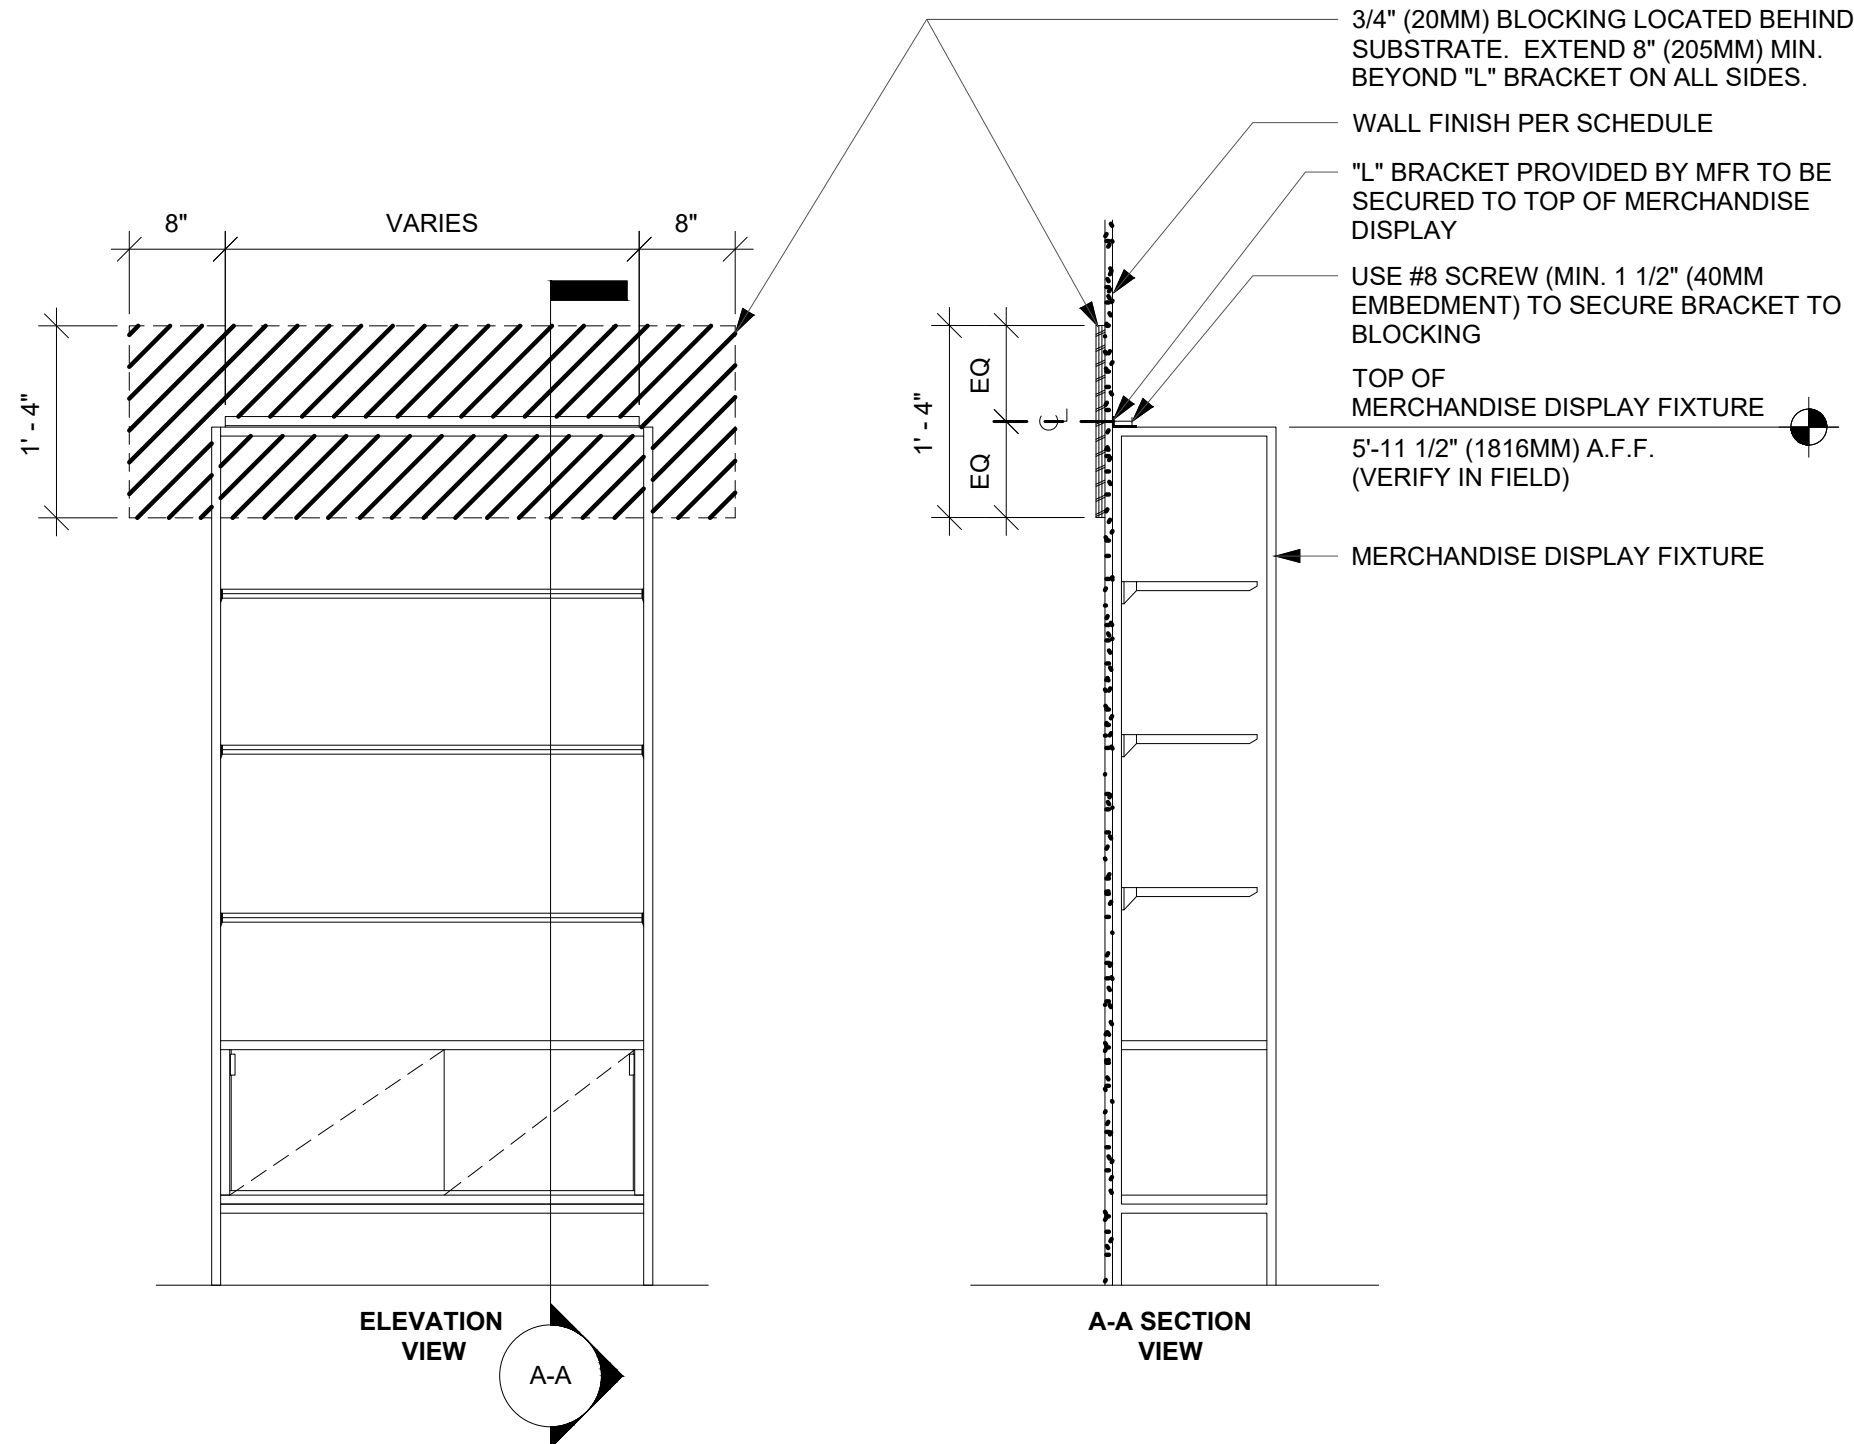

04 MERCHANDISE WALL BAY DISPLAY FIXTURE WALL ATTACHMENT
Scale: 3/4" = 1'-0"

ARCHITECT OF RECORD:

THOMAS E. MORGAN, JR.
ARCHITECT

423 FISCHER TRAIL
ELLIJAY, GEORGIA 30540

SEAL:



MRP
DESIGN GROUP

3450 Acworth Due West Road
Building 100, Suite 120
Kennesaw, Georgia 30144
P: 770-917-9172
F: 770-917-9470
www.mrpdesign.com

RELEASED FOR
CONSTRUCTION

ISSUES / REVISIONS:

DATE	DESCRIPTION
05.04.26	RELEASE FOR CONSTRUCTION

DRAWN BY: JB

CHKD BY: TM

PROJECT DESCRIPTION:

NEW CONSTRUCTION OF A TA TRAVEL CENTER IN JEFFERSONVILLE, GA, WHICH CONSISTS OF A TRUCKER LOUNGE, SHOWERS, LAUNDRY ROOM, RETAIL AREA, RESTROOMS, GAME AREA, SEATING AREAS, AND FOUR QUICK-SERVICE RESTAURANTS. THE MAJORITY OF THE PROJECT HAS ALREADY BEEN SUBMITTED. THIS ISSUE, DATED 05.04.26 HAS MODIFICATIONS RELATED TO THE ADDITION OF THE STARBUCKS QSR.

PROJECT TITLE:

TRAVEL CENTER
4838 SR 96
JEFFERSONVILLE,
GEORGIA 31044

SHEET TITLE:

CASEWORK
DETAILS


PROJECT NO: 25021

1507

FOR REFERENCE ONLY


THESE PLANS ARE THE PROPERTY OF MRP DESIGN GROUP, INC. AND ARE SUBJECT TO FEDERAL COPYRIGHT LAWS. ANY USE OF SAME WITHOUT THE EXPRESS WRITTEN PERMISSION OF MRP DESIGN GROUP, INC. IS STRICTLY PROHIBITED.

GRAPHICS AND ARTWORK SCHEDULE - "G"					
DESIGN ID	COUNT	DESCRIPTION	FURN. BY	INST. BY	COMMENTS
GRAPHICS					
16884	1	ART - UNKNOWN ARTIST - COOLING AND SCOOPING	SB	GC	SBXART_16884 - FRAME WITH NO MAT - ART SIZE: 14 7/8" W X 10 1/2" H - OVERALL SIZE: 16 3/8" W X 12" H - PAPER: PREMIUM ARCHIVAL MATTE PAPER - FRAME: 208710 EBONIZED WALNUT 3/4"
17199	1	ART - YOUNG LEE - STARBUCKS SIGN	SB	GC	SBXART_17199 - FRAMED & MATTED - ART SIZE: 11" W X 6 1/2" H - MAT BORDER: 2" - OVERALL SIZE: 16 1/2" W X 12" H - PAPER: PREMIUM ARCHIVAL MATTE PAPER - MAT: SAND DOLLAR 1126 81126 - FRAME: 208710 EBONIZED WALNUT 3/4"
17217	1	ART - UNKNOWN ARTIST - PIKE PLACE MARKET SIGN	SB	GC	SBXART_17217 - FRAME WITH NO MAT - ART SIZE: 15 1/2" W X 15 1/2" H - OVERALL SIZE: 17" W X 17" H - PAPER: PREMIUM ARCHIVAL MATTE PAPER - FRAME: 208710 EBONIZED WALNUT 3/4"
19186	1	ART - GLOBAL CREATIVE STUDIO - HACIENDA ALSACIA 8 - BW	SB	GC	SBXART_19186 - FRAME WITH NO MAT - ART SIZE: 20 1/4" W X 13 1/2" H - OVERALL SIZE: 21 3/4" W X 15" H - PAPER: PREMIUM ARCHIVAL MATTE PAPER - FRAME: 208710 EBONIZED WALNUT 3/4"
19815	1	ART - GLOBAL CREATIVE STUDIO - ROASTERY 1 - COLOR	SB	GC	SBXART_19815 - FRAME WITH NO MAT - ART SIZE: 10" W X 10" H - OVERALL SIZE: 11 3/4" W X 11 3/4" H - PAPER: PREMIUM ARCHIVAL MATTE PAPER - FRAME: 20321 LIGHT OAK 7/8"
19819	1	ART - GLOBAL CREATIVE STUDIO - ROASTERY 3 - COLOR	SB	GC	SBXART_19819 - FRAME WITH NO MAT - ART SIZE: 28 7/8" W X 19 1/4" H - OVERALL SIZE: 30 5/8" W X 21" H - PAPER: PREMIUM ARCHIVAL MATTE PAPER - FRAME: 20321 LIGHT OAK 7/8"
19863	1	ART - GLOBAL CREATIVE STUDIO - HERITAGE 1 - COLOR	SB	GC	SBXART_19863 - FRAMED & MATTED - ART SIZE: 13 1/2" W X 9" H - MAT: 3" - OVERALL SIZE: 21" W X 16 1/2" H - PAPER: PREMIUM ARCHIVAL MATTE PAPER - MAT: SAND DOLLAR 1126 81126 - FRAME: 208710 EBONIZED WALNUT 3/4"
19866	1	ART - GLOBAL CREATIVE STUDIO - HERITAGE 2 - BW	SB	GC	SBXART_19866 - FRAMED WITH NO MAT - ART SIZE: 15" W X 10" H - OVERALL SIZE: 16 3/4" W X 11 3/4" H - PAPER: PREMIUM ARCHIVAL MATTE PAPER - FRAME: 20321 LIGHT OAK 7/8"
19867	1	ART - GLOBAL CREATIVE STUDIO - HERITAGE 3 - COLOR	SB	GC	SBXART_19867 - FRAME WITH NO MAT - ART SIZE: 13 1/2" W X 9" H - OVERALL SIZE: 15" W X 10 1/2" H - PAPER: PREMIUM ARCHIVAL MATTE PAPER - FRAME: 208710EBONIZED WALNUT 3/4"
19872	1	ART - GLOBAL CREATIVE STUDIO - HERITAGE 5 - BW	SB	GC	SBXART_19872 - FRAMED WITH NO MAT - ART SIZE: 18 1/2" W X 12 1/4" H - MAT 1 1/2" - OVERALL SIZE: 20 1/4" W X 14" H - PAPER: PREMIUM ARCHIVAL MATTE PAPER - FRAME: 20321 LIGHT OAK 7/8"
21503	1	ART - JORDAN KAY - PIKE PLACE VIVID	SB	GC	SBXART_21503 - FRAMED WITH NO MAT - ART SIZE: 59 7/8" W X 30 3/4" H - OVERALL SIZE: 62 1/8" W X 33" H - PAPER: PREMIUM ARCHIVAL MATTE PAPER - FRAME: 113710 EBONIZED WALNUT 1 1/8"
24441	1	ART - LILLY CHOU - SEATTLE ROASTERY - 8 - COLOR	SB	GC	SBXART_24441 - FRAME WITH NO MAT - ART SIZE: 7" 17 1/4 X 11 1/2" H - OVERALL SIZE: 18 3/4" W X 13" H - PAPER: PREMIUM ARCHIVAL MATTE PAPER - FRAME: 208710 EBONIZED WALNUT 3/4"
24680	1	ART - GABE ARMAGOST - SULAWESI BAG - NATURAL	SB	GC	SBXART_24680 - FRAME WITH NO MAT - ART SIZE: 7 1/8" W X 9" H - OVERALL SIZE: 8 7/8" W X 10 3/4" H - PAPER: PREMIUM ARCHIVAL MATE PAPER - FRAME: 20321 LIGHT OAK 7/8"
24682	1	ART - GABE ARMAGOST - PIKE PLACE SCALE - NATURAL	SB	GC	SBXART_24682 - FRAME WITH NO MAT - ART SIZE: 12 1/2" W X 16" H - OVERALL SIZE: 14 1/4" W X 17 3/4" H - PAPER: PREMIUM ARCHIVAL MATTE PAPER - FRAME: 20321 LIGHT OAK 7/8"
24687	1	ART - ELISA DORE - PIKE PLACE RELIEF	SB	GC	SBXART_24687 - WRAPPED CANVAS IN FLOAT FRAME - ART SIZE: 11 7/8" W X 9 1/2" H - OVERALL SIZE: 13 3/8" W X 11" H - PAPER: PREMIUM ARCHIVAL MATTE PAPER - FRAME: 208710 EBONIZED WALNUT 3/4"
25365	1	ART - SARA MULLEN - ORIGIN VISTA - SUMATRA	SB	GC	SBXART_25365 - WRAPPED CANVAS IN FLOAT FRAME - ART SIZE: 48 1/4" W X 48 1/4" H - OVERALL SIZE: 49" W X 49" H - CANVAS: GF 4394 ART CANVAS - FRAME: 623674 EBONIZED WALNUT FLOAT
25369	1	ART - SARA MULLEN - ORIGIN VISTA - ETHIOPIA	SB	GC	SBXART_25369 - WRAPPED CANVAS IN FLOAT FRAME - ART SIZE: 48 1/4" W X 48 1/4" H - OVERALL SIZE: 49" W X 49" H - CANVAS: GF 4394 ART CANVAS - FRAME: 623674 EBONIZED WALNUT FLOAT

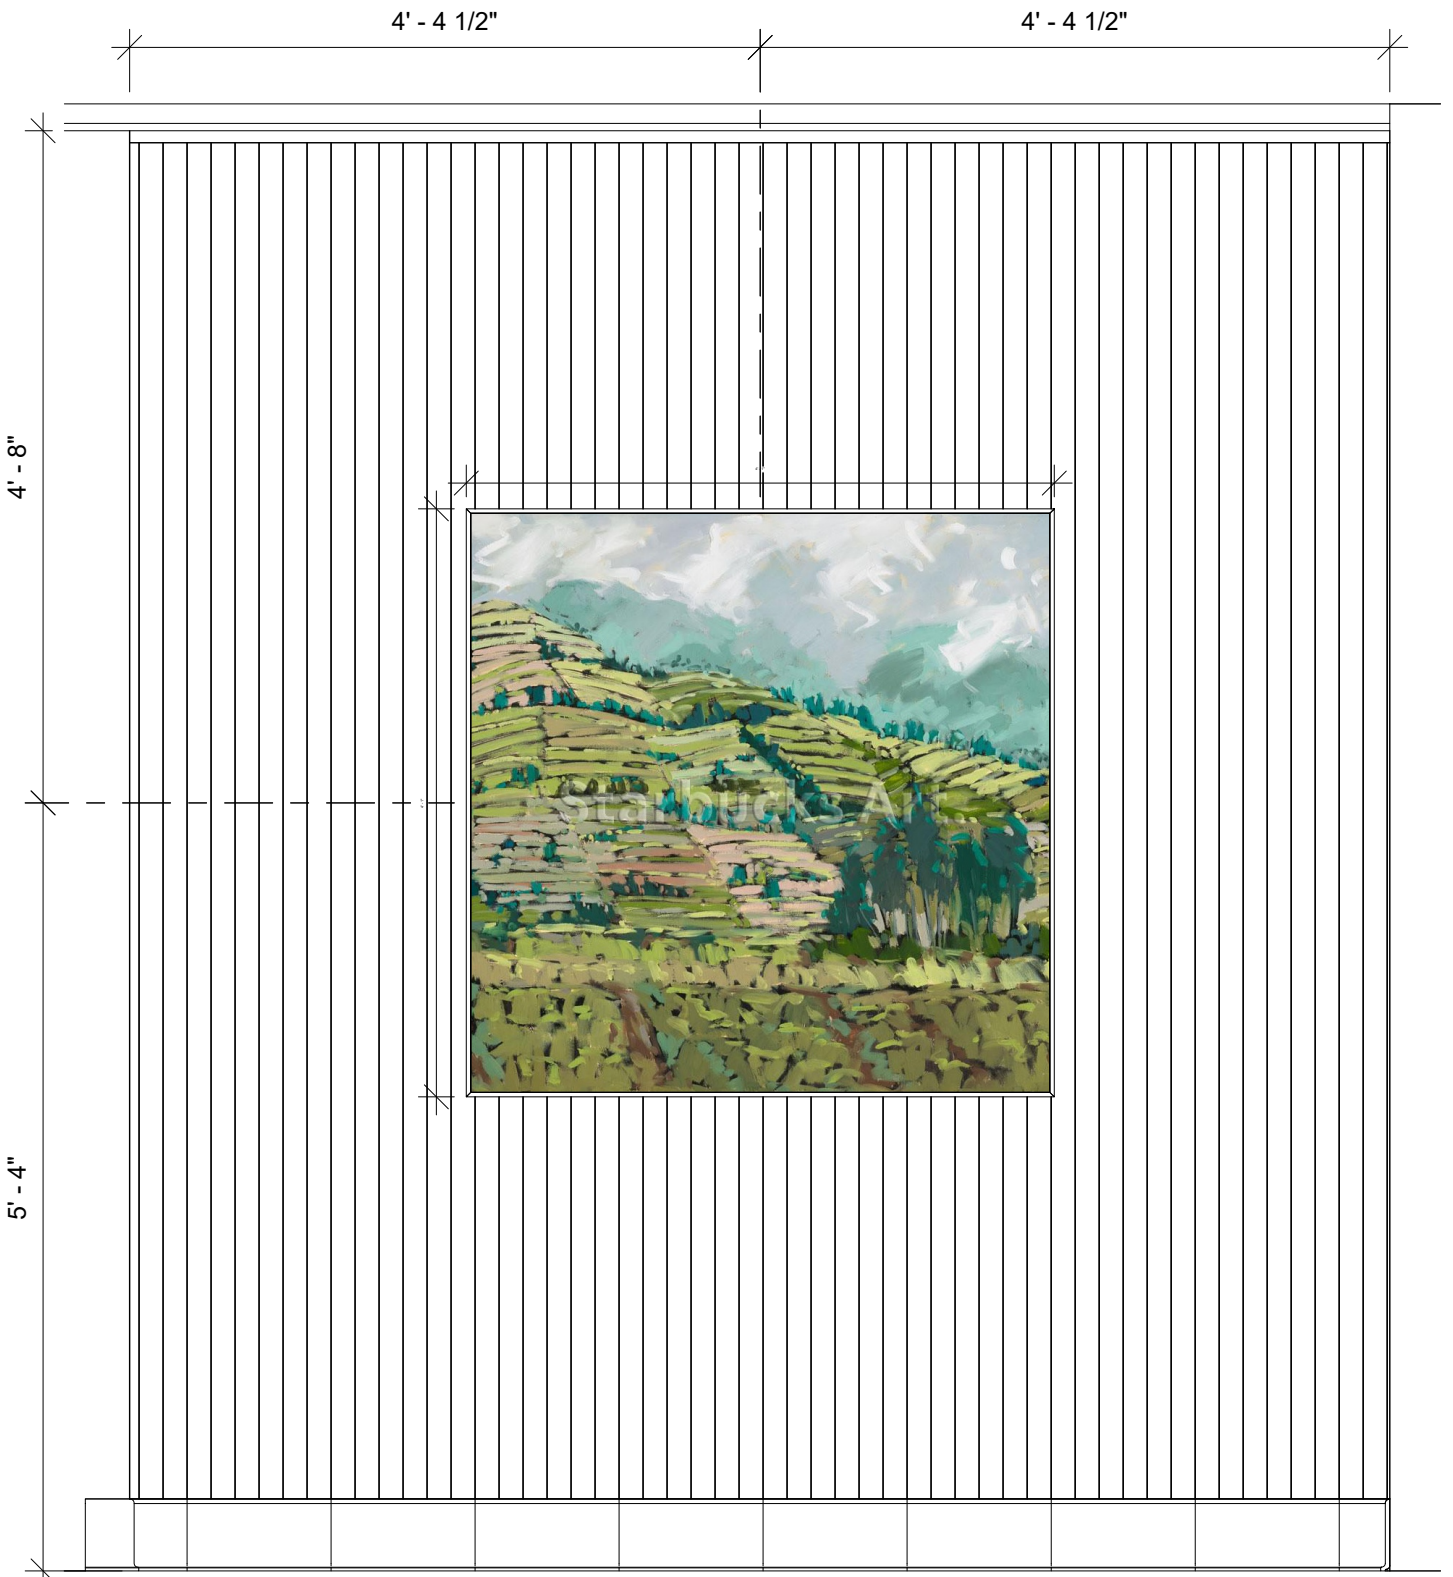

① INTERIOR ELEVATION - ART WALL - 25365


Scale: 3/4" = 1'-0"

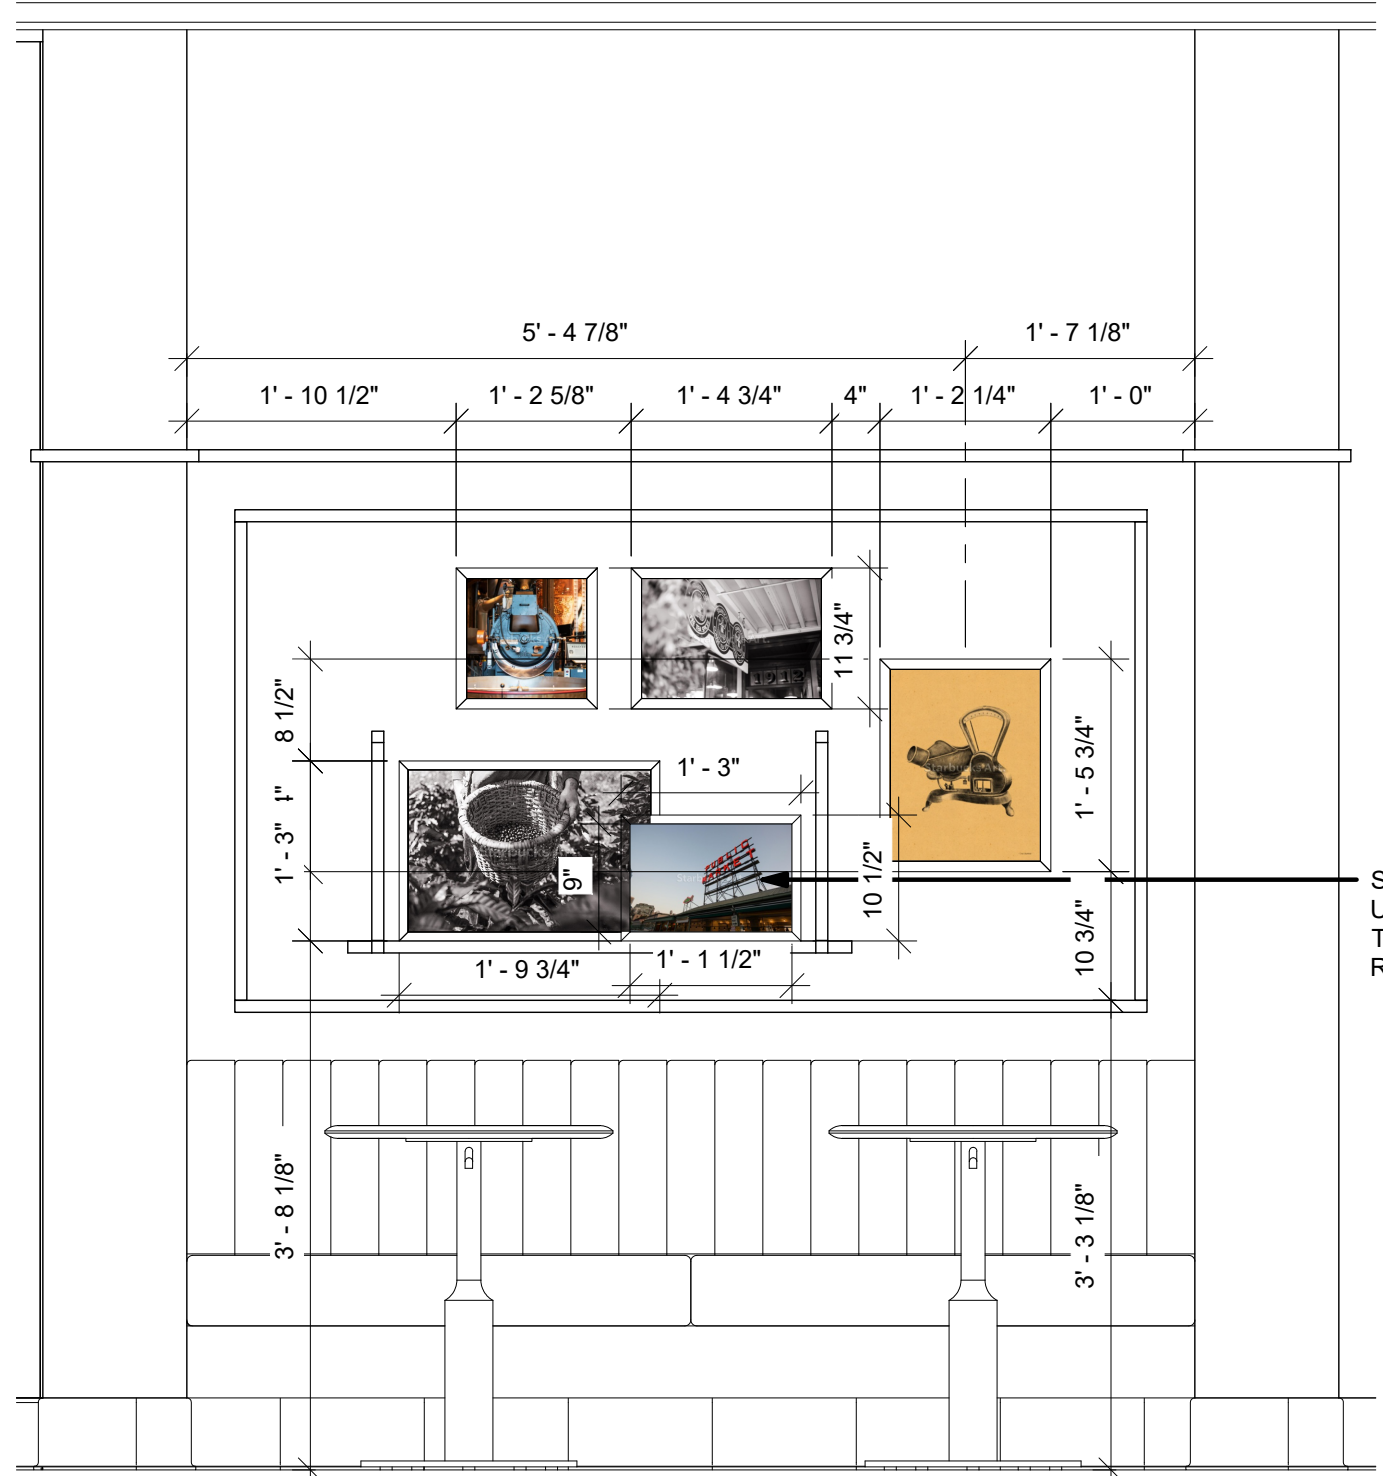

② INTERIOR ELEVATION - ART WALL - SHELVES 1

Scale: 3/4" = 1'-0"

SECURE ART FRAMES USING DOUBLE-SIDED TAPE OR VELCRO, AS REQUIRED.

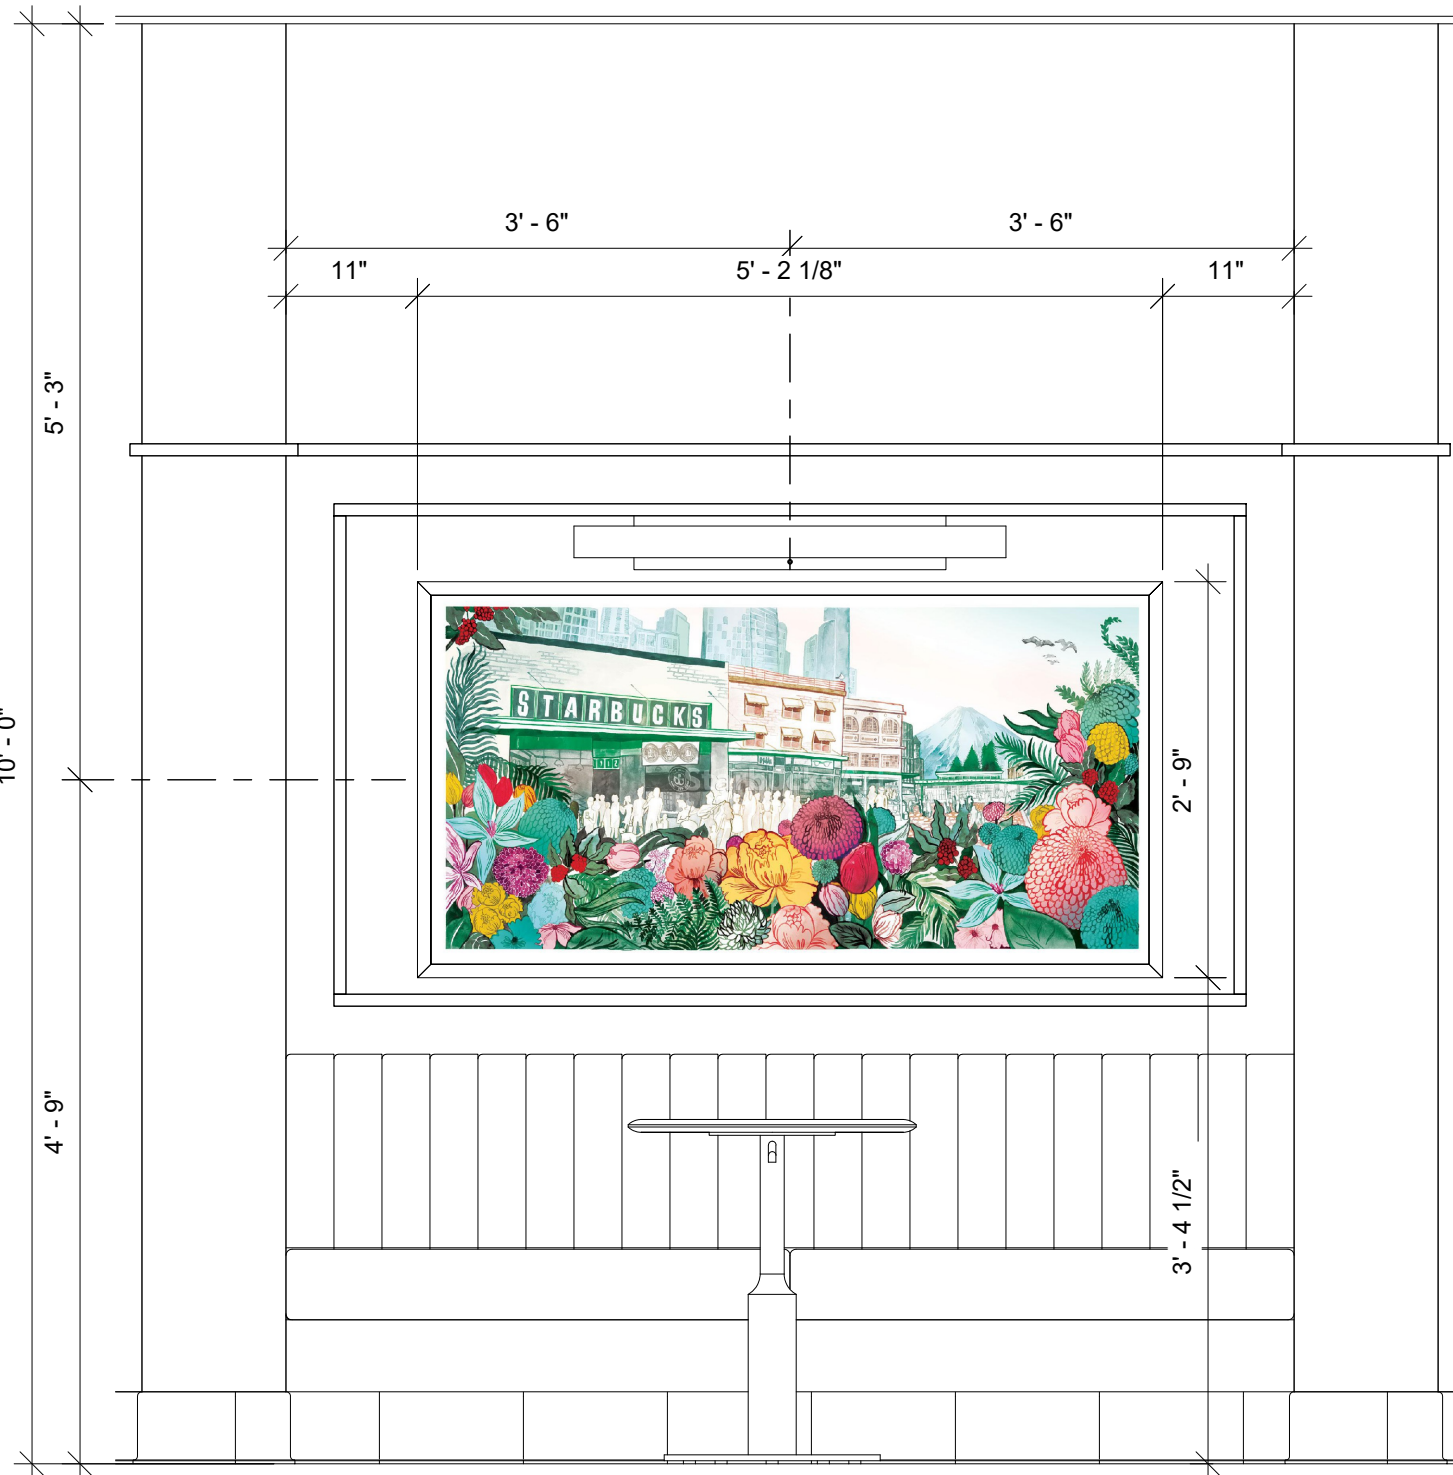

③ INTERIOR ELEVATION - ART WALL - 21503

Scale: 3/4" = 1'-0"



④ INTERIOR ELEVATION - ART WALL - SHELVES 2

Scale: 3/4" = 1'-0"

SECURE ART FRAMES USING DOUBLE-SIDED TAPE OR VELCRO, AS REQUIRED.

ARCHITECT OF RECORD:

THOMAS E. MORGAN, JR.
ARCHITECT

423 FISCHER TRAIL
ELLIJAY, GEORGIA 30540

SEAL:



MRP
DESIGN GROUP

3450 Acworth Due West Road
Building 100, Suite 120
Kennesaw, Georgia 30144
P. 770-917-9172
F. 770-917-9470
www.mrpdesign.com

RELEASED FOR
CONSTRUCTION

ISSUES / REVISIONS:

DATE	DESCRIPTION
05.04.26	RELEASE FOR CONSTRUCTION

DRAWN BY: JB

CHKD BY: TM

PROJECT DESCRIPTION:

NEW CONSTRUCTION OF A TA
TRAVEL CENTER IN
JEFFERSONVILLE, GA. WHICH
CONSISTS OF A TRUCKER
LOUNGE, SHOWERS, LAUNDRY
ROOM, RETAIL AREA,
RESTROOMS, GAME AREA,
SEATING AREAS, AND FOUR
QUICK-SERVICE RESTAURANTS.
THE MAJORITY OF THE
PROJECT HAS ALREADY BEEN
SUBMITTED. THIS ISSUE, DATED
05.04.26 HAS MODIFICATIONS
RELATED TO THE ADDITION OF
THE STARBUCKS QSR.

PROJECT TITLE:

TRAVEL CENTER
4838 SR 96
JEFFERSONVILLE,
GEORGIA 31044

SHEET TITLE:

CASEWORK
DETAILS


PROJECT NO: 25021

1508


FOR REFERENCE ONLY

THESE PLANS ARE THE PROPERTY OF MRP DESIGN GROUP, INC. AND ARE SUBJECT TO FEDERAL COPYRIGHT LAWS. ANY USE OF SAME WITHOUT THE EXPRESS WRITTEN PERMISSION OF MRP DESIGN GROUP, INC. IS STRICTLY PROHIBITED

GRAPHICS AND ARTWORK SCHEDULE - "G"					
DESIGN ID	COUNT	DESCRIPTION	FURN. BY	INST. BY	COMMENTS
GRAPHICS					
16884	1	ART - UNKNOWN ARTIST - COOLING AND SCOOPING	SB	GC	SBXART_16884 - FRAME WITH NO MAT - ART SIZE: 14 7/8" W X 10 1/2" H - OVERALL SIZE: 16 3/8" W X 12" H - PAPER: PREMIUM ARCHIVAL MATTE PAPER - FRAME: 208710 EBONIZED WALNUT 3/4"
17199	1	ART - YOUNG LEE - STARBUCKS SIGN	SB	GC	SBXART_17199 - FRAMED & MATTED - ART SIZE: 11" W X 6 1/2" H - MAT BORDER: 2" - OVERALL SIZE: 16 1/2" W X 12" H - PAPER: PREMIUM ARCHIVAL MATTE PAPER - MAT: SAND DOLLAR 1126 81126 - FRAME: 208710 EBONIZED WALNUT 3/4"
17217	1	ART - UNKNOWN ARTIST - PIKE PLACE MARKET SIGN	SB	GC	SBXART_17217 - FRAME WITH NO MAT - ART SIZE: 15 1/2" W X 15 1/2" H - OVERALL SIZE: 17" W X 17" H - PAPER: PREMIUM ARCHIVAL MATTE PAPER - FRAME: 208710 EBONIZED WALNUT 3/4"
19186	1	ART - GLOBAL CREATIVE STUDIO - HACIENDA ALSACIA 8 - BW	SB	GC	SBXART_19186 - FRAME WITH NO MAT - ART SIZE: 20 1/4" W X 13 1/2" H - OVERALL SIZE: 21 3/4" W X 15" H - PAPER: PREMIUM ARCHIVAL MATTE PAPER - FRAME: 208710 EBONIZED WALNUT 3/4"
19815	1	ART - GLOBAL CREATIVE STUDIO - ROASTERY 1 - COLOR	SB	GC	SBXART_19815 - FRAME WITH NO MAT - ART SIZE: 10" W X 10" H - OVERALL SIZE: 11 3/4" W X 11 3/4" H - PAPER: PREMIUM ARCHIVAL MATTE PAPER - FRAME: 20321 LIGHT OAK 7/8"
19819	1	ART - GLOBAL CREATIVE STUDIO - ROASTERY 3 - COLOR	SB	GC	SBXART_19819 - FRAME WITH NO MAT - ART SIZE: 28 7/8" W X 19 1/4" H - OVERALL SIZE: 30 5/8" W X 21" H - PAPER: PREMIUM ARCHIVAL MATTE PAPER - FRAME: 20321 LIGHT OAK 7/8"
19863	1	ART - GLOBAL CREATIVE STUDIO - HERITAGE 1 - COLOR	SB	GC	SBXART_19863 - FRAMED & MATTED - ART SIZE: 13 1/2" W X 9" H - MAT: 3" - OVERALL SIZE: 21" W X 16 1/2" H - PAPER: PREMIUM ARCHIVAL MATTE PAPER - MAT: SAND DOLLAR 1126 81126 - FRAME: 208710 EBONIZED WALNUT 3/4"
19866	1	ART - GLOBAL CREATIVE STUDIO - HERITAGE 2 - BW	SB	GC	SBXART_19866 - FRAMED WITH NO MAT - ART SIZE: 15" W X 10" H - OVERALL SIZE: 16 3/4" W X 11 3/4" H - PAPER: PREMIUM ARCHIVAL MATTE PAPER - FRAME: 20321 LIGHT OAK 7/8"
19867	1	ART - GLOBAL CREATIVE STUDIO - HERITAGE 3 - COLOR	SB	GC	SBXART_19867 - FRAME WITH NO MAT - ART SIZE: 13 1/2" W X 9" H - OVERALL SIZE: 15" W X 10 1/2" H - PAPER: PREMIUM ARCHIVAL MATTE PAPER - FRAME: 208710EBONIZED WALNUT 3/4"
19872	1	ART - GLOBAL CREATIVE STUDIO - HERITAGE 5 - BW	SB	GC	SBXART_19872 - FRAMED WITH NO MAT - ART SIZE: 18 1/2" W X 12 1/4" H - MAT 1 1/2" - OVERALL SIZE: 20 1/4" W X 14" H - PAPER: PREMIUM ARCHIVAL MATTE PAPAR - FRAME: 20321 LIGHT OAK 7/8"
21503	1	ART - JORDAN KAY - PIKE PLACE VIVID	SB	GC	SBXART_21503 - FRAMED WITH NO MAT - ART SIZE: 59 7/8" W X 30 3/4" H - OVERALL SIZE: 62 1/8" W X 33" H - PAPER: PREMIUM ARCHIVAL MATTE PAPEL - FRAME: 313710 EBONIZED WALNUT 1 1/8"
24441	1	ART - LILLY CHOU - SEATTLE ROASTERY - 8 - COLOR	SB	GC	SBXART_24441 - FRAME WITH NO MAT - ART SIZE: 7" 17 1/4 X 11 1/2" H - OVERALL SIZE: 18 3/4" W X 13" H - PAPER: PREMIUM ARCHIVAL MATTE PAPER - FRAME: 208710 EBONIZED WALNUT 3/4"
24680	1	ART - GABE ARMAGOST - SULAWESI BAG - NATURAL	SB	GC	SBXART_24680 - FRAME WITH NO MAT - ART SIZE: 7 1/8" W X 9" H - OVERALL SIZE: 8 7/8" W X 10 3/4" H - PAPER: PREMIUM ARCHIVAL MATE PAPER - FRAME: 20321 LIGHT OAK 7/8"
24682	1	ART - GABE ARMAGOST - PIKE PLACE SCALE - NATURAL	SB	GC	SBXART_24682 - FRAME WITH NO MAT - ART SIZE: 12 1/2" W X 16" H - OVERALL SIZE: 14 1/4" W X 17 3/4" H - PAPER: PREMIUM ARCHIVAL MATTE PAPER - FRAME: 20321 LIGHT OAK 7/8"
24687	1	ART - ELISA DORE - PIKE PLACE RELIEF	SB	GC	SBXART_24687 - WRAPPED CANVAS IN FLOAT FRAME - ART SIZE: 11 7/8" W X 9 1/2" H - OVERALL SIZE: 13 3/8" W X 11" H - PAPER: PREMIUM ARCHIVAL MATTE PAPER - FRAME: 208710 EBONIZED WALNUT 3/4"
25365	1	ART - SARA MULLEN - ORIGIN VISTA - SUMATRA	SB	GC	SBXART_25365 - WRAPPED CANVAS IN FLOAT FRAME - ART SIZE: 48 1/4" W X 48 1/4" H - OVERALL SIZE: 49" W X 49" H - CANVAS: GF 4394 ART CANVAS - FRAME: 623674 EBONIZED WALNUT FLOAT
25369	1	ART - SARA MULLEN - ORIGIN VISTA - ETHIOPIA	SB	GC	SBXART_25369 - WRAPPED CANVAS IN FLOAT FRAME - ART SIZE: 48 1/4" W X 48 1/4" H - OVERALL SIZE: 49" W X 49" H - CANVAS: GF 4394 ART CANVAS - FRAME: 623674 EBONIZED WALNUT FLOAT

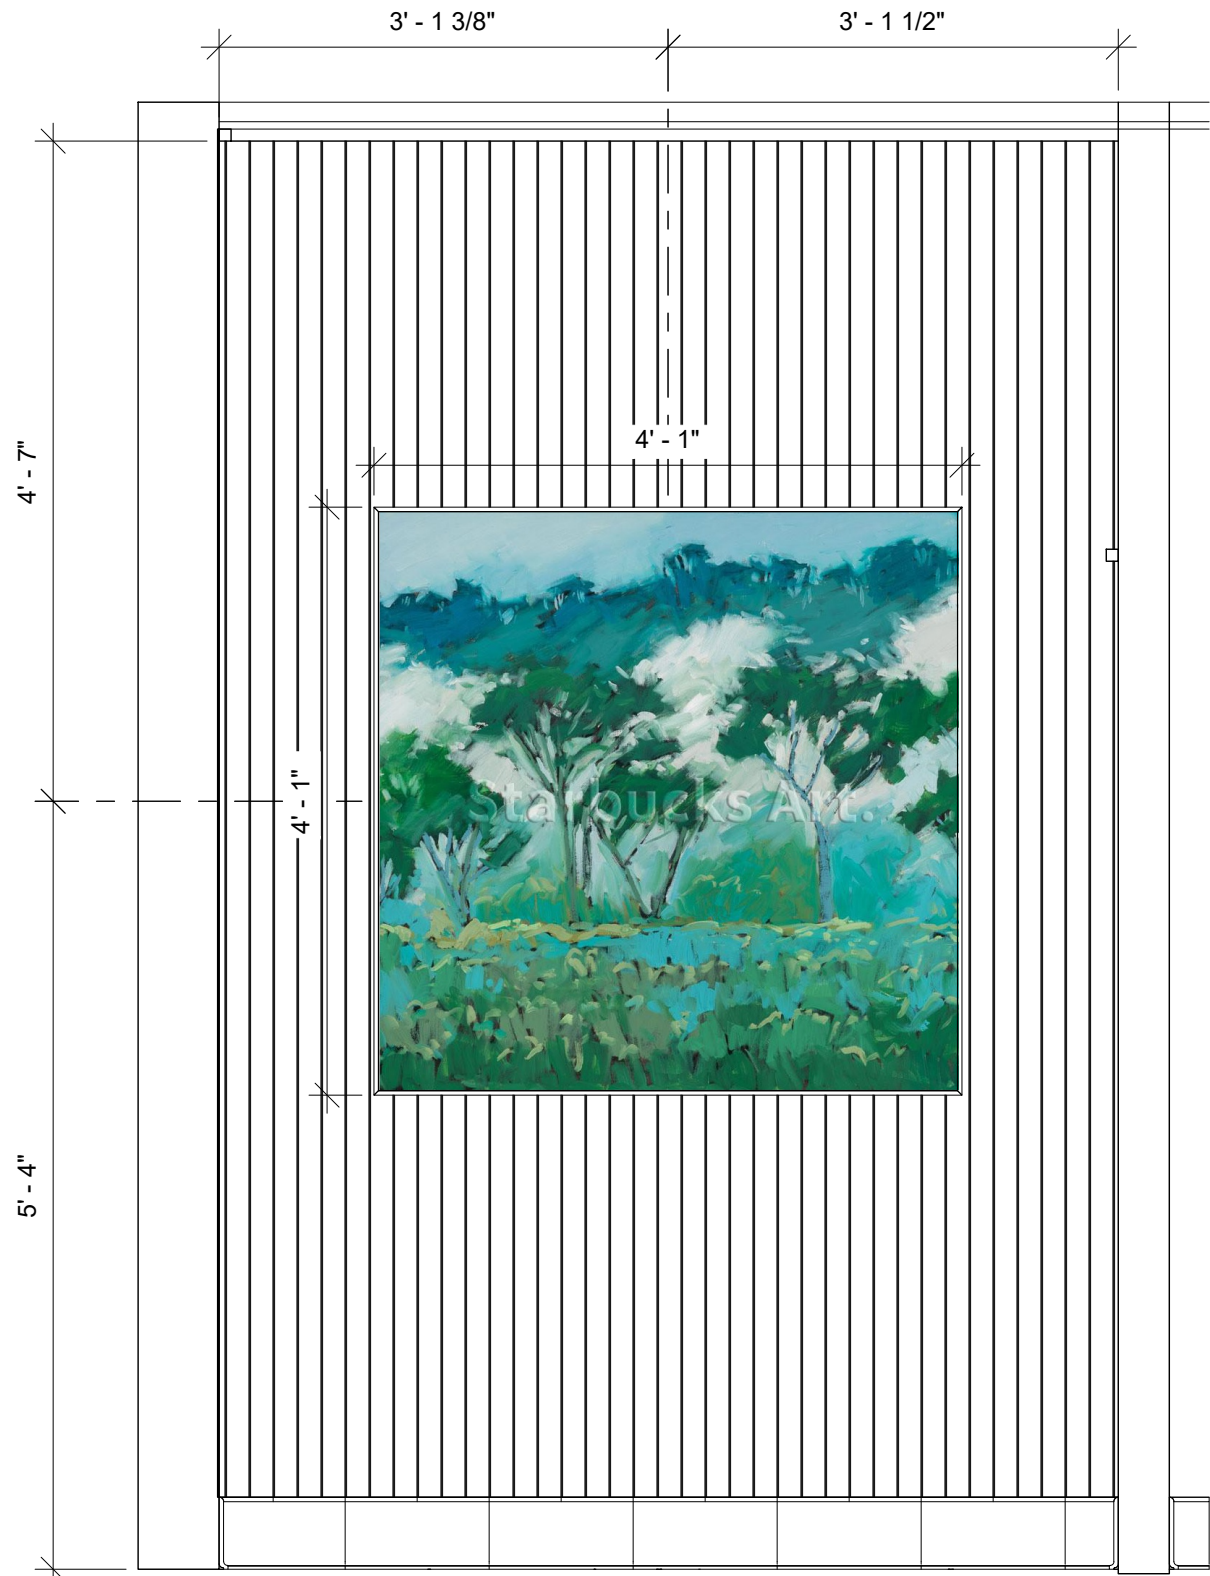

① INTERIOR ELEVATION - AR WALL - 25369
Scale: 3/4" = 1'-0"

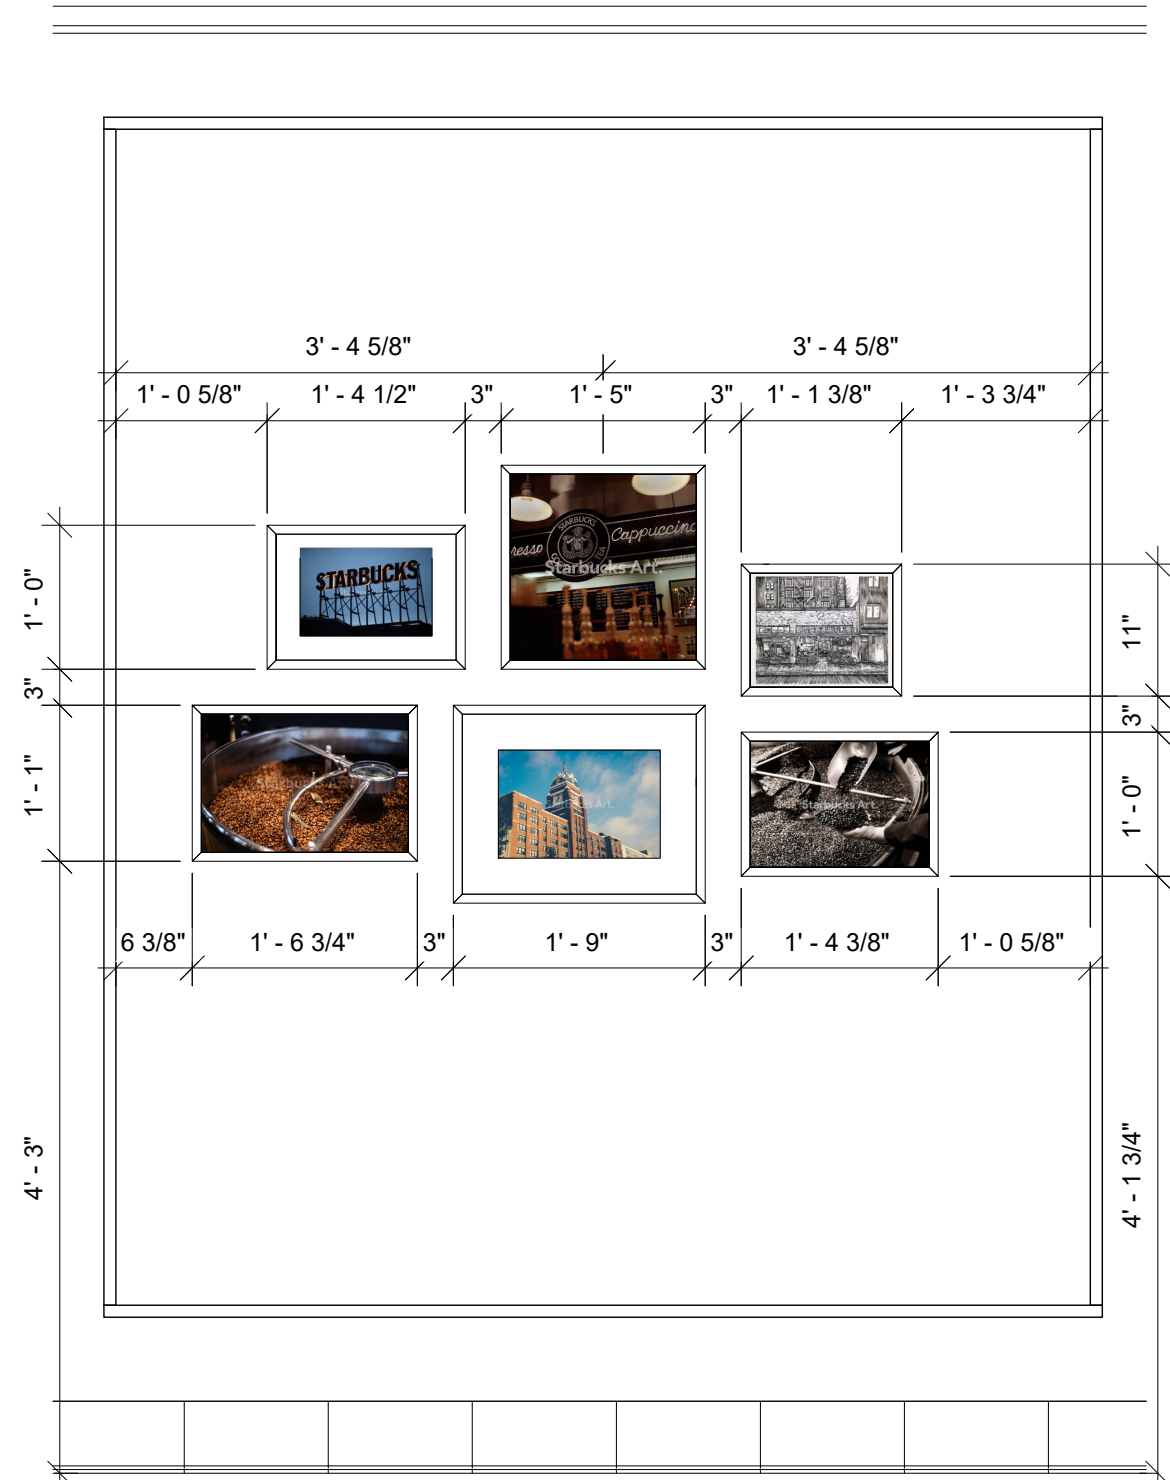

② INTERIOR ELEVATION - ART WALL - GALLERY
Scale: 3/4" = 1'-0"


FOR REFERENCE ONLY

ARCHITECT OF RECORD:

THOMAS E. MORGAN, JR.
ARCHITECT

423 FISCHER TRAIL
ELLIJAY, GEORGIA 30540

SEAL:

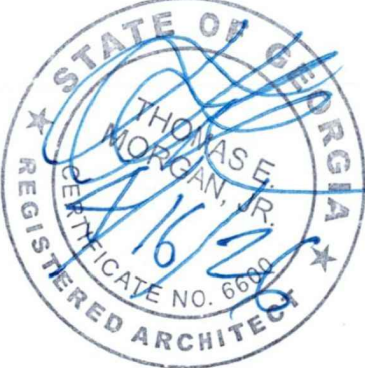

MRP
DESIGN GROUP

3450 Acworth Due West Road
Building 100, Suite 120
Kennesaw, Georgia 30144
P. 770-917-9172
F. 770-917-9470
www.mrpdesign.com

RELEASED FOR
CONSTRUCTION

ISSUES / REVISIONS:	
DATE	DESCRIPTION
05.04.26	RELEASE FOR CONSTRUCTION

DRAWN BY: JB
CHKD BY: TM

PROJECT DESCRIPTION:
NEW CONSTRUCTION OF A TA TRAVEL CENTER IN JEFFERSONVILLE, GA, WHICH CONSISTS OF A TRUCKER LOUNGE, SHOWERS, LAUNDRY ROOM, RETAIL AREA, RESTROOMS, GAME AREA, SEATING AREAS, AND FOUR QUICK-SERVICE RESTAURANTS. THE MAJORITY OF THE PROJECT HAS ALREADY BEEN SUBMITTED. THIS ISSUE, DATED 05.04.26 HAS MODIFICATIONS RELATED TO THE ADDITION OF THE STARBUCKS QSR.

PROJECT TITLE:

TRAVEL CENTER
4838 SR 96
JEFFERSONVILLE,
GEORGIA 31044


SHEET TITLE:

DESIGN
DETAIL -
ARTWORK

PROJECT NO: 25021


1509

THESE PLANS ARE THE PROPERTY OF MRP DESIGN GROUP, INC. AND ARE SUBJECT TO FEDERAL COPYRIGHT LAWS. ANY USE OF SAME WITHOUT THE EXPRESS WRITTEN PERMISSION OF MRP DESIGN GROUP, INC. IS STRICTLY PROHIBITED.

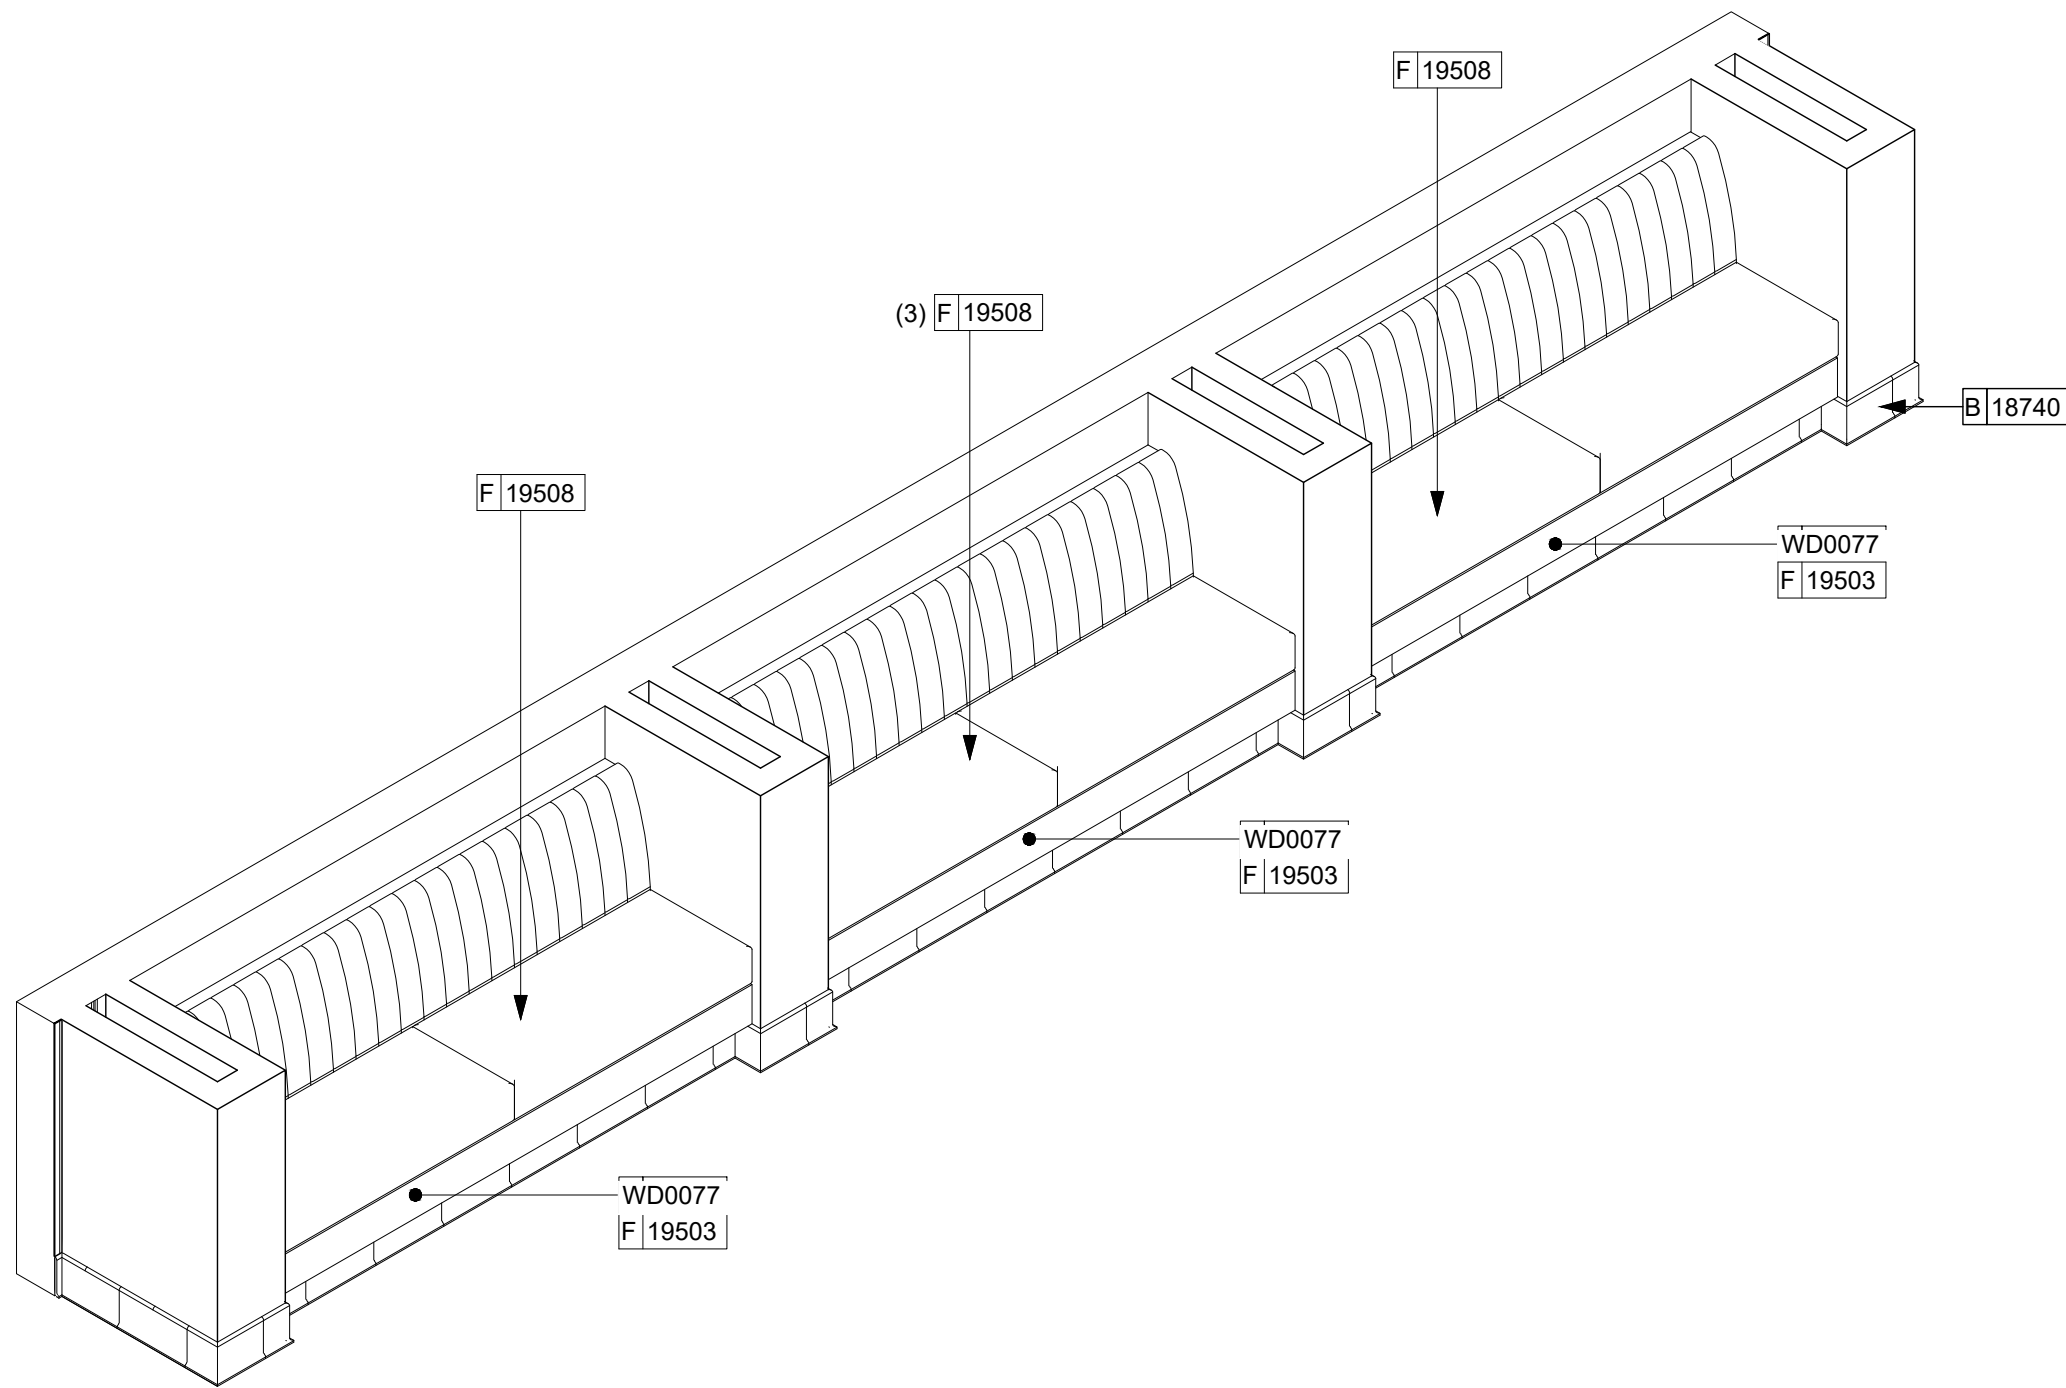


01 BANQUETTE 3D VIEW
Scale:


BANQUETTE SCHEDULE					
DESIGN ID	COUNT	DESCRIPTION	FURN. BY	INST. BY	COMMENTS
BANQUETTE					
19503	3	BANQUETTE - CLOSTER BASE - WALNUT WD0077	SB	GC	
19508	3	BANQUETTE - CLOSTER CUSHION VERTICAL STITCH - CARAMEL BROWN NATURAL F0008	SB	GC	

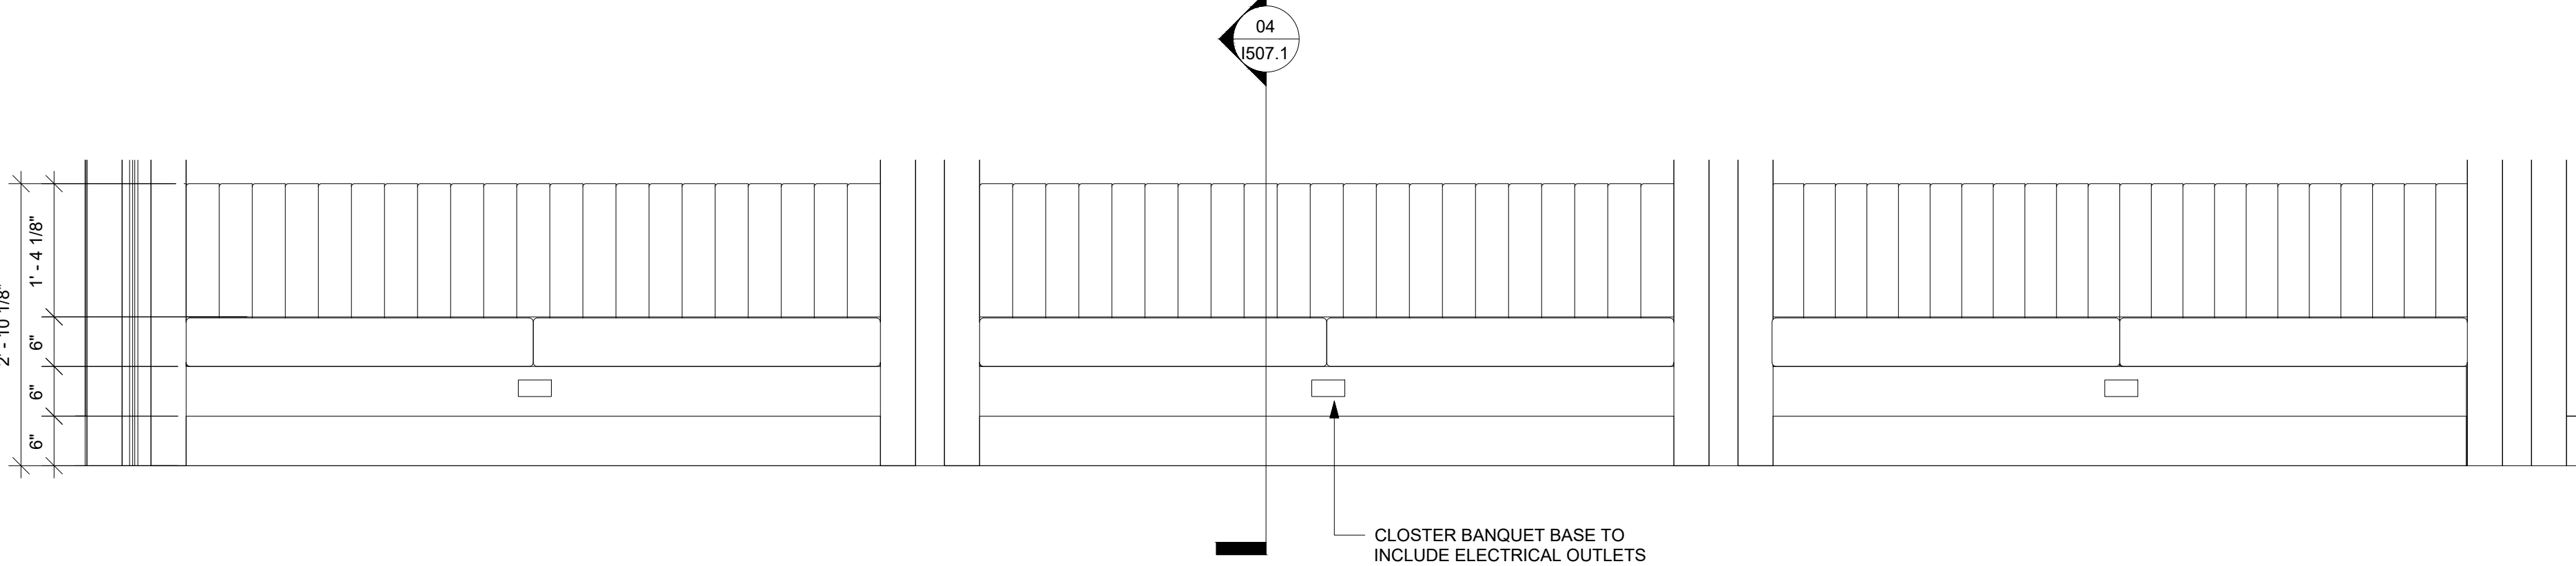

02 BANQUETTE - FRONT ELEVATION
Scale: 3/4" = 1'-0"

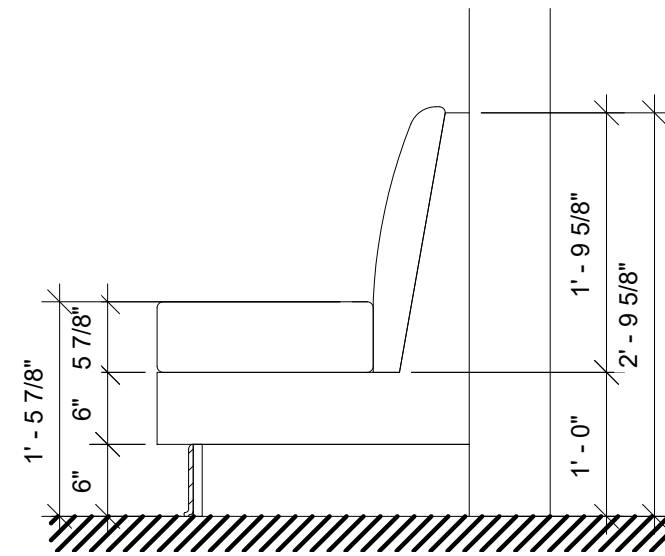

04 BANQUETTE SECTION
Scale: 3/4" = 1'-0"

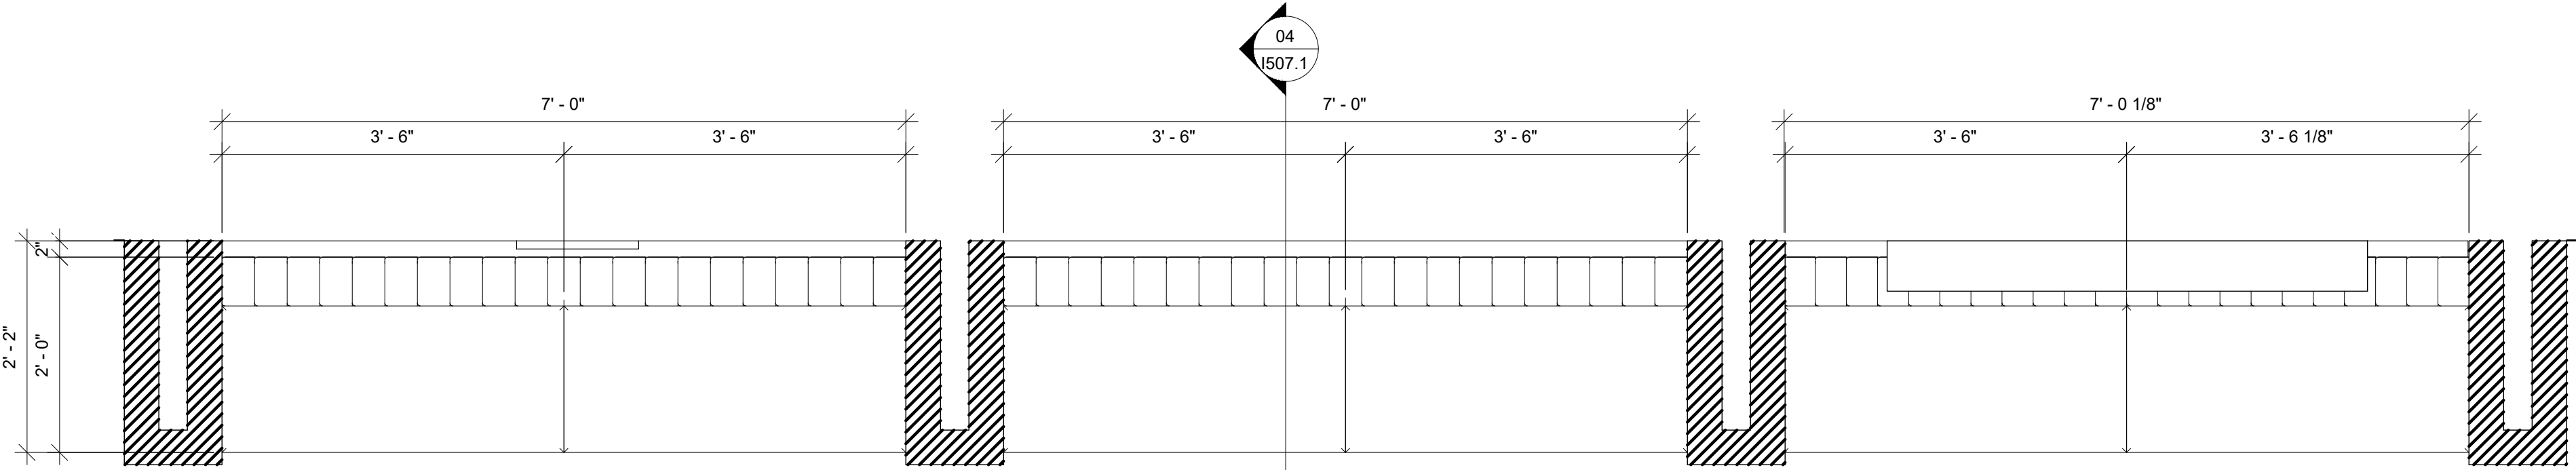


03 BANQUETTE -PLAN
Scale: 3/4" = 1'-0"

ARCHITECT OF RECORD:

THOMAS E. MORGAN, JR.
ARCHITECT

423 FISCHER TRAIL
ELLIJAY, GEORGIA 30540

SEAL:

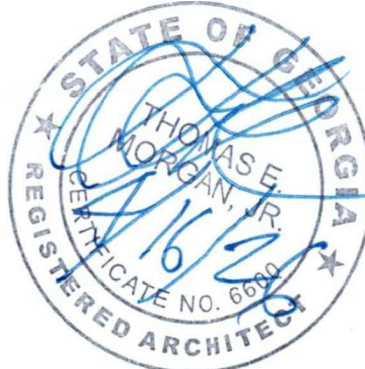

MRP
DESIGN GROUP

3450 Acworth Due West Road
Building 100, Suite 120
Kennesaw, Georgia 30144
P. 770-917-9172
F. 770-917-9470
www.mrpdesign.com

RELEASED FOR
CONSTRUCTION

ISSUES / REVISIONS:

DATE	DESCRIPTION
05.04.26	RELEASE FOR CONSTRUCTION

DRAWN BY: JB

CHKD BY: TM

PROJECT DESCRIPTION:

NEW CONSTRUCTION OF A TA
TRAVEL CENTER IN
JEFFERSONVILLE, GA. WHICH
CONSISTS OF A TRUCKER
LOUNGE, SHOWERS, LAUNDRY
ROOM, RETAIL AREA,
RESTROOMS, GAME AREA,
SEATING AREAS, AND FOUR
QUICK-SERVICE RESTAURANTS.
THE MAJORITY OF THE
PROJECT HAS ALREADY BEEN
SUBMITTED. THIS ISSUE, DATED
05.04.26 HAS MODIFICATIONS
RELATED TO THE ADDITION OF
THE STARBUCKS QSR.

PROJECT TITLE:

TRAVEL CENTER
4838 SR 96
JEFFERSONVILLE,
GEORGIA 31044

SHEET TITLE:


CASEWORK
DETAILS

PROJECT NO: 25021


1507.1

FOR REFERENCE ONLY


THESE PLANS ARE THE PROPERTY OF MRP DESIGN GROUP, INC. AND ARE SUBJECT TO FEDERAL COPYRIGHT LAWS. ANY USE OF SAME WITHOUT THE EXPRESS WRITTEN PERMISSION OF MRP DESIGN GROUP, INC. IS STRICTLY PROHIBITED.

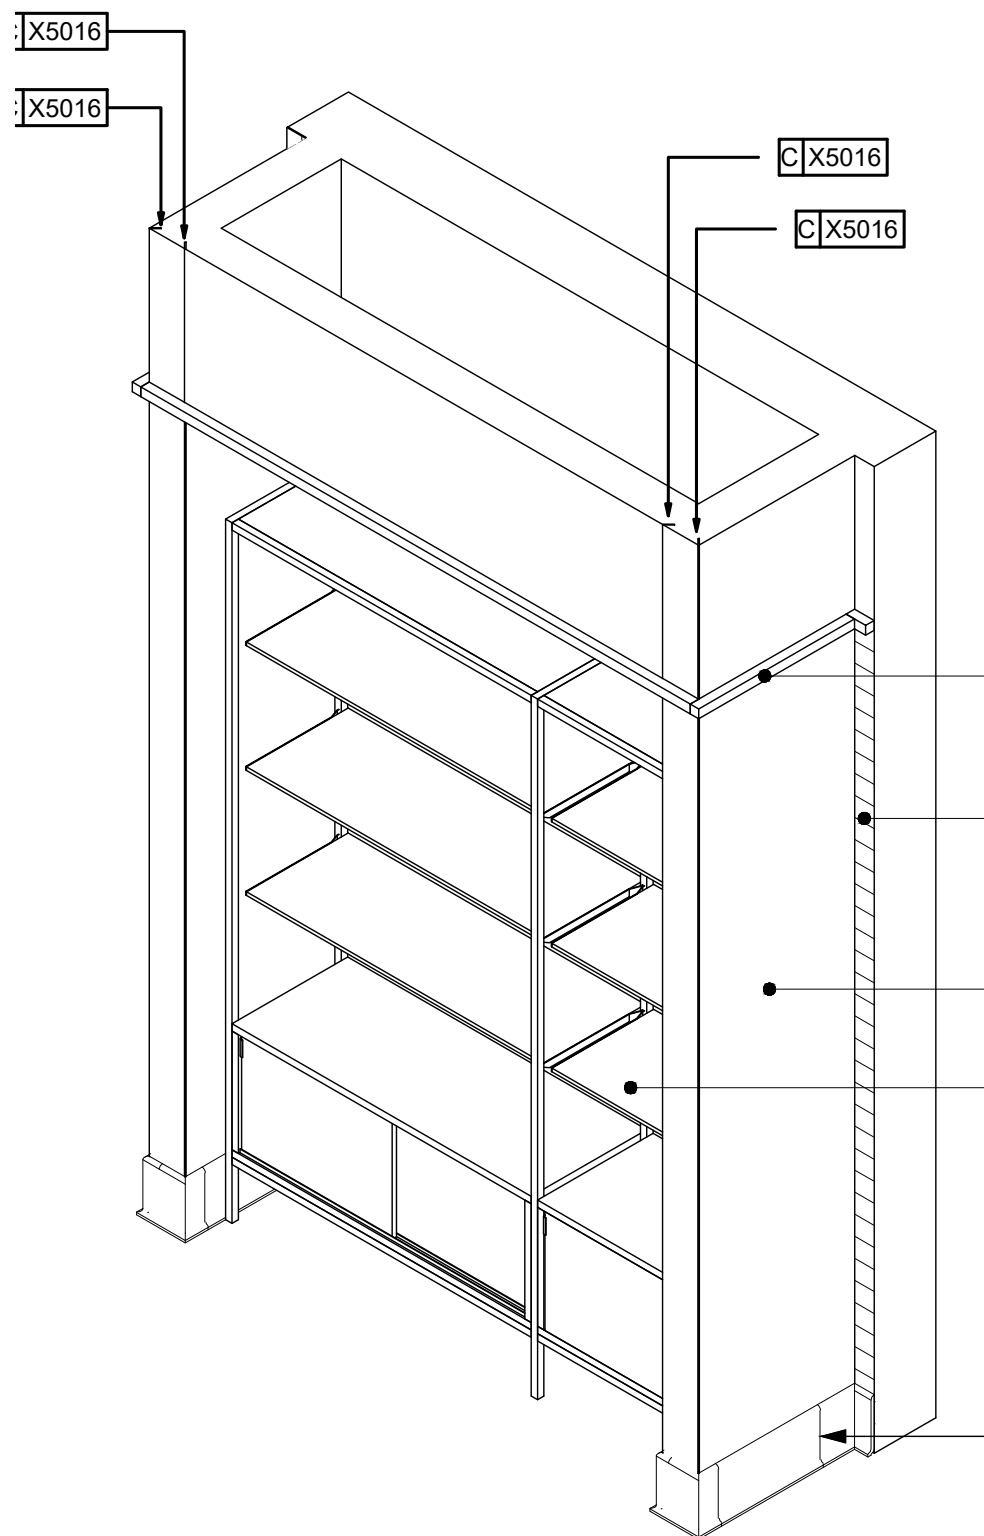

01 CASEWORK DETAIL - MERCH 3D VIEW
Scale:

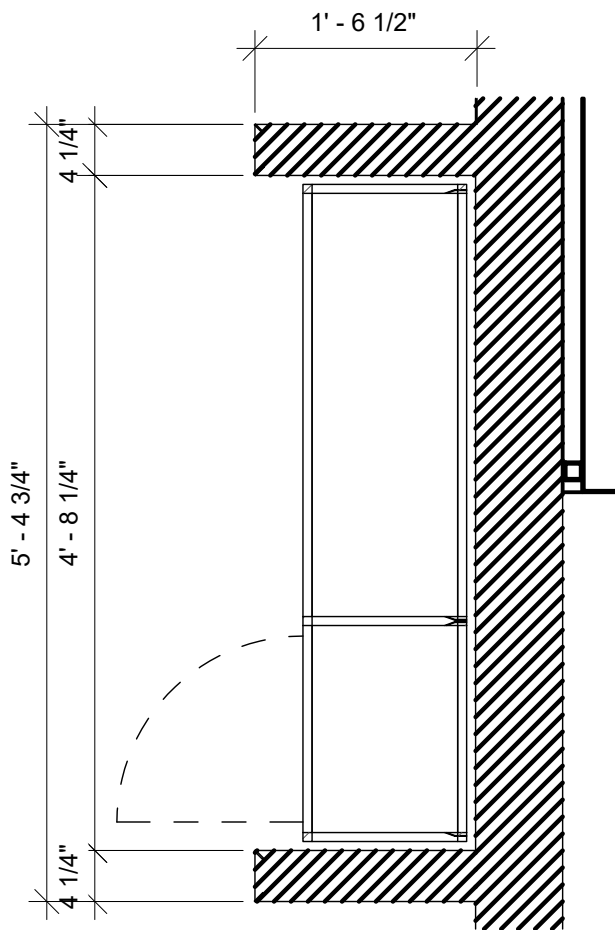

02 CASEWORK DETAIL PLAN - MERCH
Scale: 3/4" = 1'-0"

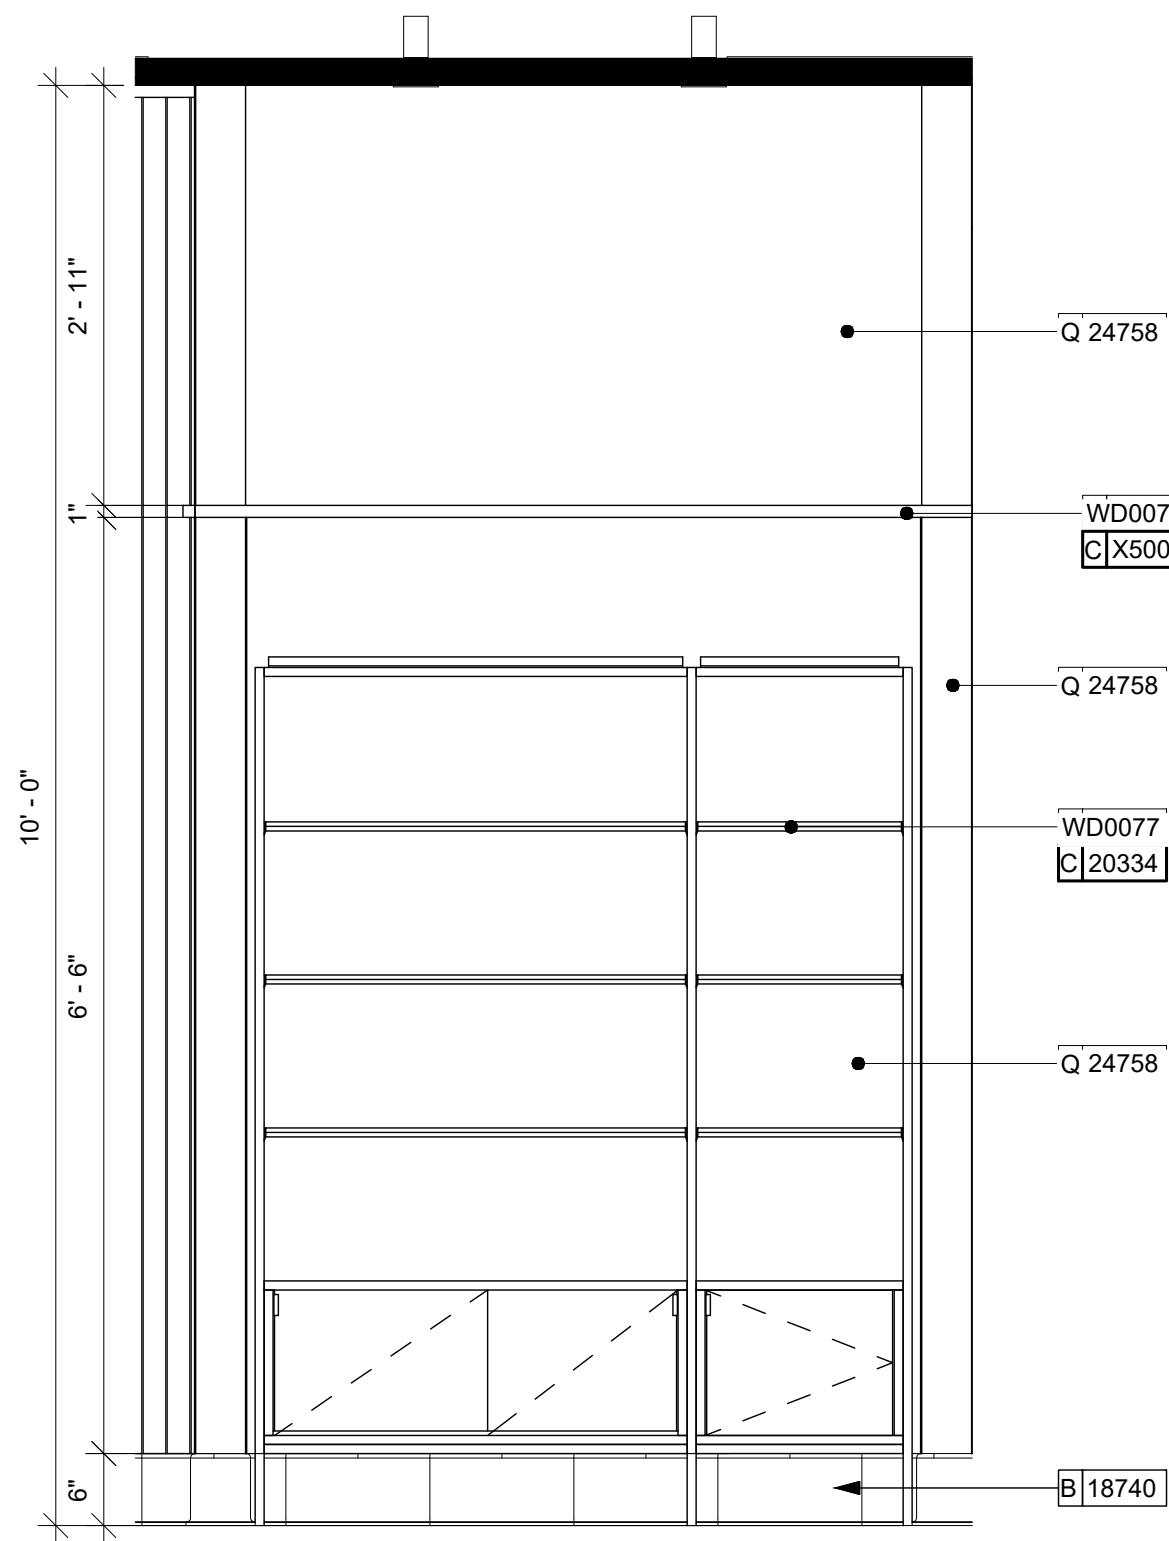


03 INTERIOR ELEVATION - MERCH
Scale: 3/4" = 1'-0"

ARCHITECT OF RECORD:

THOMAS E. MORGAN, JR.
ARCHITECT

423 FISCHER TRAIL
ELLIJAY, GEORGIA 30540

SEAL:

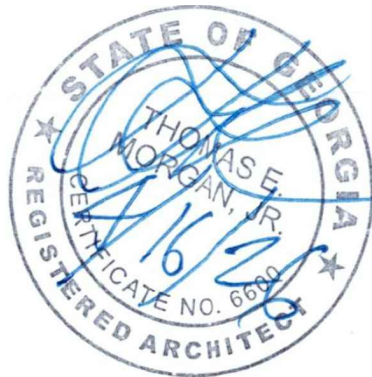

MRP
DESIGN GROUP

3450 Acworth Due West Road
Building 100, Suite 120
Kennesaw, Georgia 30144
P. 770-917-9172
F. 770-917-9470
www.mrpdesign.com

RELEASED FOR
CONSTRUCTION

ISSUES / REVISIONS:

DATE	DESCRIPTION
05.04.26	RELEASE FOR CONSTRUCTION

DRAWN BY: JB

CHKD BY: TM

PROJECT DESCRIPTION:

NEW CONSTRUCTION OF A TA
TRAVEL CENTER IN
JEFFERSONVILLE, GA. WHICH
CONSISTS OF A TRUCKER
LOUNGE, SHOWERS, LAUNDRY
ROOM, RETAIL AREA,
RESTROOMS, GAME AREA,
SEATING AREAS, AND FOUR
QUICK-SERVICE RESTAURANTS.
THE MAJORITY OF THE
PROJECT HAS ALREADY BEEN
SUBMITTED. THIS ISSUE, DATED
05.04.26 HAS MODIFICATIONS
RELATED TO THE ADDITION OF
THE STARBUCKS QSR.

PROJECT TITLE:

TRAVEL CENTER
4838 SR 96
JEFFERSONVILLE,
GEORGIA 31044

SHEET TITLE:


CASEWORK
DETAILS

PROJECT NO: 25021


1507.2

FOR REFERENCE ONLY


THESE PLANS ARE THE PROPERTY OF MRP DESIGN GROUP, INC. AND ARE SUBJECT TO FEDERAL COPYRIGHT LAWS. ANY USE OF SAME WITHOUT THE EXPRESS WRITTEN PERMISSION OF MRP DESIGN GROUP, INC. IS STRICTLY PROHIBITED.

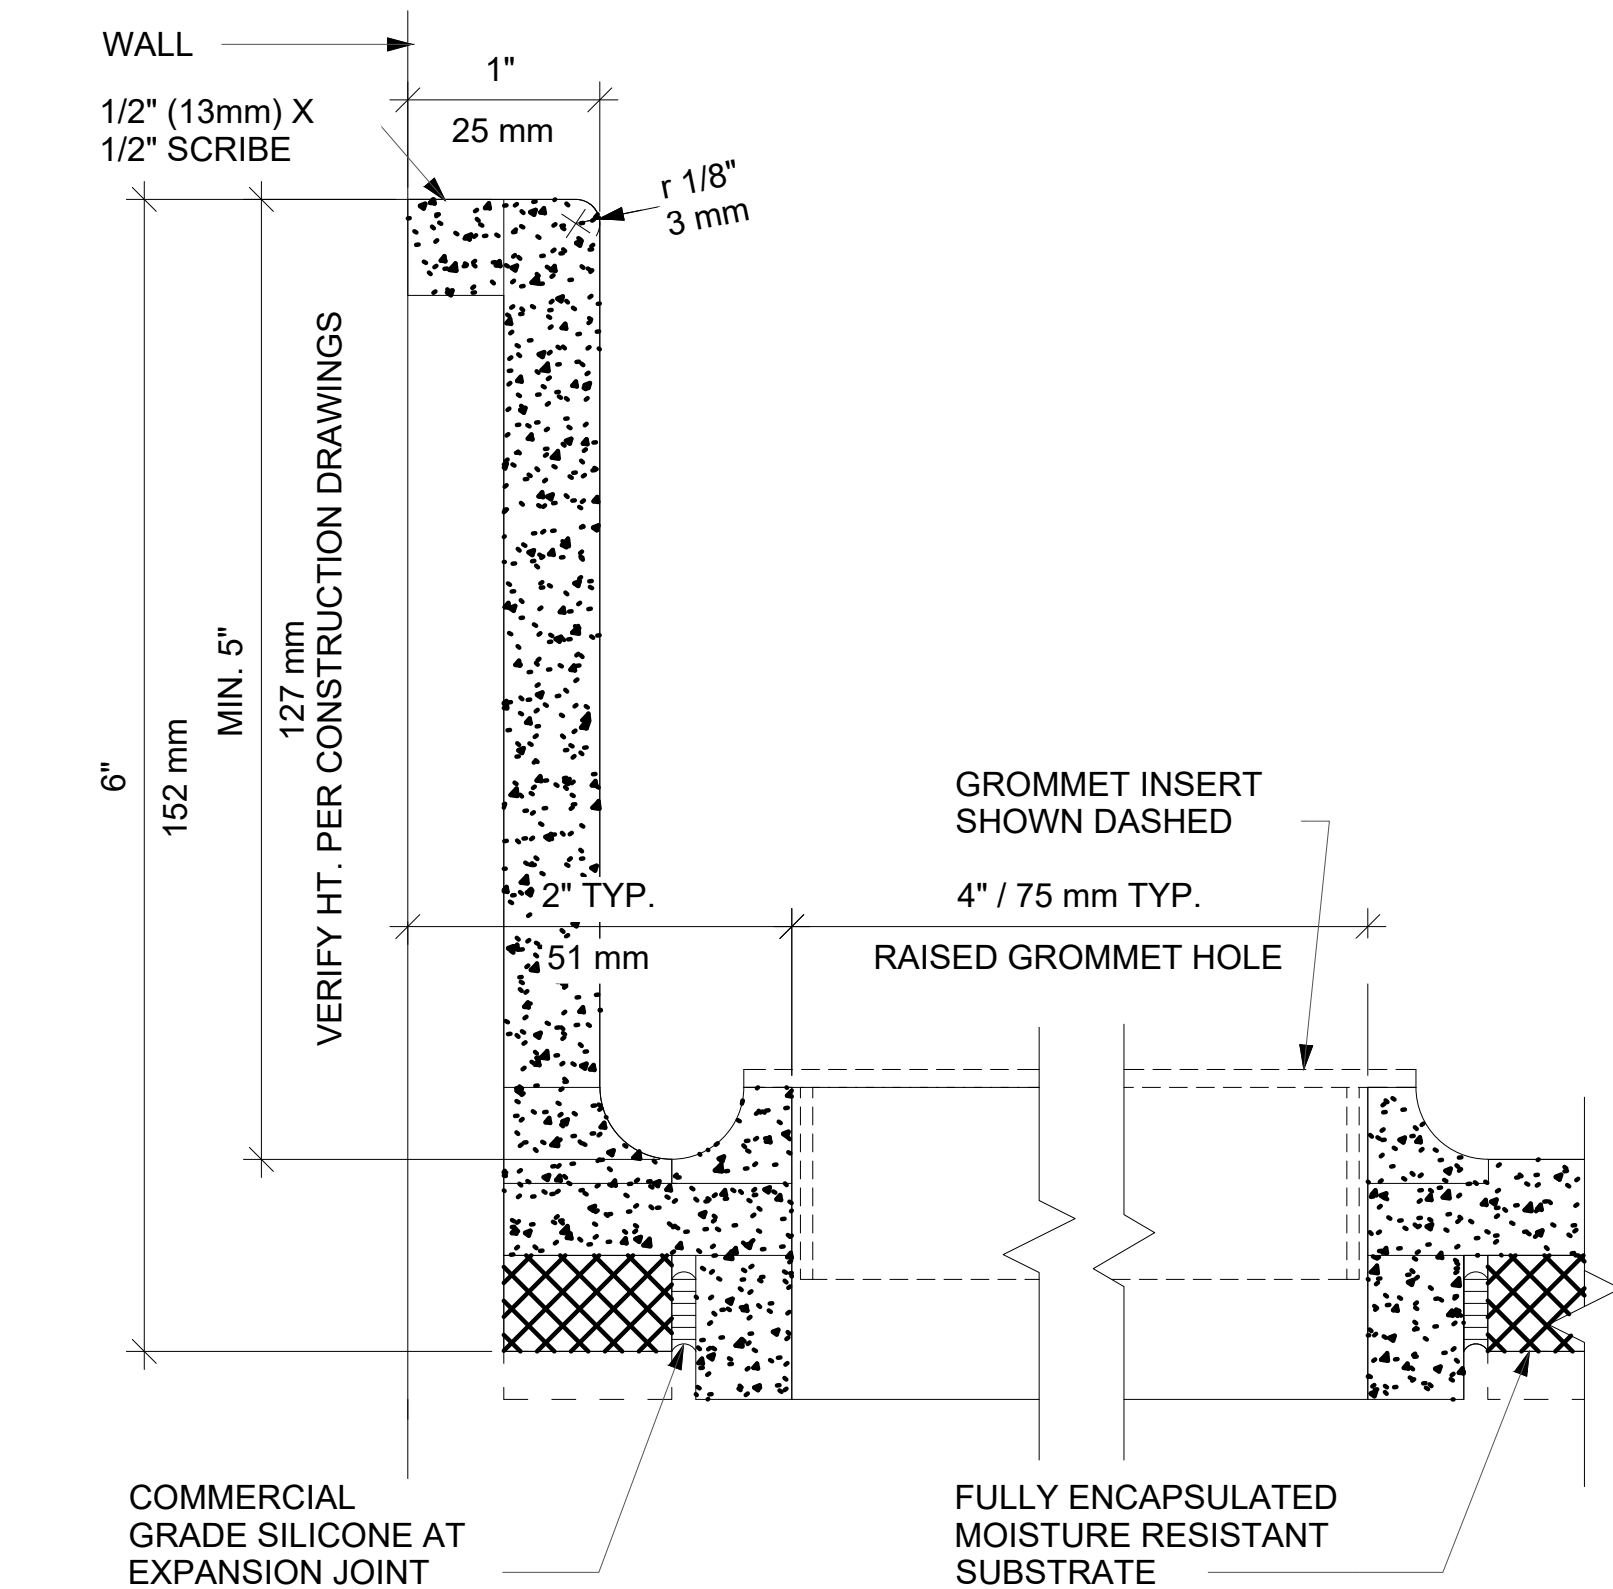


01 CORIAN COUNTERTOP BACKSPLASH AND COVERED GROMMET
Scale: 12" = 1'-0"

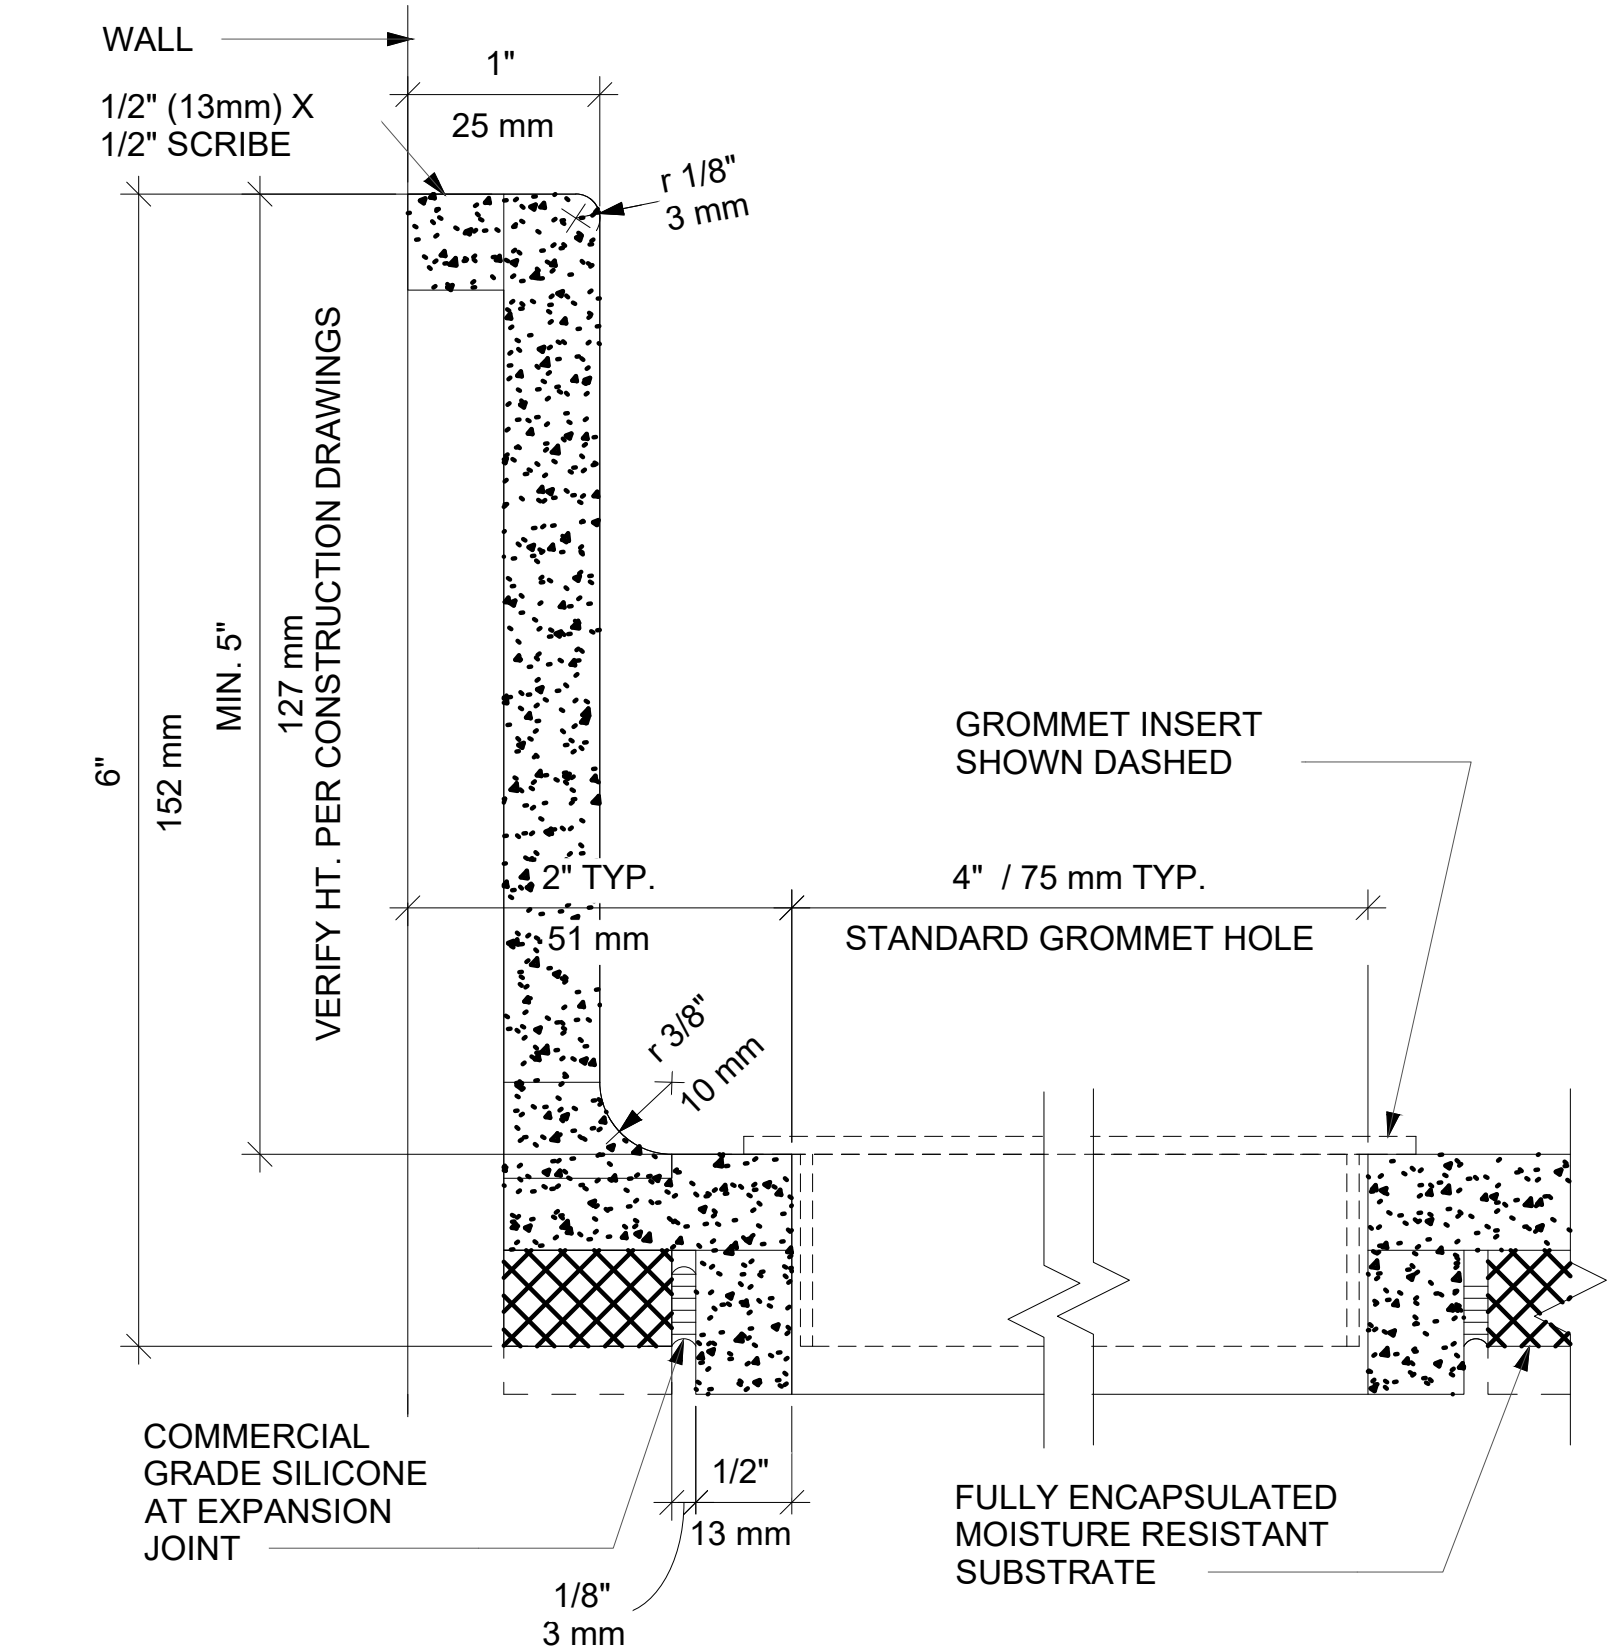


02 CORIAN COUNTERTOP BACKSPLASH AND GROMMET
Scale: 12" = 1'-0"

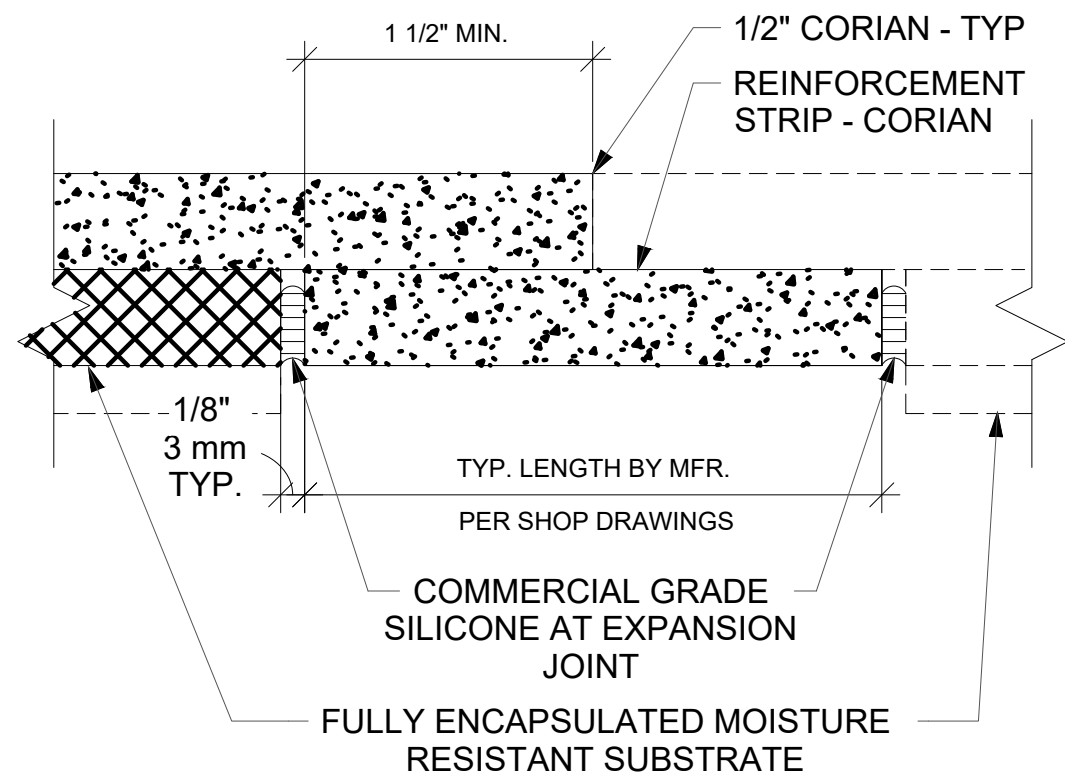


03 CORIAN COUNTERTOP REINFORCEMENT STRIP AT HARD SEAM
Scale: 12" = 1'-0"

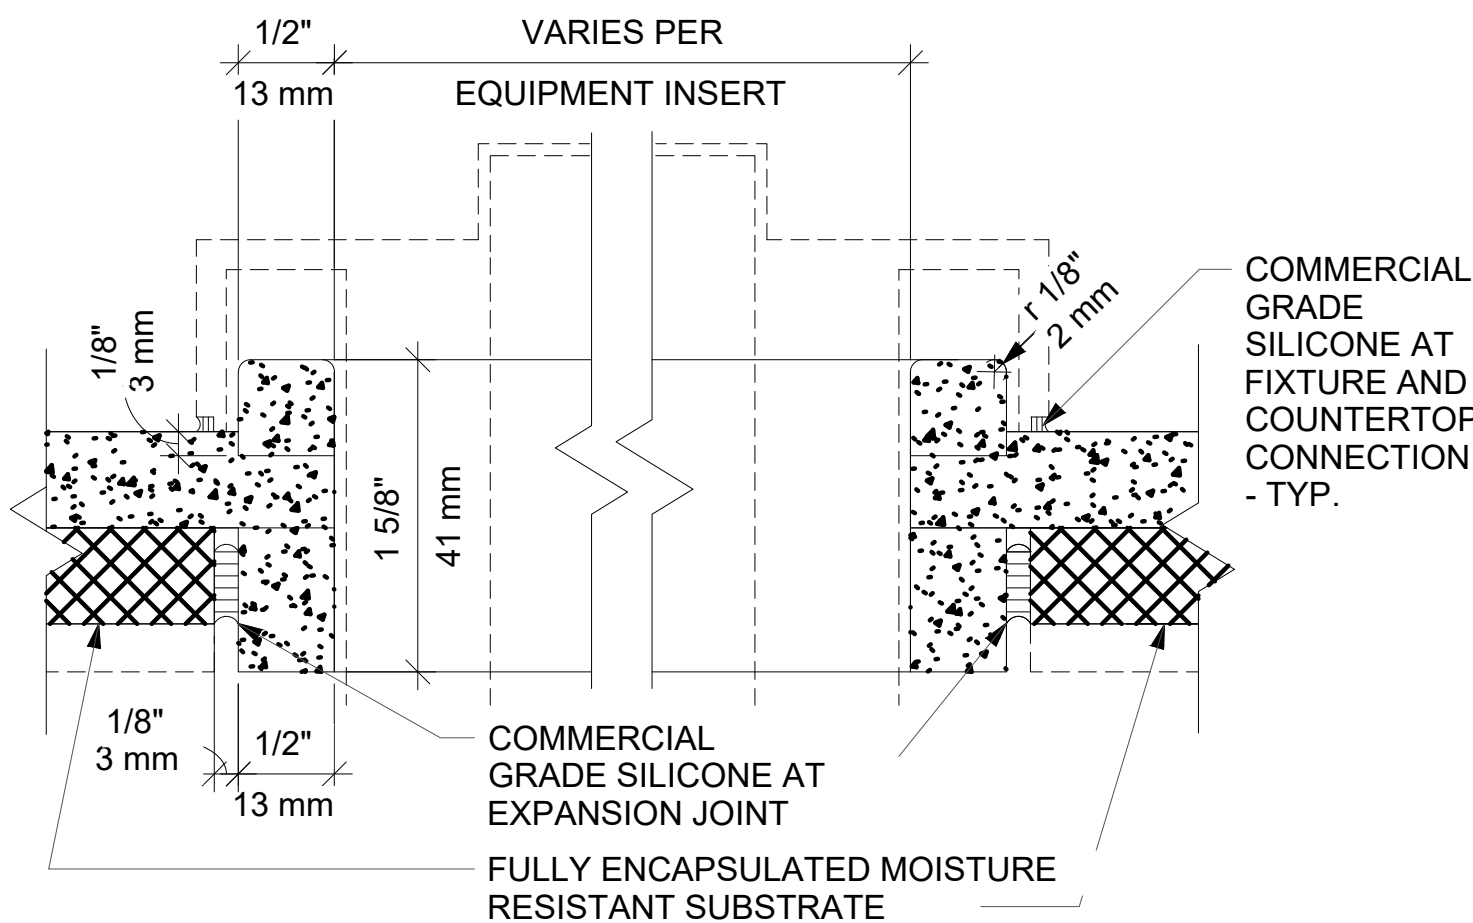


04 CORIAN COUNTERTOP TYP. ICE BIN CUTOUT WITH W/ SQUARED EDGE
Scale: 12" = 1'-0"

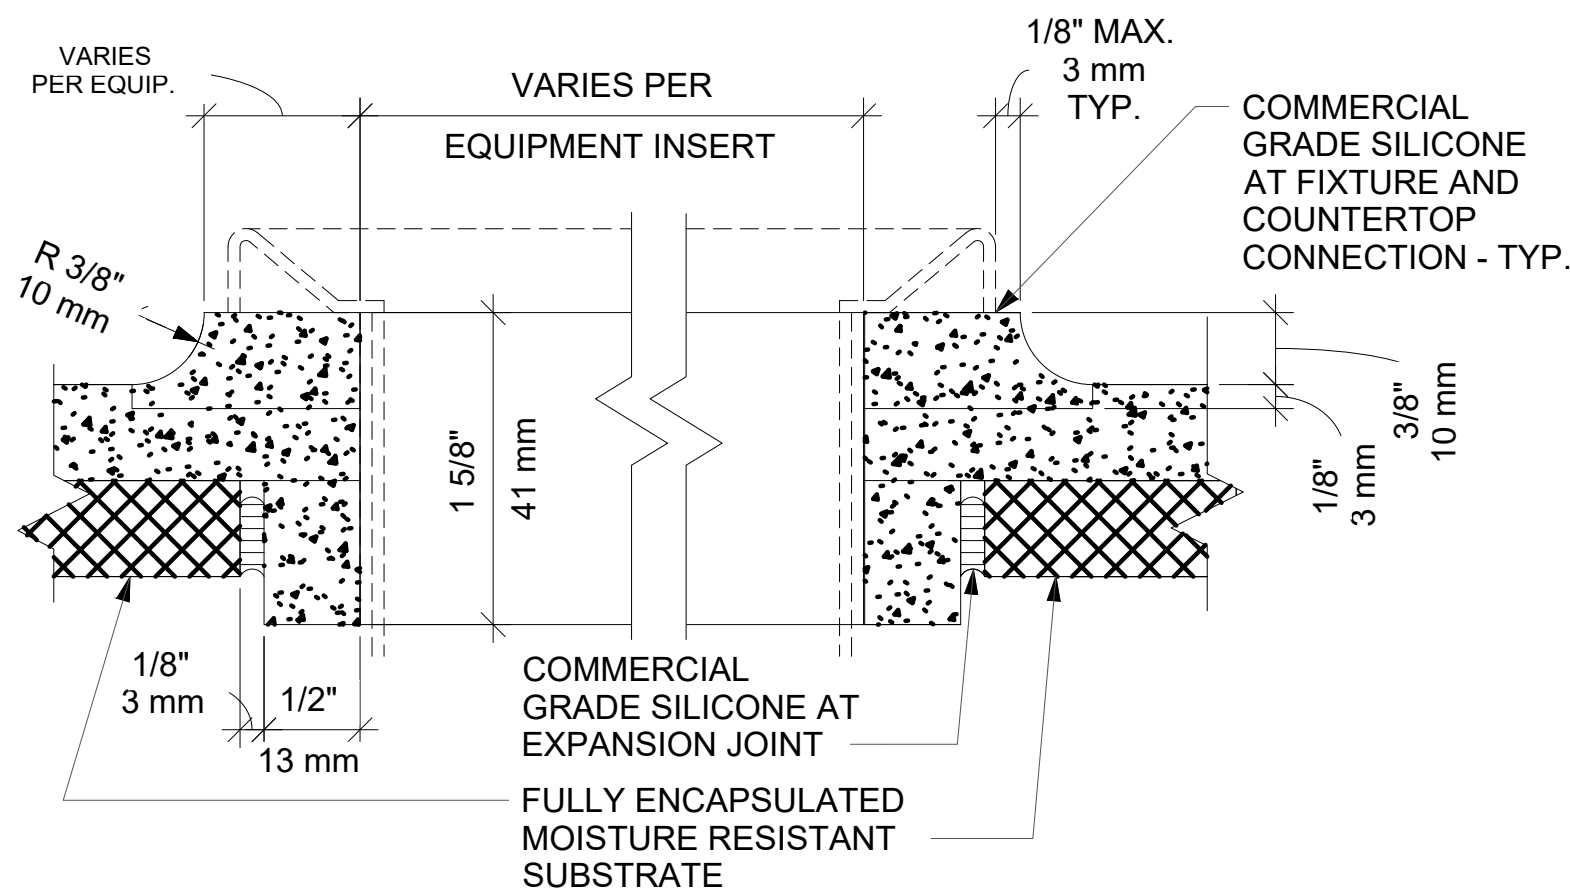


05 CORIAN COUNTERTOP TYP. SINK CUTOUT W/ COVERED EDGE
Scale: 12" = 1'-0"

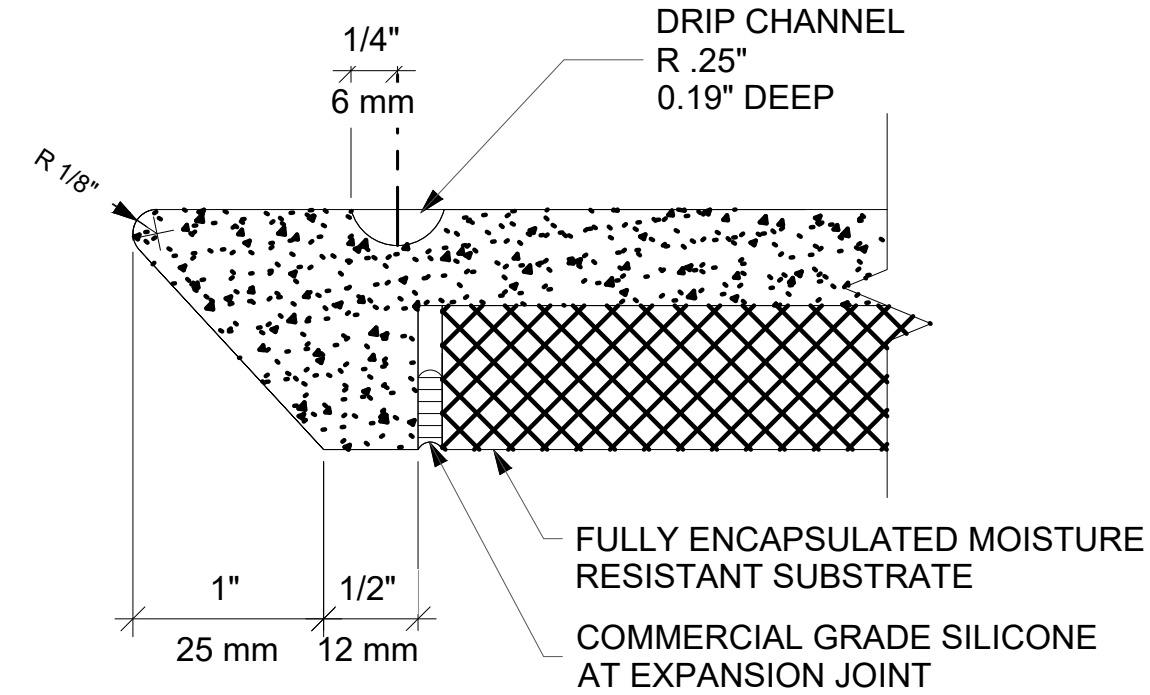

06 CORIAN COUNTERTOP FRONT EDGE AT ICE BIN
Scale: 12" = 1'-0"

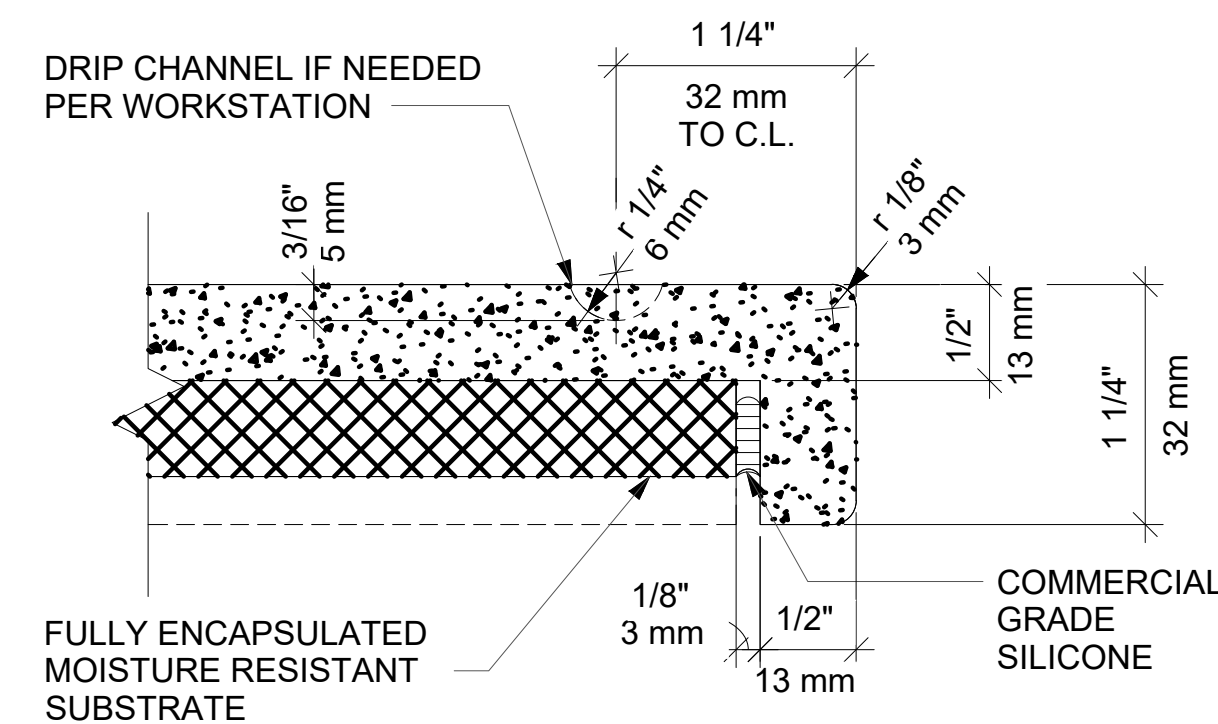

07 CORIAN COUNTERTOP FRONT EDGE
Scale: 12" = 1'-0"

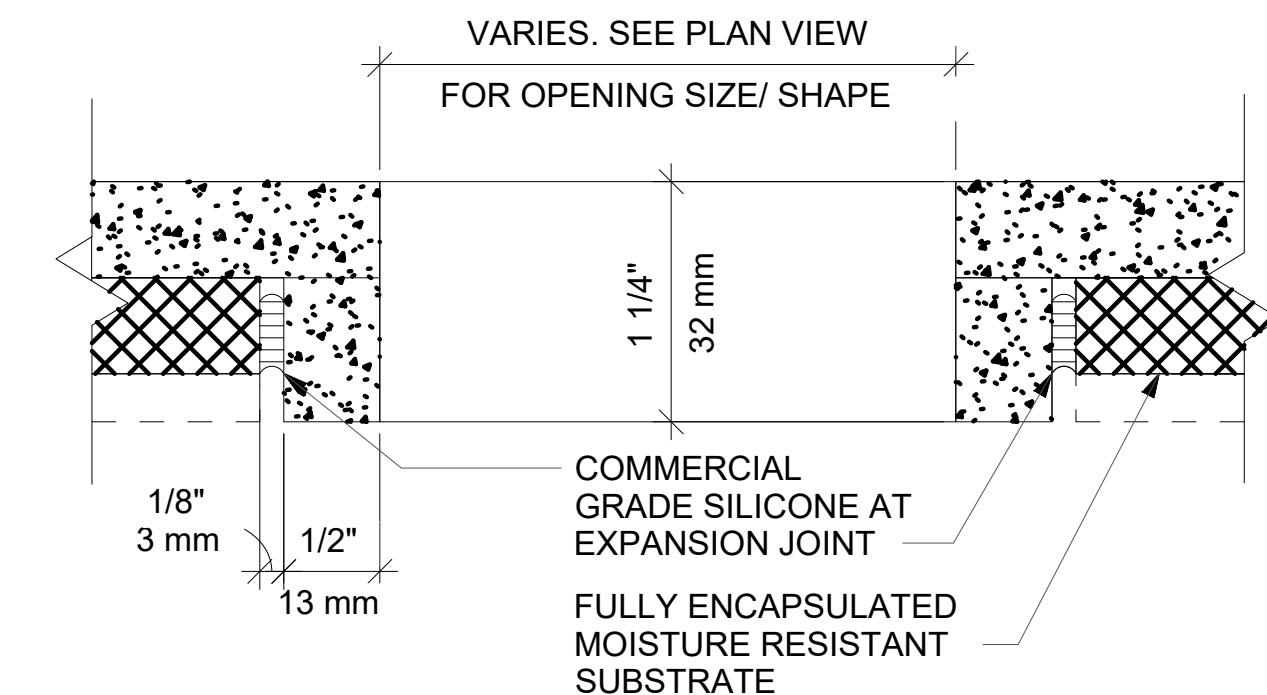

08 CORIAN COUNTERTOP TYP. CUTOUT AT TRASH AND GROMMET
Scale: 12" = 1'-0"

ARCHITECT OF RECORD:

THOMAS E. MORGAN, JR.
ARCHITECT

423 FISCHER TRAIL
ELLIJAY, GEORGIA 30540

SEAL:



MRP
DESIGN GROUP

3450 Acworth Due West Road
Building 100, Suite 120
Kennesaw, Georgia 30144
P. 770-917-9172
F. 770-917-9470
www.mrpdesign.com

RELEASED FOR
CONSTRUCTION

ISSUES / REVISIONS:

DATE	DESCRIPTION
05.04.26	RELEASE FOR CONSTRUCTION

DRAWN BY: JB

CHKD BY: TM

PROJECT DESCRIPTION:

NEW CONSTRUCTION OF A TA
TRAVEL CENTER IN
JEFFERSONVILLE, GA. WHICH
CONSISTS OF A TRUCKER
LOUNGE, SHOWERS, LAUNDRY
ROOM, RETAIL AREA,
RESTROOMS, GAME AREA,
SEATING AREAS, AND FOUR
QUICK-SERVICE RESTAURANTS.
THE MAJORITY OF THE
PROJECT HAS ALREADY BEEN
SUBMITTED. THIS ISSUE, DATED
05.04.26 HAS MODIFICATIONS
RELATED TO THE ADDITION OF
THE STARBUCKS QSR.

PROJECT TITLE:

TRAVEL CENTER
4838 SR 96
JEFFERSONVILLE,
GEORGIA 31044

SHEET TITLE:


CASEWORK
DETAILS

PROJECT NO: 25021


1507.3

FOR REFERENCE ONLY


THESE PLANS ARE THE PROPERTY OF MRP DESIGN GROUP, INC. AND ARE SUBJECT TO FEDERAL COPYRIGHT LAWS. ANY USE OF SAME WITHOUT THE EXPRESS WRITTEN PERMISSION OF MRP DESIGN GROUP, INC. IS STRICTLY PROHIBITED.

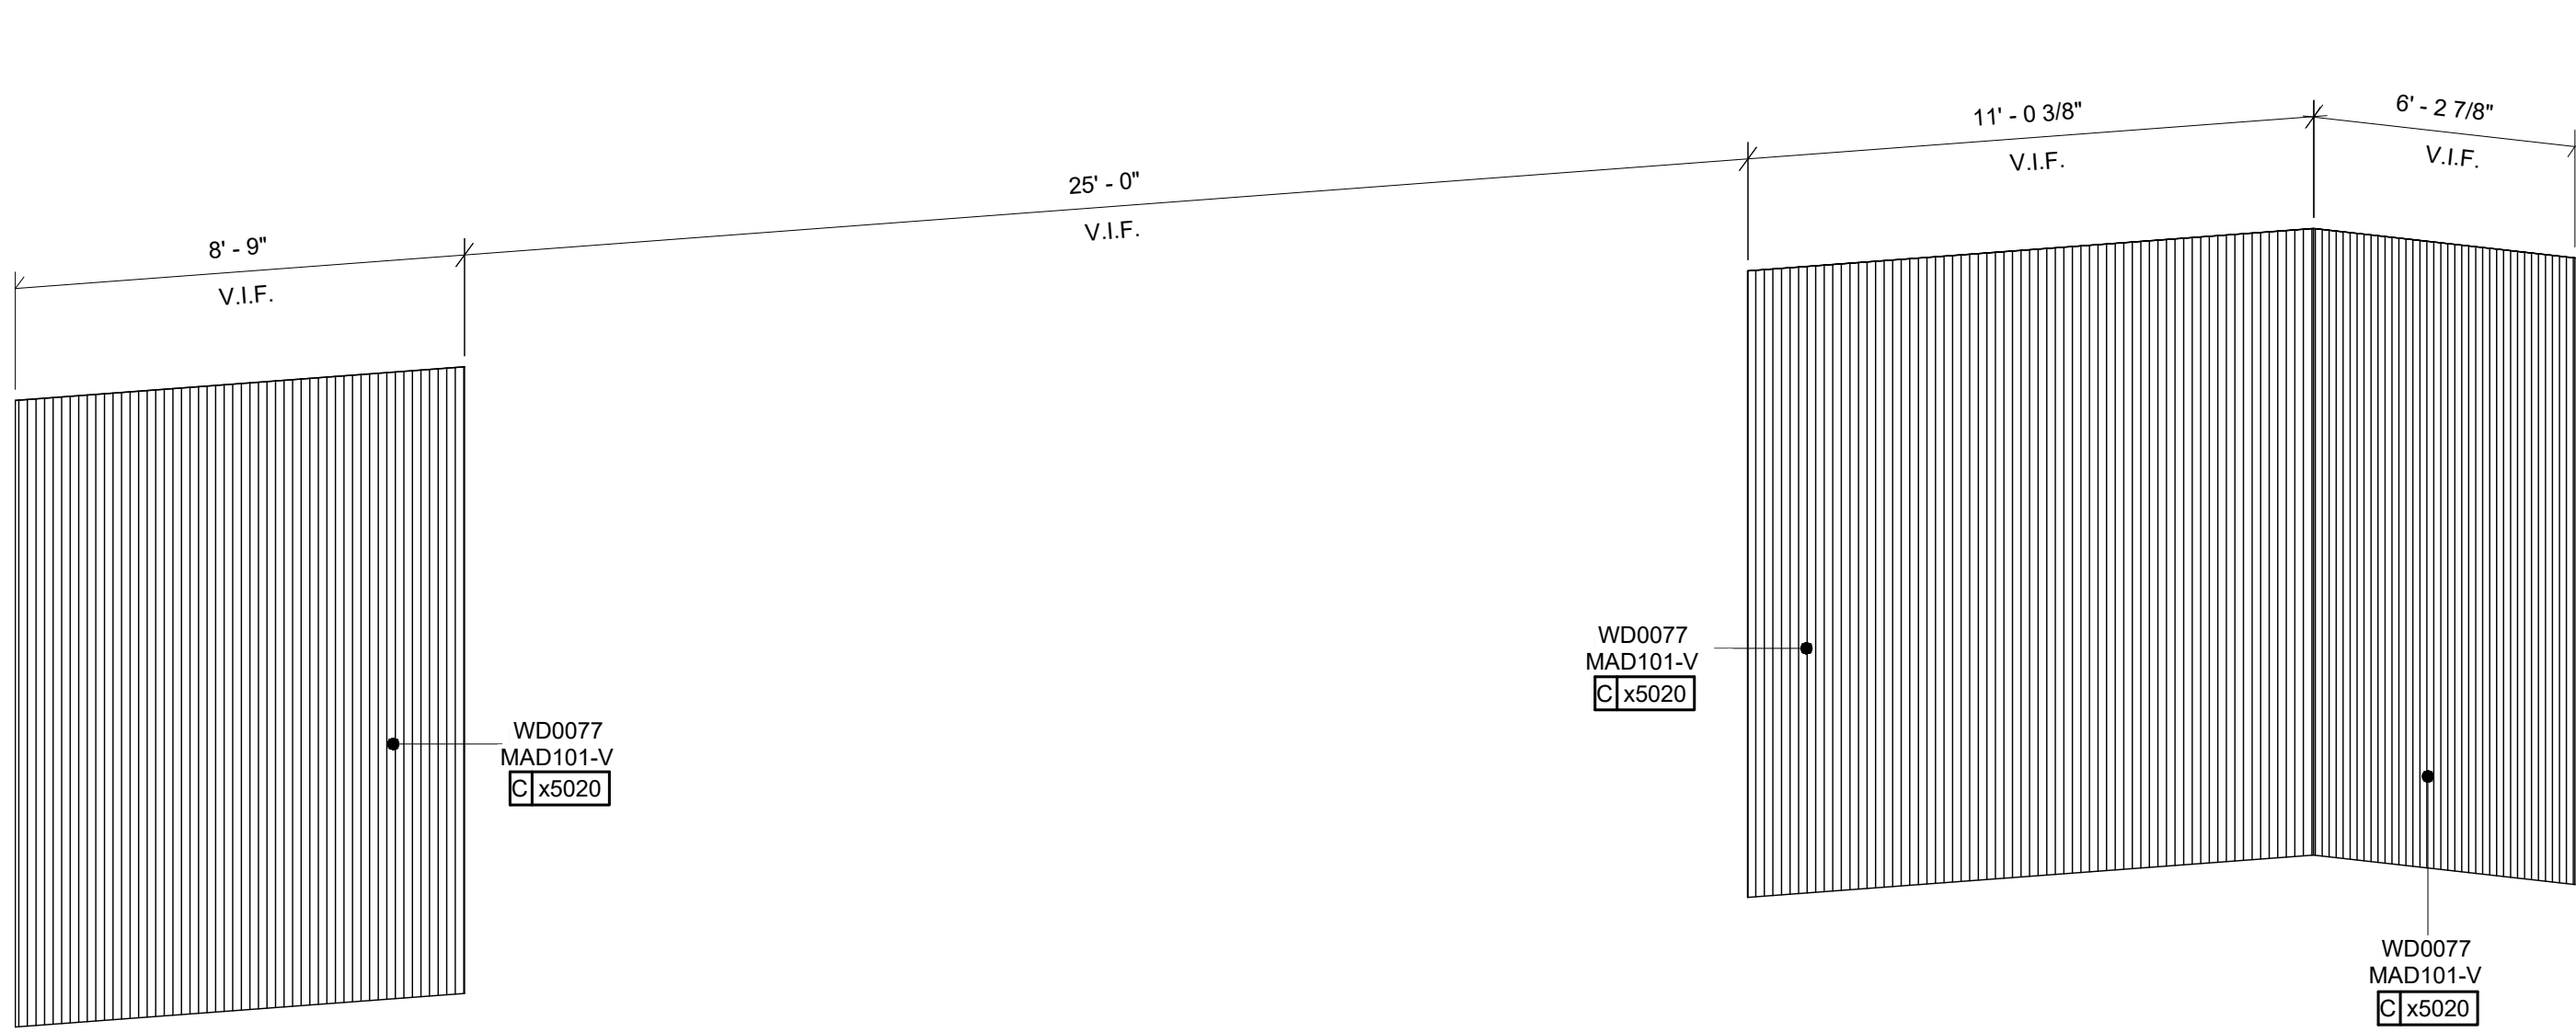

① x5020 3D VIEW
Scale: 1/2" = 1'-0"

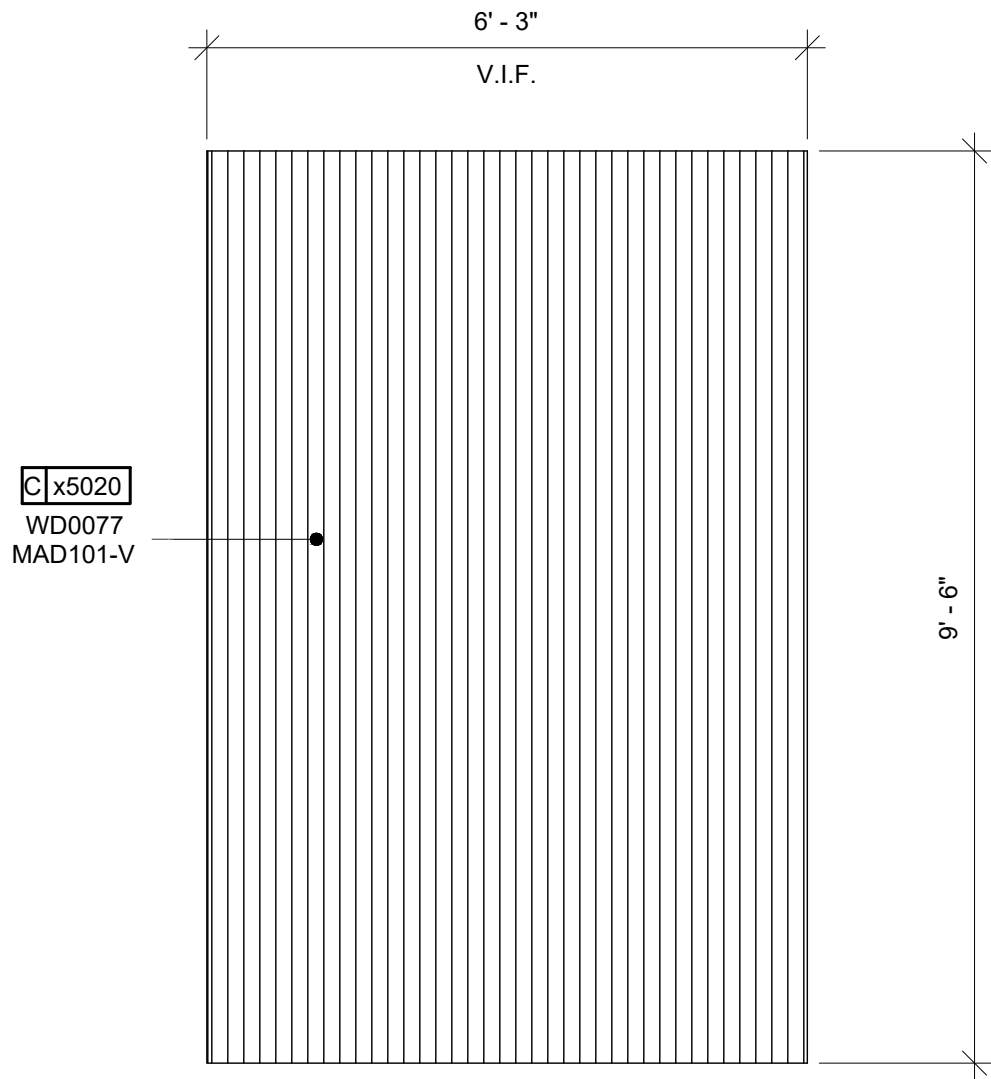

③ x5020 SIDE VIEW
Scale: 1/2" = 1'-0"

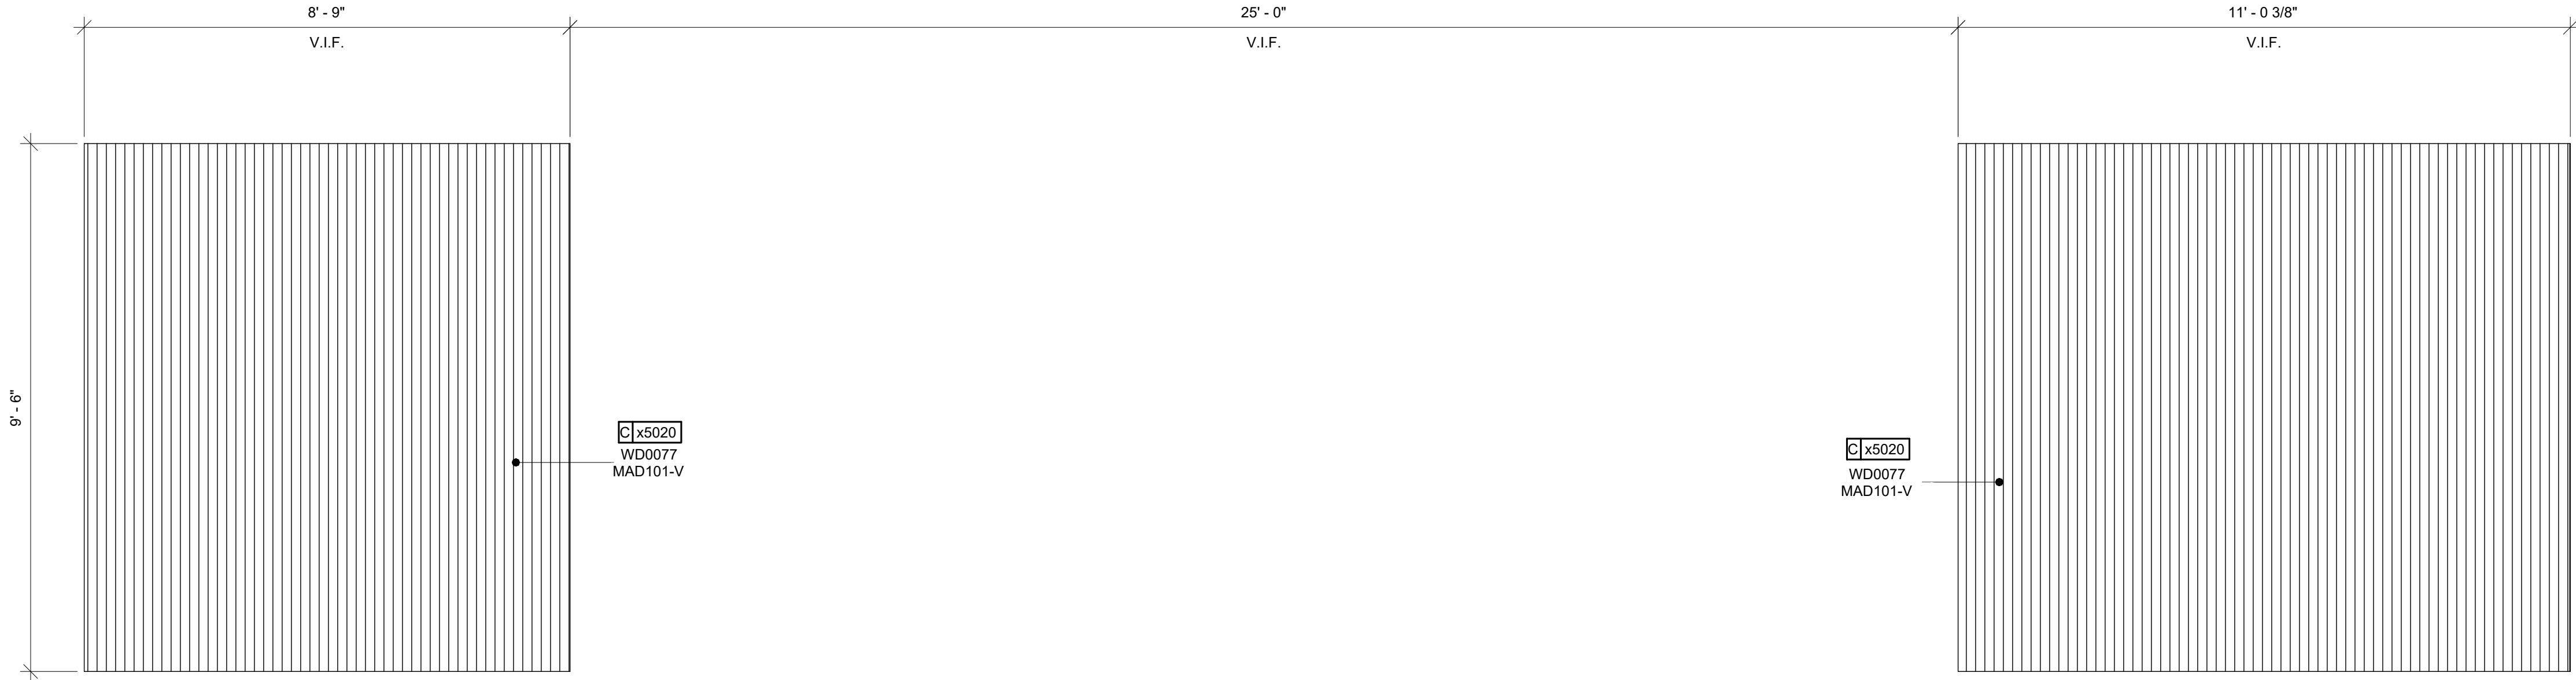

② x5020 FRONT VIEW
Scale: 1/2" = 1'-0"

ARCHITECT OF RECORD:

THOMAS E. MORGAN, JR.
ARCHITECT

423 FISCHER TRAIL
ELLIJAY, GEORGIA 30540

SEAL:



MRP
DESIGN GROUP

3450 Acworth Due West Road
Building 100, Suite 120
Kennesaw, Georgia 30144
P: 770-917-9172
F: 770-917-9470
www.mrpdesign.com

RELEASED FOR
CONSTRUCTION

ISSUES / REVISIONS:	
DATE	DESCRIPTION
05.04.26	RELEASE FOR CONSTRUCTION

DRAWN BY: JB

CHKD BY: TM

PROJECT DESCRIPTION:

NEW CONSTRUCTION OF A TA TRAVEL CENTER IN JEFFERSONVILLE, GA, WHICH CONSISTS OF A TRUCKER LOUNGE, SHOWERS, LAUNDRY ROOM, RETAIL AREA, RESTROOMS, GAME AREA, SEATING AREAS, AND FOUR QUICK-SERVICE RESTAURANTS. THE MAJORITY OF THE PROJECT HAS ALREADY BEEN SUBMITTED. THIS ISSUE, DATED 05.04.26 HAS MODIFICATIONS RELATED TO THE ADDITION OF THE STARBUCKS QSR.

PROJECT TITLE:

TRAVEL CENTER
4838 SR 96
JEFFERSONVILLE,
GEORGIA 31044

SHEET TITLE:


CASEWORK
DETAILS

PROJECT NO: 25021


1507.4

FOR REFERENCE ONLY

THESE PLANS ARE THE PROPERTY OF MRP DESIGN GROUP, INC. AND ARE SUBJECT TO FEDERAL COPYRIGHT LAWS. ANY USE OF SAME WITHOUT THE EXPRESS WRITTEN PERMISSION OF MRP DESIGN GROUP, INC. IS STRICTLY PROHIBITED.

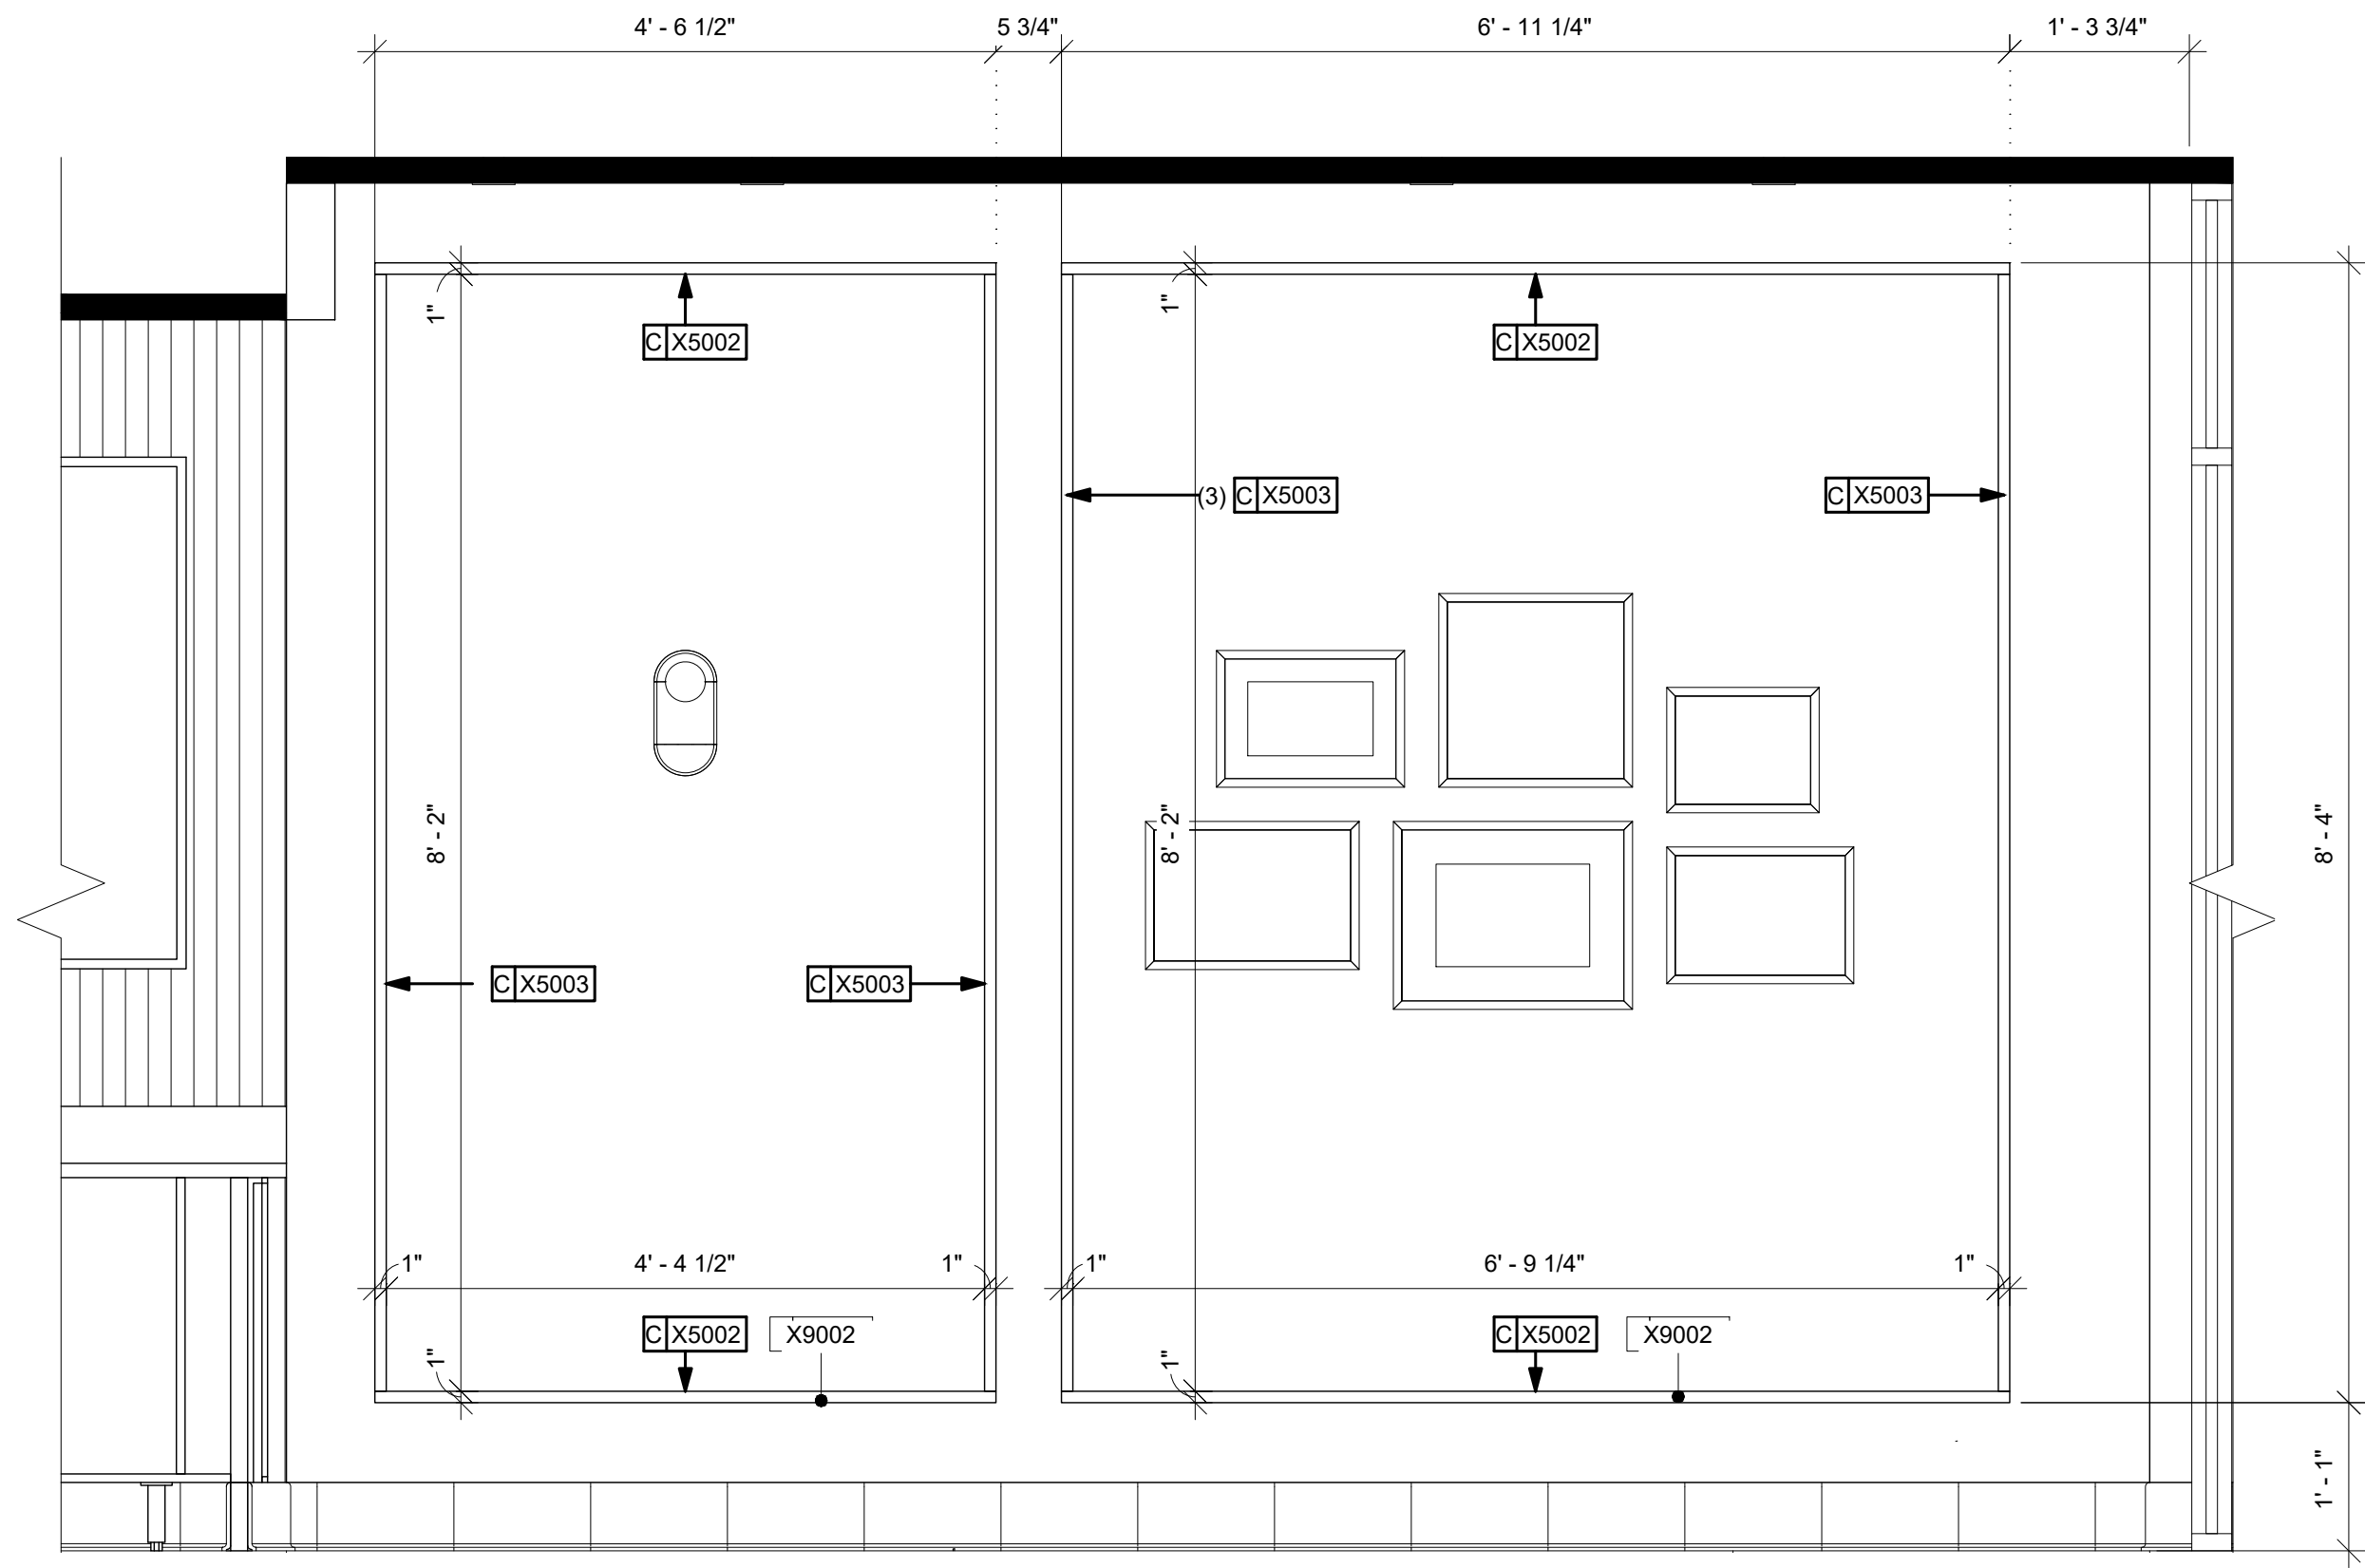

① TRIM DETAIL AT BACK BAR WALL
Scale: 3/4" = 1'-0"

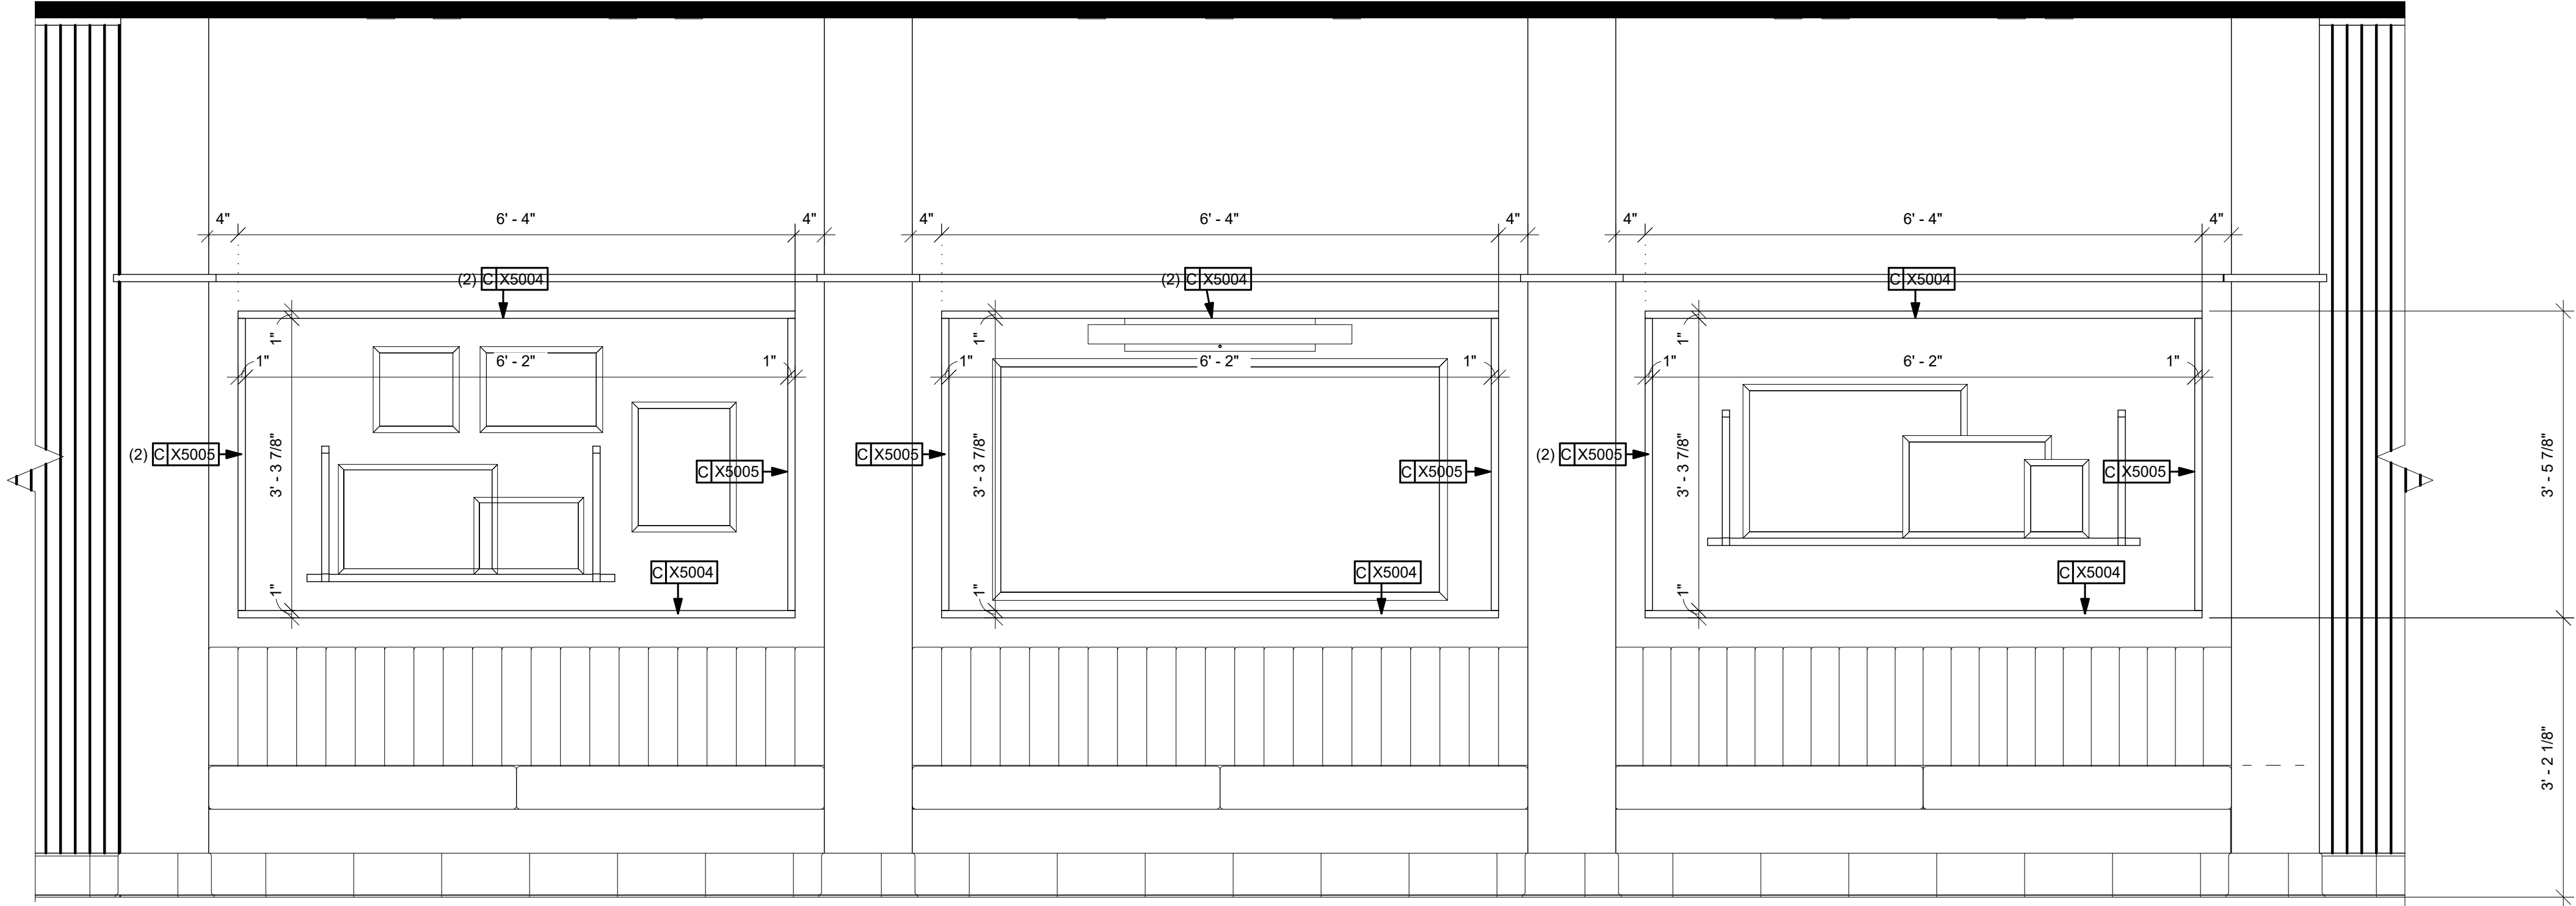

② TRIM DETAIL AT BANQUETTE WALL
Scale: 3/4" = 1'-0"

ARCHITECT OF RECORD:

THOMAS E. MORGAN, JR.
ARCHITECT

423 FISCHER TRAIL
ELLIJIAY, GEORGIA 30540

SEAL:



MRP
DESIGN GROUP

3450 Acworth Due West Road
Building 100, Suite 120
Kennesaw, Georgia 30144
P. 770-917-9172
F. 770-917-9470
www.mrpdesign.com

RELEASED FOR
CONSTRUCTION

ISSUES / REVISIONS:

DATE	DESCRIPTION
05.04.26	RELEASE FOR CONSTRUCTION

DRAWN BY: JB

CHKD BY: TM

PROJECT DESCRIPTION:

NEW CONSTRUCTION OF A TA TRAVEL CENTER IN JEFFERSONVILLE, GA. WHICH CONSISTS OF A TRUCKER LOUNGE, SHOWERS, LAUNDRY ROOM, RETAIL AREA, RESTROOMS, GAME AREA, SEATING AREAS, AND FOUR QUICK-SERVICE RESTAURANTS. THE MAJORITY OF THE PROJECT HAS ALREADY BEEN SUBMITTED. THIS ISSUE, DATED 05.04.26 HAS MODIFICATIONS RELATED TO THE ADDITION OF THE STARBUCKS QSR.

PROJECT TITLE:

TRAVEL CENTER
4838 SR 96
JEFFERSONVILLE,
GEORGIA 31044

SHEET TITLE:


CASEWORK
DETAILS

PROJECT NO: 25021

1507.5


FOR REFERENCE ONLY

THESE PLANS ARE THE PROPERTY OF MRP DESIGN GROUP, INC. AND ARE SUBJECT TO FEDERAL COPYRIGHT LAWS. ANY USE OF SAME WITHOUT THE EXPRESS WRITTEN PERMISSION OF MRP DESIGN GROUP, INC. IS STRICTLY PROHIBITED

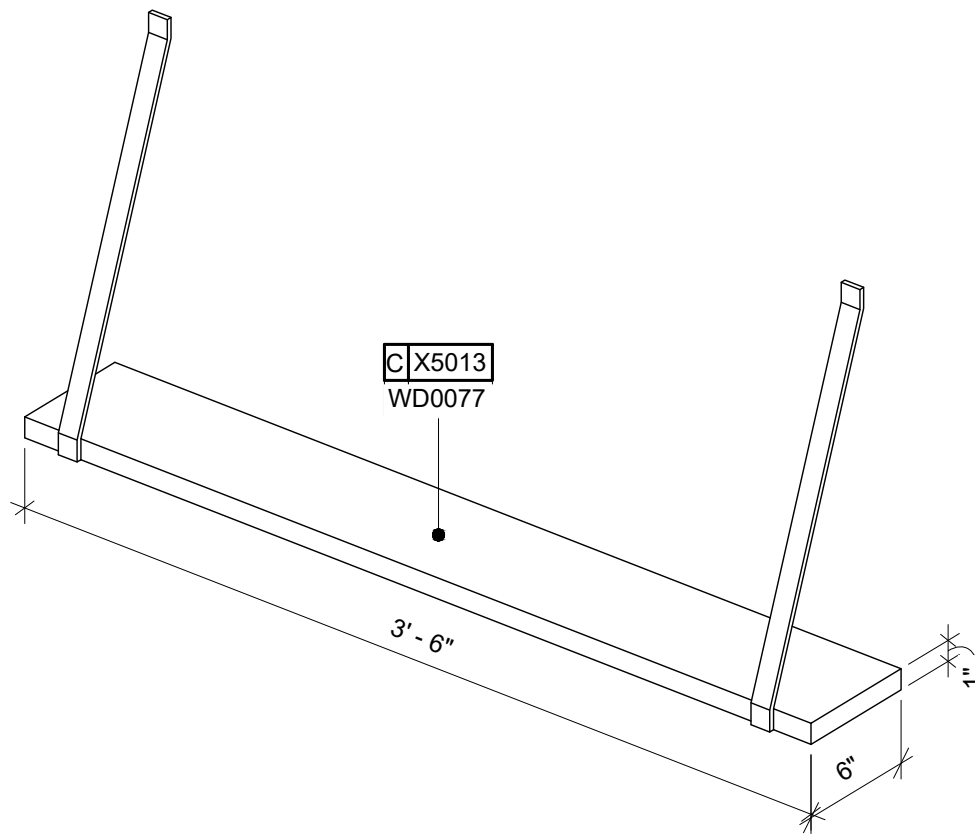


1 3D VIEW - CUSTOM SHELF X5013

Scale:

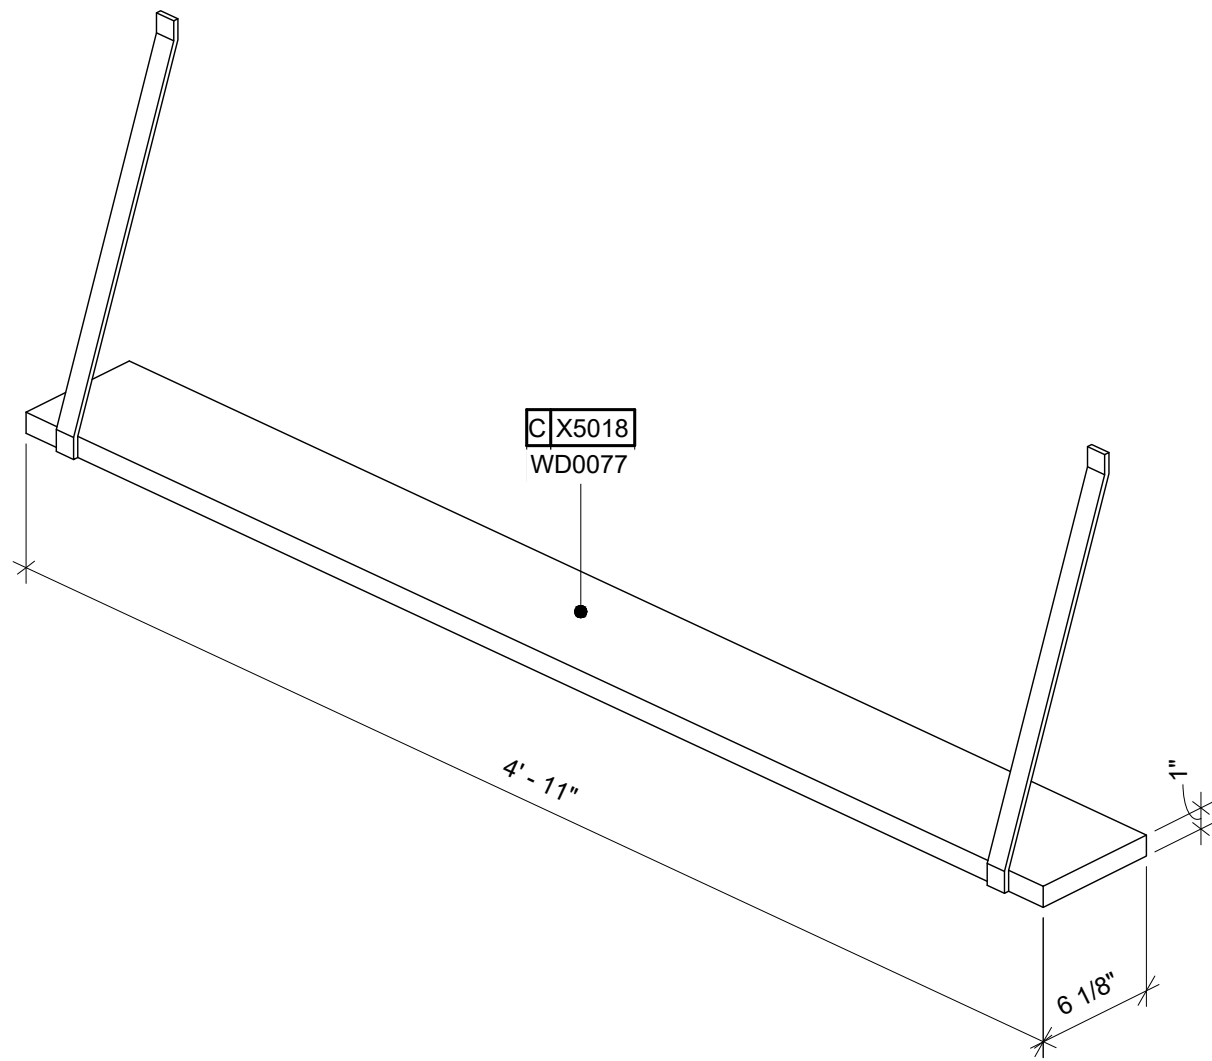


4 3D VIEW - CUSTOM SHELF X5018

Scale:

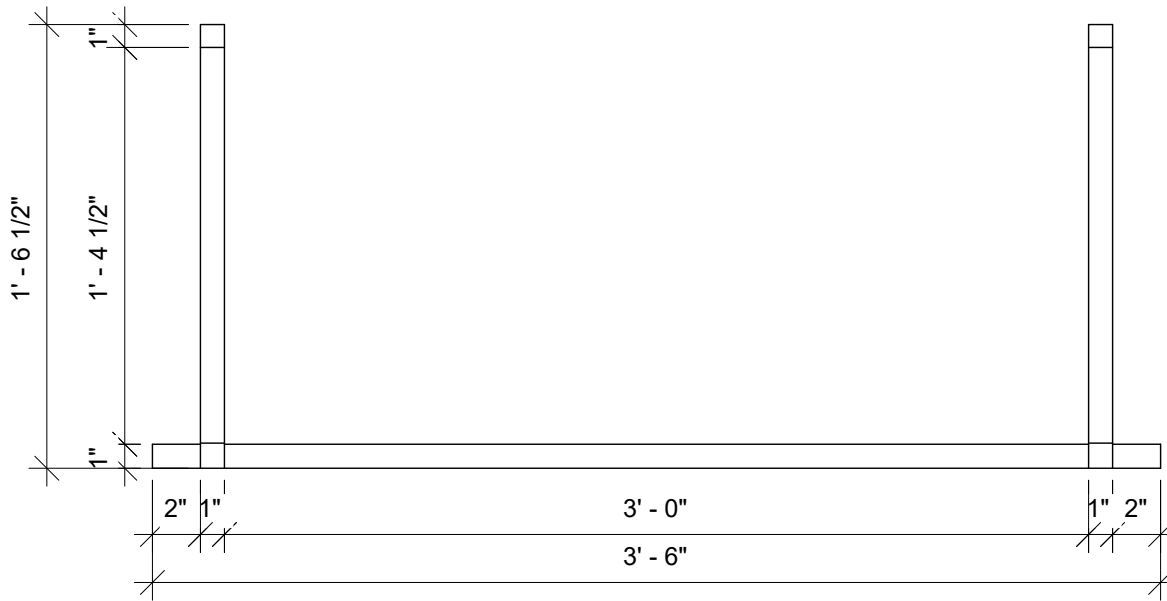


2 FRONT ELEVATION - CUSTOM SHELF X5013

Scale: 1 1/2" = 1'-0"

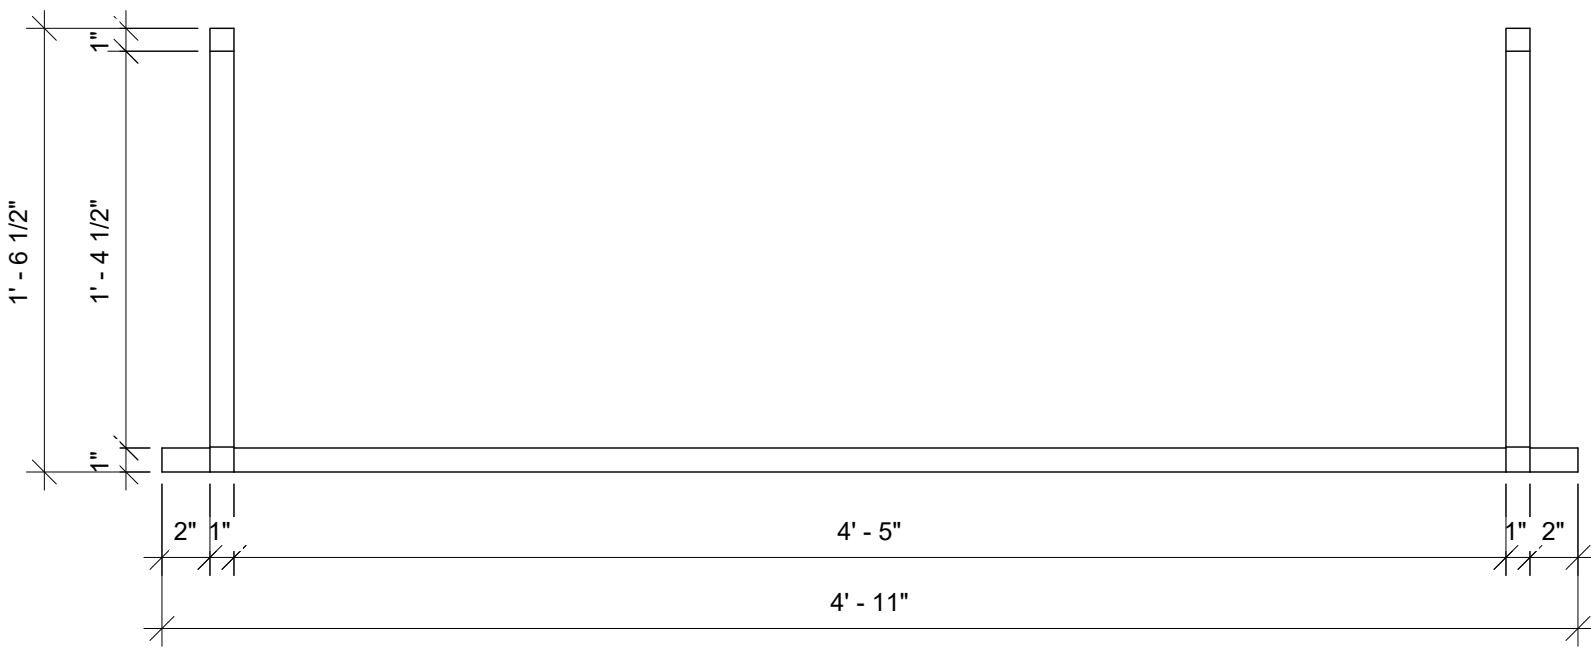


5 FRONT ELEVATION - CUSTOM SHELF X5018

Scale: 1 1/2" = 1'-0"

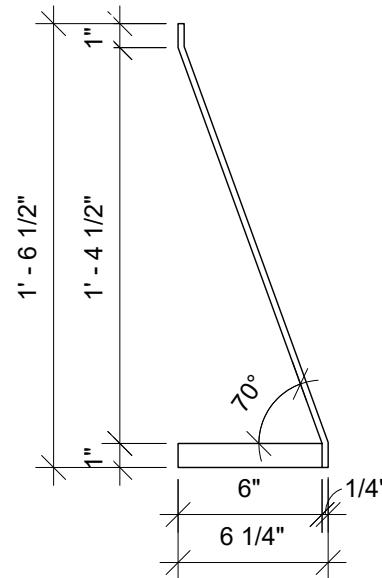

3 SIDE ELEVATION - CUSTOM SHELF X5013

Scale: 1 1/2" = 1'-0"

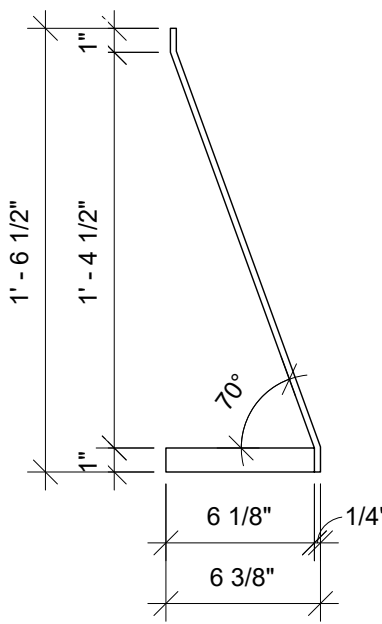

6 SIDE ELEVATION - CUSTOM SHELF X5018

Scale: 1 1/2" = 1'-0"

ARCHITECT OF RECORD:

THOMAS E. MORGAN, JR.
ARCHITECT

423 FISCHER TRAIL
ELLIJAY, GEORGIA 30540

SEAL:



MRP
DESIGN GROUP

3450 Acworth Due West Road
Building 100, Suite 120
Kennesaw, Georgia 30144
P. 770-917-9172
F. 770-917-9470
www.mrpdesign.com

RELEASED FOR
CONSTRUCTION

ISSUES / REVISIONS:

DATE	DESCRIPTION
05.04.26	RELEASE FOR CONSTRUCTION

DRAWN BY: JB

CHKD BY: TM

PROJECT DESCRIPTION:

NEW CONSTRUCTION OF A TA
TRAVEL CENTER IN
JEFFERSONVILLE, GA, WHICH
CONSISTS OF A TRUCKER
LOUNGE, SHOWERS, LAUNDRY
ROOM, RETAIL AREA,
RESTROOMS, GAME AREA,
SEATING AREAS, AND FOUR
QUICK-SERVICE RESTAURANTS.
THE MAJORITY OF THE
PROJECT HAS ALREADY BEEN
SUBMITTED. THIS ISSUE, DATED
05.04.26 HAS MODIFICATIONS
RELATED TO THE ADDITION OF
THE STARBUCKS QSR.

PROJECT TITLE:

TRAVEL CENTER
4838 SR 96
JEFFERSONVILLE,
GEORGIA 31044

SHEET TITLE:

CASEWORK
DETAILS

PROJECT NO: 25021

1507.6

 
 
 
 
 
 
 
FOR REFERENCE ONLY

THESE PLANS ARE THE PROPERTY OF MRP DESIGN GROUP, INC. AND ARE SUBJECT TO FEDERAL COPYRIGHT LAWS. ANY USE OF SAME WITHOUT THE EXPRESS WRITTEN PERMISSION OF MRP DESIGN GROUP, INC. IS STRICTLY PROHIBITED

HVAC GENERAL NOTES

- CONTRACTOR SHALL PROVIDE A COMPLETE AND FUNCTIONAL HEATING, VENTILATING, AND AIR CONDITIONING SYSTEM PER THESE CONTRACT DOCUMENTS.
- ALL MECHANICAL EQUIPMENT AND INSTALLATIONS SHALL CONFORM WITH THE REQUIREMENTS OF THE INTERNATIONAL MECHANICAL CODE, THE INTERNATIONAL BUILDING CODE, THE STATE ENERGY CODE, NFPA 90A, 96, 101 AND ALL APPLICABLE LOCAL CODES AND ORDINANCES.
- PRIOR TO PURCHASING ANY MATERIALS OR STARTING ANY WORK, CONTRACTOR SHALL FIELD VERIFY ALL EXISTING CONDITIONS, DUCTWORK SIZES AND LOCATIONS, EQUIPMENT, ETC. SHOWN ON THE DRAWINGS OR AFFECTING THIS WORK AND SHALL REPORT ANY DEVIATIONS TO THE ARCHITECT.
- SHOP DRAWINGS SHALL BE SUBMITTED TO AND APPROVED BY THE ARCHITECT PRIOR TO ORDERING, PURCHASING, OR FABRICATING ANY MECHANICAL EQUIPMENT. SHOP DRAWINGS SHALL INCLUDE: ALL EQUIPMENT SCHEDULED OR SPECIFIED ON THE DRAWINGS.
- CONTRACTOR SHALL COORDINATE ELECTRICAL CHARACTERISTICS AND REQUIREMENTS OF ALL MECHANICAL EQUIPMENT WITH ELECTRICAL DRAWINGS PRIOR TO ORDERING EQUIPMENT OR SUBMITTING SHOP DRAWINGS, AND SHALL FURNISH EQUIPMENT WIRED FOR THE VOLTAGES SHOWN THEREIN.
- ALL MECHANICAL EQUIPMENT REQUIRING ELECTRICAL POWER SHALL BE INSTALLED WITH DISCONNECT SWITCHES AT EACH PIECE OF EQUIPMENT. COORDINATE SWITCH TYPE WITH EQUIPMENT CHARACTERISTICS AND ELECTRICAL DRAWINGS.
- ALL REQUIRED CONTROL WIRING NOT SHOWN ON THE ELECTRICAL DRAWINGS SHALL BE INCLUDED AS PART OF THE MECHANICAL WORK. WIRING IN HVAC PLENUM SPACES SHALL BE INSTALLED ACCORDING TO CODE REQUIREMENTS.
- UNLESS NOTED OTHERWISE, STARTERS, SMOKE DETECTORS, TRANSFORMERS, CONTROLS AND CONTROL WIRING REQUIRED FOR ALL MECHANICAL SYSTEMS SHALL BE FURNISHED AND INSTALLED BY THE MECHANICAL CONTRACTOR.
- ALL FANS SUPPLYING MORE THAN 2000 CFM OF AIR TO ANY SPACE AND ALL RECIRCULATING FAN SYSTEMS SERVING AREAS OF EGRESS SHALL BE INSTALLED WITH A SMOKE DETECTOR IN THE SUPPLY DUCTWORK. THE SMOKE DETECTOR SHALL BE WIRED TO STOP THE FAN UPON DETECTION OF SMOKE, AND SIGNAL THE BUILDING FIRE ALARM CONTROL PANEL (IF BUILDING IS SO EQUIPPED). IF THE BUILDING IS NOT PROVIDED WITH A FIRE ALARM SYSTEM, THE SMOKE DETECTOR SHALL CAUSE A VISIBLE AND AUDIBLE ALARM SIGNAL IN A NORMALLY OCCUPIED AREA. SMOKE DETECTOR TROUBLE CONDITIONS SHALL BE INDICATED VISUALLY OR AUDIBLY IN A NORMALLY OCCUPIED AREA AND SHALL BE IDENTIFIED AS AIR DUCT DETECTOR TROUBLE.
- ALL MECHANICAL EQUIPMENT SHALL BE INSTALLED ACCORDING TO MANUFACTURER'S RECOMMENDATIONS.
- ALL MECHANICAL EQUIPMENT AND SYSTEMS SHALL BE GUARANTEED FOR A PERIOD OF ONE YEAR AFTER ACCEPTANCE BY OWNER.
- ALL HVAC COMPRESSORS SHALL HAVE EXTENDED 5-YEAR MANUFACTURER'S WARRANTY.
- SUPPLY, RETURN AND EXHAUST DUCTWORK SHALL BE CONSTRUCTED OF GALVANIZED SHEET METAL AS RECOMMENDED IN SMACNA LOW PRESSURE DUCT CONSTRUCTION STANDARDS, LATEST EDITION. ALL JOINTS AND SEAMS IN ALL DUCTWORK SHALL BE SEALED WITH DUCT SEALER.
- DUCTWORK IN NON-AIR CONDITIONED AREAS SHALL BE INSULATED WITH 2" THICK FIBERGLASS DUCT INSULATION WITH FOIL VAPOR BARRIER, U.L. LISTED, MINIMUM R-8.
- ALL DUCTWORK SHALL BE SUPPORTED BY THE BUILDING STRUCTURE AND SHALL NOT REST ON CEILING TILES OR CEILING STRUCTURE. DUCT SUPPORTS AND ATTACHMENT TO STRUCTURE SHALL BE AS PER SMACNA STANDARDS.
- EXPOSED ROUND DUCTWORK SHALL BE MEDIUM PRESSURE SPIRAL TYPE, UNITED SHEET METAL OR EQUAL.
- FLEXIBLE DUCTWORK SHALL BE FLEXMASTER TYPE 3 OR EQUAL, SAME SIZE AS DIFFUSER NECKS, MAXIMUM 8'-0" LONG. FLEXIBLE DUCTWORK SHALL BE INSTALLED AS STRAIGHT AS POSSIBLE, AND SHALL BE ROUTED AND SUPPORTED WITHOUT FORMING CRIMPS OR OTHER AIR FLOW RESTRICTIONS.
- ROUND AND FLEXIBLE DUCTWORK SHALL BE CONNECTED TO MAIN DUCTS WITH SPIN-IN FITTINGS WITH AIR EXTRACTORS AND BALANCING DAMPERS.
- DUCTWORK DIMENSIONS SHOWN ON THE DRAWINGS ARE INSIDE CLEAR DIMENSIONS.
- CONDENSATE FROM ALL AIR CONDITIONING EQUIPMENT SHALL BE TRAPPED AND ROUTED TO THE NEAREST APPROVED LOCATION. CONDENSATE PIPING SHALL BE SCHEDULE 40 PVC (EXCEPT INSULATED COPPER IN HVAC PLENUMS).
- AFTER CONSTRUCTION, THE ENTIRE HVAC SYSTEM SHALL BE TESTED, ADJUSTED, AND BALANCED TO DELIVER THE AIR FLOW QUANTITIES SHOWN ON THE DRAWINGS. SUBMIT CERTIFIED TEST AND BALANCE REPORT TO ARCHITECT FOR APPROVAL.
- ANY EXISTING WALL, FLOOR, OR CEILING SURFACE THAT IS DISTURBED DURING THE COURSE OF THE HVAC WORK SHALL BE REPAIRED TO MATCH NEW AND/OR EXISTING CONDITIONS.
- CONTRACTOR SHALL COORDINATE THE INSTALLATION OF ALL MECHANICAL EQUIPMENT, DUCTWORK, ETC. TO FIT WITHIN THE SPACE ALLOWED BY THE ARCHITECTURAL AND STRUCTURAL CONDITIONS. CUTTING OR OTHERWISE ALTERING ANY STRUCTURAL MEMBERS SHALL NOT BE PERMITTED WITHOUT WRITTEN PERMISSION FROM THE ARCHITECT.
- MOUNT THERMOSTATS 42" AFF UNLESS NOTED OTHERWISE. PROVIDE CLEAR LOCKING COVER ASSEMBLIES FOR ALL THERMOSTATS.
- ALL ROOFTOP MOUNTED EQUIPMENT SHALL BE INSTALLED LEVEL ON AND ANCHORED TO MINIMUM 14" HIGH INSULATED ROOF CURBS. CONTRACTOR SHALL COORDINATE ROOF SLOPE AND ACTUAL CURB HEIGHTS WITH ARCHITECTURAL DRAWINGS. ALL REFERENCES TO ROOF HEIGHTS REFER TO HEIGHTS ABOVE FINISHED ROOF SURFACE.
- LOCATIONS OF GRILLES, REGISTERS, & DIFFUSERS SHOWN ON THE DRAWINGS ARE APPROXIMATE. COORDINATE EXACT LOCATIONS WITH LIGHTS, CEILING GRID, ETC.
- ROOFTOP HVAC UNITS SHALL BE INSTALLED SUCH THAT ROOF DECK IS COMPLETE AND CONTINUOUS UNDER BOTTOMS OF HVAC UNITS, AND SHALL BE CUT ONLY FOR UNIT SUPPLY AND RETURN OPENINGS. SPACE BETWEEN ROOF DECK AND BOTTOM OF ROOFTOP HVAC UNITS (INSIDE OF ROOF CURBS) SHALL BE FILLED WITH HIGH DENSITY ACOUSTICAL INSULATION.
- DUCTWORK CONNECTING KITCHEN EXHAUST HOODS TO ROOFTOP EXHAUST FANS SHALL BE CONSTRUCTED OF BLACK STEEL WITH WELDED SEAMS, 16 GAUGE FOR EXHAUST. ALL DUCTWORK SHALL BE CONSTRUCTED AND INSTALLED ACCORDING TO REQUIREMENTS OF LOCAL CODE AUTHORITIES AND NFPA-96 REQUIREMENTS. INSTALL ACCESS DOORS AT EACH CHANGE OF DIRECTION.
- KITCHEN HOOD EXHAUST DUCTWORK SHALL BE INSULATED PER NFPA 96 AND LOCAL CODE REQUIREMENTS.

HVAC LEGEND

SYMBOL	DESCRIPTION	ABBREVIATIONS
----	ABOVE FINISHED FLOOR	AFF
	AIR EXTRACTOR	----
----	BRAKE HORSEPOWER	BHP
----	BOTTOM OF DUCT	BOD
----	BRITISH THERMAL UNIT	BTU
	CEILING DIFFUSER	CD
	CEILING RETURN GRILLE	RAG
	DIFFUSER TYPE "A" BALANCED FOR 200 CFM	A/200
----	DRY BULB	DB
14x12	DUCT SIZE (RECTANGULAR)	----
8"	DUCT SIZE (ROUND)	----
----	ENERGY EFFICIENCY RATING	EER
----	ENTERING AIR TEMPERATURE	EAT
	EQUIPMENT NUMBER DESIGNATION (EF--1)	----
----	EXHAUST FAN	EF
----	EXTERNAL STATIC PRESSURE (IN. W.C.)	ESP
----	HORSEPOWER	HP
----	INCHES WATER COLUMN	IN. W.C.
----	KILOWATT	KW
----	LEAVING AIR TEMPERATURE	LAT
	MANUAL VOLUME DAMPER	MVD
----	THOUSAND BTU/HOUR	MBH
	NEGATIVE PRESSURE DUCT OR OUTLET	----
----	OUTSIDE AIR	O/A
----	PACKAGED ROOFTOP UNIT	RTU
	POSITIVE PRESSURE DUCT OR OUTLET	----
	REMOTE HUMIDITY SENSOR	----
	REMOTE TEMPERATURE SENSOR	----
----	RETURN AIR	R/A
	RISE	R
----	SEASONAL ENERGY EFFICIENCY RATING	SEER
	SMOKE DETECTOR	SD
	SPIN IN FITTING W/ DAMPER & FLEX DUCTWORK	----
----	SUPPLY AIR	S/A
----	SUPPLY FAN	SF
----	TO BE DETERMINED (FUTURE TENANT)	TBD
	THERMOSTAT	T'STAT
----	UNDERCUT (DOOR) 1"	U/C 1"
----	WET BULB	WB

SCHEDULE – AIR DISTRIBUTION

TAG	SERIES	CFM	DUTY	NECK	SIZE	DAMPER	MATERIAL	DESCRIPTION
A	TMS-AA	SEE DWGS	SUPPLY	SEE DWGS	24x24	YES	ALUMINUM	1
B	TMS-AA	50-100	SUPPLY	SEE DWGS	12x12	YES	ALUMINUM	1
C	TMR-AA	250-350	SUPPLY	10"	18"	YES	ALUMINUM	2
D	CT-700L	100	XFER	8x8	10x10	NO	ALUMINUM	6
E	50F	75-150	EXHAUST	6x6	8x8	NO	ALUMINUM	3
F	50F	SEE DWGS	RETURN	22x22	24x24	NO	ALUMINUM	3
G	PAS-AA	300	SUPPLY	10"	24x24	YES	ALUMINUM	4
H	300 FS	250	SUPPLY	8x8	10x10	YES	ALUMINUM	5
NOTES: A. REFER TO ARCHITECTURAL DRAWINGS FOR TYPE OF CEILING AND/OR SUSPENSION SYSTEM. B. FINISH SHALL BE OF THE TYPE AND COLOR SELECTED BY ARCHITECT. SUBMIT FINISH CHART WITH SHOP DRAWINGS. DESCRIPTION: 1. LOUVER FACE, HIGH PERFORMANCE, ROUND NECK, SQUARE DIFFUSER. 2. LOUVERED ROUND SUPPLY AIR GRILLE. 3. 1/2" X 1/2" X 1/2" EGGRATE RETURN / EXHAUST GRILLE. 4. PERFORATED FACE, 3-WAY BLOW, ROUND NECK, SQUARE DIFFUSER. 5. DOUBLE DEFLECTION SIDEWALL SUPPLY GRILLE. 6. V-BLADE DOOR GRILLE. PROVIDE ADDITIONAL TRIM ON INSIDE OF DOOR OPENING. SELECTIONS ARE BASED ON PRODUCTS BY TITUS. EQUAL PRODUCTS: KRUEGER, CARNES, METAL*WIRE & PRICE.								

SCHEDULE – PROPANE ROOFTOP UNIT

TAG	MODEL No.	TOTAL CFM	MIN. O.A. CFM	ESP	FAN BHP	MBH TOT. COOL	MBH SEN. COOL	E.A.T. db/wb	L.A.T. db/wb	SEER	VOLTAGE	HZ./ø	MCA	MOCP	MBH LP IN	MBH LP OUT	WEIGHT (LB)	ACCESSORIES
RTU-1	48FEDN12	4000	1000	0.75"	2.65	125.8	96.2	80/67	58/57	15.0	208-230	60/3	58	70	180	148	1004	1,2,3,4,5,6,7,8,10
RTU-2	48FEEN14	5000	1250	0.75"	4.65	147.6	109.0	80/67	60/58	15.0	208-230	60/3	69	80	224	181	1137	1,2,3,4,5,6,7,8,10
RTU-3	48FEEN07	2400	600	0.5"	1.32	72.4	55.6	80/67	59/58	15.5	208-230	60/3	31	45	110	88	673	1,2,3,4,5,6,7,8,10
RTU-4	48FEEB06	2000	500	0.5"	1.07	59.3	44.7	80/67	59/58	14.0	208-230	60/3	31	45	110	88	613	1,2,3,4,5,6,7,8,10
RTU-5	TO BE DETERMINED (FUTURE TENANT)																	
RTU-6	48FEEB06	2000	500	0.5"	1.07	59.3	44.7	80/67	59/58	14.0	208-230	60/3	31	45	110	88	613	1,2,3,4,5,6,7,8,9,10
RTU-7	-	3100	2000	SEE SHEET M302														
RTU-8	48FEDN08	3000	750	0.5"	1.45	89.6	65.3	80/67	60/58	15.0	208-230	60/3	37	45	125	103	874	1,2,3,4,5,6,7,8,10
ACCESSORIES:																		
1. 14" HIGH INSULATED ROOF CURB, DISCONNECT SWITCH AND 120 VOLT GFI OUTLET.																		
2. SMOKE DETECTOR IN SUPPLY AIR DUCT OR AS REQUIRED BY LOCAL CODE / AMMEMNDMENTS.																		
3. ECONOMIZER WITH DIFFERENTIAL ENTHALPY CONTROLS.																		
4. THERMOSTAT AND HUMIDISTAT WITH REMOTE TEMPERATURE SENSOR.																		
5. PROVIDE PROPANE CONVERSION KIT.																		
6. "HUMIDIMIZER" LIQUID AND HOT GAS RE-HEAT OPTION.																		
7. R-454B REFRIGERANT AND DISSIPATION BOARD AND LEAK SENSOR.																		
8. FAN SHALL RUN CONTINUOUSLY DURING HOURS OF OCCUPANCY.																		
9. INTERLOCK WITH HOOD CONTROLS TO SHUT DOWN UNIT UPON ACTIVATION OF FIRE SUPPRESSION SYSTEM.																		
10. PROVIDE FLOAT SWITCH IN DRAIN PAN WIRED TO DE-ENERGIZE THE UNIT UPON DETECTION OF WATER.																		
SELECTIONS ARE BASED ON PRODUCTS BY CARRIER.																		
EQUAL PRODUCTS: TRANE.																		

SCHEDULE – AIR BALANCE

TAG	EXHAUST CFM	OUTSIDE AIR CFM
KEF-1 (KFC)	1125	-
KEF-2 (KFC)	1125	-
KEF-3 (SBARRO)	1800	-
KEF-4 (FUTURE)	TBD	-
TEF-1 (SHOWERS)	800	-
TEF-2 (RESTROOMS)	900	-
RTU-1	-	1000
RTU-2	-	1250
RTU-3	-	600
RTU-4	-	500
RTU-5	-	TBD
RTU-6	-	500
RTU-7	-	2000
RTU-8	-	750
TOTALS	TBD	TBD
BUILDING TOTALS	TO BE DETERMINED	

SCHEDULE – FANS

TAG	MODEL	DUTY	CFM	E.S.P.	MOTOR SIZE	RPM	DRIVE	WEIGHT (Lb)	ACCESSORIES
TEF-1	DX08B	EXHAUST	800	0.25"	1/6 HP	1240	BELT	35	1,2,3,4,5
TEF-2	DX08B	EXHAUST	900	0.25"	1/4 HP	1350	BELT	35	1,2,3,4,5
ACCESSORIES: 1. GRAVITY BACKDRAFT DAMPERS. 2. WIRE FOR CONTINUOUS OPERATION DURING BUILDING OCCUPIED MODE. 3. DISCONNECT SWITCH. 4. 14" HIGH INSULATED ROOF CURB. 5. BIRD SCREEN. SELECTIONS ARE BASED ON PRODUCTS BY PENN. EQUAL PRODUCTS: GREENHECK, CARNES, JENNAIRE, COOK, AMMERIAN.									

OUTSIDE AIR / EXHAUST VENTILATION COMPLIANCE

UNIT NUMBER	AREA CLASSIFICATION	AREA (SQ. FT.)	NO. OF PEOPLE PER 1000 SQ. FT. (TABLE 403.3)	PEOPLE QUANTITY	AIRFLOW PER PERSON (TABLE 403.3)	AIRFLOW PER SQ. FT. (TABLE 403.3)	TOTAL OUTSIDE AIR REQUIRED (CFM)	OUTSIDE AIR PROVIDED (CFM)	EXHAUST AIR REQUIRED (CFM)**	EXHAUST AIR PROVIDED (CFM)
RTU-1 & 2	SALESFLOOR	2660	15	40	7.5	0.12	620			
	CASHER	475	-	5	7.5	0.12	95			
	CORRIDOR	640	-	-	-	0.06	38			
	SEATING AREA	1835	70	128	7.5	0.18	1294	2250		
	LOUNGE	250	30	7.5	5	0.06	53			
RTU-3	CORRIDOR	340	-	-	-	0.06	21			
	STORAGE	100	-	-	-	0.06	6			
	GAMING	200	20	4	7.5	0.18	66	600		
RTU-4	BREAKROOM	250	30	7.5	5	0.06	53			
	CORRIDOR	308	-	-	-	0.06	19			
	STORAGE	425	-	-	-	0.06	26	500		
RTU-5	TO BE DETERMINED (FUTURE TENANT)									
RTU-6	SERVING	195	-	2	7.5	0.12	38			
	OFFICE	56	5	1	5	0.06	8			
	KITCHEN	340	20	7	7.5	0.12	92			
	STORAGE	200	-	-	-	0.06	12	500		
RTU-7	SERVING	200	-	2	7.5	0.12	38			
	OFFICE	145	5	1	5	0.06	14			
	KITCHEN	707	20	14	7.5	0.12	191			
	STORAGE	250	-	-	-	0.06	15	2000		
RTU-8	CAFE	760	-	25	7.5	0.18	324			
	SERVING	307	-	3	7.5	0.12	60			
	WORKROOM	350	-	3	7.5	0.12	65	750		
TEF-1	SHOWERS	675							560	800
TEF-2	RESTROOMS	820							600	900
KEF-1&2	KFC KITCHEN	707							495	2250
KEF-3	SBARRO KITCHEN	340							238	1800
KEF-4	TO BE DETERMINED (FUTURE TENANT)									
TOTALS							TBD	TBD	TBD	TBD
NOTES: 1. CALCULATIONS BASED ON INTERNATIONAL MECHANICAL CODE TABLE 403.3. 2. KITCHEN 0.7 CFM/SF, RESTROOMS PER TABLE 403.3 FOOTNOTE "E" & "F" 50 CFM PER WC & URINAL, 20 CFM PER SHOWER HEAD, CONTINUOUS EXHAUST.										

ARCHITECT OF RECORD:

THOMAS E. MORGAN, JR.
ARCHITECT

423 FISCHER TRAIL
ELLIJAY, GEORGIA 30540

SEAL:



MRP
DESIGN GROUP

3450 Acworth Due West Road
Building 100, Suite 120
Kennesaw, Georgia 30144
P. 770-917-9172
F. 770-917-9470
www.mrpdesign.com

RELEASED FOR
CONSTRUCTION

ISSUES / REVISIONS:

DATE	DESCRIPTION
3/11/06	PROGRESS SET
4/28/06	FOR PERMIT / CONSTRUCTION
6/15/06	STARBUCKS TENANT ADDITION AND UTILITY ROOM COORDINATION

DRAWN BY: JWE

CHKD BY: JWE

PROJECT DESCRIPTION:

THE DEVELOPMENT AND CONSTRUCTION OF A C-STORE LAYOUT, WHICH INCLUDES RETAIL SPACE, STORAGE, DRINK COOLER, BEER CAVES, DRINKING STATIONS, BREAK ROOM, TRUCKER LOUNGE AND RESTROOMS, PUBLIC RESTROOMS AND 4 QSR'S WITH WALK IN COOLERS AND FREEZERS .

PROJECT TITLE:

TRAVEL CENTER
5524 GA HIGHWAY 96 W
JEFFERSONVILLE
GEORGIA 31044


SHEET TITLE:

NOTES, SCHEDULES,
LEGEND - HVAC

PROJECT NO: 25021

M000

THESE PLANS ARE THE PROPERTY OF MRP DESIGN GROUP, INC. AND ARE SUBJECT TO FEDERAL COPYRIGHT LAWS. ANY USE OF SAME WITHOUT THE EXPRESS WRITTEN PERMISSION OF MRP DESIGN GROUP, INC. IS STRICTLY PROHIBITED.

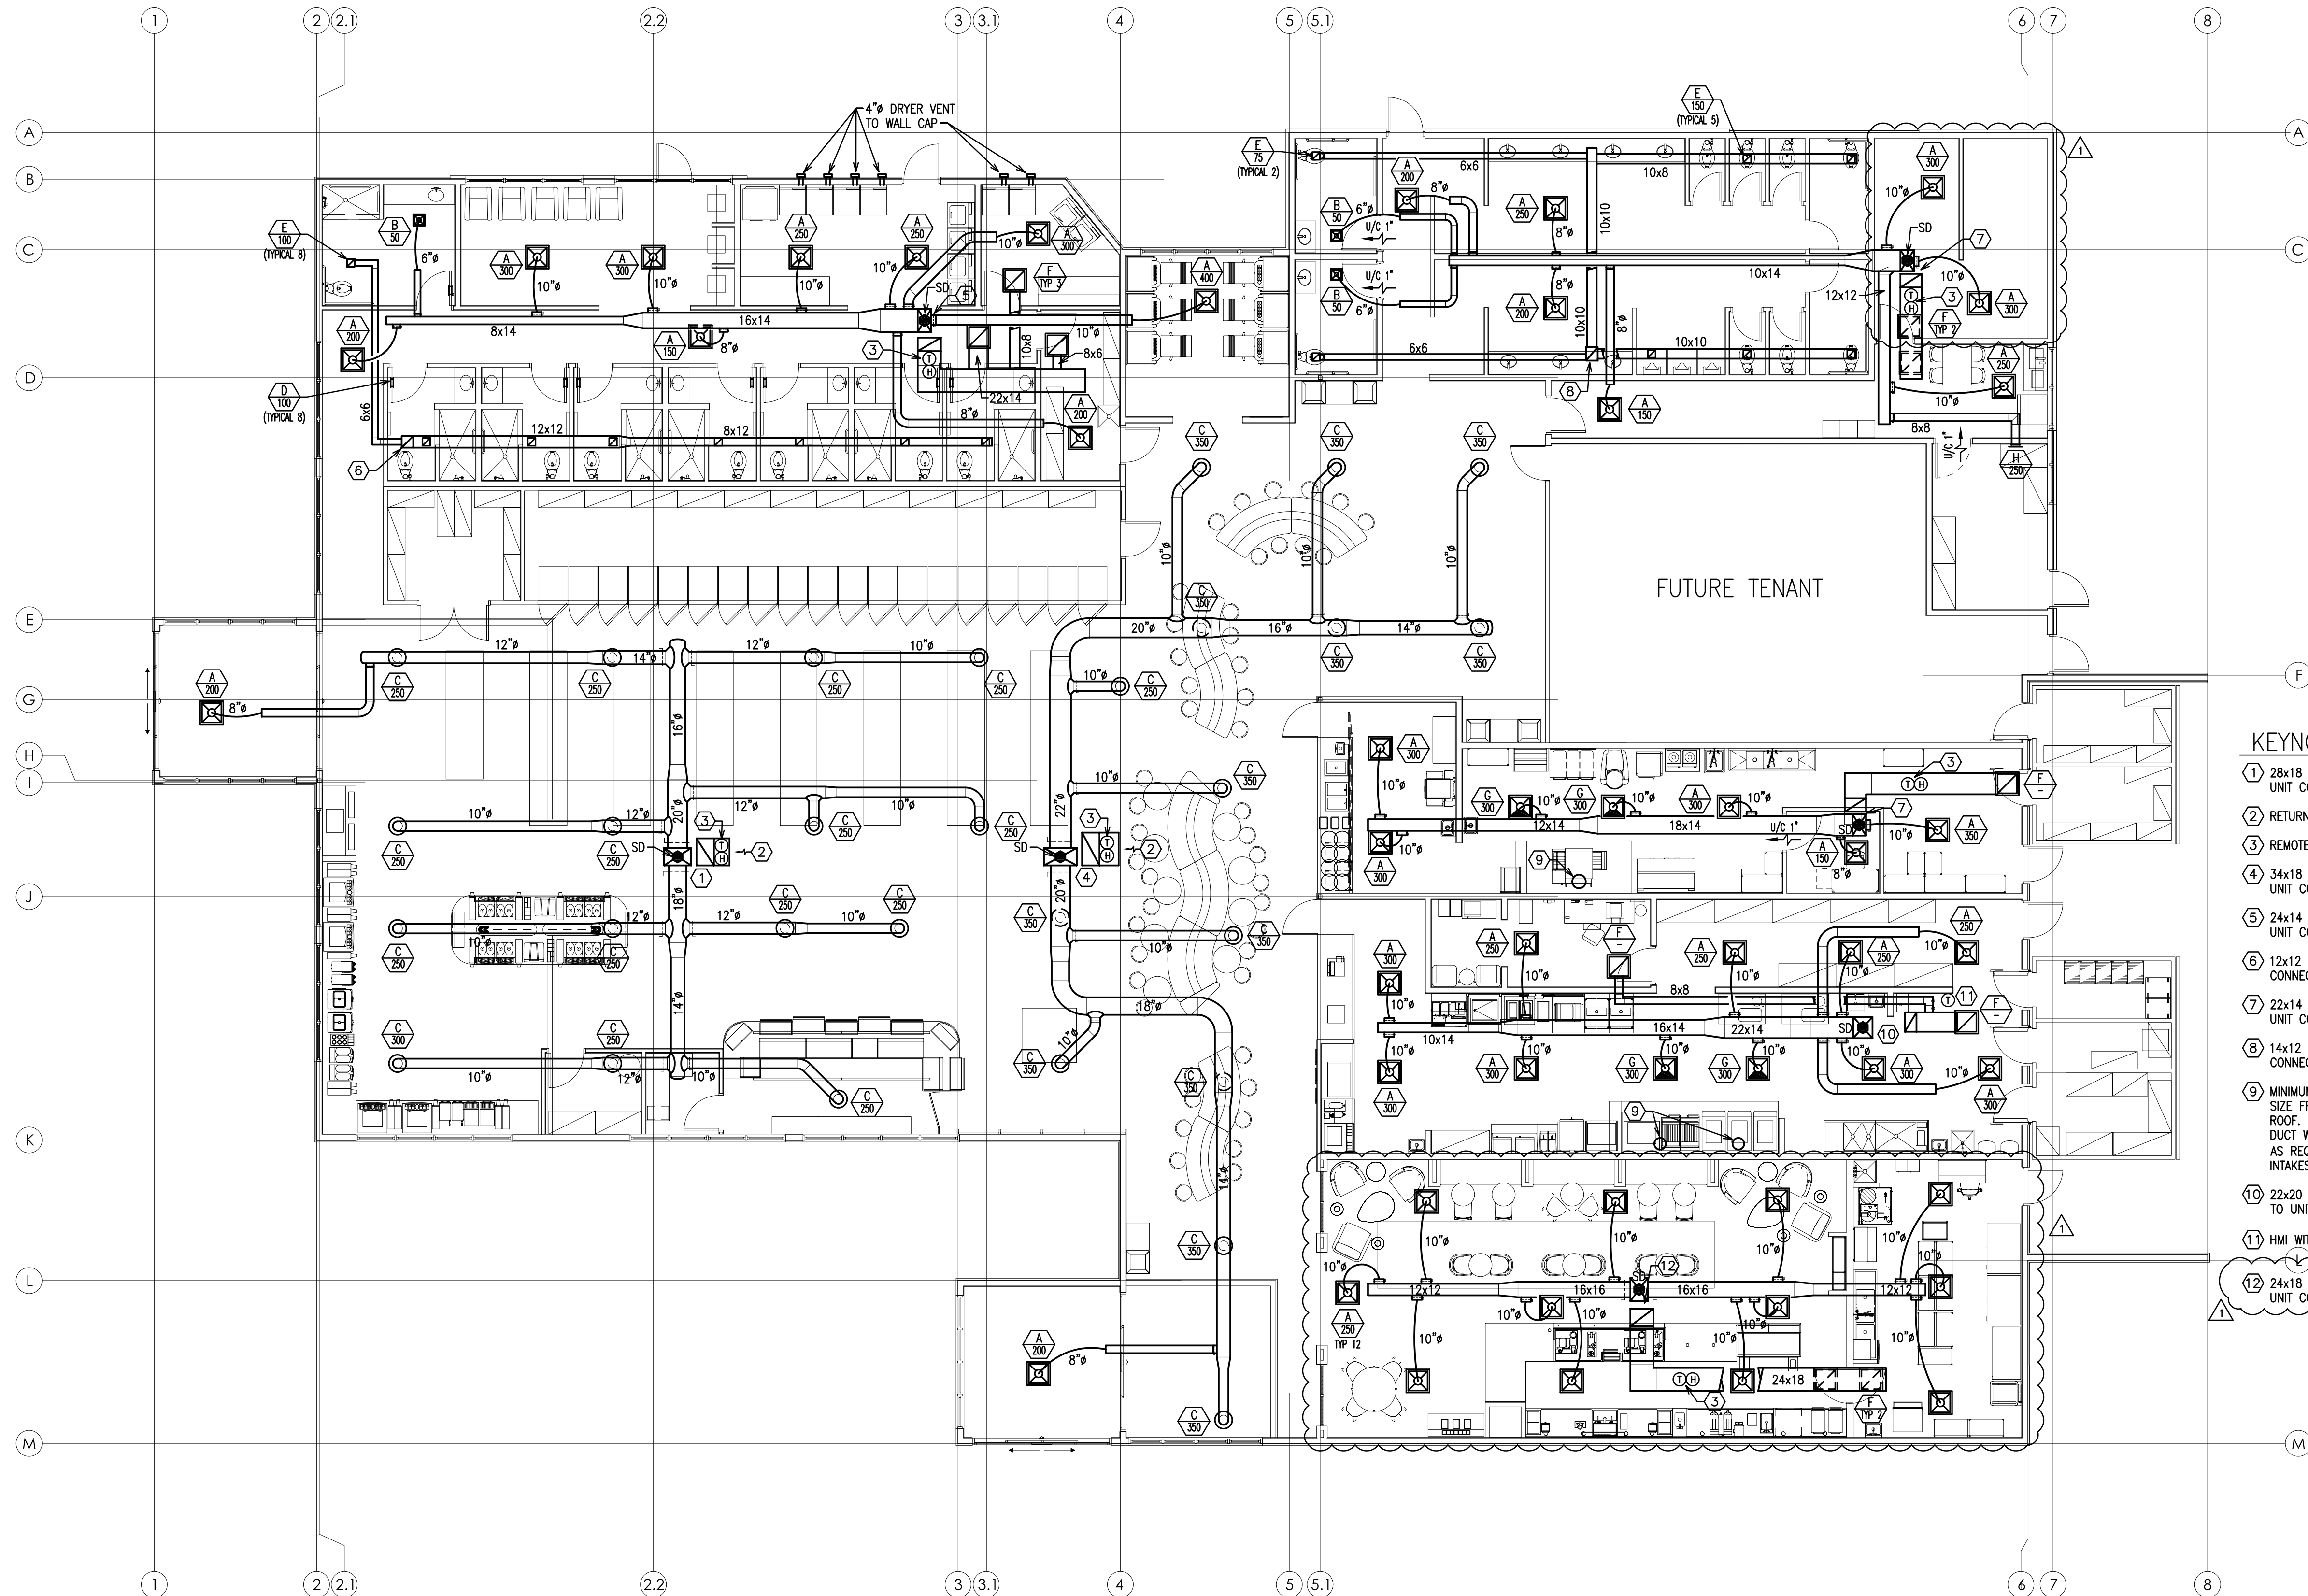

1 FLOOR PLAN - HVAC
M100 SCALE: 1/8"=1'-0"

ARCHITECT OF RECORD:

THOMAS E. MORGAN, JR.
ARCHITECT

423 FISCHER TRAIL
ELLIJAY, GEORGIA 30540

SEAL:



MRP
DESIGN GROUP

3450 Acworth Due West Road
Building 100, Suite 120
Kennesaw, Georgia 30144
P. 770-917-9172
F. 770-917-9470
www.mrpdesign.com

RELEASED FOR
CONSTRUCTION

ISSUES / REVISIONS:	
DATE	DESCRIPTION
3/1/06	PROGRESS SET
4/28/06	FOR PERMIT / CONSTRUCTION
6/15/06	STARBUCKS TENANT ADDITION AND UTILITY ROOM COORDINATION

DRAWN BY: JWE
CHKD BY: JWE

PROJECT DESCRIPTION:

THE DEVELOPMENT AND
CONSTRUCTION OF A
C-STORE LAYOUT, WHICH
INCLUDES RETAIL SPACE,
STORAGE, DRINK COOLER,
BEER CAVES, DRINKING
STATIONS, BREAK ROOM,
TRUCKER LOUNGE AND
RESTROOMS, PUBLIC
RESTROOMS AND 4 QSR'S
WITH WALK IN COOLERS AND
FREEZERS .

PROJECT TITLE:

TRAVEL CENTER
5524 GA HIGHWAY 96 W
JEFFERSONVILLE
GEORGIA 31044


SHEET TITLE:

FLOOR PLAN - HVAC

PROJECT NO: 25021

M100

THESE PLANS ARE THE PROPERTY OF MRP DESIGN GROUP, INC. AND ARE SUBJECT TO FEDERAL COPYRIGHT LAWS. ANY USE OF SAME WITHOUT THE EXPRESS WRITTEN PERMISSION OF MRP DESIGN GROUP, INC. IS STRICTLY PROHIBITED.

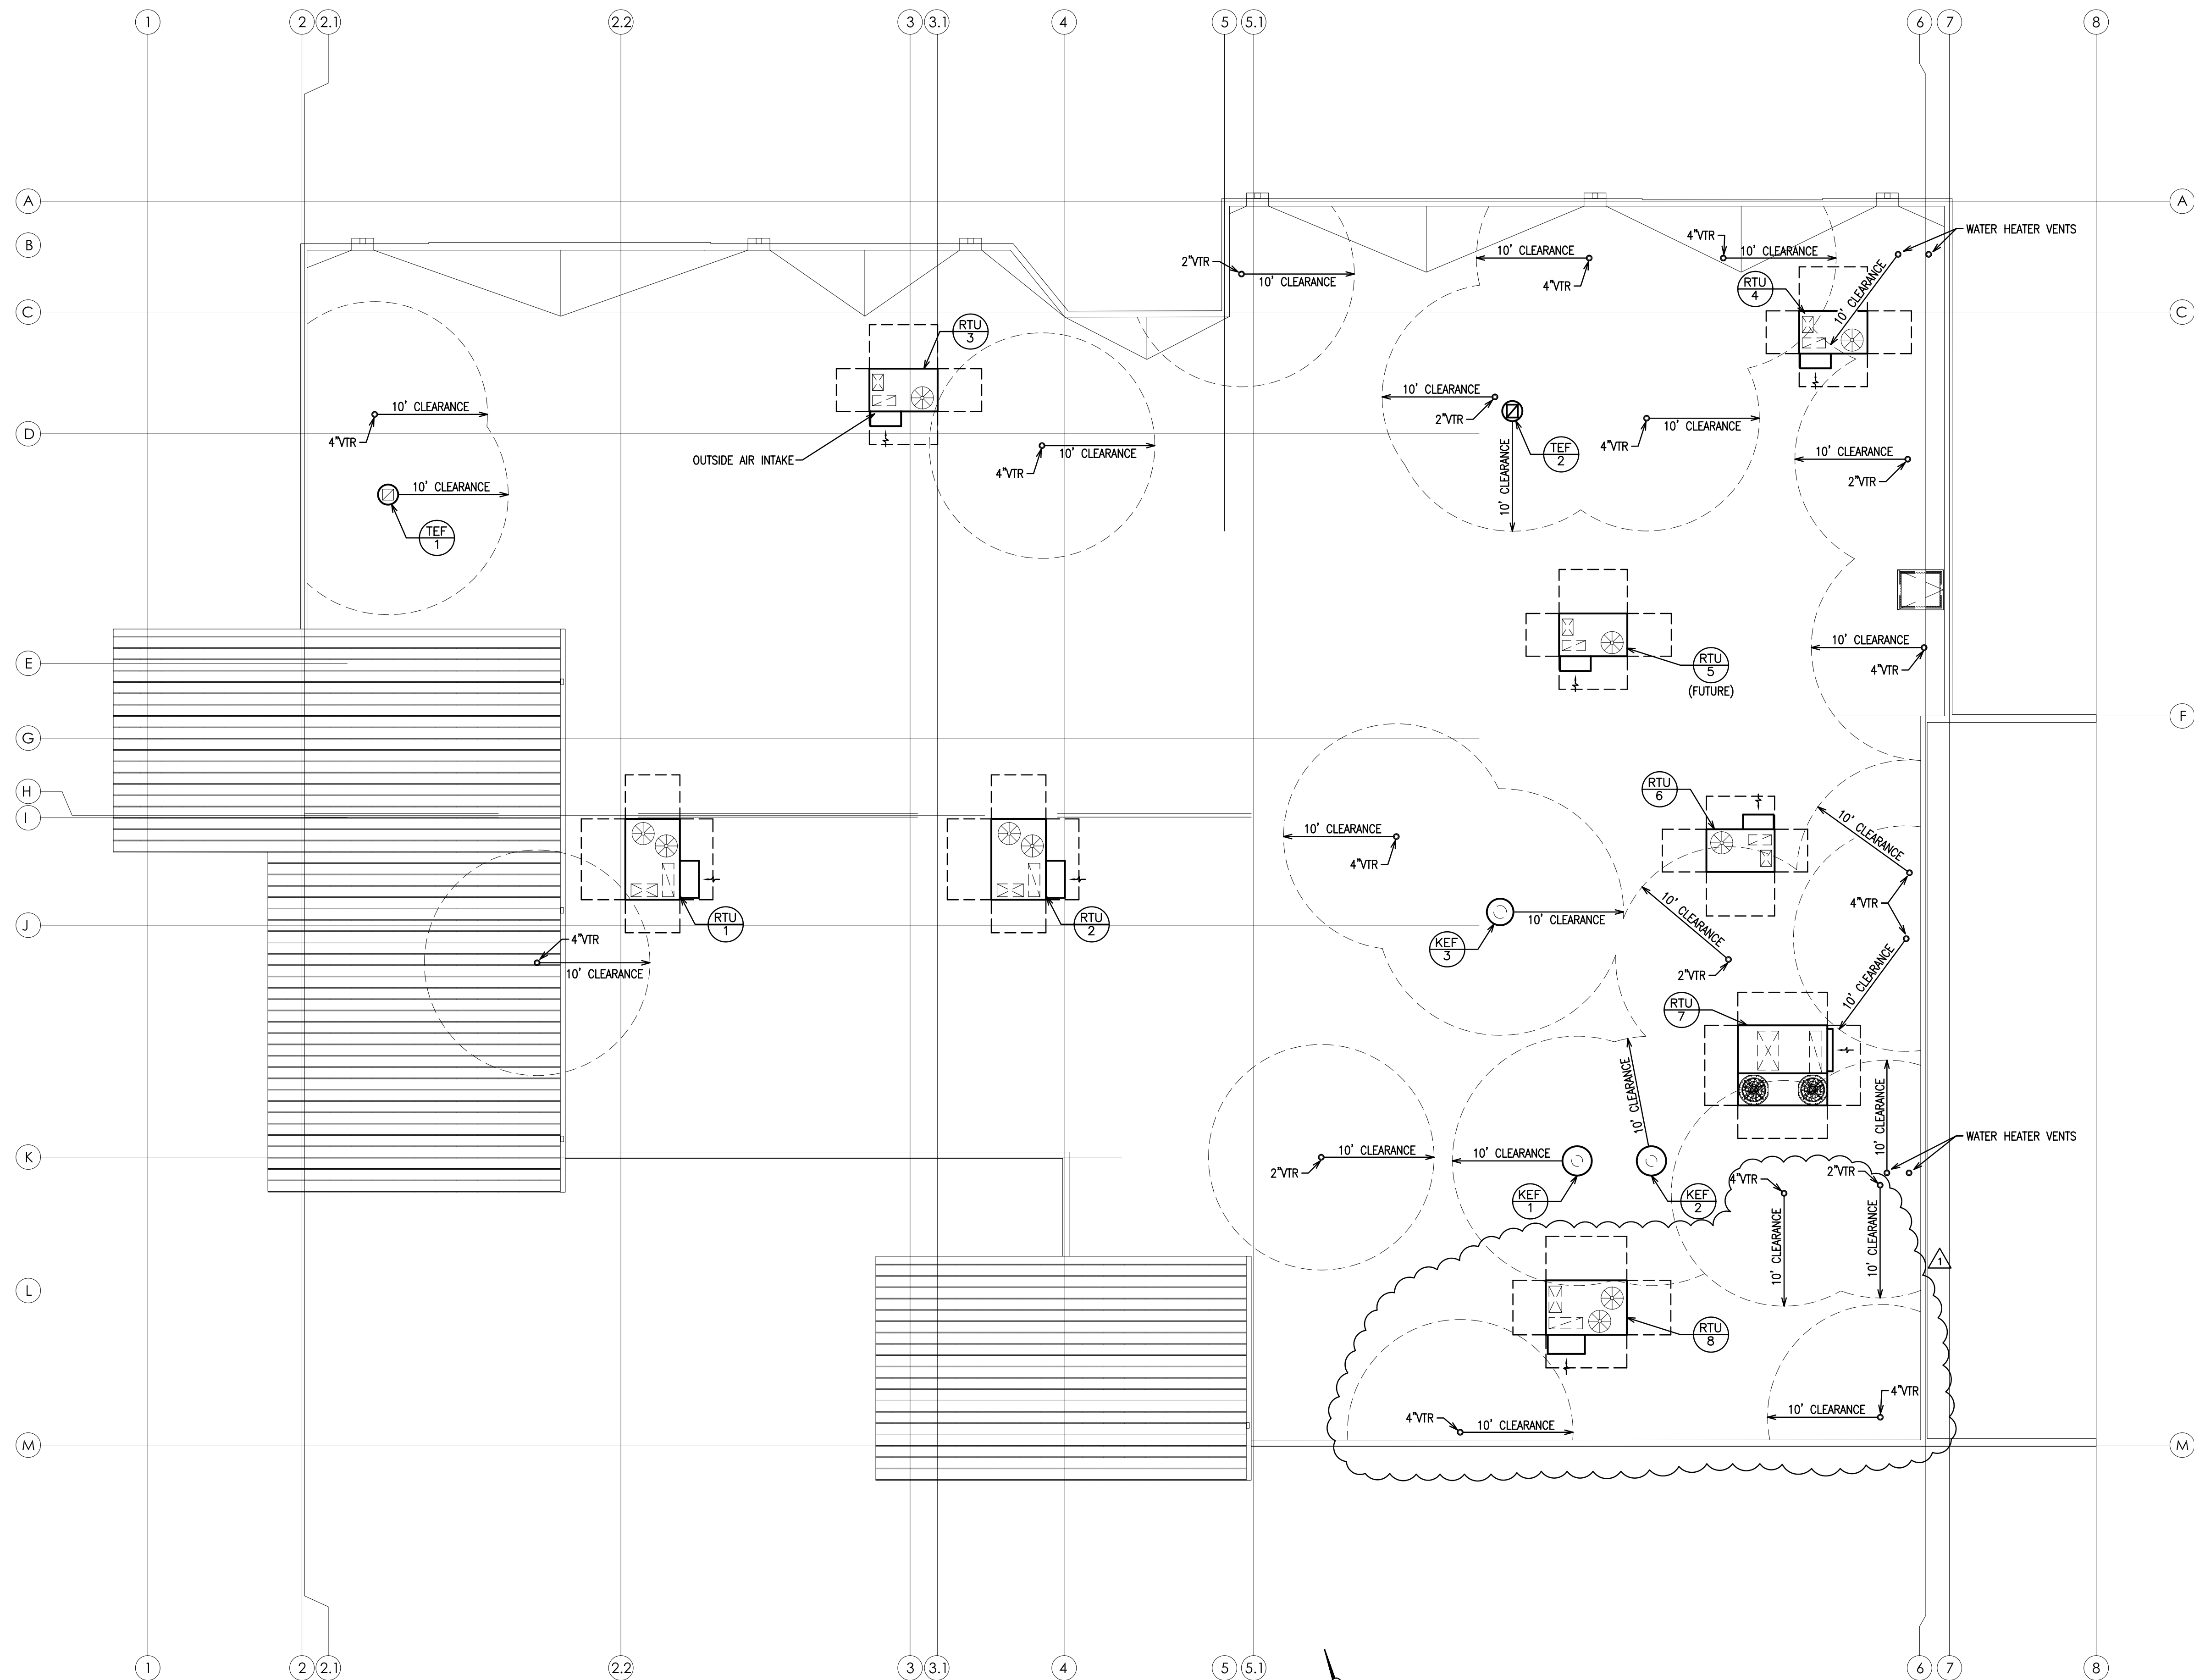

1
M101

ROOF PLAN - HVAC

SCALE: 1/8"=1'-0"

ARCHITECT OF RECORD:

THOMAS E. MORGAN, JR.
ARCHITECT

423 FISCHER TRAIL
ELLIJAY, GEORGIA 30540

SEAL:



3450 Acworth Due West Road
Building 100, Suite 120
Kennesaw, Georgia 30144
P. 770-917-9172
F. 770-917-9470
www.mrpdesign.com

RELEASED FOR
CONSTRUCTION

ISSUES / REVISIONS:	
DATE	DESCRIPTION
3/11/06	PROGRESS SET
4/28/06	FOR PERMIT / CONSTRUCTION
6/15/06	STARBUCKS TENANT ADDITION AND UTILITY ROOM COORDINATION

DRAWN BY: JWE

CHK'D BY: JWE

PROJECT DESCRIPTION:
THE DEVELOPMENT AND
CONSTRUCTION OF A
C-STORE LAYOUT, WHICH
INCLUDES RETAIL SPACE,
STORAGE, DRINK COOLER,
BEER CAVES, DRINKING
STATIONS, BREAK ROOM,
TRUCKER LOUNGE AND
RESTROOMS, PUBIC
RESTROOMS AND 4 QSR'S
WITH WALK IN COOLERS AND
FREEZERS .

PROJECT TITLE:

TRAVEL CENTER
5524 GA HIGHWAY 96 W
JEFFERSONVILLE
GEORGIA 31044

SHEET TITLE:

ROOF PLAN - HVAC

PROJECT NO: 25021

M101

THESE PLANS ARE THE PROPERTY OF MRP DESIGN GROUP, INC. AND ARE SUBJECT TO FEDERAL COPYRIGHT LAWS. ANY USE OF SAME WITHOUT THE EXPRESS WRITTEN PERMISSION OF MRP DESIGN GROUP, INC. IS STRICTLY PROHIBITED.

1

QSR : PANELS MDP3, K1, K2, ST1 & ST2 LOAD SUMMARY				
<u>CONN VA</u>		<u>DEMAND VA</u>		
<u>PANEL'MDP3':</u>				
LIGHTING:	7800	x	125%	= 9750
RECEPTACLE:	14120	x	85%	= 12060
MISC:	11200	x	80%	= 8960
HVAC:	2100	x	100%	= 2100
WTR HTR:	24000	x	80%	= 19200
REFRIGERATION:	11200	x	100%	= 11200
FOOD SERV:	134200	x	65%	= 87230
	183960/360=			150500/360=
	511A			418A
418A x 125% = 523A				
THEREFORE, SIZE THE PANEL MDP3, PANEL FEEDER, PANEL FEEDER				
MAIN DISCONNECT SWITCH, DS3 FOR <u>600A</u> .				

KFC: PANELS K1 & K2 LOAD SUMMARY				
<u>PANEL'K1':</u>				
LIGHTING:	3500	x	125% =	4375
RECEPTACLE:	7200	x	100% =	7200
MISC:	10000	x	80% =	8000
HVAC:	2100	x	100% =	2100
REFRIGERATION:	11200	x	100% =	11200
FOOD SERV:	66500	x	65% =	43225
	100500/360=			76100/360=
	279A			211A
211A x 125% = 264A THEREFORE, SIZE THE KFC PANEL K1, PANEL FEEDER, PANEL FEEDER CIRCUIT BREAKER FOR <u>300A</u> .				
<u>PANEL'K2':</u>				
FOOD SERV:	29700	x	65% =	19305
	29700/360=			19305/360=
	83A			54A
54A x 125% = 67A THEREFORE, SIZE THE KFC PANEL 'K2', PANEL FEEDER, PANEL FEEDER CIRCUIT BREAKER FOR <u>100A</u> .				

STARBUCKS: PANELS ST1 & ST2 LOAD SUMMARY				
<u>PANEL'ST1':</u>				
LIGHTING:	4300	x	125% =	5375
RECEPTACLE:	6920	x	100% =	6920
MISC:	1200	x	100% =	1200
WTR HTR:	24000	x	80% =	19200
FOOD SERV:	67700	x	65% =	44005
	104120/360=			76700/360=
	289A			213A
213A x 125% = 266A THEREFORE, SIZE THE STARBUCKS PANEL ST1, PANEL FEEDER, PANEL FEEDER CIRCUIT BREAKER FOR <u>300A</u> .				
<u>PANEL'ST2':</u>				
RECEPTACLE:	4300	x	100% =	4300
LIGHTING:	3500	x	125% =	4375
FOOD SERV:	15600	x	65% =	10140
	23400/360=			18815/360=
	65A			52A
52A x 125% = 65A THEREFORE, SIZE THE STARBUCKS PANEL 'ST2', PANEL FEEDER, PANEL FEEDER CIRCUIT BREAKER FOR <u>100A</u> .				

TRAVEL CENTER: MAIN DISCONNECT SWITCH, MDS LOAD SUMMARY				
	CONN VA		DEMAND VA	
<u>PANEL'MDS':</u>				
LIGHTING:	50000	x	125%	= 62500
RECEPTACLE:	39360	x	63%	= 24680
HVAC:	123800	x	80%	= 99040
REFRIGERATION:	42400	x	100%	= 42400
FOOD SERV:	319360	x	65%	= 207585
FUEL SERV EQ:	24680	x	100%	= 24680
MISC:	<u>69940</u>	x	70%	= <u>48960</u>
	273792/360=			509845/360=
TOTAL PANEL 'MDS'	761A			1416A
1416A x 125% = 1770A				
THEREFORE, SIZE SERVICE FEEDER AND SERVICE MAIN DISCONNECT SWITCH, MDS FOR <u>2000A</u> .				

QSR : PANELS MDP2, A1, A2 & SB LOAD SUMMARY				
<u>CONN VA</u>		<u>DEMAND VA</u>		
<u>XXX PANEL'MDP2':</u>				
LIGHTING:	6600	x	125%	= 8250
RECEPTACLE:	9300	x	100%	= 9300
HVAC:	4700	x	100%	= 4700
REFRIGERATION:	9500	x	100%	= 9500
FOOD SERV:	<u>113900</u>	x	65%	= <u>74035</u>
	98400/360=			105785/360=
	273A			294A
294A x 125% = 367A				
THEREFORE, SIZE THE PANEL MDP2, PANEL FEEDER, PANEL FEEDER				
MAIN DISCONNECT SWITCH, DS2 FOR <u>400A</u> .				

ARBY'S: PANELS A1 & A2 LOAD SUMMARY				
<u>XXX PANEL'A1':</u>				
LIGHTING:	3400	x	125% =	4250
RECEPTACLE:	7200	x	100% =	7200
HVAC:	2900	x	100% =	2900
REFRIGERATION:	6300	x	100% =	6300
FOOD SERV:	66500	x	65% =	43225
	86300/360=			63875/360=
	240A			177A
177A x 125% = 222A THEREFORE, SIZE THE ARBY'S PANEL A1, PANEL FEEDER, PANEL FEEDER CIRCUIT BREAKER FOR <u>300A</u> .				
<u>XXX PANEL'A2':</u>				
FOOD SERV:	29700	x	65% =	19305
	29700/360=			19305/360=
	83A			54A
54A x 125% = 67A THEREFORE, SIZE THE ARBY'S PANEL 'A2', PANEL FEEDER, PANEL FEEDER CIRCUIT BREAKER FOR <u>100A</u> .				

SBARROS: PANEL SB LOAD SUMMARY				
<u>XXX PANEL'SB':</u>				
LIGHTING:	3200	x	125% =	4000
RECEPTACLE:	2100	x	100% =	2100
HVAC:	1800	x	100% =	1800
REFRIGERATION:	3200	x	100% =	3200
FOOD SERV:	47400	x	65% =	30810
	57700/360=			41910/360=
	160A			116A
116A x 125% = 146A THEREFORE, SIZE THE SBARROS PANEL SB, PANEL FEEDER, PANEL FEEDER CIRCUIT BREAKER FOR <u>150A</u> .				

TRAVEL CENTER: PANEL H LOAD SUMMARY				
<u>CONN VA</u>		<u>DEMAND VA</u>		
XXX <u>PANEL'H'</u> :				
HVAC:	112400	x	80%	= 88920
	112400/360=			88920/360=
	312A			250A
250A x 125% = 312A				
THEREFORE, SIZE THE PANEL H, PANEL FEEDER, PANEL FEEDER				
MAIN CIRCUIT BREAKER FOR <u>400A</u> .				

WAITING FOR ARBY'S
LOADS TO COMPLETE
CALCULATIONS

TRAVEL CENTER: PANELS MDP1, 'L1/L1A', L2, L3/L3A, L4 & 'L5' LOAD SUMMARY				
	CONN VA		DEMAND VA	
<u>PANEL'MDP1':</u>				
LIGHTING:	36400	x	125%	= 45500
RECEPTACLE:	16100	x	81%	= 13050
HVAC:	1500	x	100%	= 1500
REFRIGERATION:	21700	x	100%	= 21700
FOOD SERV:	79700	x	65%	= 51805
FUEL SERV EQ:	24680	x	100%	= 24680
MISC:	49100	x	50%	= 24550
	273792/360=			182785/360=
TOTAL PANEL 'MDP1'	761A			508A
508A x 125% = 635A THEREFORE, SIZE PANEL 'MDP1', PANEL FEEDER, PANEL MAIN DISCONNECT SWITCH, DS1 FOR <u>800A</u> .				
<u>XXX PANEL'L1/L1A':</u>				
RECEPTACLE:	16100	x	81%	= 13050
HVAC:	1500	x	100%	= 1500
REFRIGERATION:	21700	x	100%	= 21700
FOOD SERV EQ:	3100	x	65%	= 2015
MISC:	47400	x	50%	= 23700
TOTAL PANEL 'L1/L1A'	89800/360=			61965/360=
	249A			172A
172A x 125% = 215A THEREFORE, SIZE PANEL 'L1/L1A', PANEL FEEDER, PANEL FEEDER CIRCUIT BREAKER FOR <u>225A</u> .				
<u>XXX PANEL'L2':</u>				
LIGHTING:	36400	x	125%	= 45500
MISC:	1700	x	100%	= 1700
TOTAL PANEL 'L2'	38100/360=			47200/360=
	106A			131A
131A x 125% = 164A THEREFORE, SIZE PANEL 'L2', PANEL FEEDER, PANEL FEEDER CIRCUIT BREAKER FOR <u>200A</u> .				
<u>XXX PANEL'L3/L3A':</u>				
FUEL SERV EQ:	18800	x	100%	= 18800
TOTAL PANEL 'L3/L3A'	18800/120=			18800/120=
	157A			157A
157A x 125% = 196A THEREFORE, SIZE PANEL 'L3/L3A', PANEL FEEDER, PANEL FEEDER CIRCUIT BREAKER FOR <u>200A</u> .				
<u>XXX PANEL'L3B':</u>				
FUEL SERV EQ:	5880	x	100%	= 5880
TOTAL PANEL 'L3B'	5880/120=			5880/120=
	49A			49A
49A x 125% = 61A THEREFORE, SIZE PANEL 'L3B', PANEL FEEDER, PANEL FEEDER CIRCUIT BREAKER FOR <u>100A</u> .				
<u>XXX PANEL'L4':</u>				
FOOD SERV:	44400	x	65%	= 28860
TOTAL PANEL 'L4'	44400/360=			28800/360=
	123A			81A
81A x 125% = 101A THEREFORE, SIZE PANEL 'L4', PANEL FEEDER, PANEL FEEDER CIRCUIT BREAKER FOR <u>150A</u> .				
<u>XXX PANEL'L5':</u>				
FOOD SERV:	32200	x	65%	= 20930
	32200/360=			20930/360=
	89A			58A
TOTAL PANEL 'L5'				
58A x 125% = 73A THEREFORE, SIZE PANEL 'L5', PANEL FEEDER, PANEL FEEDER CIRCUIT BREAKER FOR <u>100A</u> .				

TRAVEL CENTER FAULT CURRENT CALCULATIONS

SERVICE IS BASED ON AN ESTIMATED 500KVA, PAD MOUNTED TRANSFORMER WITH A FAULT CURRENT* OF 86800 AMPS AT THE TRANSFORMER SECONDARY (FROM XFMR FC TABLE). CONTRACTOR SHALL VERIFY FAULT CURRENT AVAILABLE FROM POWER COMPANY TRANSFORMER AND MAKE ADJUSTMENTS TO EQUIPMENT AIC RATING AS REQUIRED.

1. @ MDS: L = 180 I_{sc} = 86800
 E = 208 C = 23256 (#500KCMIL CU)

f = (1.732 x 180 x 86800)/(6 x 23256) X 208 =0.932

1/1.932= 0.518

I_oMDS = .518 x 86800 = 44928 AMPS
THEREFORE, MINIMUM AIC RATING IS 65000 FOR PANEL H.

2. @ PANEL MDP1: LET-THRU 800A CLASS L FUSES: I_{sc} = 19000
 L = 10
 E = 208 C = 23256 (#500KCMIL CU)

f = (1.732 x 10 x 19000)/2 X 23256 X 208 =0.034

1/1.034= 0.967

I_oMDP1 = .967 x 19000 = 18375 AMPS
THEREFORE, MINIMUM AIC RATING IS 22000 FOR MDP1 AND ALL DOWNSTREAM PANELS MINIMUM AIC RATINGS ARE 22000 .

3. @ PANEL MDP2: LET-THRU 400A RK1 FUSES: I_{sc} = 11000
 L = 30
 E = 208 C = 23256 (#500KCMIL CU)

f = (1.732 x 30 x 11000)/2 X 23256 X 208 =0.059

1/1.059= 0.944

I_oMDP2 = .944 x 11000 = 10387 AMPS
THEREFORE, MINIMUM AIC RATING IS 22000 FOR MDP2.

4. @ PANEL A1/A2: L = 40 I_{sc} = 10387
 E = 208 C = 16670 (#350KCMIL0 CU)

f = (1.732 x 40 x 10387)/16670 X 208 =0.208

1/1.208= 0.828

I_oA1/A2 = .828 x 10387 = 8598 AMPS
THEREFORE, MINIMUM AIC RATING IS 10000 FOR A1/A2 AND SB.

5. @ PANEL MDP3: LET-THRU 600A RK1 FUSES: I_{sc} = 15500
 L = 40
 E = 208 C = 16670 (#350KCMIL CU)

f = (1.732 x 40 x 15500)/2 X 16670 X 208 =0.155

1/1.155= 0.866

I_oMDP3 = .866 x 15500 = 13420 AMPS
THEREFORE, MINIMUM AIC RATING IS 22000 FOR MDP3 AND ALL DOWNSTREAM PANELS MINIMUM AIC RATINGS ARE 22000 .

6. @ PANEL K1/K2: L = 60 I_{sc} = 13420
 E = 208 C = 16670 (#350KCMIL0 CU)

f = (1.732 x 60 x 13420)/16670 X 208 =0.402

1/1.402= 0.713

I_oK1/K2 = .713 x 13420 = 9572 AMPS
THEREFORE, MINIMUM AIC RATING IS 10000 FOR K1/K2 AND ST1/ST2.

ARCHITECT OF RECORD:

THOMAS E. MORGAN, JR.
ARCHITECT

423 FISCHER TRAIL
ELLIJAY, GEORGIA 30540

SEAL:



MRP
DESIGN GROUP

3450 Acworth Due West Road
Building 100, Suite 120
Kennesaw, Georgia 30144
P. 770-917-9172
F. 770-917-9470
www.mrpdesign.com

RELEASED FOR
CONSTRUCTION

ISSUES / REVISIONS:

DATE	DESCRIPTION
03/11/2025	PROGRESS COORDINATION
05/05/2025	FOR PERMIT CONSTRUCTION
06/26/2025	STARBUCKS TENANT ADDN & UTILITY RM REVISION

DRAWN BY: BAM
CHKD BY: JFM

PROJECT DESCRIPTION:

THE DEVELOPMENT AND
CONSTRUCTION OF A
C-STORE LAYOUT, WHICH

TRAVEL CENTER SELF-SERVE FOOD SERVICE EQUIPMENT CONNECTION SCHEDULE															
ITEM NO.	QTY	DESCRIPTION	ELECTRICAL												
			VOLTS	PHASE	KW	HP	FLA	CIRCUIT DESIG	BREAKER AMPS POLE	FEEDER	DIRECT PLUG	PLUG TYPE	NOTES		
105	1	WIC LTS	120	1			2.13	L2-6	20	1	2#12, 2#12G-3/4"C	X			1
105.1	2	WIC COND UNIT	208	3			21.9	L1A-1,3,5	40	3	3#8, 1#10G-3/4"C	X	60/3/NF/3R		2,4,6
		WIC COND UNIT	208	3			21.9	L1A-7,9,11	40	3	3#8, 1#10G-3/4"C	X	60/3/NF/3R		2,4,6
105.2	2	WIC FAN COILS	120	1			6.00	L1A-2	15	1	2#12, 2#12G-3/4"C	X	30/1/NF/3R		3
	2	WIC FAN COILS	120	1			6.00	L1A-4	15	1	2#12, 2#12G-3/4"C	X	30/1/NF/3R		3
105.3	10	WIC DOORS,HTRS	120	1			12.3	L2-12	20	1	2#12, 2#12G-3/4"C	X			1
	10	WIC DOORS,HTRS	120	1			11.1	L2-14	20	1	2#12, 2#12G-3/4"C	X			1
106	1	BEER CAVE LTS	120	1			0.53	L2-6	20	1	2#12, 2#12G-3/4"C	X			1
106.1	1	BEER CAVE COND UNIT	208	3			11.6	L1A-13,15,17	20	3	3#12, 1#12G-3/4"C	X	30/3/NF/3R		2,4,6
106.2	1	BEER CAVE EVAP COILS	120	1			3.00	L1A-6	15	1	2#12, 1#12G-3/4"C	X	30/1/NF/3R		3
106.3	2	BEER CAVE DR HTR	120	1			4.00	L2-26	20	1	2#12, 1#12G-3/4"C	X			
CO01	1	75" TV	120	1			4.20	L1A-8	20	1	2#12, 1#12G-3/4"C	X	NEMA 5-20R		
CO04	1	VENDING MACHINE	120	1			10.0	L1-31	20	1	2#12, 1#12G-3/4"C	X	NEMA 5-20R		
CO05	4	DRYER (PUBLIC LAUNDRY)	208	1			22.3	L1-8,10	30	2	2#10, 1#10G-3/4"C	X	NEMA 6-30R		
		DRYER (PUBLIC LAUNDRY)	208	1			22.3	L1-12,14	30	2	2#10, 1#10G-3/4"C	X	NEMA 6-30R		
		DRYER (PUBLIC LAUNDRY)	208	1			22.3	L1-16,18	30	2	2#10, 1#10G-3/4"C	X	NEMA 6-30R		
		DRYER (PUBLIC LAUNDRY)	208	1			22.3	L1-26,28	30	2	2#10, 1#10G-3/4"C	X	NEMA 6-30R		
CO06	4	WASHER (PUBLIC LAUNDRY)	120	1			4.20	L1-24	20	1	2#12, 1#12G-3/4"C	X	NEMA 5-20R		
		WASHER (PUBLIC LAUNDRY)	120	1			4.20	L1-13	20	1	2#12, 1#12G-3/4"C	X	NEMA 5-20R		
		WASHER (PUBLIC LAUNDRY)	120	1			4.20	L1-15	20	1	2#12, 1#12G-3/4"C	X	NEMA 5-20R		
		WASHER (PUBLIC LAUNDRY)	120	1			4.20	L1-17	20	1	2#12, 1#12G-3/4"C	X	NEMA 5-20R		
CO07	2	DRYER (PRIVATE LAUNDRY)	208	1			22.3	L1-30,32	30	2	2#10, 1#10G-3/4"C	X	NEMA 6-30R		
		DRYER (PRIVATE LAUNDRY)	208	1			22.3	L1-34,36	30	2	2#10, 1#10G-3/4"C	X	NEMA 6-30R		
CO08	2	WASHER (PRIVATE LAUNDRY)	120	1			7.50	L1-33	20	1	2#12, 1#12G-3/4"C	X	NEMA 5-20R		
		WASHER (PRIVATE LAUNDRY)	120	1			7.50	L1-35	20	1	2#12, 1#12G-3/4"C	X	NEMA 5-20R		
CO11	2	GAMING MACHINE	120	1			10.0	L1-2	20	1	2#12, 2#12G-3/4"C	X	NEMA 5-20R		
		GAMING MACHINE	120	1			10.0	L1-4	20	1	2#12, 2#12G-3/4"C	X	NEMA 5-20R		
		GAMING MACHINE	120	1			10.0	L1-6	20	1	2#12, 2#12G-3/4"C	X	NEMA 5-20R		
CO14	5	MICROWAVE	120	1			8.30	L1-9	20	1	2#12, 1#12G-3/4"C	X	NEMA 5-20R		
		MICROWAVE	120	1			8.30	L4-6	20	1	2#12, 1#12G-3/4"C	X	NEMA 5-20R		
		MICROWAVE	120	1			8.30	L4-8	20	1	2#12, 1#12G-3/4"C	X	NEMA 5-20R		
		MICROWAVE	120	1			8.30	L4-10	20	1	2#12, 1#12G-3/4"C	X	NEMA 5-20R		
		MICROWAVE	120	1			8.30	L4-12	20	1	2#12, 1#12G-3/4"C	X	NEMA 5-20R		
CO16	1	REFRIGERATOR	120	1			5.40	L1-3	20	1	2#12, 1#12G-3/4"C	X	NEMA 5-20R		
CO26	2	POS	120	1			4.20	L3-1	20	1	2#12, 2#12G-3/4"C	X	NEMA 5-20R		5
		POS	120	1			4.20	L3-7	20	1	2#12, 2#12G-3/4"C	X	NEMA 5-20R		5
CO28	4	SODA MACHINE	120	1			5.20	L5-24	20	1	2#12, 1#12G-3/4"C	X	NEMA 5-20R		
		SODA MACHINE	120	1			5.20	L5-26	20	1	2#12, 1#12G-3/4"C	X	NEMA 5-20R		
		SODA MACHINE	120	1			5.20	L5-28	20	1	2#12, 1#12G-3/4"C	X	NEMA 5-20R		
		SODA MACHINE	120	1			5.20	L5-30	20	1	2#12, 1#12G-3/4"C	X	NEMA 5-20R		
CO29	2	TEA BREWER	120	1			14.4	L5-8	20	1	2#12, 1#12G-3/4"C	X	NEMA 5-20R		
		TEA BREWER	120	1			14.4	L5-6	20	1	2#12, 1#12G-3/4"C	X	NEMA 5-20R		
CO33	2	CAPPUCCINO	120	1			15.0	L5-2	20	1	2#12, 1#12G-3/4"C	X	NEMA 5-20R		
		CAPPUCCINO	120	1			15.0	L5-4	20	1	2#12, 1#12G-3/4"C	X	NEMA 5-20R		
CO34	2	COLD COFFEE MACHINE	120	1			10.0	L5-10	20	1	2#12, 1#12G-3/4"C	X	NEMA 5-20R		7
		COLD COFFEE MACHINE	120	1			10.0	L5-12	20	1	2#12, 1#12G-3/4"C	X	NEMA 5-20R		7
CO35	8	HOT COFFEE MACHINE	208	1			24.0	L4-1,3	30	2	2#10, 1#10G-3/4"C	X	NEMA 6-30R		7
		HOT COFFEE MACHINE	208	1			24.0	L4-5,7	30	2	2#10, 1#10G-3/4"C	X	NEMA 6-30R		7
		HOT COFFEE MACHINE	208	1			24.0	L4-9,11	30	2	2#10, 1#10G-3/4"C	X	NEMA 6-30R		7
		HOT COFFEE MACHINE	208	1			24.0	L4-13,15	30	2	2#10, 1#10G-3/4"C	X	NEMA 6-30R		7
		HOT COFFEE MACHINE	208	1			24.0	L4-17,19	30	2	2#10, 1#10G-3/4"C	X	NEMA 6-30R		7
		HOT COFFEE MACHINE	208	1			24.0	L4-21,23	30	2	2#10, 1#10G-3/4"C	X	NEMA 6-30R		7
		HOT COFFEE MACHINE	208	1			24.0	L4-25,27	30	2	2#10, 1#10G-3/4"C	X	NEMA 6-30R		7
		HOT COFFEE MACHINE	208	1			24.0	L4-2,4	30	2	2#10, 1#10G-3/4"C	X	NEMA 6-30R		7
CO36	2	SLUSHI MACHINE	120	1			12.0	L5-19	20	1	2#12, 1#12G-3/4"C	X	NEMA 5-20R		7
		SLUSHI MACHINE	120	1			12.0	L5-17	20	1	2#12, 1#12G-3/4"C	X	NEMA 5-20R		7
CO37	2	ICE CREAM MACHINE	208	1			16.0	L5-1,3	20	2	2#12, 1#12G-3/4"C	X	NEMA L6-20R		7
		ICE CREAM MACHINE	280	1			16.0	L5-5,7	20	2	2#12, 1#12G-3/4"C	X	NEMA L6-20R		
CO40	2	CREAMER	120	1			2.00	L4-14	20	1	2#12, 1#12G-3/4"C	X	NEMA 5-20R		
		CREAMER	120	1			2.00	L4-16	20	1	2#12, 1#12G-3/4"C	X	NEMA 5-20R		
CO41	2	ICE MERCHANDISER	120	1			12.1	L1-5	20	1	2#12, 1#12G-3/4"C	X	NEMA 5-20R		
CO42	4	ICE MAKER	120	1			22.3	L5-9	30	1	2#10, 1#10G-3/4"C	X	NEMA 5-30R		7
		ICE MAKER	120	1			22.3	L5-11	30	1	2#10, 1#10G-3/4"C	X	NEMA 5-30R		7
		ICE MAKER	120	1			22.3	L5-13	30	1	2#10, 1#10G-3/4"C	X	NEMA 5-30R		7
		ICE MAKER	120	1			22.3	L5-15	30	1	2#10, 1#10G-3/4"C	X	NEMA 5-30R		7
CO43	3	HAND DRYER	120	1			13.5	L1-19	20	1	2#12, 1#12G-3/4"C	X	NEMA 5-20R		11
	3	HAND DRYER	120	1			13.5	L1-21	20	1	2#12, 1#12G-3/4"C	X	NEMA 5-20R		11
	2	HAND DRYER	120	1			9.00	L1-23	20	1	2#12, 1#12G-3/4"C	X	NEMA 5-20R		11
	3	HAND DRYER	120	1			13.5	L1-27	20	1	2#12, 1#12G-3/4"C	X	NEMA 5-20R		11
	3	HAND DRYER	120	1			13.5	L1-29	20	1	2#12, 1#12G-3/4"C	X	NEMA 5-20R		11
	2	HAND DRYER	120	1			9.00	L1-26	20	1	2#12, 1#12G-3/4"C	X	NEMA 5-20R		11

[illegible]

STARBUCKS EQUIPMENT CONNECTION SCHEDULE																
ITEM NO.	QTY	DESCRIPTION	ELECTRICAL													
			VOLTS	PHASE	KW	HP	FLA	CIRCUIT DESIG	BREAKER		FEEDER		DIRECT	PLUG	PLUG TYPE	NOTES
								AMPS	POLE							
A10005	1	MUSIC SYSTEM	120	1			2.00	ST2-23	20	1		2#12, 1#12G-3/4"C	X	NEMA 5-20R		8
A10008	2	POS REGISTER	120	1			3.00	ST2-19	20	1		2#12, 1#12G-3/4"C	X	NEMA 5-20R		8
		POS REGISTER	120	1			3.00	ST2-21	20	1		2#12, 1#12G-3/4"C	X	NEMA 5-20R		8
A10014	2	POS PRINTER	120	1			1.50	ST2-19	20	1		2#12, 1#12G-3/4"C	X	NEMA 5-20R		8
		POS PRINTER	120	1			1.50	ST2-21	20	1		2#12, 1#12G-3/4"C	X	NEMA 5-20R		8
A10075	4	CUP LABELER	120	1			3.00	ST2-26	20	1		2#12, 1#12G-3/4"C	X	NEMA 5-20R		8
		CUP LABELER	120	1			3.00	ST2-28	20	1		2#12, 1#12G-3/4"C	X	NEMA 5-20R		8
		CUP LABELER	120	1			3.00	ST2-30	20	1		2#12, 1#12G-3/4"C	X	NEMA 5-20R		8
		CUP LABELER	120	1			3.00	ST2-32	20	1		2#12, 1#12G-3/4"C	X	NEMA 5-20R		8
A10076	1	AMPLIFIER	120	1			1.38	ST2-23	20	1		2#12, 1#12G-3/4"C	X	NEMA 5-20R		8
A18801	1	DIGITAL PRODUCTION MGR	120	1			5.00	ST2-25	20	1		2#12, 1#12G-3/4"C	X	NEMA 5-20R		8
A21874	1	PRODUCTION CONTROLLER	120	1			10.0	ST2-24	20	1		2#12, 1#12G-3/4"C	X	NEMA 5-20R		8
A23021	1	MENUBOARD-DIGITAL DISPLAY	120	1			2.00	ST2-27	20	1		2#12, 1#12G-3/4"C	X	NEMA 5-20R		8
A24899	3	MB-DIGITAL DISPLAY, TRIPLE	120	1			6.00	ST2-29	20	1		2#12, 1#12G-3/4"C	X	NEMA 5-20R		8
E10267	4	UC REFRIGERATOR	120	1			4.00	ST2-7	20	1		2#12, 1#12G-3/4"C	X	NEMA 5-20R		8
		UC REFRIGERATOR	120	1			4.00	ST2-9	20	1		2#12, 1#12G-3/4"C	X	NEMA 5-20R		8
		UC REFRIGERATOR	120	1			4.00	ST2-11	20	1		2#12, 1#12G-3/4"C	X	NEMA 5-20R		8
		UC REFRIGERATOR	120	1			4.00	ST2-13	20	1		2#12, 1#12G-3/4"C	X	NEMA 5-20R		8
E10808	1	GRINDER	120	1			13.0	ST2-7	20	1		2#12, 1#12G-3/4"C	X	NEMA 5-20R		8
E11083	2	RI REFRIGERATOR, 2DR	120	1			5.60	ST2-15	20	1		2#12, 1#12G-3/4"C	X	NEMA 5-20R		8
		RI REFRIGERATOR, 2DR	120	1			5.60	ST2-16	20	1		2#12, 1#12G-3/4"C	X	NEMA 5-20R		8
E12058	2	BLENDER	120	1			10.0	ST2-10	20	1		2#12, 1#12G-3/4"C	X	NEMA 5-20R		8
		BLENDER	120	1			10.0	ST2-12	20	1		2#12, 1#12G-3/4"C	X	NEMA 5-20R		8
E11083	1	UC REFRIGERATOR	120	1			7.20	ST2-15	20	1		2#12, 1#12G-3/4"C	X	NEMA 5-20R		8
E13682	1	RI FREEZER	120	1			9.60	ST2-15	20	1		2#12, 1#12G-3/4"C	X	NEMA 5-20R		8
E16238	1	FOOD CASE	208	1			10.7	ST1-30,32	20	2		2#12, 1#12G-3/4"C	X	NEMA 6-20R		5,10
E18842	1	ICE MACHINE	208	1			11.8	ST1-26,28	20	2		3#12, 1#12G-3/4"C	X	30/2P/1/F20A		12
E19742	2	ESPRESSO MACHINE	208	1			35.0	ST1-13,15	20	2		2#8, 1#10G-3/4"C	X	NEMA 6-50R		8
		ESPRESSO MACHINE	208	1			35.0	ST1-17,19	20	2		2#8, 1#10G-3/4"C	X	NEMA 6-50R		8
E20011	1	UC REFIG, NITRO	120	1			2.50	ST2-17	20	1		2#12, 1#12G-3/4"C	X	NEMA 5-20R		8
E20032	2	OVEN	208	1			22.2	ST1-25,27	30	2		2#10, 1#10G-3/4"C	X	NEMA 6-30R		8
		OVEN	208	1			22.2	ST1-29,31	30	2		2#10, 1#10G-3/4"C	X	NEMA 6-30R		8
E21679	1	NITROGEN GEN. ELEMENT	120	1			2.80	ST2-17	20	1		2#12, 1#12G-3/4"C	X	NEMA 5-20R		8
E22885	1	BREWER, DOUBLE	208	1			35.0	ST1-21,23	20	2		2#8, 1#10G-3/4"C	X	NEMA 14-50R		7,8
E24007	1	DISHWASHER	208	3			24.0	ST1-8,10,12	30	3		3#10, 1#10G-3/4"C	X	30/3P/1/F30A		12
P11109	1	EWH-1	208	3			66.7	ST1-2,4,6	90	3		3#3, 1#8G-1"C	X	100/3P/1/NF		12
P13082	1	WATER SOFTENER	120	1			2.50	ST2-15	20	1		2#12, 1#12G-3/4"C	X	NEMA 5-20R		8
P22642	3	HOT WATER BOILER	208	1			13.5	ST1-14,16	20	2		2#12, 1#12G-3/4"C	X	NEMA L6-20R		8
		HOT WATER BOILER	208	1			13.5	ST1-18,20	20	2		2#12, 1#12G-3/4"C	X	NEMA L6-20R		8
		HOT WATER BOILER	208	1			13.5	ST1-22,24	20	2		2#12, 1#12G-3/4"C	X	NEMA L6-20R		8

FOOD SERVICE/KITCHEN EQUIPMENT SCHEDULE NOTES:

- NOTE 1. SEE DWG. E100.
- NOTE 2. PROVIDE WP DISCONNECT SWITCH AND MOUNT TO CONDENSING UNIT ON ROOF. MAKE FINAL CONNECTION FROM DISC. SW. TO CONDENSING UNIT.
- NOTE 3. PROVIDE WP DISCONNECT SWITCH AND MOUNT TO FCU. MAKE FINAL CONNECTION FROM DISC. SW. TO FCU.
- NOTE 4. SEE DWG. E205.
- NOTE 5. PROVIDE "IG" TYPE RECEPTACLE.
- NOTE 6. COORDINATE WITH MANUFACTURER FOR EXACT REQUIREMENTS. PROVIDE ALL INTERCONNECTIONS, AS REQUIRED.
- NOTE 7. PROVIDE CORD AND PLUG FOR EQUIPMENT TO MATCH RECEPTACLE.
- NOTE 8. VERIFY RECEPTACLE WITH PLUG ON EQUIPMENT PRIOR TO ORDERING OR INSTALLING.
- NOTE 9. PROVIDE ALL CONDUIT AND WIRING REQUIRED AND CONNECT TO HOOD UTILITY CABINET FOR ALL THE INTERCONNECTING POWER AND CONTROL WIRING, AS SHOWN ON THE CAPTIVE AIRE DWGS.
- NOTE 10. COORDINATE EXACT LOCATION AND MOUNTING HEIGHT W/KITCHEN EQUIPMENT SUPPLIER PRIOR TO INSTALLATION.
- NOTE 11. COORDINATE RECEPTACLE/J-BOX INSTALLATION WITH MANUFACTURER REQUIREMENTS AND RECOMMENDATIONS.
- NOTE 12. PROVIDE FINAL CONNECTION FROM DISCONNECT SWITCH TO UNIT.

WAITING ON ARBY'S
EQUIPMENT TO
COMPLETE SCHEDULE

THOMAS E. MORGAN, JR.
ARCHITECT

423 FISCHER TRAIL
ELLIJAY, GEORGIA 30541

SEAL:



3450 Acworth Due West Road
Building 100, Suite 120
Kennesaw, Georgia 30144
P. 770-917-9172
F. 770-917-9470
www.mrpdesign.com

RELEASED FOR
CONSTRUCTION

ISSUES / REVISIONS:

DATE	DESCRIPTION
03/11/2026	PROGRESS/COORDINATION
05/05/2026	FOR PERMIT/CONSTRUCTION
06/26/2026	STARBUCKS TENANT ADD'N & UTILITY RM REVISION

DRAWN BY: BAM

CHK'D BY: JFM

PROJECT DESCRIPTION:

HE DEVELOPMENT AND CONSTRUCTION OF A C-STORE LAYOUT, WHICH INCLUDES RETAIL SPACE, STORAGE, DRINK COOLER, BEER CAVES, DRINKING STATIONS, BREAK ROOM, TRUCKER LOUNGE AND RESTROOMS, PUBLIC RESTROOMS AND 4 QSR'S WITH WALK IN COOLERS AND FREEZERS.

PROJECT TITLE:

TRAVEL CENTER
4838 SR 96
JEFFERSONVILLE,
GEORGIA 31044


SHEET TITLE:

FOOD SERVICE EQUIPMENT SCHEDULES

PROJECT NO: 25021

E004

THESE PLANS ARE THE PROPERTY OF MRP DESIGN GROUP, INC. AND ARE SUBJECT TO FEDERAL COPYRIGHT LAWS. ANY USE OF SAME WITHOUT THE EXPRESS WRITTEN PERMISSION OF MRP DESIGN GROUP, INC. IS STRICTLY PROHIBITED.

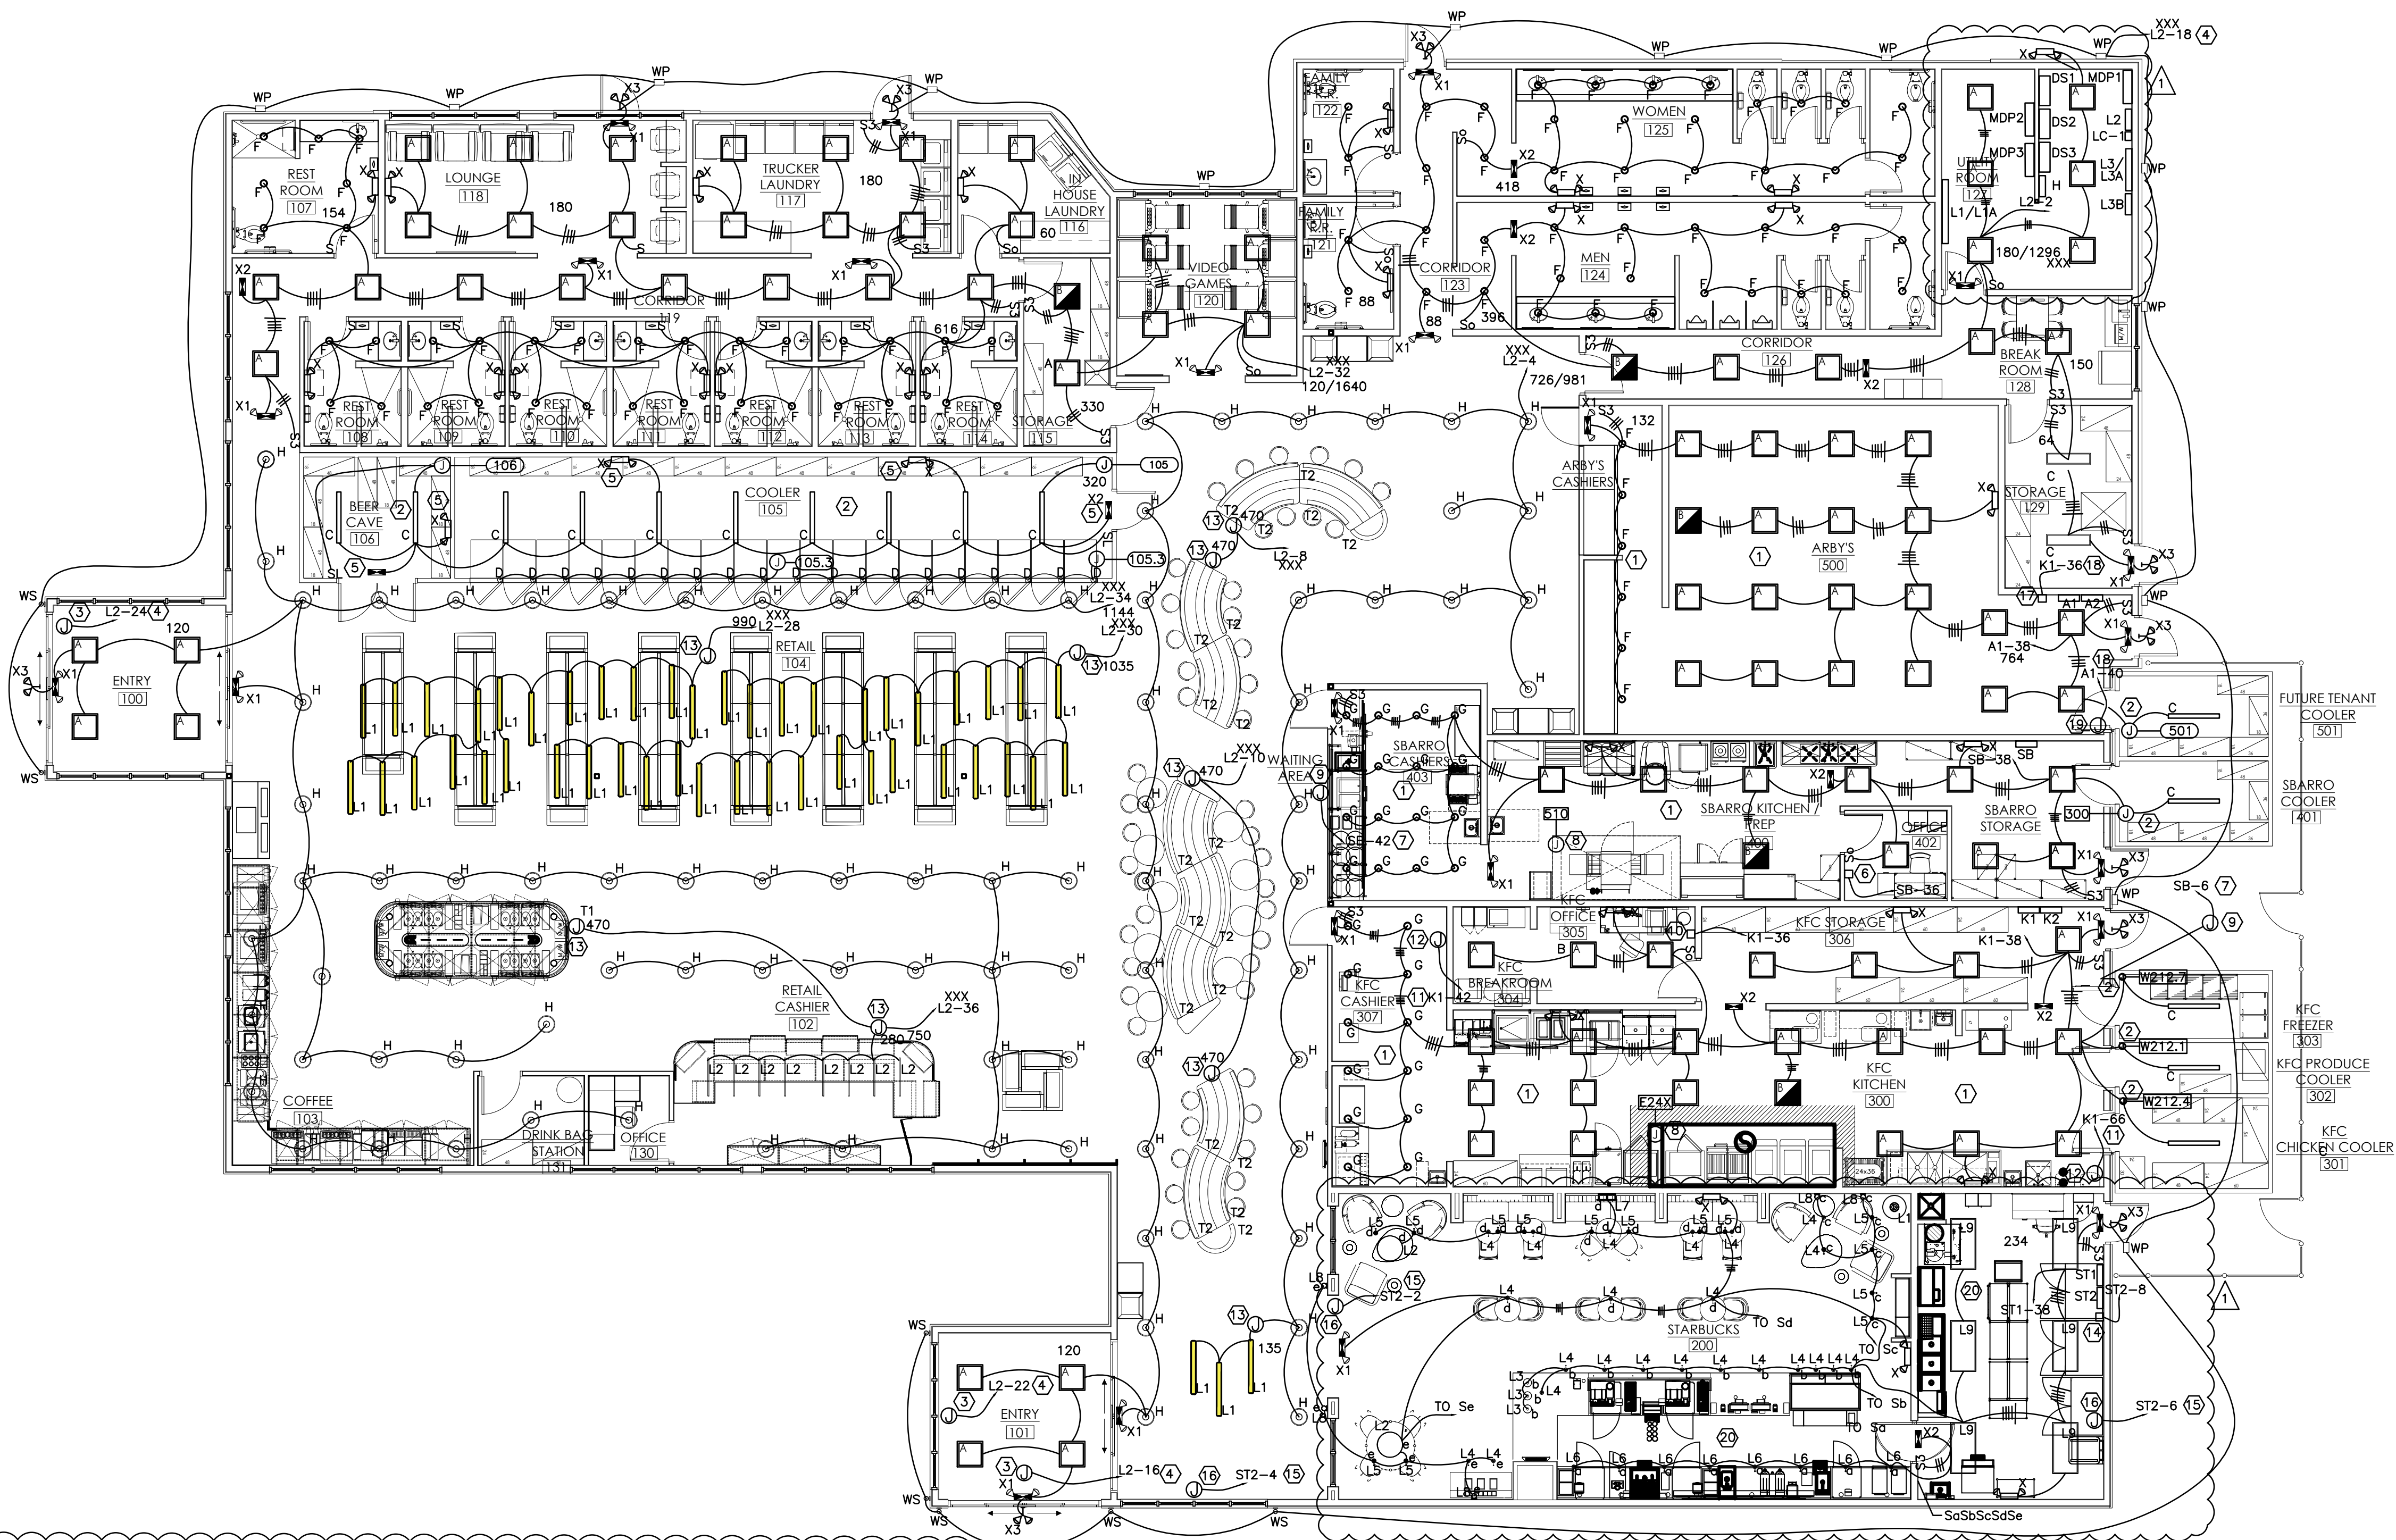

GENERAL NOTES:

- THIS CONTRACTOR SHALL BECOME FAMILIAR WITH THE DRAWINGS, INCLUDING OTHER DISCIPLINES, AND THE SCOPE OF WORK TO BE COMPLETED. FULLY COORDINATE BETWEEN ALL DISCIPLINE PLANS AND THE WORK TO BE COMPLETED.
- VERIFY ALL LIGHT FIXTURE LOCATIONS AND MOUNTING HEIGHTS WITH REFLECTED CEILING PLANS A112-115 AND ARCHITECTURAL ELEVATIONS A200-A201. LOADING SHALL NOT EXCEED 1800VA. PROVIDE ALL MATERIAL AND LABOR, INCLUDING BUT NOT LIMITED TO, CONDUIT, WIRE, CIRCUIT BREAKERS, HANGERS, SWITCHES ETC., AS TO PROVIDE A COMPLETE AND OPERATIONAL SYSTEM.
- FOR LEGEND AND C-STORE, KFC, SBARROS AND ARBY'S LIGHTING FIXTURE SCHEDULE (LFS), SEE DRAWING E000. FOR STARBUCKS LFS, SEE THIS SHEET.
- ALL LIGHT SWITCHES SHALL BE 120/277V, SINGLE-POLE, SINGLE-THROW, UON.
- EXIT/EMERGENCY LIGHT FIXTURES SHALL BE CONNECTED AHEAD OF ROOM/AREA SWITCH, PER NEC ARTICLE 700-12(F).
- GENERALLY, THE CIRCUITING SHOWN SHALL GO TO PANEL AND CIRCUIT INDICATED; HOWEVER, IF CIRCUITS ARE SHIFTED TO OTHER CIRCUIT NUMBERS IN THAT PANEL, CIRCUIT BALANCING, SHARED NEUTRAL AND PHASING SHALL BE ADJUSTED AS NECESSARY TO MAINTAIN CIRCUIT INTEGRITY.
- QSR INTERIOR SIGN CONTROL SHALL BE PROVIDED AND WIRED THRU EACH QSR TIME CLOCK. ALL RETAIL LIGHTING SHALL BE CONTROLLED BY PANEL CIRCUIT BREAKERS AND ALL OTHER INTERIOR LIGHTING SHALL BE CONTROLLED BY LOCAL SWITCHES, EXCLUDING EMERGENCY LIGHTING.
- PROVIDE GROMMET FOR ALL CEILING PENETRATIONS FOR FIXTURE SUPPORT ABOVE CEILING.
- ADJUST FOCUS OF ALL RECESSED DIRECTIONAL FIXTURES TO ILLUMINATE ARTWORK, MENUBOARDS AND MERCHANDISE. COORDINATE AIMING W/OWNER.

C-STORE/QSR KEYED NOTES:

- ALL FIXTURES IN KITCHEN/SERVING AREAS SHALL BE PROVIDED W/ GASKETED LENS.
- LIGHT FIXTURES W/SWITCH, SUPPLIED W/WIC/BEER CAVE. EC SHALL INSTALL AS REQUIRED AND CONNECT TO WIC/BEER CAVE J-BOX.
- PROVIDE WP J-BOX AND TOGGLE TYPE 20A-1P DISCONNECT SWITCH FOR BUILDING MTD SIGN. COORDINATE SIGN LOCATION W/SIGN INSTALLER AND VERIFY SIGN ELECTRICAL LOADS. PROVIDE FINAL CONNECTION FROM J-BOX TO SIGN.
- ROUTE CIRCUIT THRU LC-1.
- PROVIDE EMERGENCY LIGHT FIXTURE (TYPE X) AND EXIT LIGHT (X2) W/WEATHERPROOF ENCLOSURE AND COMPATIBLE FOR COOLER/BEER CAVE ENVIRONMENT.
- PROVIDE TIME CLOCK, TC-1 FOR SBARROS SIGN.
- ROUTE CIRCUIT THRU TC-L.
- PROVIDE J-BOX ABOVE CEILING FOR PREWIRED HOOD LIGHTS AND SWITCH, FSS, CONTROLS, ETC. AS SHOWN ON QSR HOOD DRAWINGS PROVIDE FINAL CONNECTION FROM J-BOX TO HOOD UTILITY CABINET.
- SAME AS NOTE #3 FOR SBARROS SIGN AND COORDINATE LOCATION W/ ARCHITECTURAL ELEVATIONS.
- PROVIDE TIME CLOCK, TC-2 FOR KFC.
- ROUTE CIRCUIT THRU TC-2.
- SAME AS NOTE #9 FOR KFC SIGN.
- PROVIDE J-BOX IN STRUCTURE ABOVE TINES CEILING FEATURE. PROVIDE CONNECTION FROM J-BOX TO FEATURE LIGHT FIXTURES. COORDINATE W/ CEILING FEATURE/LIGHTS INSTALLER.
- PROVIDE TIME CLOCK, TC-3 FOR STARBUCKS.
- ROUTE CIRCUIT THRU TC-3.
- SAME AS NOTE #9 FOR STARBUCKS SIGN.
- PROVIDE TIME CLOCK, TC-4 FOR ARBY'S.
- ROUTE CIRCUIT THRU TC-4.
- SAME AS NOTE #9 FOR ARBY'S SIGN.

- ALL FIXTURES IN WORKROOM, FRONT AND BACK LINES, ABOVE CONDIMENT CART AND ANY OTHER AREAS WHERE FOOD, CLEAN EQUIPMENT OR UTENSILS ARE EXPOSED, SHALL BE PROVIDED WITH GASKETED LENS. ALL OF THESE AREAS WITH FIXTURES WITHOUT LENS SHALL BE PROVIDED WITH SHATTERPROOF LAMPS.

TRAVEL CENTER LIGHTING PLAN

1
E100 1/8"=1'-0"

STARBUCKS LIGHT FIXTURE SCHEDULE NOTES:

- ALL BATTERY BACKED FIXTURES SHALL BE RATED FOR MINIMUM 1100 LUMENS.
- ALL FIXTURES TO BE LISTED AND CERTIFIED WITH THE CEC DIRECTORY.
- COORDINATE FIXTURE MOUNTING HEIGHT AND LOCATION REQUIREMENTS W/ARCHITECTURAL DRAWINGS/ DETAILS/ELEVATIONS PRIOR TO ROUGH-IN. SUPPORT FIXTURES TO STRUCTURE, NOT CEILING GRID.
- SEE NOTES ON THE ARCHITECTURAL REFLECTED CEILING PLAN.

STARBUCKS LIGHTING FIXTURE SCHEDULE - "L"					
LABEL	DESIGN ID	COUNT	DESCRIPTION	FURN. BY	INST. BY
FLOOR LAMP					
L1	25158	1	FLOOR LAMP POLAR CEMENT-BLACK	SB	GC
PENDANT					
L2	25142	2	PENDANT-RODAN-ANTIQUE PEWTER	SB	GC
L3	25159	3	PENDANT-KAURI ORGANIC-BRASS AND CERAMIC	SB	GC
RECESSED DOWNLIGHT					
L4	21771	24	RECESSED - LED ADJUSTABLE DOWNLIGHT	SB	GC
L5	21773	14	RECESSED - LED ADJUSTABLE DOWNLIGHT	SB	GC
L6	21775	8	RECESSED - LED WALL WASH	SB	GC
SCONCE					
L7	14895	1	SCONCE-HOUSE OF TROY CLASSIC TRADITIONAL-BRONZE	SB	GC
L8	25154	5	SCONCE-NATHAN-1781 AGB	SB	GC
TROFFER					
L9	21783	6	TROFFER - LED RECESSED	GC	GC
EXIT/EMERGENCY					
X	-	2	EMERGENCY LIGHT W/2-HEADS	GC	GC
X1	-	2	EXIT/EMERGENCY COMBINATION LIGHT	GC	GC
X2	-	1	EXIT LIGHT	GC	GC
X3	-	1	EXTERIOR EMERGENCY LIGHT W/2-HEADS	GC	GC

ARCHITECT OF RECORD:

THOMAS E. MORGAN, JR.
ARCHITECT

423 FISCHER TRAIL
ELLIJAY, GEORGIA 30540

SEAL:



MRP
DESIGN GROUP

3450 Acworth Due West Road
Building 100, Suite 120
Kennesaw, Georgia 30144
P. 770-917-9172
F. 770-917-9470
www.mrpdesign.com

RELEASED FOR
CONSTRUCTION

ISSUES / REVISIONS:

DATE	DESCRIPTION
03/11/2025	PROGRESS/COORDINATION
05/05/2025	FOR PERMIT/CONSTRUCTION
05/26/2025	STARBUCKS TENANT ADDN & UTILITY RM REVISION

DRAWN BY: BAM

CHKD BY: JFM

PROJECT DESCRIPTION:

THE DEVELOPMENT AND CONSTRUCTION OF A C-STORE LAYOUT, WHICH INCLUDES RETAIL SPACE, STORAGE, DRINK COOLER, BEER CAVES, DRINKING STATIONS, BREAK ROOM, TRUCKER LOUNGE AND RESTROOMS, PUBLIC RESTROOMS AND 4 QSR'S WITH WALK IN COOLERS AND FREEZERS.

PROJECT TITLE:

TRAVEL CENTER
4838 SR 96
JEFFERSONVILLE,
GEORGIA 31044

SHEET TITLE:

TRAVEL CENTER
LIGHTING PLAN

PROJECT NO: 25021

E100

THESE PLANS ARE THE PROPERTY OF MRP DESIGN GROUP, INC. AND ARE SUBJECT TO FEDERAL COPYRIGHT LAWS. ANY USE OF SAME WITHOUT THE EXPRESS WRITTEN PERMISSION OF MRP DESIGN GROUP, INC. IS STRICTLY PROHIBITED.

PROJ: STARBUCKS-JEFFERSONVILLE, C/PANEL: ST1										DATED: 06/26/2026		REVS: 00		X	
208	VOLT-LL		22	K-AIC RATING		ENCLOSURE TYPE		NEMA 1							
120	VOLT-LN		3	PHASE		BRANCH OCP TYPE		M/C BKRS							
400	BUSS AMPS		MLO	MAIN OCP		GENERAL NOTES		SURFACE MTD, NOTE 2							
R	N	DESCRIPTION	LT	WVA	AMP	P	#	P	#	WVA	LT	DESCRIPTION	N	R	
		PANEL ST2	A	8000	100	-	1	A	2	90	-	8000	M	BWH-1	
		---	A	8000	-	-	3	B	4	-	-	8000	M	---	
		---	A	8000	-	-	5	C	6	-	-	8000	M	---	
		REC-UPS	R	1000	20	/	7	A	8	30	-	2880	A	DISHWASHER, #E24007	
		REC-DESK	R	540	20	/	9	B	10	-	-	2880	A	---	
		REC-DESK	R	1080	20	/	11	C	12	-	-	2880	A	---	
		REC-ESPRESSO, #E1974	A	3640	50	/	13	A	14	-	-	1404	A	REC-WTR BLR, #P22642	
		---	A	3640	-	-	15	B	16	-	-	1404	A	---	
		REC-ESPRESSO, #E1974	A	3640	50	/	17	C	18	-	-	1404	A	REC-WTR BLR, #P22642	
		---	A	3640	-	-	19	A	20	-	-	1404	A	---	
		REC-BREWER, #E22885	A	3640	50	/	21	B	22	-	-	1404	A	REC-WTR BLR, #P22642	
		---	A	3640	-	-	23	C	24	-	-	1404	A	---	
		REC-OVEN, #E20032	A	2309	30	/	25	A	26	-	-	1227	A	ICE MACH, #E18842	
		---	A	2309	-	-	27	B	28	-	-	1227	A	ICE MACH, #E18842	
		REC-OVEN, #E20032	A	2309	30	/	29	C	30	-	-	743	A	REC-FD CASE, #E16238	
		---	A	2309	-	-	31	A	32	-	-	743	A	---	
		SPARE		20	/	1	33	B	34	20	/	1	600	M	DOOR ACTUATOR
		SPARE		20	/	1	35	C	36	20	/	1	600	M	DOOR ACTUATOR
		SPARE		20	/	1	37	A	38	20	/	1	768	L	LTG
		SPARE		20	/	1	39	B	40	20	/	1			SPARE
		SPARE		20	/	1	41	C	42	20	/	1			SPARE
NT# 1. HACR TYPE CIRCUIT BREAKER (CB). 2. PROVIDE WISOLATED GROUND BUS.															

THESE PLANS ARE THE PROPERTY OF MRP DESIGN GROUP, INC. AND ARE SUBJECT TO FEDERAL COPYRIGHT LAWS. ANY USE OF SAME WITHOUT THE EXPRESS WRITTEN PERMISSION OF MRP DESIGN GROUP, INC. IS STRICTLY PROHIBITED.

NOTES

1. FLOOR MOUNTED, FLUSH VALVE WATER CLOSET: AMERICAN STANDARD "MADERA FLOWISE" 2234.001, 1.28 GPF, WHITE VITREOUS CHINA, TOP OF RIM AT 15" AFF, 1-1/2" TOP SPUD. PROVIDE EXPOSED BATTERY POWERED, SENSOR OPERATED AUTOMATIC FLUSH VALVE, 1.28 GPF, CHROME PLATED AMERICAN STANDARD "ELECTRONIC" 6065.121.002. PROVIDE HEAVY DUTY OPEN FRONT SEAT, LESS COVER AMERICAN STANDARD 5905.100, 4"x4"x4" CLOSET FLANGE WITH WAX SEAL.
2. HANDICAP ACCESSIBLE, FLOOR MOUNTED, FLUSH VALVE WATER CLOSET: AMERICAN STANDARD "MADERA FLOWISE" 3043.001, 1.28 GPF, WHITE VITREOUS CHINA, TOP OF RIM AT 16 1/2" AFF, 1-1/2" TOP SPUD. PROVIDE EXPOSED BATTERY POWERED, SENSOR OPERATED AUTOMATIC FLUSH VALVE, 1.28 GPF, CHROME PLATED AMERICAN STANDARD "ELECTRONIC" 6065.121.002. PROVIDE HEAVY DUTY OPEN FRONT SEAT, LESS COVER AMERICAN STANDARD 5905.100, 4"x4"x4" CLOSET FLANGE WITH WAX SEAL.
3. WALL HUNG URINAL: AMERICAN STANDARD "WASHBROOK" 6590.001, WHITE VITREOUS CHINA, HIGH EFFICIENCY "WATERSENSE" LISTED. PROVIDE ZURN 1222 SPUD SYSTEM. COORDINATE MOUNTING HEIGHT(S) AND ADA DESIGNATIONS WITH ARCHITECTURAL DRAWINGS. SIPHON-JET, 3/4" TOP SPUD, 2" OUTLET. PROVIDE EXPOSED URINAL FLUSHMETER (SENSOR OPERATED, BATTERY POWERED) CHROME PLATED, 0.5 GPF AMERICAN STANDARD "ELECTRONICS" 6063.051.002.
4. UNDERMOUNT LAVATORY: KOHLER "BACHATA" K-2609 AND BATTERY POWERED, SENSOR OPERATED FAUCET WITH POLISHED CHROME FINISH ZURN "AQUASENSE" ZB915-XL. HANDICAP DRAIN OFFSET WITH GRID DRAIN ZURN 8746-PC AND CHROME PLATED P-TRAP ZURN 28701-PC. CHROME PLATED BRASS ANGLE SUPPLY STOPS WITH 12" LONG X 3/8" FLEX SUPPLIES MCGUIRE H165. WHERE NOT CONCERNED BY COUNTER SHROUD, INSULATE OFFSET, TRAP AND SUPPLY LINES THROUGH "LAVGUARD #103 EZ.
5. SHOWER VALVE: MOEN 8370, 1222 CARTRIDGE DESIGN. PROVIDE INDUSTRIAL SHOWER HEAD.
6. SHOWER SYSTEM H/C HANDHELD: MOEN 8341 W/ 8290.
7. EXTERIOR NON-FREEZE WALL HYDRANT: WOODFORD MODEL B65, FREEZELESS BRASS WALL HYDRANT WITH BRASS BOX AND LOCKING DOOR, INTEGRAL VACUUM BREAKER, 3/4" HOSE THREAD NOZZLE, AND LOOSE KEY TEE. INSTALL AT 24" ABOVE FINISHED GRADE. COORDINATE BARREL LENGTH WITH WALL THICKNESS.
8. THERMOSTATIC MIXING VALVE: SYMMONS MODEL 4-10A POINT-OF-USE THERMOSTATIC MIXING VALVE, ALL ROUGH BRONZE CONSTRUCTION. 1/2" INLETS, 1/2" OUTLETS. MOUNT IN SUPPLY LINES TO ALL HAND SINKS. SET TO 105°F
9. FLOOR DRAIN - GENERAL: JAY R. SMITH MODEL 2010C-P050-NB CAST IRON BODY FLOOR DRAIN WITH ADJUSTABLE STRAINER HEAD, 3" INSIDE CAULK OUTLET, 5" DIA. NICKEL BRONZE STRAINER, AND 1/2" TRAP PRIMER CONNECTION.
10. FLOOR DRAIN - KITCHEN: JAY R. SMITH MODEL 2350C-NB CAST IRON BODY FLOOR DRAIN WITH FLASHING COLLAR, ADJUSTABLE STRAINER HEAD, 3" INSIDE CAULK OUTLET, 8" DIA. NICKEL BRONZE STRAINER, AND CAST IRON SEDIMENT BUCKET, SEE DETAIL.
11. FLOOR SINK: JAY R. SMITH MODEL 3430C-14 CAST IRON BODY FLOOR SINK WITH "SANI-CEPT" ACID-RESISTANT COATING, 8" DEEP BASIN, FLASHING COLLAR, ADJUSTABLE STRAINER HEAD, 3" INSIDE CAULK OUTLET, 12" SQUARE STRAINER WITH 2-1/2" DIA. CENTER HOLE CUT-OUT, AND ALUMINUM DOME STRAINER.
12. FLOOR CLEANOUT: JAY R. SMITH 4025 CAST IRON BODY FLOOR CLEANOUT WITH ADJUSTABLE SCORIATED NICKEL BRONZE TOP. SEE DETAIL AND PLAN FOR SIZE.
13. GRADE CLEANOUT: JAY R. SMITH 428B-TP CAST IRON CLEANOUT WITH BRONZE CLEANOUT PLUG. SEE DETAIL AND PLAN FOR SIZE.
14. HUB DRAIN: SIOUX CHIEF 832 SERIES, ADJUSTABLE HUB DRAIN FIXTURE, PROVIDE STAINLESS STEEL MESH DEBRIS BASKET. PROVIDE ASSI 1072 TRAP SEALER ZURN Z1072.
15. TRAP PRIMER VALVE: PRECISION PLUMBING PRODUCTS OREGON-1 AUTOMATIC TRAP PRIMER VALVE. ROUTE TRAP PRIMER LINE TO DRAIN, PER THE PLANS.
16. WATER HAMMER ARRESTOR: JAY R. SMITH 5000 SERIES STAINLESS STEEL WATER HAMMER ARRESTOR. PDI SIZE DESIGNATION INDICATED ON PLANS ("X").
17. WASHING MACHINE BOX: GUY GREY FR-12 METAL BOX WITH 1/4 TURN HAMMER ARRESTOR VALVES AND 2" DRAIN OUTLET.

ELECTRIC WATER HEATER DETAIL

SCALE: NOT TO SCALE

Diagram illustrating the components and installation of a vacuum relief valve assembly:

- WATTS 36A OR EQUAL VACUUM RELIEF VALVE LOCATE @ 6" MIN. ABOVE HEATER. (TYP)
- EXPANSION TANK AMTROL MODEL 30 PROVIDE W/ HANGERS
- 6" MERCURY THERMOMETER INSTALL AS CLOSE TO HEATER AS POSSIBLE. (TYP)
- ASME RATED PRESSURE & TEMP. RELIEF VALVE (TYP)
- DIELECTRIC UNION EACH TANK CONNECTION (TYP)
- BALL VALVE (TYP)
- CHECK VALVE (TYP)
- ROUTE DISCHARGE PIPING FULL SIZE TO SPILL @ 3"A.F.F.
- DRAIN VALVE (TYP)
- 4" HIGH CONC. PAD W/CHAMFER

- 1
P000
- ELECTRIC
- SCALE: NOT TO SCALE

1. ALL WORK ON THIS PROJECT SHALL COMPLY WITH APPLICABLE CODES AND ORDINANCES ADOPTED BY THE LOCAL AUTHORITY.
2. THE CONTRACT DRAWINGS ARE SCHEMATIC AND ARE INTENDED TO CONVEY A FUNCTIONAL PLUMBING SYSTEM AND TO DEPICT THE GENERAL LOCATION OF THE SYSTEM COMPONENTS.
3. CONTRACTOR SHALL EXAMINE ALL CONTRACT DOCUMENTS AND SHALL BE FAMILIAR WITH ALL THE REQUIREMENTS OF THE PROJECT. NOTIFY THE A/E OF ANY OBSERVED DISCREPANCIES AND/OR AMBIGUITY IN THE CONTRACT DOCUMENTS SUCH THAT THESE MAY BE RESOLVED PRIOR TO SUBMISSION OF PRICING BIDS.
4. BY SUBMISSION OF BID, THE CONTRACTOR SHALL ACKNOWLEDGE ACCEPTANCE OF THE CONTRACT DOCUMENTS AS AN ADEQUATE DEFINITION OF THE SCOPE OF WORK AND EXTRA COST CLAIMS BASED ON INADEQUACY OF CONTRACT DOCUMENTS WILL NOT BE CONSIDERED.
5. ALL WORK ON THIS PROJECT SHALL BE INSTALLED IN ACCORDANCE WITH APPLICABLE CODES AND REGULATIONS AND THE LOCAL AHJ.
6. CONTRACTOR SHALL THOROUGHLY CLEAN THEIR WORK AREA DAILY. THE CONTRACTOR SHALL REMOVE ALL TRASH OR SCRAP CAUSED BY THEIR SCOPE OF WORK AT COMPLETION OF WORK.
7. CONTRACTOR SHALL VERIFY ALL DIMENSIONS AND LOCATIONS FOR PROPER EQUIPMENT INSTALLATION PRIOR TO SUBMITTING EQUIPMENT SHOP DRAWINGS FOR APPROVAL.
8. CONTRACTOR SHALL VERIFY ALL VOLTAGE AND POWER REQUIREMENTS AND COORDINATE WITH ELECTRICAL CONTRACTOR AS REQUIRED.
9. ALL SYSTEMS SHALL BE CLEAN OF FOREIGN MATERIAL AND ROUGH SPOTS PRIOR TO BEING PLACED IN SERVICE AND BEFORE OPERATIONAL TEST ARE PERFORMED.
10. THE CONTRACTOR SHALL LOCATE ALL EQUIPMENT WHICH MUST BE SERVICED, OPERATED OR MAINTAINED IN FULLY ACCESSIBLE POSITION. EQUIPMENT SHALL INCLUDE, BUT NOT BE LIMITED TO, VALVES, TRAPS, CLEAN OUTS, MOTORS, CONTROLLERS, DRAIN POINTS, ETC. IF REQUIRED FOR ACCESSIBILITY, FURNISH ACCESS DOORS FOR THIS PURPOSE. MINOR DEVIATIONS FROM THE DRAWINGS MAY BE MADE TO ALLOW FOR BETTER ACCESSIBILITY, AND ANY CHANGE FOR THAT PURPOSE SHALL BE SUBMITTED FOR APPROVAL AND FIELD DOCUMENTED ON REDLINE DRAWING PRINTS.
11. CONTRACTOR IS PROHIBITED FROM USING LEAD BASED SOLDER FOR ANY SYSTEM WHICH COMES IN CONTACT WITH DOMESTIC, OR POTABLE WATER.
12. CONTRACTOR AND MATERIAL SUPPLIERS SHALL BE RESPONSIBLE FOR INSPECTION OF JOINT CONDITIONS AFFECTING THE INSTALLATION OF AN ITEM AND FOR TAKING ALL FIELD MEASUREMENTS PRIOR TO THE FABRICATION OR PURCHASE OF THE ITEM TO ENSURE THAT THE ITEM CONCERNED WILL INTEGRATE PROPERLY WITH ALL ADJACENT MATERIALS AND WILL FIT ALL OTHER CONDITIONS AS THE EXIST OR WILL EXIST IN THE FINISHED BUILDING. SLEEVES, ANCHORS OR ITEMS EMBEDDED IN OR AFFECTING OTHER PORTIONS OF THE WORK SHALL BE LOCATED AND SET WHILE SUCH PORTIONS OF THE WORK ARE IN PROGRESS.
13. UNLESS OTHERWISE SPECIFIED, ALL ANCHORS, BOLTS, SCREWS, FITTINGS, FILLER, HARDWARE, ACCESSORIES, TRIM AND OTHER PARTS REQUIRED FOR, OR IN CONNECTION WITH, AN ITEM OR MATERIAL TO MAKE A COMPLETE, SERVICEABLE, FINISHED AND QUALITY INSTALLATION SHALL BE FURNISHED AS PART OF THE ITEM OR MATERIAL, WHETHER CALLED FOR OR NOT.
14. UNLESS OTHERWISE SPECIFICALLY MENTIONED, ALL ITEMS AND PARTS THEREOF THAT ARE MADE OF STEEL, IRON OR OTHER FERROUS METAL THAT ARE NOT GALVANIZED, PLATED OR OTHERWISE SPECIFIED TO BE FACTORY FINISHED, SHALL BE CLEANED AND PAINTED WITH ONE COAT OF HIGH QUALITY RUST INHIBITIVE METALLIC PRIMER. AFTER INSTALLATION, ALL EXPOSED METAL CONNECTIONS AND ABRASIONS SHALL BE TOUCHED-UP WITH THE SAME MATERIAL AS THE SHOP COAT AND LEFT IN GOOD CONDITION FOR FINAL FINISHING, IF REQUIRED.
15. ALL ITEMS SHALL BE FURNISHED AND INSTALLED IN A WORKMANLIKE MANNER IN ACCORDANCE WITH THE BEST RECOGNIZED PRACTICE IN THE FIELD CONCERNED. MANUFACTURED ITEMS AND EQUIPMENT SHALL BE INSTALLED IN STRICT ACCORDANCE WITH THE MANUFACTURER'S PRINTED DIRECTIONS, SPECIFICATIONS AND WRITTEN RECOMMENDATIONS. ALL WORKING PARTS SHALL BE PROPERLY ADJUSTED AFTER INSTALLATION AND LEFT IN PERFECT WORKING ORDER. ITEMS IN ALL CASES SHALL BE INSTALLED PLUMB.
16. ALL DIMENSIONS SHOWN ARE NOMINAL DIMENSIONS, EQUIPMENT AND CLEARANCES SHOWN SHALL BE COMPLIED WITH AS MINIMUM REQUIREMENTS.
17. PIPE PENETRATIONS THROUGH FIRE RATED WALLS OR FLOORS SHALL HAVE EQUIVALENTLY RATED SLEEVES AND SHALL BE SEALED AND FIRE CAULKED WITH A UL LISTED FIRE STOPPING SYSTEM INSTALLED IN ACCORDANCE WITH THE MFR'S LISTED DETAILS AND SPECS.
18. THE CONTRACTOR SHALL PAY FOR AND OBTAIN ALL NECESSARY FEES, PERMITS AND INSPECTIONS FOR APPLICABLE PORTIONS OF THE WORK.
19. LAYOUT SHOWN IS DIAGRAMATIC. THE CONTRACTOR IS RESPONSIBLE FOR REVIEWING THE ARCHITECTURAL, CIVIL, STRUCTURAL, MECHANICAL AND ELECTRICAL DRAWINGS TO ENSURE ALL PLUMBING WORK IS PROVIDED TO FACILITATE REMAINING SERVICES FOR ALL EQUIPMENT PROVIDED. FOR THE PROJECT, NEW OR EXISTING TO REMAIN, PROVIDE NECESSARY OFFSETS, RISERS, AND PIPING TO COORDINATE WITH THE BUILDING STRUCTURE AND THE WORK OF OTHER TRADES.
20. PLUMBING FIXTURES SHOWN ON FLOOR PLANS ARE ARCHITECTURAL SYMBOLS. THE CONTRACTOR IS RESPONSIBLE FOR REVIEWING THE ARCHITECTURAL DRAWINGS FOR EXACT DIMENSIONS AND LOCATION OF PLUMBING FIXTURES. (IE SINK SIZE AND COUNTERTOP SPACE, ETC.) PLUMBING FIXTURE SCHEDULE GOVERNS EXACT TYPE AND CONFIGURATION OF EACH FIXTURE.
21. THE CONTRACTOR SHALL OBTAIN EXACT WALL, FIXTURE, AND LAYOUT DIMENSIONS FROM THE ARCHITECTURAL DRAWINGS. THE CONTRACTOR IS RESPONSIBLE FOR OBTAINING ROUGH-IN AND INSTALLATION DRAWINGS FOR ALL PLUMBING FIXTURES, KITCHEN EQUIPMENT, OWNER FURNISHED EQUIPMENT, AND SHALL COORDINATE THE PLUMBING INSTALLATION PRIOR TO COMMENCING THE WORK. THE CONTRACTOR IS RESPONSIBLE FOR PROVIDING AND INSTALLING ALL NECESSARY VALVES, CONNECTIONS, TRAPS, ACCESS PANELS, UNIONS, ESCUTOCHONS, WATER HAMMER ARRESTORS, VACUUM BREAKERS, RELIEF VALVES, PIPE INSULATION, AND EQUIPMENT SPECIALTY DEVICES AS REQUIRED TO FACILITATE COMPLETE AND OPERATIONAL CONDITIONS WHICH ARE IN STRICT COMPLIANCE WITH THE FIXTURE OR EQUIPMENT, MANUFACTURERS INSTALLATION INSTRUCTIONS.
22. THE CONTRACTOR IS RESPONSIBLE FOR COORDINATING WITH THE CIVIL DRAWINGS AND AVAILABLE SITE CONDITIONS TO ENSURE SANITARY, STORM AND GREASE WASTE INVERTS ACTUALLY ON SITE WILL ACCOMMODATE THE PLANNED BUILDING DRAINAGE PIPING. REPORT ANY DISCREPANCIES PRIOR TO COMMENCING WITH THE WORK.
23. THE CONTRACTOR IS RESPONSIBLE FOR COORDINATING WITH THE THE REQUIREMENTS OF THE COUNTY HEALTH DEPARTMENT AND OTHER LOCAL AUTHORITIES HAVING JURISDICTION REGARDING CROSS CONNECTION CONTROL OR OBTAINING A FOOD SERVICE PERMIT. REPORT ANY OBSERVED DISCREPANCIES TO THE A/E PRIOR TO COMMENCING WITH THE WORK.
24. THE CONTRACTOR IS RESPONSIBLE FOR COORDINATING ALL UNDERSLAB DRAWINGS WITH THE STRUCTURAL FRAMING DRAWINGS, STRUCTURAL FOUNDATION DRAWINGS, GRADE BEAMS, THICKENED SLABS, AND ALL FOOTINGS.
25. COORDINATE THE ELECTRICAL REQUIREMENTS AND CHARACTERISTICS OF ALL PLUMBING EQUIPMENT WITH THE ELECTRICAL CONTRACTOR PRIOR TO PURCHASING EQUIPMENT. SHOP DRAWINGS SHALL INDICATE VOLTAGE, PHASE, MINIMUM CIRCUIT AMPACITY, AND MAXIMUM OVERCURRENT PROTECTION.
26. THE CONTRACTOR IS RESPONSIBLE FOR REVIEWING THE ARCHITECTURAL DRAWINGS FOR ADEQUATE WALL THICKNESS TO ENSURE ALL SANITARY PIPING, VENT PIPING, WATER PIPING, WALL CLEANOUTS, HOSE BIBBS, NON FREEZE HOSE BIBBS, AND RECESSED ACCESS PANELS WILL FIT IN WALL SPACE. CONTRACTOR SHALL NOTIFY THE ARCHITECT IF WALL SPACE IS INADEQUATE PRIOR TO COMMENCING WITH THE WORK.
27. NO PLUMBING WATER PIPING IS ALLOWED IN AN EXTERIOR WALL. THE CONTRACTOR SHALL NOTIFY THE ARCHITECT IF CHASE SPACE IS INADEQUATE OR IF FIXTURES ARE LOCATED ON OUTSIDE WALLS. ROUTE ALL PIPING ON WARM SIDE OF BUILDING INSULATION.
28. PRESSURE TESTS SHALL BE PERFORMED TO PROVE PIPING SYSTEMS INSTALLED TO BE TIGHT UNDER PRESSURE AND DISINFECTION AS FOLLOWS: PRESSURE PIPING: MAINTAIN 150 PSI HYDROSTATIC PRESSURE FOR 1 HOUR. NATURAL GAS PIPING: MAINTAIN 10 PSI AIR PRESSURE FOR 24 HOURS, OR AS REQUIRED BY LOCAL AUTHORITY HAVING JURISDICTION.

TEST BY SECTION OR BY ENTIRE SYSTEM. CLOSE OFF OPENINGS WITH PLUGS OR SECTIONALIZING VALVES. PROVE TIGHTNESS OF SYSTEM WITHOUT LOSS OF TEST LEVEL OR PRESSURE. CORRECT ANY LEAKS AND RETEST.

29. AFTER POTABLE WATER SYSTEM HAS BEEN PROVEN TO BE TIGHT UNDER PRESSURE, DISINFECT THE PIPING SYSTEM IN ACCORDANCE WITH FEDERAL SPECIFICATION BB-C-120 AND THE FOLLOWING:


DRAIN AND REFILL PIPING SYSTEM WITH WATER CONTAINING 50 PARTS PER MILLION AVAILABLE CHLORINE, LET STAND FOR 6 HOURS, DRAIN, AND FLUSH CHLORINATED WATER FROM SYSTEM BEFORE PLACING IN SERVICE. SUBSEQUENT TO THE DISINFECTING OF THE POTABLE WATER PIPING SYSTEM, WATER SAMPLES SHALL BE SENT TO THE LOCAL HEALTH DEPARTMENT (LHD) OR INDEPENDENT LABORATORY APPROVED BY THE LHD FOR TESTING. APPROVAL SHALL BE OBTAINED FROM THE LHD OR INDEPENDENT LABORATORY BEFORE THE POTABLE WATER SYSTEM IS PLACED INTO SERVICE. PROVIDE CERTIFIED REPORTS TO ARCHITECT. MARK ALL FAUCETS, SINKS AND VALVES NON POTABLE, DO NOT DRINK UNTIL DISINFECTION IS COMPLETED.

UPON COMPLETION OF CLEANING, PIPING AND CHLORINATION, HAVE LOCAL HEALTH DEPARTMENT CERTIFY IN WRITING THAT THE BUILDING WATER SYSTEM IS SAFE FOR DRINKING.

TAG	MODEL	STORAGE CAPACITY	POWER INPUT (KW)	GPH RECOVERY @ 100°F RISE	TEMP OF WATER TO BE DELIVERED	ACCESSORIES
EWH-1	E40A-24-G	40 GAL.	24	139	140°F	1,2
REQUIRED ACCESSORIES: 1. T & P RELIEF VALVE, DRAIN VALVE, DIELECTRIC FITTINGS ON INLET & OUTLET, BALL VALVE ON INLET, THERMOMETER ON OUTLET, EXPANSION TANK, SEE DETAIL. 2. 3-YEAR COMMERCIAL WARRANTY.						
SELECTIONS BASED ON — RHEEM APPROVED EQUAL — A.O. SMITH						

P000

THESE PLANS ARE THE PROPERTY OF MRP DESIGN GROUP, INC. AND ARE SUBJECT TO FEDERAL COPYRIGHT LAWS. ANY USE OF SAME WITHOUT THE EXPRESS WRITTEN PERMISSION OF MRP DESIGN GROUP, INC. IS STRICTLY PROHIBITED.

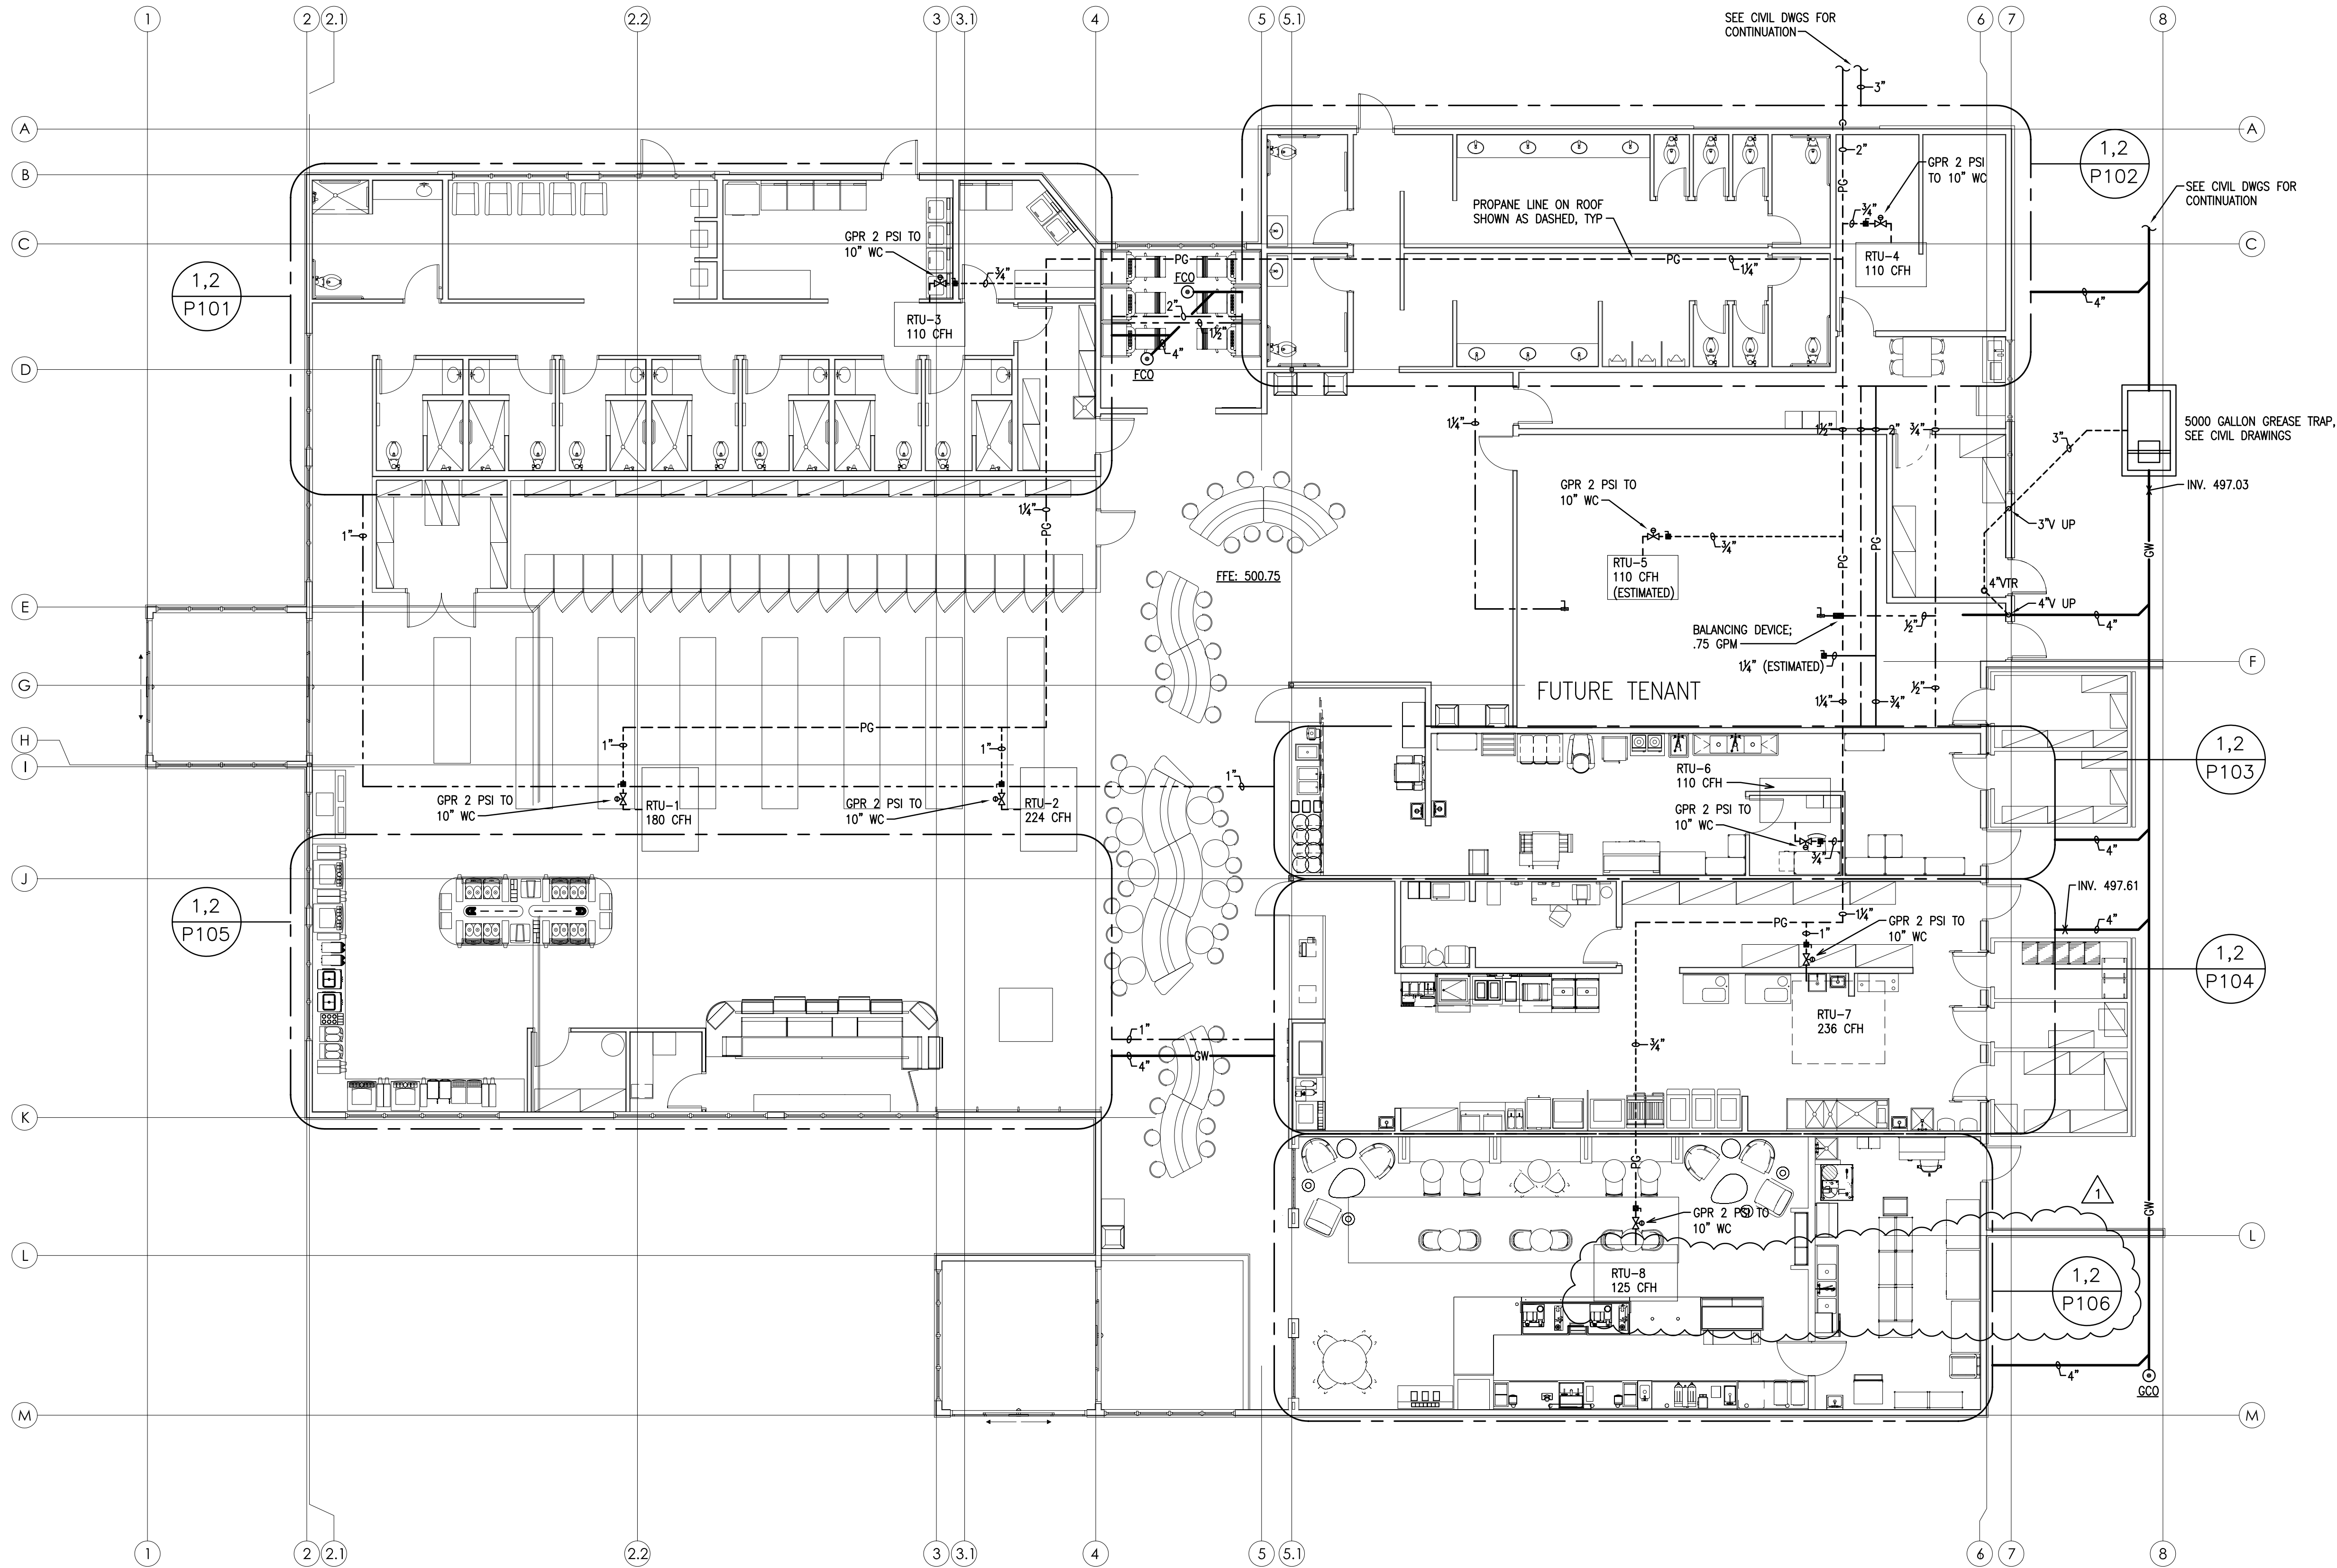

1 FLOOR PLAN - PLUMBING
P100 SCALE: 1/8"=1'-0"

ARCHITECT OF RECORD:

THOMAS E. MORGAN, JR.
ARCHITECT

423 FISCHER TRAIL
ELLIJAY, GEORGIA 30540

SEAL:



MRP
DESIGN GROUP

3450 Acworth Due West Road
Building 100, Suite 120
Kennesaw, Georgia 30144
P. 770-917-9172
F. 770-917-9470
www.mrpdesign.com

RELEASED FOR
CONSTRUCTION

ISSUES / REVISIONS:	
DATE	DESCRIPTION
3/1/06	PROGRESS SET
4/28/06	FOR PERMIT / CONSTRUCTION
6/15/06	STARBUCKS TENANT ADDITION AND UTILITY ROOM COORDINATION

DRAWN BY: RLP
CHKD BY: JWF

PROJECT DESCRIPTION:
THE DEVELOPMENT AND
CONSTRUCTION OF A
C-STORE LAYOUT, WHICH
INCLUDES RETAIL SPACE,
STORAGE, DRINK COOLER,
BEER CAVES, DRINKING
STATIONS, BREAK ROOM,
TRUCKER LOUNGE AND
RESTROOMS, PUBLIC
RESTROOMS AND 4 QSR'S
WITH WALK IN COOLERS AND
FREEZERS.

PROJECT TITLE:


TRAVEL CENTER
5524 GA HIGHWAY 96 W
JEFFERSONVILLE
GEORGIA 31044

SHEET TITLE:


FLOOR PLAN - PLUMBING

PROJECT NO: 25021

P100

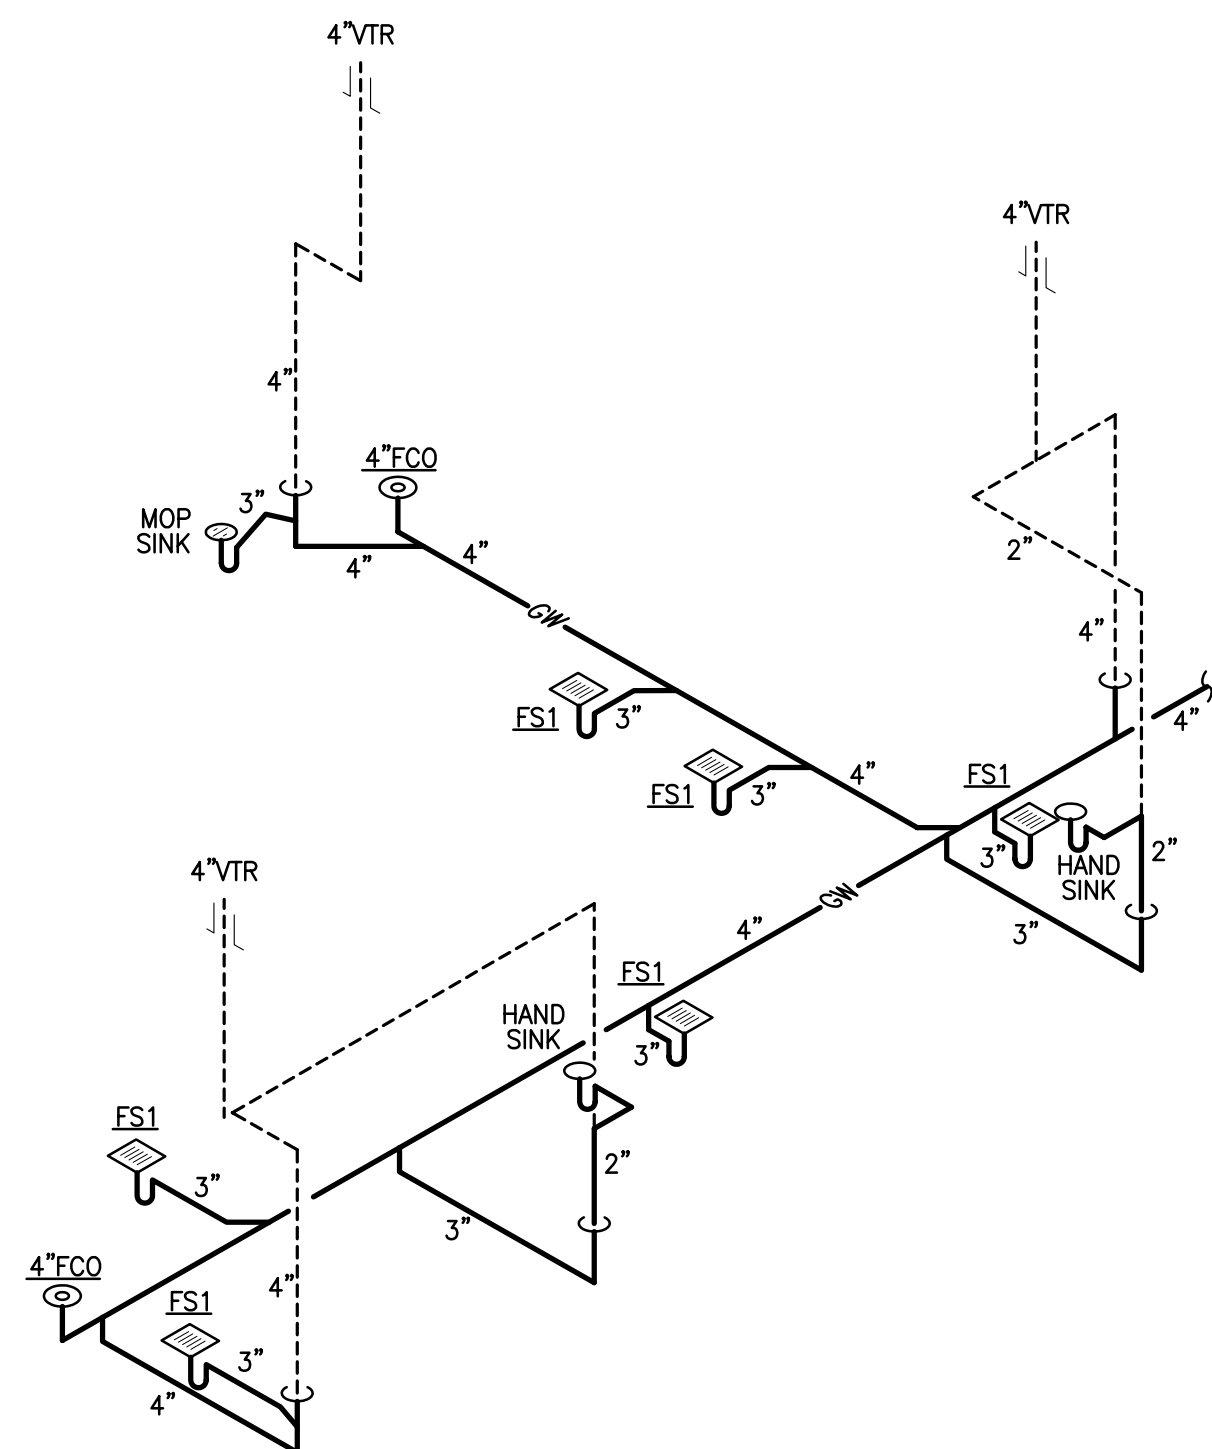


3 GREASE W&V DIAGRAM STARBUCKS
P106 SCALE: NOT TO SCALE

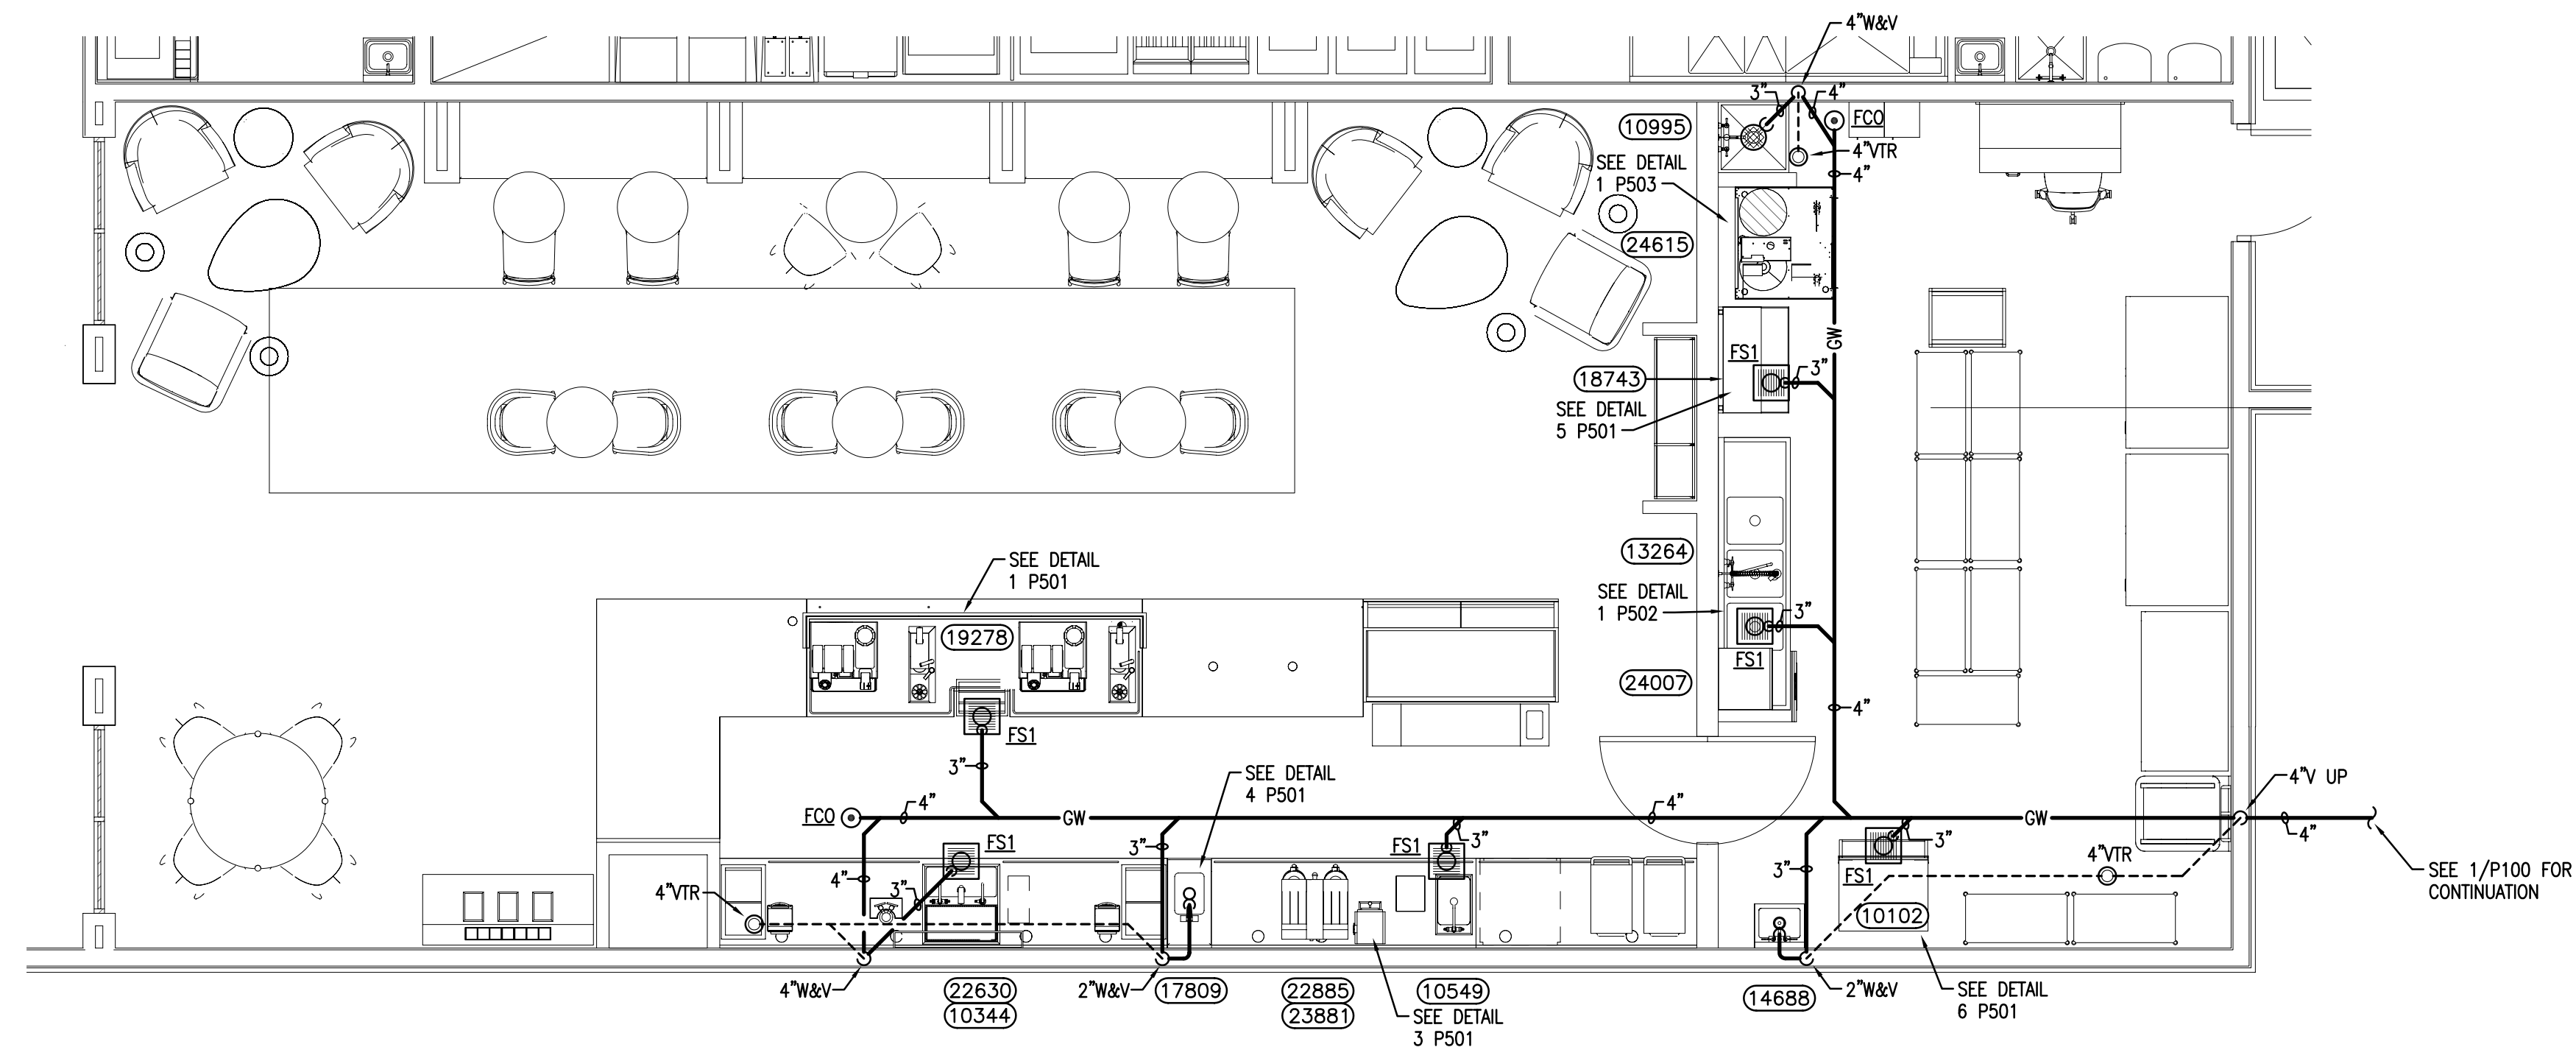

1
P106

PART PLAN STARBUCKS – WASTE & VENT

SCALE: 1/4"=1'-0"

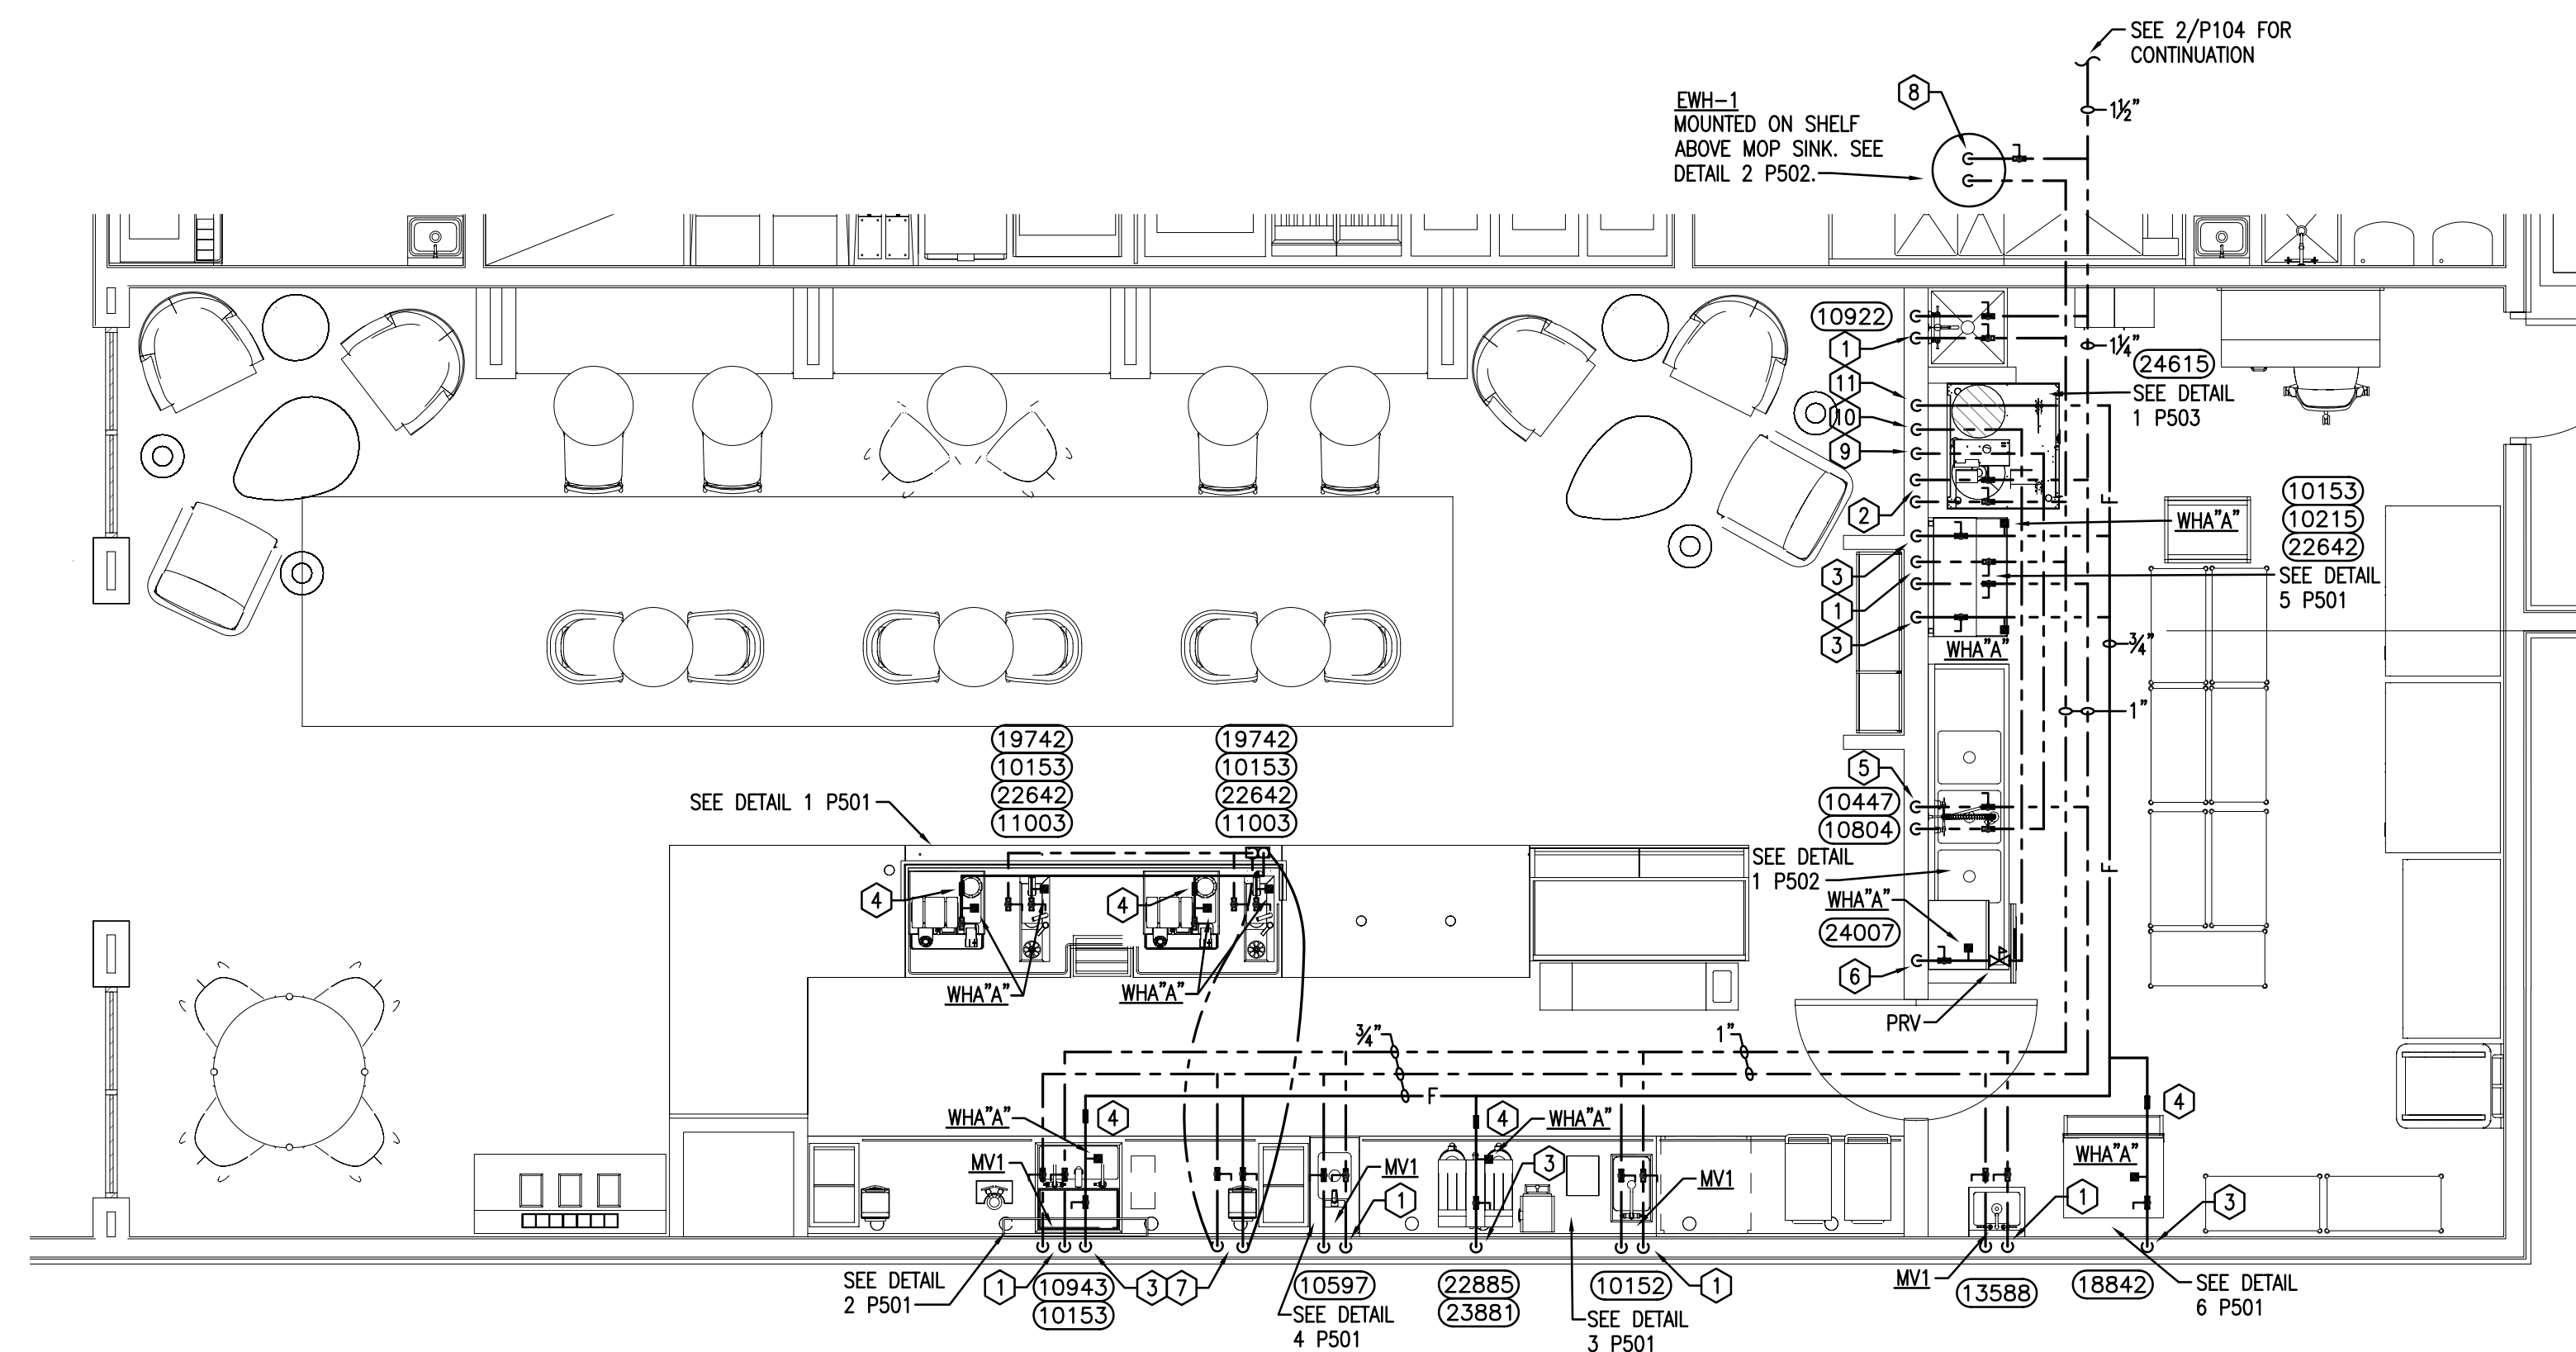

2 PART PLAN STARBUCKS – WATER & GAS
P106 SCALE: 1/4"=1'-0"

- ## PLAN KEY NOTES
- ① $\frac{1}{2}"$ H&CW DN.
 - ② $\frac{3}{4}"$ CW & $\frac{1}{2}"$ HW DN WATER FILTER CABINET. CABINET AND FILTER COMPONENTS PROVIDED AND INSTALLED BY STARBUCKS.
 - ③ $\frac{1}{2}"$ FW DN.
 - ④ BACKFLOW PREVENTOR.
 - ⑤ $\frac{1}{2}"$ SOFTENED HW & $\frac{1}{2}"$ CW DN.
 - ⑥ $\frac{1}{2}"$ SOFTENED CW DN TO DISHWASHER. PROVIDE PRV SET TO 20 PSIG, LINE STRAINER AND SHOCK ARRESTOR.
 - ⑦ $\frac{3}{4}"$ FW & $\frac{3}{4}"$ CW DN TO SOFT COPPER TUBING BELOW FLOOR.
 - ⑧ 1" CW DN & 1" HW UP FROM FWH-1.
 - ⑨ $\frac{1}{2}"$ SOFTENED HW UP.
 - ⑩ $\frac{1}{2}"$ SOFTENED CW UP.
 - ⑪ $\frac{3}{4}"$ FW UP.

DENOTES KITCHEN EQUIPMENT - REFER TO FOOD SERVICE PLANS FOR ADDITIONAL INFORMATION.

<u>GENERAL NOTE</u> PROVIDE FINAL PLUMBING CONNECTIONS TO ALL FOOD SERVICE EQUIPMENT INCLUDING ALL INDIRECT WASTE LINES, FITTINGS, AND APPURTENANCES FOR A COMPLETE INSTALLATION. REFER TO FOOD SERVICE EQUIPMENT DRAWINGS FOR ADDITIONAL ROUGH-IN INFORMATION AND CONNECTION DETAILS.

THOMAS E. MORGAN, JR.
ARCHITECT

423 FISCHER TRAIL
ELLIJAY, GEORGIA 30540

SEAL:



3450 Acworth Due West Road
Building 100, Suite 120
Kennesaw, Georgia 30144
P. 770-917-9172
F. 770-917-9470
www.mrpdesign.com

RELEASED FOR
CONSTRUCTION

[illegible]

DRAWN BY:	RLP
CHK'D BY:	JWE

PROJECT DESCRIPTION:

THE DEVELOPMENT AND CONSTRUCTION OF A C-STORE LAYOUT, WHICH INCLUDES RETAIL SPACE, STORAGE, DRINK COOLER, BEER CAVES, DRINKING STATIONS, BREAK ROOM, TRUCKER LOUNGE AND RESTROOMS, PUBIC RESTROOMS AND 4 QSR'S WITH WALK IN COOLERS AND FREEZERS .

PROJECT TITLE:

TRAVEL CENTER
4 GA HIGHWAY 96 W
JEFFERSONVILLE
GEORGIA 31044

SHEET TITLE:

PART PLANS -
STARBUCKS

PROJECT NO:	25021
-------------	-------

P106